

BUILDER/CONTRACTOR:



DESIGNER:



3990 S.R. 38 East Suite 8 Lafayette, IN 47905
(765) 471-8020 (765) 471-8065 fax

It is the contractor's responsibility to verify all details and dimensions

All work shall be performed in accordance with all applicable national, state, and local codes and regulations.

All dimensions are to rough frame of studs or to the outside of masonry.

Final cabinet layout will be designed by cabinet supplier.


All footings to be below frost line and must rest on undisturbed soil capable of handling the building.

All penetrations are to be sealed in accordance with state and local codes.



UNIT-3

FIRST FLOOR PLAN LAYOUT

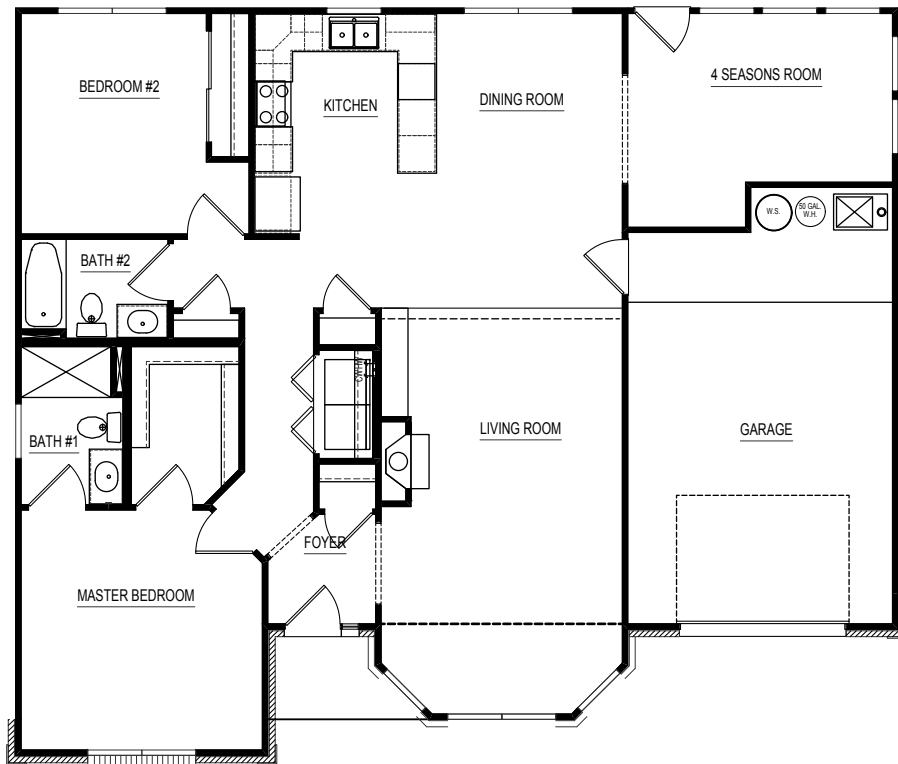

SECOND FLOOR PLAN LAYOUT

TABLE OF CONTENTS

A-01	FRONT ELEVATION
A-02	REAR ELEVATION
A-03	RIGHT ELEVATION
A-04	LEFT ELEVATION
A-05	FOUNDATION PLAN
A-07	FIRST FLOOR PLAN
S-01	SECTIONS
R-01	ROOF PLAN
E-02	FIRST FLOOR ELECTRICAL PLAN

PROJECT INFORMATION

1st. FLOOR (ABOVE GRADE)	1493	SQ.FT.
2nd. FLOOR (ABOVE GRADE)	0	SQ.FT.
FINISHED BASEMENT	0	SQ.FT.
Total Heated:-----	1493	SQ.FT.
GARAGE	356	SQ.FT.
FRONT PORCH	35	SQ.FT.
BACK PORCH	0	SQ.FT.
UNFINISHED BASEMENT	0	SQ.FT.

"FINISHED SQUARE FOOTAGE CALCULATIONS FOR THIS HOUSE WERE MADE BASED ON PLAN DIMENSIONS AND MAY VARY FROM THE FINISHED SQUARE FOOTAGE OF THE HOUSE AS BUILT."

REV. NO.	DATE	REMARKS
REV-1	07/24/2014	CHANGES PER BUILDER REQUESTS
REV-2	09/22/2014	CHANGES TO ROOF LINE




PRINT DATE:
09/23/2014

UNIT-3
FOR: FAITH MINISTRIES
LOCATION:
LOT #:


SHEET NUMBER
CS-01



FRONT-LEFT

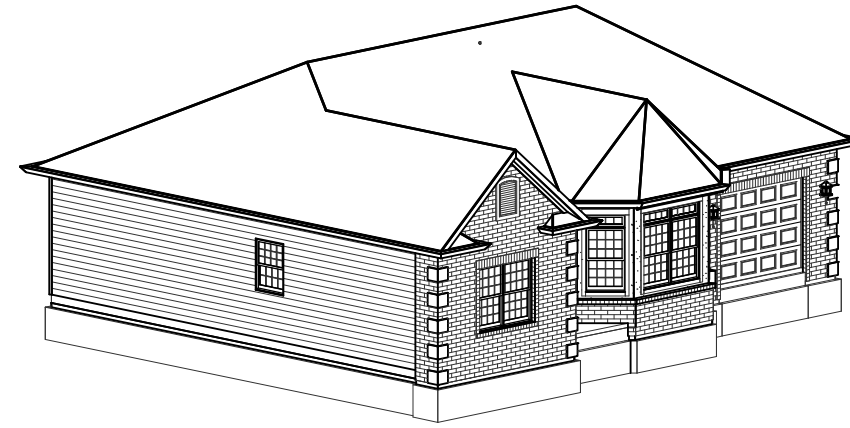

FRONT-RIGHT

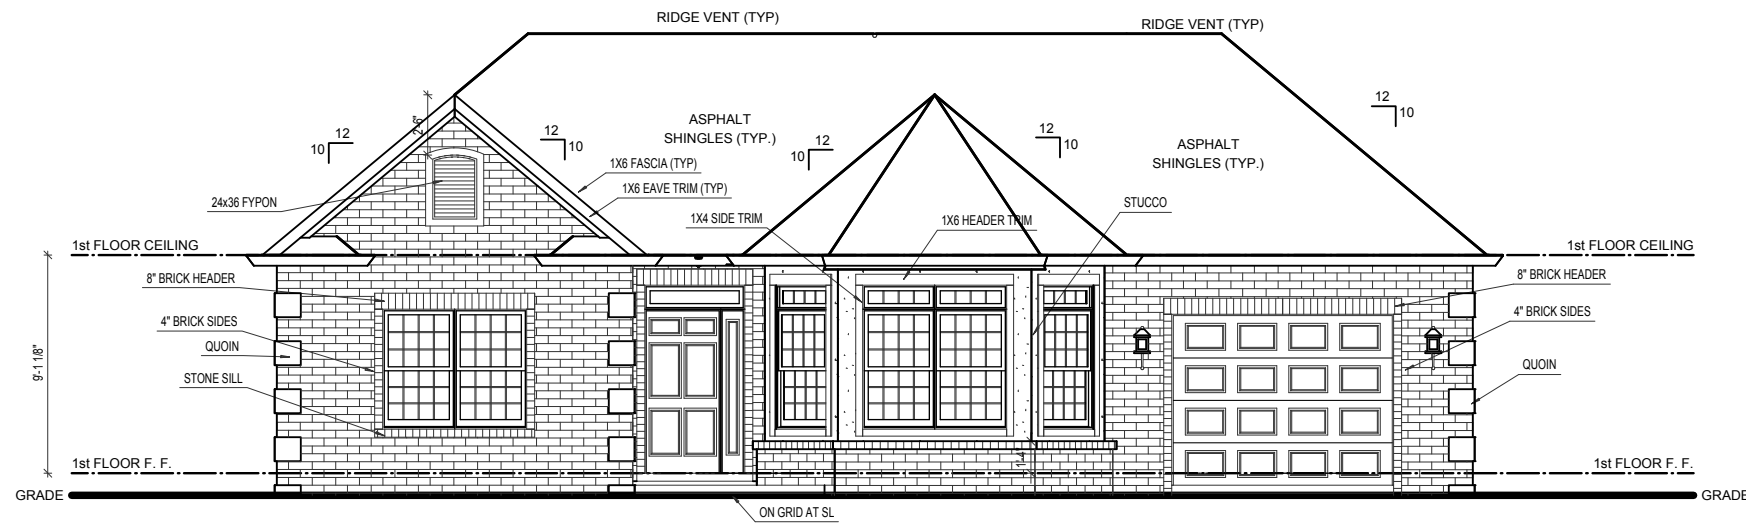


FRONT ELEVATION

SCALE: 1/8"=1'-0"


REV. NO.	DATE	REMARKS
REV-1	07/24/2014	CHANGES PER BUILDER REQUESTS
REV-2	09/22/2014	CHANGES TO ROOF LINE




UNIT-3	PRINT DATE: 09/23/2014
FOR: FAITH MINISTRIES	
LOCATION:	
LOT #:	
SHEET NUMBER	
A-01	

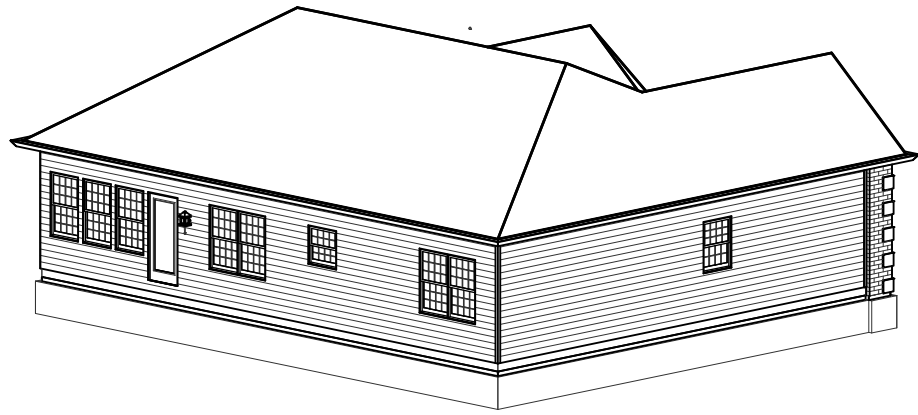

REAR-RIGHT

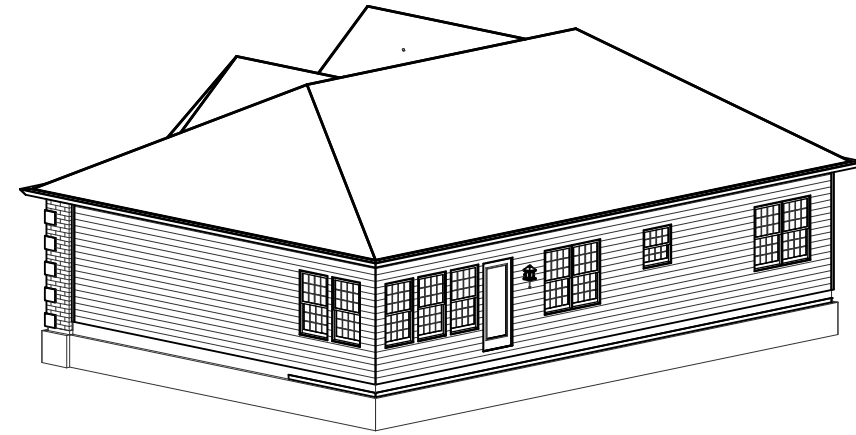

REAR-LEFT

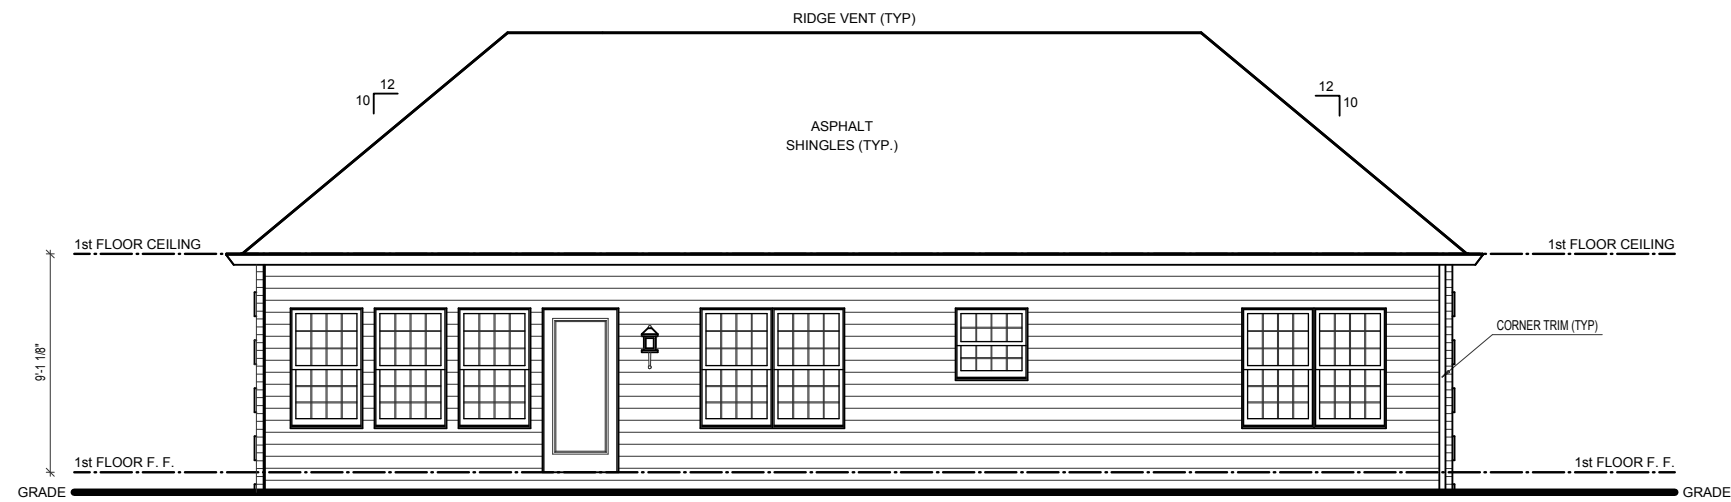

REAR ELEVATION

SCALE: 1/8"=1'-0"


REV. NO.	DATE	REMARKS
REV-1	07/24/2014	CHANGES PER BUILDER REQUESTS
REV-2	09/22/2014	CHANGES TO ROOF LINE




UNIT-3	PRINT DATE: 09/23/2014
FOR: FAITH MINISTRIES	
LOCATION:	
LOT #	
SHEET NUMBER	
A-02	



FRONT-RIGHT

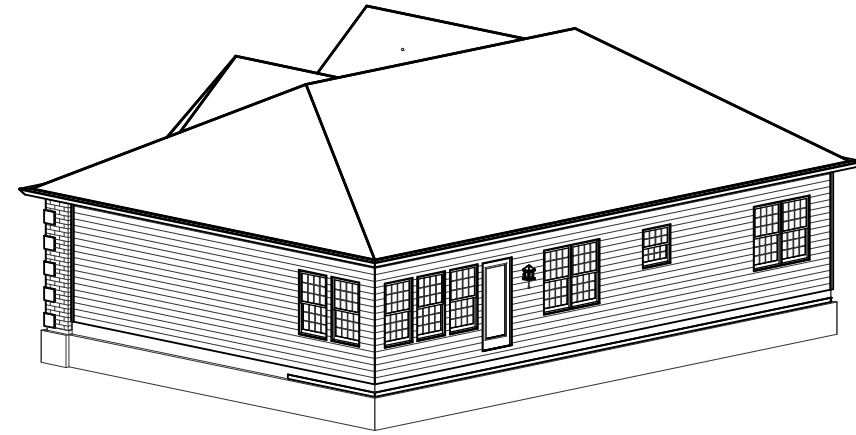

REAR-RIGHT

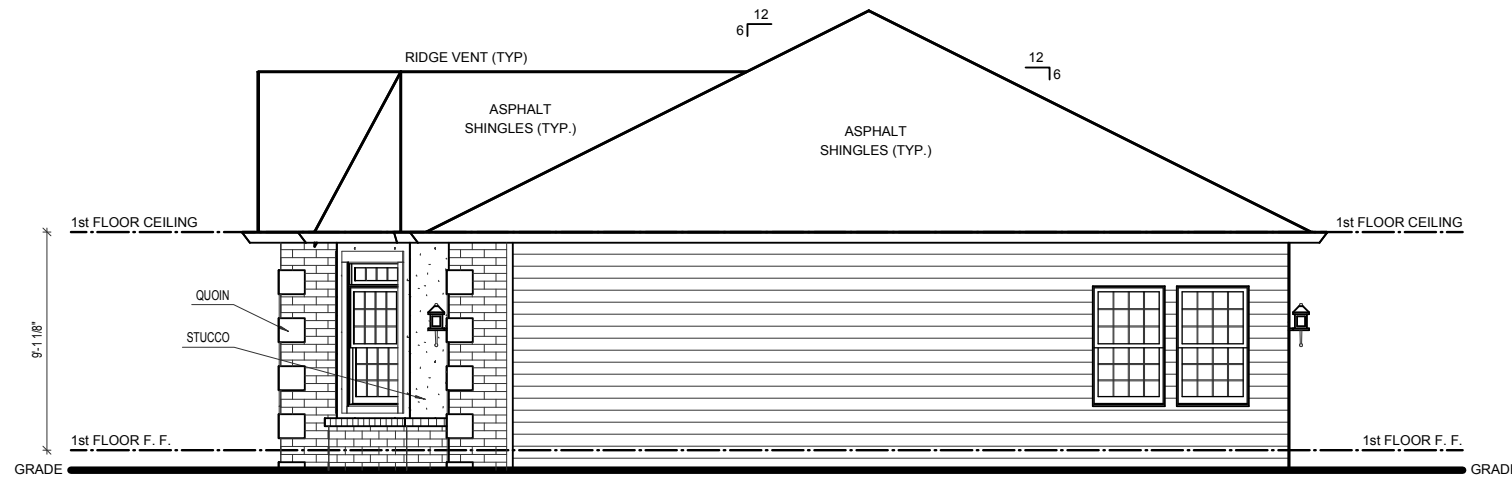


RIGHT ELEVATION

SCALE: 1/8"=1'-0"


REV. NO.	DATE	REMARKS
REV-1	07/24/2014	CHANGES PER BUILDER REQUESTS
REV-2	09/22/2014	CHANGES TO ROOF LINE




PRINT DATE: 09/23/2014	
UNIT-3	FOR: FAITH MINISTRIES
SHEET NUMBER	LOCATION:
A-03	LOT #:

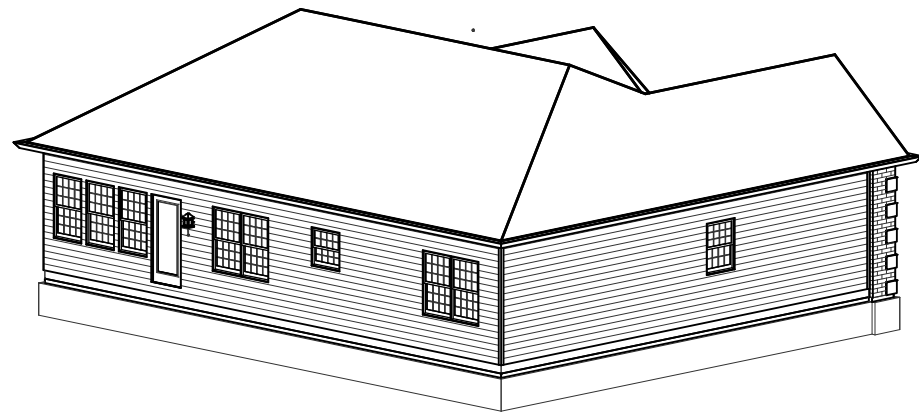

REAR-LEFT

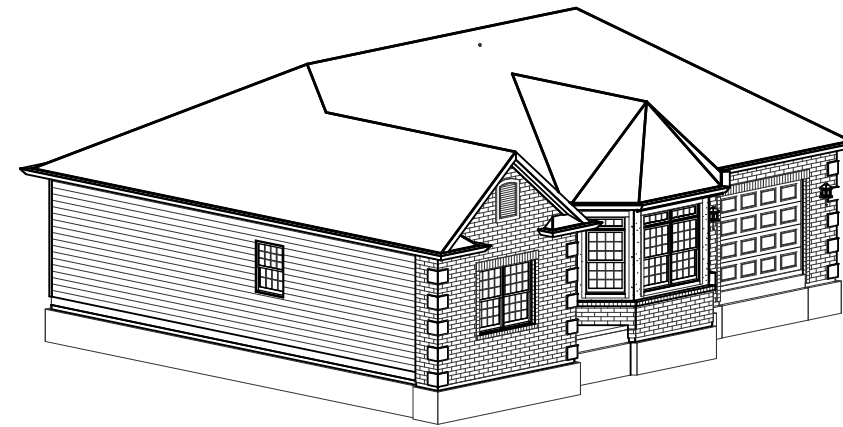

FRONT-LEFT

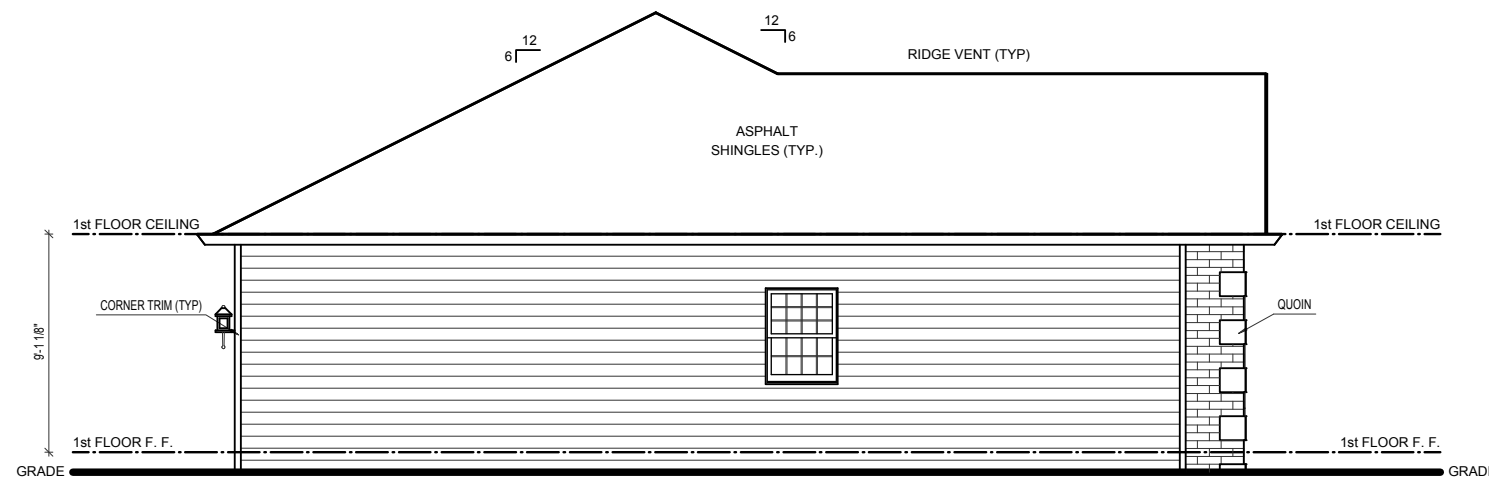

LEFT ELEVATION

SCALE: 1/8"=1'-0"


REV. NO.	DATE	REMARKS
REV-1	07/24/2014	CHANGES PER BUILDER REQUESTS
REV-2	09/22/2014	CHANGES TO ROOF LINE



UNIT-3	PRINT DATE: 09/23/2014
FOR: FAITH MINISTRIES	
LOCATION:	
LOT #:	
SHEET NUMBER	
A-04	

FOUNDATION PLAN NOTES:

1. ALL DIMENSIONS ARE TO THE OUTSIDE OF MASONRY
2. SLOPE EXTERIOR SLABS AWAY FROM BUILDING FOUNDATION WALLS FOR DRAINAGE
3. ALL BEAMS AND LOCATIONS ARE TO BE VARIFIED WITH THE ENGINEERED FLOOR SYSTEM LAYOUT
4. ANY WALK-OUT CONDITION IS TO BE VARIFIED WITH THE BUILDER
5. IT IS THE CONTRACTOR'S RESPONSIBILITY TO VERIFY ALL MECHANICAL AND ELECTRICAL REQUIREMENTS AND CLEARANCES.
6. DIMENSIONS TO BEAM LOCATIONS ARE TO THE CENTER OF BEAM.

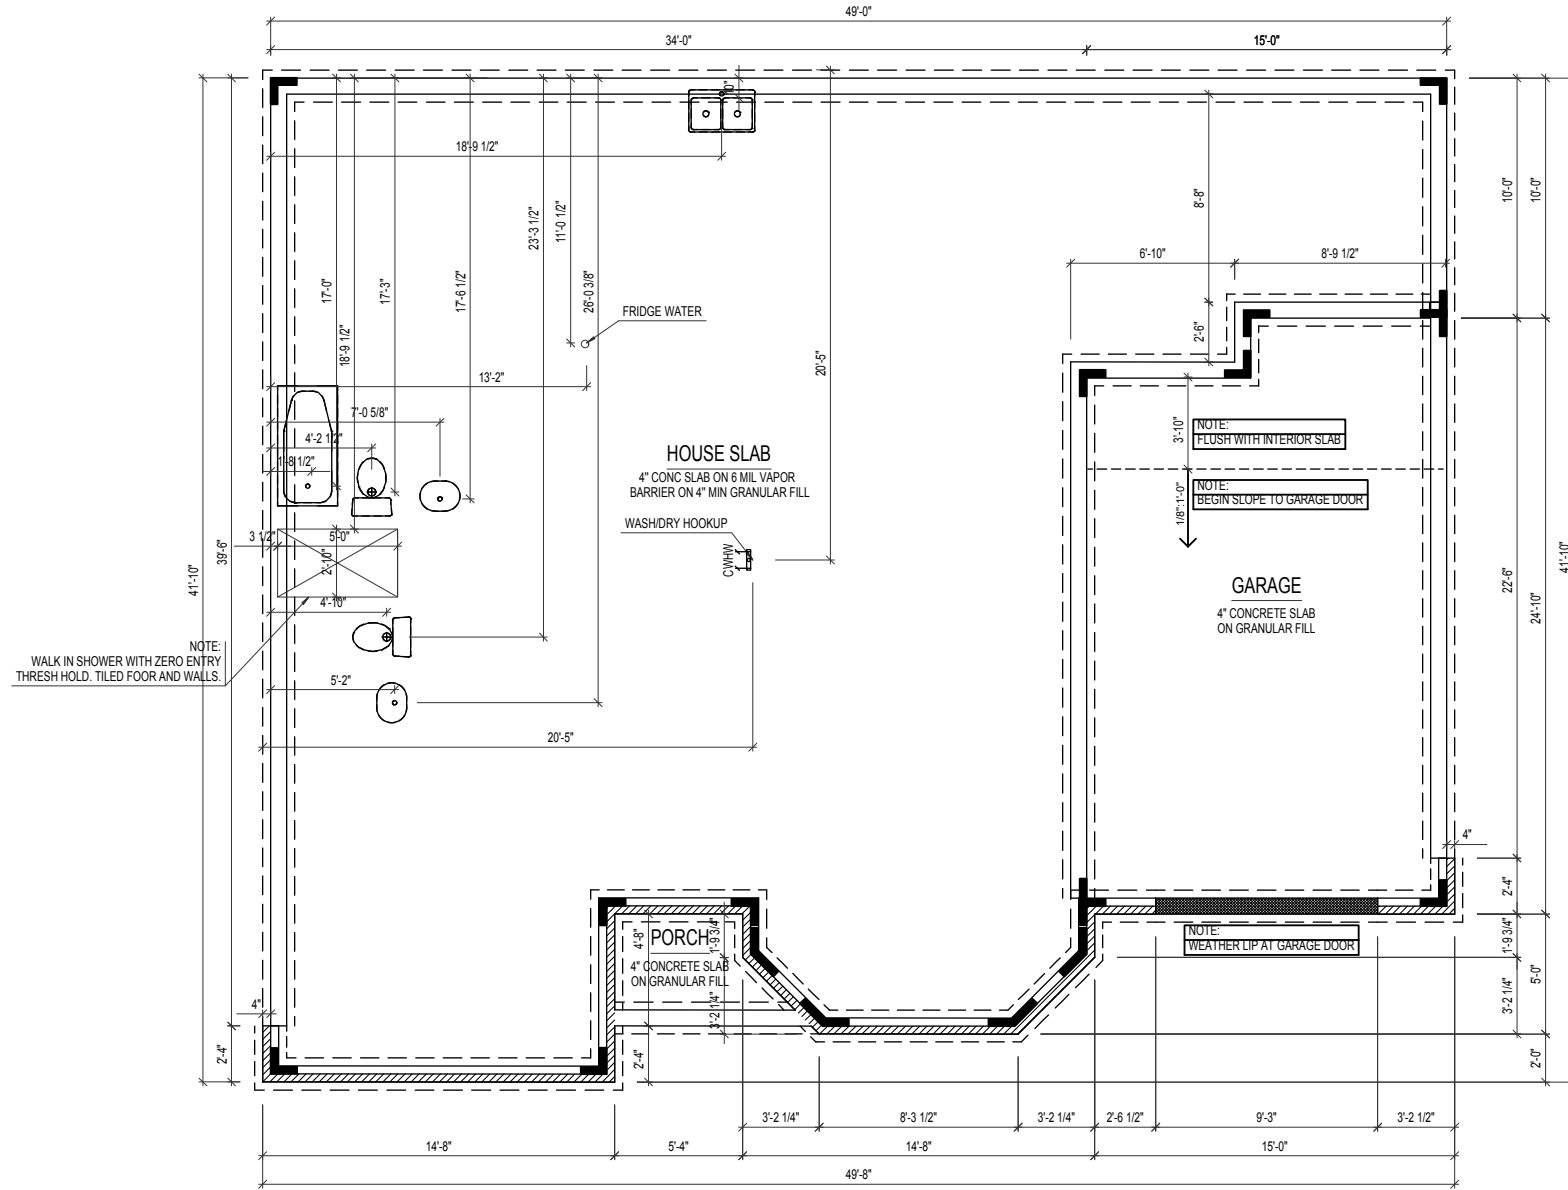

FOUNDATION PLAN

SCALE: 1/8"=1'-0"

STONE LEDGE HATCH	
BRICK LEDGE HATCH	
LOCATION OF FRAMED WALL ABOVE	


REV. NO.	DATE	REMARKS
REV-1	07/24/2014	CHANGES PER BUILDER REQUESTS
REV-2	09/22/2014	CHANGES TO ROOF LINE



UNIT-3
FOR: FAITH MINISTRIES
LOCATION:
LOT #:
PRINT DATE: 09/23/2014
SHEET NUMBER
A-05

FLOOR PLAN NOTES:

1. ALL DIMENSIONS ARE TO THE ROUGH FRAME OF STUDS
2. CENTER ALL OPENINGS UNLESS OTHERWISE NOTED
3. THESE PLANS ARE NOT TO BE SCALED FOR CONSTRUCTION PURPOSES
4. FINAL CABINET LAYOUT WILL BE DESIGNED BY CABINET SUPPLIER
5. IT IS THE CONTRACTOR'S RESPONSIBILITY TO VERIFY THE ACCURACY OF ALL DETAILS AND DIMENSIONS
6. VERIFY WITH THE WINDOW MFG. ALL WINDOW SIZES AND EGRESS REQ.

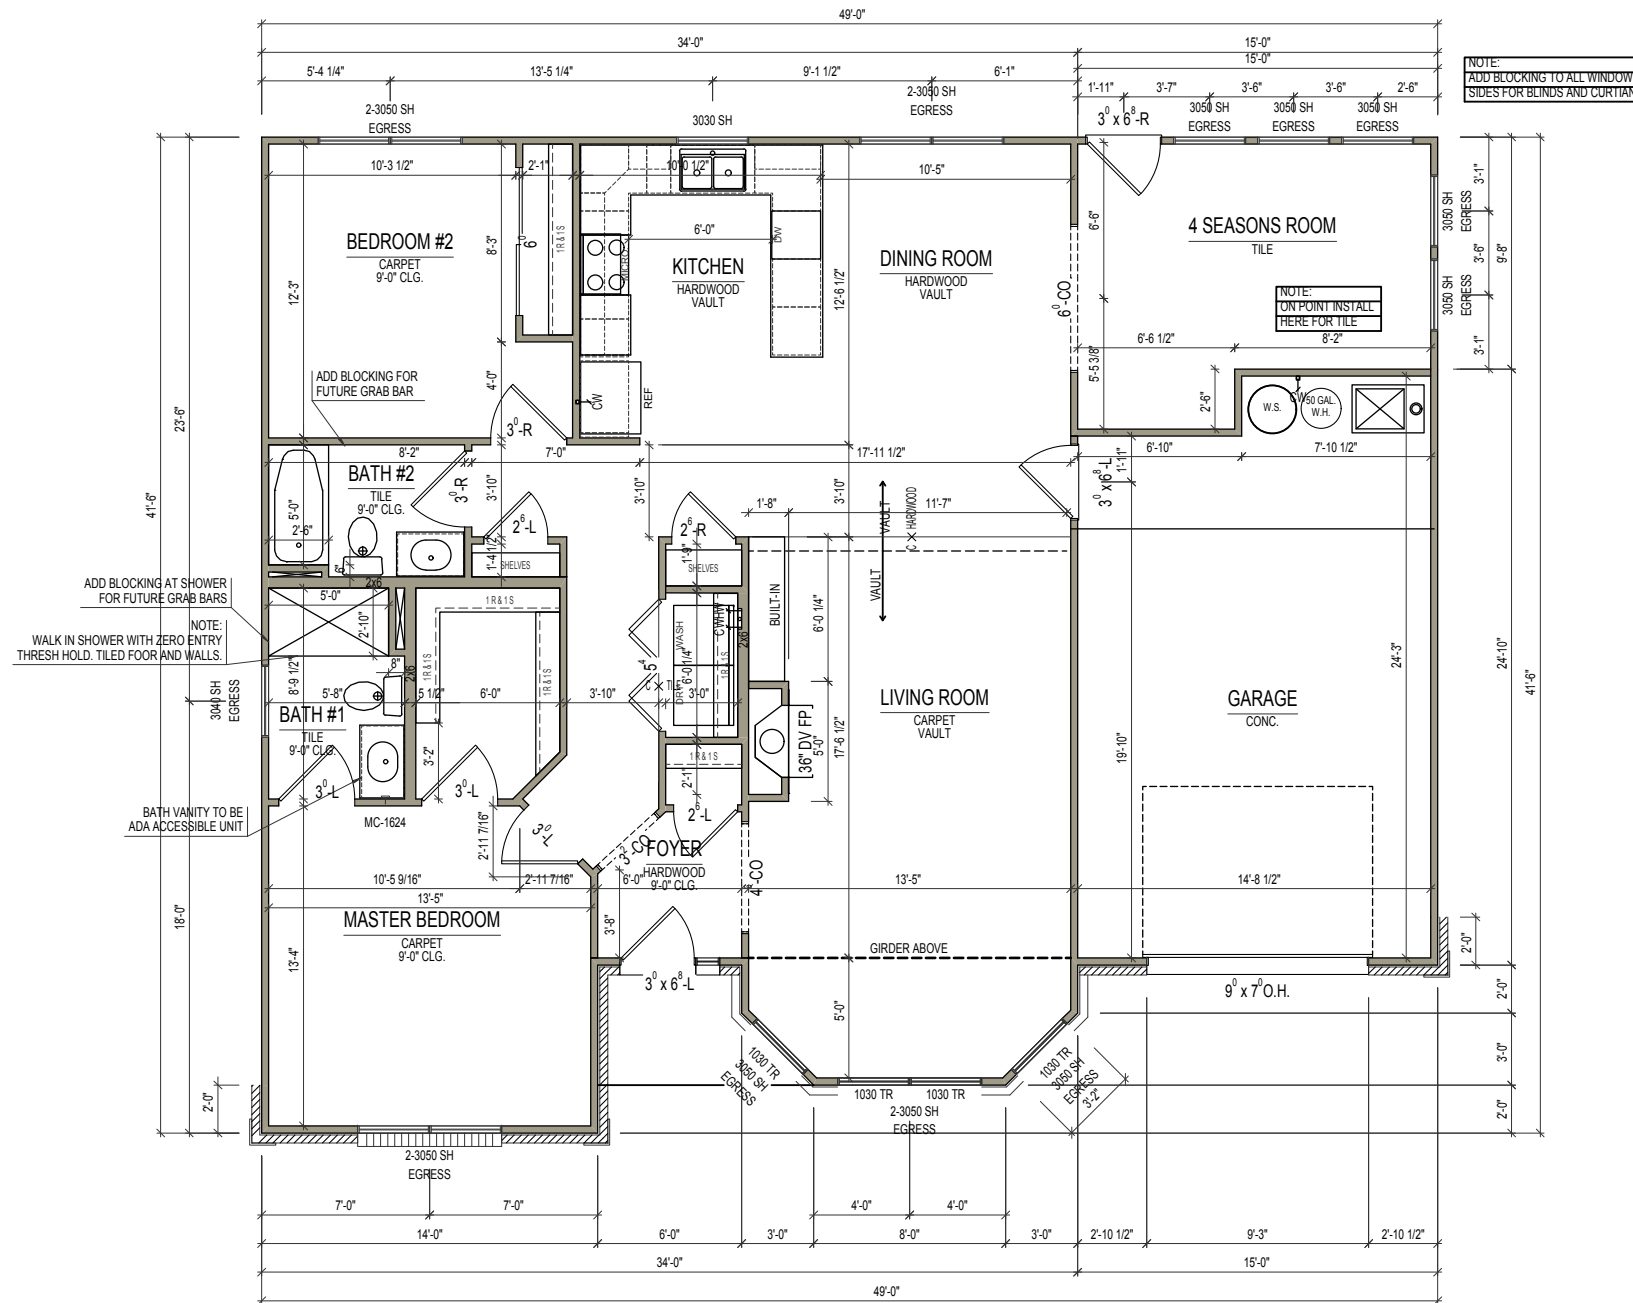

FIRST FLOOR PLAN


SCALE: 1/8"=1'-0"

REV. NO.	DATE	REMARKS
REV-1	07/24/2014	CHANGES PER BUILDER REQUESTS
REV-2	09/22/2014	CHANGES TO ROOF LINE




PRINT DATE: 09/23/2014	
UNIT-3	FOR: FAITH MINISTRIES
	LOCATION:
	LOT #:
SHEET NUMBER	
A-06	

View_Sheets/B-07-Section.vxp

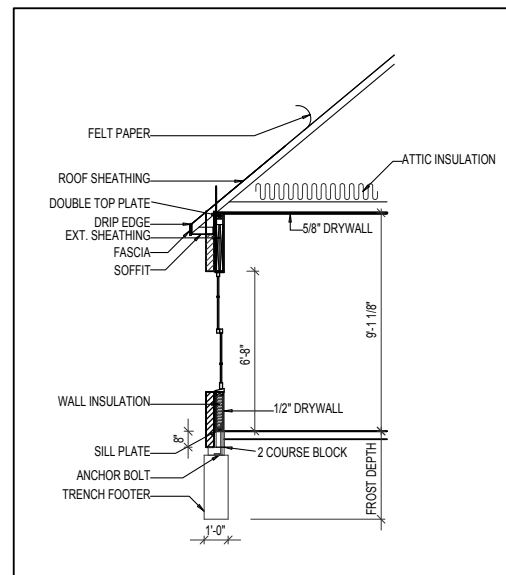


(TYP) SECTION @ MASONRY

SCALE: 1/8"=1'-0"

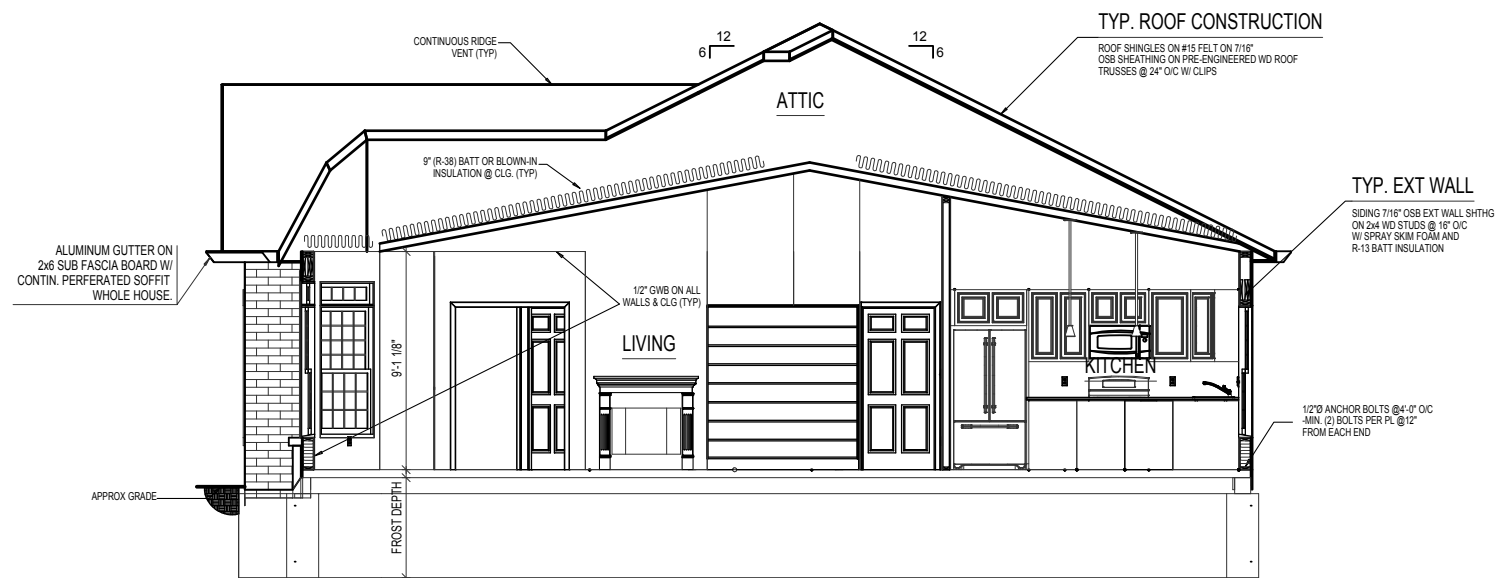

SECTION A-A

SCALE: 1/8"=1'-0"

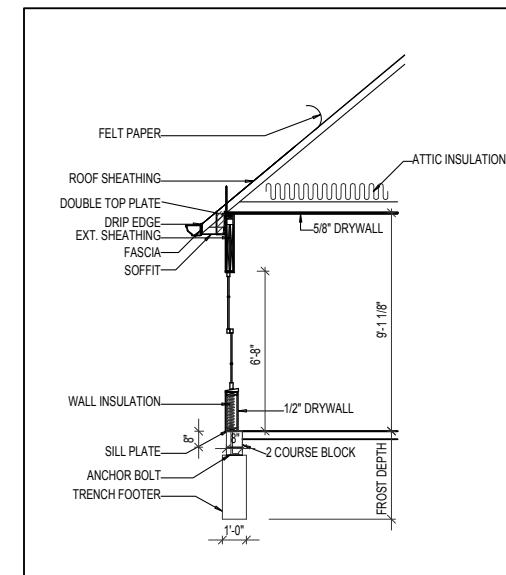

(TYP) SECTION @ SIDING

SCALE: 1/8"=1'-0"

REV. NO.	DATE	REMARKS
REV-1	07/24/2014	CHANGES PER BUILDER REQUESTS
REV-2	09/22/2014	CHANGES TO ROOF LINE



PRINT DATE:
09/23/2014


UNIT-3
FOR: FAITH MINISTRIES
LOCATION:
LOT #:

SHEET NUMBER
S-01

© CG Visions 2006 PLAN CREATION DATE 08/13/2013

ROOF PLAN NOTES:

1. ALL ROOF OVERHANGS ARE TO BE AT 1'-0" U.N.O.
2. THESE PLANS ARE NOT TO BE SCALED FOR CONSTRUCTION PURPOSES
3. IT IS THE CONTRACTOR'S RESPONSIBILITY TO VERIFY THE ACCURACY OF ALL DETAILS AND DIMENSIONS

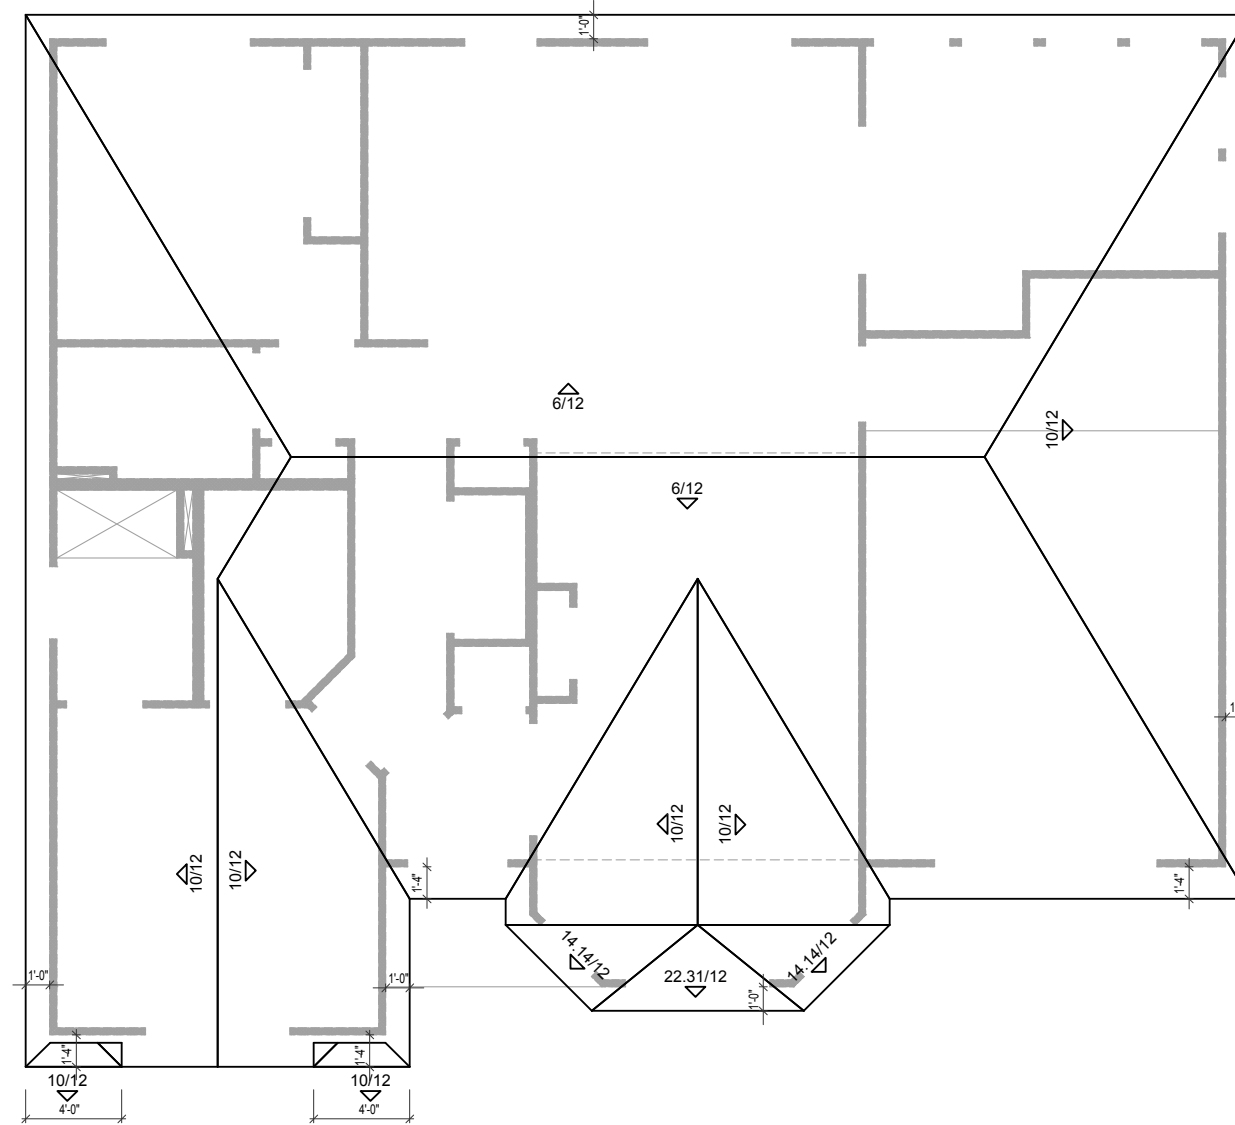

ROOF PLAN


SCALE: 1/8"=1'-0"

REV. NO.	DATE	REMARKS
REV-1	07/24/2014	CHANGES PER BUILDER REQUESTS
REV-2	09/22/2014	CHANGES TO ROOF LINE



PRINT DATE: 09/23/2014	
UNIT-3	FOR: FAITH MINISTRIES
SHEET NUMBER	LOCATION:
R-01	LOT #:

	SINGLE POLE SWITCH
	THREE WAY SWITCH
	FOUR WAY SWITCH
	DIMMER SWITCH
	PHOTO CELL SWITCH
	SWITCH AND OUTLET
	SINGLE OUTLET
	DUPLEX OUTLET
	CEILING OUTLET
	FLOOR OUTLET
	GROUND FAULT INTERRUPT
	RANGE OUTLET
	WATERPROOF OUTLET
	HIGH VOLTAGE OUTLET (220)
	GARBAGE DISPOSAL
	SMOKE DETECTOR WALL/CLG
	CARBON MONOXIDE WALL/CLG
	THERMOSTAT
	DATA OUTLET
	DOOR BELL BUTTON
	DOOR BELL CHIMES
	TELEVISION OUTLET
	TELEPHONE OUTLET
	ELECTRICAL PANEL
	FLOOD LIGHT
	EXTERIOR WALL FIXTURE
	GARAGE SERVICE DOOR
	LIGHT TRACK PACKAGE
	BATH FAN
	BATH FAN / LIGHT COMBO
	PULL CHAIN FIXTURE
	CEILING FIXTURE - FLUSH MOUNT
	CEILING KEYLESS LIGHT
	WATERPROOF RECESSED CAN
	HANGING CEILING FIXTURE
	WALL FIXTURE SINGLE
	WALL FIXTURE DOUBLE
	RECESSED CAN LIGHT FIXTURE
	RECESSED EYEBALL CAN FIXTURE
	BATH STRIP LIGHT
	WALL FIXTURE / STAIR LIGHT
	UNDER CABINET LIGHT FIXTURE
	PENDANT LIGHT FIXTURE
	CLOSET CASTER LIGHT
	LIGHTED CEILING FAN PACKAGE
	CEILING LIGHT WITH ROUGH IN FOR FAN (TWO SWITCHES)
	FLUORESCENT PACKAGE

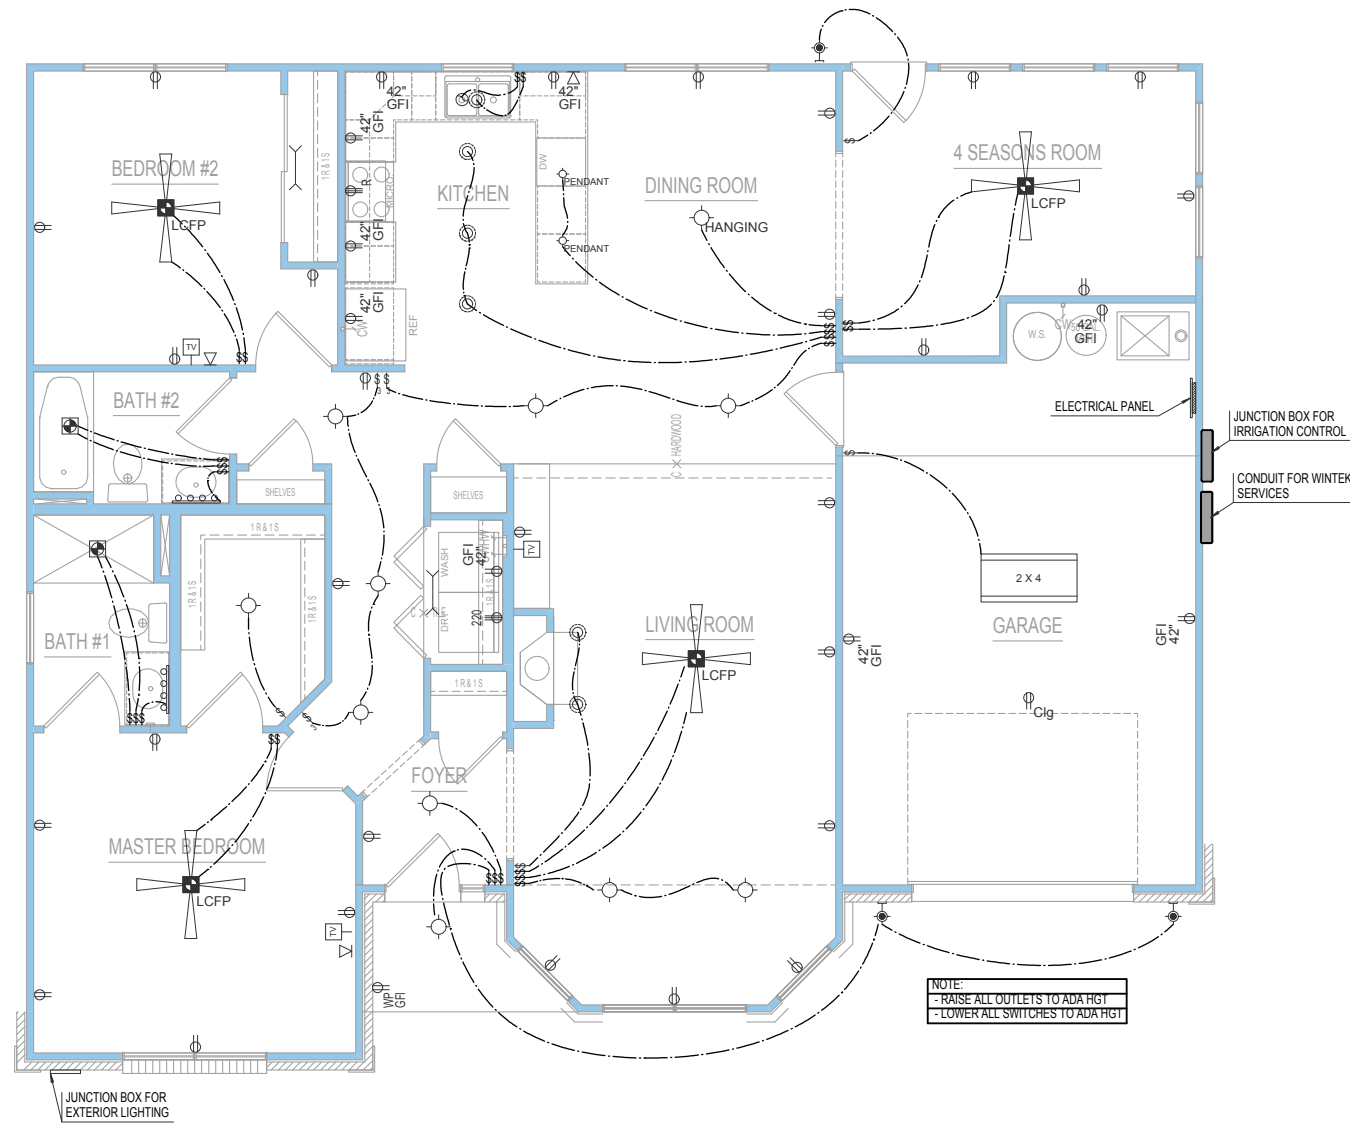

1ST FLOOR ELECTRICAL

SCALE: 1/8"=1'-0"

REV. NO.	DATE	REMARKS
REV-1	07/24/2014	CHANGES PER BUILDER REQUESTS
REV-2	09/22/2014	CHANGES TO ROOF LINE



UNIT-3	PRINT DATE: 09/23/2014
FOR: FAITH MINISTRIES	
LOCATION:	
LOT #:	
SHEET NUMBER	
E-02	