

P&D Builders - Job # 1369

PLEASE NOTE: PRELIMINARY DESIGNS ARE SUBJECT TO CHANGE DUE TO STRUCTURAL OR CODE REQUIREMENTS. ITEMS SHOWN MAY BE OPTIONAL/EXTRA. PLEASE REFER TO YOUR CONTRACT FOR SPECIFICATIONS & DESCRIPTION.

ELEVATIONS




P&D Builders Ltd.
59 Greif Parkway Suite 100
Delaware, Ohio 43015
(740) 201-8079
Fax (740) 201-8084
www.pndbuilders.com

ALL ELEVATIONS ARE THE EXCLUSIVE PROPERTY OF P&D BUILDERS LTD. NO REPRODUCTION OR COVER USE OF THESE PLANS MAY BE MADE WITHOUT THEIR WRITTEN CONSENT OF THE AUTHOR OF THE PLANS.

P&D JOB # 1369




FRONT ELEVATION
SCALE : 1/4" = 1'-0"

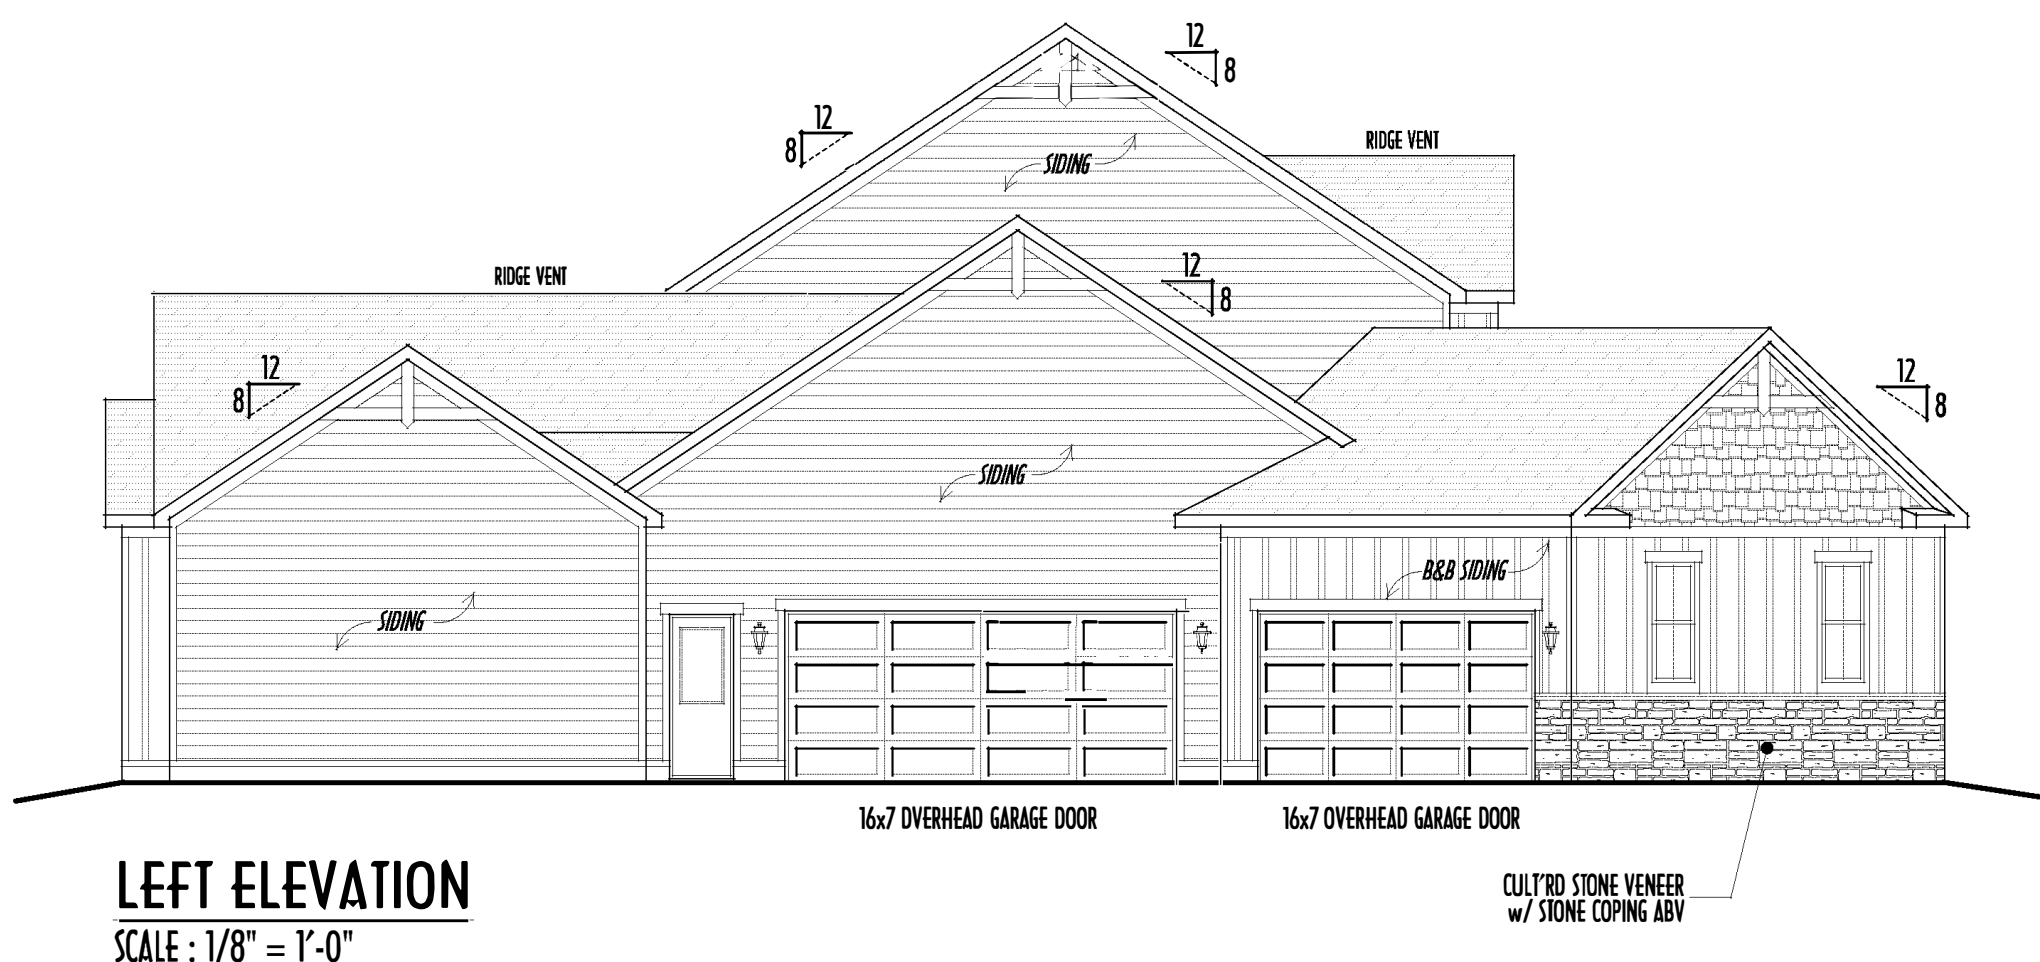


LEFT ELEVATION
SCALE : 1/8" = 1'-0"

FIRST FLOOR CEILINGS @ 9'-1 1/8" UNLESS NOTED OTHERWISE
FIRST FLOOR WINDOW HEADERS @ 7'-6" UNLESS NOTED OTHERWISE
SECOND FLOOR CEILINGS @ 8'-1 1/8" UNLESS NOTED OTHERWISE
SECOND FLOOR WINDOW HEADERS @ 6'-10" UNLESS NOTED OTHERWISE
EMERGENCY EGRESS OPERABLE (E.E.O.) WINDOWS IN ALL BEDROOMS
SEE ROOF PLAN FOR SOFFIT & RAKE SIZES
RUN BRICK VENEER 1" PAST FRAMING CORNERS
CULTURED STONE VENEER WRAPS FRONT CORNERS MIN 6" INTO 1X6 WOOD TRIM UNLESS NOTED
FLASH & CAULK ELEVATIONS AS NECESSARY TO PROVIDE A WEATHER-TIGHT SEAL BETWEEN MATERIALS, FRAMING & TRIM
WINDOWS & DOORS (BRAND & DESIGN) PER CONTRACT
WINDOWS & DOORS ARE TO BE INSTALLED PER MANUFACTURERS SPECIFICATIONS
CONFIRM WINDOW SIZES & ROUGH-OPENINGS WITH SUPPLIER
RUN STUCCO, STONE & BRICK VENEER TO GRADE UNLESS NOTED
WEEP SCREENS FOR SLUICED EXTERIORS SHALL COMPLY WITH R-703.6.2.1 (#36 GALV CORROSION-RESISTANT SCREENED AT/ABV FOUNDATION PLATE (3.5" FLANGE) PLACED AT MIN 4" ABV EARTH / 2" ABV PAVING, ALLOWING TRAP'D WATER TO DRAIN)
SLOPE GRADE AWAY FROM FOUNDATION FOR PROPER DRAINAGE

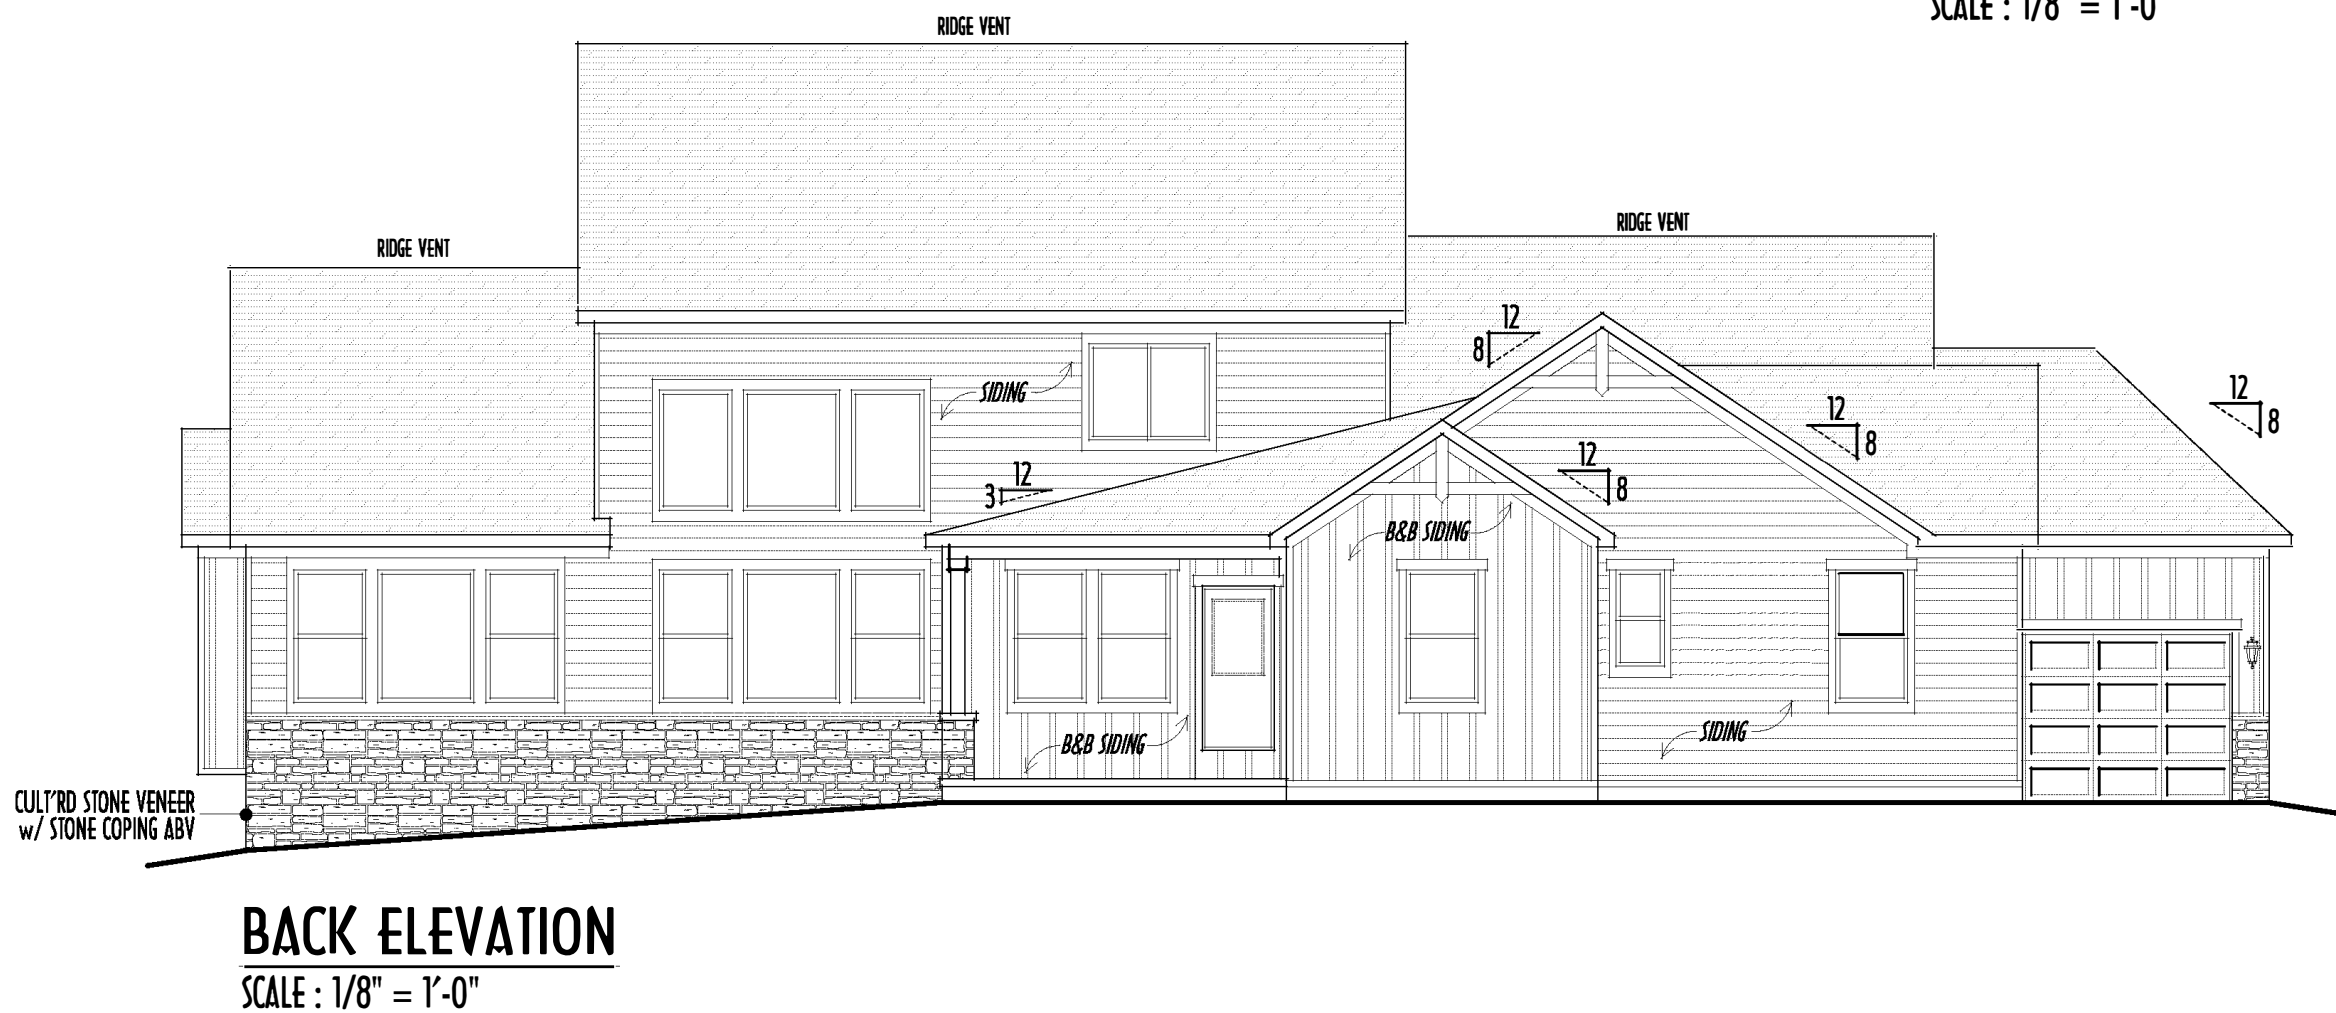

BACK ELEVATION
SCALE : 1/8" = 1'-0"

FINAL WINDOW DESIGN PER PROVIDER, ALL FRAMING ROUGH-OPENINGS TO BE BASED ON FINAL LAYOUT ONLY
EXACT WINDOW & DOOR GRID PATTERNS (MULLIONS) MAY DIFFER - REFER TO MANUFACTURER OR SUPPLIER
GRADE ELEVATION SHOWN IS APPROXIMATE
FIELD VERIFY & ADJUST FOUNDATION AS NECESSARY

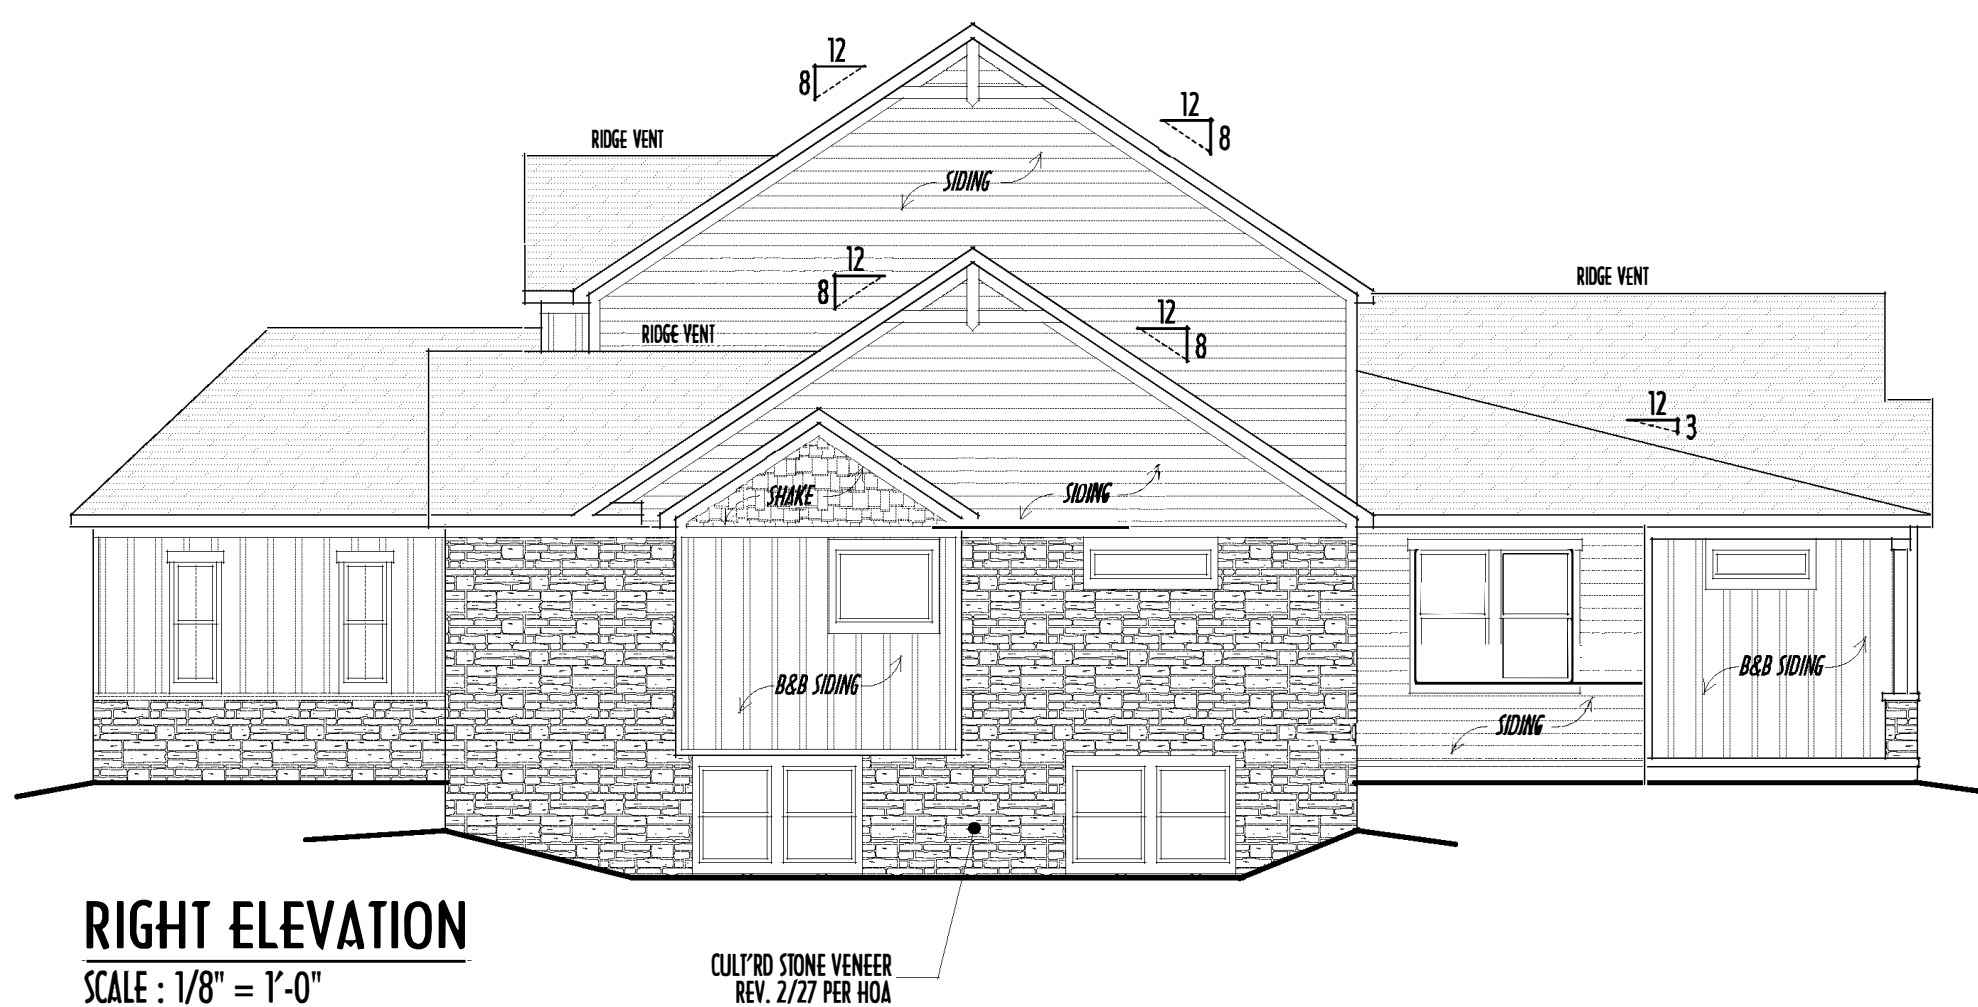

RIGHT ELEVATION
SCALE : 1/8" = 1'-0"

- DIMENSIONAL SHINGLES
- FAUX STONE VENEER
- BOARD & BATTEN SIDING
- SHAKE SIDING
- HORIZONTAL LAP SIDING

FIRST FLR LIVING SP = 2,437 SQ.FT.
SECOND FLR LIVING SP = 807 SQ.FT.
TOTAL LIVING SP = 3,244 SQ.FT.
OPT. FINISHED BSMT = 72 SQ.FT.

PRELIMINARY DESIGN
NOT TO SCALE - NOT FOR CONSTRUCTION


Danne
Residential Design & Drafting, LLC
614.207.6286 dannehd@gmail.com

REVISION DATE:	BY:	DATE/CD
11/30/18	rwd	concept
12/2/18	---	concept rev
12/26/18	---	prelim
1/10/19	1/r	prelim rev
2/9/19	1/r	prelim rev
3/3/19	rwd	per HOA

TO SCALE WHEN PRINTED 24"X36" - PAPER SIZE 11"
FIELD DIMENSIONS - DO NOT SCALE PRINTS

DESIGNED: P&D / rwd

PAGE : 5 of 8

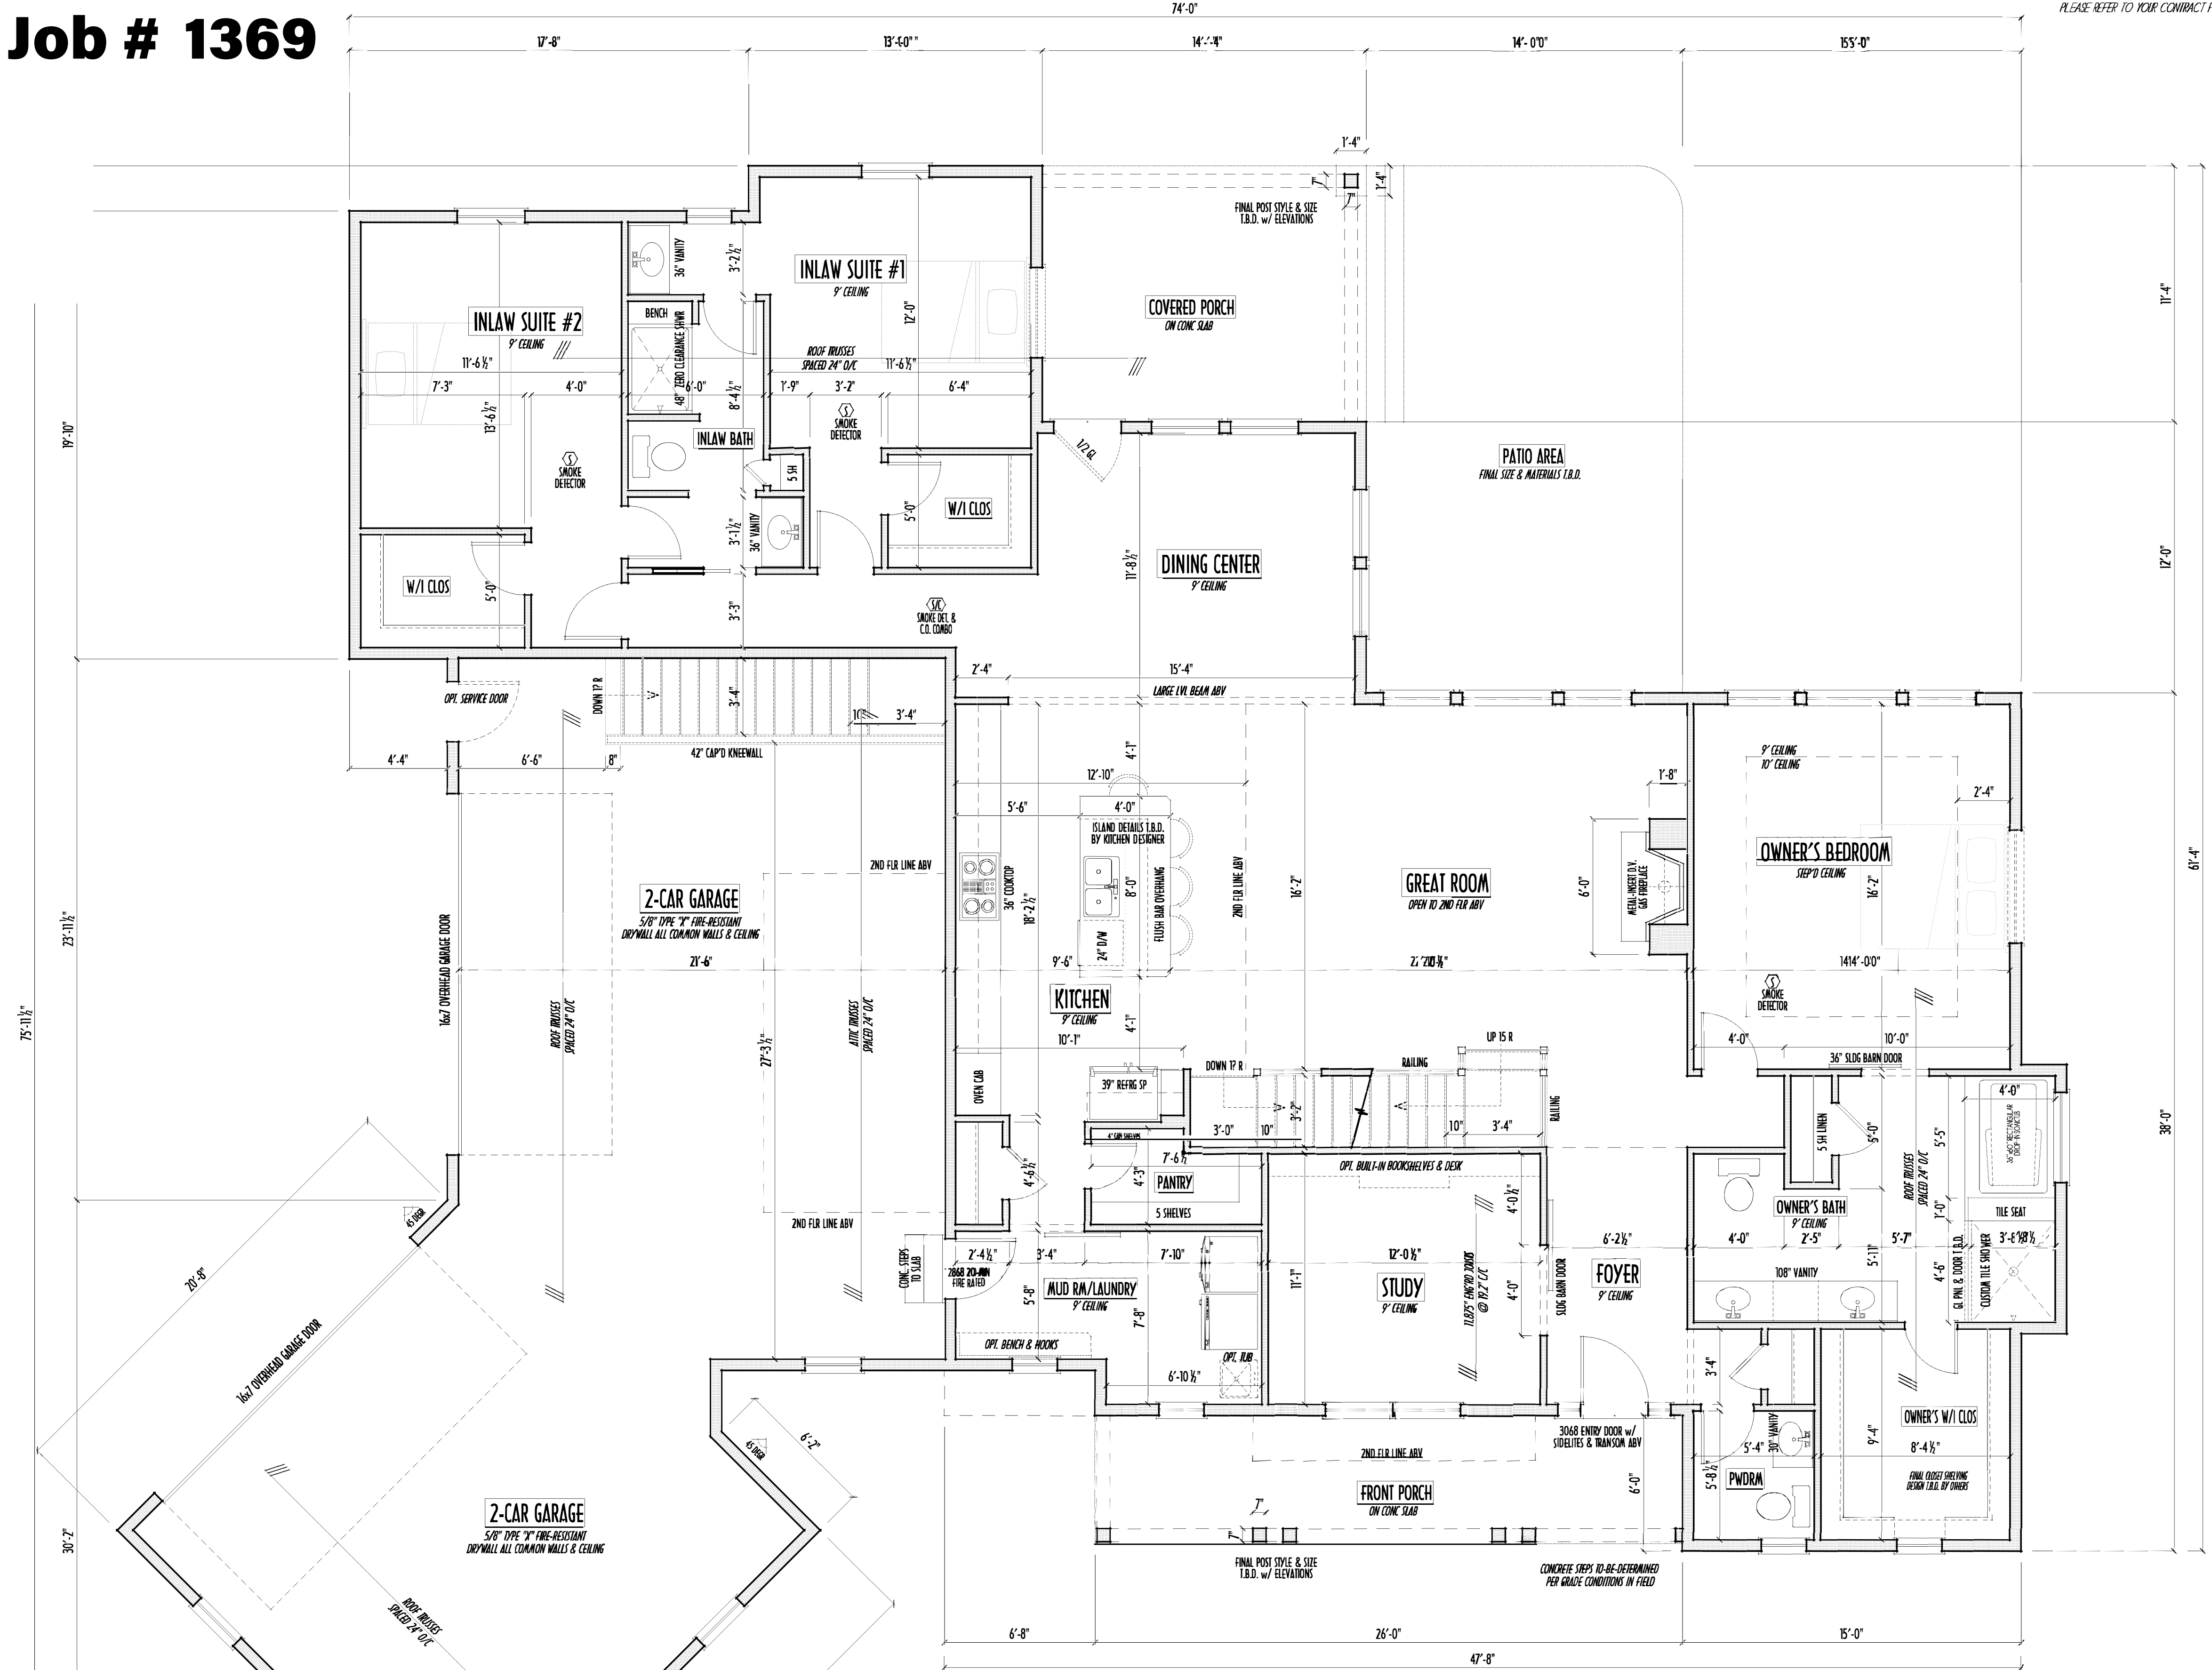

FIRST FLOOR PLAN
SCALE: 1/4" = 1'-0"

FIRST FLOOR CEILINGS AT 9'-1 1/8" UNLESS NOTED OTHERWISE
FIRST FLOOR WINDOWS HEADERS AT 7'-6" UNLESS NOTED OTHERWISE
CONTRACTORS TO SITE-VERIFY ALL DIMENSIONS AND REPORT ANY DISCREPANCIES WITH THE PLANS TO THE JOB SUPERVISOR ASAP
FIRST FLOOR DESIGN LIVE LOAD = 40 PSF
ALL FRAMING AND STRUCTURAL CONSTRUCTION IS TO CONFORM TO 2013 I.C.C. AND/OR APPLICABLE LOCAL CODES
WINDOWS & DOORS (BRAND & DESIGN) PER CONTRACT
CONFIRM WINDOW ROUGH-OPENINGS AND HEADER HGT'S w/ PROVIDER
CONFIRM FLOORING & FINISH MATERIALS w/ JOB SUPERVISOR (PER CONTRACT)
ALL DIMENSIONS CORRESPOND TO EITHER CENTERLINES OR CORNERS OF WOOD FRAMING LENGTHS AND/OR FENESTRATION
AVOID FLOORJOISTS LOCATED DIRECTLY BELOW PLUMBING DRAINS
BLOCK BETWEEN FLOORJOISTS BELOW STRUCTURAL POINTS (CRUSH ZONES)
BRACE FLOORJOISTS AT MIDSPAN PER CODE
INTERIOR DOORS SHOWN 4" OFF CORNERS UNLESS NOTED
NOTE: DIMENSIONS FOR ANGLED WALLS MAY CONTAIN ROUNDING ERRORS OF LESS THAN 1/8" TYPICALLY
FINAL/INSTALLED INSULATION VALUES SHOULD MATCH REA-RATE SHEETS FROM TACOMA ENERGY (THOSE SHOWN ON THESE PLANS ARE PRELIMINARY/REFERENCE ONLY)
INSTALL ALL LVL & LSL BEAMS WITH LABELS VISIBLE FOR BLDG INSPECTION

FIRST FLR LIVING SP =	2,437 SQ.FT.
SECOND FLR LIVING SP =	807 SQ.FT.
TOTAL LIVING SP =	3,244 SQ.FT.
OPT. FINISHED BSMT =	72 SQ.FT.

Danne
Residential Design & Drafting
614.207.6286 dannehd@gmail.com

REVISION DATE:	BY:	PROVIDED
11/30/16	rwd	concepts
12/2/16	---	concept rev
12/26/16	---	perms
1/10/17	y/r	perm rev
2/9/17	y/r	perm rev
3/3/17	rwd	per HOA

TO SCALE WHEN PRINTED 24"X36" - PAPER SIZE 11"
0 6 12 18 24 30 36 42 48 54 60
FIELD DIMENSIONS - DO NOT SCALE PLANS

DESIGNED: P&D / rwd

PAGE: 3 of 8

2ND FLR



P&D Builders Ltd.
59 Greif Parkway Suite 100
Suite 100
Delaware, Ohio 43015
(740) 201-8079
Fax (740) 201-8084
www.pndbuilders.com

ALL DIMENSIONS ARE THE GROSS MEASUREMENT OF THE BUILDING EXCEPT WHERE SHOWN OTHERWISE. THESE PLANS MAY BE MADE WITHOUT THEIR OWNERS' CONSENT OF THE DESIGN OF THE PLANS.


1369

PRELIMINARY DESIGN
NOT TO SCALE - NOT FOR CONSTRUCTION



Danne
Residential Design & Drafting
614.207.6286 dannehd@gmail.com


REVISION DATE:	BY:	DATE/CD
11/30/18	rwd	concept
12/2/18	" "	concept rev
12/26/18	" "	prelim
1/10/19	j/r	prelim rev
2/9/19	j/r	prelim rev
3/3/19	rwd	per HOA

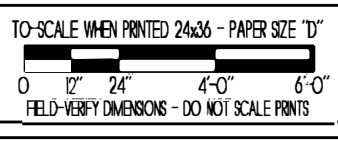

DESIGNED: P&D / rwd

PAGE : 4 of 8


FIRST FLR LIVING SP =	2,437 SQ.FT.
SECOND FLR LIVING SP =	807 SQ.FT.
TOTAL LIVING SP =	3,244 SQ.FT.
OPT. FINISHED BSMT =	72 SQ.FT.

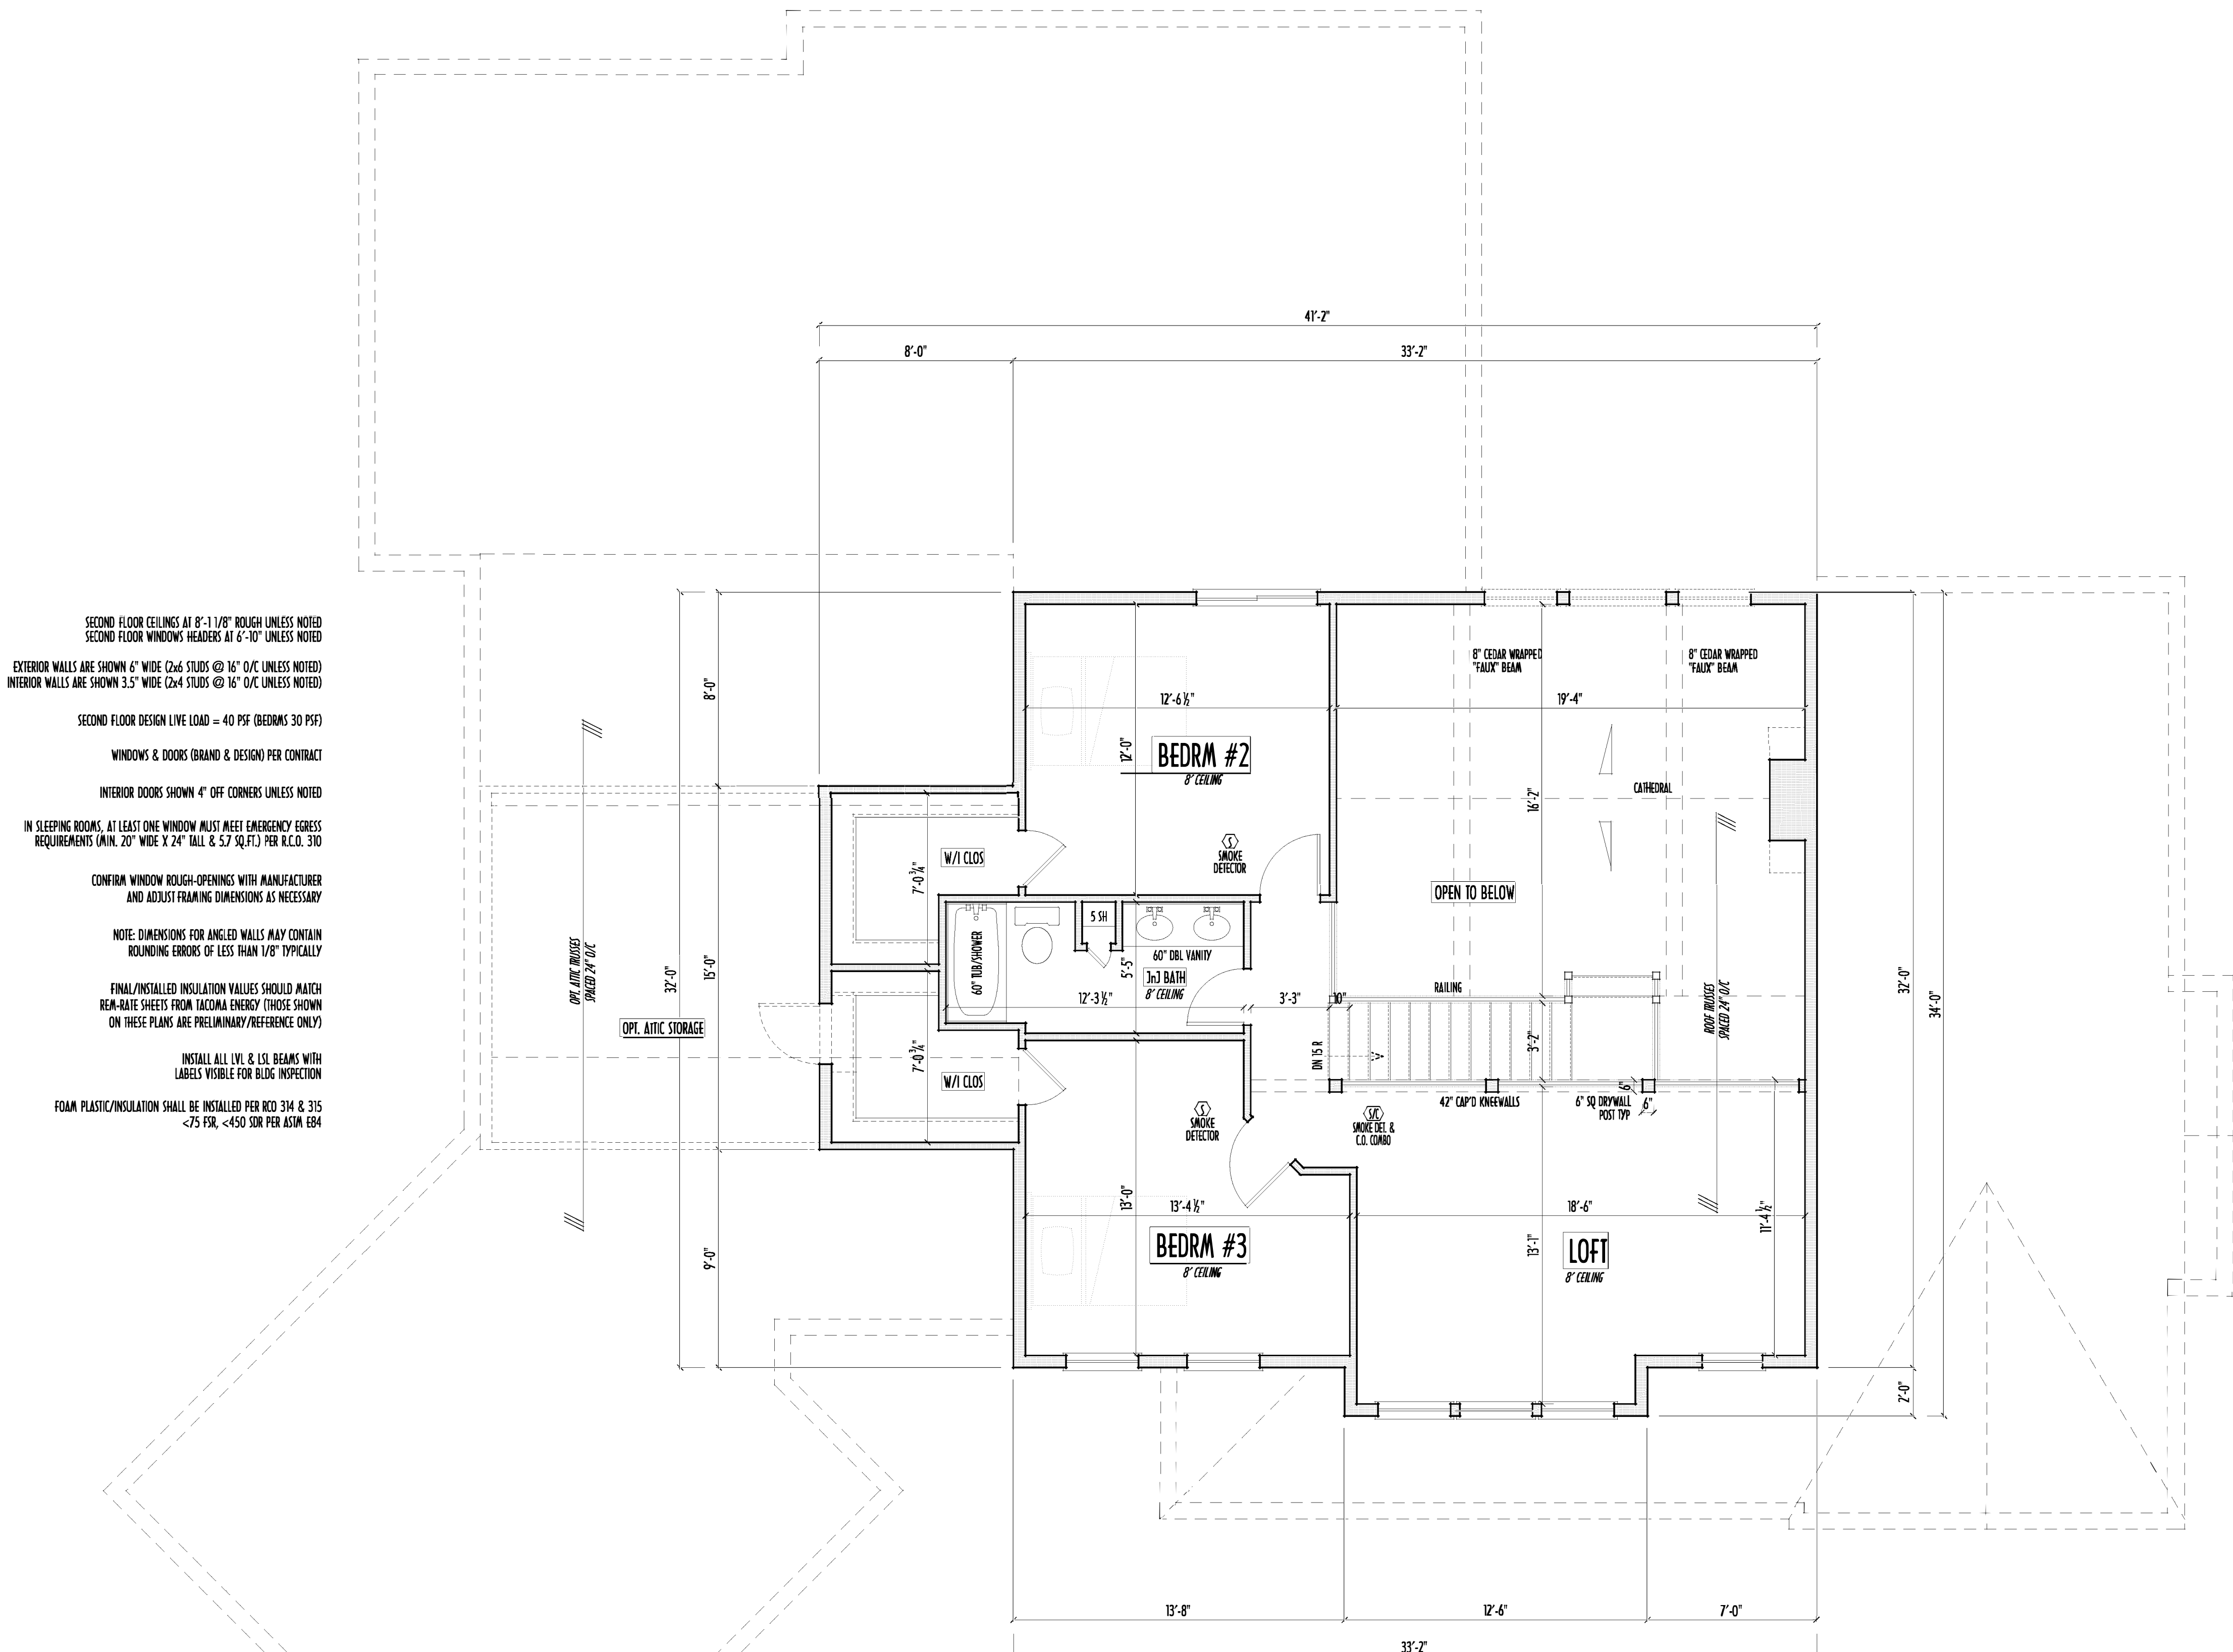

P&D Builders - Job # 1369

PLEASE NOTE: PRELIMINARY DESIGNS ARE SUBJECT TO CHANGE DUE TO STRUCTURAL OR CODE REQUIREMENTS. ITEMS SHOWN MAY BE OPTIONAL/EXTRA. PLEASE REFER TO YOUR CONTRACT FOR SPECIFICATIONS & DESCRIPTIONS.

FND/BSMT

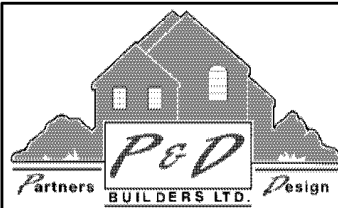

P&D Builders Ltd.
59 Greif Parkway Suite
Suite 100
Delaware, Ohio 43015
(740) 201-8079
Fax (740) 201-8084
www.pndbuilders.com

ALL STORIES ARE THE EXCLUSIVE PROPERTY OF P&D BUILDERS LTD.
NO REPRODUCTION OR COVER USE OF THESE PLANS MAY BE MADE
WITHOUT PRIOR WRITTEN CONSENT OF THE AUTHOR OF THE PLANS

1369


1369

PRELIMINARY DESIGN
NOT TO SCALE - NOT FOR CONSTRUCTION



614.207.6286 dannehd@gmail.com

REVISION DATE:	BY:	DATE:
11/30/18	rwd	concepts
12/2/18	---	concept rev
12/26/18	---	perms
1/10/19	y/r	perm rev
2/9/19	y/r	perm rev
3/3/19	rwd	per HOA

 


DESIGNED: P&D / rwd


PAGE : 2 of 8

FIRST FLR LIVING SP = 2,437 SQ.FT.
SECOND FLR LIVING SP = 807 SQ.FT.
TOTAL LIVING SP = 3,244 SQ.FT.
OPT. FINISHED BSMT = 72 SQ.FT.

FOUNDATION / BASEMENT PLAN
SCALE : 1/4" = 1'-0"

- MAX. UNBALANCED FILL FOR 8" THICK POURED CONC. WALL OR C.M.U. BLOCK WALL = 7'-0" ABOVE SLAB
- WATERPROOFING / DAMPROOFING PER CODE
- ALL STRUCTURAL LUMBER IS MIN. CANADIAN SPECIES #2 SPRUCE-PINE-FIR, UNLESS NOTED OTHERWISE
- FIRST FLOOR DESIGN LIVE LOAD = 40 PSF
- BASEMENT ELECTRICAL LAYOUT FOR REFERENCE ONLY - CONSULT WITH HOMEOWNER PRIOR TO INSTALLATION FOR EXACT LOCATIONS
- GRADE MIN. 8" BELOW TOP OF FOUNDATION, SLOPING AWAY FOR PROPER DRAINAGE MIN. 6" DROP IN FIRST 10FT OF RUN
- AVOID FLOORJOISTS LOCATED DIRECTLY BELOW PLUMBING DRAINS & TRAPS
- BLOCK BETWEEN FLOORJOISTS BELOW STRUCTURAL POINTS (CRUSH ZONES) WITH APPROPRIATE 2X FILL
- SEE COVER SHEET FOR GENERAL FOUNDATION CONSTRUCTION NOTES
- STEP DOWN FOOTING AS NECESSARY TO REMAIN MIN. 36" BELOW GRADE
- USE PRES-TREATED EXTERIOR-GRADE LUMBER WHERE EXPOSED TO WEATHER OR IN CONTACT WITH CONCRETE
- FOUNDATION WALL ENGINEERING & REINFORCEMENT PER SHEPHERD EXCAVATING DESIGN-DETAIL RC-16
- INSTALL ALL LVL & LSL BEAMS WITH LABELS VISIBLE FOR BLDG INSPECTION

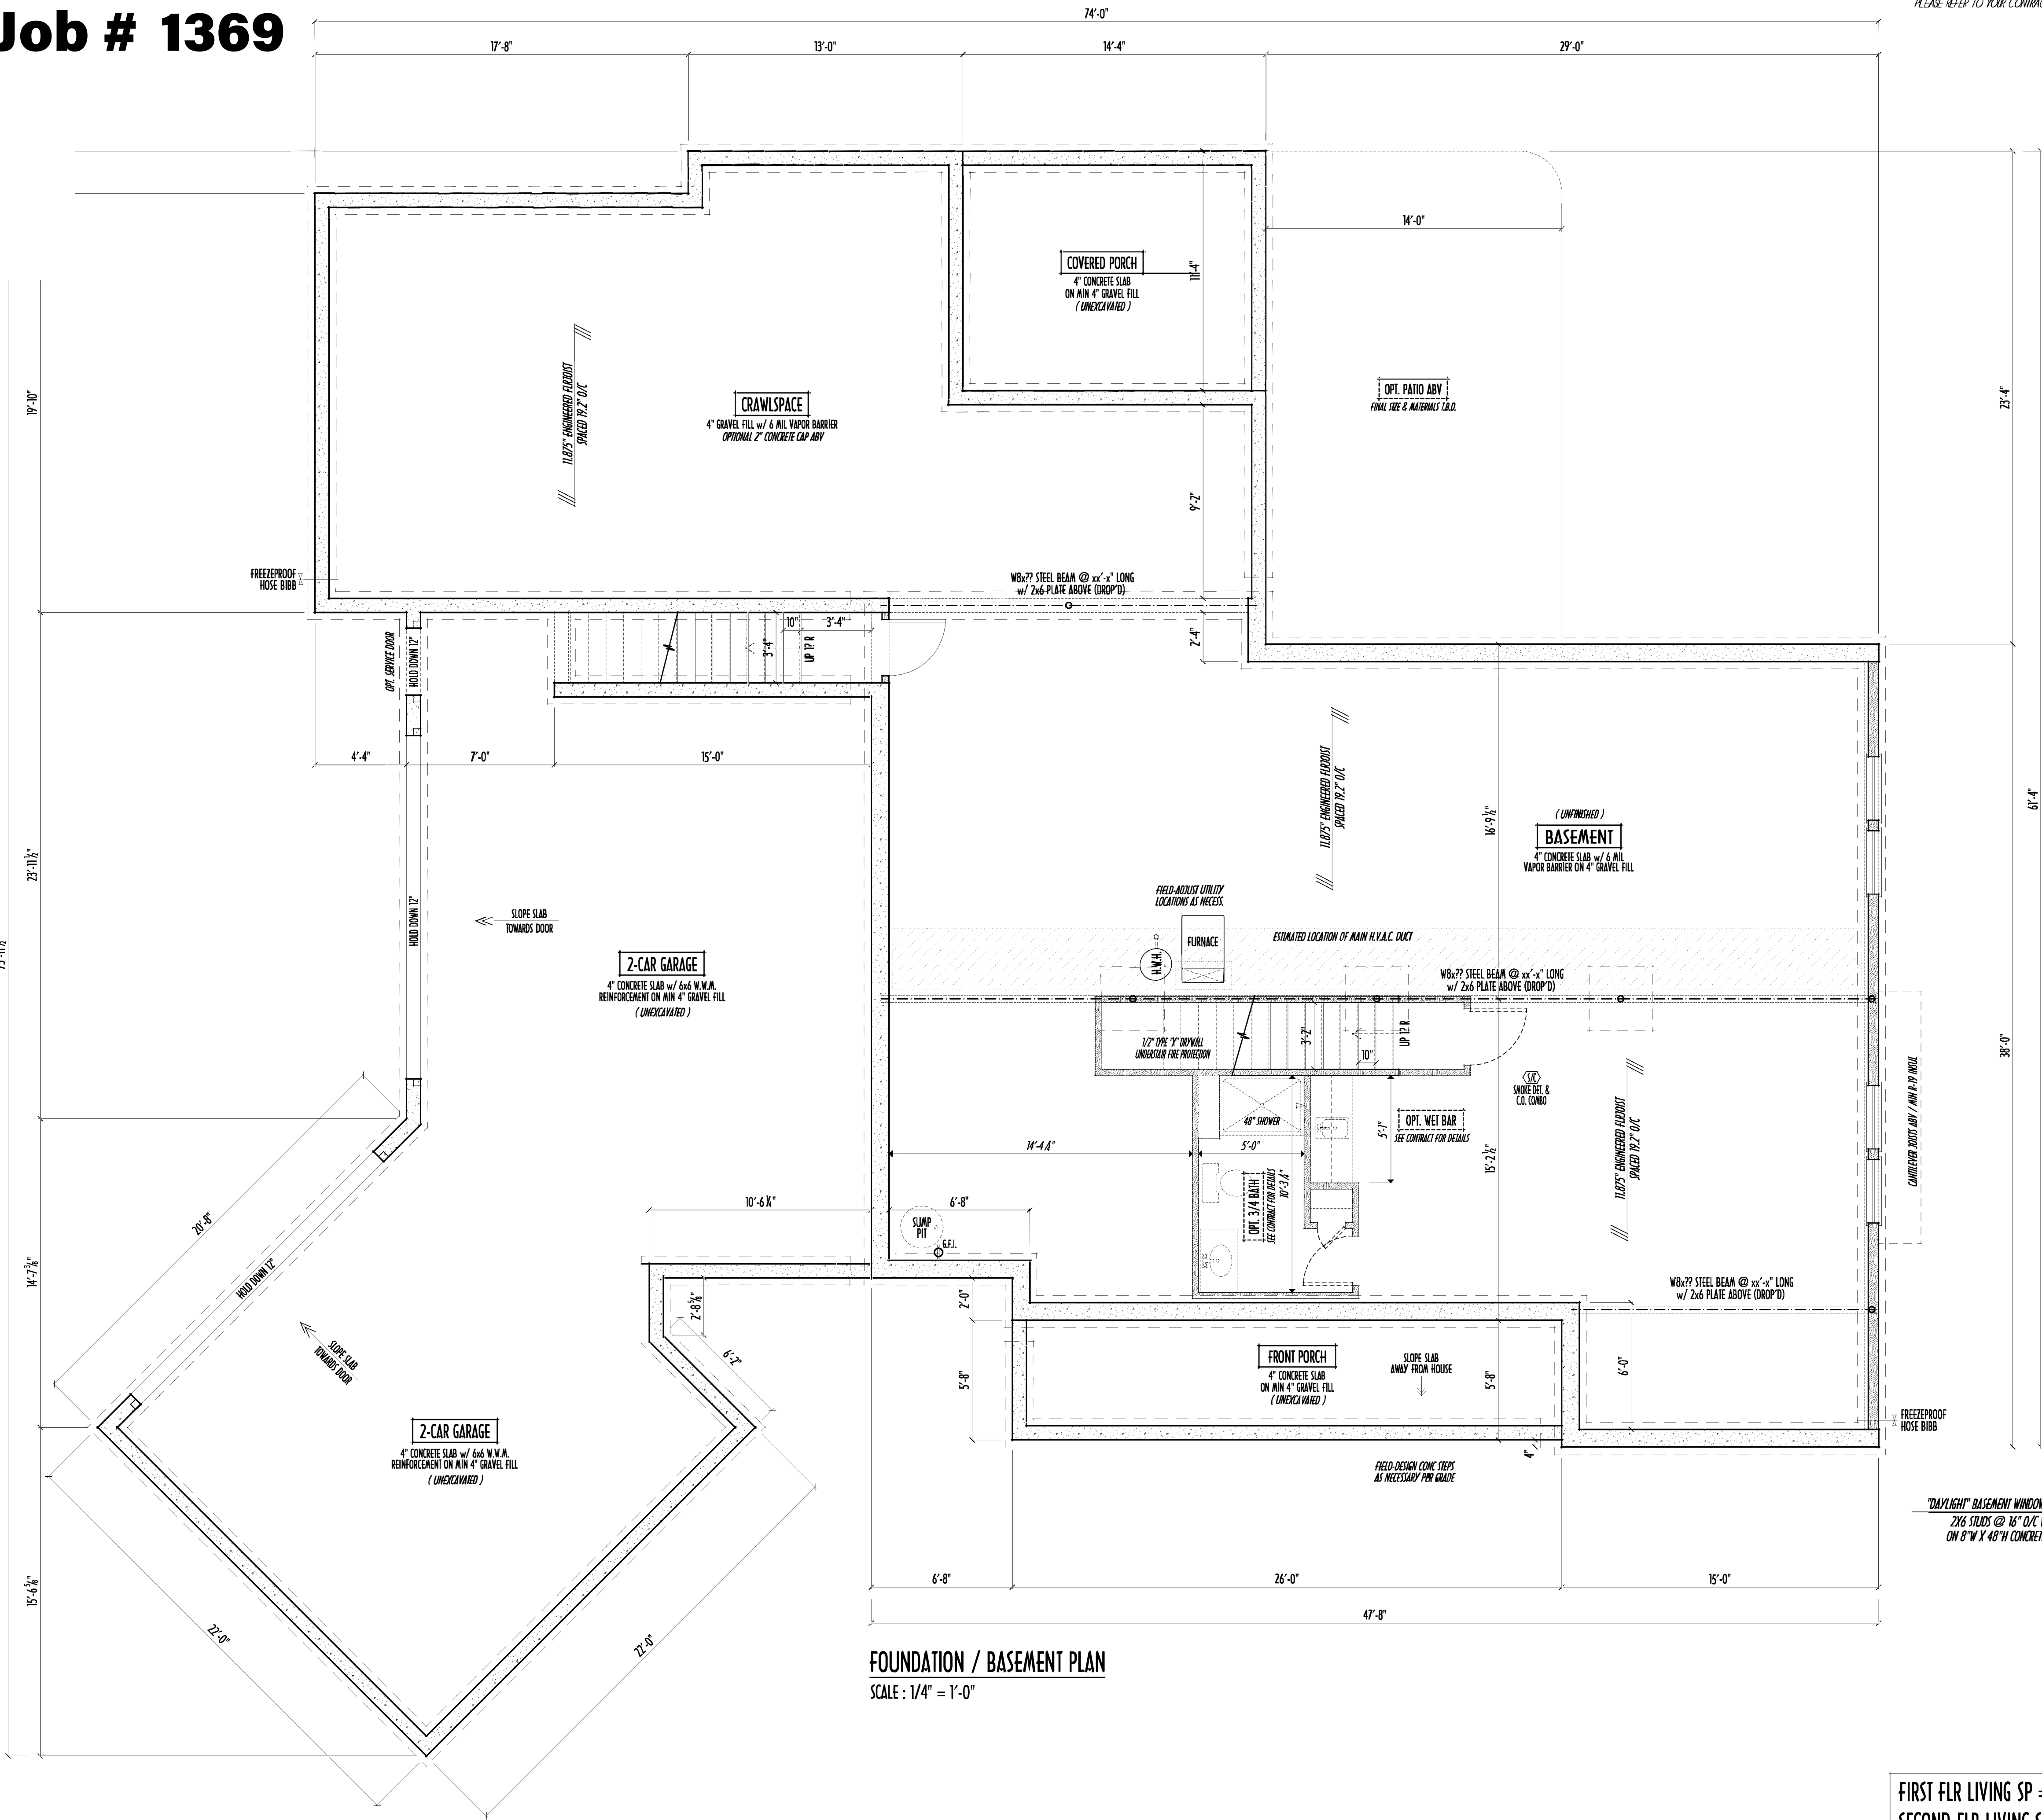


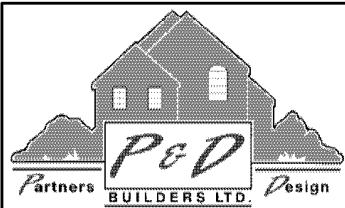

P&D Builders Ltd.
59 Greif Parkway Suite 100
Delaware, Ohio 43015
(740) 201-8079
Fax (740) 201-8084
www.pndbuilders.com


ALL DRAWINGS ARE THE EXCLUSIVE PROPERTY OF P&D BUILDERS LTD.
NO REPRODUCTION OR CONSTRUCTION OF THESE PLANS MAY BE MADE
WITHOUT THE WRITTEN CONSENT OF THE AUTHOR OF THE PLANS.

PRELIMINARY DESIGN
NOT TO SCALE - NOT FOR CONSTRUCTION

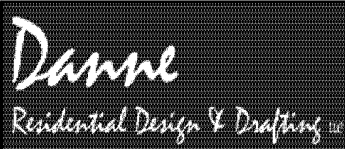

Danne
Residential Design & Drafting
614.207.6286 dannehd@gmail.com

REVISION DATE:		BY:	DATE:
11/30/18	rdw	concept	
12/2/18	rdw	concept rev	
12/26/18	rdw	prelim	
1/10/19	rdw	prelim rev	
2/9/19	rdw	prelim rev	
3/3/19	rdw	per HOA	

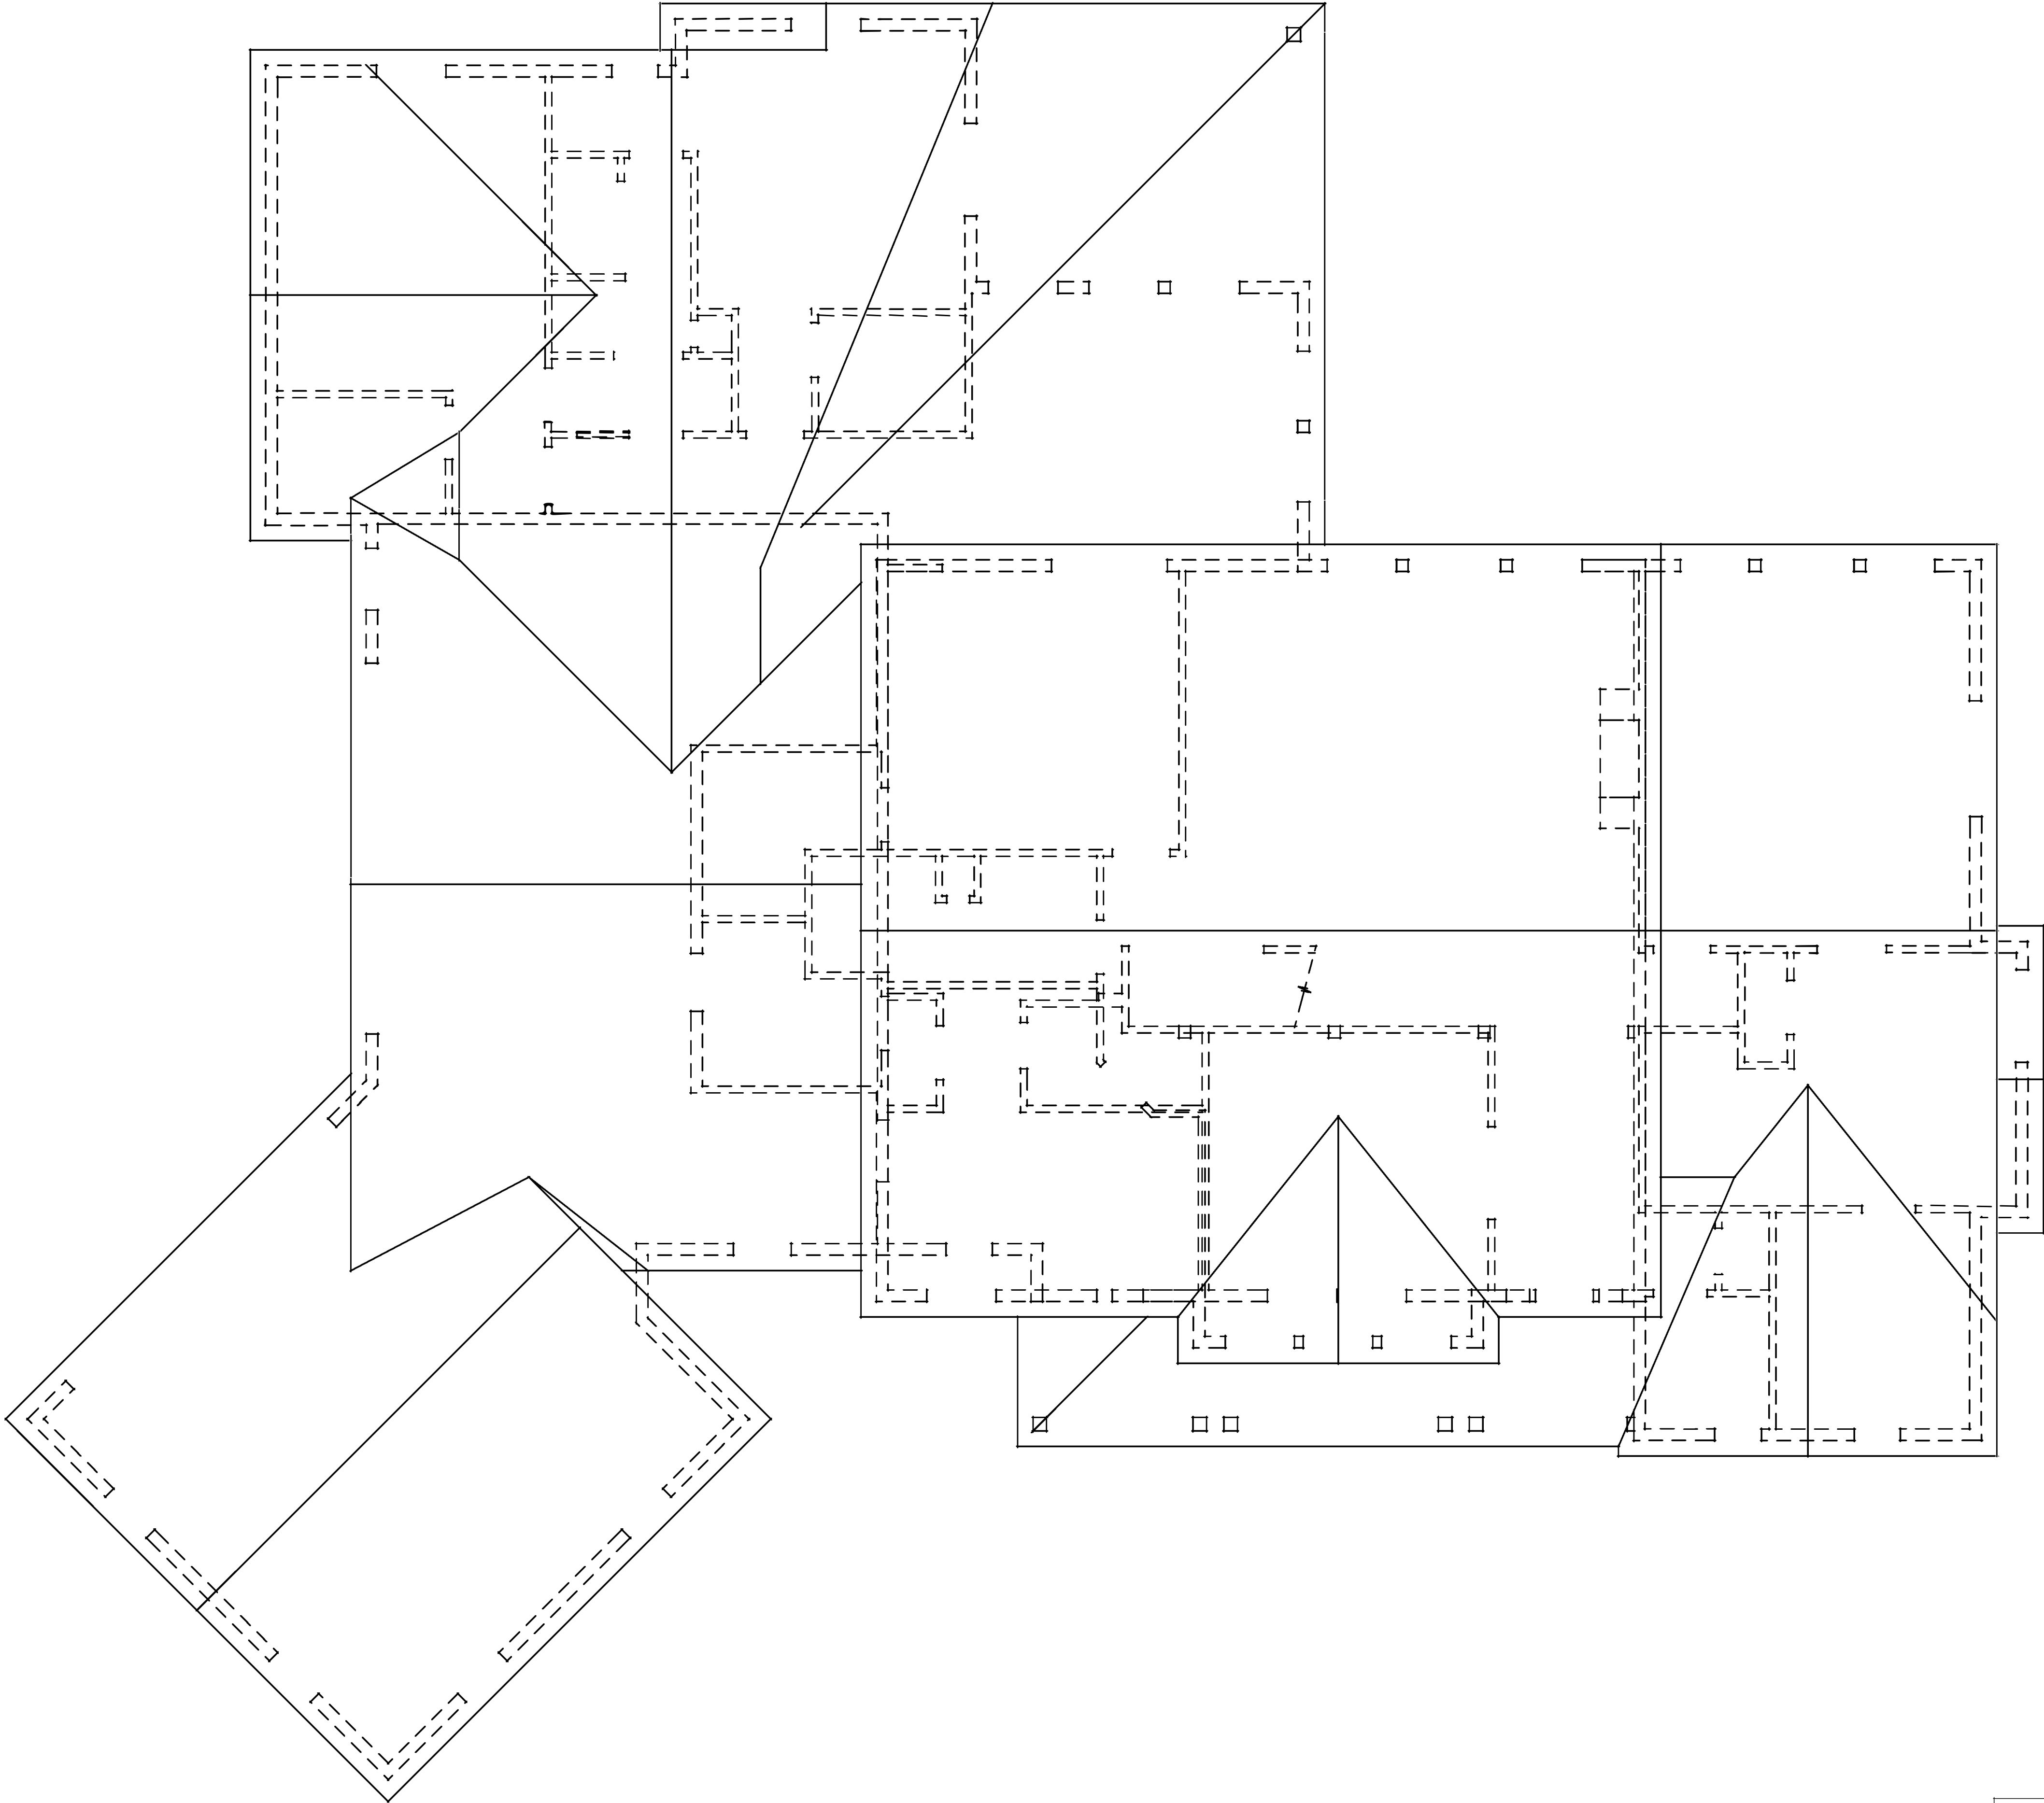

FIRST FLR LIVING SP =	2,437 SQ.FT.
SECOND FLR LIVING SP =	807 SQ.FT.
TOTAL LIVING SP =	3,244 SQ.FT.
OPT. FINISHED BSMT =	72 SQ.FT.