
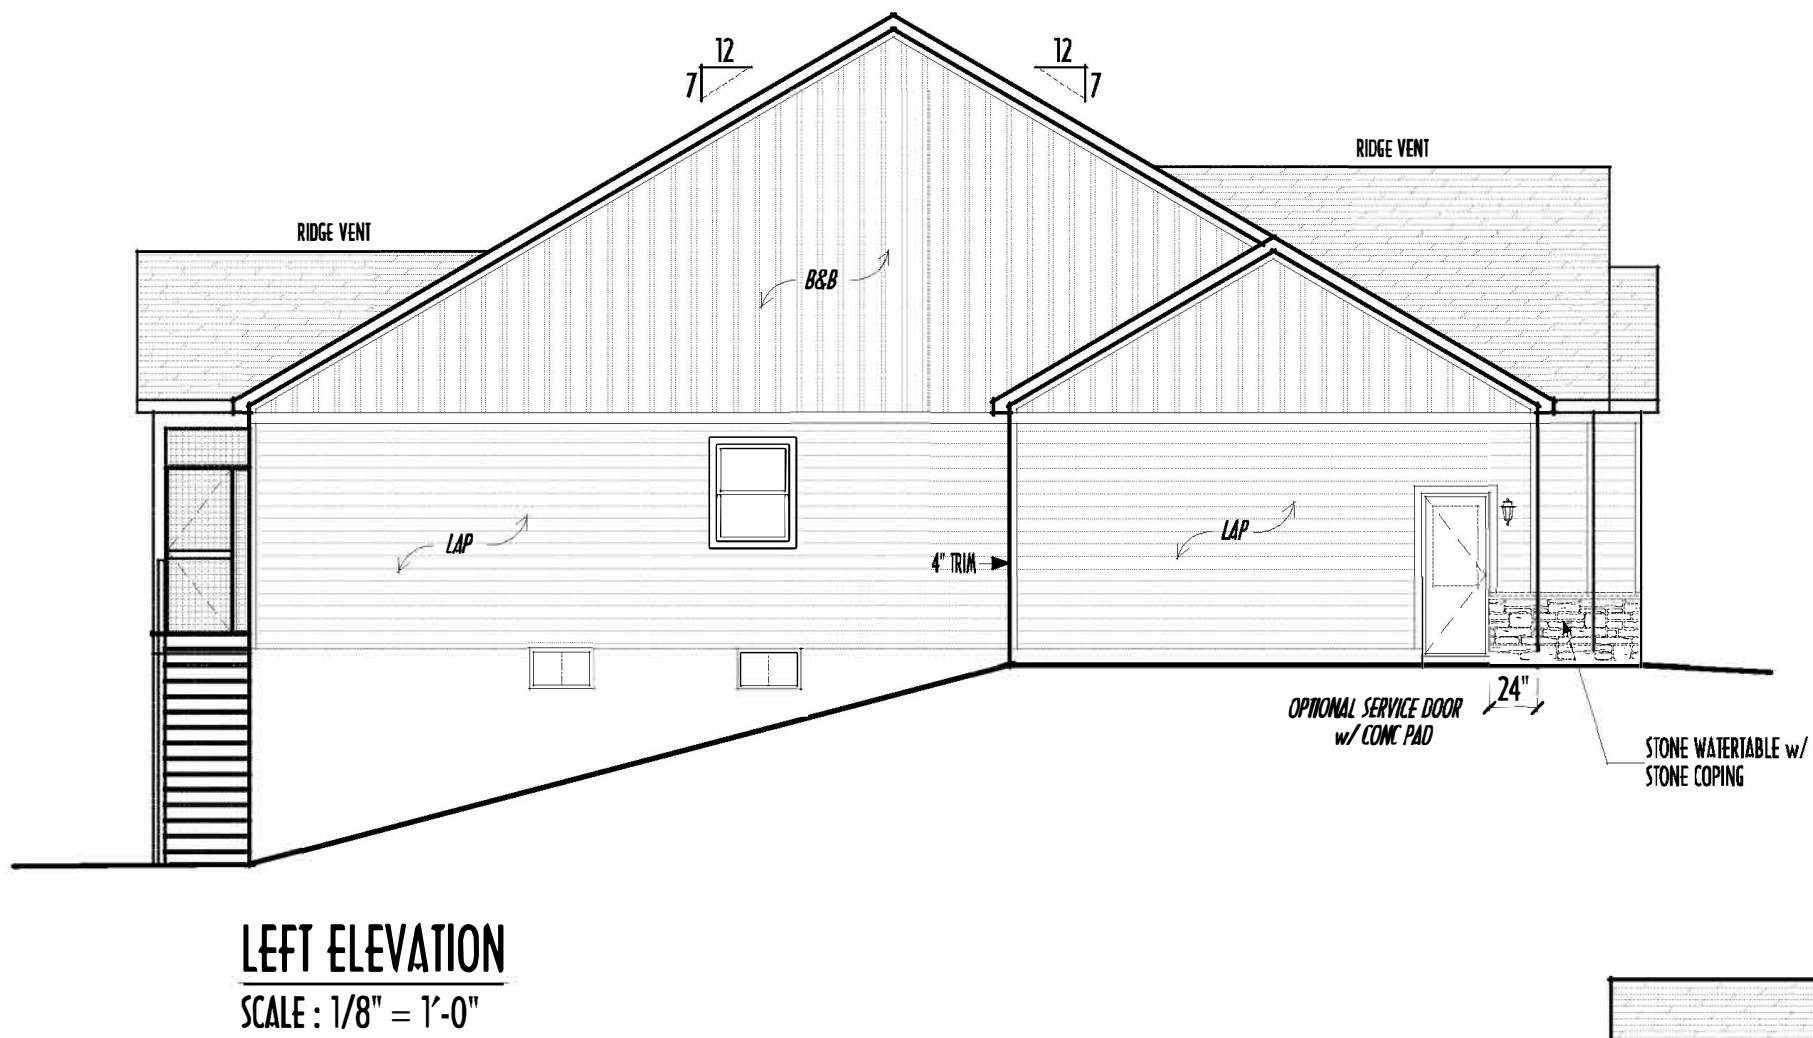
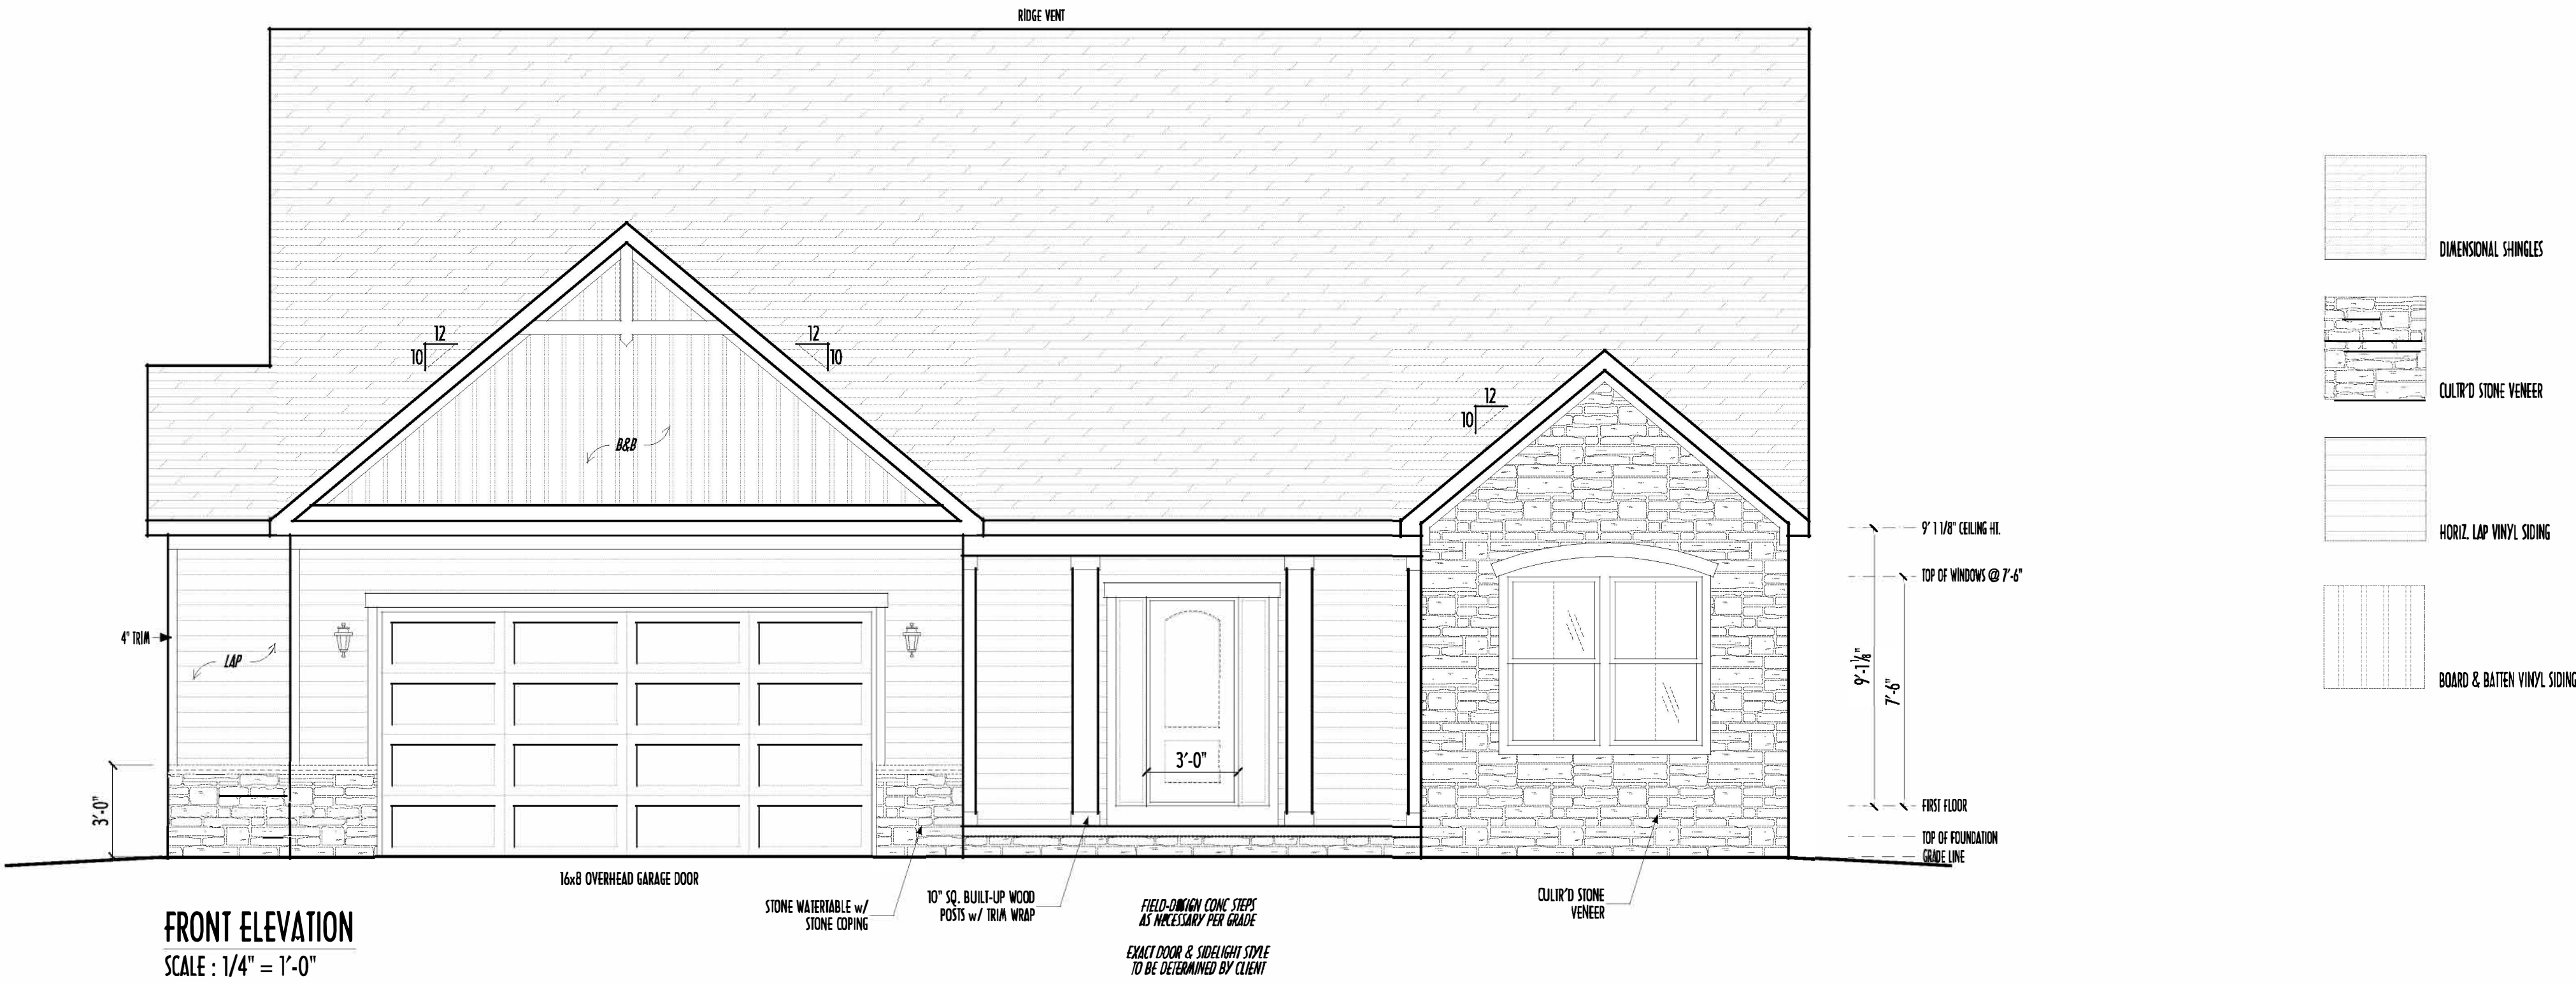




P&D Builders - Job #1664

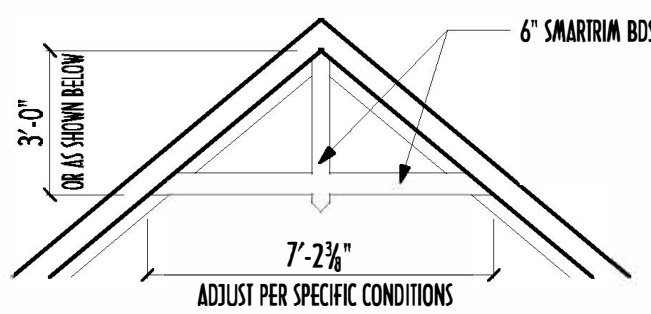

FINAL WINDOW DESIGN PER PROVIDER. ALL FRAMING ROUGH-OPENINGS TO BE BASED ON FINAL LAYOUT ONLY

EXACT WINDOW & DOOR GRID PATTERNS (MULLIONS) MAY DIFFER - REFER TO MANUFACTURER OR SUPPLIER

GRADE ELEVATION SHOWN IS APPROXIMATE. FIELD VERIFY & ADJUST FOUNDATION AS NECESSARY

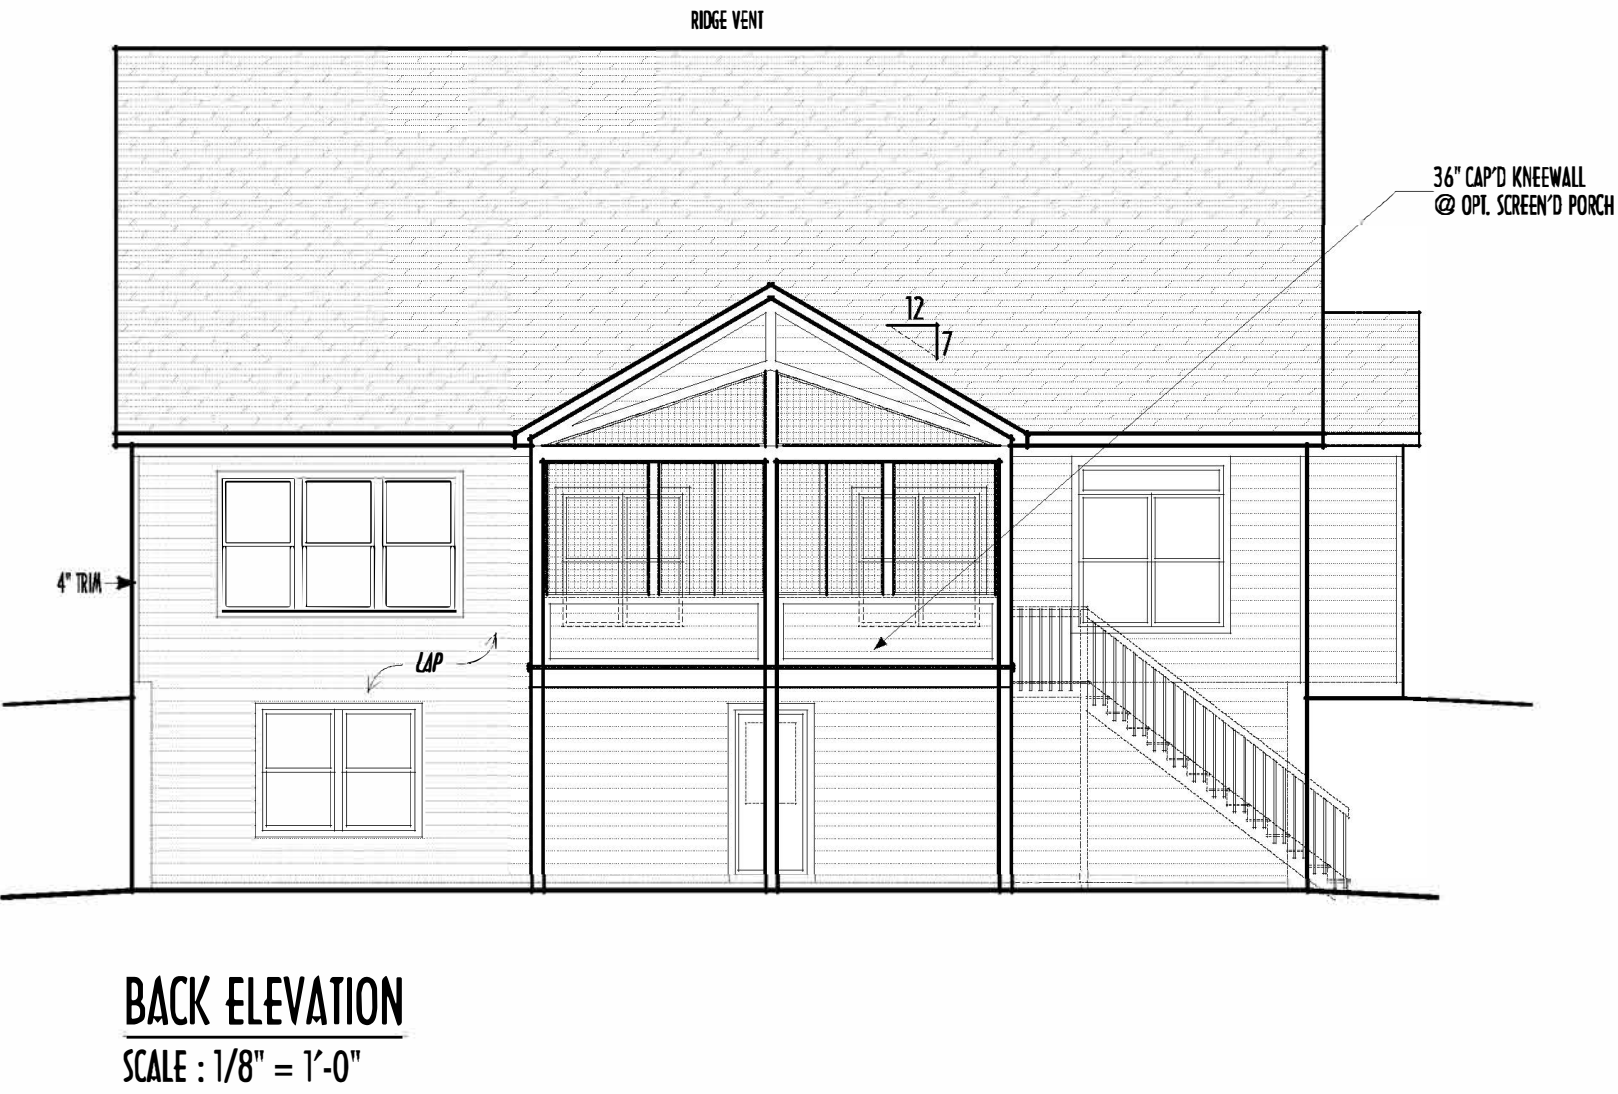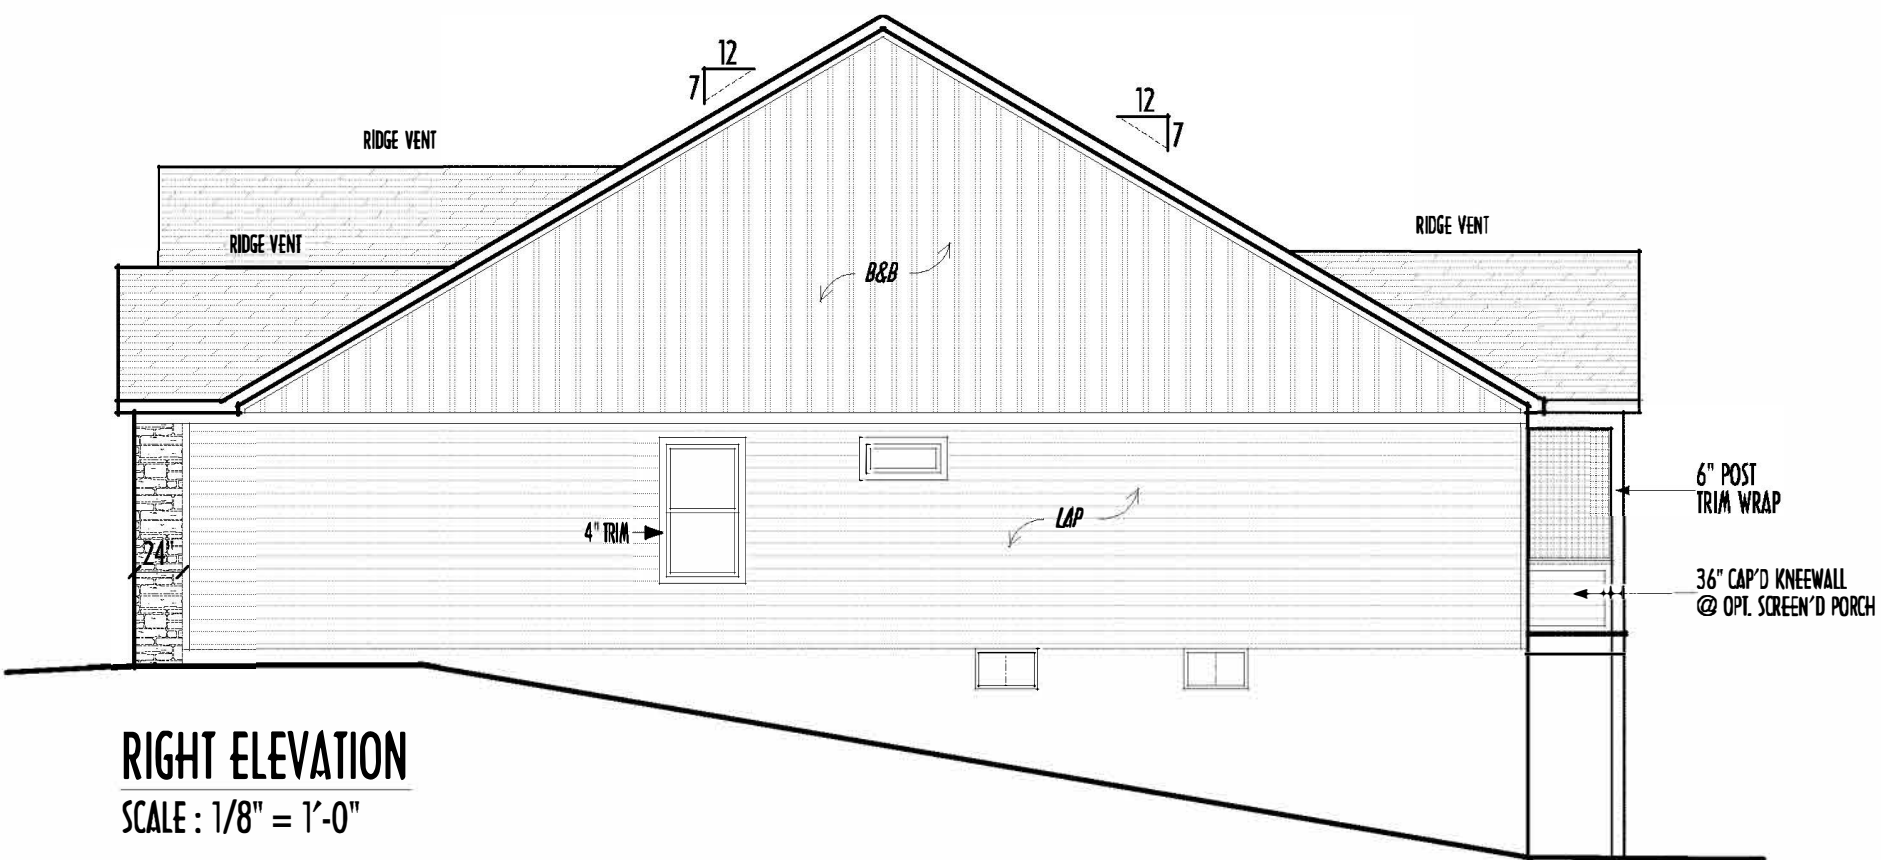

FIRST FLOOR CEILINGS @ 9'-1 1/8" UNLESS NOTED OTHERWISE
FIRST FLOOR WINDOW HEADERS @ 7'-6" UNLESS NOTED OTHERWISE

EMERGENCY EGRESS OPERABLE (E.E.O.) WINDOWS IN ALL BEDROOMS

SEE ROOF PLAN FOR SOFFIT & RAKE SIZES

CULTURED STONE VENEER WRAPS FRONT CORNERS MIN 6" INTO 1X6 WOOD TRIM UNLESS NOTED

FLASH & CAULK ELEVATIONS AS NECESSARY TO PROVIDE A WEATHER-TIGHT SEAL BETWEEN MATERIALS, FRAMING & TRIM

WINDOWS & DOORS (BRAND & DESIGN) PER CONTRACT

WINDOWS & DOORS ARE TO BE INSTALLED PER MANUFACTURERS SPECIFICATIONS. CONFIRM WINDOW SIZES & ROUGH-OPENINGS WITH SUPPLIER

RUN STUCCO, STONE & BRICK VENEER TO GRADE UNLESS NOTED

WEEP SCREENS FOR STUCCO EXTERIORS SHALL COMPLY WITH R-703.6.2.1 (#26 GALV CORROSION-RESISTANT SCREEN AT/ABV FOUNDATION PLATE (3.5" FLANGE) PLACED AT MIN 4" ABV EARTH / 2" ABV PAVING, ALLOWING TRAP'D WATER TO DRAIN)

SLOPE GRADE AWAY FROM FOUNDATION FOR PROPER DRAINAGE

FIRST FLOOR = 2,001 SQ.FT.
OPT FIN. BSMT = xxx SQ.FT.



ELEVATIONS

P&D Builders Ltd.
59 Great Parkway Suite 100
Delaware, Ohio 43015
(740) 201-8079
Fax (740) 201-8084
www.pndbuilders.com

ALL DESIGNS ARE THE SOLE PROPERTY OF P&D BUILDERS LTD. NO REPRODUCTION OR COPIES OF THESE DRAWINGS ARE ALLOWED WITHOUT THE WRITTEN CONSENT OF THE DESIGNER OF THE PLAN.

P&D JOB #1664

DATE: 03/14/2024 7:25 AM

RONALD W. DANNE
1717085
REGISTERED ARCHITECT

RONALD W. DANNE LICENSE #1070285
EXPIRATION DATE 12/31/2025

Danne
Residential Design & Drafting LLC
614.207.6266 dannehd@gmail.com


REVISION DATE	BY	PROJECT
1/8/24	rwg	concepts
1/29/24	rwg	prelims
2/7/24	rwg	prelims
2/7/24	rwg	prelims
2/7/24	rwg	prelims
3/1/24	rwg	prelims

TO SCALE: WHEN PRINTED 24x36 - PAPER SIZE: 11x17
0' 10' 20' 30' 40' 50' 60' 70' 80' 90' 100'
1" = 10'-0" (1" = 10'-0")

DESIGNED: P&D / rwd

PAGE: 4 of 8

P&D Builders - Job #1664

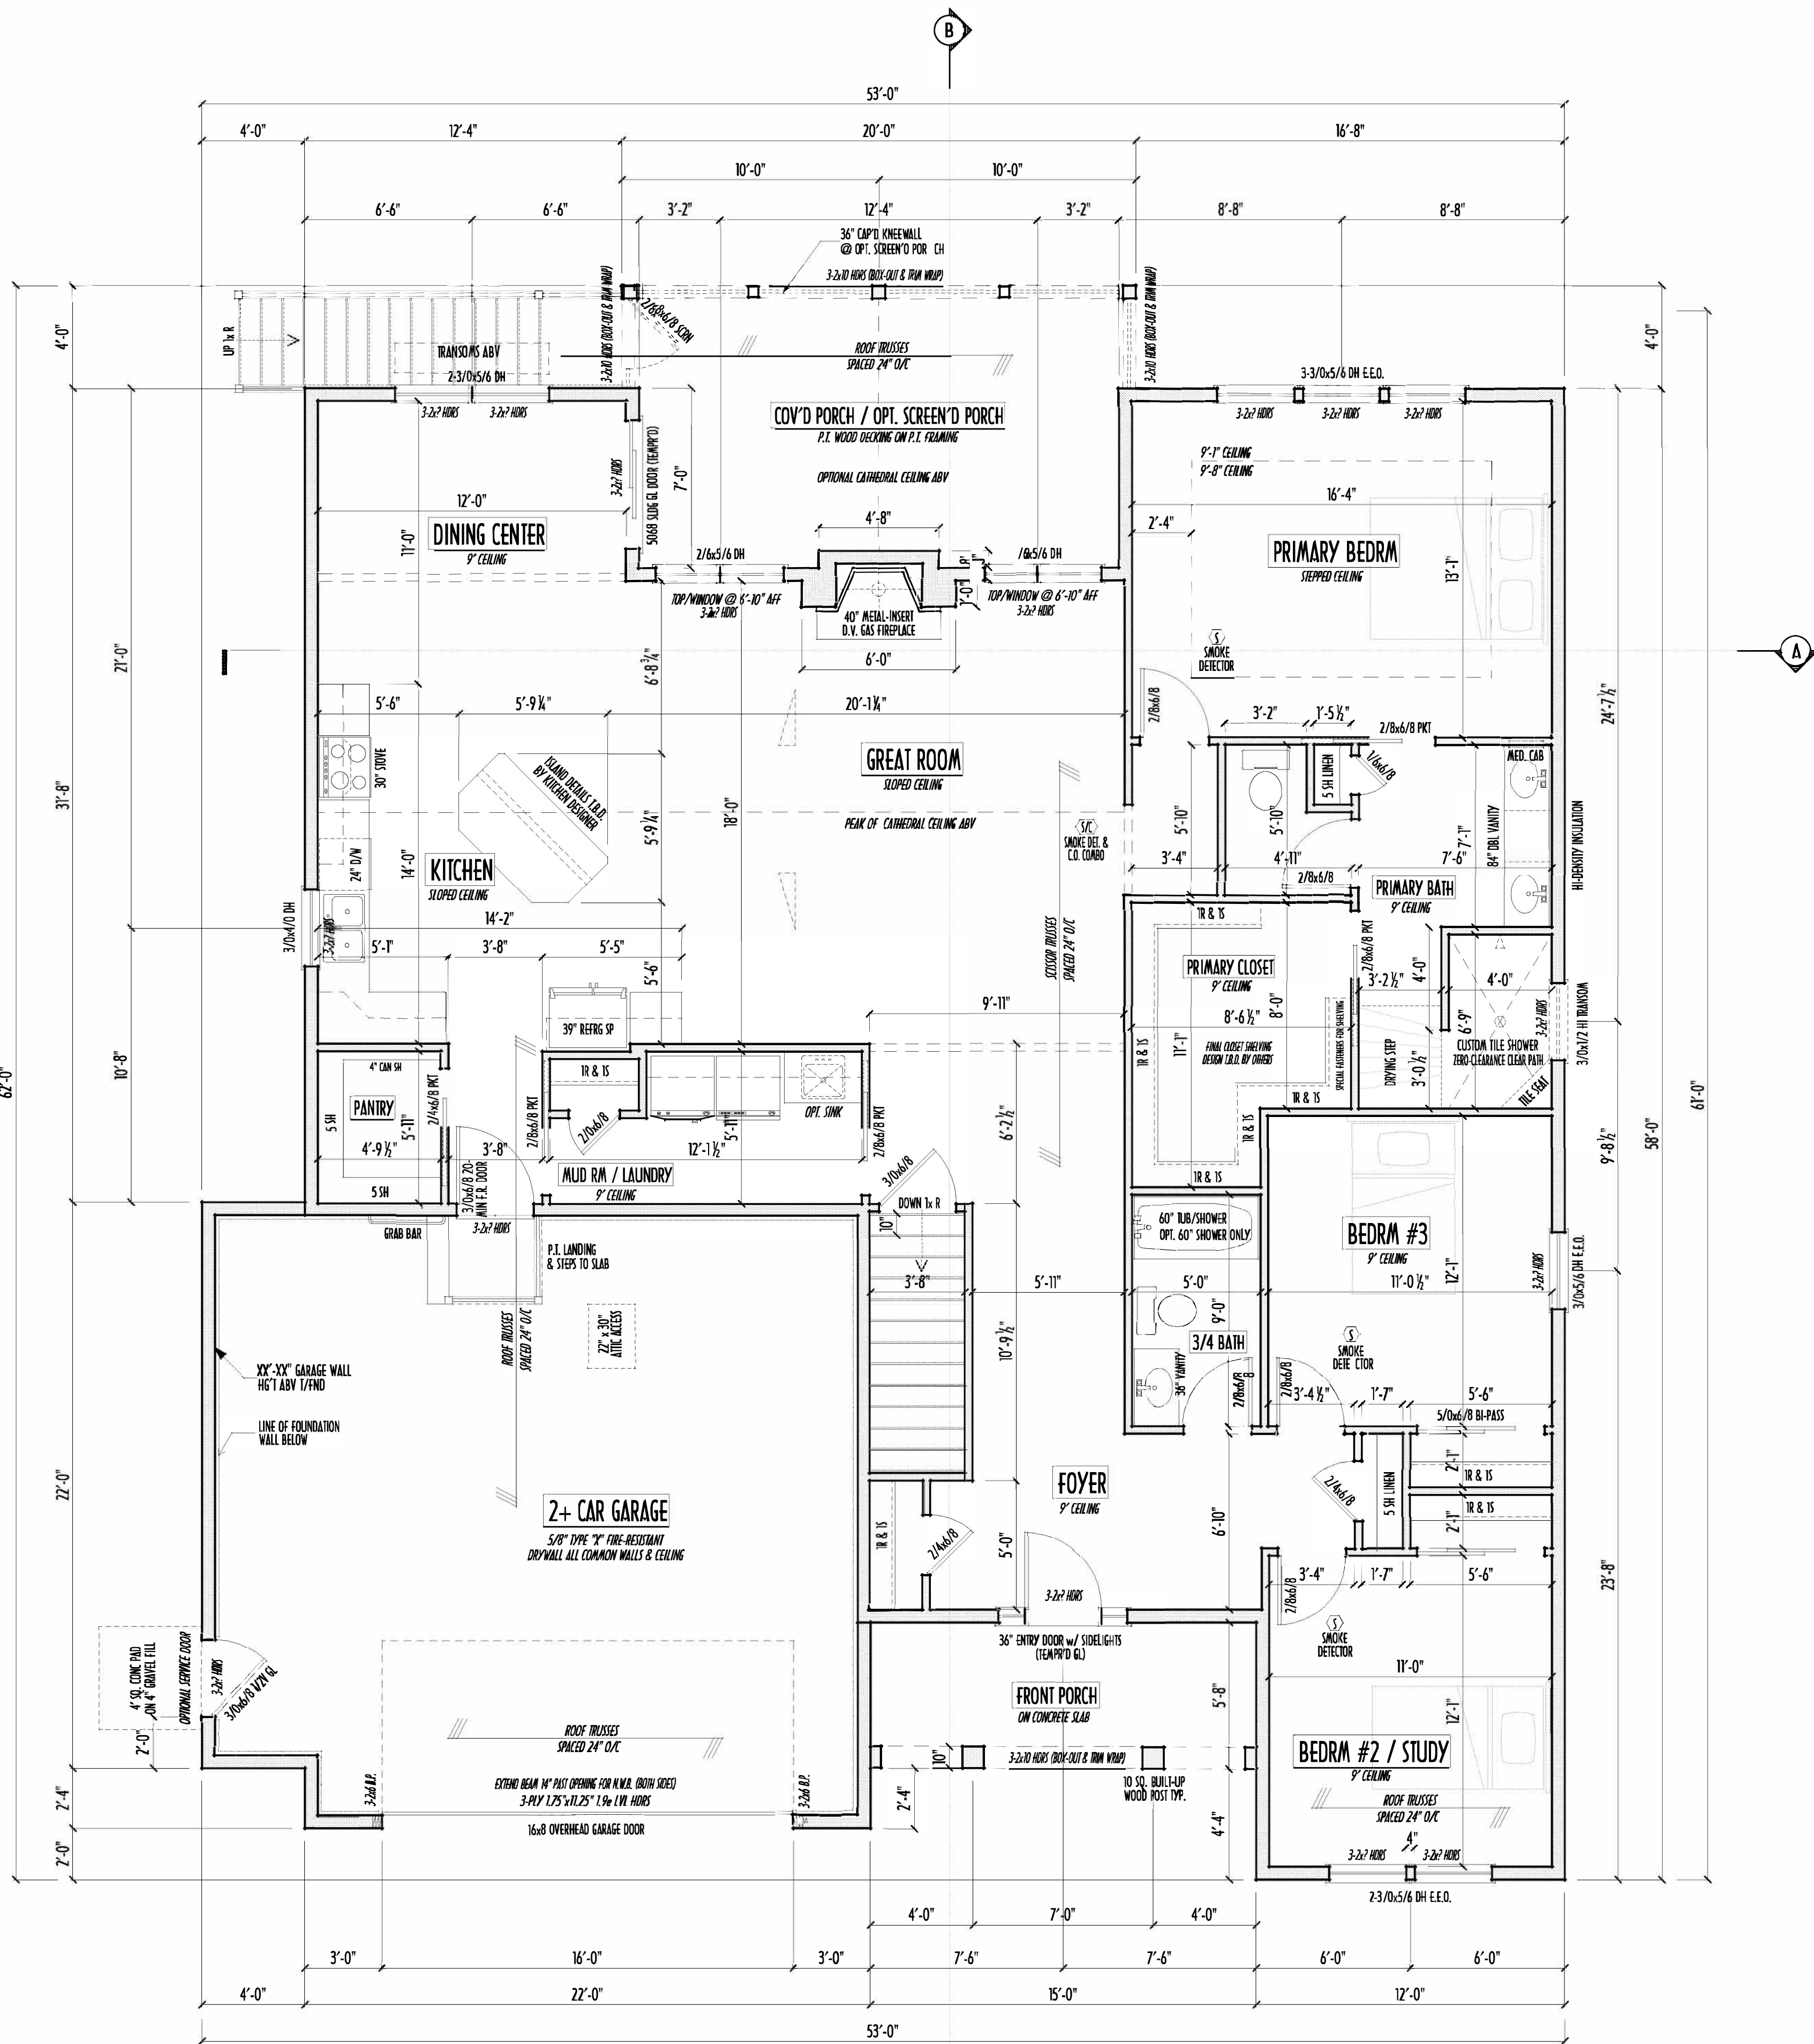

FIRST FLOOR PLAN
SCALE: 1/4" = 1'-0"



FIRST FLOOR =
OPT FIN. BSMT =

2,001 SQ.FT.
xxx SQ.FT.

1ST FLR

P&D Builders Ltd.
59 Great Parkway Suite 100
Delaware, Ohio 43015
(740) 201-8079
Fax (740) 201-8084
www.pndbuilders.com

ALL DESIGN ARE THE SOLE PROPERTY OF P&D BUILDERS LTD.
NO REPRODUCTION OR OTHER USE OF THESE PLANS ARE ALLOWED WITHOUT THE WRITTEN CONSENT OF THE DESIGNER OF THE PLANS.

1664

1664

STATE OF OHIO
REGISTERED ARCHITECT
RONALD W. DANNIE
1717085

RONALD W. DANNIE LICENSE #007085
EXPIRATION DATE 03/31/2025

Danne
Residential Design & Drafting
614.207.6266
dannedd@gmail.com

REVISION DATE	BY	REVISION
1/8/24	1/2/24	rwg concepts
1/29/24	rwg	prelims
2/2/24	2/3/24	prelims rev
2/7/24	1/1	prelims rev
2/7/24	2/20/24	prelims rev
3/1/24	1/1	prelims rev

1/4" = 1'-0"


DESIGNED: P&D / rwd

PAGE: 3 of 8


P&D Builders - Job #1664



- MAX. UNBALANCED FILL FOR 8" THICK POURED CONC. WALL OR C.M.U. BLOCK WALL = 7'-0" ABOVE SLAB
- WATERPROOFING / DAMPROOFING PER CODE
- ALL STRUCTURAL LUMBER IS MIN. CANADIAN SPECIES #2 SPRUCE-PINE-FIR, UNLESS NOTED OTHERWISE
- FIRST FLOOR DESIGN LIVE LOAD = 40 PSF
- BASEMENT ELECTRICAL LAYOUT FOR REFERENCE ONLY - CONSULT WITH HOMEOWNER PRIOR TO INSTALLATION FOR EXACT LOCATIONS
- GRADE MIN. 8" BELOW TOP OF FOUNDATION, SLOPING AWAY FOR PROPER DRAINAGE MIN. 6" DROP IN FIRST 10' OF RUN
- AVOID FLOORJOISTS LOCATED DIRECTLY BELOW PLUMBING DRAINS & TRAPS
- BLOCK BETWEEN FLOORJOISTS BELOW STRUCTURAL POINTS (CUSH ZONES) WITH APPROPRIATE 2X FILL
- SEE COVER SHEET FOR GENERAL FOUNDATION CONSTRUCTION NOTES
- STEP DOWN FOOTING AS NECESSARY TO REMAIN MIN. 36" BELOW GRADE
- USE PRES-TREATED EXTERIOR-GRADE LUMBER WHERE EXPOSED TO WEATHER OR IN CONTACT WITH CONCRETE
- FOUNDATION WALL ENGINEERING & REINFORCEMENT PER SHEPHERD EXCAVATING DESIGN DETAIL RC-16
- INSTALL ALL LVL & LSL BEAMS WITH LABELS VISIBLE FOR BLDG INSPECTION

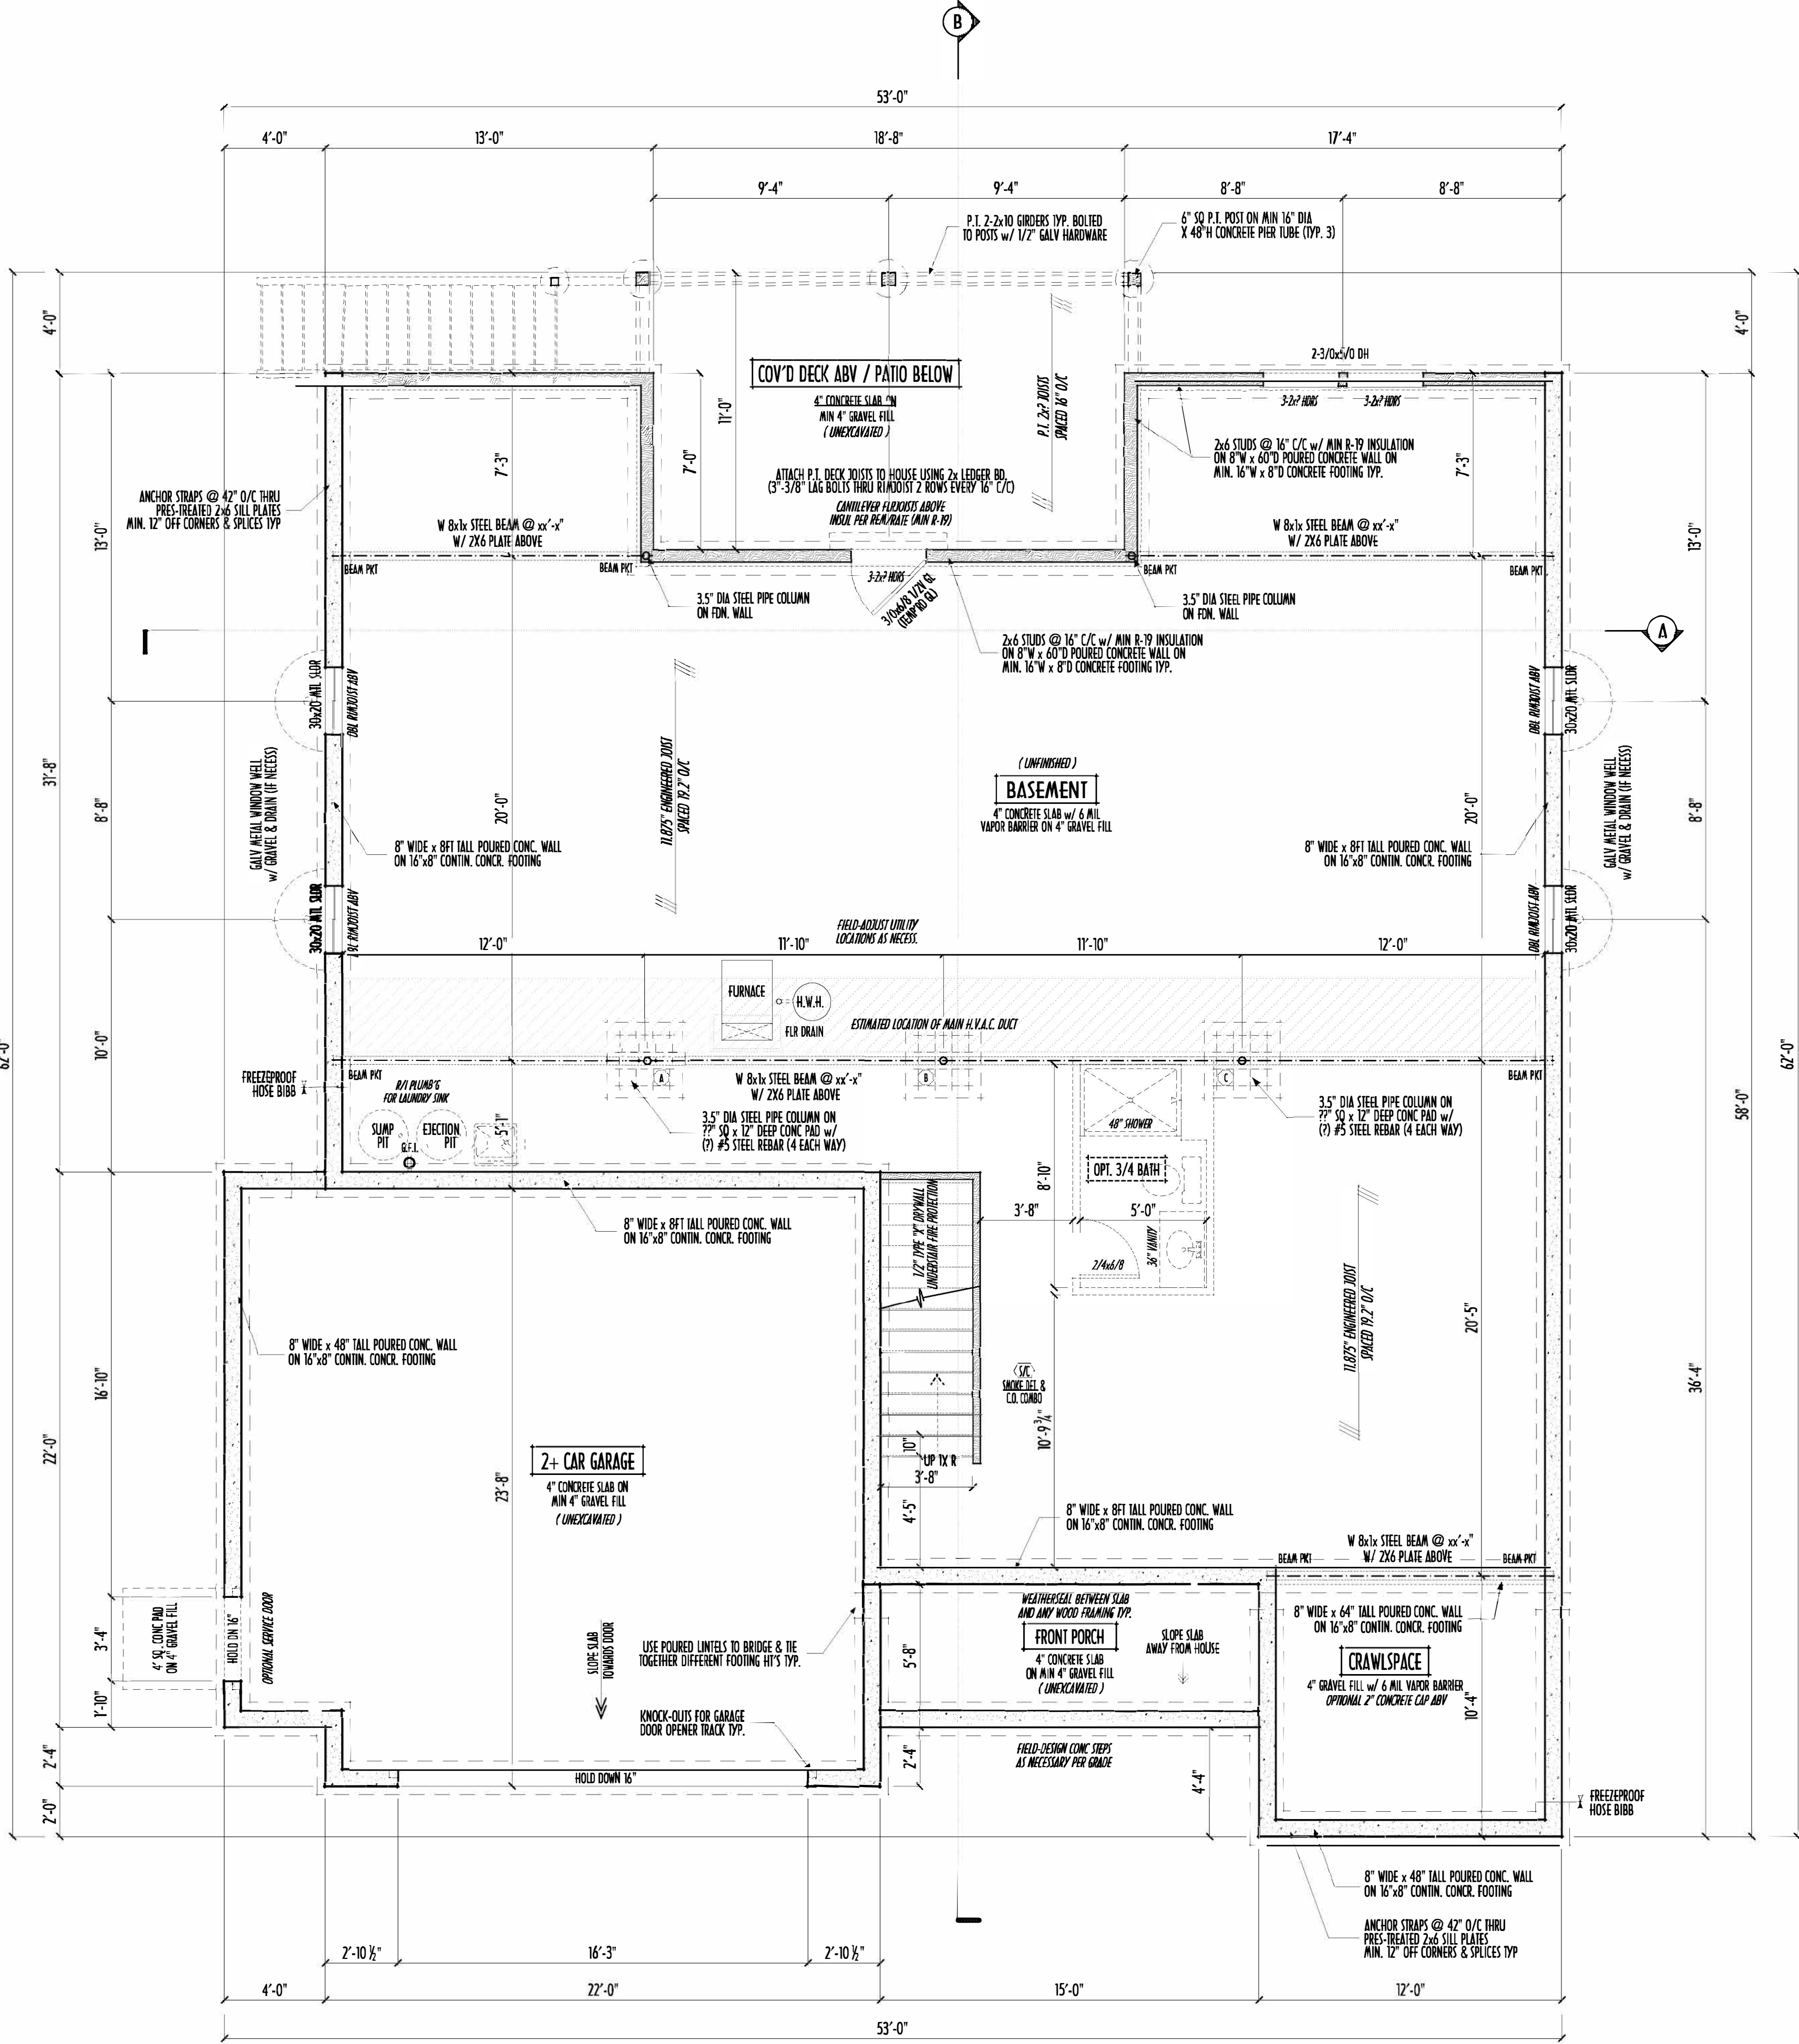

FOUNDATION / BASEMENT PLAN
SCALE: 1/4" = 1'-0"

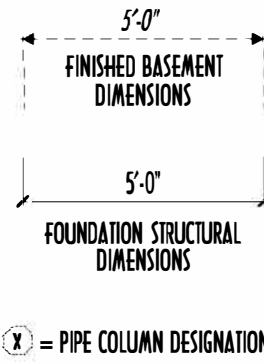

NO. REVISIONS	DATE	BY	DESCRIPTION
1	1/29/24	rw	prelim rev
2	2/7/24	rw	prelim rev
3	2/7/24	rw	prelim rev
4	2/7/24	rw	prelim rev
5	2/7/24	rw	prelim rev
6	2/7/24	rw	prelim rev
7	2/7/24	rw	prelim rev
8	2/7/24	rw	prelim rev
9	2/7/24	rw	prelim rev
10	2/7/24	rw	prelim rev

BASEMENT SLAB =	1,768 SQ.FT.
FRONT PORCH =	85 SQ.FT.
GARAGE SLAB =	571 SQ.FT.
BACK PORCH SLAB =	x SQ.FT.
WOOD DECK AREA =	x SQ.FT.
OPT. FINISHED BSMT =	x SQ.FT.

FIRST FLOOR = 2,001 SQ.FT.
OPT FIN. BSMT = xxx SQ.FT.

FND/BSMT

P&D Builders Ltd.
59 Great Parkway Suite 100
Delaware, Ohio 43015
(740) 201-8079
Fax (740) 201-8084
www.pndbuilders.com

ALL DIMENSIONS ARE THE EXACT DIMENSIONS OF THE FOUNDATION. NO DIMENSIONS TO CENTER UNLESS OTHERWISE NOTED. DIMENSIONS TO THE CENTER OF THE WALL OR THE CENTER OF THE COLUMN.

1664

RONALD W. DANNE
1717085
RESIDENTIAL DESIGN & DRAFTING INC.
614.207.6266
danne@pnd.com

REVISION DATE:	BY:	DESCRIPTION
1/29/24	rw	prelim rev
2/7/24	rw	prelim rev
2/7/24	rw	prelim rev
TO SCALE: WHEN PRINTED SLAB - PAPER SIZE: 11" x 17" (11" x 17" SCALE: 1/4" = 1'-0")
FIELD VERT DIMENSIONS: 1/4" = 1'-0" (1/4" = 1'-0")

DESIGNED: P&D / rwd

PAGE: 2 of 8