

ELEVATIONS

P & D

BUILDERS

EST. 1962

59 Great Parkway Suite

Suite 100

Delaware, Ohio 43015

(740) 201-8079

Fax (740) 201-8084

www.pndbuilders.com

ALL DESIGNS ARE THE PROPERTY OF P&D BUILDERS. NO REPRODUCTION OR OTHER USE OF THESE DESIGNS IS ALLOWED WITHOUT THE WRITTEN CONSENT OF THE ARCHITECT OR THE FIRM.

1704

PRELIMINARY DESIGN
NOT TO SCALE - NOT FOR CONSTRUCTION

STATE OF OHIO

REGISTERED ARCHITECT

RONALD W. DANNE

1717085


RONALD W. DANNE LICENSE #107085
EXPIRATION DATE 12/31/2025

Danne

Residential Design & Drafting, Inc.


614.207.6266 danneind@gmail.com

REVISION DATE:	BY:	PHEN/VD
10/16/24	j/r	concept
11/28/24	jam	concept rev
11/1/24	rwd	concept rev
11/12/24 & 11/26/24	r/j	revisions
11/28/24 & 11/29/24	r/j	prelim rev
12/6/24	rwd	QTO


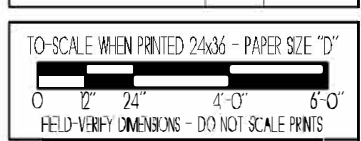


DESIGNED: P&D / rwd

PAGE: 4 of 8

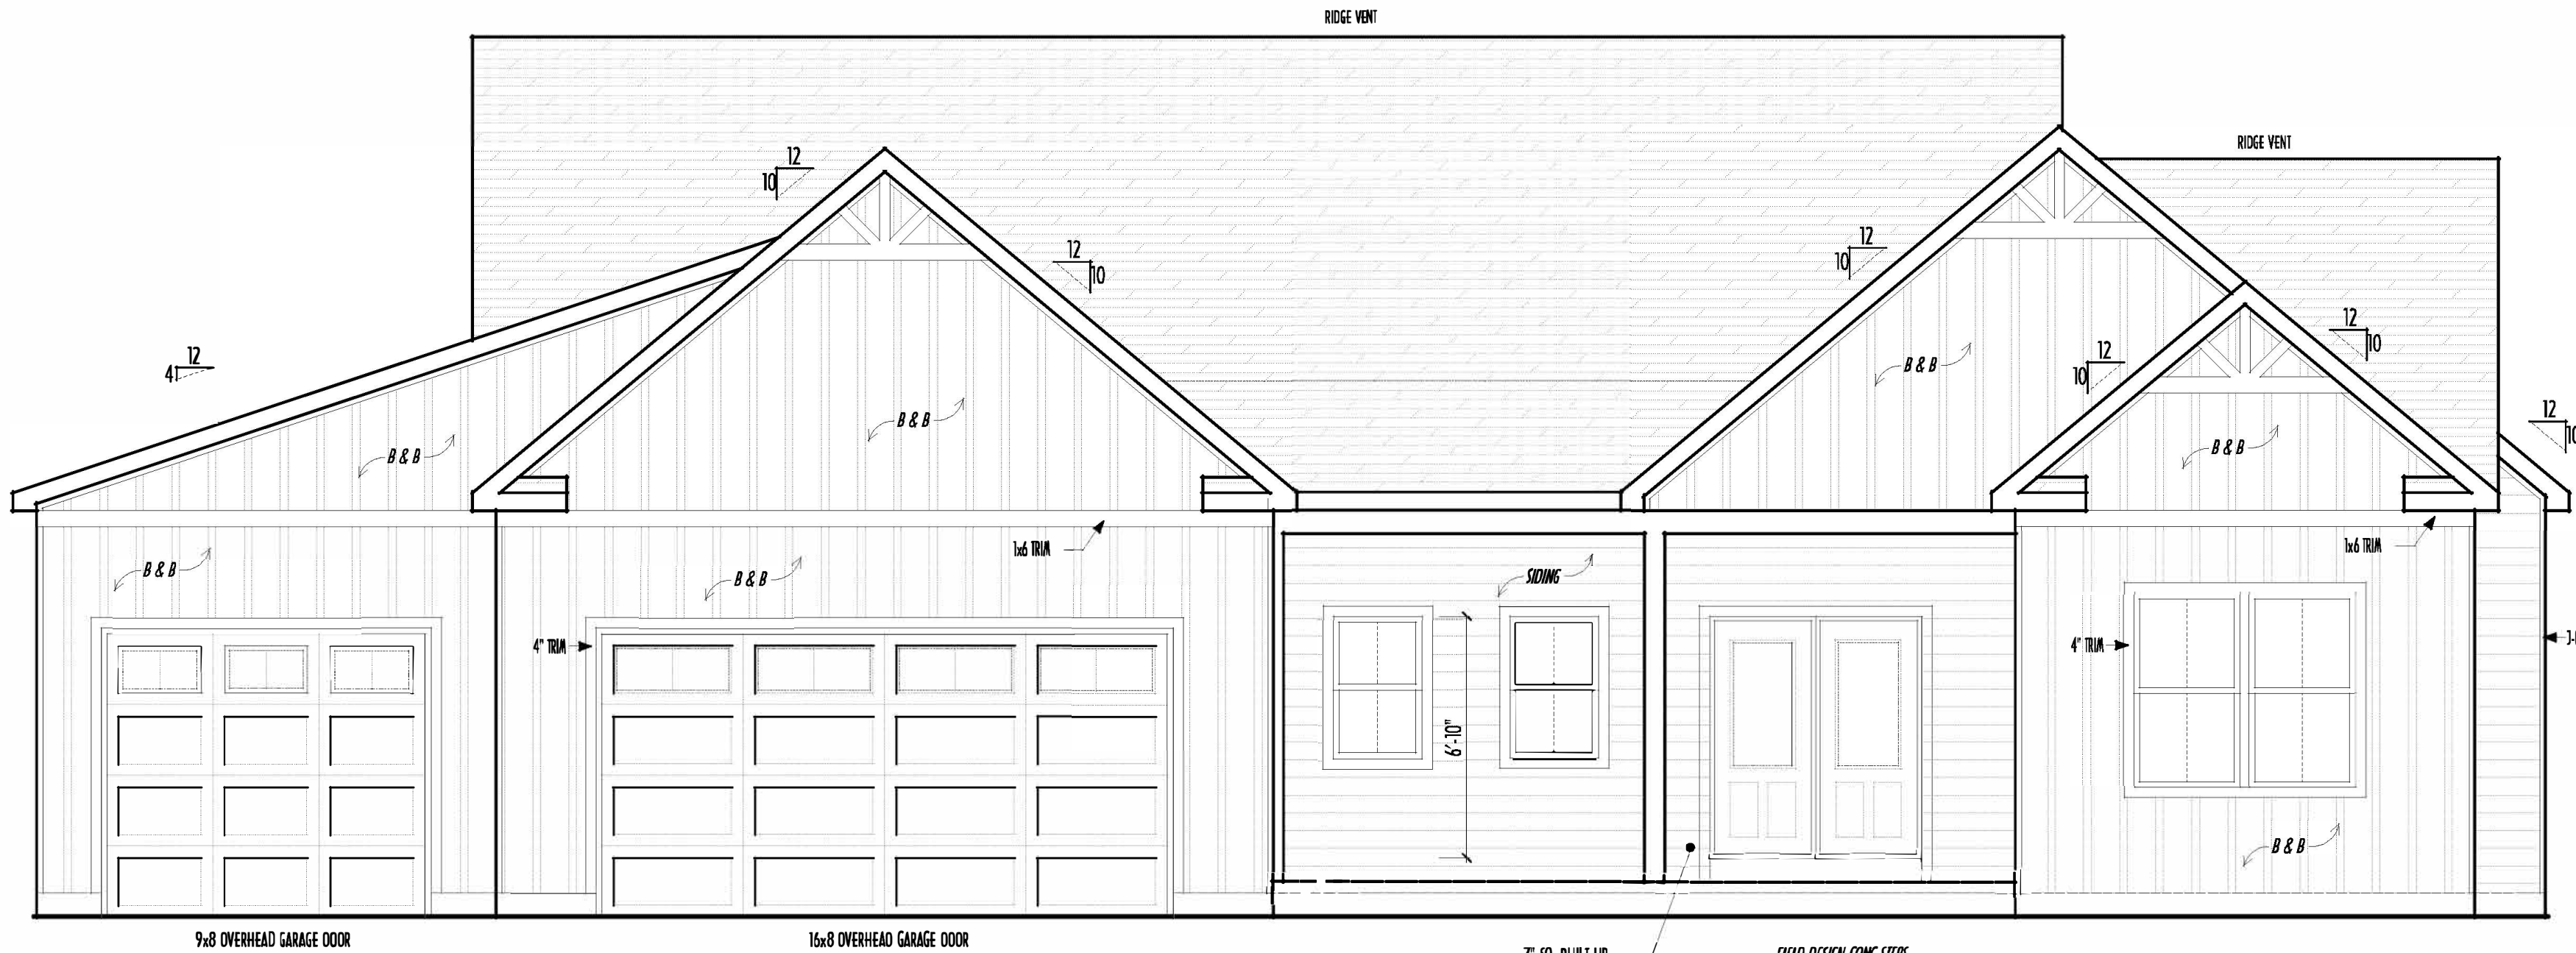

FRONT ELEVATION
SCALE : 1/4" = 1'-0"

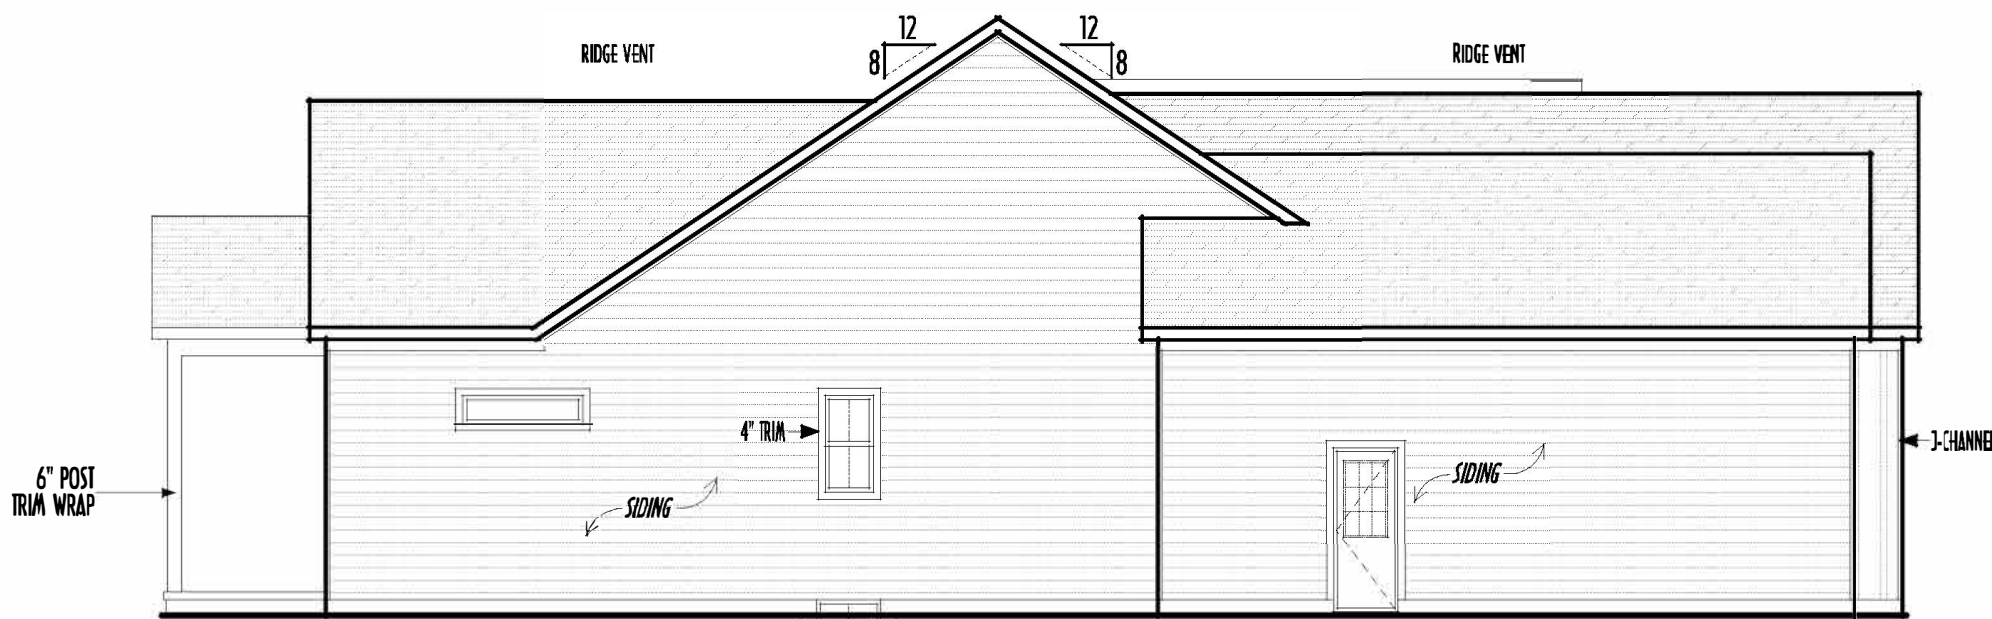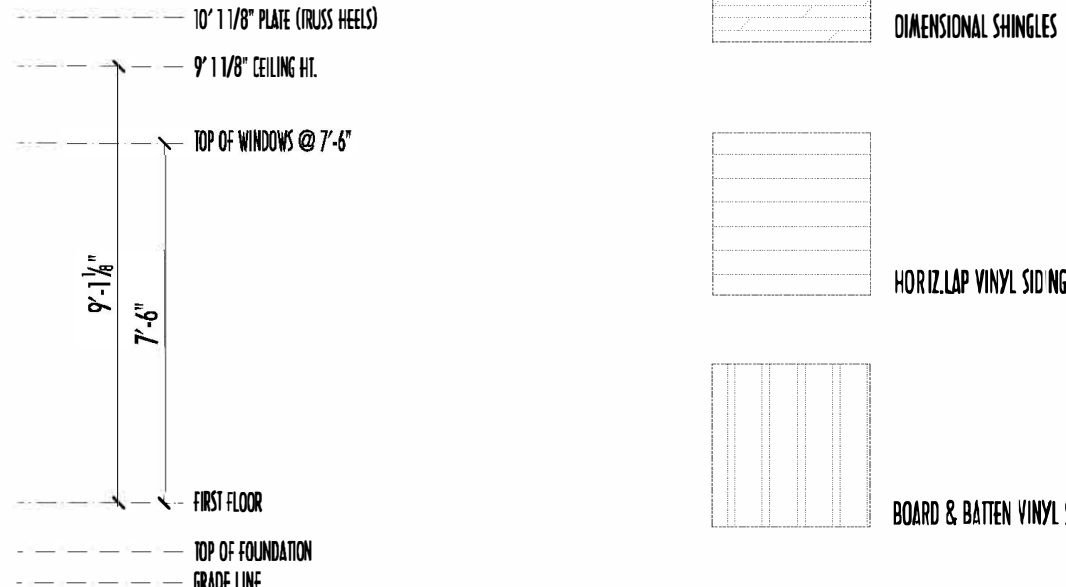


LEFT ELEVATION
SCALE : 1/8" = 1'-0"

WINDOW WELLS w/ GRAVEL & DRAIN PIPES (SEE FND)

FINAL WINDOW DESIGN PER PROVIDER. ALL FRAMING ROUGH-OPENINGS TO BE BASED ON FINAL LAYOUT ONLY


EXACT WINDOW & DOOR GRID PATTERNS (MULLIONS) MAY DIFFER - REFER TO MANUFACTURER OR SUPPLIER

GRADE ELEVATION SHOWN IS APPROXIMATE FIELD VERIFY & ADJUST FOUNDATION AS NECESSARY

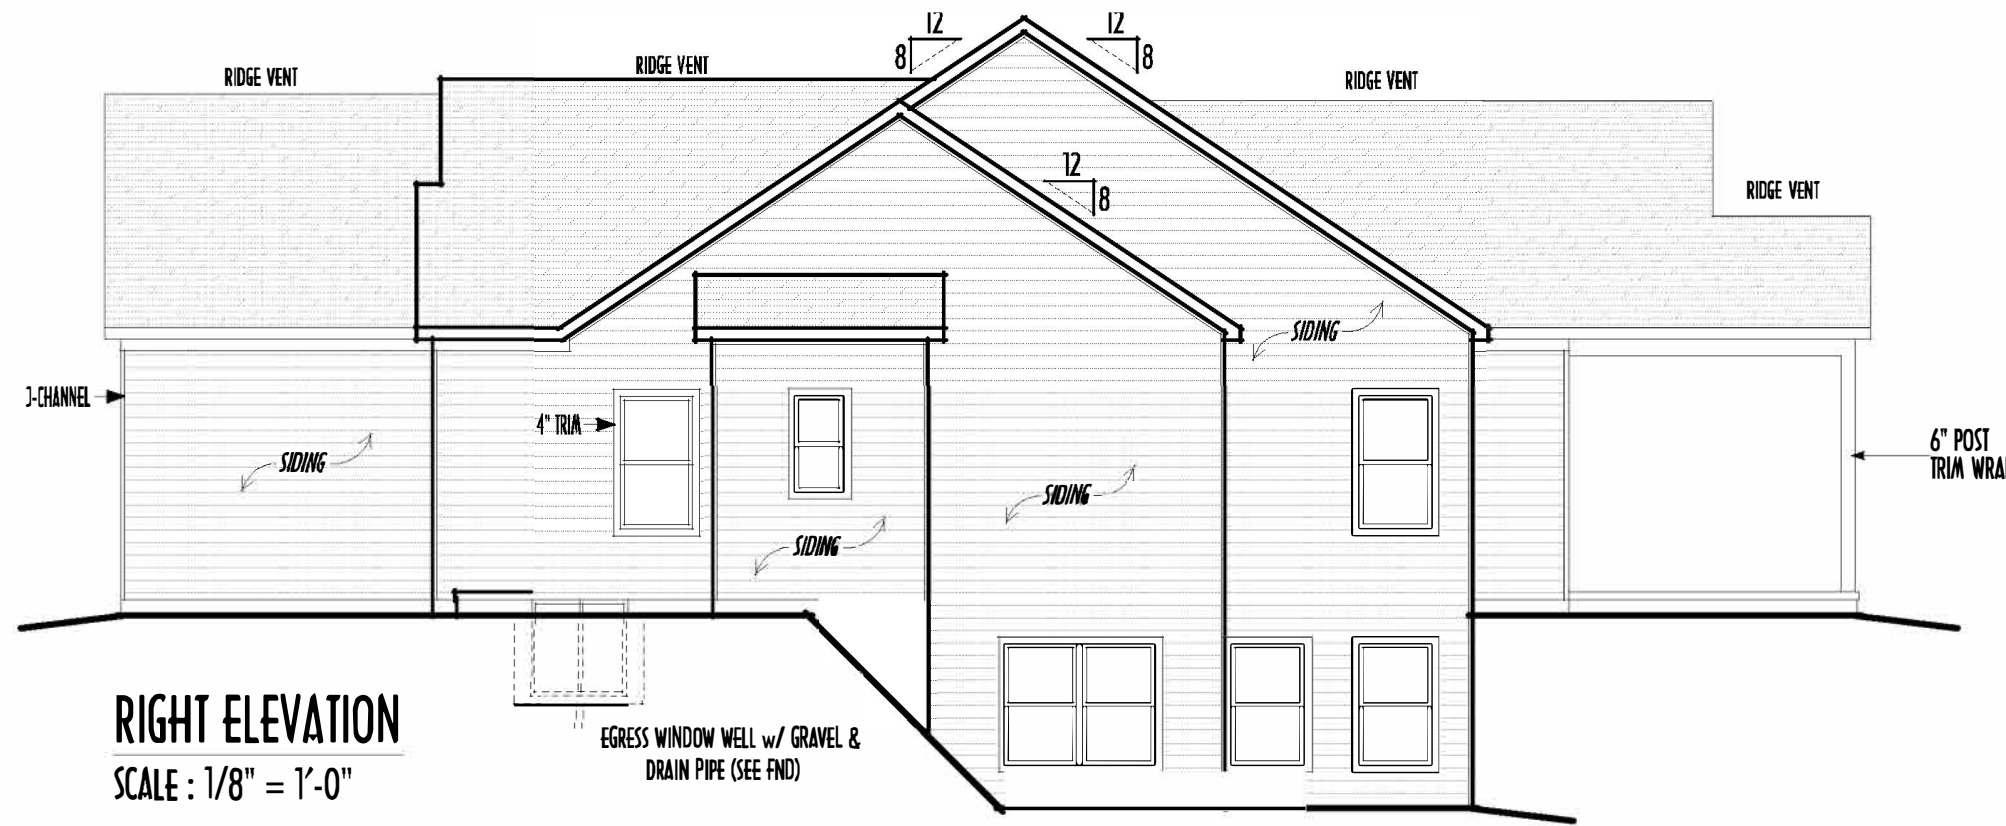

RIGHT ELEVATION
SCALE : 1/8" = 1'-0"

EGRESS WINDOW WELL w/ GRAVEL & DRAIN PIPE (SEE FND)

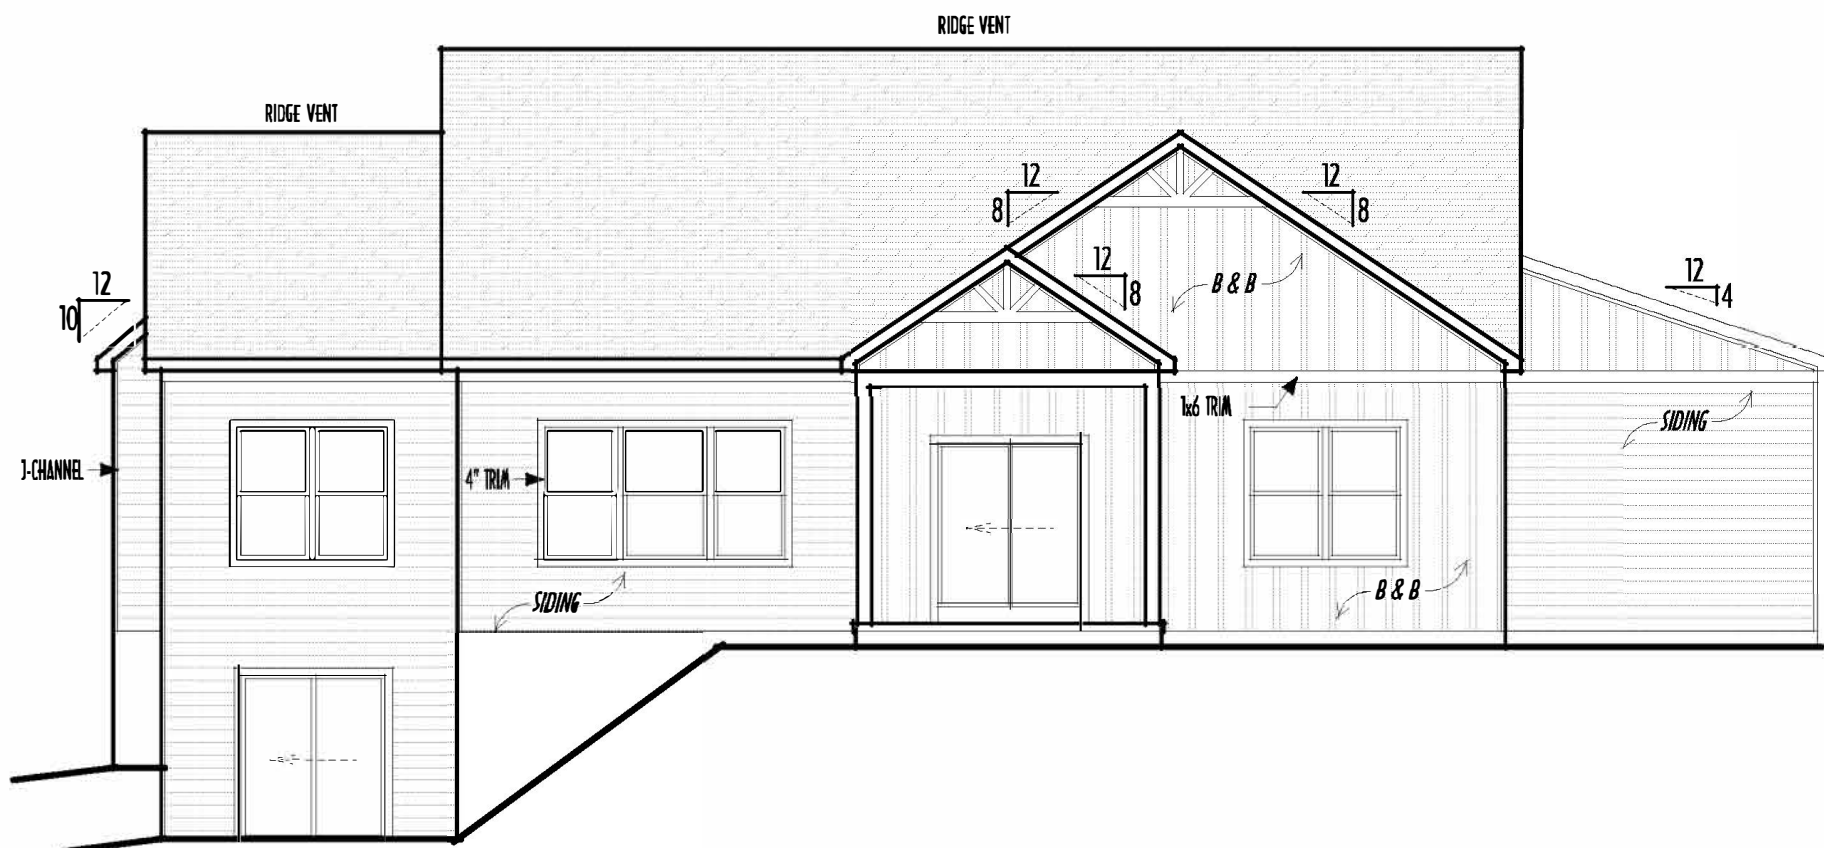

BACK ELEVATION
SCALE : 1/8" = 1'-0"

FIRST FLOOR CEILINGS @ 9'-1 1/8" UNLESS NOTED OTHERWISE
FIRST FLOOR WINDOW HEADERS @ 7'-6" UNLESS NOTED OTHERWISE

EMERGENCY EGRESS OPERABLE (E.E.O.) WINDOWS IN ALL BEDROOMS

SEE ROOF PLAN FOR SOFFIT & RAKE SIZES

CULTURED STONE VENEER WRAPS FRONT CORNERS MIN 6" INTO T&G WOOD TRIM UNLESS NOTED

FLASH & CAULK ELEVATIONS AS NECESSARY TO PROVIDE A WEATHER-TIGHT SEAL BETWEEN MATERIALS, FRAMING & TRIM

WINDOWS & DOORS (BRAND & DESIGN) PER CONTRACT

WINDOWS & DOORS ARE TO BE INSTALLED PER MANUFACTURERS SPECIFICATIONS CONFIRM WINDOW SIZES & ROUGH-OPENINGS WITH SUPPLIER

RUN STUCCO, STONE & BRICK VENEER TO GRADE UNLESS NOTED

WEEP SCREEDS FOR STUCCO EXTERIORS SHALL COMPLY WITH R-703.6.2.1 (#36 GALV CORROSION-RESISTANT SCREED AT/ABV FOUNDATION PLATE (3.5" FLANGED) PLACED AT MIN 4" ABV EARTH / 2" ABV PAVING, ALLOWING TRAP'D WATER TO DRAIN)

SLOPE GRADE AWAY FROM FOUNDATION FOR PROPER DRAINAGE

P & D
BUILDERS
EST. 1962

ST FLR

9 Greif Parkway Suite
Suite 100
Delaware, Ohio 43015
(740) 201-8079
Fax (740) 201-8084
www.pndbuilders.com

1704

SEAL OF THE STATE OF OHIO
RONALD W.
DANNE
1717085

Danne
Residential Design & Drafting inc.
416.207.6266 dannednd@gmail.com

REVISION DATE:	BY:	Prelim/CO
10/16/24	j/r	concepts
10/28/24	jarn	concept rev
11/1/24	rwd	concept rev
11/17/24 & 11/8/24	r/l	prelims
11/26/24 & 11/29/24	r/j	prelim rev
12/6/24	rwd	QTO


GRAPHIC SCALE WHEN PRINTED 24x36 - PAPER SIZE "D"

0 12 24 48 60

FIELD-VERIFY DIMENSIONS - DO NOT SCALE PRINTS

P&D / rwd


3 of 8

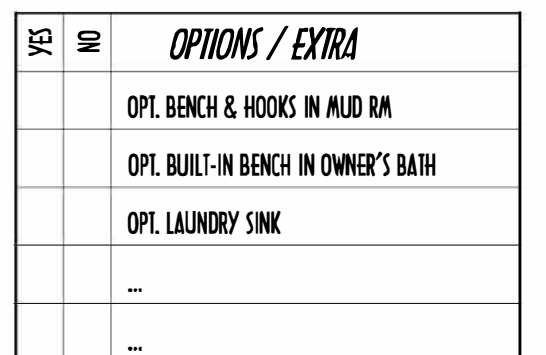

FIRST FLOOR =	2,160 SQ.FT.
OPT FIN. BSMT =	855 SQ.FT.


PRELIMINARY DESIGN
NOT TO SCALE - NOT FOR CONSTRUCTION

REVISION DATE:	BY:	REASON
10/16/24	J/T	concept
10/28/24	J/T	concept rev
11/1/24	rwd	concept rev
11/17/24 & 11/8/24	r/j	revisions
1/28/25 & 1/29/25	r/j	revisions
2/6/25	rwd	QTO

 

DESIGNED: P&D / rwd

PAGE: 2 of 8

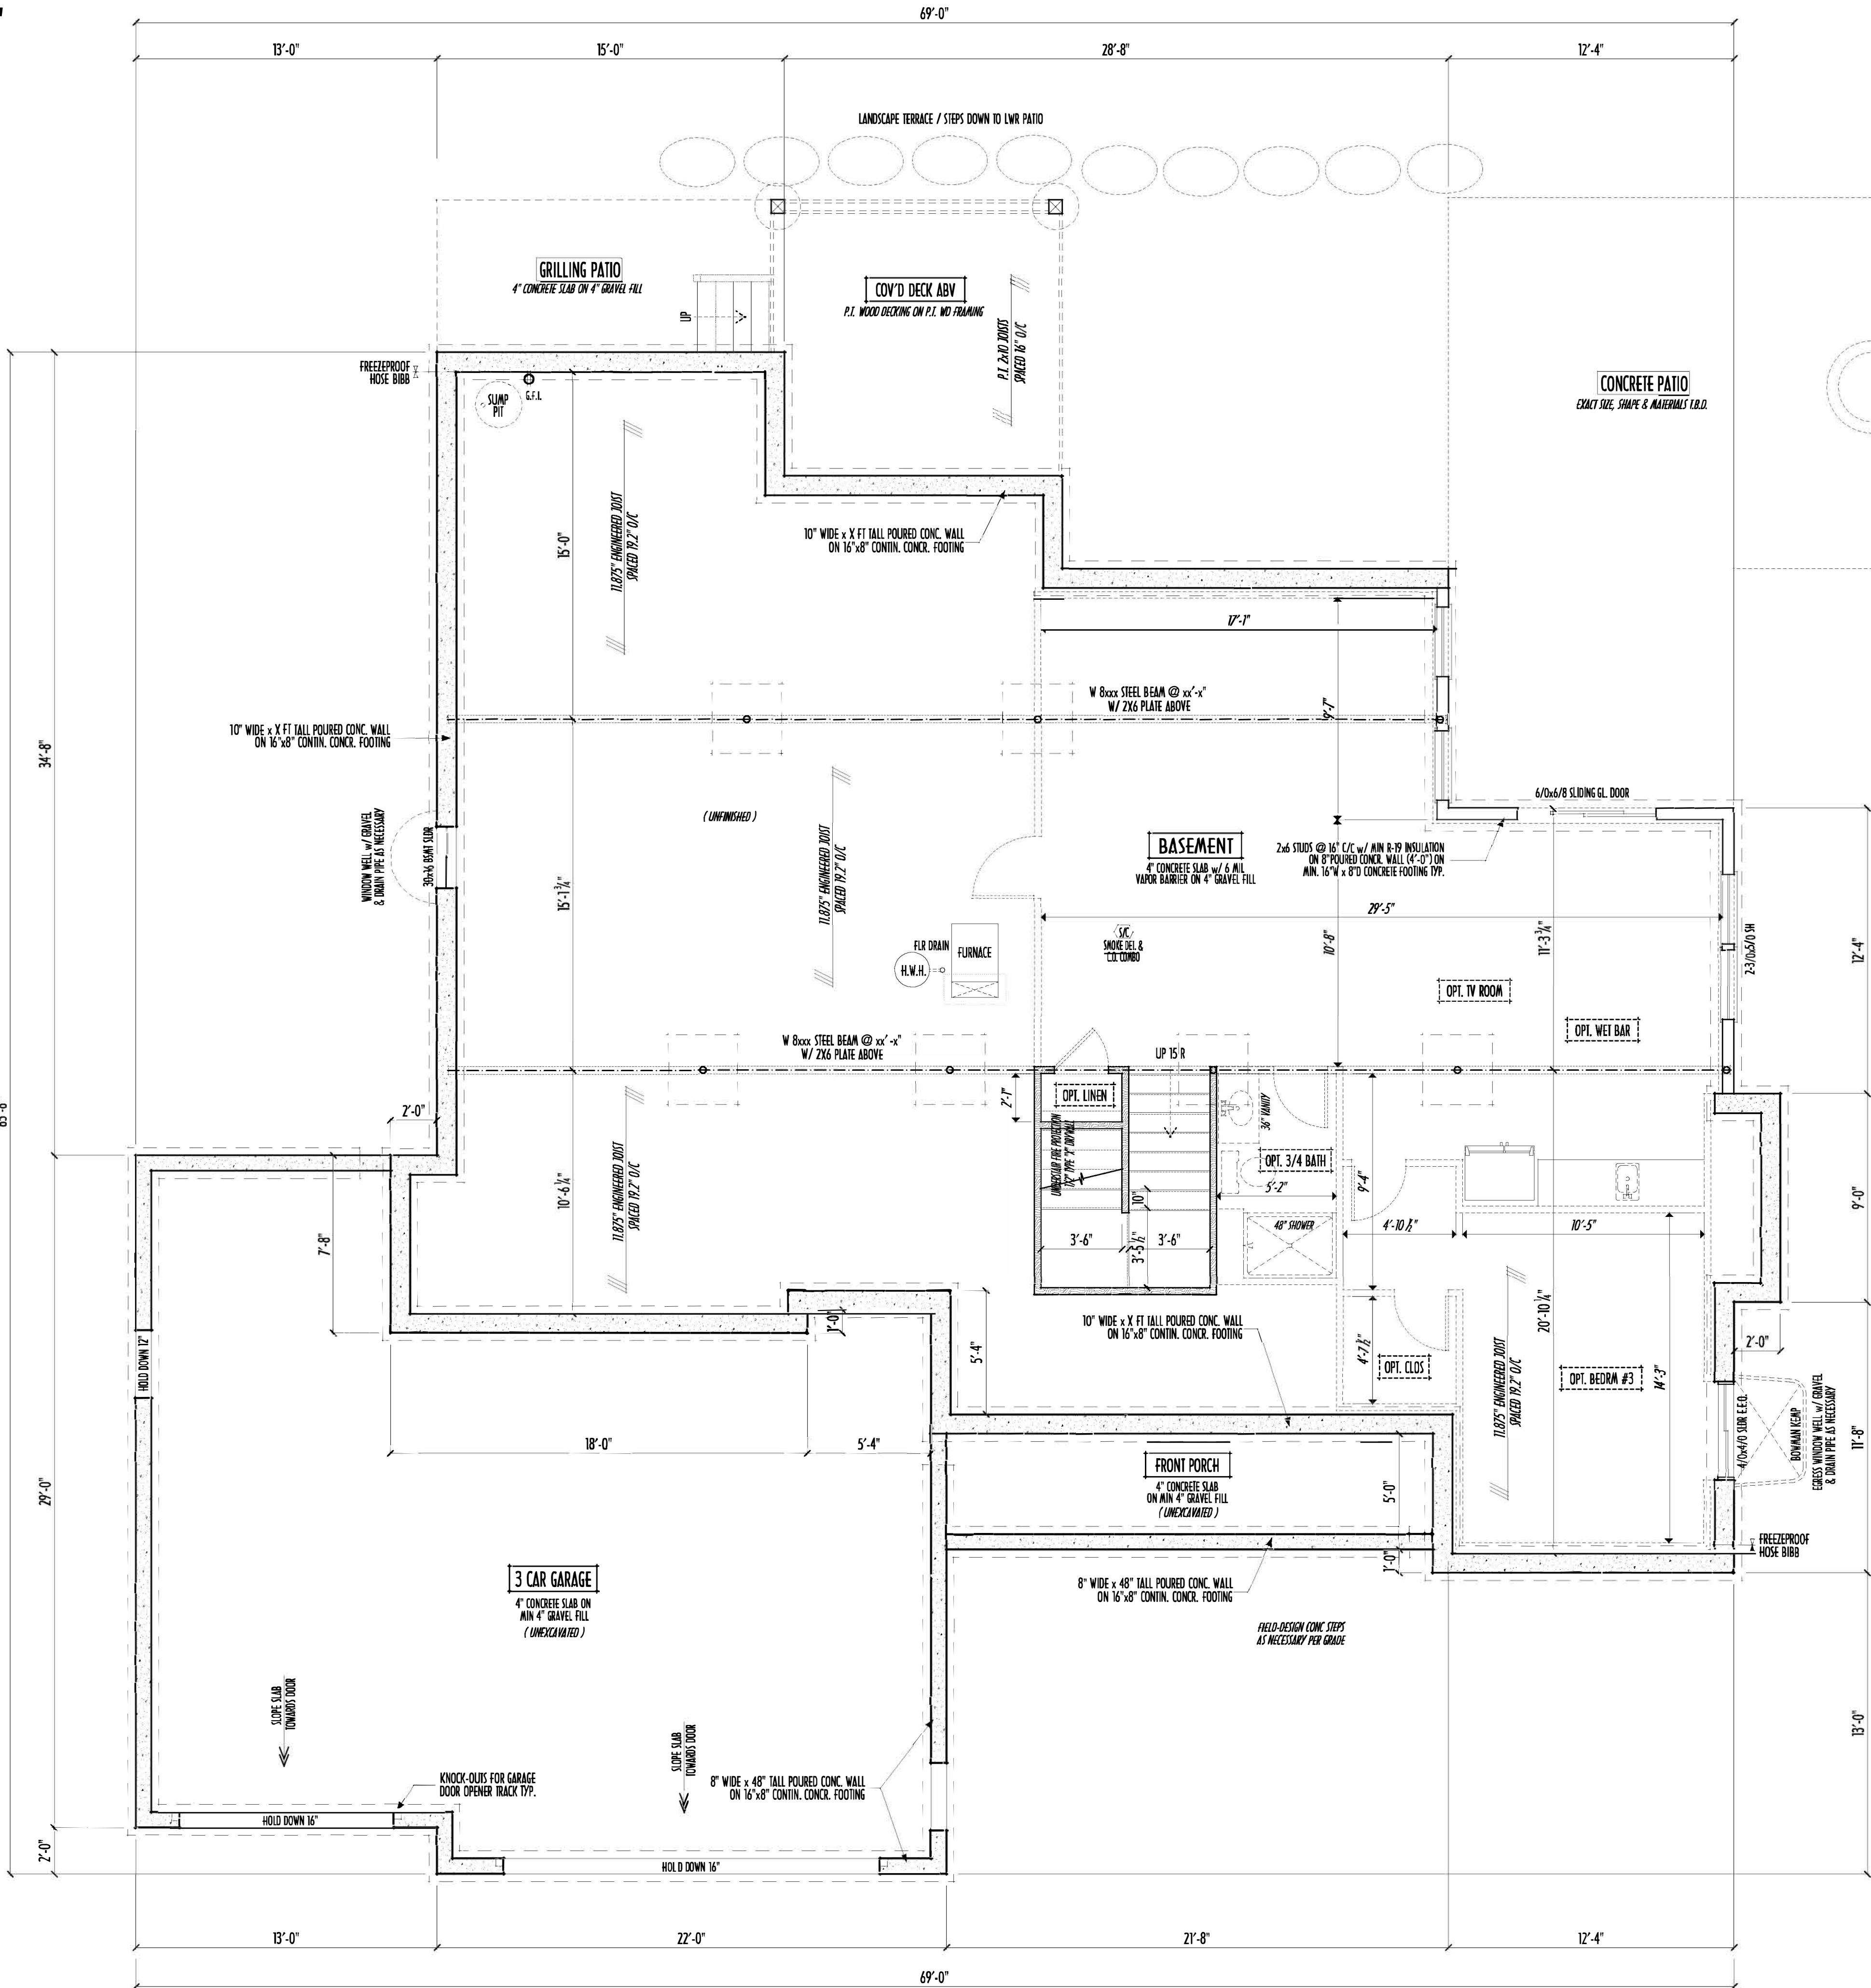

FOUNDATION / BASEMENT PLAN
SCALE: 1/4" = 1'-0"

FIRST FLOOR = 2,160 SQ.FT.
OPT FIN. BSMT = 855 SQ.FT.

MAX. UNBALANCED FILL FOR 8" THICK POURED CONC. WALL OR C.M.U. BLOCK WALL = 7'-0" ABOVE SLAB

WATERPROOFING / DAMPROOFING PER CODE

ALL STRUCTURAL LUMBER IS MIN. CANADIAN SPECIES #2 SPRUCE-PINE-FIR, UNLESS NOTED OTHERWISE

FIRST FLOOR DESIGN LIVE LOAD = 40 PSF

BASEMENT ELECTRICAL LAYOUT FOR REFERENCE ONLY - CONSULT WITH HOMEOWNER PRIOR TO INSTALLATION FOR EXACT LOCATIONS

GRADE MIN. 8" BELOW TOP OF FOUNDATION, SLOPING AWAY FOR PROPER DRAINAGE MIN. 6" DROP IN FIRST 10 FT OF RUN

AVOID FLOORJOISTS LOCATED DIRECTLY BELOW PLUMBING DRAINS & TRAPS

BLOCK BETWEEN FLOORJOISTS BELOW STRUCTURAL POINTS (CROSS ZONES) WITH APPROPRIATE 2X FILL


SEE COVER SHEET FOR GENERAL FOUNDATION CONSTRUCTION NOTES

STEP DOWN FOOTING AS NECESSARY TO REMAIN MIN. 36" BELOW GRADE

USE PRES-TREATED EXTERIOR-GRADE LUMBER WHERE EXPOSED TO WEATHER OR IN CONTACT WITH CONCRETE

FOUNDATION WALL ENGINEERING & REINFORCEMENT PER SHEPHERD EXCAVATING DESIGN-DETAIL RC-16


INSTALL ALL LV. & LSL BEAMS WITH LABELS VISIBLE FOR BUG INSPECTION

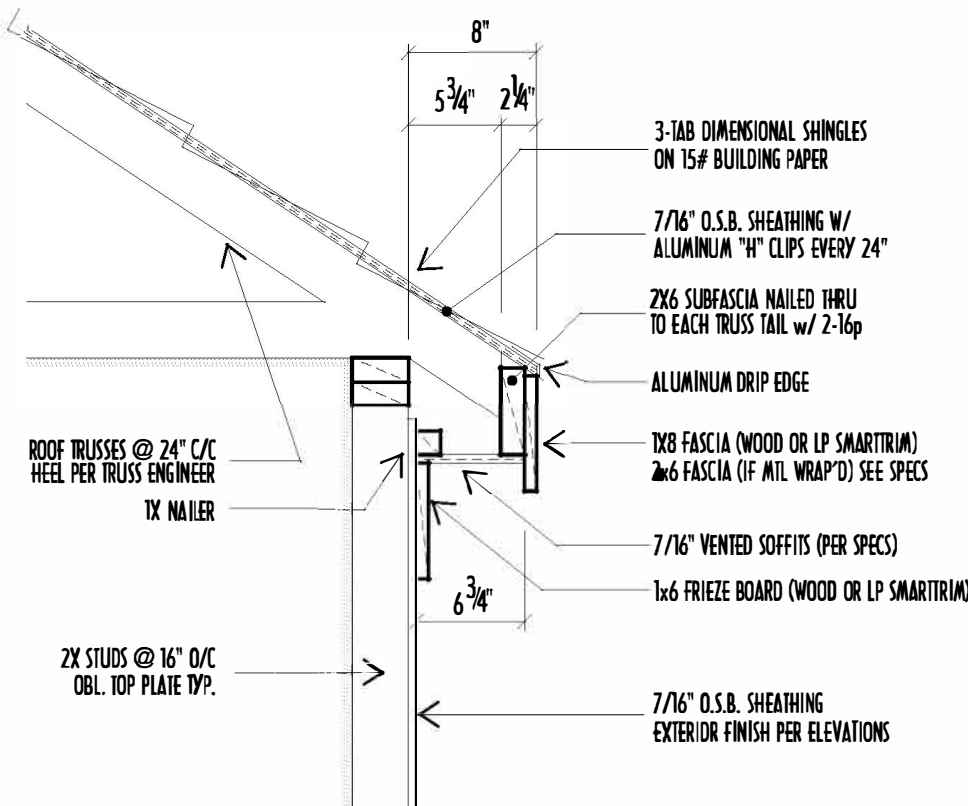

8" SOFFIT / EAVE DETAIL
SCALE: 1" = 1'-0"

MAX. ALLOWABLE SPANS RAFTERS	
CEILING APPLIED DIRECTLY TO BOTTOM / REPETITIVE USE	
SOUTHERN YELLOW PINE #2	SPRUCE/PINE/FIR #2
2x4 @ 16" ~ MAX. SPAN = 8'-11"	2x4 @ 16" ~ MAX. SPAN = 8'-8"
2x4 @ 24" ~ MAX. SPAN = 7'-5"	2x4 @ 24" ~ MAX. SPAN = 6'-11"
2x6 @ 16" ~ MAX. SPAN = 13'-0"	2x6 @ 16" ~ MAX. SPAN = 12'-5"
2x6 @ 24" ~ MAX. SPAN = 10'-8"	2x6 @ 24" ~ MAX. SPAN = 10'-2"
2x8 @ 16" ~ MAX. SPAN = 16'-10"	2x8 @ 16" ~ MAX. SPAN = 15'-9"
2x8 @ 24" ~ MAX. SPAN = 13'-9"	2x8 @ 24" ~ MAX. SPAN = 12'-10"
2x10 @ 16" ~ MAX. SPAN = 20'-4"	2x10 @ 16" ~ MAX. SPAN = 19'-3"
2x10 @ 24" ~ MAX. SPAN = 16'-5"	2x10 @ 24" ~ MAX. SPAN = 15'-8"
2x12 @ 16" ~ MAX. SPAN = 23'-7"	2x12 @ 16" ~ MAX. SPAN = 22'-4"
2x12 @ 24" ~ MAX. SPAN = 19'-3"	2x12 @ 24" ~ MAX. SPAN = 18'-3"

MAX. ALLOWABLE SPANS CEILING JOISTS	
SPRUCE/PINE/FIR #2 OR BETTER (REPETITIVE USE)	
EXTREME FIBER STRESS IN BENDING 700' = 1100# PSI MODULUS OF ELASTICITY E' = 1.4 MIL PSI	
NO STORAGE ALLOWED:	LIMITED ATTIC STORAGE:
2x4 @ 16" ~ MAX. SPAN = 10'-8"	2x4 @ 16" ~ MAX. SPAN = 8'-11"
2x4 @ 24" ~ MAX. SPAN = 9'-10"	2x4 @ 24" ~ MAX. SPAN = 7'-8"
2x6 @ 16" ~ MAX. SPAN = 16'-11"	2x6 @ 16" ~ MAX. SPAN = 13'-5"
2x6 @ 24" ~ MAX. SPAN = 15'-6"	2x6 @ 24" ~ MAX. SPAN = 11'-0"
2x8 @ 16" ~ MAX. SPAN = 22'-4"	2x8 @ 16" ~ MAX. SPAN = 17'-5"
2x8 @ 24" ~ MAX. SPAN = 20'-1"	2x8 @ 24" ~ MAX. SPAN = 14'-2"
2x10 @ 16" ~ MAX. SPAN = 26'-0"	2x10 @ 16" ~ MAX. SPAN = 20'-9"
2x10 @ 24" ~ MAX. SPAN = 23'-11"	2x10 @ 24" ~ MAX. SPAN = 16'-11"

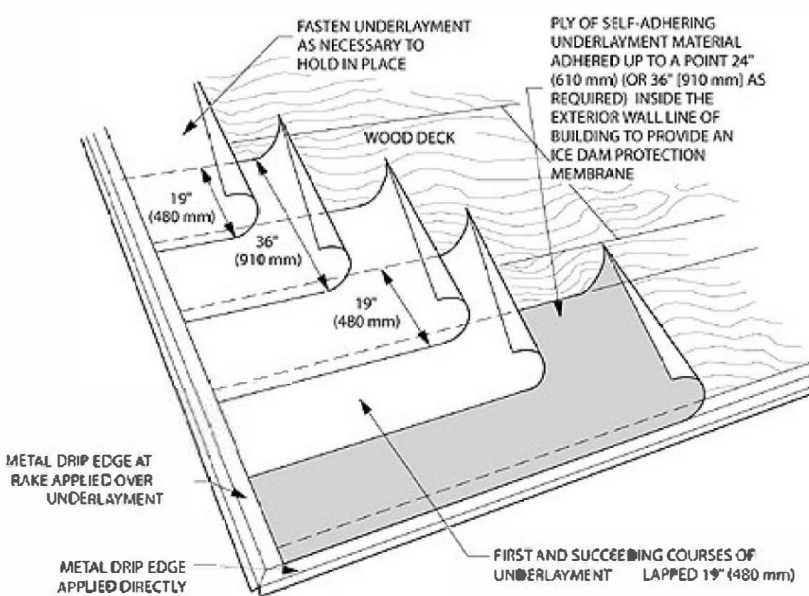


NOTE - DIMENSIONS ARE APPROXIMATE

A PROTECTION @ EAVES USING 2 LAYERS OF OVERLAPPED UNDERLAYMENT
HER UNDER SHINGLES EXTENDING IN MIN. 24" FROM OUTSIDE OF WALL BELOW

DOF SLOPES LESS THAN 4 IN 12 SHALL HAVE MIN. 12 LAYERS
F 415 FELT PARALLEL TO EAVES WITH MIN. 10" LAP AT TOP
NO MIN. 12" END LAP WITH MIN. 72" BETWEEN ROYS OF END LAPS

OR - INSTALLED PER SHINGLE MANUFACTURER'S SPECIFICATIONS
OR COLD-WEATHER LOW-SLOPE CONDITIONS

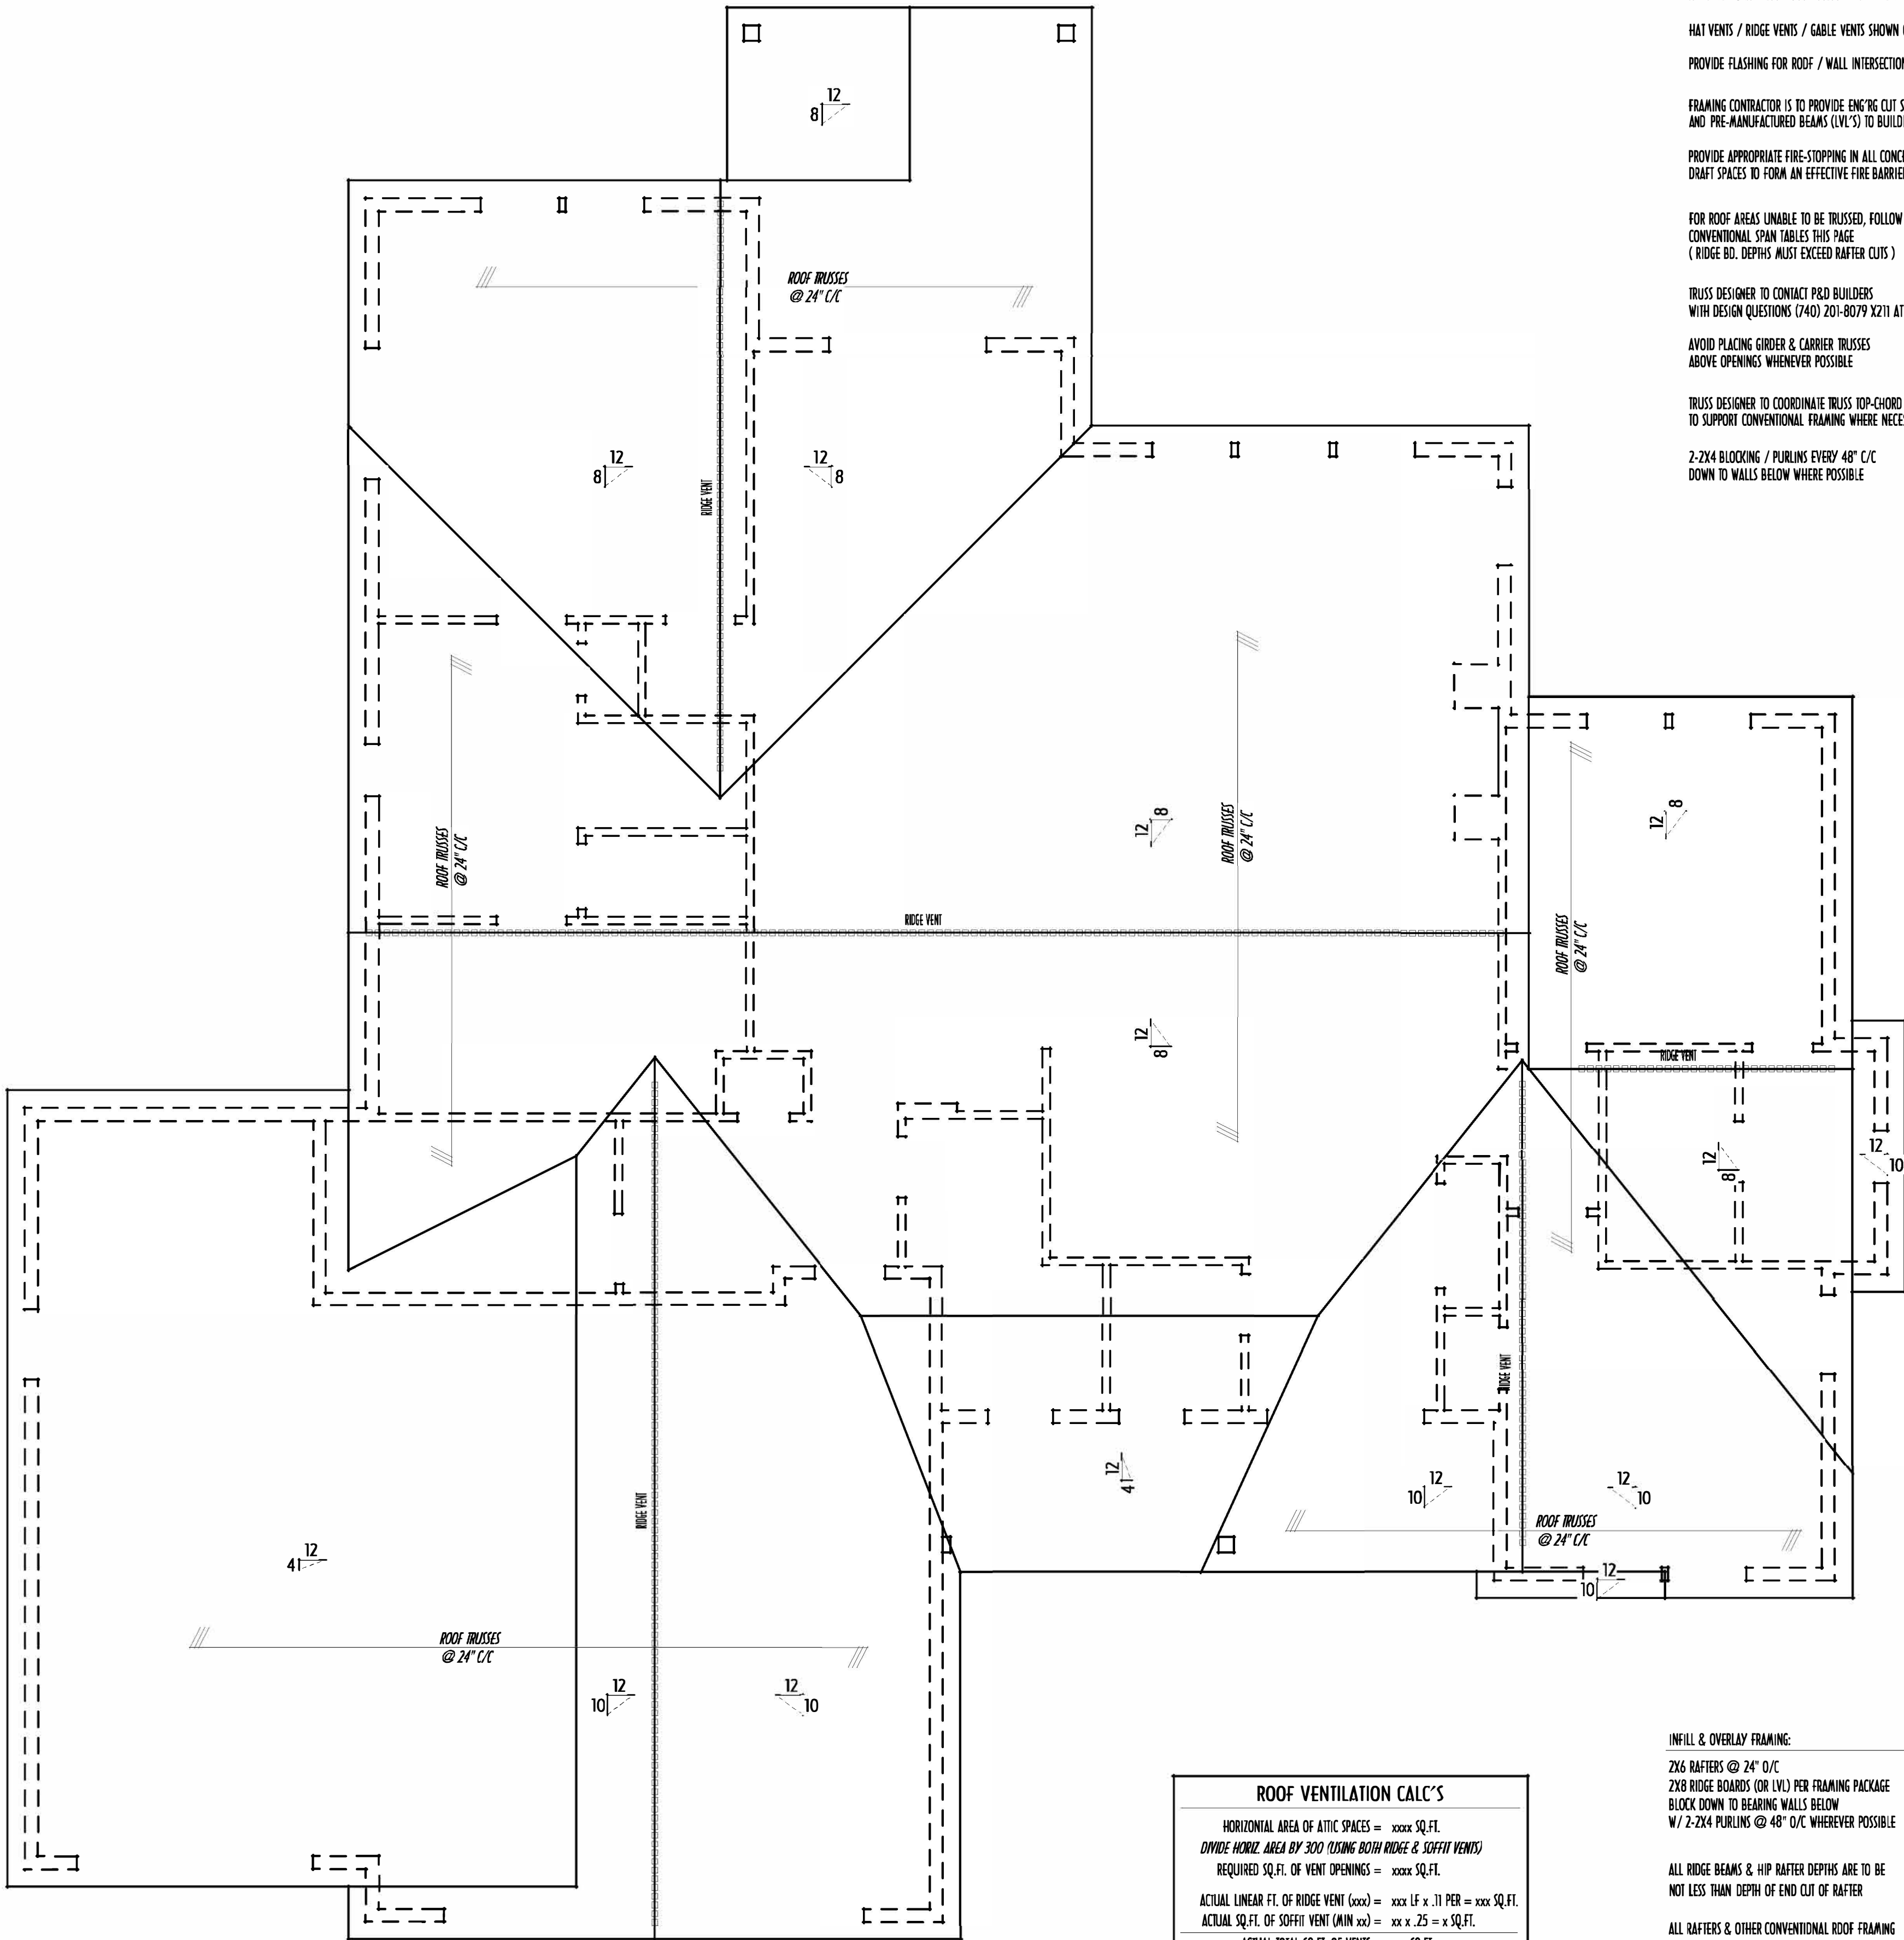

ROOF VENTILATION CALC'S	
HORIZONTAL AREA OF ATTIC SPACES = xxxx SQ.FT.	
DIVIDE HORIZ. AREA BY 300 (USING BOTH RIDGE & SOFFIT VENTS)	
REQUIRED SQ.FT. OF VENT OPENINGS = xxxx SQ.FT.	
ACTUAL LINEAR FT. OF RIDGE VENT (xxxx) = xxxx LF x .11 PER = xxxx SQ.FT.	
ACTUAL SQ.FT. OF SOFFIT VENT (MINI xxx) = xx x .25 = x SQ.FT.	
ACTUAL TOTAL SQ.FT. OF VENTS = xxxx SQ.FT.	

INFILL & OVERLAY FRAMING:

2X6 RAFTERS @ 24" O/C
2X8 RIDGE BOARDS (OR LVL) PER FRAMING PACKAGE
BLOCK DOWN TO BEARING WALLS BELOW
W/ 2-2X4 PURLING @ 48" O/C WHEREVER POSSIBLE

ALL RIDGE BEAMS & HIP RAFTER DEPTHS ARE TO BE
NOT LESS THAN DEPTH OF END CUT OF RAFTER

ALL RAFTERS & OTHER CONVENTIONAL ROOF-FRAMING
LUMBER IS TO COMPLY WITH SPAN TABLES ABOVE

MIN. 2X6 VALLEY PLATE ON ROOF SHEATHING
NAIL THRU TO RAFTERS/TRUSSES BELOW

FIRST FLOOR = 2,160 SQ.FT.
OPT. FIN. BSMT = 855 SQ.FT.

REVISION DATE:	BY:	REASON
10/16/24	J.T.	concept
11/28/24	J.T.	concept rev
11/1/24	rw3	concept rev
1/17/25 & 1/8/24	J.T.	reline
1/28/24 & 1/29/24	J.T.	prelim rev
12/6/24	rw3	QTO