



P&D Builders Ltd.
59 Great Parkway Suite 100
Delaware, Ohio 43015
(740) 201-8079
Fax (740) 201-8084
www.pndbuilders.com


ALL DRAWINGS ARE THE EXCLUSIVE PROPERTY OF P&D BUILDERS LTD.
NO REPRODUCTION OR OTHER USE OF THESE PLANS MAY BE MADE
WITHOUT PRIOR WRITTEN CONSENT OF THE AUTHOR OF THE PLANS

1488

PRELIMINARY DESIGN - NOT FOR CONSTRUCTION

DESIGNED BY: P&D / rwd

PAGE: 5 of 9

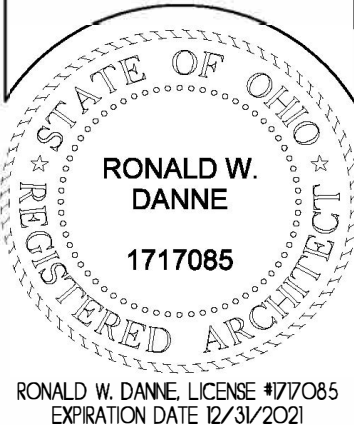


RONALD W. DANNE
1717085
RESIDENTIAL DESIGN & DRAFTING, INC.
614.207.6266 dannedrd@gmail.com



REVISION DATE:	BY:	REVISION
12/8/20	jam	prelim
12/9/20	rwcd	prelim rev
1/19/21	jam	prelim rev
2/23/21	jam	prelim rev
2/26/21	lch	prelim rev
3/1/21	lch	prelim rev
3/3/21	rwcd	prelim rev
3/25/21	L/r	prelim rev

TO SCALE WHEN PRINTED 24x36 - PAPER SIZE 11"
0 6 12 18 24 30 36 42 48 54 60
FIELD VIEWS DIMENSIONS - DO NOT SCALE PLOTS

FIRST FLOOR CEILINGS @ 9'-1 1/8" UNLESS NOTED OTHERWISE
FIRST FLOOR WINDOW HEADERS @ 7'-6" UNLESS NOTED OTHERWISE
SECOND FLOOR CEILINGS @ 8'-1 1/8" UNLESS NOTED OTHERWISE
SECOND FLOOR WINDOW HEADERS @ 6'-10" UNLESS NOTED OTHERWISE
EMERGENCY EGRESS OPERABLE (E.E.O.) WINDOWS IN ALL BEDROOMS
SEE ROOF PLAN FOR SOFFIT & RAKE SIZES
RUN BRICK VENEER 1" PAST FRAMING CORNERS
CULTURED STONE VENEER WRAPS FRONT CORNERS MIN 6"
INTO 1x6 WOOD TRIM UNLESS NOTED
FLASH & CAULK ELEVATIONS AS NECESSARY TO PROVIDE A
WEATHER-TIGHT SEAL BETWEEN MATERIALS, FRAMING & TRIM
WINDOWS & DOORS (BRAND & DESIGN) PER CONTRACT
WINDOWS & DOORS ARE TO BE INSTALLED PER MANUFACTURERS SPECIFICATIONS
CONFIRM WINDOW SIZES & ROUGH-OPENINGS WITH SUPPLIER
RUN STUCCO, STONE & BRICK VENEER TO GRADE UNLESS NOTED
WEEP SCREENS FOR STUCCO EXTERIORS SHALL COMPLY WITH R-703.6.2.1
(#26 GALV CORROSION-RESISTANT SCREED AT/ABV FOUNDATION PLATE (3.5" FLANGED)
PLACED AT MIN 4" ABV EARTH / 2" ABV PAVING, ALLOWING TRAPD WATER TO DRAIN)
SLOPE GRADE AWAY FROM FOUNDATION FOR PROPER DRAINAGE

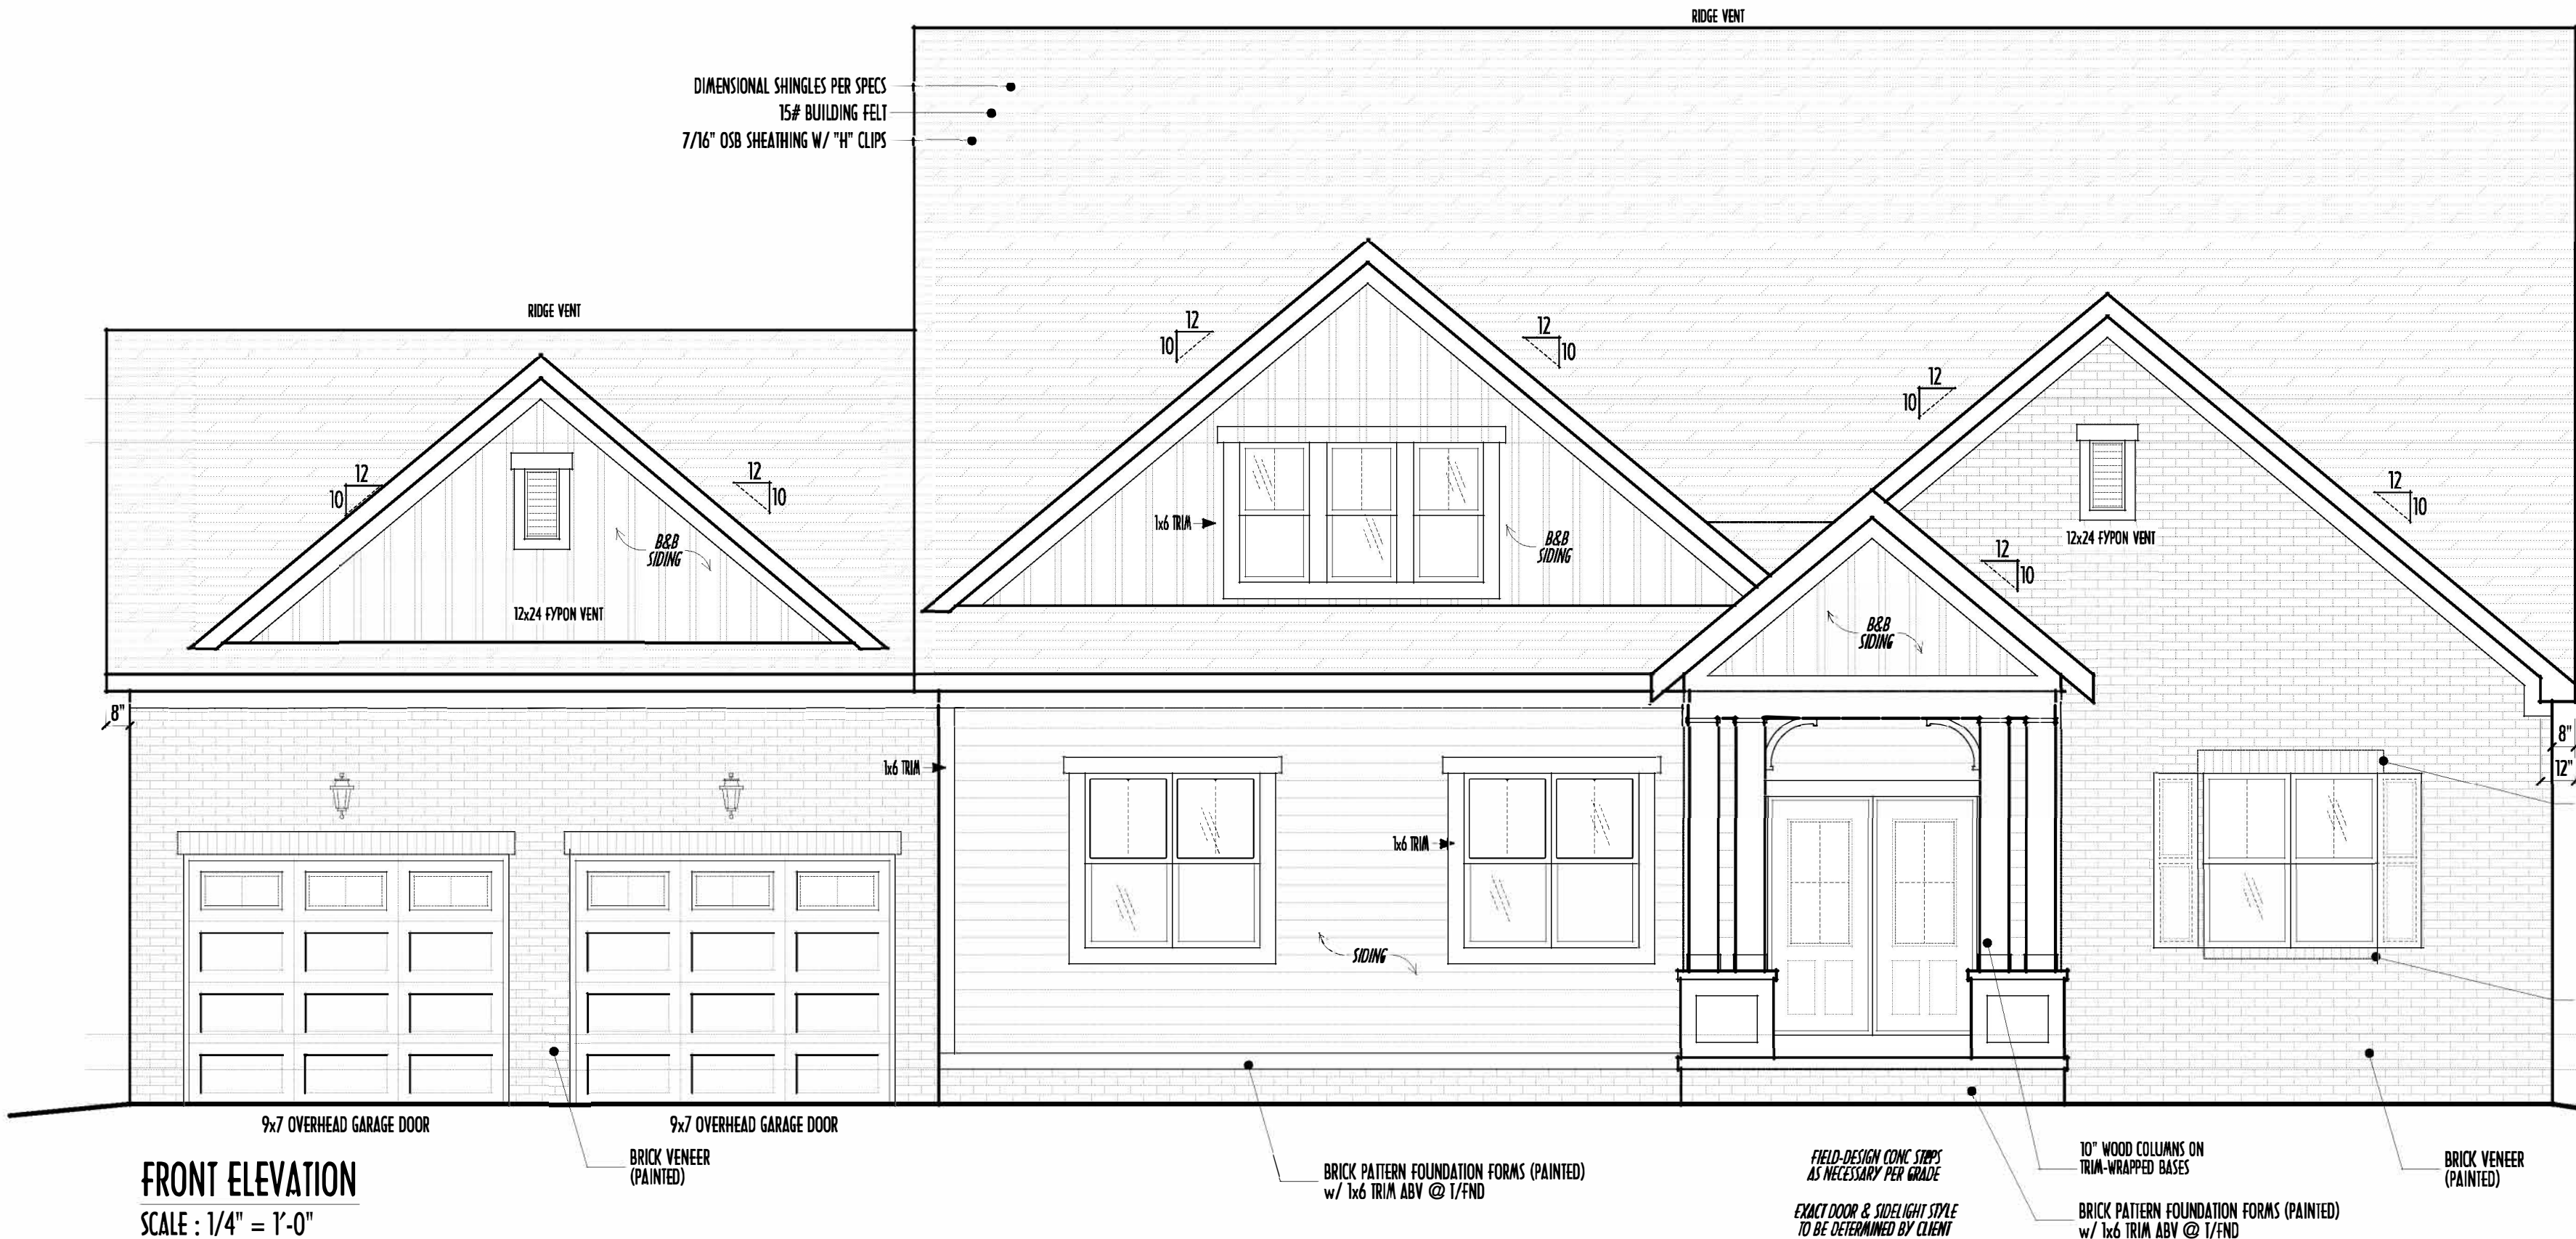


FINAL WINDOW DESIGN PER PROVIDER. ALL FRAMING ROUGH-
OPENINGS TO BE BASED ON FINAL LAYOUT ONLY
EXACT WINDOW & DOOR GRID PATTERNS (MULLIONS)
MAY DIFFER - REFER TO MANUFACTURER OR SUPPLIER
GRADE ELEVATION SHOWN IS APPROXIMATE
FIELD VERIFY & ADJUST FOUNDATION AS NECESSARY

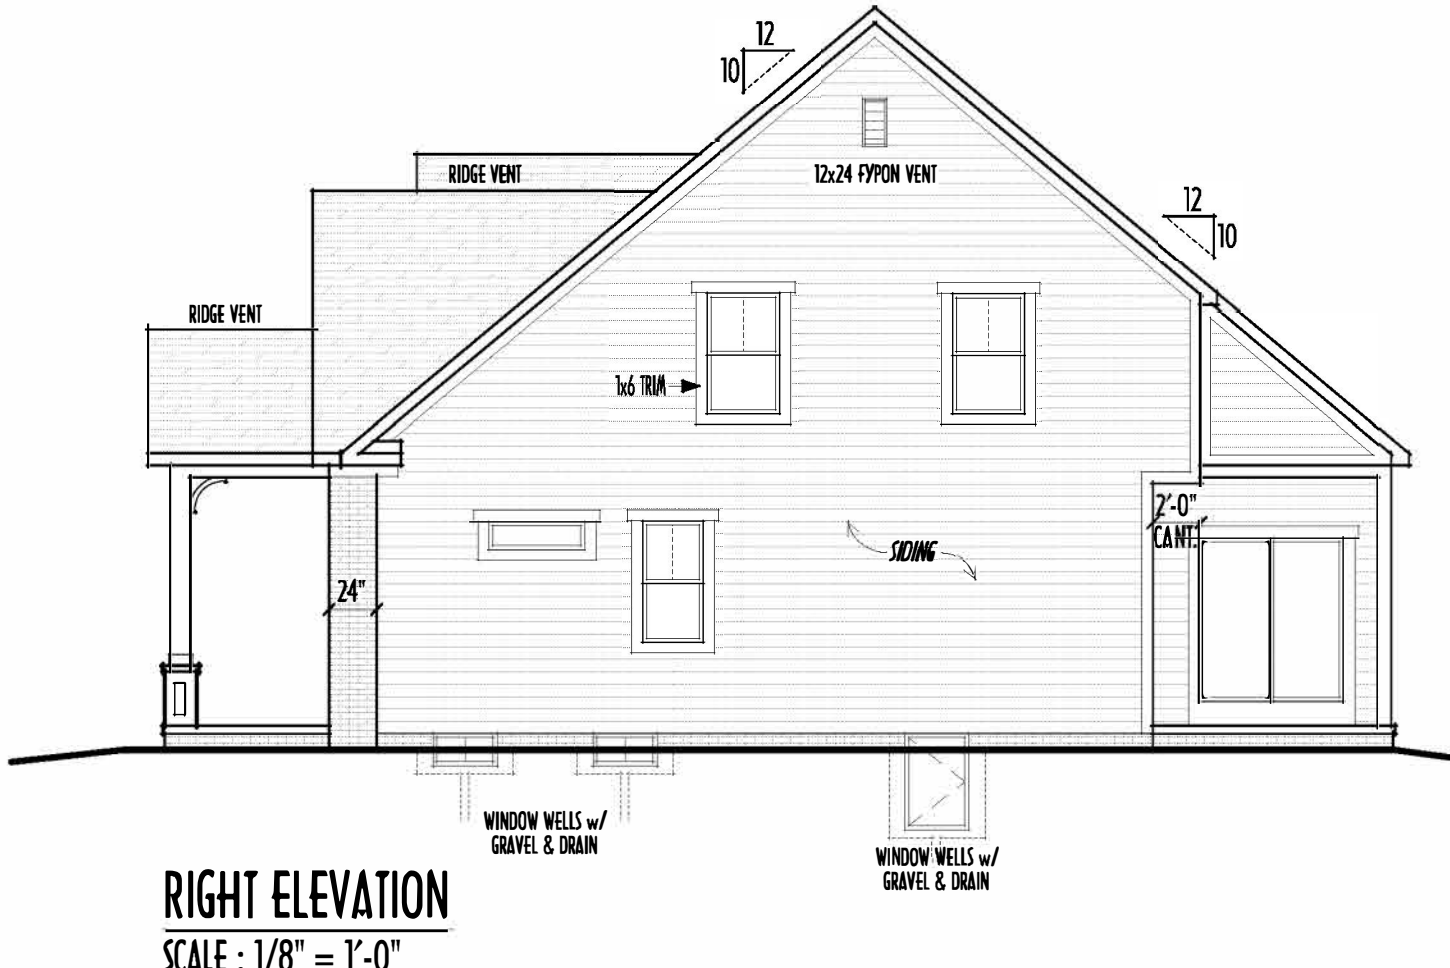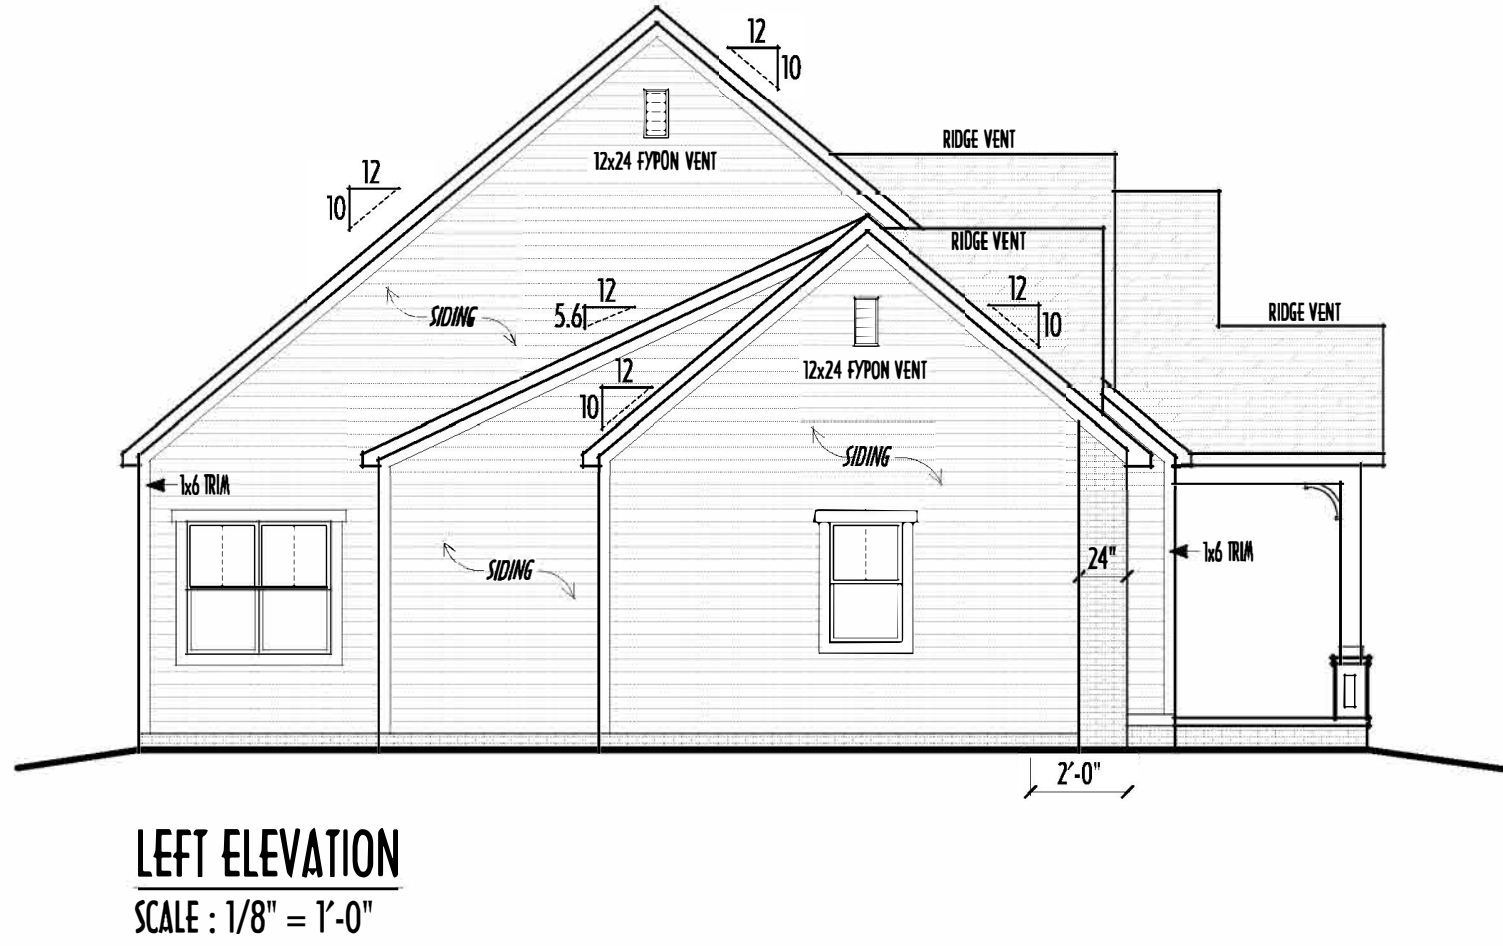

FIRST FLR LIVING SP =	1,690 SQ.FT.
SECOND FLR LIVING SP =	801 SQ.FT.
TOTAL LIVING SP =	2,491 SQ.FT.
OPT FIN. BSMT AREAS =	650 SQ.FT.

P & D
BUILDERS
— EST. 1962 —

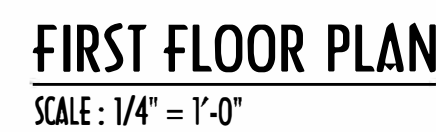

DESIGNED: P&D / rwd
PAGE: 3 of 9


TO-SCALE WHEN PRINTED 24x36 - PAPER SIZE "D"



0 12 24 48 60

DO NOT SCALE PLOTS


PAGE: 3 of 9

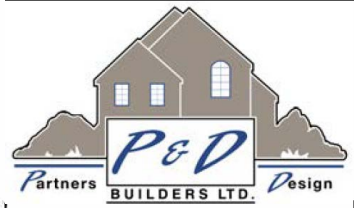

P&D Builders Ltd.
59 Grell Parkway Suite 100
Delaware, Ohio 43015
(740) 201-8079
Fax (740) 201-8084
www.pndbuilders.com


ALL DIMENSIONS ARE THE EXACT SPECIFICATIONS FOR THE PROJECT. NO DIMENSIONS SHALL BE LESS THAN 1/8" UNLESS NOTED. DIMENSIONS SHALL BE MEASURED FROM THE CENTER OF THE ROOM OR THE CENTER OF THE WALL.

- SECOND FLOOR CEILINGS AT 8'-1 1/8" ROUGH UNLESS NOTED
SECOND FLOOR WINDOWS HEADERS AT 6'-10" UNLESS NOTED
EXTERIOR WALLS ARE SHOWN 6" WIDE (2x6 STUDS @ 16" O/C UNLESS NOTED)
INTERIOR WALLS ARE SHOWN 3.5" WIDE (2x4 STUDS @ 16" O/C UNLESS NOTED)
SECOND FLOOR DESIGN LIVE LOAD = 40 PSF (BEDROOMS 30 PSF)
WINDOWS & DOORS (BRAND & DESIGN) PER CONTRACT
INTERIOR DOORS SHOWN 4" OFF CORNERS UNLESS NOTED
IN SLEEPING ROOMS, AT LEAST ONE WINDOW MUST MEET EMERGENCY EGRESS REQUIREMENTS (MIN. 20" WIDE X 24" TALL & 5.7 SQ.FT.) PER I.C.C. 310
CONFIRM WINDOW ROUGH-OPENINGS WITH MANUFACTURER AND ADJUST FRAMING DIMENSIONS AS NECESSARY
NOTE: DIMENSIONS FOR ANGLED WALLS MAY CONTAIN ROUNDING ERRORS OF LESS THAN 1/8" TYPICALLY
FINAL/INSTALLED INSULATION VALUES SHOULD MATCH REA-RATE SHEETS FROM TACOMA ENERGY (THOSE SHOWN ON THESE PLANS ARE PRELIMINARY/REFERENCE ONLY)
INSTALL ALL LVL & LSL BEAMS WITH LABELS VISIBLE FOR BLDG INSPECTION
FOAM PLASTIC/INSULATION SHALL BE INSTALLED PER R20 R30 & R35 <75 PSR, <450 SOR PER ASTM E84

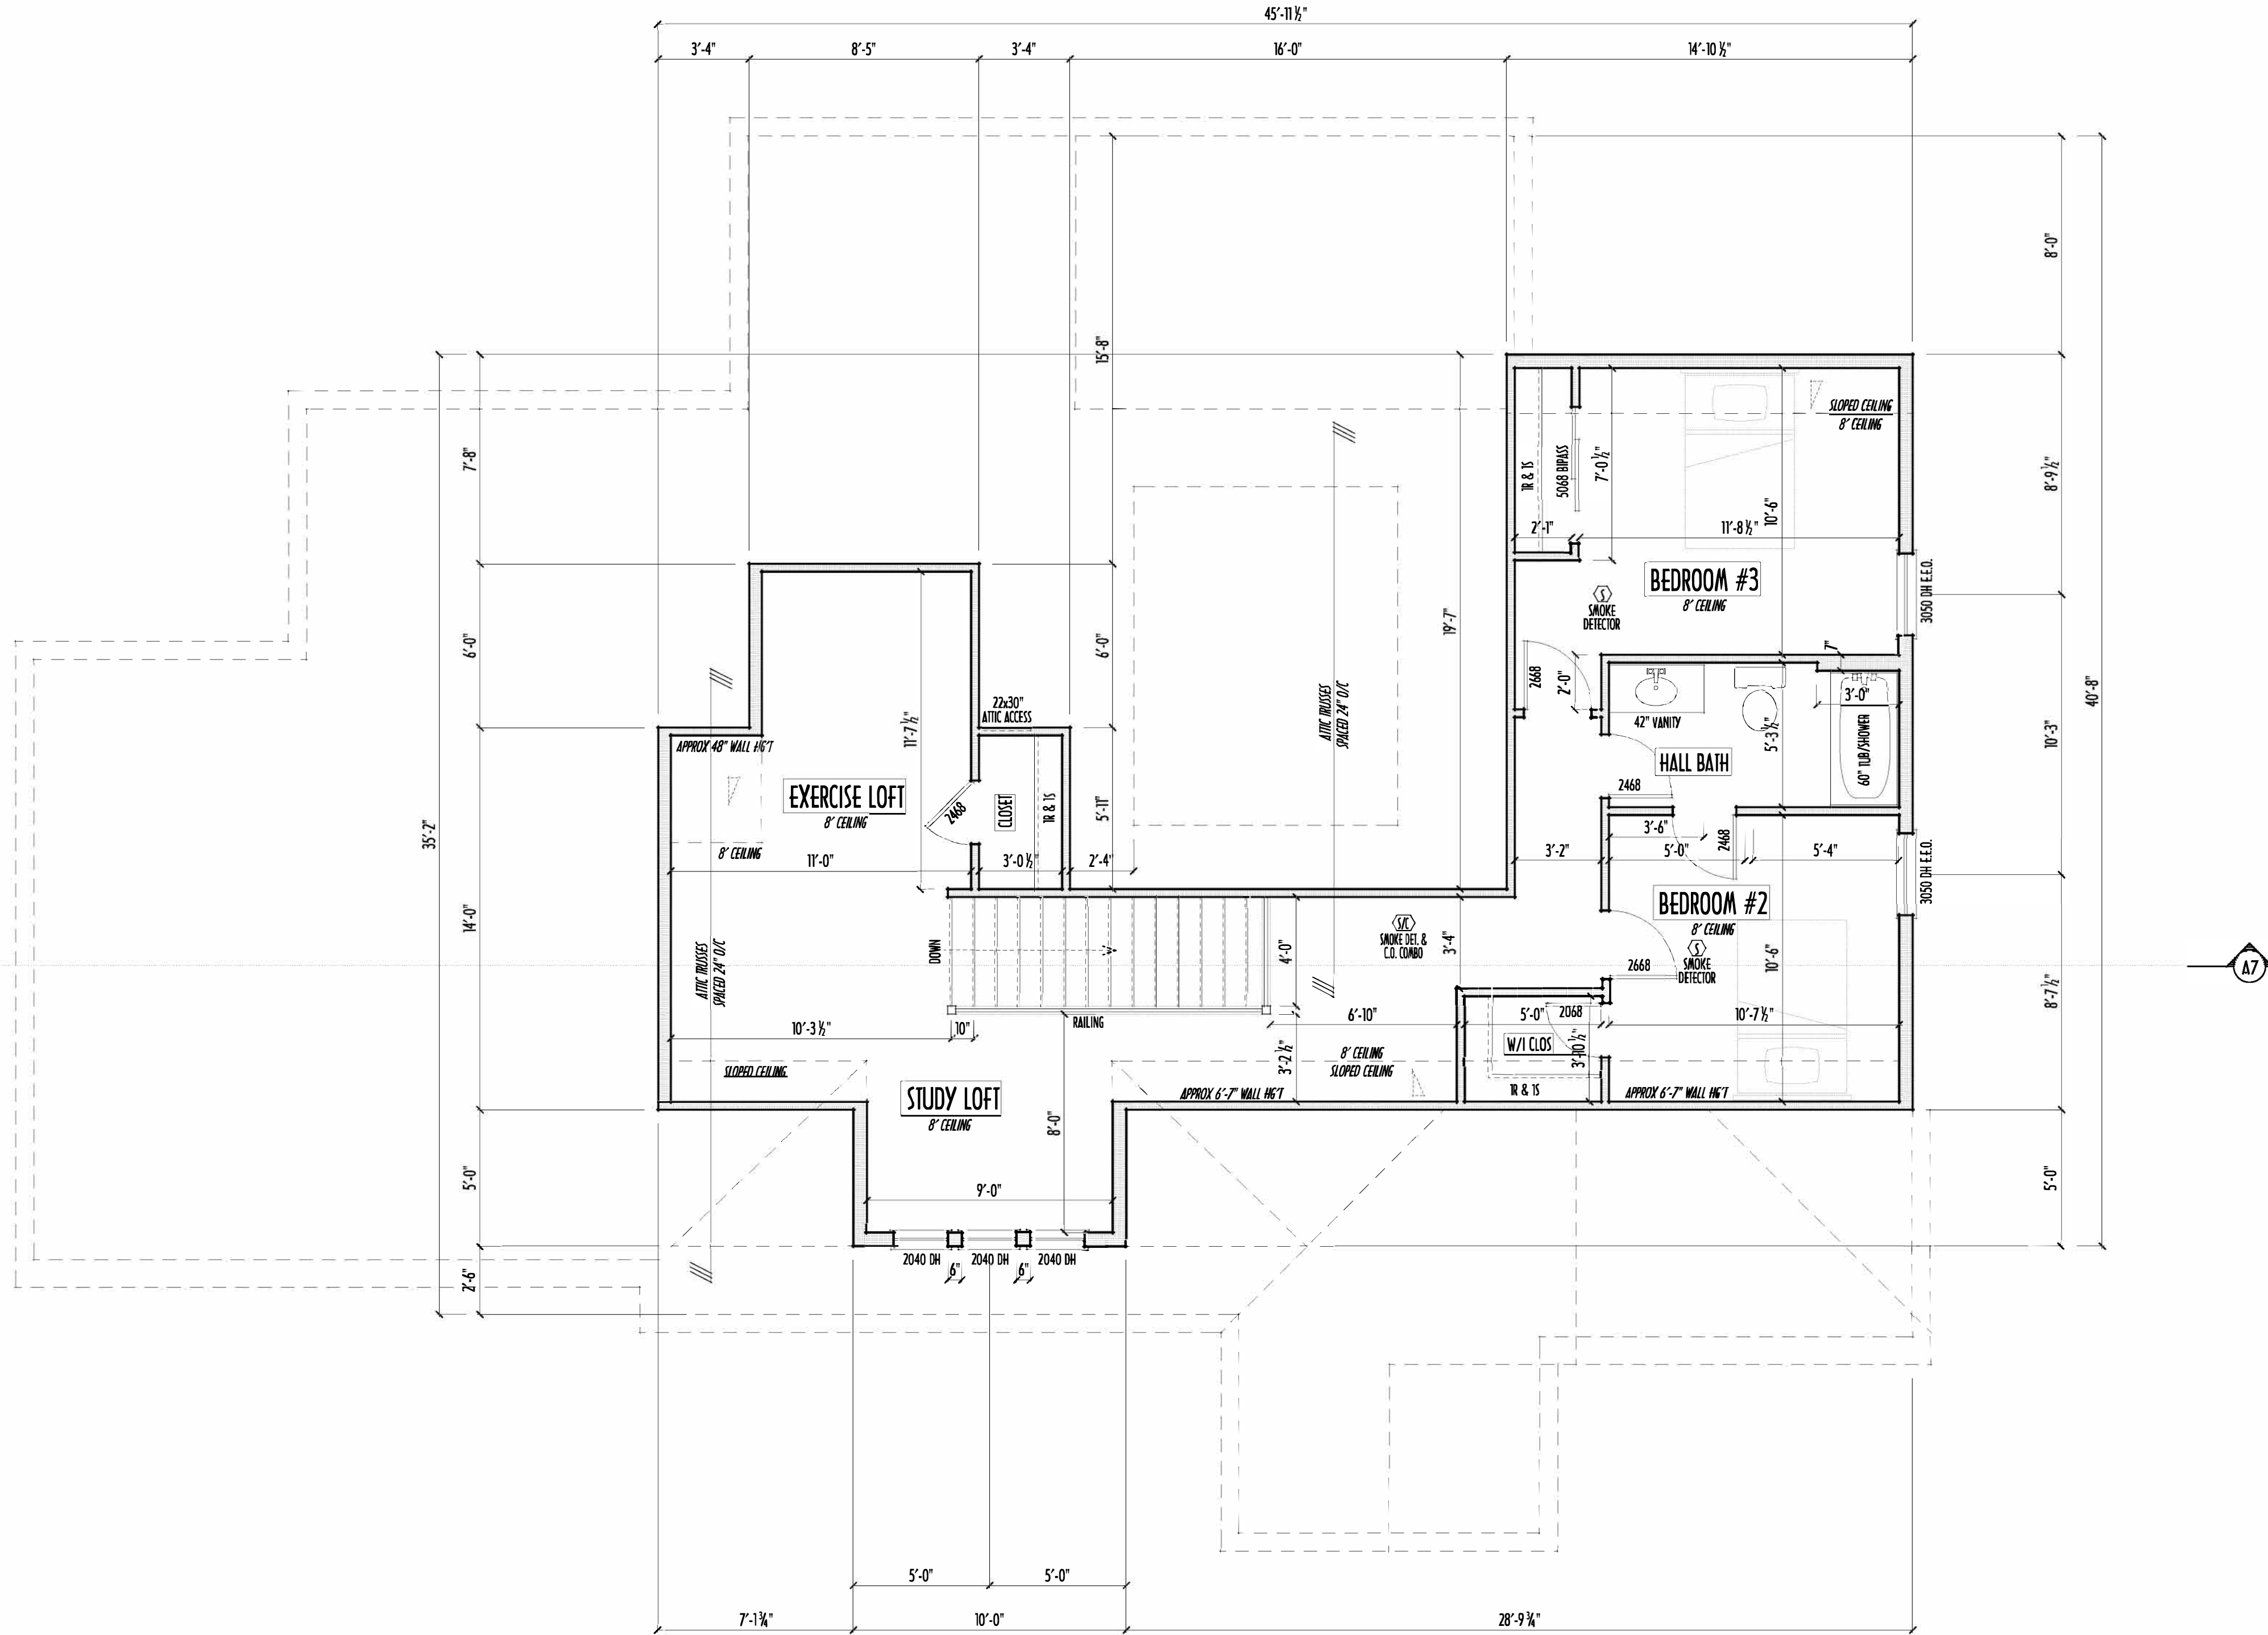

SECOND FLOOR PLAN
SCALE: 1/4" = 1'-0"

FIRST FLR LIVING SP =	1,690 SQ.FT.
SECOND FLR LIVING SP =	801 SQ.FT.
TOTAL LIVING SP =	2,491 SQ.FT.
OPT FIN. BSMT AREAS =	650 SQ.FT.

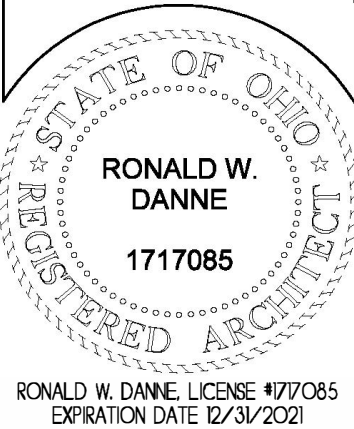


RONALD W. DANNE
1717085
RONALD W. DANNE LICENSE #1717085
EXPIRATION DATE 12/31/2021



Danne
Residential Design & Drafting
614.207.6266 dannehd@gmail.com

REVISION DATE:	BY:	DESCRIPTION
12/8/20	jam	prelim
12/9/20	rwcd	prelim rev
1/19/21	jam	prelim rev
2/23/21	jam	prelim rev
2/26/21	lch	prelim rev
3/1/21	lch	prelim rev
3/3/21	rwcd	prelim rev
3/25/21	L/r	prelim rev

 

MAX. UNBALANCED FILL FOR 8" THICK POURED CONC. WALL OR C.M.U. BLOCK WALL = 7'-0" ABOVE SLAB

WATERPROOFING / DAMPROOFING PER CODE

ALL STRUCTURAL LUMBER IS MIN. CANADIAN SPECIES #2 SPRUCE-PINE-FIR, UNLESS NOTED OTHERWISE

FIRST FLOOR DESIGN LIVE LOAD = 40 PSF

BASEMENT ELECTRICAL LAYOUT FOR REFERENCE ONLY - CONSULT WITH HOMEOWNER PRIOR TO INSTALLATION FOR EXACT LOCATIONS

GRADE MIN. 8" BELOW TOP OF FOUNDATION, SLOPING AWAY FOR PROPER DRAINAGE MIN. 6" DROP IN FIRST 10FT OF RUN

AVOID FLOORJOISTS LOCATED DIRECTLY BELOW PLUMBING DRAINS & TRAPS

BLOCK BETWEEN FLOORJOISTS BELOW STRUCTURAL POINTS (CRUSH ZONES) WITH APPROPRIATE 2X FILL


SEE COVER SHEET FOR GENERAL FOUNDATION CONSTRUCTION NOTES

STEP DOWN FOOTING AS NECESSARY TO REMAIN MIN. 36" BELOW GRADE

USE PRES-TREATED EXTERIOR-GRADE LUMBER WHERE EXPOSED TO WEATHER OR IN CONTACT WITH CONCRETE

FOUNDATION WALL ENGINEERING & REINFORCEMENT PER SHEPHERD EXCAVATING DESIGN-DETAIL, INC-16

INSTALL ALL LVL & LSL BEAMS WITH LABELS VISIBLE FOR BLDG INSPECTION

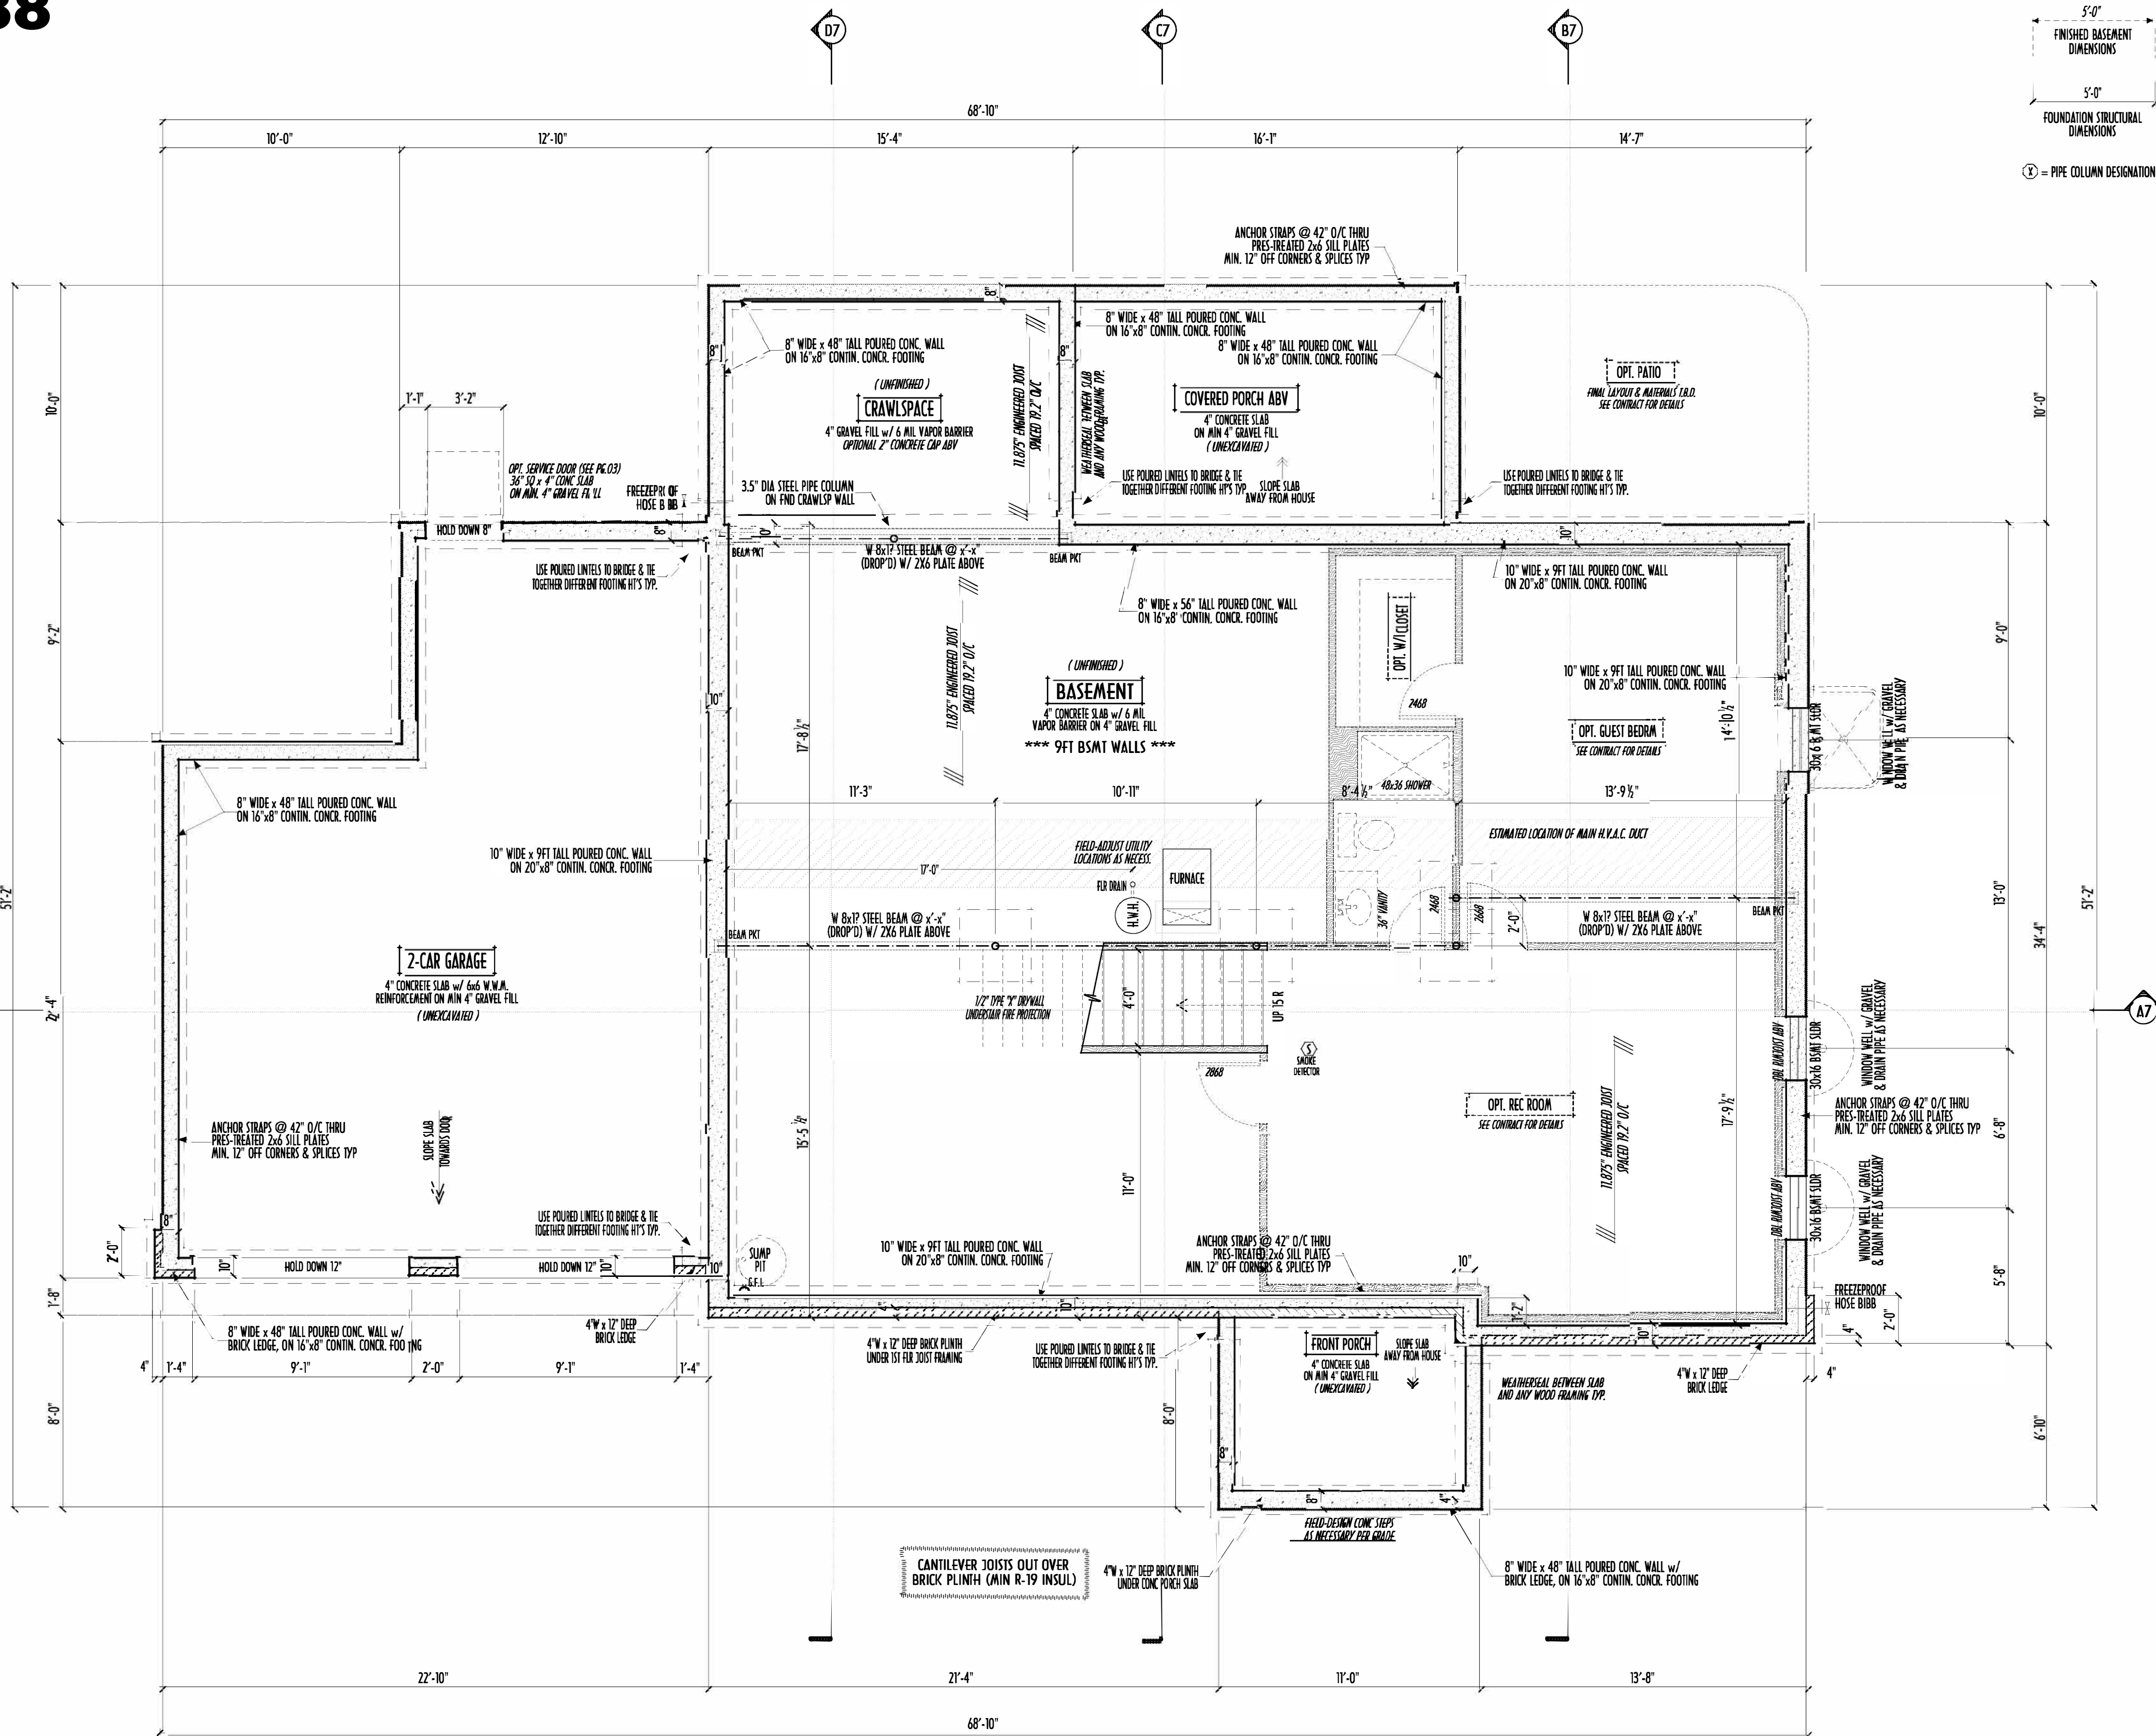

FOUNDATION / BASEMENT PLAN
SCALE: 1/4" = 1'-0"

FIRST FLR LIVING SP = 1,690 SQ.FT.
SECOND FLR LIVING SP = 801 SQ.FT.
TOTAL LIVING SP = 2,491 SQ.FT.
OPT FIN. BSMT AREAS = 650 SQ.FT.

FND/BSMT



P&D Builders Ltd.
59 Grell Parkway Suite 100
Delaware, Ohio 43015
(740) 201-8079
Fax (740) 201-8084
www.pndbuilders.com

ALL DRAWINGS ARE THE PROPERTY OF P&D BUILDERS LTD.
NO REPRODUCTION OR OTHER USE IS PERMITTED WITHOUT THE WRITTEN CONSENT OF THE AUTHOR OF THE PLANS.

1488

1717085

RONALD W. DANNE
1717085
RESIDENTIAL DESIGN & DRAFTING INC.
614.207.6266 danne.rwd@gmail.com

REVISION DATE:	BY:	DESCRIPTION
12/8/20	jam	prelim
12/9/20	rwd	prelim rev
1/19/21	jam	prelim rev
2/23/21	jam	prelim rev
2/26/21	lch	prelim rev
3/1/21	lch	prelim rev
3/3/21	rwd	prelim rev
3/25/21	L/r	prelim rev

TO SCALE WHEN PRINTED 24x36 - PAPER SIZE 11"

0 6 12 24 48 60"

FIELD VERTICALLY DIMENSIONING - DO NOT SCALE DIMS

DESIGNED: P&D / rwd

PAGE: 2 of 9