

P&D Builders - Job # 1291

PLEASE NOTE: PRELIMINARY DESIGNS ARE SUBJECT TO CHANGE DUE TO STRUCTURAL OR CODE REQUIREMENTS. ITEMS SHOWN MAY BE OPTIONAL/EXTRA. PLEASE REFER TO YOUR CONTRACT FOR SPECIFICATIONS & DESCRIPTIONS.

1ST FLR



P&D Builders Ltd.
59 Greif Parkway Suite 100
Delaware, Ohio 43015
(740) 201-8079
Fax (740) 201-8084
www.pndbuilders.com

ALL NOTES ARE THE PROPERTY OF P&D BUILDERS LTD.
NO REPRODUCTION OR CIRCULATION OF THESE PLANS MAY BE MADE
WITHOUT WRITTEN CONSENT OF THE AUTHOR OF THE PLANS.

1291

P&D JOB #

1291

1291


1291

1291

1291


PRELIMINARY DESIGN
NOT TO SCALE - NOT FOR CONSTRUCTION

FIRST FLOOR CEILINGS AT 9'-1 1/8" UNLESS NOTED OTHERWISE
FIRST FLOOR WINDOWS HEADERS AT 7'-6" UNLESS NOTED OTHERWISE
CONTRACTORS TO SITE VERIFY ALL DIMENSIONS AND REPORT ANY DISCREPANCIES WITH THE PLANS TO THE JOB SUPERVISOR ASAP
FIRST FLOOR DESIGN LIVE LOAD = 40 PSF
ALL FRAMING AND STRUCTURAL CONSTRUCTION IS TO CONFORM TO 2013 R.C.O. AND/OR APPLICABLE LOCAL CODES
WINDOWS & DOORS (BRAND & DESIGN) PER CONTRACT
CONFIRM WINDOW ROUGH-OPENINGS AND HEADER HSTS w/ PROVIDER
CONFIRM FLOORING & FINISH MATERIALS w/ JOB SUPERVISOR (PER CONTRACT)
ALL DIMENSIONS CORRESPOND TO EITHER CENTERLINES OR CORNERS OF WOOD FRAMING LENGTHS AND/OR PENETRATION
AVOID FLOORJOISTS LOCATED DIRECTLY BELOW PLUMBING DRAINS
BLOCK BETWEEN FLOORJOISTS BELOW STRUCTURAL POINTS (CRUSH ZONES)
BRACE FLOORJOISTS AT MIDSPAN PER CODE
INTERIOR DOORS SHOWN 4" OFF CORNERS UNLESS NOTED
NOTE: DIMENSIONS FOR ANGLED WALLS MAY CONTAIN ROUNDING ERRORS OF LESS THAN 1/8" TYPICALLY
FINAL/INSTALLED INSULATION VALUES SHOULD MATCH REM-RATE SHEETS FROM TACOMA ENERGY (THOSE SHOWN ON THESE PLANS ARE PRELIMINARY/REFERENCE ONLY)
INSTALL ALL LVL & LSL BEAMS WITH LABELS VISIBLE FOR BLOG INSPECTION

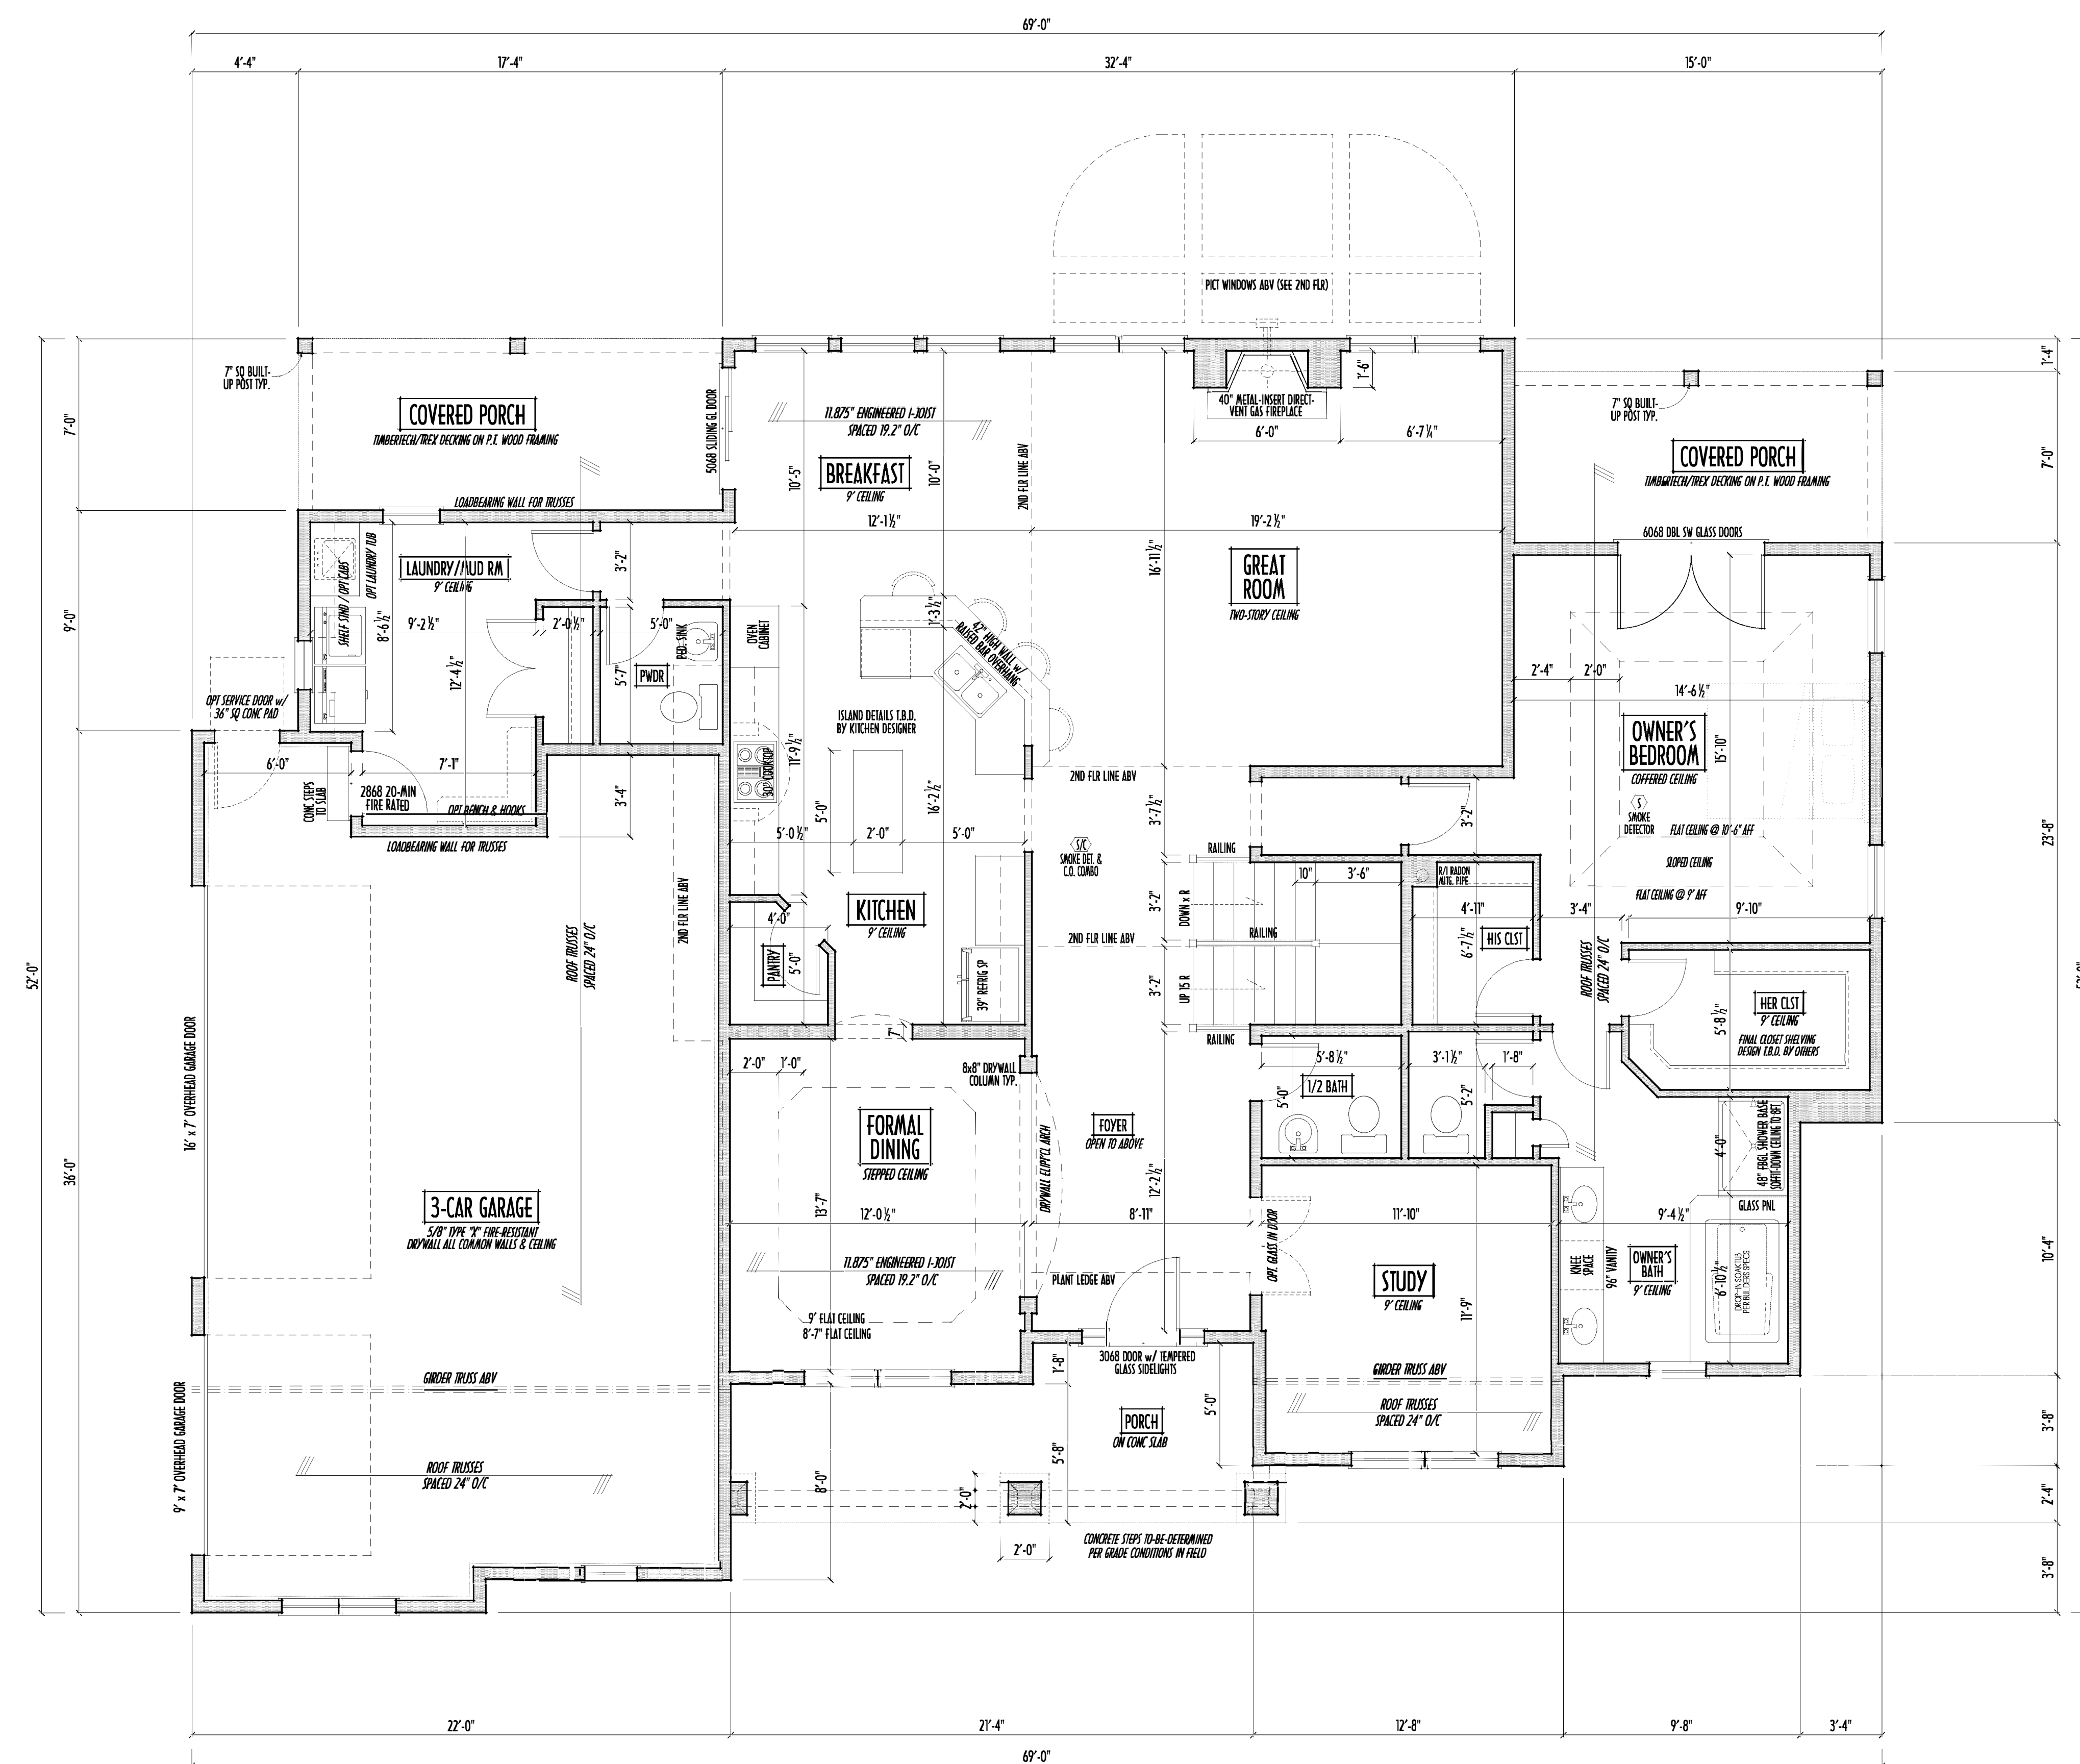

FIRST FLOOR PLAN
SCALE: 1/4" = 1'-0"

FIRST FLR LIVING SP =	2,086 SQ.FT.
SECOND FLR LIVING SP =	627 SQ.FT.
TOTAL LIVING SP =	2,713 SQ.FT.
OPT. FINISHED BSMT =	1,257 SQ.FT.

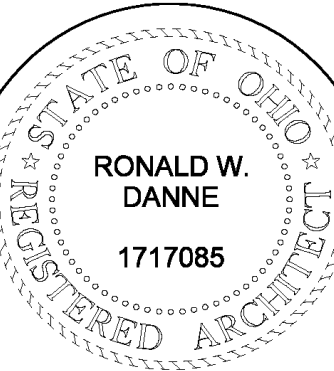

RONALD W. DANNE, LICENSE #1717085
EXPIRATION DATE 12/31/2017

Danne
Residential Design & Drafting, LLC
618.207.6266 danne@danne.com

REVISION DATE:	BY:	REVISED
11/13/17	rwd	concepts
		prelims

TO SCALE WHEN PRINTED 24" x 36" - PAPER SIZE 11"
0' 0" 24' 48' 60'
FIELD HATCH OR CROSSING - DO NOT SCALE PRINTS

DESIGNED: P&D / rwd

PAGE: 3 OF 8

P&D Builders - Job # 1291



PLEASE NOTE: PRELIMINARY DESIGNS ARE SUBJECT TO CHANGE DUE TO STRUCTURAL OR CODE REQUIREMENTS. THIS DRAWING MAY BE OBTAINED EXTRA. PLEASE REFER TO YOUR CONTRACT FOR SPECIFICATIONS & DESCRIPTIONS.

P&D

Partners

BUILDERS LTD.

Design

P&D Builders Ltd.

59 Grief Parkway Suite 100

Delaware, Ohio 43015

(740) 201-8079

Fax (740) 201-8084

www.pndbuilders.com

11/13/17

NO PRODUCTION OR REUSE OF THESE DRAWINGS IS ALLOWED WITHOUT WRITTEN CONSENT OF THE ARCHITECT. THE ARCHITECT

1291

STATE OF OHIO

REGISTERED ARCHITECT

RONALD W. DANNE

1717085

RONALD W. DANNE LICENSE #177085

EXPIRATION DATE 12/31/2017

Danne

Residential Design & Drafting, Inc.

614.207.6266

dannedan@gmail.com

REVISION DATE: 11/13/17

BY: rwd / concepts

...

...

prelims


TO SCALE WHEN PRINTED 24x36 - PAPER SIZE 11x17

0 2 4 8 16

FEET - METERS (ROUNDING - DO NOT SCALE PRINTS)

DESIGNED: P&D / rwd

PAGE: 4 of 9

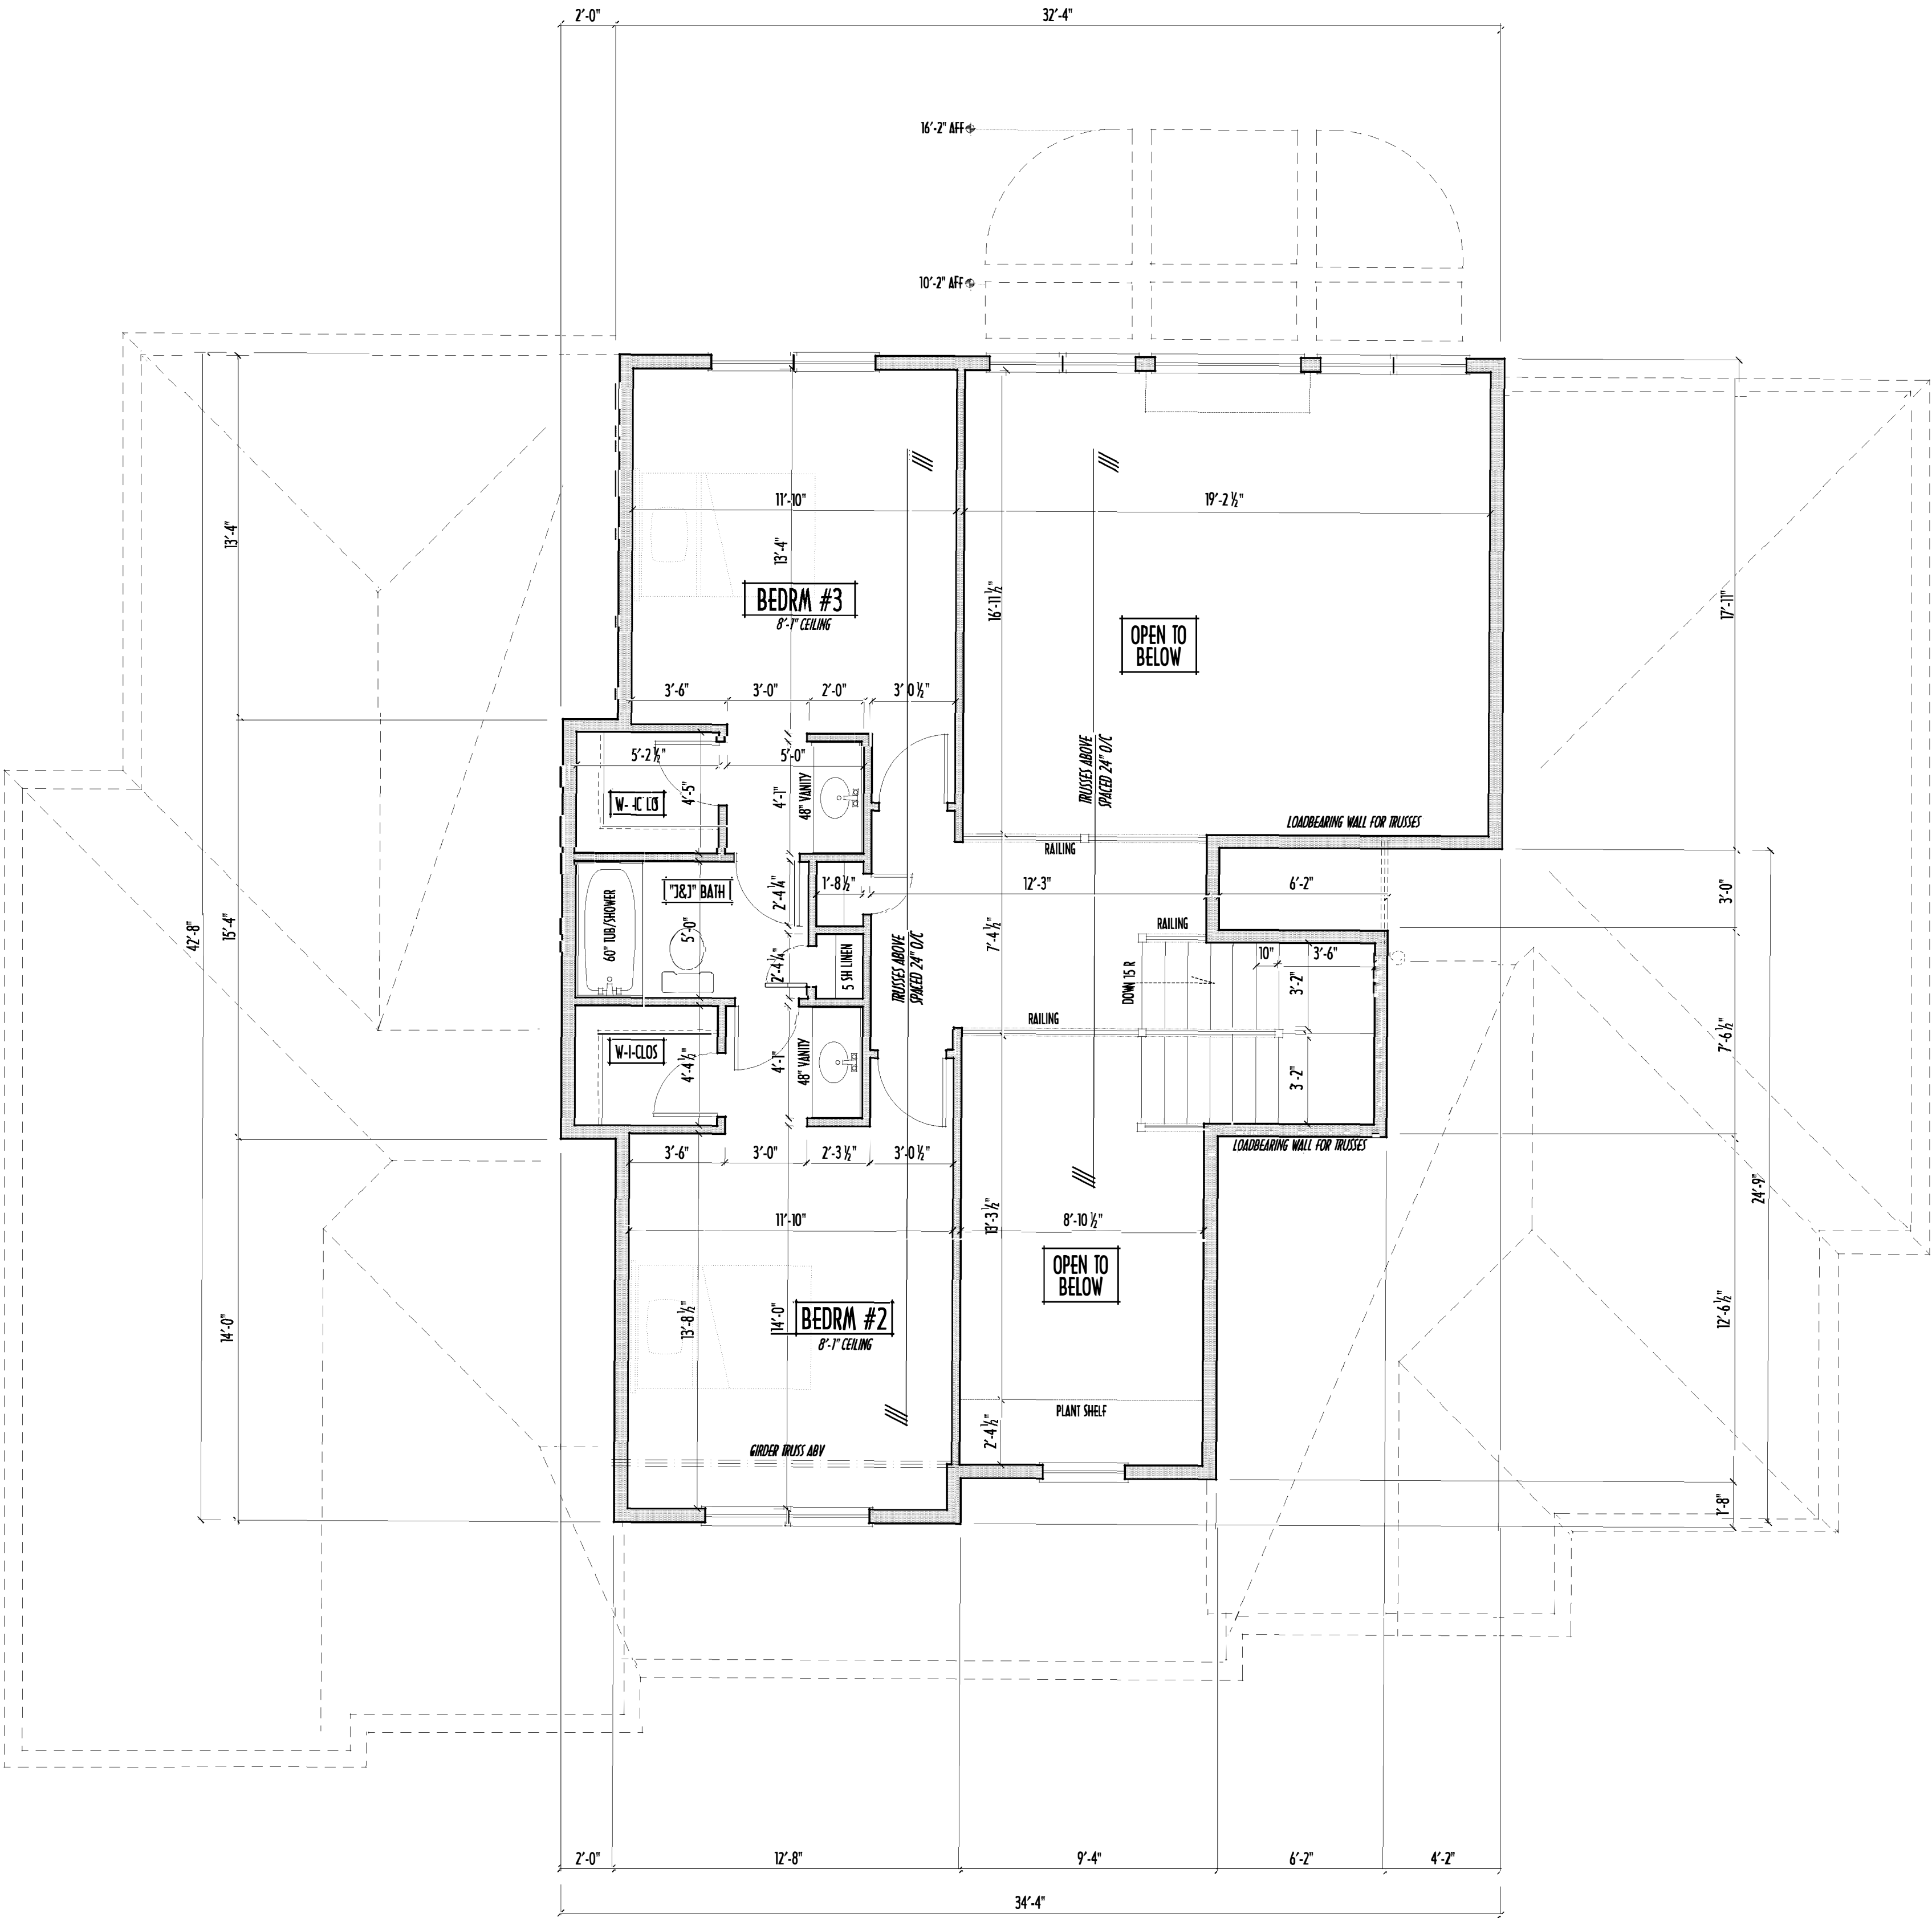

SECOND FLOOR PLAN
SCALE: 1/4" = 1'-0"

FIRST FLR LIVING SP =	2,086 SQ.FT.
SECOND FLR LIVING SP =	627 SQ.FT.
TOTAL LIVING SP =	2,713 SQ.FT.
OPT. FINISHED BSMT =	1,257 SQ.FT.

PRELIMINARY DESIGN
NOT TO SCALE - NOT FOR CONSTRUCTION

P&D Builders - Job # 1291



PLEASE NOTE: PRELIMINARY DESIGNS ARE SUBJECT TO CHANGE DUE TO STRUCTURAL OR CODE REQUIREMENTS. ITEMS SHOWN MAY BE OPTIONAL/EXTRA. PLEASE REFER TO YOUR CONTRACT FOR SPECIFICATIONS & DESCRIPTIONS.

5'-0" FINISHED BASEMENT DIMENSIONS

5'-0" FOUNDATION STRUCTURAL DIMENSIONS

③ = PIPE COLUMN DESIGNATION

MAX. UNBALANCED FILL FOR 8" THICK POURED CONC. WALL OR C.A.L.U. BLOCK WALL = 7'-0" ABOVE SLAB

WATERPROOFING / DAMPROOFING PER CODE

ALL STRUCTURAL LUMBER IS MIN. CANADIAN SPECIES #2 SPRUCE-PINE-FIR, UNLESS NOTED OTHERWISE

FIRST FLOOR DESIGN LIVE LOAD = 40 PSF

BASEMENT ELECTRICAL LAYOUT FOR REFERENCE ONLY - CONSULT WITH HOMEOWNER PRIOR TO INSTALLATION FOR EXACT LOCATIONS

GRADE MIN. 8" BELOW TOP OF FOUNDATION, SLOPING AWAY FOR PROPER DRAINAGE MIN. 6" DROP IN FIRST 10 FT OF RUN

AVOID FLOORJOISTS LOCATED DIRECTLY BELOW PLUMBING DRAINS & TRAPS

BLOCK BETWEEN FLOORJOISTS BELOW STRUCTURAL POINTS (CRUSH ZONES) WITH APPROPRIATE 2X FILL


SEE COVER SHEET FOR GENERAL FOUNDATION CONSTRUCTION NOTES

STEP DOWN FOOTING AS NECESSARY TO REMAIN MIN. 36" BELOW GRADE

USE PRES-TREATED EXTERIOR-GRADE LUMBER WHERE EXPOSED TO WEATHER OR IN CONTACT WITH CONCRETE

FOUNDATION WALL ENGINEERING & REINFORCEMENT PER SHEPHERD EXCAVATING DESIGN-DETAIL RC-16

INSTALL ALL LVL & LSL BEAMS WITH LABELS VISIBLE FOR BLDG INSPECTION

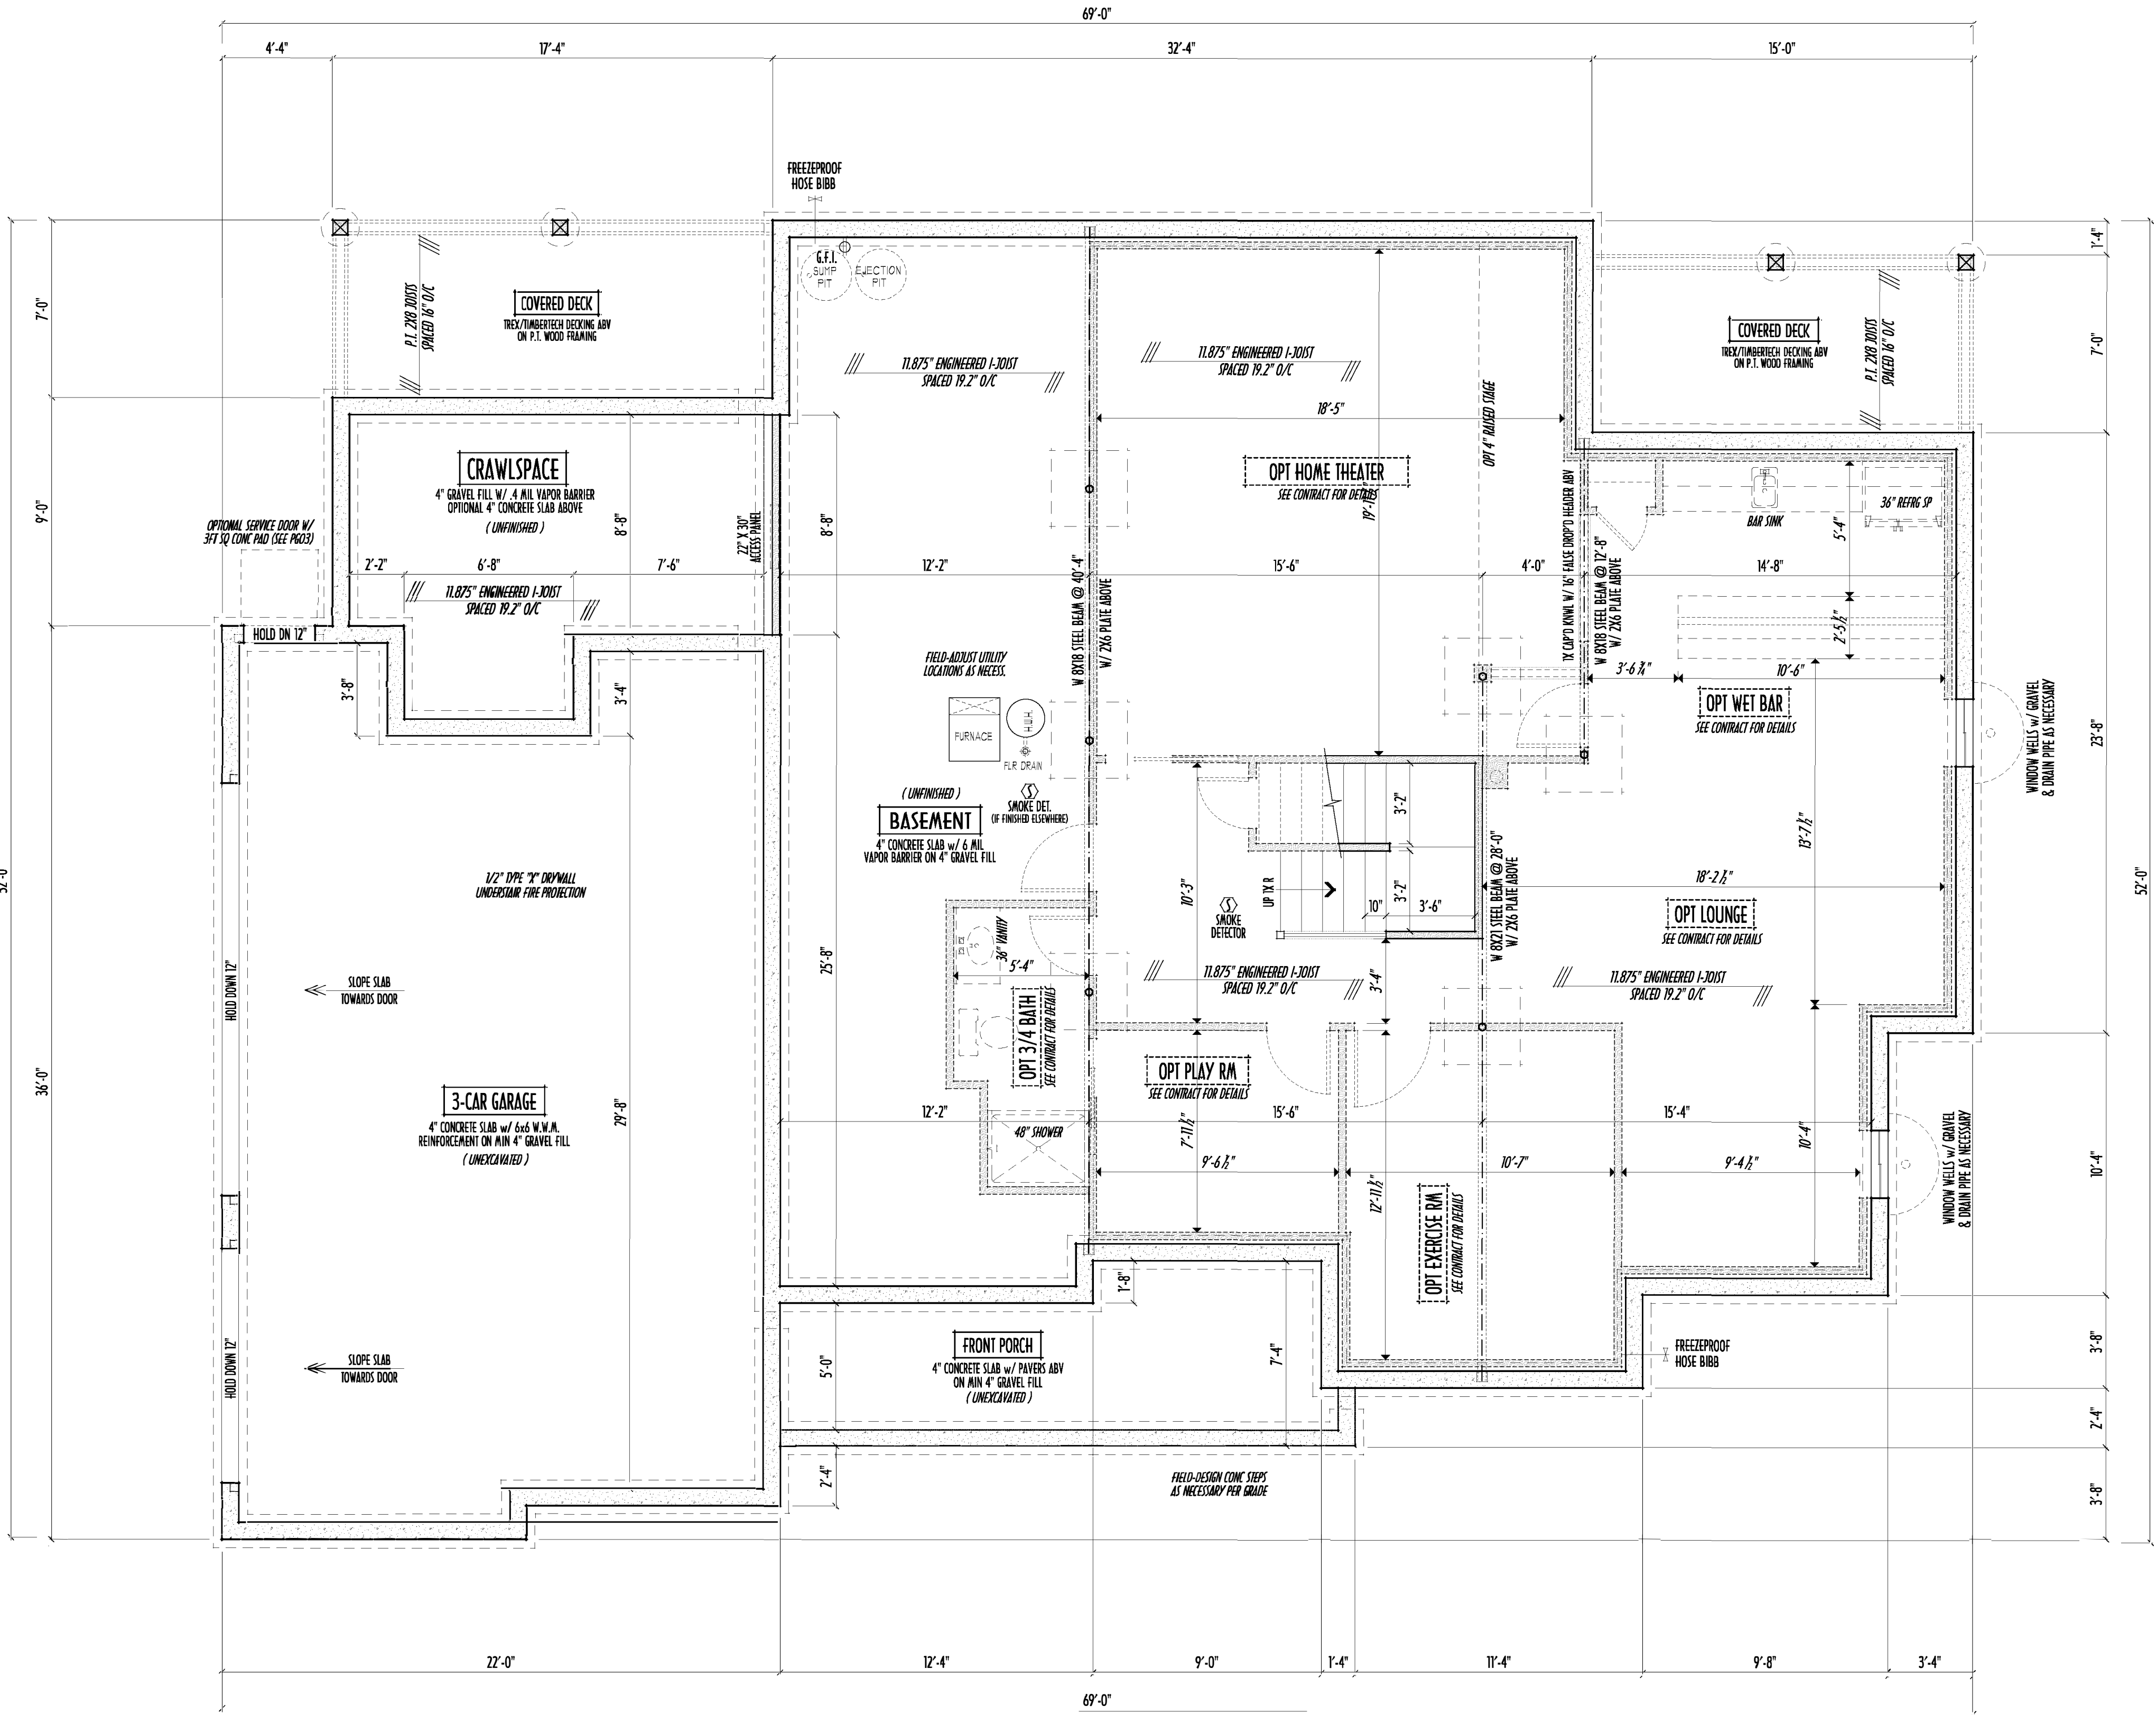

FOUNDATION / BASEMENT PLAN
SCALE : 1/4" = 1'-0"

FIRST FLR LIVING SP =	2,086 SQ.FT.
SECOND FLR LIVING SP =	627 SQ.FT.
TOTAL LIVING SP =	2,713 SQ.FT.
OPT. FINISHED BSMT =	1,257 SQ.FT.

FND/BSMT

P&D BUILDERS LTD.

P&D Builders Ltd.

59 Greif Parkway Suite 100
Delaware, Ohio 43015
(740) 201-8079
Fax (740) 201-8084
www.pndbuilders.com

ALL DIMENSIONS ARE THE UNLESS OTHERWISE NOTED. NO DIMENSIONS OR SPECIFICATIONS OF THESE PLANS ARE TO BE USED WITHOUT FIRST HAVING BEEN CHECKED BY THE ARCHITECT OF THE PLANS.

NO. 1291

PRELIMINARY DESIGN
NOT TO SCALE - NOT FOR CONSTRUCTION

RONALD W. DANNE
1717085

RONALD W. DANNE, LICENSE #177085
EXPIRATION DATE 12/31/2017

Danne
Residential Design & Drafting, Inc.

614.207.6266 danne.dan@gmail.com

REVISION DATE: 11/13/17 BY: rwd concepts

... .. prelims

10 SCALE: 1/4" = 1'-0" (PLAN) 1/8" = 1'-0" (SECTION)

FIELD DIMENSIONS - DO NOT SCALE PRINTS

DESIGNED: P&D / rwd

PAGE: 2 of 9