


P&D Builders - Job # 1541

FIRST FLOOR CEILINGS @ 9'-1 1/8" UNLESS NOTED OTHERWISE
FIRST FLOOR WINDOW HEADERS @ 7'-5" UNLESS NOTED OTHERWISE
SECOND FLOOR CEILINGS @ 8'-1 1/8" UNLESS NOTED OTHERWISE
SECOND FLOOR WINDOW HEADERS @ 6'-10" UNLESS NOTED OTHERWISE
EMERGENCY EGRESS OPERABLE (E.E.O.) WINDOWS IN ALL BEDROOMS
SEE ROOF PLAN FOR SOFFIT & RAKE SIZES
RUN BRICK VENEER 1" PAST FRAMING CORNERS
CULTURED STONE VENEER WRAPS FRONT CORNERS MIN 6"
INTO 1X6 WOOD TRIM UNLESS NOTED
FLASH & CAULK ELEVATIONS AS NECESSARY TO PROVIDE A
A WEATHER-TIGHT SEAL BETWEEN MATERIALS, FRAMING & TRIM


WINDOWS & DOORS (BRAND & DESIGN PER CONTRACT
WINDOWS & DOORS ARE TO BE INSTALLED PER MANUFACTURERS SPECIFICATIONS
CONFORM WINDOW SIZES & ROUGH-OPENINGS WITH SUPPLIER
RUN STUCCO, STONE & BRICK VENEER TO GRADE UNLESS NOTED
WEEP SCREEDS FOR STUCCO EXTERIORS SHALL COMPLY WITH R-703.6.2.1
(#36 GALV CORROSION-RESISTANT SCREED AT/ABV FOUNDATION PLATE (3.5" FLANGE)
PLACED AT MIN 4" ABV EARTH / 2" ABV PAVING, ALLOWING TRAP'D WATER TO DRAIN)
SLOPE GRADE AWAY FROM FOUNDATION FOR PROPER DRAINAGE



LEFT SIDE ELEVATION
SCALE : 3/16" = 1'-0"

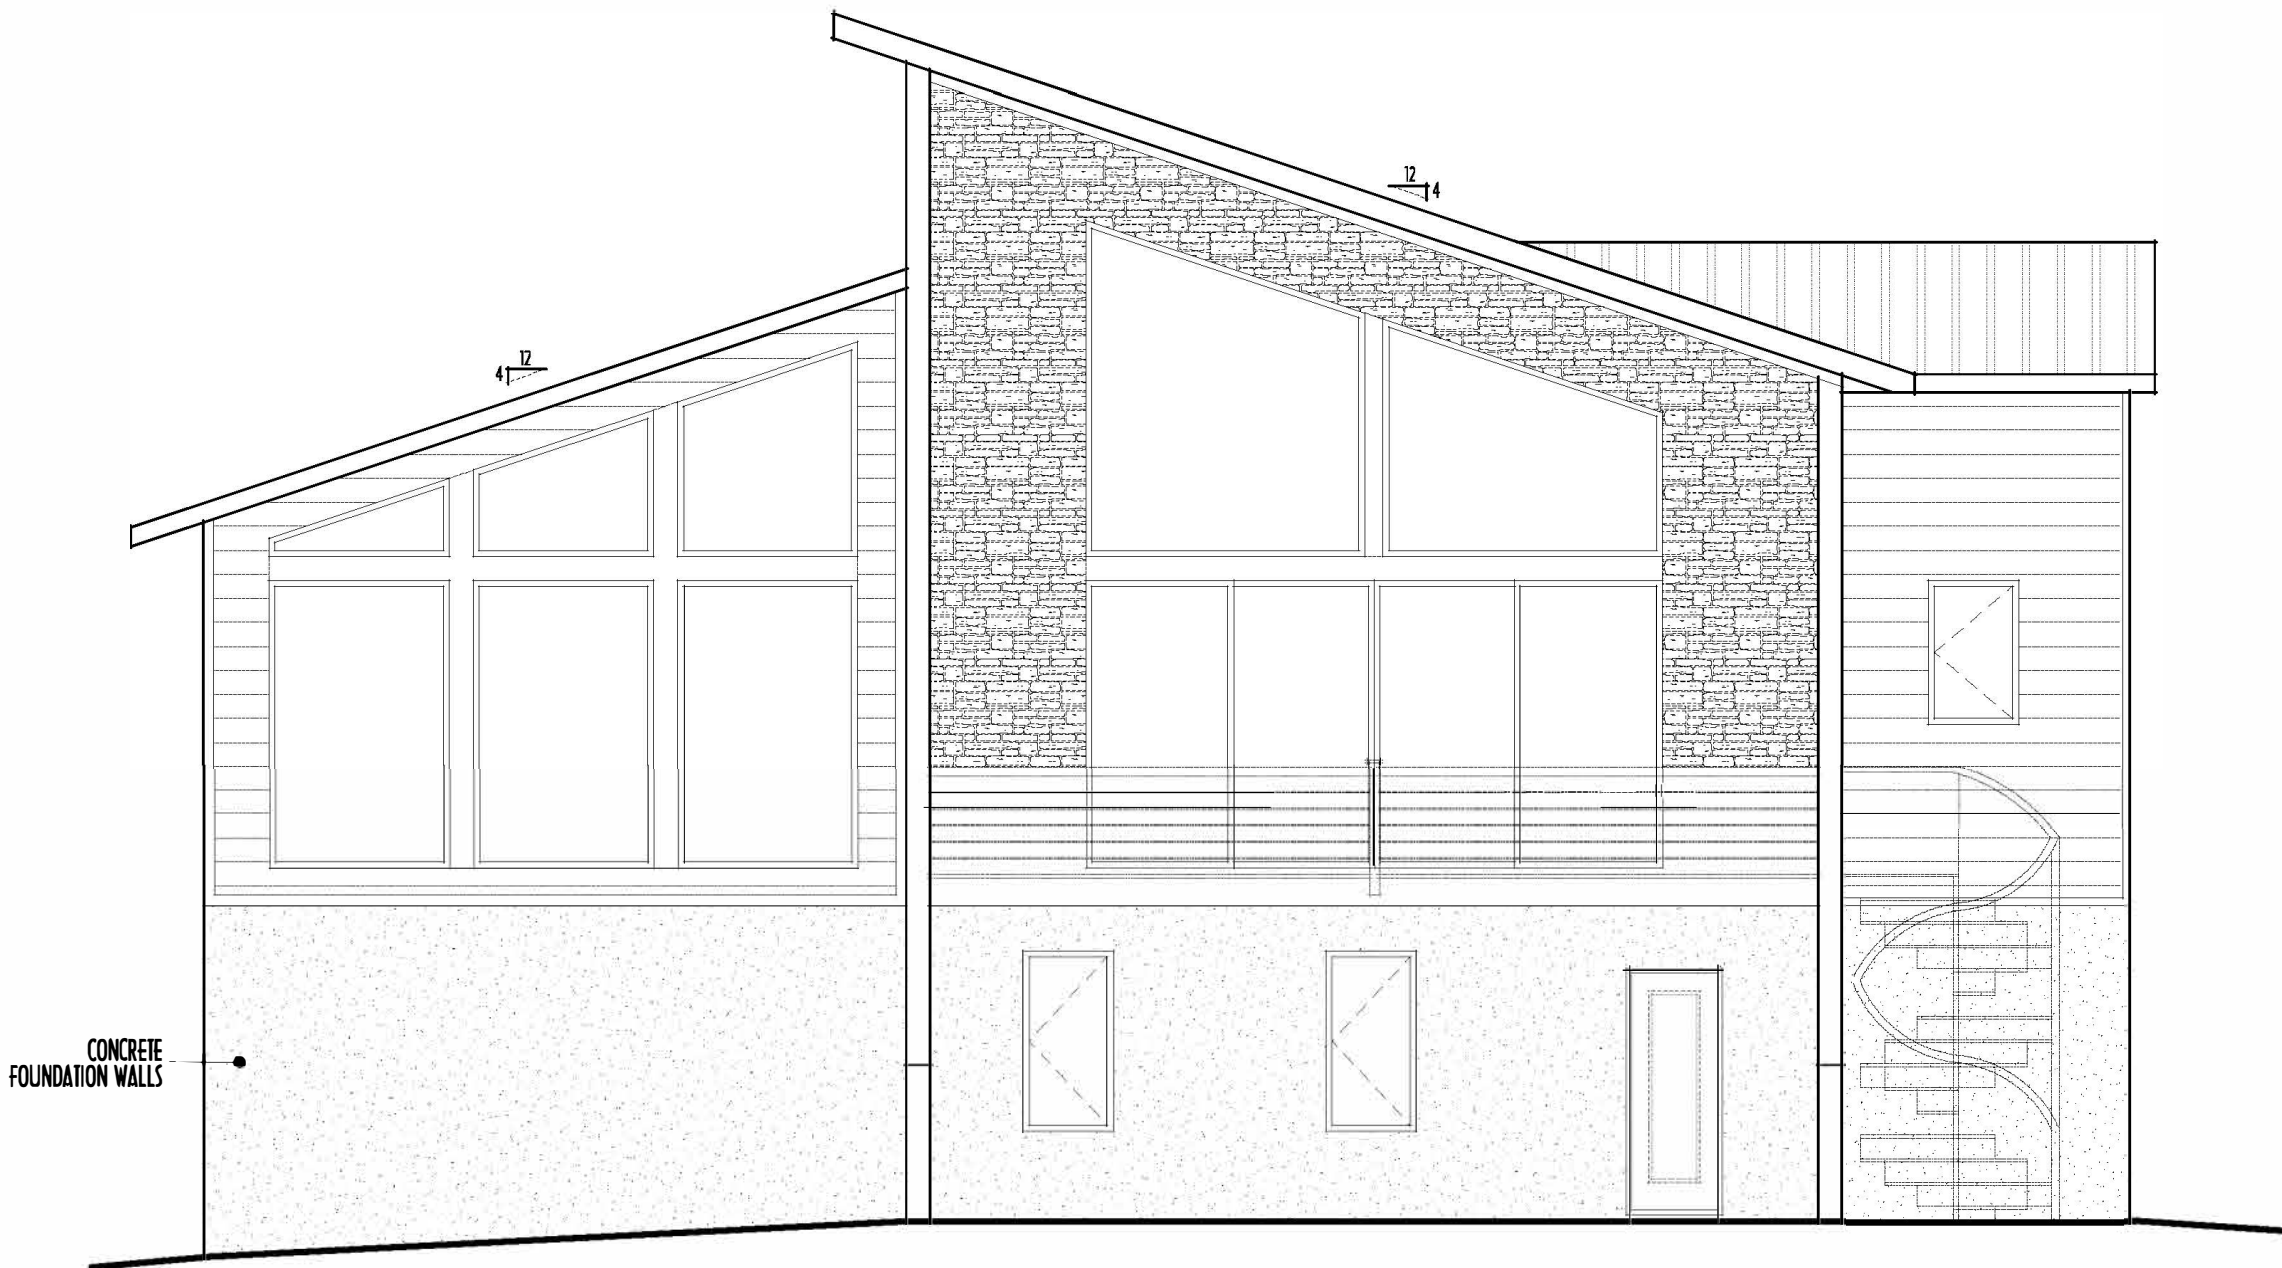


BACK ELEVATION
SCALE : 3/16" = 1'-0"

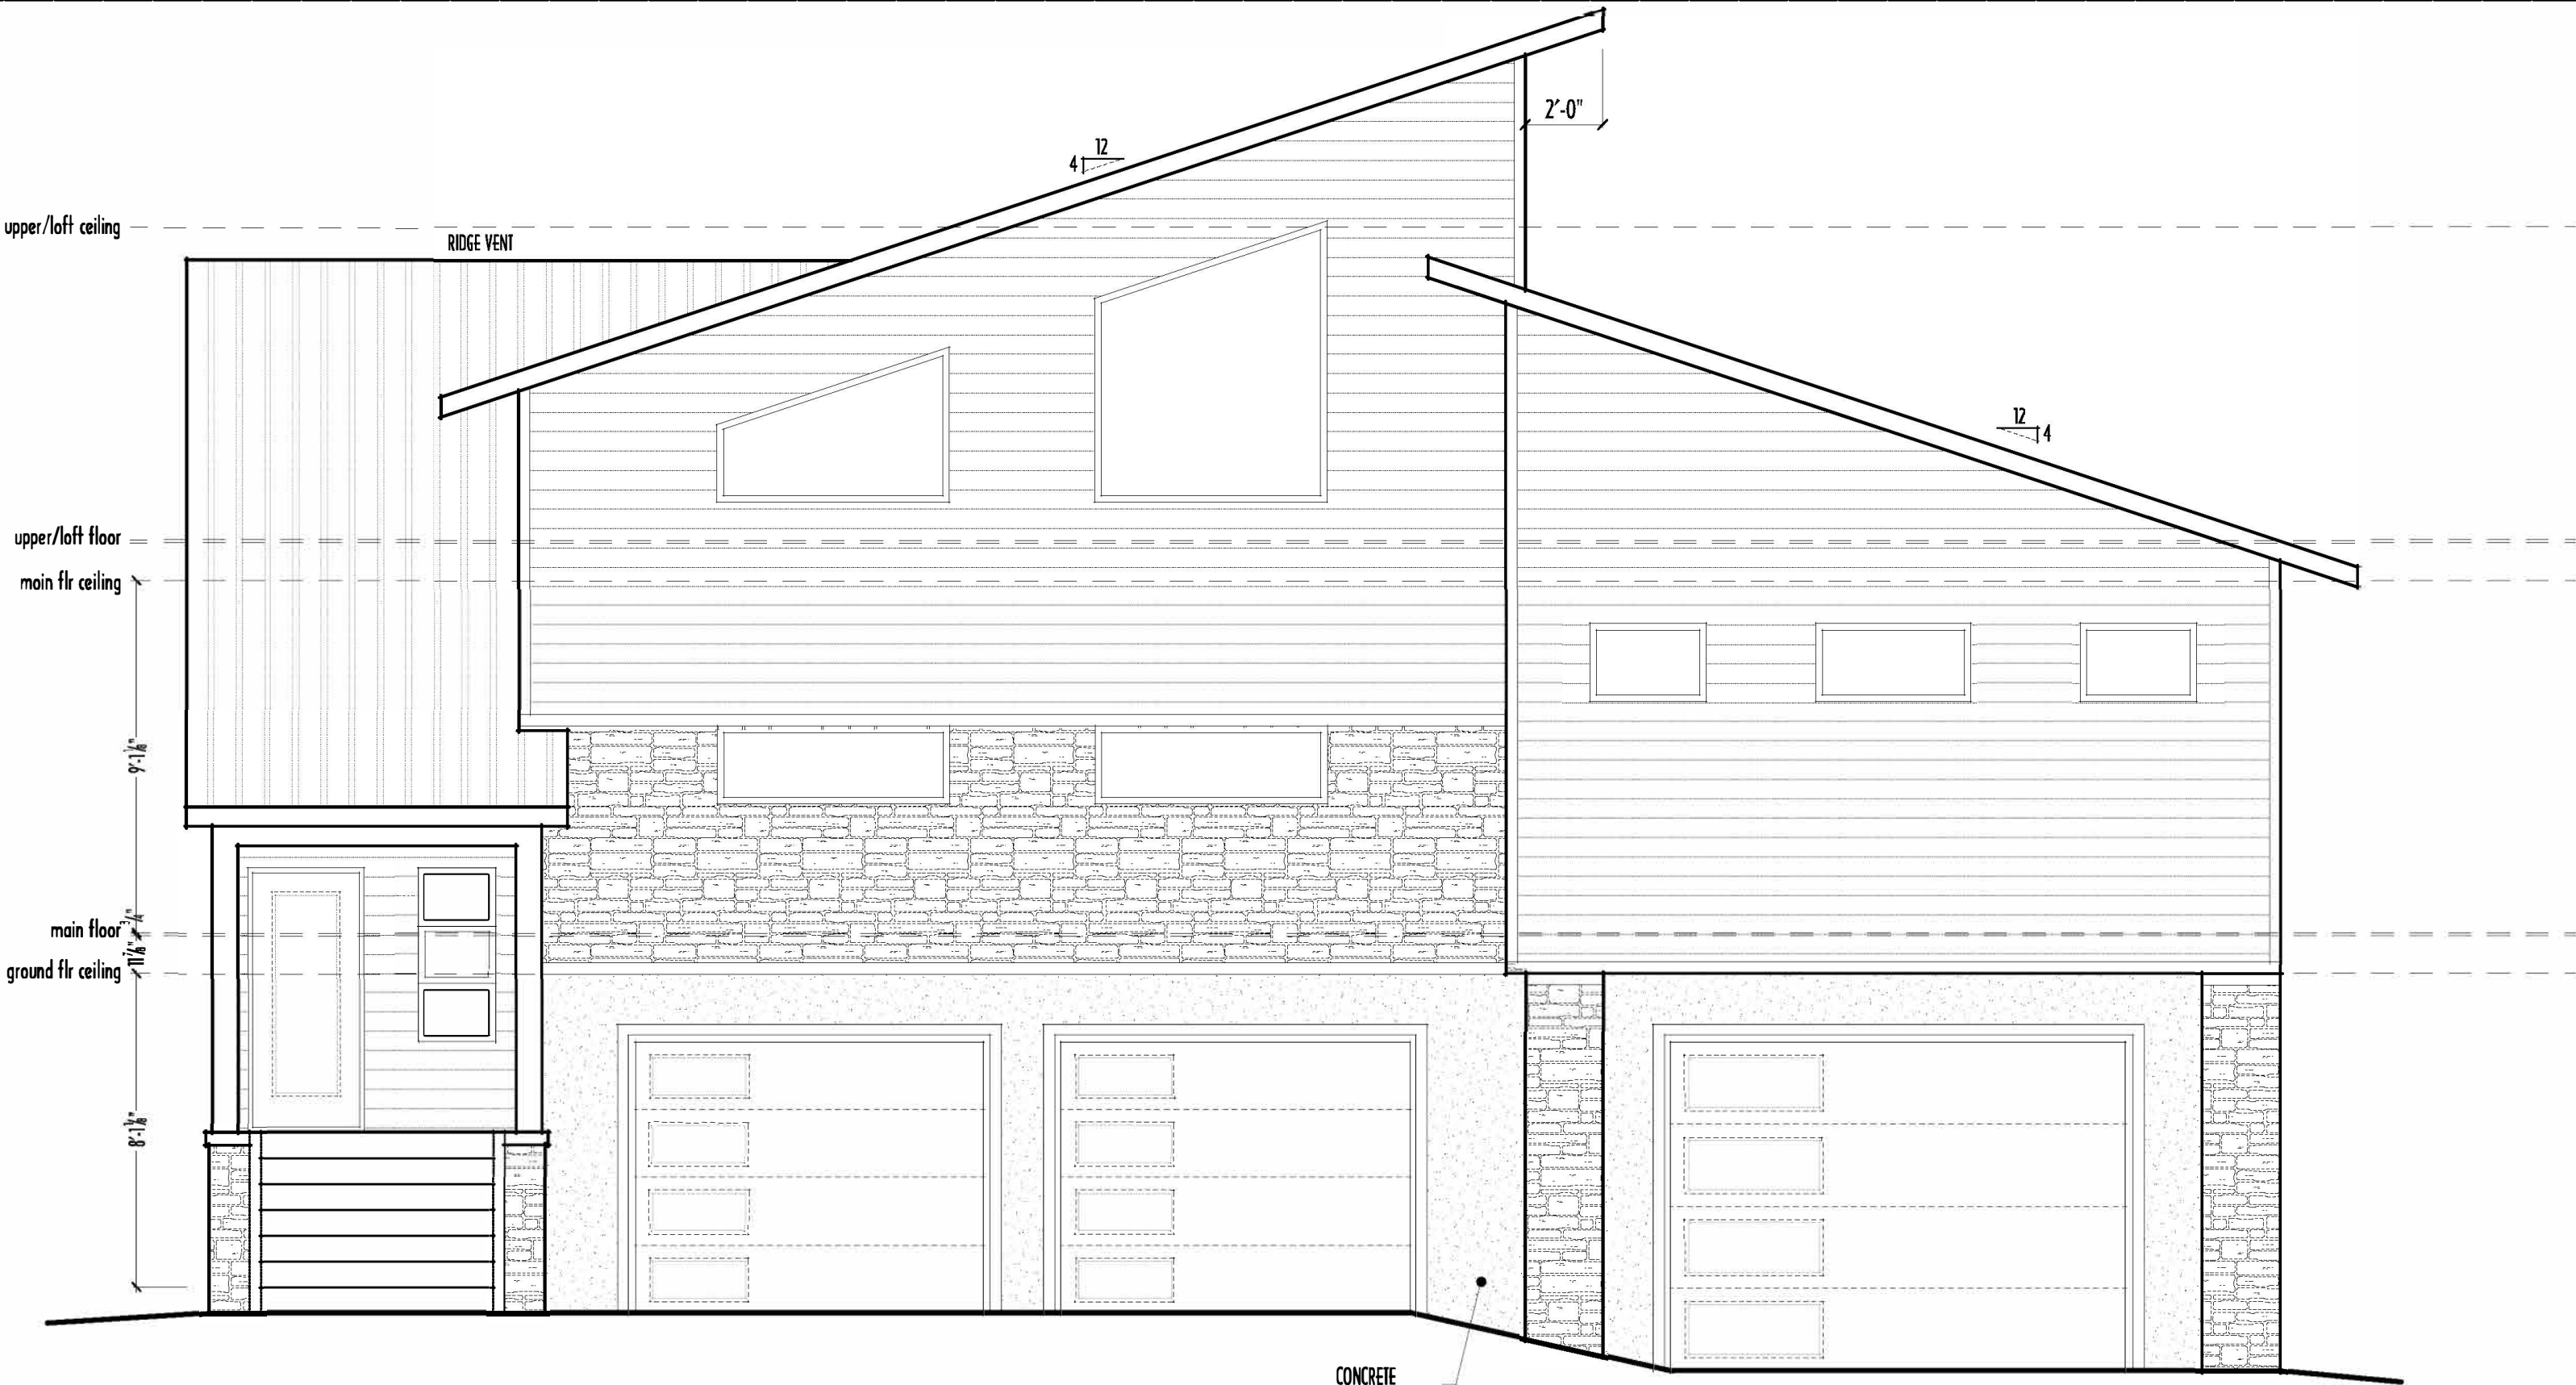


FRONT ELEVATION
SCALE : 1/4" = 1'-0"

FINAL WINDOW DESIGN PER PROVIDER, ALL FRAMING ROUGH-
OPENINGS TO BE BASED ON FINAL LAYOUT ONLY
EXACT WINDOW & DOOR GRID PATTERNS (MILLIONS)
MAY DIFFER - REFER TO MANUFACTURER OR SUPPLIER
GRADE ELEVATION SHOWN IS APPROXIMATE
FIELD VERIFY & ADJUST FOUNDATION AS NECESSARY

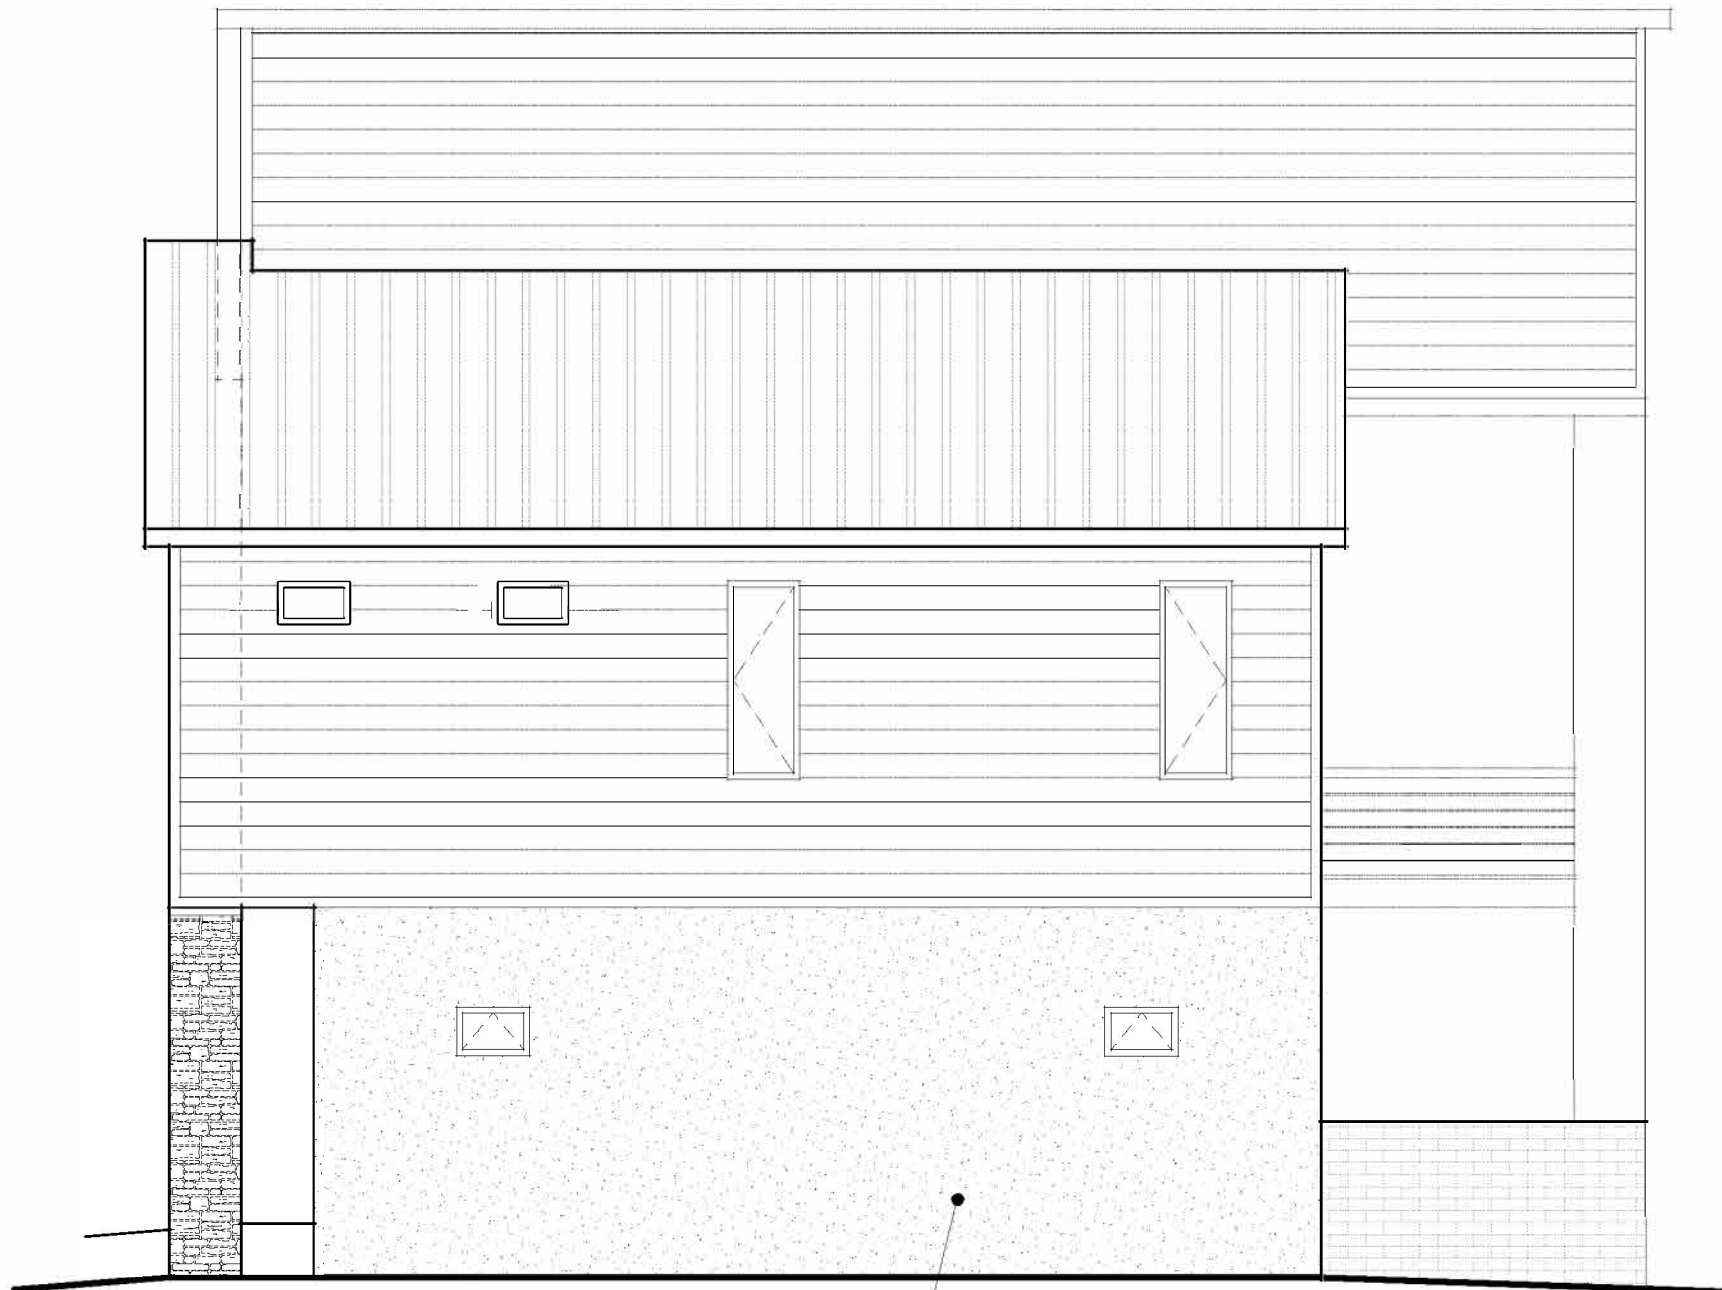

RIGHT SIDE ELEVATION
SCALE : 3/16" = 1'-0"

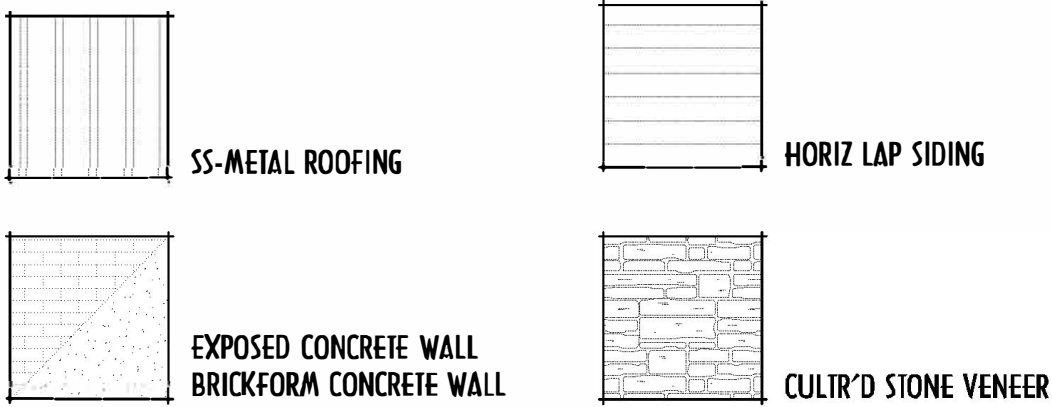

GROUND FLR FIN. AREA =	76 SQ.FT.
FIRST FLR LIVING SP =	1,487 SQ.FT.
SECOND FLR/LOFT LIVING SP =	277 SQ.FT.
TOTAL HEATED AREA =	1,840 SQ.FT.

ELEVATIONS



P&D Builders Ltd.
59 Greif Parkway Suite 100
Delaware, Ohio 43015
(740) 201-8079
Fax (740) 201-8084
www.pndbuilders.com

ALL DRAWINGS ARE THE EXCLUSIVE PROPERTY OF P&D BUILDERS LTD.
NO REPRODUCTION OR CIRCULATION OF THESE DRAWINGS IS PERMITTED
WITHOUT WRITTEN CONSENT OF THE ARCHITECT OR HIS FIRM.

1541

PRELIMINARY DESIGN - NOT FOR CONSTRUCTION

STATE OF OHIO
REGISTERED ARCHITECT
RONALD W. DANNE
1717085
RONALD W. DANNE LICENSE #1717085
EXPIRATION DATE 12/31/2021

Danne
Residential Design & Drafting, LLC
614.207.6266 danne@danne.com


REVISION DATE BY: JWD
9/2/21 jam concepts
9/7/21 rwd concepts
9/15/21 jam concept rev
9/16/21 rwd concept rev
10/2/21 rwd prelim
10/4/21 rwd prelim rev
10/6/21 jam prelim rev
11/2/21 rwd prelim rev
10/24/22 jam prelim rev
10/26/22 rwd prelim rev

10 SCALE WHEN PRINTED 24"X36" - HARD COPY
0 10 20 30 40 50 60 70 80 90 100
FIELD DIMENSIONS - 3/16" SCALE PRINTS

DESIGNED BY P&D / rwd

PAGE 5 of 9

RAISED FIRST FLOOR CEILINGS AT 9'-1 1/8" UNLESS NOTED OTHERWISE
RAISED FIRST WINDOWS HEADERS AT 7'-5" UNLESS NOTED OTHERWISE
CONTRACTORS TO SITE VERIFY ALL DIMENSIONS AND REPORT ANY DISCREPANCIES WITH THE PLANS TO THE JOB SUPERVISOR ASAP
UPPER FLOOR DESIGN LIVE LOAD = 40 PSF
ALL FRAMING AND STRUCTURAL CONSTRUCTION IS TO CONFORM TO 2019 R.C.O. AND/OR APPLICABLE LOCAL CODES
WINDOWS & DOORS (BRAND & DESIGN) PER CONTRACT
CONFIRM WINDOW ROUGH-OPENINGS AND HEADER HGT'S w/ PROVIDER
CONFIRM FLOORING & FINISH MATERIALS w/ JOB SUPERVISOR (PER CONTRACT)
ALL DIMENSIONS CORRESPOND TO EITHER CENTERLINES OR CORNERS OF WOOD FRAMING LENGTHS AND/OR PENETRATION
AVOID FLOORJOISTS LOCATED DIRECTLY BELOW PLUMBING DRAINS
BLOCK BETWEEN FLOORJOISTS BELOW STRUCTURAL POINTS (CRUSH ZONES)
BRACE FLOORJOISTS AT MIDSPAN PER CODE
INTERIOR DOORS SHOWN 4" OFF CORNERS UNLESS NOTED
NOTE: DIMENSIONS FOR ANGLED WALLS MAY CONTAIN ROUNDING ERRORS OF LESS THAN 1/8" TYPICALLY
FINAL/INSTALLED INSULATION VALUES SHOULD MATCH REIN. RATE SHEETS FROM IBC/COMA ENERGY (THOSE SHOWN ON THESE PLANS ARE PRELIMINARY/REFERENCE ONLY)
INSTALL ALL LVL & L3S BEAMS WITH LABELS VISIBLE FOR BLDG INSPECTION

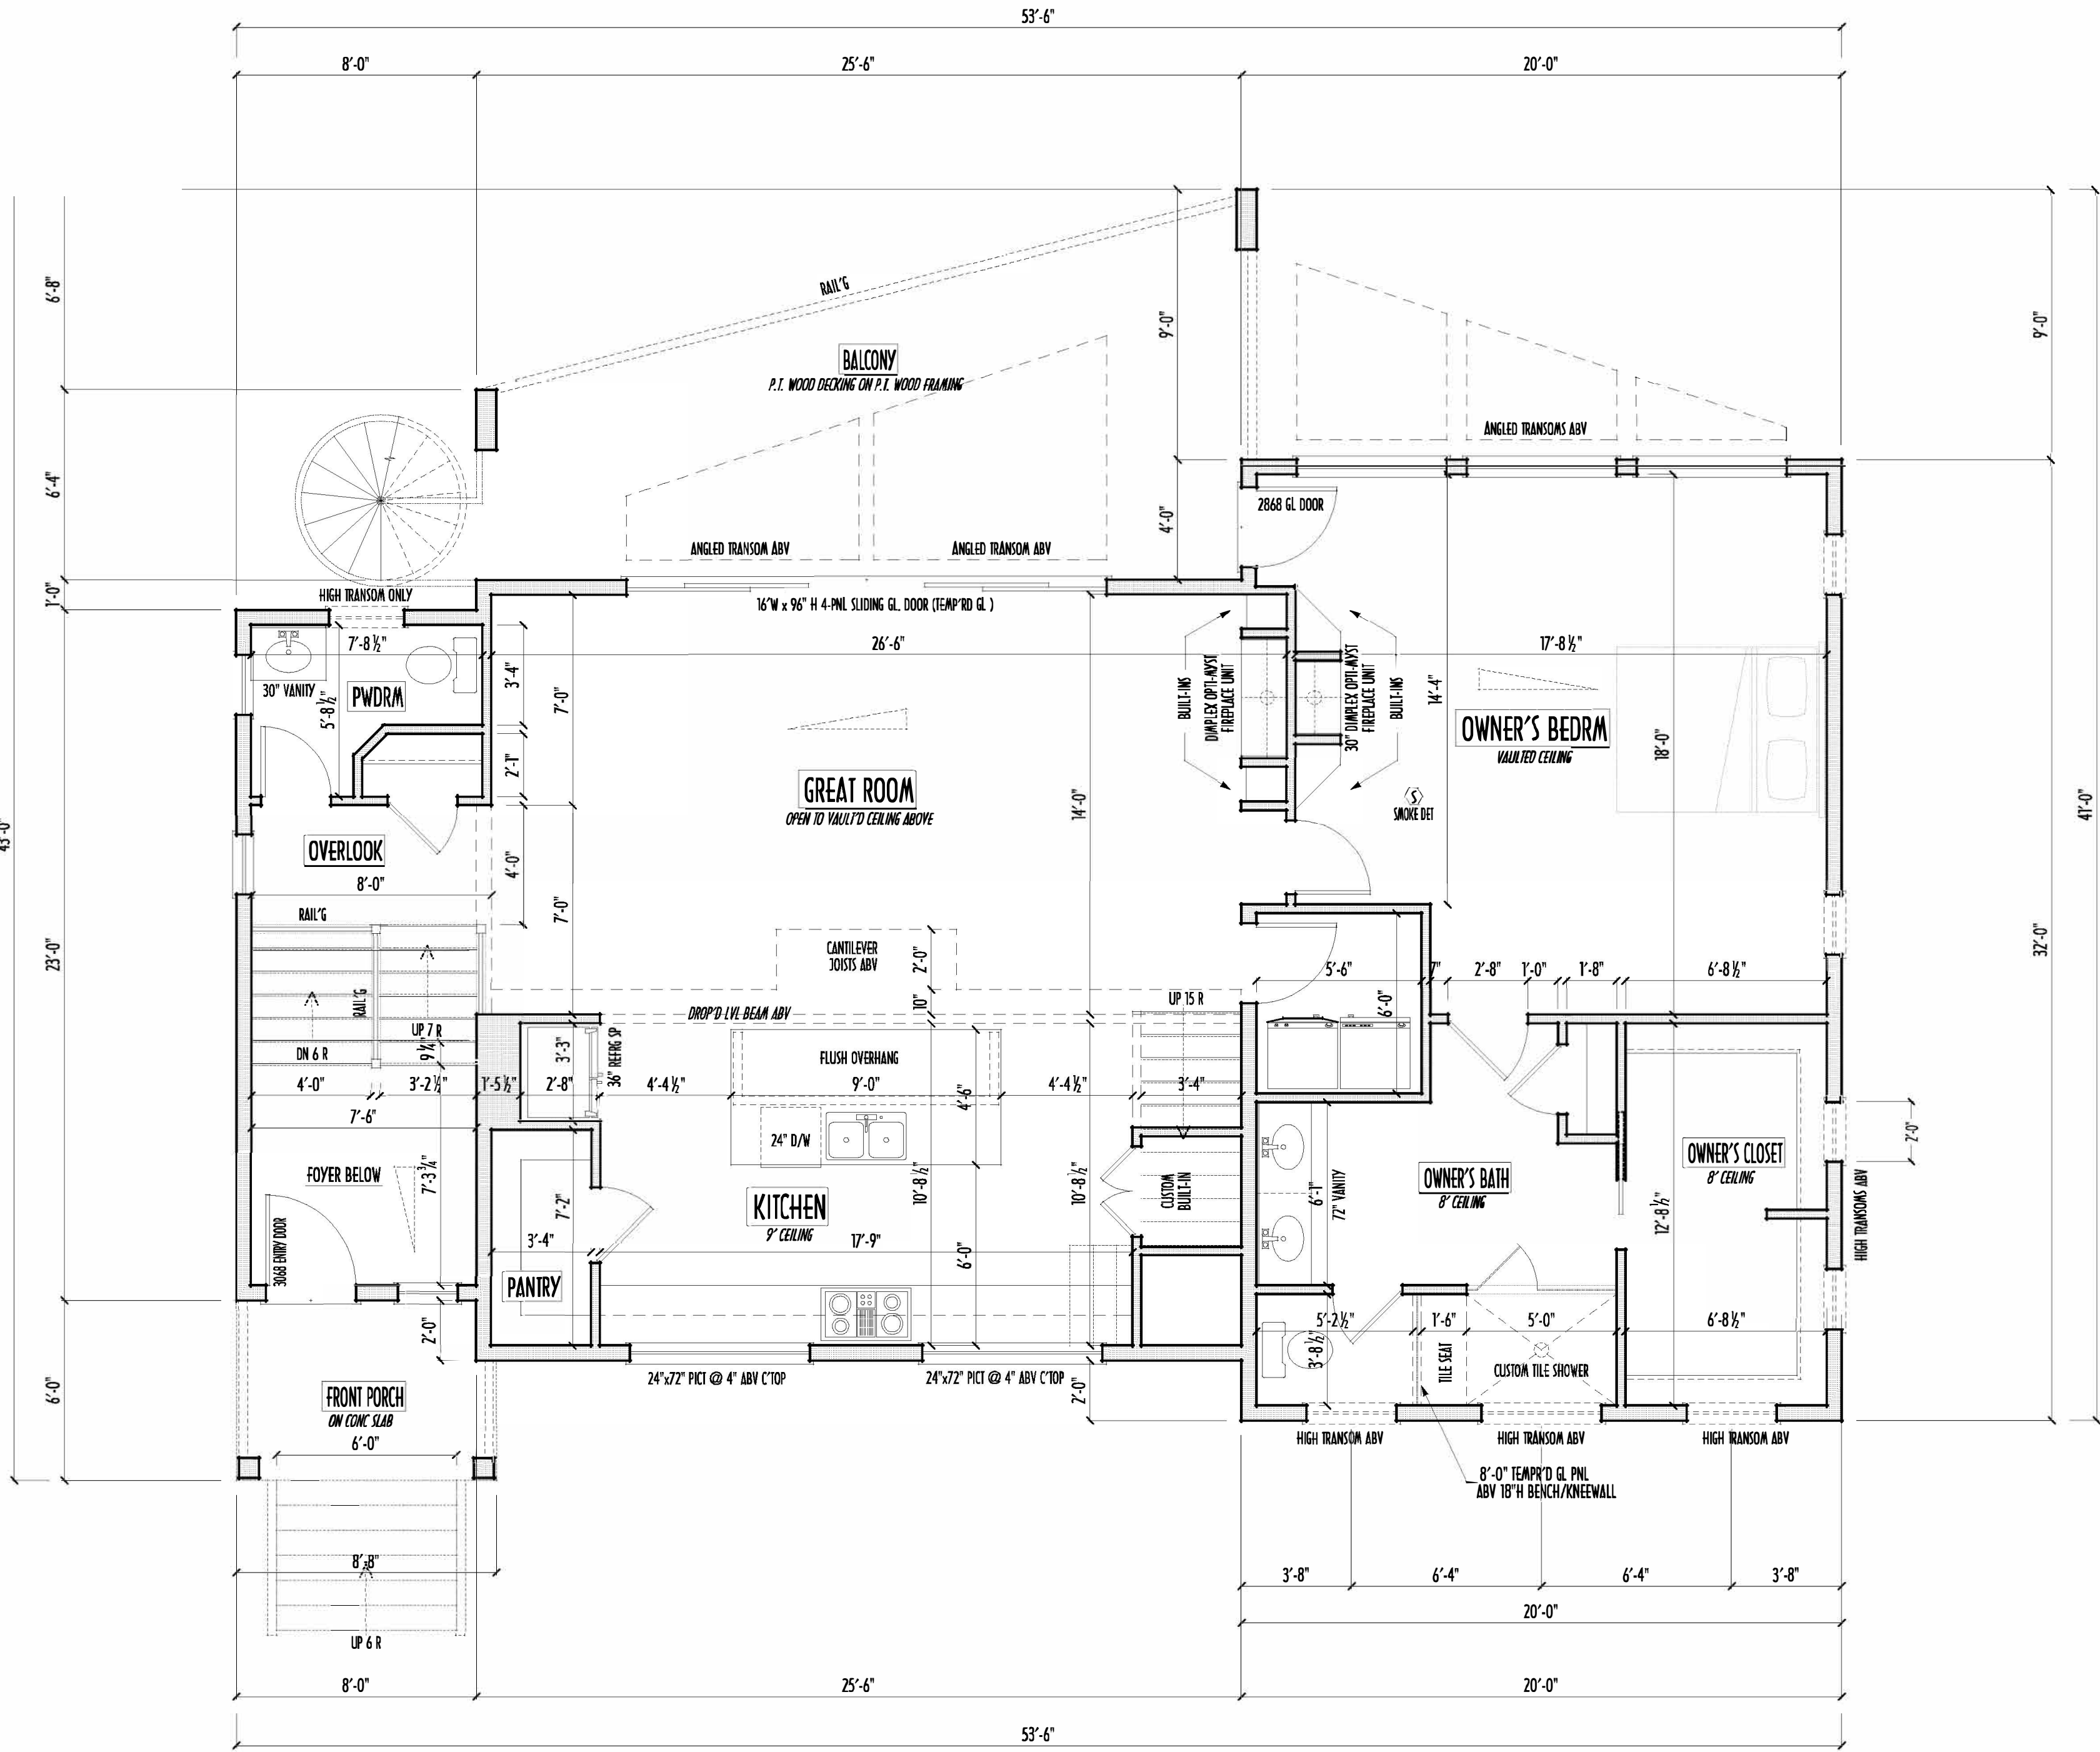

RAISED FIRST FLOOR PLAN
SCALE: 1/4" = 1'-0"

GROUND FLR FIN. AREA =	76 SQ.FT.
FIRST FLR LIVING SP =	1,487 SQ.FT.
SECOND FLR/LOFT LIVING SP =	277 SQ.FT.
TOTAL HEATED AREA =	1,840 SQ.FT.



P&D Builders Ltd.
59 Great Parkway Suite
Suite 100
Delaware, Ohio 43015
(740) 201-8079
Fax (740) 201-8084
www.pndbuilders.com

ALL DRAWINGS ARE THE EXCLUSIVE PROPERTY OF P&D BUILDERS LTD. NO REPRODUCTION OR USE OF THESE DRAWINGS IS ALLOWED WITHOUT WRITTEN CONSENT OF THE AUTHOR OR HIS PLACE.

10.0.0.1

PRELIMINARY DESIGN - NOT FOR CONSTRUCTION

PRELIMINARY DESIGN - NOT FOR CONSTRUCTION


PRELIMINARY DESIGN - NOT FOR CONSTRUCTION

PRELIMINARY DESIGN - NOT FOR CONSTRUCTION

PRELIMINARY DESIGN - NOT FOR CONSTRUCTION

DESIGNED: P&D / rwd
PAGE: 3 of 9

SECOND FLOOR CEILINGS AT 8'-1 1/8" ROUGH UNLESS NOTED
SECOND FLOOR WINDOWS HEADERS AT 6'-10" UNLESS NOTED
EXTERIOR WALLS ARE SHOWN 6" WIDE (2x6 STUDS @ 16" O/C UNLESS NOTED)
INTERIOR WALLS ARE SHOWN 3.5" WIDE (2x4 STUDS @ 16" O/C UNLESS NOTED)
SECOND FLOOR DESIGN LIVE LOAD = 40 PSF (BEDROOMS 30 PSF)
WINDOWS & DOORS (BRAND & DESIGN) PER CONTRACT
INTERIOR DOORS SHOWN 4" OFF CORNERS UNLESS NOTED
IN SLEEPING ROOMS, AT LEAST ONE WINDOW MUST MEET EMERGENCY EGRESS
REQUIREMENTS (MIN. 20" WIDE X 24" TALL & 5.7 SQ.FT.) PER R.C.O. 310
CONFIRM WINDOW ROUGH-OPENINGS WITH MANUFACTURER
AND ADJUST FRAMING DIMENSIONS AS NECESSARY
NOTE: DIMENSIONS FOR ANGLED WALLS MAY CONTAIN
ROUNDING ERRORS OF LESS THAN 1/8" TYPICALLY
FINAL/INSTALLED INSULATION WALLIES SHOULD MATCH
REIN-STATE SHEETS FROM TACOMA ENERGY (THOSE SHOWN
ON THESE PLANS ARE PRELIMINARY/REFERENCE ONLY)
INSTALL ALL LVL & LSL BEAMS WITH
LABELS VISIBLE FOR BLDG INSPECTION
FOAM PLASTIC/INSULATION SHALL BE INSTALLED PER RCD 314 & 315
<75 PSR, <450 SDR PER ASTM E84

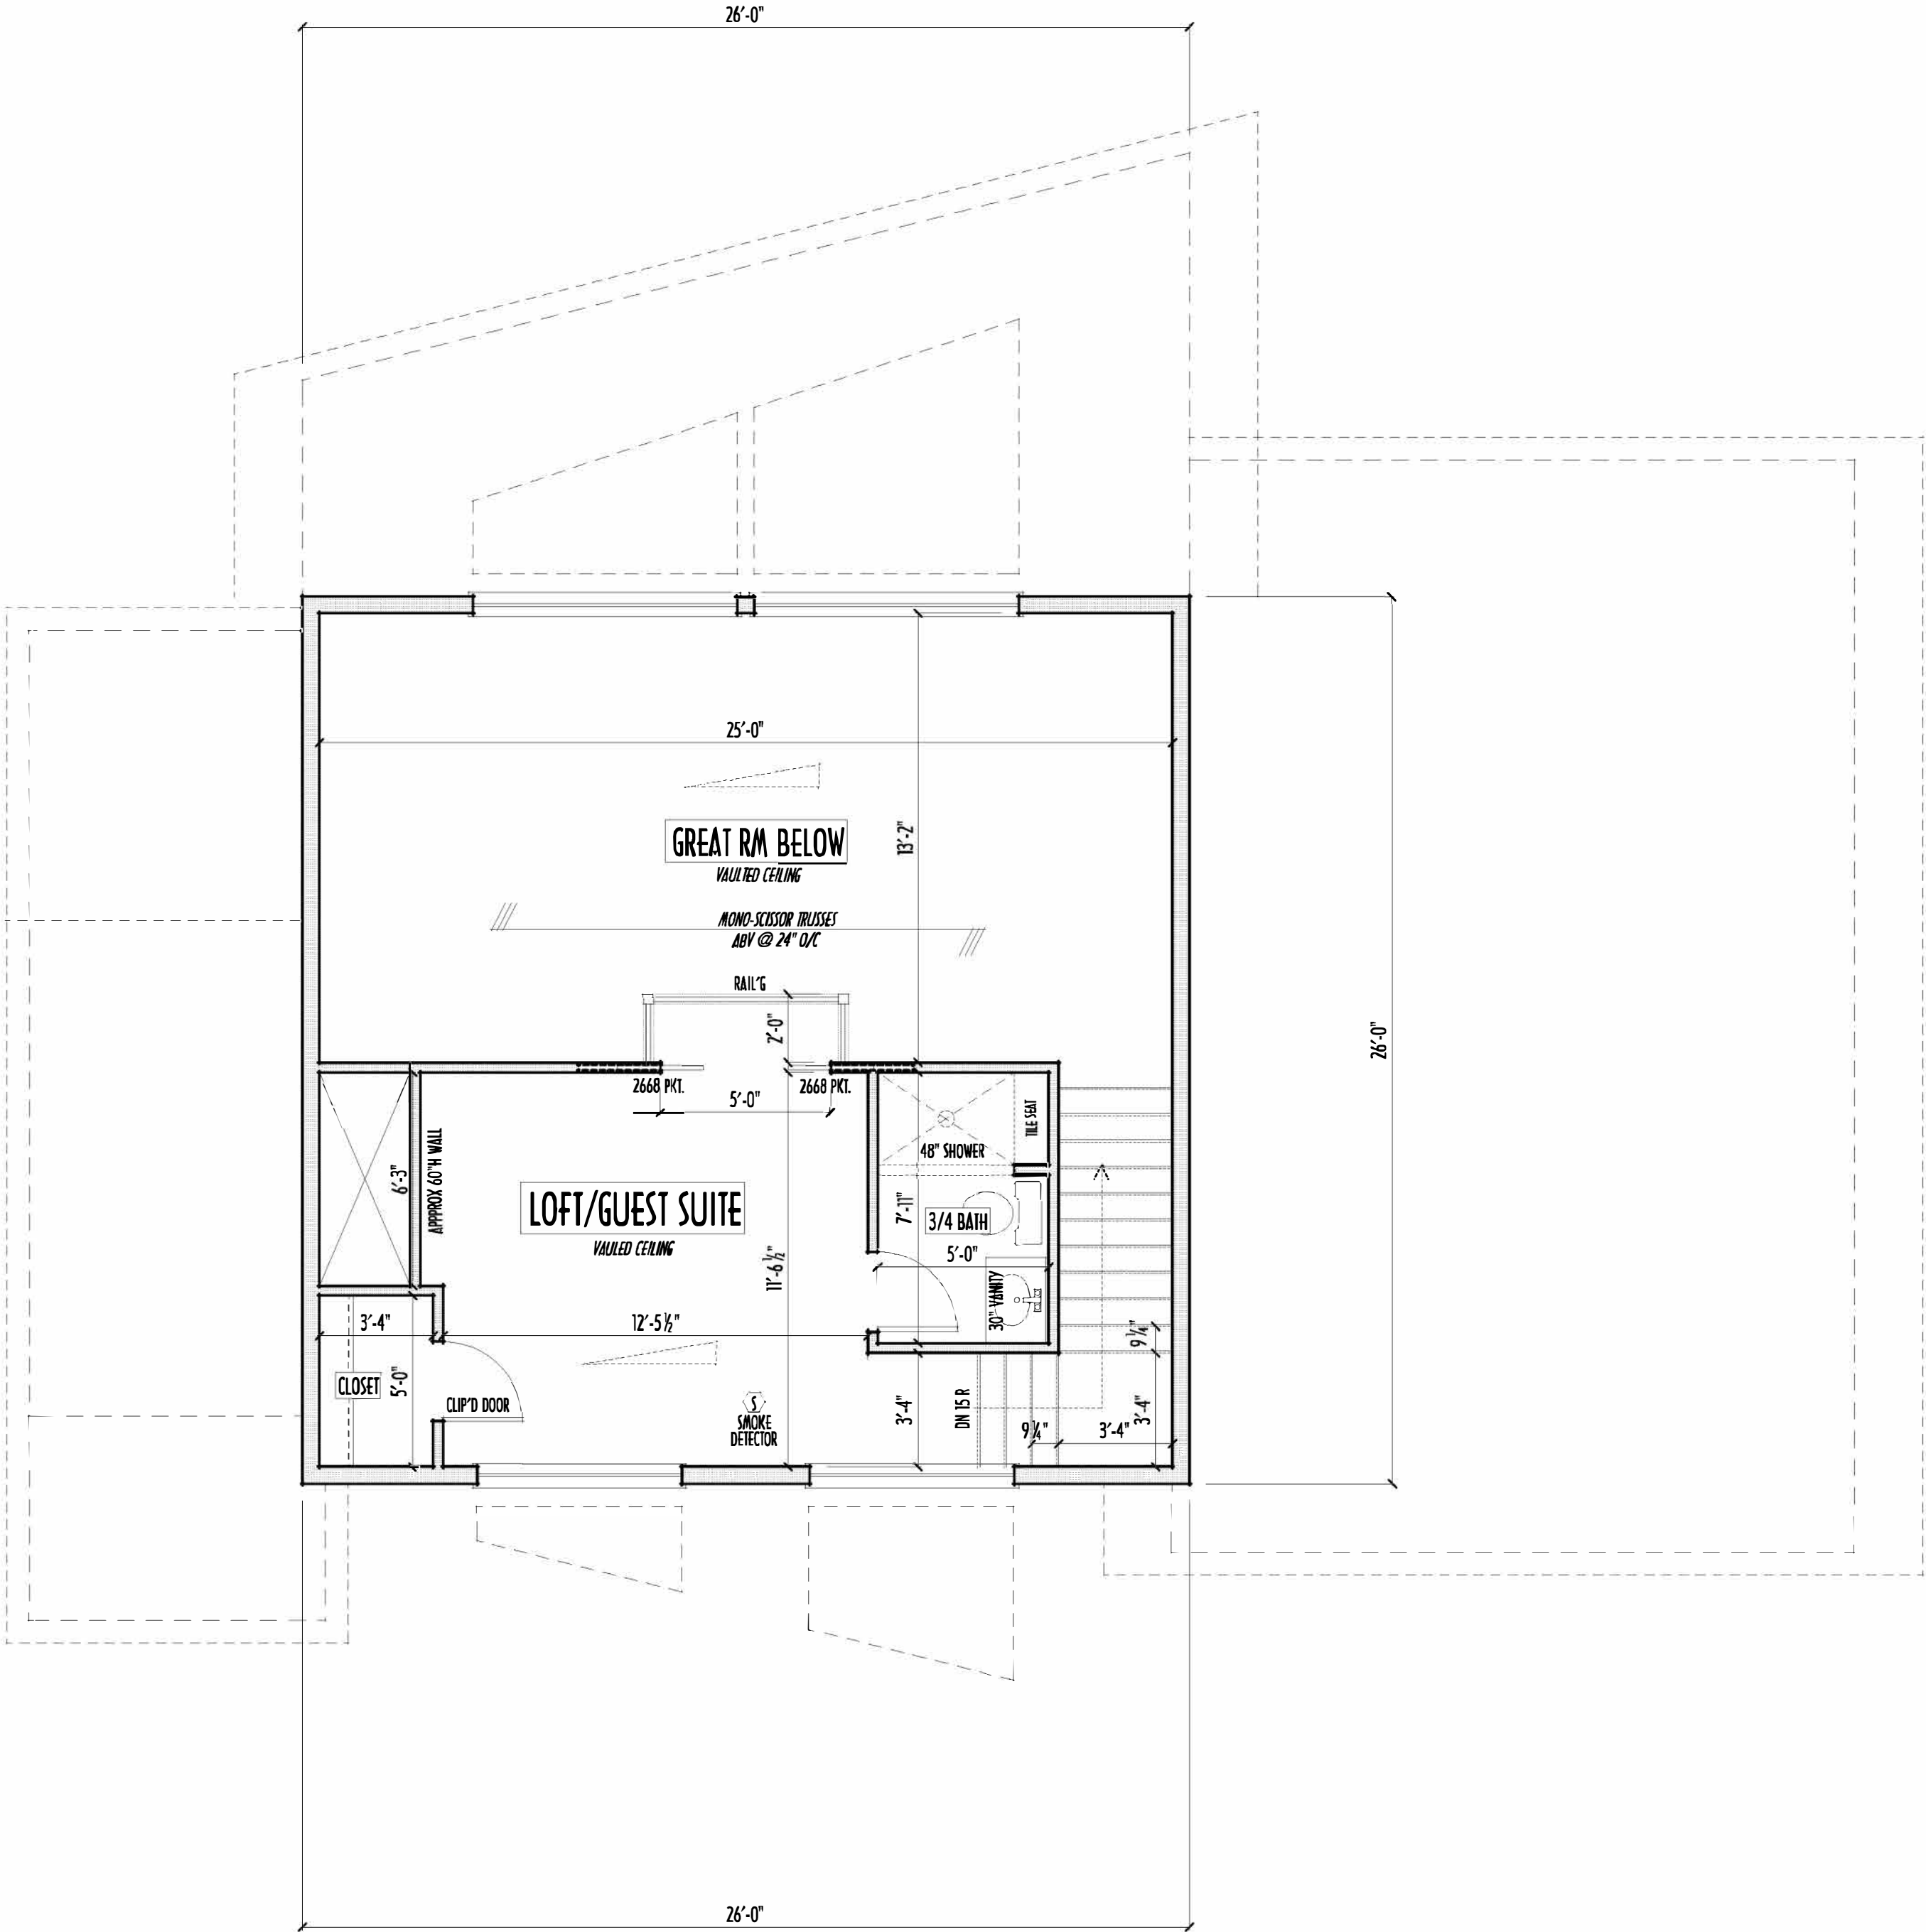

SECOND FLOOR PLAN
SCALE : 1/4" = 1'-0"

GROUND FLR FIN. AREA =	76 SQ.FT.
FIRST FLR LIVING SP =	1,487 SQ.FT.
SECOND FLR/LOFT LIVING SP =	277 SQ.FT.
TOTAL HEATED AREA =	1,840 SQ.FT.

2ND FLR

P&D Builders Ltd.
59 Greif Parkway Suite 100
Delaware, Ohio 43015
(740) 201-8079
Fax (740) 201-8084
www.pndbuilders.com

1541

STATE OF OHIO
REGISTERED ARCHITECT
RONALD W. DANNE
1717085

RONALD W. DANNE LICENSE #1717085
EXPIRATION DATE 12/31/2021

Danne
Residential Design & Drafting, LLC
614.207.6266 dannehd@gmail.com

REVISION DATE	BY:	INITIALS
9/2/21	jam	concepts
9/7/21	rwd	concepts
9/15/21	jam	concept rev
9/16/21	rwd	concept rev
10/2/21	rwd	prelims
10/4/21	rwd	prelim rev
10/6/21	jam	prelim rev
11/2/21	rwd	prelim rev
10/24/22	jam	prelim rev
10/26/22	rwd	prelim rev



DESIGNED: P&D / rwd

PAGE: 4 of 9



P&D Builders Ltd.
59 Greif Parkway Suite 100
Delaware, Ohio 43015
(740) 201-8079
Fax (740) 201-8084
www.pndbuilders.com

ALL DRAWINGS ARE THE EXCLUSIVE PROPERTY OF P&D BUILDERS LTD. NO REPRODUCTION OR CONSTRUCTION OF THESE DRAWINGS IS ALLOWED WITHOUT WRITTEN CONSENT OF THE ARCHITECT OR ENGINEER.

1541

1541


1541

1541

1541

1541

SEE SITEPLAN BY SURVEYOR FOR BASE FLOOD ELEVATIONS
ALL MECHANICAL AND ELECTRICAL MUST BE INSTALLED ABOVE THE BASE FLOOD ELEVATION
ALL MATERIALS USED FOR CONSTRUCTION BELOW THE BFE MUST BE OF FLOOD RESISTANT MATERIAL

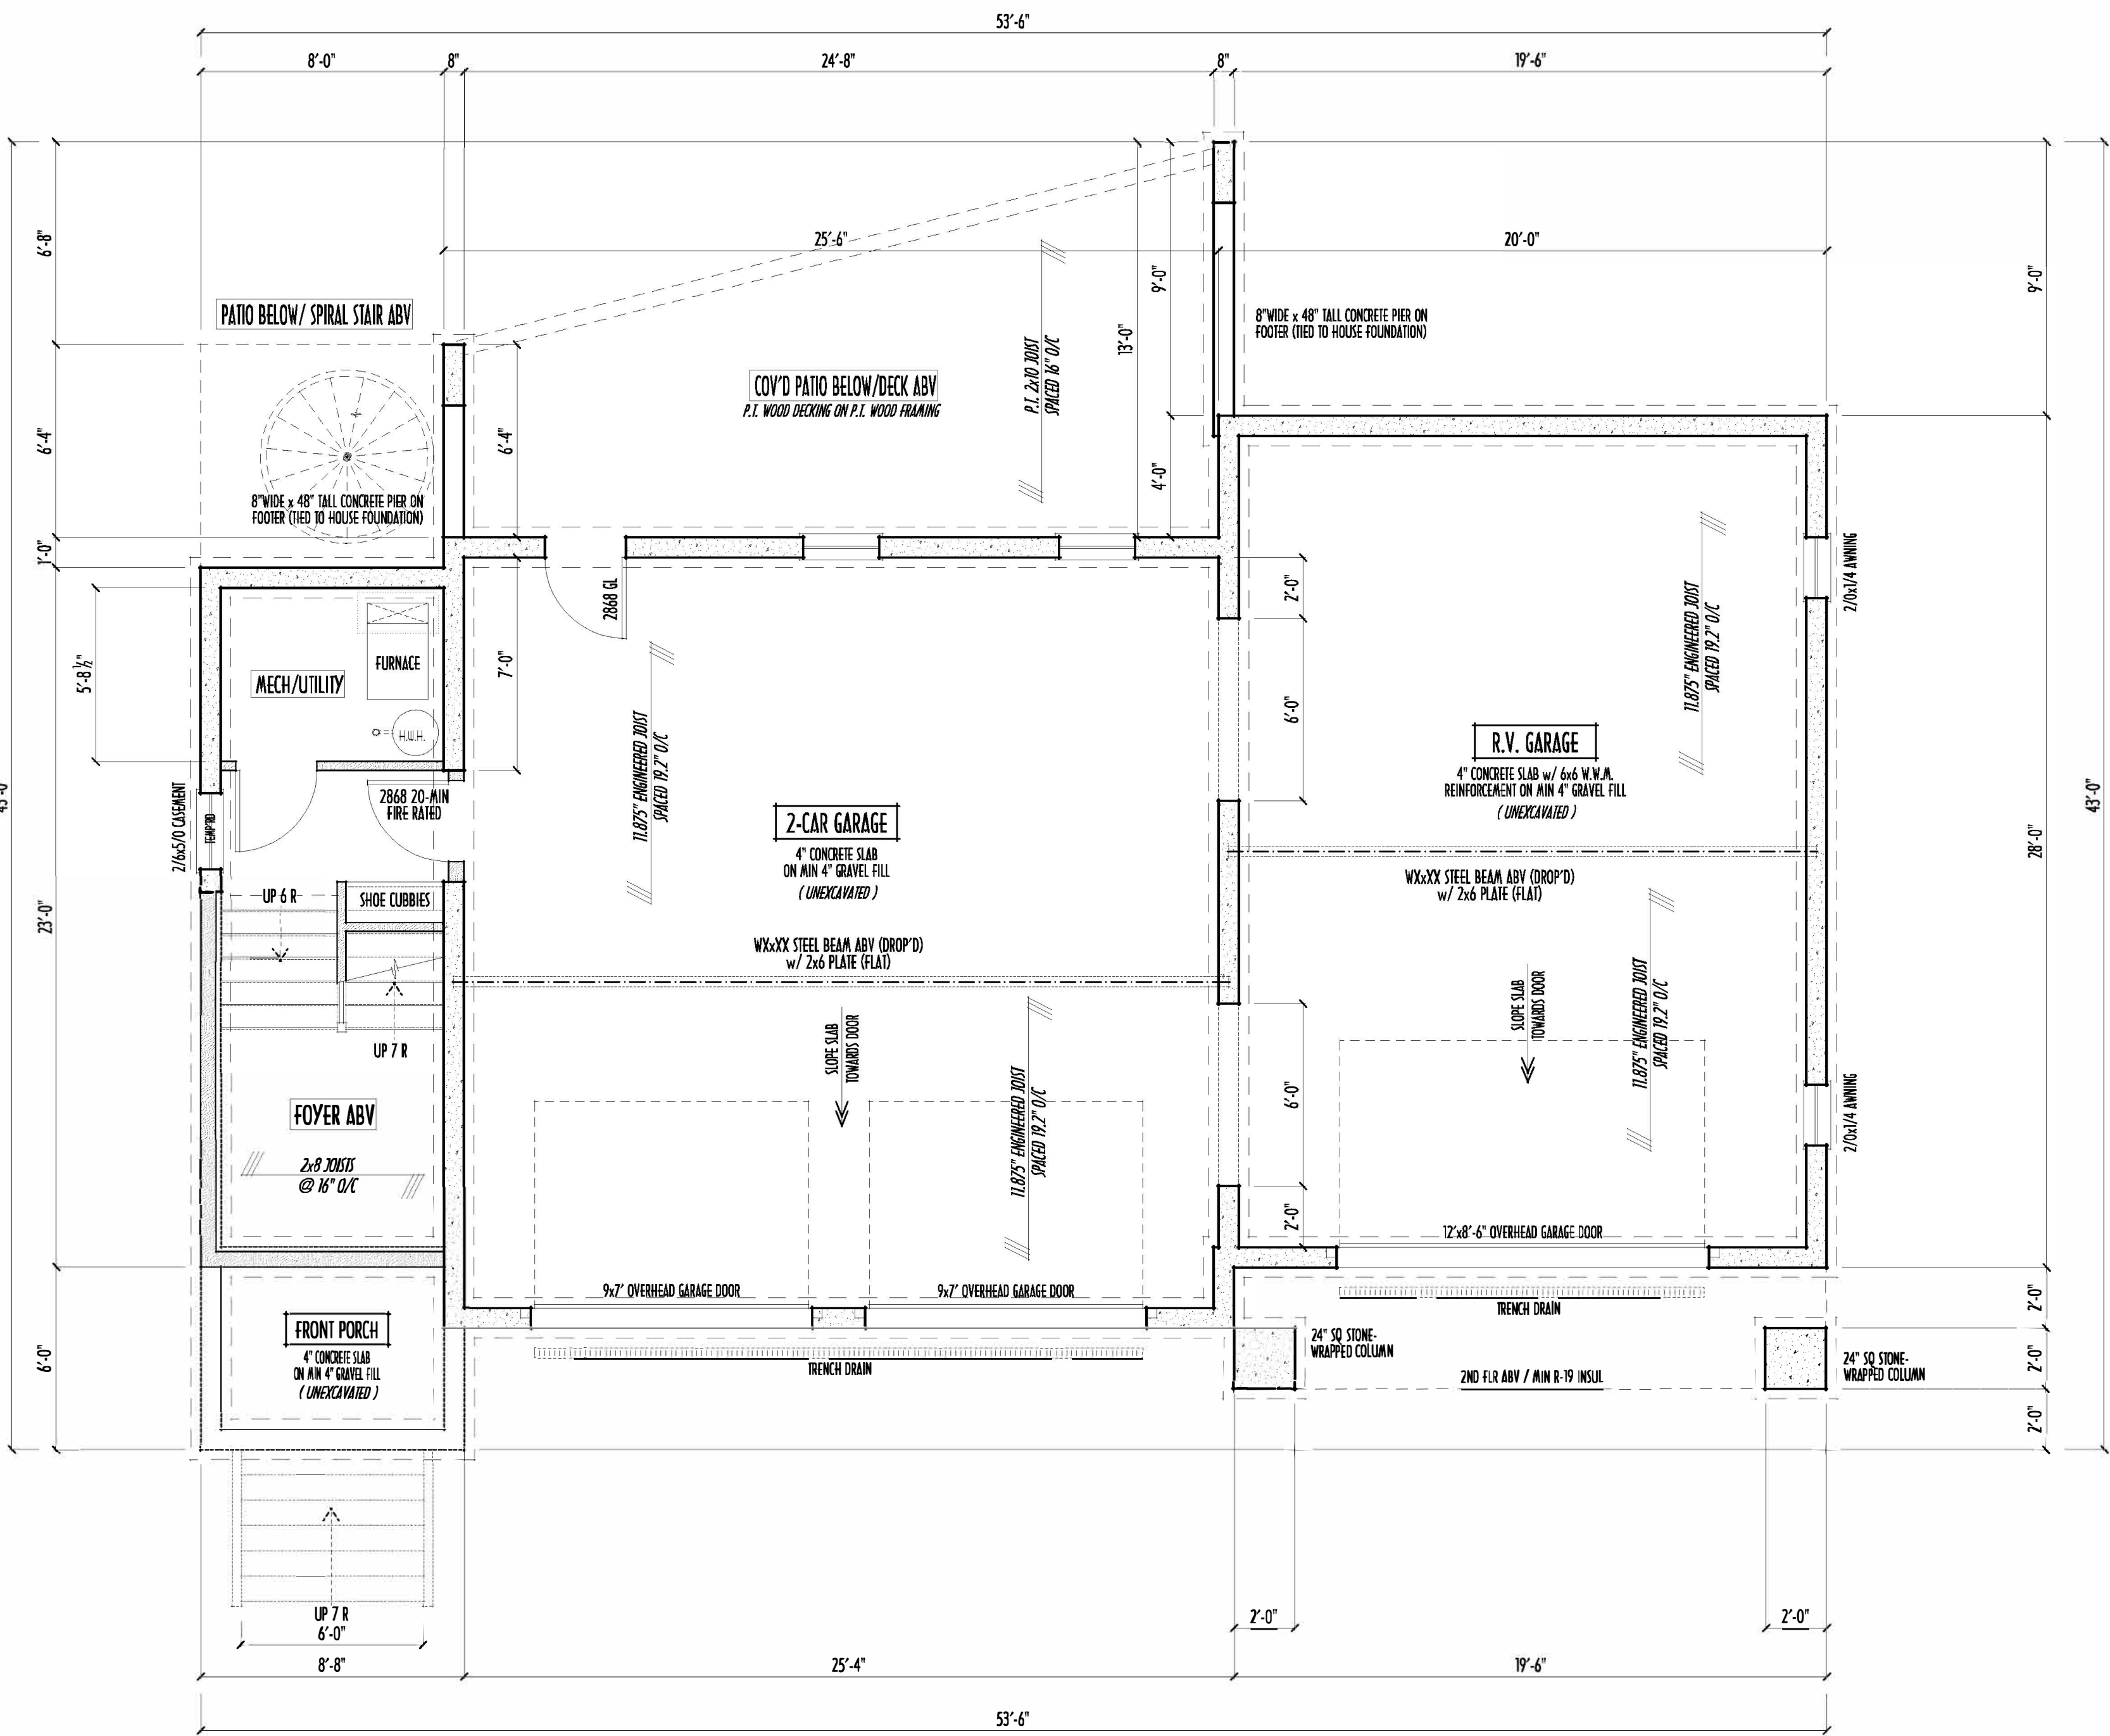


MAX. UNBALANCED FILL FOR 8" THICK POURED CONC. WALL OR CMU BLOCK WALL = 7'-0" ABOVE SLAB
WATERPROOFING / DAMPROOFING PER CODE
ALL STRUCTURAL LUMBER IS MIN. CANADIAN SPECIES #2 SPRUCE-PINE-FIR, UNLESS NOTED OTHERWISE
FIRST FLOOR DESIGN LIVE LOAD = 40 PSF
BASEMENT ELECTRICAL LAYOUT FOR REFERENCE ONLY - CONSULT WITH HOMEOWNER PRIOR TO INSTALLATION FOR EXACT LOCATIONS
GRADE MIN. 8" BELOW TOP OF FOUNDATION, SLOPING AWAY FOR PROPER DRAINAGE MIN. 6" DROP IN FIRST 10 FT OF RUN
AVOID FLOORJOISTS LOCATED DIRECTLY BELOW PLUMBING DRAINS & TRAPS
BLOCK BETWEEN FLOORJOISTS BELOW STRUCTURAL POINTS (CRUSH ZONES) WITH APPROPRIATE 2X FILL
SEE COVER SHEET FOR GENERAL FOUNDATION CONSTRUCTION NOTES
STEP DOWN FOOTING AS NECESSARY TO REMAIN MIN. 36" BELOW GRADE
USE PRES-TREATED EXTERIOR-GRADE LUMBER WHERE EXPOSED TO WEATHER OR IN CONTACT WITH CONCRETE
FOUNDATION WALL ENGINEERING & REINFORCEMENT PER SHEPHERD EXCAVATING DESIGN-DETAIL RC-16
INSTALL ALL LVL & LSL BEAMS WITH LABELS VISIBLE FOR BLDG INSPECTION

FOUNDATION / LOWER LVL FLOOR PLAN
SCALE : 1/4" = 1'-0"



GROUND FLR FIN. AREA =	76 SQ.FT.
FIRST FLR LIVING SP =	1,487 SQ.FT.
SECOND FLR/LOFT LIVING SP =	277 SQ.FT.
TOTAL HEATED AREA =	1,840 SQ.FT.

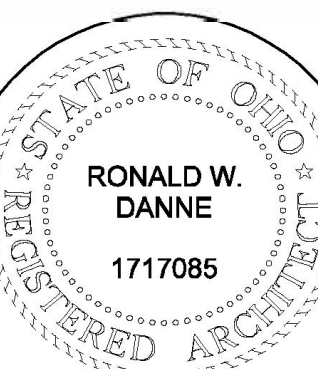

RONALD W. DANNE LICENSE #1717085
EXPIRATION DATE 12/31/2021

Danne
Residential Design & Drafting LLC
614.207.6266 dannehd@gmail.com

REVISION DATE	BY	REV
9/2/21	jam	concepts
9/7/21	rwd	concepts
9/15/21	jam	concept rev
9/16/21	rwd	concept rev
10/2/21	rwd	prelims
10/4/21	rwd	prelim rev
10/6/21	jam	prelim rev
11/2/21	rwd	prelim rev
10/24/22	jam	prelim rev
10/26/22	rwd	prelim rev



DESIGNED: P&D / rwd