

P&D Builders - Job # 1289

PLEASE NOTE: PRELIMINARY DESIGNS ARE SUBJECT TO CHANGE DUE TO STRUCTURAL OR CODE REQUIREMENTS. ITEMS SHOWN MAY BE OPTIONAL/EXTRA. PLEASE REFER TO YOUR CONTRACT FOR SPECIFICATIONS & DESCRIPTIONS.

ELEVATIONS




P&D Builders Ltd.
59 Greif Parkway Suite 100
Delaware, Ohio 43015
(740) 201-8079
Fax (740) 201-8084
www.pndbuilders.com


ALL ELEVATIONS ARE THE SOLE PROPERTY OF P&D BUILDERS LTD. NO REPRODUCTION OR CHANGES OF THESE ELEVATIONS MAY BE MADE WITHOUT WRITTEN CONSENT OF THE ARCHITECT OF THE FIRM.

1289


PRELIMINARY DESIGN
NOT TO SCALE - NOT FOR CONSTRUCTION

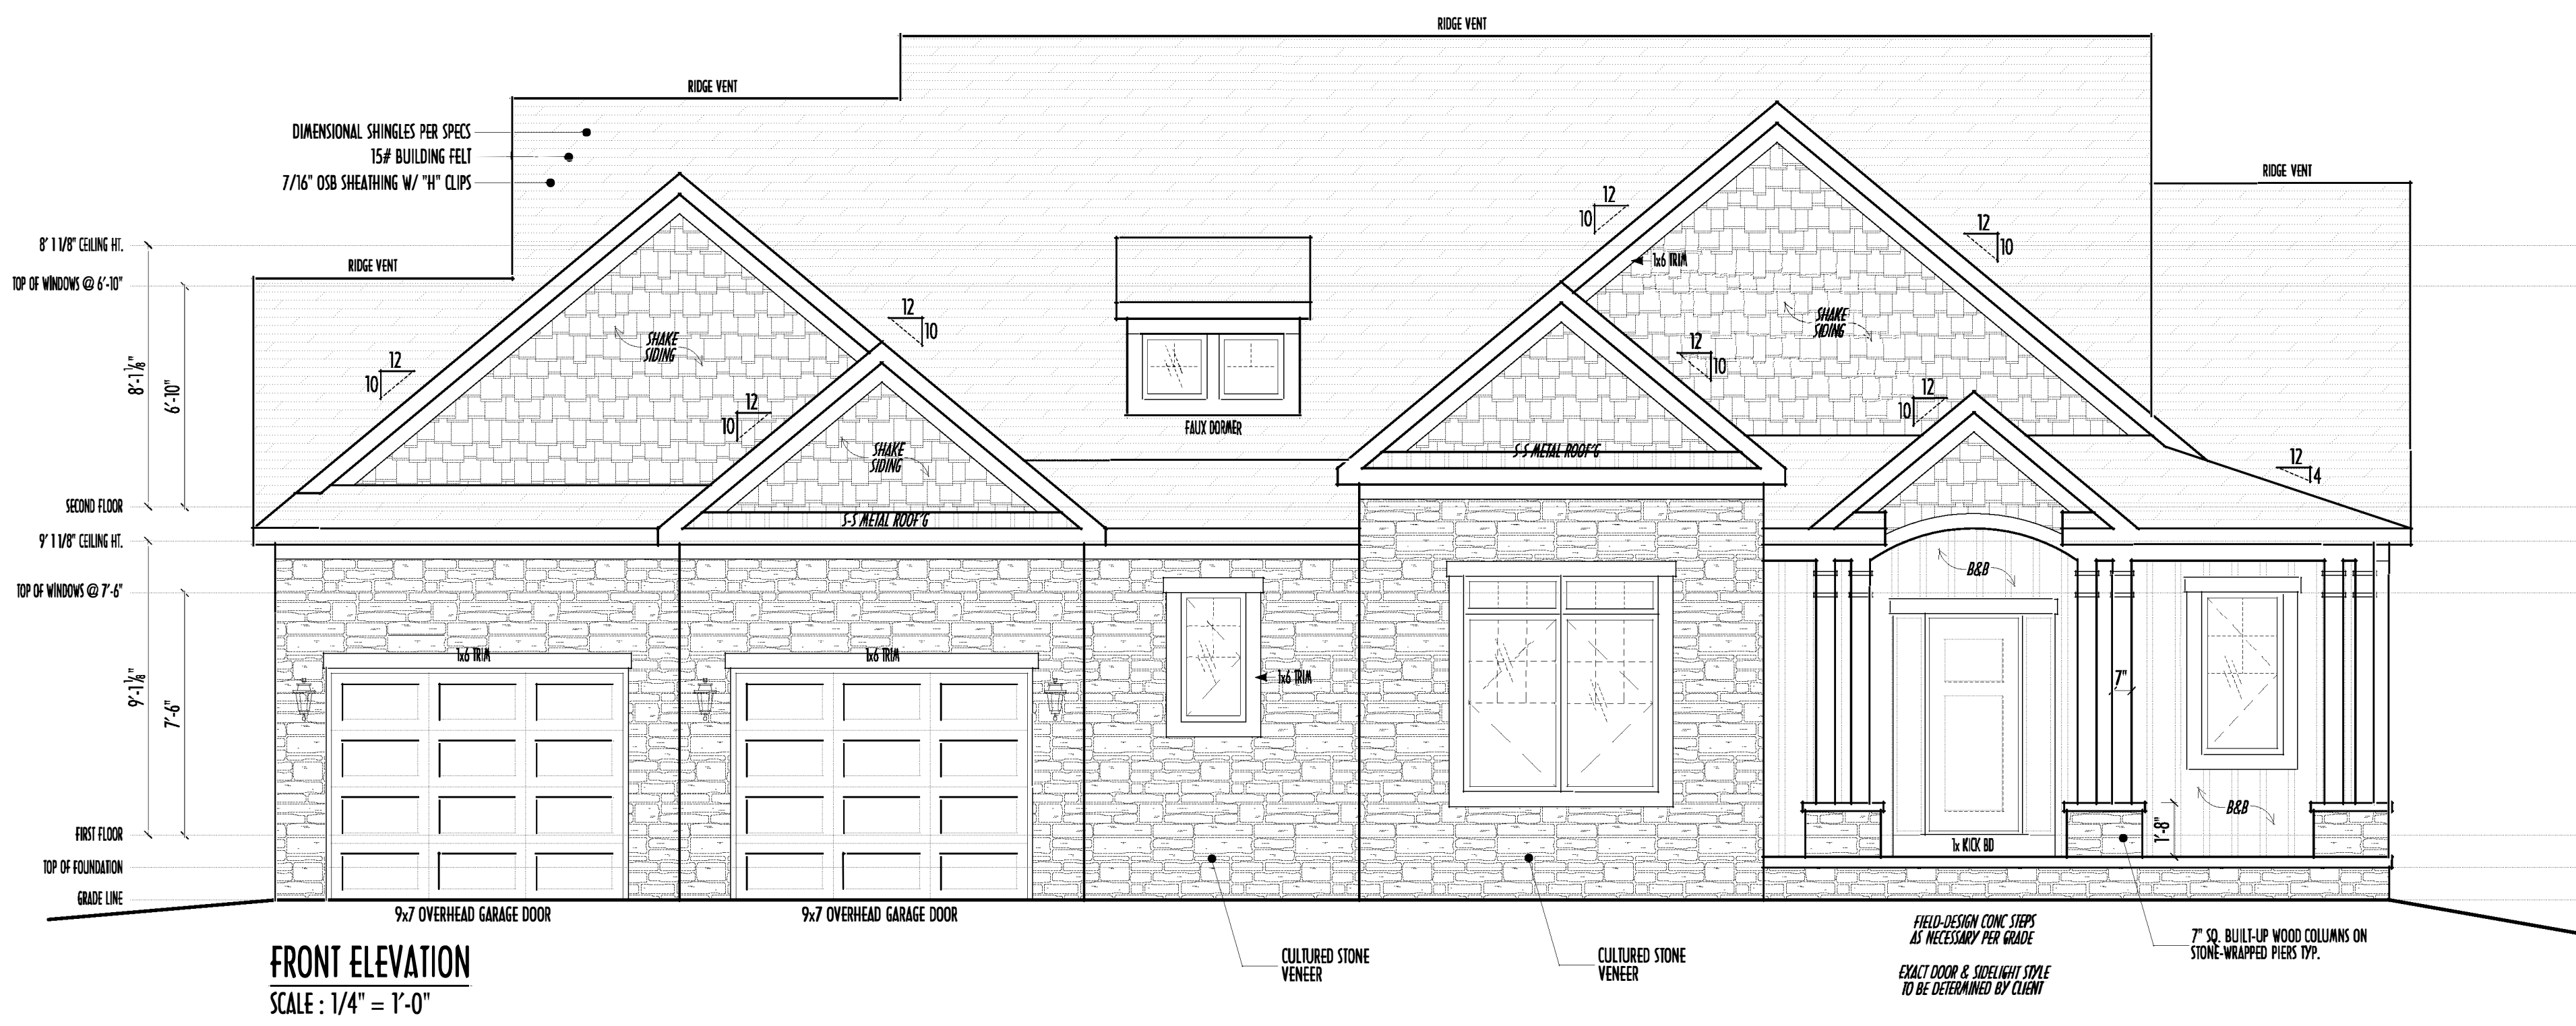


FRONT ELEVATION
SCALE : 1/4" = 1'-0"

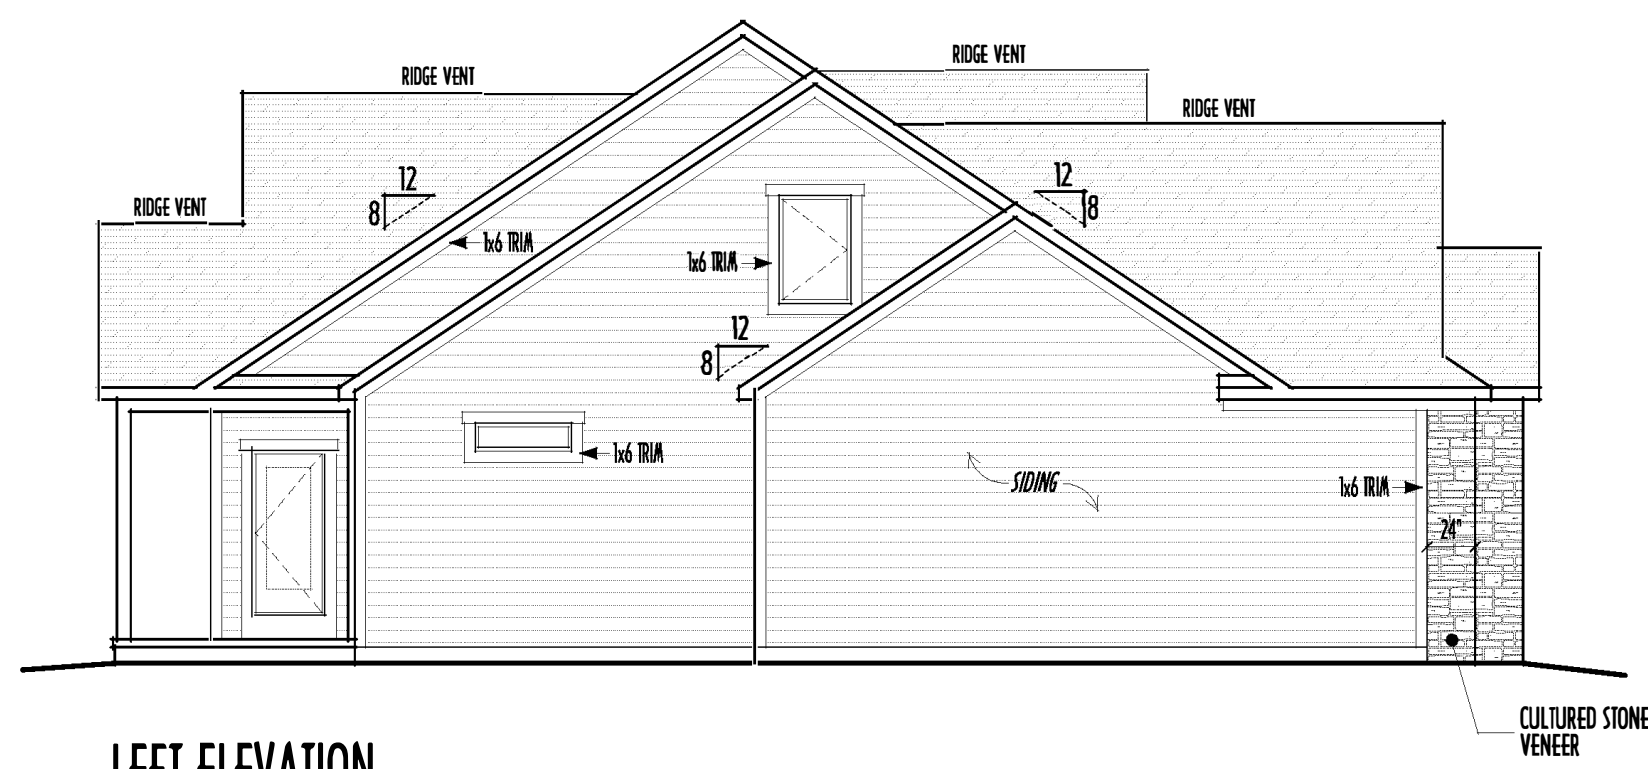

LEFT ELEVATION
SCALE : 1/8" = 1'-0"

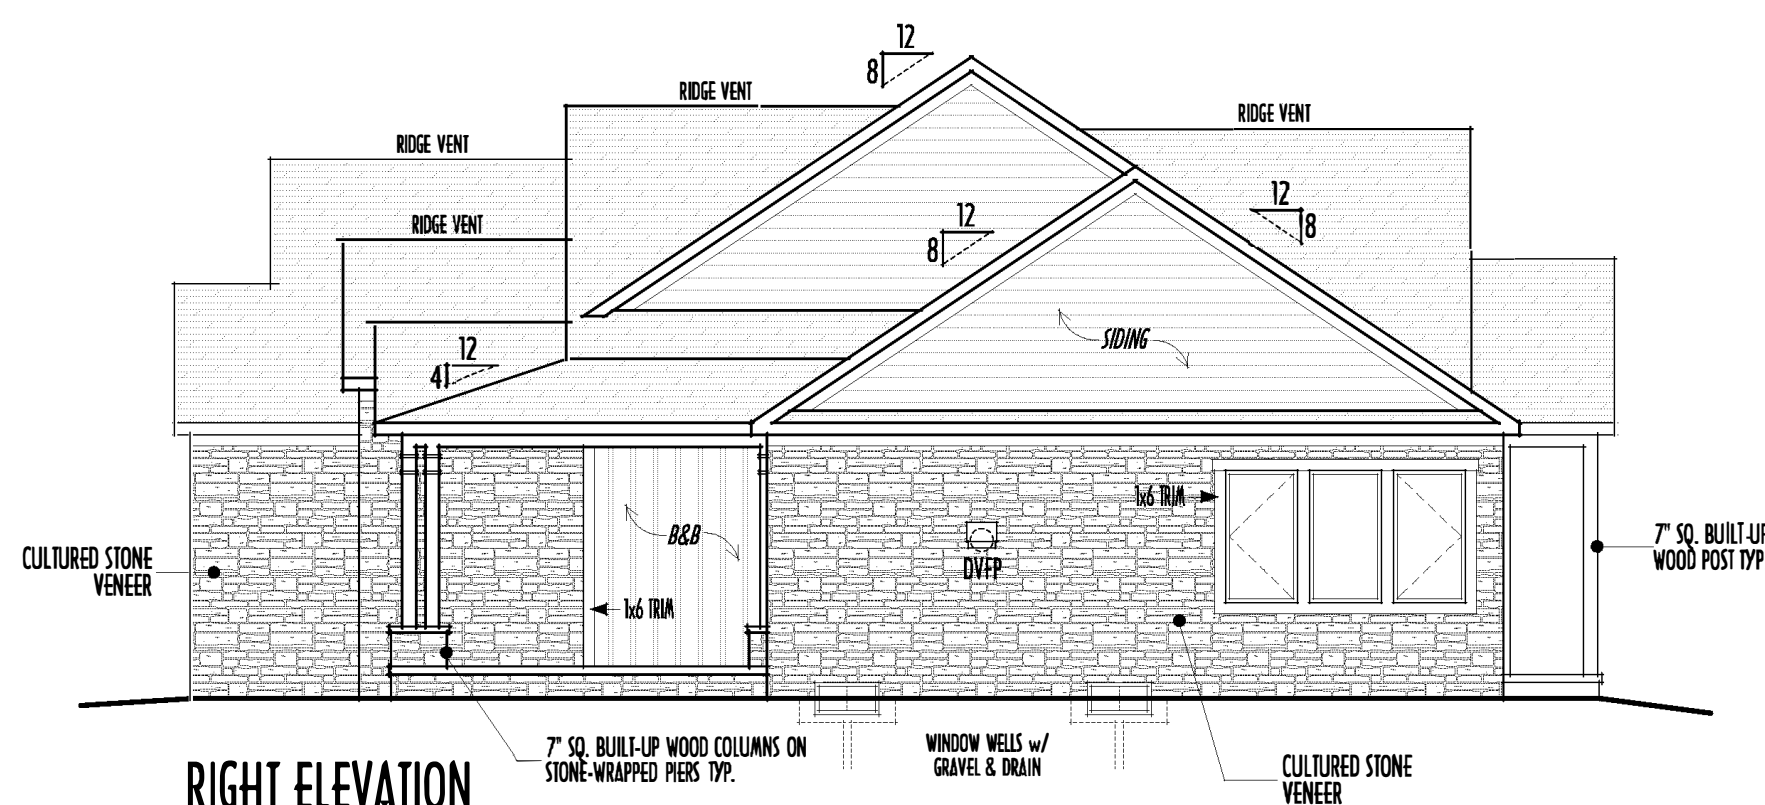

RIGHT ELEVATION
SCALE : 1/8" = 1'-0"

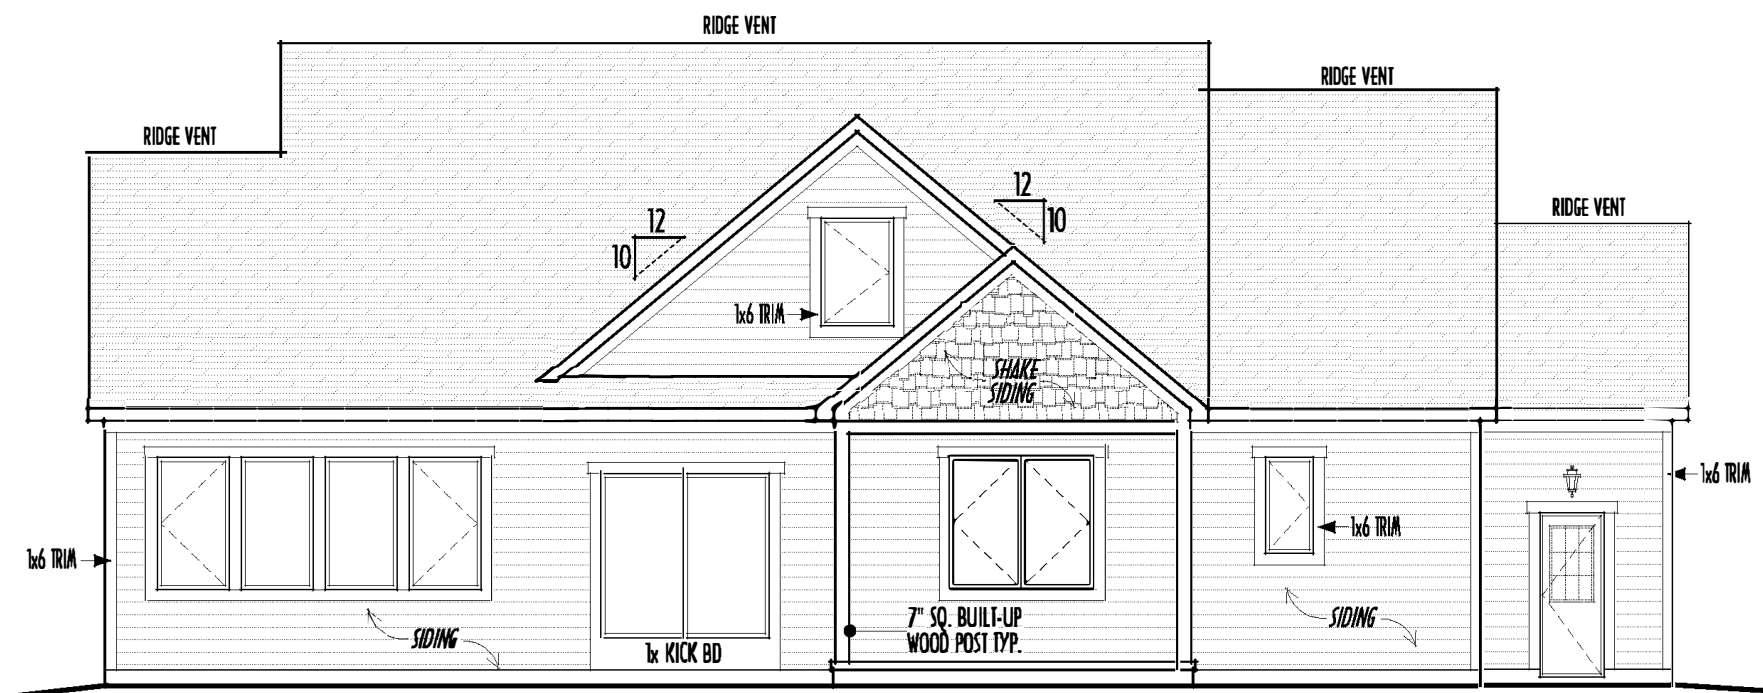

BACK ELEVATION
SCALE : 1/8" = 1'-0"


- DIMENSIONAL SHINGLES
- FAUX STONE VENEER
- HORIZ. LAP HARDPLANK C.B. SIDING
- HARD-SHAKE SIDING
- BOARD & BATTEN SIDING

FINAL WINDOW DESIGN PER PROVIDER, ALL FRAMING ROUGH-OPENINGS TO BE BASED ON FINAL LAYOUT ONLY
EXACT WINDOW & DOOR GRID PATTERNS (MULLIONS) MAY DIFFER - REFER TO MANUFACTURER OR SUPPLIER
GRADE ELEVATION SHOWN IS APPROXIMATE
FIELD VERIFY & ADJUST FOUNDATION AS NECESSARY

FIRST FLOOR CEILINGS @ 9'-1 1/8" UNLESS NOTED OTHERWISE
FIRST FLOOR WINDOW HEADERS @ 7'-5" UNLESS NOTED OTHERWISE
SECOND FLOOR CEILINGS @ 8'-1 1/8" UNLESS NOTED OTHERWISE
SECOND FLOOR WINDOW HEADERS @ 6'-10" UNLESS NOTED OTHERWISE
EMERGENCY EGRESS OPERABLE (E.E.O.) WINDOWS IN ALL BEDROOMS
SEE ROOF PLAN FOR SOFFIT & RAKE SIZES
RUN BRICK VENEER 1" PAST FRAMING CORNERS
CULTURED STONE VENEER WRAPS FRONT CORNERS MIN 6" INTO 1X6 WOOD TRIM UNLESS NOTED
FLASH & CAULK ELEVATIONS AS NECESSARY TO PROVIDE A WEATHER-TIGHT SEAL BETWEEN MATERIALS, FRAMING & TRIM
WINDOWS & DOORS (BRAND & DESIGN) PER CONTRACT
WINDOWS & DOORS ARE TO BE INSTALLED PER MANUFACTURERS SPECIFICATIONS
CONFIRM WINDOW SIZES & ROUGH-OPENINGS WITH SUPPLIER
RUN STUCCO, STONE & BRICK VENEER TO GRADE UNLESS NOTED
WEEP SCREENS FOR STUCCO EXTERIORS SHALL COMPLY WITH R-703.6.2.1
(#26 GALV CORROSION-RESISTANT SCREEN AT/ABV FOUNDATION PLATE (3.5" FLANGED)
PLACED AT MIN 4" ABV EARTH / 2" ABV PAVING, ALLOWING TRAP'D WATER TO DRAIN)
SLOPE GRADE AWAY FROM FOUNDATION FOR PROPER DRAINAGE



FIRST FLR LIVING SP =	2,049 SQ.FT.
SECOND FLR LIVING SP =	658 SQ.FT.
TOTAL LIVING SP =	2,707 SQ.FT.
OPT. FINISHED BSMT =	x SQ.FT.

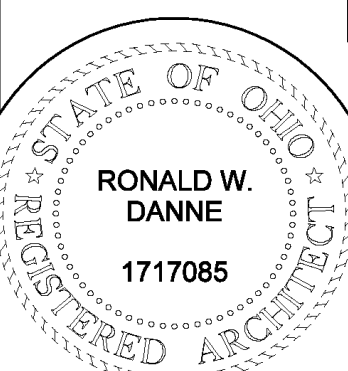

RONALD W. DANNE LICENSE #1717085
EXPIRATION DATE 12/31/2019

Danne
Residential Design & Drafting
614.207.6266 dannedd@gmail.com

REVISION DATE:	BY:	DESCRIPTION
11/16/17	rwd	concept
11/20/17	...	concept rev
1/18/18	...	prelim
1/18/18 & 1/22/18	...	prelim rev
1/23/18 & 1/24/18	...	prelim rev
2/2/18 & 2/26/18	...	prelim rev
3/2/18 & 3/17/18	...	prelim rev
3/2/18 & 3/24/18	...	prelim rev

TO SCALE WHEN PRINTED 24x36 - PAPER SIZE: 10"
FIELD VERIFY DIMENSIONS - DO NOT SCALE PRINTS

DESIGNED: P&D / rwd

PAGE: 5 of 8

PLEASE NOTE: PRELIMINARY DESIGNS ARE SUBJECT TO CHANGE DUE TO STRUCTURAL OR CODE REQUIREMENTS. ITEMS SHOWN MAY BE OPTIONAL/EXTRA. PLEASE REFER TO YOUR CONTRACT FOR SPECIFICATIONS & DESCRIPTIONS.

1ST FLR




P&D Builders Ltd.
59 Greif Parkway Suite 100
Delaware, Ohio 43015
(740) 201-8079
Fax (740) 201-8084
www.pndbuilders.com

ALL DRAWINGS ARE THE PROPERTY OF P&D BUILDERS LTD. NO REPRODUCTION OR COPIES OF THESE DRAWINGS SHALL BE MADE WITHOUT PRIOR WRITTEN CONSENT OF THE ARCHITECT OF THE FIRM.

1289

PRELIMINARY DESIGN
NOT TO SCALE - NOT FOR CONSTRUCTION

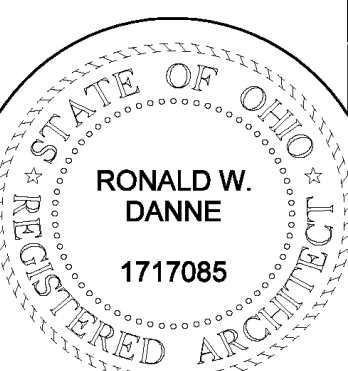

RONALD W. DANNE
1717085
REGISTERED ARCHITECT

RONALD W. DANNE LICENSE #1717085
EXPIRATION DATE 12/31/2019




Danne
Residential Design & Drafting
614.207.6266 danne.drd@gmail.com

REVISION DATE:	BY:	Notes
11/16/17	rwd	concepts
11/20/17	...	concept rev
1/18/18	...	prelim
1/19/18 & 1/22/18	...	prelim rev
1/23/18 & 1/24/18	...	prelim rev
2/2/18 & 2/26/18	...	prelim rev
3/2/18 & 3/17/18	...	prelim rev
3/21/18 & 3/24/18	...	prelim rev

TO SCALE WHEN PRINTED 24x36 - PAPER SIZE 11"
FIELD VERIFY DIMENSIONS - DO NOT SCALE PRINTS

DESIGNED BY: P&D / rwd

PAGE: 3 of 8

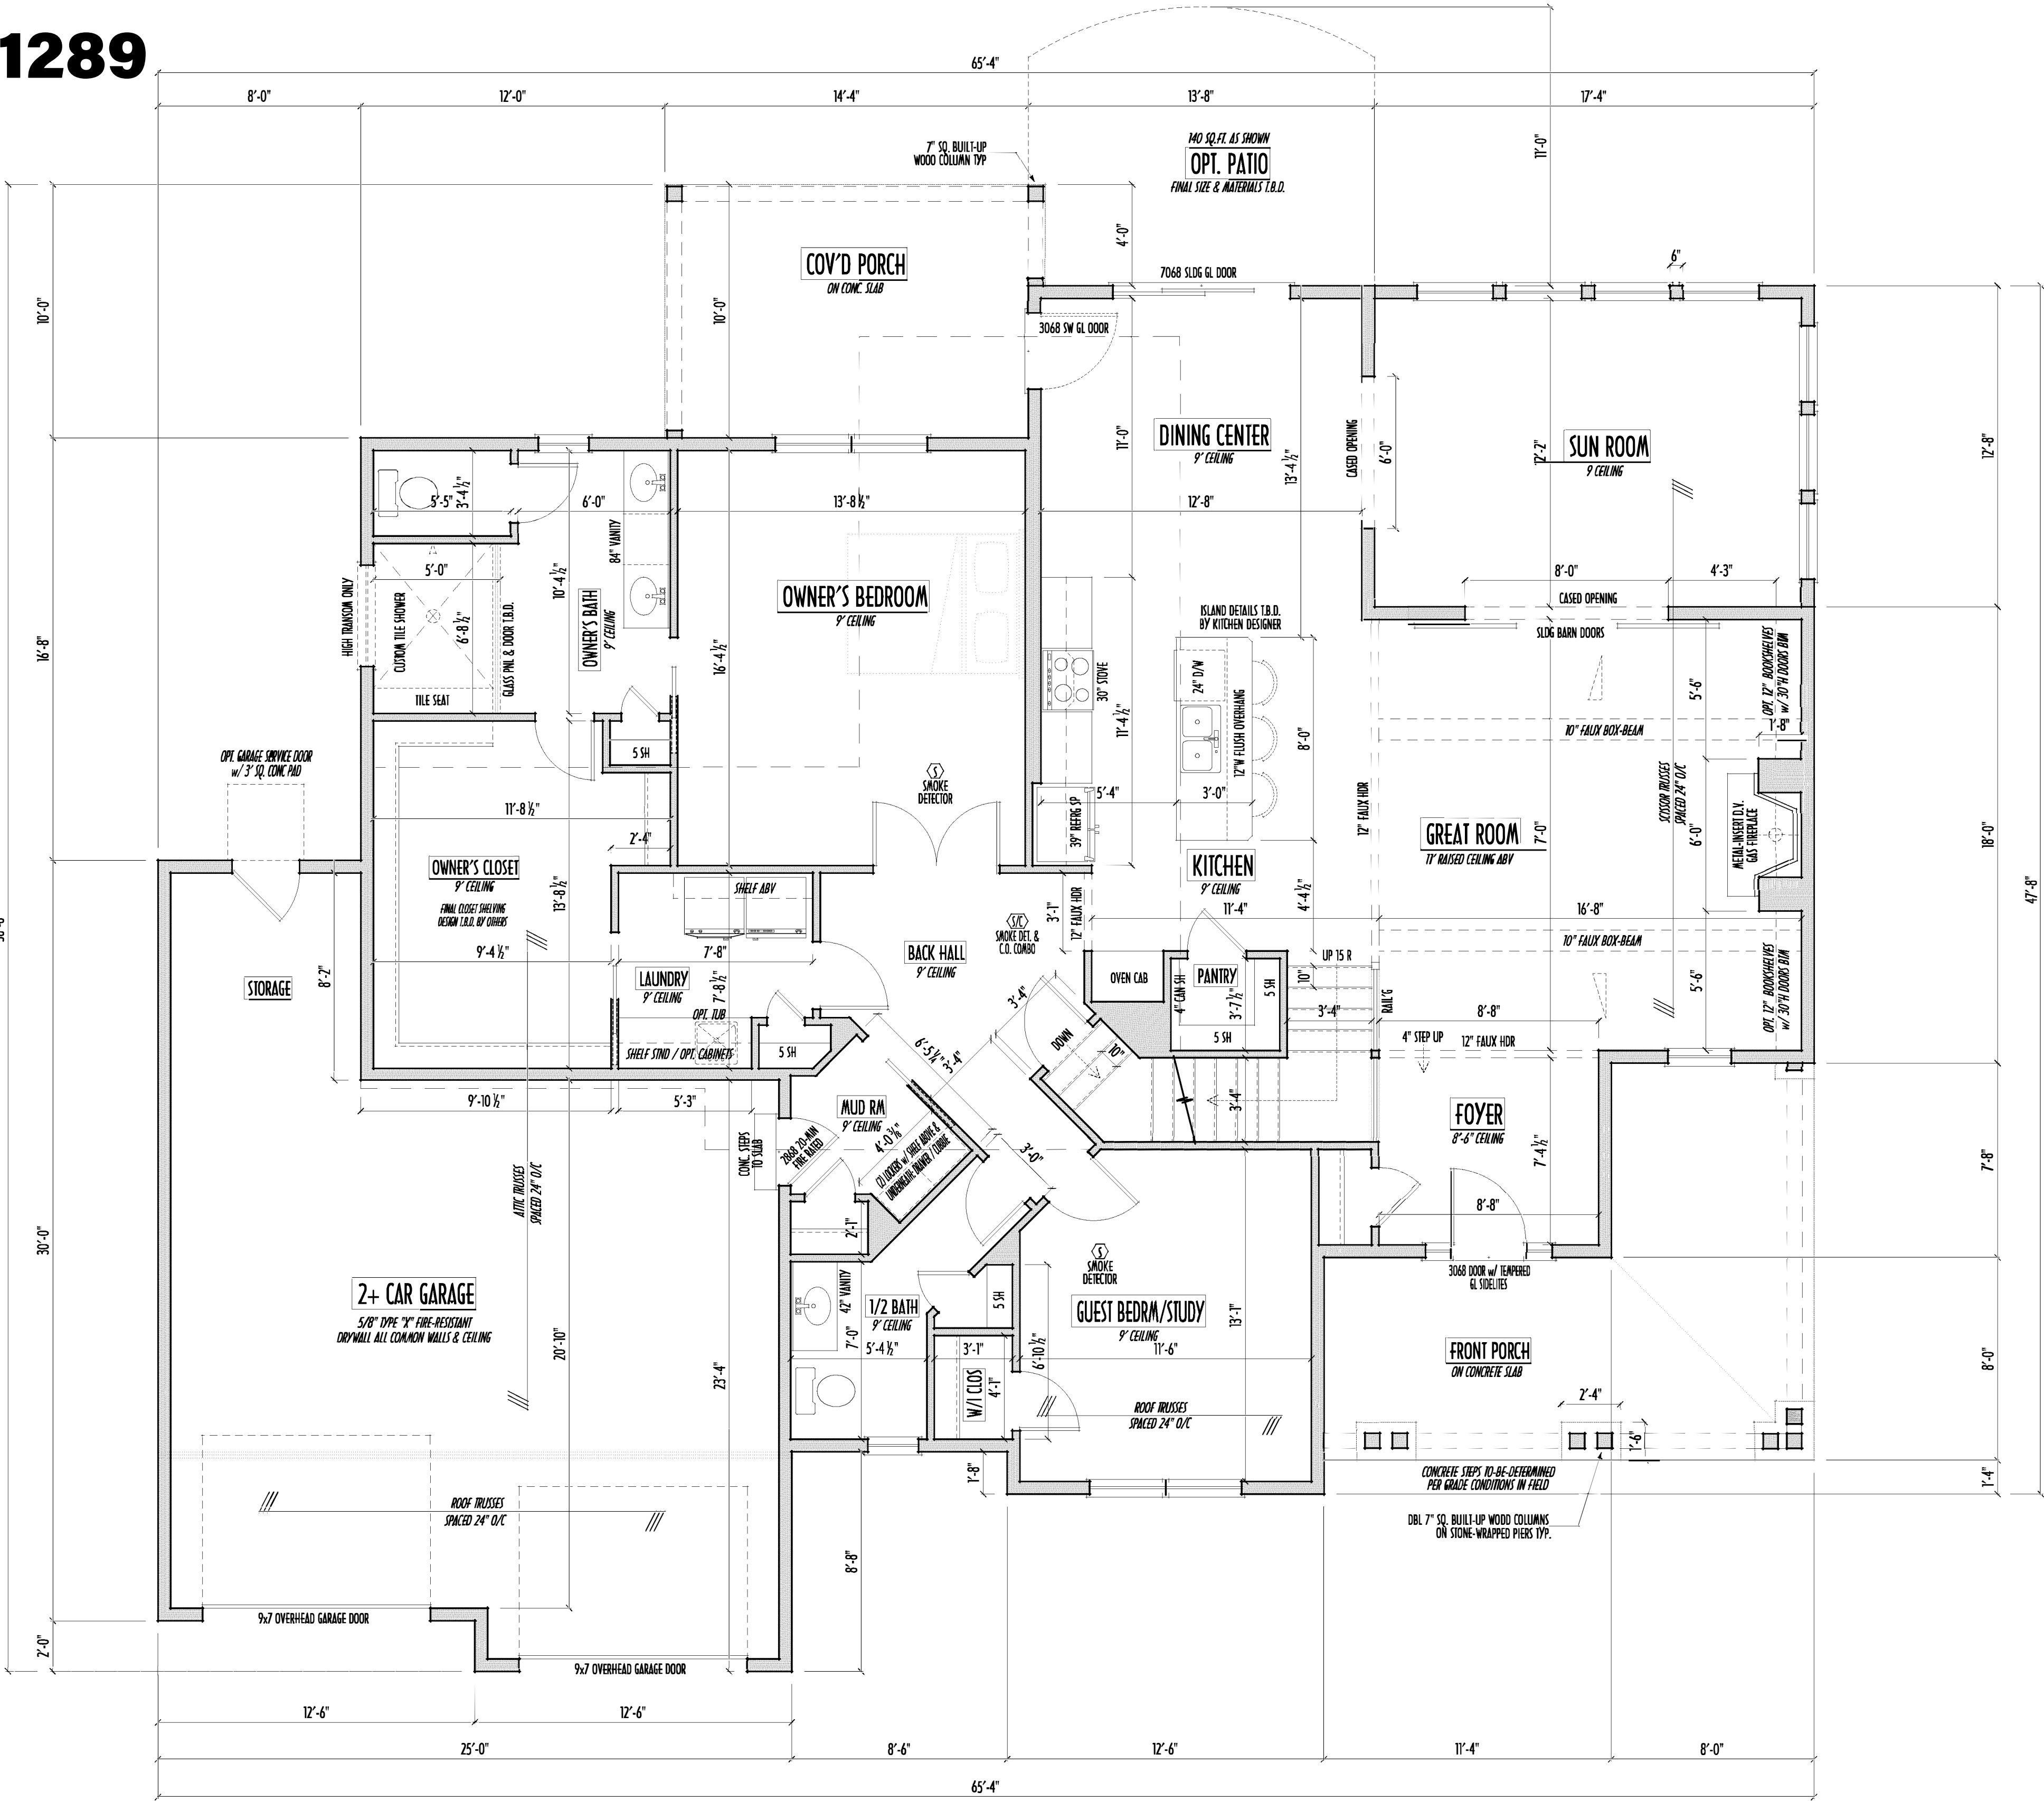

FIRST FLOOR PLAN
SCALE: 1/4" = 1'-0"

FIRST FLR LIVING SP =	2,049 SQ.FT.
SECOND FLR LIVING SP =	658 SQ.FT.
TOTAL LIVING SP =	2,707 SQ.FT.
OPT. FINISHED BSMT =	x SQ.FT.

2ND FLR




P&D Builders Ltd.

59 Greif Parkway Suite 100
Delaware, Ohio 43015
(740) 201-8079
Fax (740) 201-8084
www.pndbuilders.com

ALL DRAWINGS ARE THE SOLE PROPERTY OF P&D BUILDERS. NO REPRODUCTION OR CIRCULATION OF THESE DRAWINGS IS ALLOWED WITHOUT PRIOR WRITTEN CONSENT OF THE ARCHITECT OF THE PLANS.

PROJ #1289

PRELIMINARY DESIGN
NOT TO SCALE - NOT FOR CONSTRUCTION

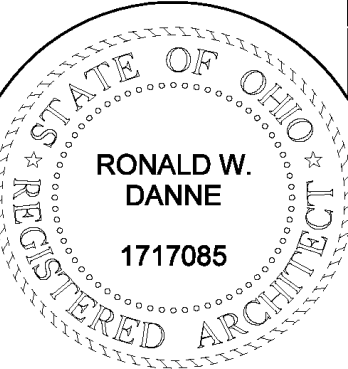

RONALD W. DANNE LICENSE #1717085
EXPIRATION DATE 12/31/2019

Danne

Residential Design & Drafting, Inc.

614.207.6266 dannedrd@gmail.com

REVISION DATE:	BY:	DESCRIPTION
11/16/17	rwd	concepts
11/20/17	...	concept rev
1/18/18	...	prelim
1/19/18 & 1/22/18	...	prelim rev
1/23/18 & 1/24/18	...	prelim rev
2/2/18 & 2/26/18	...	prelim rev
3/2/18 & 3/17/18	...	prelim rev
3/21/18 & 3/24/18	...	prelim rev

TO SCALE WHEN PRINTED 24x36 - PAPER SIZE: 11"
FIELD VERIFY DIMENSIONS - DO NOT SCALE PRINTS

DESIGNED BY: P&D / rwd

PAGE: 4 of 8

SECOND FLOOR PLAN
SCALE: 1/4" = 1'-0"

Notes:
SECOND FLOOR CEILINGS AT 8'-1 1/8" ROUGH UNLESS NOTED
SECOND FLOOR WINDOWS HEADERS AT 8'-10" UNLESS NOTED
EXTERIOR WALLS ARE SHOWN 6" WIDE (2x6 STUDS @ 16" O/C UNLESS NOTED)
INTERIOR WALLS ARE SHOWN 3.5" WIDE (2x4 STUDS @ 16" O/C UNLESS NOTED)
SECOND FLOOR DESIGN LIVE LOAD = 40 PSF (BEDRMS 30 PSF)
WINDOWS & DOORS (BRAND & DESIGN) PER CONTRACT
INTERIOR DOORS SHOWN 4" OFF CORNERS UNLESS NOTED
IN SLEEPING ROOMS, AT LEAST ONE WINDOW MUST MEET EMERGENCY EGRESS REQUIREMENTS (MIN. 20" WIDE X 24" TALL & 5.7 SQ.FT.) PER I.C.O. 310
CONFIRM WINDOW ROUGH-OPENINGS WITH MANUFACTURER AND ADJUST FRAMING DIMENSIONS AS NECESSARY
NOTE: DIMENSIONS FOR ANGLED WALLS MAY CONTAIN ROUNDING ERRORS OF LESS THAN 1/8" TYPICALLY
FINAL/INSTALLED INSULATION VALUES SHOULD MATCH REM-RATE SHEETS FROM TACOMA ENERGY (THOSE SHOWN ON THESE PLANS ARE PRELIMINARY/REFERENCE ONLY)
INSTALL ALL LVL & LSL BEAMS WITH LABELS VISIBLE FOR BLDG INSPECTION
FOAM PLASTIC/INSULATION SHALL BE INSTALLED PER RCO 314 & 315 <75 PSR, <450 SDR PER ASTM E84

P&D BUILDERS
EST. 1962

FIRST FLR LIVING SP =	2,049 SQ.FT.
SECOND FLR LIVING SP =	658 SQ.FT.
TOTAL LIVING SP =	2,707 SQ.FT.
OPT. FINISHED BSMT =	x SQ.FT.

3/30/2018 10:01 PM

P&D Builders - Job # 1289

MAX. UNBALANCED FILL FOR 8" THICK POURED CONC. WALL OR C.M.U. BLOCK WALL = 7'-0" ABOVE SLAB

WATERPROOFING / DAMPROOFING PER CODE

ALL STRUCTURAL LUMBER IS MIN. CANADIAN SPECIES #2 SPRUCE-PINE-FIR, UNLESS NOTED OTHERWISE

FIRST FLOOR DESIGN LIVE LOAD = 40 PSF

BASEMENT ELECTRICAL LAYOUT FOR REFERENCE ONLY - CONSULT WITH HOMEOWNER PRIOR TO INSTALLATION FOR EXACT LOCATIONS

GRADE MIN. 8" BELOW TOP OF FOUNDATION, SLOPING AWAY FOR PROPER DRAINAGE MIN. 6" DROP IN FIRST 10FT OF RUN

AVOID FLOODJOISTS LOCATED DIRECTLY BELOW PLUMBING DRAINS & TRAPS

BLOCK BETWEEN FLOODJOISTS BELOW STRUCTURAL POINTS (CRUSH ZONES) WITH APPROPRIATE 2X FILL


SEE COVER SHEET FOR GENERAL FOUNDATION CONSTRUCTION NOTES

STEP DOWN FOOTING AS NECESSARY TO REMAIN MIN. 36" BELOW GRADE

USE PRES-TREATED EXTERIOR-GRADE LUMBER WHERE EXPOSED TO WEATHER OR IN CONTACT WITH CONCRETE

FOUNDATION WALL ENGINEERING & REINFORCEMENT PER SHEPHERD EXCAVATING DESIGN-DETAIL RC-16

INSTALL ALL LVL & LSL BEAMS WITH LABELS VISIBLE FOR BLDG INSPECTION

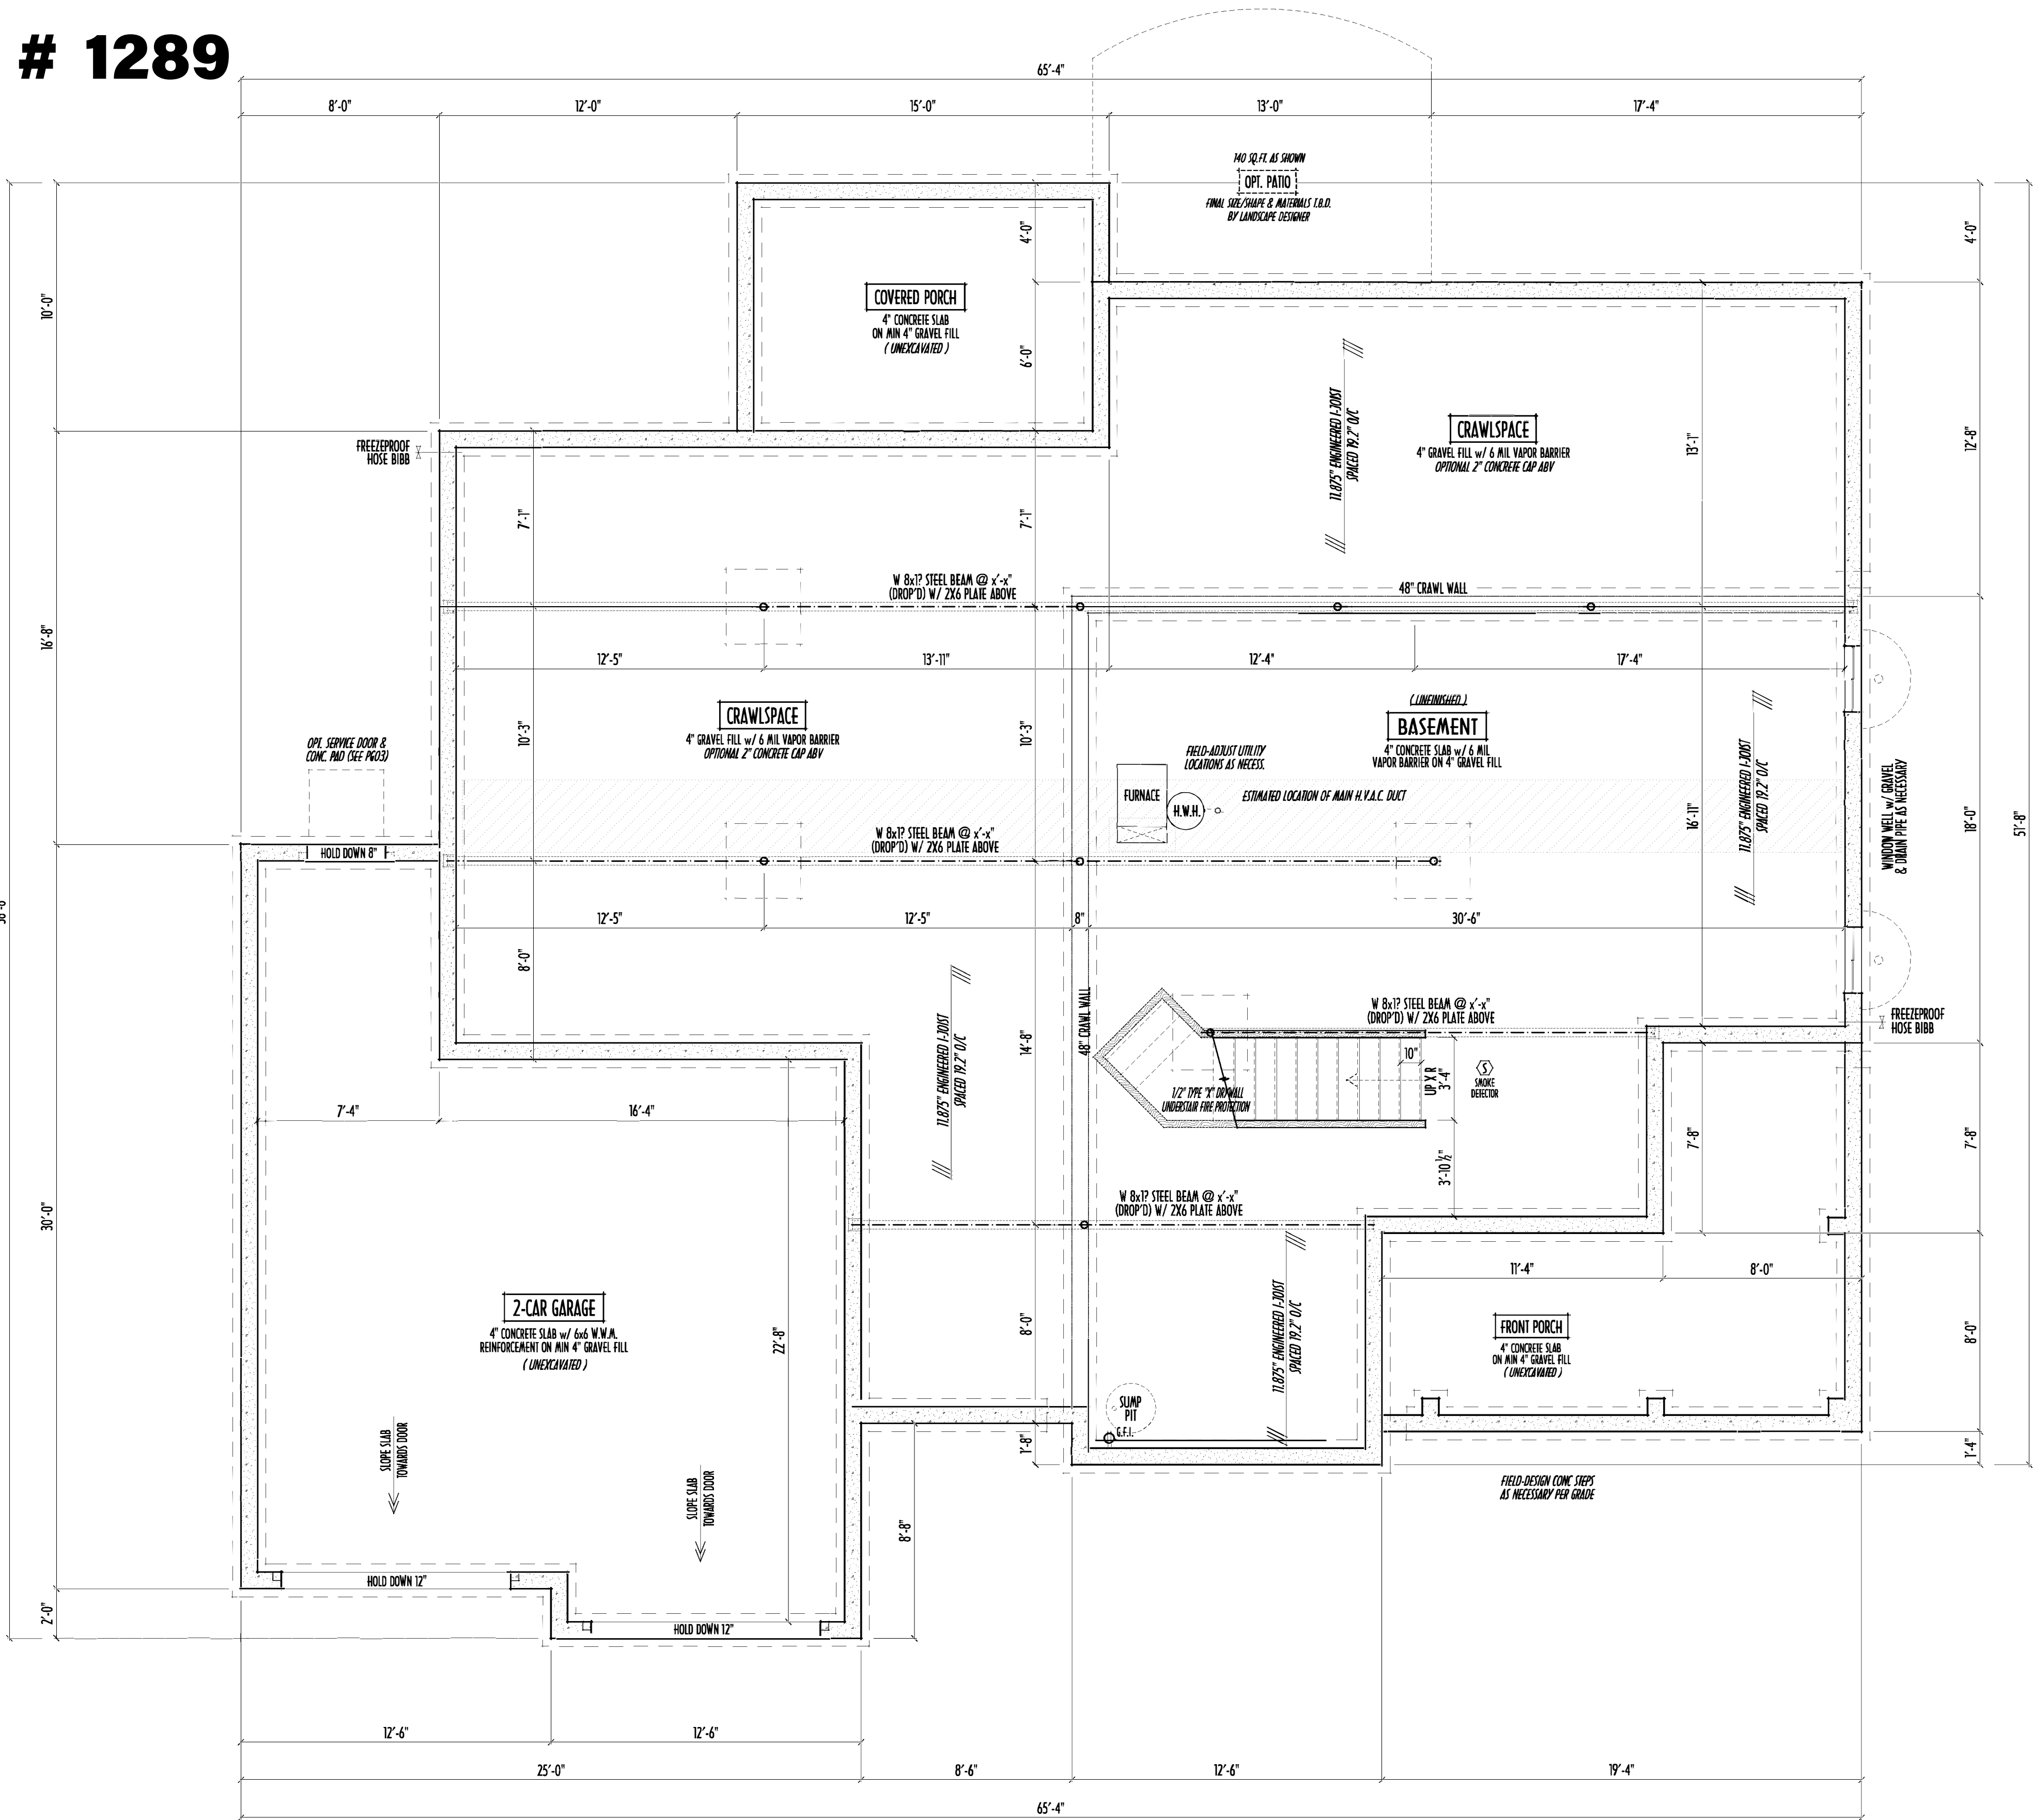

FOUNDATION / BASEMENT PLAN
SCALE : 1/4" = 1'-0"



PLEASE NOTE: PRELIMINARY DESIGNS ARE SUBJECT TO CHANGE DUE TO STRUCTURAL OR CODE REQUIREMENTS. ITEMS SHOWN MAY BE OPTIONAL/EXTRA. PLEASE REFER TO YOUR CONTRACT FOR SPECIFICATIONS & DESCRIPTIONS.


FND/BSMT

P&D Builders Ltd.
59 Greif Parkway Suite 100
Delaware, Ohio 43015
(740) 201-8079
Fax (740) 201-8084
www.pndbuilders.com

BY ORDERING THE FOLLOWING PROPERTY TO BE MEASURED, TO BE MEASURED FOR THE PURPOSES OF THIS PLAN, THE MEASUREMENTS SHALL BE THE RESPONSIBILITY OF THE MEASURER. THE MEASUREMENTS SHALL BE THE RESPONSIBILITY OF THE MEASURER.

1289

PRELIMINARY DESIGN
NOT TO SCALE - NOT FOR CONSTRUCTION

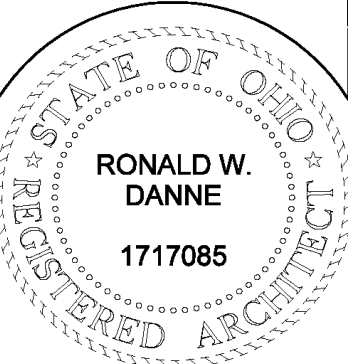

RONALD W. DANNE LICENSE #1717085
EXPIRATION DATE 12/31/2019

Danne
Residential Design & Drafting, Inc.
614.207.6266 danne.rdw@gmail.com

REVISION DATE:	BY:	DESCRIPTION
11/16/17	rwd	concept
11/20/17	...	concept rev
1/18/18	...	prelim
1/18/18 & 1/22/18	...	prelim rev
1/23/18 & 1/24/18	...	prelim rev
2/2/18 & 2/26/18	...	prelim rev
3/2/18 & 3/17/18	...	prelim rev
3/2/18 & 3/24/18	...	prelim rev

TO SCALE WHEN PRINTED 24x36 - PAPER SIZE 11"
FIELD VERIFY DIMENSIONS - DO NOT SCALE PRINTS

DESIGNED BY: P&D / rwd

PAGE: 2 of 8

FIRST FLR LIVING SP =	2,049 SQ.FT.
SECOND FLR LIVING SP =	658 SQ.FT.
TOTAL LIVING SP =	2,707 SQ.FT.
OPT. FINISHED BSMT =	x SQ.FT.