

P&D Builders - Job # 1224

PLEASE NOTE: PRELIMINARY DESIGNS ARE SUBJECT TO CHANGE DUE TO STRUCTURAL OR CODE REQUIREMENTS. ITEMS SHOWN MAY BE OPTIONAL. PLEASE REFER TO YOUR CONTRACT FOR SPECIFICATIONS & DESCRIPTIONS.

ELEVATIONS



P&D Builders Ltd.
59 Greff Parkway Suite 100
Delaware, Ohio 43015
(740) 201-8079
Fax (740) 201-8084
www.pndbuilders.com

ALL DIMENSIONS ARE EXCEPT WHERE NOTED OTHERWISE. DIMENSIONS ARE TO FACE UNLESS NOTED OTHERWISE. DIMENSIONS ARE TO FACE UNLESS NOTED OTHERWISE.

1224

1224

PRELIMINARY DESIGN
NOT TO SCALE - NOT FOR CONSTRUCTION

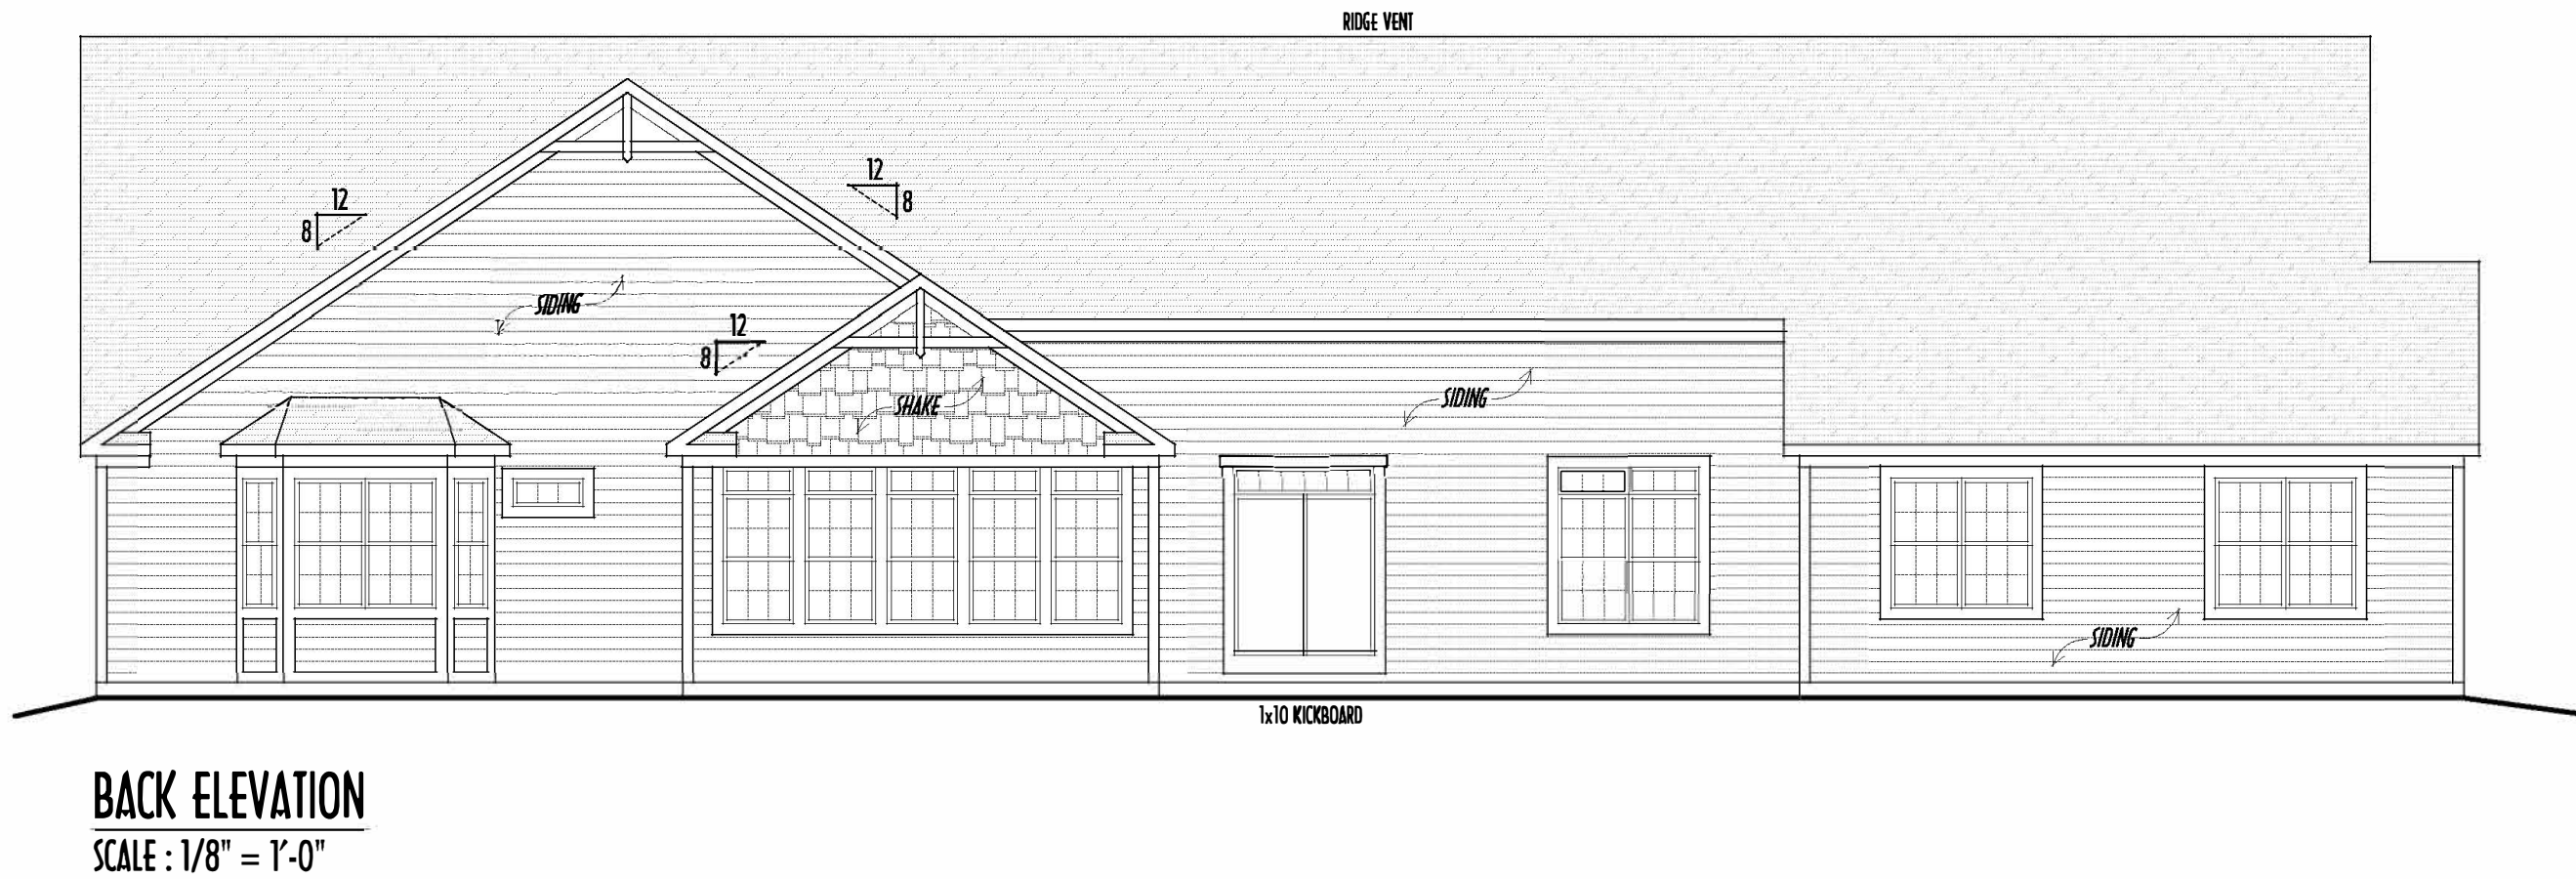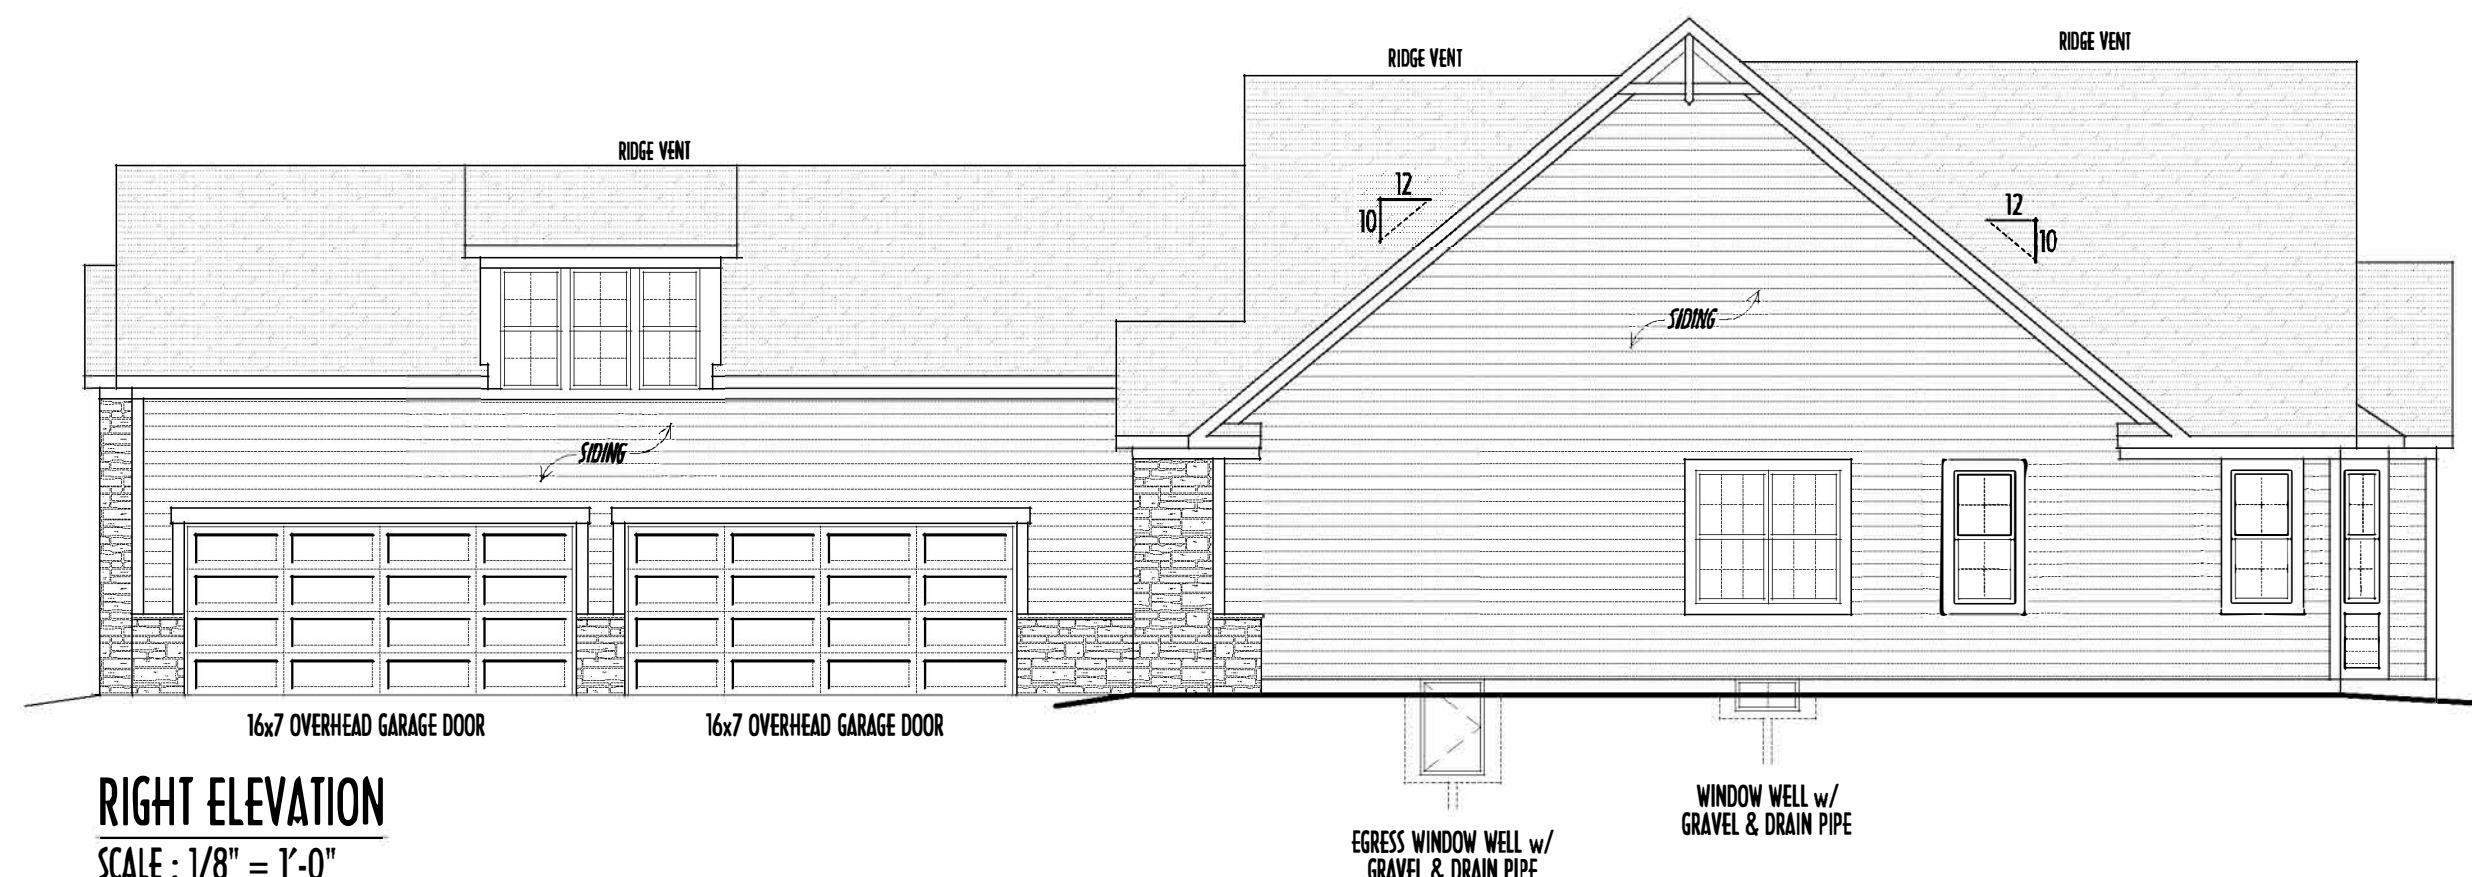

- DIMENSIONAL SHINGLES
- CULTURED STONE VENEER
- VERT. LAP SIDING
- SHAKE SIDING

FIRST FLOOR CEILING @ 9'-1 1/8" UNLESS NOTED OTHERWISE
FIRST FLOOR WINDOW HEADERS @ 7'-6" UNLESS NOTED OTHERWISE
EMERGENCY EGRESS OPERABLE (E.E.O.) WINDOWS IN ALL BEDROOMS
SEE ROOF PLAN FOR SOFFIT & RAKE SIZES
RUN BRICK VENEER 1" PAST FRAMING CORNERS
CULTURED STONE VENEER WRAPS FRONT CORNERS MIN 6"
INTO 2x6 WOOD TRIM UNLESS NOTED
FLASH & CAULK ELEVATIONS AS NECESSARY TO PROVIDE A
A WEATHER-TIGHT SEAL BETWEEN MATERIALS, FRAMING & TRIM
WINDOWS & DOORS (BRAND & DESIGN) PER CONTRACT
WINDOWS & DOORS ARE TO BE INSTALLED PER MANUFACTURERS SPECIFICATIONS
CONFIRM WINDOW SIZES & ROUGH-OPENINGS WITH SUPPLIER
RUN STUCCO, STONE & BRICK VENEER TO GRADE UNLESS NOTED
WEAP SCREENS FOR STUCCO EXTERIORS SHALL COMPLY WITH R-703.6.2.1
(#26 GALLY CORROSION-RESISTANT SCREEN AT/ABV FOUNDATION PLATE (3.5" FLANGED)
PLACED AT MIN 4" ABV EARTH / 2" ABV PAVING, ALLOWING TRAP'D WATER TO DRAIN)
SLOPE GRADE AWAY FROM FOUNDATION FOR PROPER DRAINAGE

Reviewed & Approved

Clients Name
Date
COPYRIGHT - P & D BUILDERS LTD.
ALL DESIGNS REMAIN THE EXCLUSIVE PROPERTY OF P & D BUILDERS LTD.
DRAWINGS MAY NOT BE REPRODUCED WITHOUT PRIOR PERMISSION



FINAL WINDOW DESIGN PER PROVIDER, ALL FRAMING ROUGH-
OPENINGS TO BE BASED ON FINAL LAYOUT ONLY

EXACT WINDOW & DOOR GRID PATTERNS (MULLIONS)
MAY DIFFER - REFER TO MANUFACTURER OR SUPPLIER

GRADE ELEVATION SHOWN IS APPROXIMATE
FIELD VERIFY & ADJUST FOUNDATION AS NECESSARY


FIRST FLOOR =	3,860 SQ.FT.
SECOND FLOOR =	655 SQ.FT.
TOTAL =	4,515 SQ.FT.
4-SEASON RM =	278 SQ.FT.
OPT FIN. BSMT =	1,228 SQ.FT.

TO-SCALE WHEN PRINTED 24x36 - PAPER SIZE 12"
0 6" 12" 18" 24" 30" 36" 42" 48" 54" 60" 66" 72" 78" 84" 90" 96" 102" 108" 114" 120"
FIELD MEASUREMENTS - DO NOT SCALE PRINTS

DESIGNED BY: P&D / rwd

PAGE: 5 of 8

P&D Builders - Job #1224

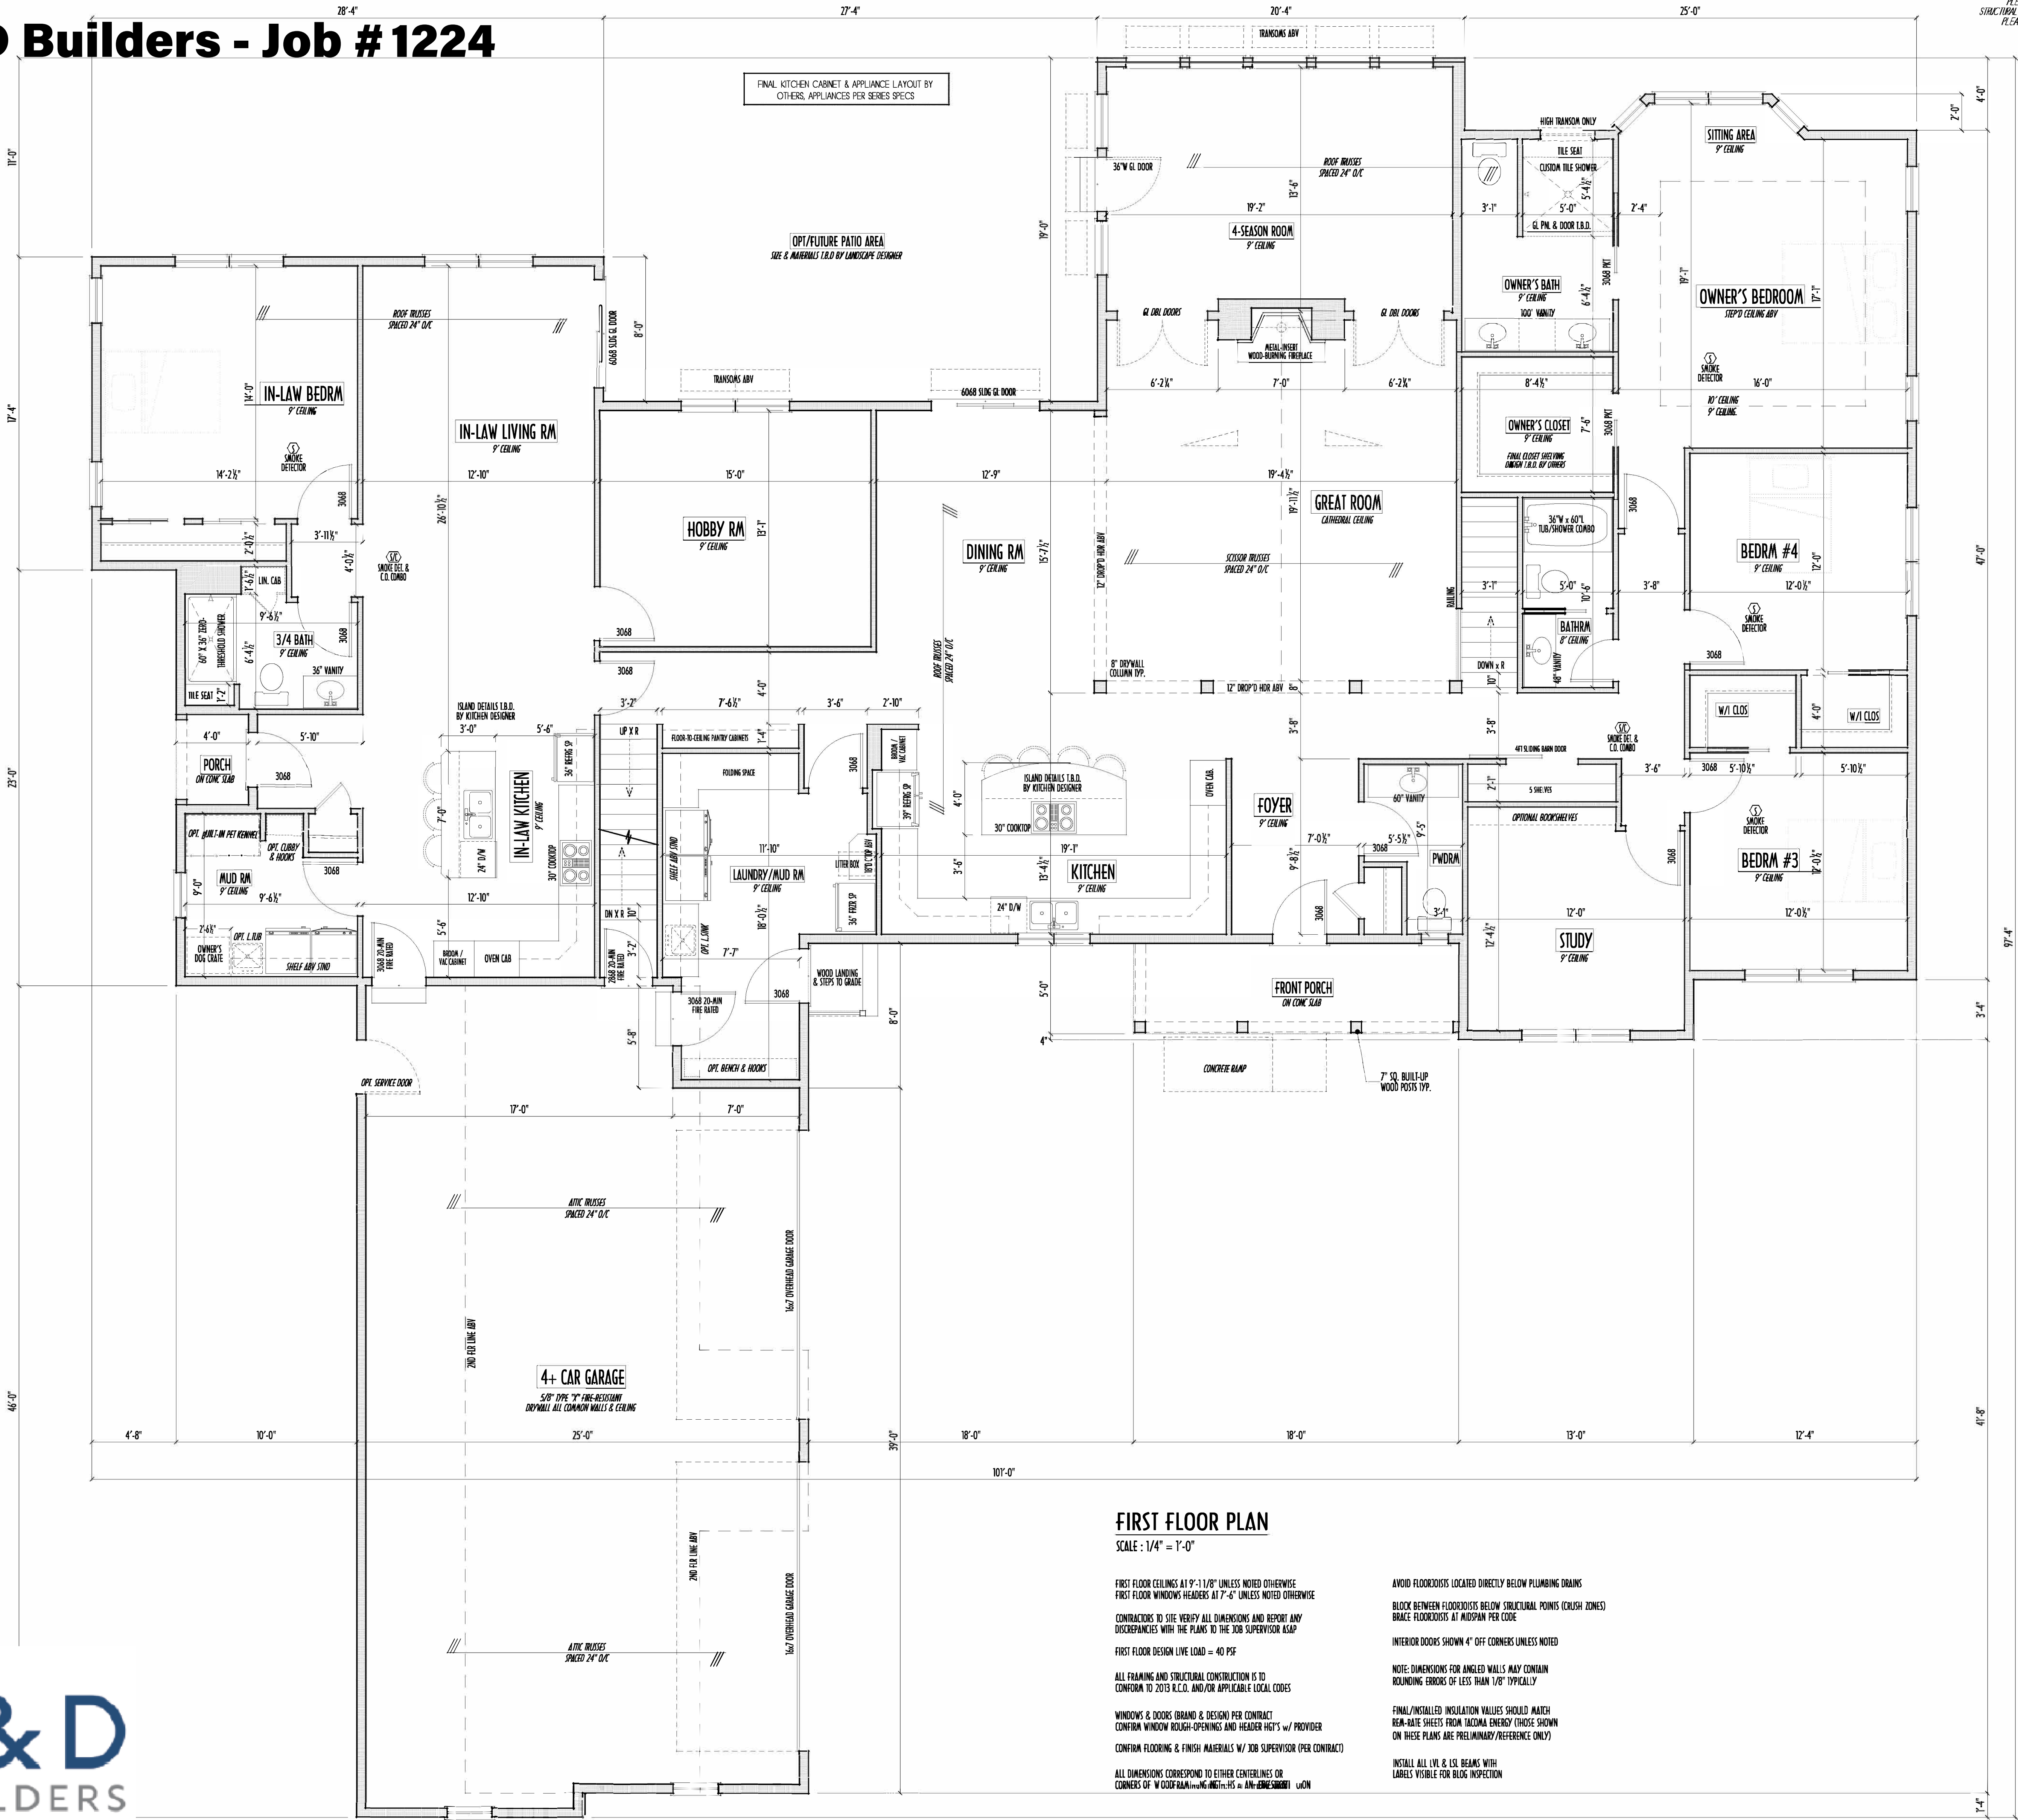

FIRST FLOOR PLAN
SCALE: 1/4" = 1'-0"

FIRST FLOOR CEILINGS AT 9'-1 1/8" UNLESS NOTED OTHERWISE
FIRST FLOOR WINDOWS HEADERS AT 7'-6" UNLESS NOTED OTHERWISE
CONTRACTORS TO SITE VERIFY ALL DIMENSIONS AND REPORT ANY DISCREPANCIES WITH THE PLANS TO THE JOB SUPERVISOR ASAP
FIRST FLOOR DESIGN LIVE LOAD = 40 PSF
ALL FRAMING AND STRUCTURAL CONSTRUCTION IS TO CONFORM TO 2013 I.C.C. AND/OR APPLICABLE LOCAL CODES
WINDOWS & DOORS (BRAND & DESIGN) PER CONTRACT
CONFIRM WINDOW ROUGH-OPENINGS AND HEADER HGT'S w/ PROVIDER
CONFIRM FLOORING & FINISH MATERIALS w/ JOB SUPERVISOR (PER CONTRACT)
ALL DIMENSIONS CORRESPOND TO EITHER CENTERLINES OR CORNERS OF WOOD FRAMING MEMBERS as SHOWN
AVOID FLOORJOISTS LOCATED DIRECTLY BELOW PLUMBING DRAINS
BLOCK BETWEEN FLOORJOISTS BELOW STRUCTURAL POINTS (COLUSH ZONES)
BRACE FLOORJOISTS AT AUSPAIN PER CODE
INTERIOR DOORS SHOWN 4" OFF CORNERS UNLESS NOTED
NOTE: DIMENSIONS FOR ANGLED WALLS MAY CONTAIN ROUNDING ERRORS OF LESS THAN 1/8" TYPICALLY
FINAL/INSTALLED INSULATION VALUES SHOULD MATCH HEAD-WALL SHEETS FROM THERMA ENERGY (THOSE SHOWN ON THESE PLANS ARE PRELIMINARY/REFERENCE ONLY)
INSTALL ALL LVL & LSL BEAMS WITH LABELS VISIBLE FOR BLOG INSPECTION

FIRST FLOOR =	3,860 SQ.FT.
SECOND FLOOR =	655 SQ.FT.
TOTAL =	4,515 SQ.FT.
4-SEASON RM =	278 SQ.FT.
OPT FIN. BSMT =	1,228 SQ.FT.

Reviewed & Approved

Clients Name

Date

© COPYRIGHT - P & D BUILDERS LTD.
ALL DESIGNS REMAIN THE EXCLUSIVE PROPERTY OF P & D BUILDERS LTD.
DRAWINGS MAY NOT BE REPRODUCED WITHOUT PRIOR PERMISSION

1ST FLR

P&D Builders Ltd.
59 Greff Parkway Suite 100
Delaware, Ohio 43015
(740) 201-8079
Fax (740) 201-8064
www.pndbuilders.com

1224

PRELIMINARY DESIGN
NOT TO SCALE - NOT FOR CONSTRUCTION

REVISION DATE:	BY:	DATE
8/3/16	rwd	concept
8/4/16	...	concept rev
8/18/16	...	concept rev
8/22/16	...	concept rev
8/31/16	...	prelims
9/6/16	...	prelims rev

TO SCALE WHEN PRINTED 24x36 - 1/4" = 1'-0"
0 4 8 12 16 20 24 28 32 36 40 44 48 52 56 60 64 68 72 76 80 84 88 92 96 100
FEET - METERS (DO NOT SCALE PRINTS)

DESIGNED BY:	P&D / rwd
PAGE:	3 of 8

PLEASE NOTE: PRELIMINARY DESIGNS ARE SUBJECT TO CHANGE DUE TO STRUCTURAL OR CODE REQUIREMENTS. ITEMS SHOWN MAY BE OPTIONAL. PLEASE REFER TO YOUR CONTRACT FOR SPECIFICATIONS & DESCRIPTIONS.

ALL DRAWINGS ARE THE EXCLUSIVE PROPERTY OF P&D BUILDERS LTD. NO REPRODUCTION OR OTHER USE OF THESE DRAWINGS IS ALLOWED WITHOUT PRIOR WRITTEN CONSENT OF THE ARCHITECT OR ENGINEER.

PRELIMINARY DESIGN
NOT TO SCALE - NOT FOR CONSTRUCTION




P&D Builders Ltd.
59 Greff Parkway Suite 100
Delaware, Ohio 43015
(740) 201-8079
Fax (740) 201-8064
www.pndbuilders.com

ALL DIMENSIONS ARE THE EXCLUSIVE PROPERTY OF P&D BUILDERS LTD. NO REPRESENTATION OR OPINION OF THIS FIRM SHALL BE MADE WITHOUT THE WRITTEN CONSENT OF THE ARCHITECT OF THE FIRM.

1224

PRELIMINARY DESIGN
NOT TO SCALE - NOT FOR CONSTRUCTION

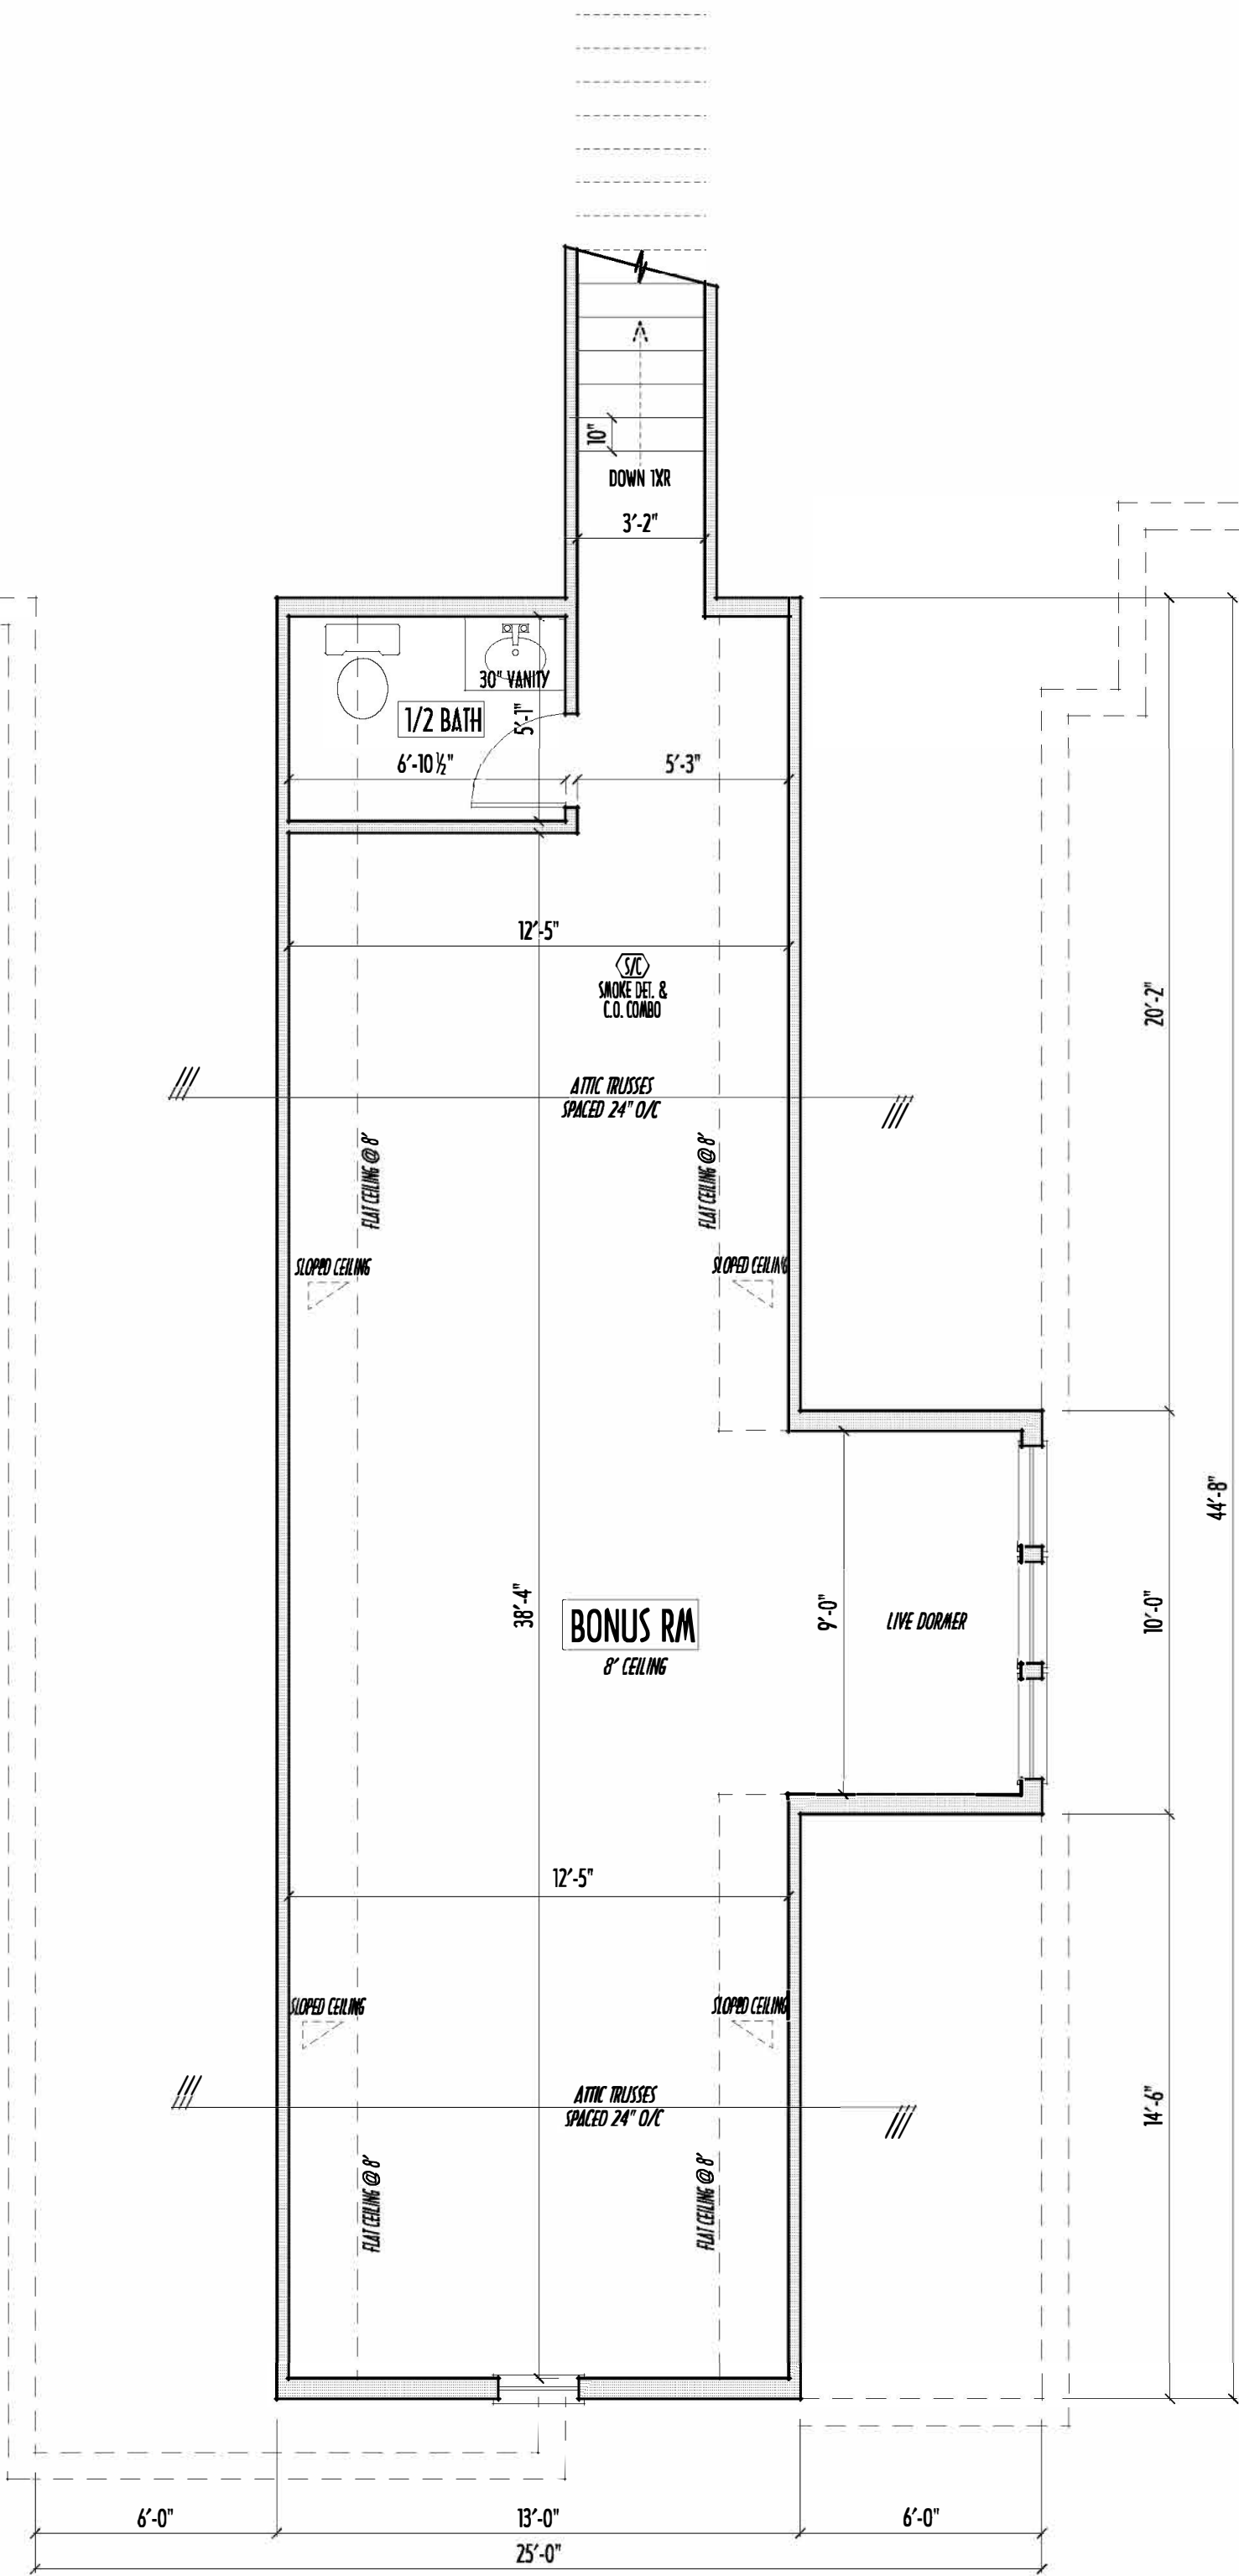

SECOND FLOOR PLAN

SCALE : 1/4" = 1'-0"

SECOND FLOOR CEILINGS AT 8'-1 1/8" ROUGH UNLESS NOTED
SECOND FLOOR WINDOWS HEADERS AT 6'-10" UNLESS NOTED
EXTERIOR WALLS ARE SHOWN 6" WIDE (2x6 STUDS @ 16" O.C. UNLESS NOTED)
INTERIOR WALLS ARE SHOWN 3.5" WIDE (2x4 STUDS @ 16" O.C. UNLESS NOTED)
SECOND FLOOR DESIGN LIVE LOAD = 40 PSF (BEDROOMS 30 PSF)
WINDOWS & DOORS (BRAND & DESIGN) PER CONTRACT
INTERIOR DOORS SHOWN 4" OFF CORNERS UNLESS NOTED
IN SLEEPING ROOMS, AT LEAST ONE WINDOW MUST MEET EMERGENCY EGRESS REQUIREMENTS (MIN. 20" WIDE X 24" TALL & 5.7 SQ.FT.) PER I.C.D. 310
CONFIRM WINDOW ROUGH-OPENINGS WITH MANUFACTURER AND ADJUST FRAMING DIMENSIONS AS NECESSARY
NOTE: DIMENSIONS FOR ANGLED WALLS MAY CONTAIN ROUNDING ERRORS OF LESS THAN 1/8" TYPICALLY
FINAL/INSTALLED INSULATION VALUES SHOULD MATCH REAR-BATE SHEETS FROM TACOMA ENERGY (THOSE SHOWN ON THESE PLANS ARE PRELIMINARY/REFERENCE ONLY)
INSTALL ALL LVL & LSL BEAMS WITH LABELS VISIBLE FOR BLOC INSPECTION
FOAM PLASTIC/INSULATION SHALL BE INSTALLED PER RCD 314 & 315 <75 PSF, <450 SOR PER ASTM E84

Reviewed & Approved

Clients Name


Date

© COPYRIGHT - P & D BUILDERS LTD.
ALL DESIGNS REMAIN THE EXCLUSIVE PROPERTY OF P & D BUILDERS LTD.
DRAWINGS MAY NOT BE REPRODUCED WITHOUT PRIOR PERMISSION

FIRST FLOOR =	3,860 SQ.FT.
SECOND FLOOR =	655 SQ.FT.
TOTAL =	4,515 SQ.FT.
4-SEASON RM =	278 SQ.FT.
OPT FIN. BSMT =	1,228 SQ.FT.




REVISION DATE:	BY:	DATE
8/3/16	rwd	concept
8/4/16	...	concept rev
8/18/16	...	concept rev
8/22/16	...	concept rev
8/31/16	...	prelims
9/6/16	...	prelims rev

 

DESIGNED: P&D / rwd

P&D Builders - Job # 1224

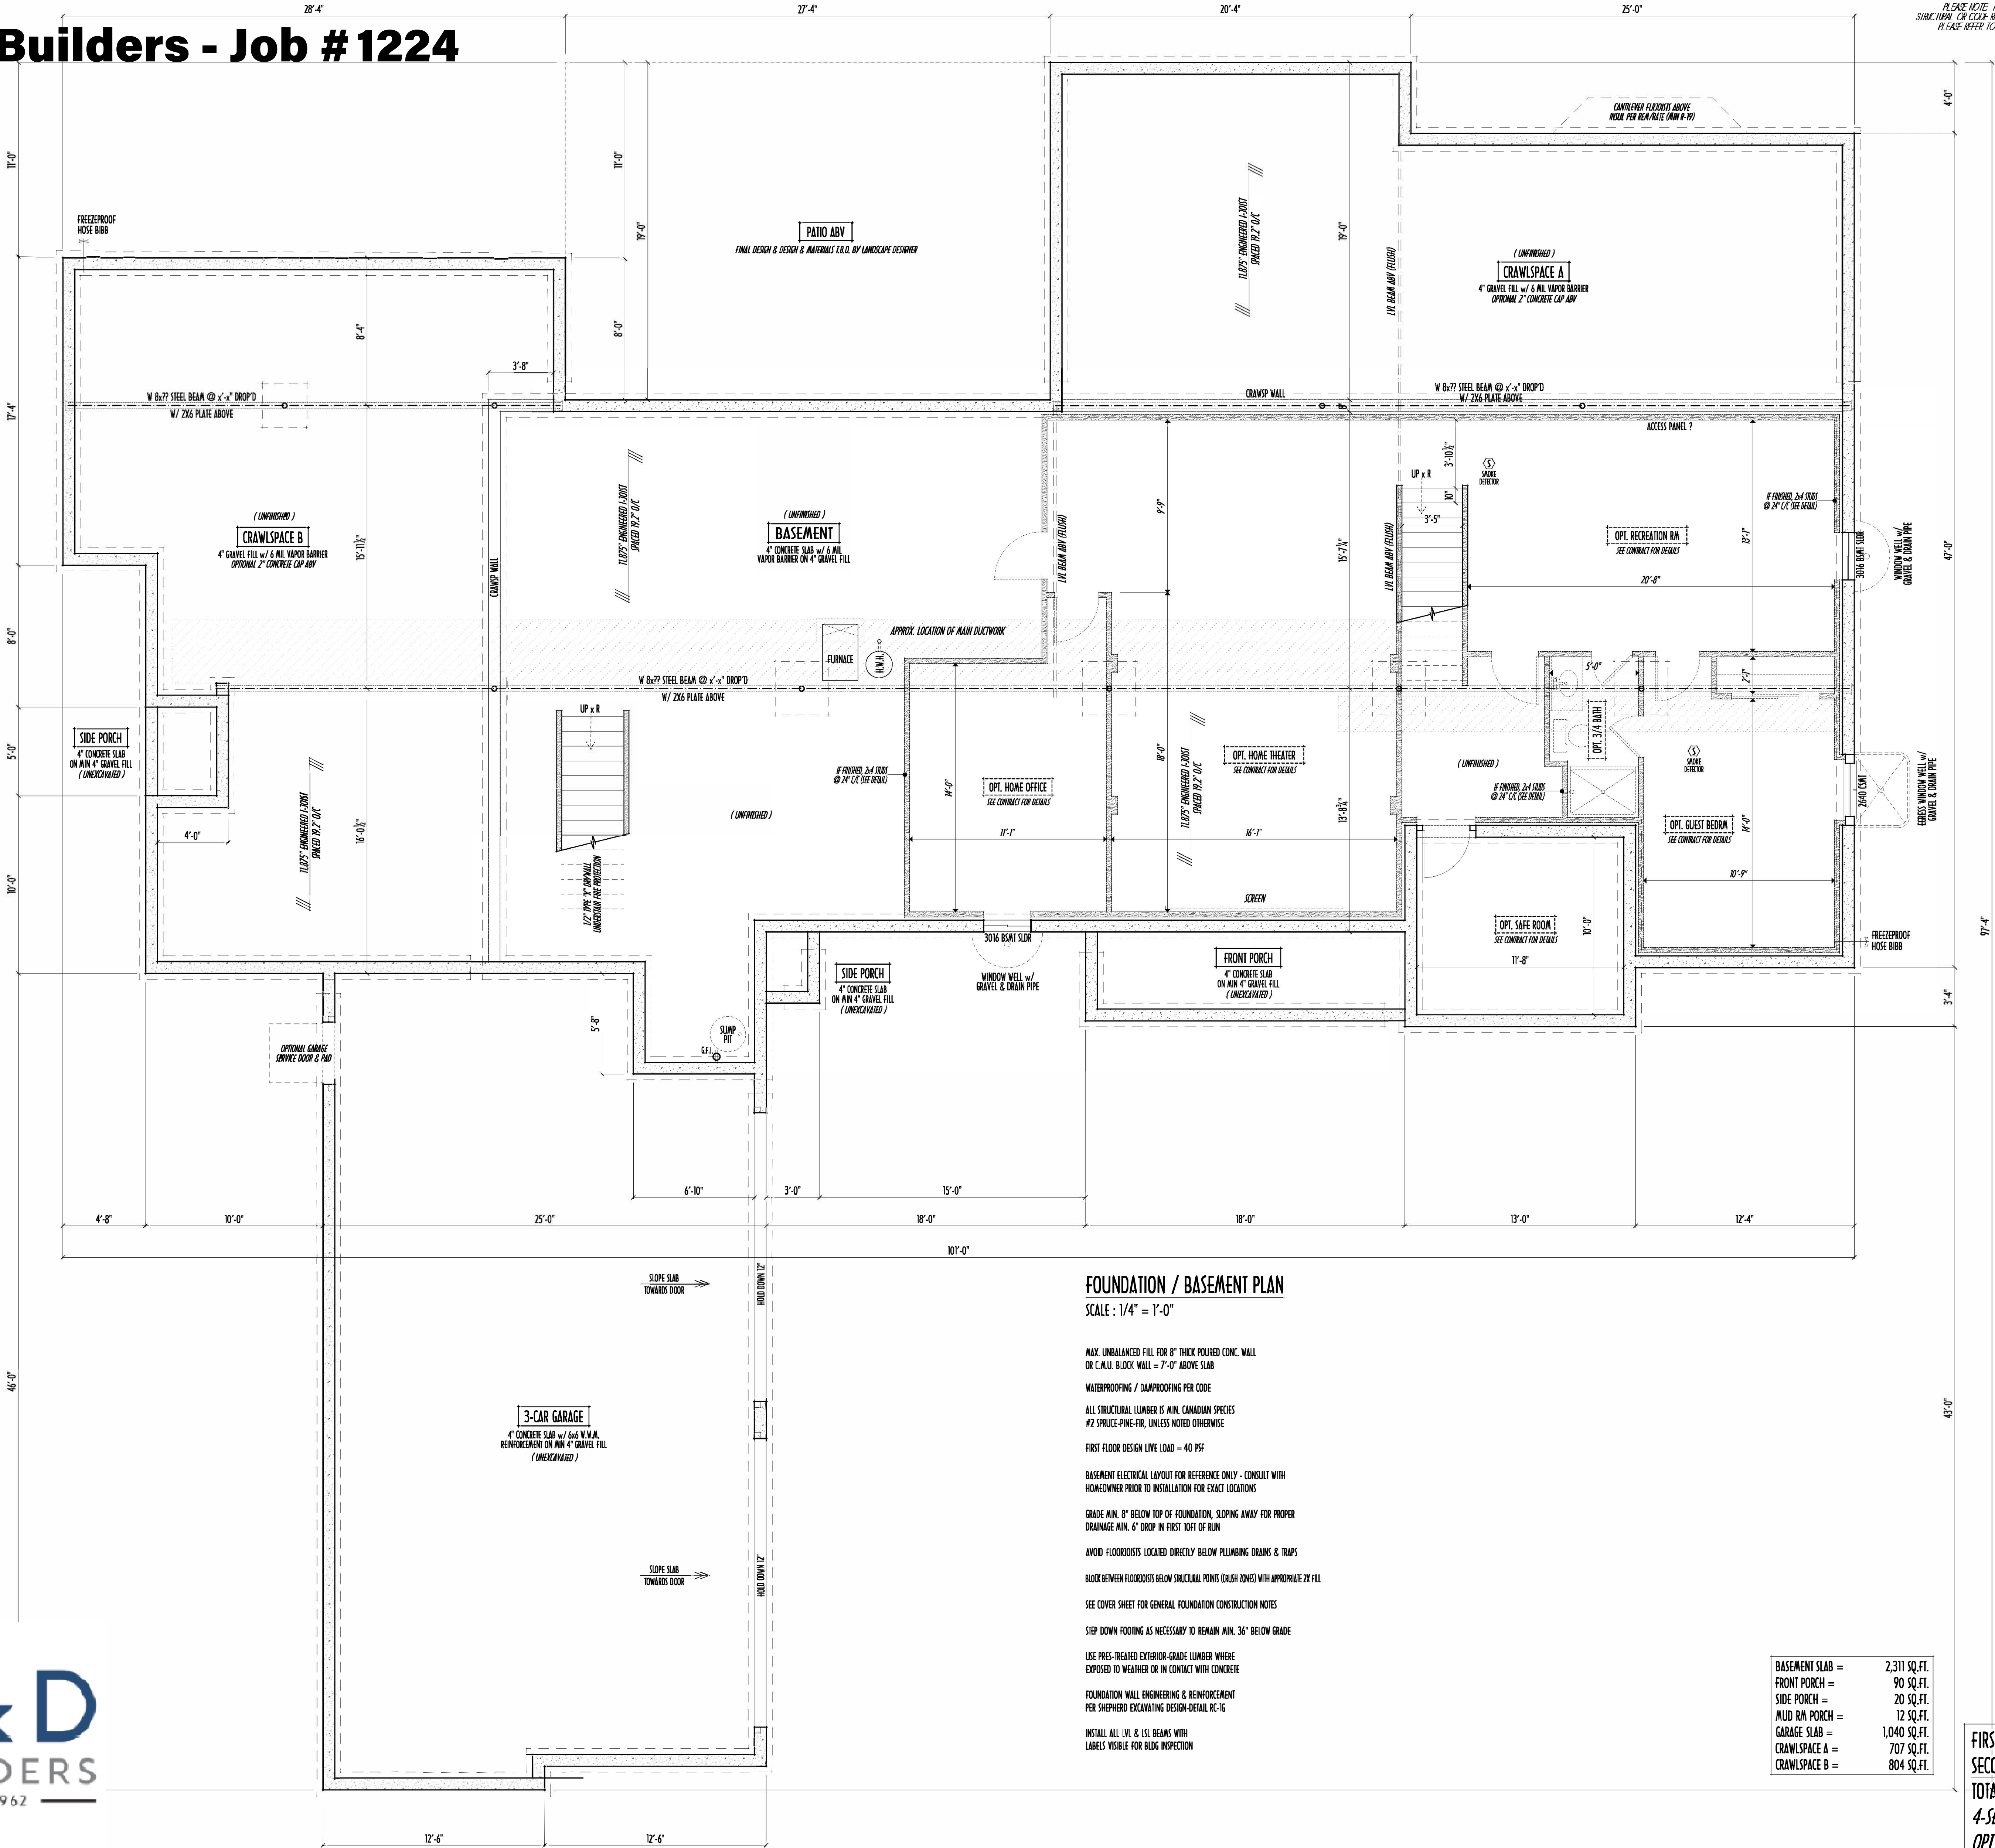

FOUNDATION / BASEMENT PLAN
SCALE : 1/4" = 1'-0"

MAX. UNBALANCED FILL FOR 8" THICK POURED CONC. WALL OR C.M.U. BLOCK WALL = 7'-0" ABOVE SLAB
WATERPROOFING / DAMPROOFING PER CODE
ALL STRUCTURAL LUMBER IS MIN. CANADIAN SPECIES
#2 SPLICED-PINE-FIR, UNLESS NOTED OTHERWISE
FIRST FLOOR DESIGN LIVE LOAD = 40 PSF
BASEMENT ELECTRICAL LAYOUT FOR REFERENCE ONLY - CONSULT WITH HOMEOWNER PRIOR TO INSTALLATION FOR EXACT LOCATIONS
GRADE MIN. 8" BELOW TOP OF FOUNDATION, SLOPING AWAY FOR PROPER DRAINAGE MIN. 6" DROP IN FIRST 10 FT OF RUN
AVOID FLOORJOISTS LOCATED DIRECTLY BELOW PLUMBING DRAINS & TRAPS
BLOCK BETWEEN FLOORJOISTS BELOW STRUCTURAL POINTS (CUSH ZONES) WITH APPROPRIATE 2X FILL
SEE COVER SHEET FOR GENERAL FOUNDATION CONSTRUCTION NOTES
STEP DOWN FOOTING AS NECESSARY TO REMAIN MIN. 36" BELOW GRADE
USE PRES-TREATED EXTERIOR-GRADE LUMBER WHERE EXPOSED TO WEATHER OR IN CONTACT WITH CONCRETE
FOUNDATION WALL ENGINEERING & REINFORCEMENT PER SHEPHERD EXCAVATING DESIGN-DETAIL RC-16
INSTALL ALL LVL & LSL BEAMS WITH LABELS VISIBLE FOR BLDG INSPECTION

BASEMENT SLAB =	2,311 SQ.FT.
FRONT PORCH =	90 SQ.FT.
SIDE PORCH =	20 SQ.FT.
MUD RM PORCH =	12 SQ.FT.
GARAGE SLAB =	1,040 SQ.FT.
CRAWLSPACE A =	707 SQ.FT.
CRAWLSPACE B =	804 SQ.FT.

FIRST FLOOR = 3,860 SQ.FT.
SECOND FLOOR = 655 SQ.FT.
TOTAL = 4,515 SQ.FT.
4-SEASON RM = 278 SQ.FT.
OPT. FIN. BSMT = 1,228 SQ.FT.

Reviewed & Approved

Clients Name
Date
© COPYRIGHT - P & D BUILDERS LTD.
ALL DESIGNS REMAIN THE EXCLUSIVE PROPERTY OF P & D BUILDERS LTD.
DRAWINGS MAY NOT BE REPRODUCED WITHOUT PRIOR PERMISSION

AI	BD	BIA
Building Design	Building Design	Building Design
REVISION DATE:	BY:	DATE
6/3/16	rwd	concept
8/4/16	...	concept rev
8/18/16	...	concept rev
8/22/16	...	concept rev
8/31/16	...	prelims
9/6/16	...	prelims rev
TO-SCALE WHEN PRINTED 24x36" - PAPER SIZE 11"		
FIELD & BAY DIMENSIONS - DO NOT SCALE PRINTS		
DESIGNED:	P&D / rwd	
PAGE :	2 of 8	

FND/BSMT

P&D BUILDERS LTD.
59 Greff Parkway Suite 100
Delaware, Ohio 43015
(740) 201-8079
Fax (740) 201-8084
www.pndbuilders.com

ALL DRAWINGS ARE THE EXCLUSIVE PROPERTY OF P&D BUILDERS LTD.
NO PART MAY BE REPRODUCED OR COPIED IN ANY FORM OR BY ANY MEANS WITHOUT PRIOR WRITTEN PERMISSION OF THE AUTHOR OF THE PLAN.

1224

PRELIMINARY DESIGN
NOT TO SCALE - NOT FOR CONSTRUCTION