

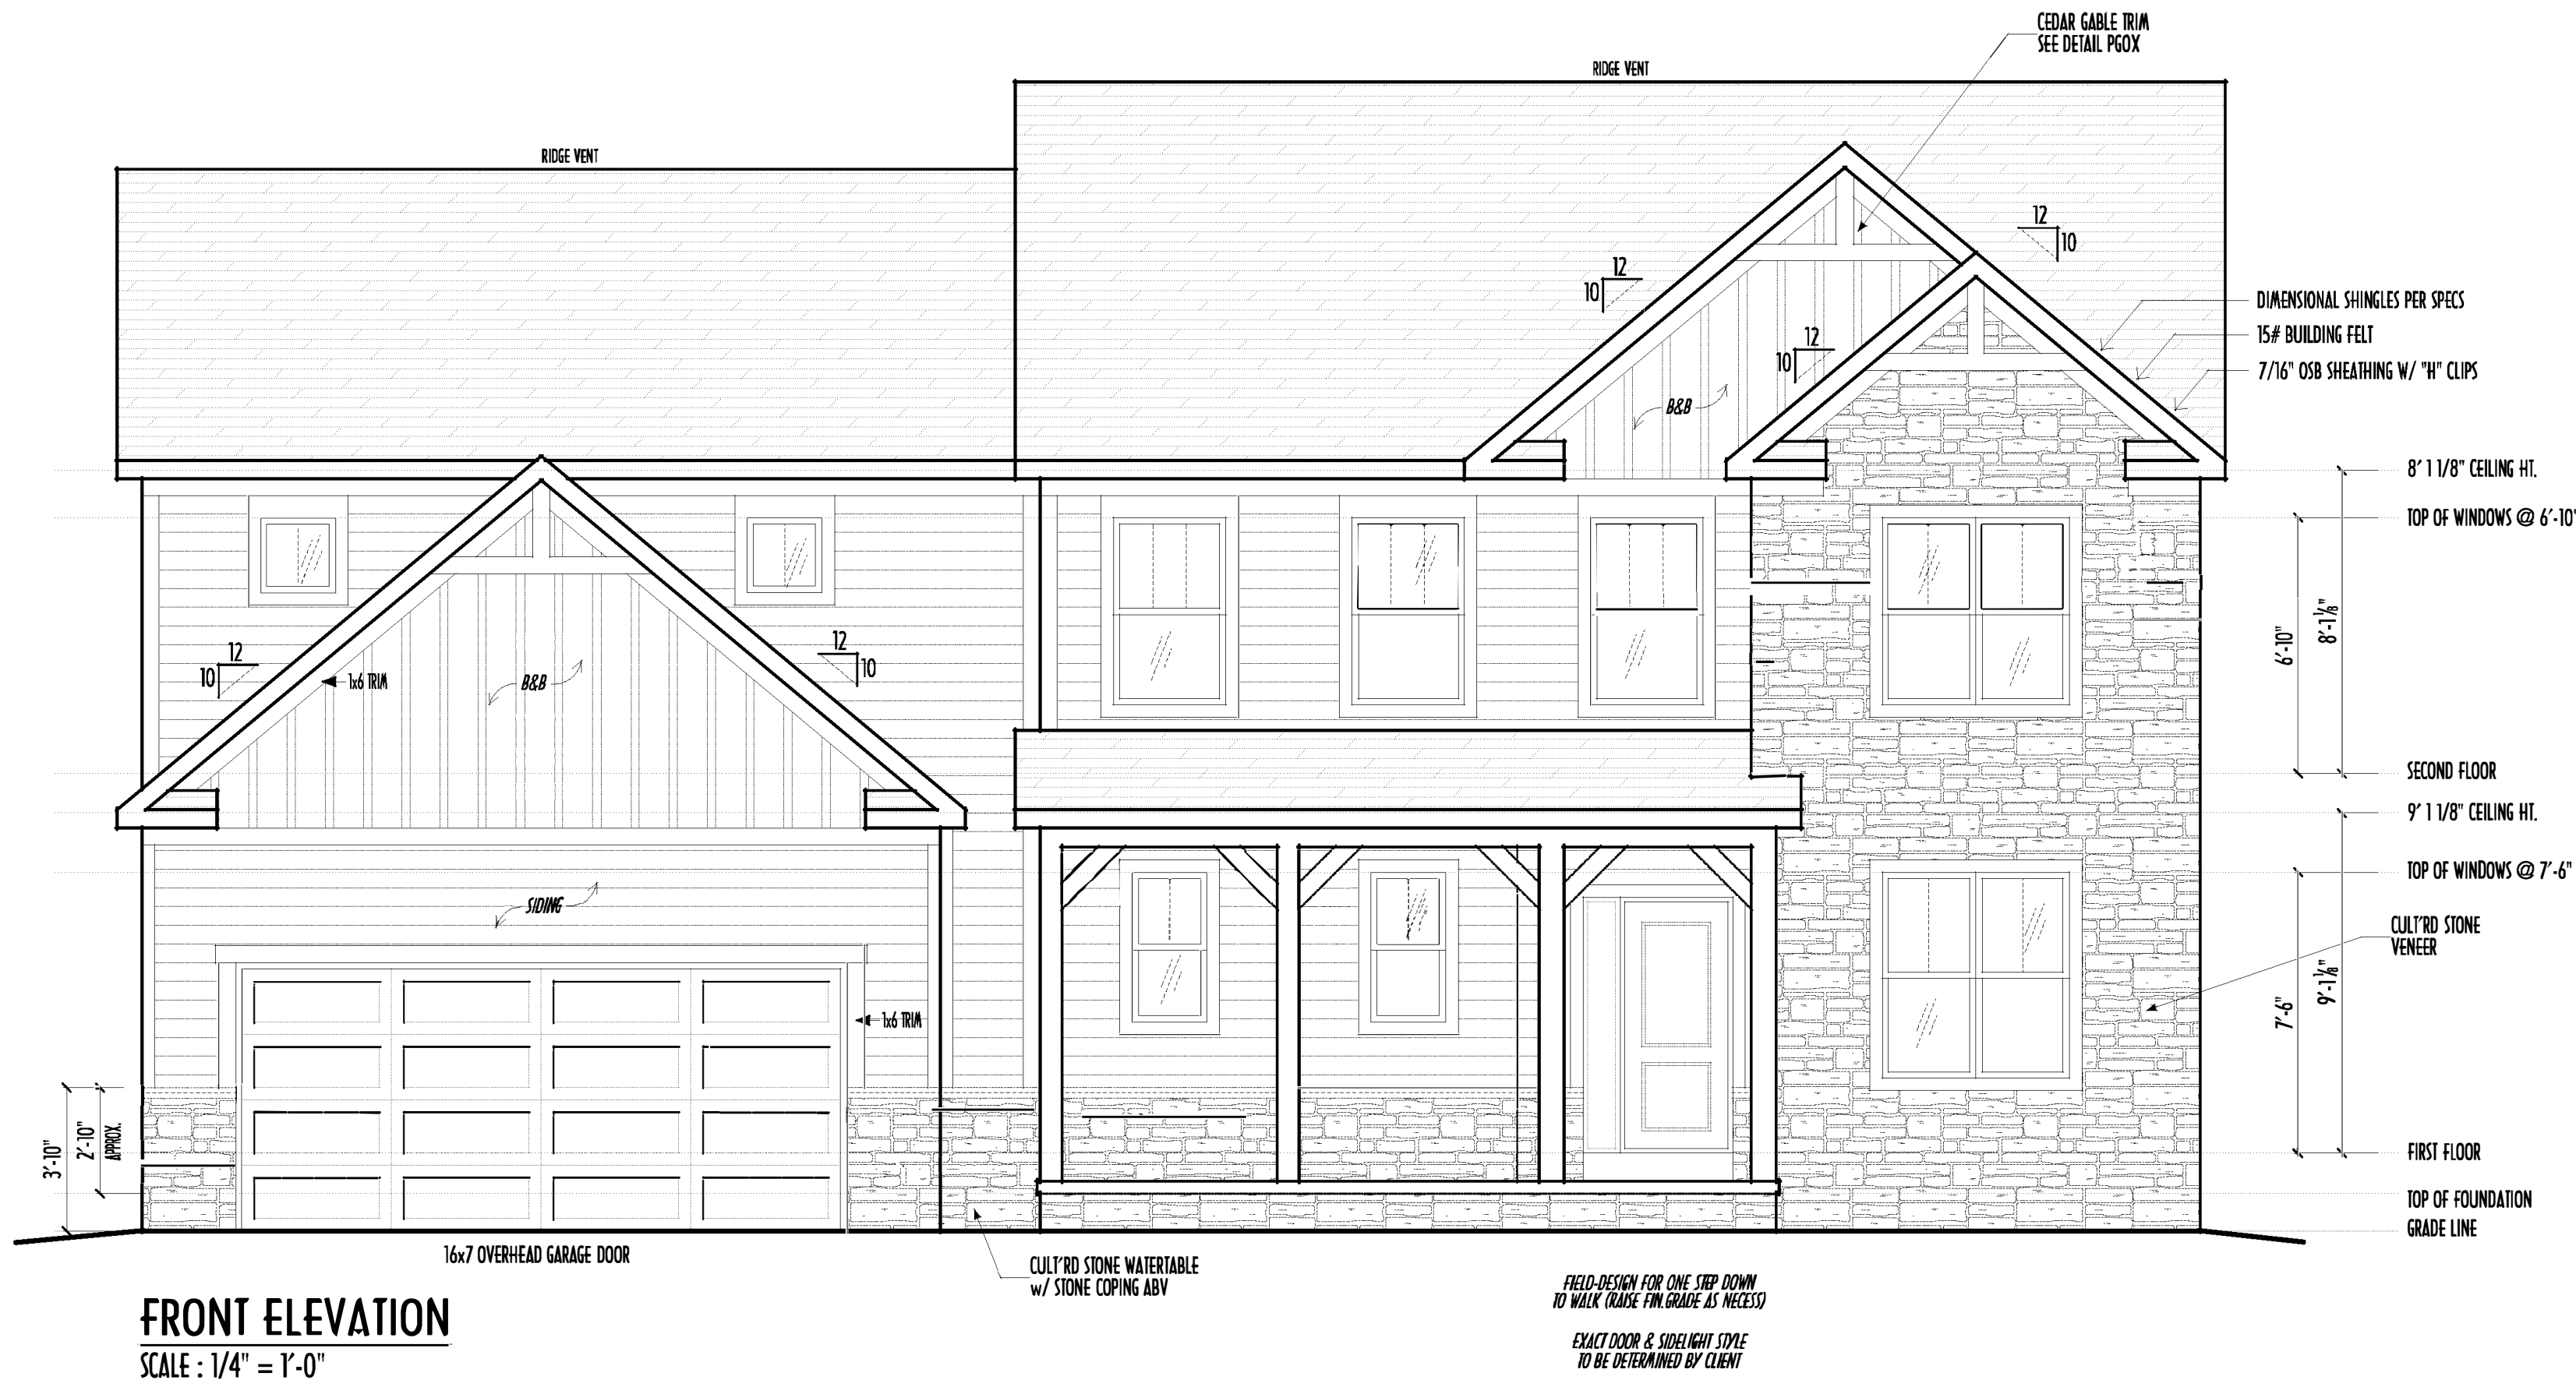


FIRST FLOOR CEILINGS @ 9'-1 1/8" UNLESS NOTED OTHERWISE
FIRST FLOOR WINDOW HEADERS @ 7'-6" UNLESS NOTED OTHERWISE
EMERGENCY EGRESS OPERABLE (E.E.O.) WINDOWS IN ALL BEDROOMS
SEE ROOF PLAN FOR SOFFIT & RAKE SIZES
RUN BRICK VENEER 1" PAST FRAMING CORNERS
CULTURED STONE VENEER WRAPS FRONT CORNERS MIN 6"
INTO 1x6 WOOD TRIM UNLESS NOTED
FLASH & CAULK ELEVATIONS AS NECESSARY TO PROVIDE A
WEATHER-TIGHT SEAL BETWEEN MATERIALS, FRAMING & TRIM
WINDOWS & DOORS (BRAND & DESIGN) PER CONTRACT
WINDOWS & DOORS ARE TO BE INSTALLED PER MANUFACTURERS SPECIFICATIONS
CONFIRM WINDOW SIZES & ROUGH-OPENINGS WITH SUPPLIER
RUN STUCCO, STONE & BRICK VENEER TO GRADE UNLESS NOTED
WEEP SCREEDS FOR STUCCO EXTERIORS SHALL COMPLY WITH R-703.6.2.1
(#26 GALV CORROSION-RESISTANT SCHED ALUMINUM FOUNDATION PLATE (3.5" FLANGED)
PLACED AT MIN 4" AWAY EARTH / 2" AWAY PAVING, ALLOWING TRAP'D WATER TO DRAIN)
SLOPE GRADE AWAY FROM FOUNDATION FOR PROPER DRAINAGE

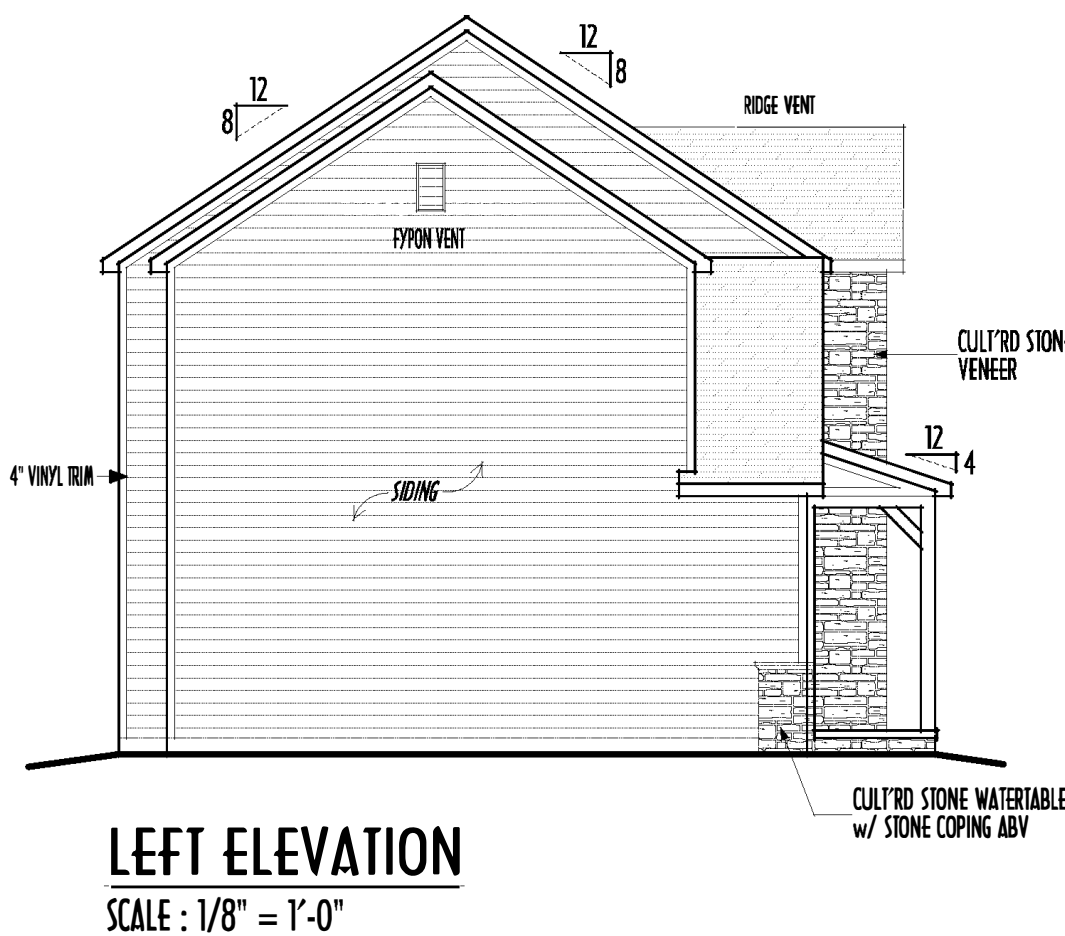


FRONT ELEVATION
SCALE : 1/4" = 1'-0"

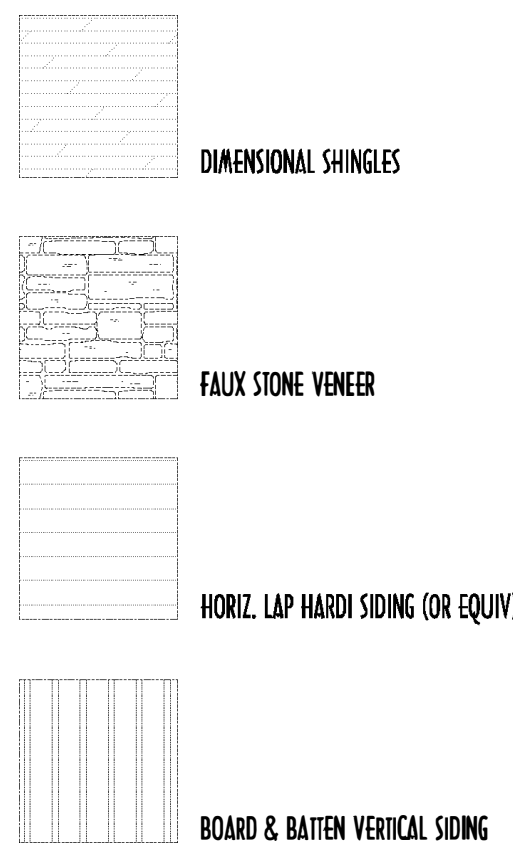


LEFT ELEVATION
SCALE : 1/8" = 1'-0"

FINAL WINDOW DESIGN PER PROVIDER, ALL FRAMING ROUGH-
OPENINGS TO BE BASED ON FINAL LAYOUT ONLY
EXACT WINDOW & DOOR GRID PATTERNS (MULLIONS)
MAY DIFFER - REFER TO MANUFACTURER OR SUPPLIER
GRADE ELEVATION SHOWN IS APPROXIMATE
FIELD VERIFY & ADJUST FOUNDATION AS NECESSARY

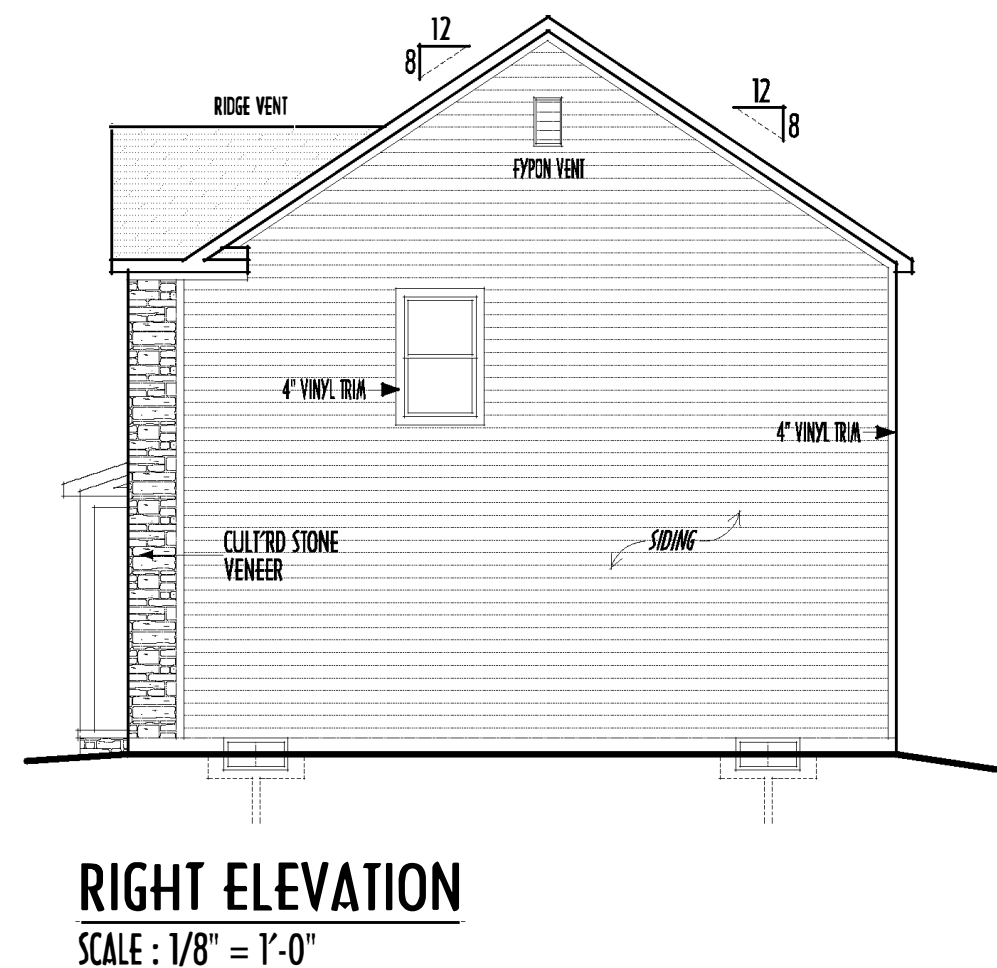

RIGHT ELEVATION
SCALE : 1/8" = 1'-0"

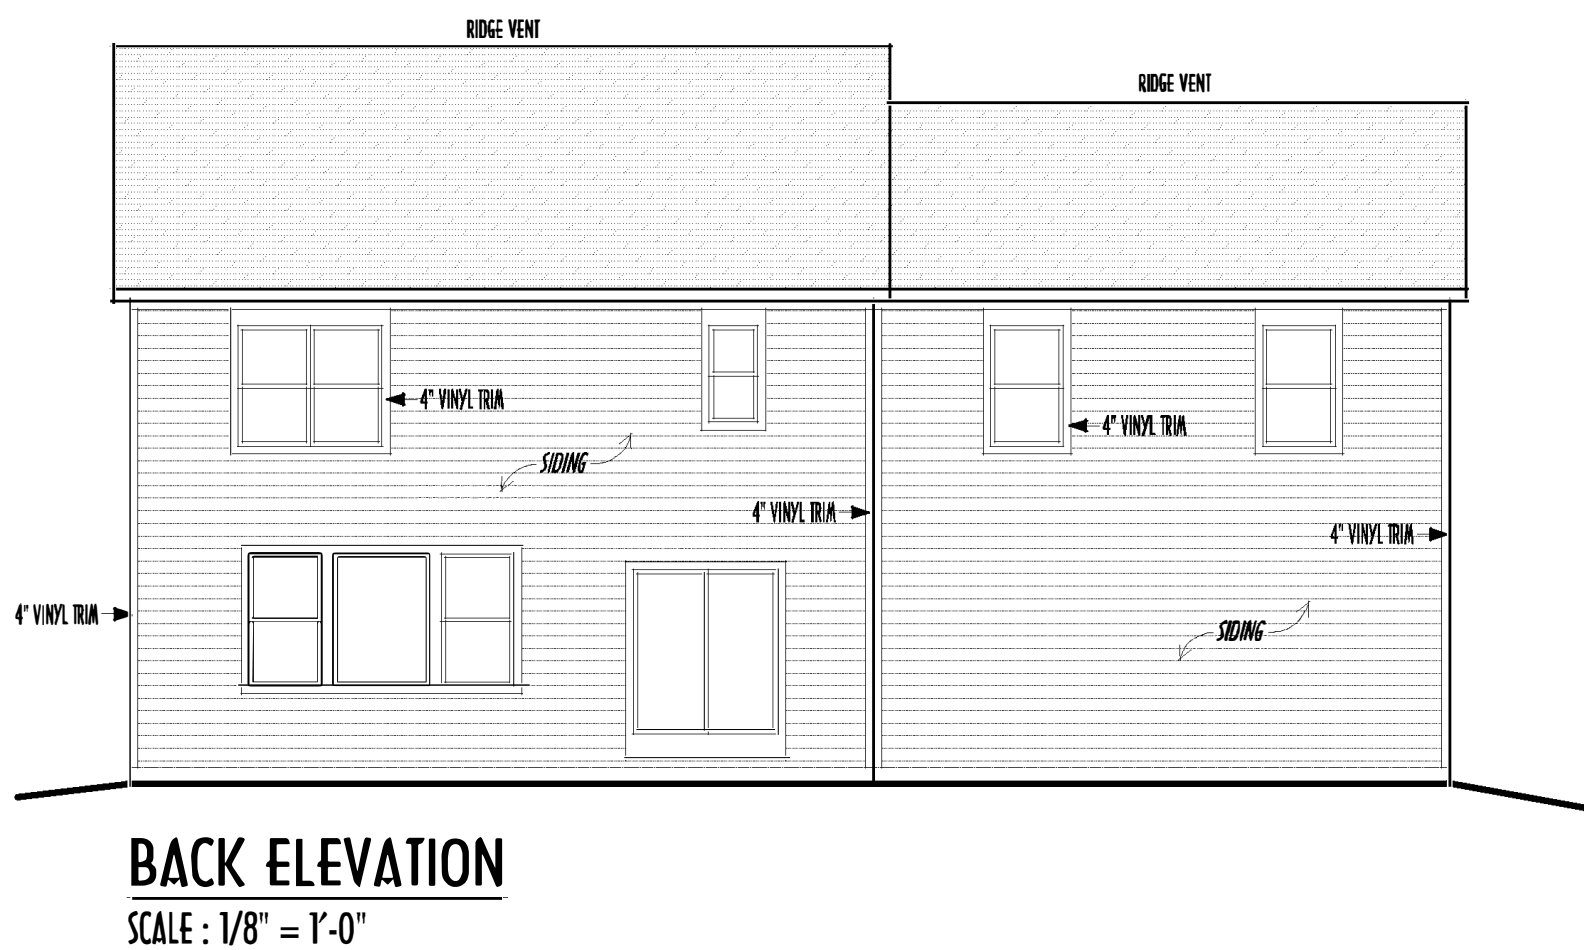

BACK ELEVATION
SCALE : 1/8" = 1'-0"

FIRST FLR LIVING SP =	926 SQ.FT.
SECOND FLR LIVING SP =	1,358 SQ.FT.
TOTAL LIVING SP =	2,284 SQ.FT.
OPT. FINISHED BSMT =	36 SQ.FT.

ELEVATIONS




P&D Builders Ltd.
59 Greif Parkway Suite 100
Delaware, Ohio 43015
(740) 201-8079
Fax (740) 201-8084
www.pndbuilders.com

ALL DRAWINGS ARE THE PROPERTY OF P&D BUILDERS LTD.
NO PERMISSION OR OTHER USE OF THESE DRAWINGS MAY BE MADE
WITHOUT THE WRITTEN CONSENT OF THE ARCHITECT OF THE FIRM.


1419

1/16/2020 9:27 AM

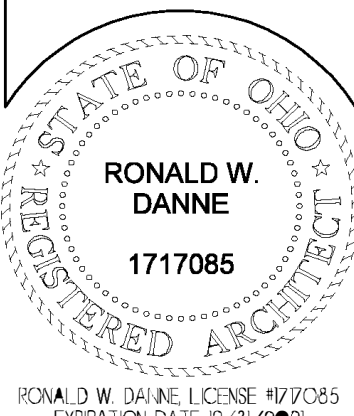

Danne
Residential Design & Drafting, Inc.
614.207.6266 danne@danne.com

REVISION DATE:	BY:	PROJECT
12/21/19	rwd	concepts
12/23/19	" "	prelims
1/15/20	" "	pre-eng

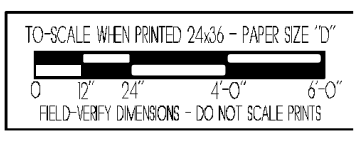

DESIGNED BY: P&D / rwd

PAGE : 5 of 9



P&D Builders Ltd.
59 Greif Parkway Suite
Suite 100
Delaware, Ohio 43015
(740) 201-8079
Fax (740) 201-8084
www.pndbuilders.com

ALL DIMENSIONS ARE THE EXACT NUMBER OF FEET AND INCHES TO THE
AND PERMANENT OR OTHER USE OF THESE PLANS MAY BE MADE
WITHOUT WRITTEN CONSENT OF THE ARCHITECT OF THE PLANS.

DATE: 12/21/2019

1419

1419


1419

1419

1419

1419

FIRST FLOOR CEILINGS AT 9'-1 1/8" UNLESS NOTED OTHERWISE
FIRST FLOOR WINDOWS HEADERS AT 7'-6" UNLESS NOTED OTHERWISE
CONTRACTORS TO SITE VERIFY ALL DIMENSIONS AND REPORT ANY
DISCREPANCIES WITH THE PLANS TO THE JOB SUPERVISOR ASAP
FIRST FLOOR DESIGN LIVE LOAD = 40 PSF
ALL FRAMING AND STRUCTURAL CONSTRUCTION IS TO
CONFORM TO 2015 I.R.C.O. AND/OR APPLICABLE LOCAL CODES
WINDOWS & DOORS (BRAND & DESIGN) PER CONTRACT
CONFIRM WINDOW ROUGH-OPENINGS AND HEADER HGT'S W/ PROVIDER
CONFIRM FLOORING & FINISH MATERIALS W/ JOB SUPERVISOR (PER CONTRACT)
ALL DIMENSIONS CORRESPOND TO EITHER CENTERLINES OR
CORNERS OF WOOD FRAMING LENGTHS AND/OR PENETRATION
AVOID FLOORJOISTS LOCATED DIRECTLY BELOW PLUMBING DRAINS
BLOCK BETWEEN FLOORJOISTS BELOW STRUCTURAL POINTS (CRUSH ZONES)
BRACE FLOORJOISTS AT MIDSPAN PER CODE
INTERIOR DOORS SHOWN 4" OFF CORNERS UNLESS NOTED
NOTE: DIMENSIONS FOR ANGLED WALLS MAY CONTAIN
ROUNDING ERRORS OF LESS THAN 1/8" TYPICALLY
FINAL/INSTALLED INSULATION VALUES SHOULD MATCH
REX-DATE SHEETS FROM TACOMA ENERGY (THOSE SHOWN
ON THESE PLANS ARE PRELIMINARY/REFERENCE ONLY)
INSTALL ALL LVL & LSL BEAMS WITH
LABELS VISIBLE FOR BLDG INSPECTION

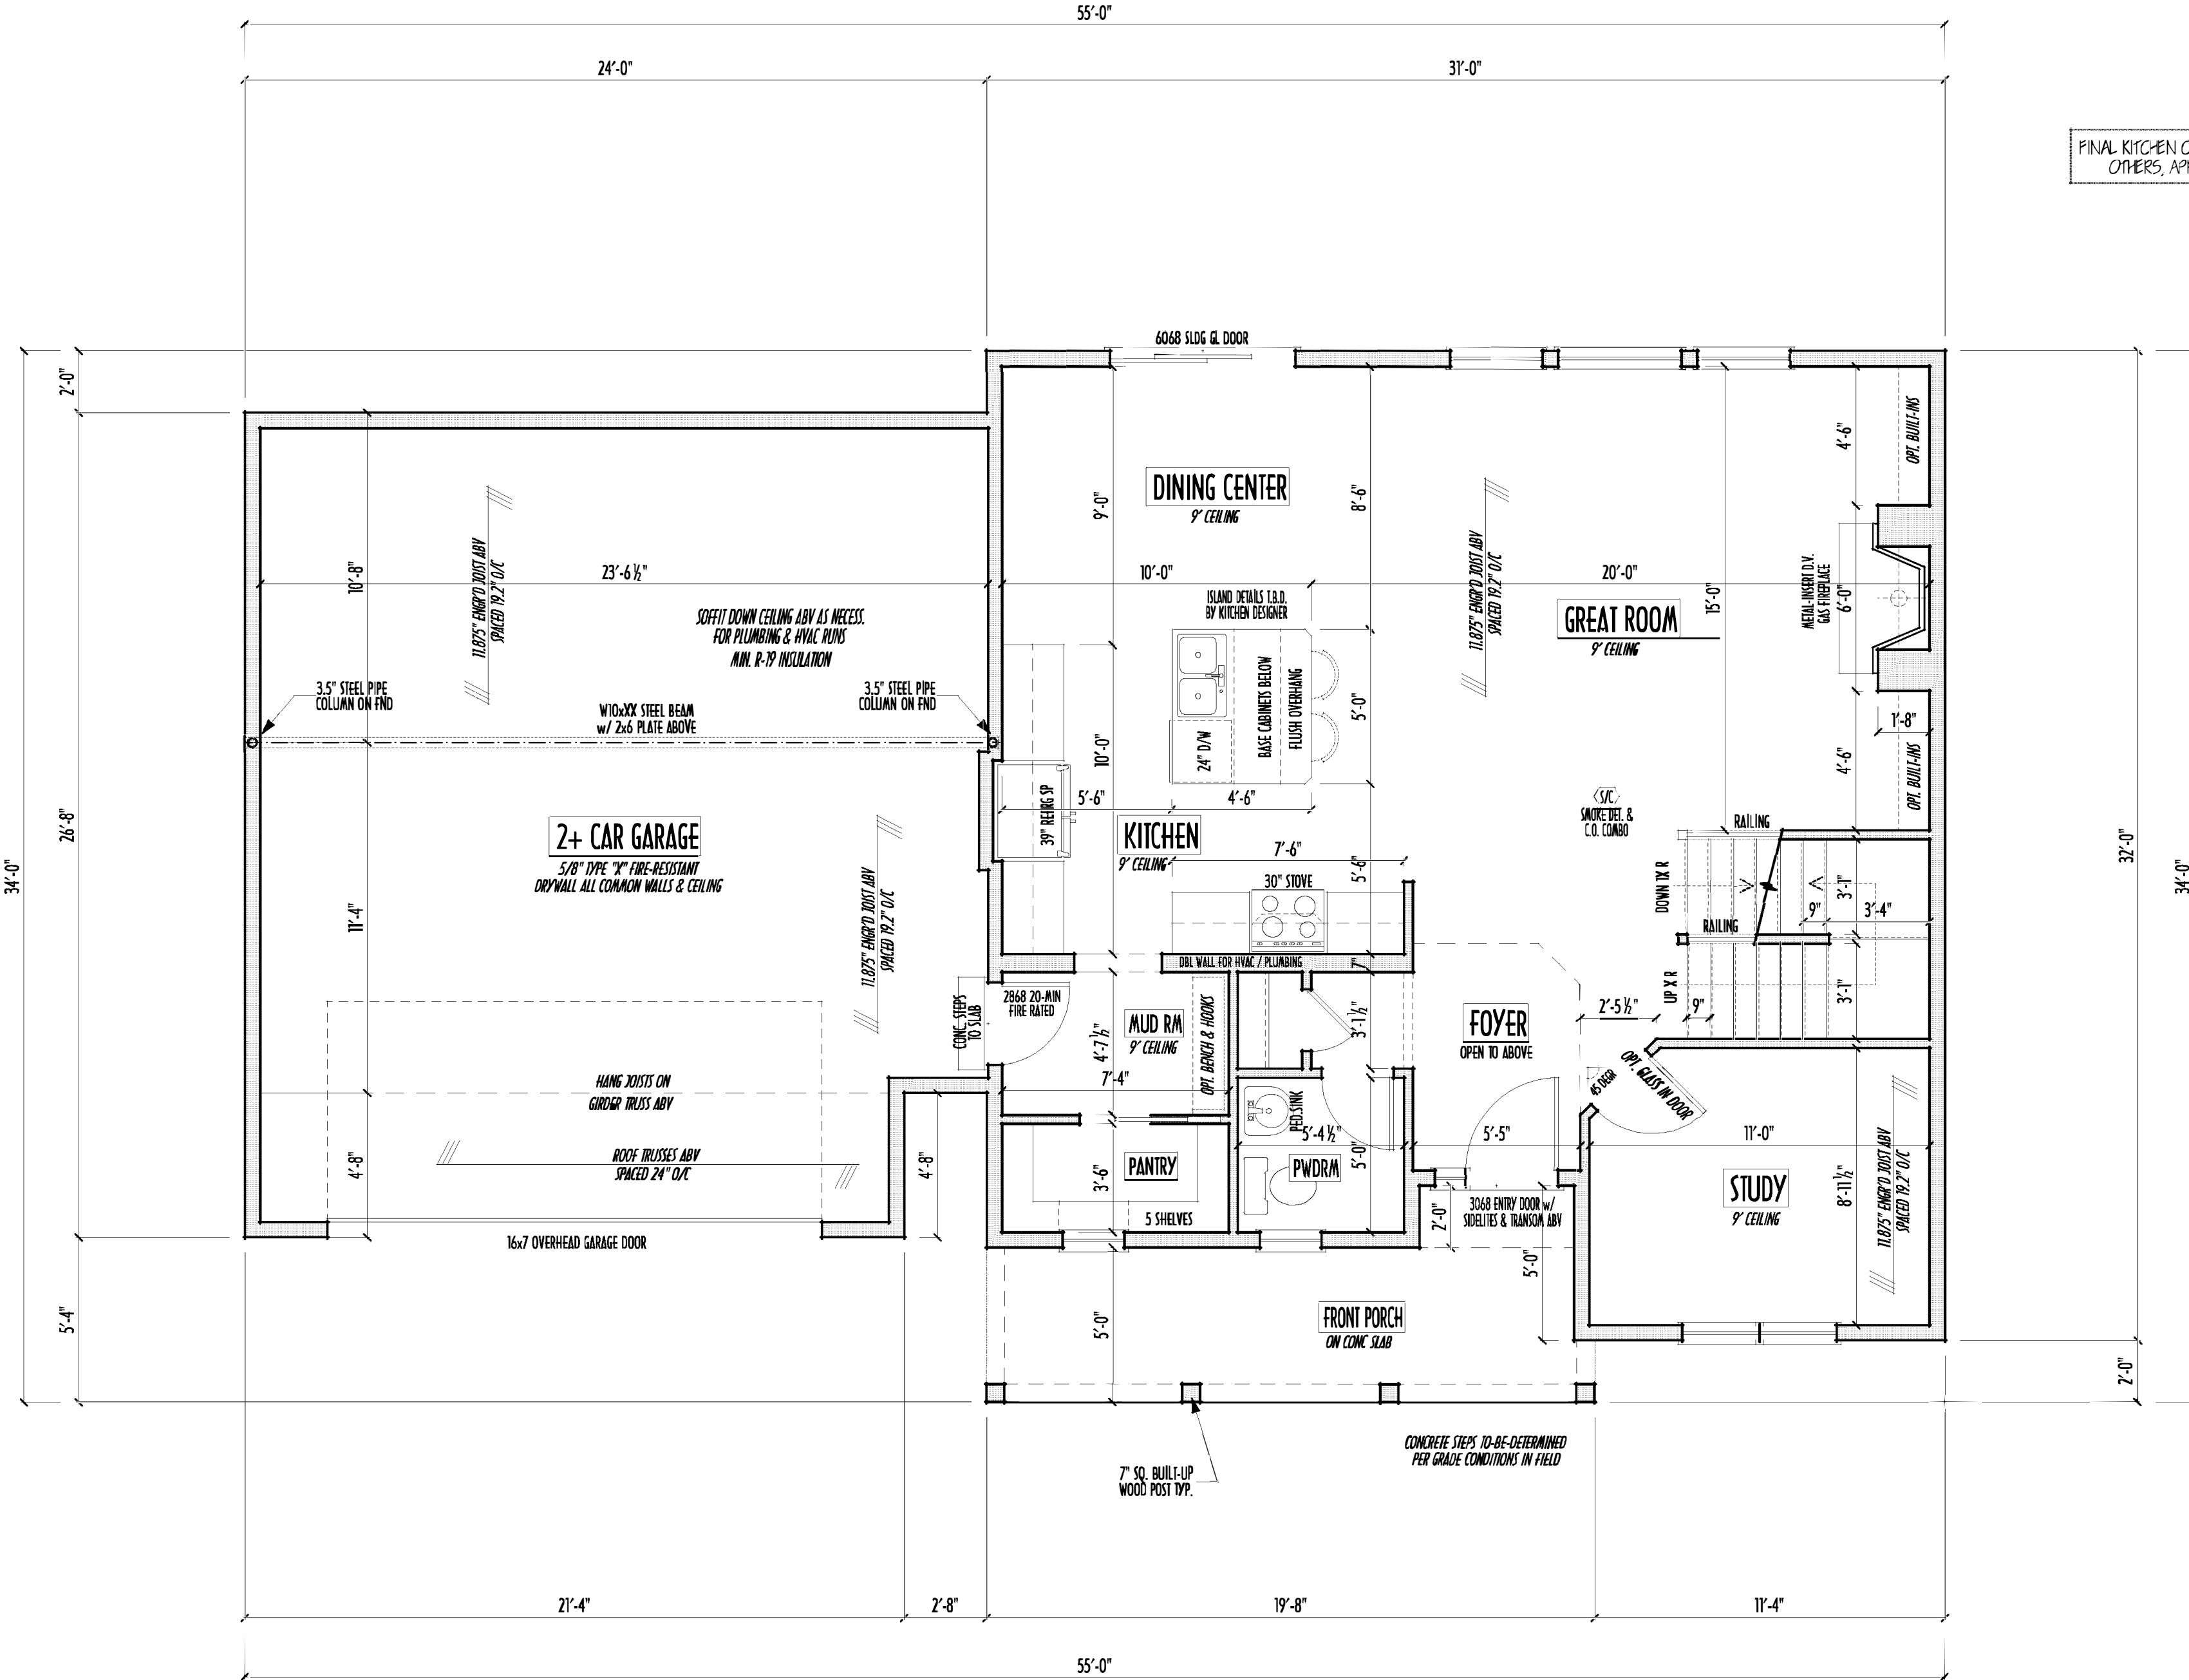


FIRST FLOOR PLAN
SCALE : 1/4" = 1'-0"

FINAL KITCHEN CABINET & APPLIANCE LAYOUT BY
OTHERS, APPLIANCES PER SERIES SPECS

FIRST FLR LIVING SP =	926 SQ.FT.
SECOND FLR LIVING SP =	1,358 SQ.FT.
TOTAL LIVING SP =	2,284 SQ.FT.
OPT. FINISHED BSMT =	36 SQ.FT.

SECOND FLOOR CEILINGS AT 8'-1 1/8" ROUGH UNLESS NOTED
SECOND FLOOR WINDOWS HEADERS AT 6'-10" UNLESS NOTED
EXTERIOR WALLS ARE SHOWN 6" WIDE (2x6 STUDS @ 16" O/C UNLESS NOTED)
INTERIOR WALLS ARE SHOWN 3.5" WIDE (2x4 STUDS @ 16" O/C UNLESS NOTED)
SECOND FLOOR DESIGN LIVE LOAD = 40 PSF (BEDRMS 30 PSF)
WINDOWS & DOORS (BRAND & DESIGN) PER CONTRACT
INTERIOR DOORS SHOWN 4" OFF CORNERS UNLESS NOTED
IN SLEEPING ROOMS, AT LEAST ONE WINDOW MUST MEET EMERGENCY EGRESS
REQUIREMENTS (MIN. 20" WIDE X 24" TALL & 5.7 SQ.FT.) PER R.C.O. 310
CONFIRM WINDOW ROUGH-OPENINGS WITH MANUFACTURER
AND ADJUST FRAMING DIMENSIONS AS NECESSARY
NOTE: DIMENSIONS FOR ANGLED WALLS MAY CONTAIN
ROUNDING ERRORS OF LESS THAN 1/8" TYPICALLY
FINAL/INSTALLED INSULATION VALUES SHOULD MATCH
REIN-RATE SHEETS FROM TACOMA ENERGY (THOSE SHOWN
ON THESE PLANS ARE PRELIMINARY/REFERENCE ONLY)
INSTALL ALL LVL & LSL BEAMS WITH
LABELS VISIBLE FOR BUG INSPECTION
FOAM PLASTIC/INSULATION SHALL BE INSTALLED PER RCO 314 & 315
<75 PSR, <450 SDR PER ASTM E94

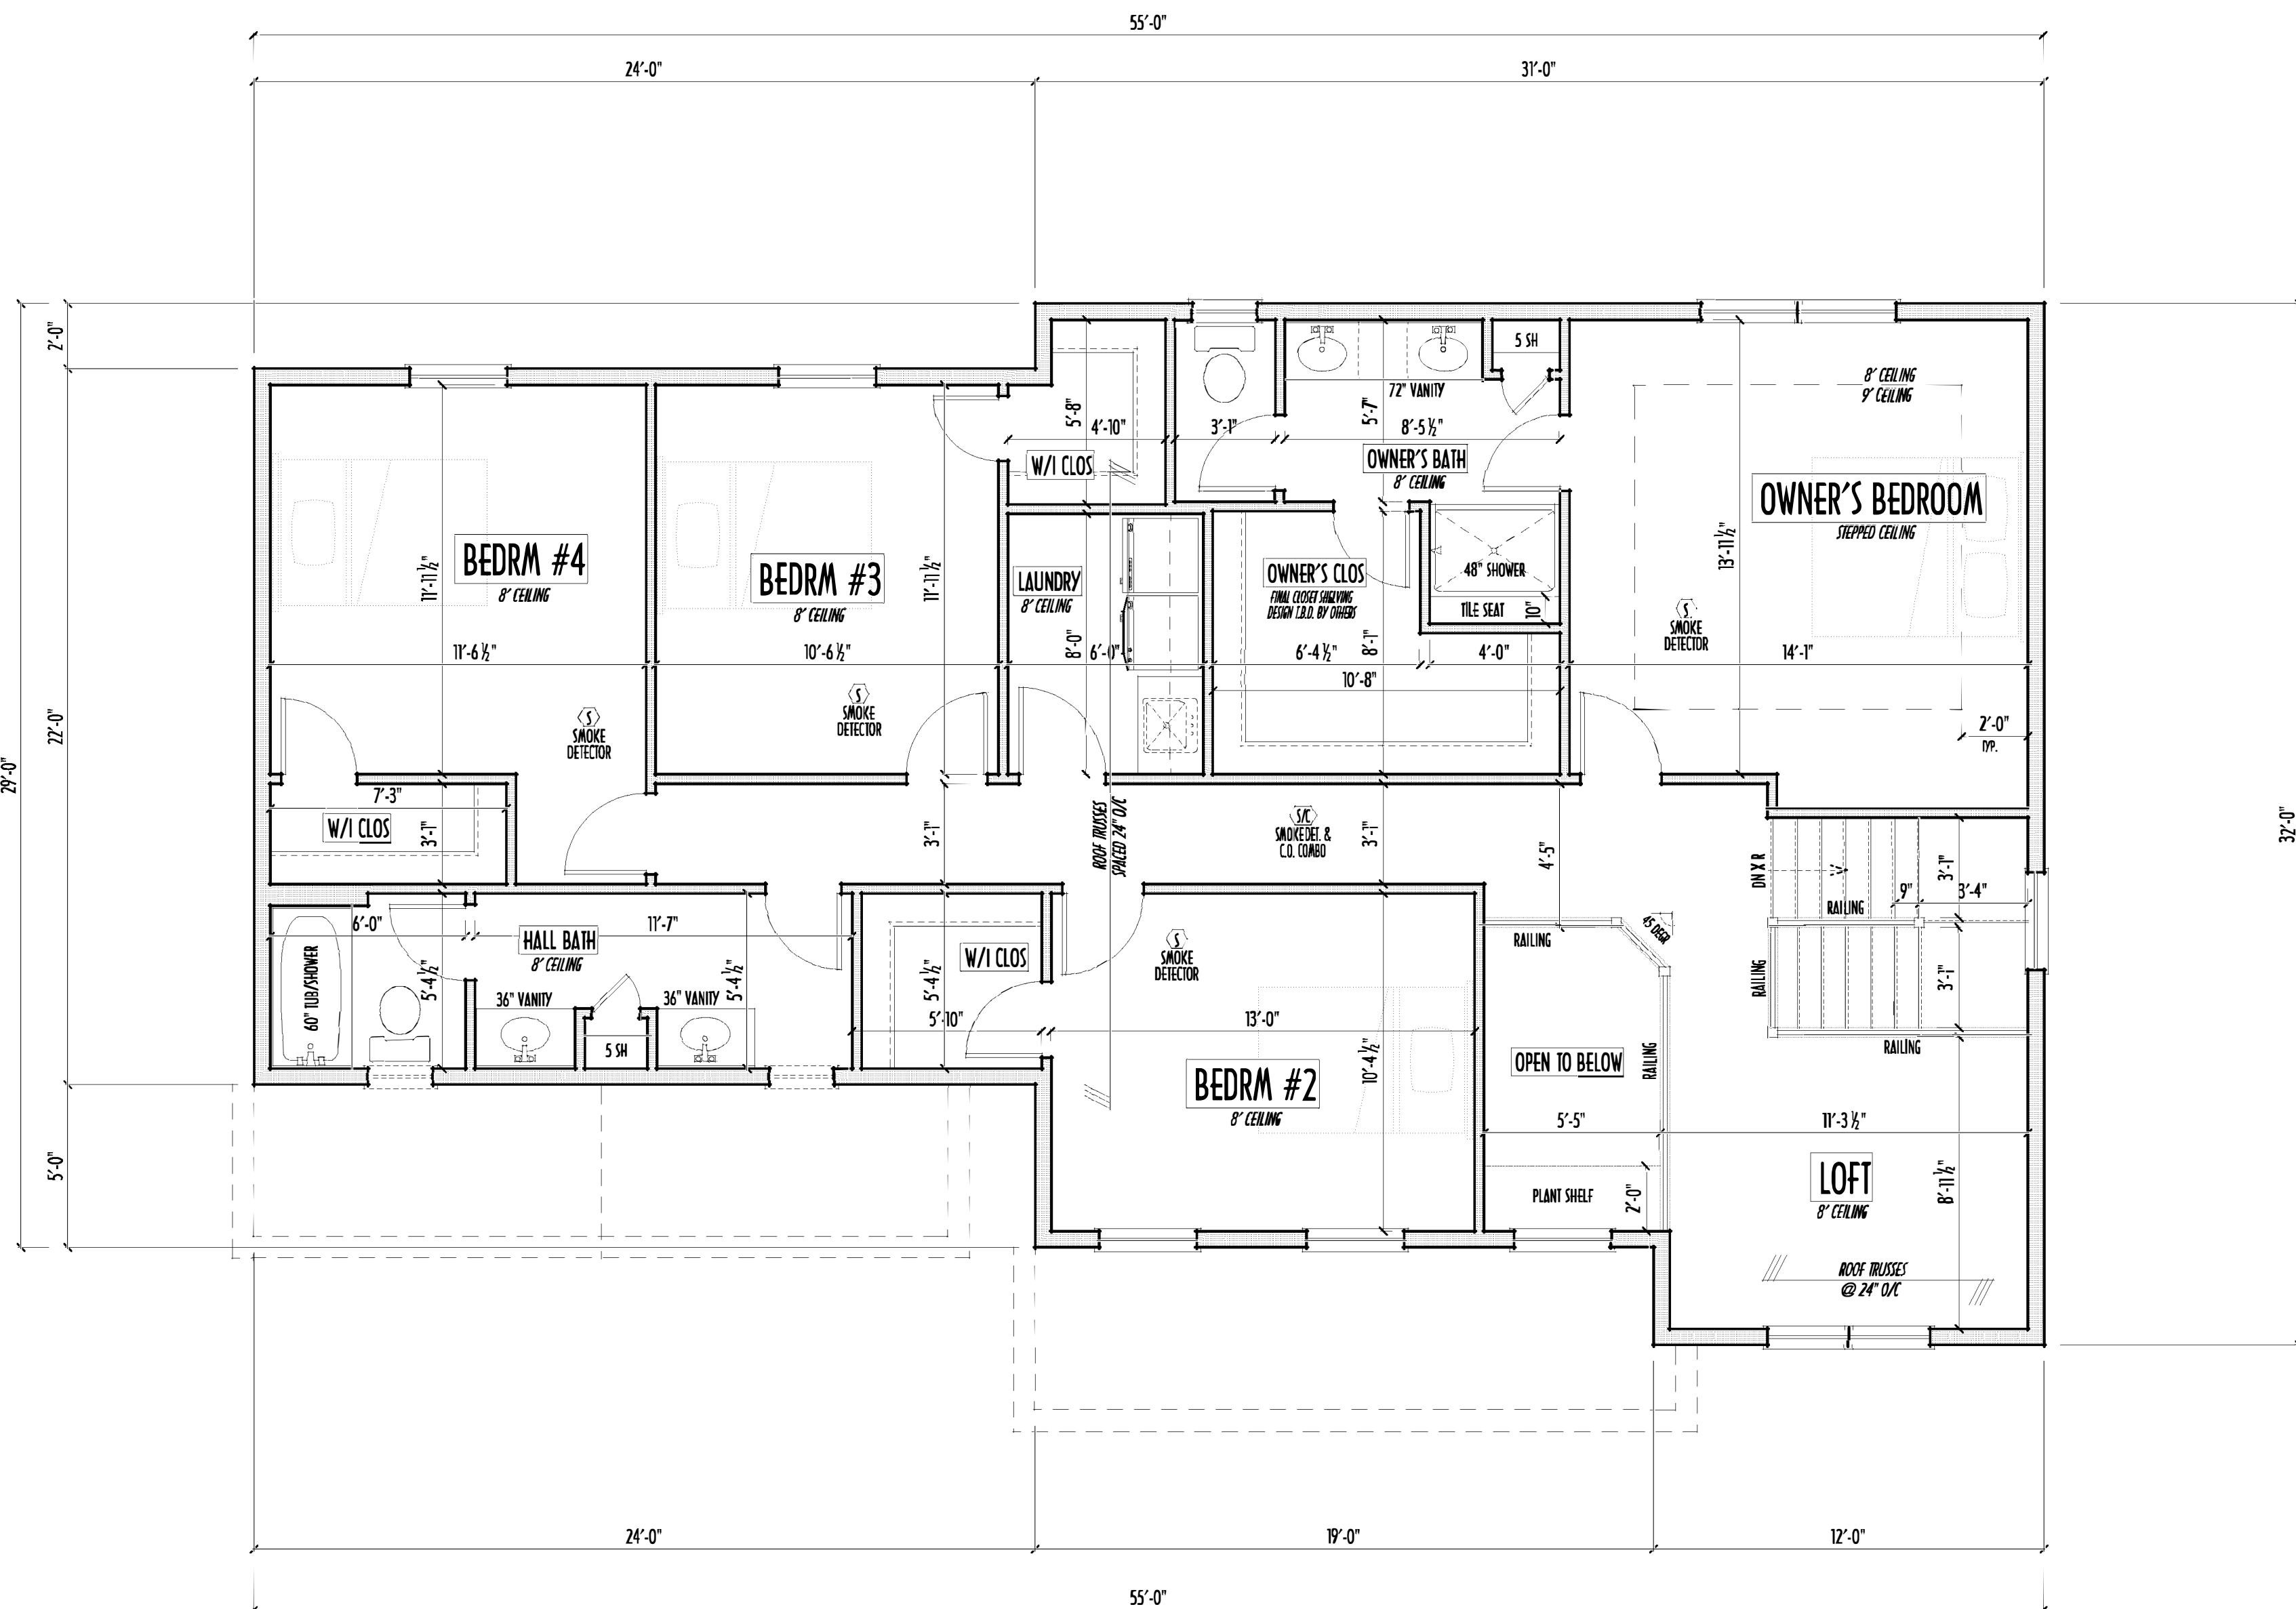

SECOND FLOOR PLAN
SCALE: 1/4" = 1'-0"

FIRST FLR LIVING SP =	926 SQ.FT.
SECOND FLR LIVING SP =	1,358 SQ.FT.
TOTAL LIVING SP =	2,284 SQ.FT.
OPT. FINISHED BSMT =	36 SQ.FT.

2ND FLR

P&D Builders Ltd.
59 Greff Parkway Suite
Suite 100
Delaware, Ohio 43015
(740) 201-8079
Fax (740) 201-8084
www.pndbuilders.com

1419

STATE OF OHIO
REGISTERED ARCHITECT
RONALD W. DANNE
17117085
RONALD W. DANNE LICENSE #1270285
EXPIRATION DATE 12/31/2021

Danne
Residential Design & Drafting, Inc.
614.207.6766 danne@danne.com

REVISION DATE:	BY:	PROJ. NO.
12/21/19	rwd	concepts
12/23/19	" "	prelims
1/15/20	" "	pre-eng


TO SCALE WHEN PRINTED 24x36 - PAPER SIZE 11"
0 12 24 36 48 60
FIELD VERIFY DIMENSIONS - DO NOT SCALE NOTES

DESIGNED: P&D / rwd

PAGE: 4 of 9

1/16/2020 9:27 AM

- MAX. UNBALANCED FILL FOR 8" THICK POURED CONC. WALL OR C.M.U. BLOCK WALL = 7'-0" ABOVE SLAB
- WATERPROOFING / DAMPROOFING PER CODE
- ALL STRUCTURAL LUMBER IS MIN. CANADIAN SPECIES #2 SPRUCE-PINE-FIR, UNLESS NOTED OTHERWISE
- FIRST FLOOR DESIGN LIVE LOAD = 40 PSF
- BASEMENT ELECTRICAL LAYOUT FOR REFERENCE ONLY - CONSULT WITH HOMEOWNER PRIOR TO INSTALLATION FOR EXACT LOCATIONS
- GRADE MIN. 8" BELOW TOP OF FOUNDATION, SLOPING AWAY FOR PROPER DRAINAGE MIN. 6" DROP IN FIRST 10FT OF RUN
- AVOID FLOORJOISTS LOCATED DIRECTLY BELOW PLUMBING DRAINS & TRAPS
- BLOCK BETWEEN FLOORJOISTS BELOW STRUCTURAL POINTS (CRUSH ZONES) WITH APPROPRIATE 2X FILL
- SEE COVER SHEET FOR GENERAL FOUNDATION CONSTRUCTION NOTES
- STEP DOWN FOOTING AS NECESSARY TO REMAIN MIN. 36" BELOW GRADE
- USE PRES-TREATED EXTERIOR-GRADE LUMBER WHERE EXPOSED TO WEATHER OR IN CONTACT WITH CONCRETE
- FOUNDATION WALL ENGINEERING & REINFORCEMENT PER SHEPHERD EXCAVATING DESIGN-DETAIL DC-16
- INSTALL ALL LVL & LSL BEAMS WITH LABELS VISIBLE FOR BLDG INSPECTION

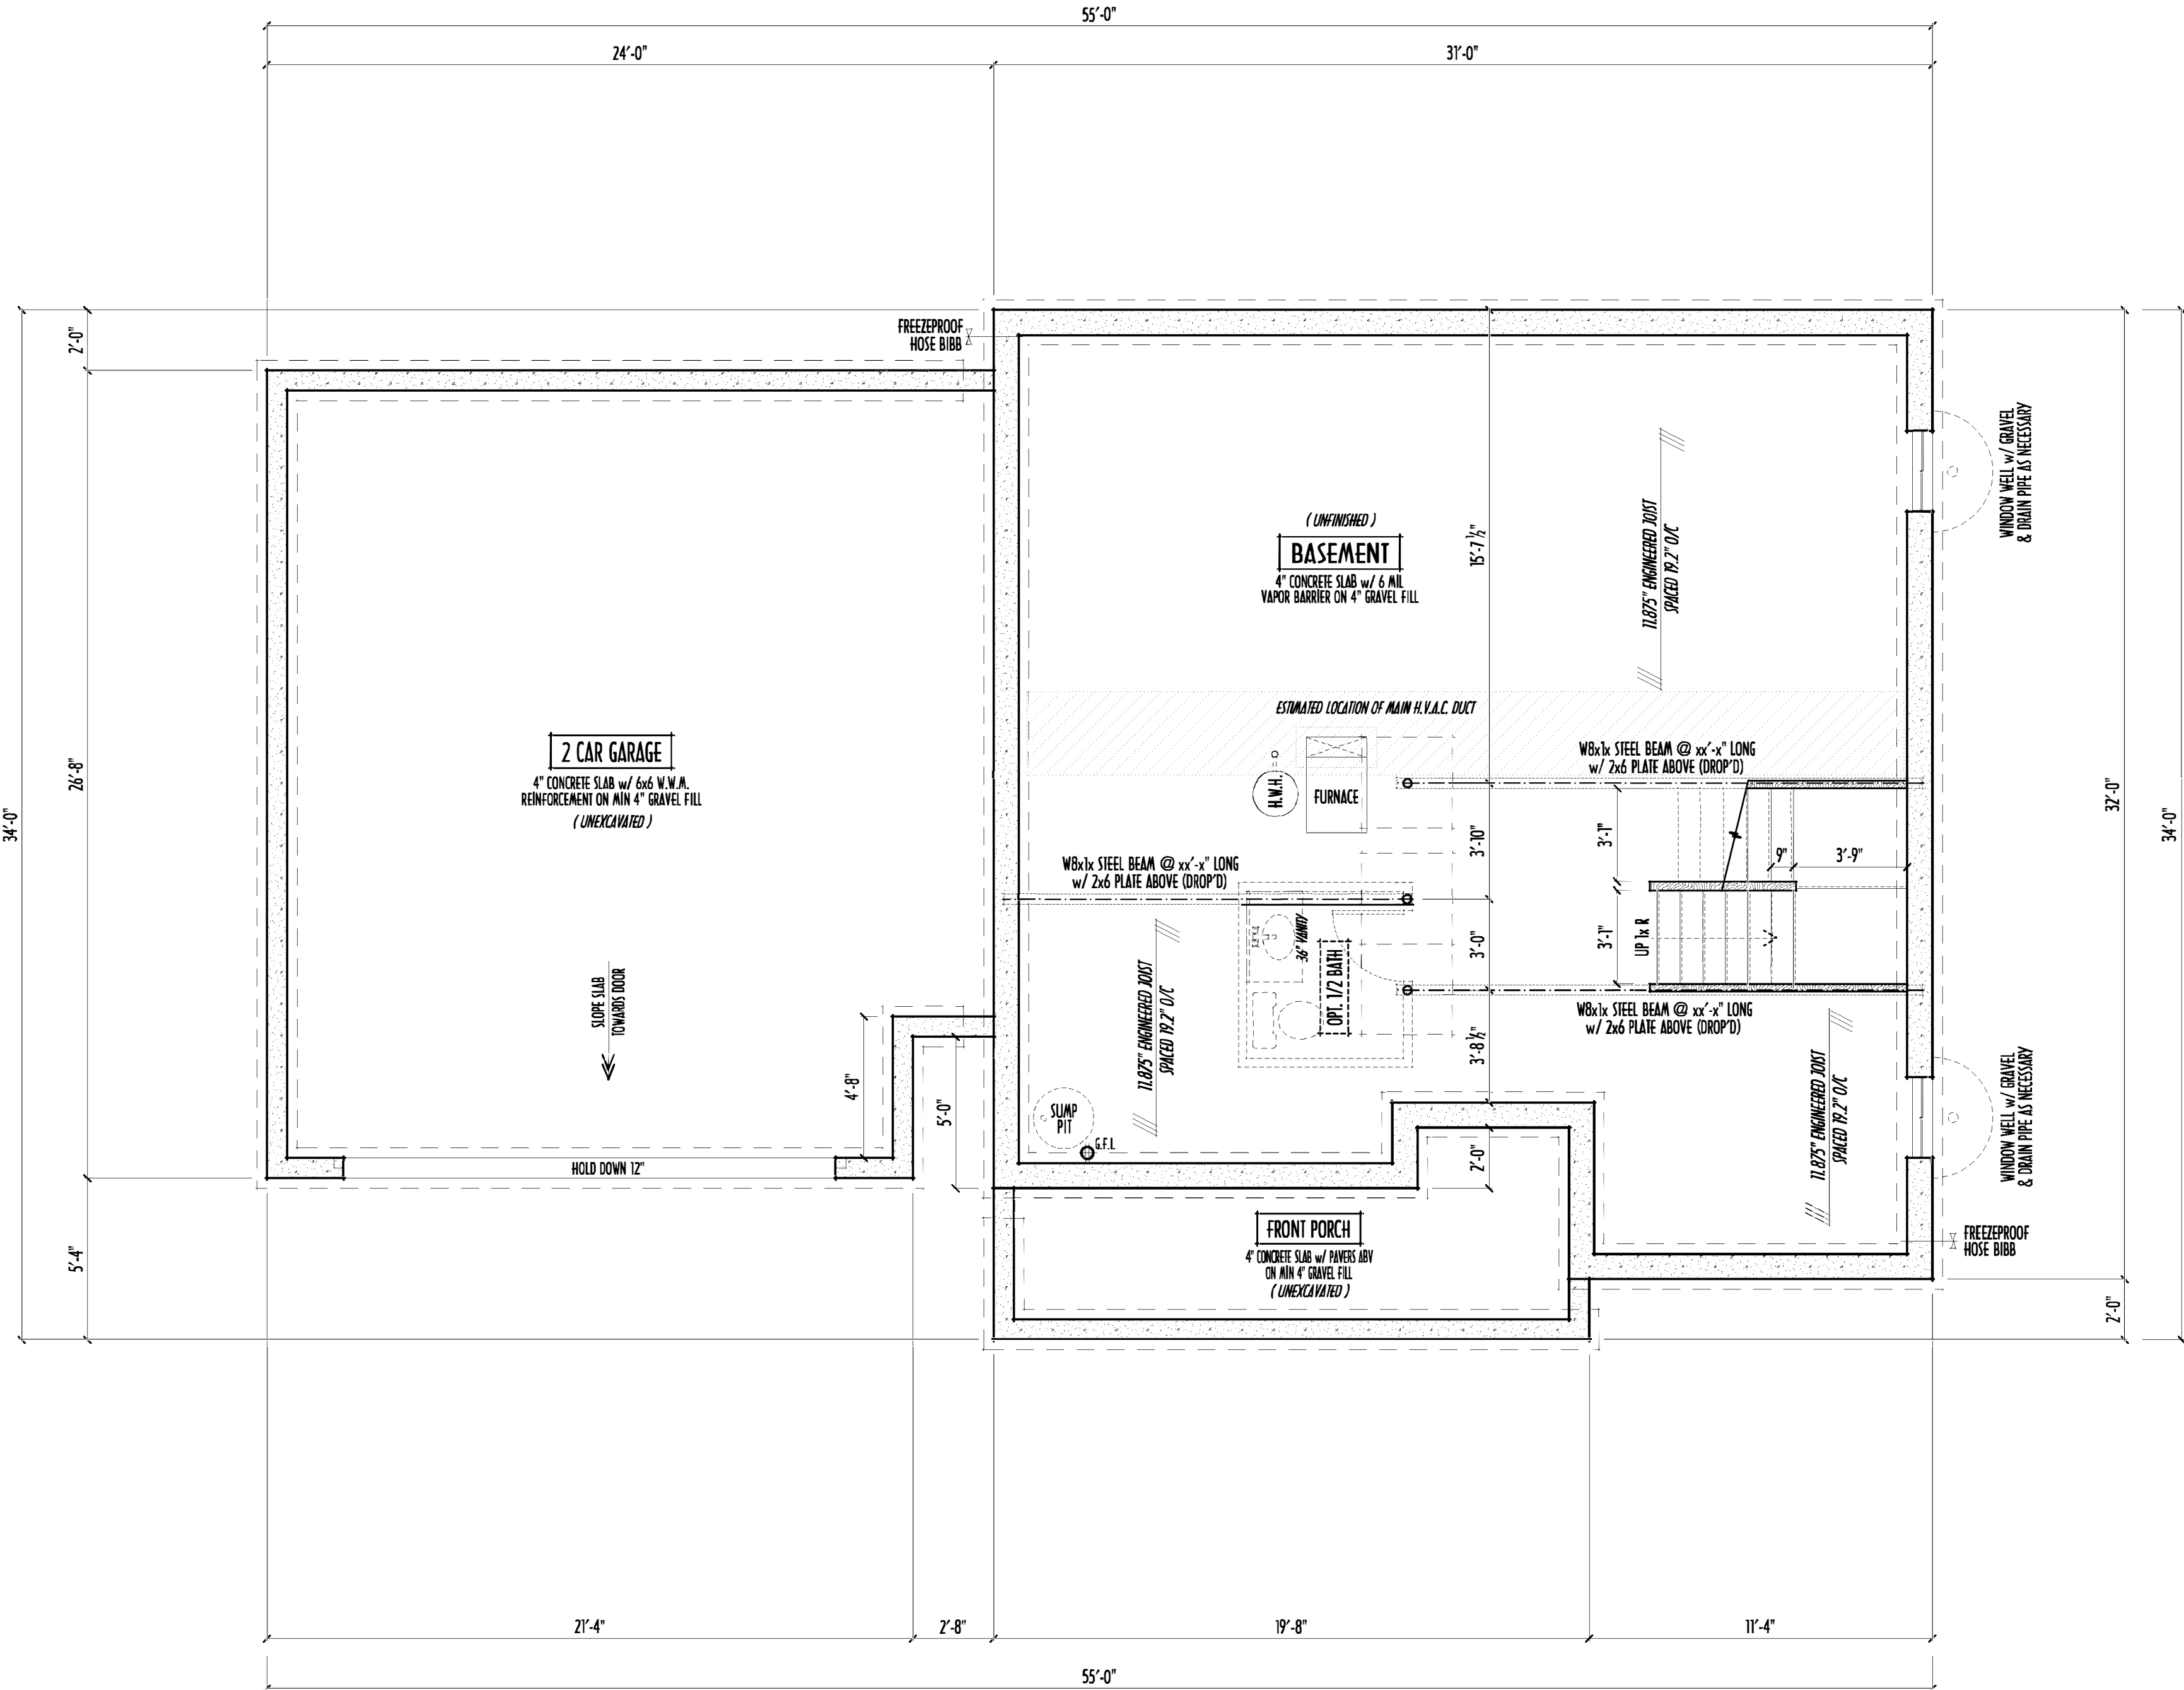

FOUNDATION / BASEMENT PLAN
SCALE : 1/4" = 1'-0"

5'-0"
FINISHED BASEMENT
DIMENSIONS

5'-0"
FOUNDATION STRUCTURAL
DIMENSIONS

X = PIPE COLUMN DESIGNATION

FND/BSMT



P&D Builders Ltd.
59 Greif Parkway Suite 100
Delaware, Ohio 43015
(740) 201-8079
Fax (740) 201-8084
www.pndbuilders.com

ALL DRAWINGS ARE THE PROPERTY OF P&D BUILDERS LTD. NO PERMISSION OR USE OF THESE DRAWINGS IS ALLOWED WITHOUT WRITTEN CONSENT OF THE AUTHOR OF THE PLAN.

FND JOB

1419

STATE OF OHIO
REGISTERED ARCHITECT
RONALD W. DANNE
1717085
RONALD W. DANNE LICENSE #1717085
EXPIRATION DATE 12/31/2021



Danne
Residential Design & Drafting Inc.
614.207.6266 danne@danne.com

REVISION DATE:	BY:	PROJ:
12/21/19	rwd	concepts
12/23/19	" "	prelims
1/15/20	" "	pre-eng

TO SCALE WHEN PRINTED 24x36 - PAPER SIZE 11"

0 12 24 36 48 60 72 84 96 108 120

FIELD MEASUREMENTS - DO NOT SCALE NOTES

DESIGNED

P&D / rwd

PAGE :

2 of 9

FIRST FLR LIVING SP =	926 SQ.FT.
SECOND FLR LIVING SP =	1,358 SQ.FT.
TOTAL LIVING SP =	2,284 SQ.FT.
OPT. FINISHED BSMT =	36 SQ.FT.

1/16/2020 9:27 AM