



TABBY LANE RESIDENCE


7.1.25 by BG
Electrical Redlines 6.18.25 by MS per 6.17 field notes Brad Hawkins

11 TABBY LANE
ISLE OF PALMS, SC 29451


Redlined

BUILDING AREA TABULATION							
	FINISHED	UNF. AREA	GARAGES	ROOFED PORCHES	FRAMED	COVERED PATIOS	OPEN PATIOS/ DECKS
LOWER (ABOVE GRADE)	197	1598	1629	-	3,414	1642	-
MAIN (ABOVE GRADE)	3,680	-	-	1,452	5,182	-	-
UPPER LEVEL	2,292	-	-	-	2,292	-	308
TOTALS	6,169	1598	1629	1,452	10,888	1642	308


5 Area Calc - Client
1/4" = 1'-0"

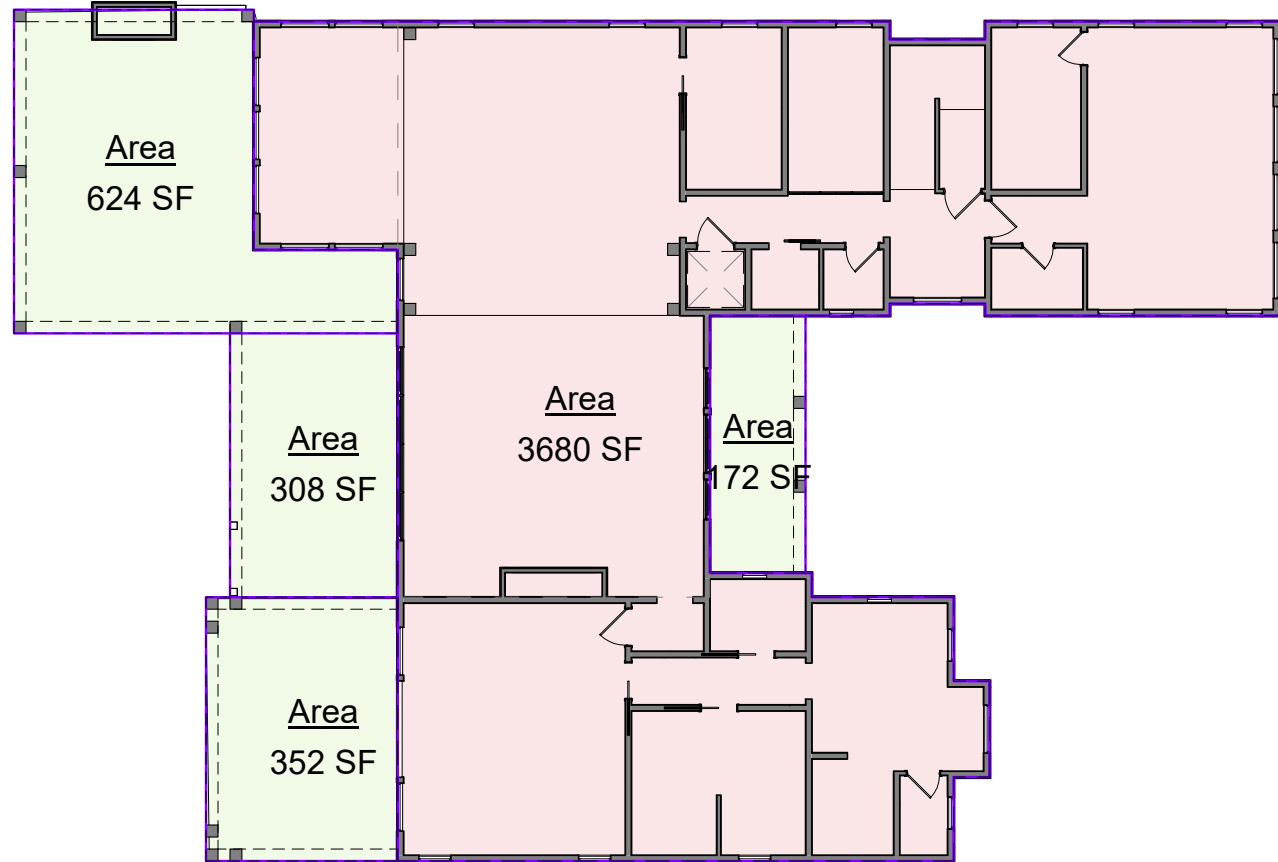

2 MAIN LEVEL FFE(1)
1/16" = 1'-0"



























































































































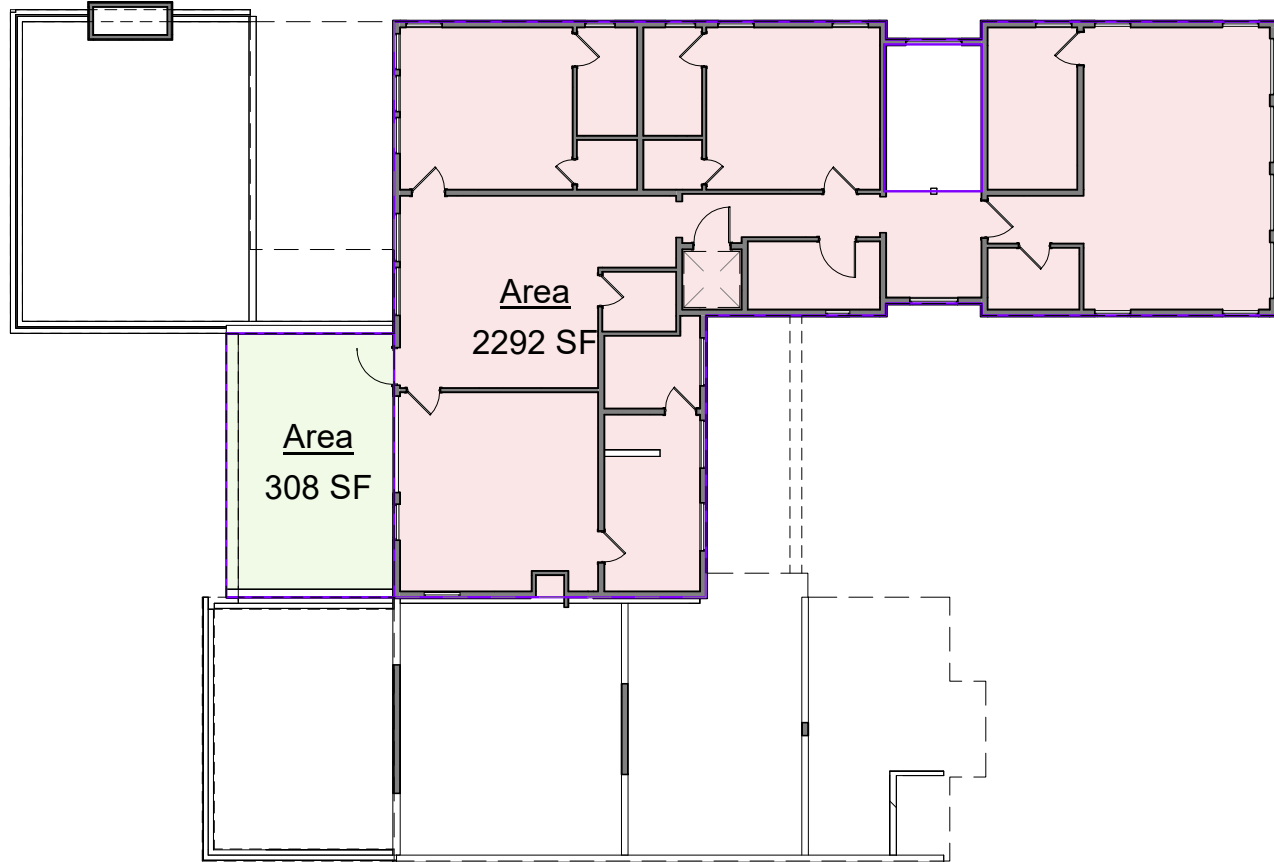




3 UPPER LEVEL SUBFL.
1/16" = 1'-0"

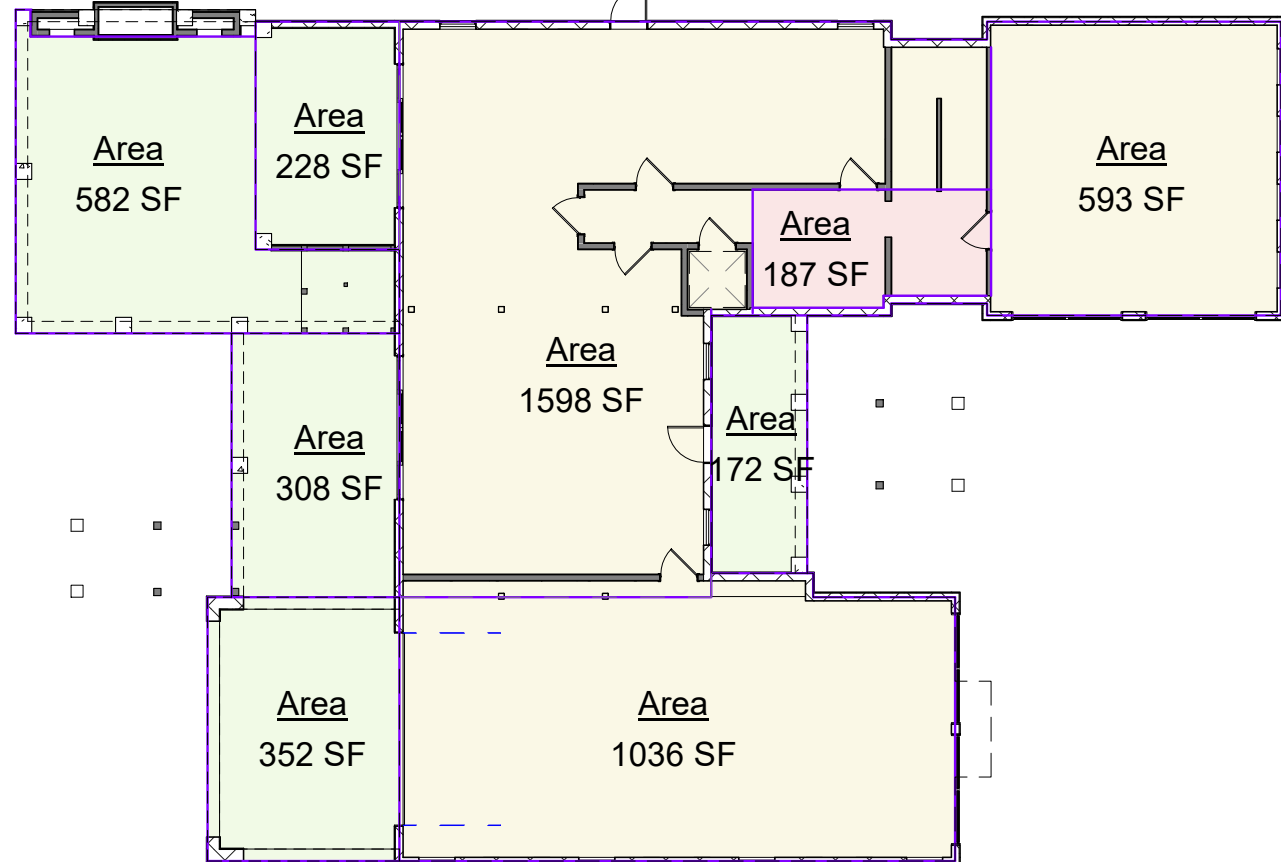

4 L.L. F.F.
1/16" = 1'-0"

SHEET LIST	
SHEET NO.	SHEET NAME
A0.01	COVER SHEET
A1.01	LOWER LEVEL FLOOR PLAN
A1.02	MAIN FLOOR PLAN
A1.03	UPPER LEVEL FLOOR PLAN
A1.04	ROOF PLAN
A2.01	EXTERIOR ELEVATIONS
A2.02	EXTERIOR ELEVATIONS
A3.01	BUILDING SECTIONS
A3.02	BUILDING SECTIONS
A3.03	BUILDING SECTIONS
A3.04	BUILDING SECTIONS
A3.05	BUILDING SECTIONS
A3.06	BUILDING SECTIONS
A3.07	BUILDING SECTIONS
A8.01	PERSPECTIVES
A8.02	PERSPECTIVES
E1.01	ELECTRICAL PLAN
E1.02	ELECTRICAL PLAN
E1.03	ELECTRICAL PLAN

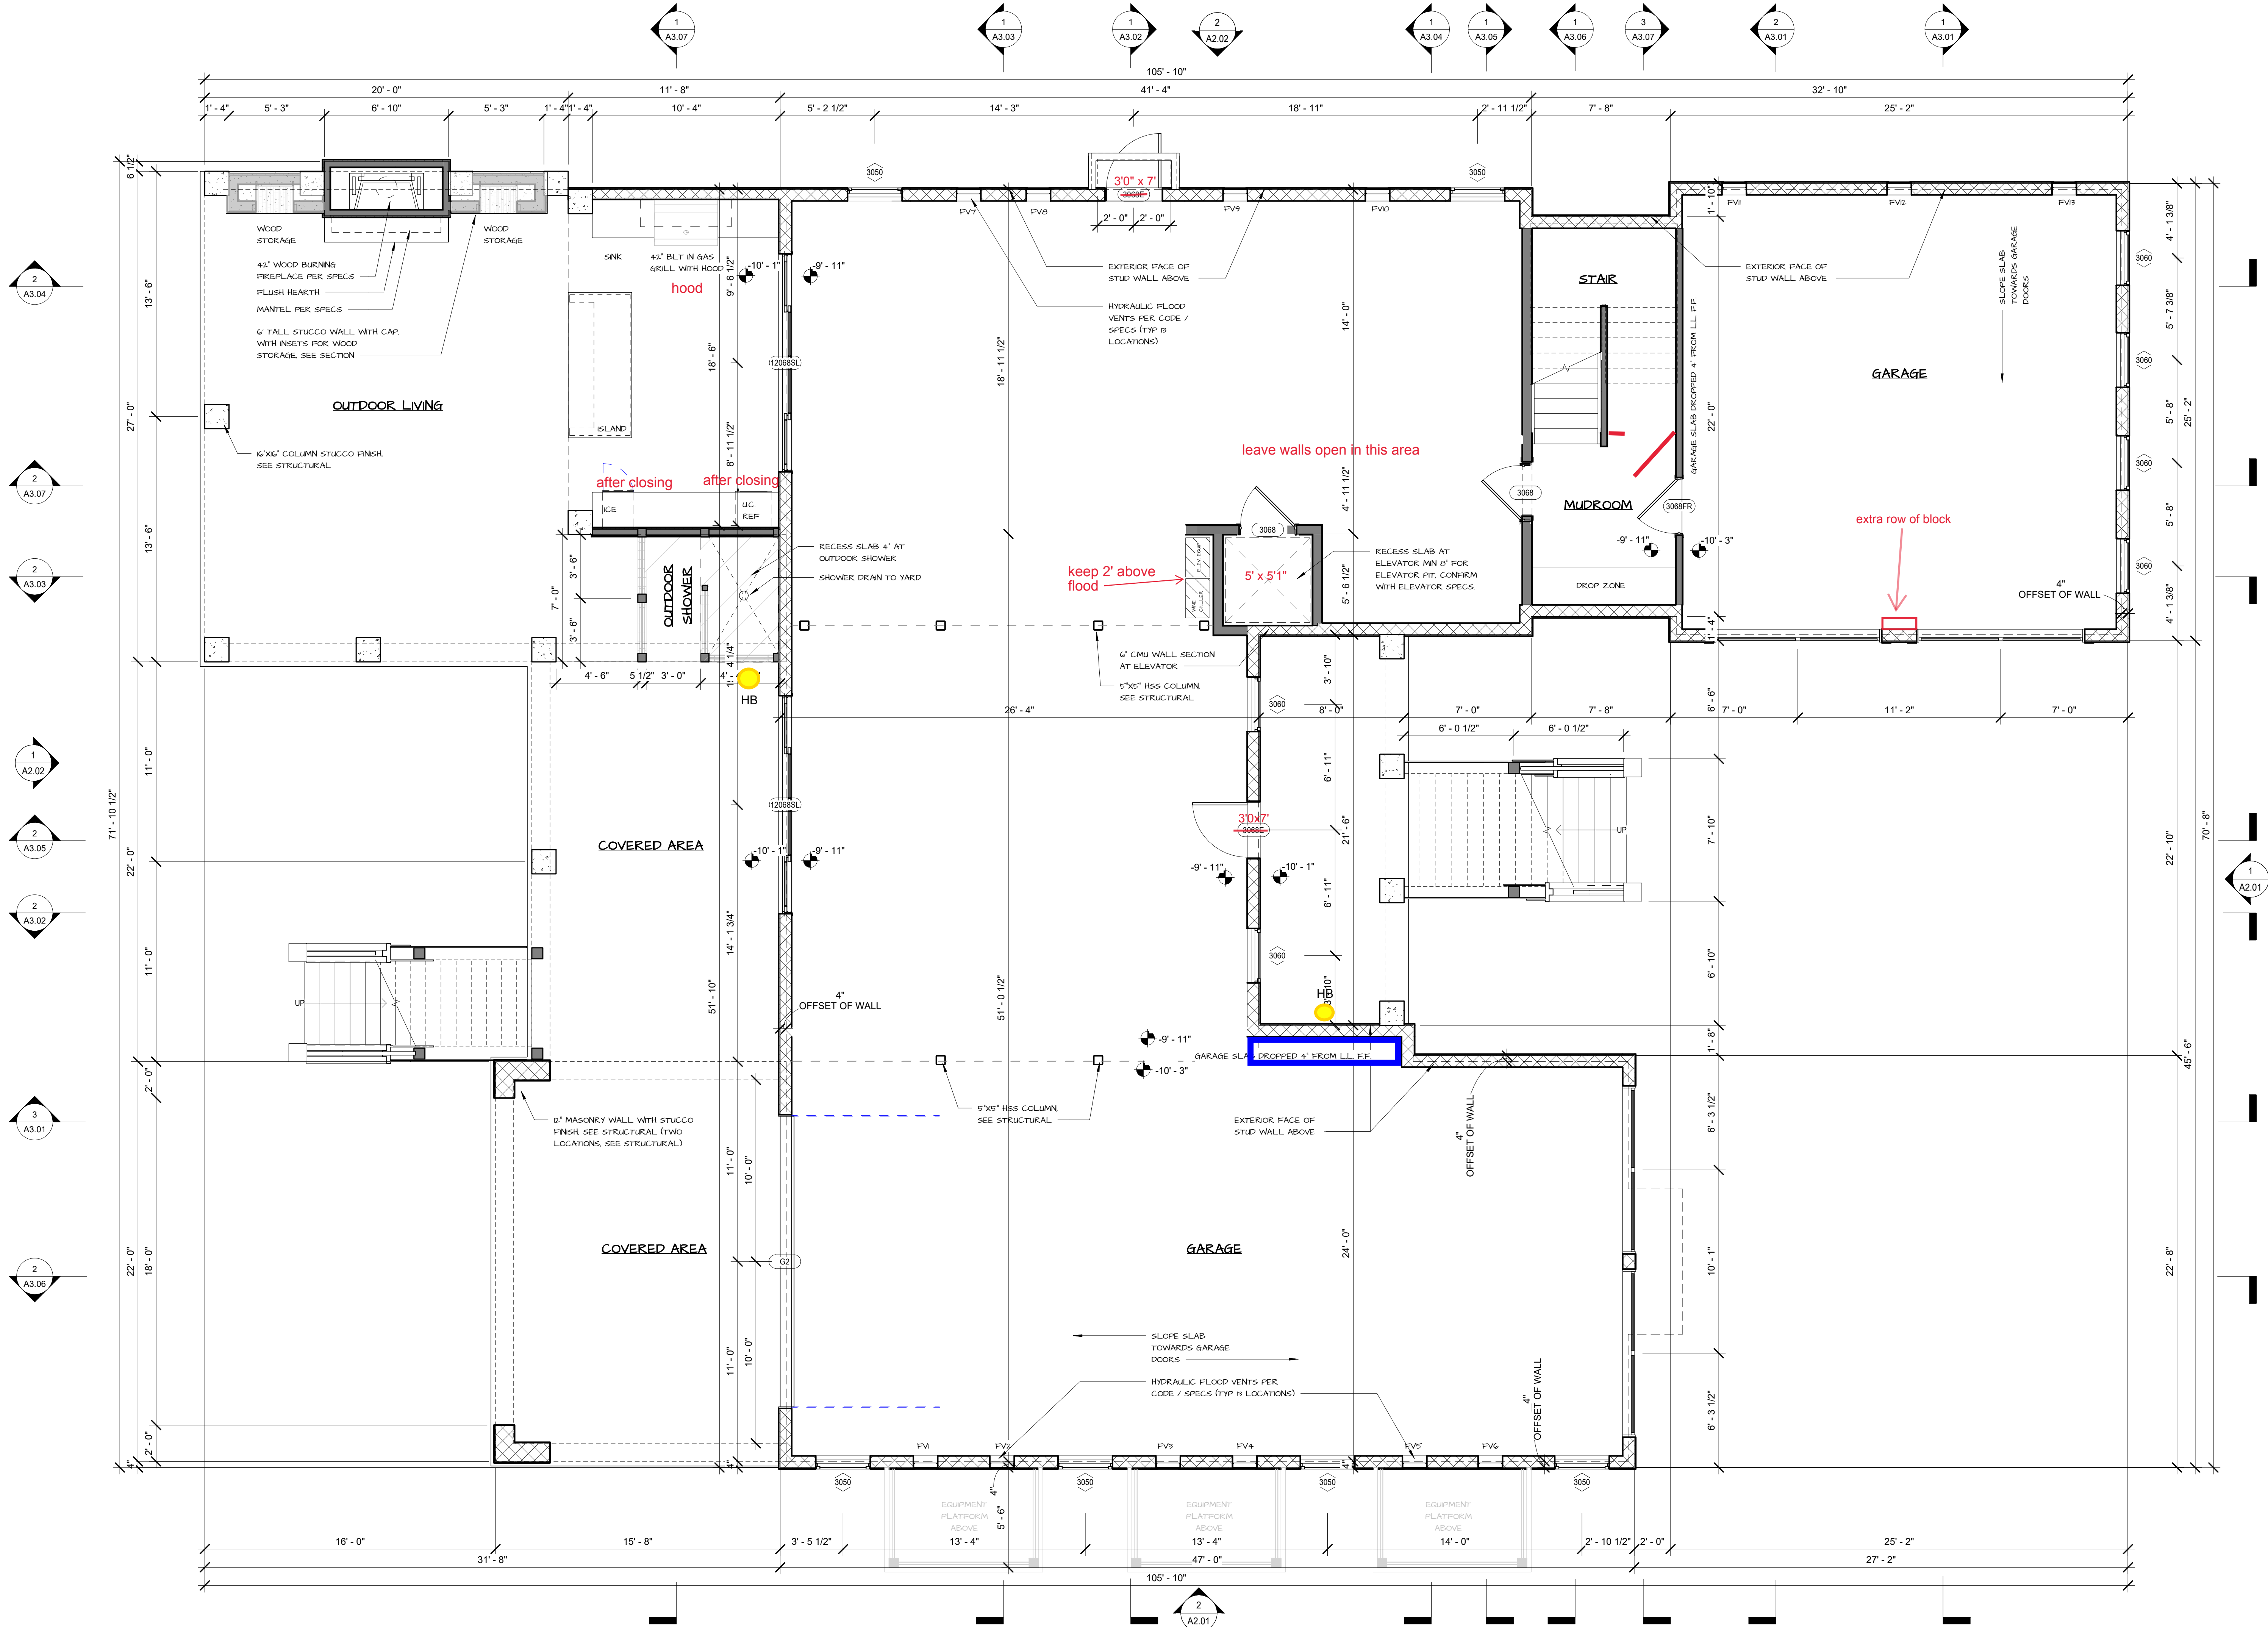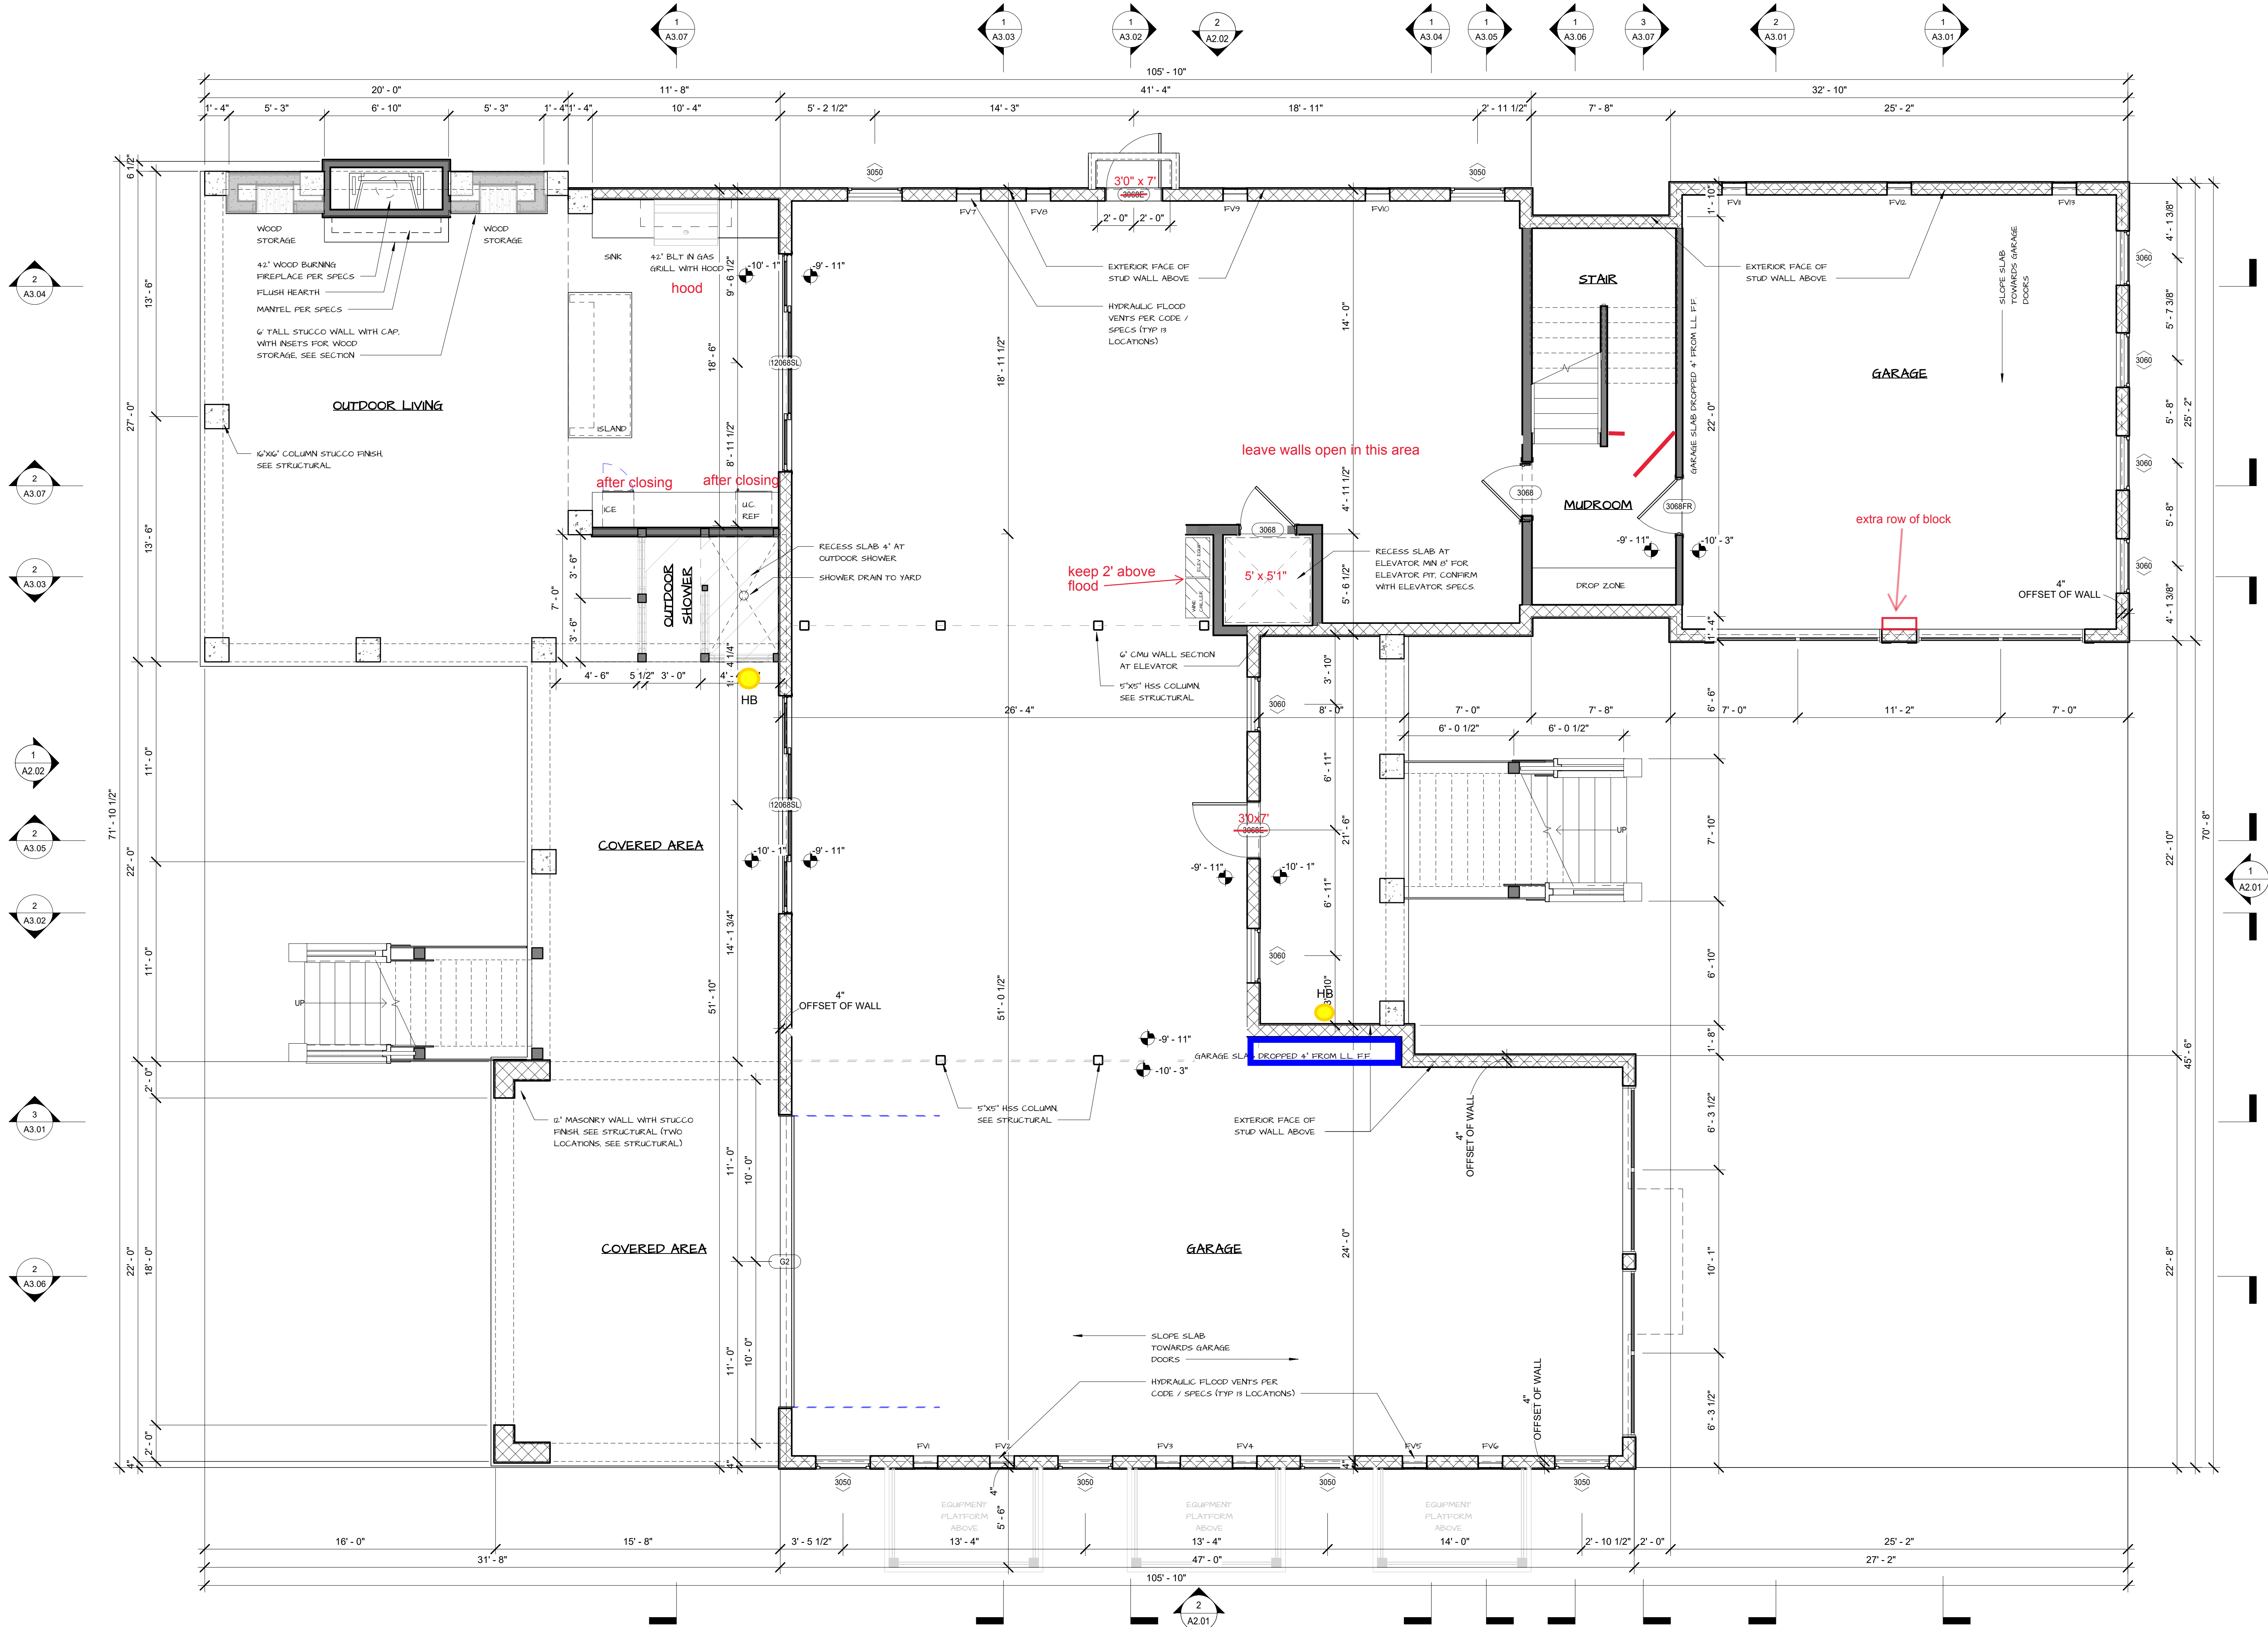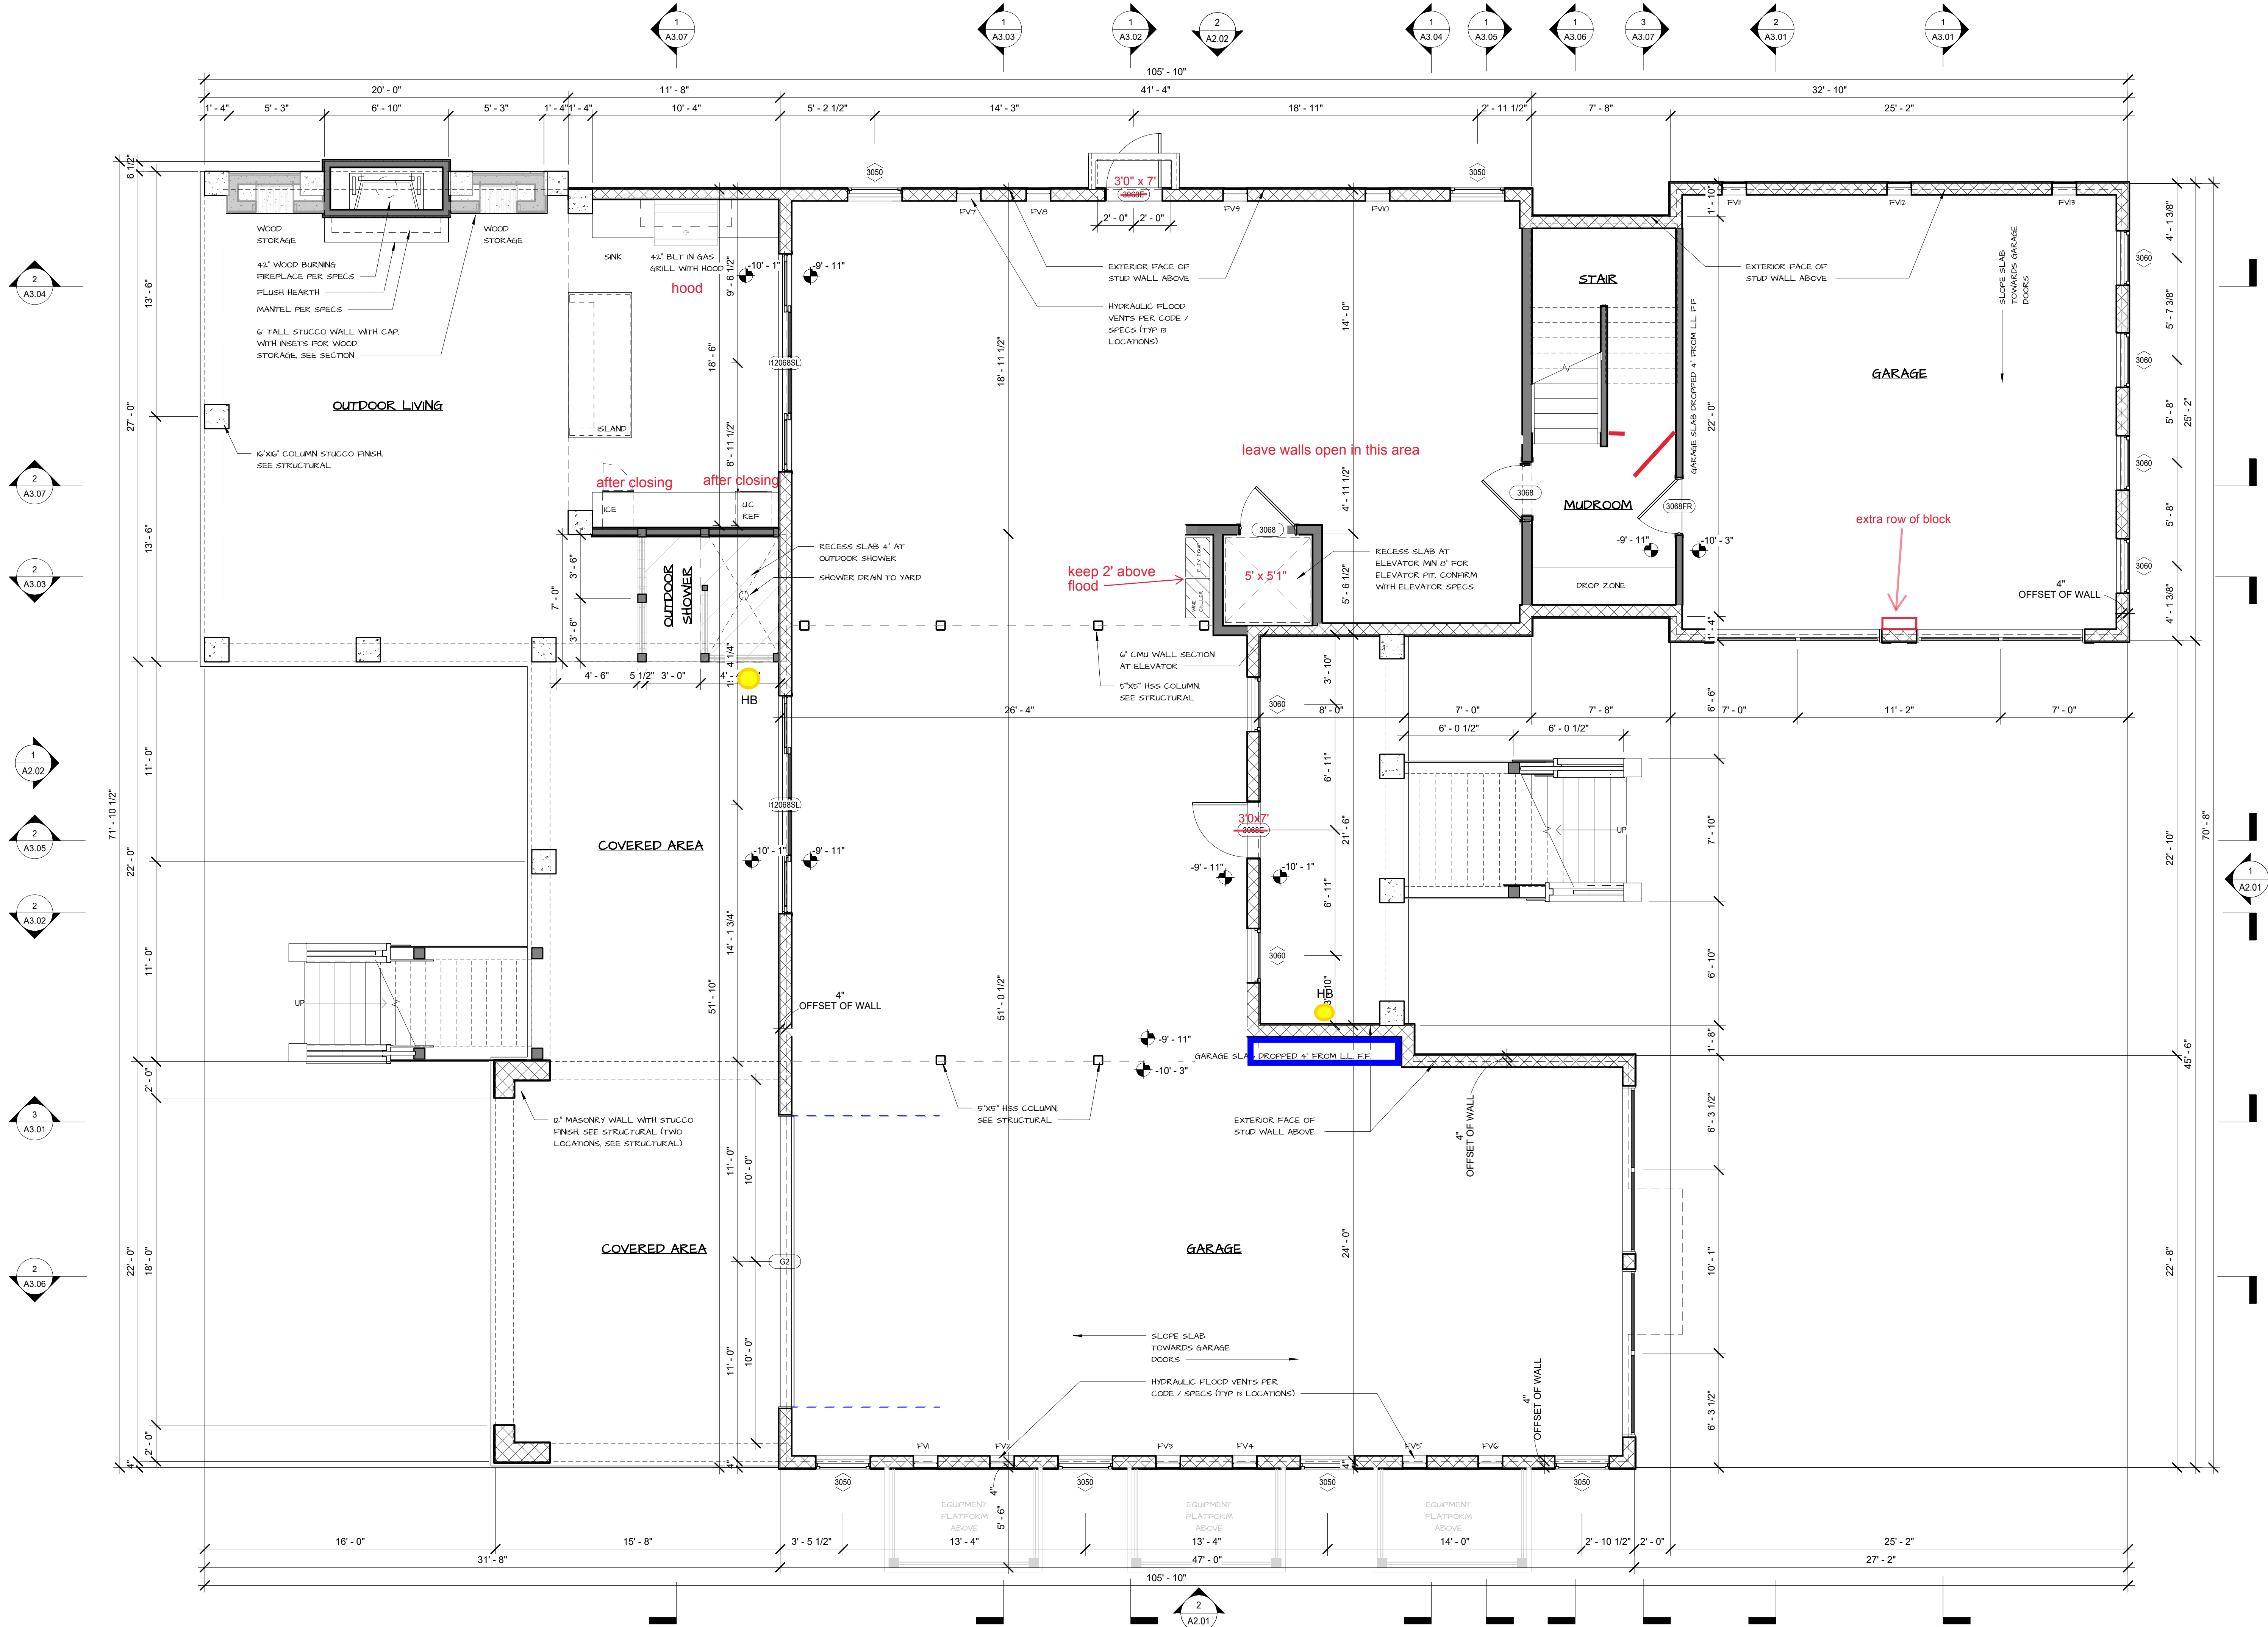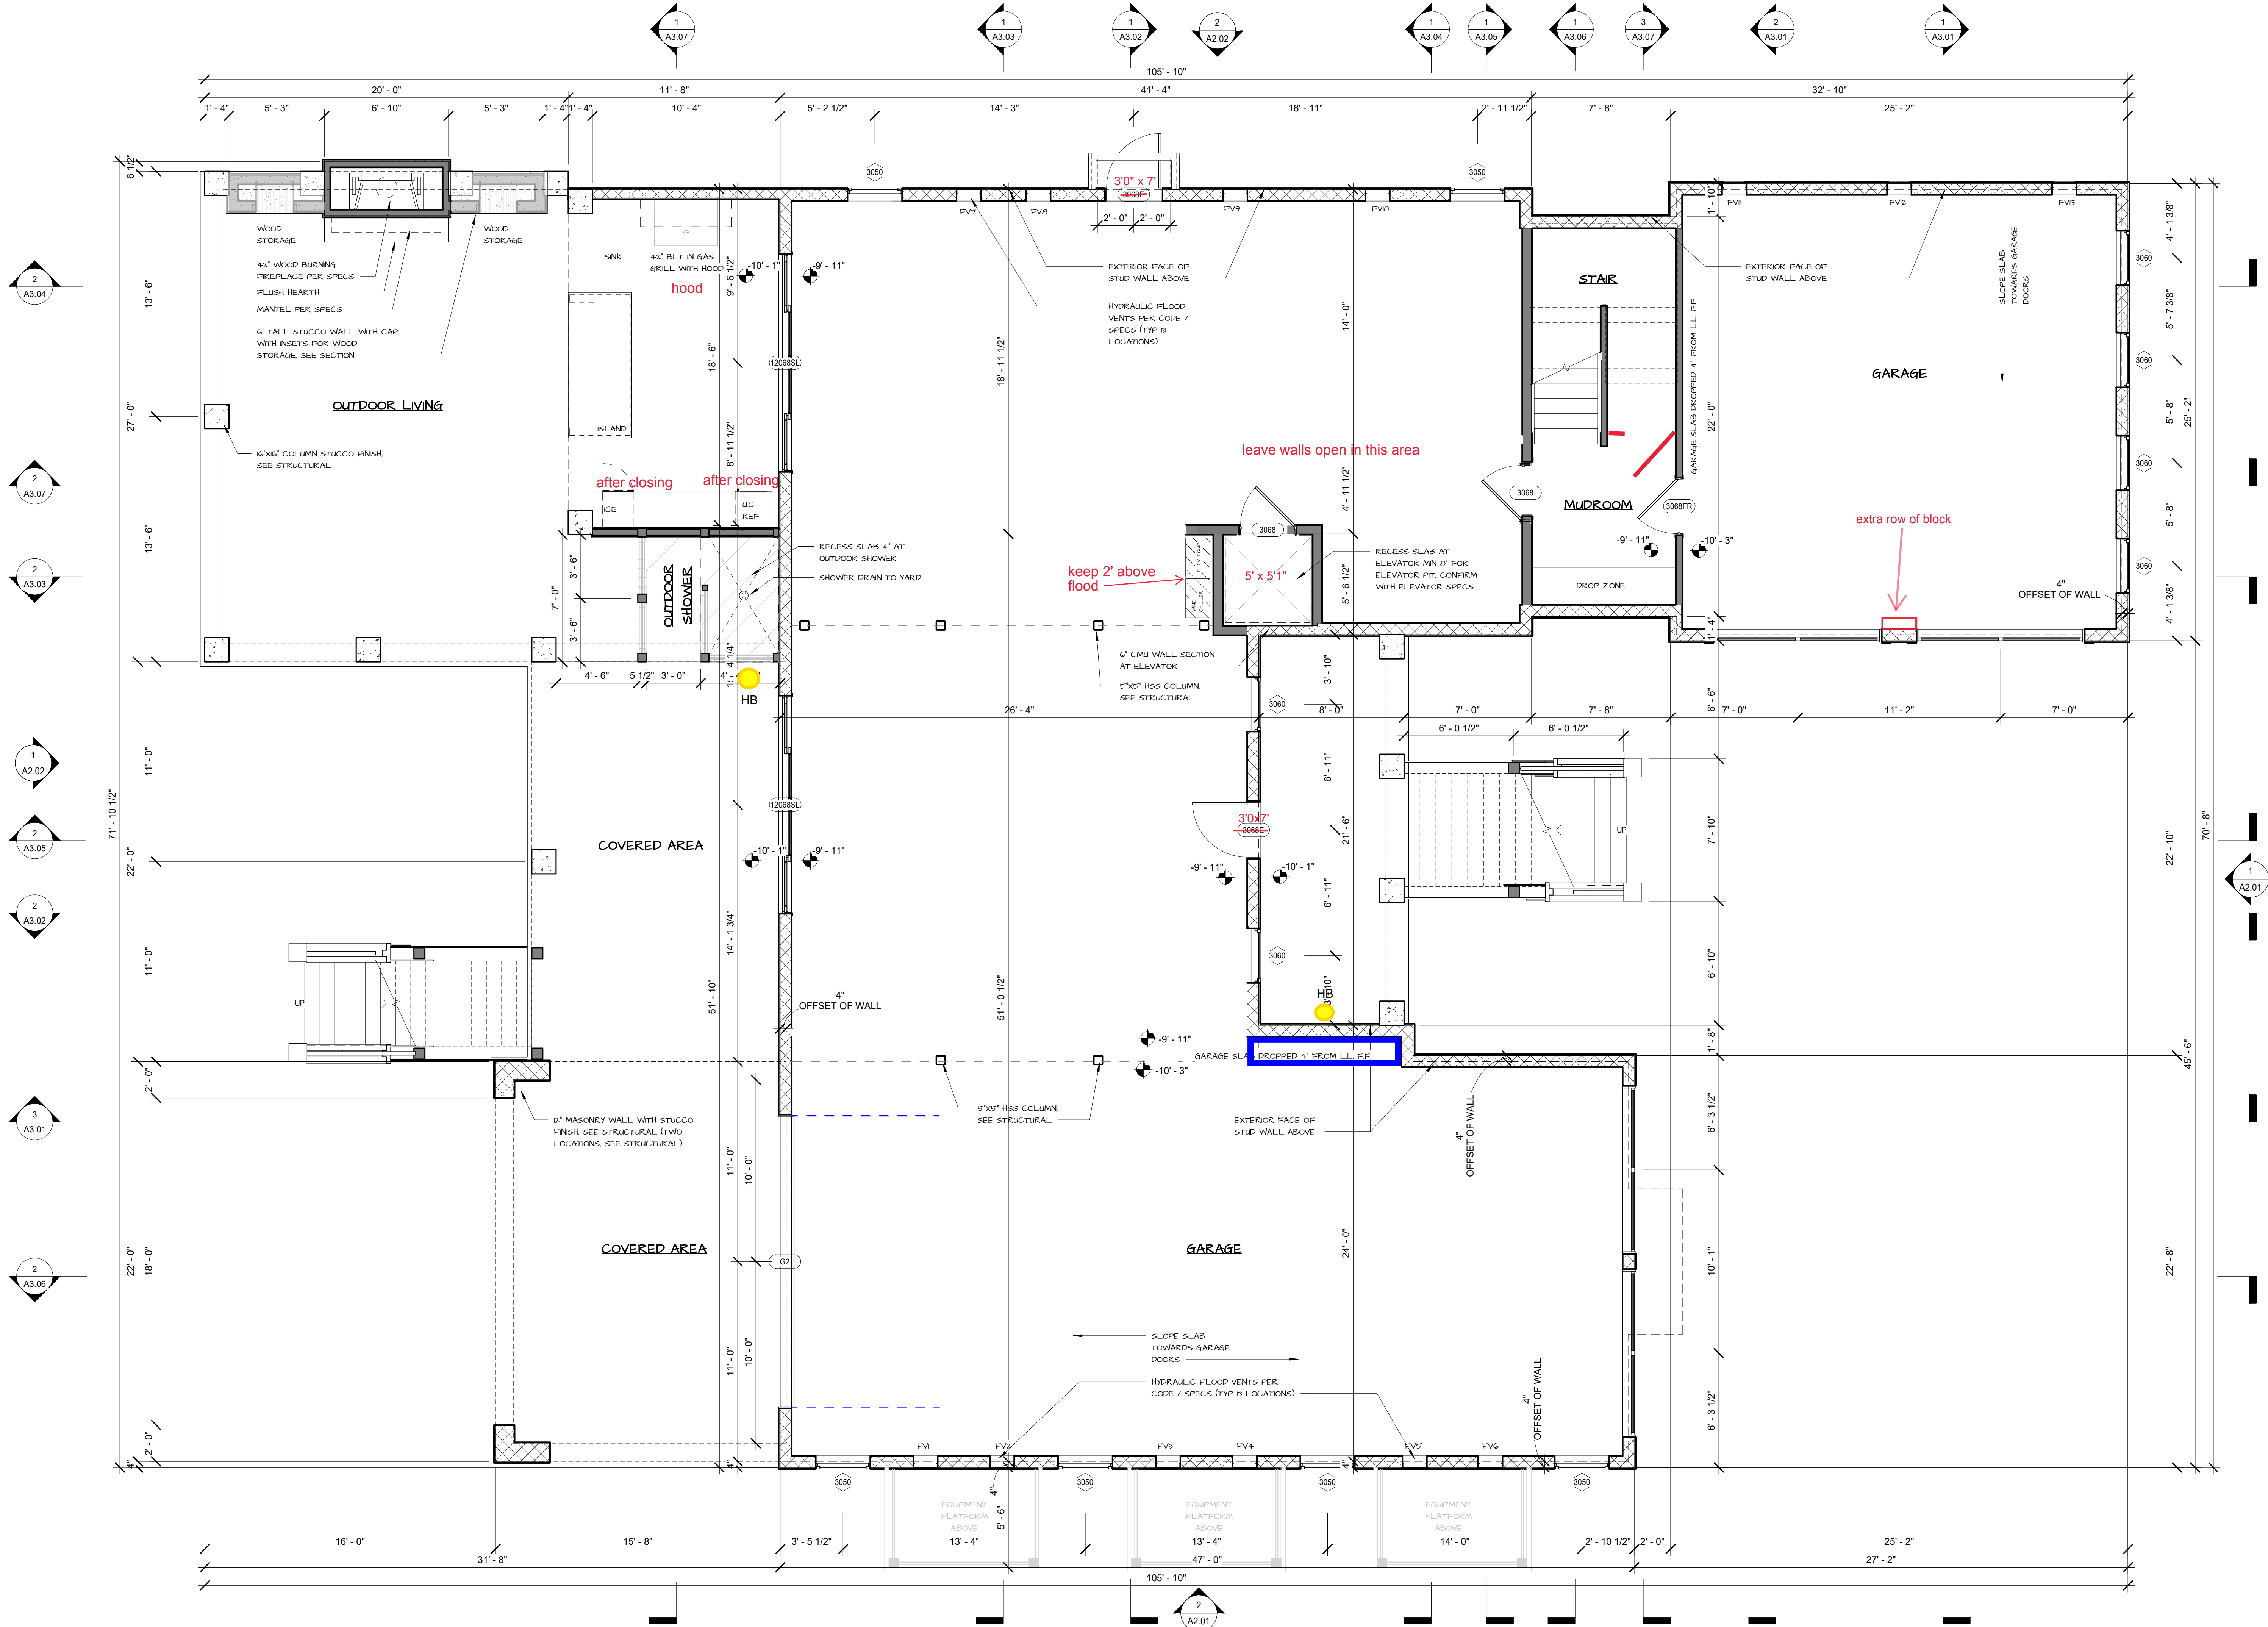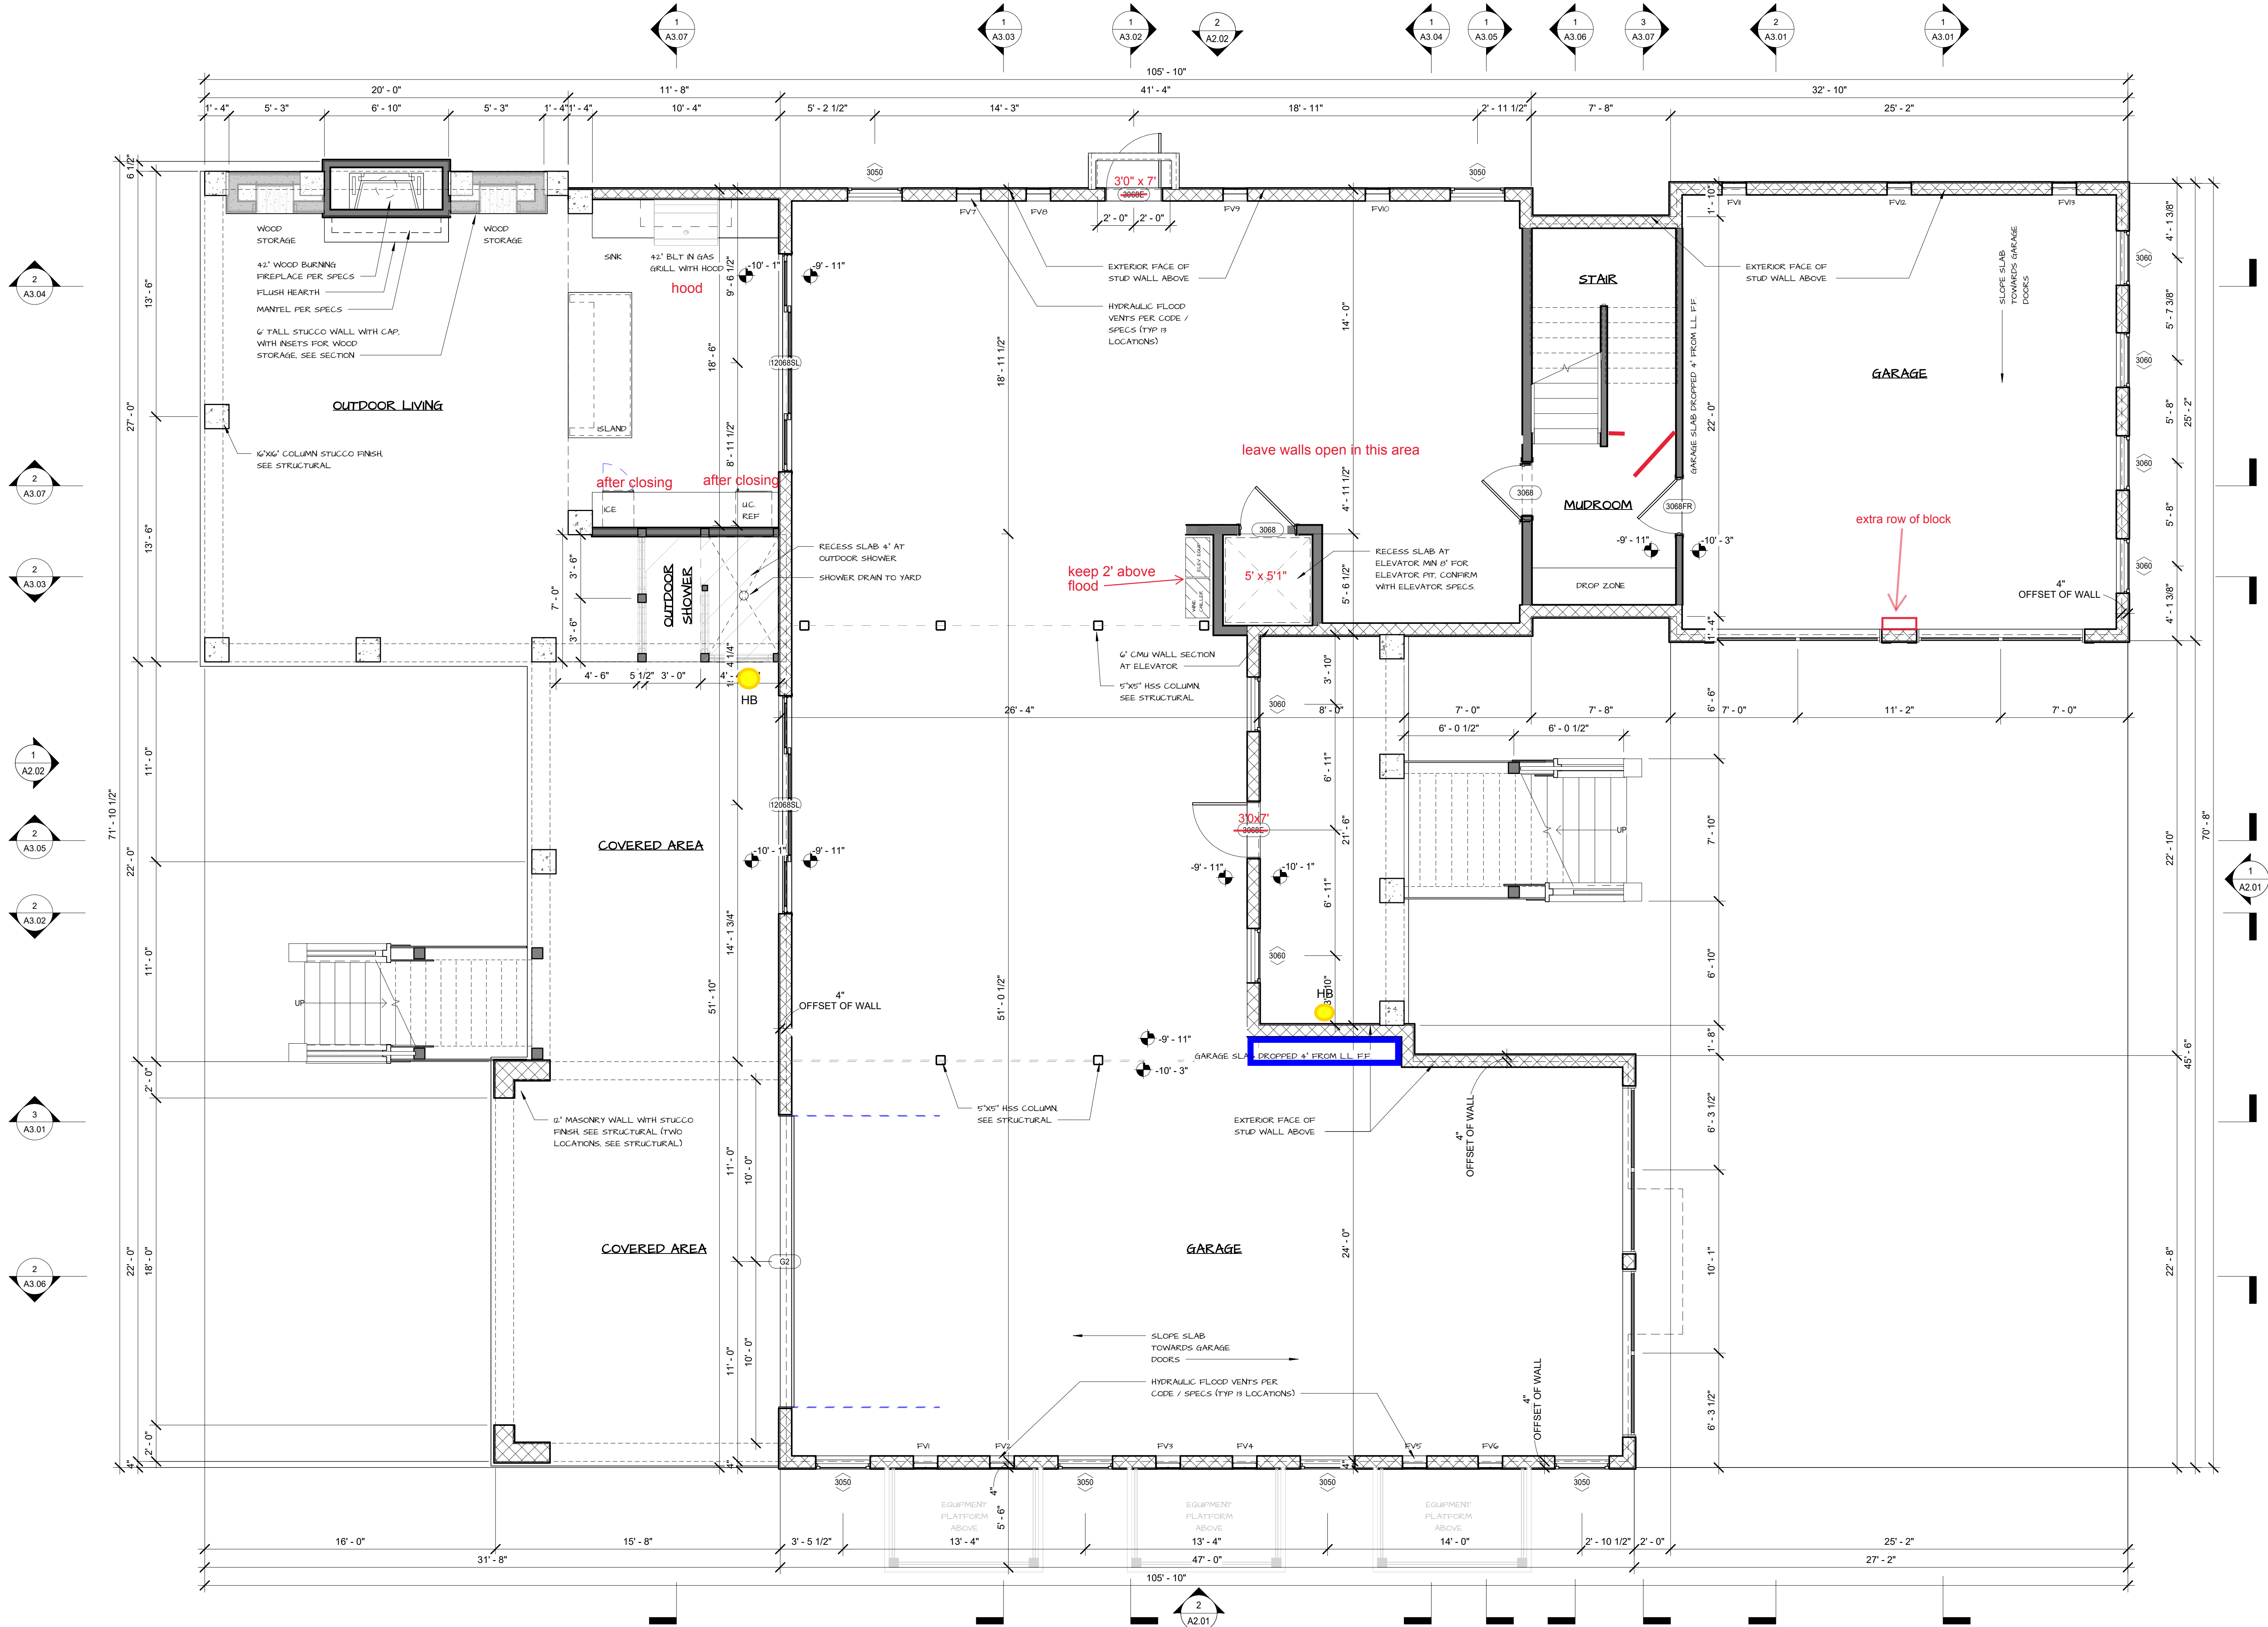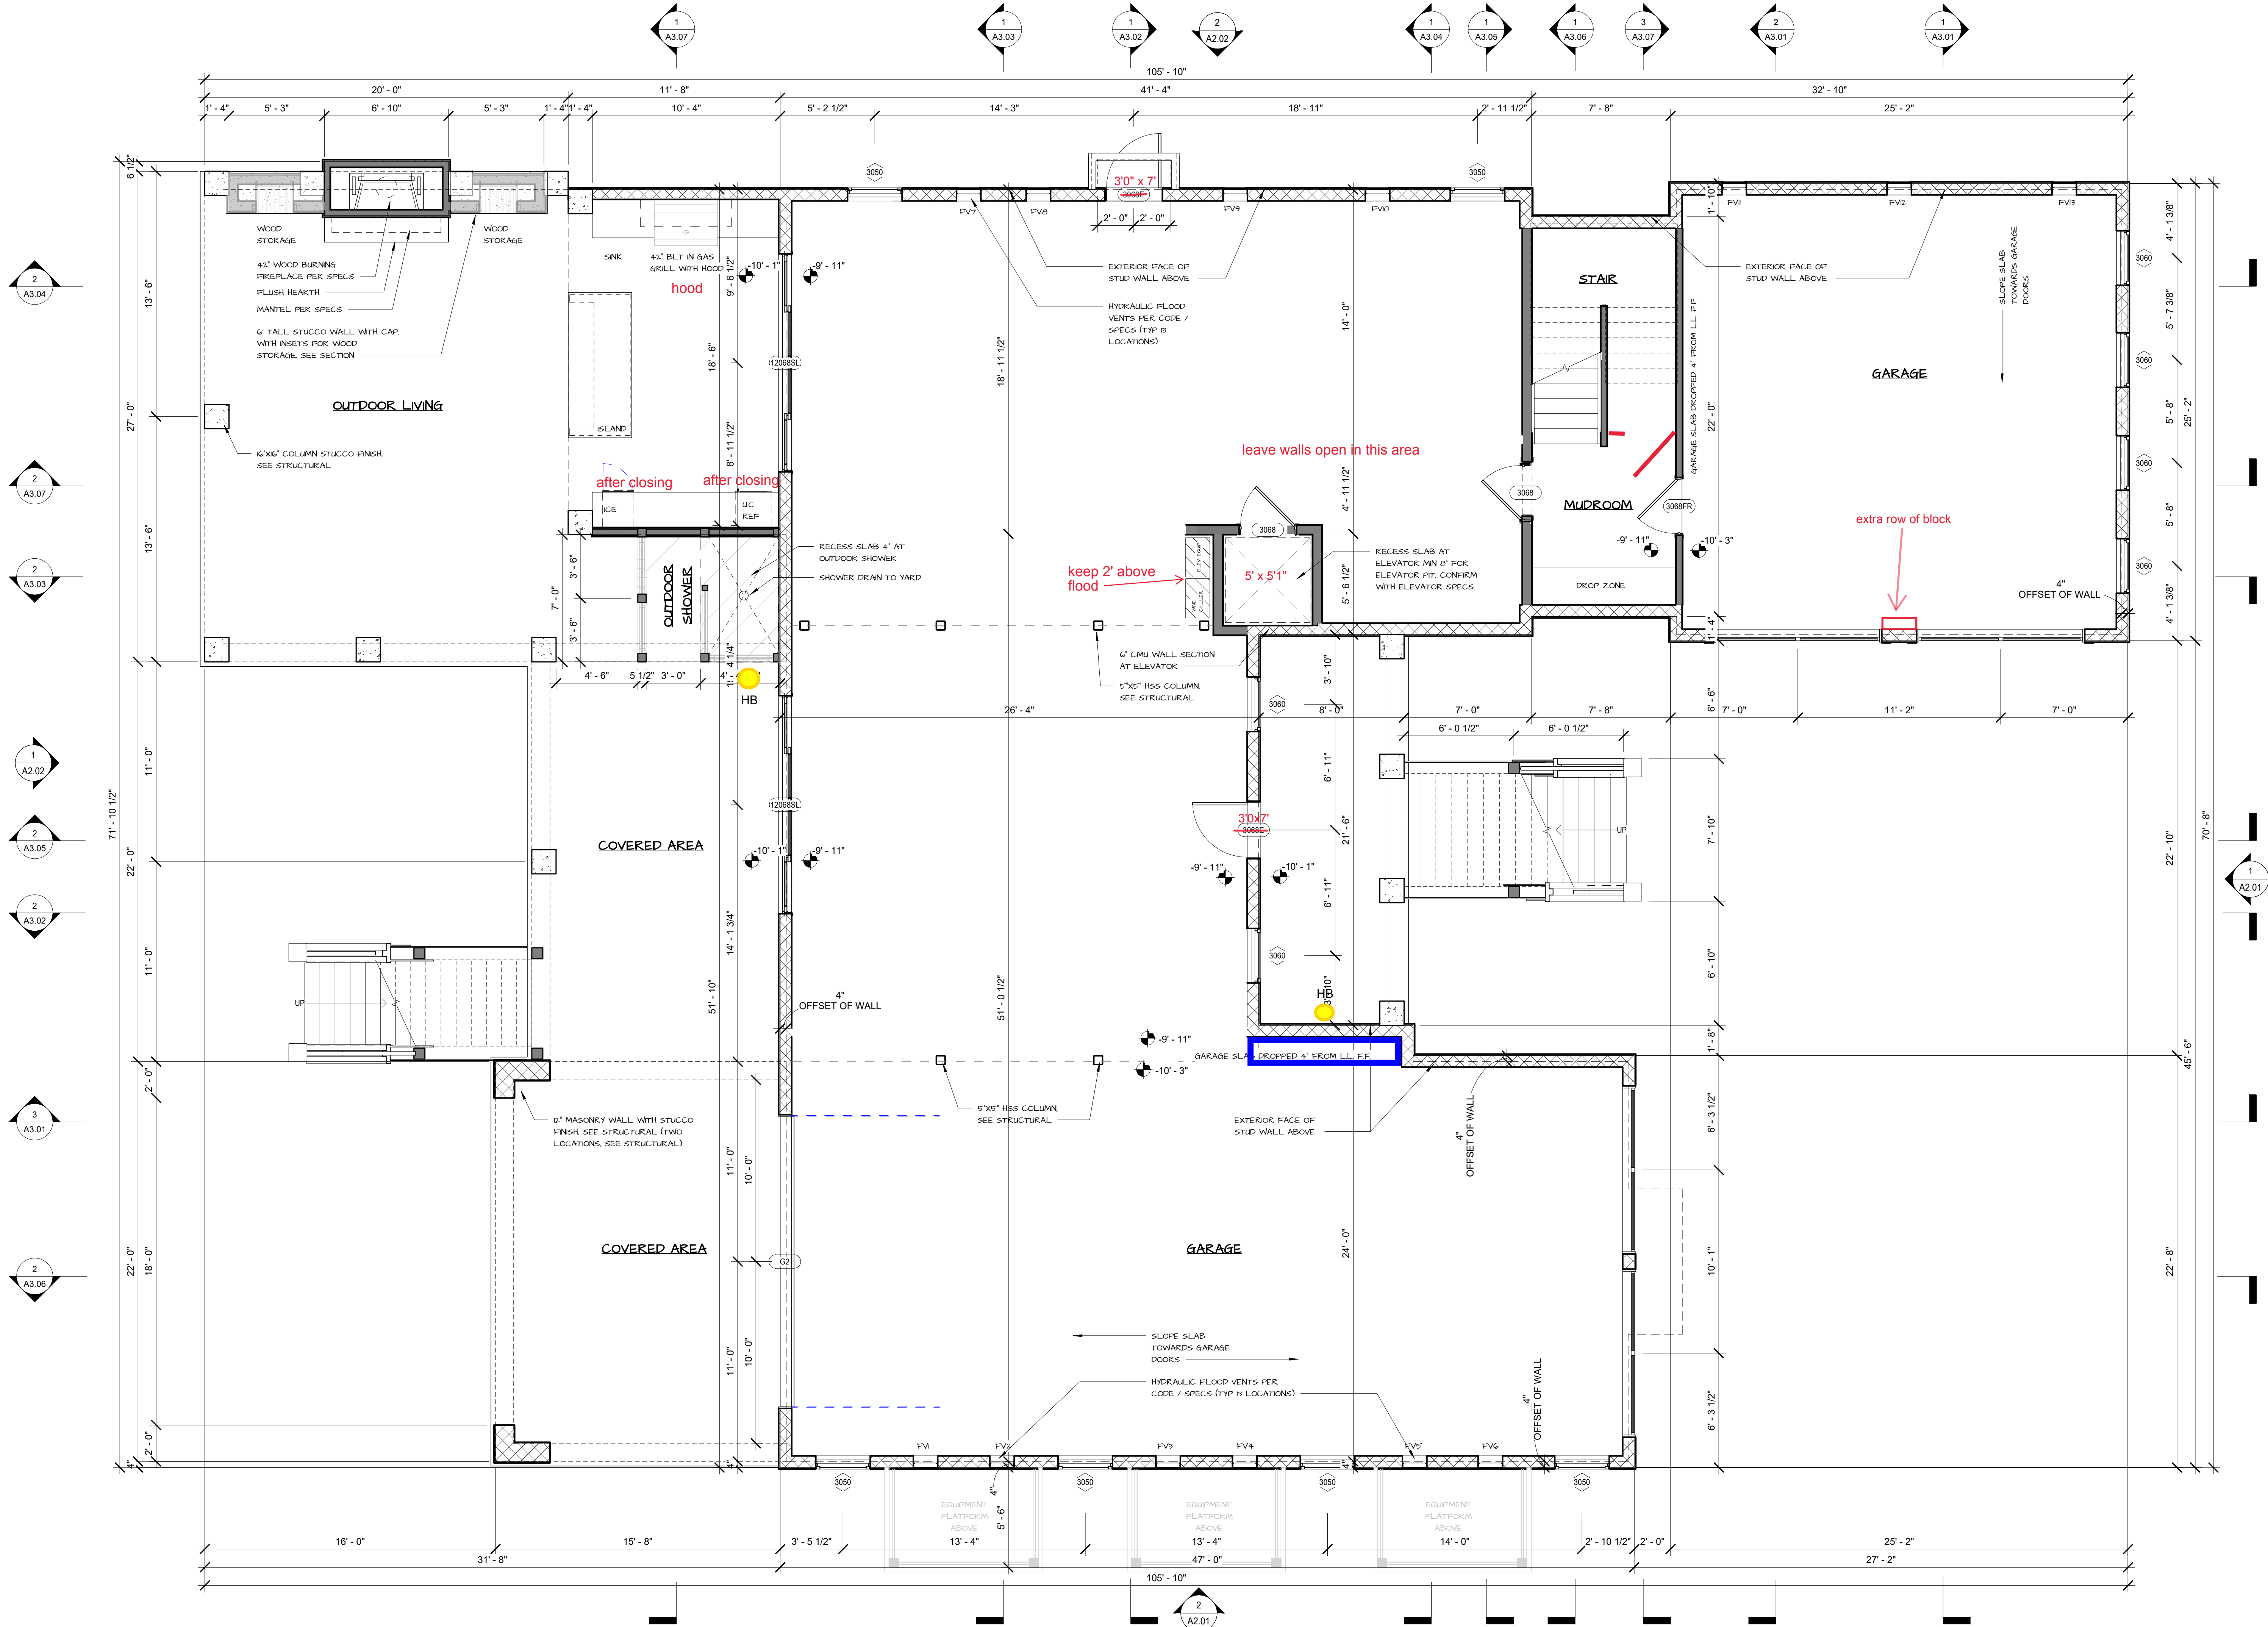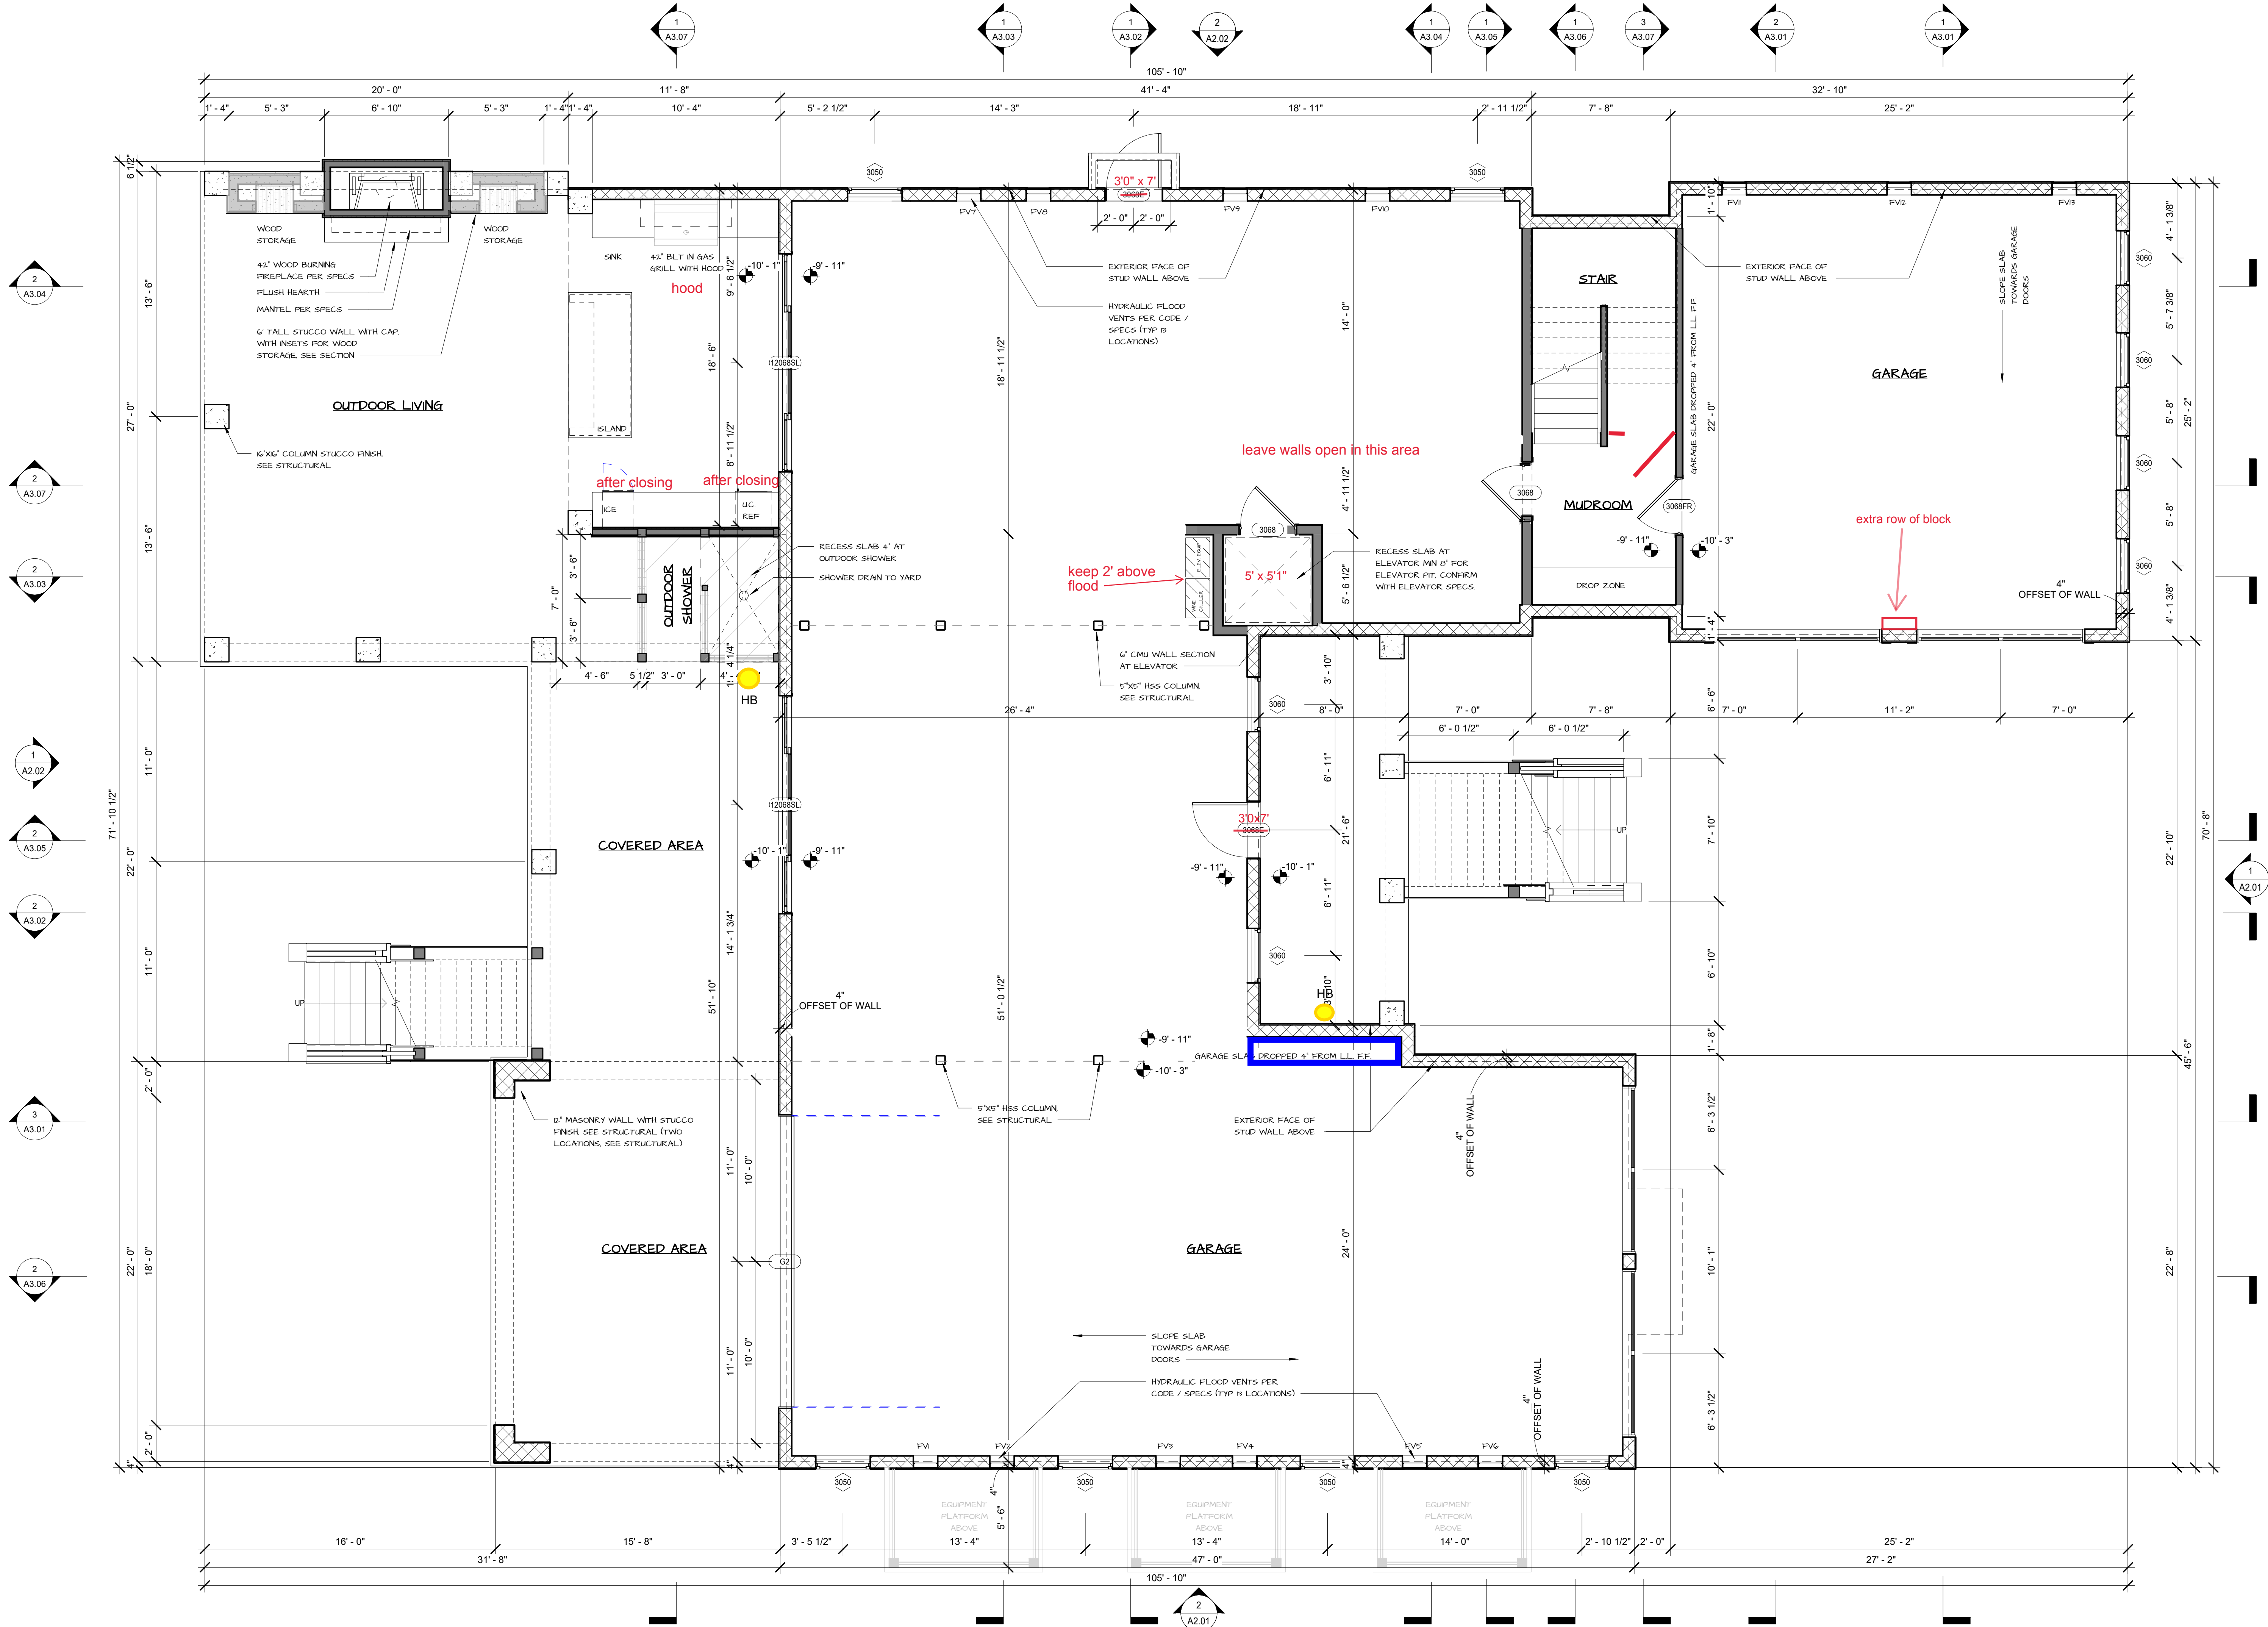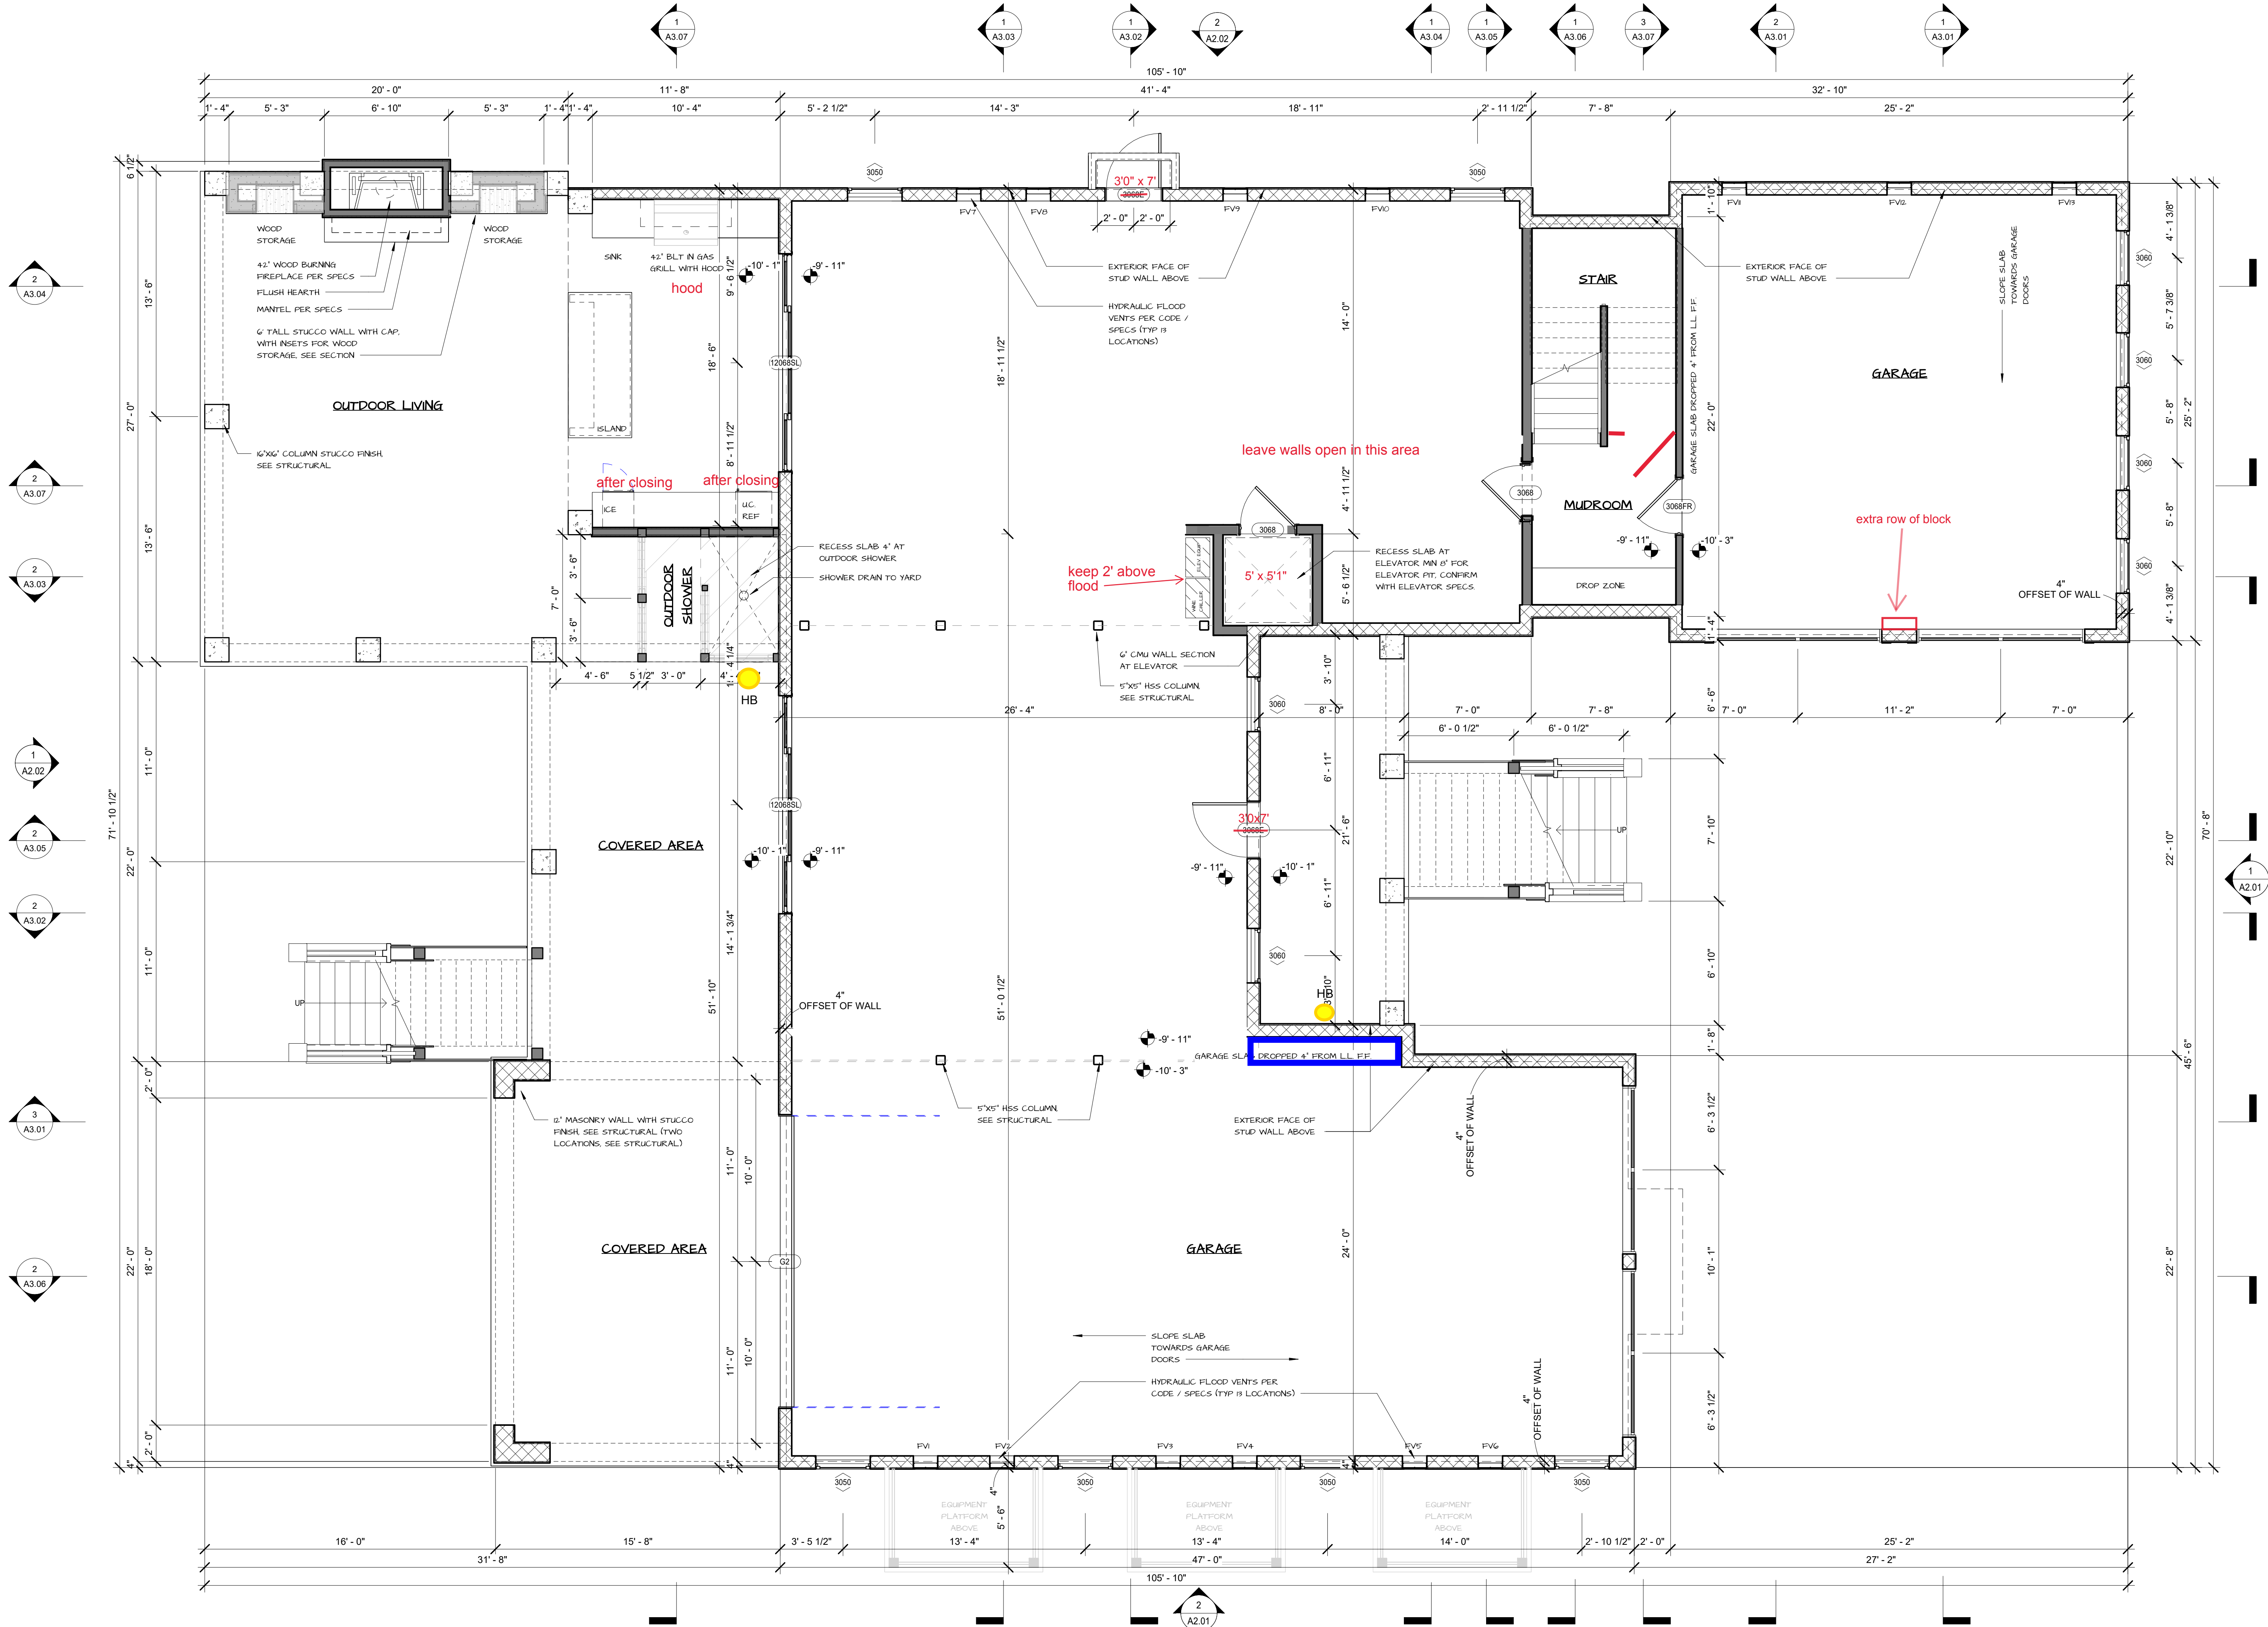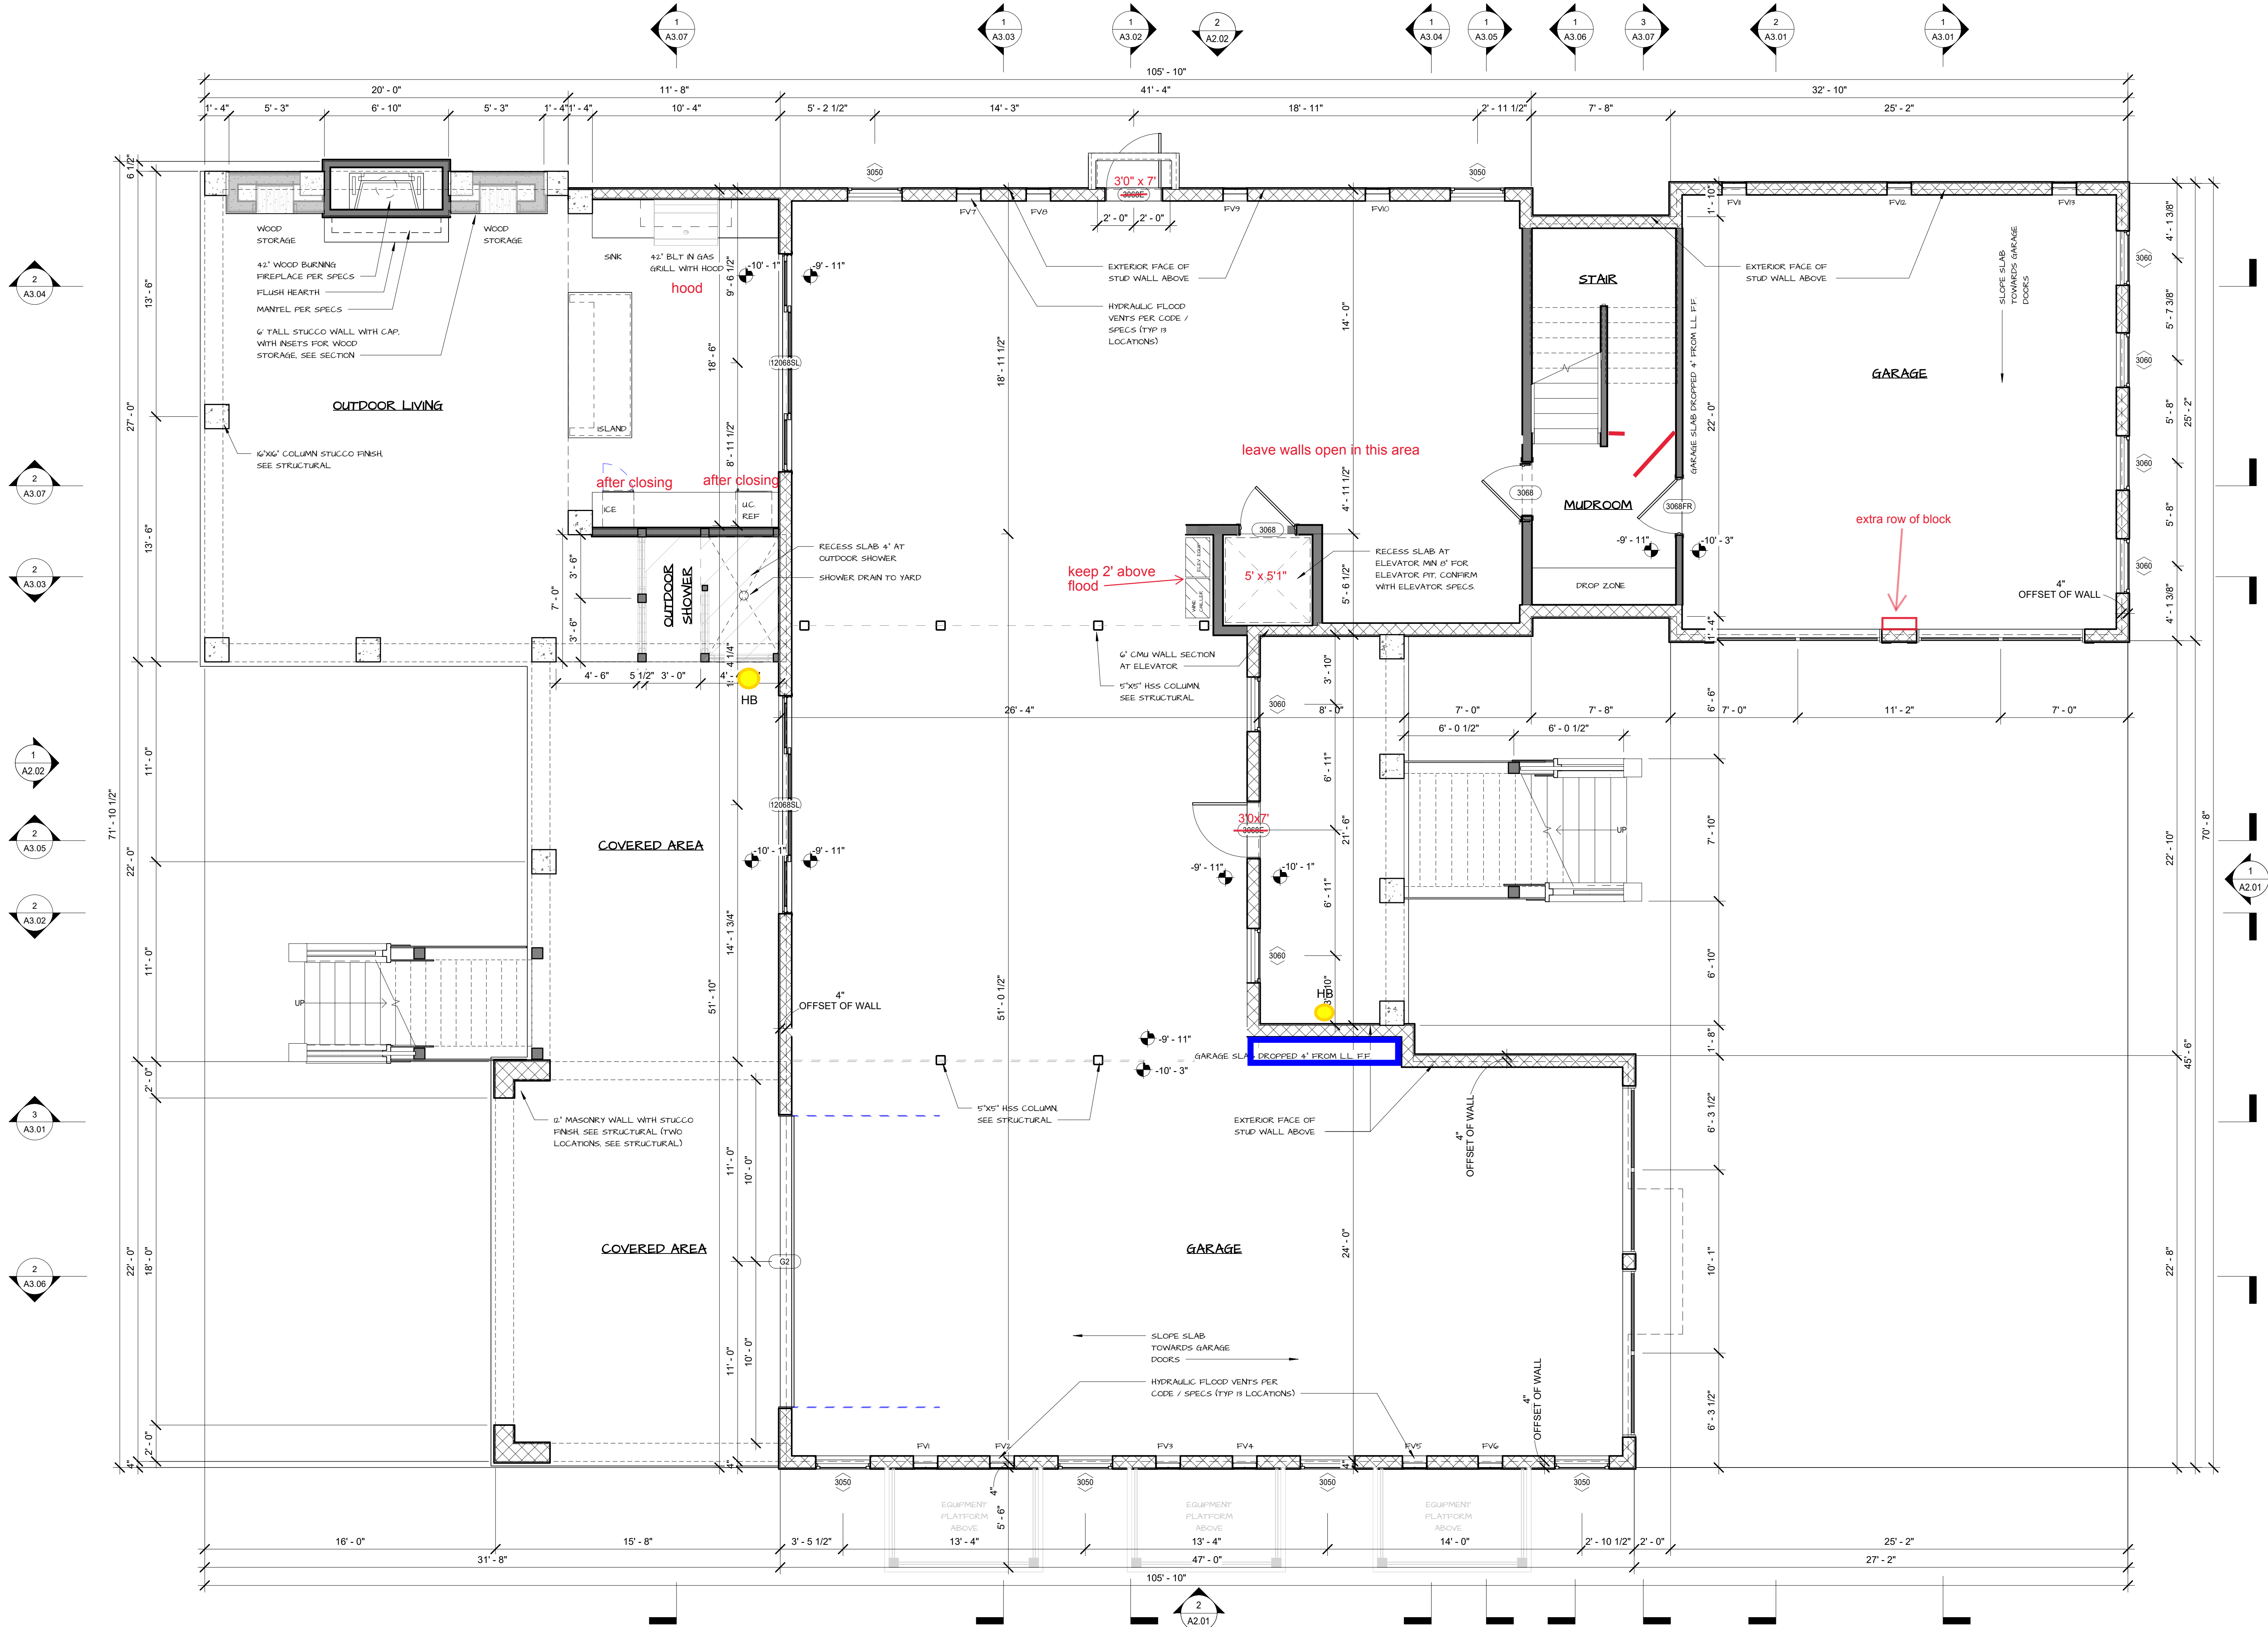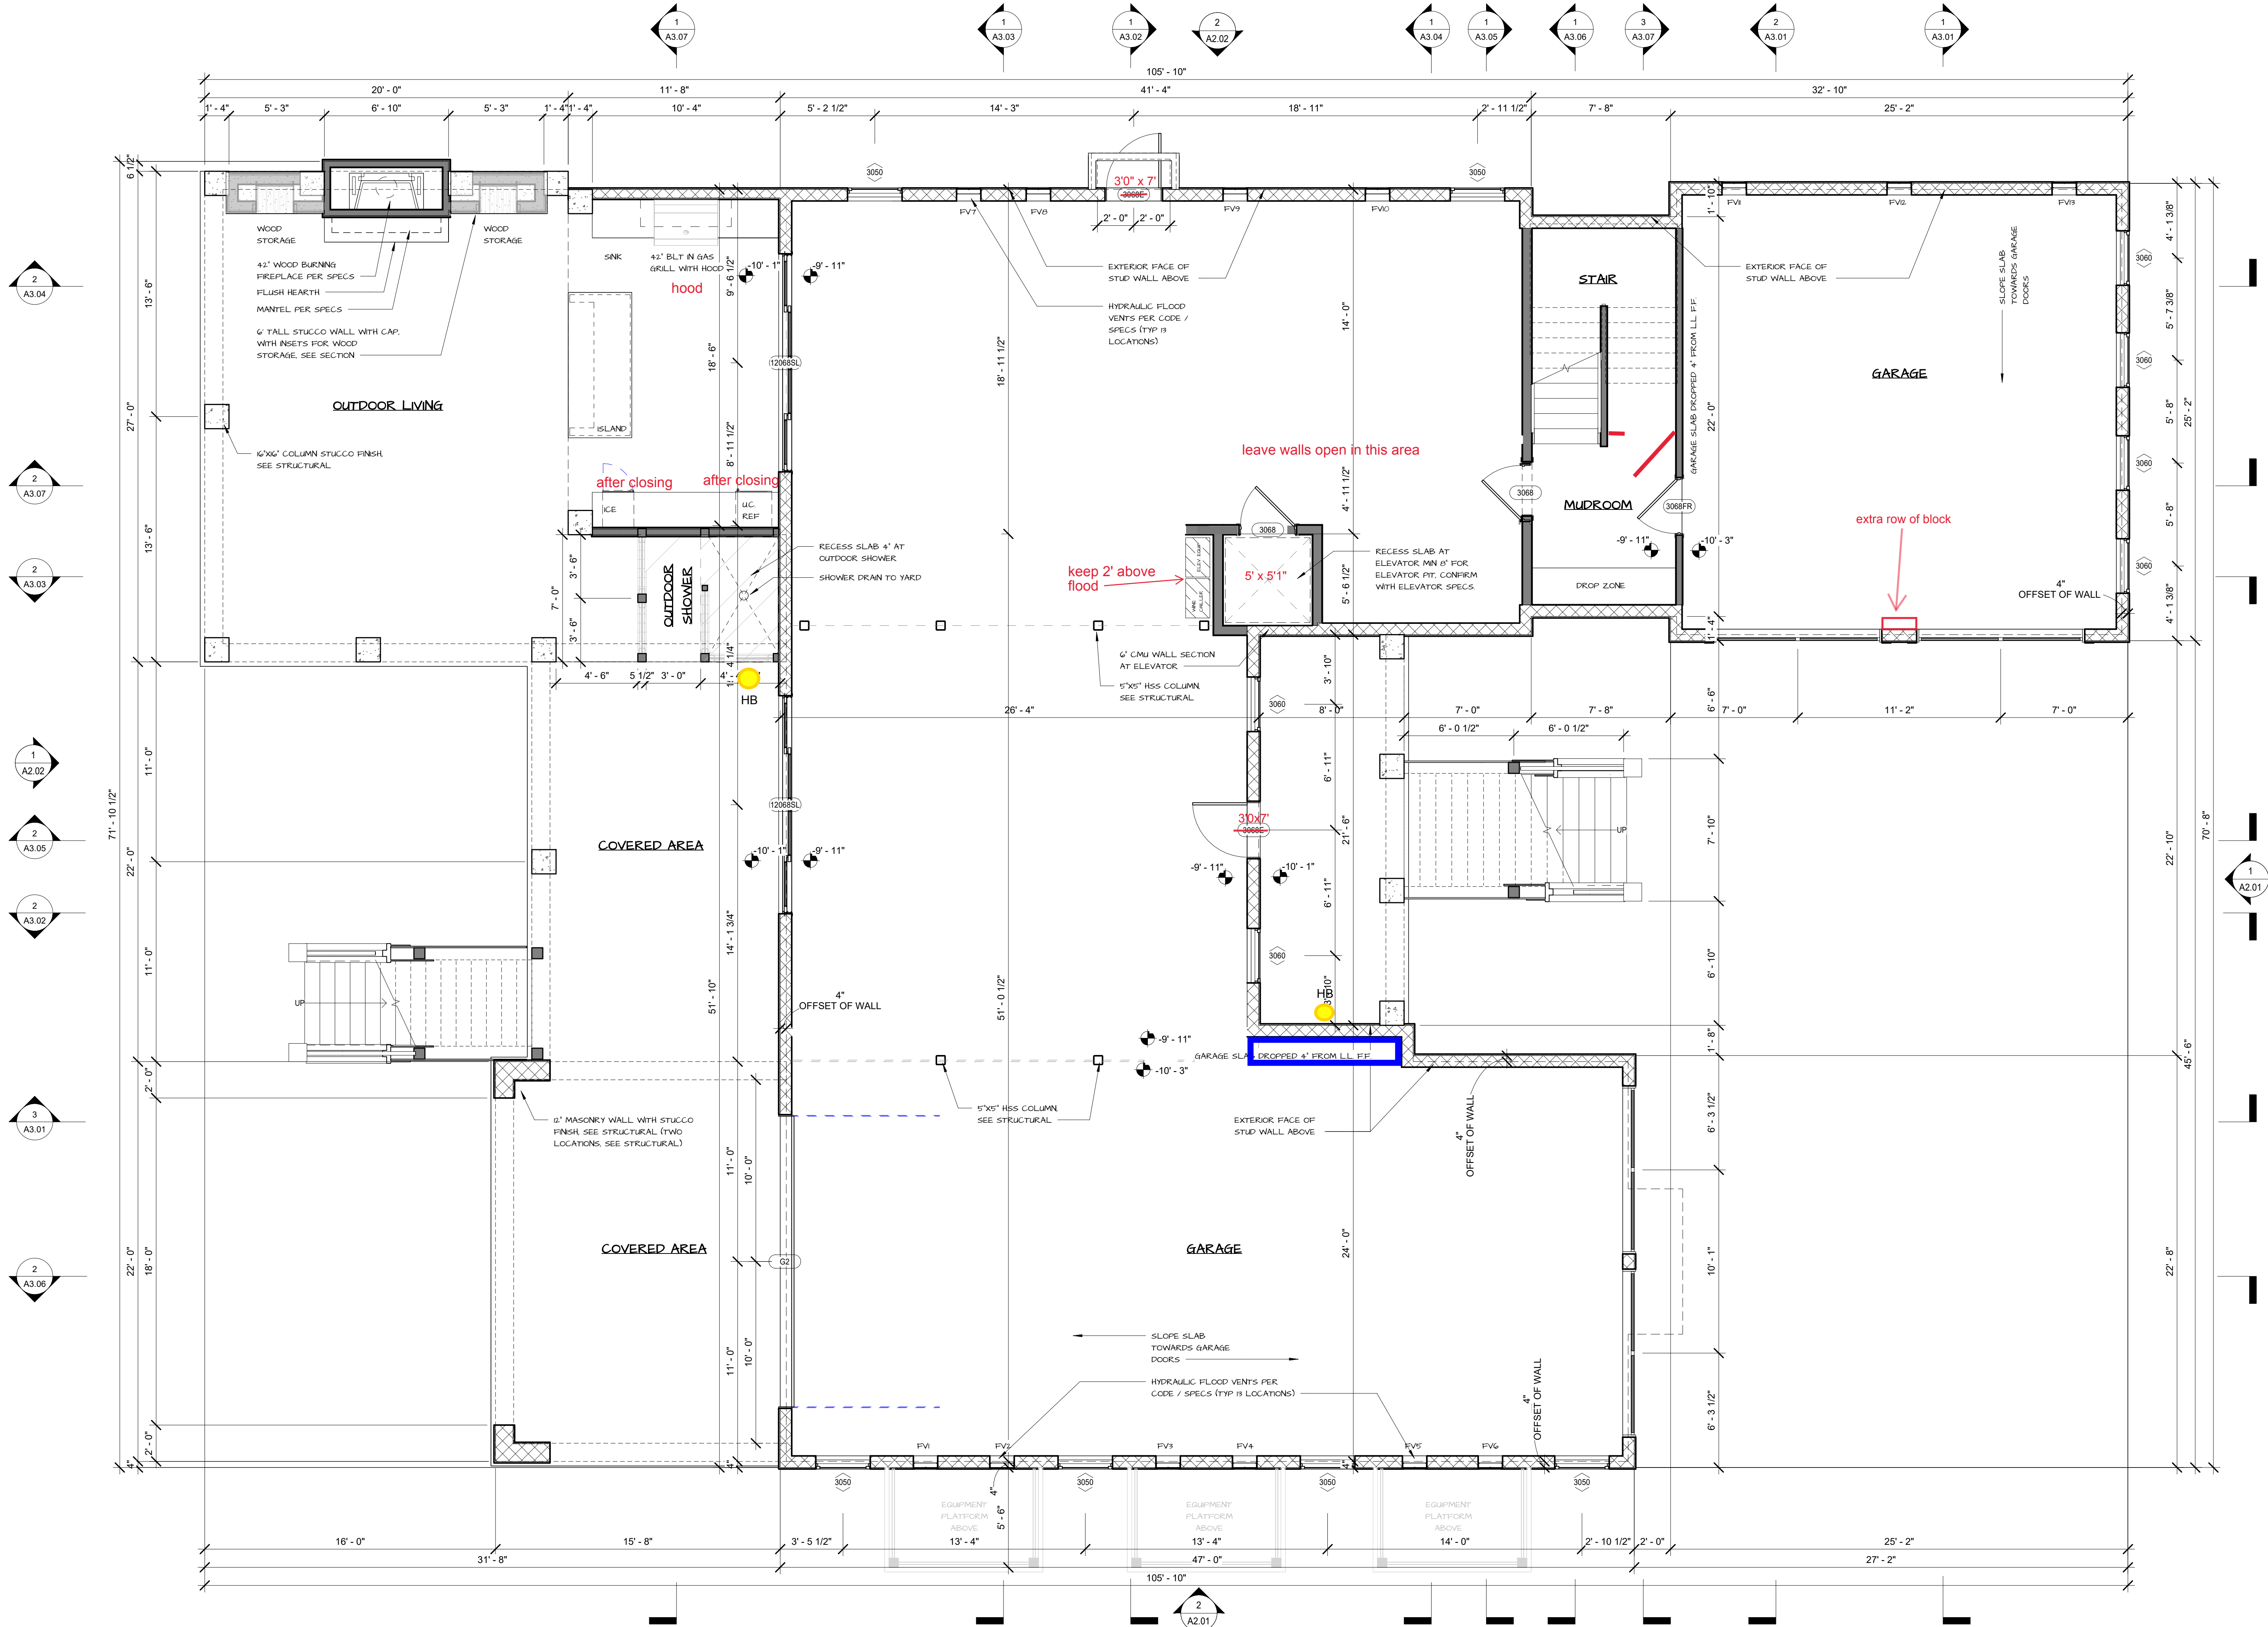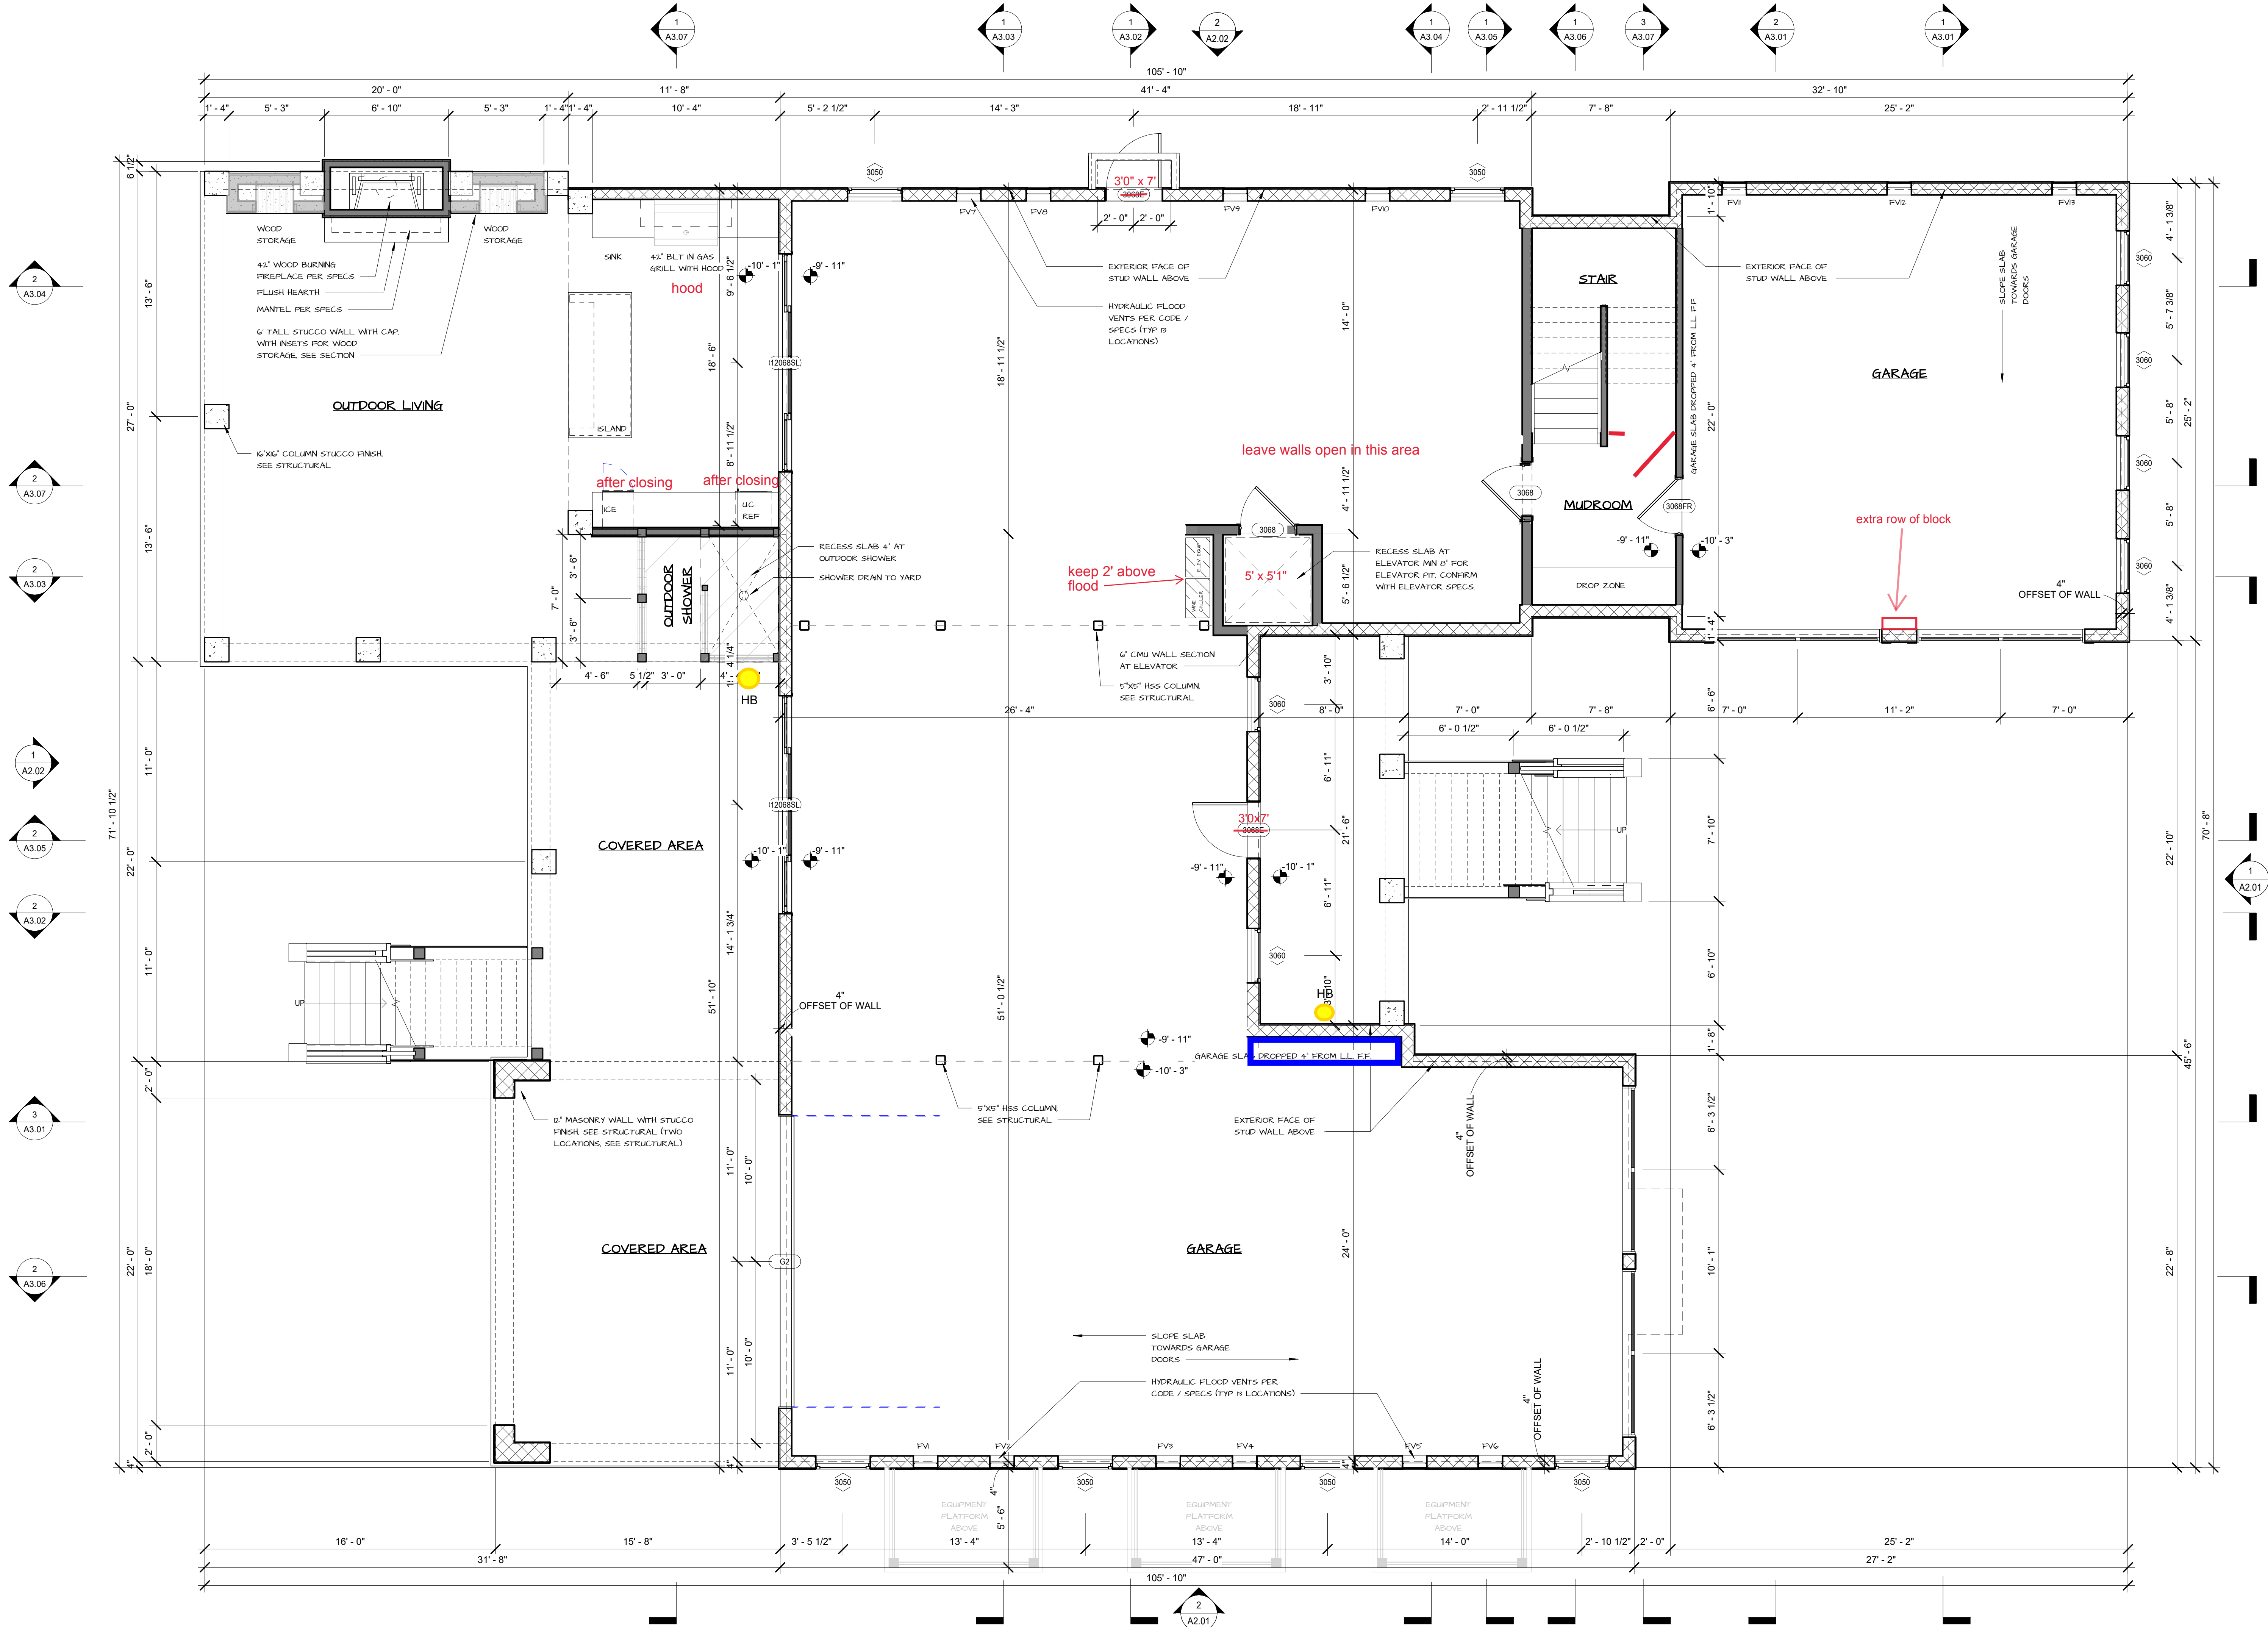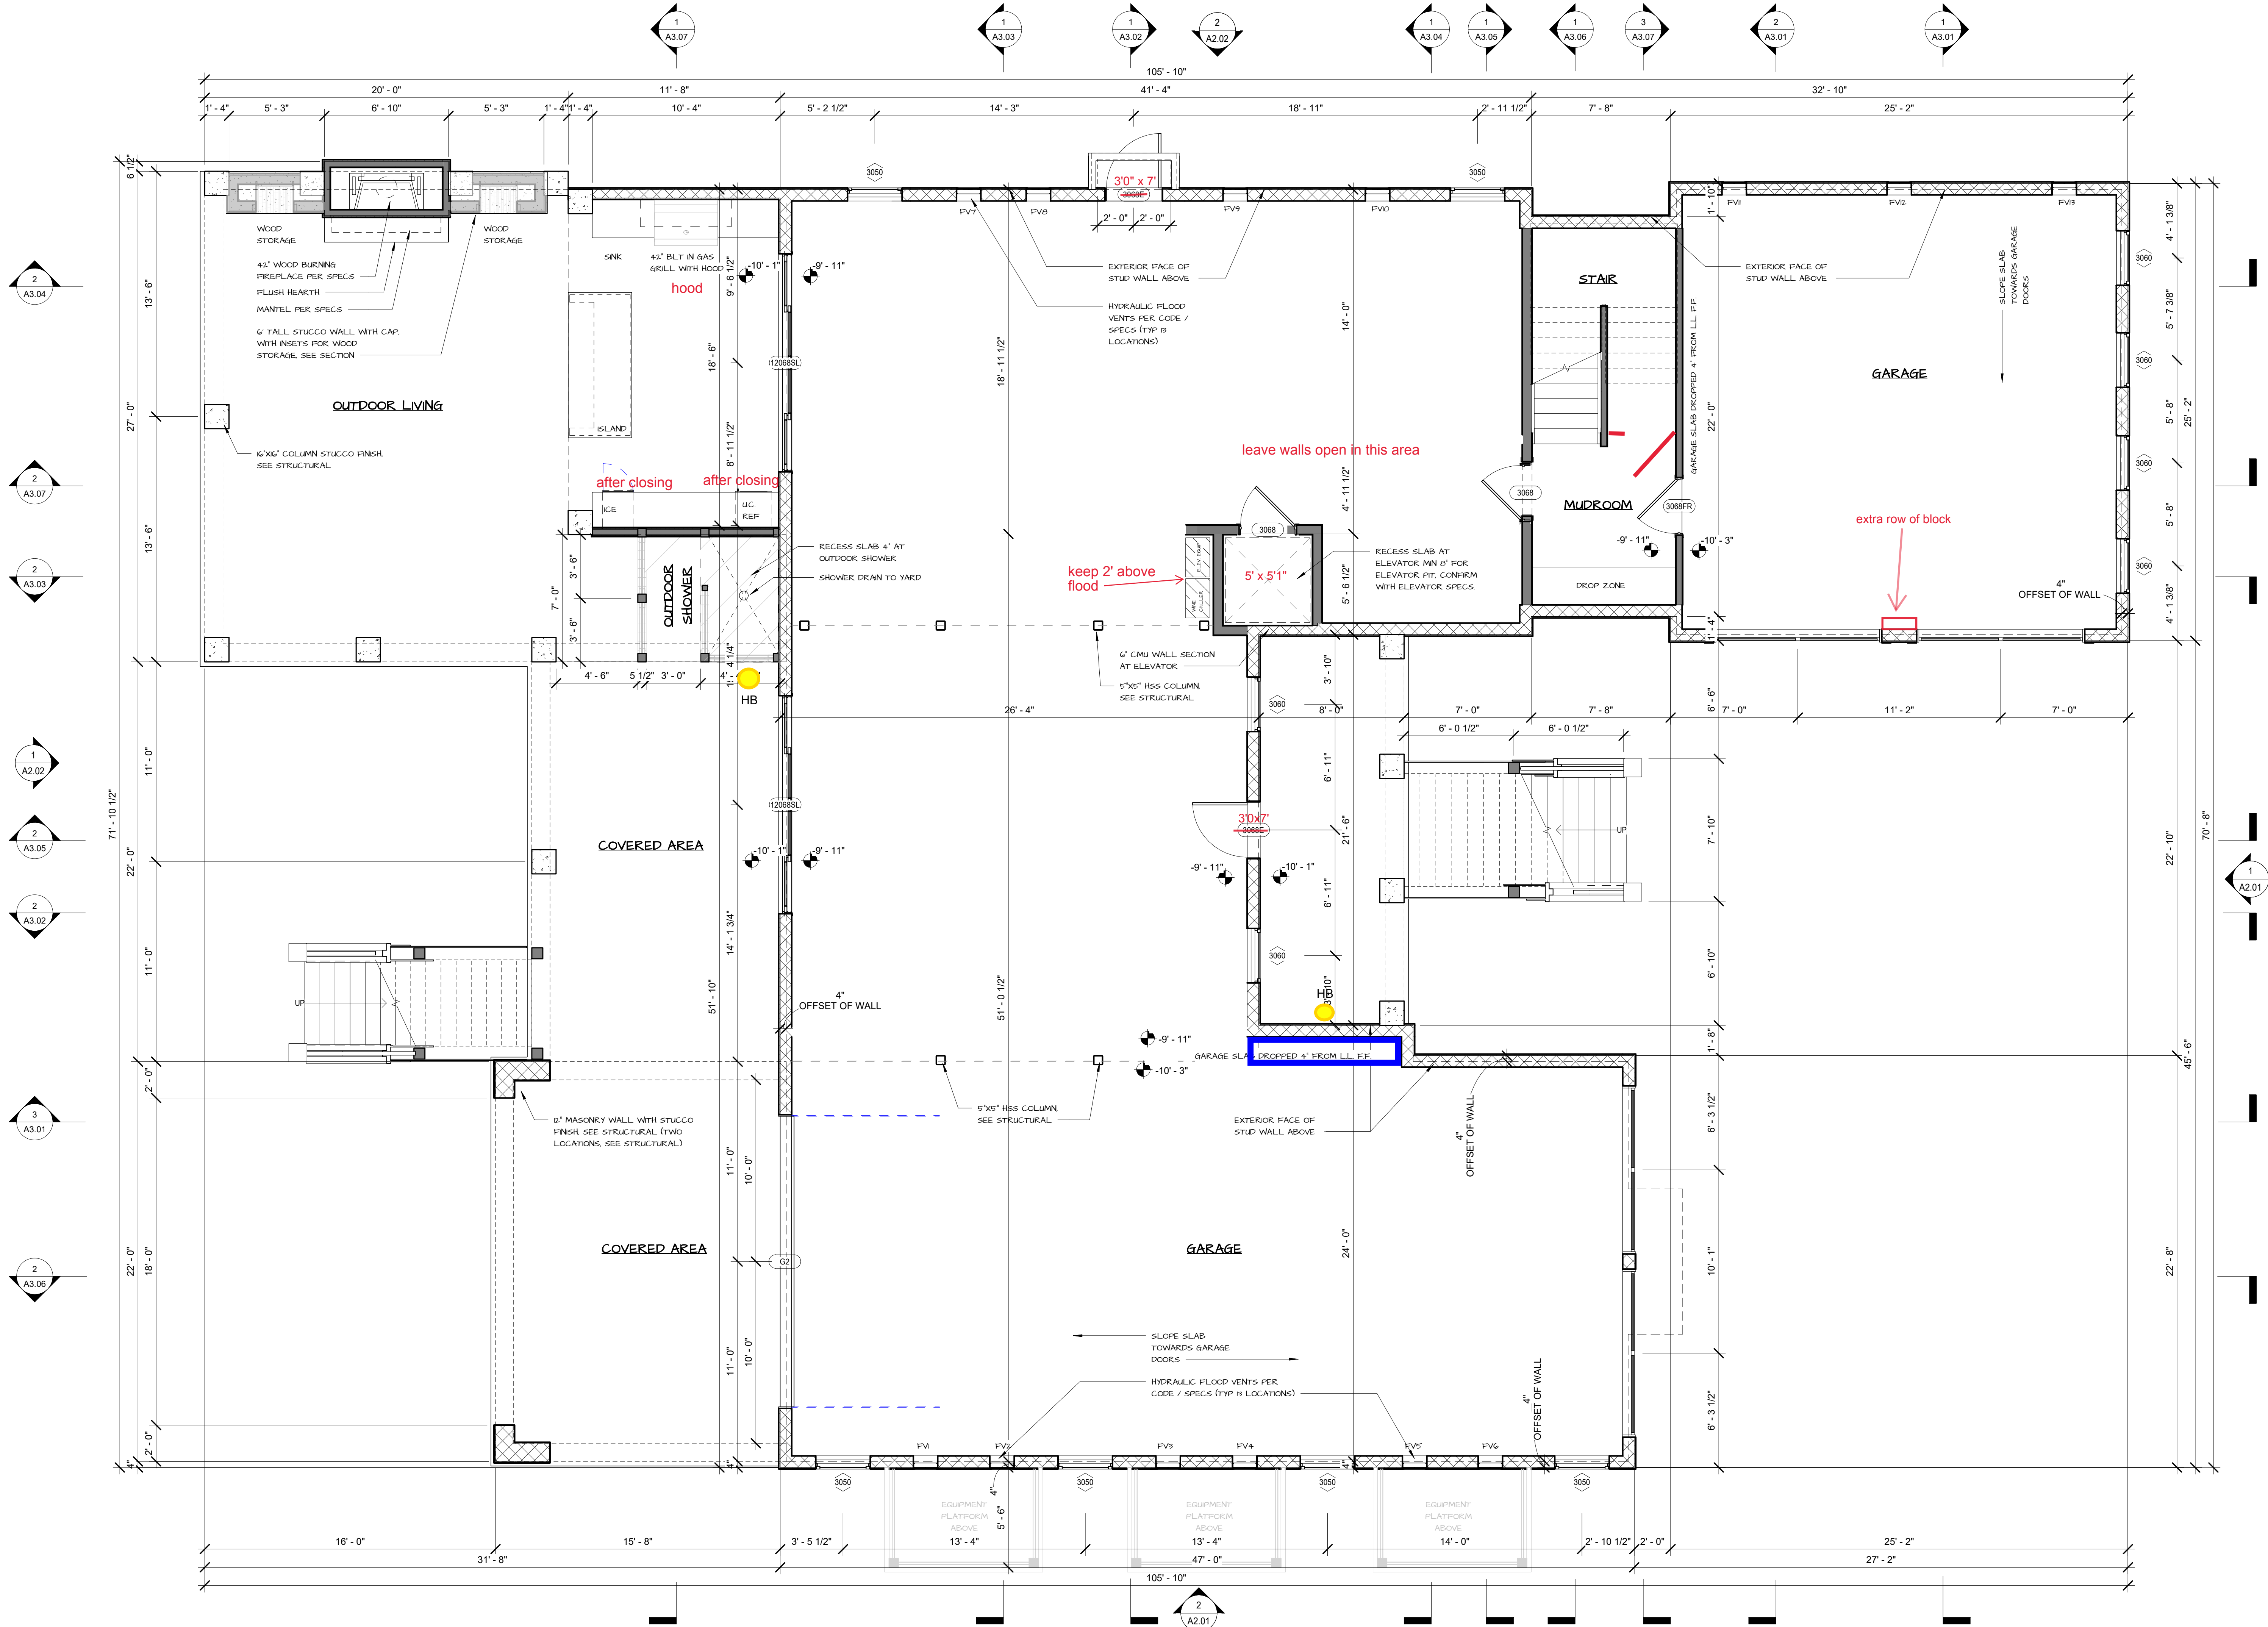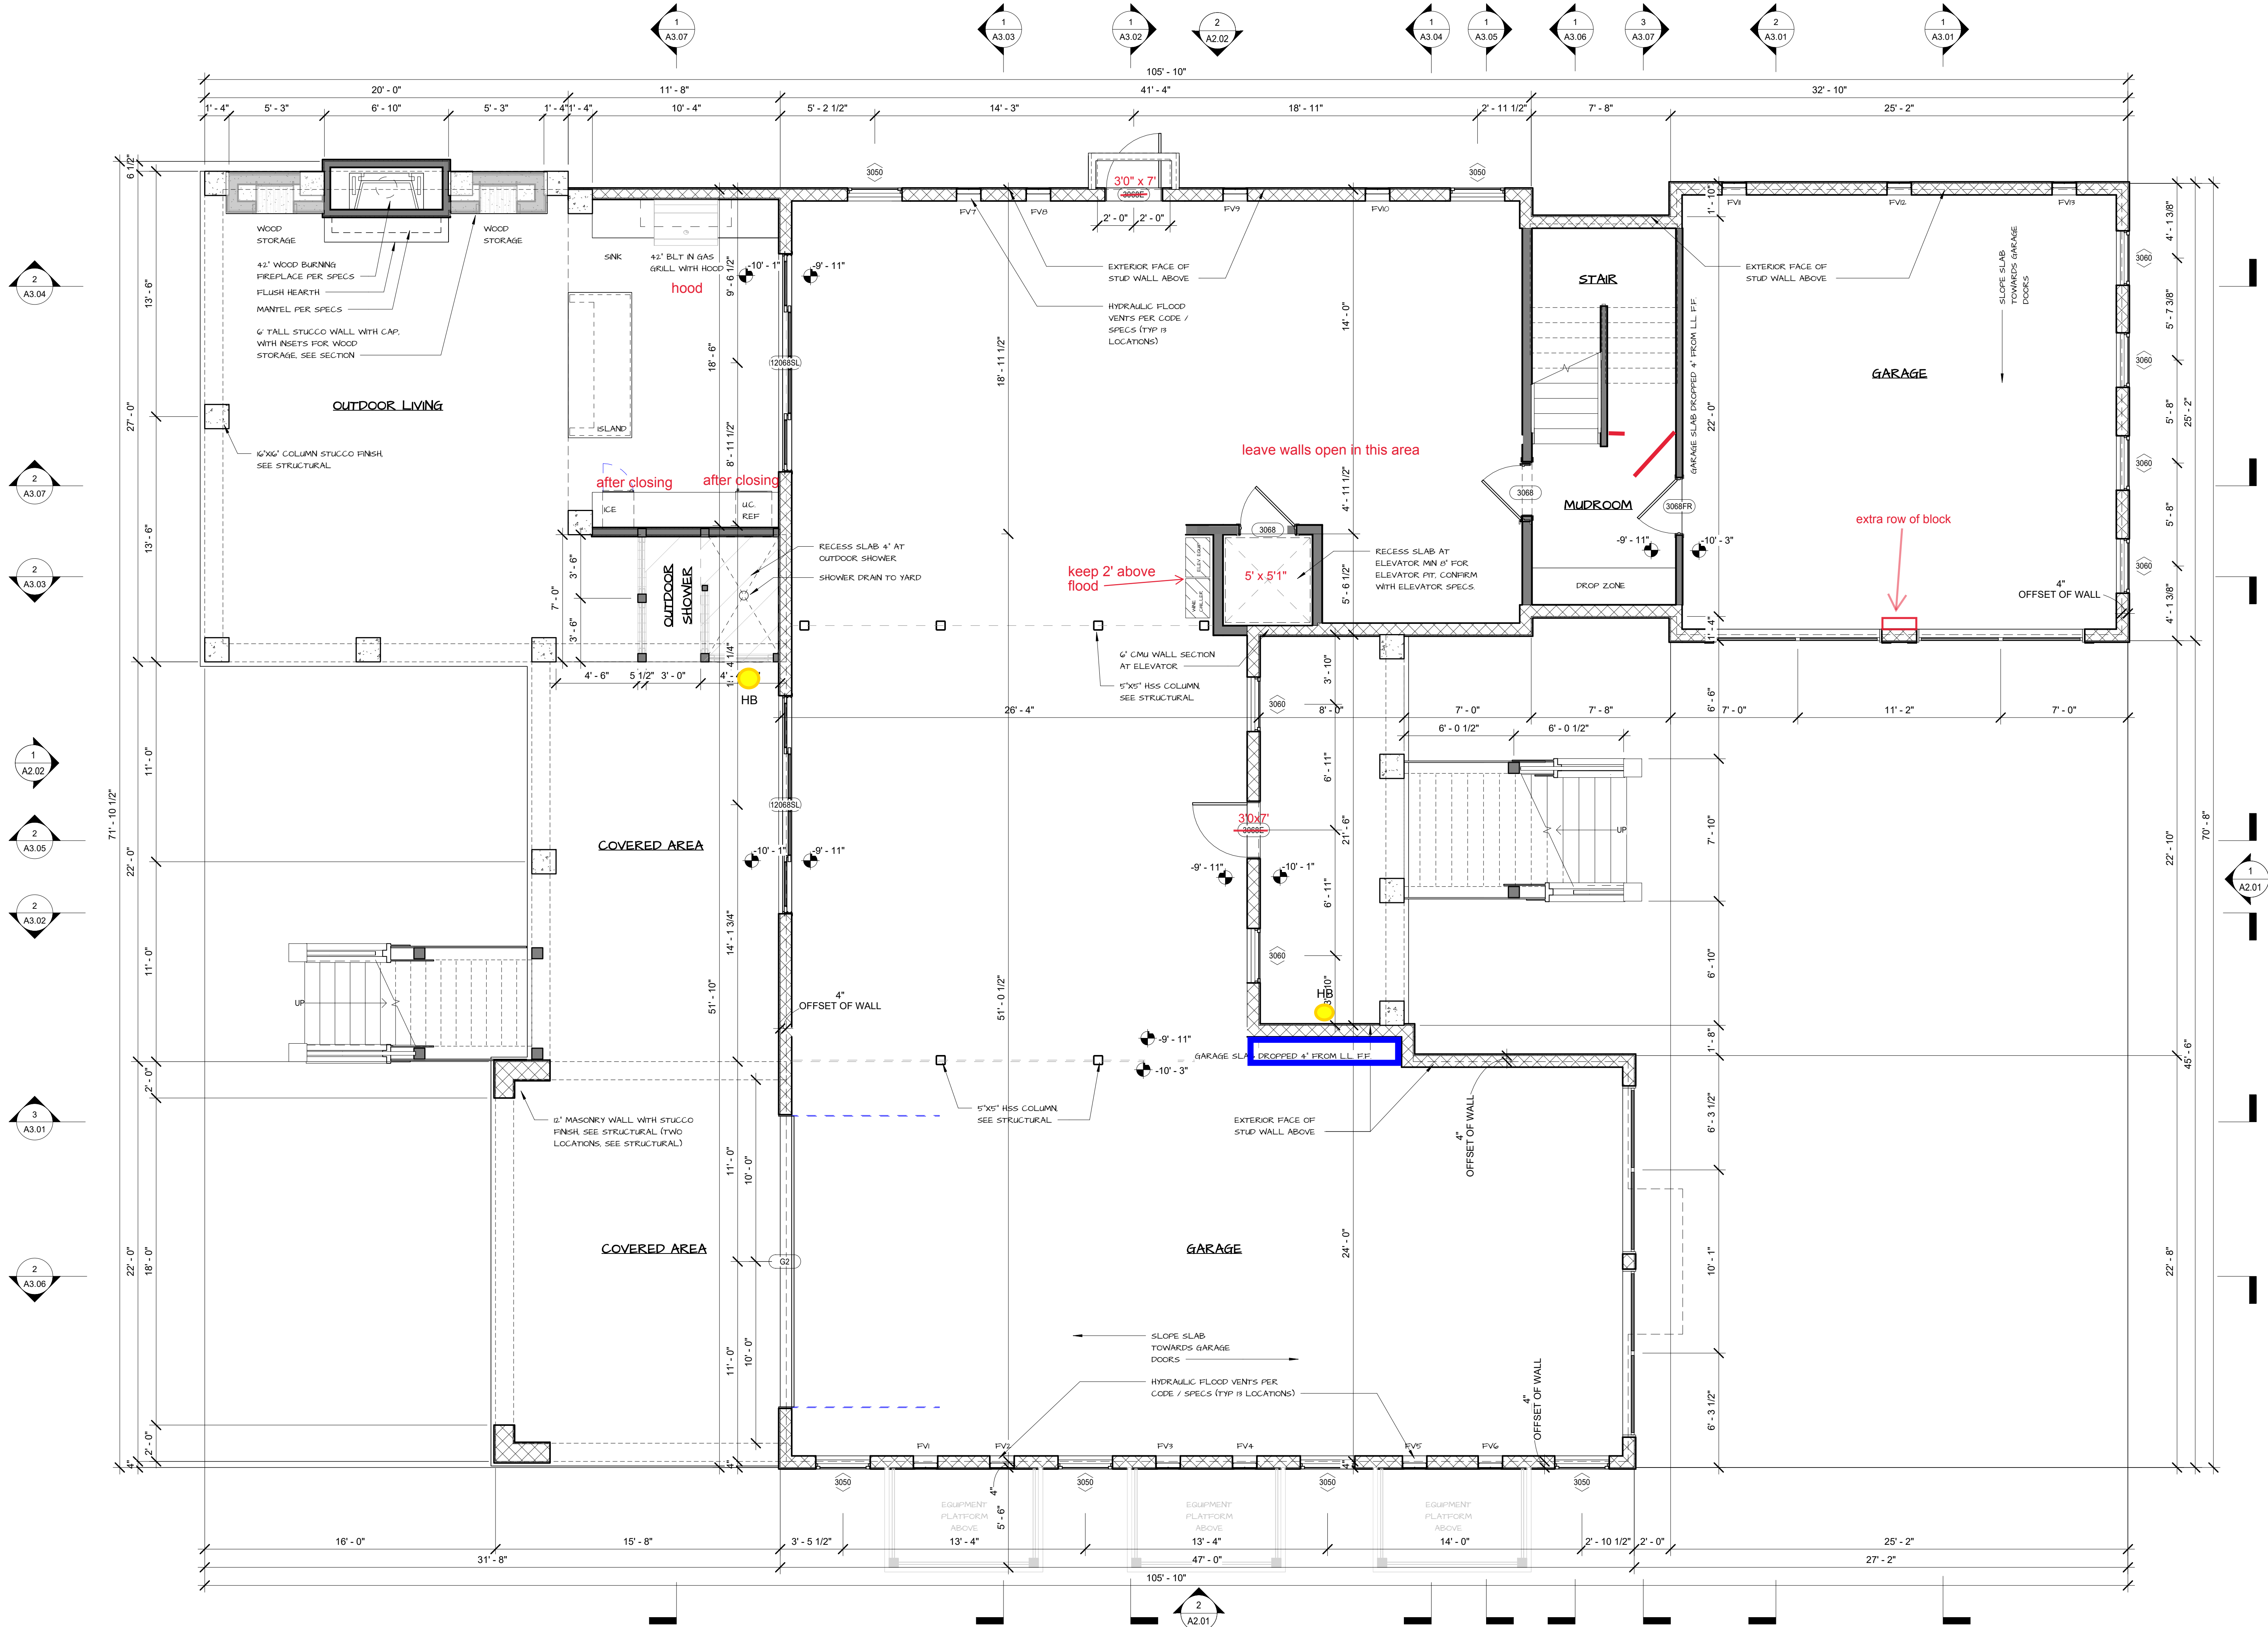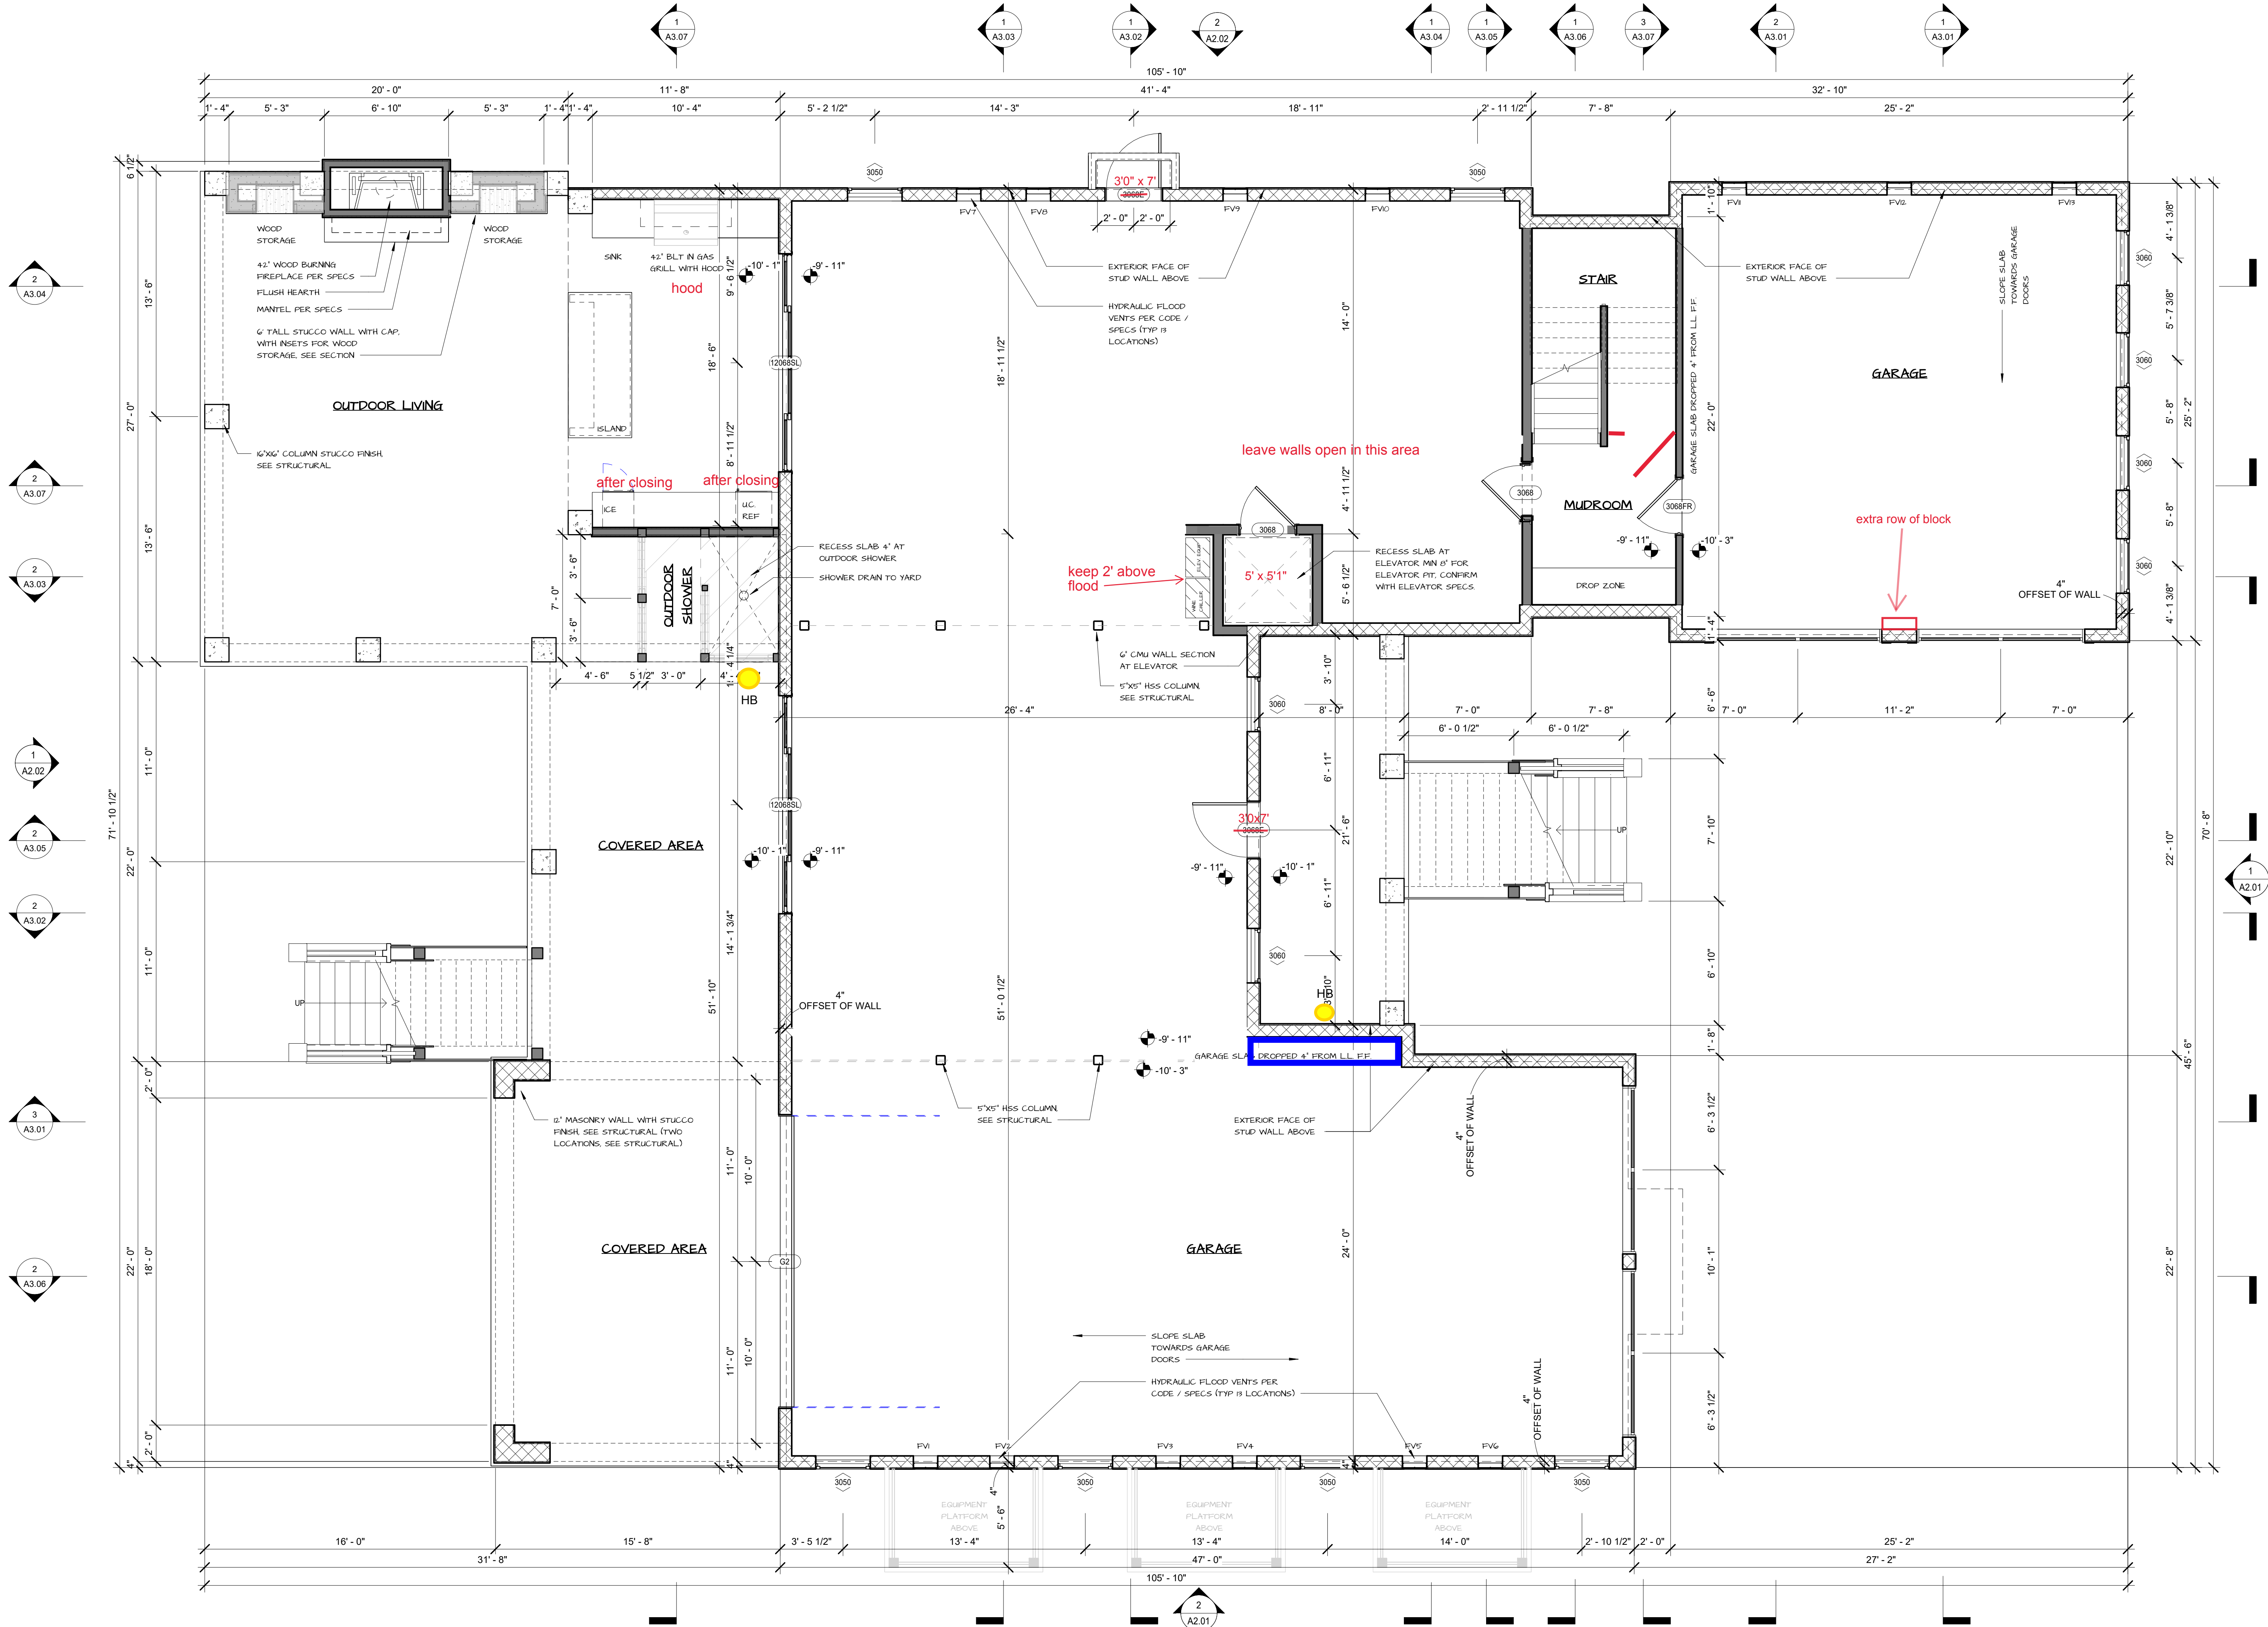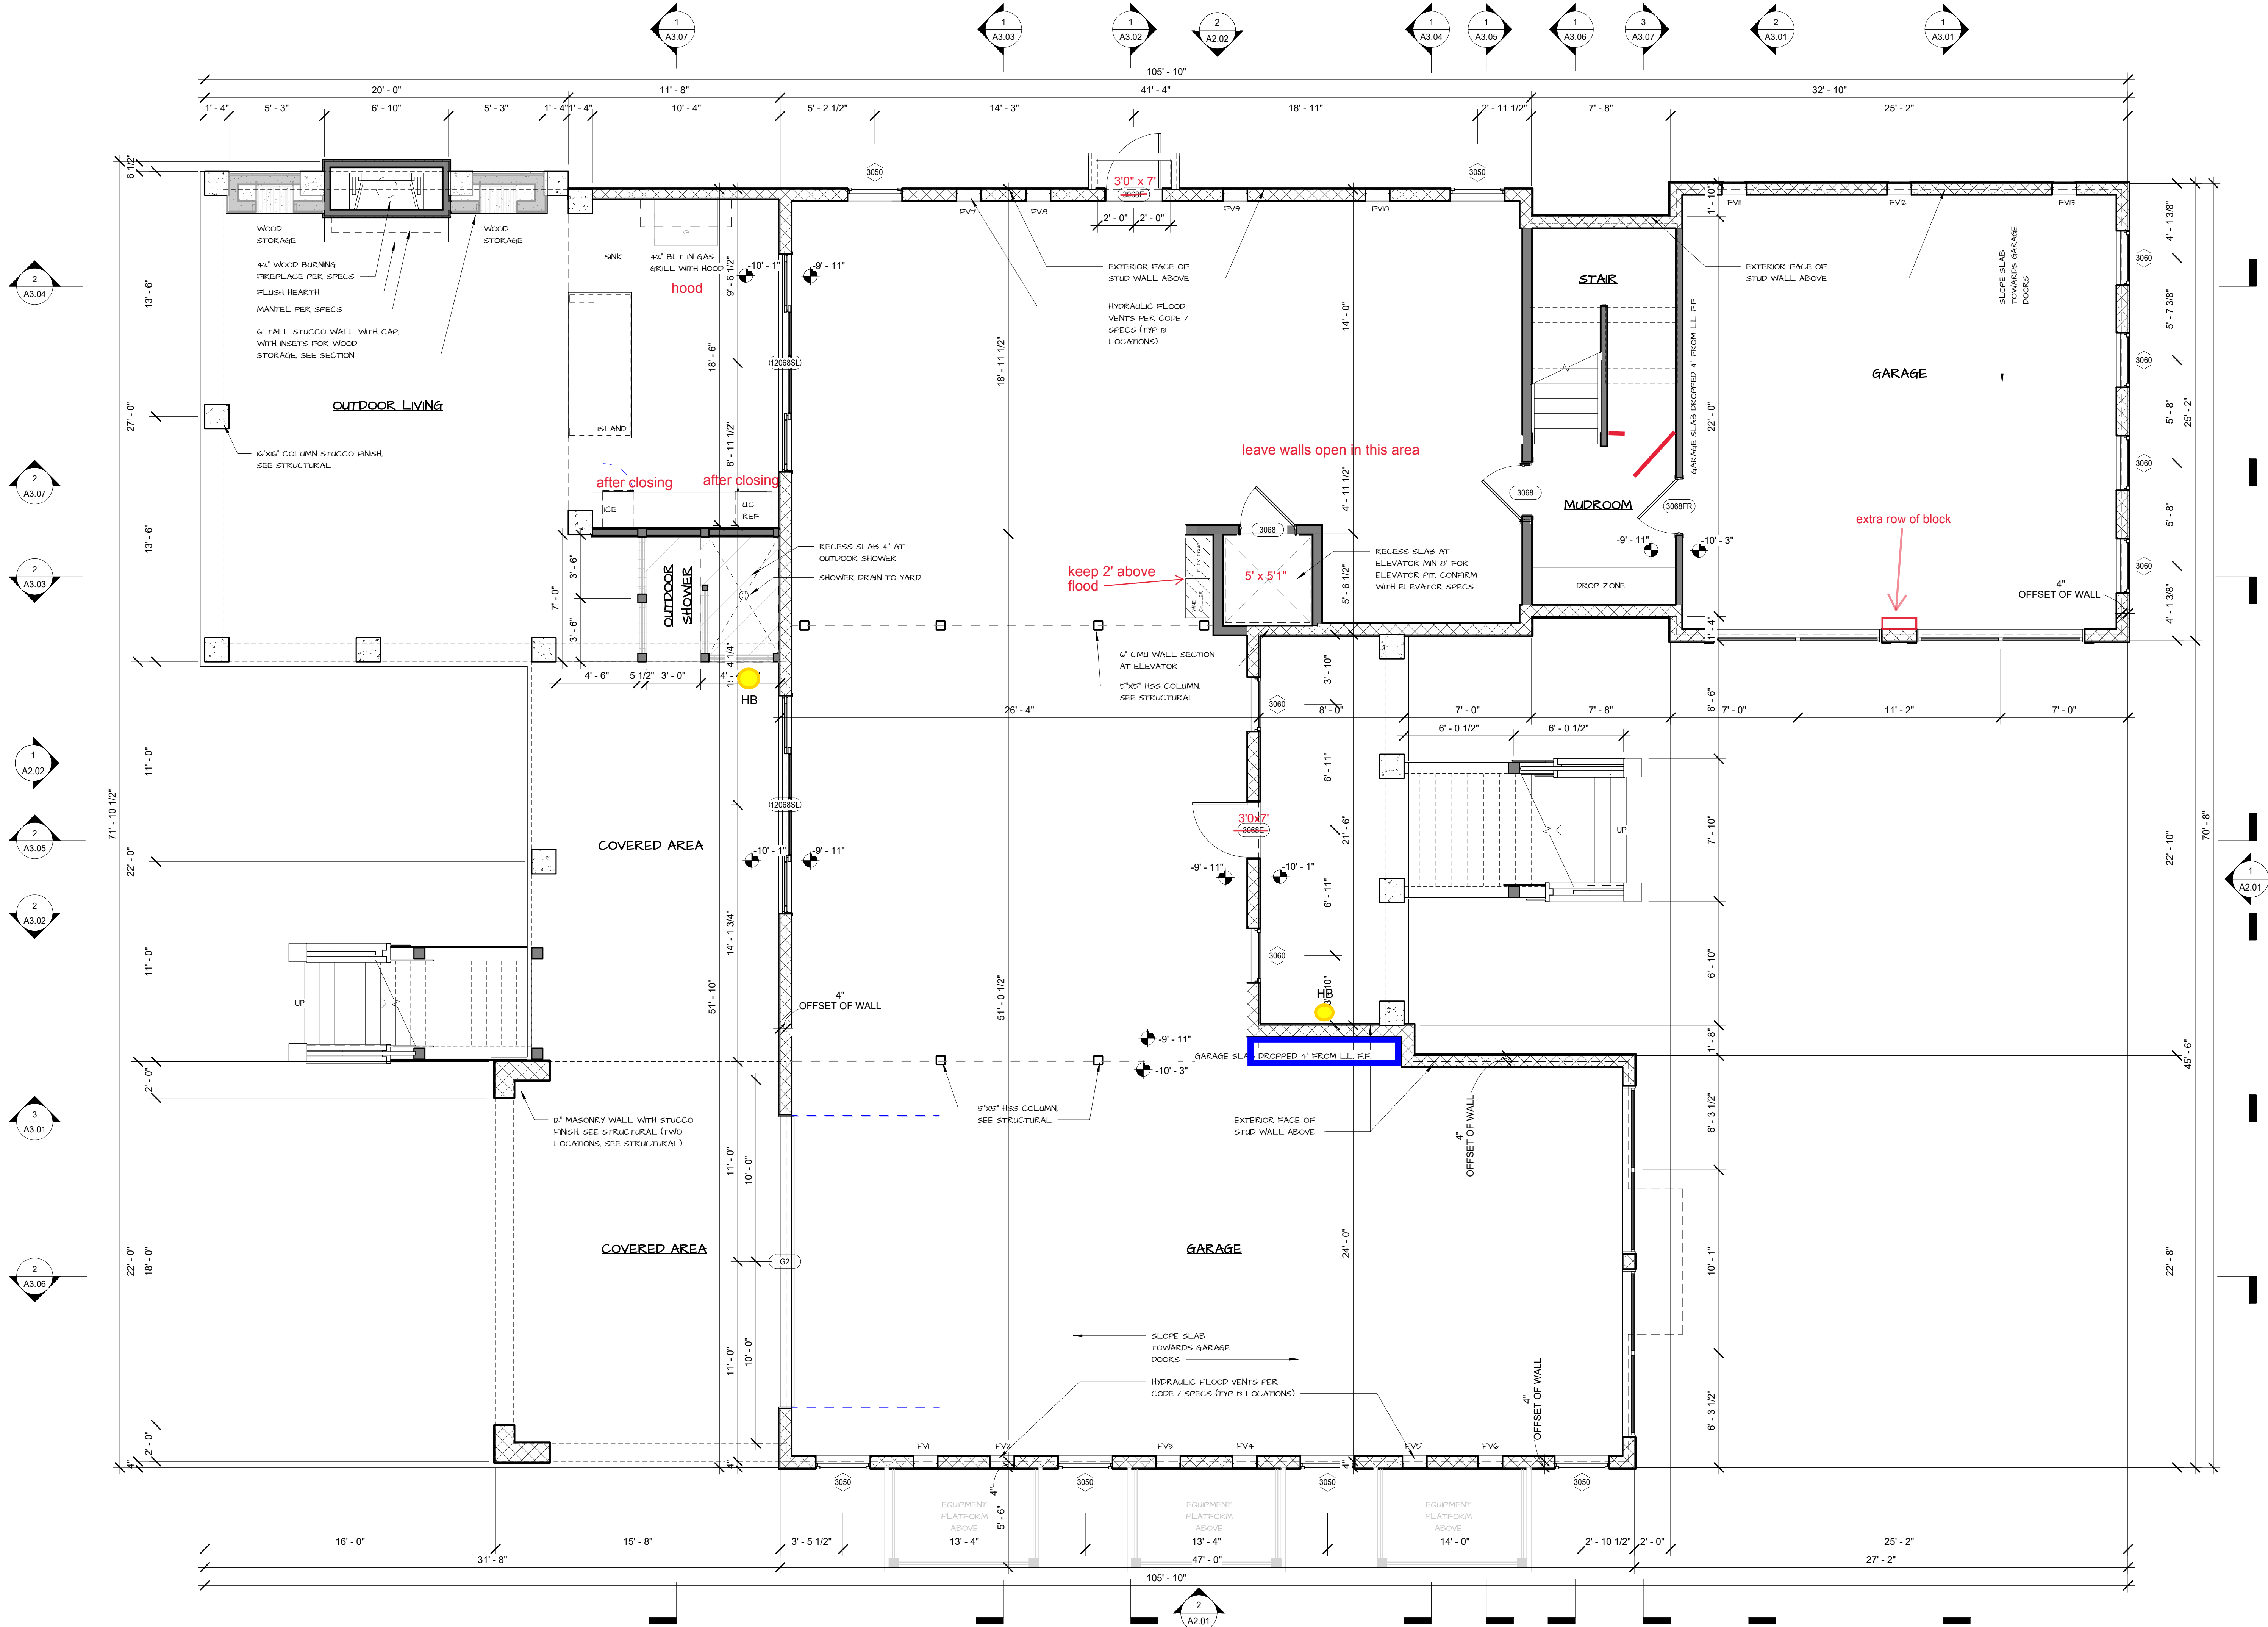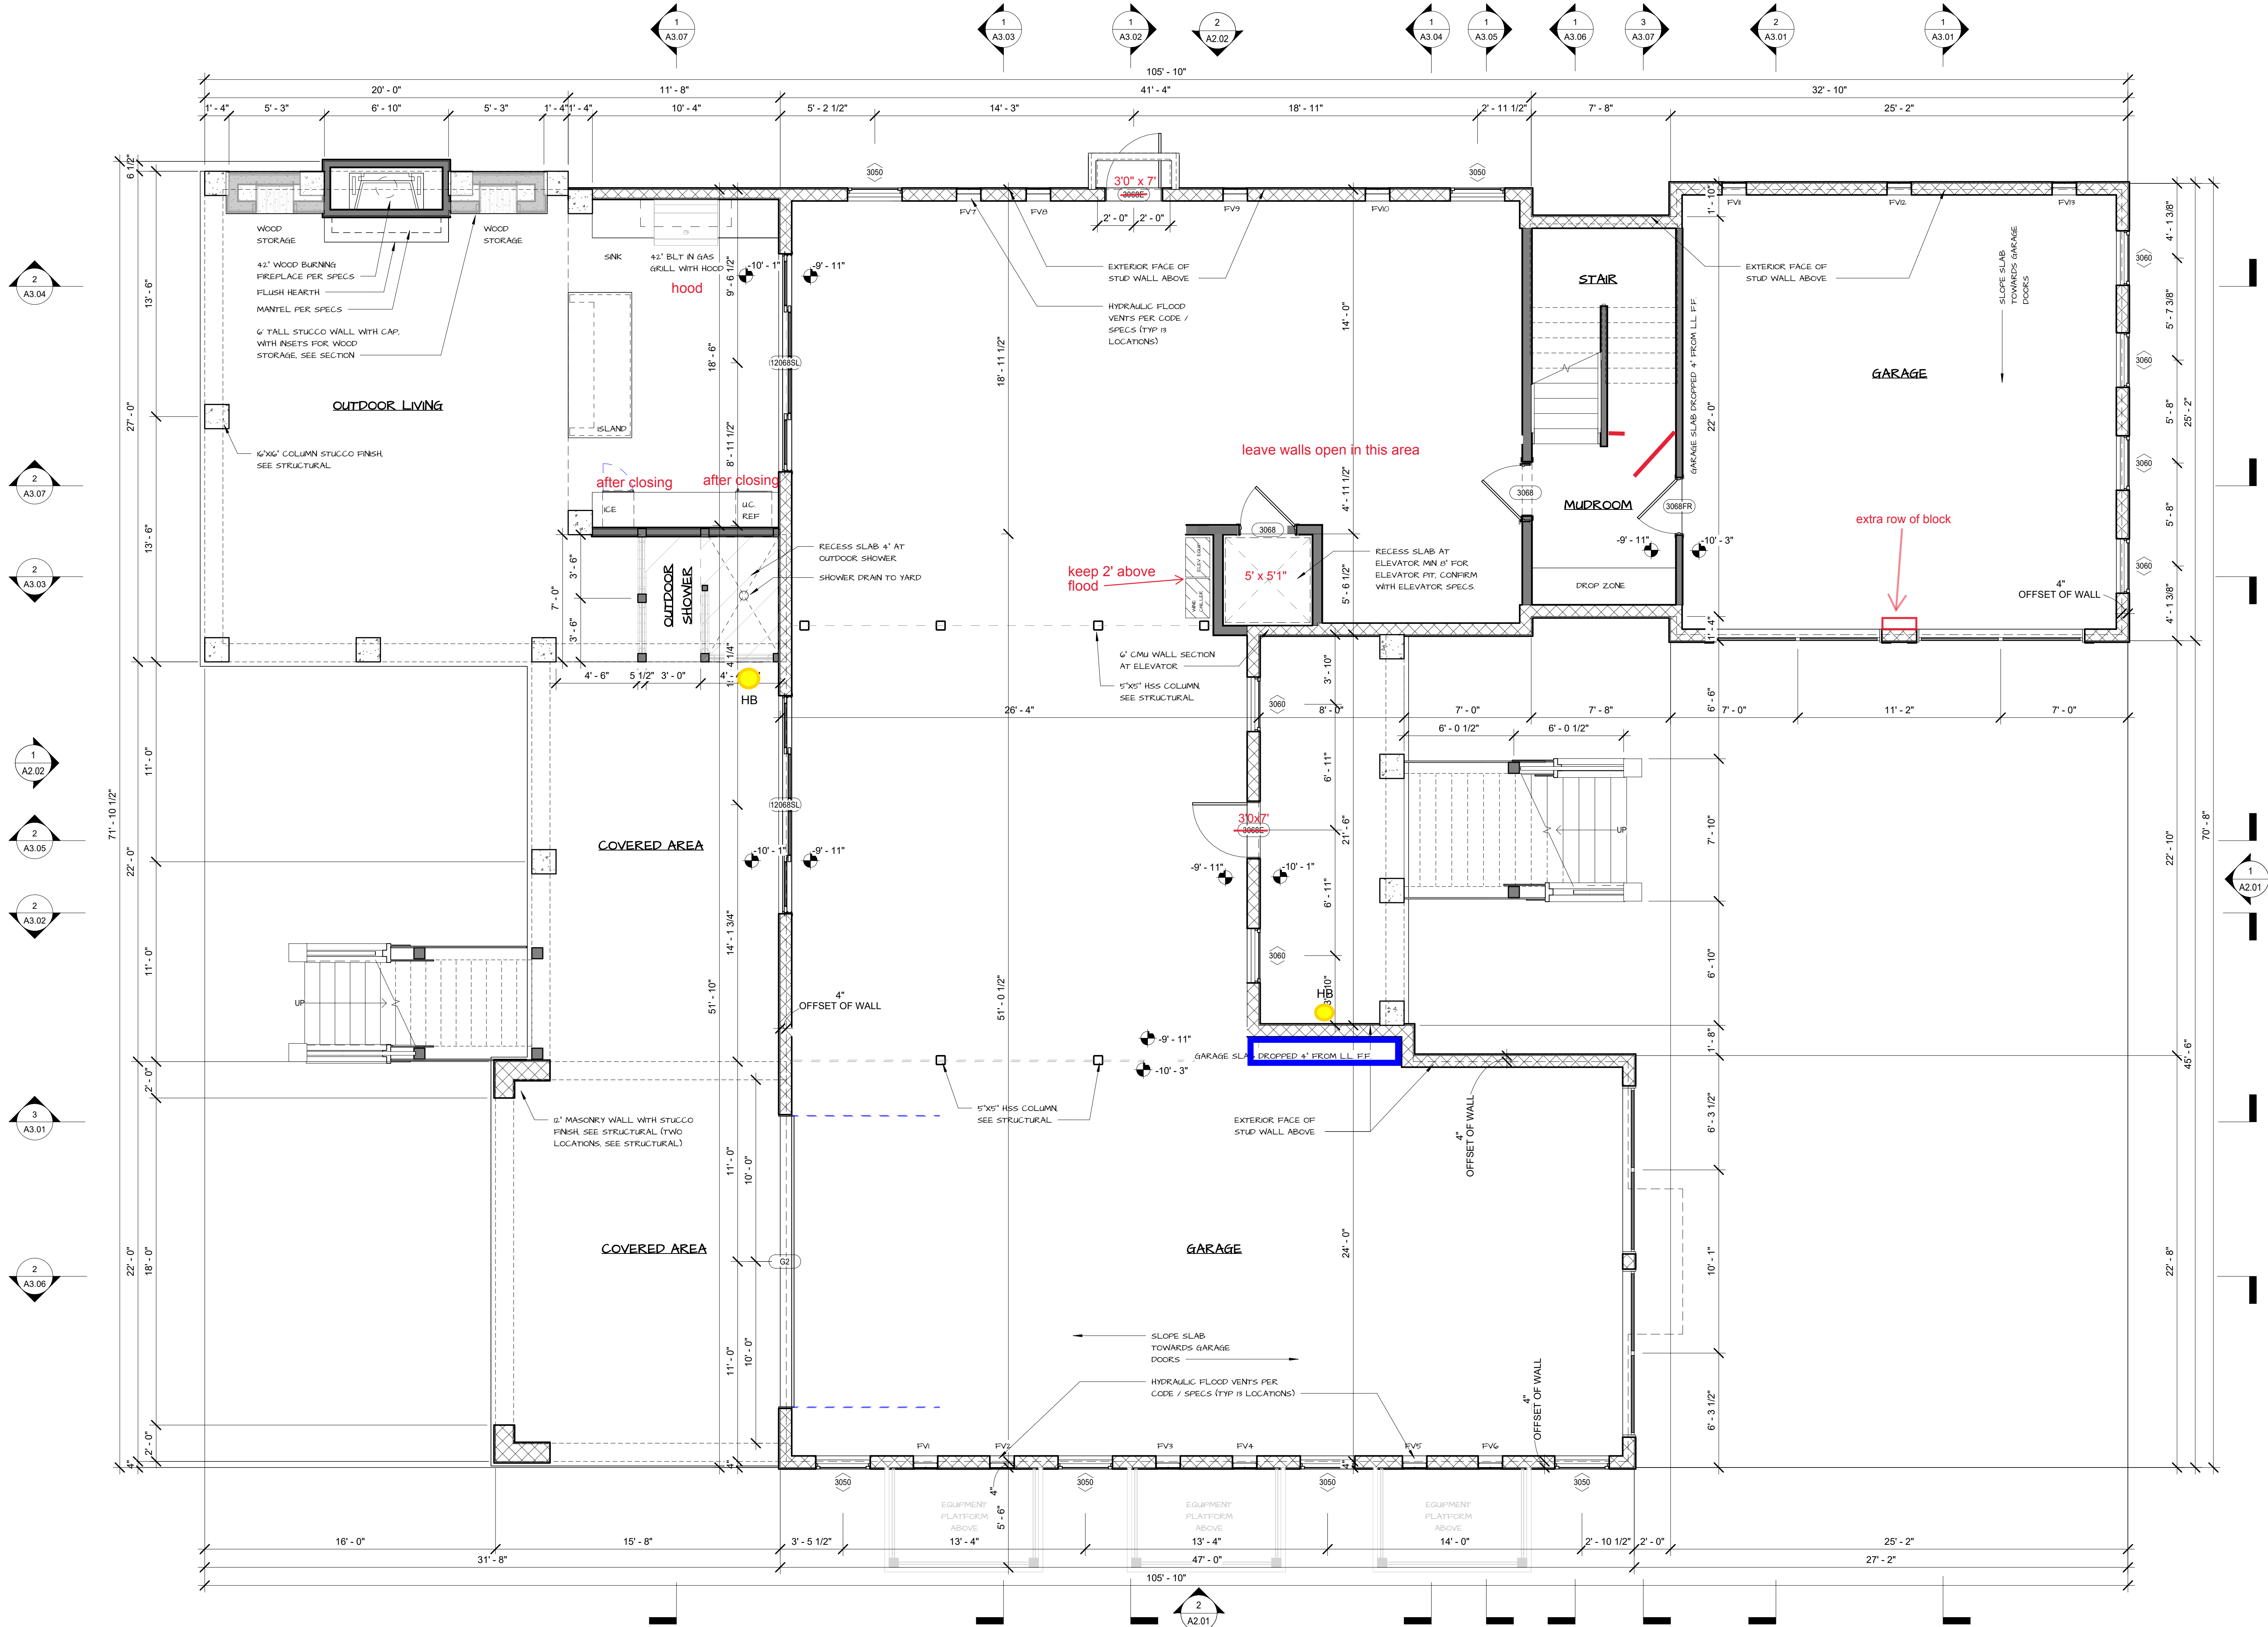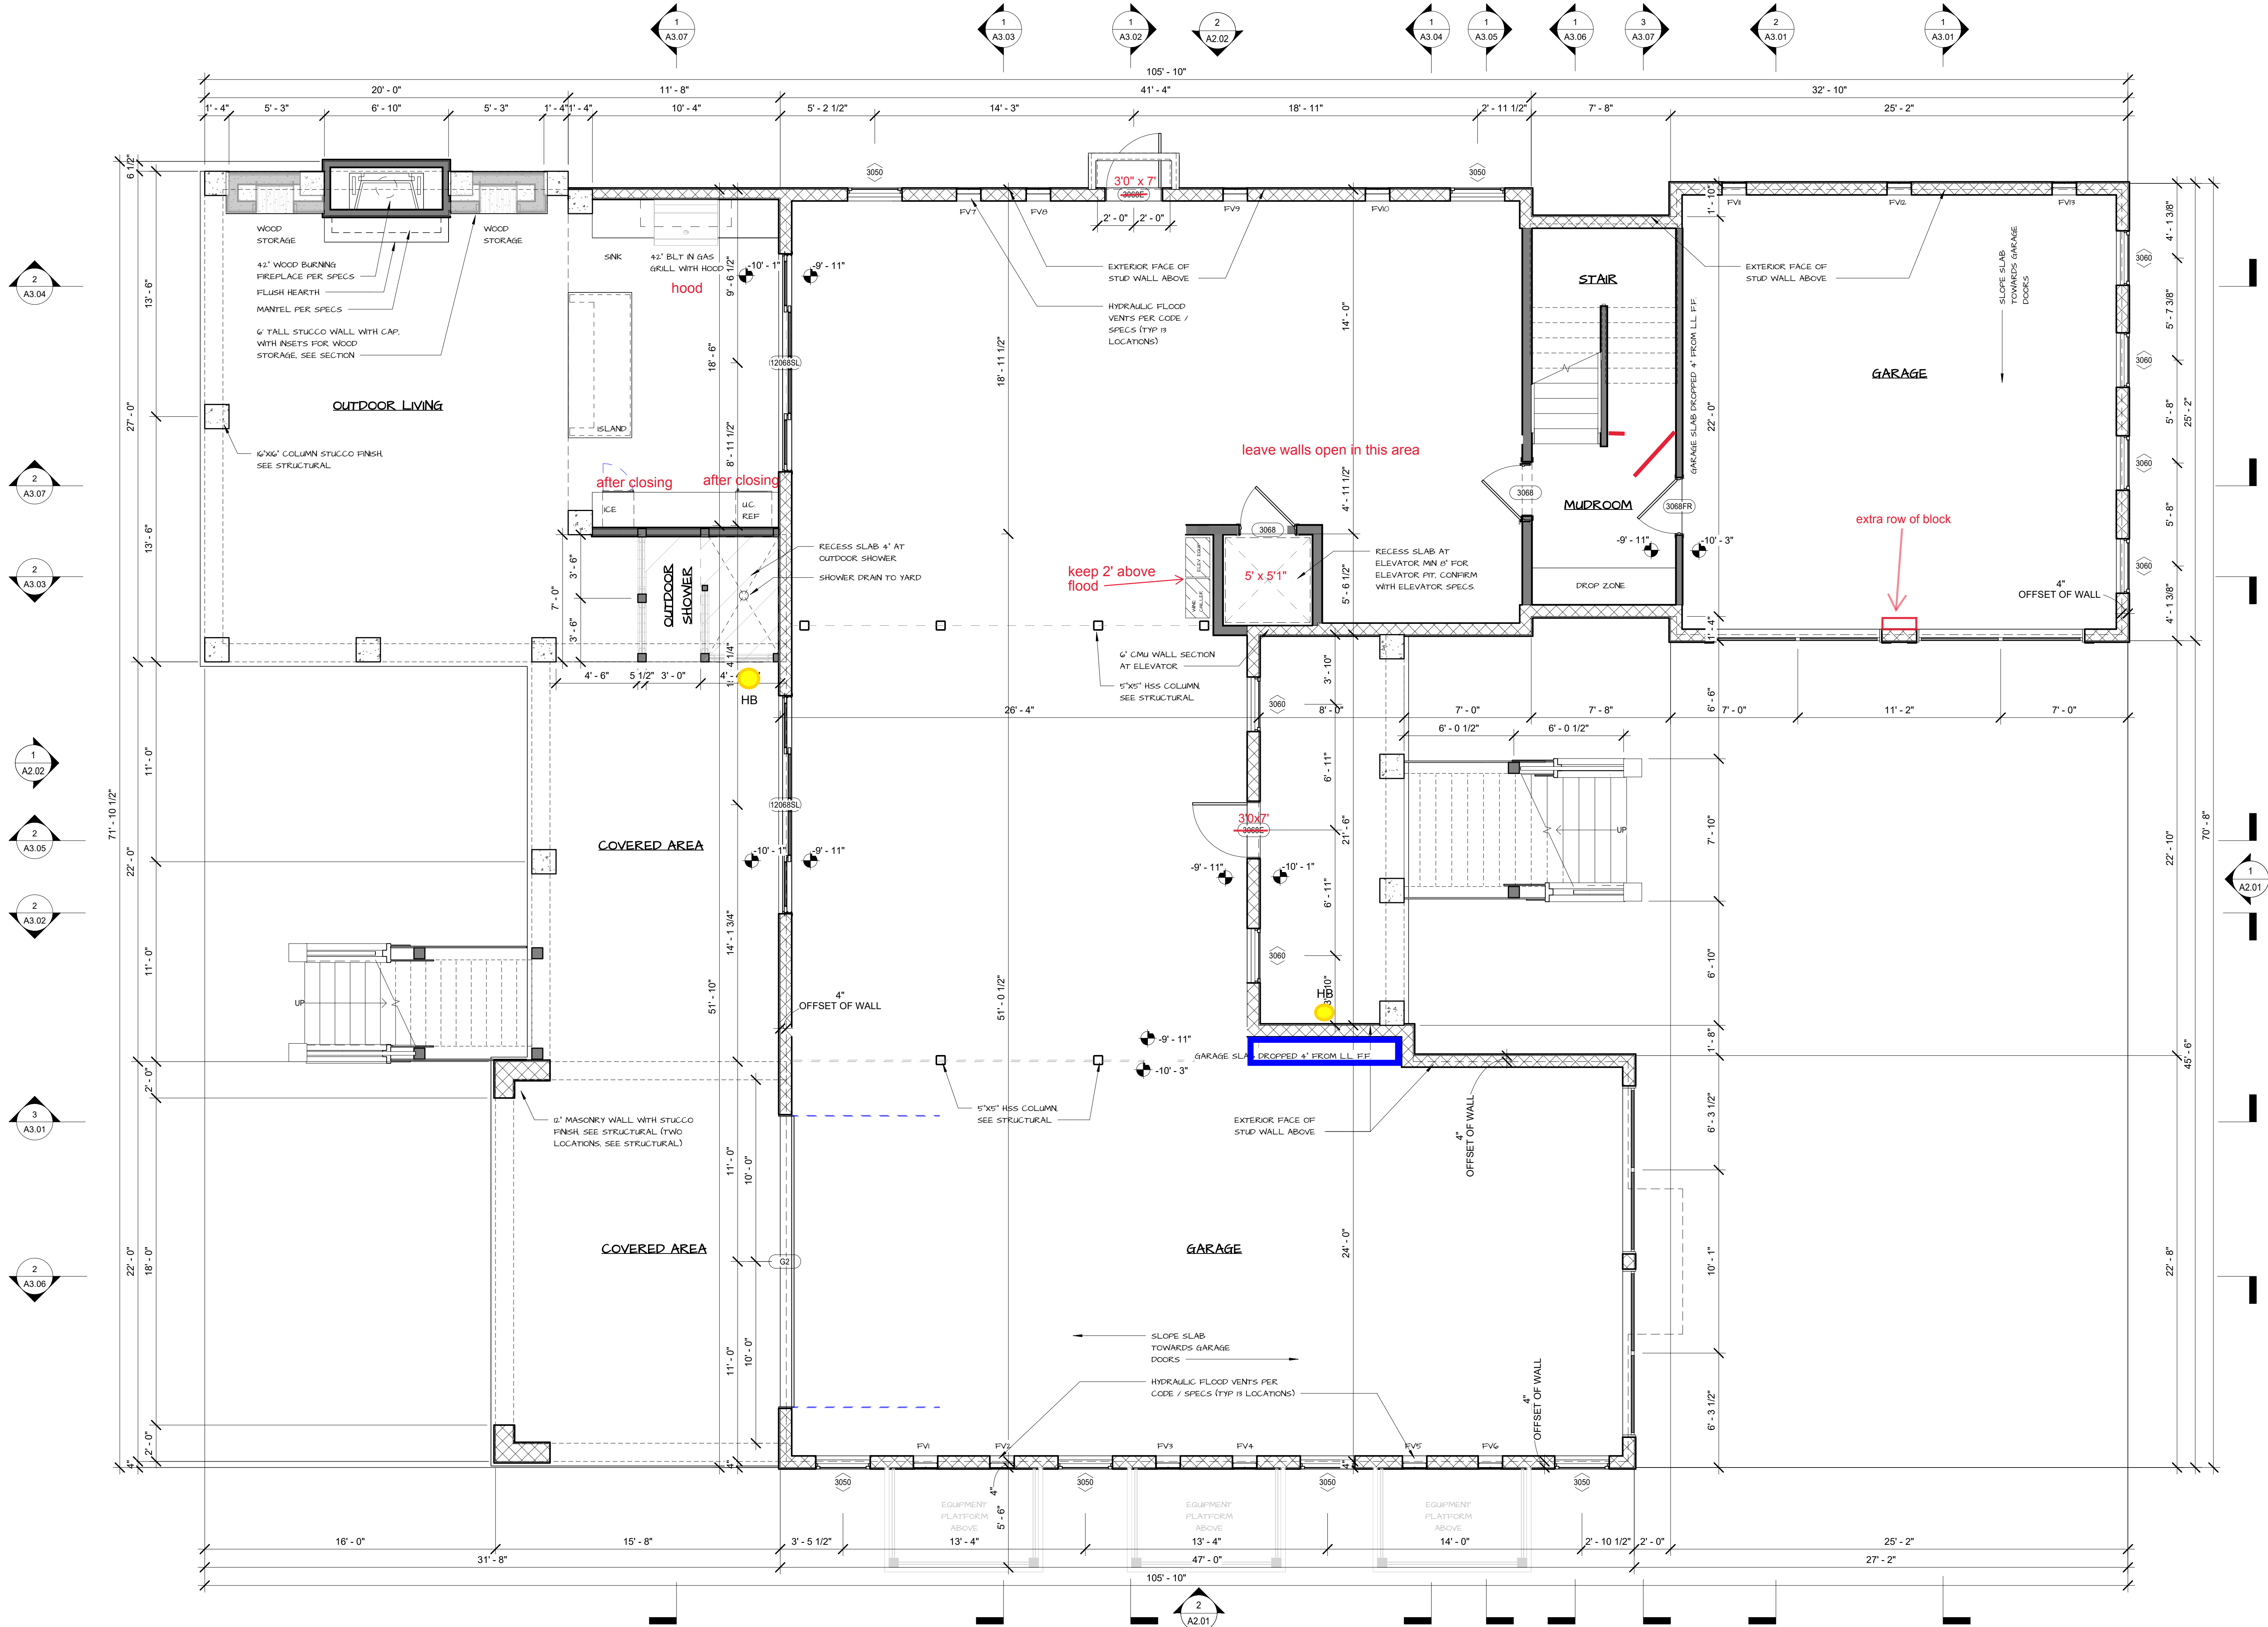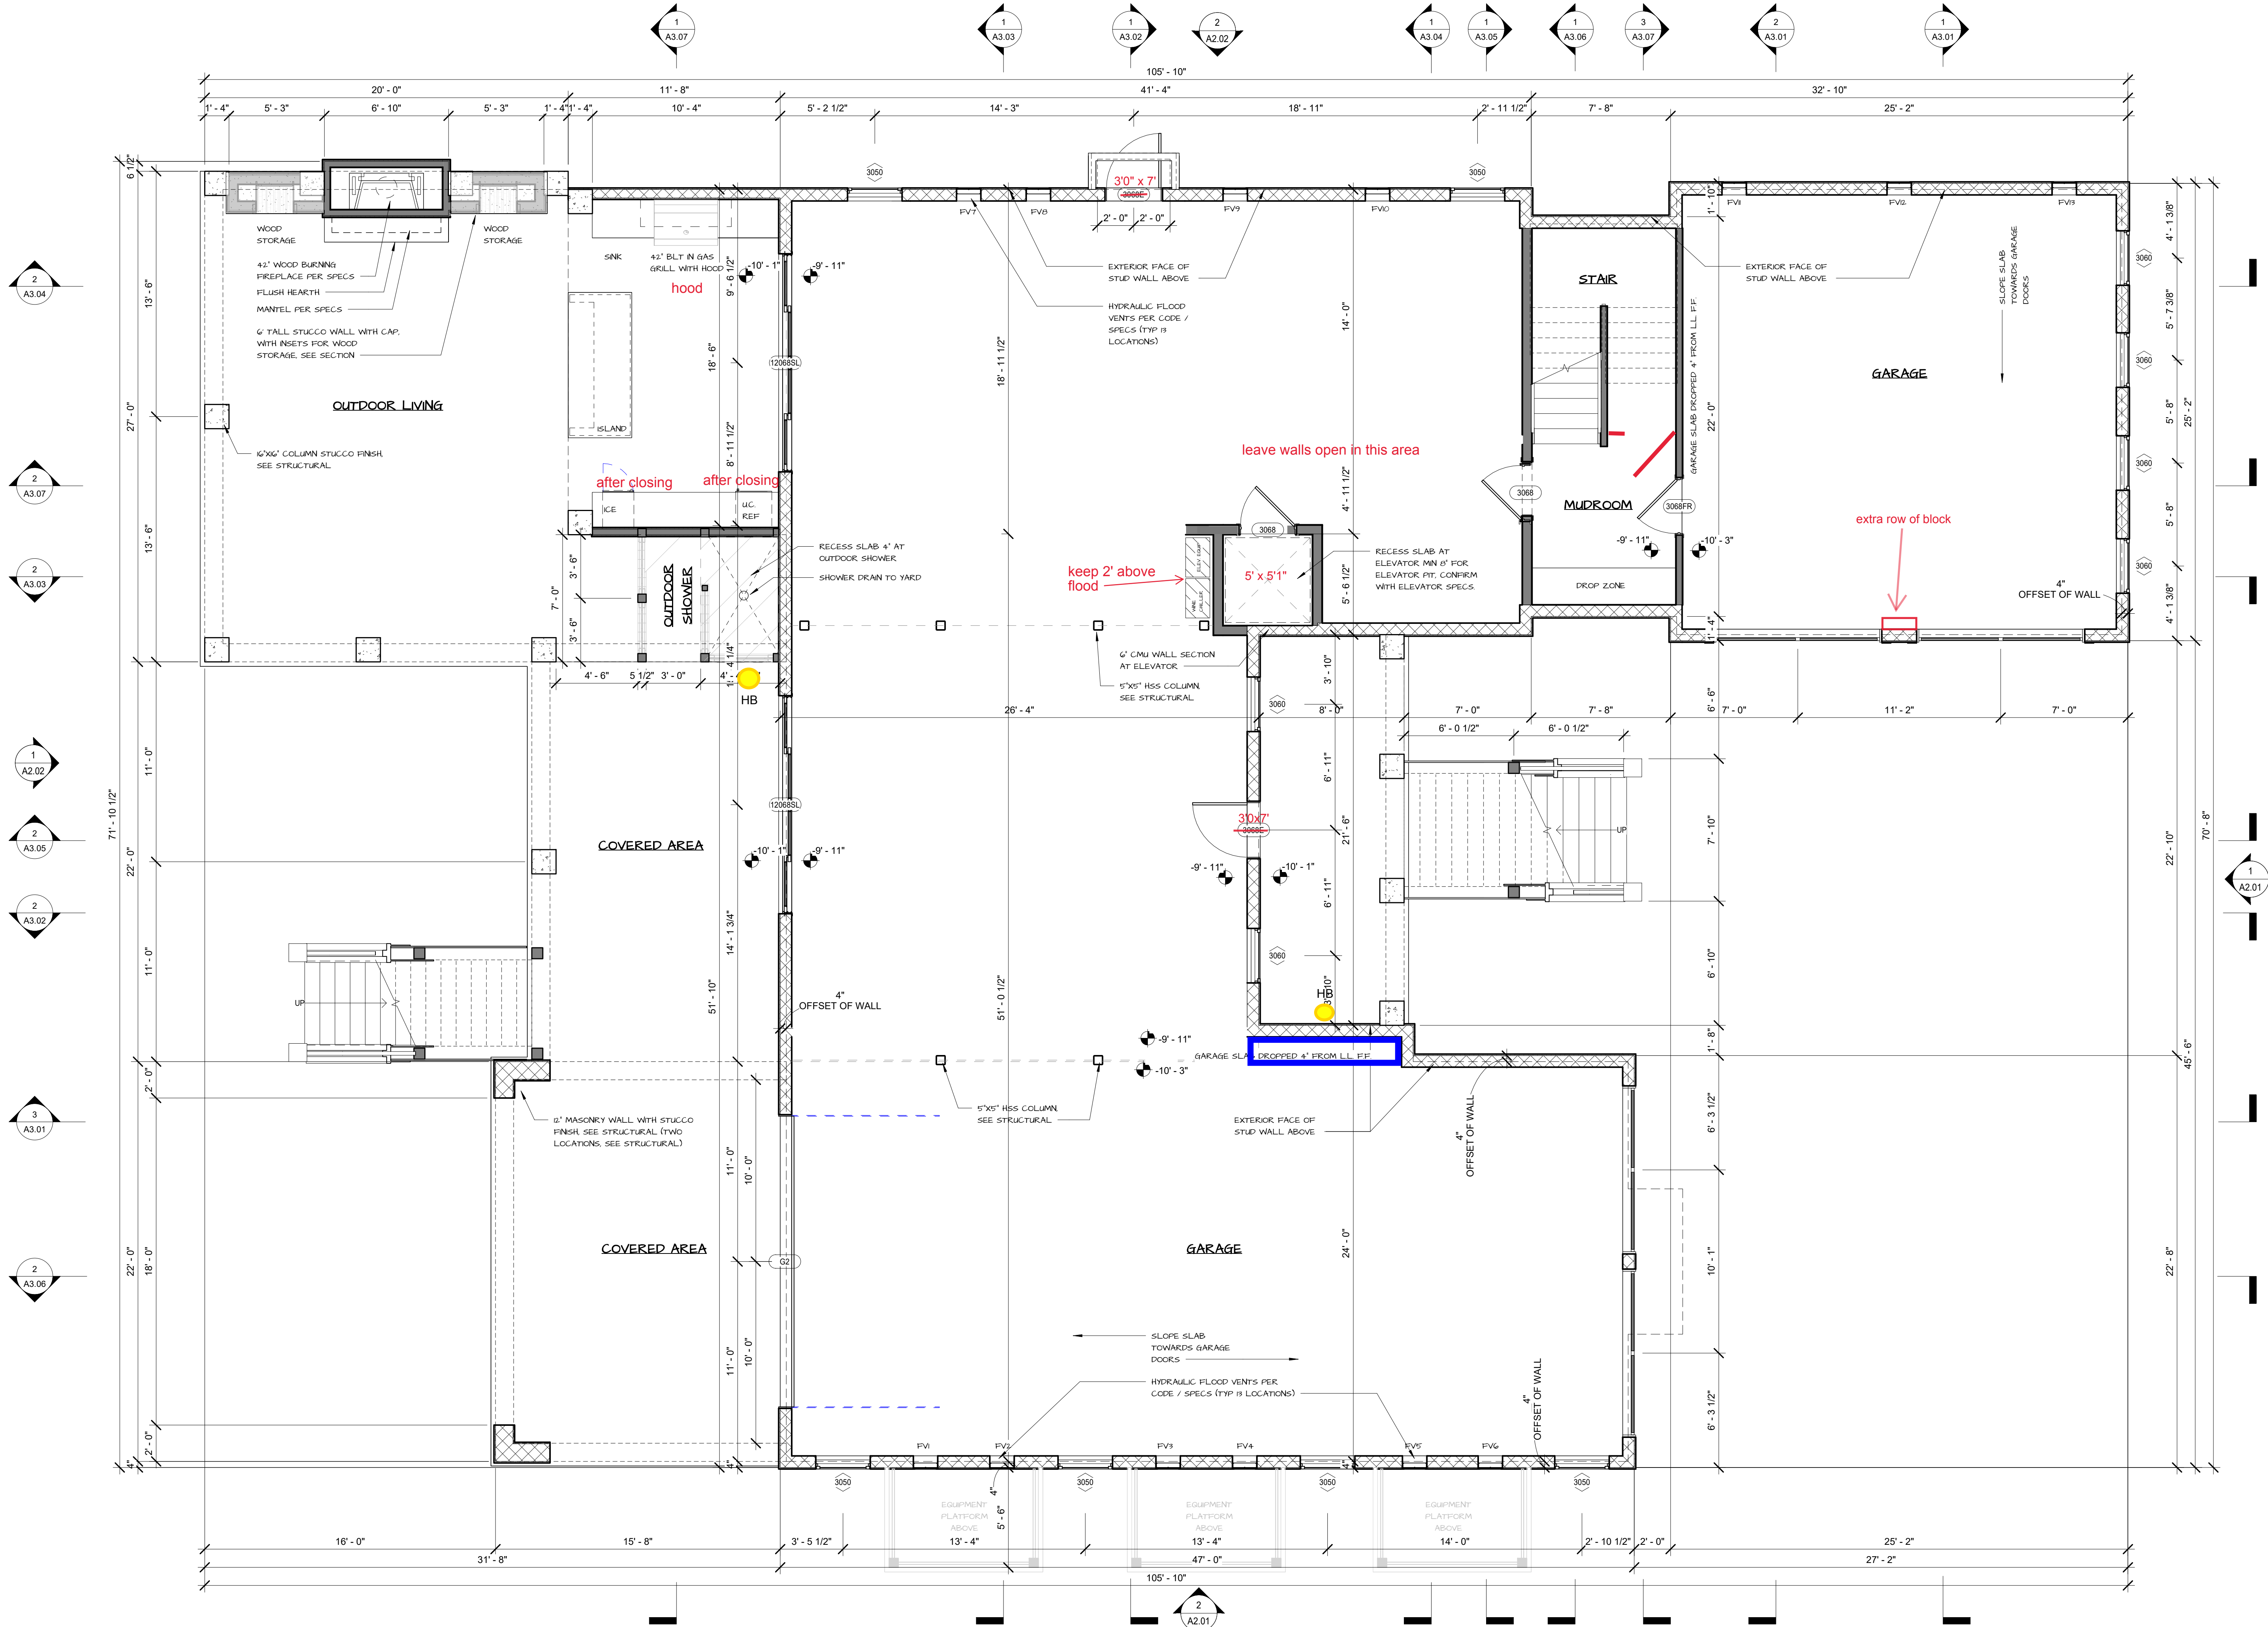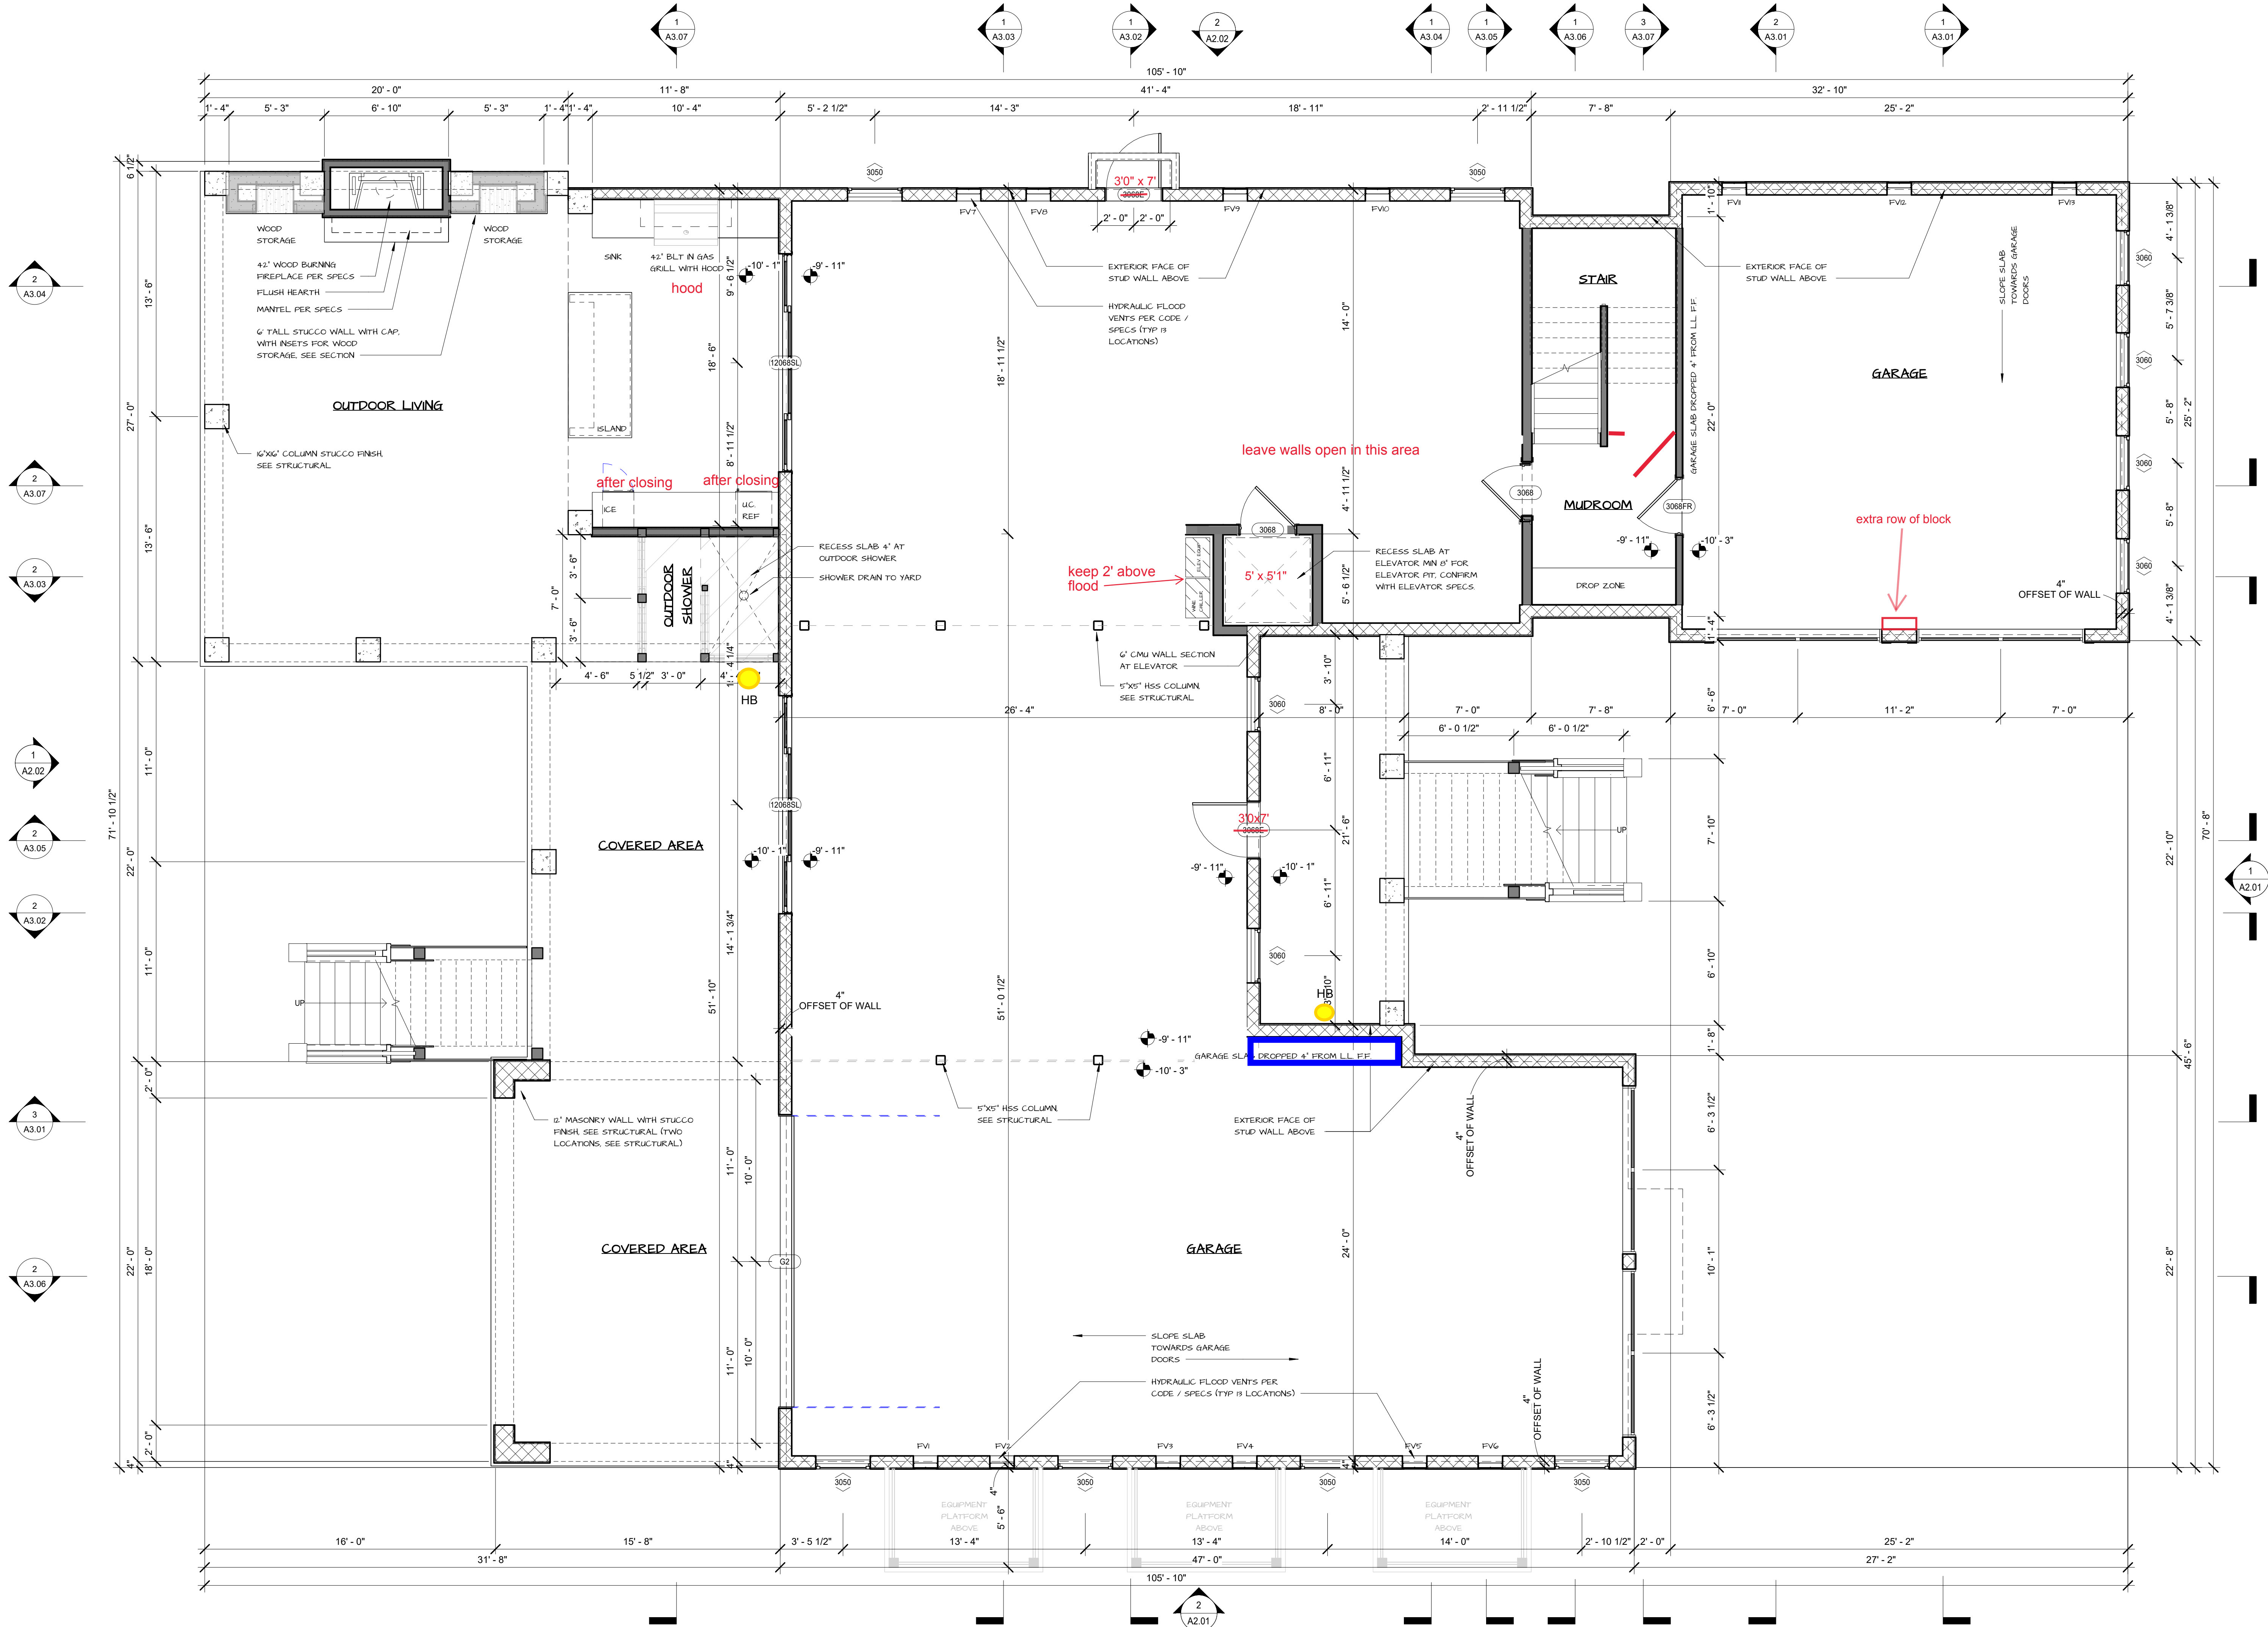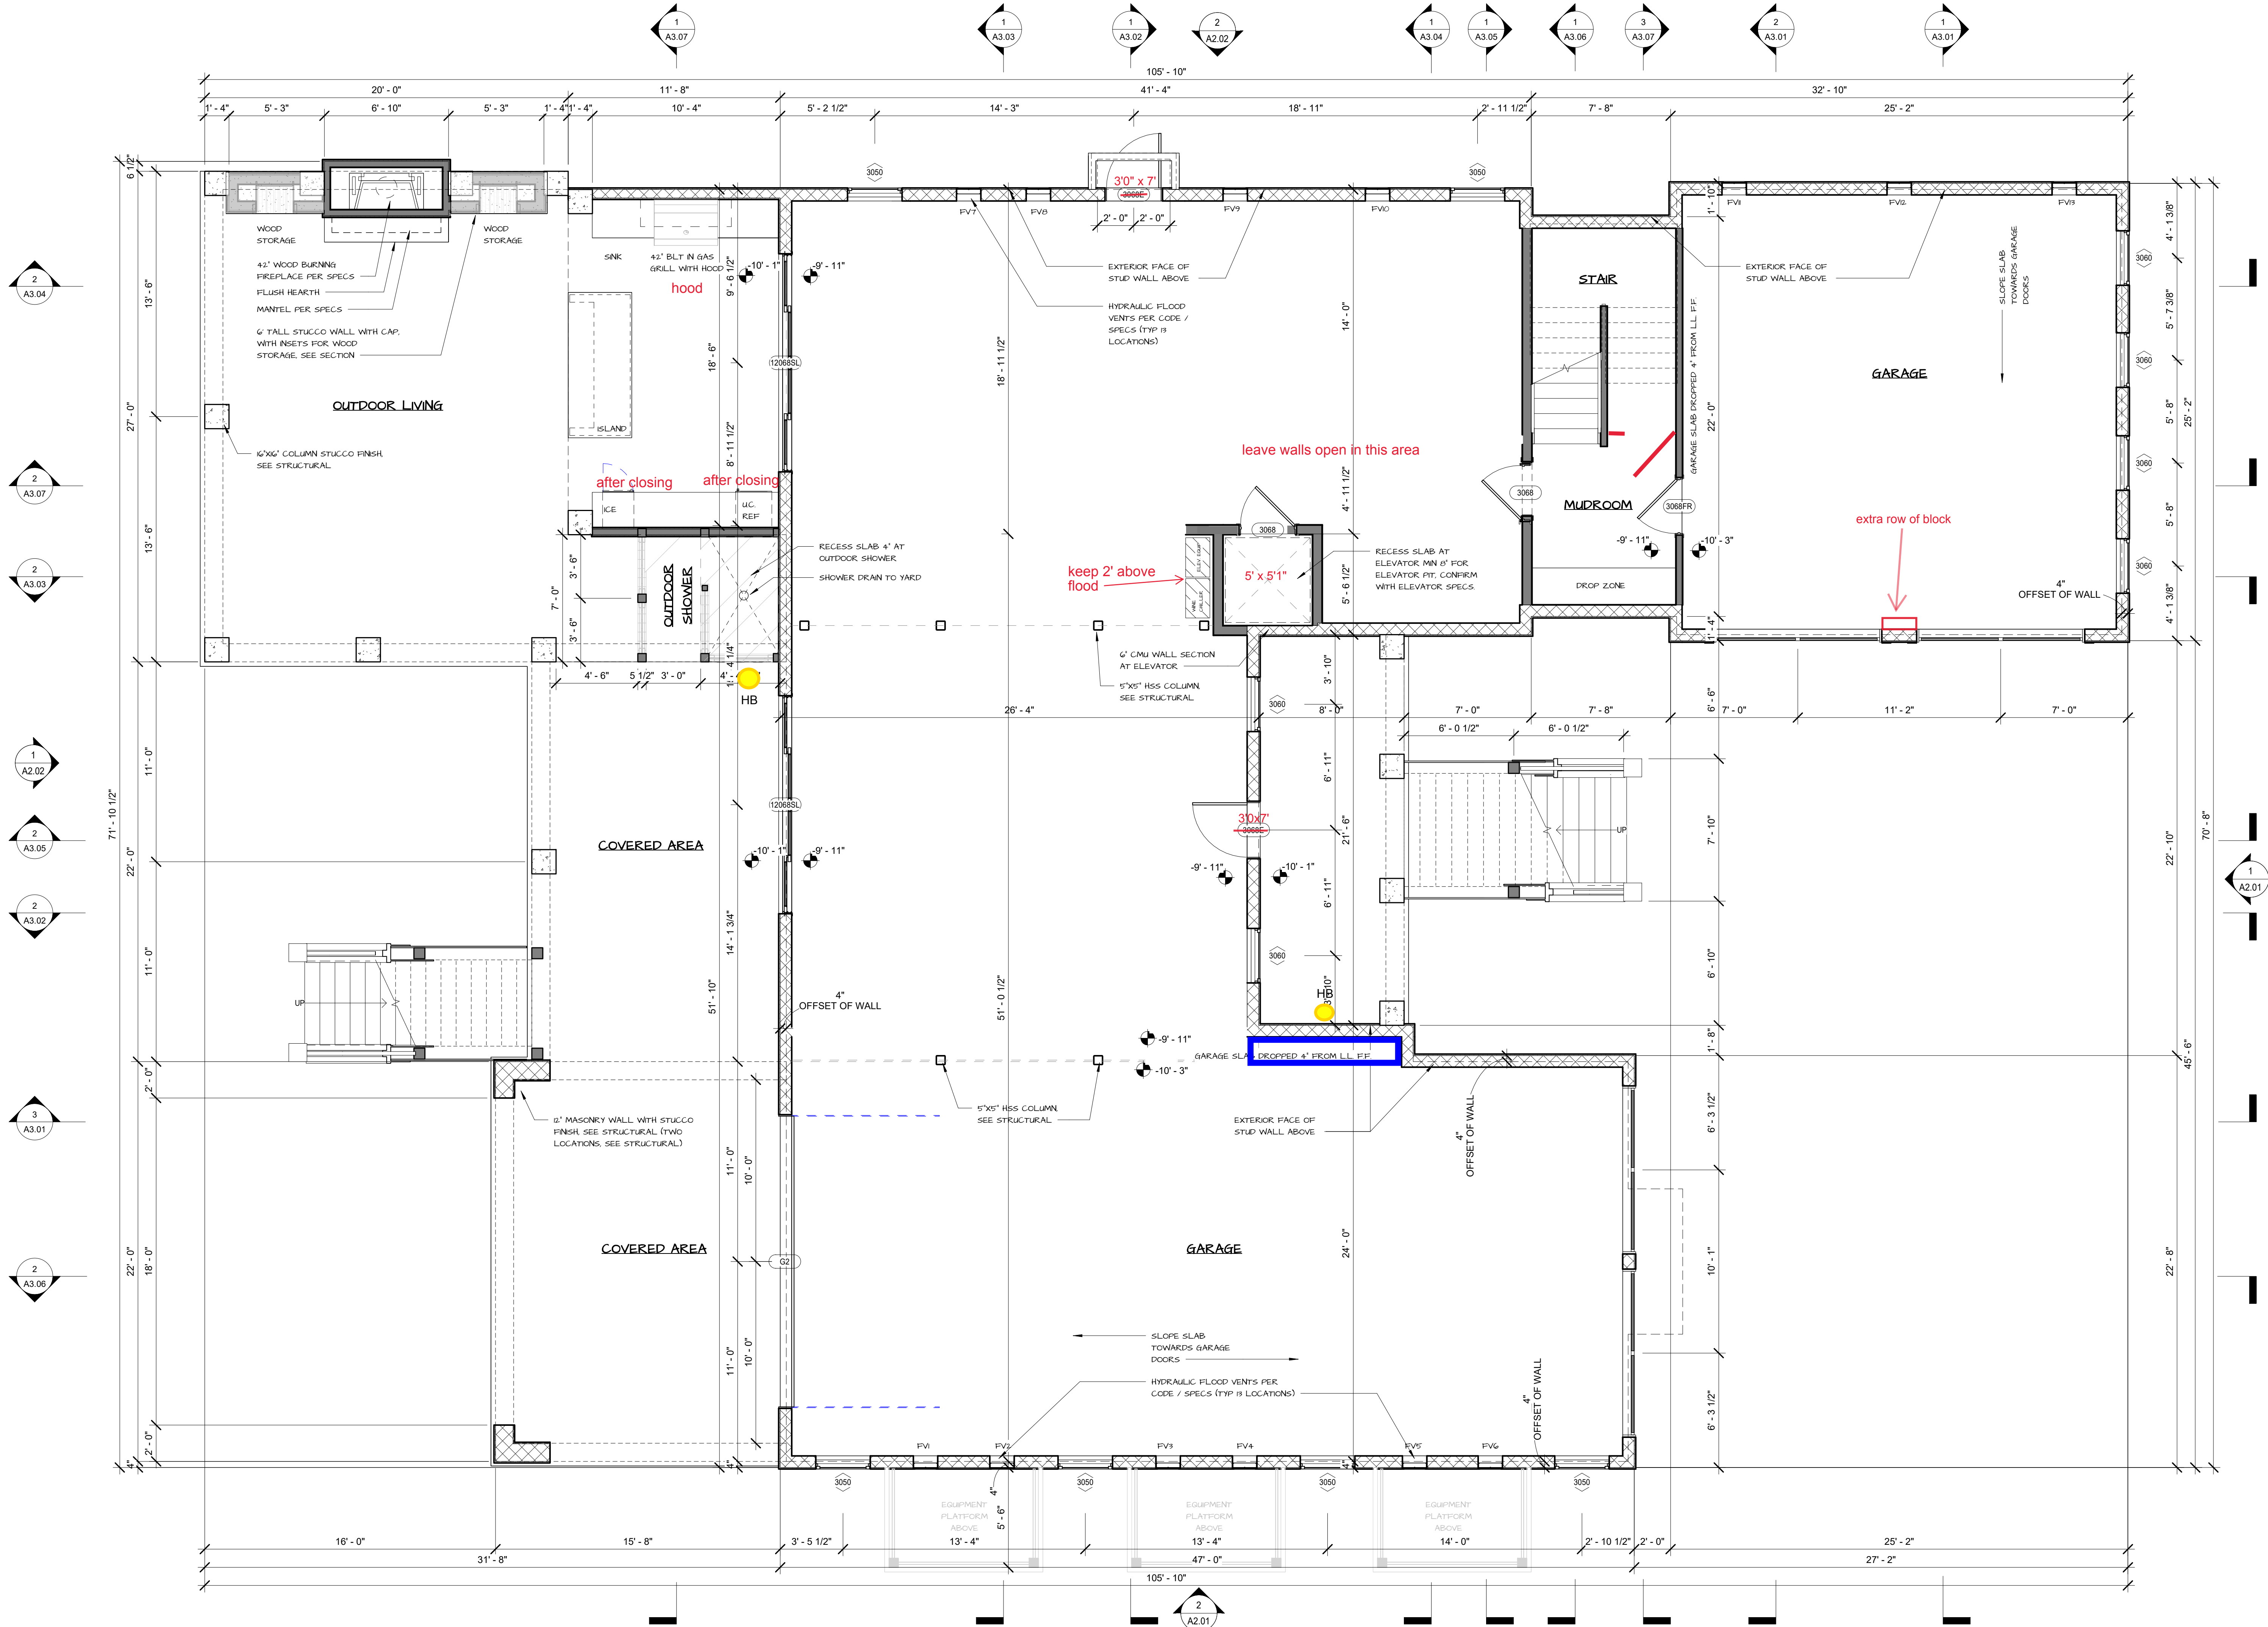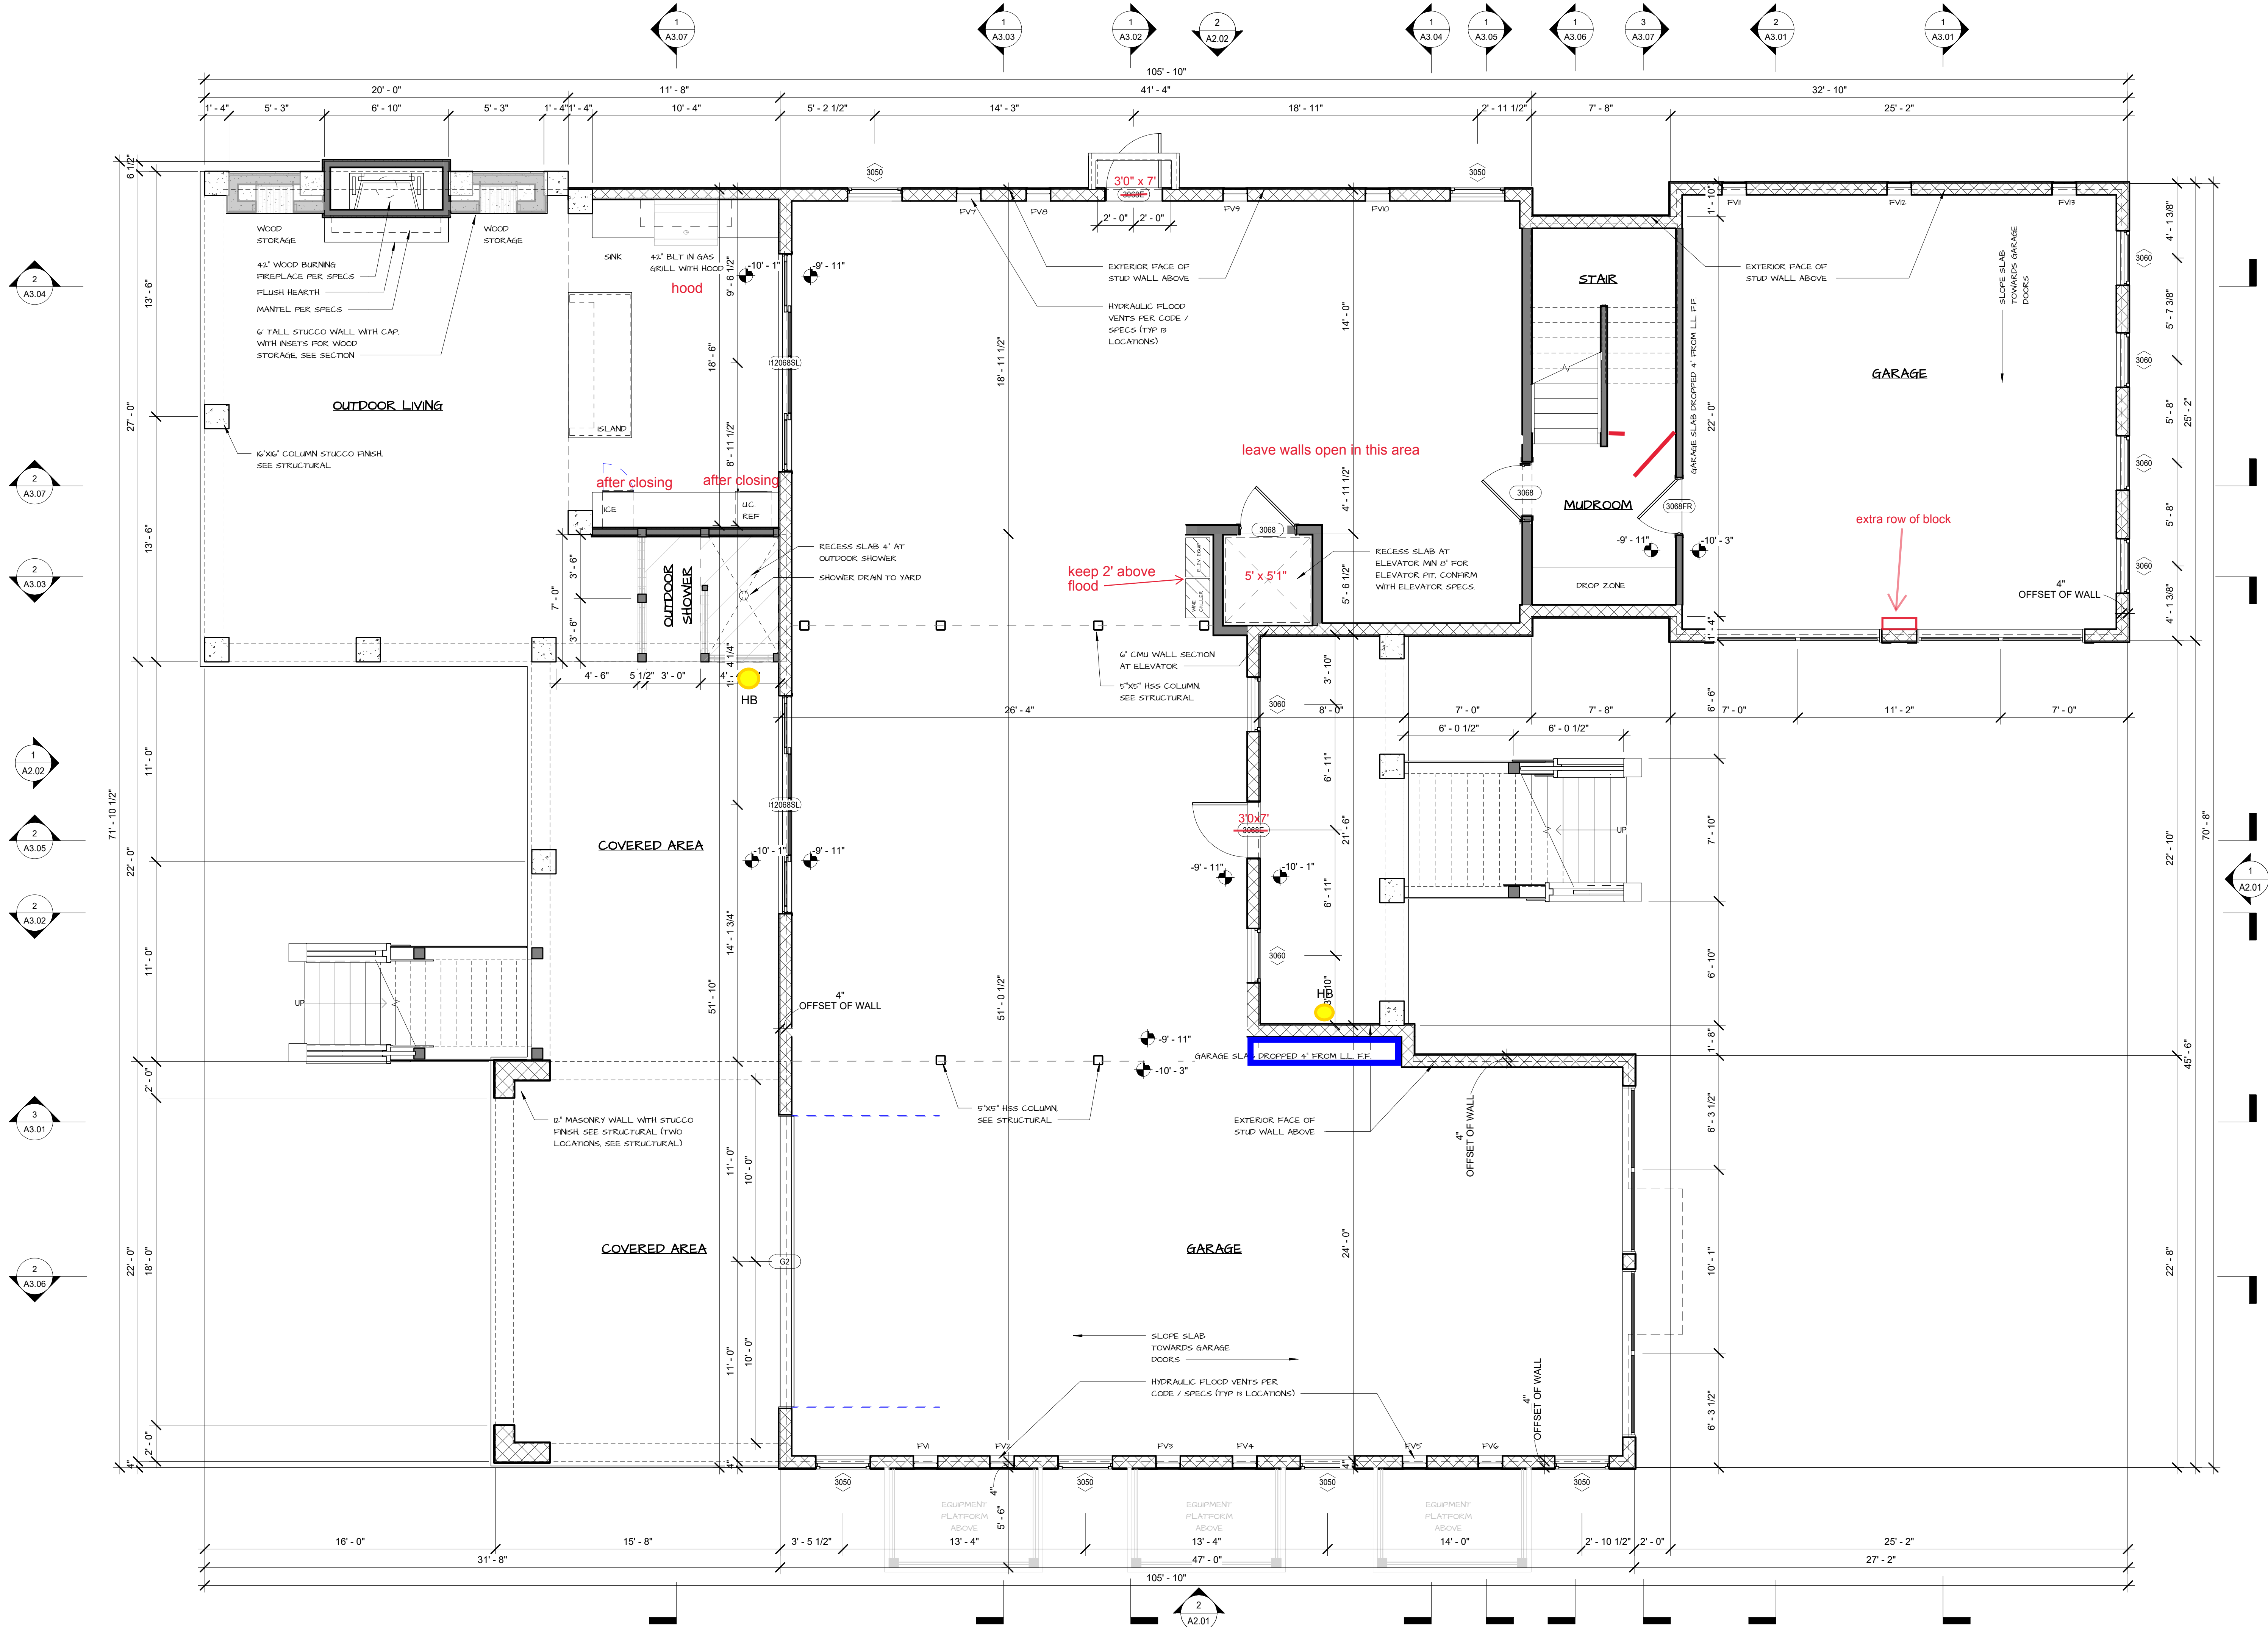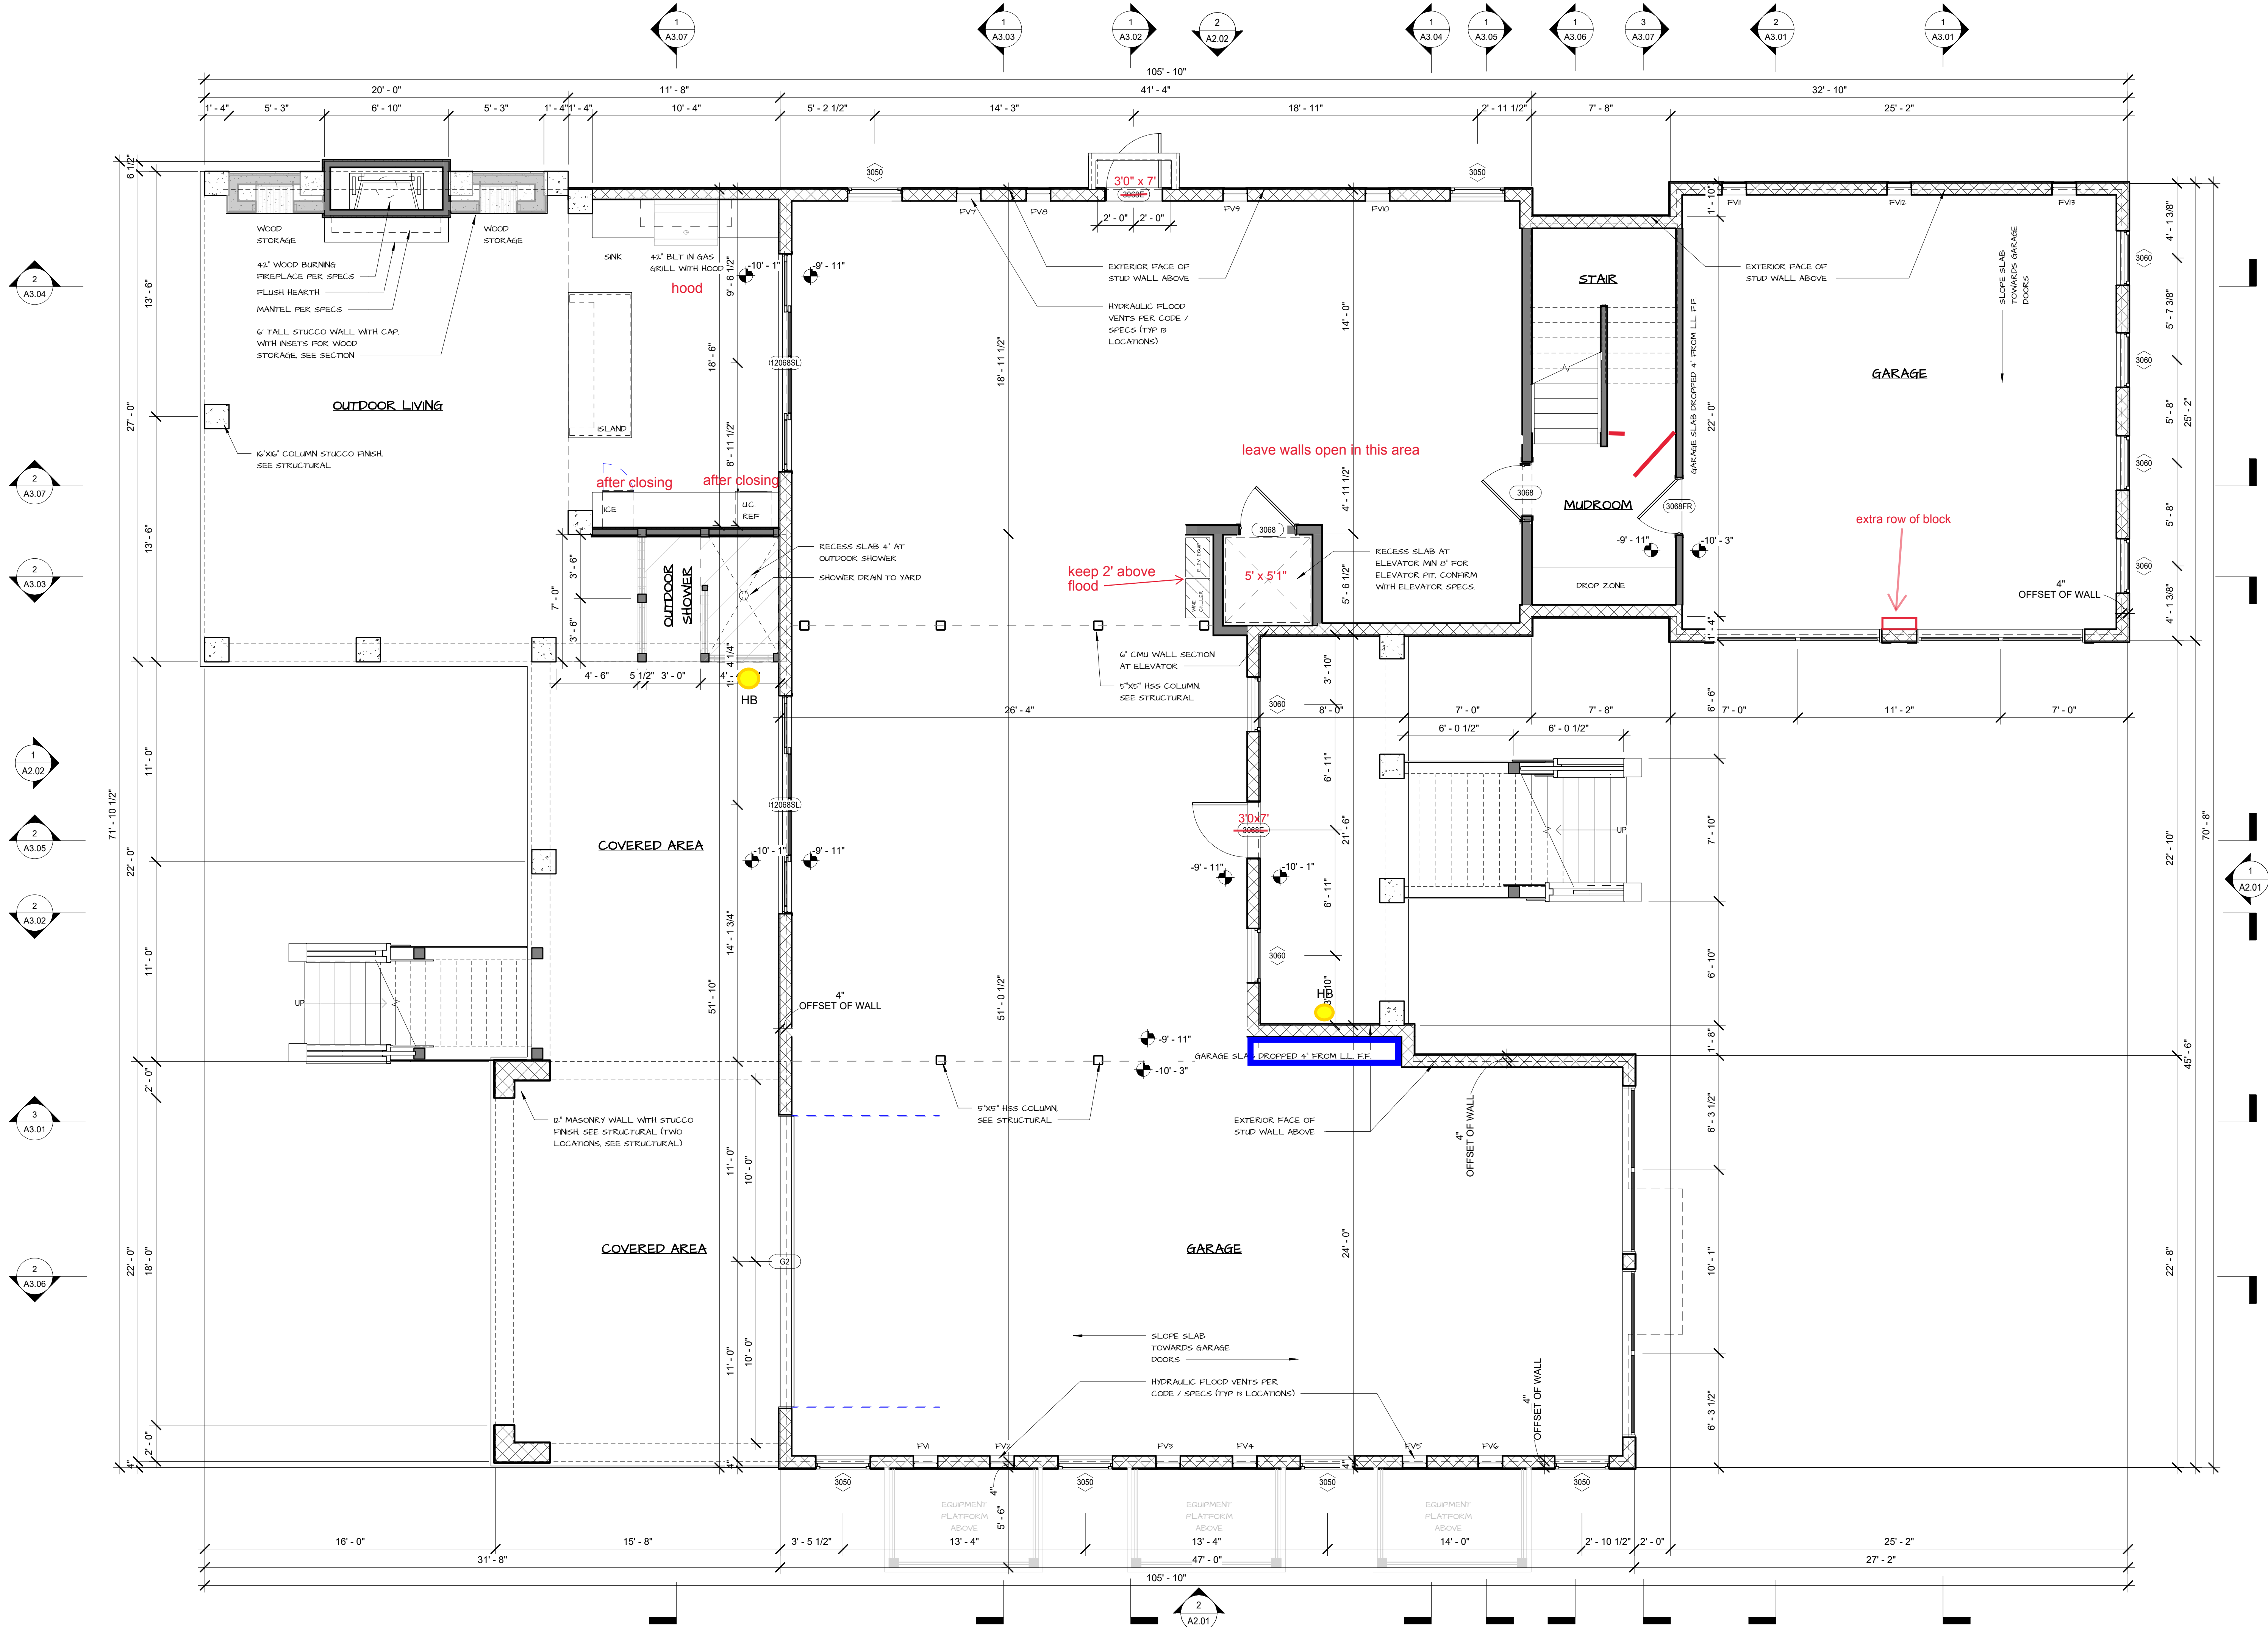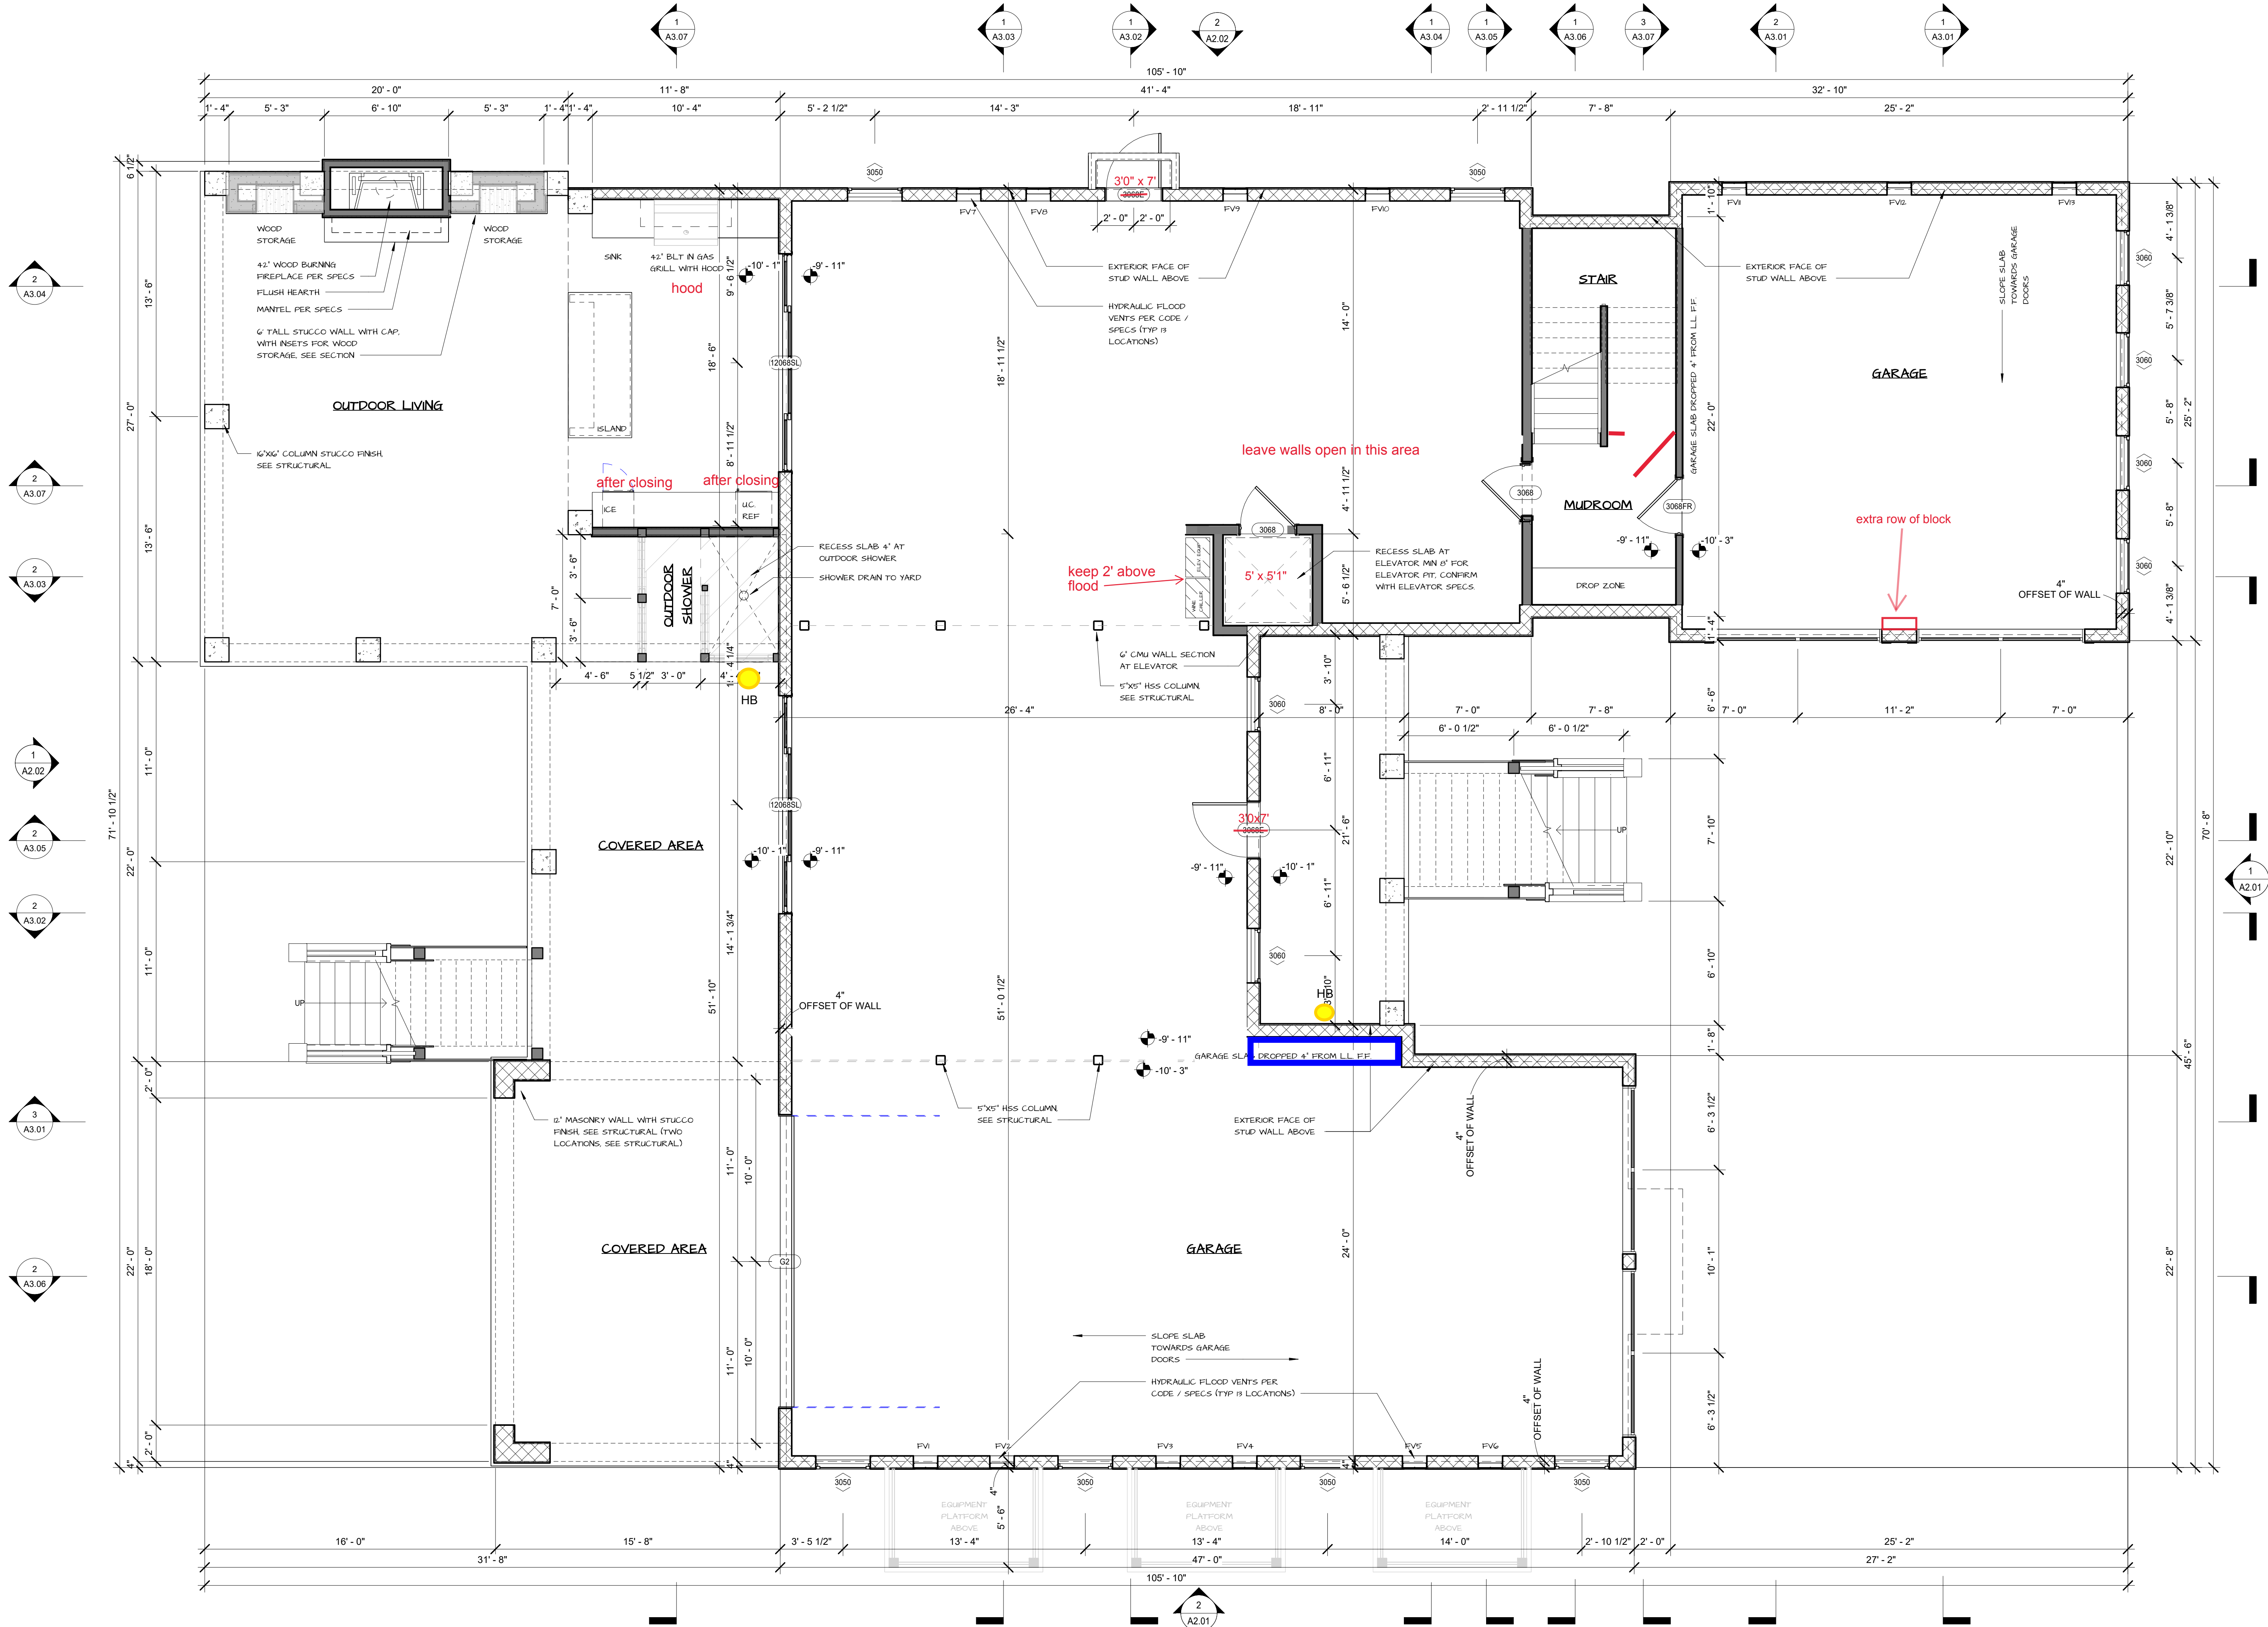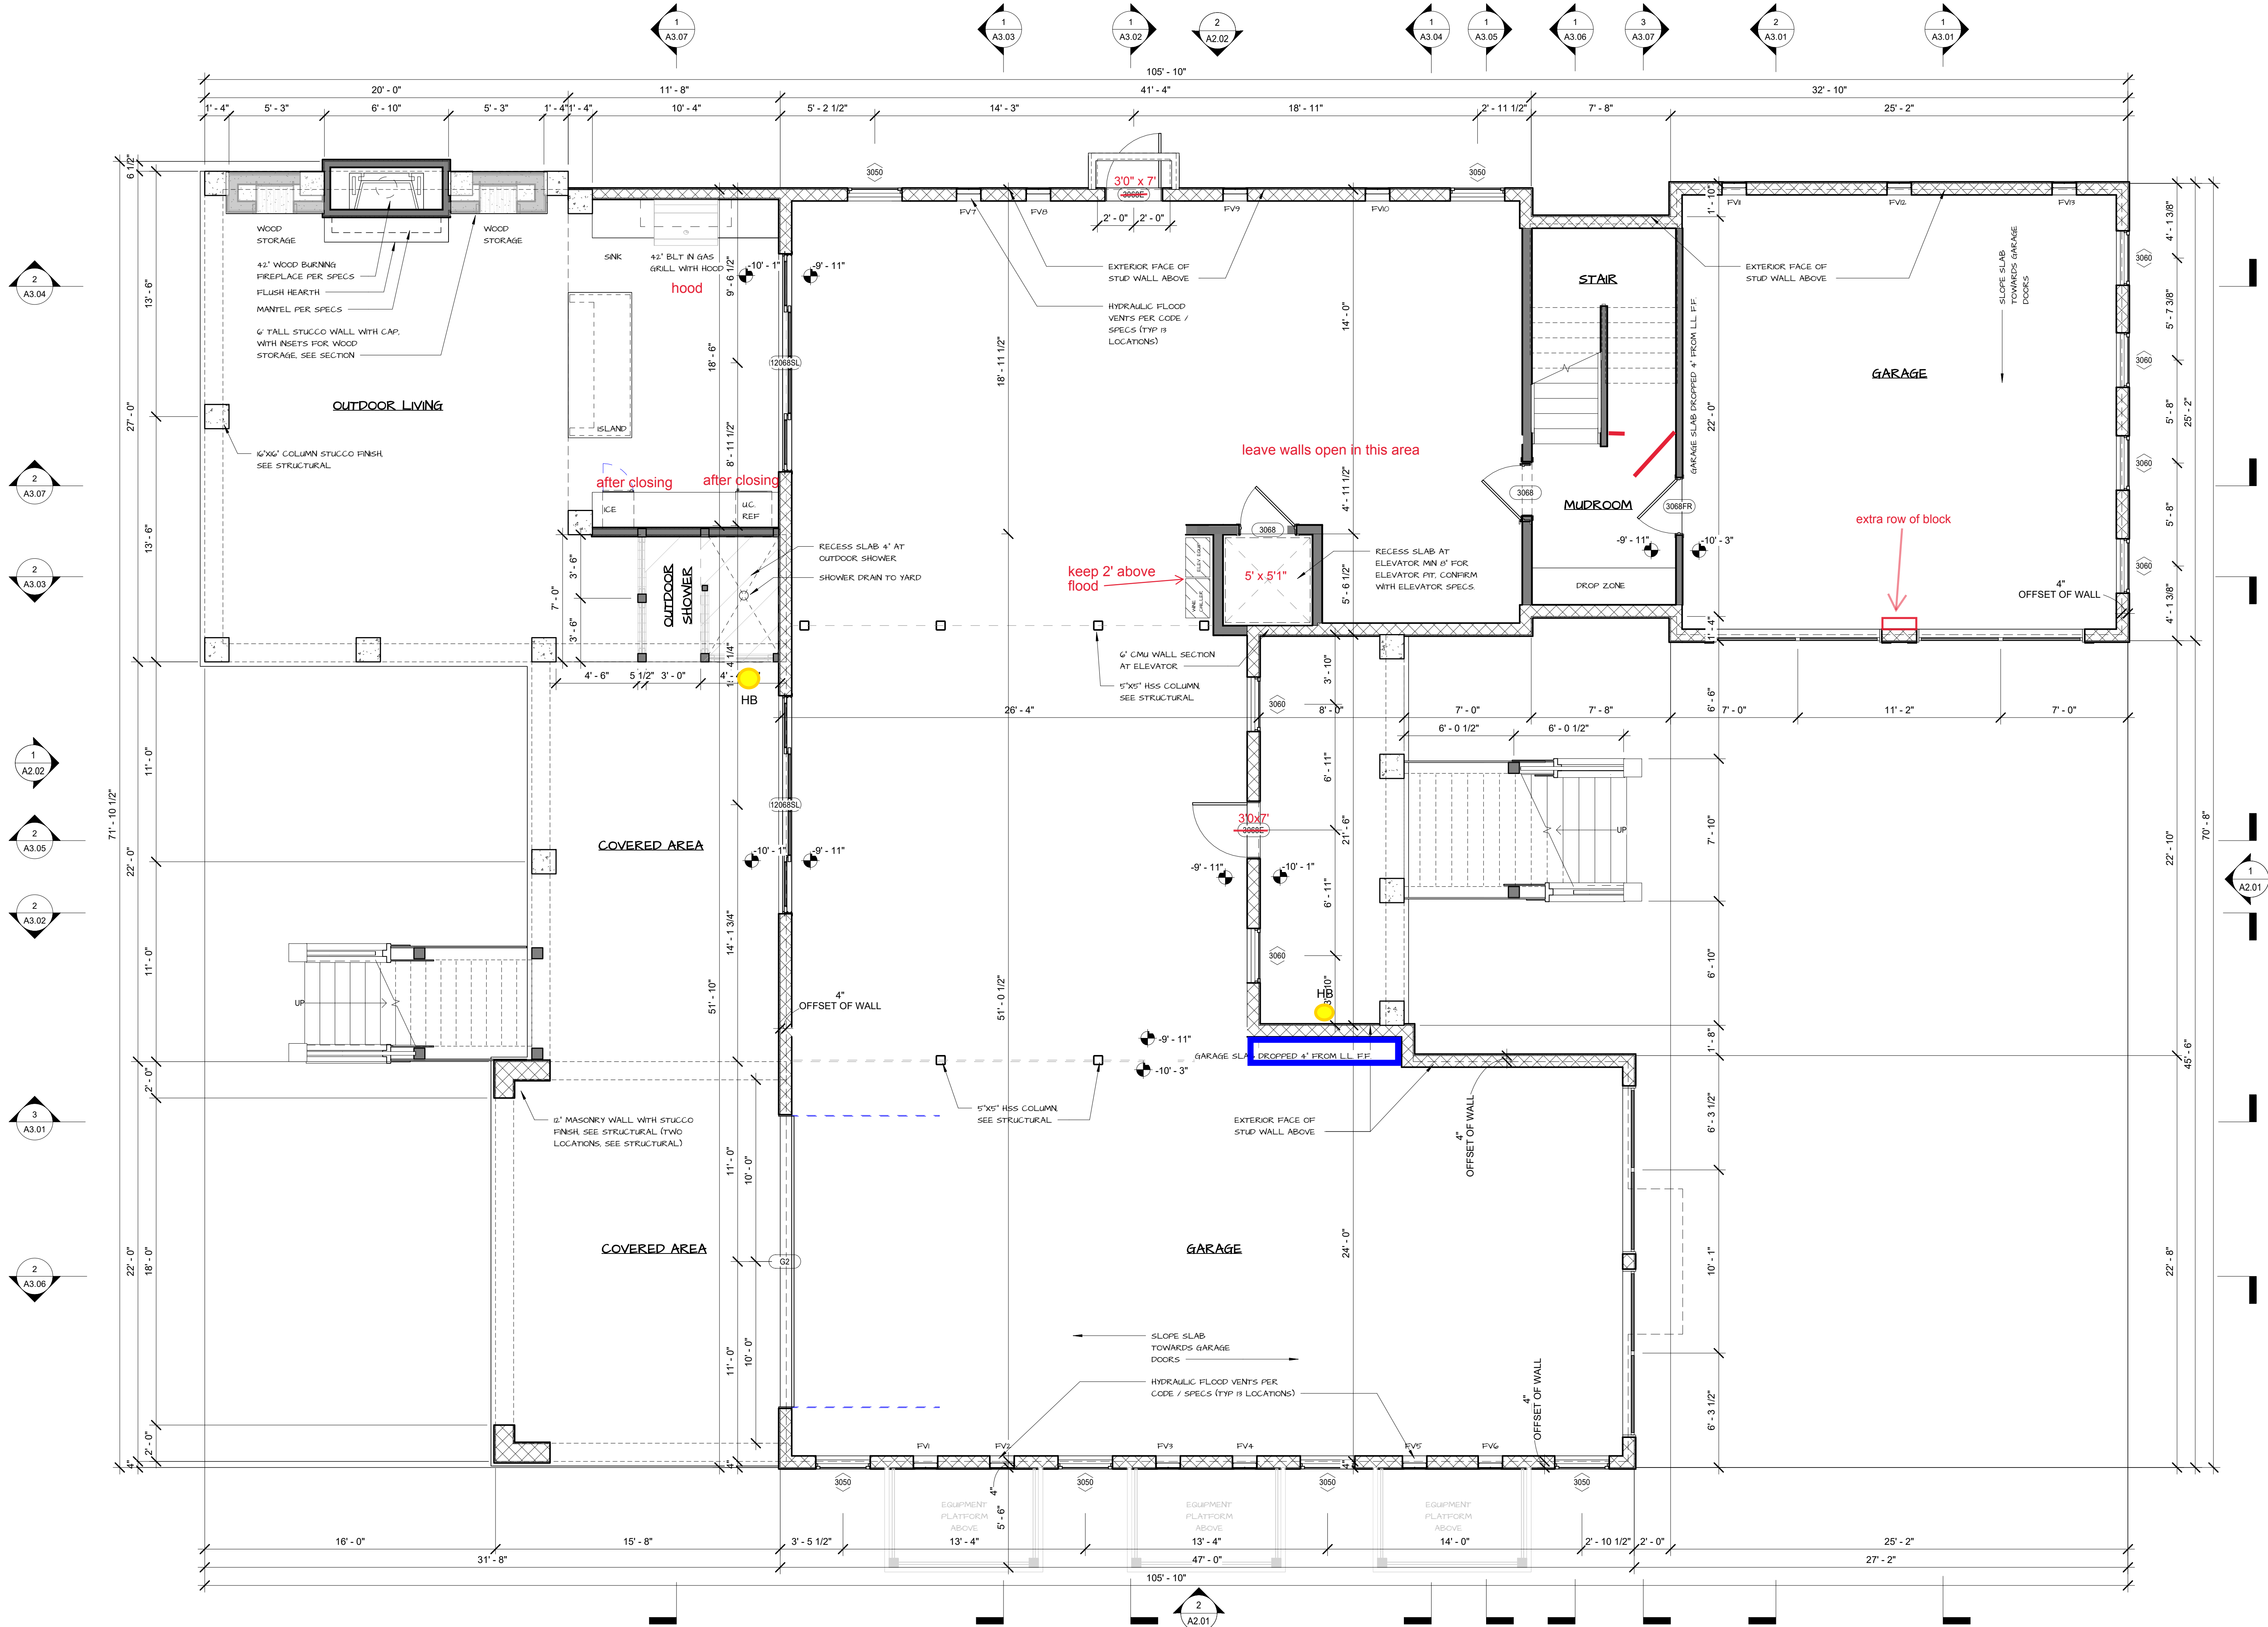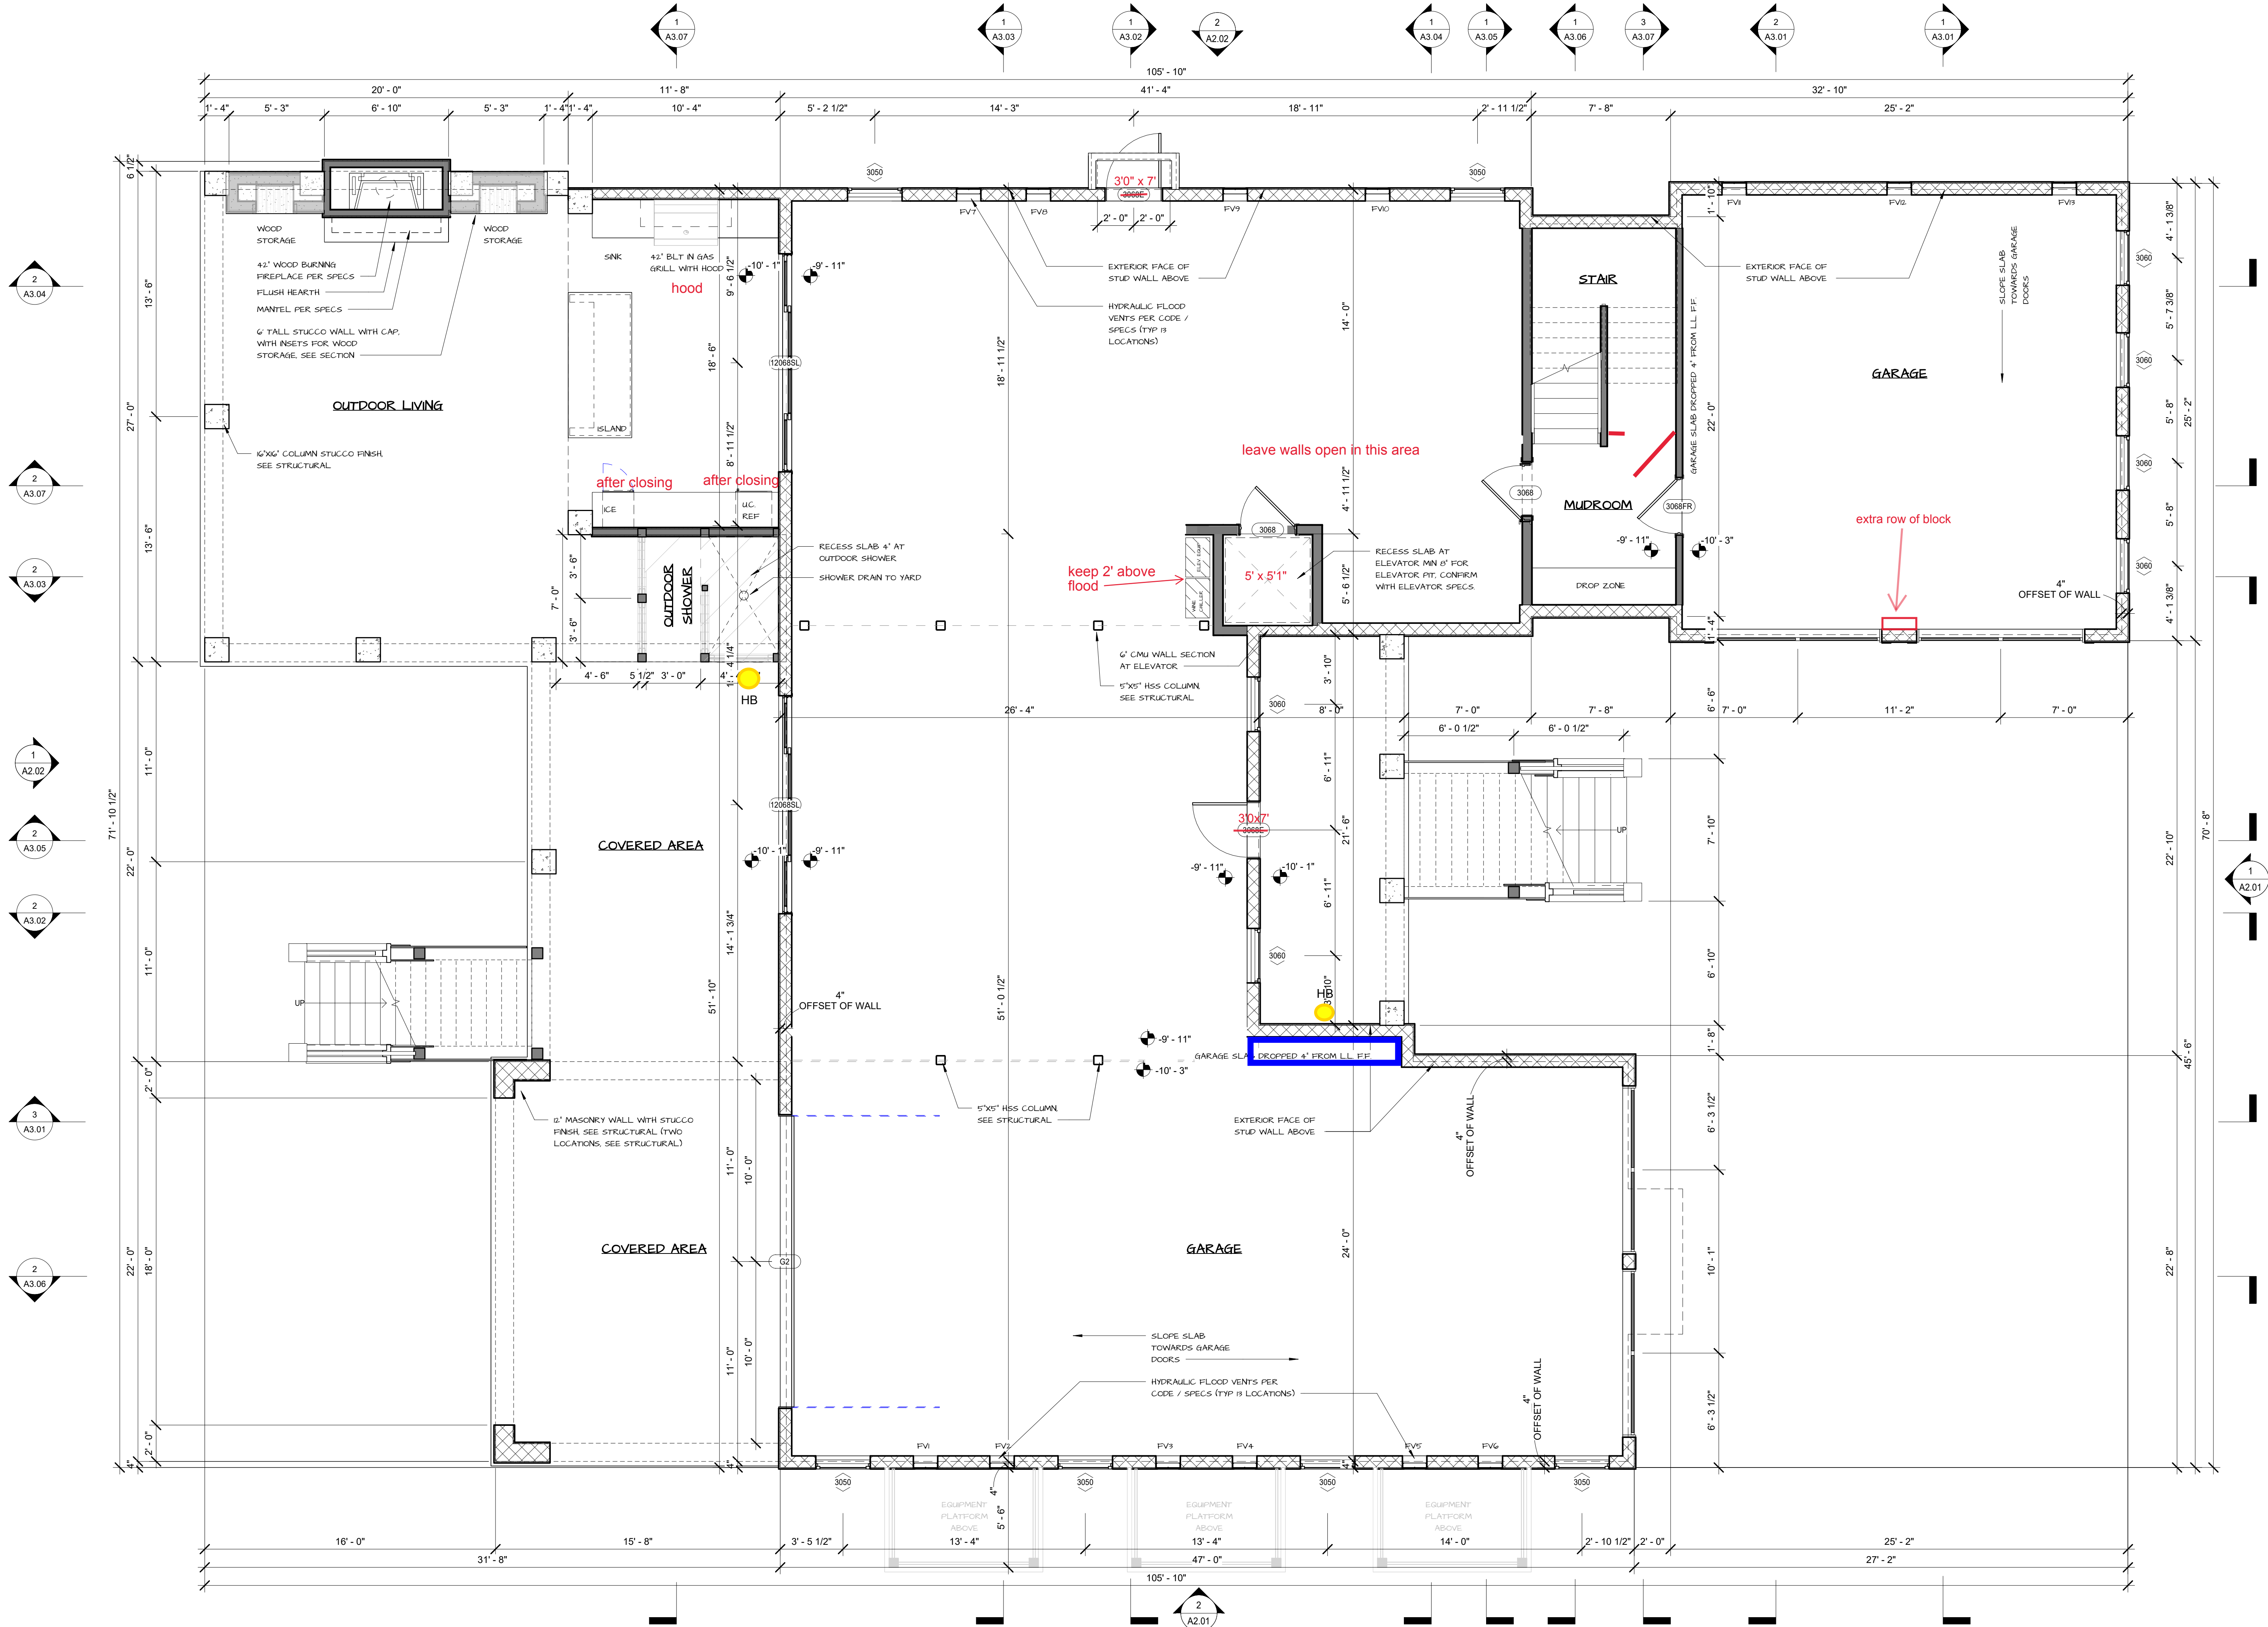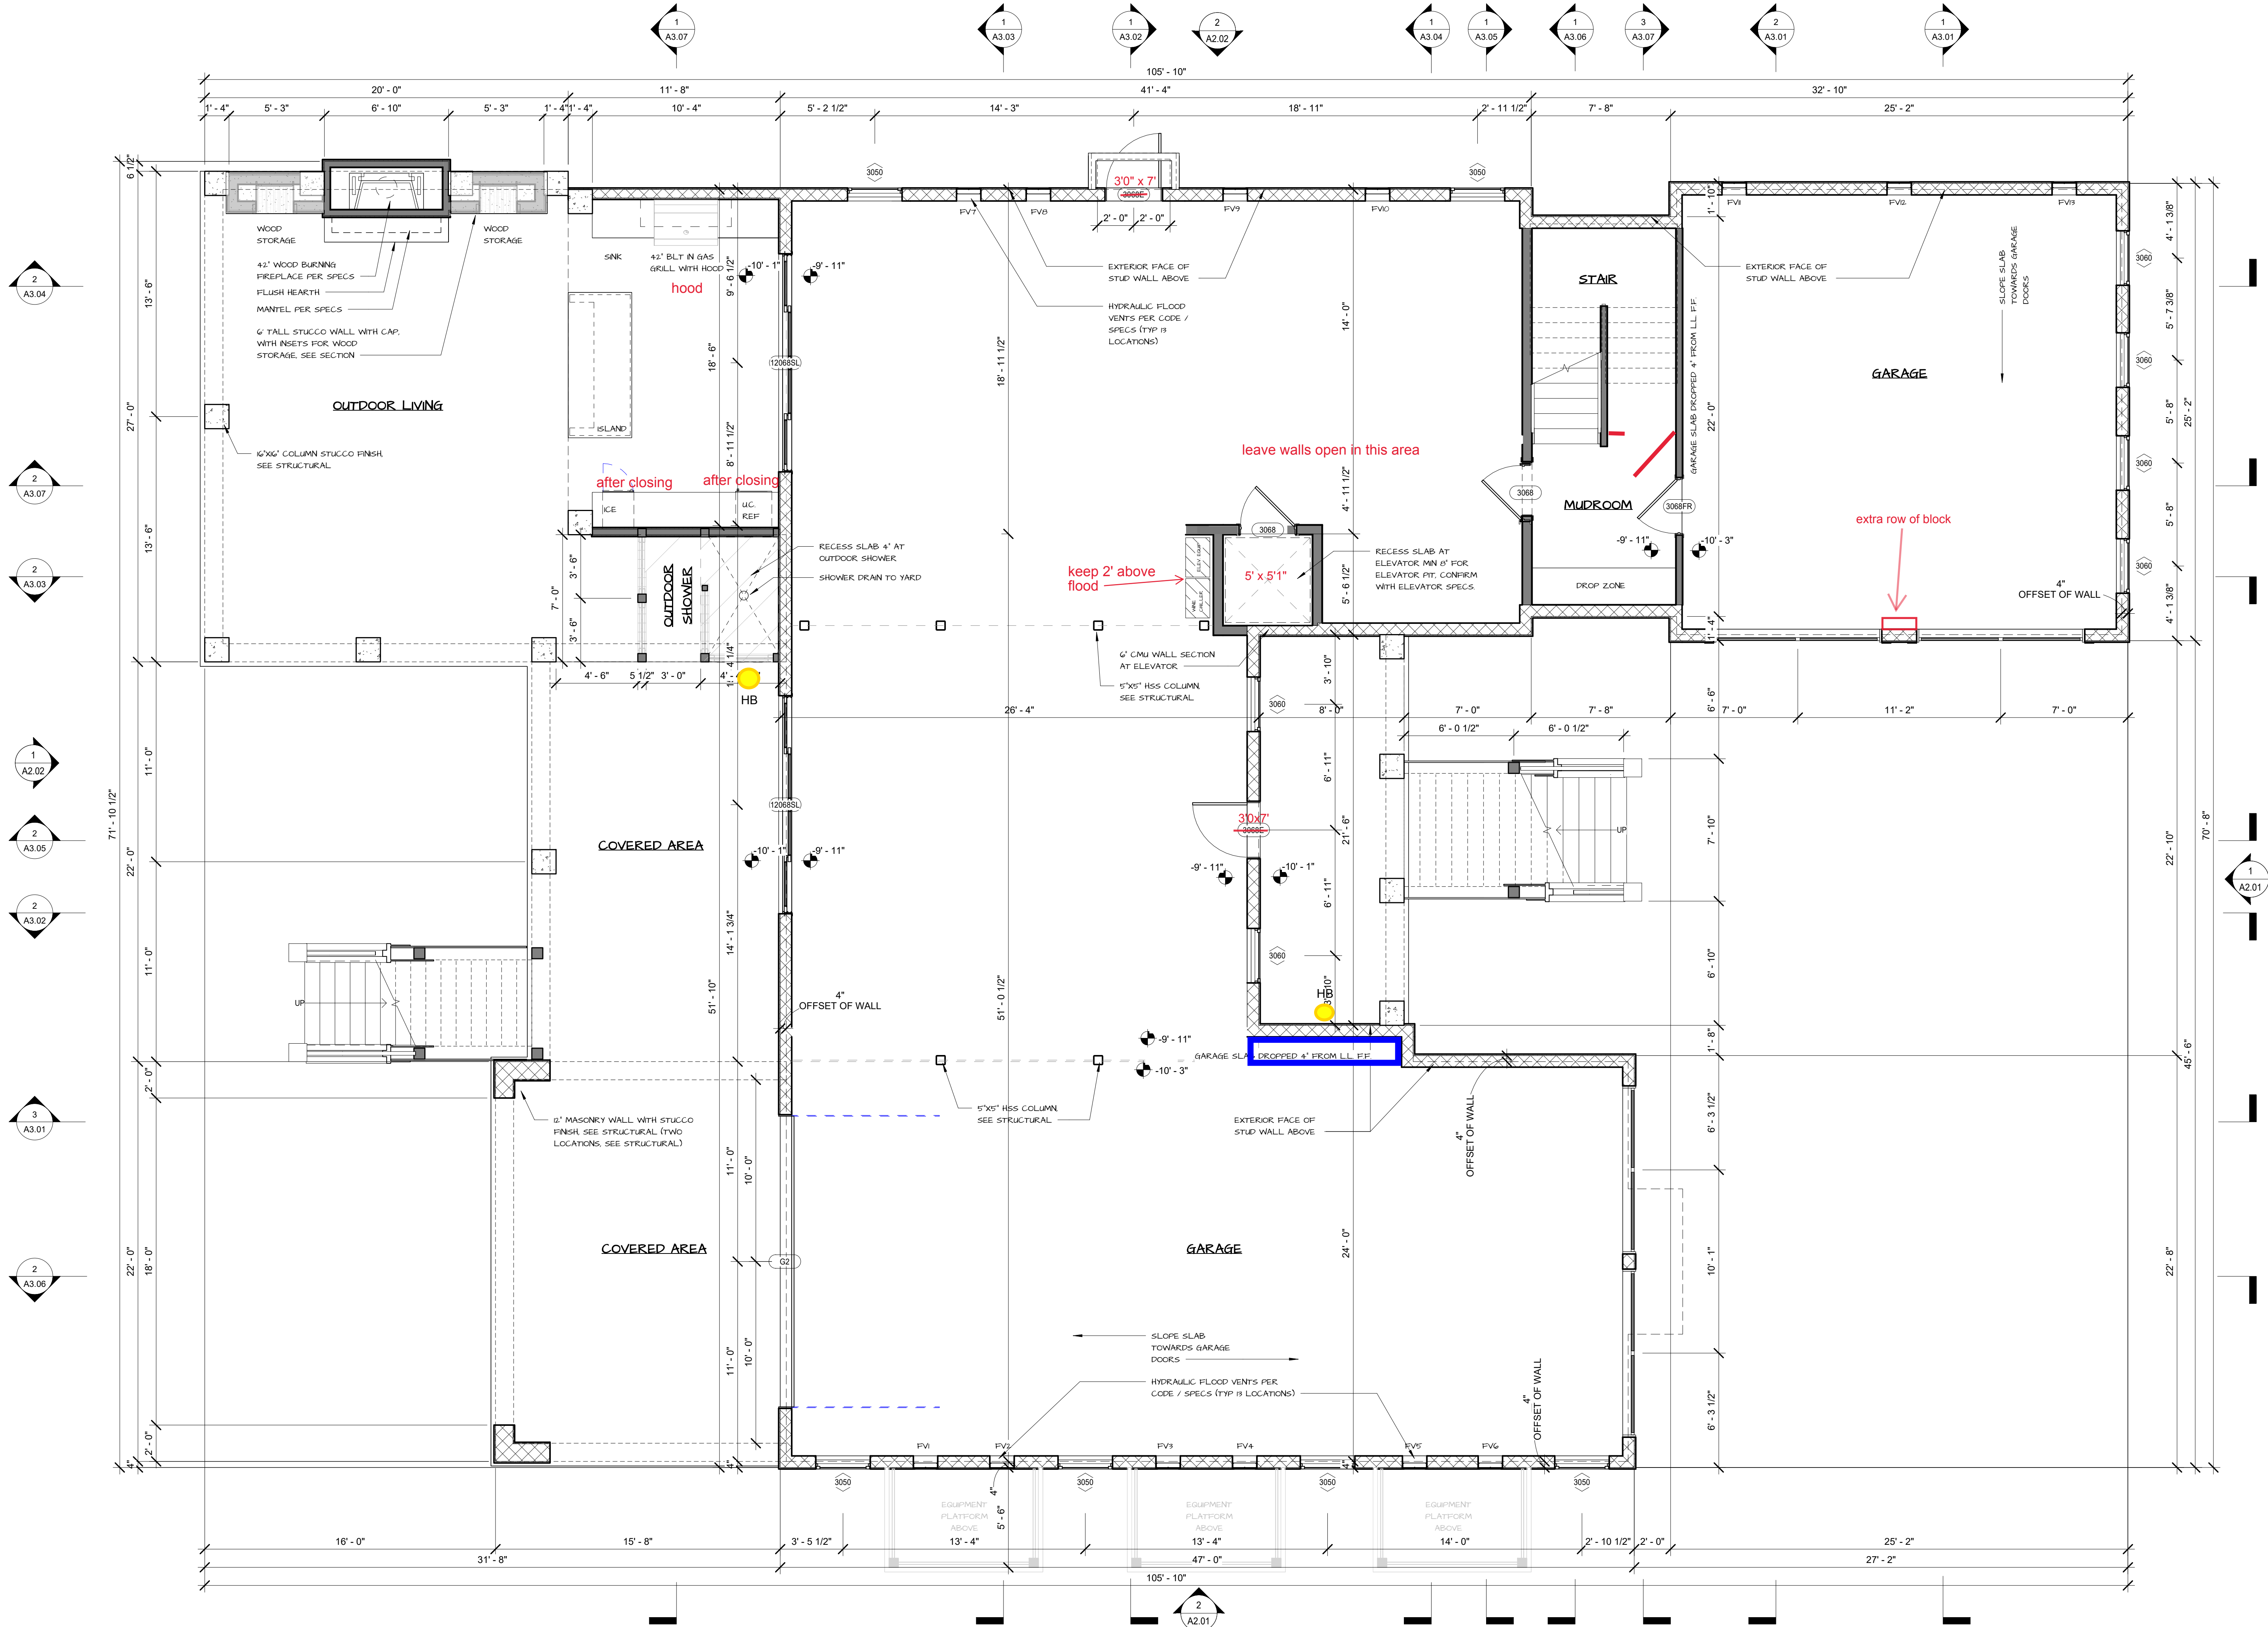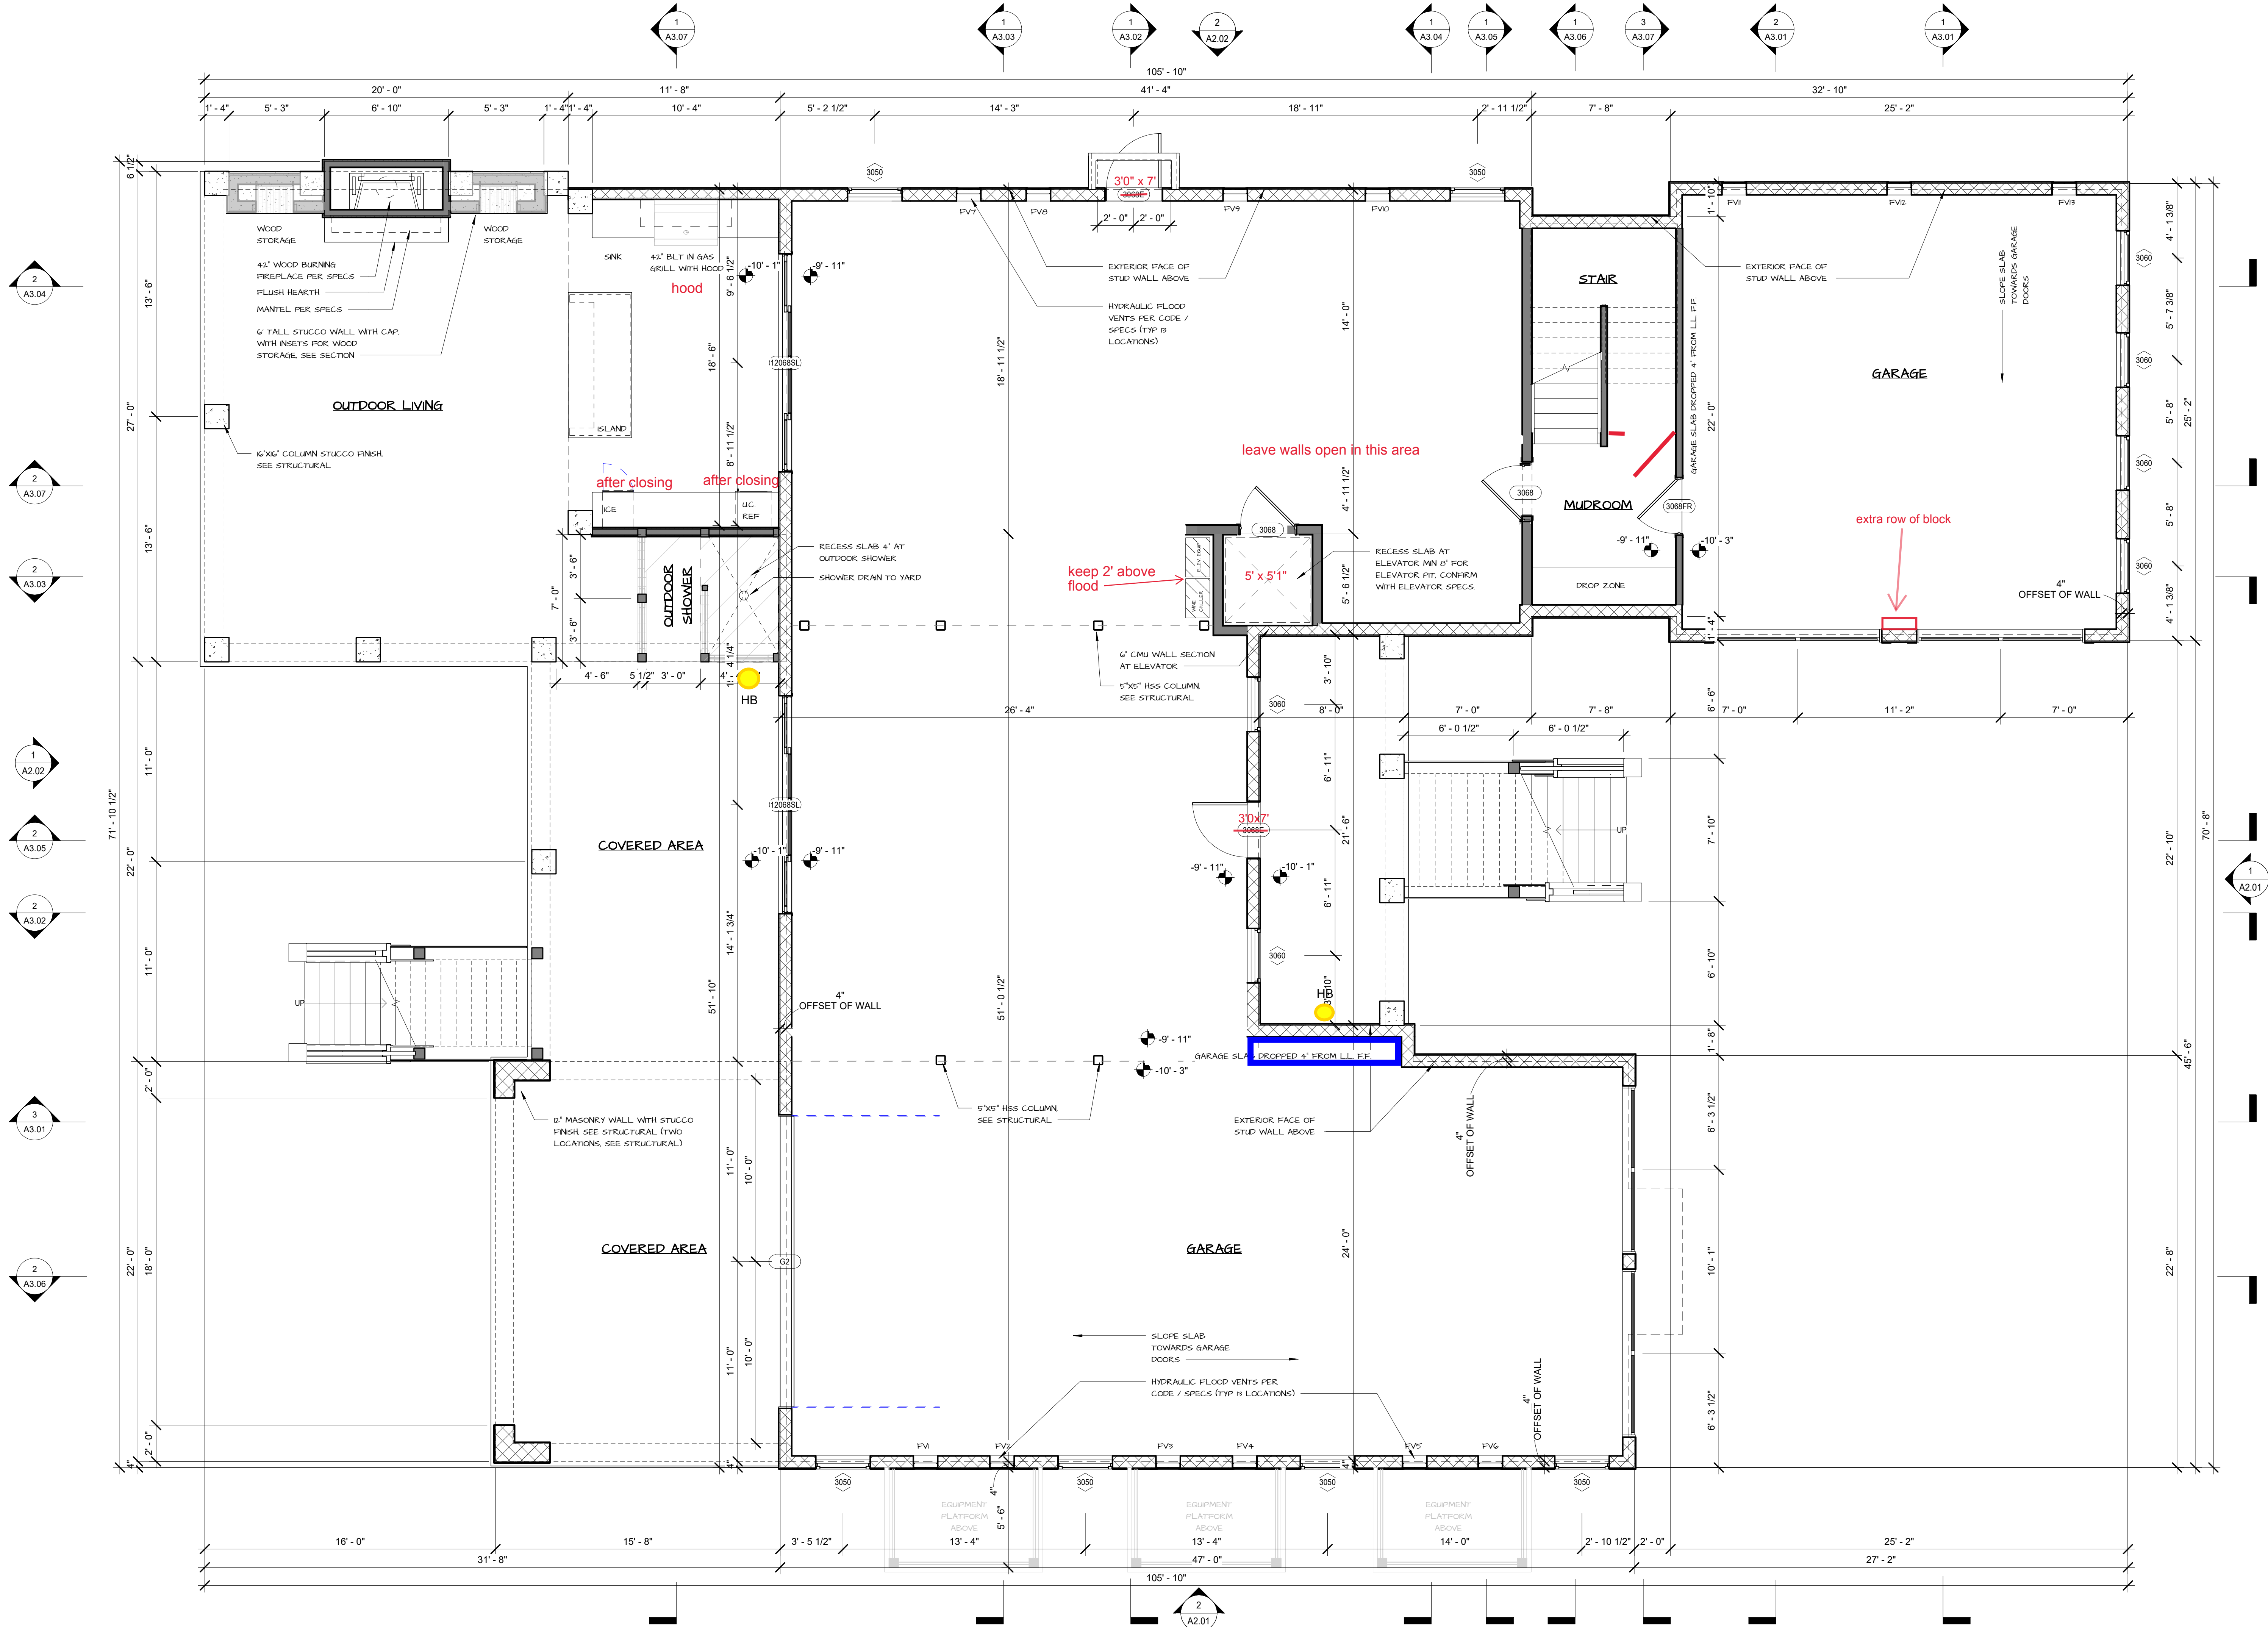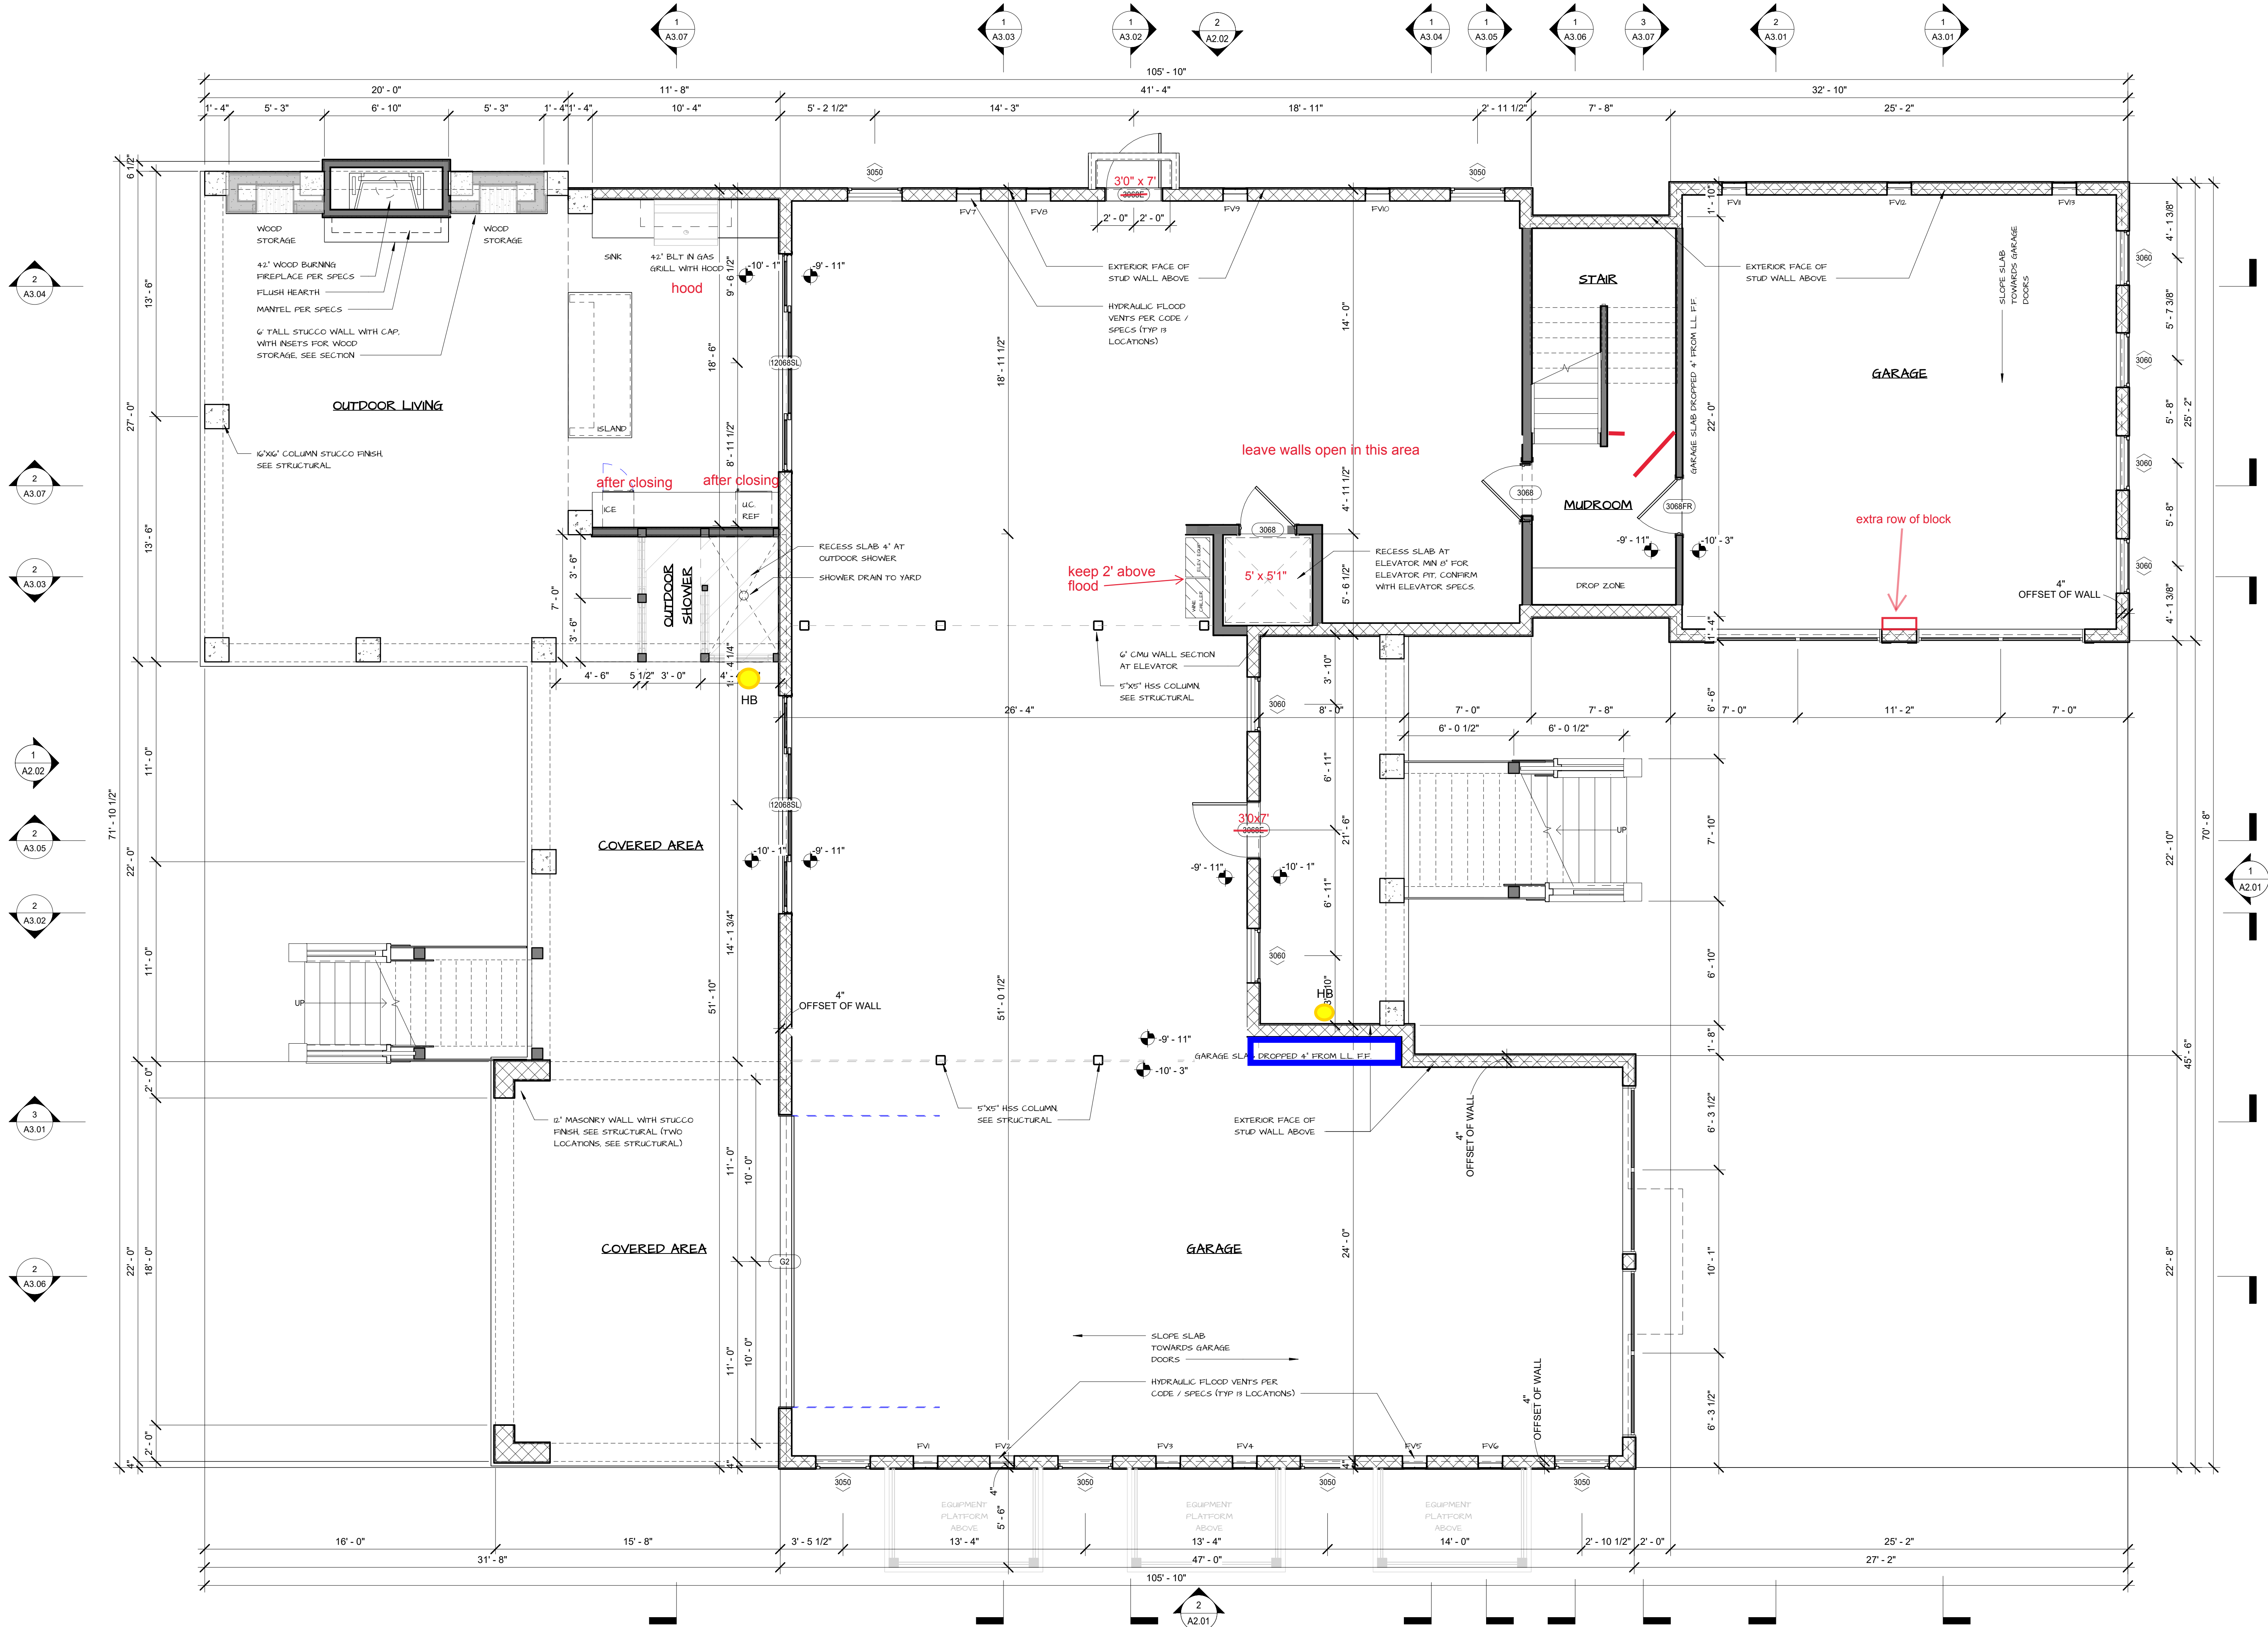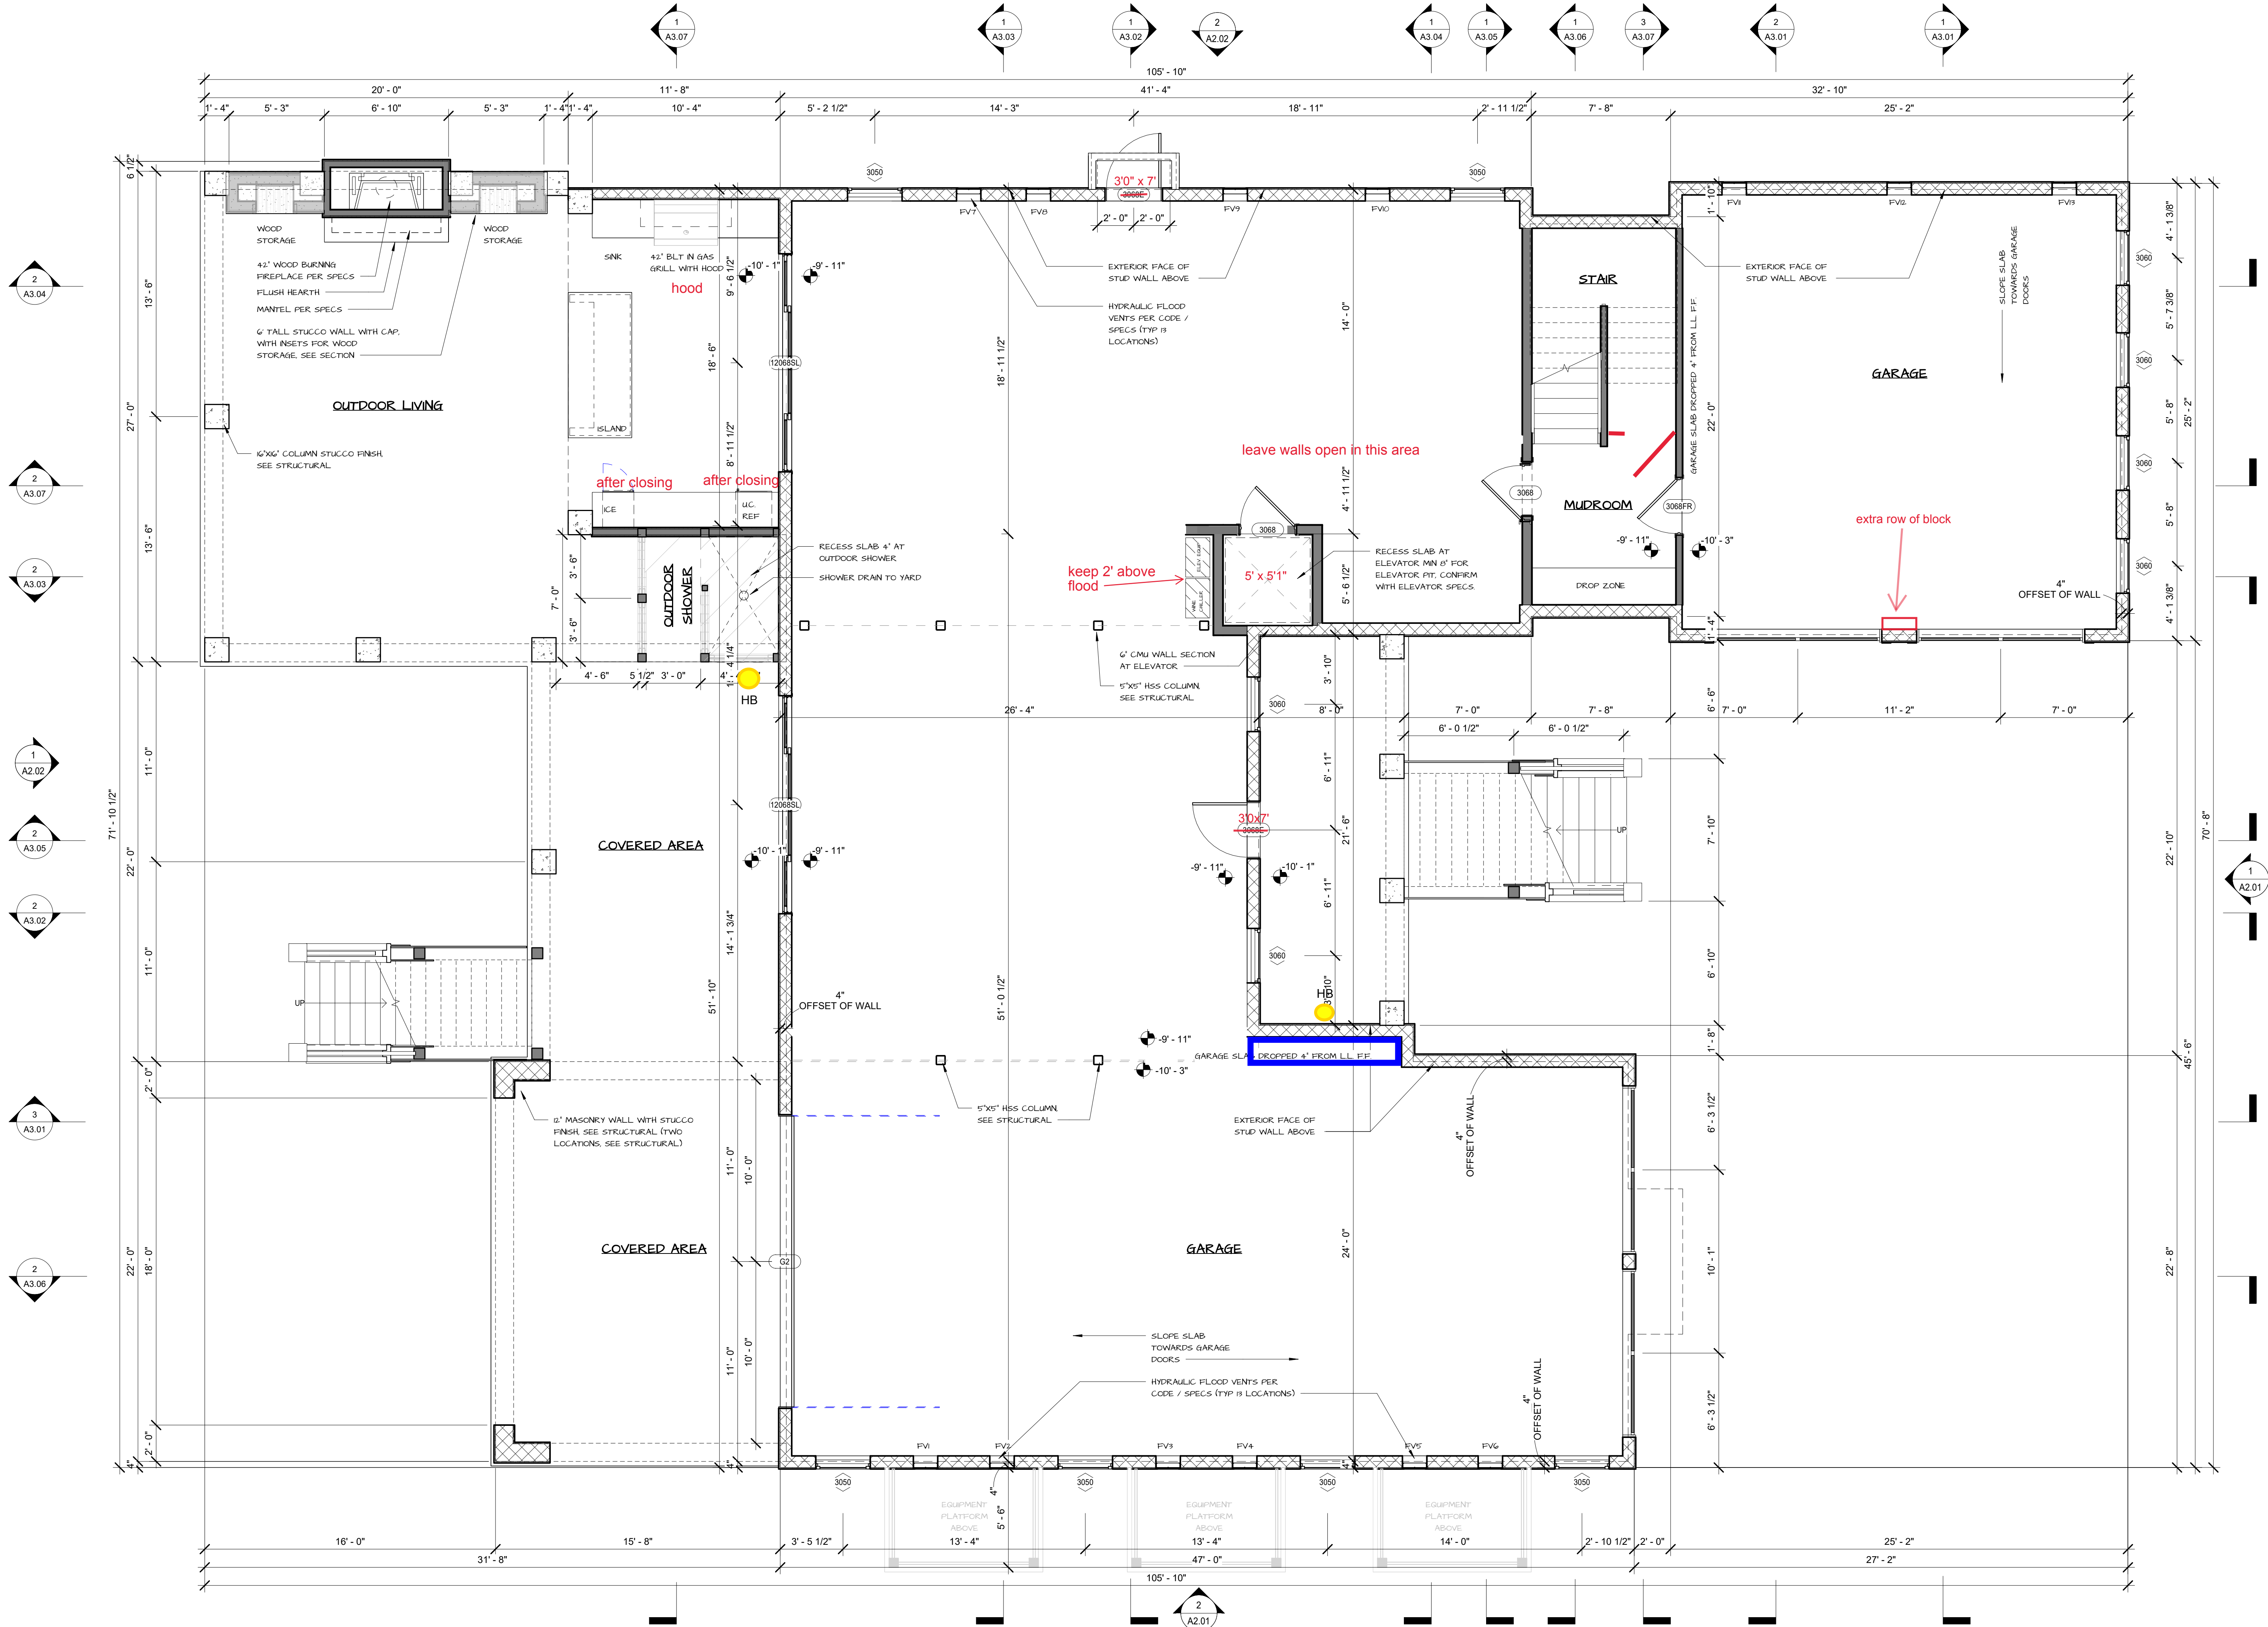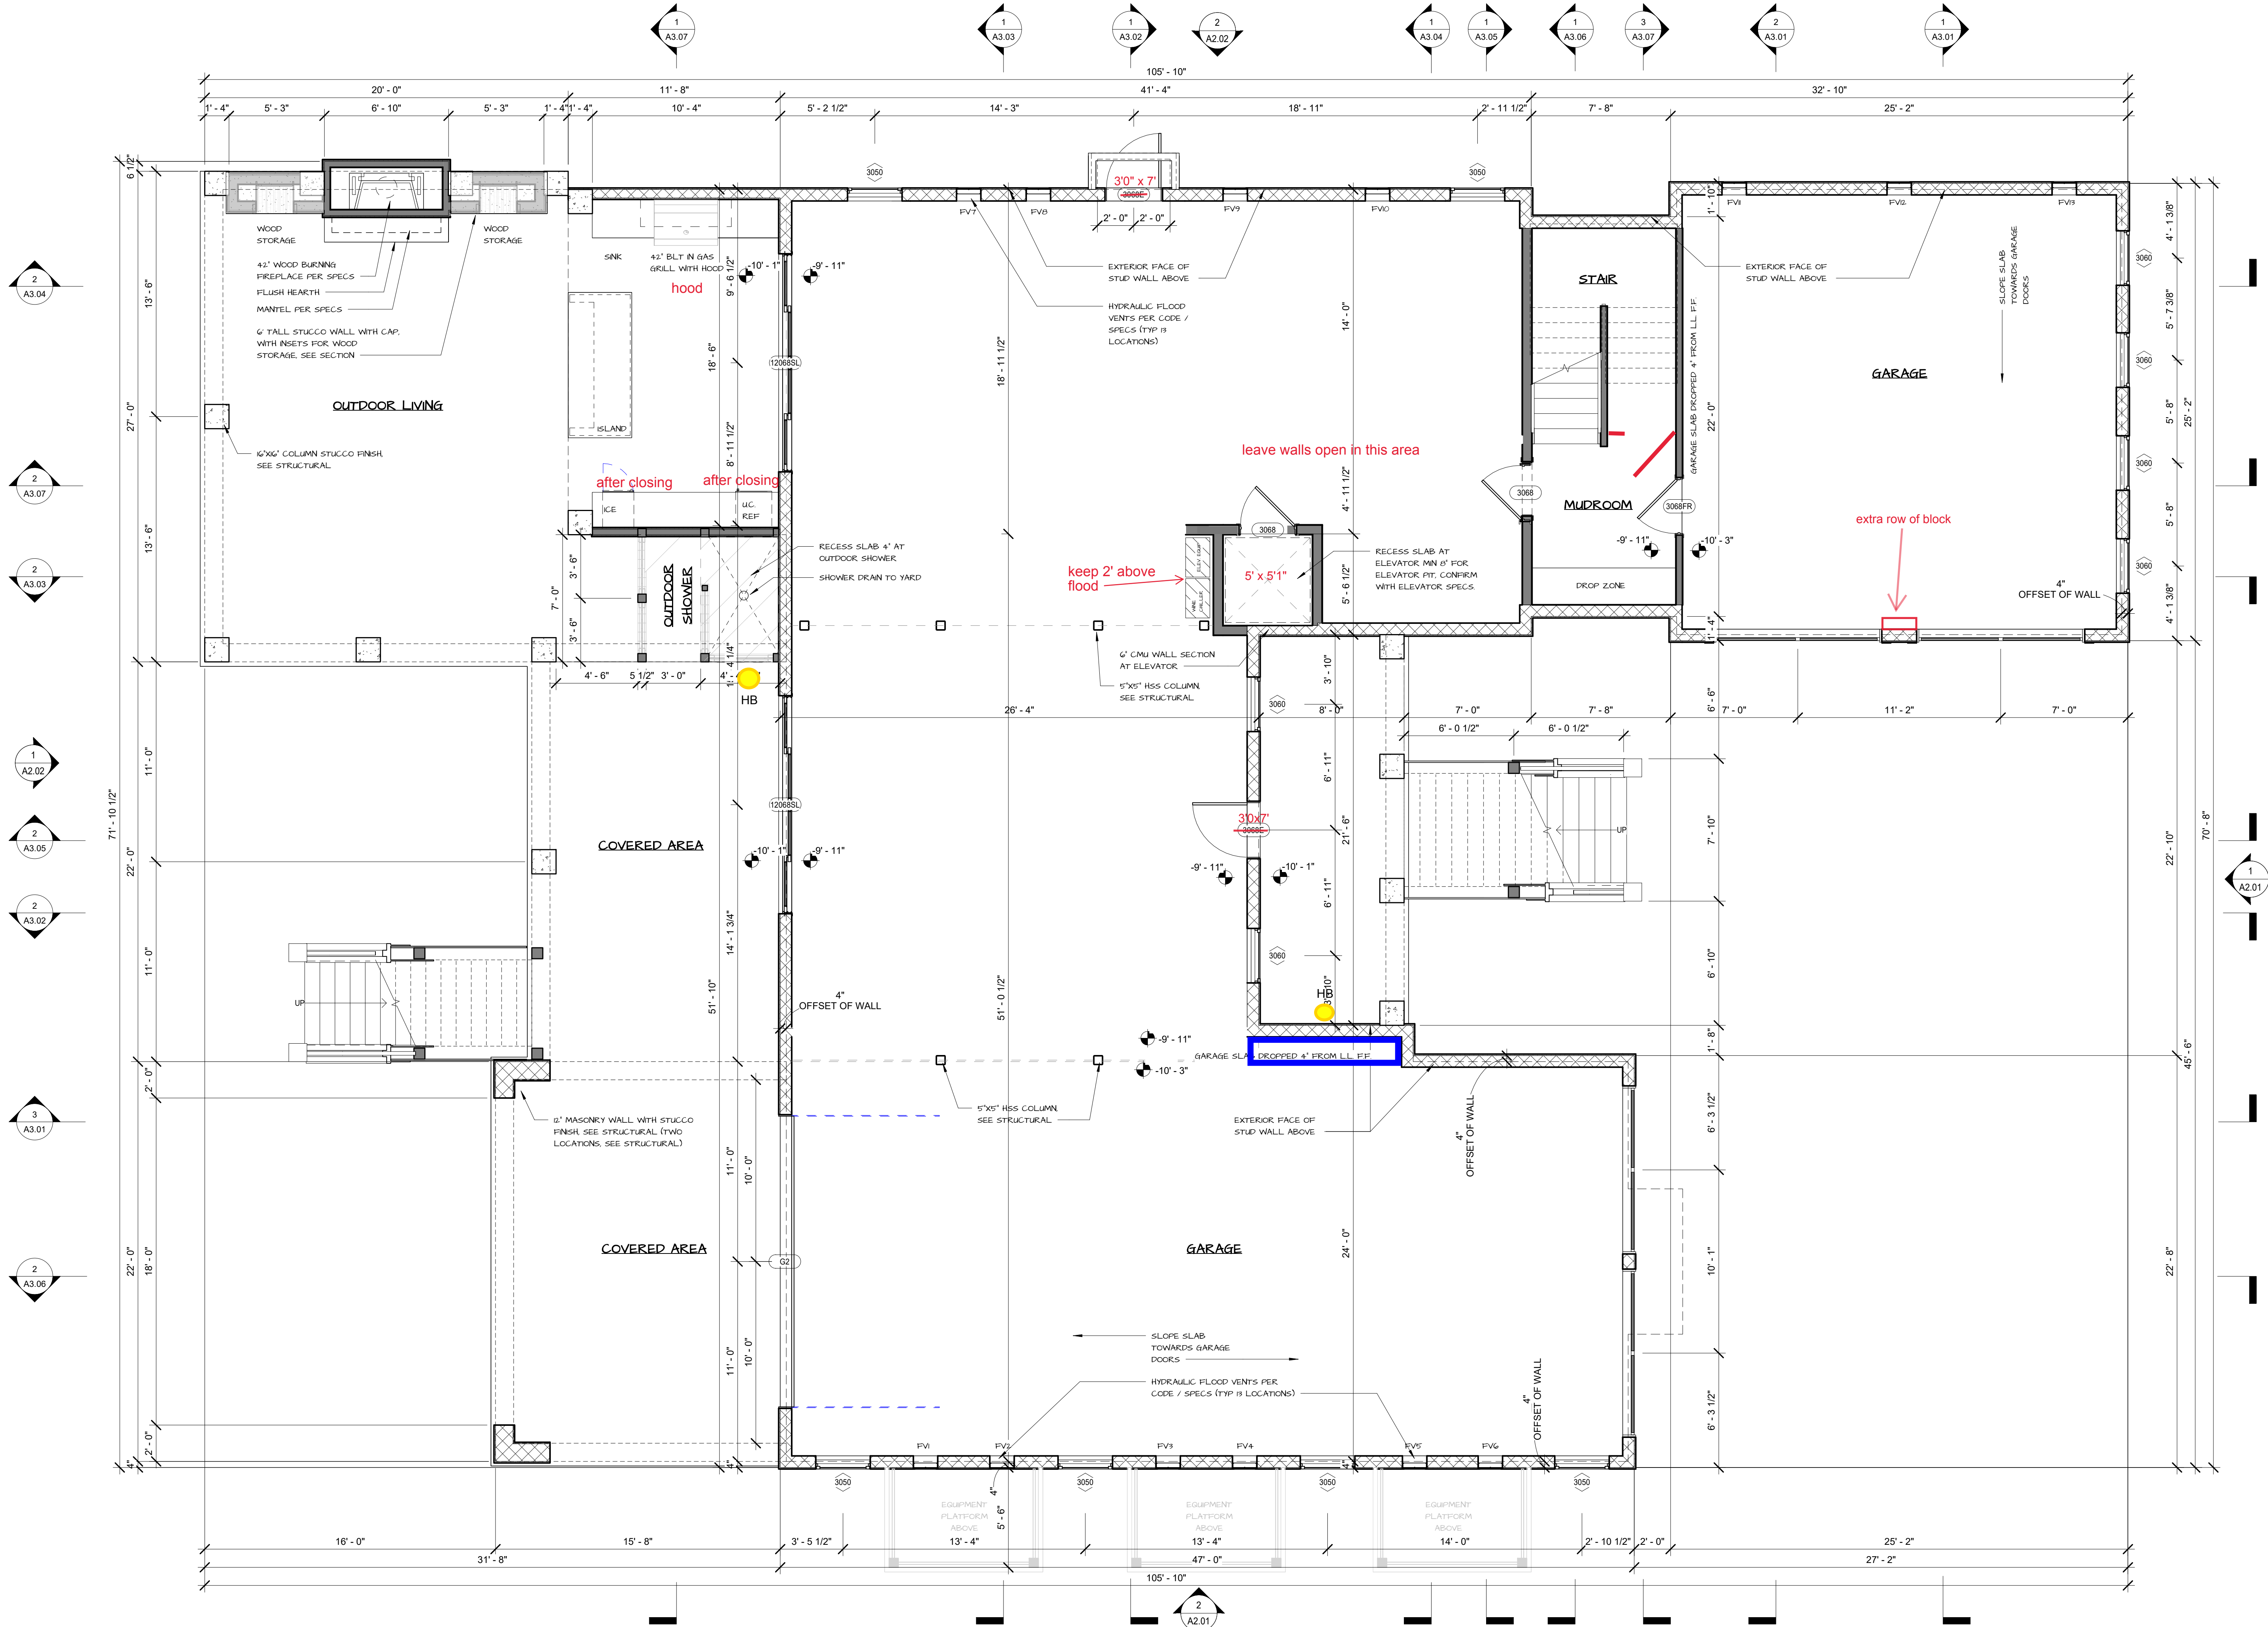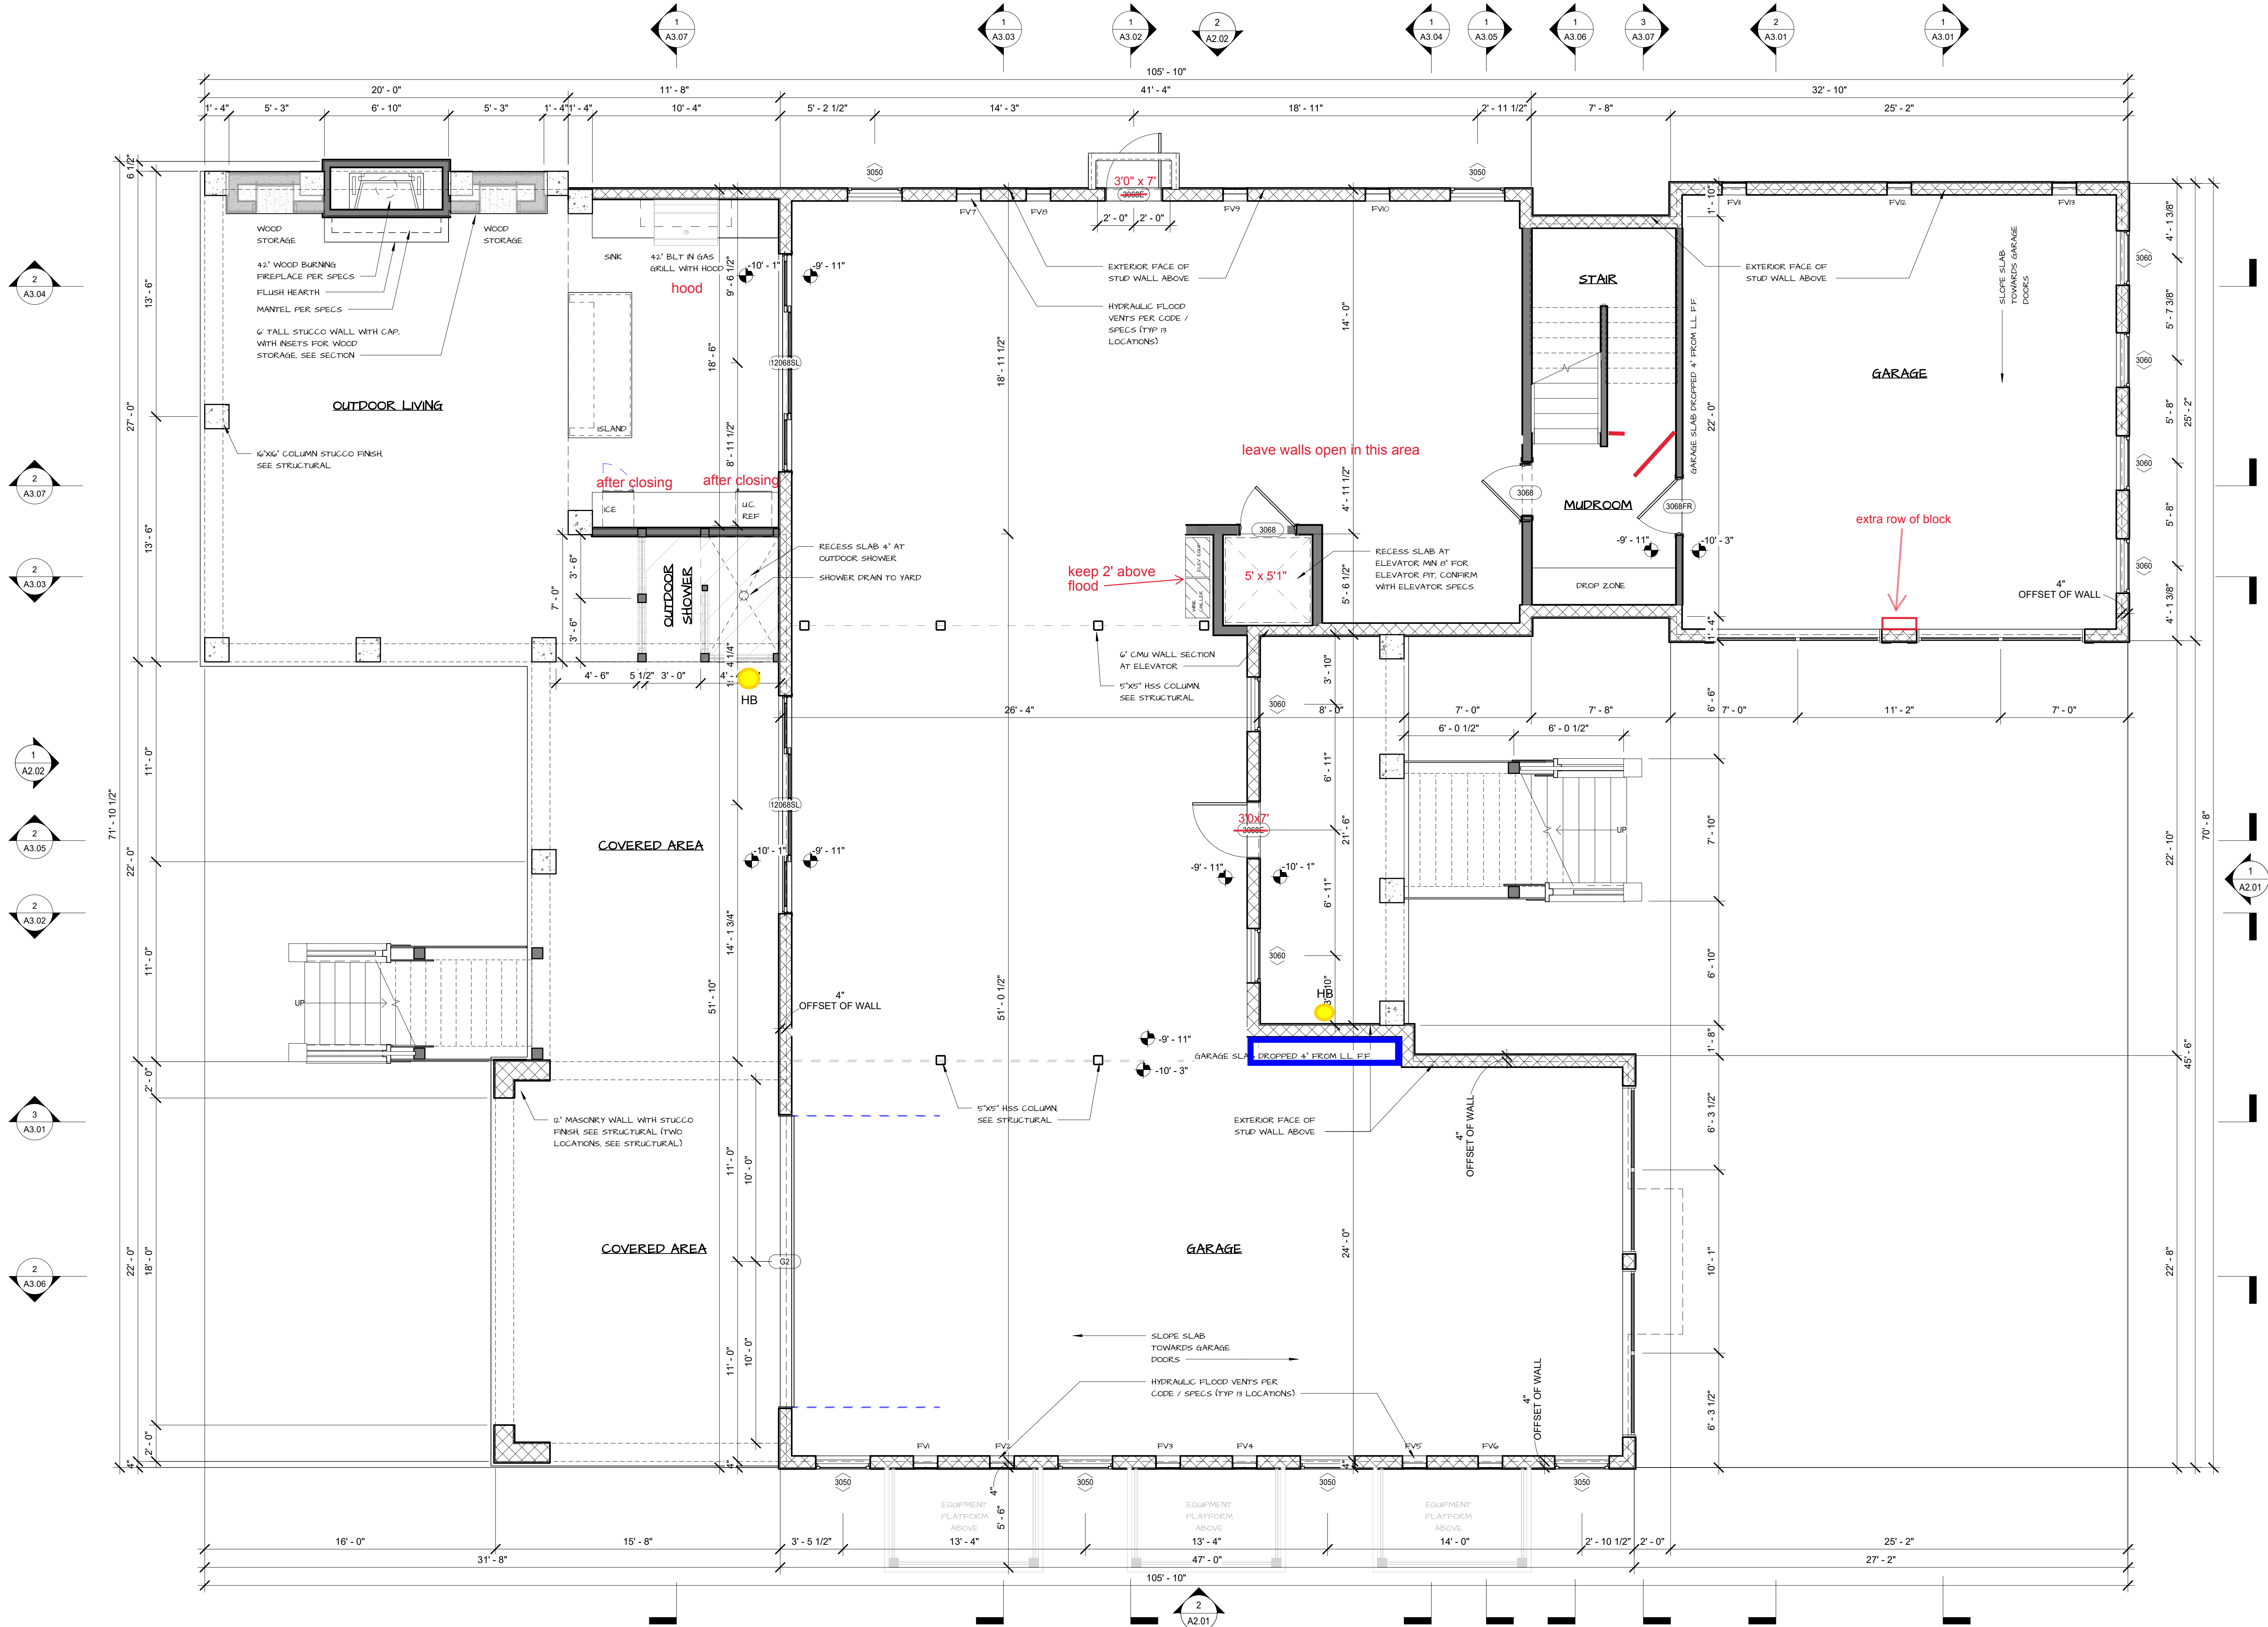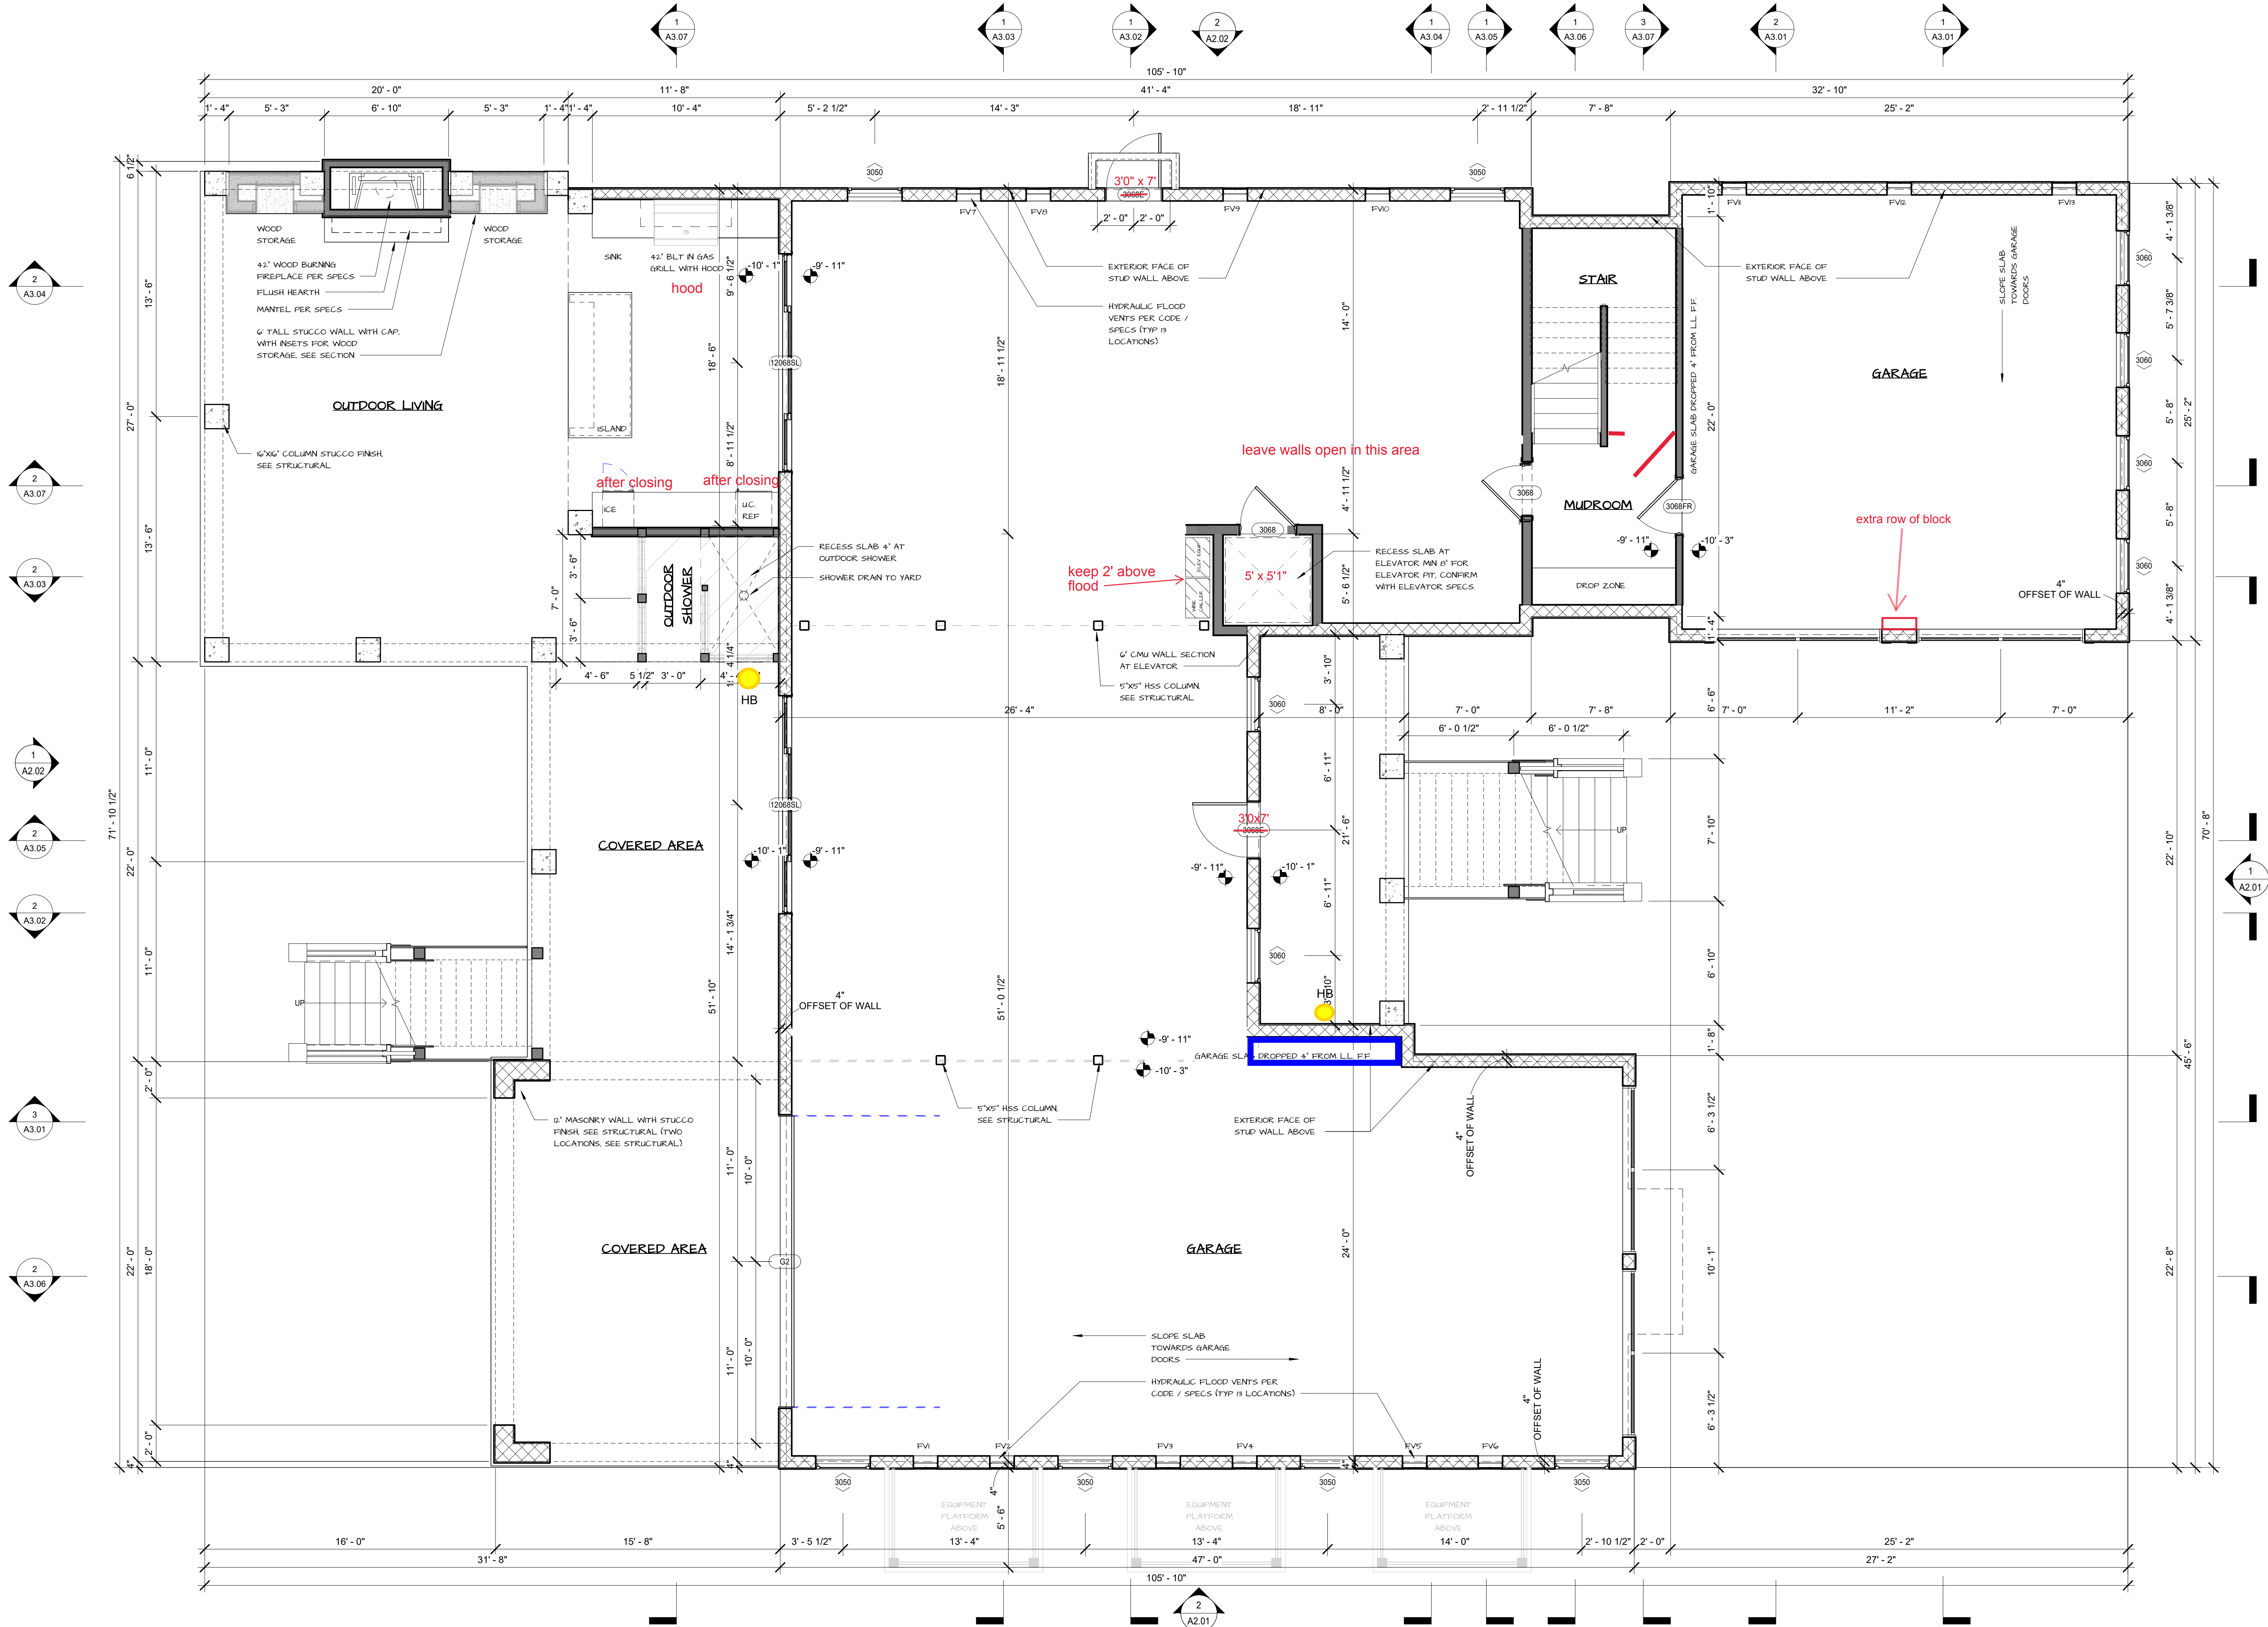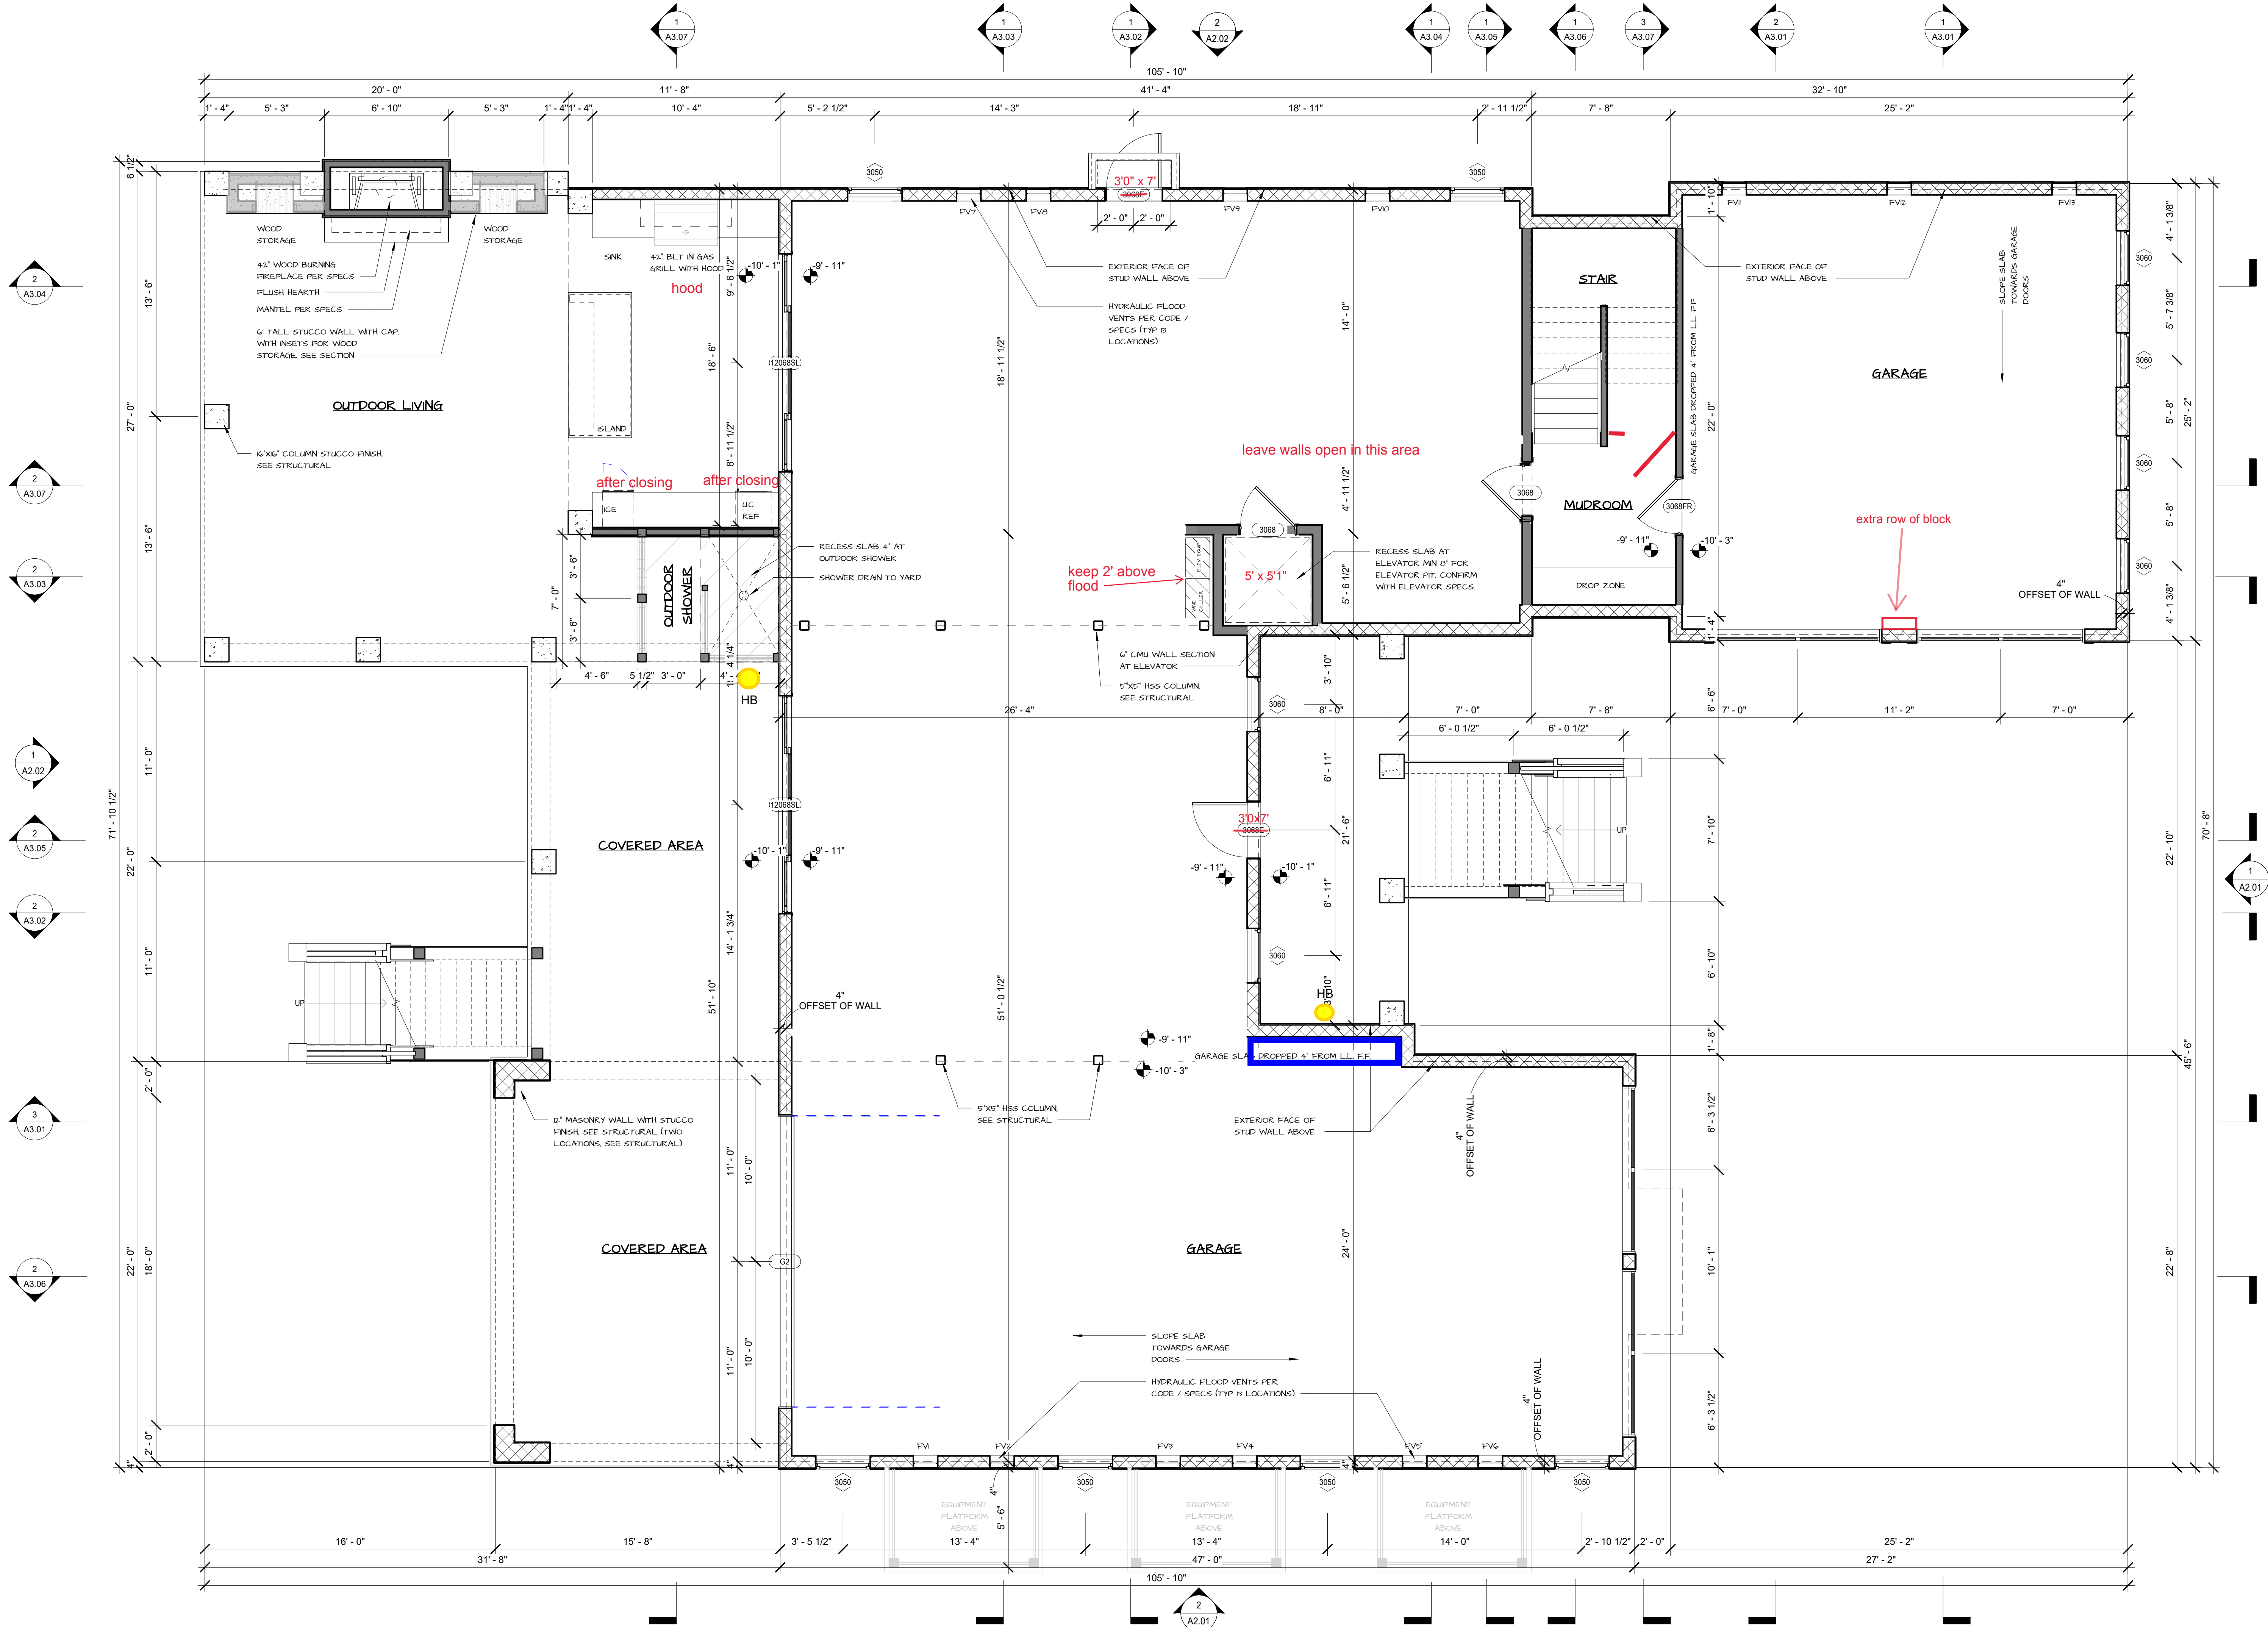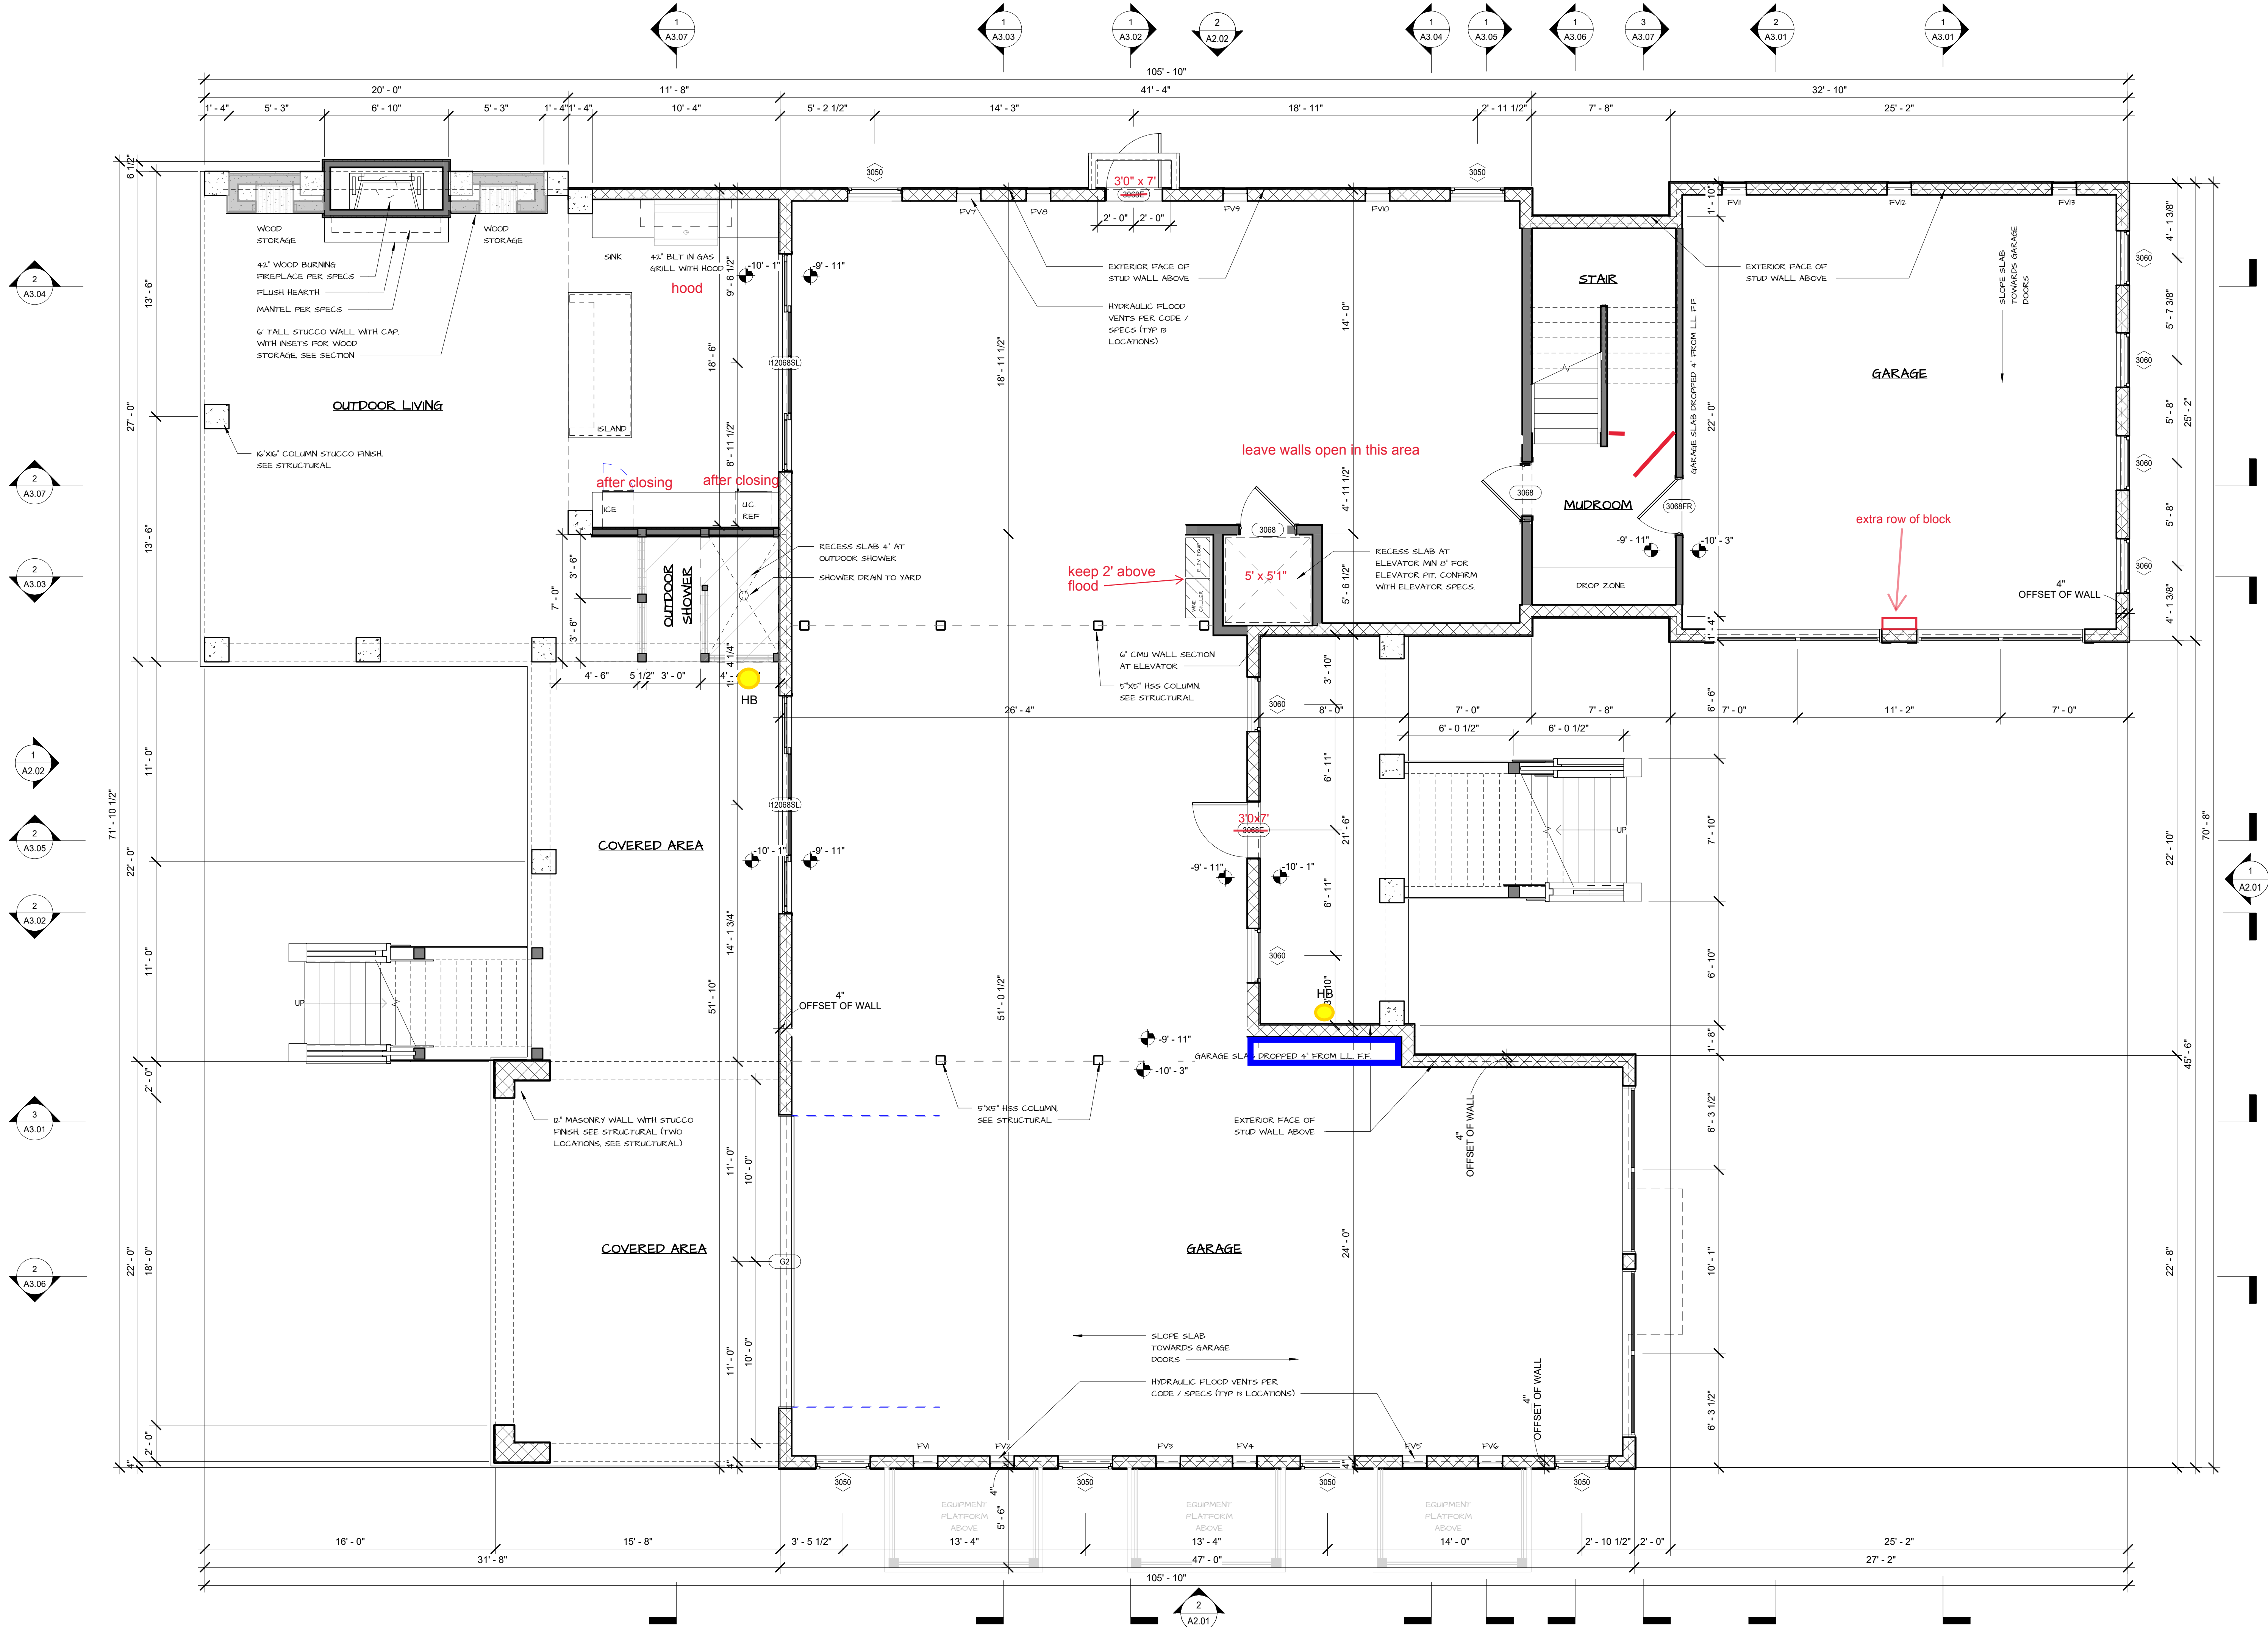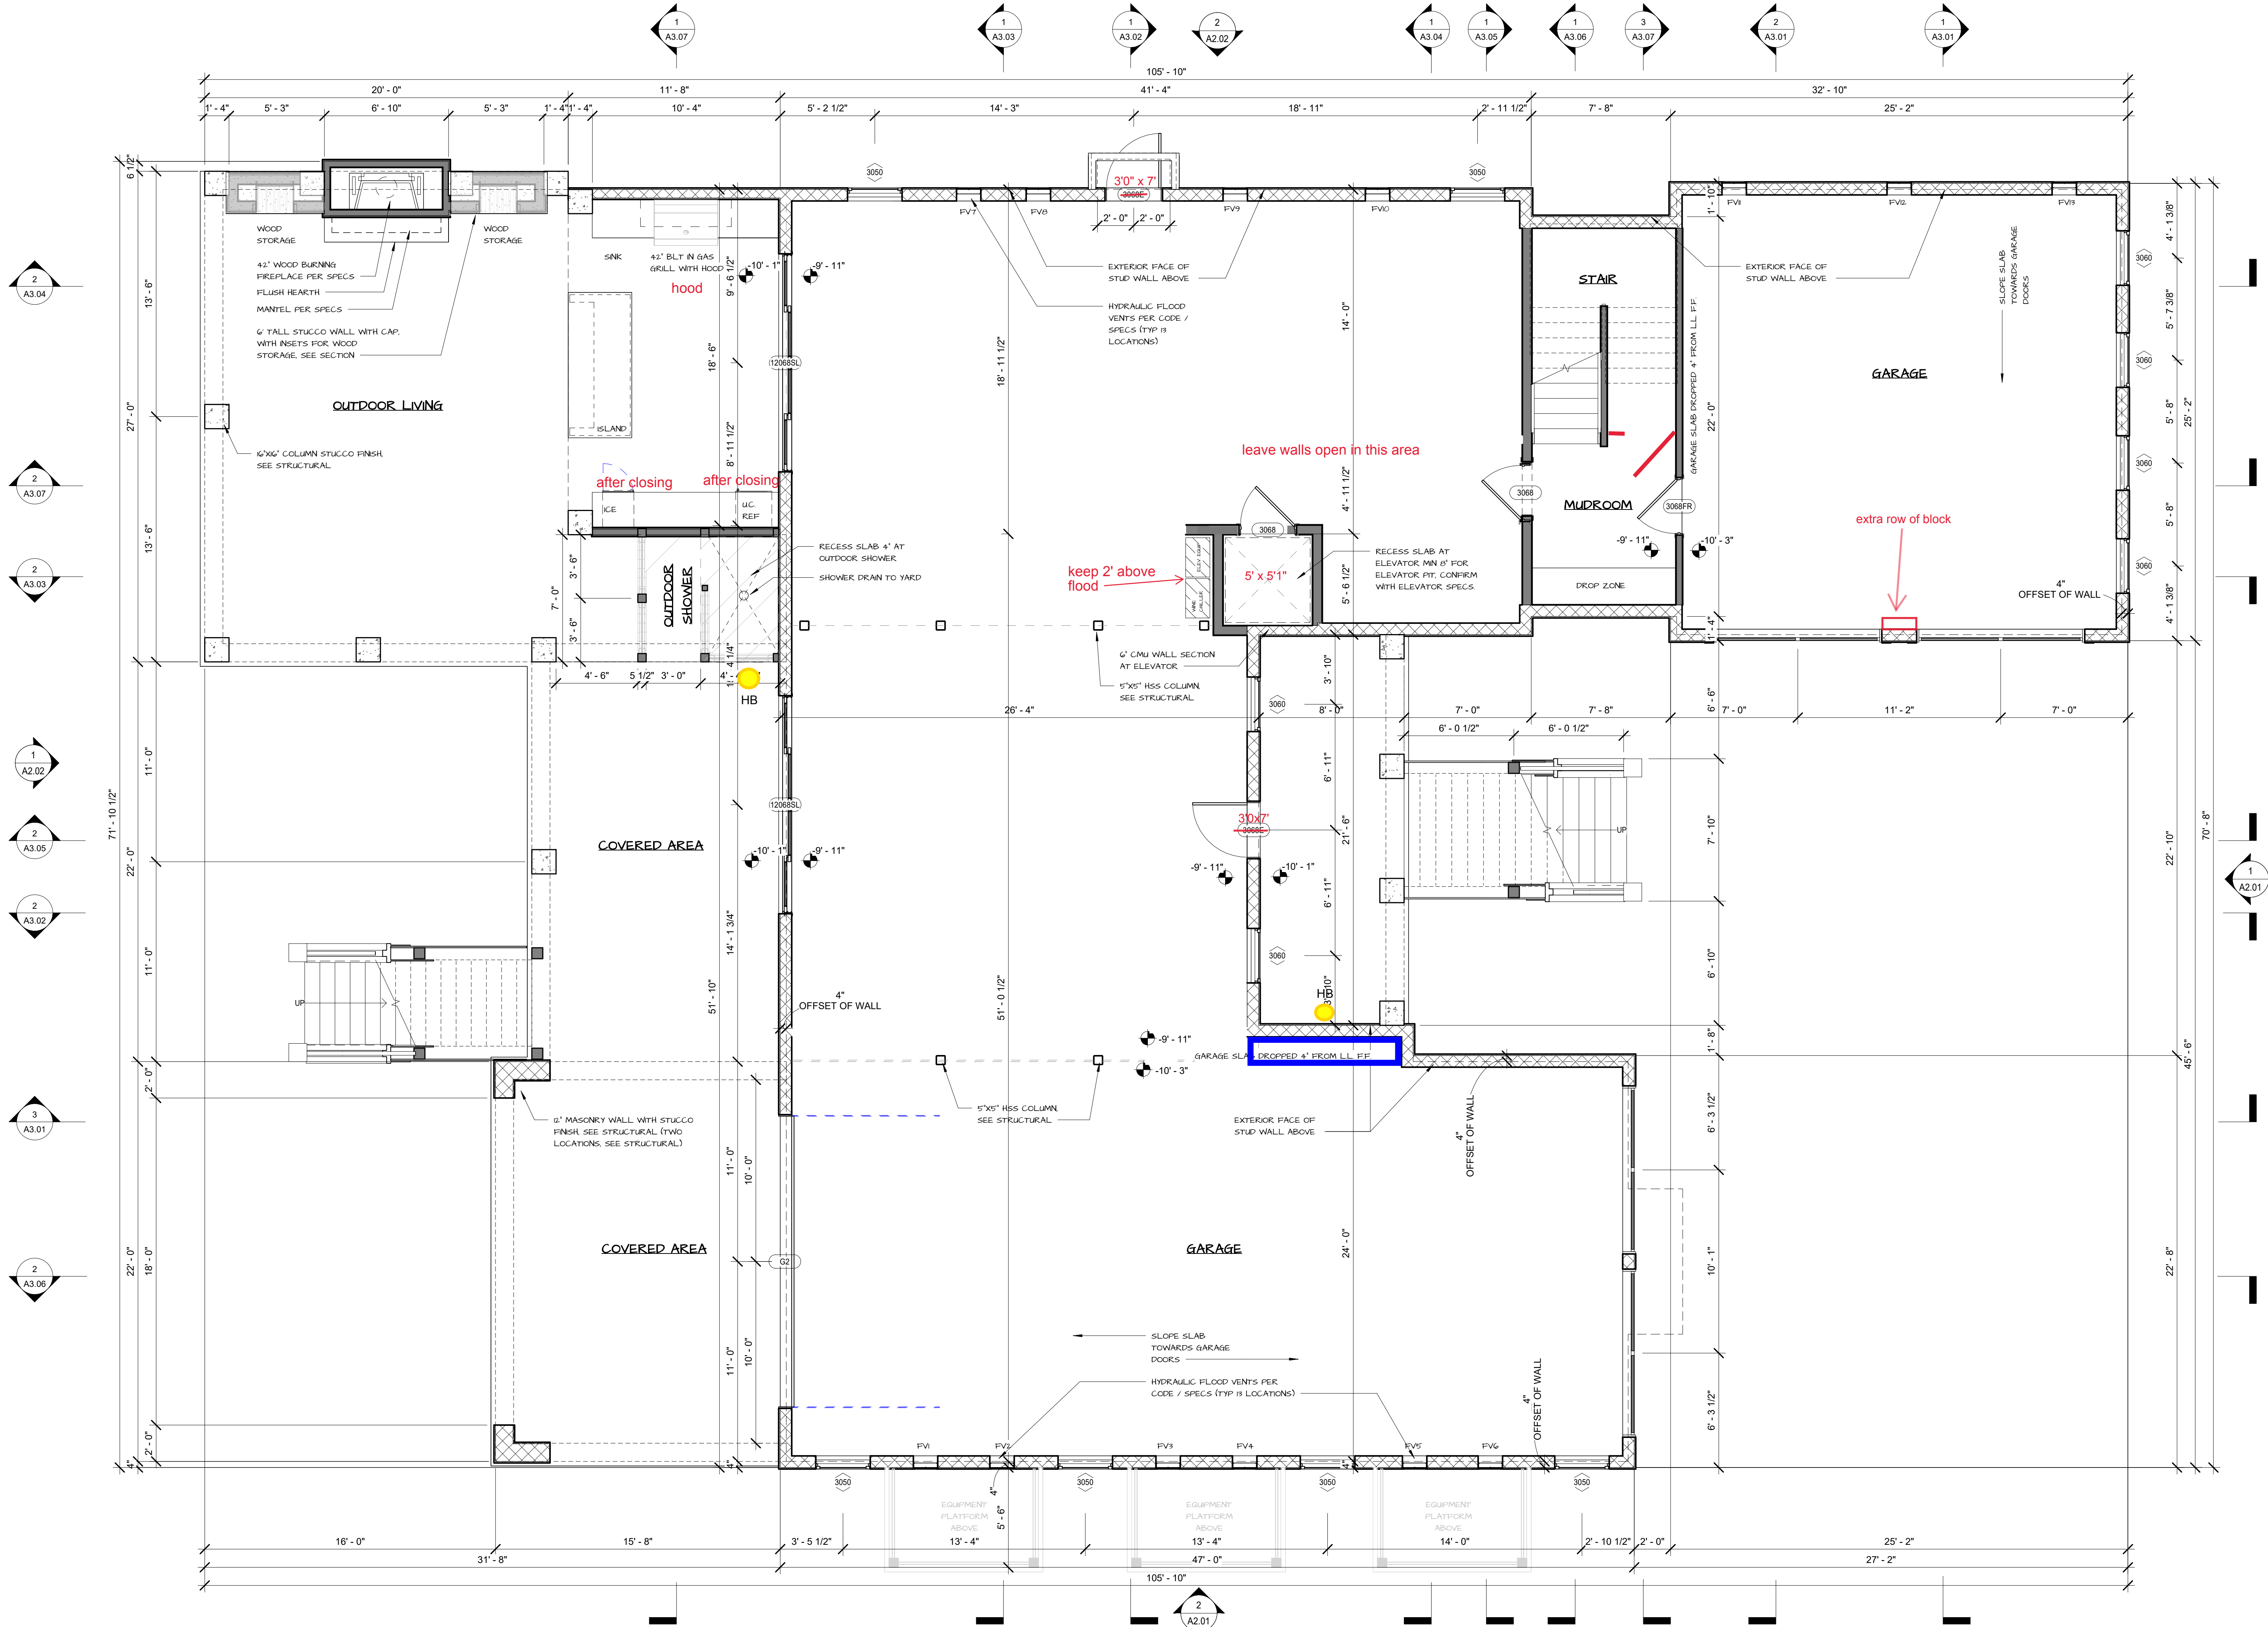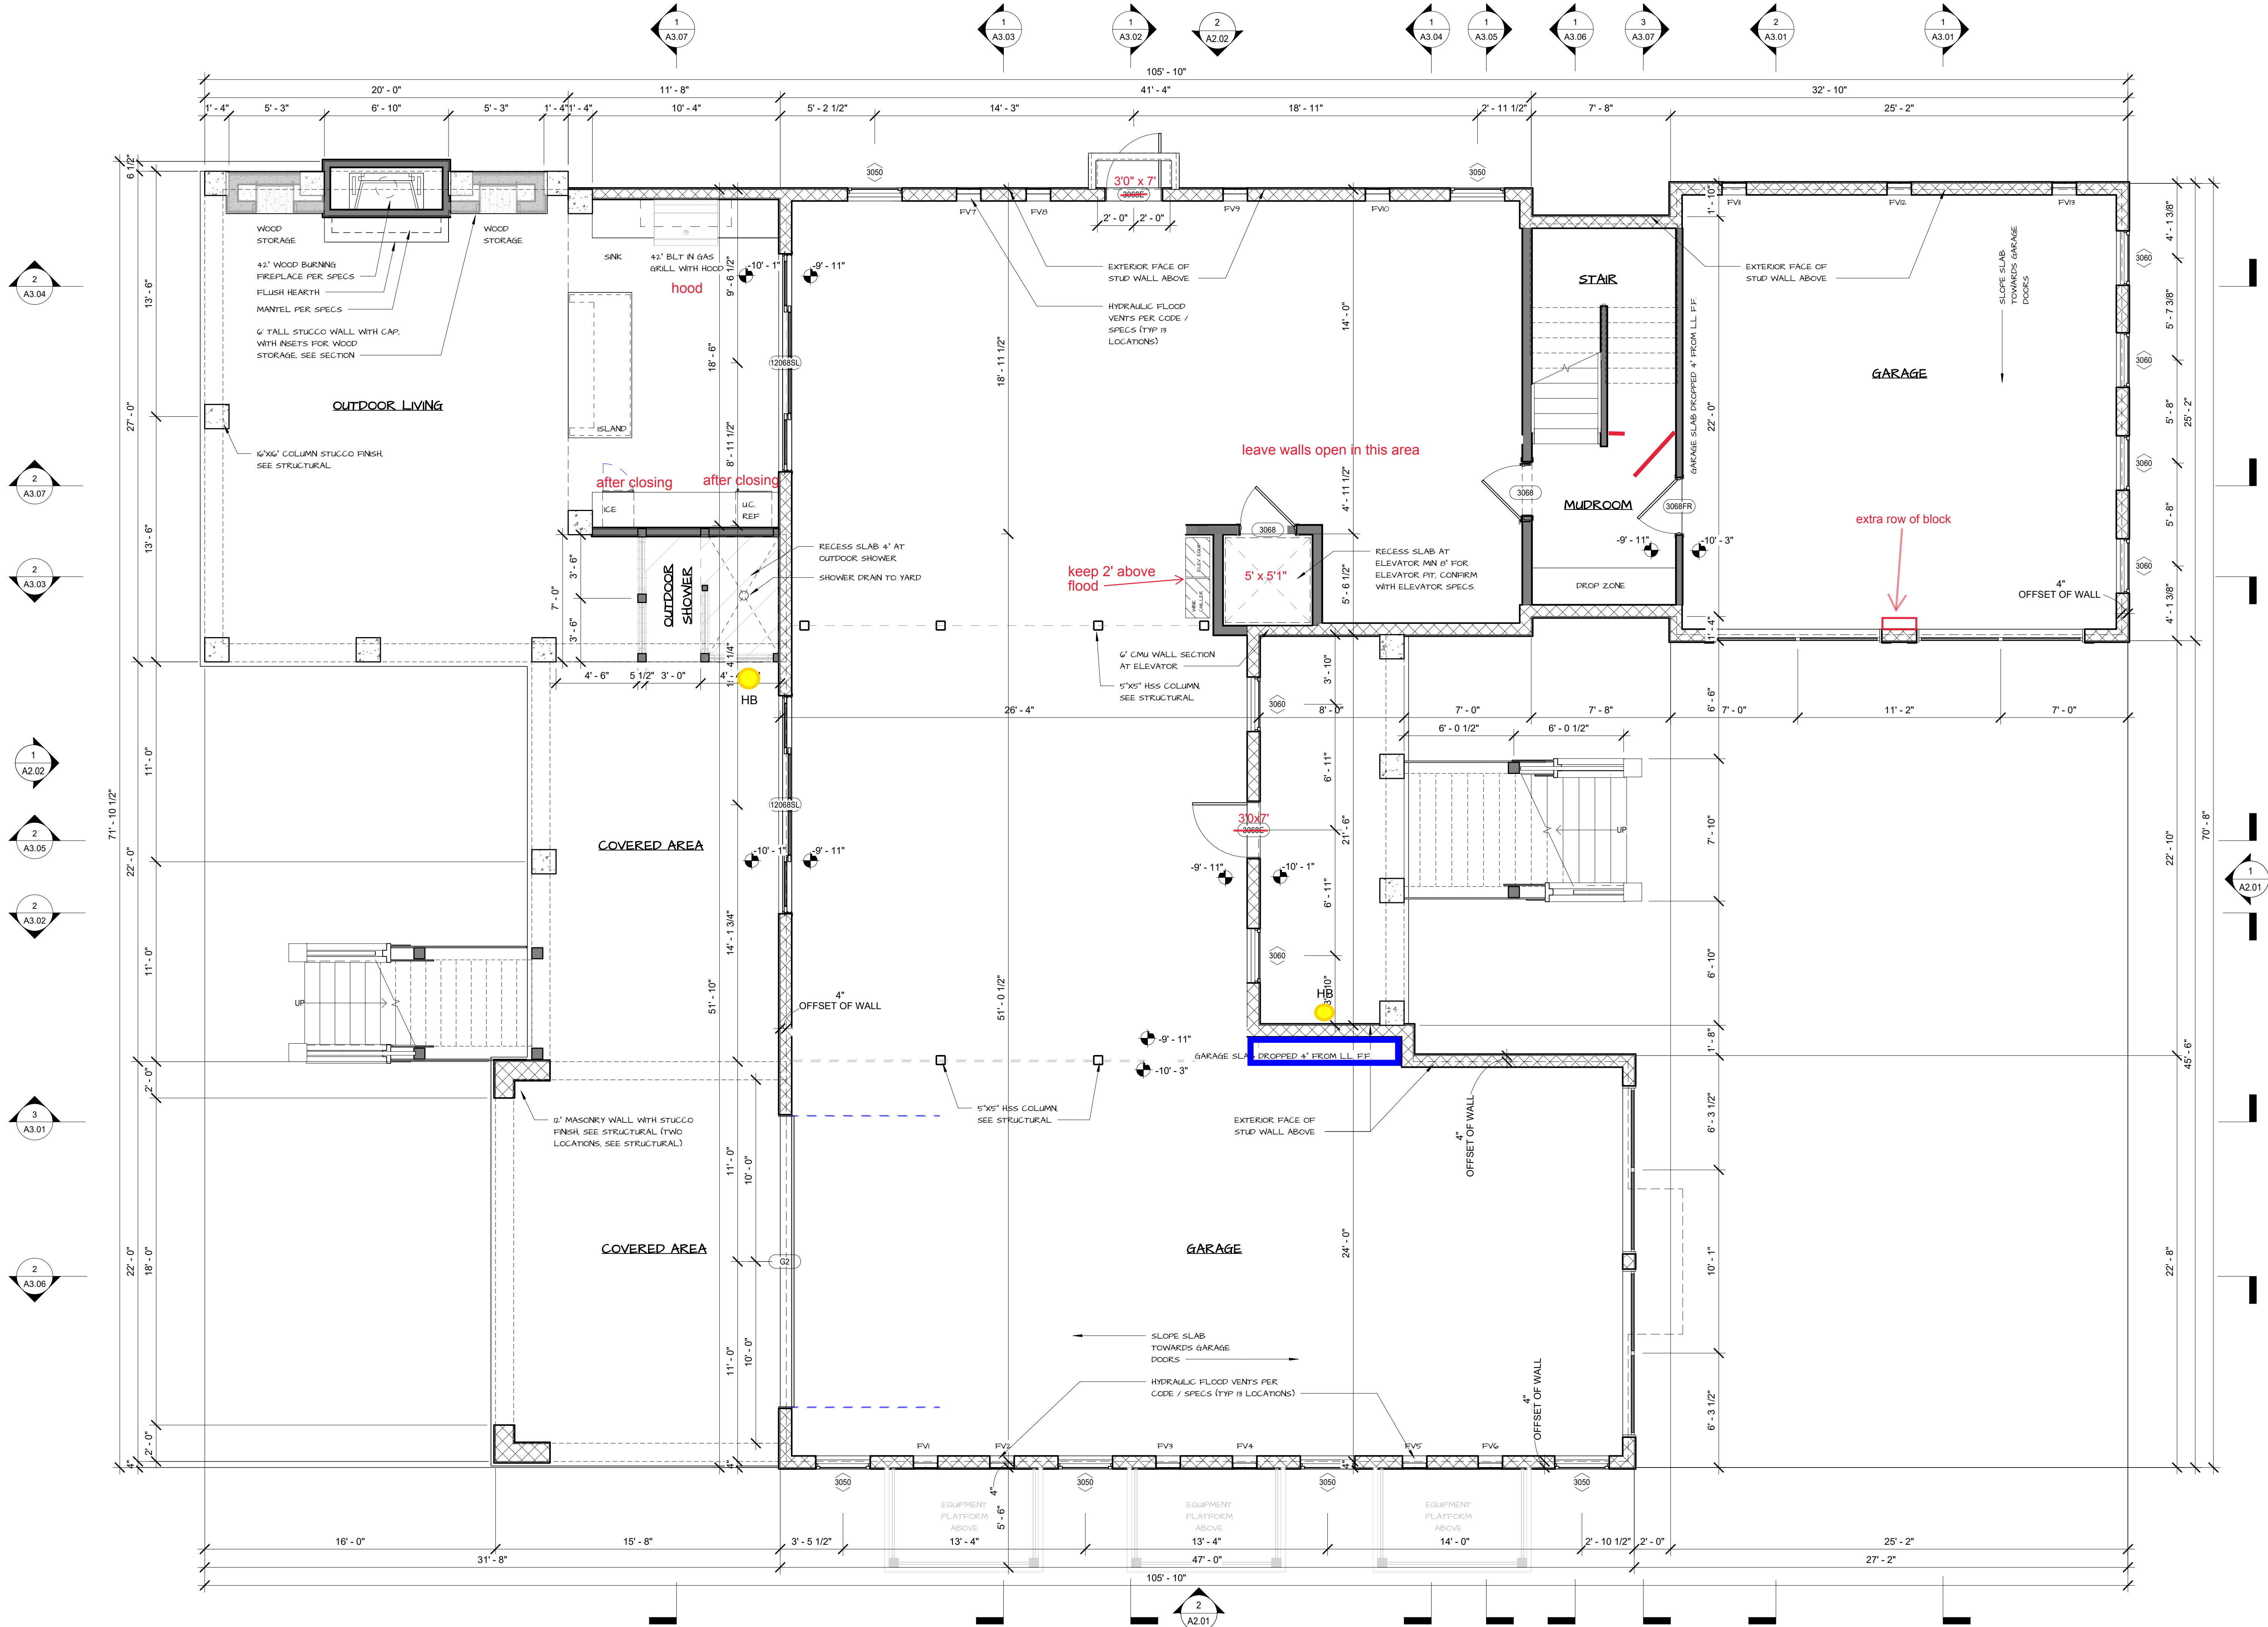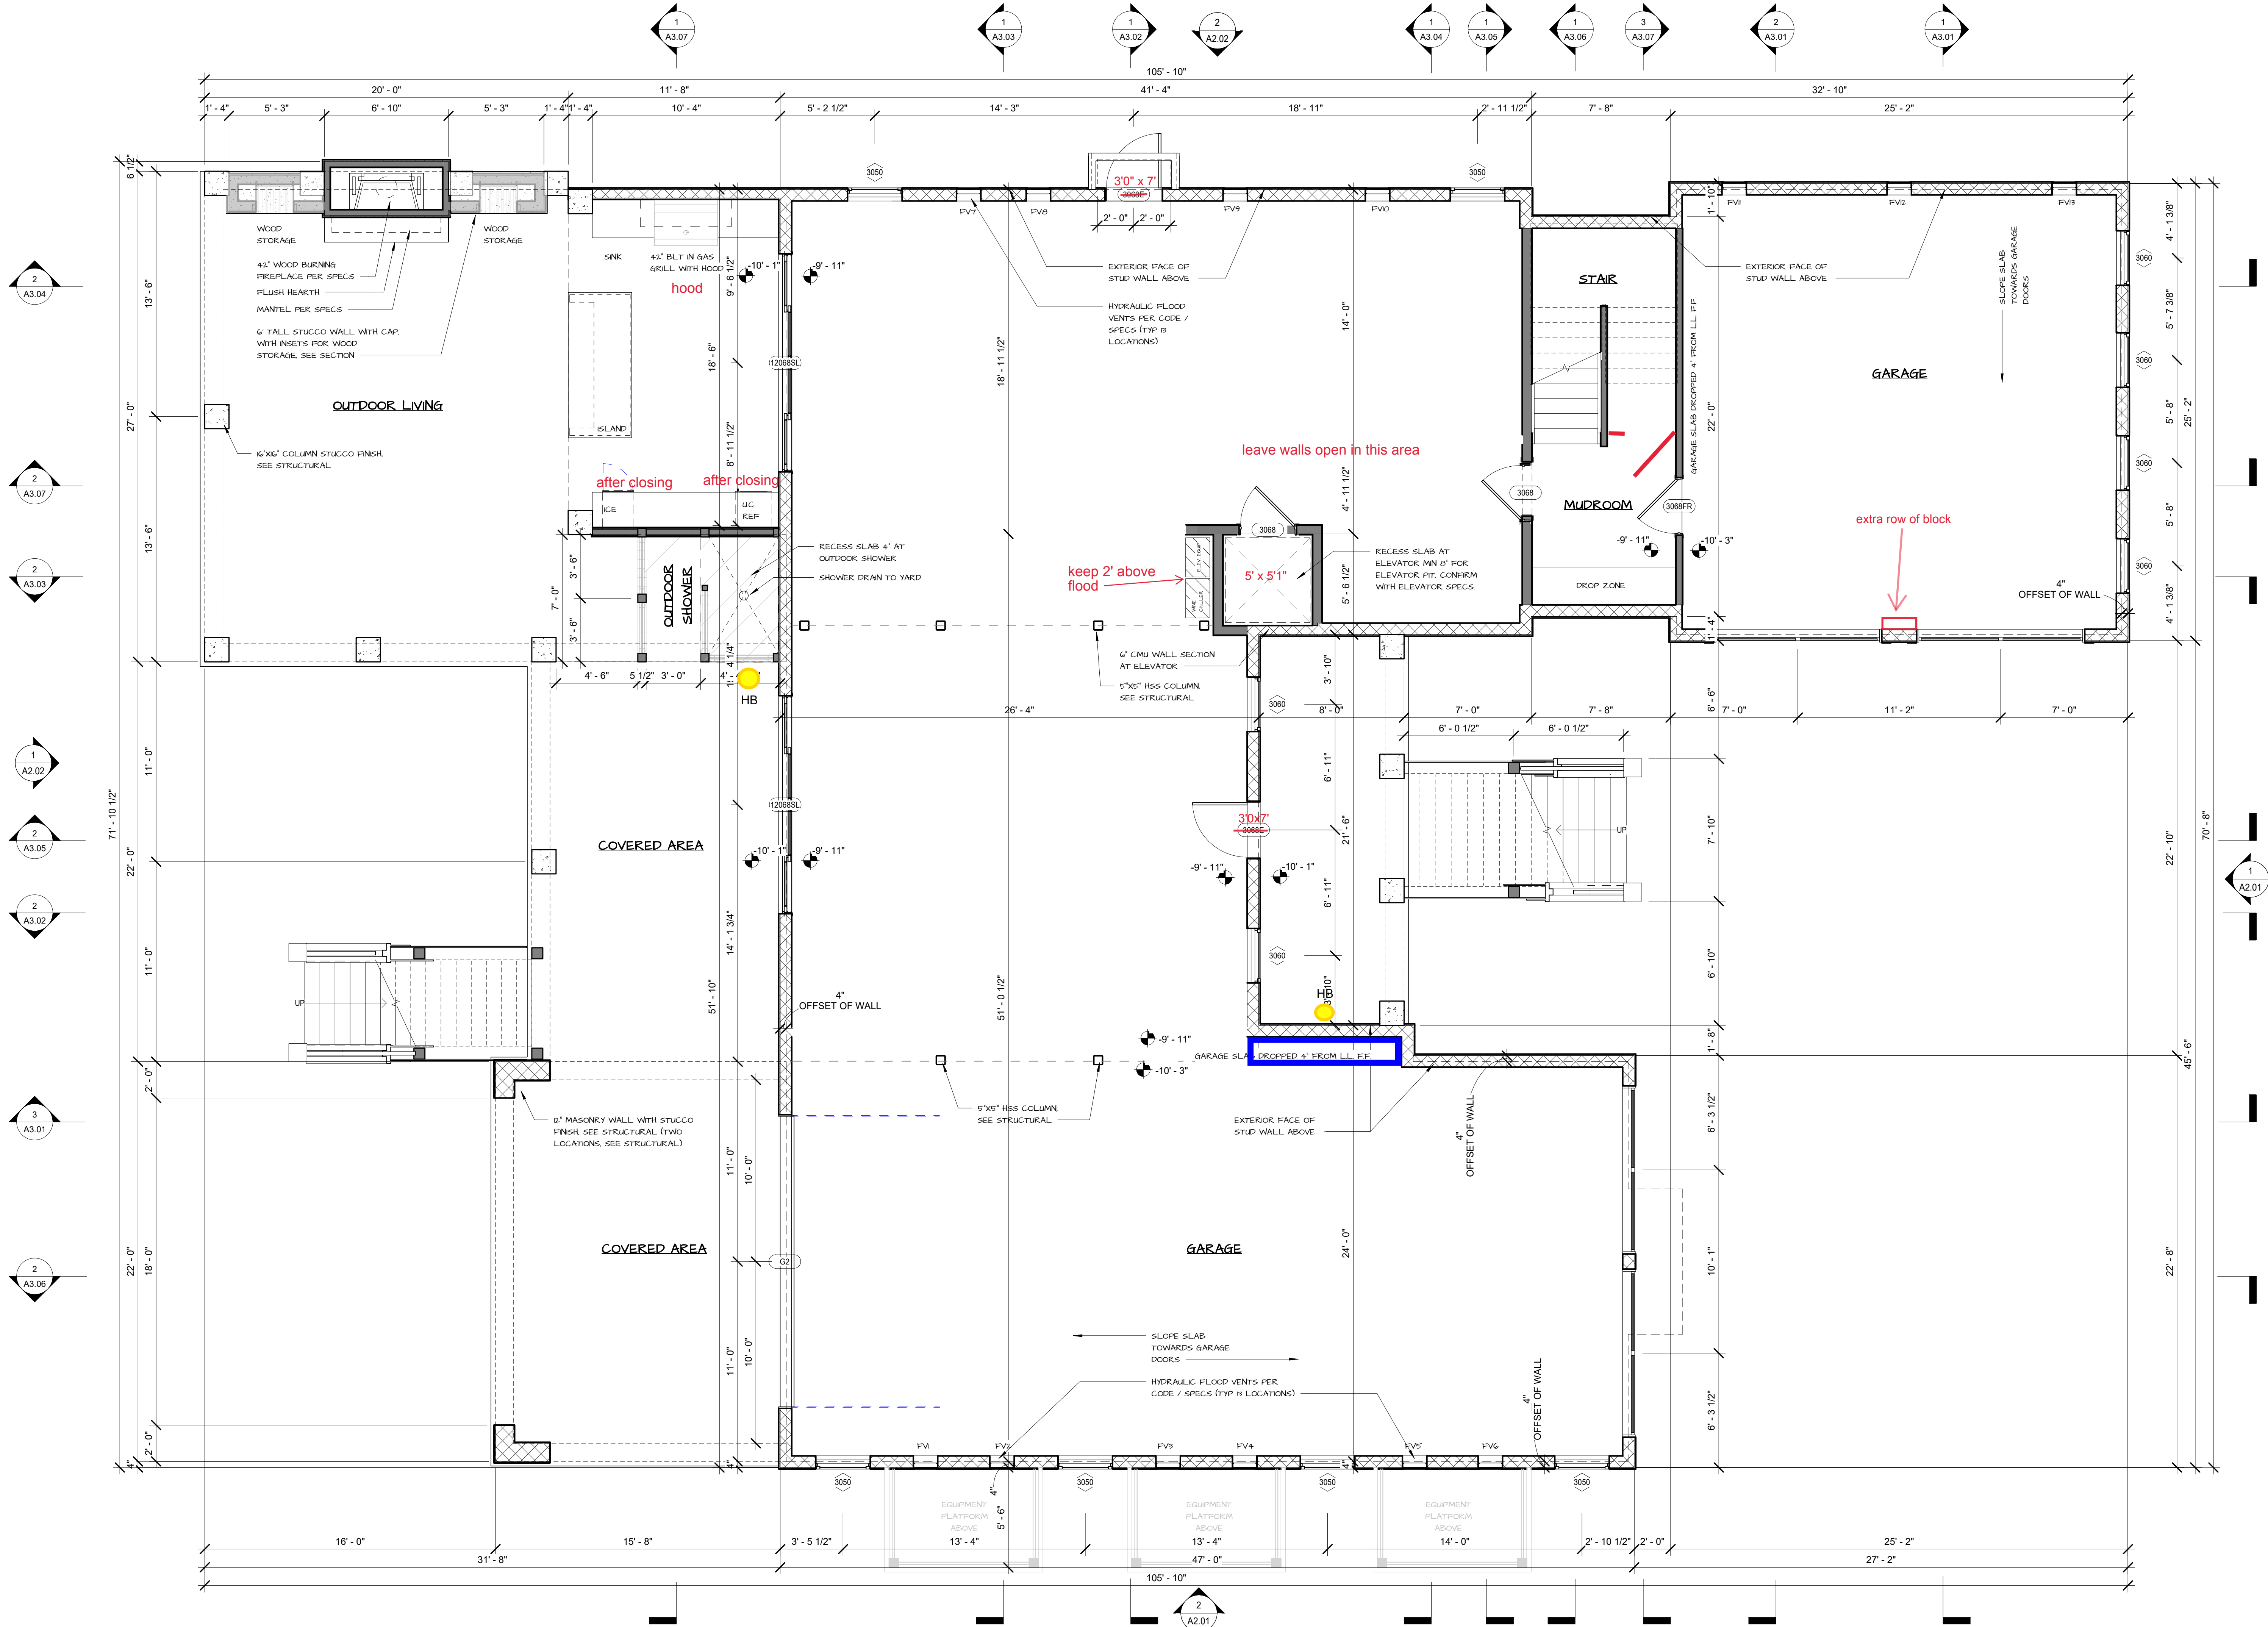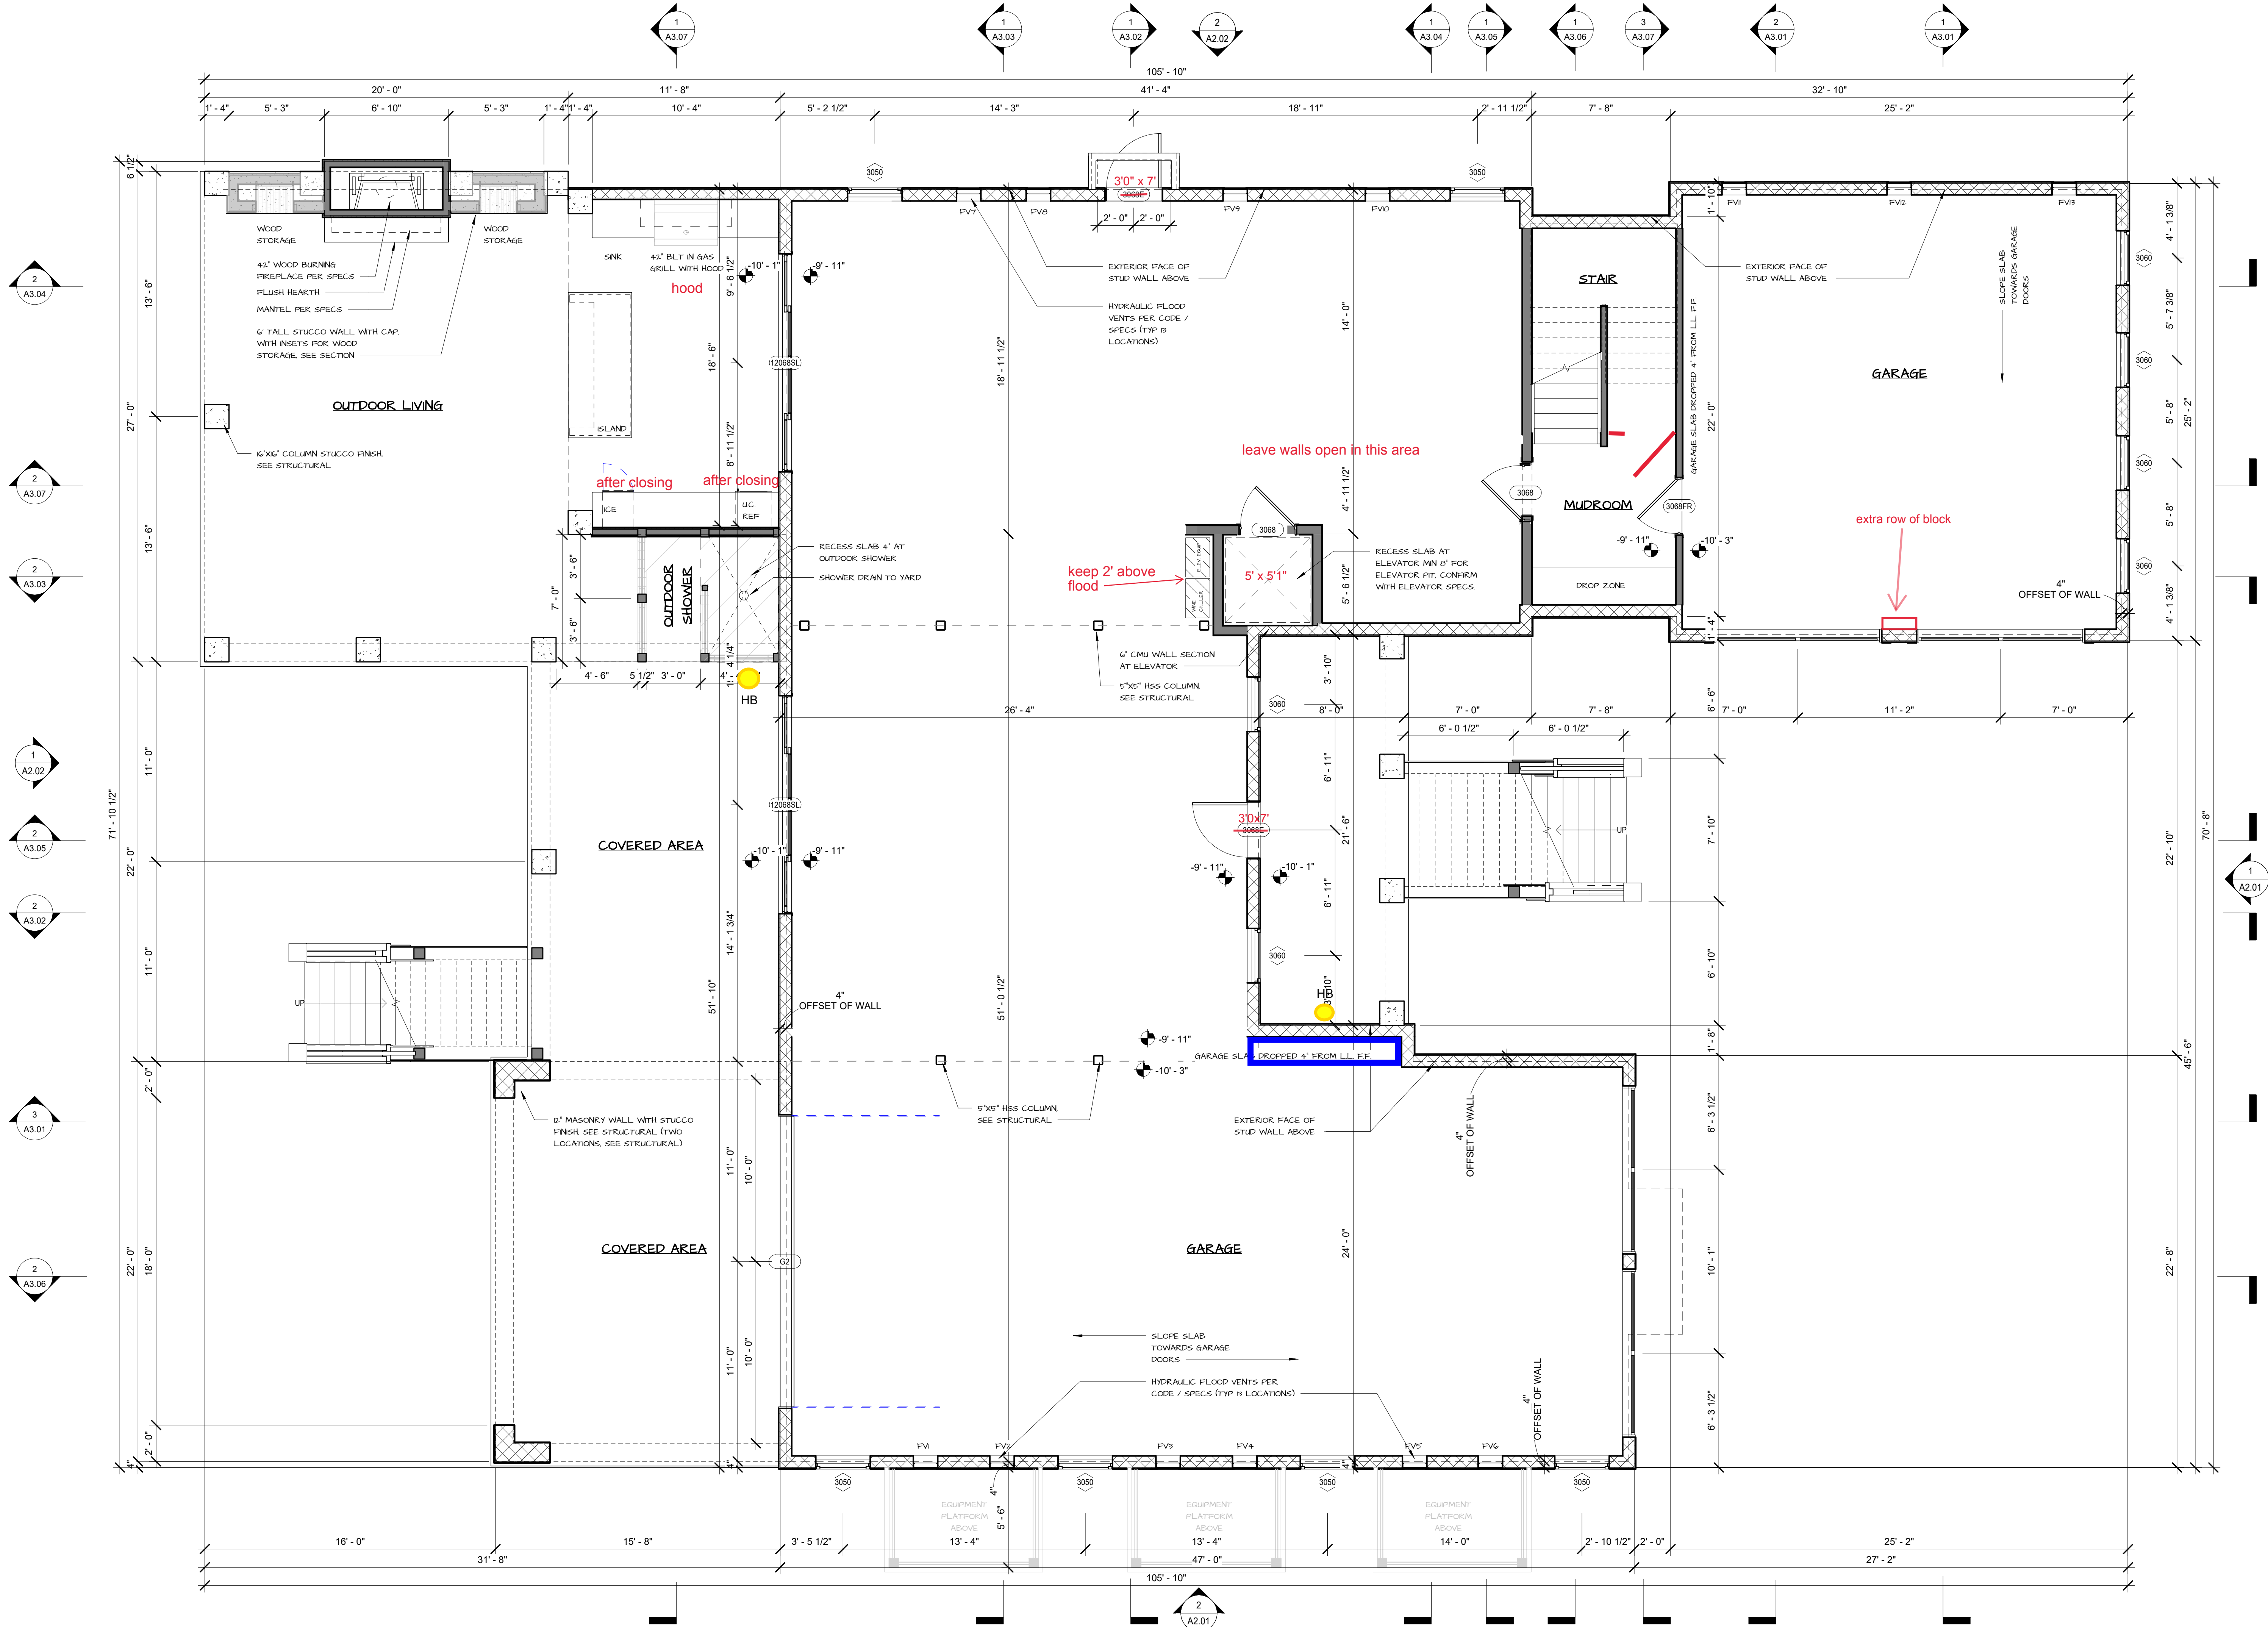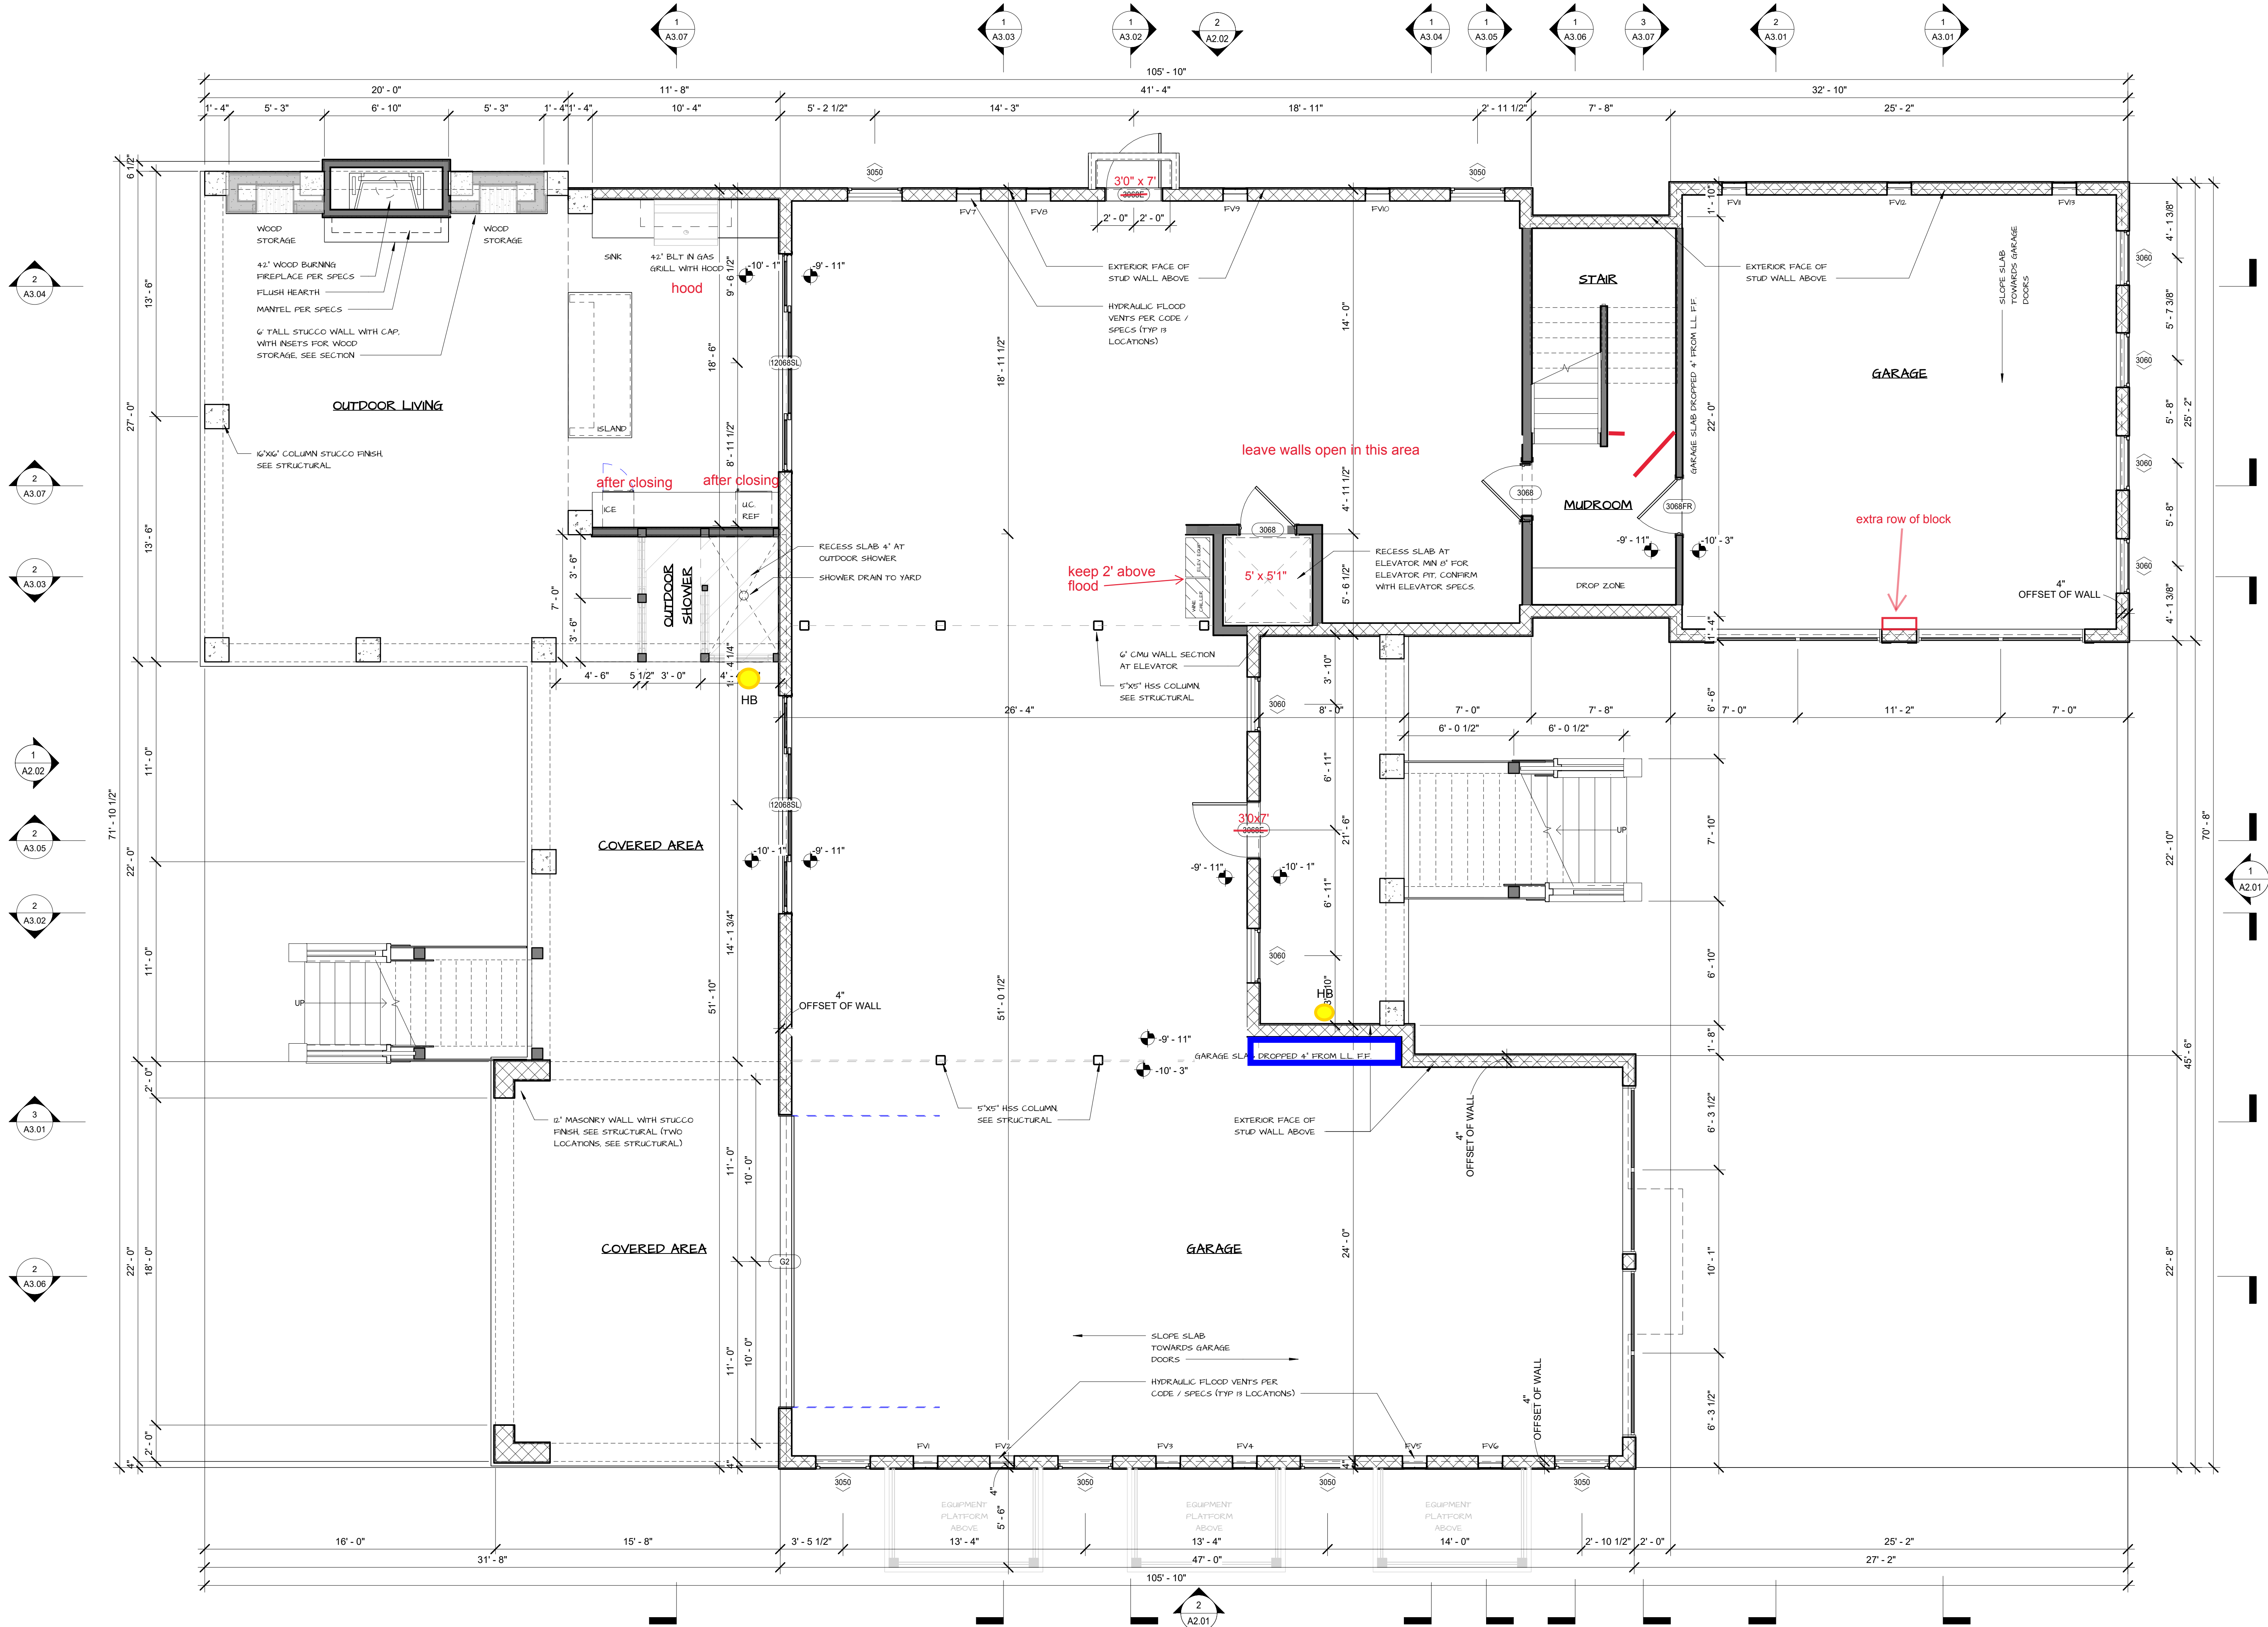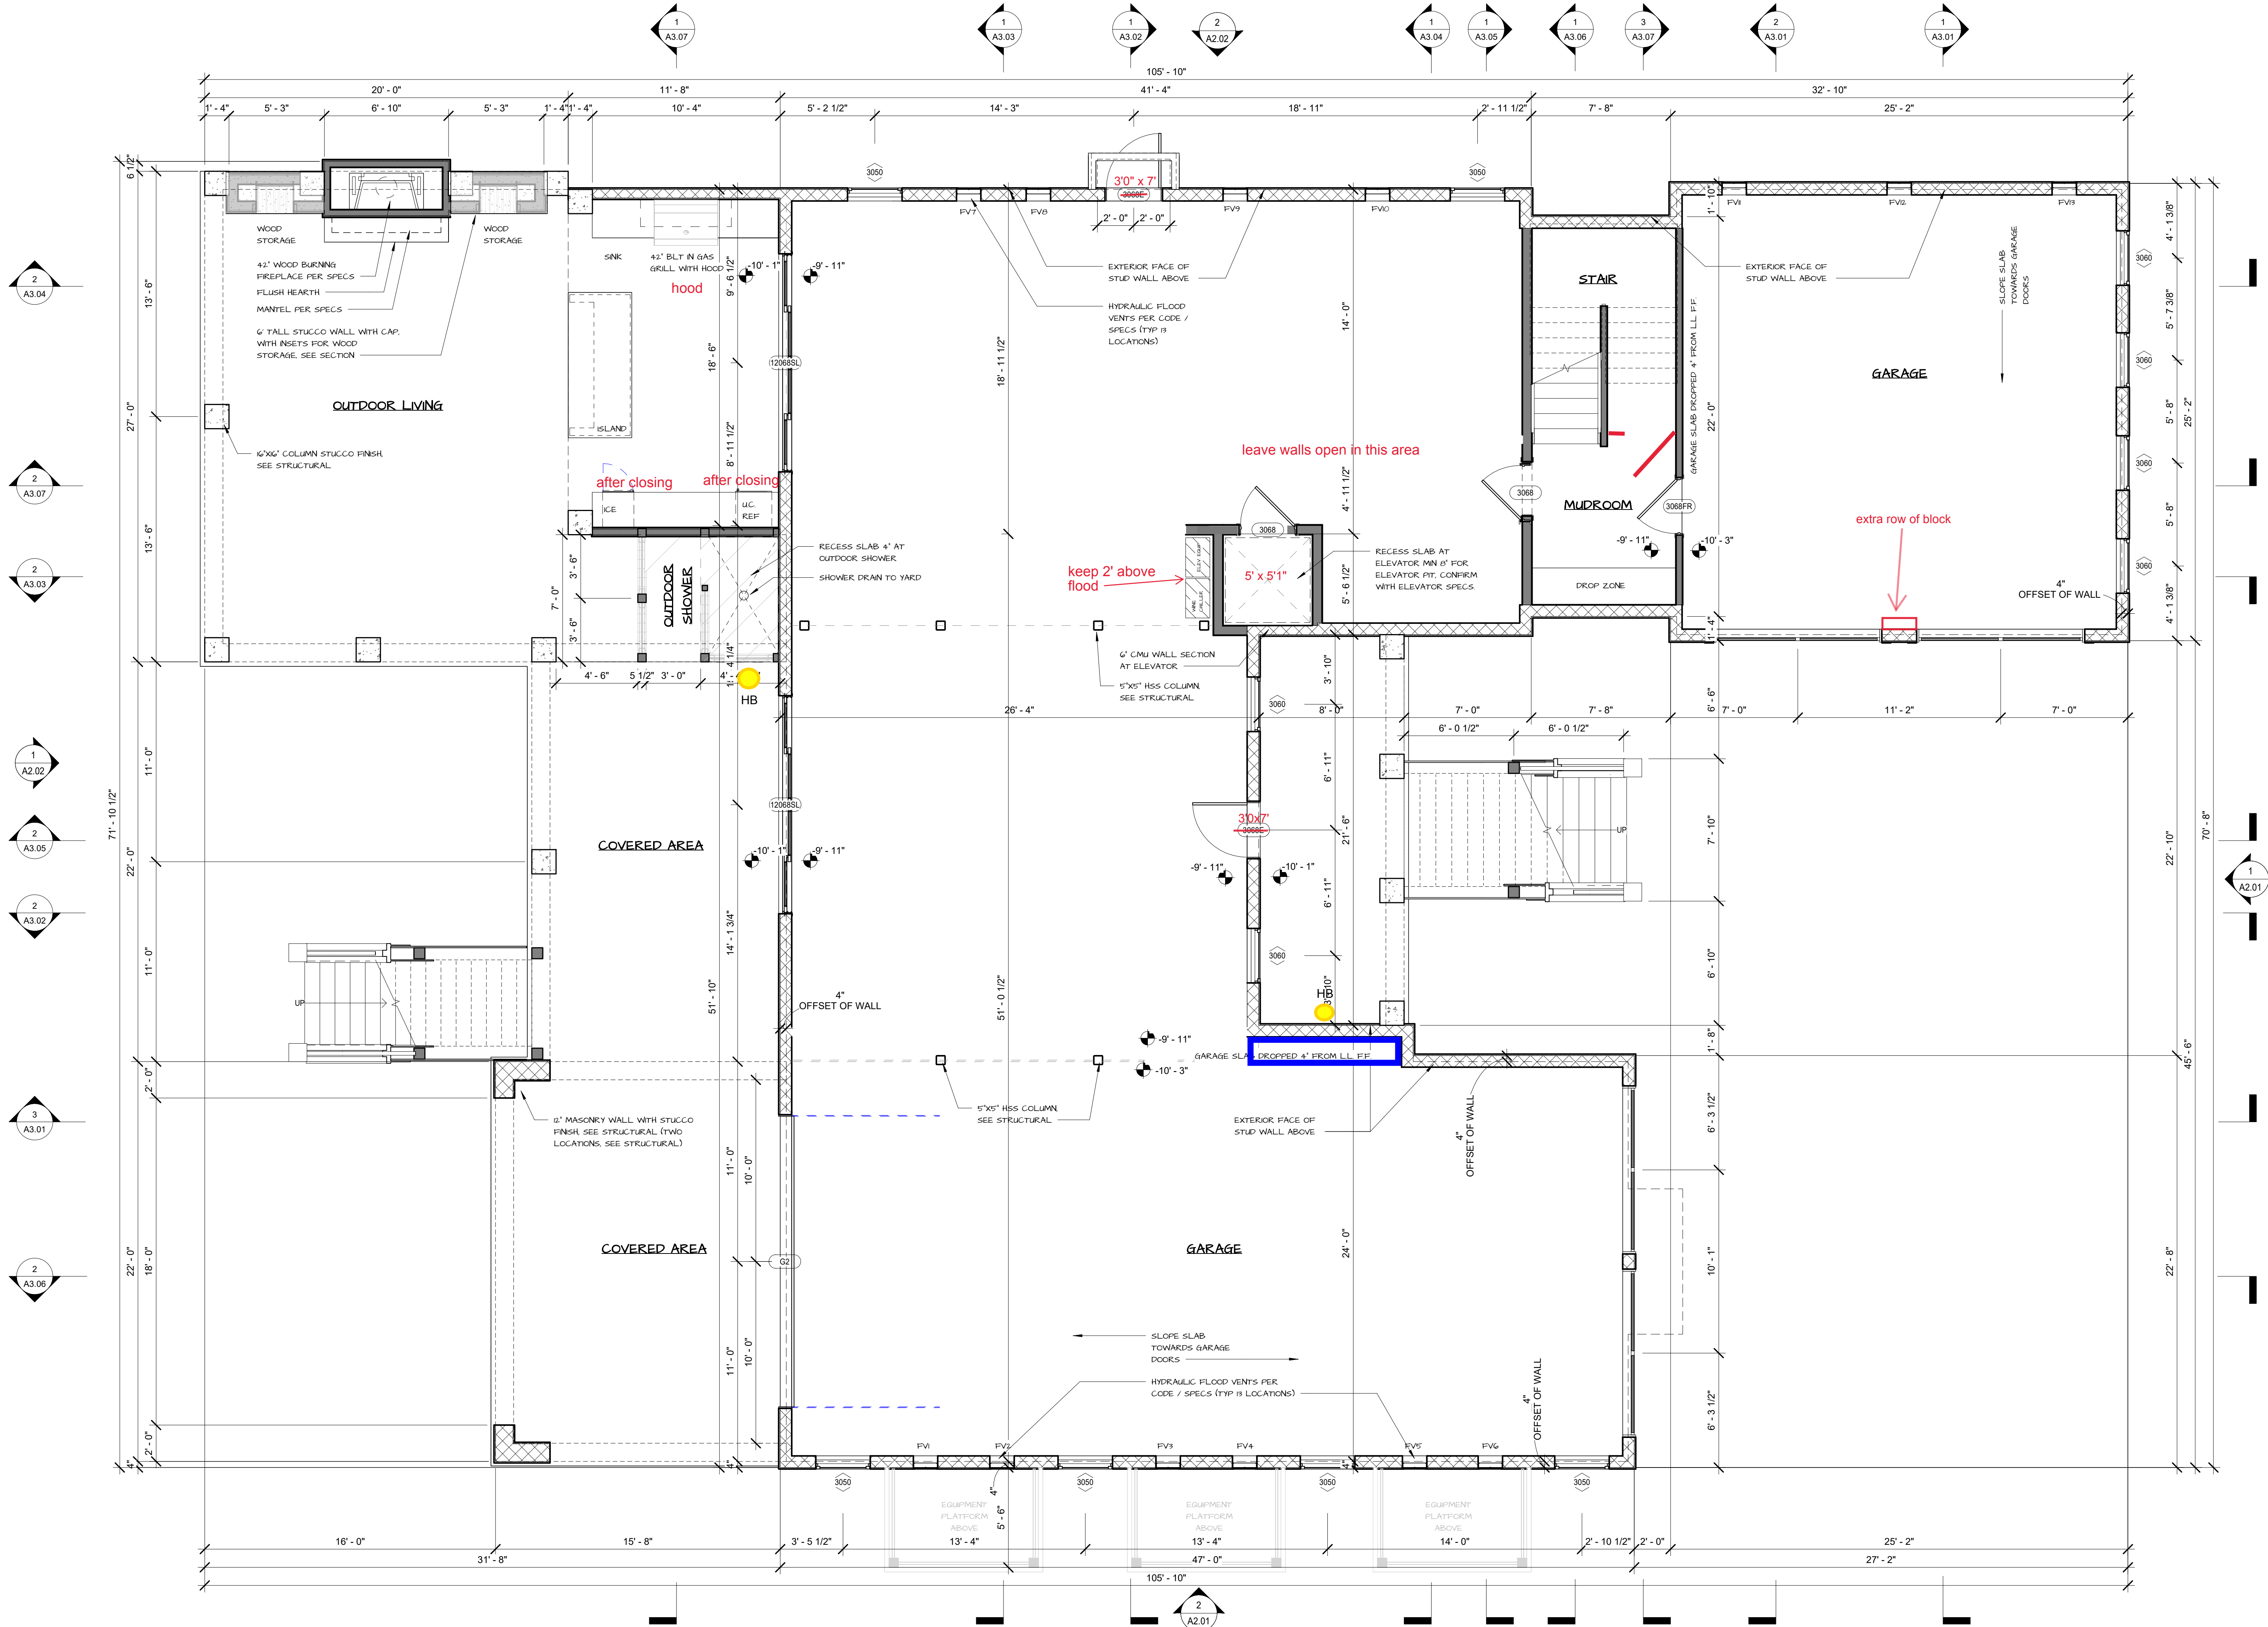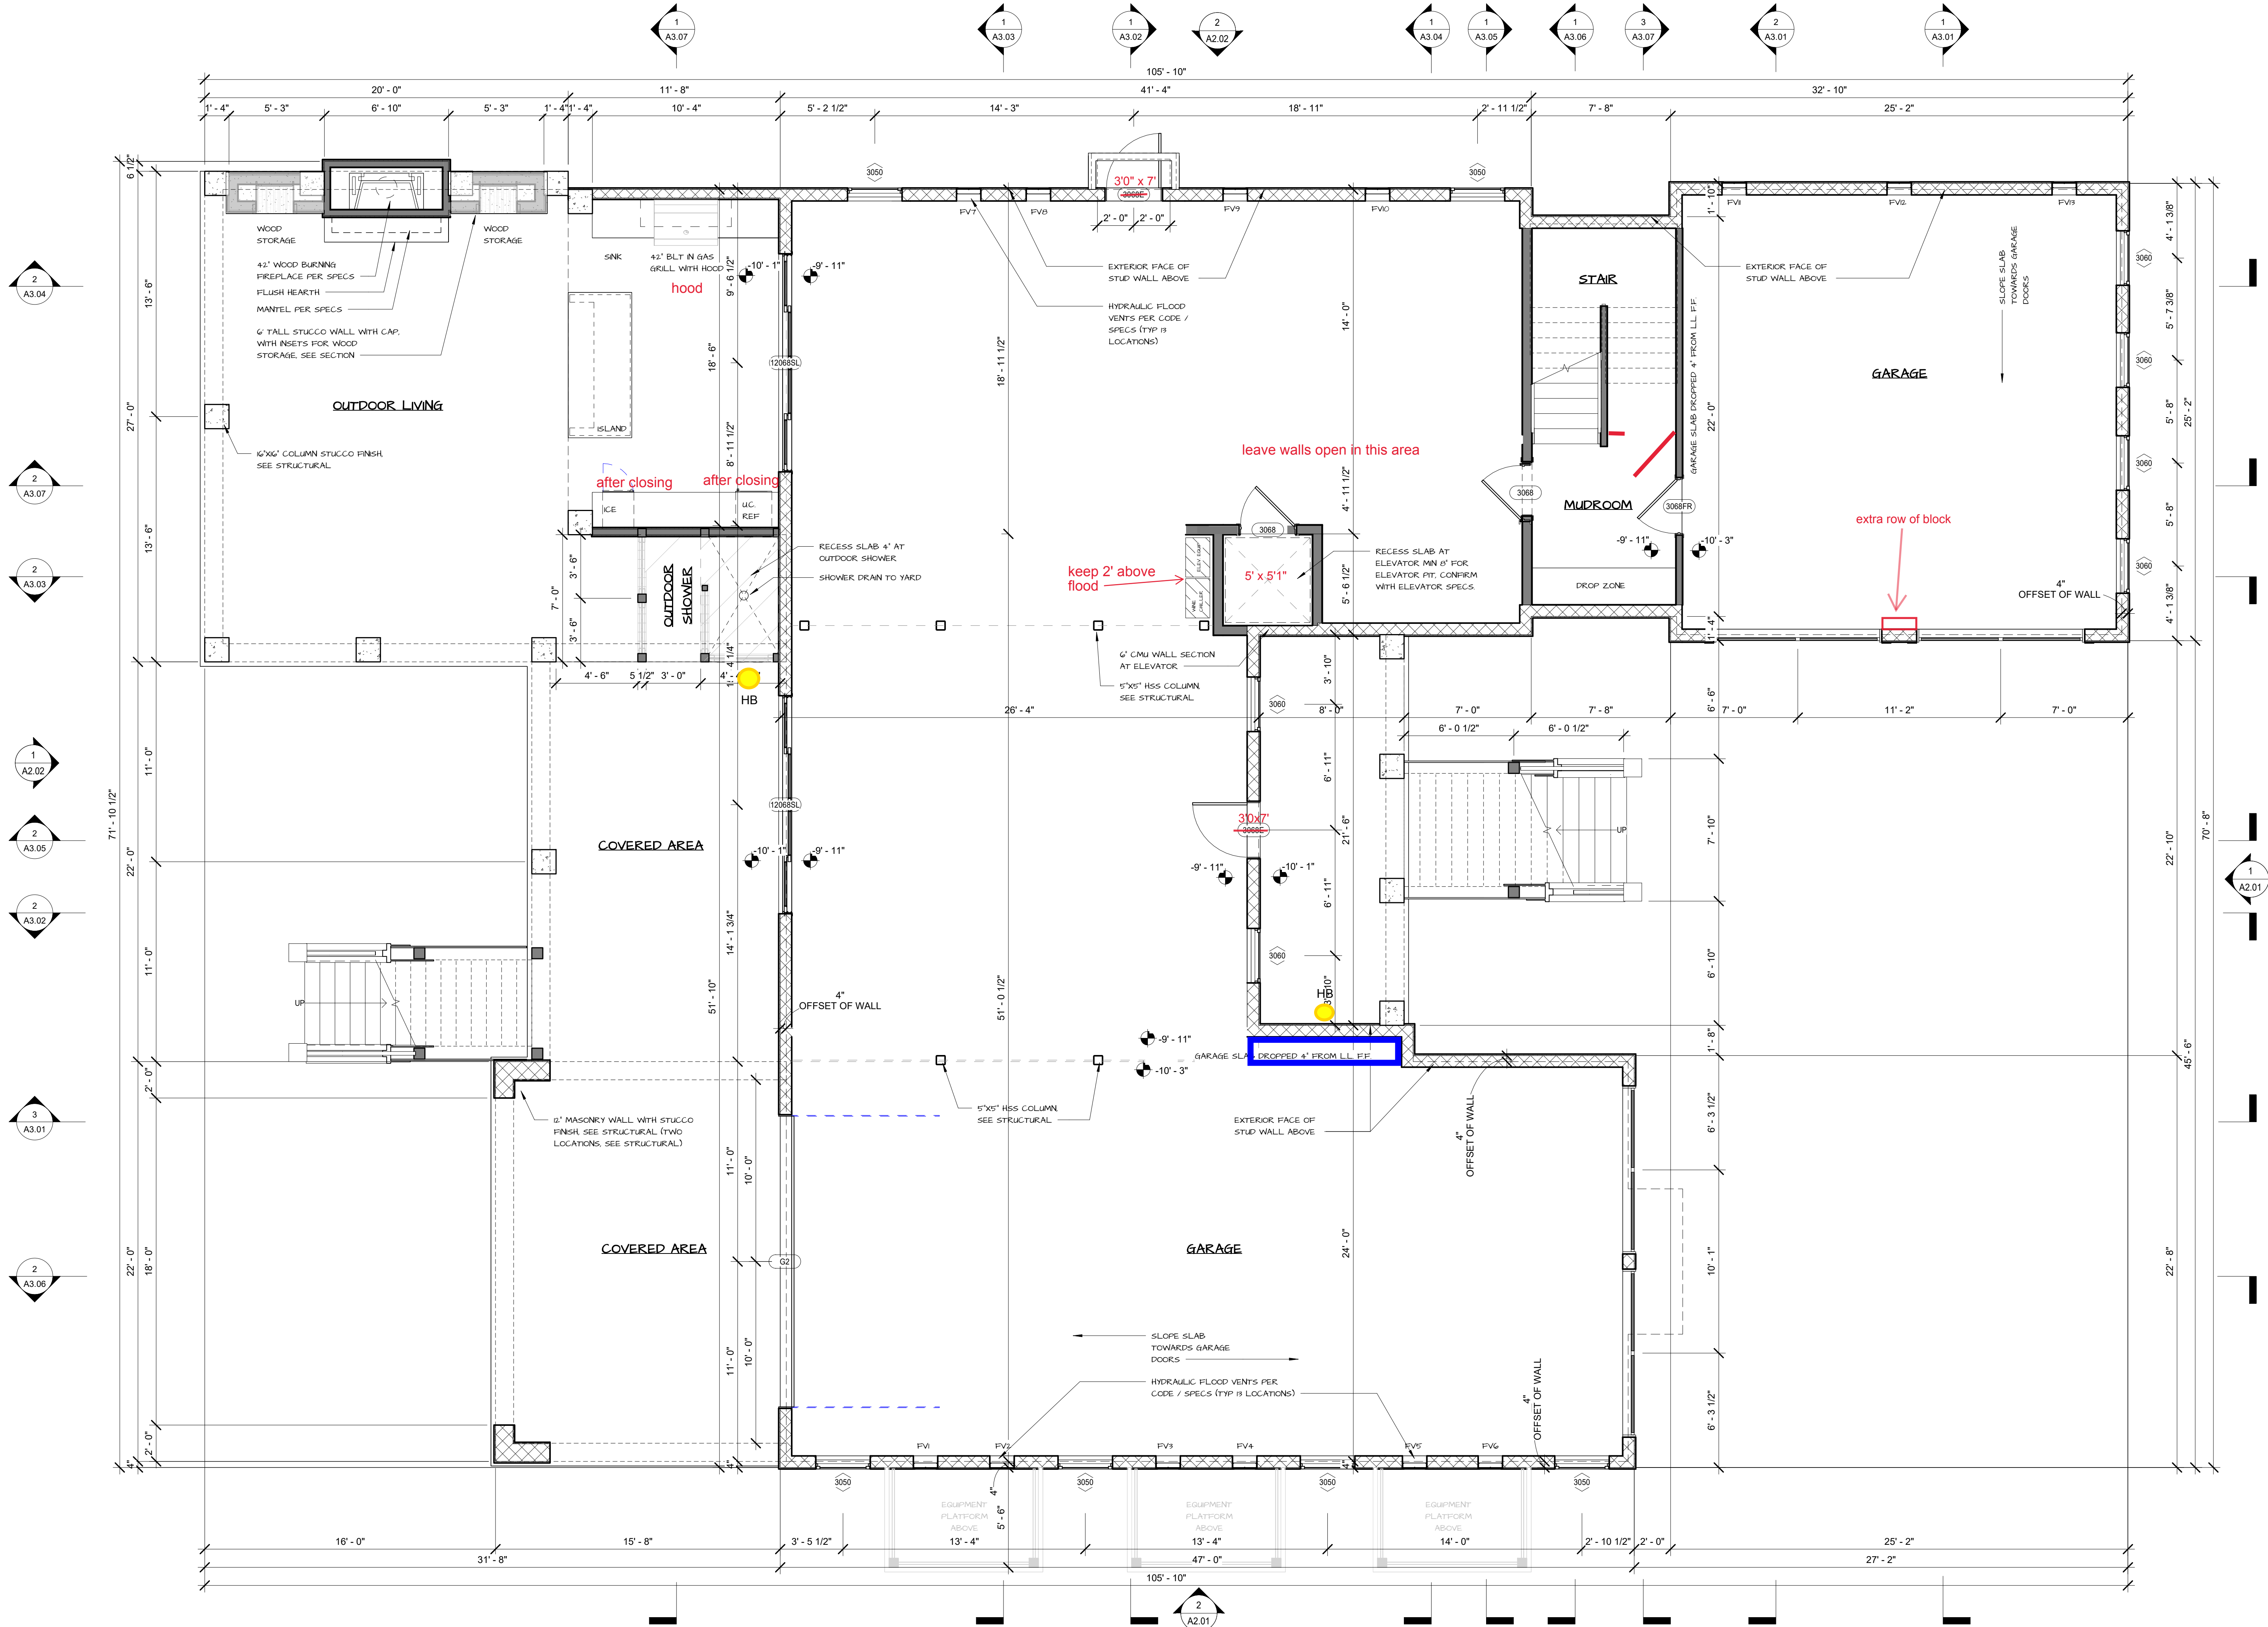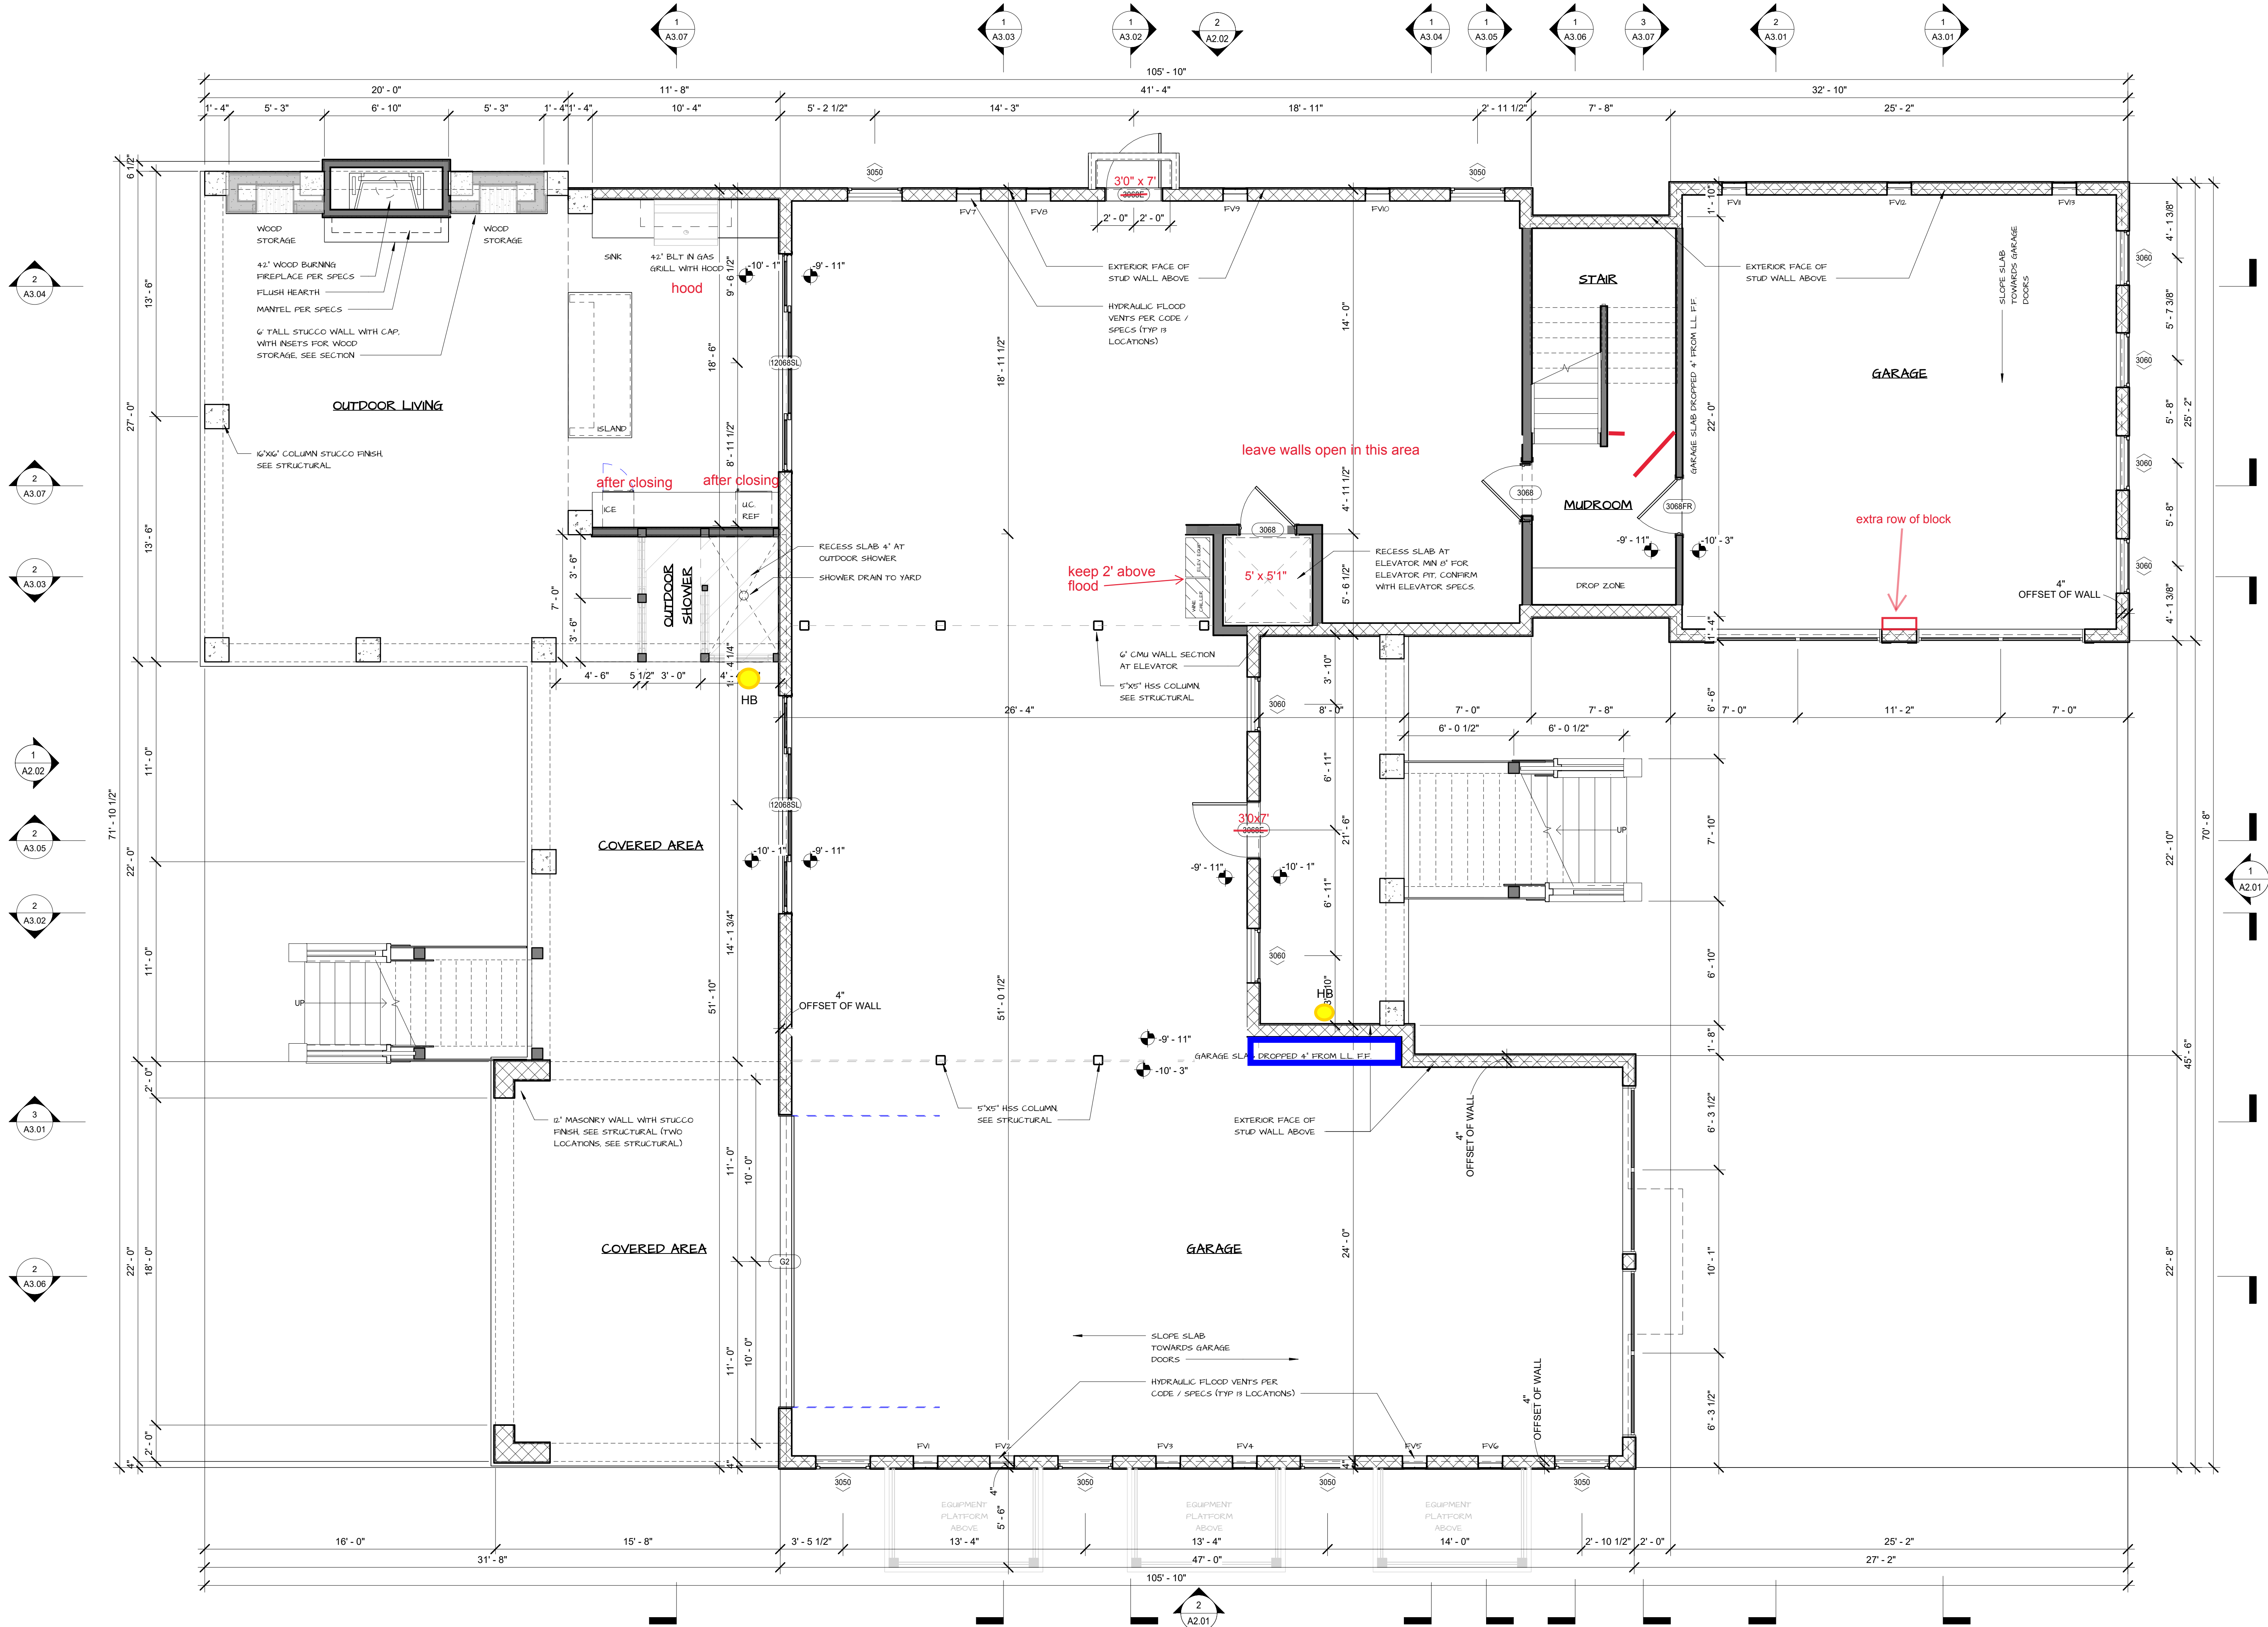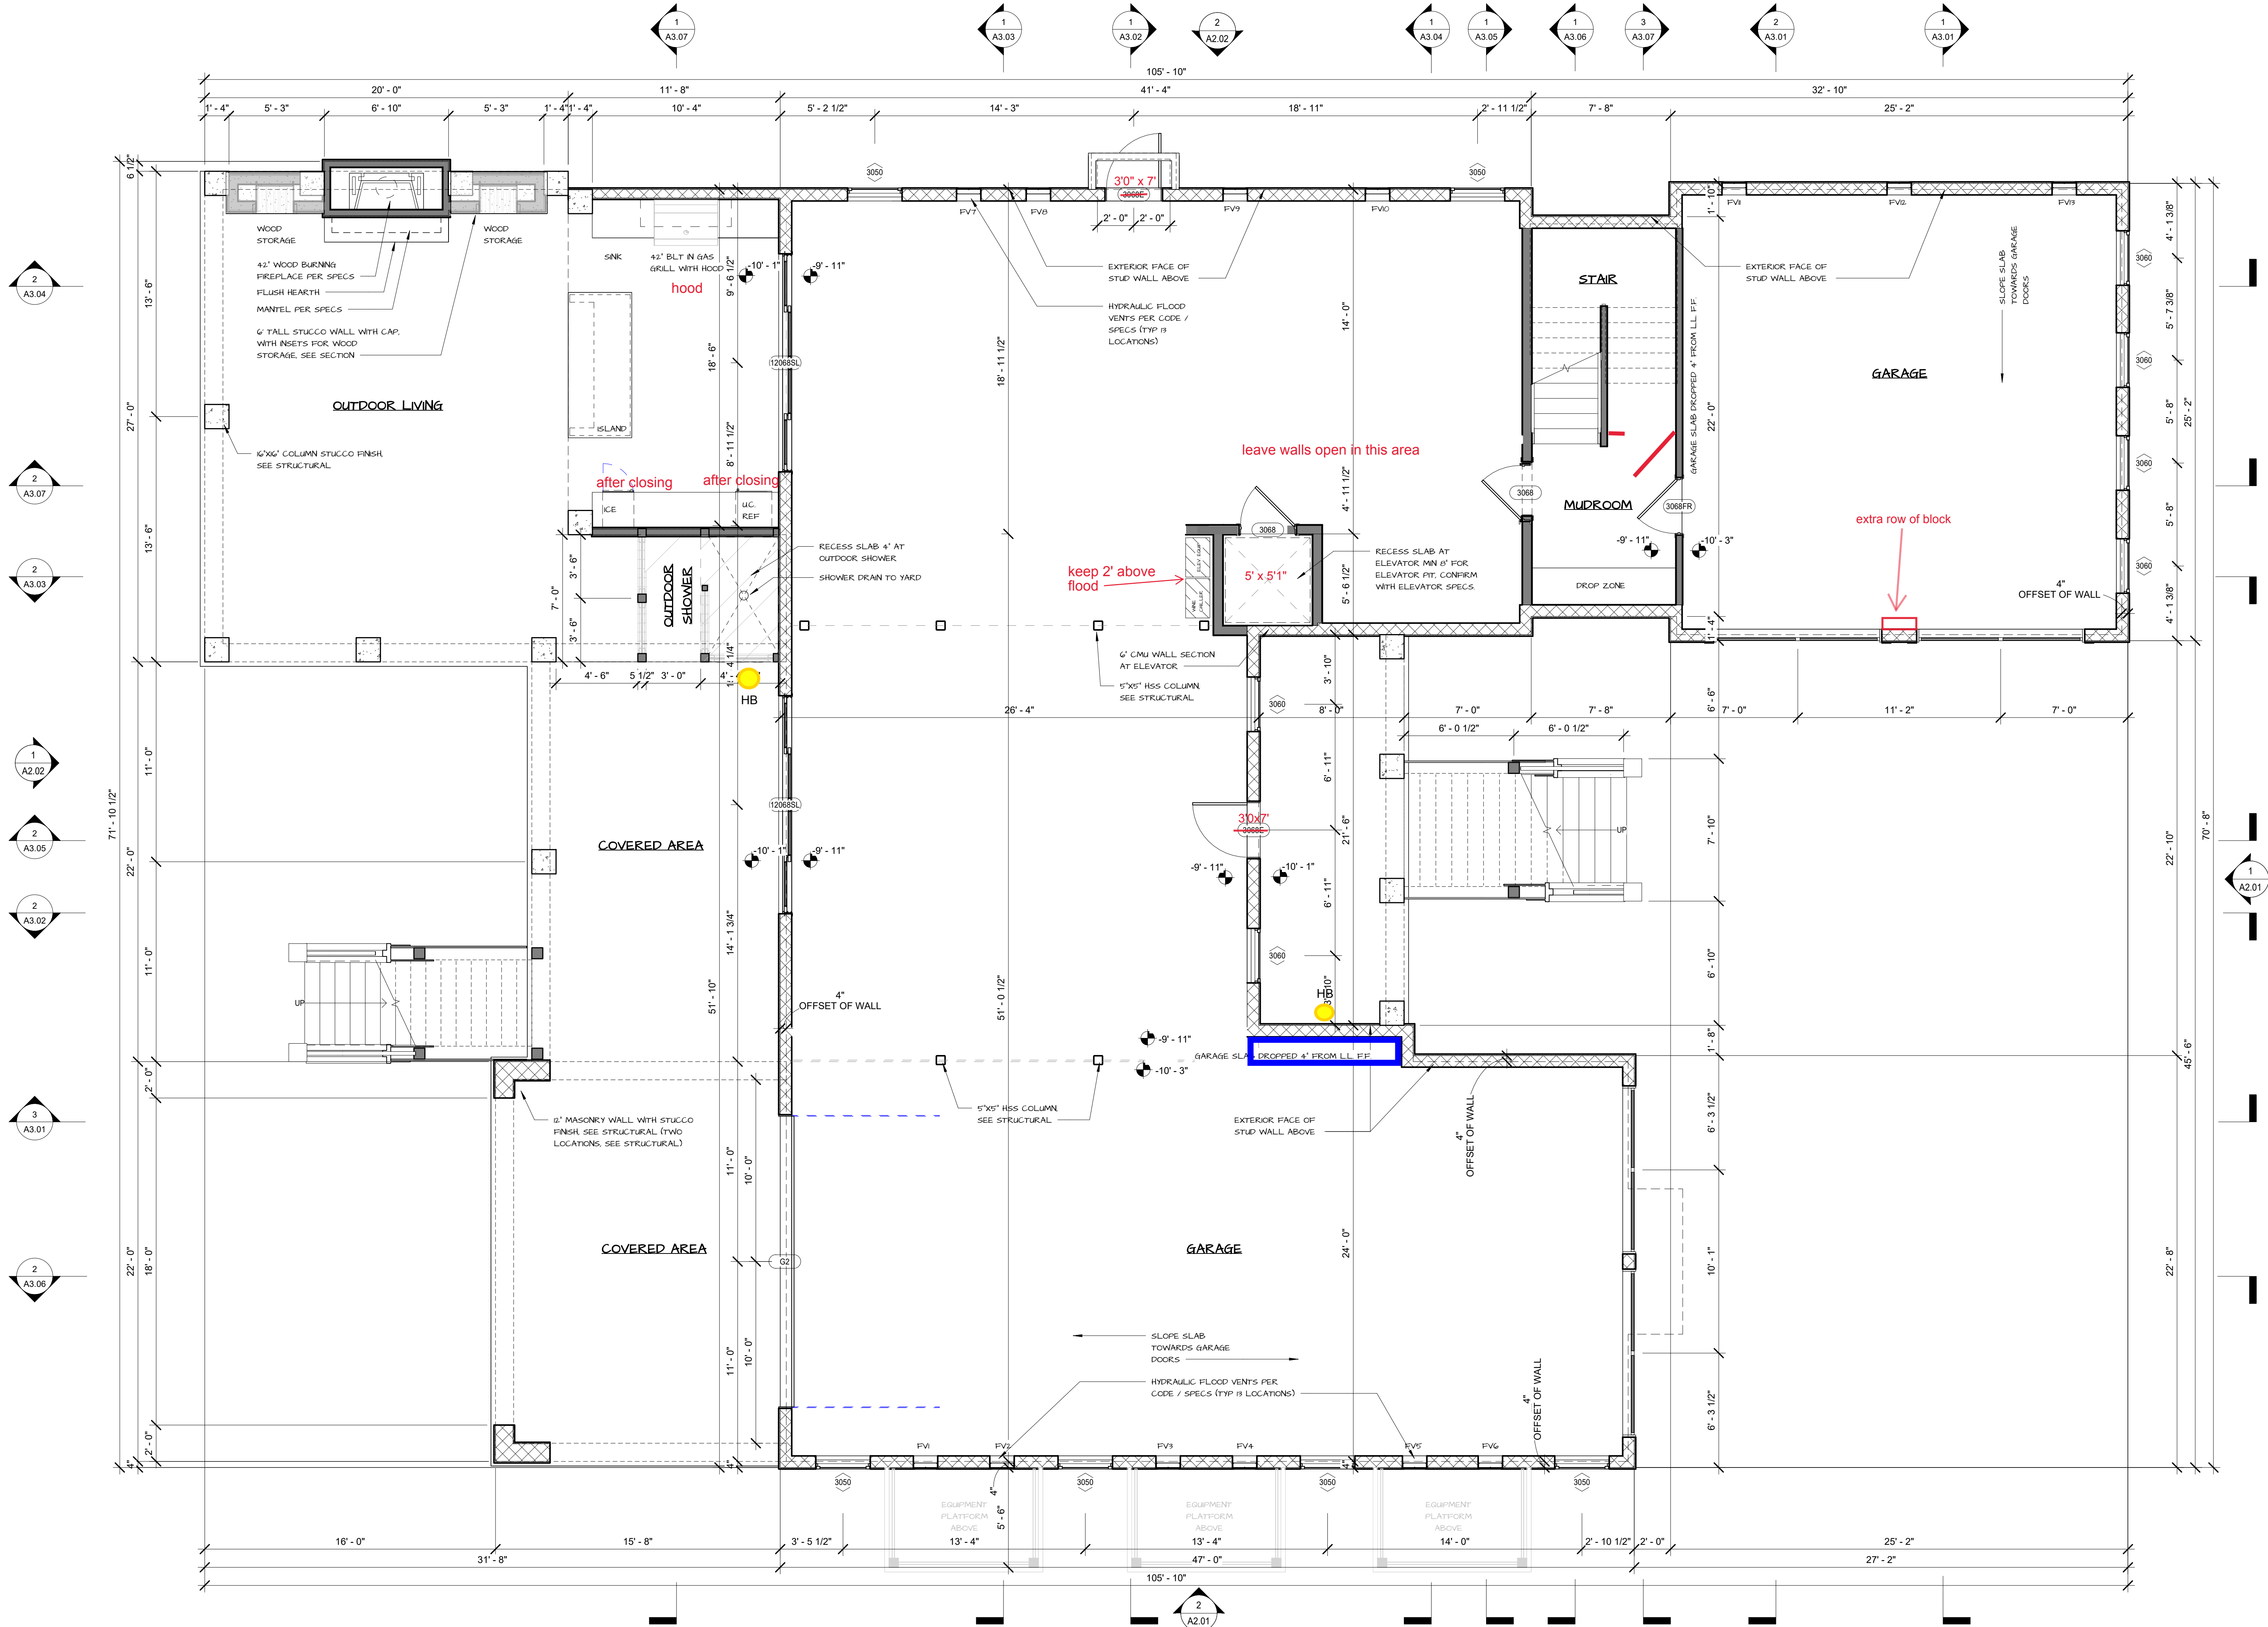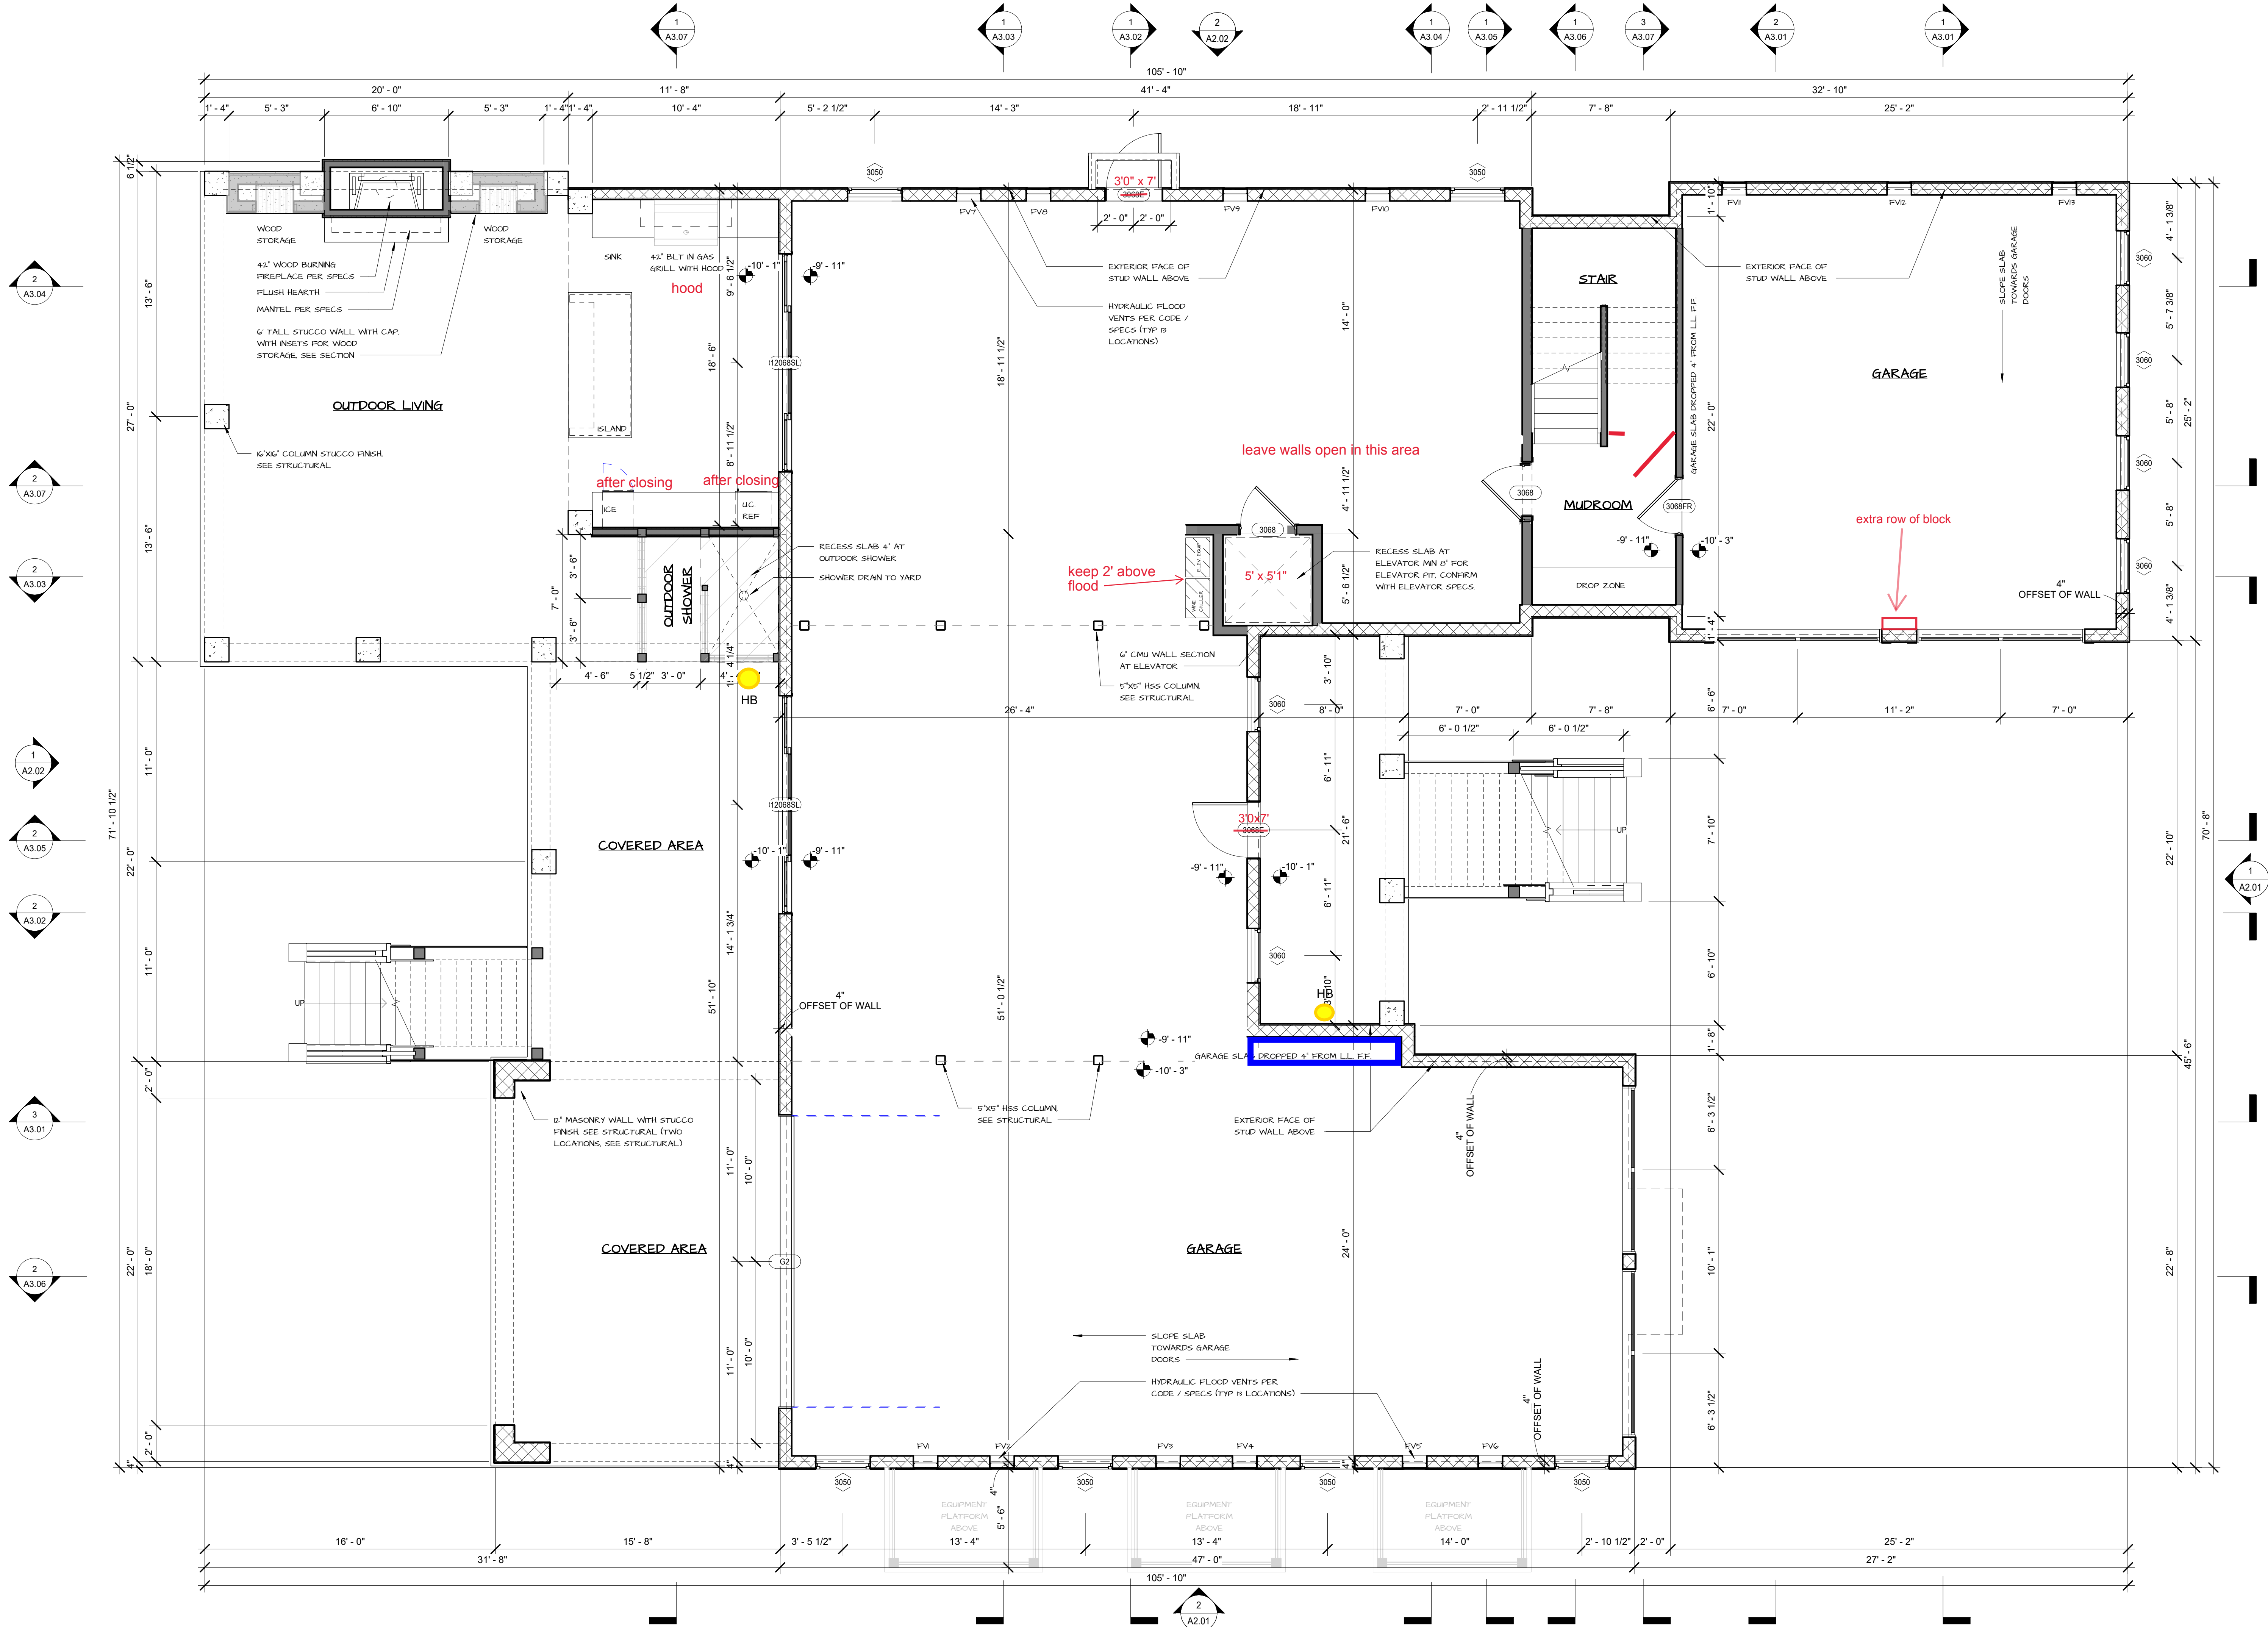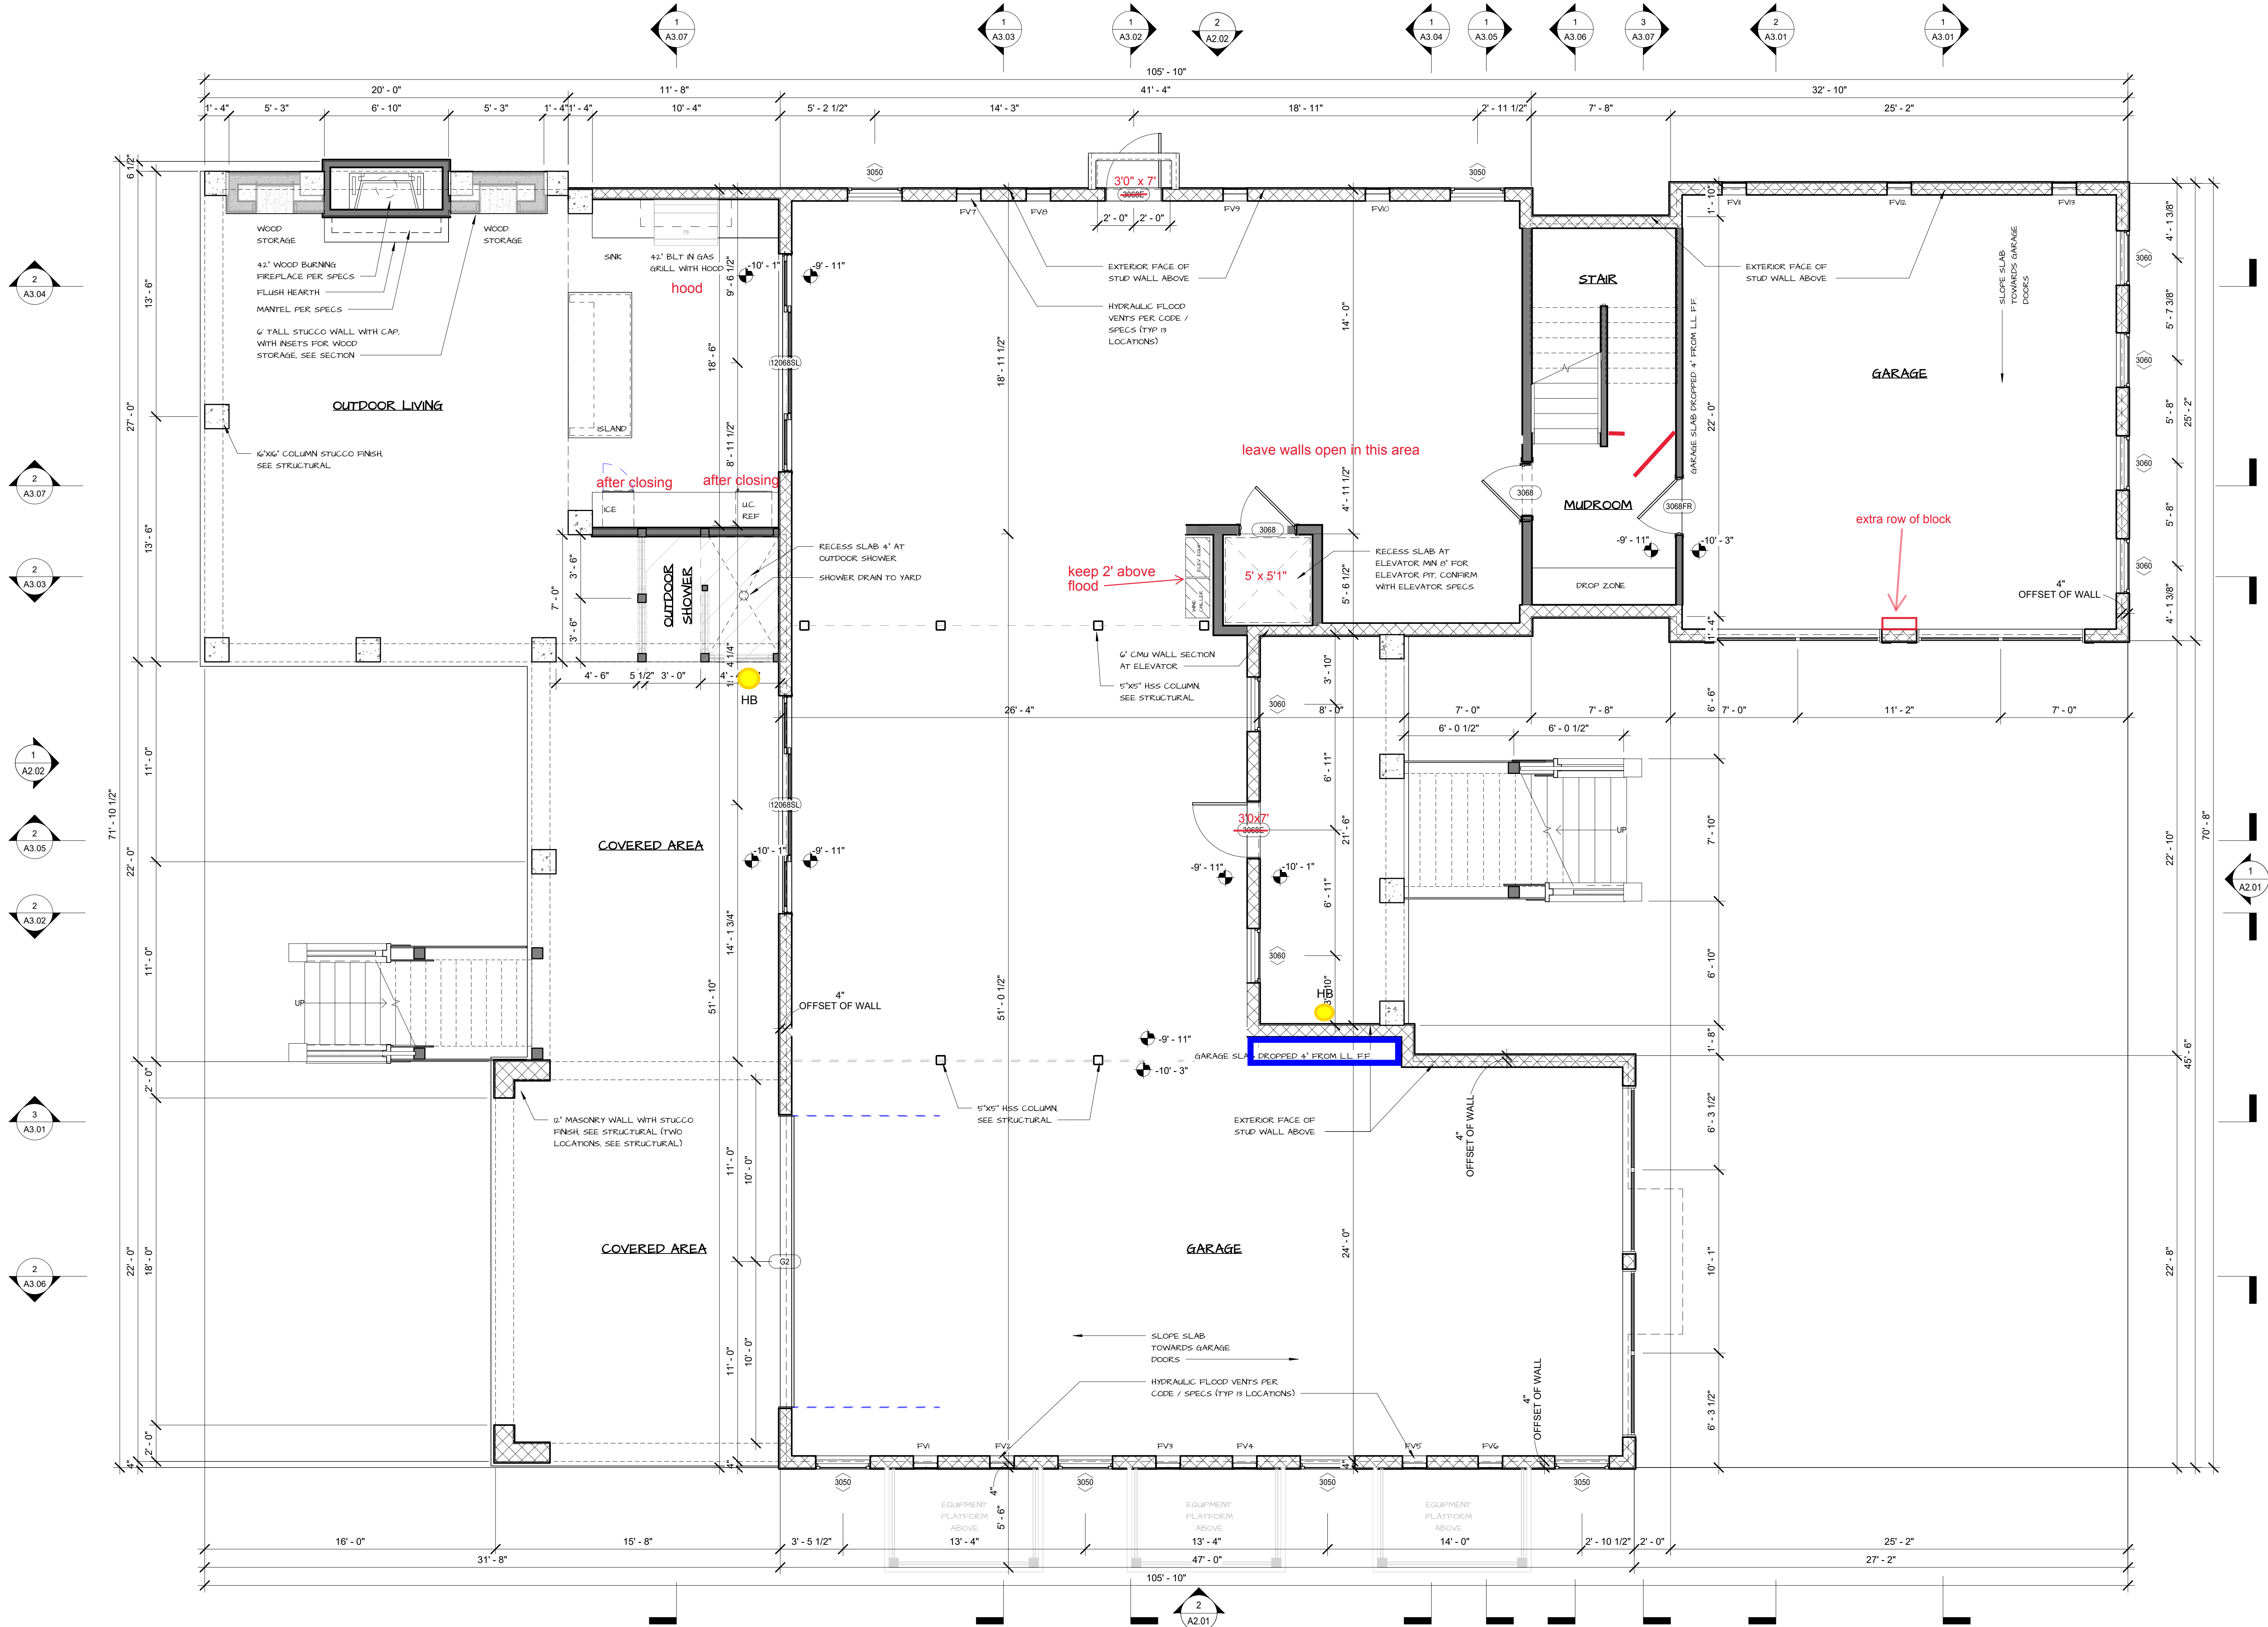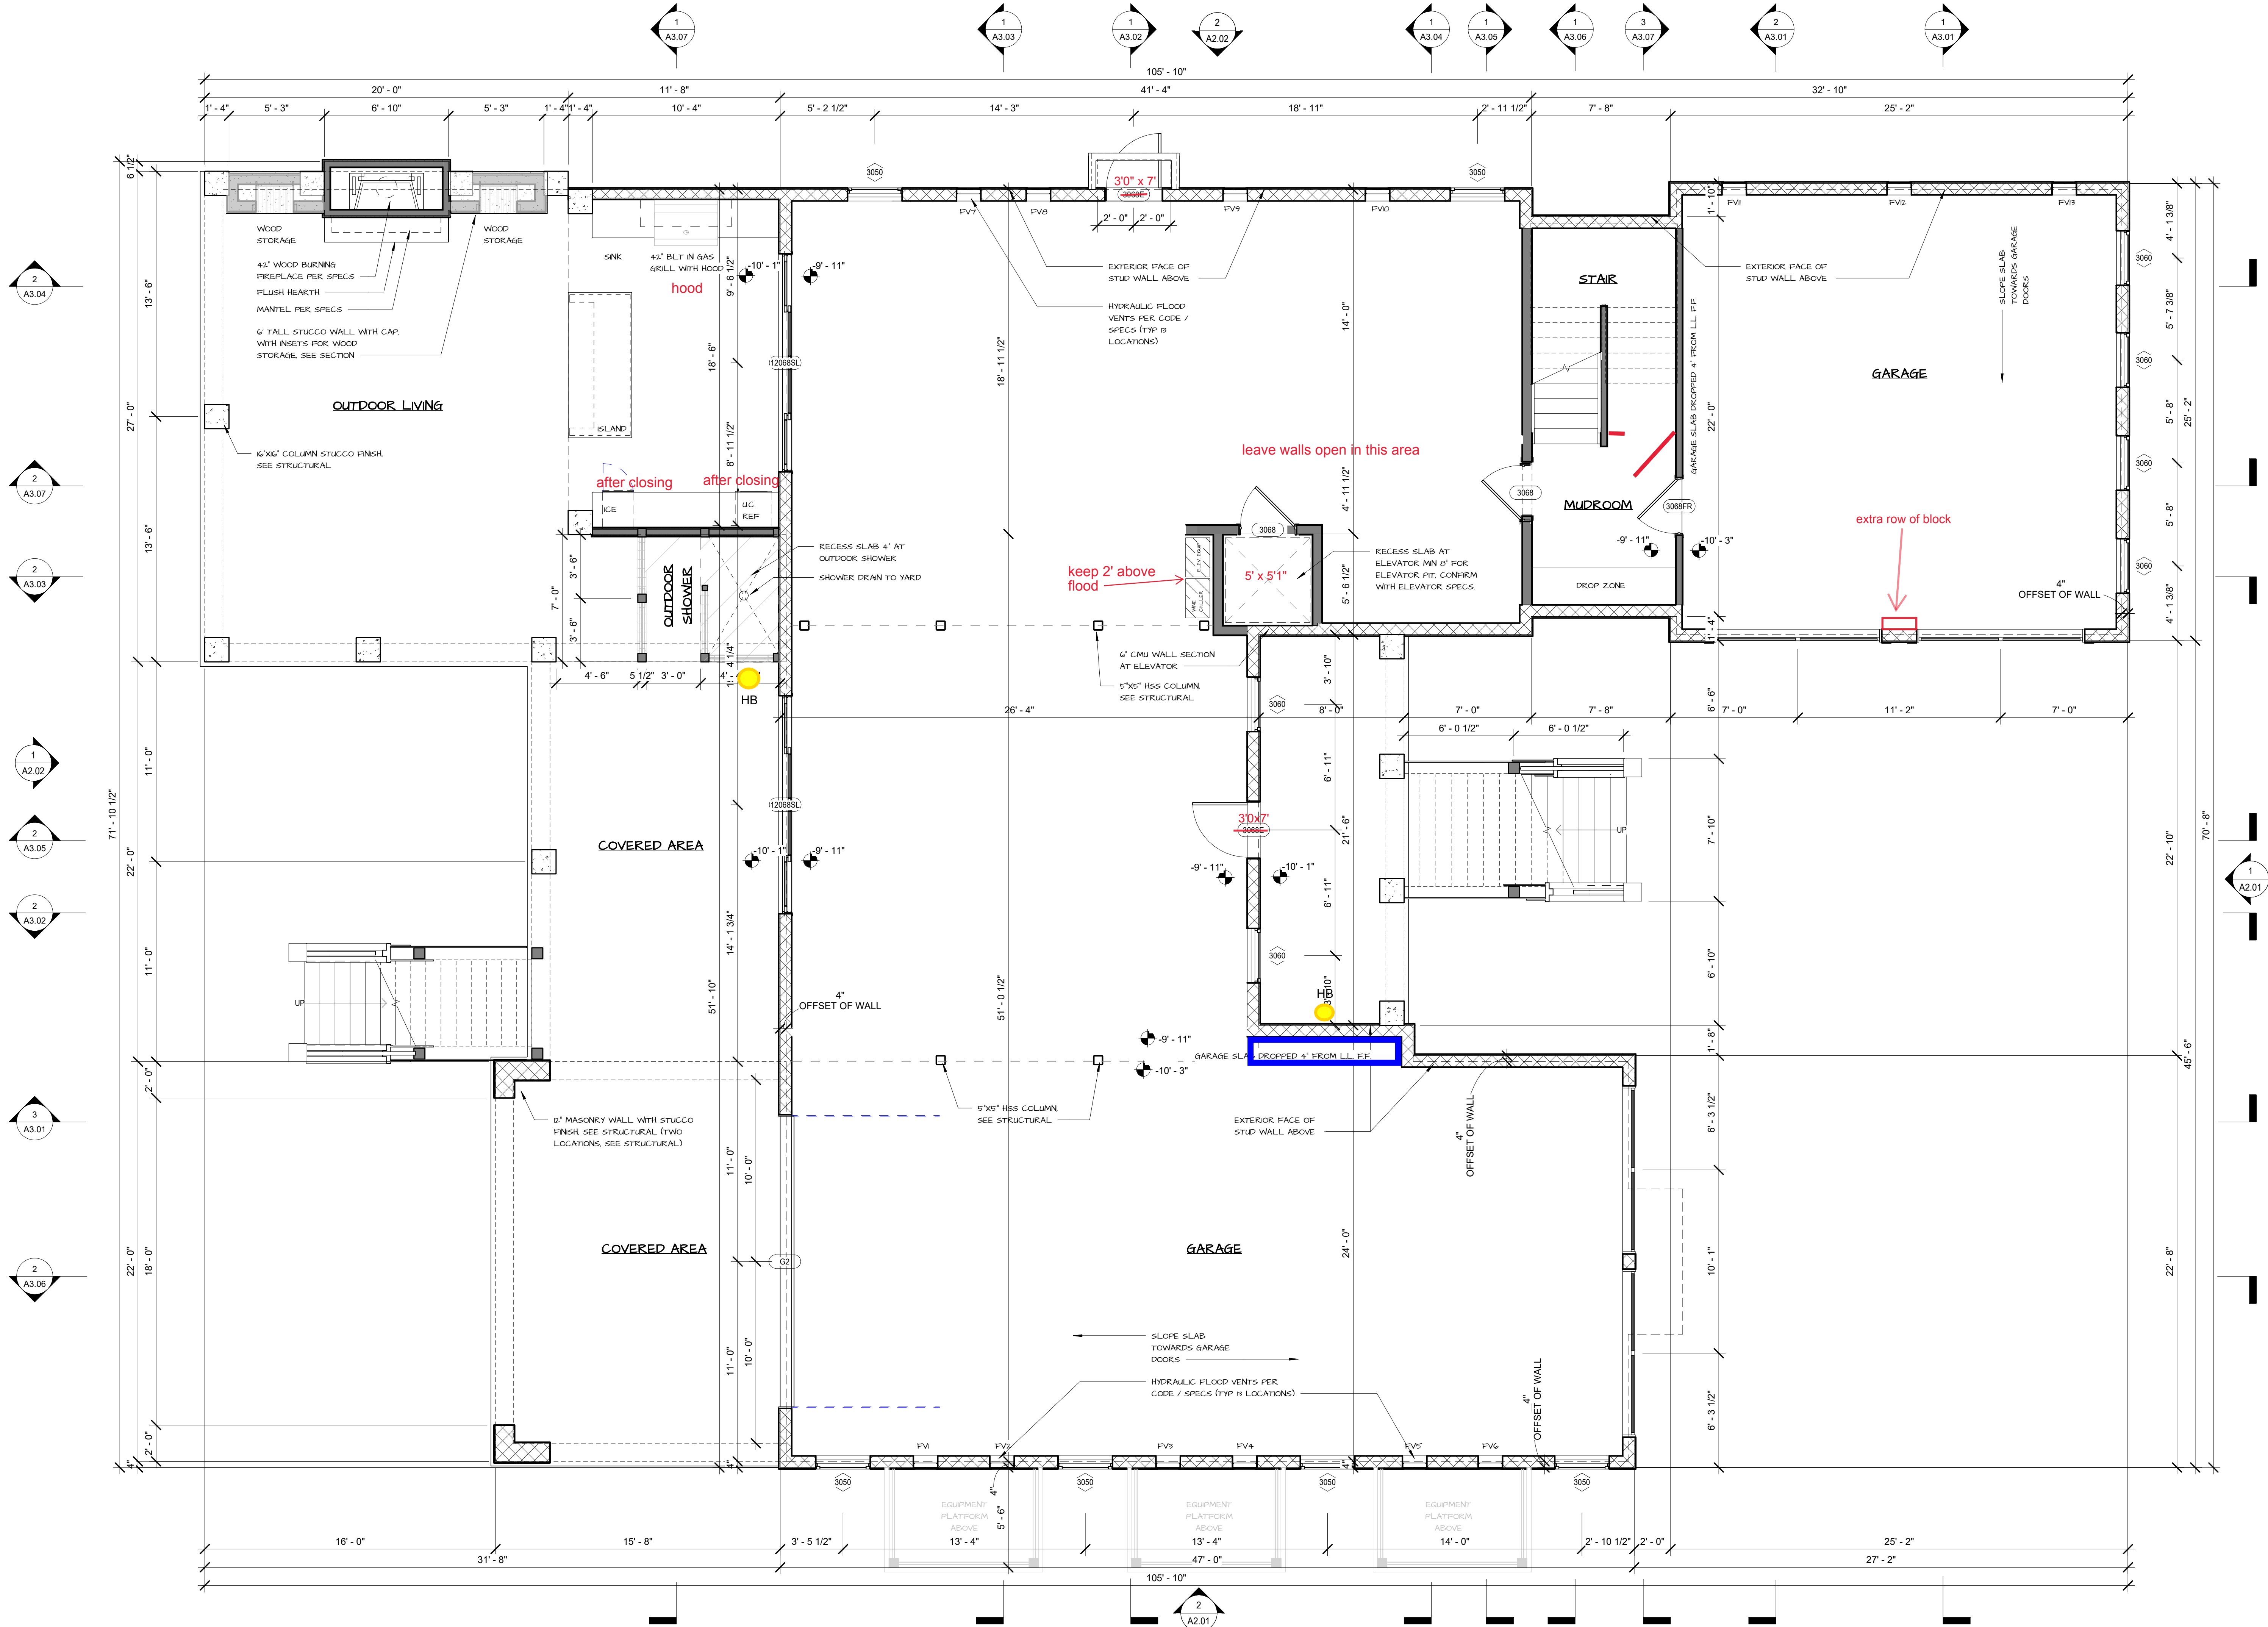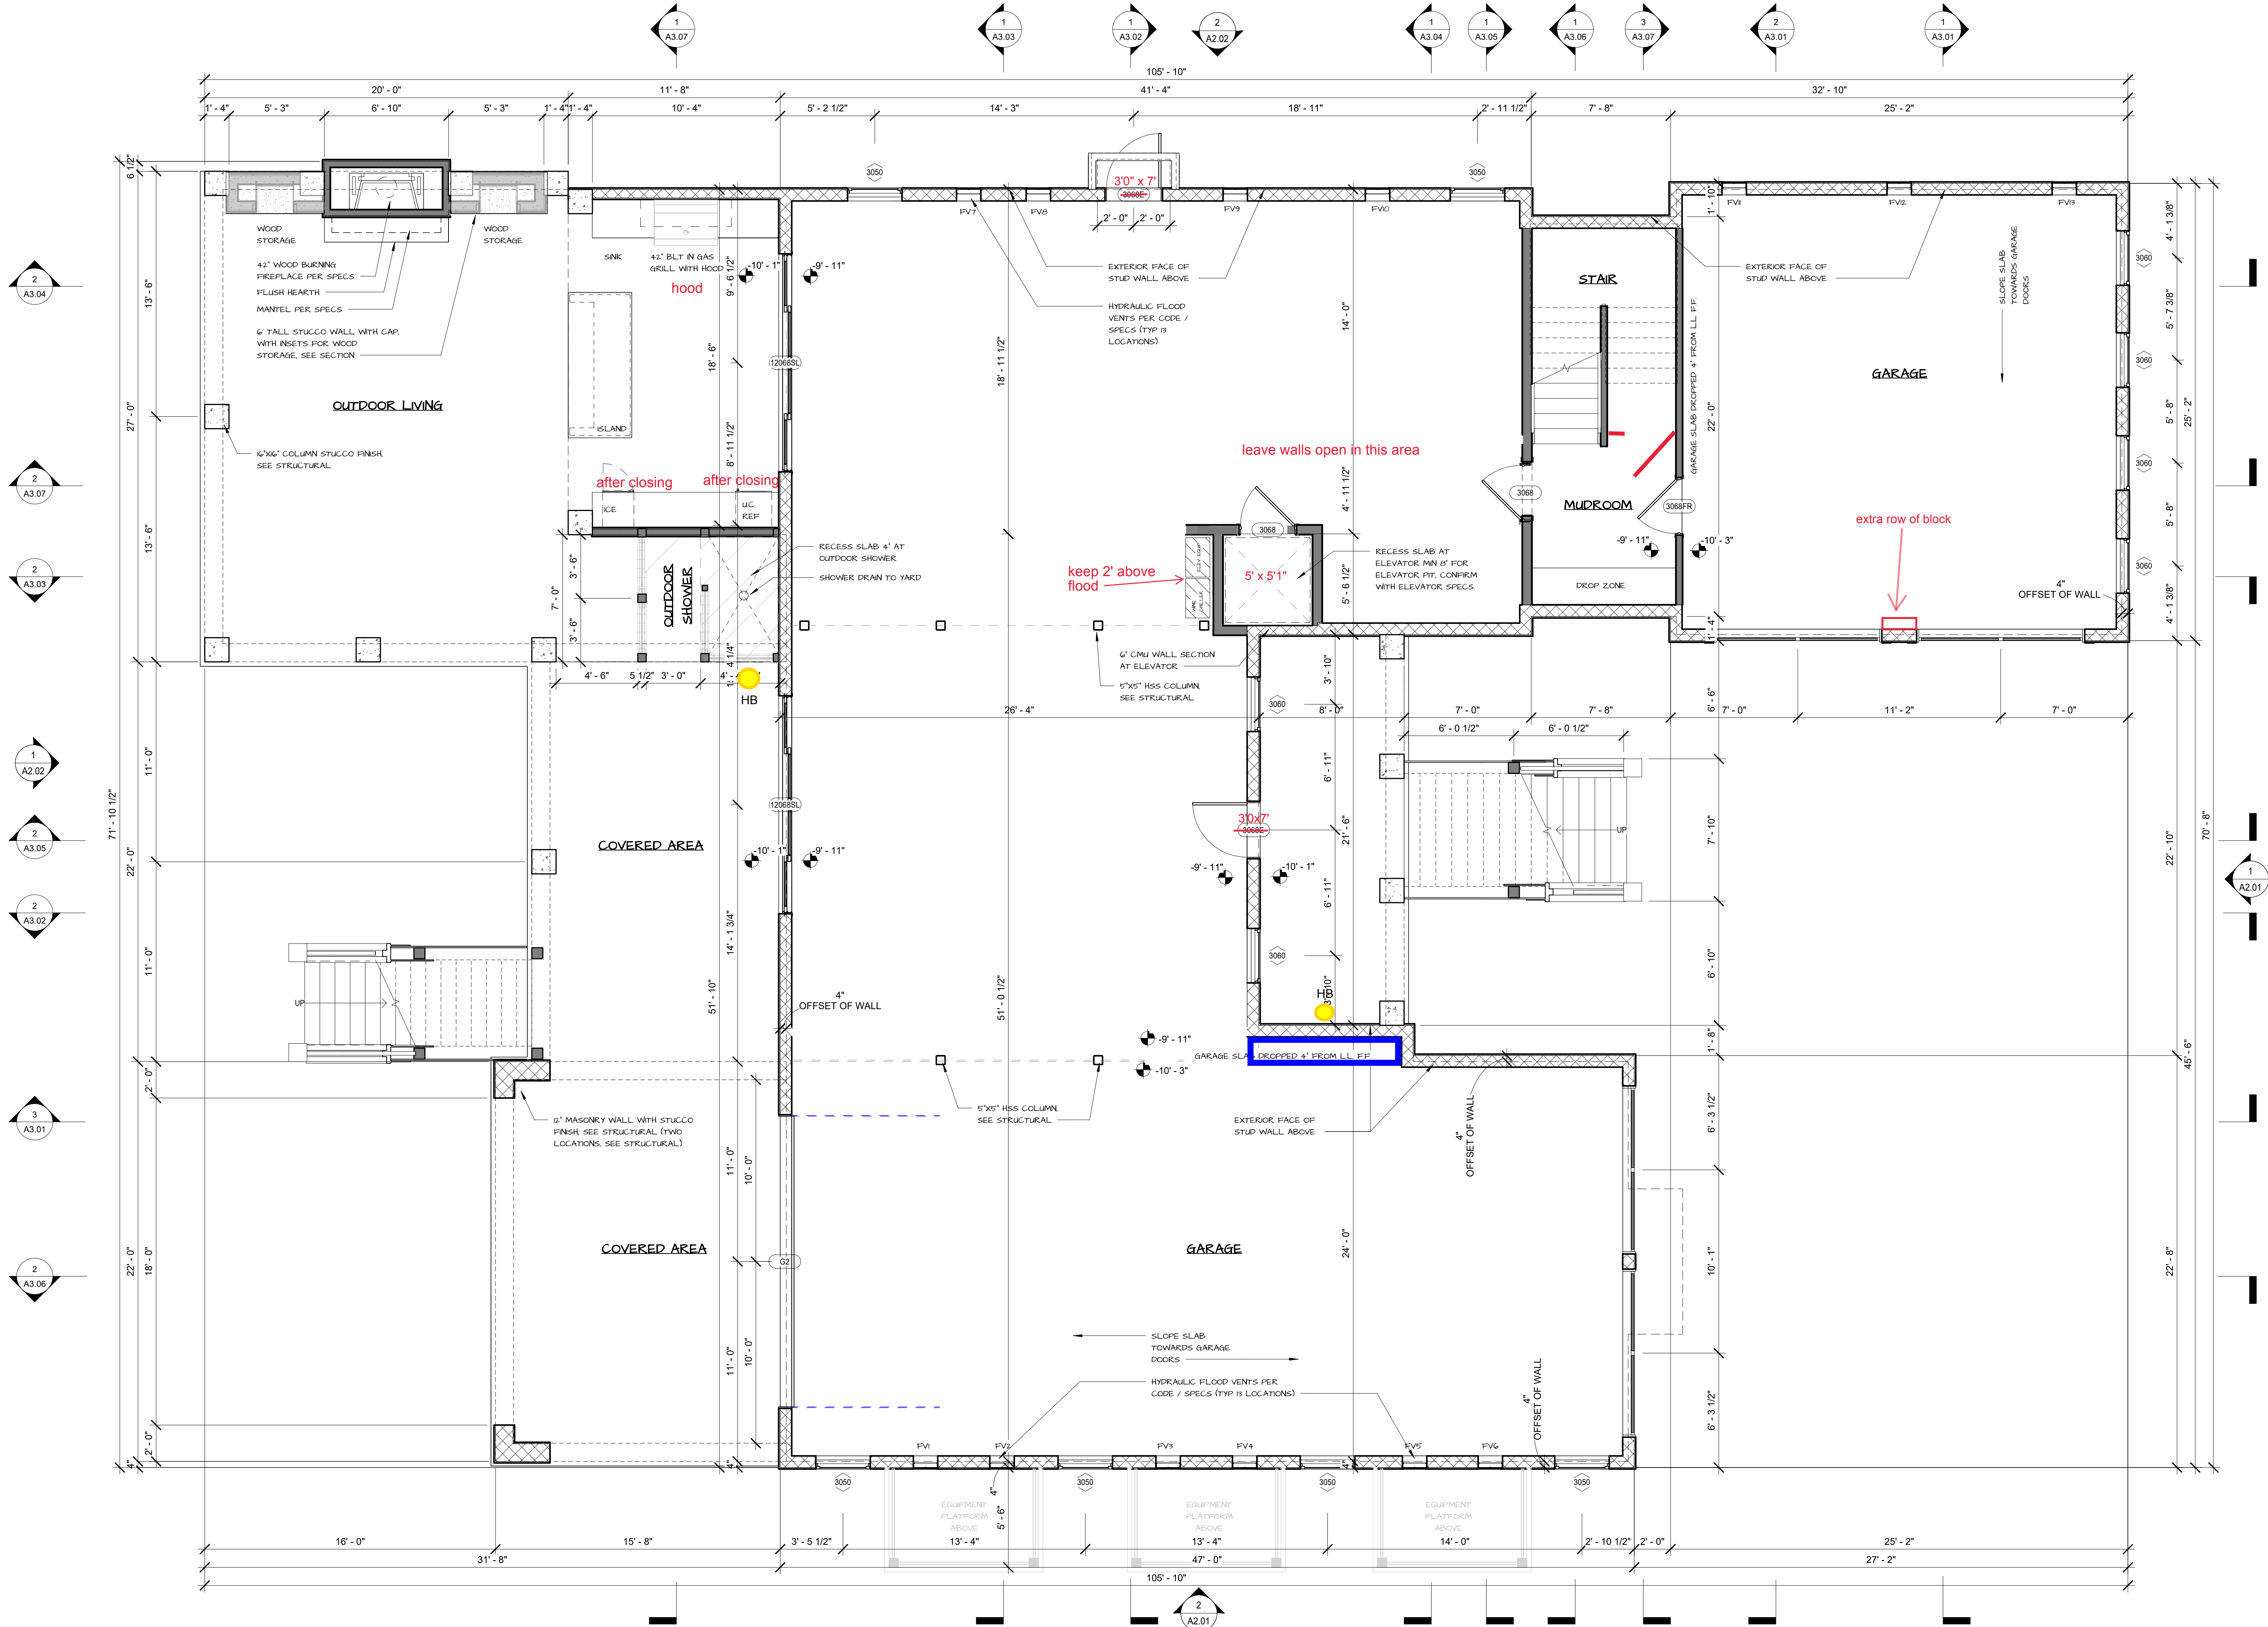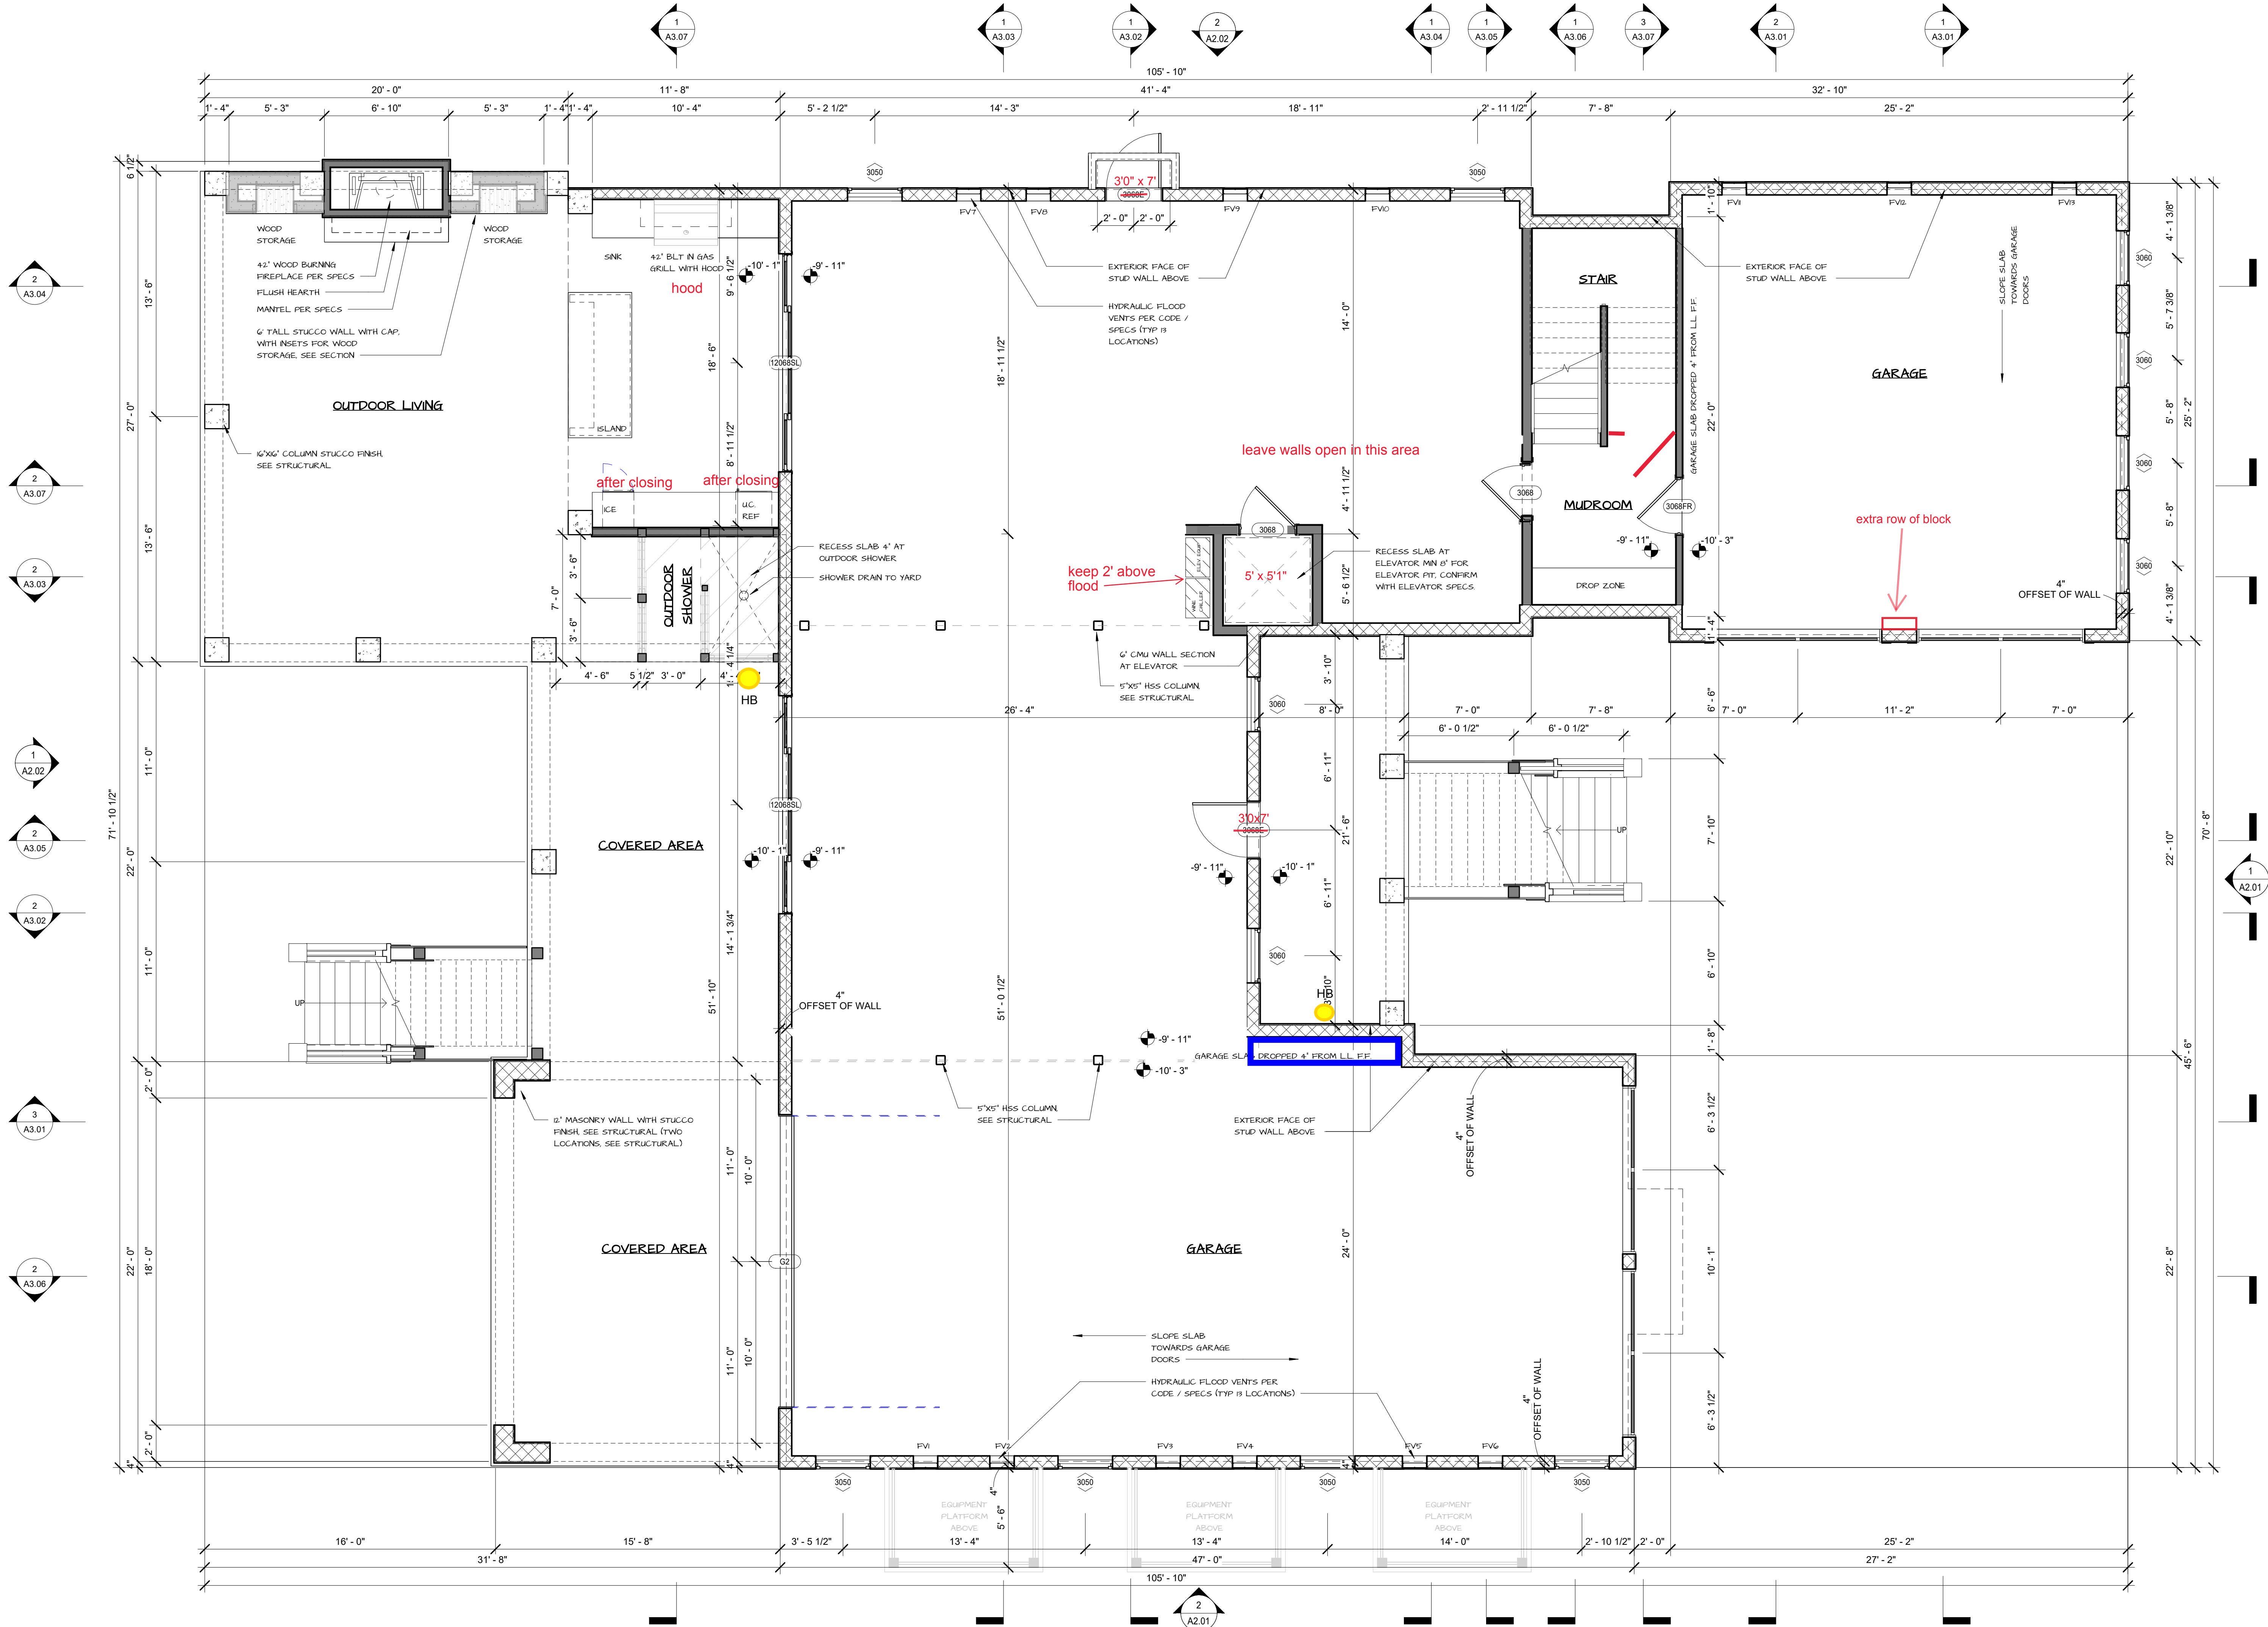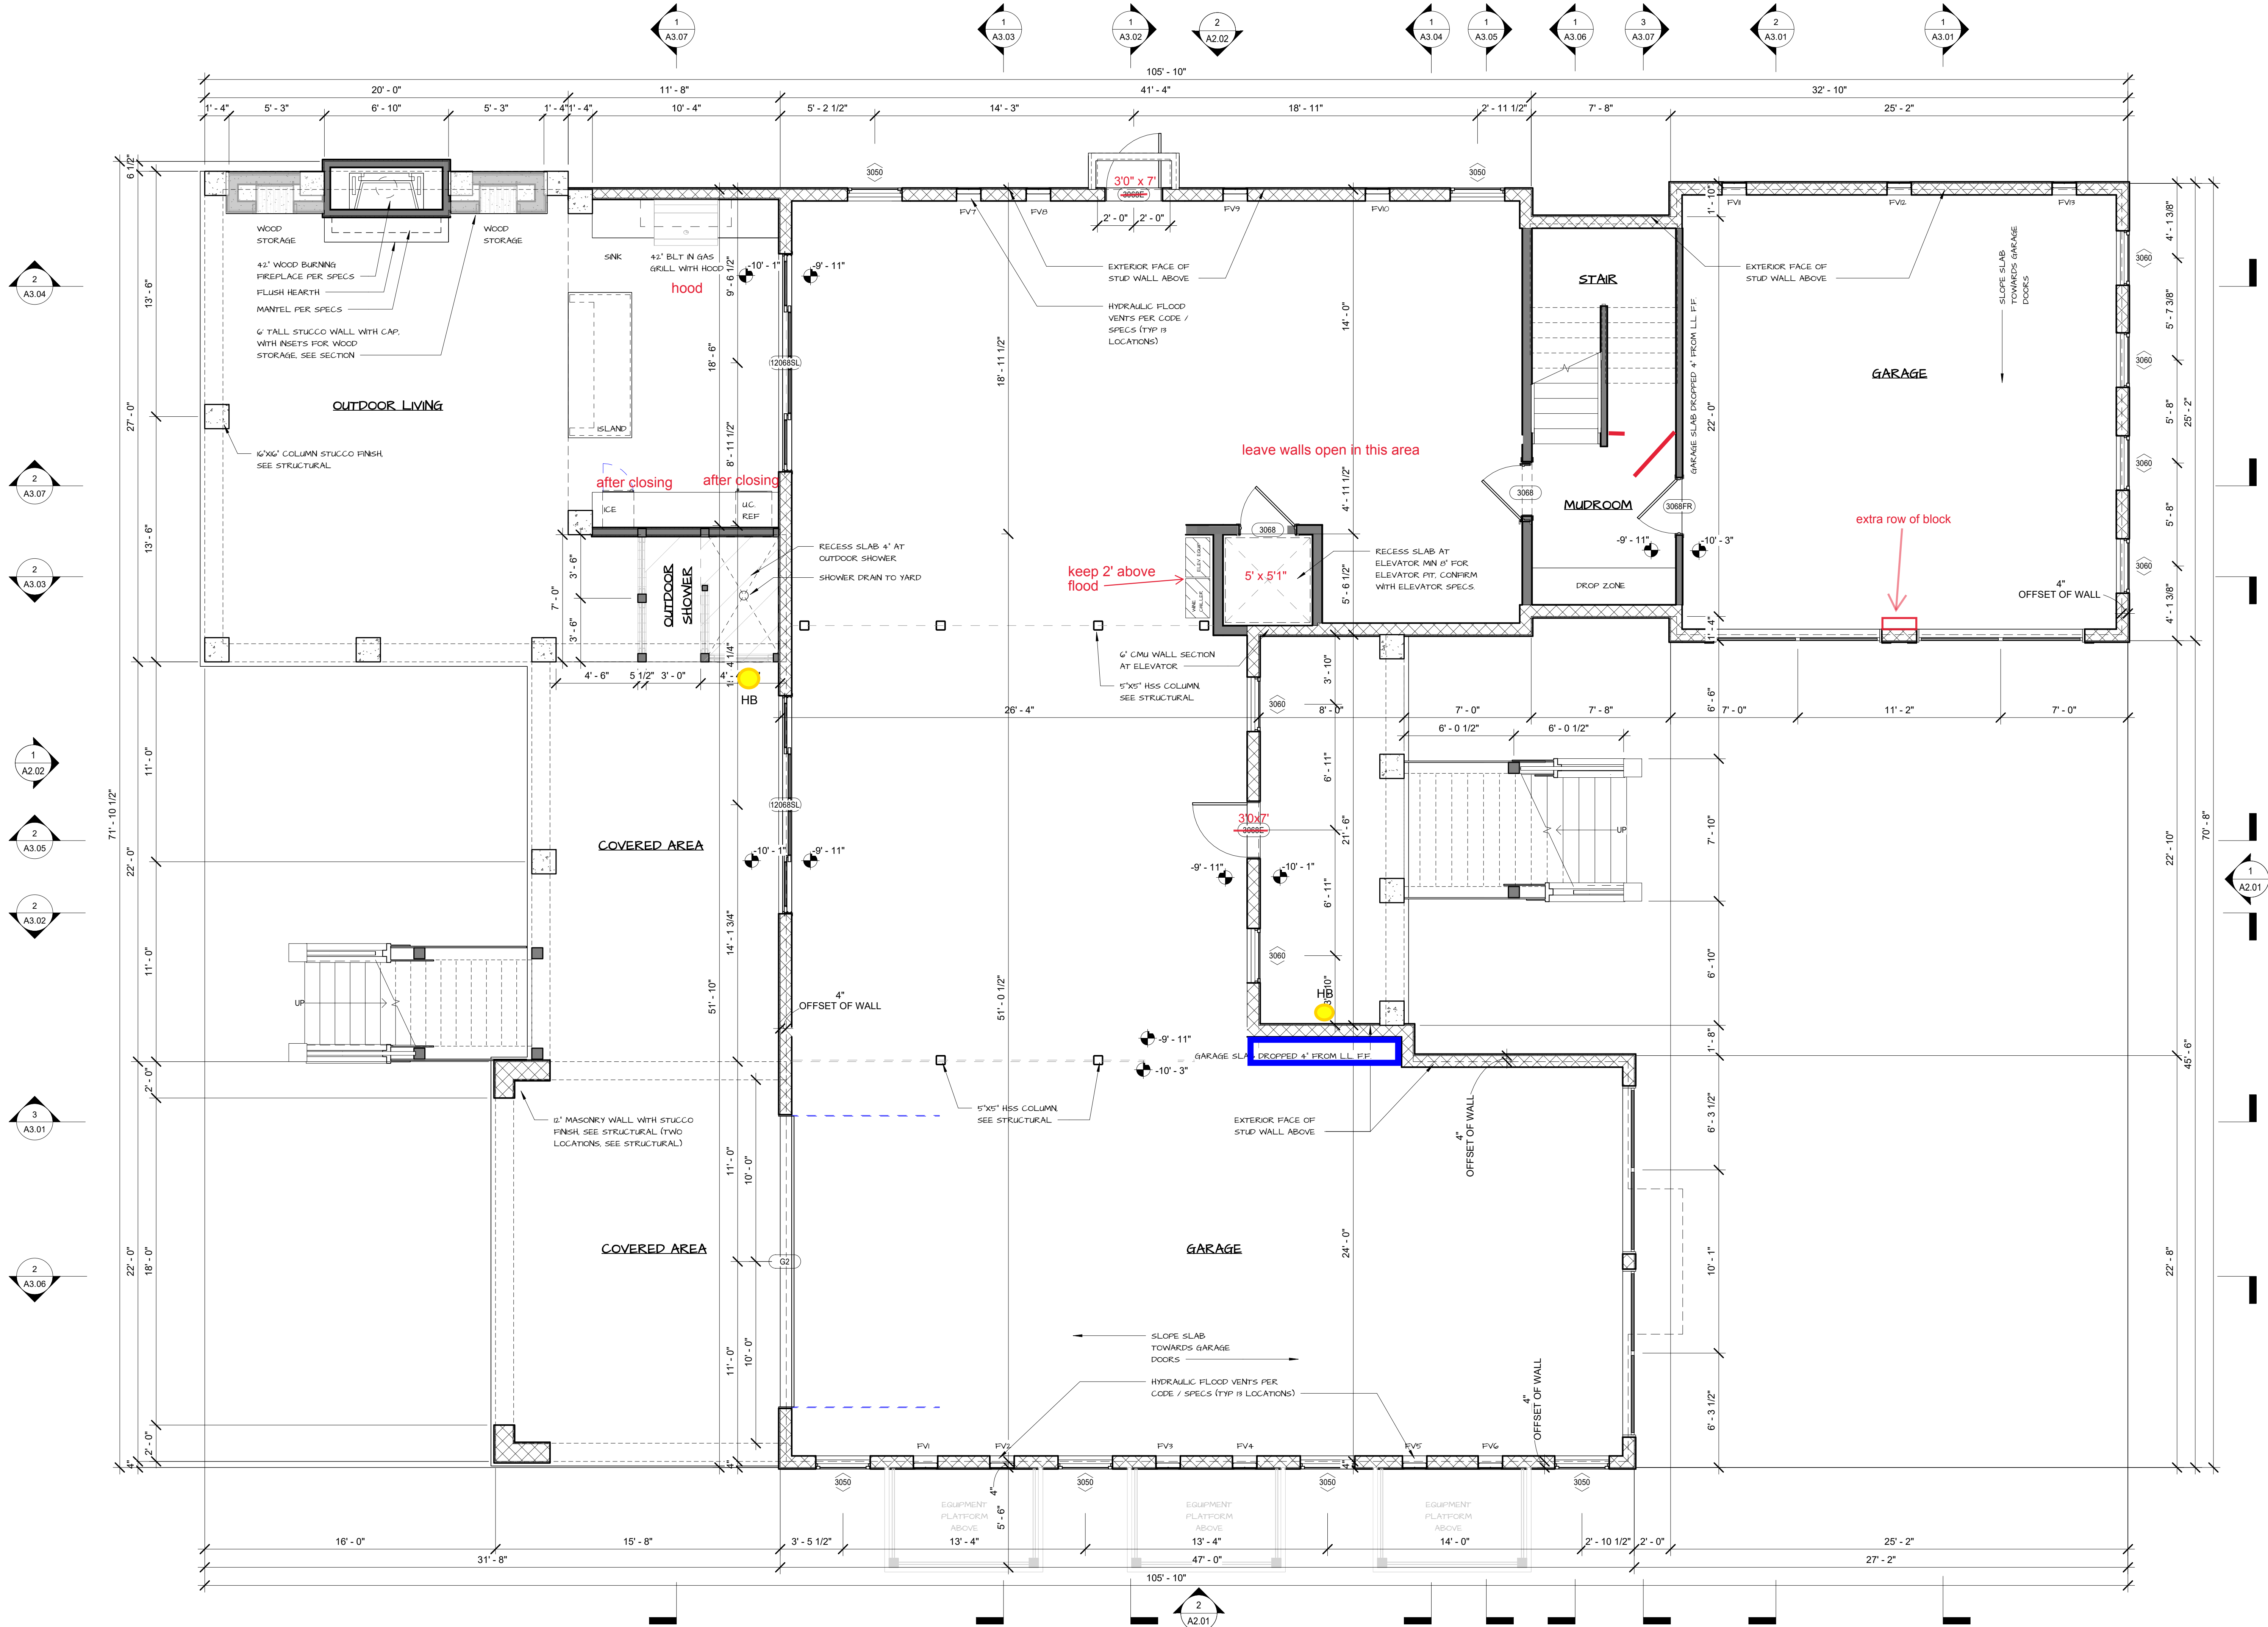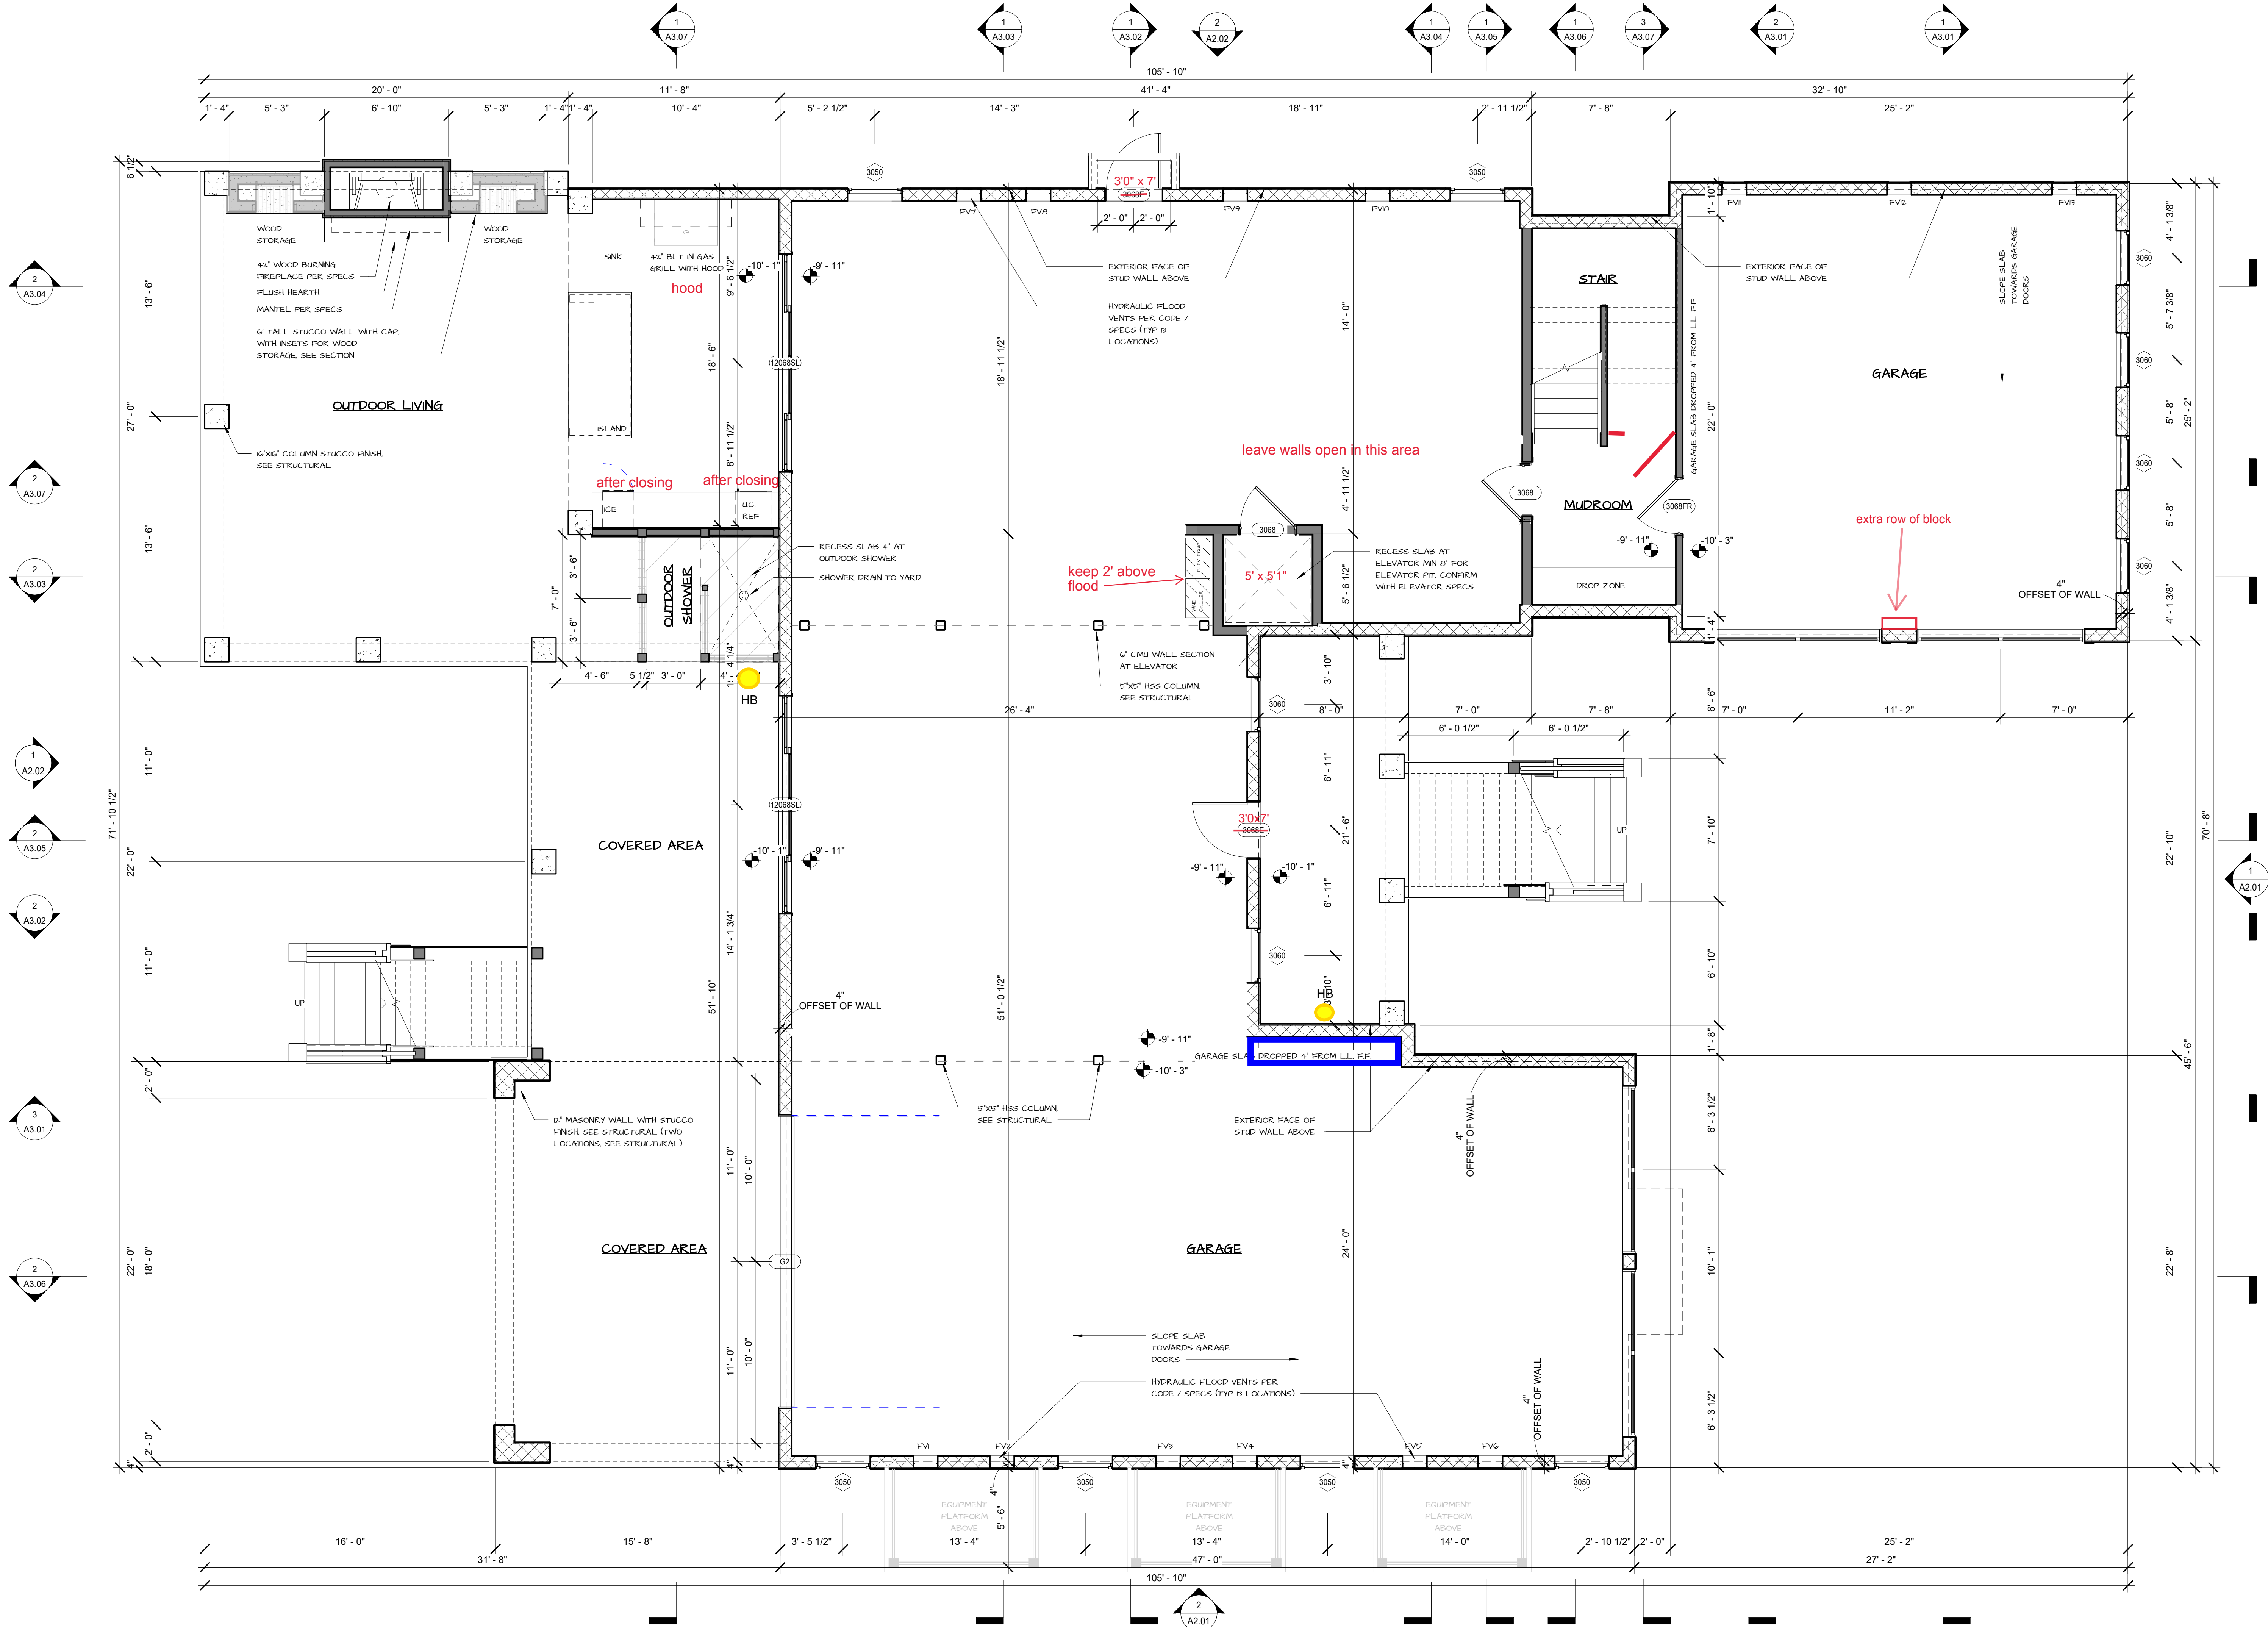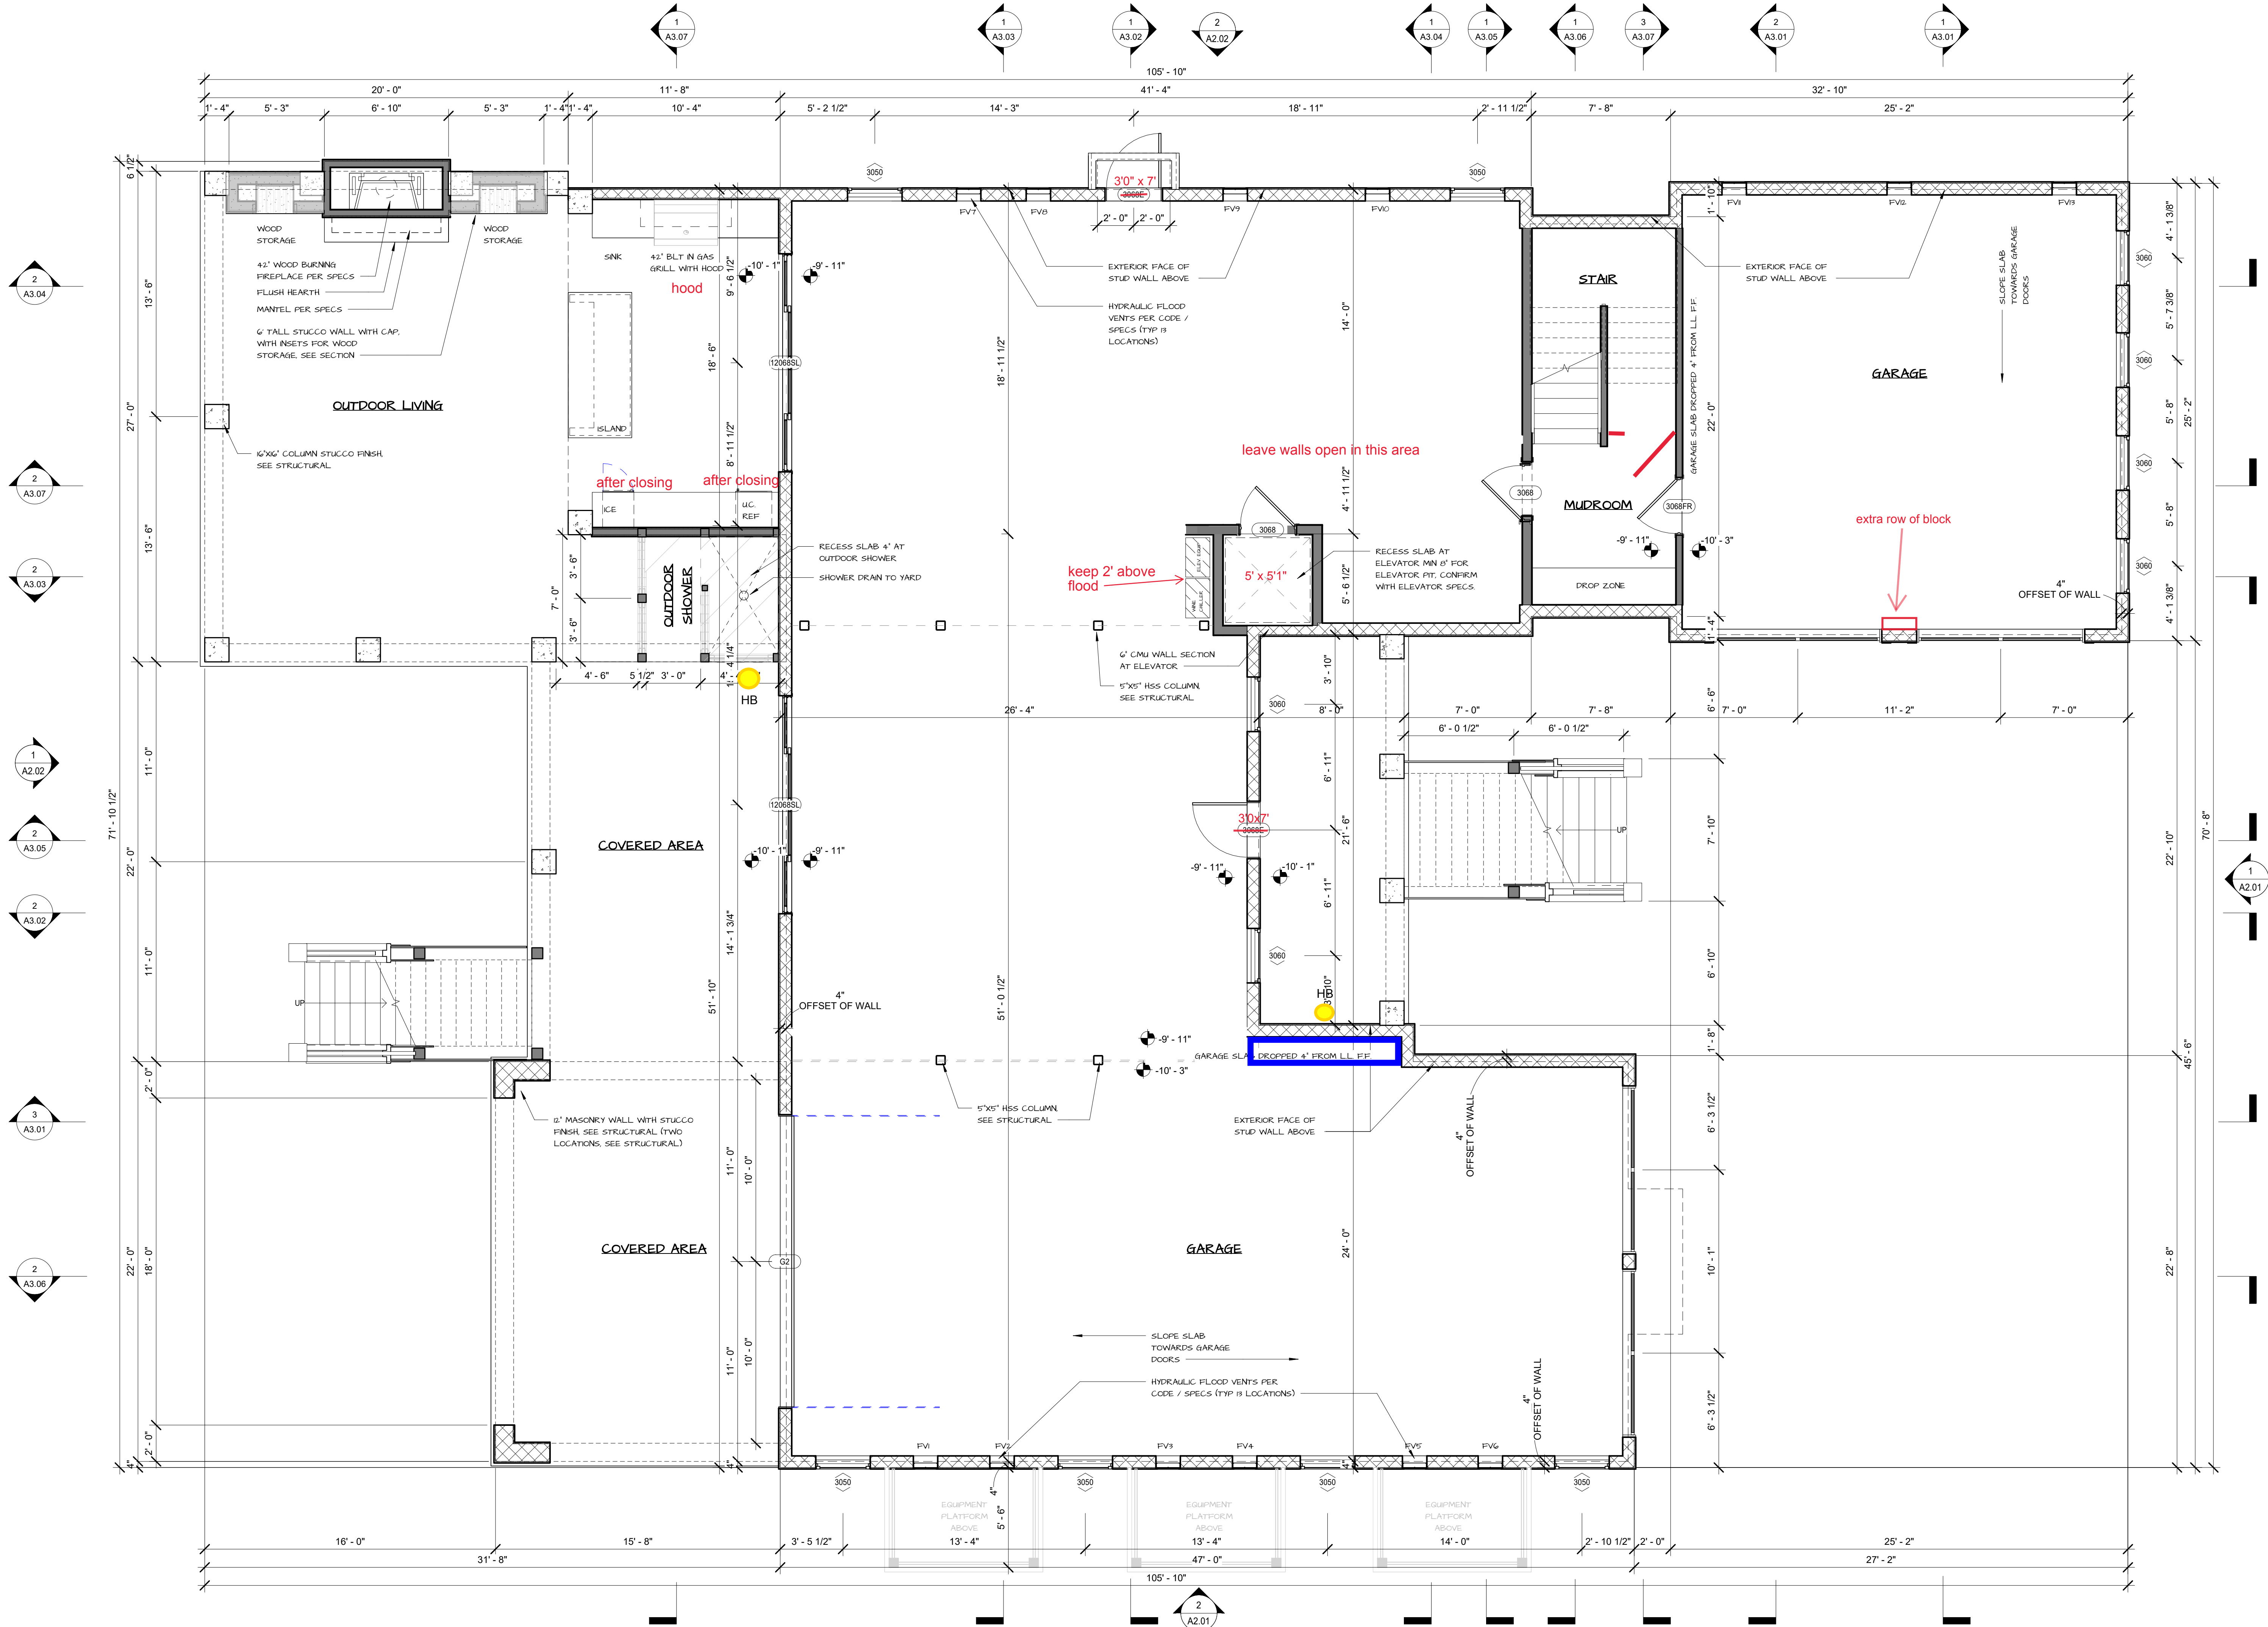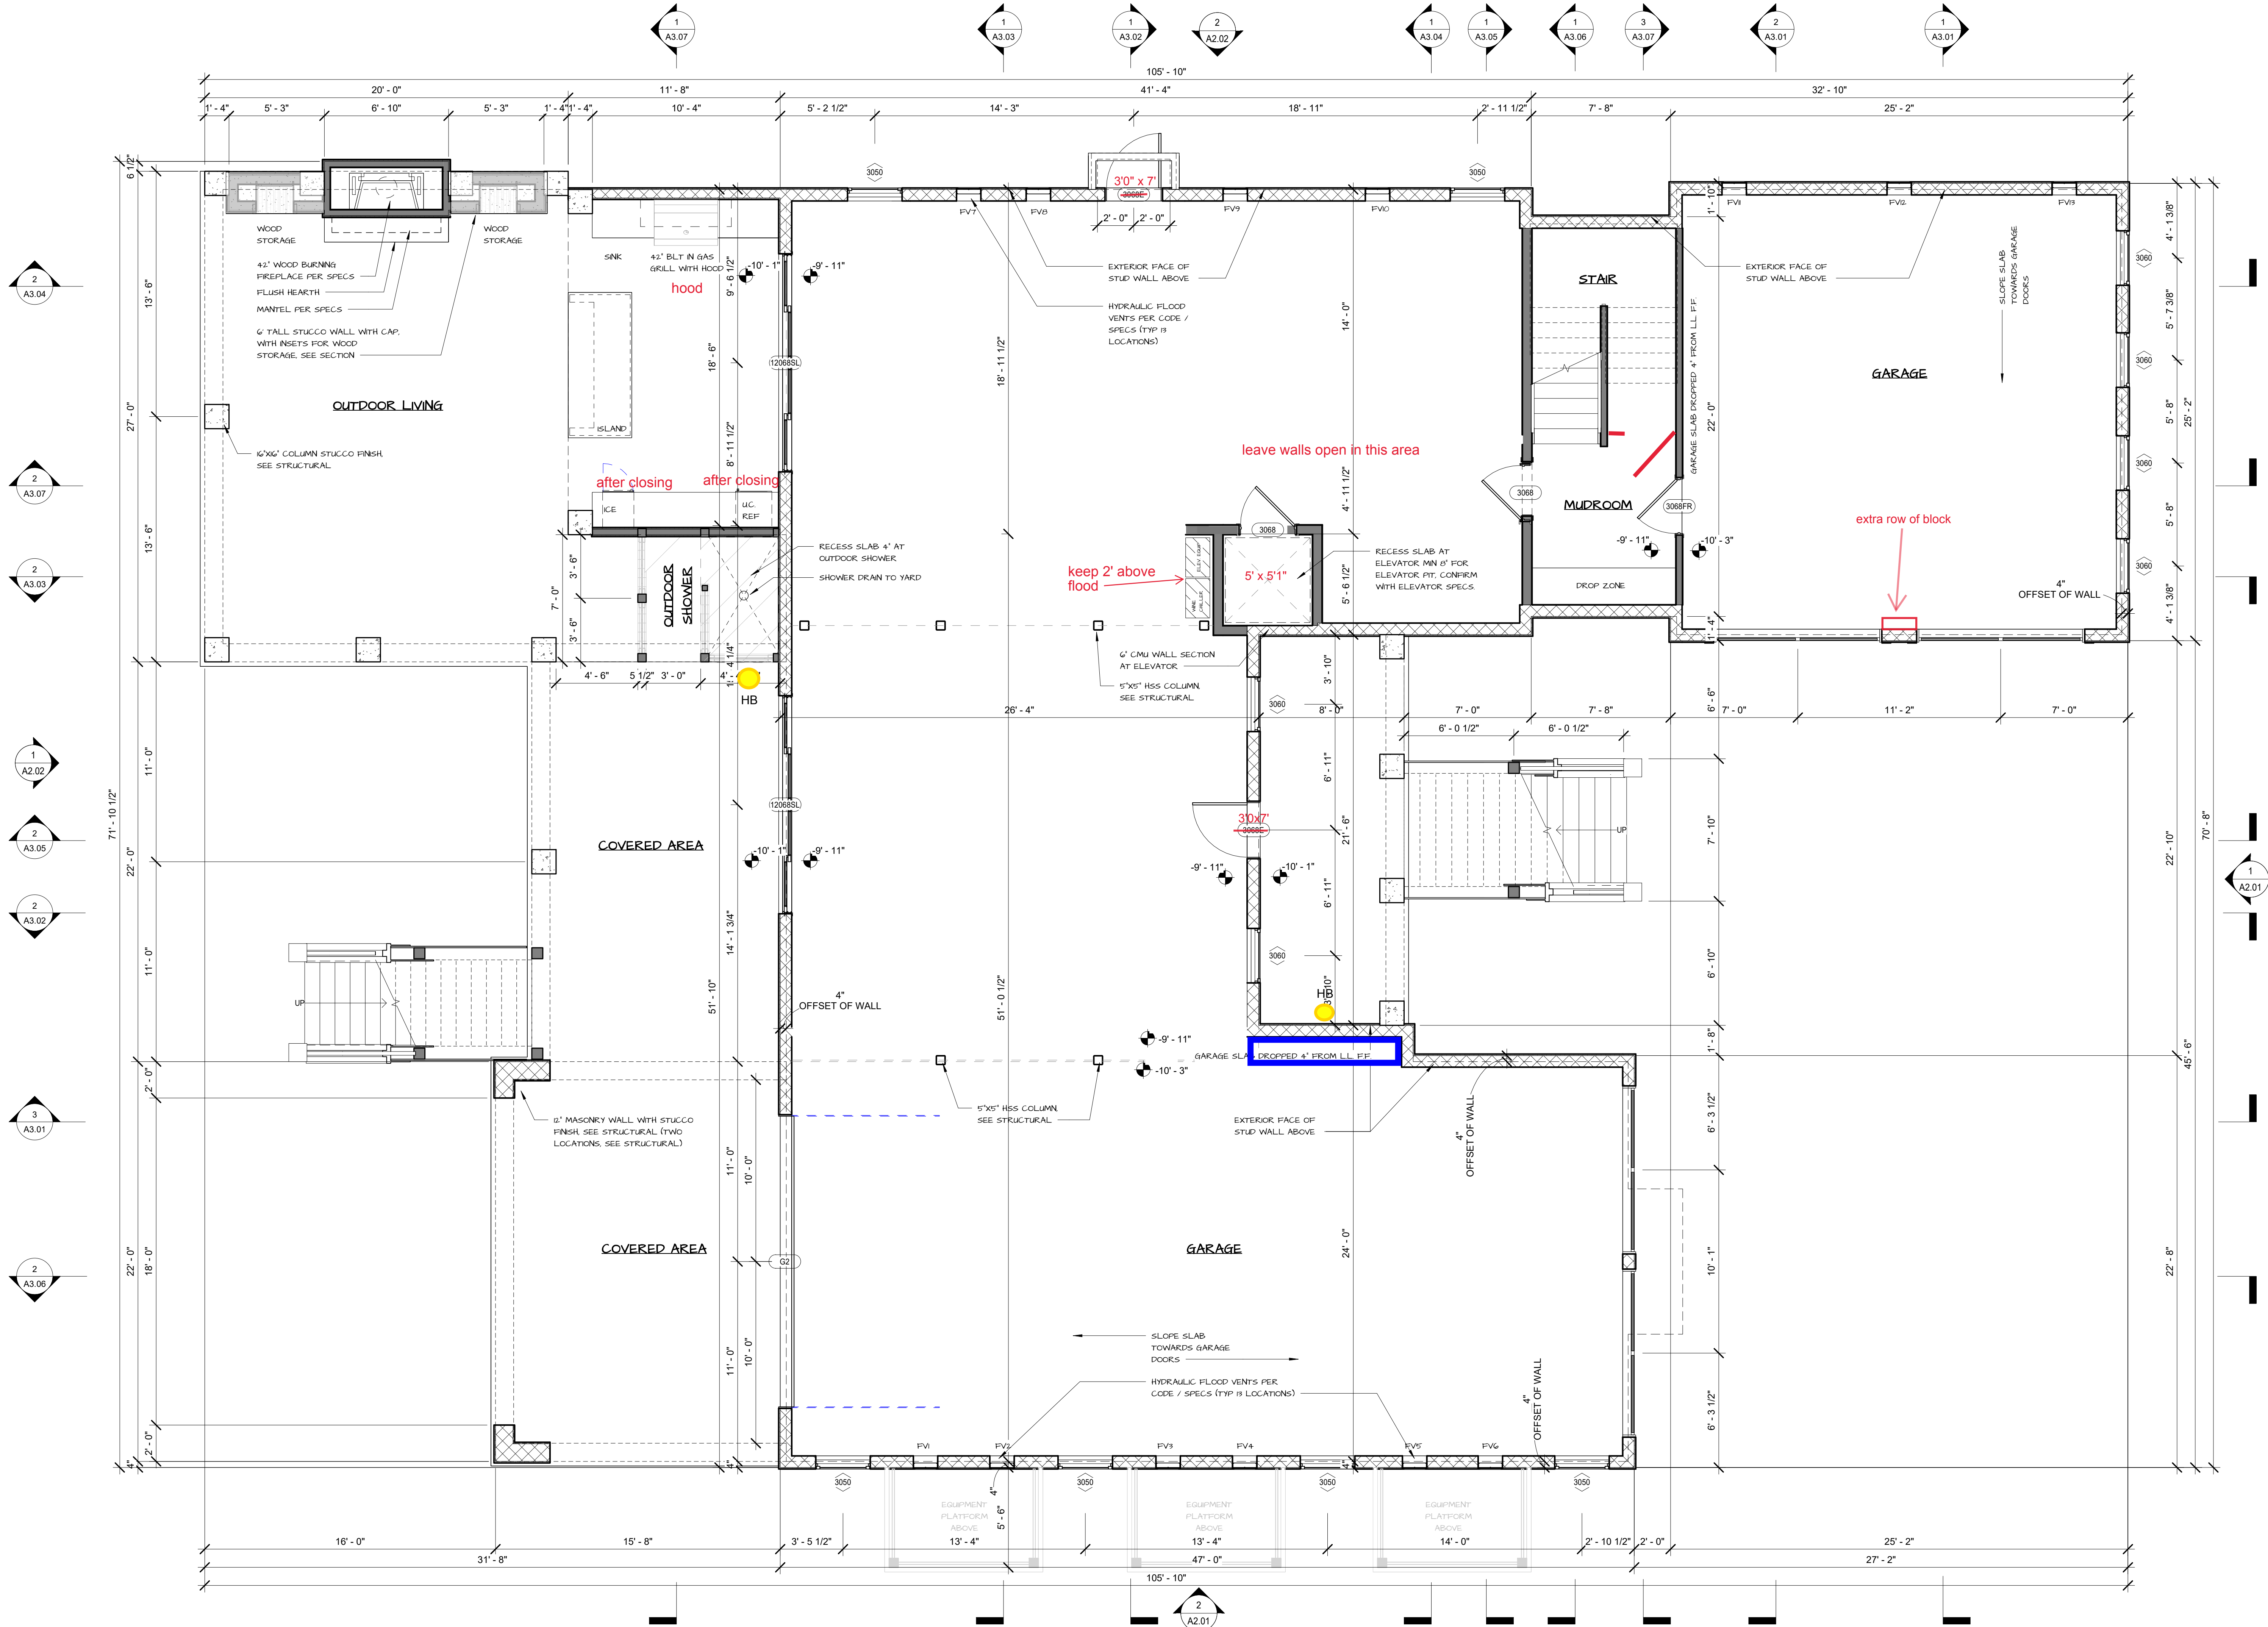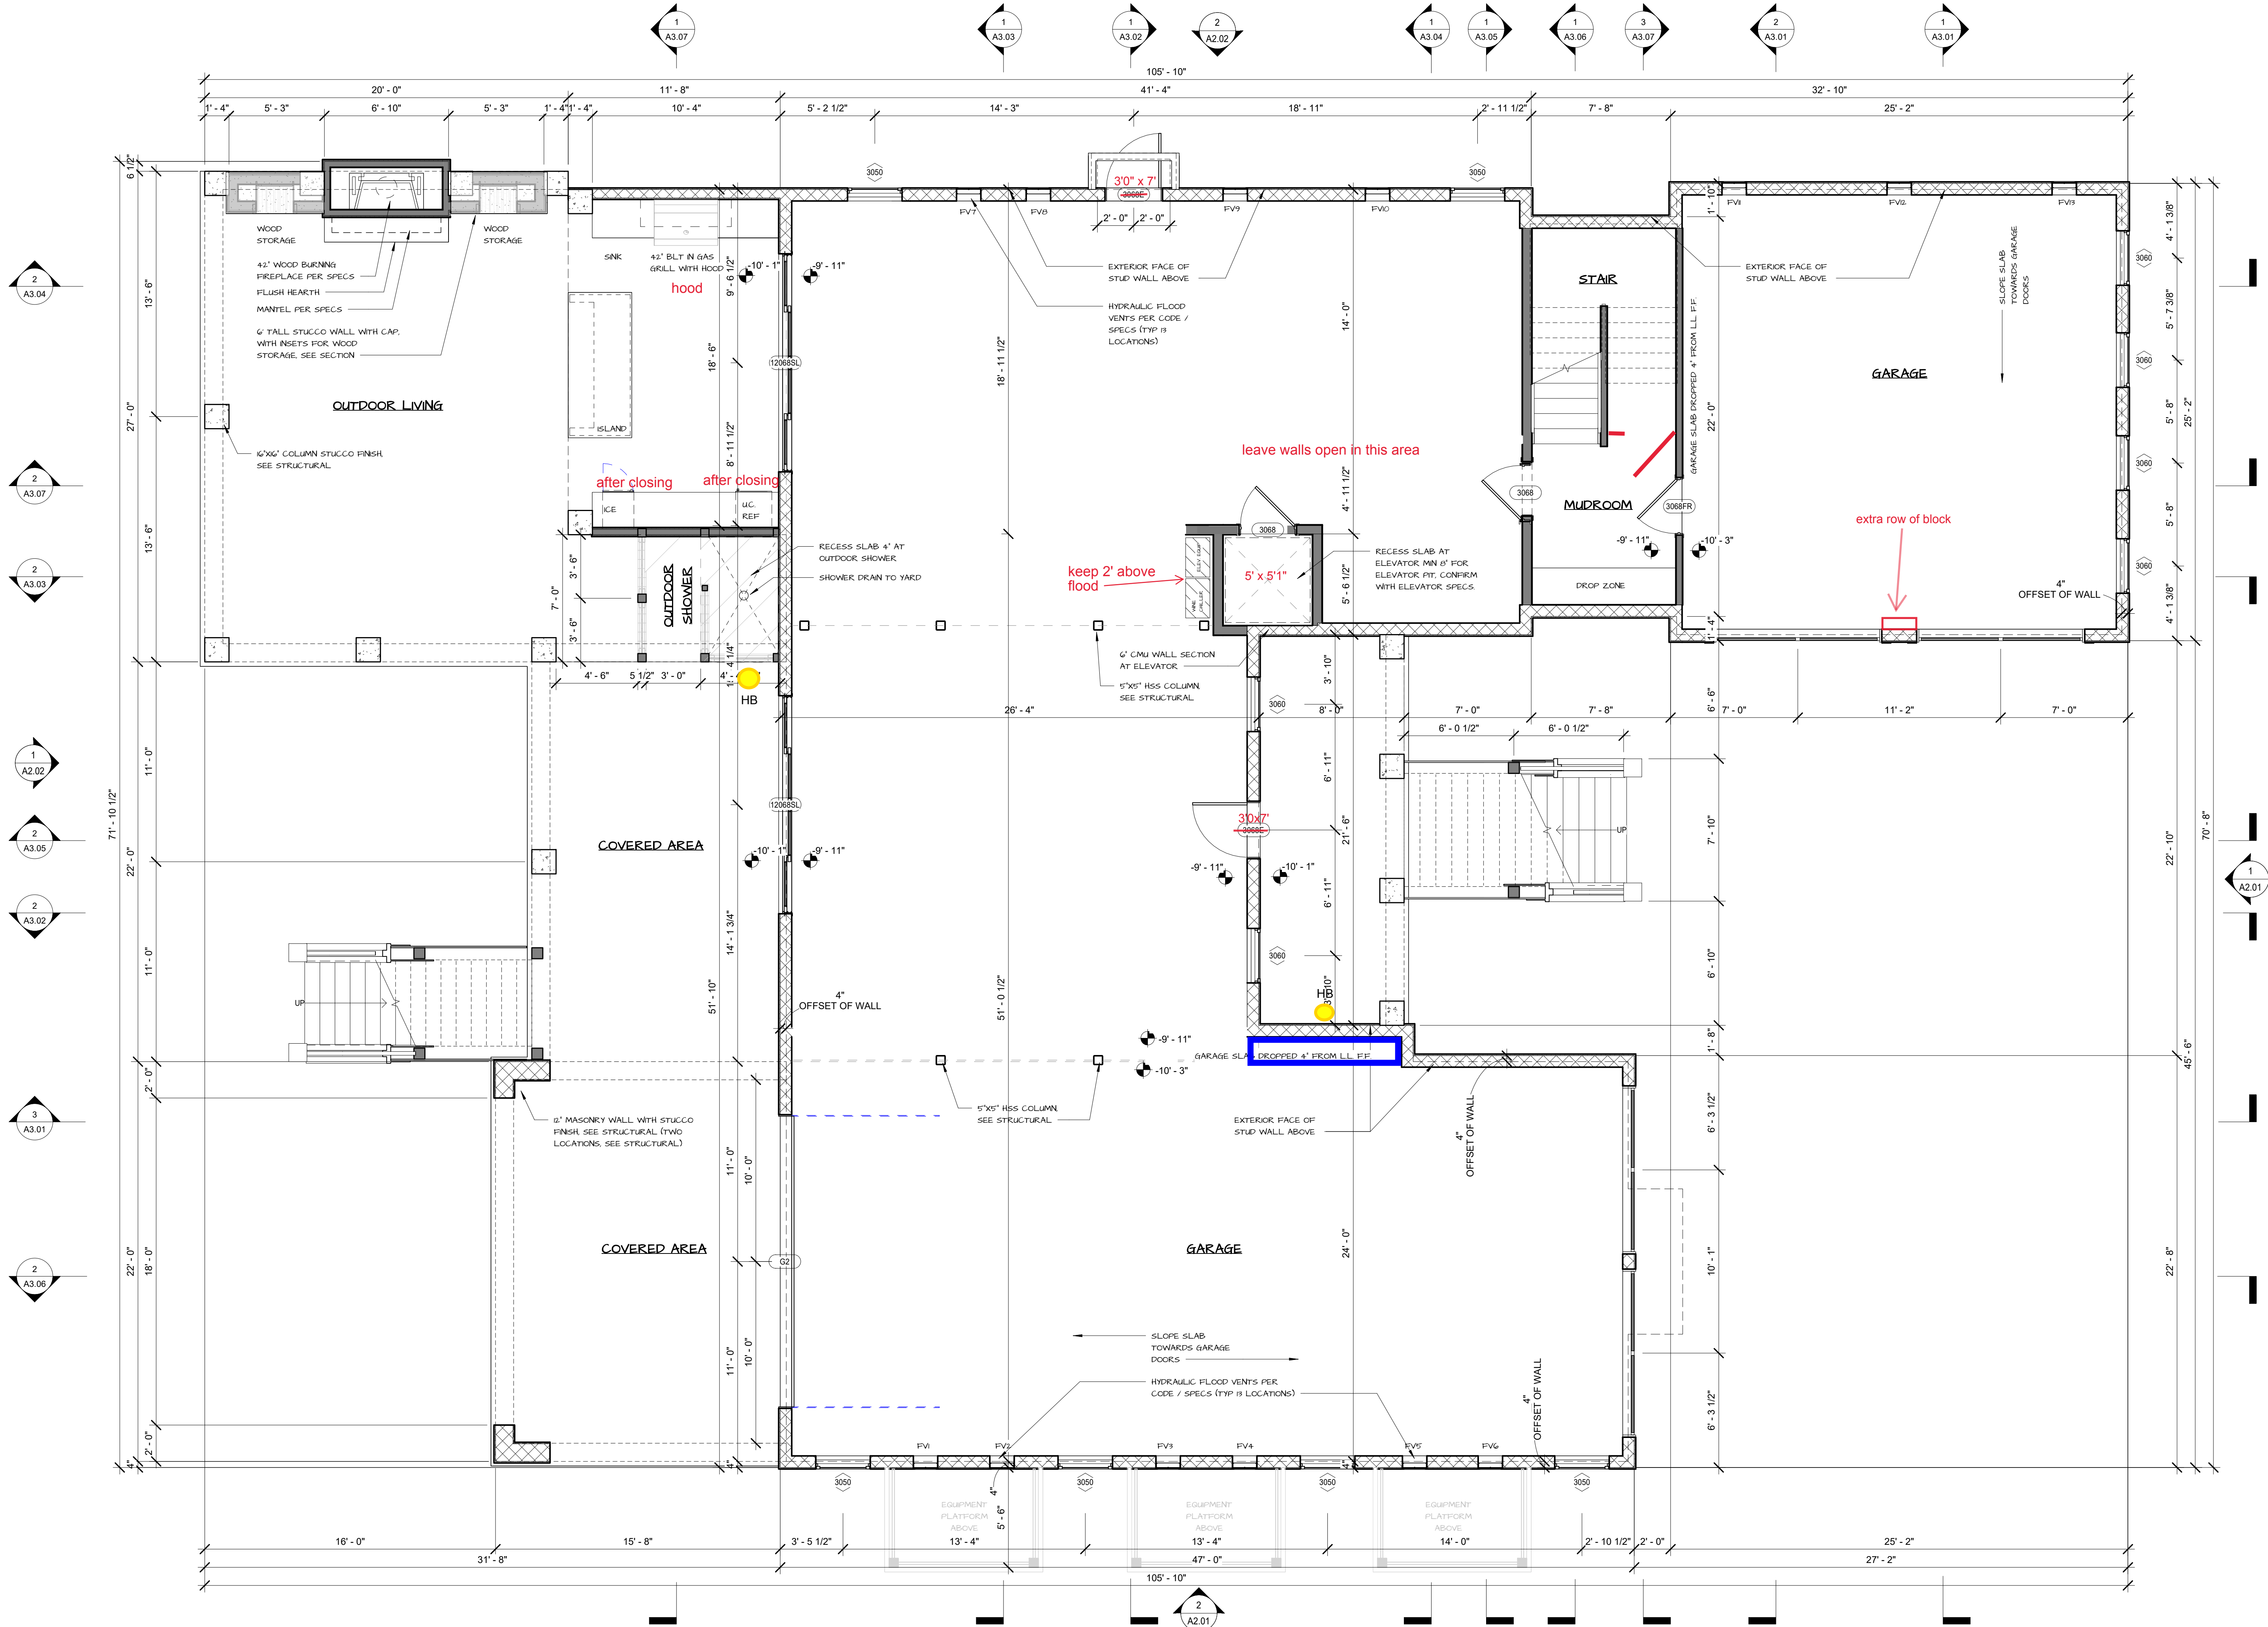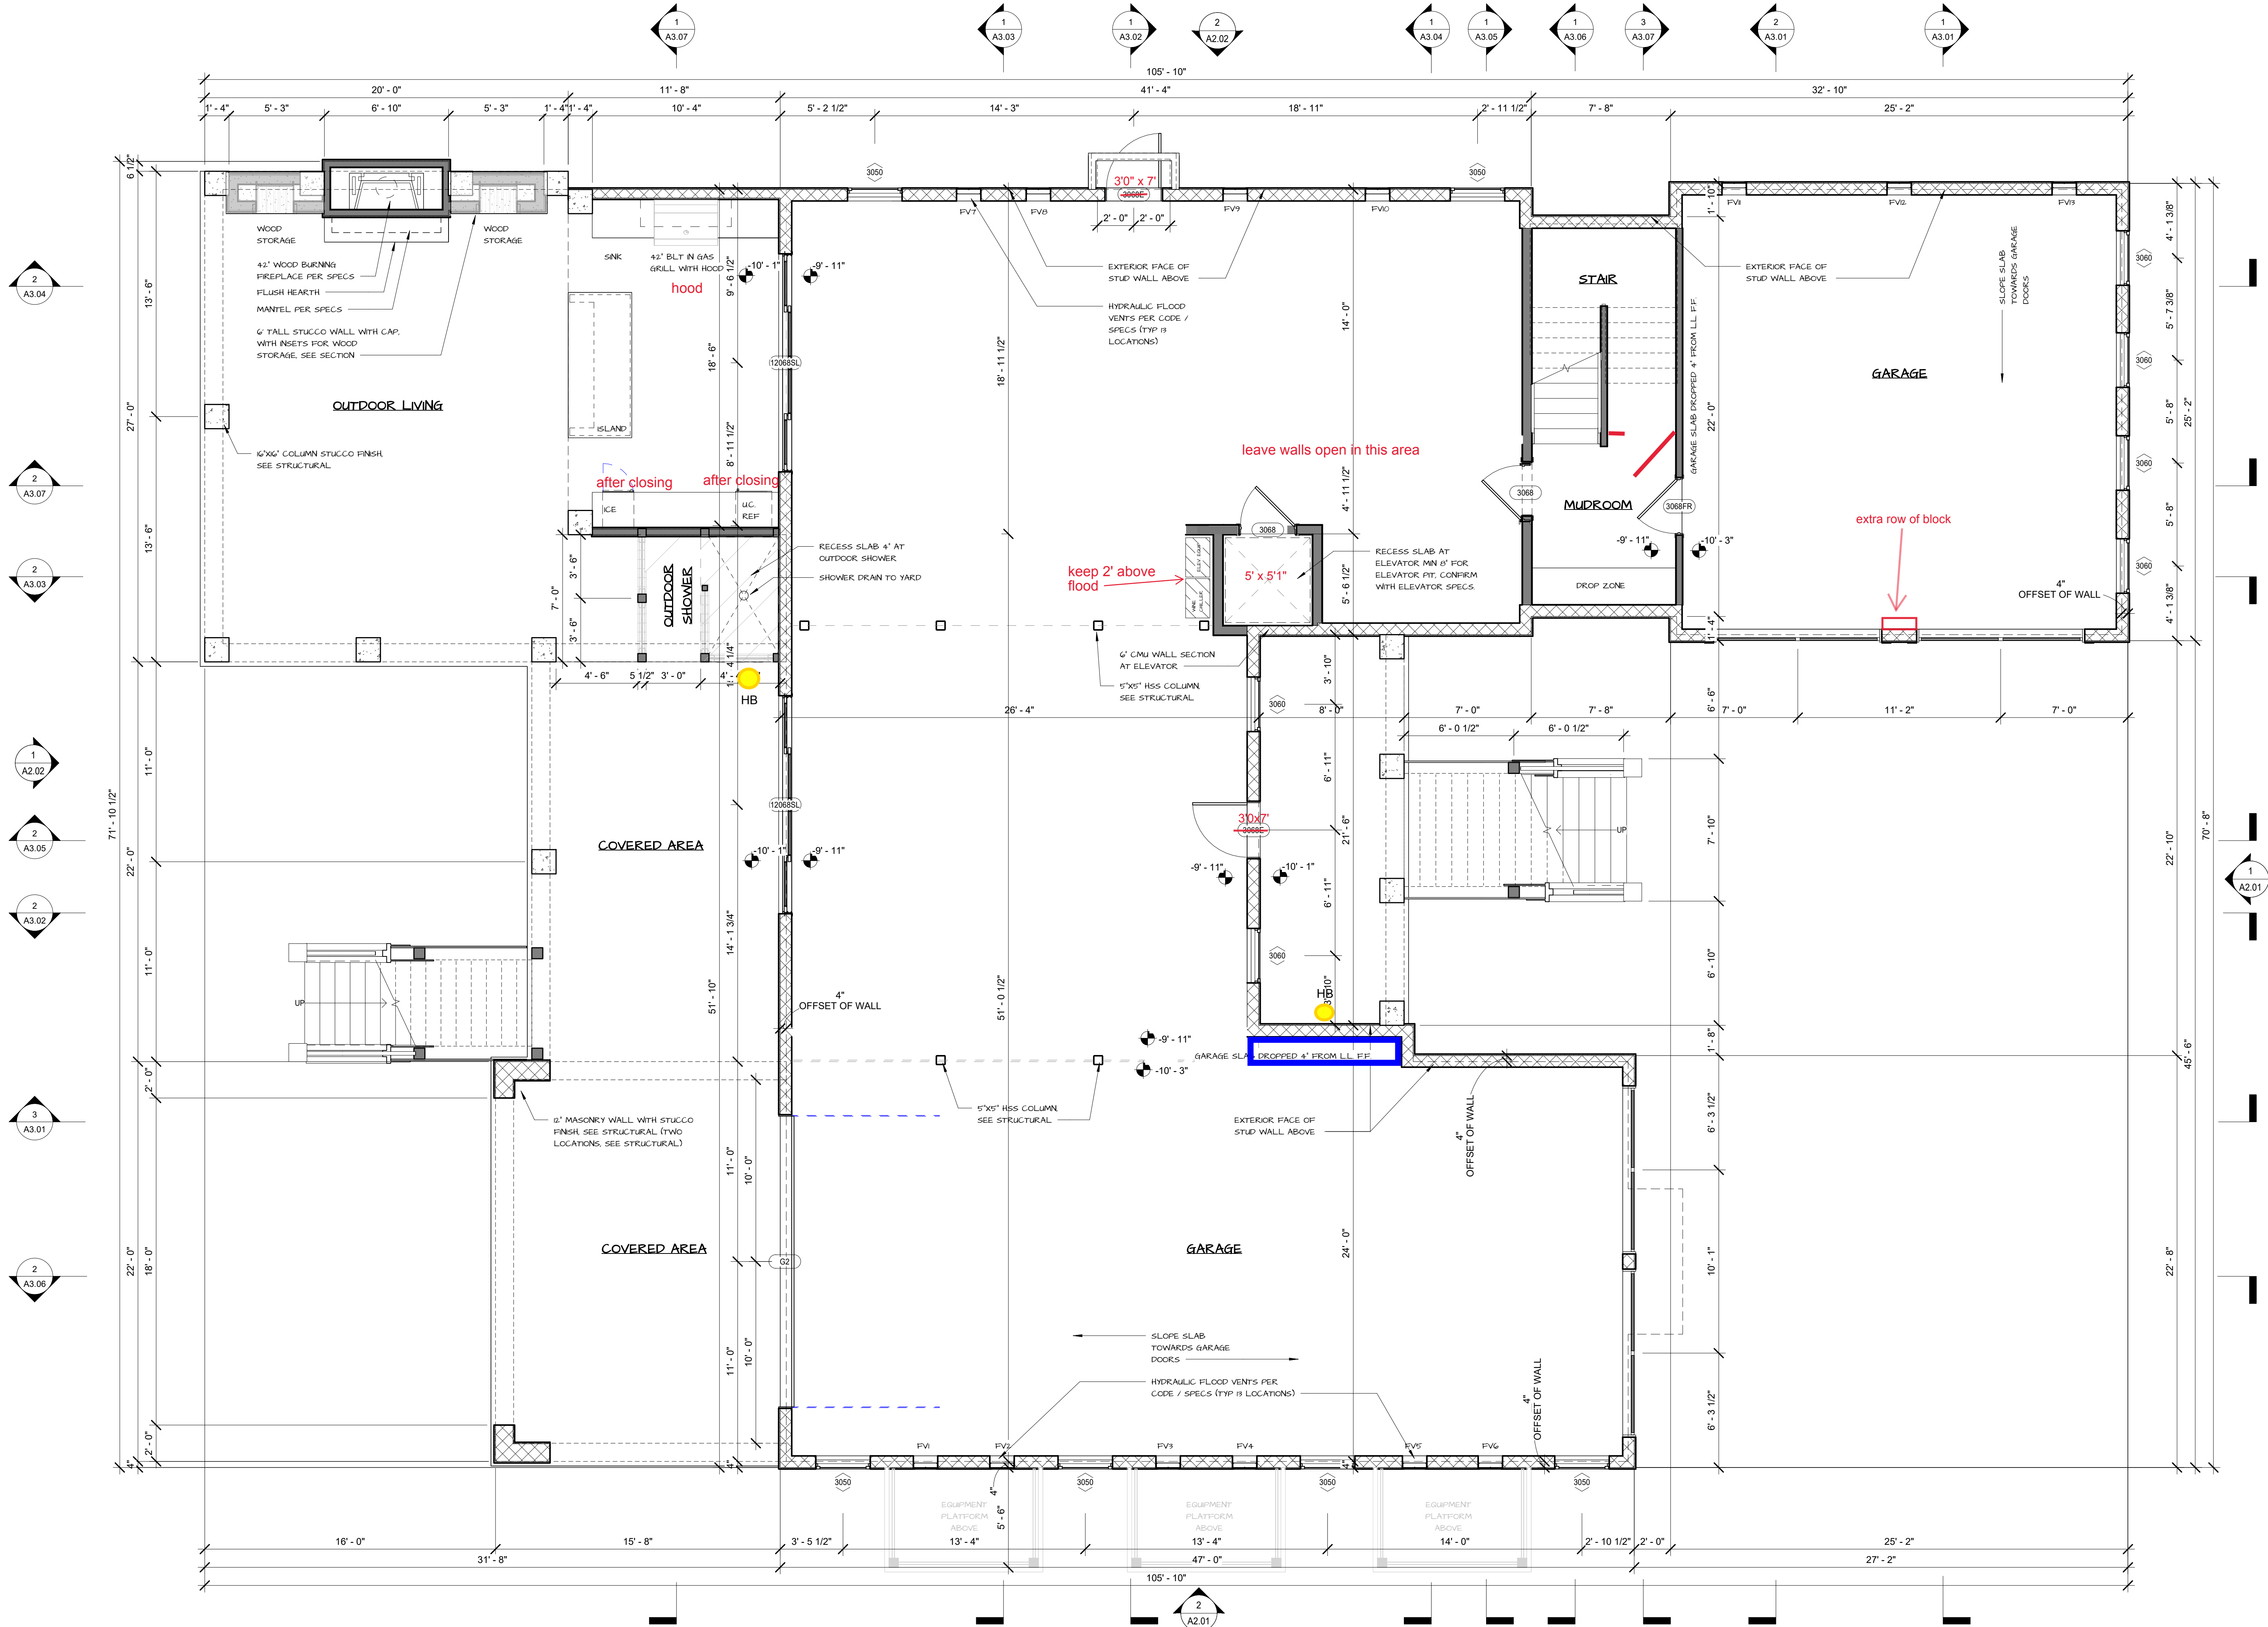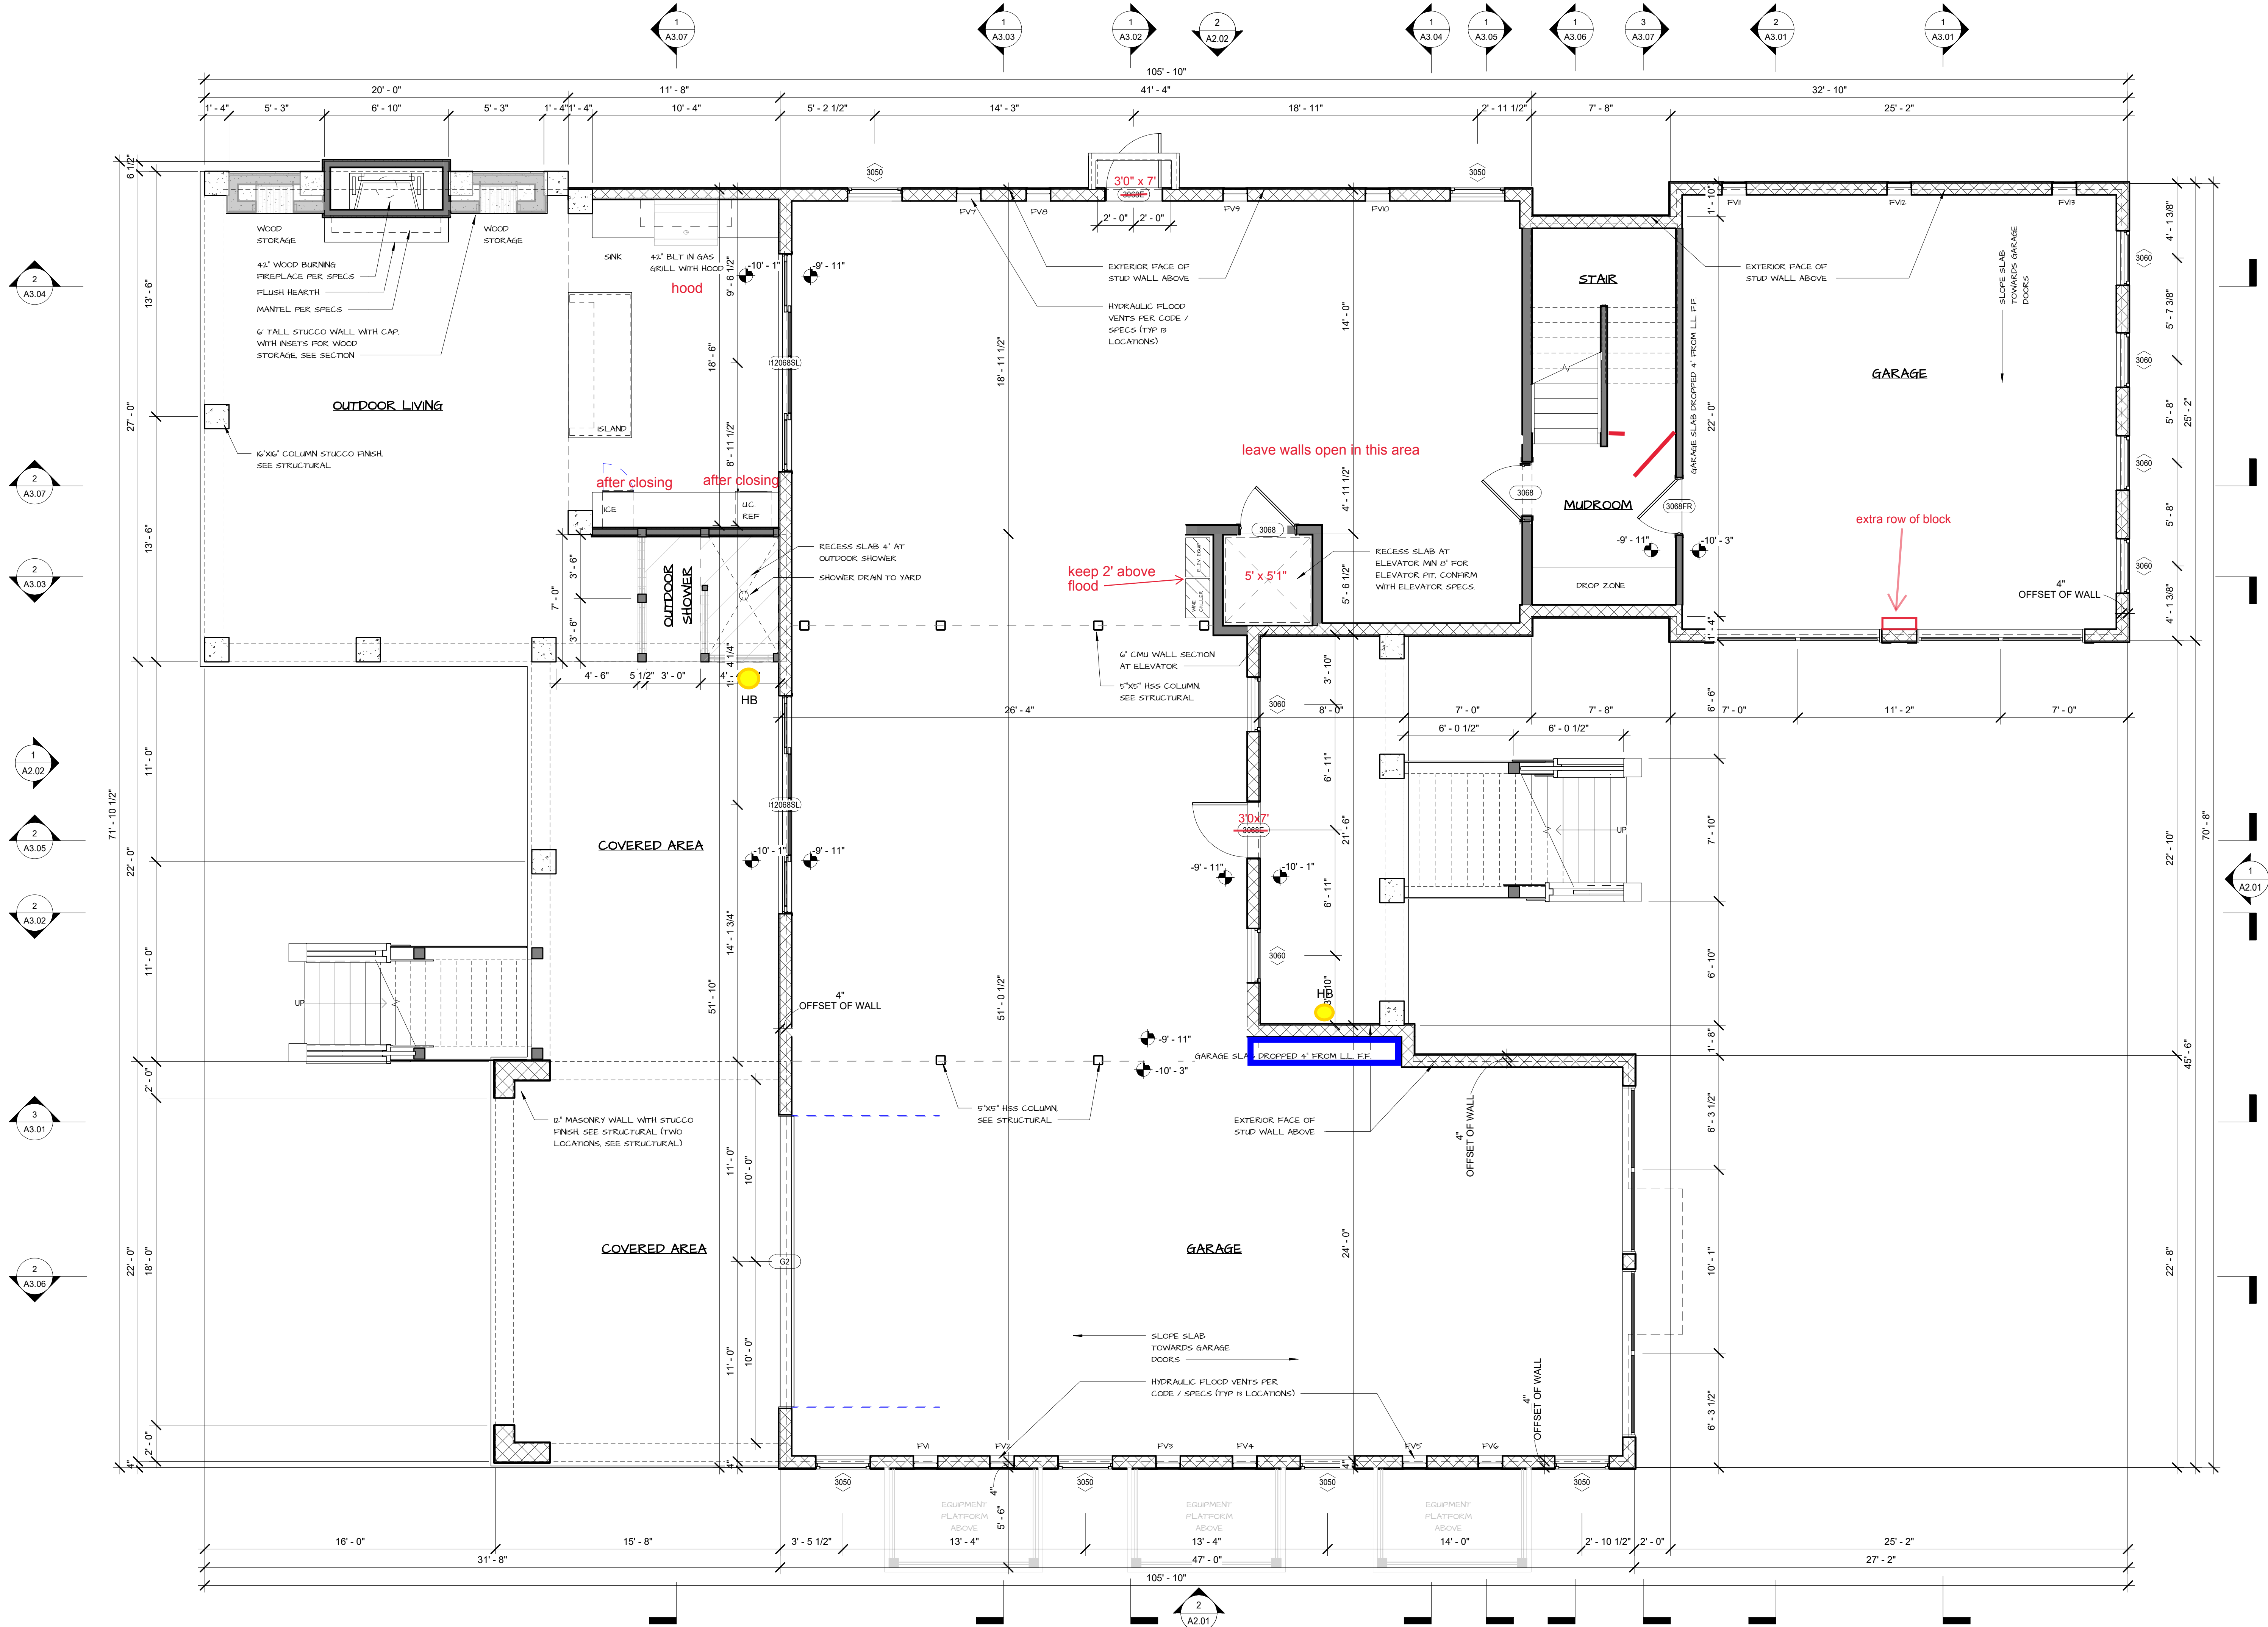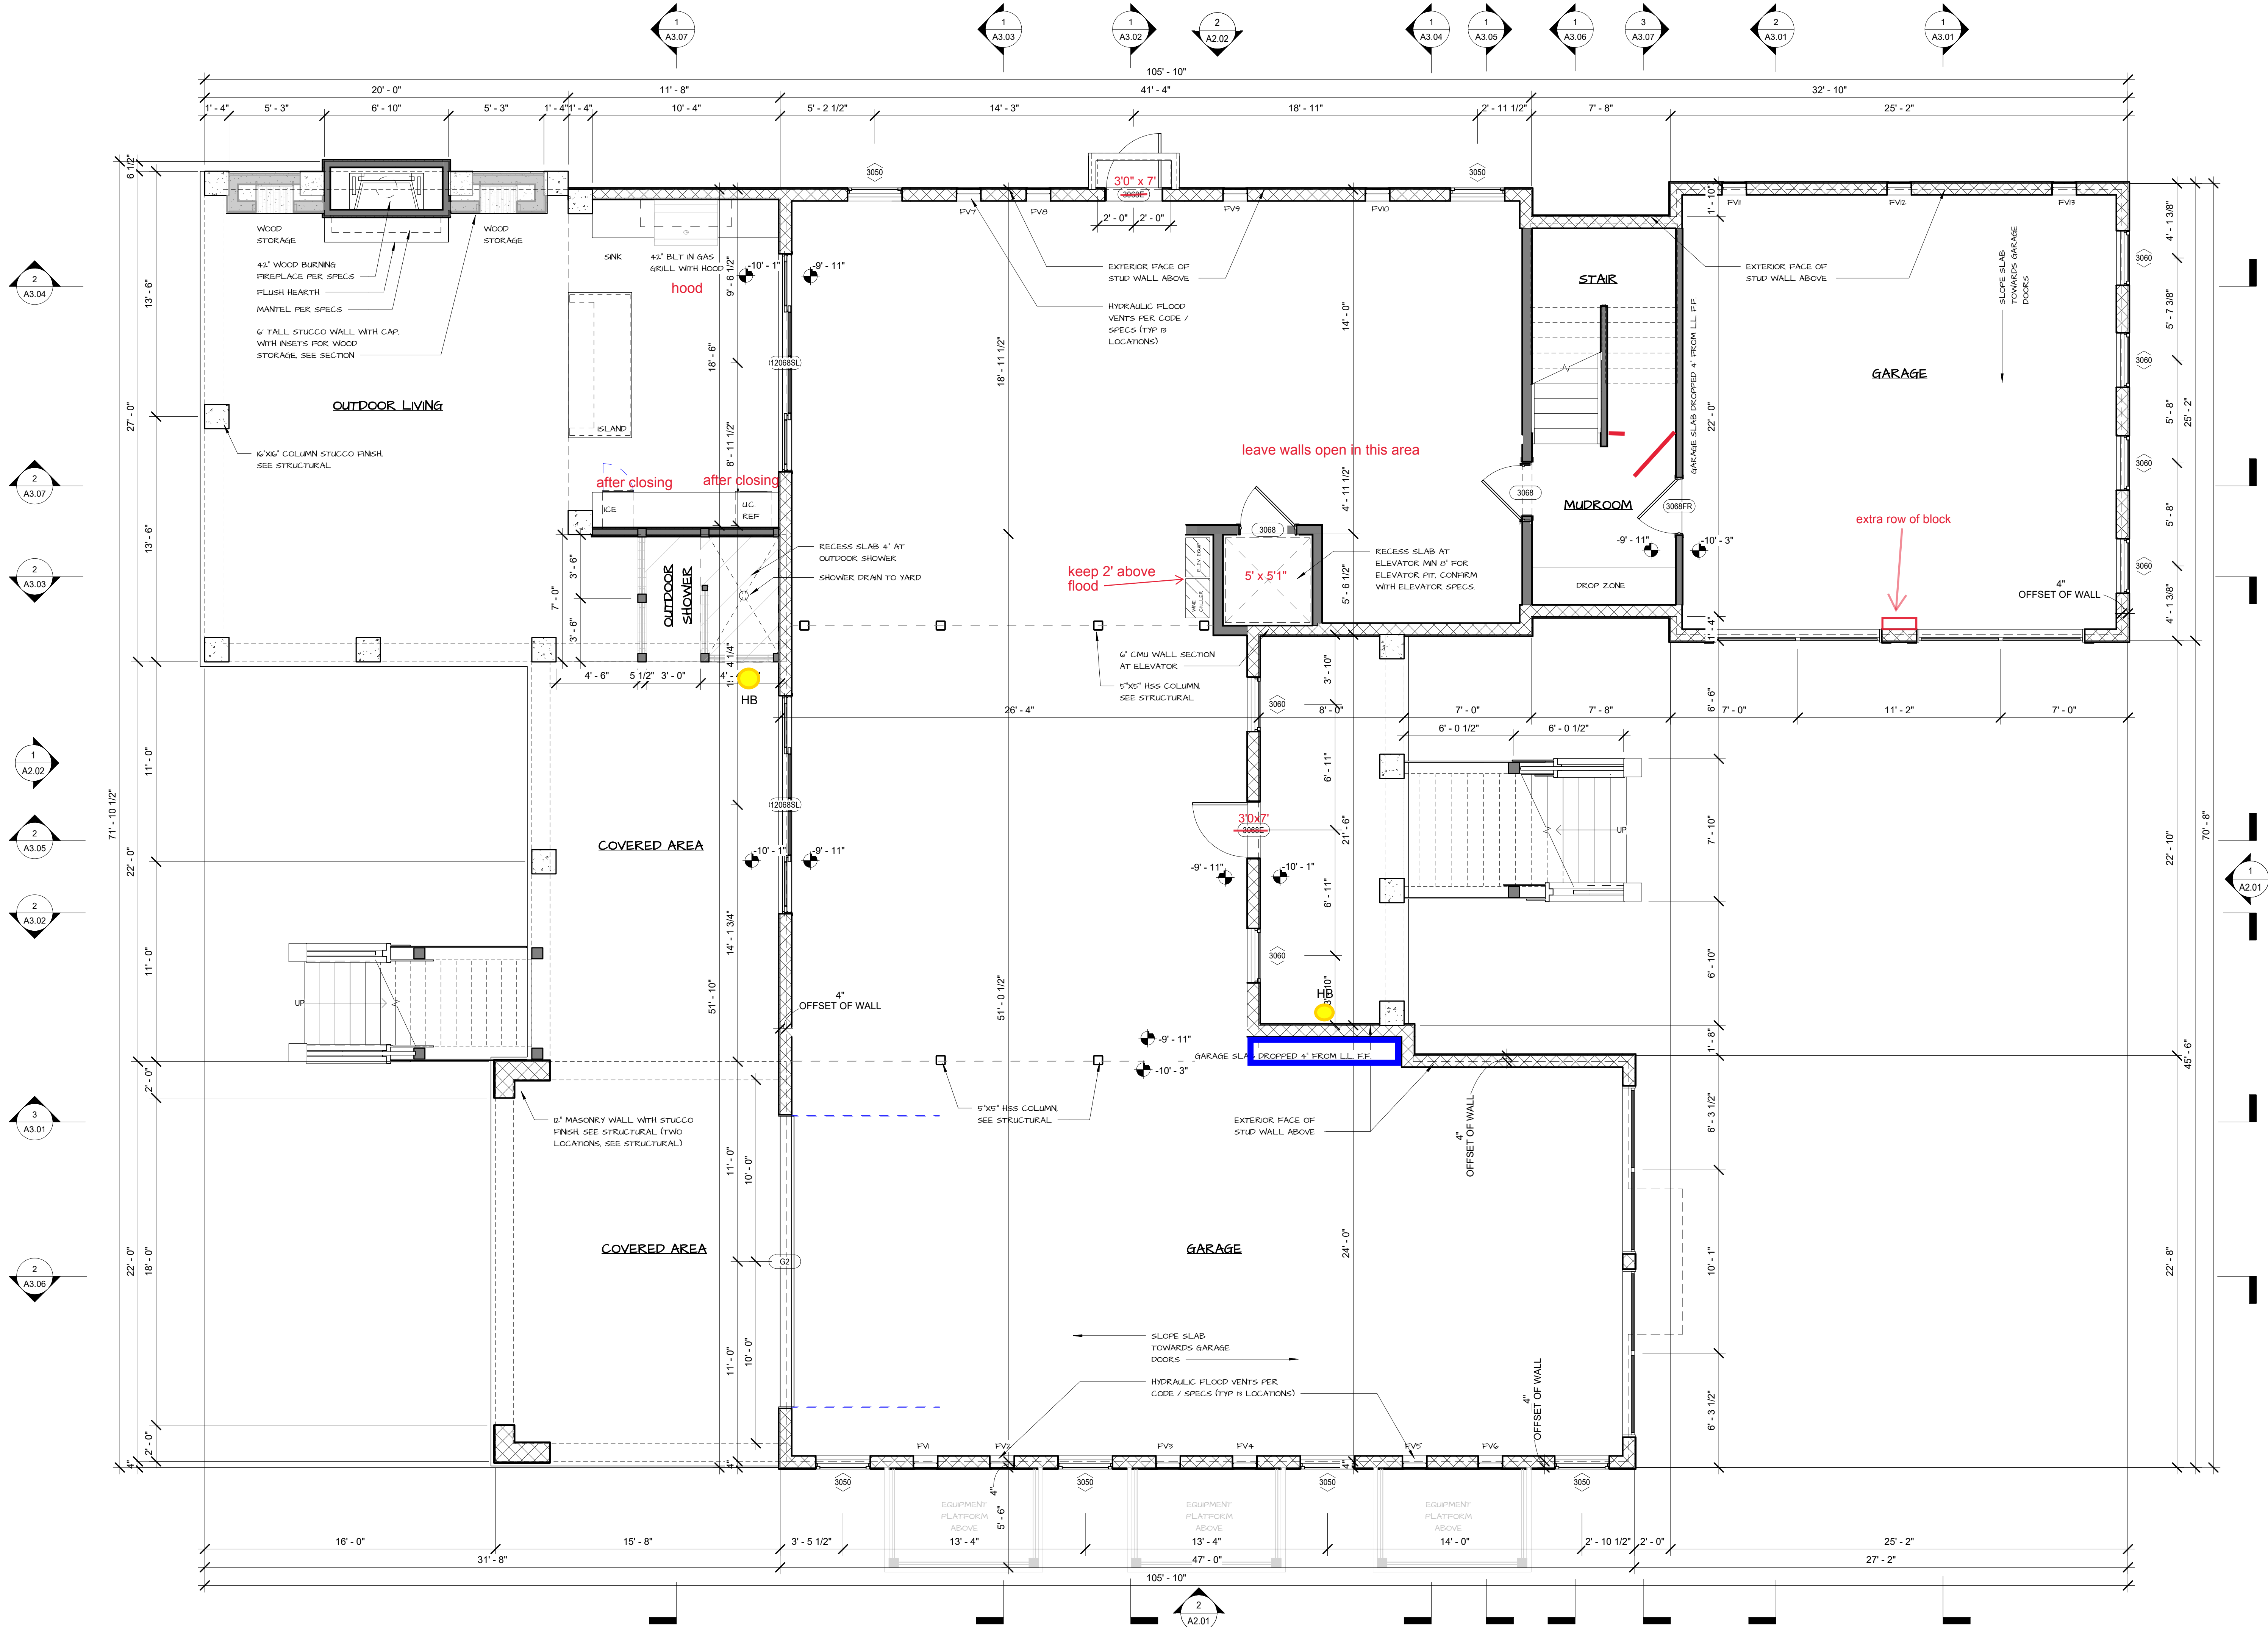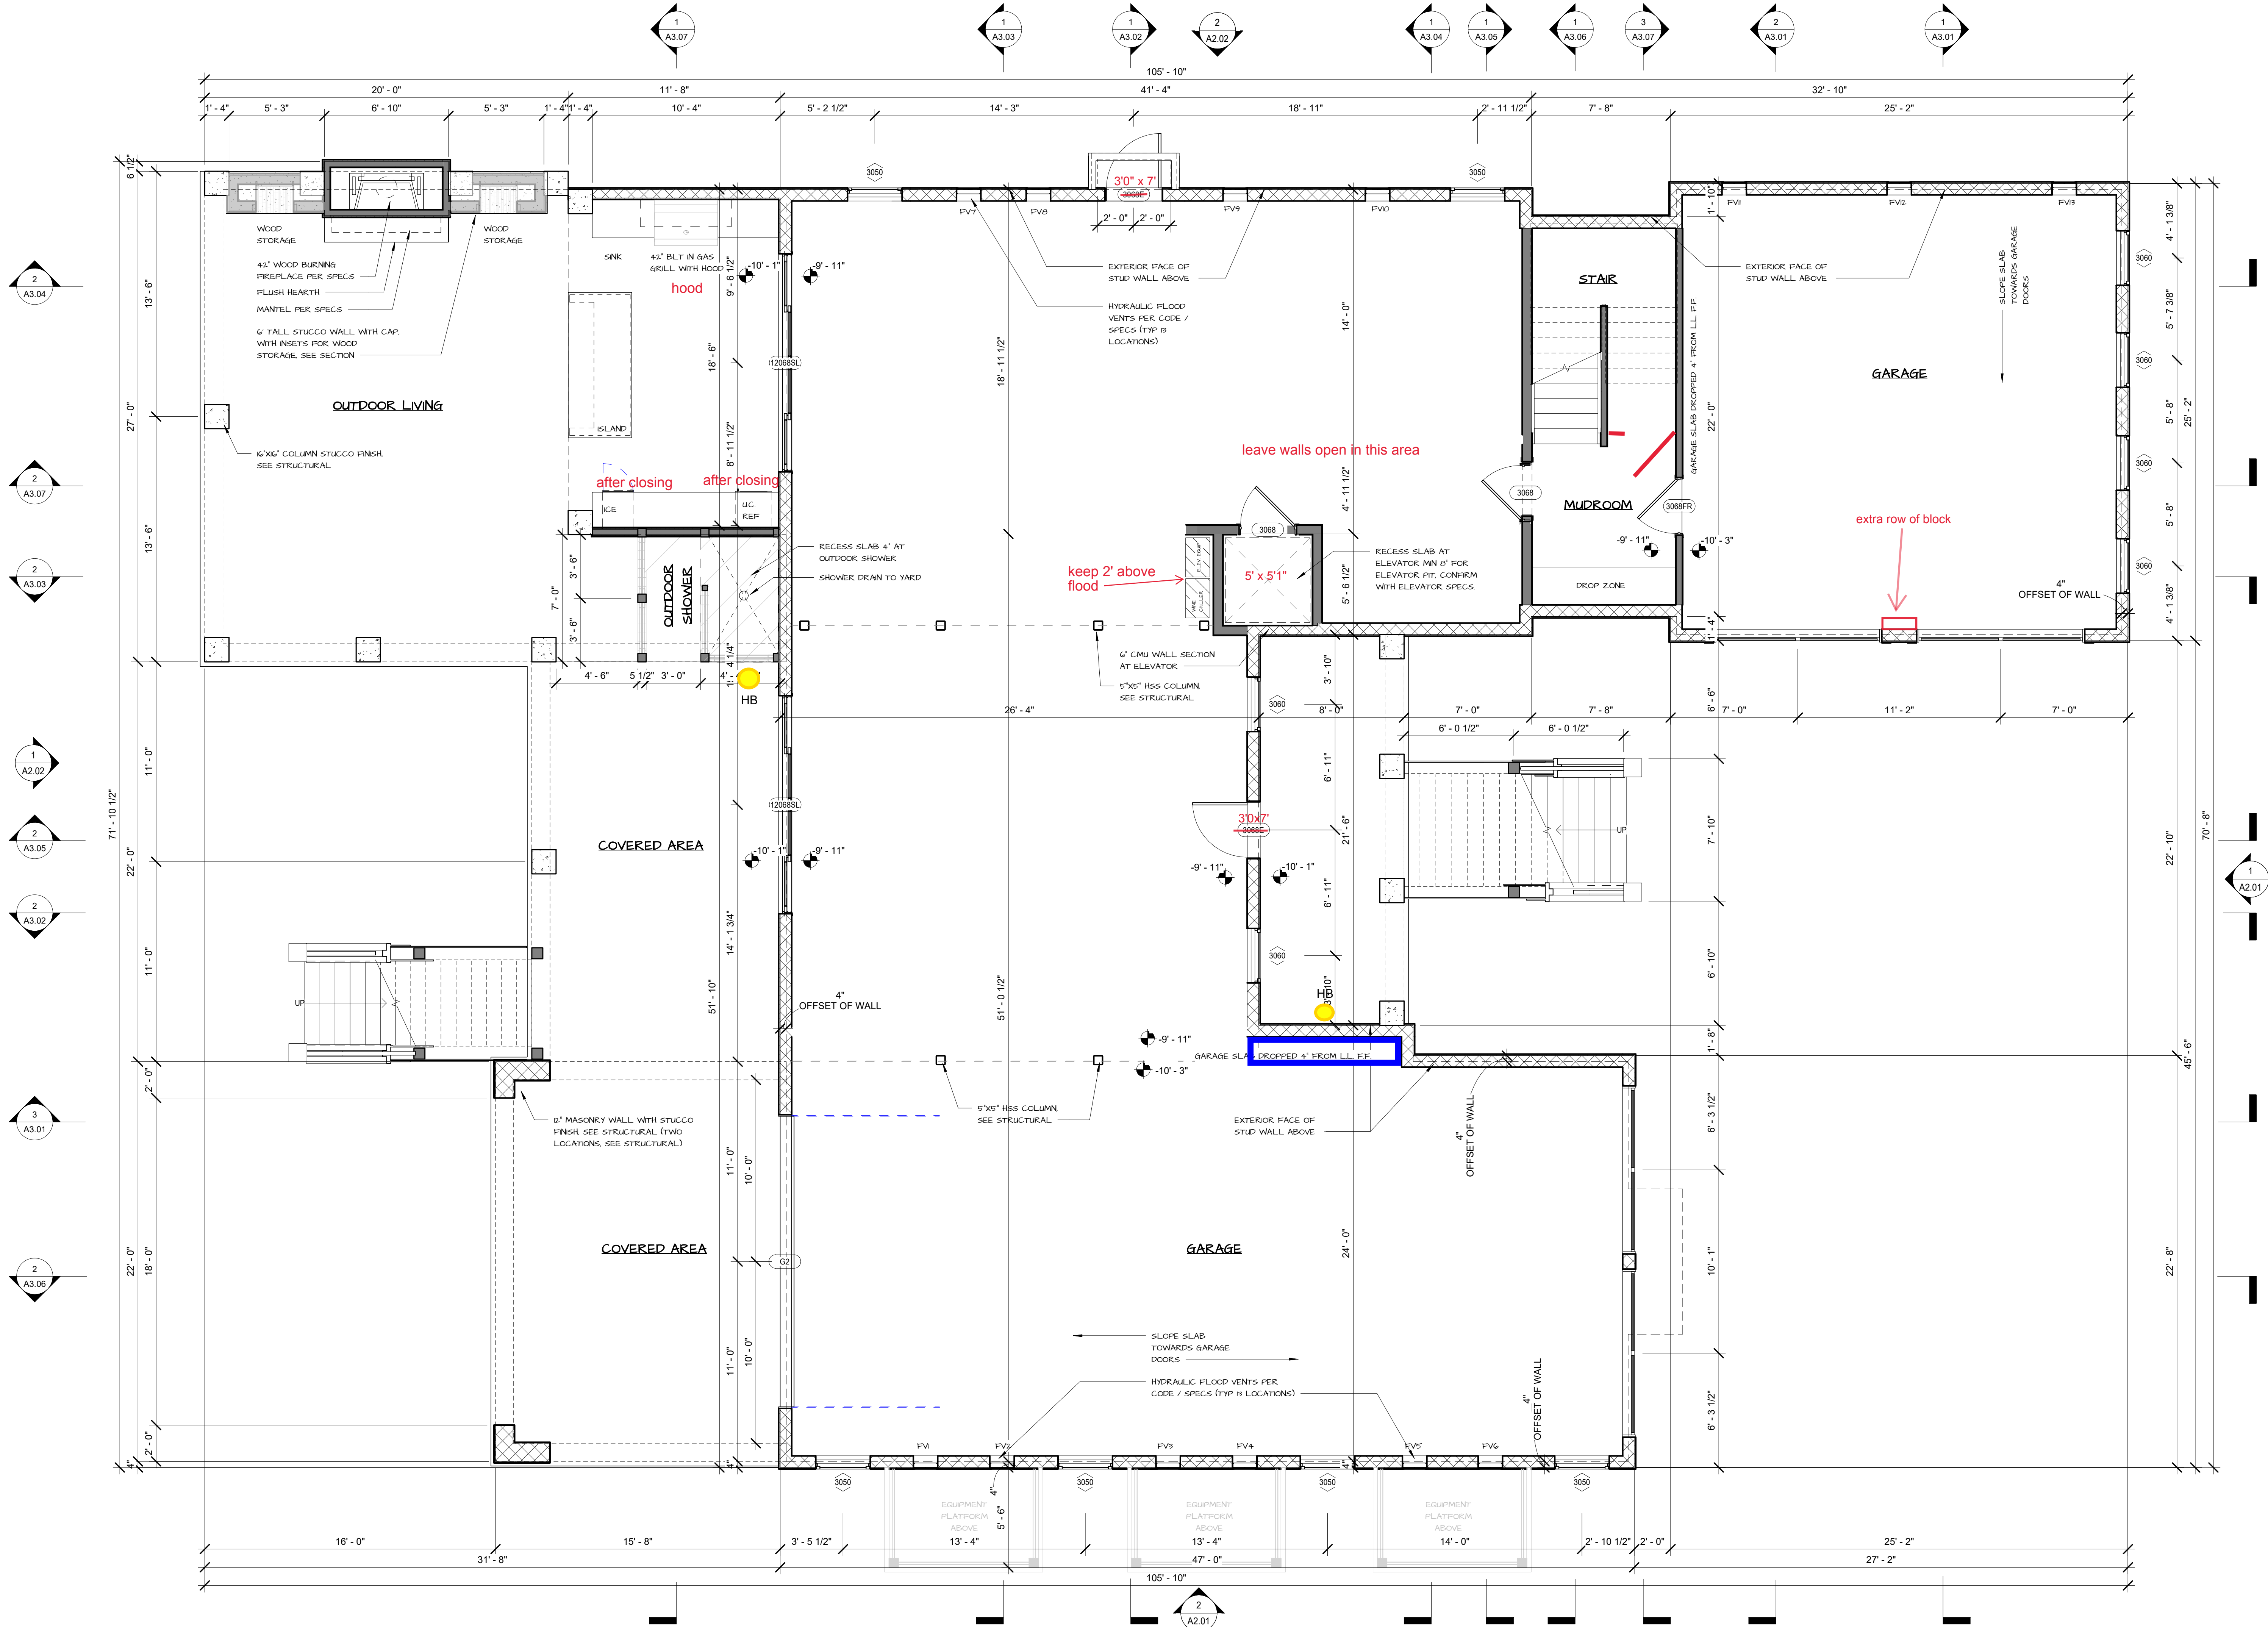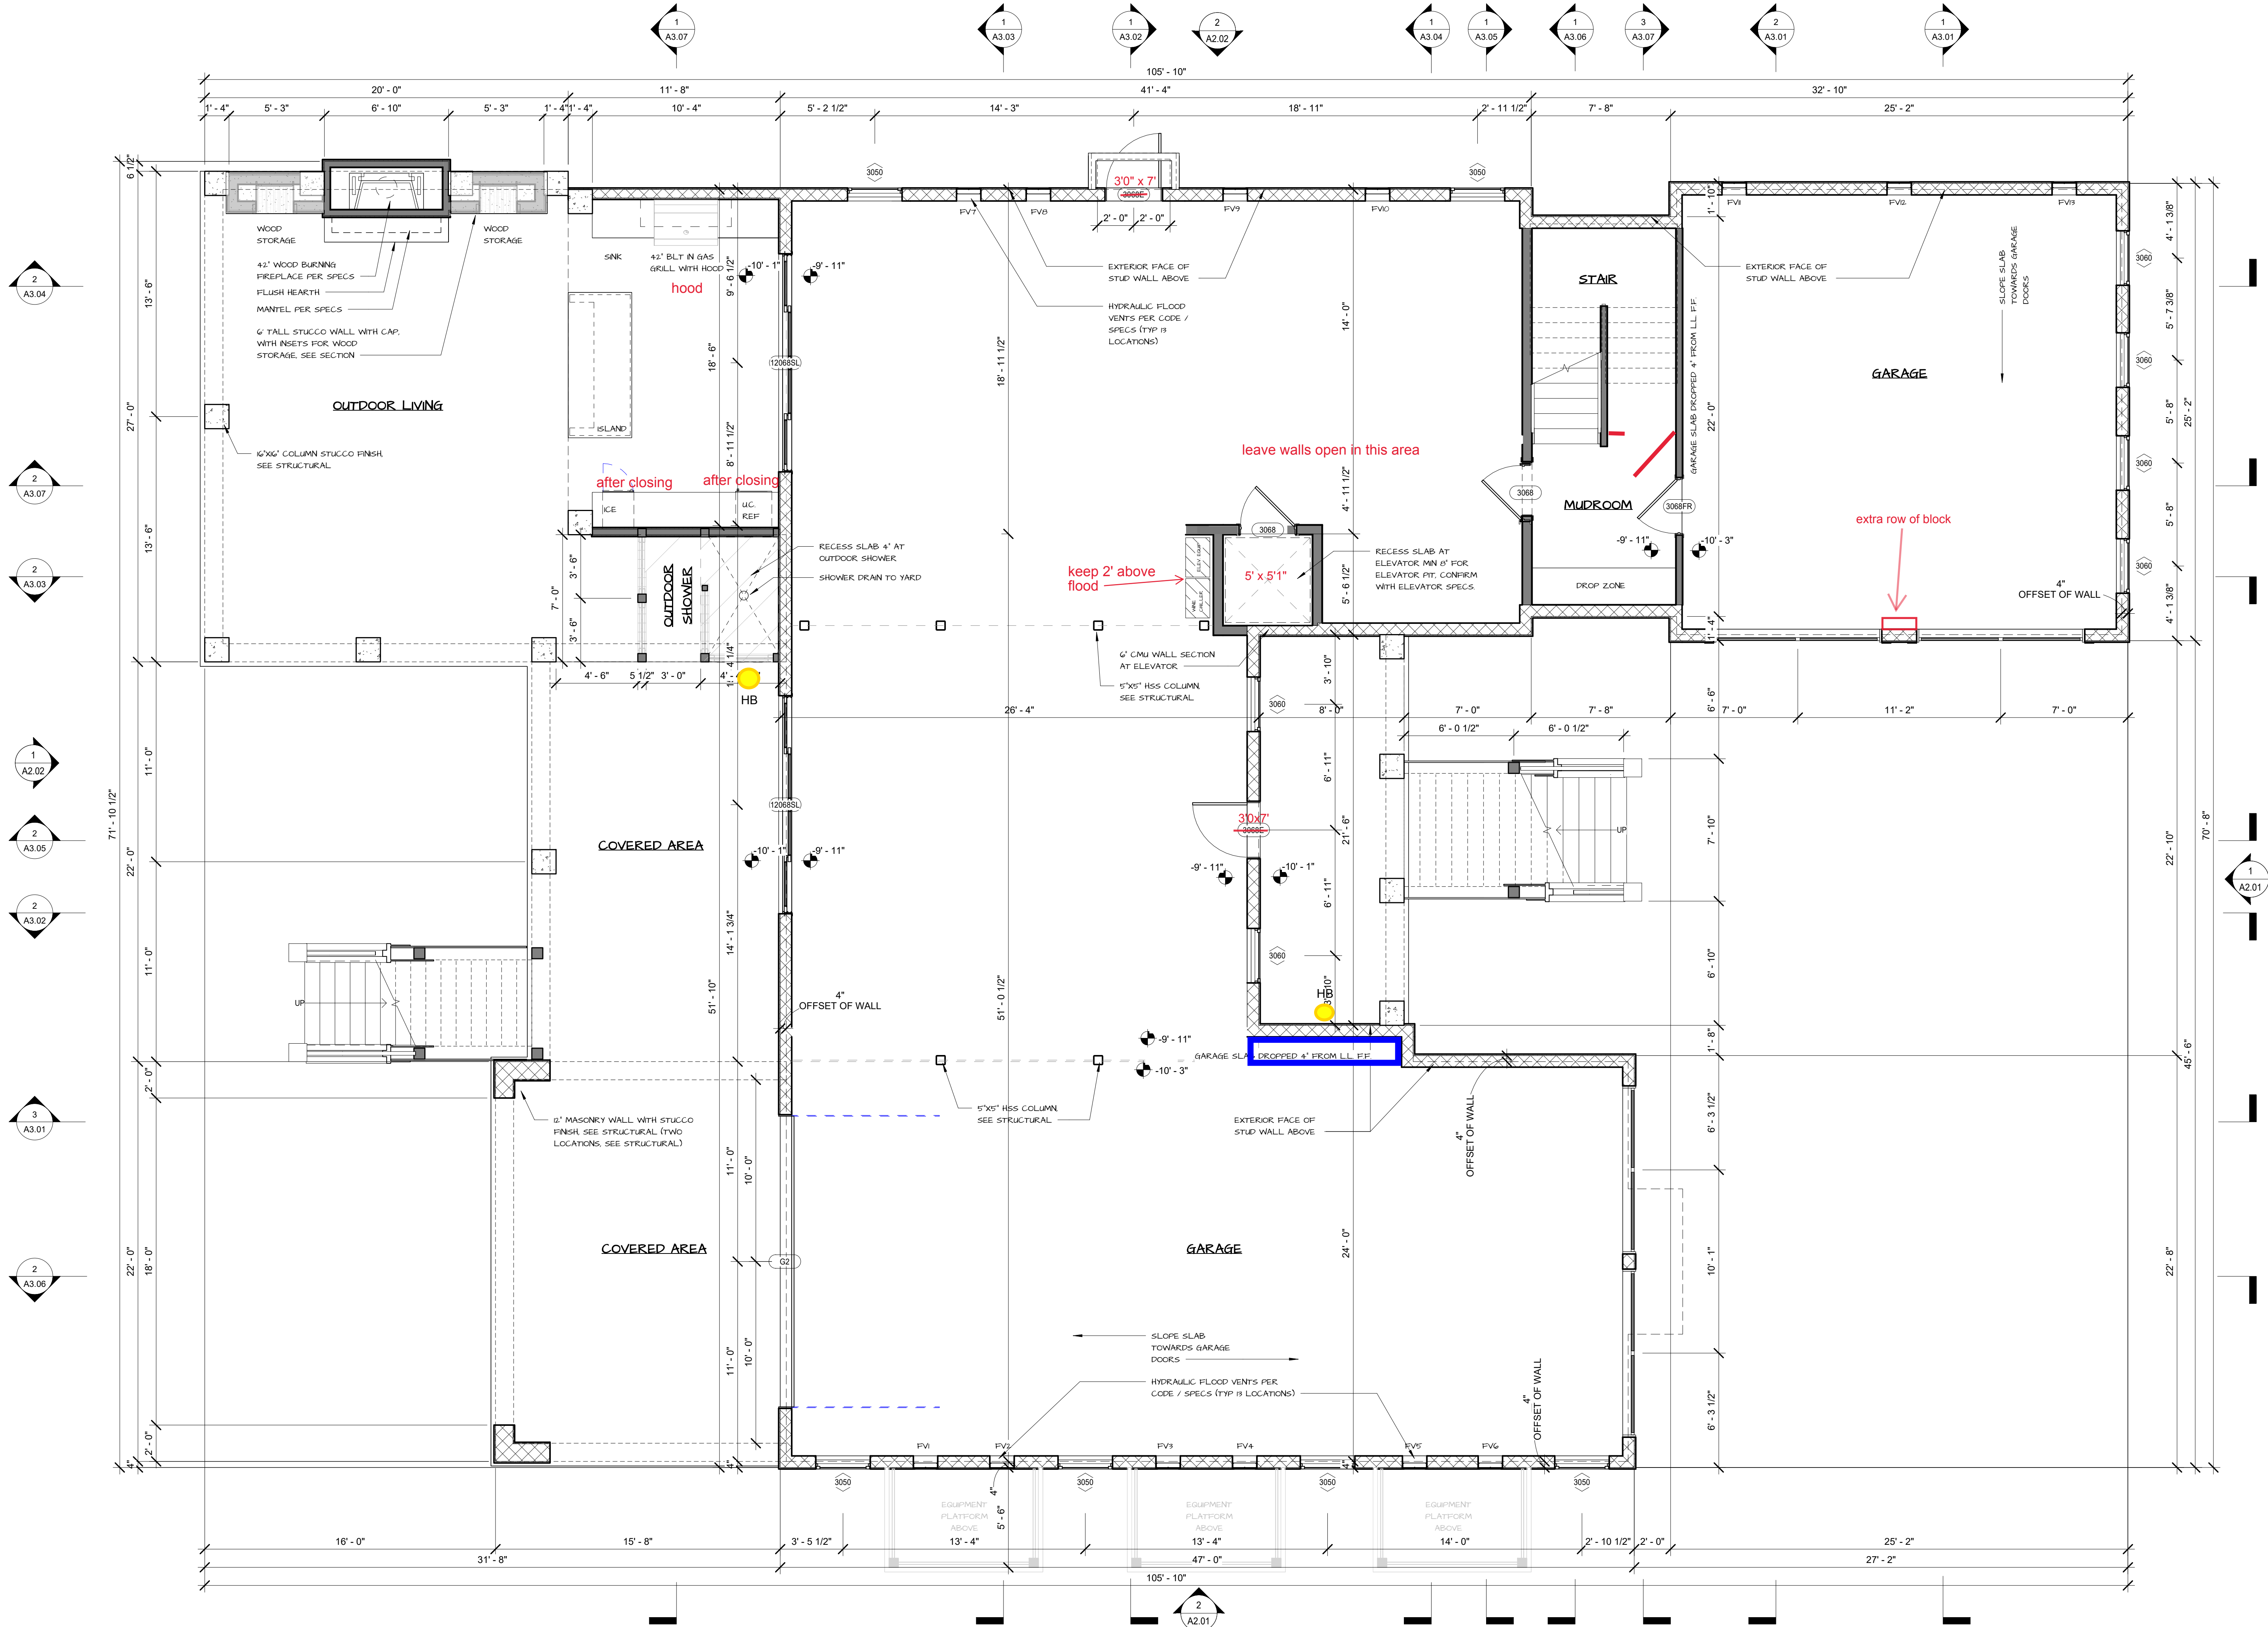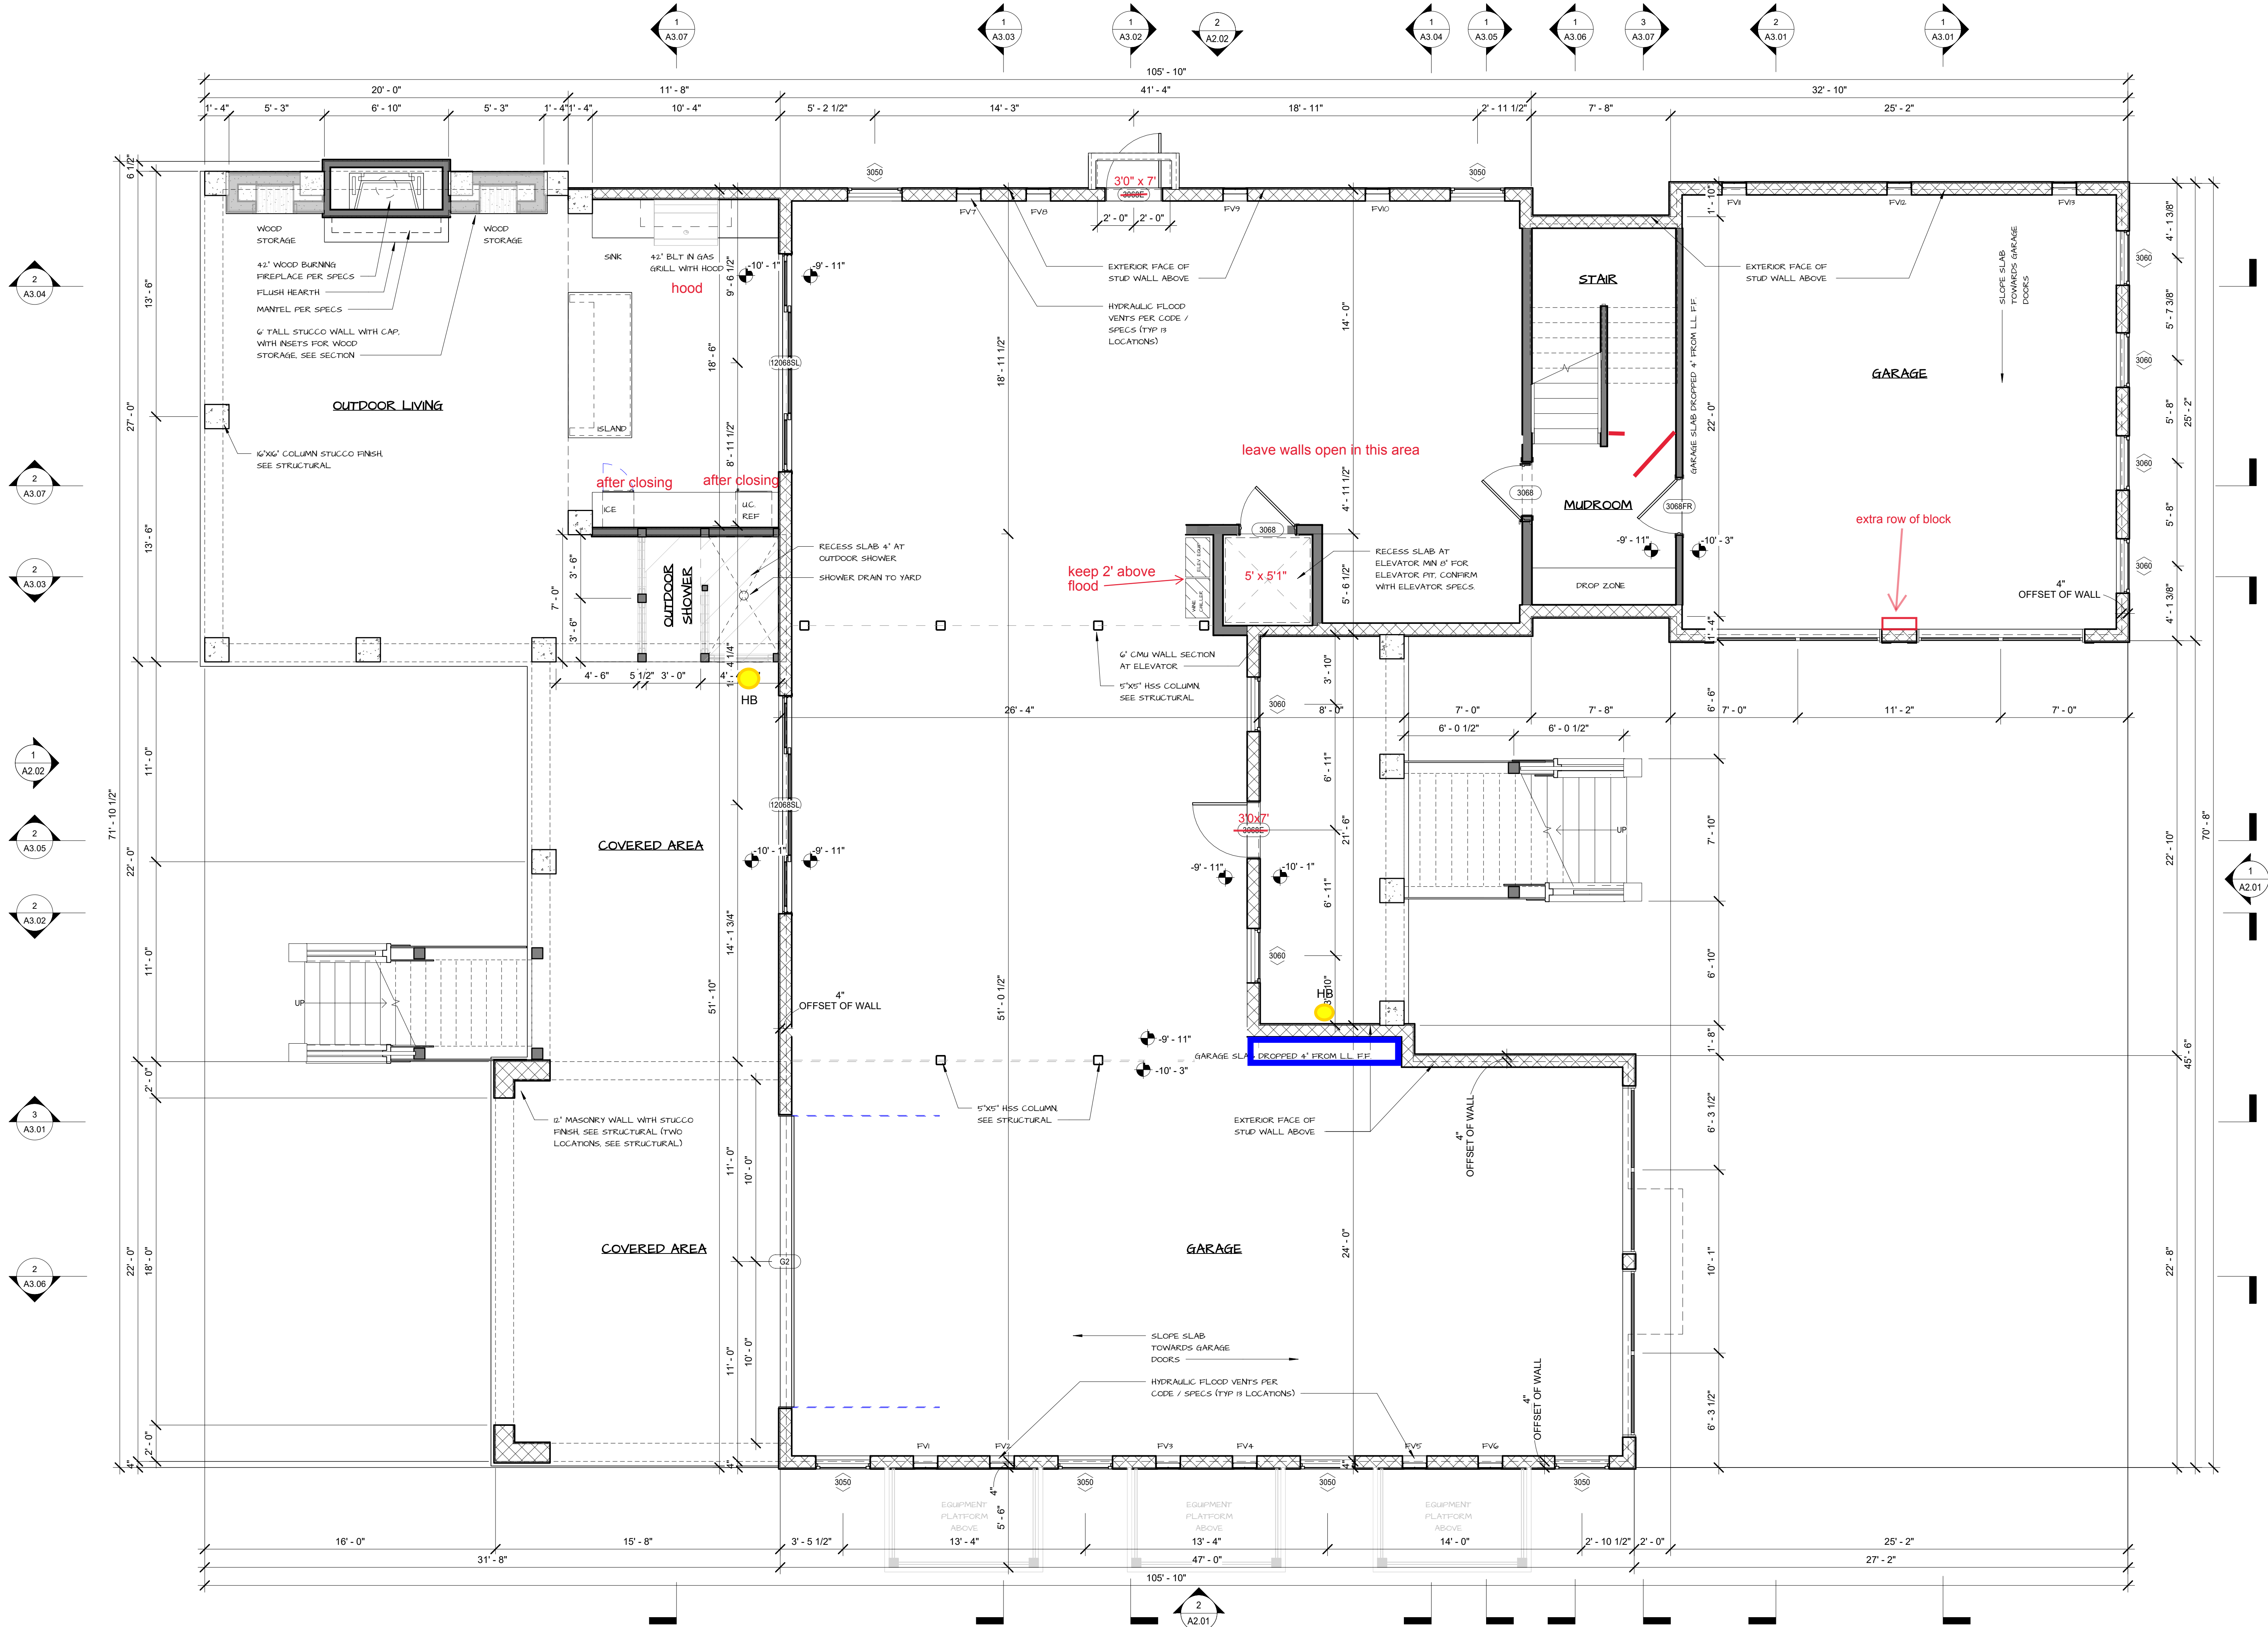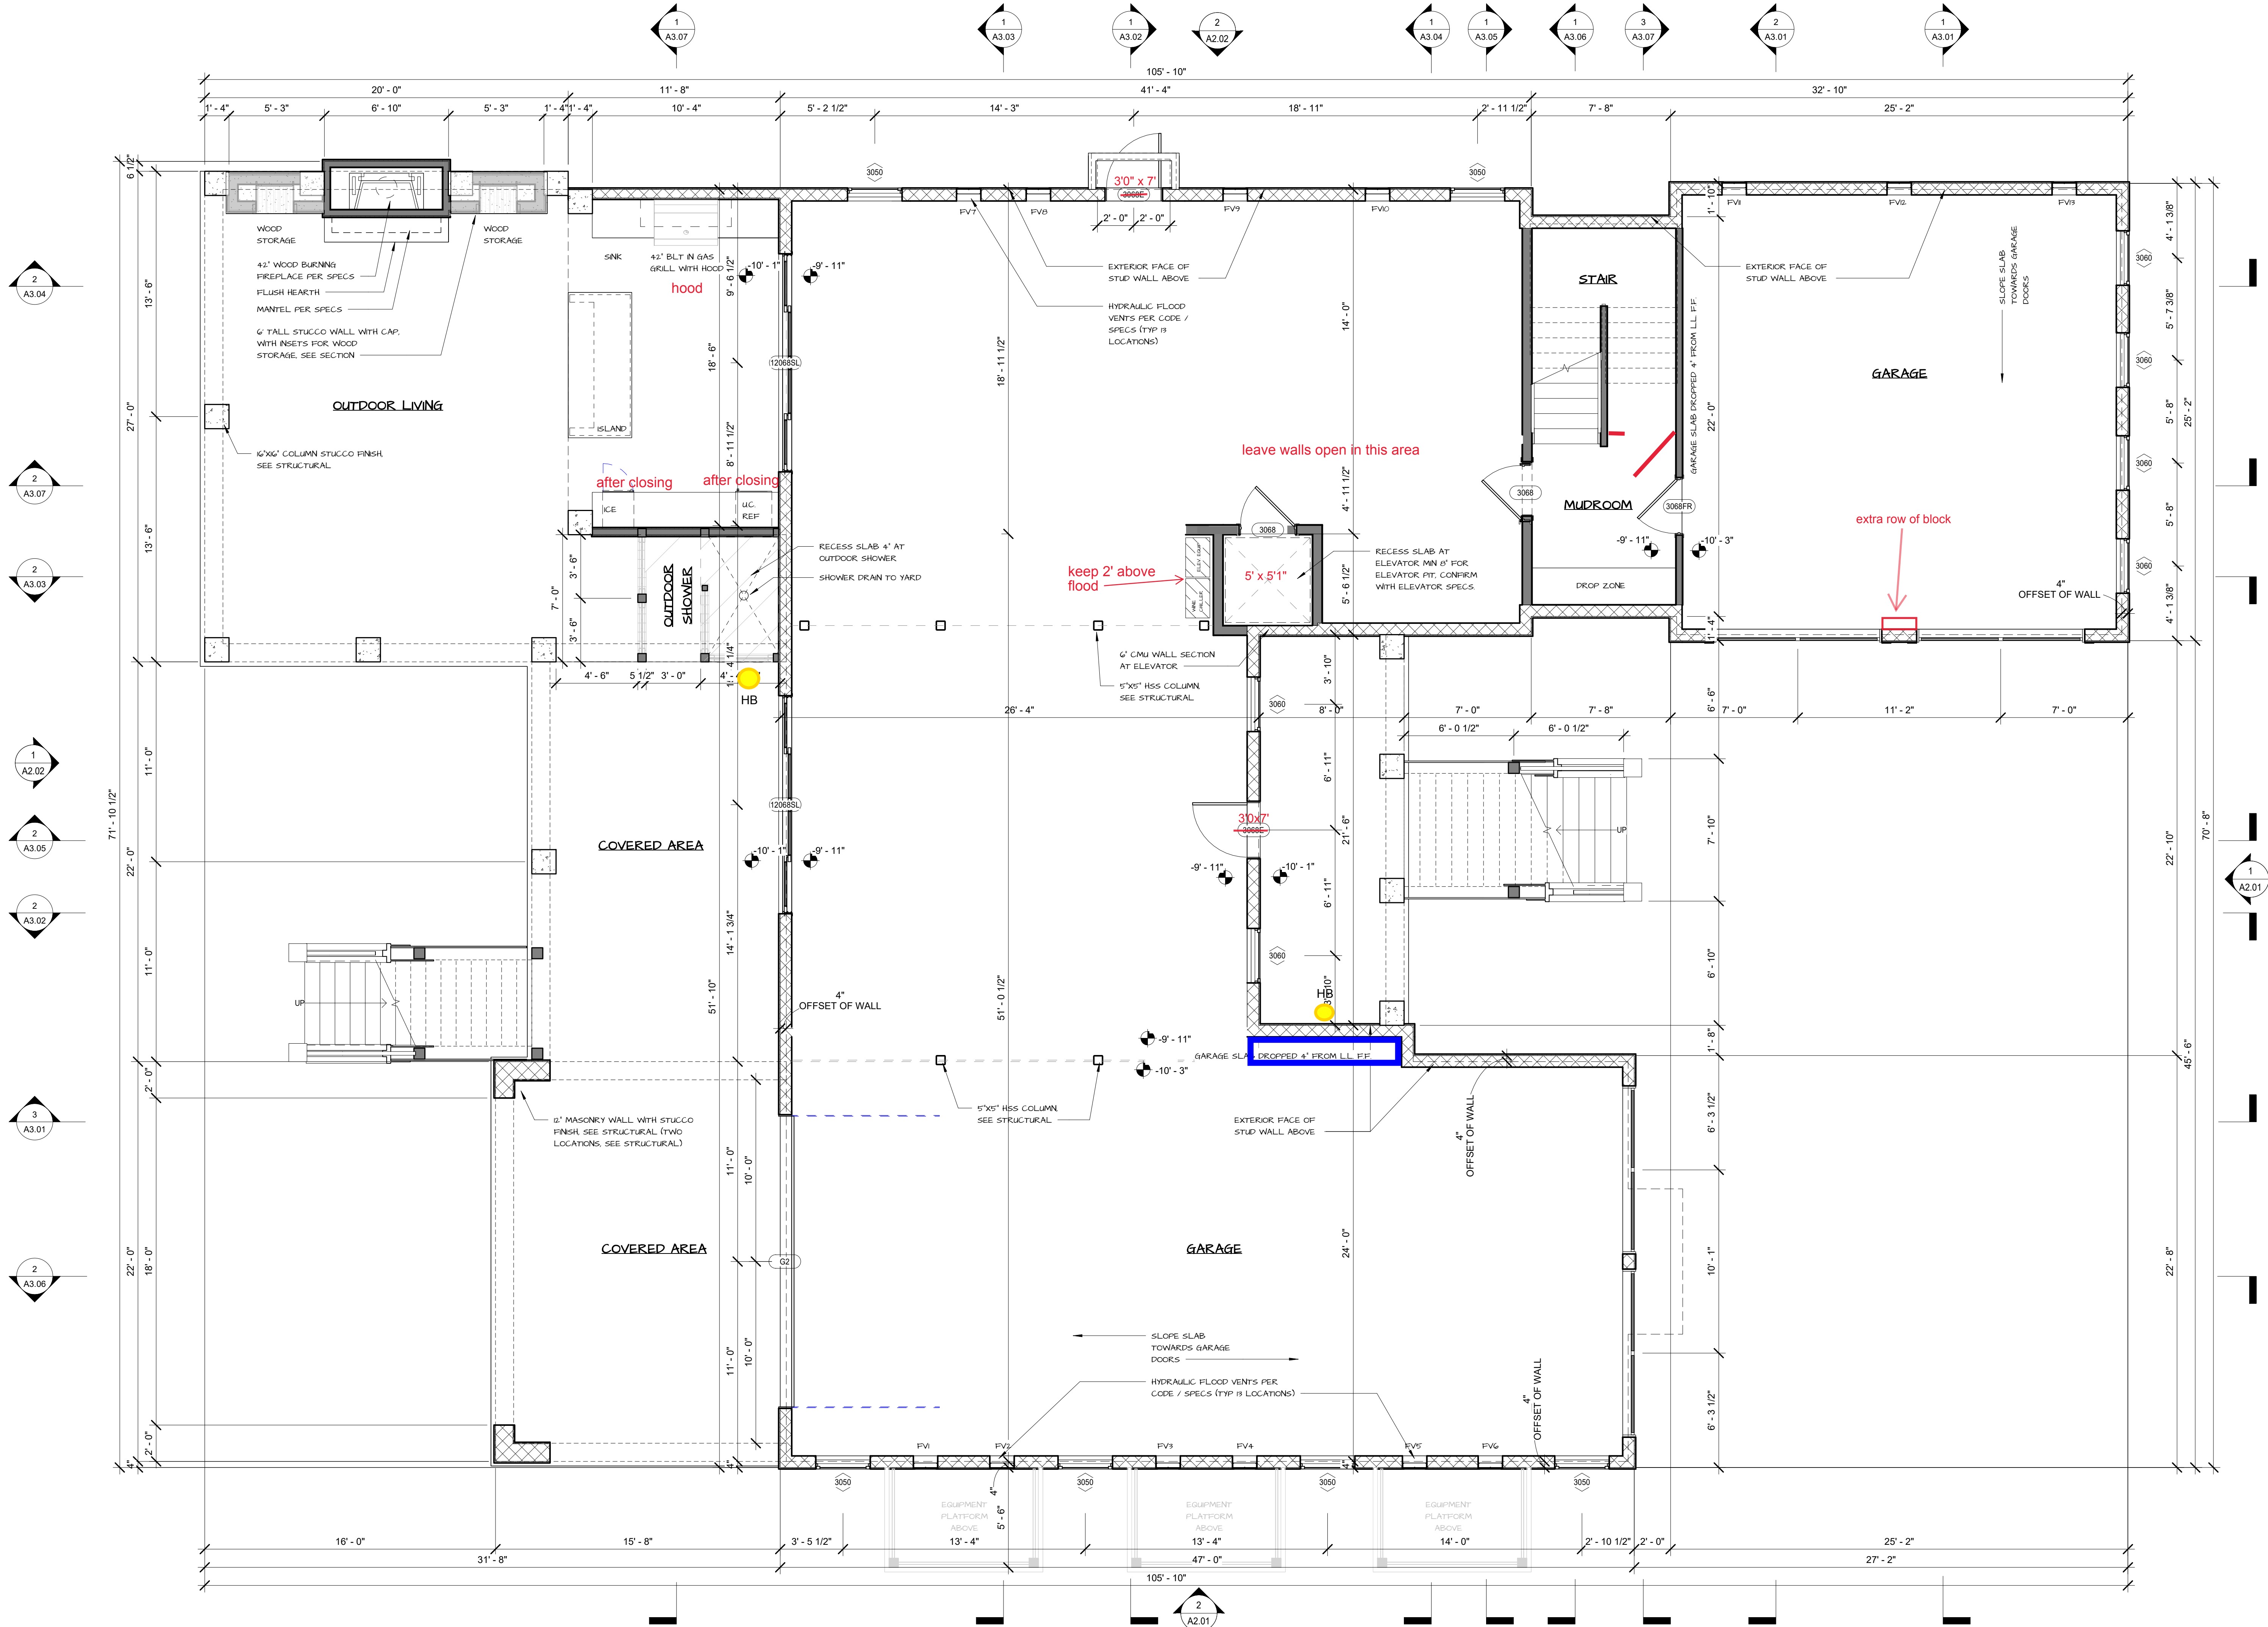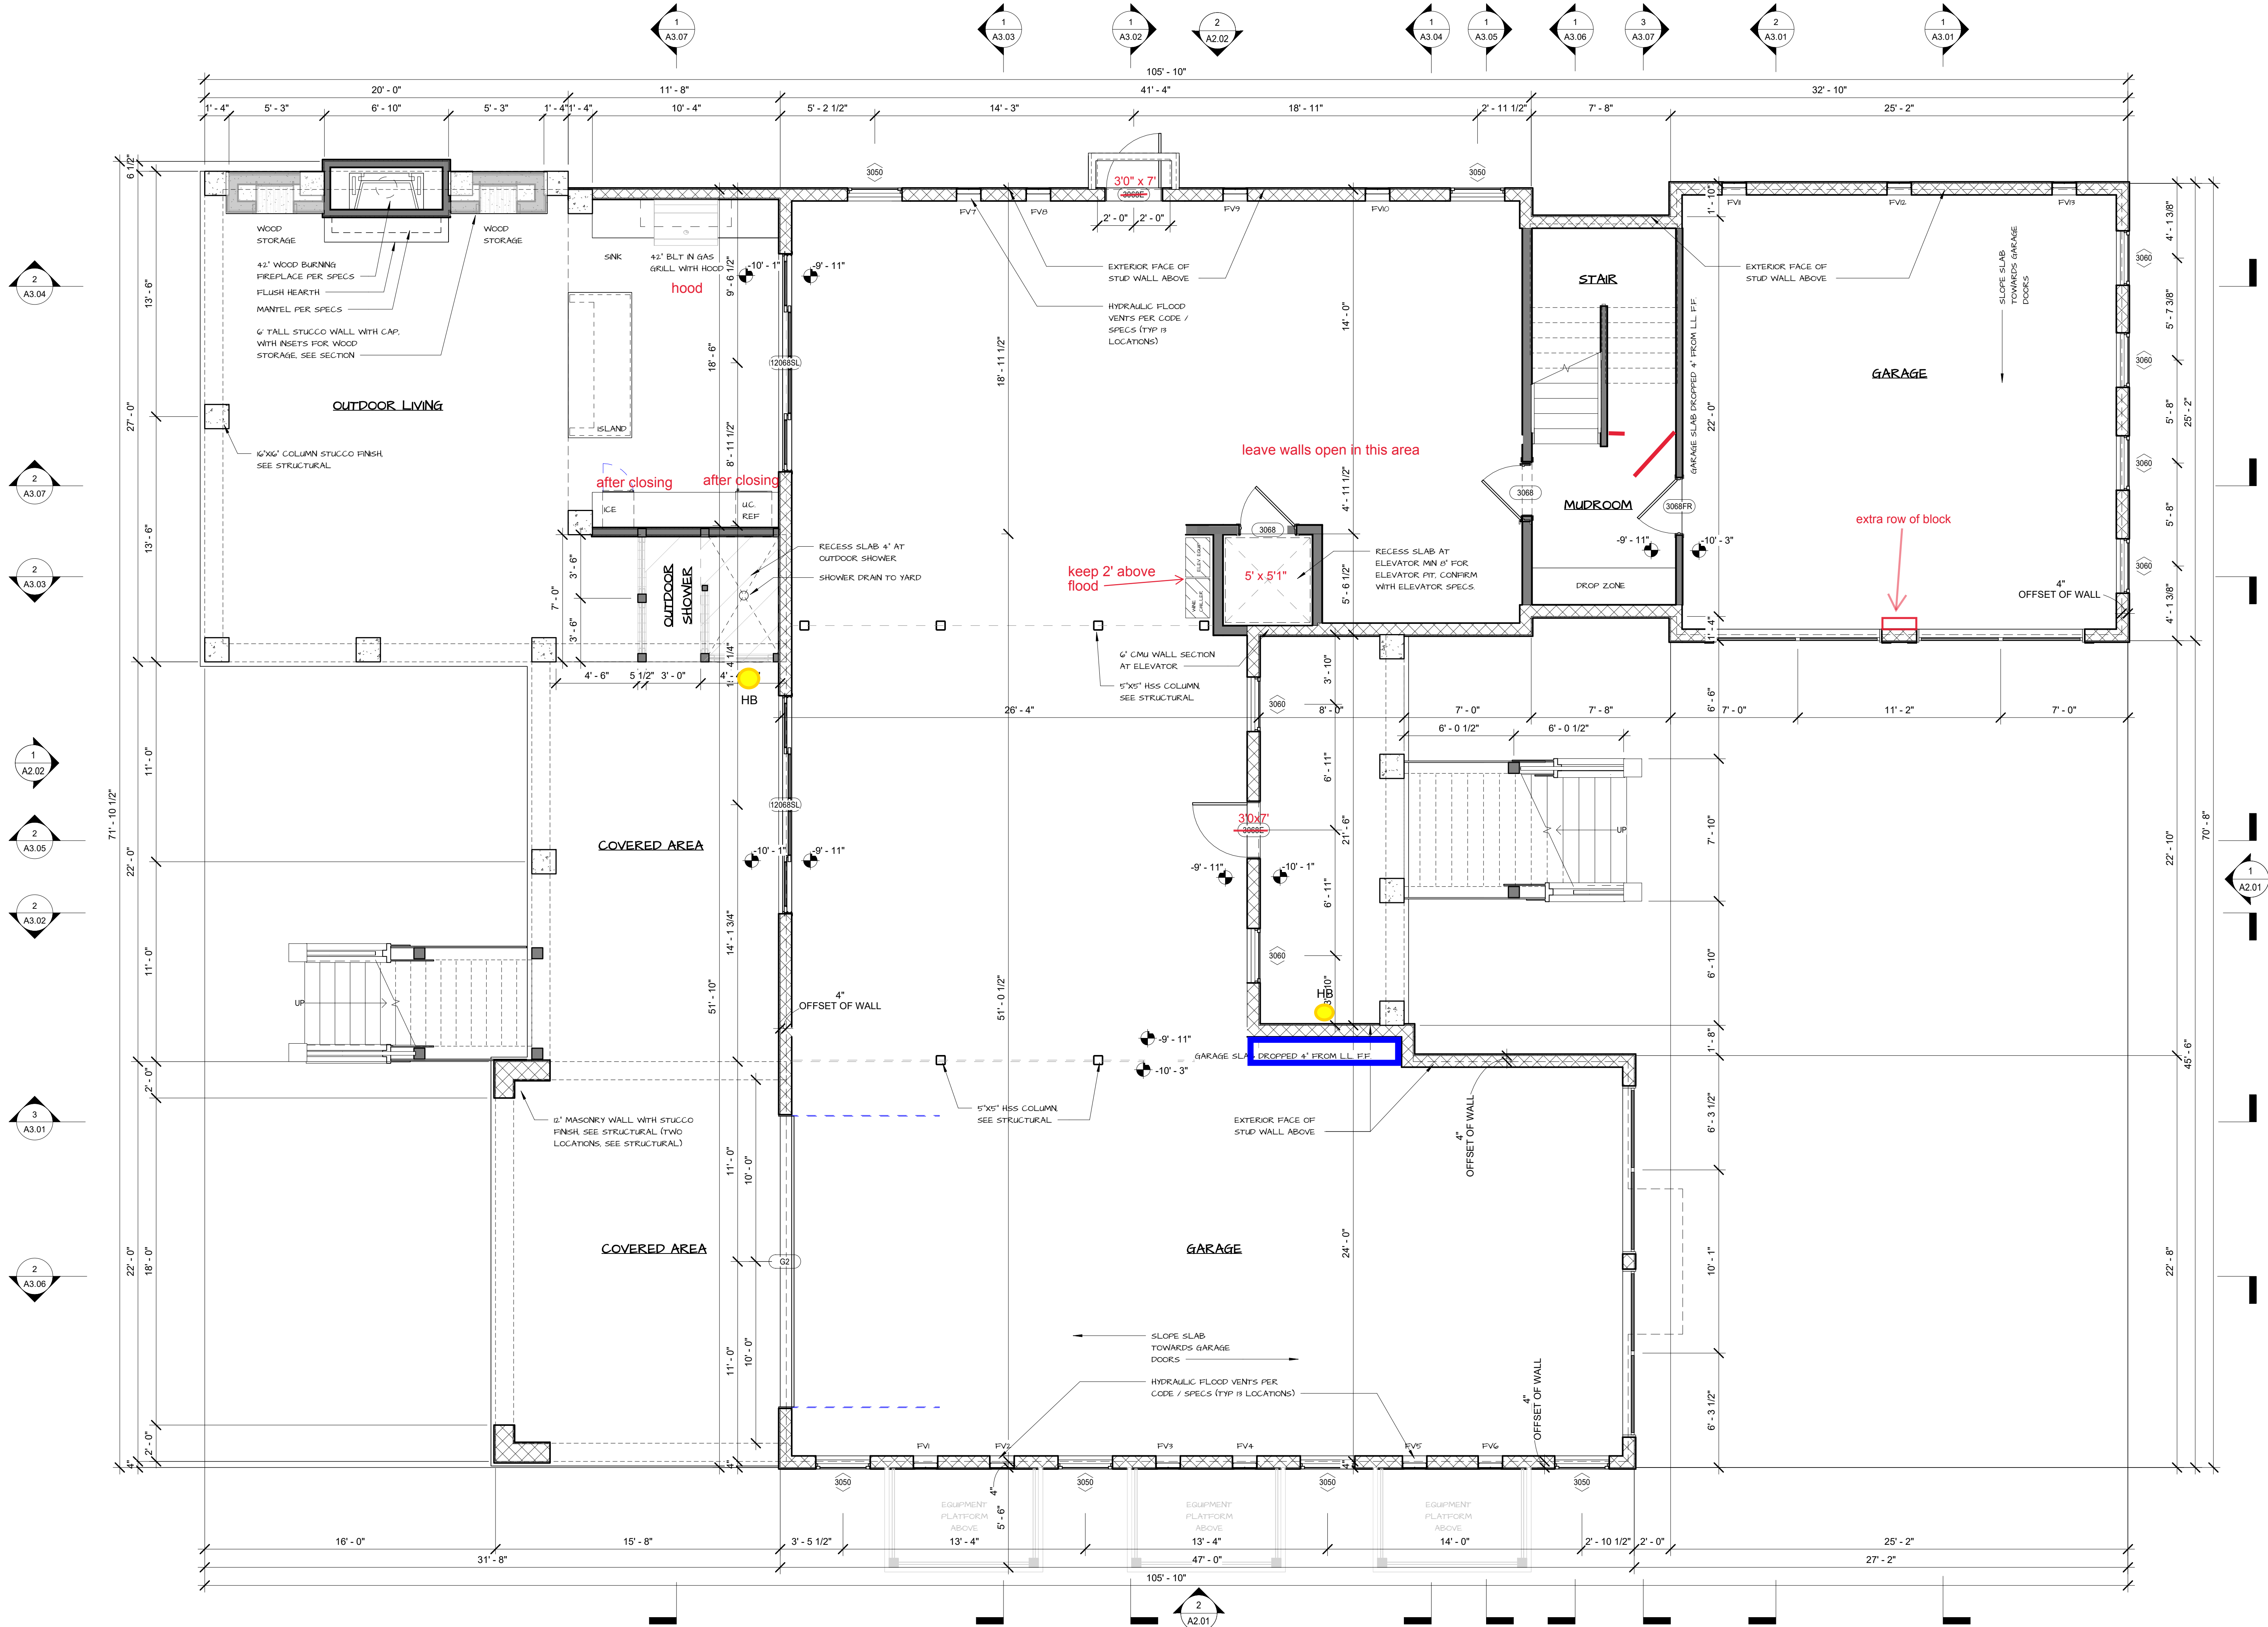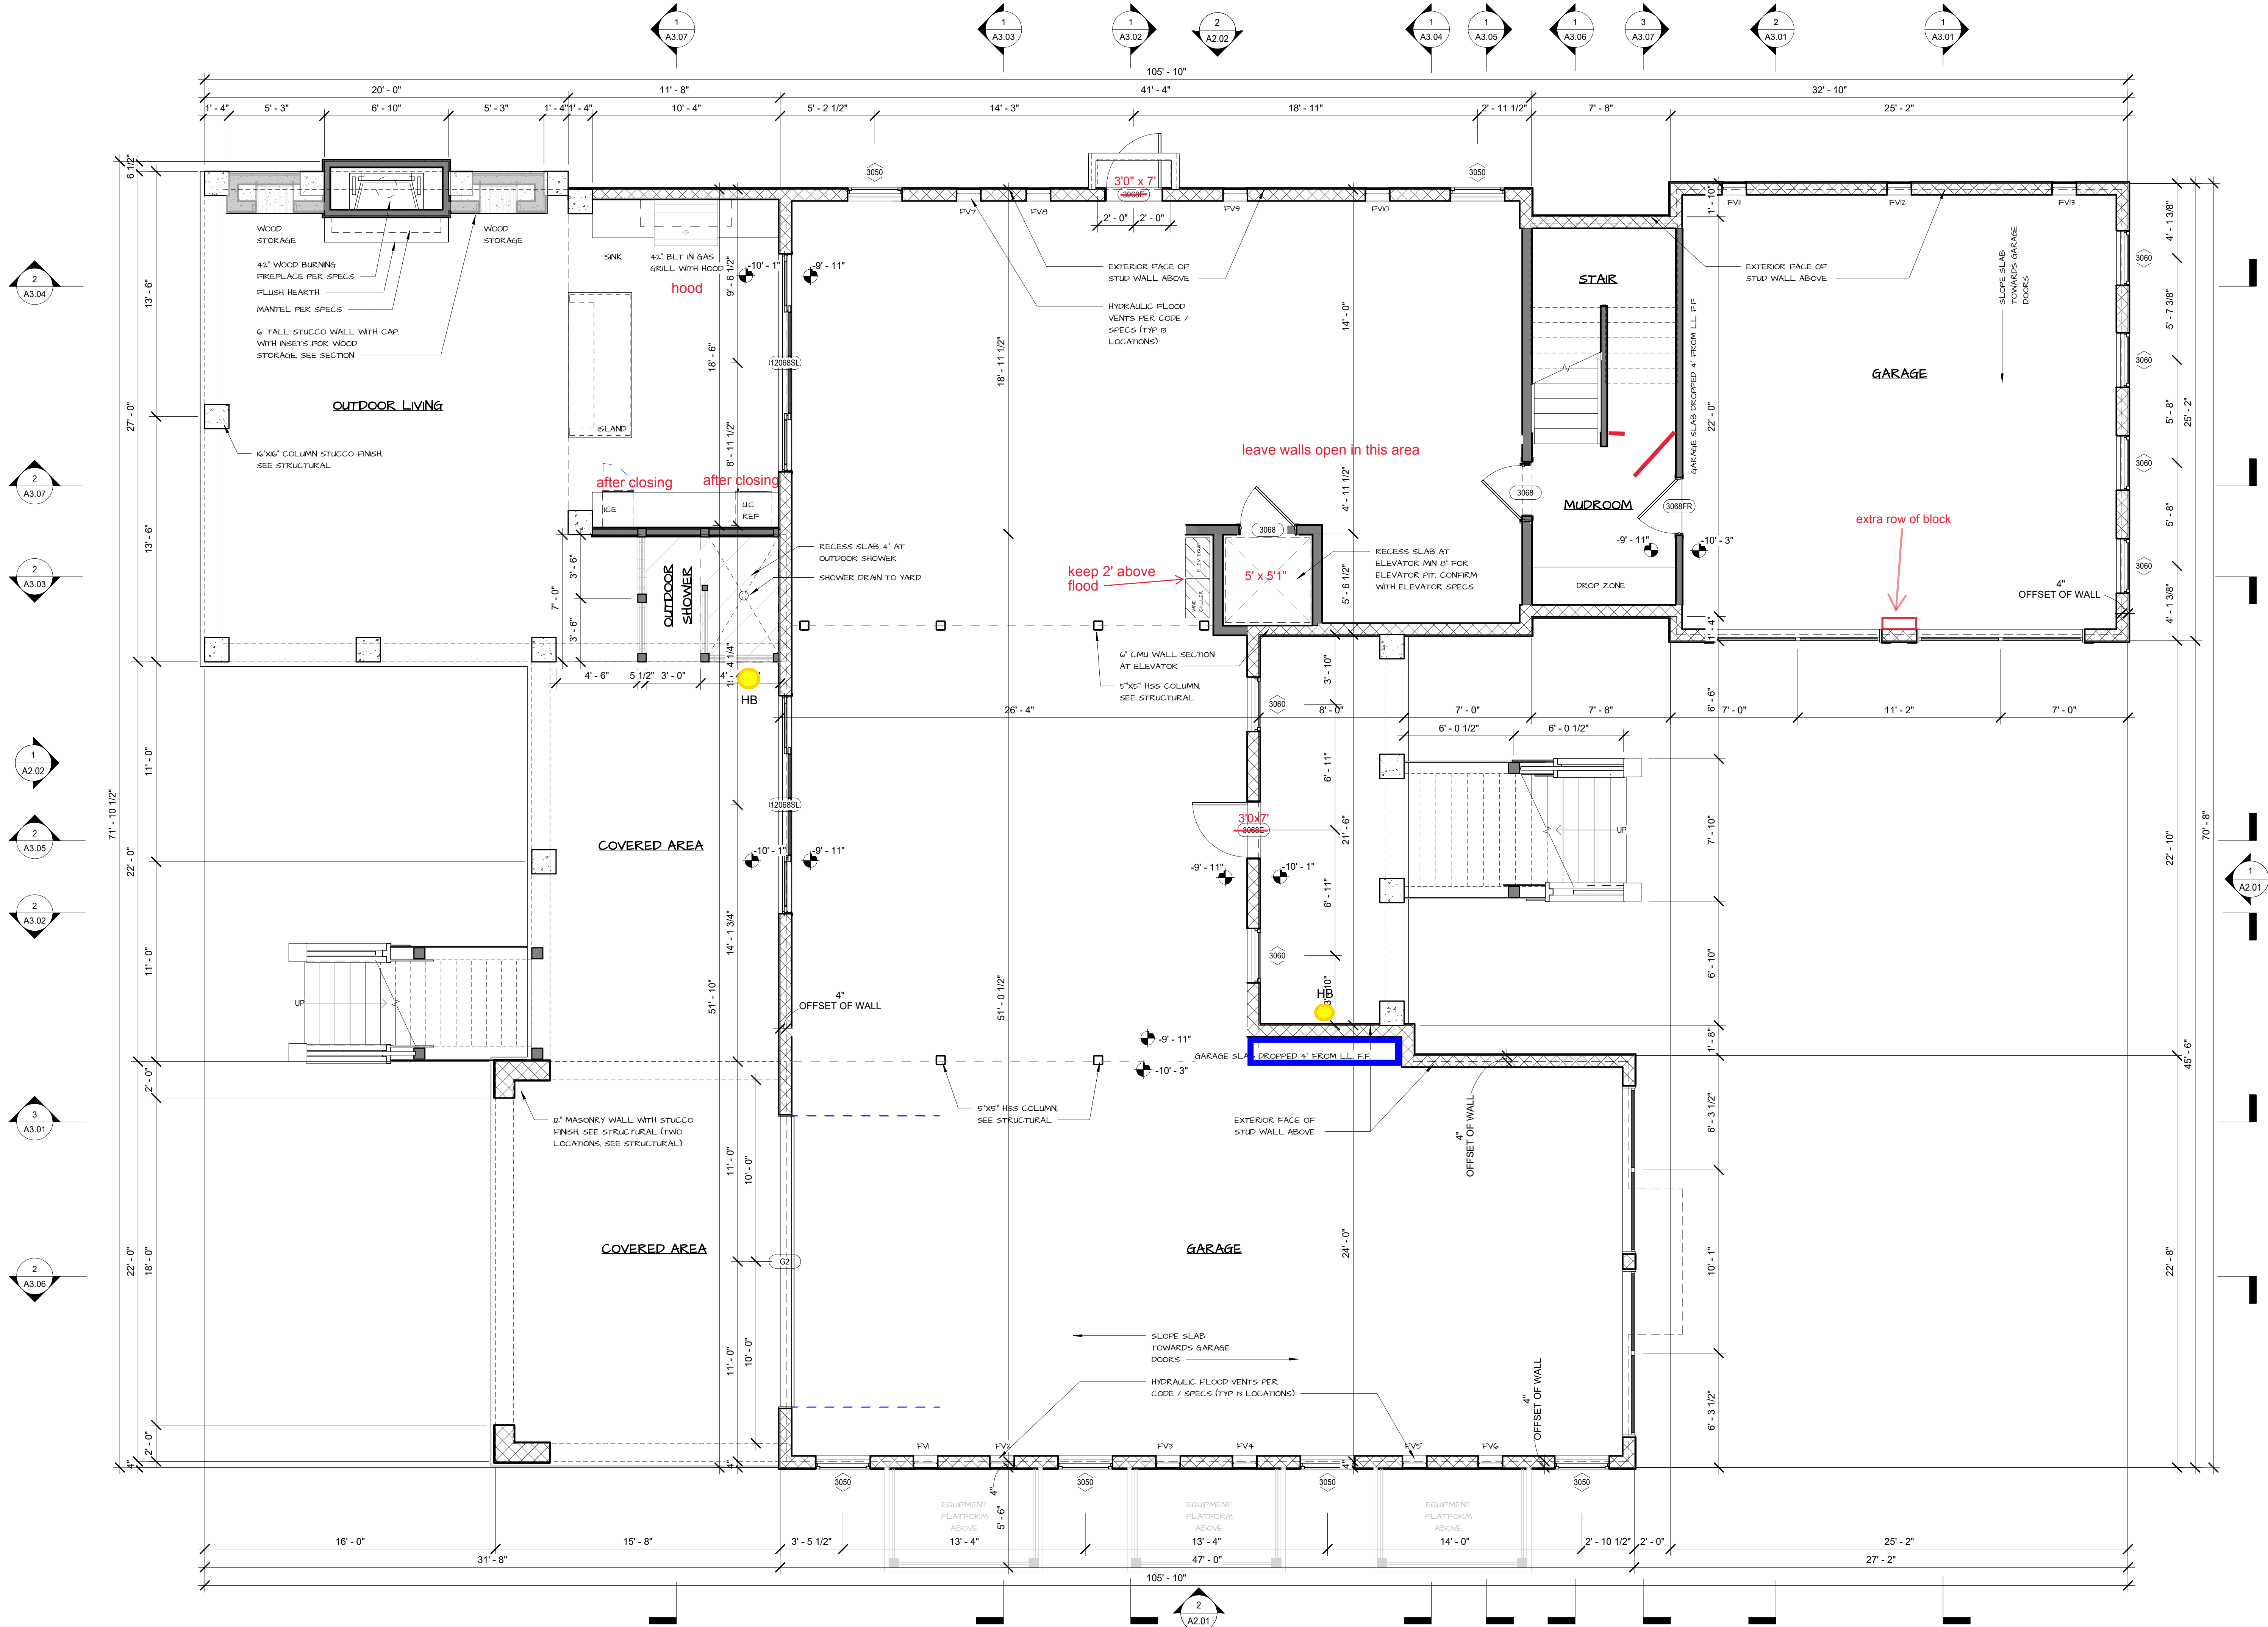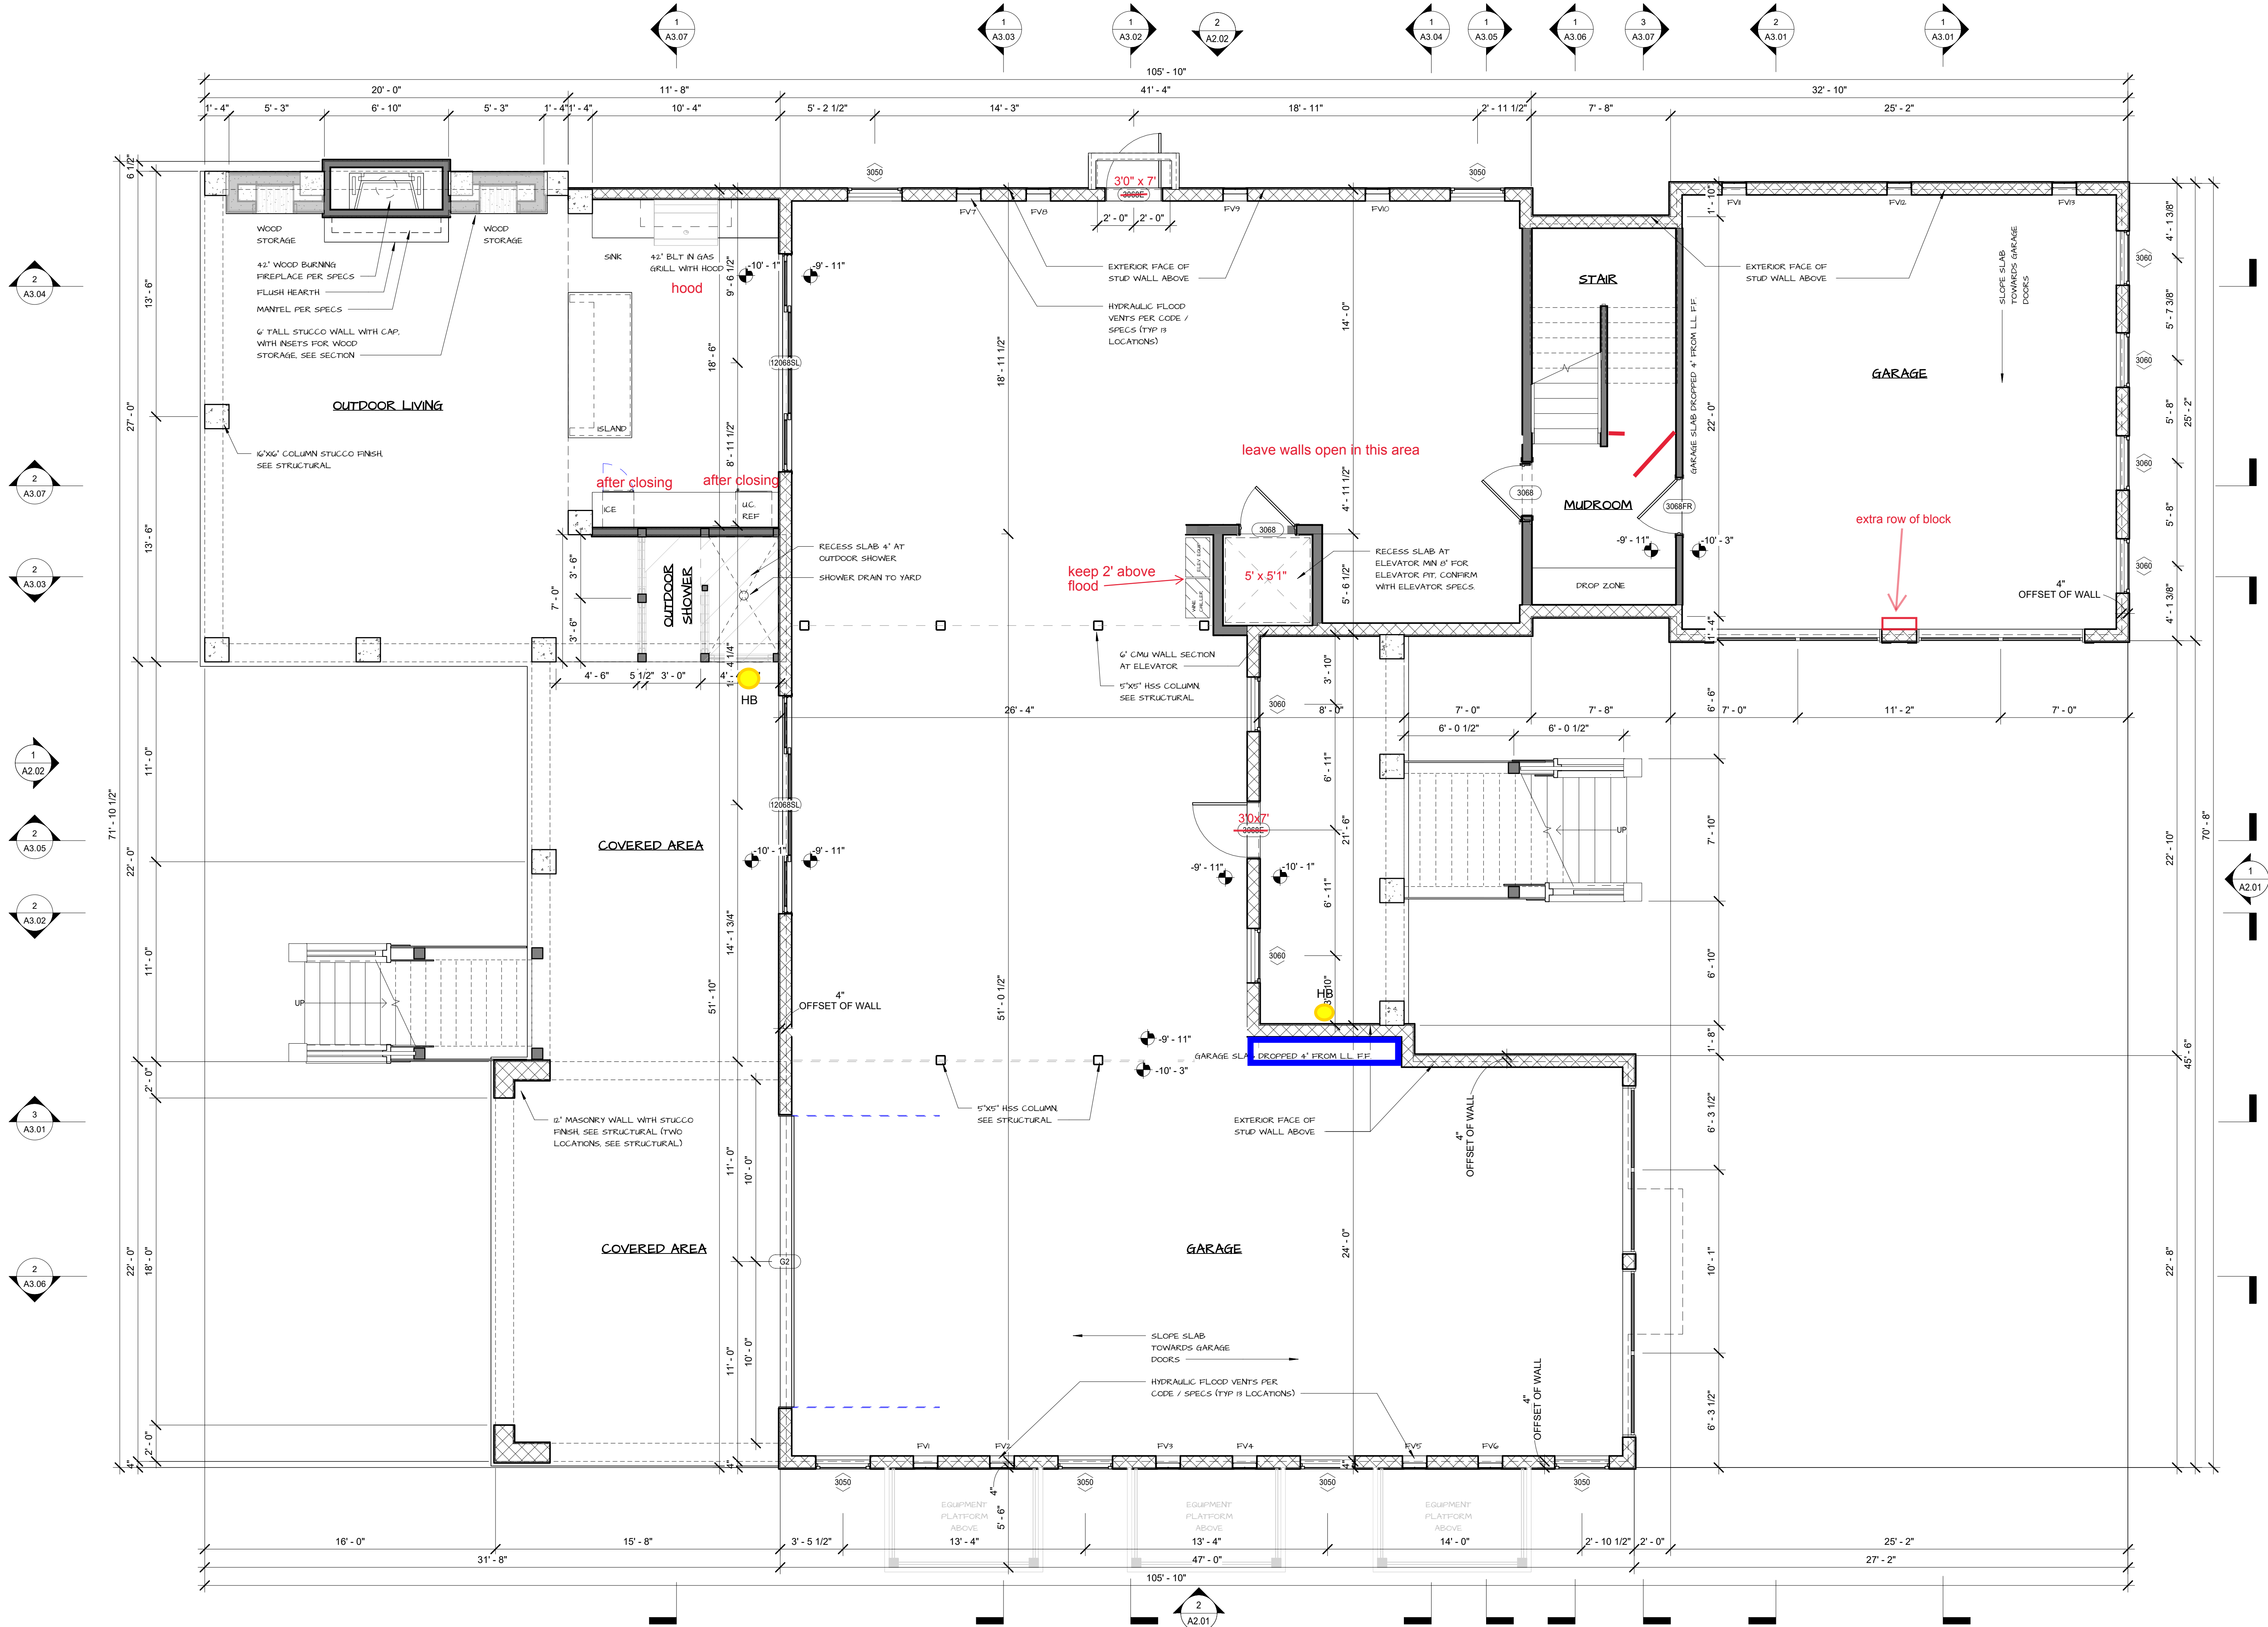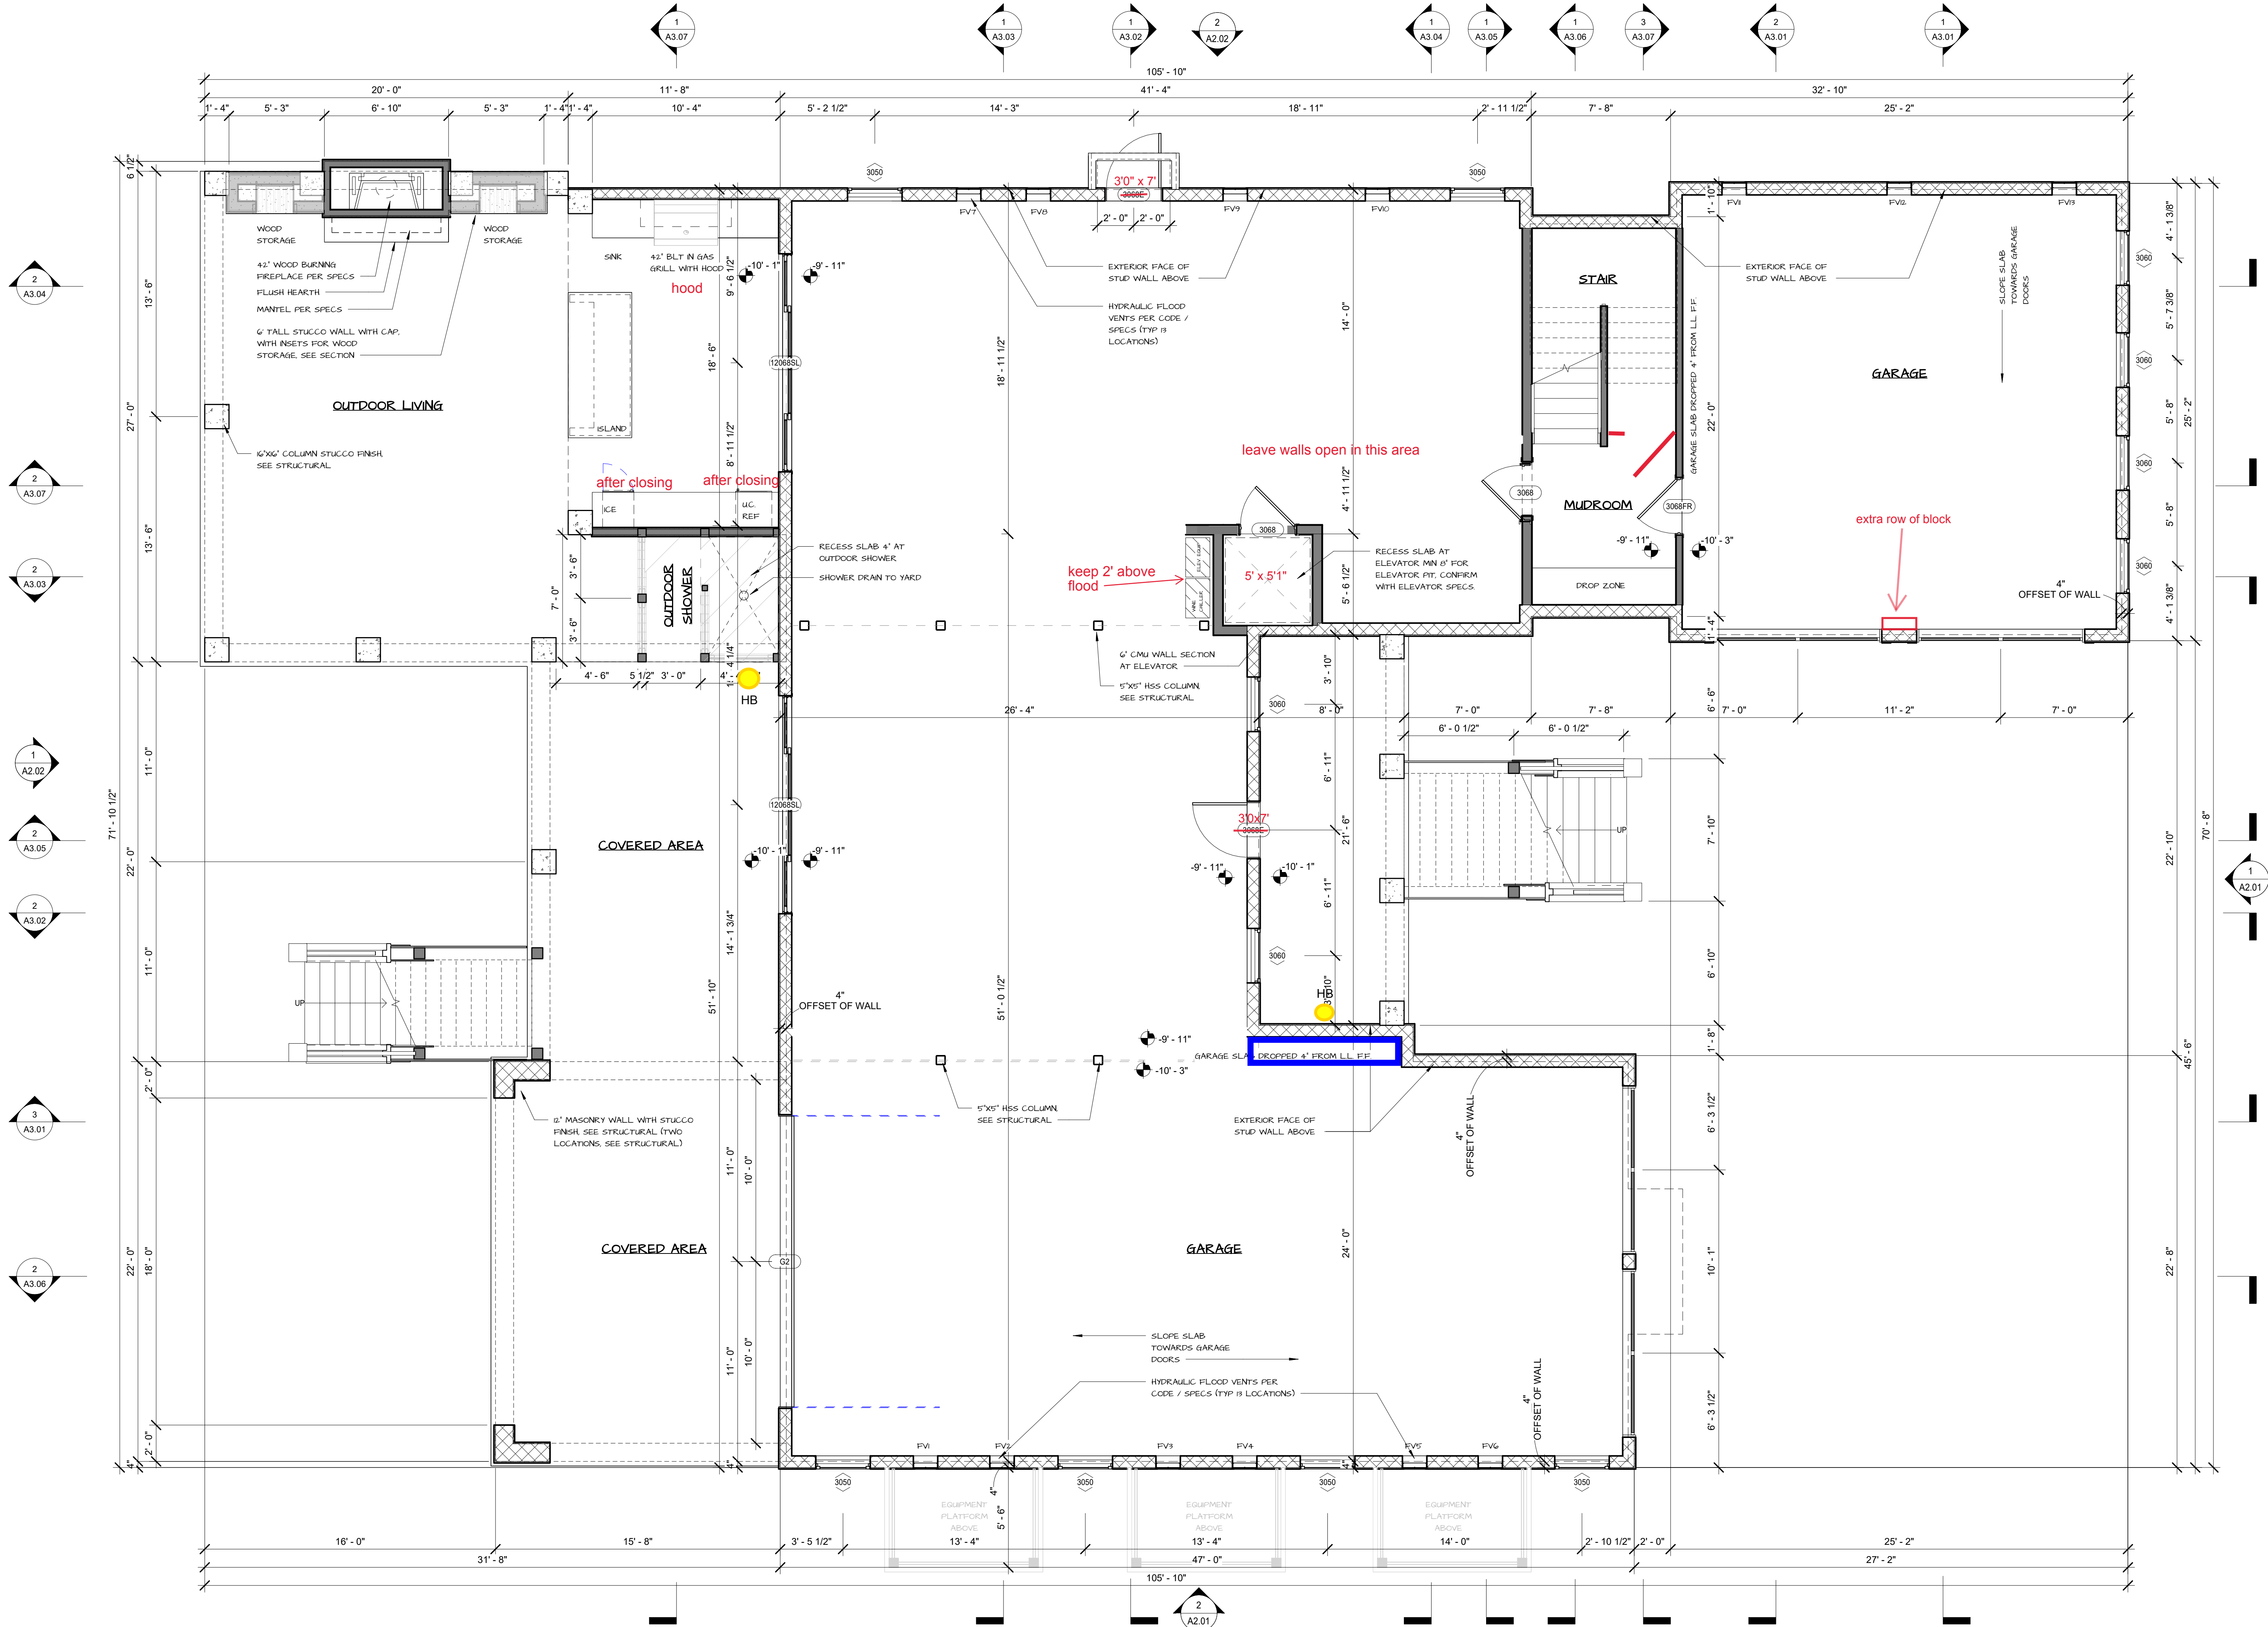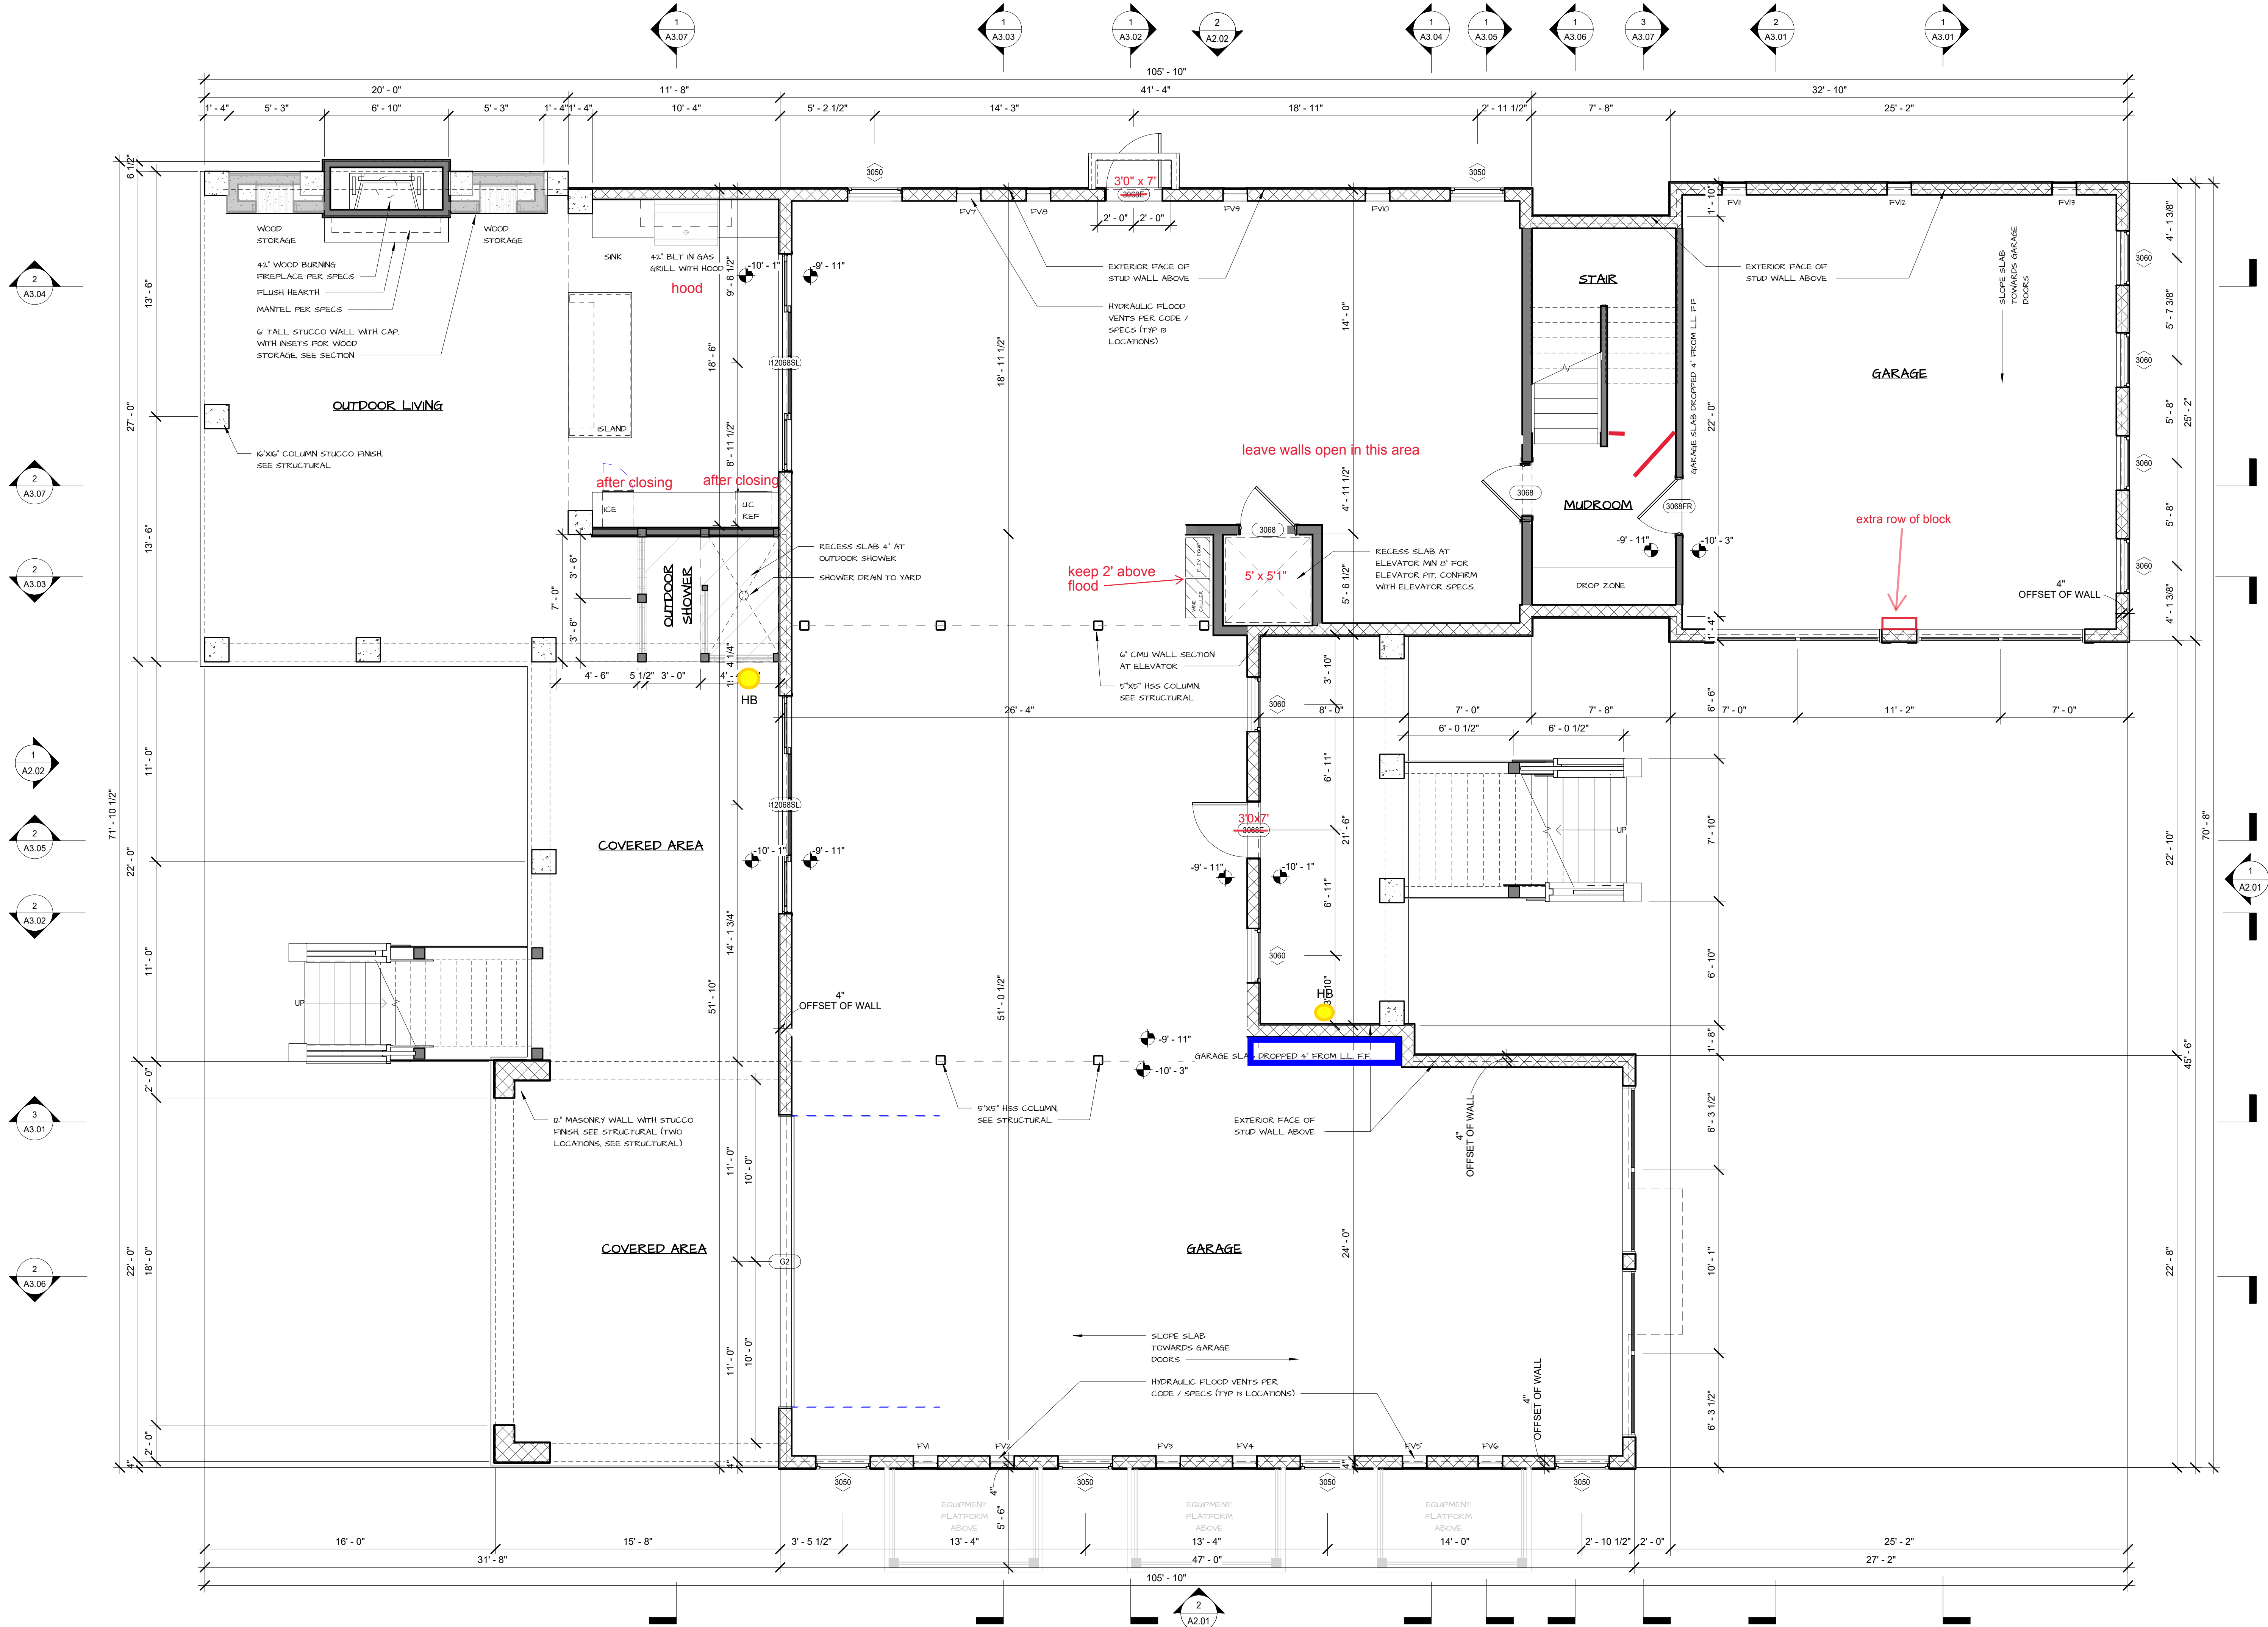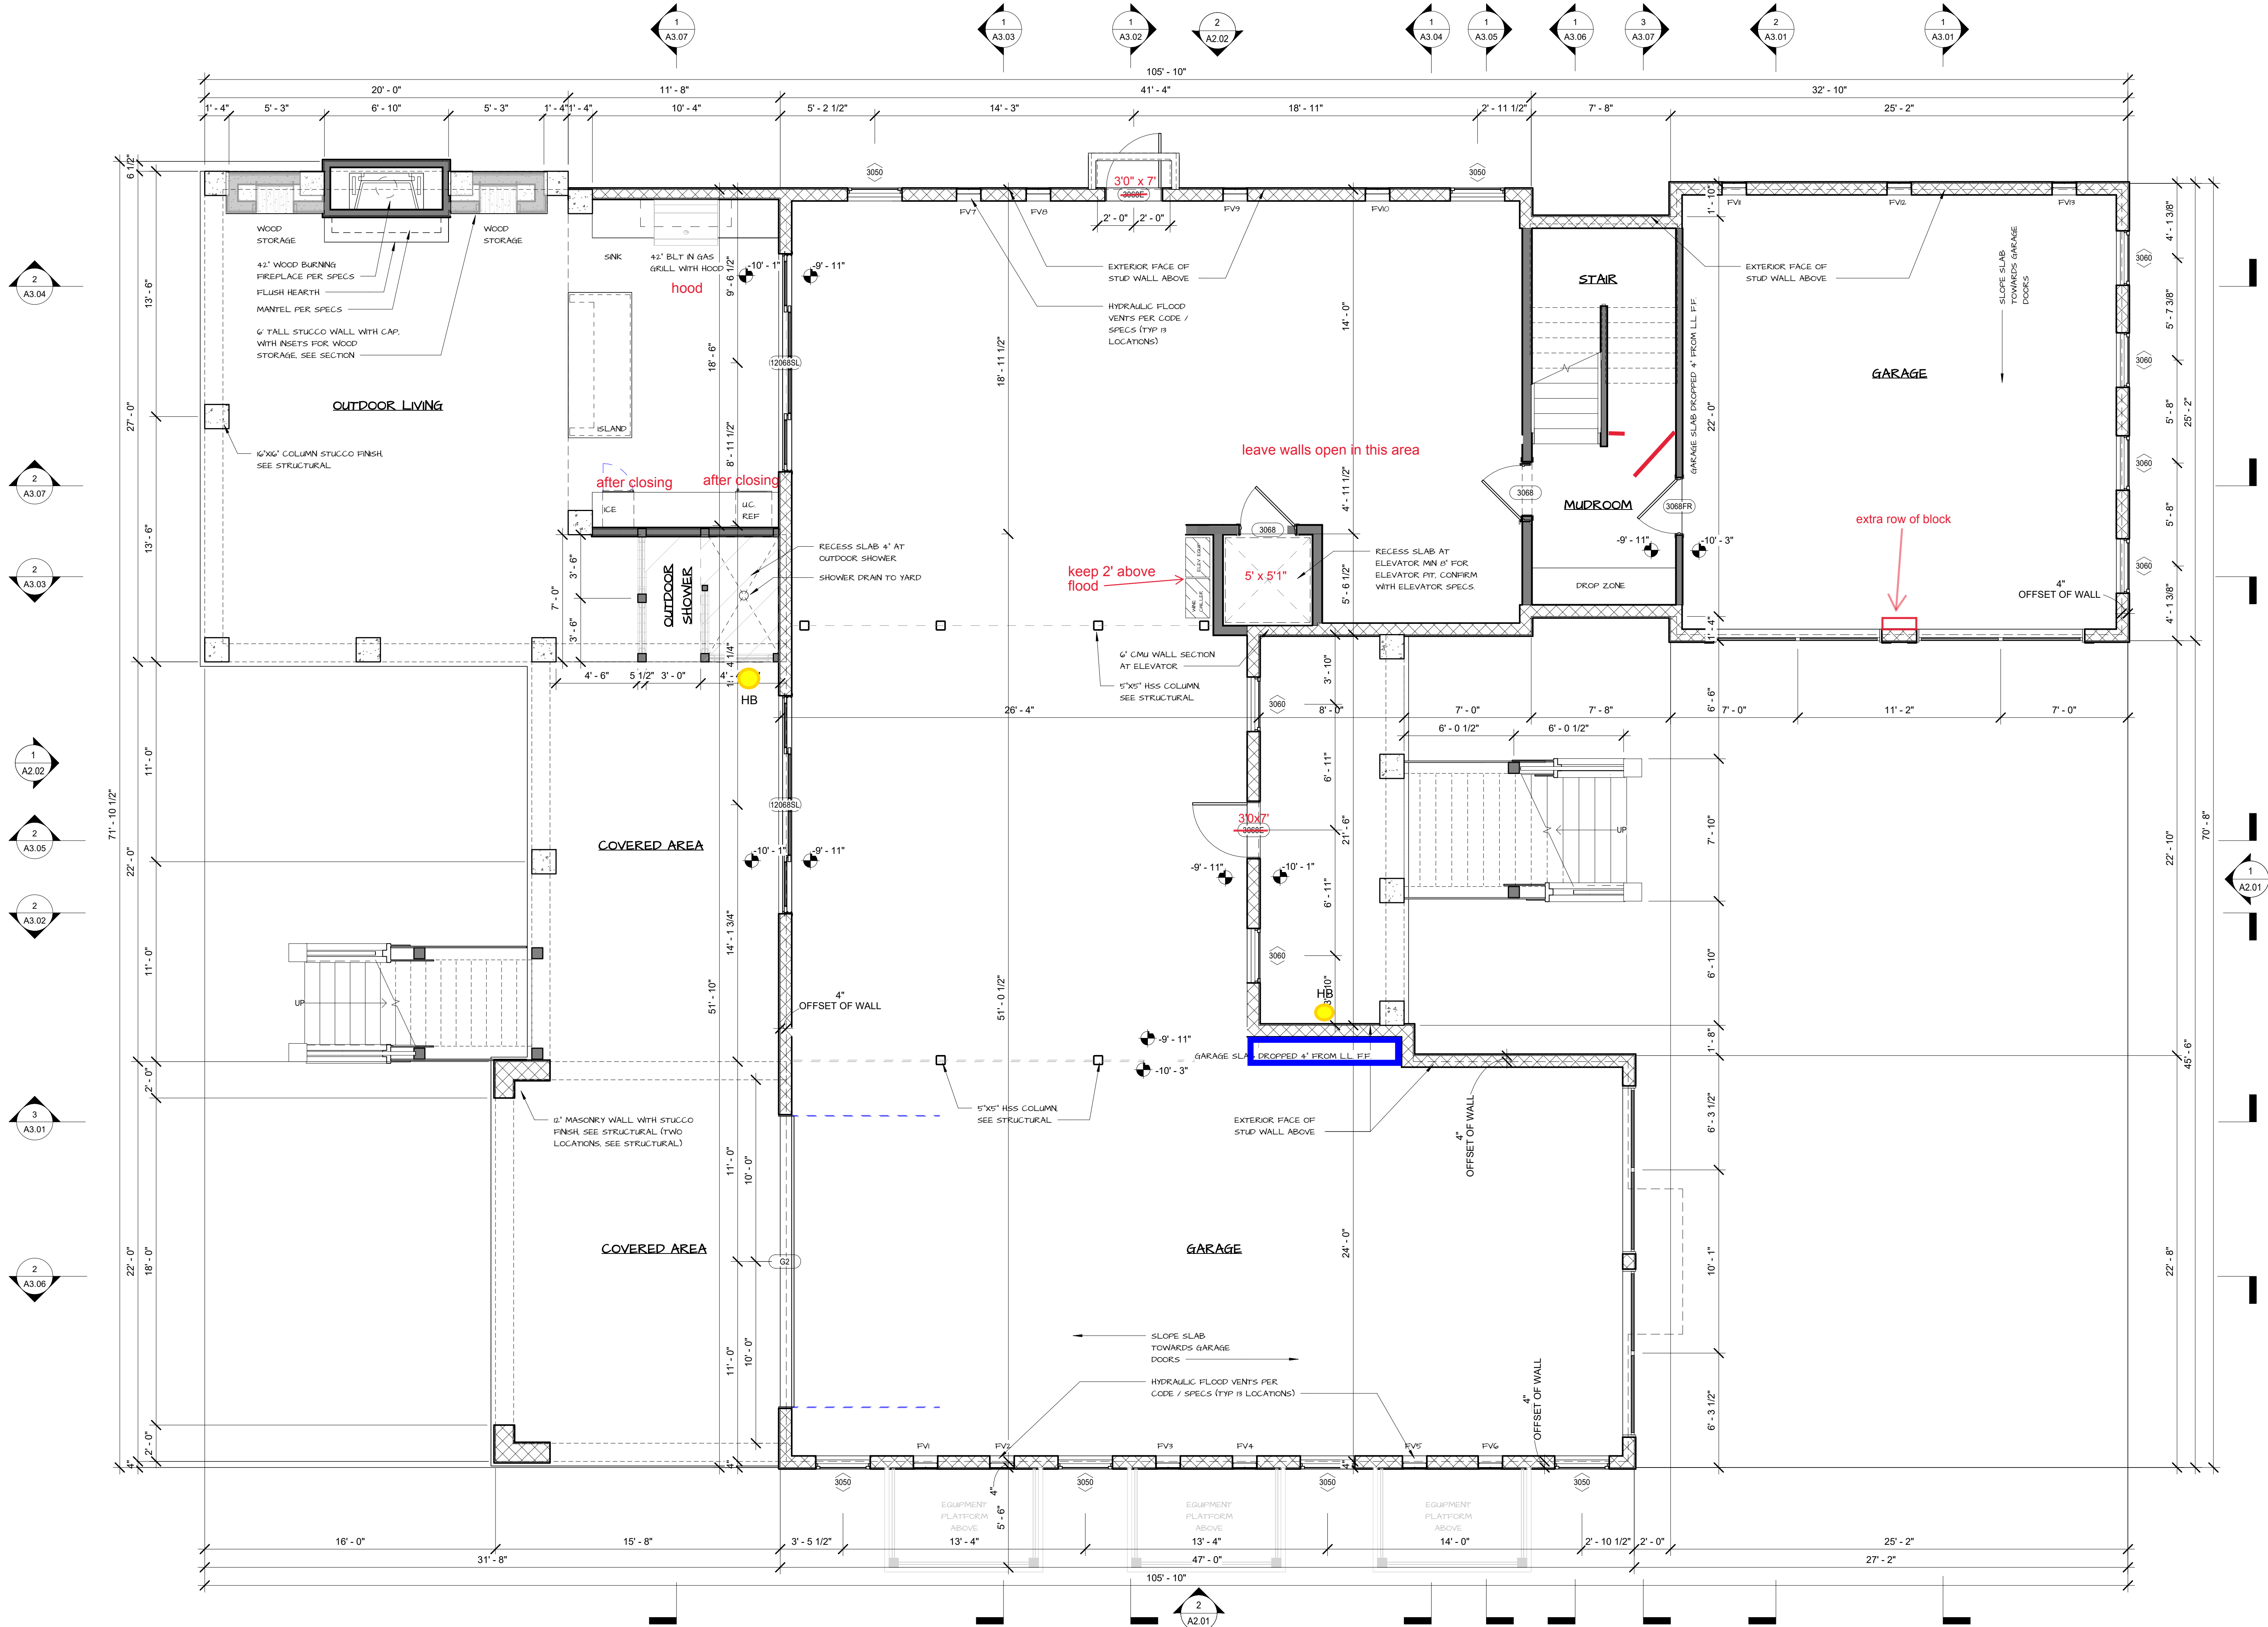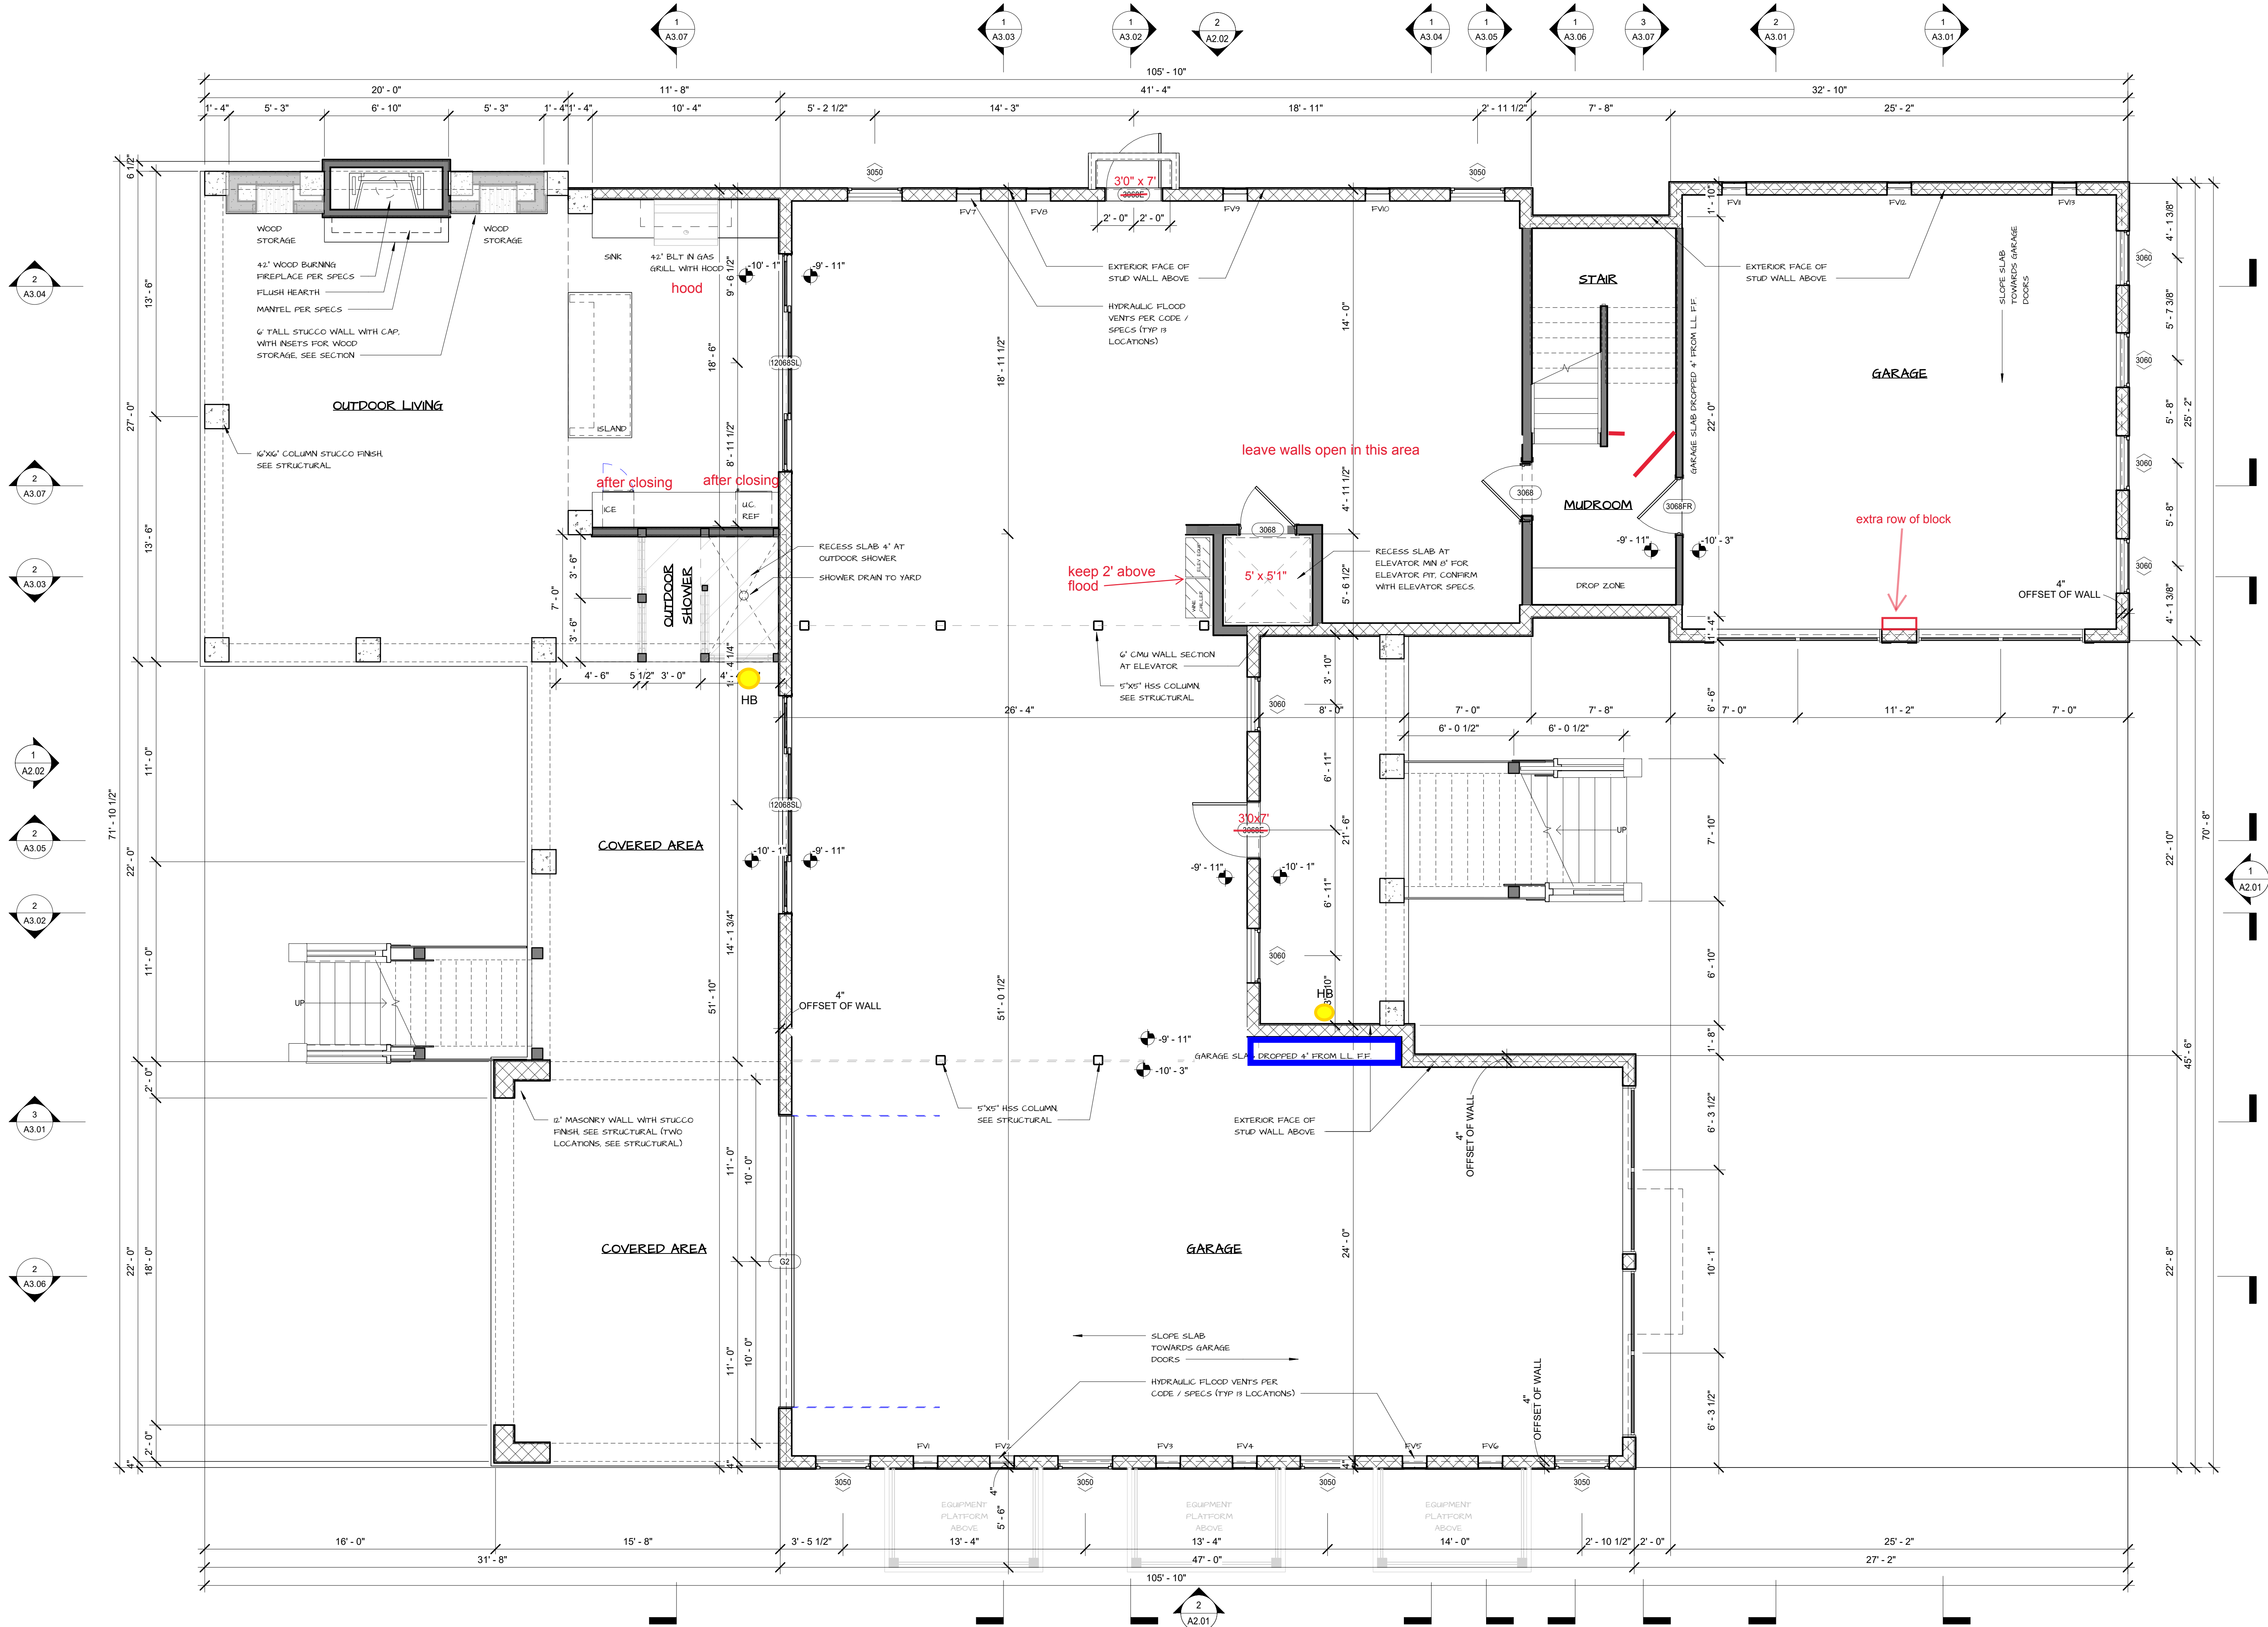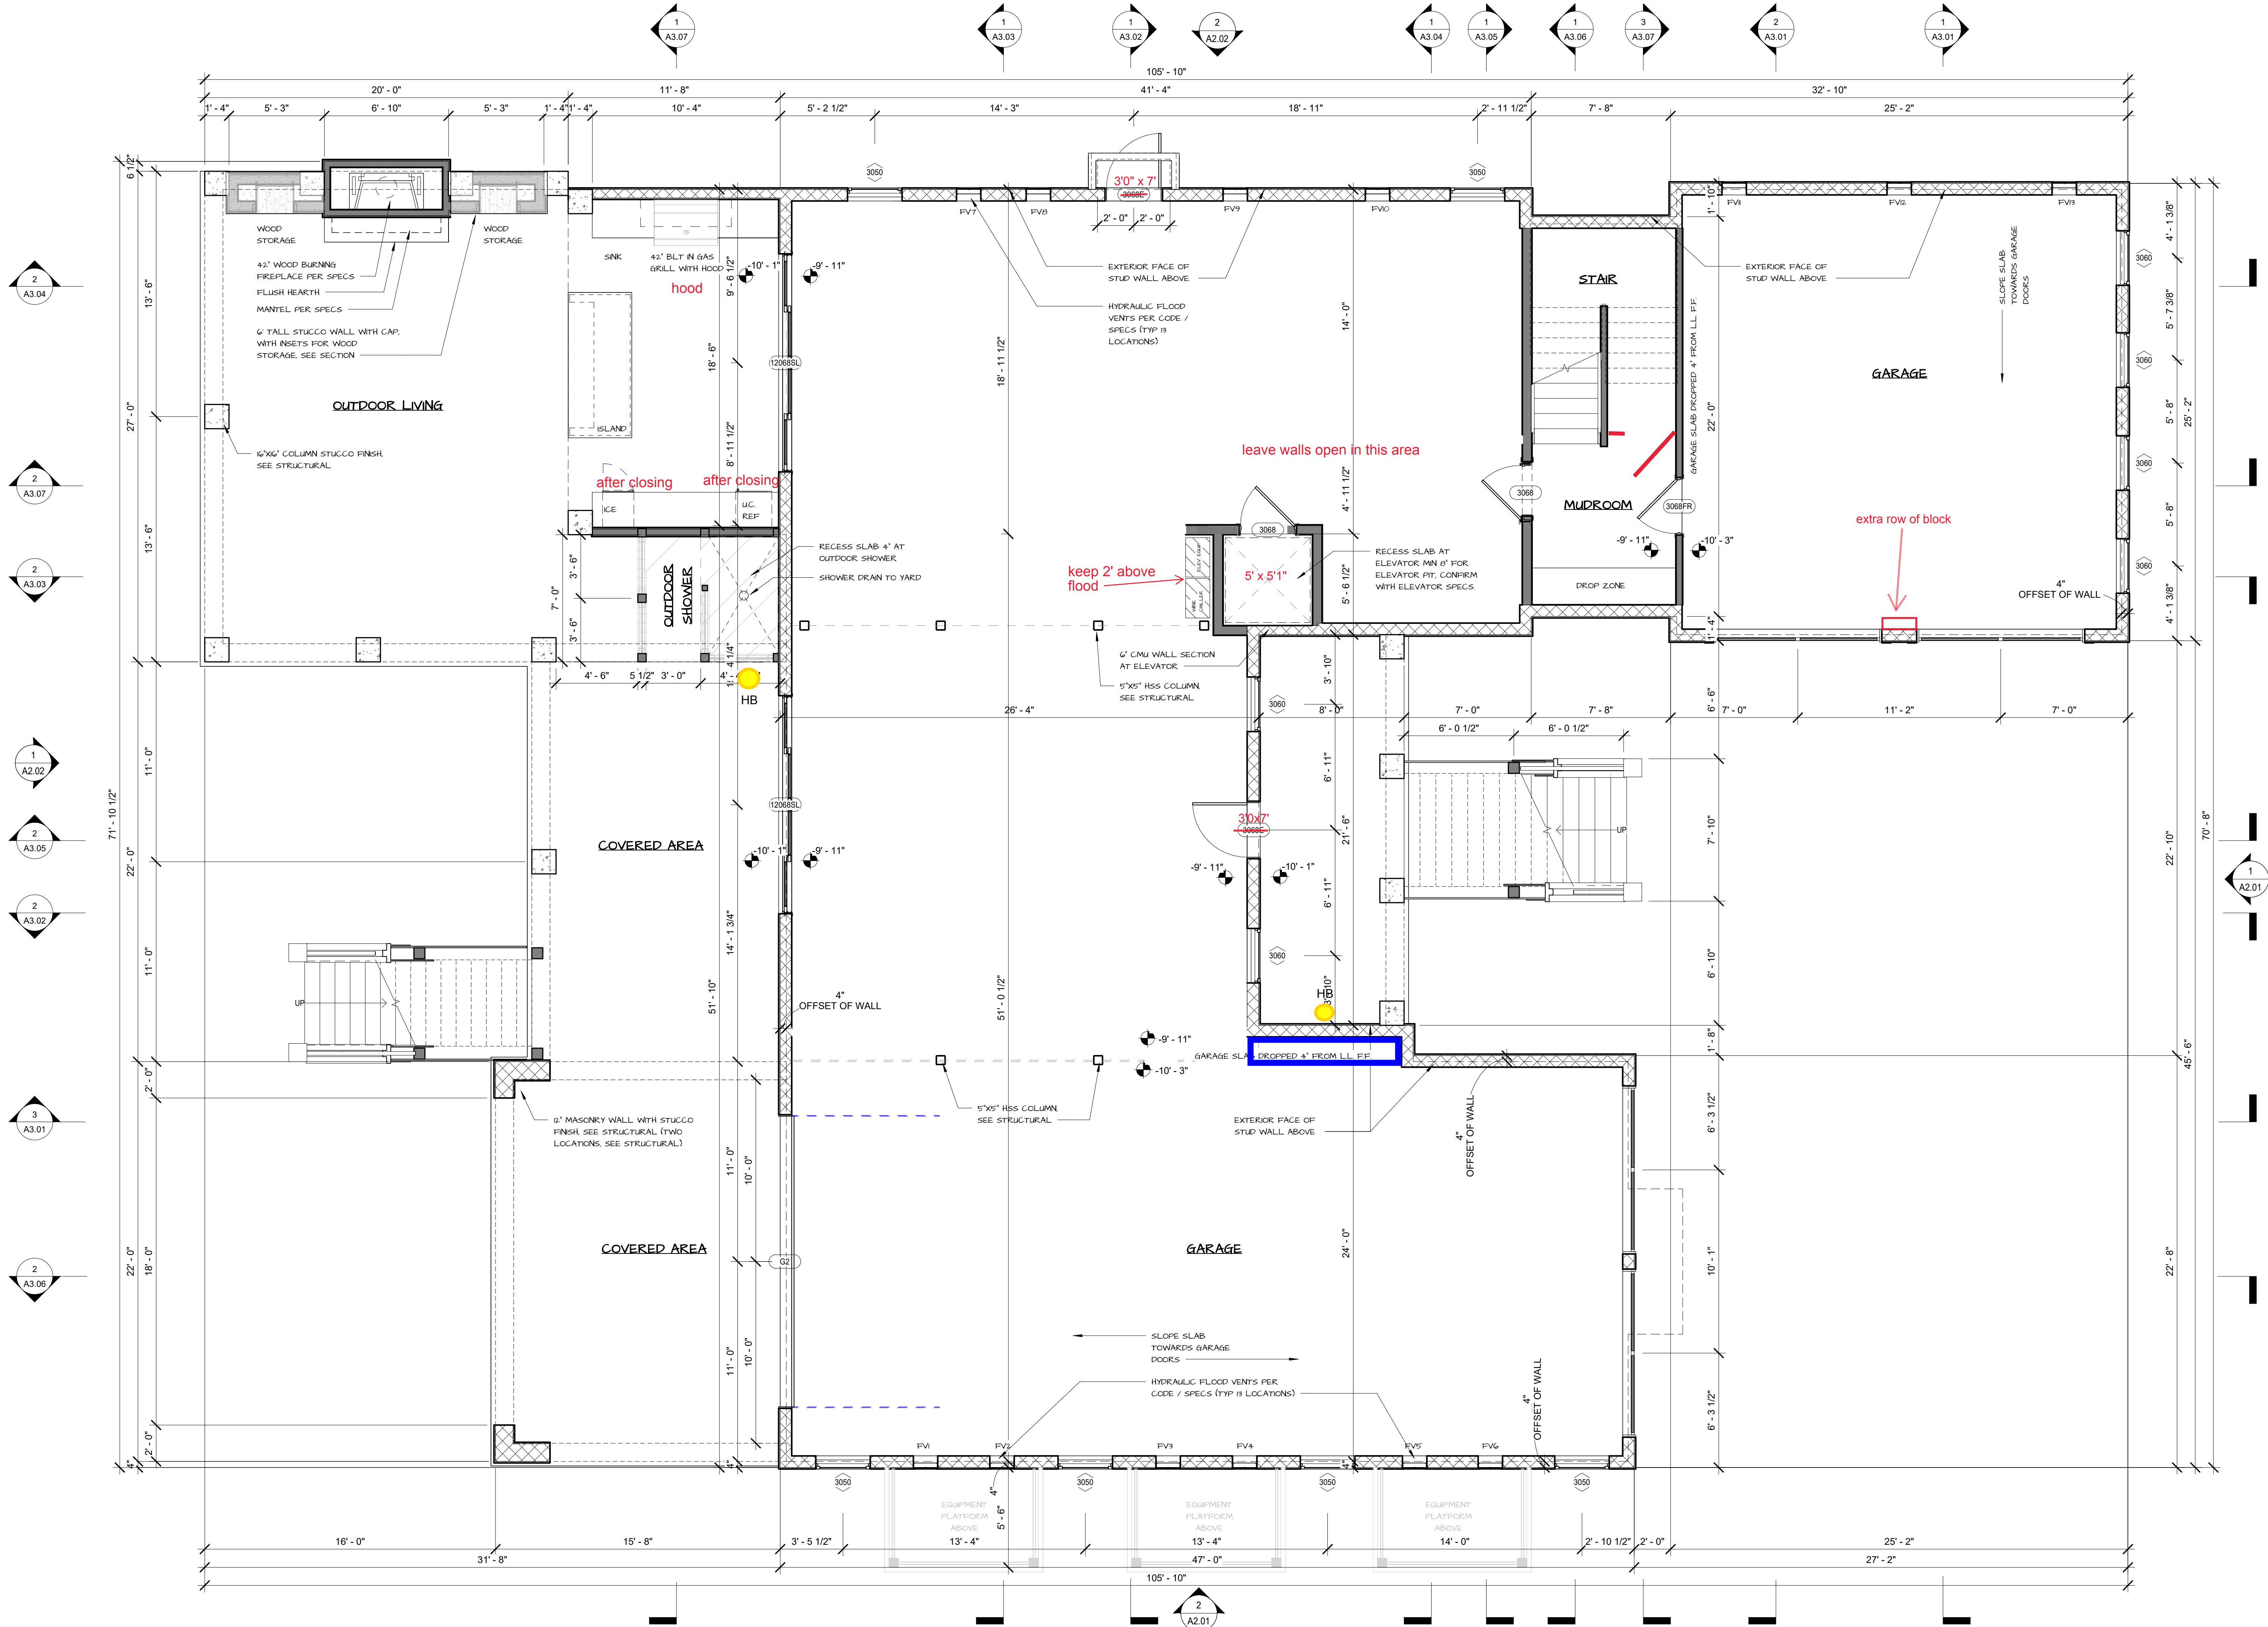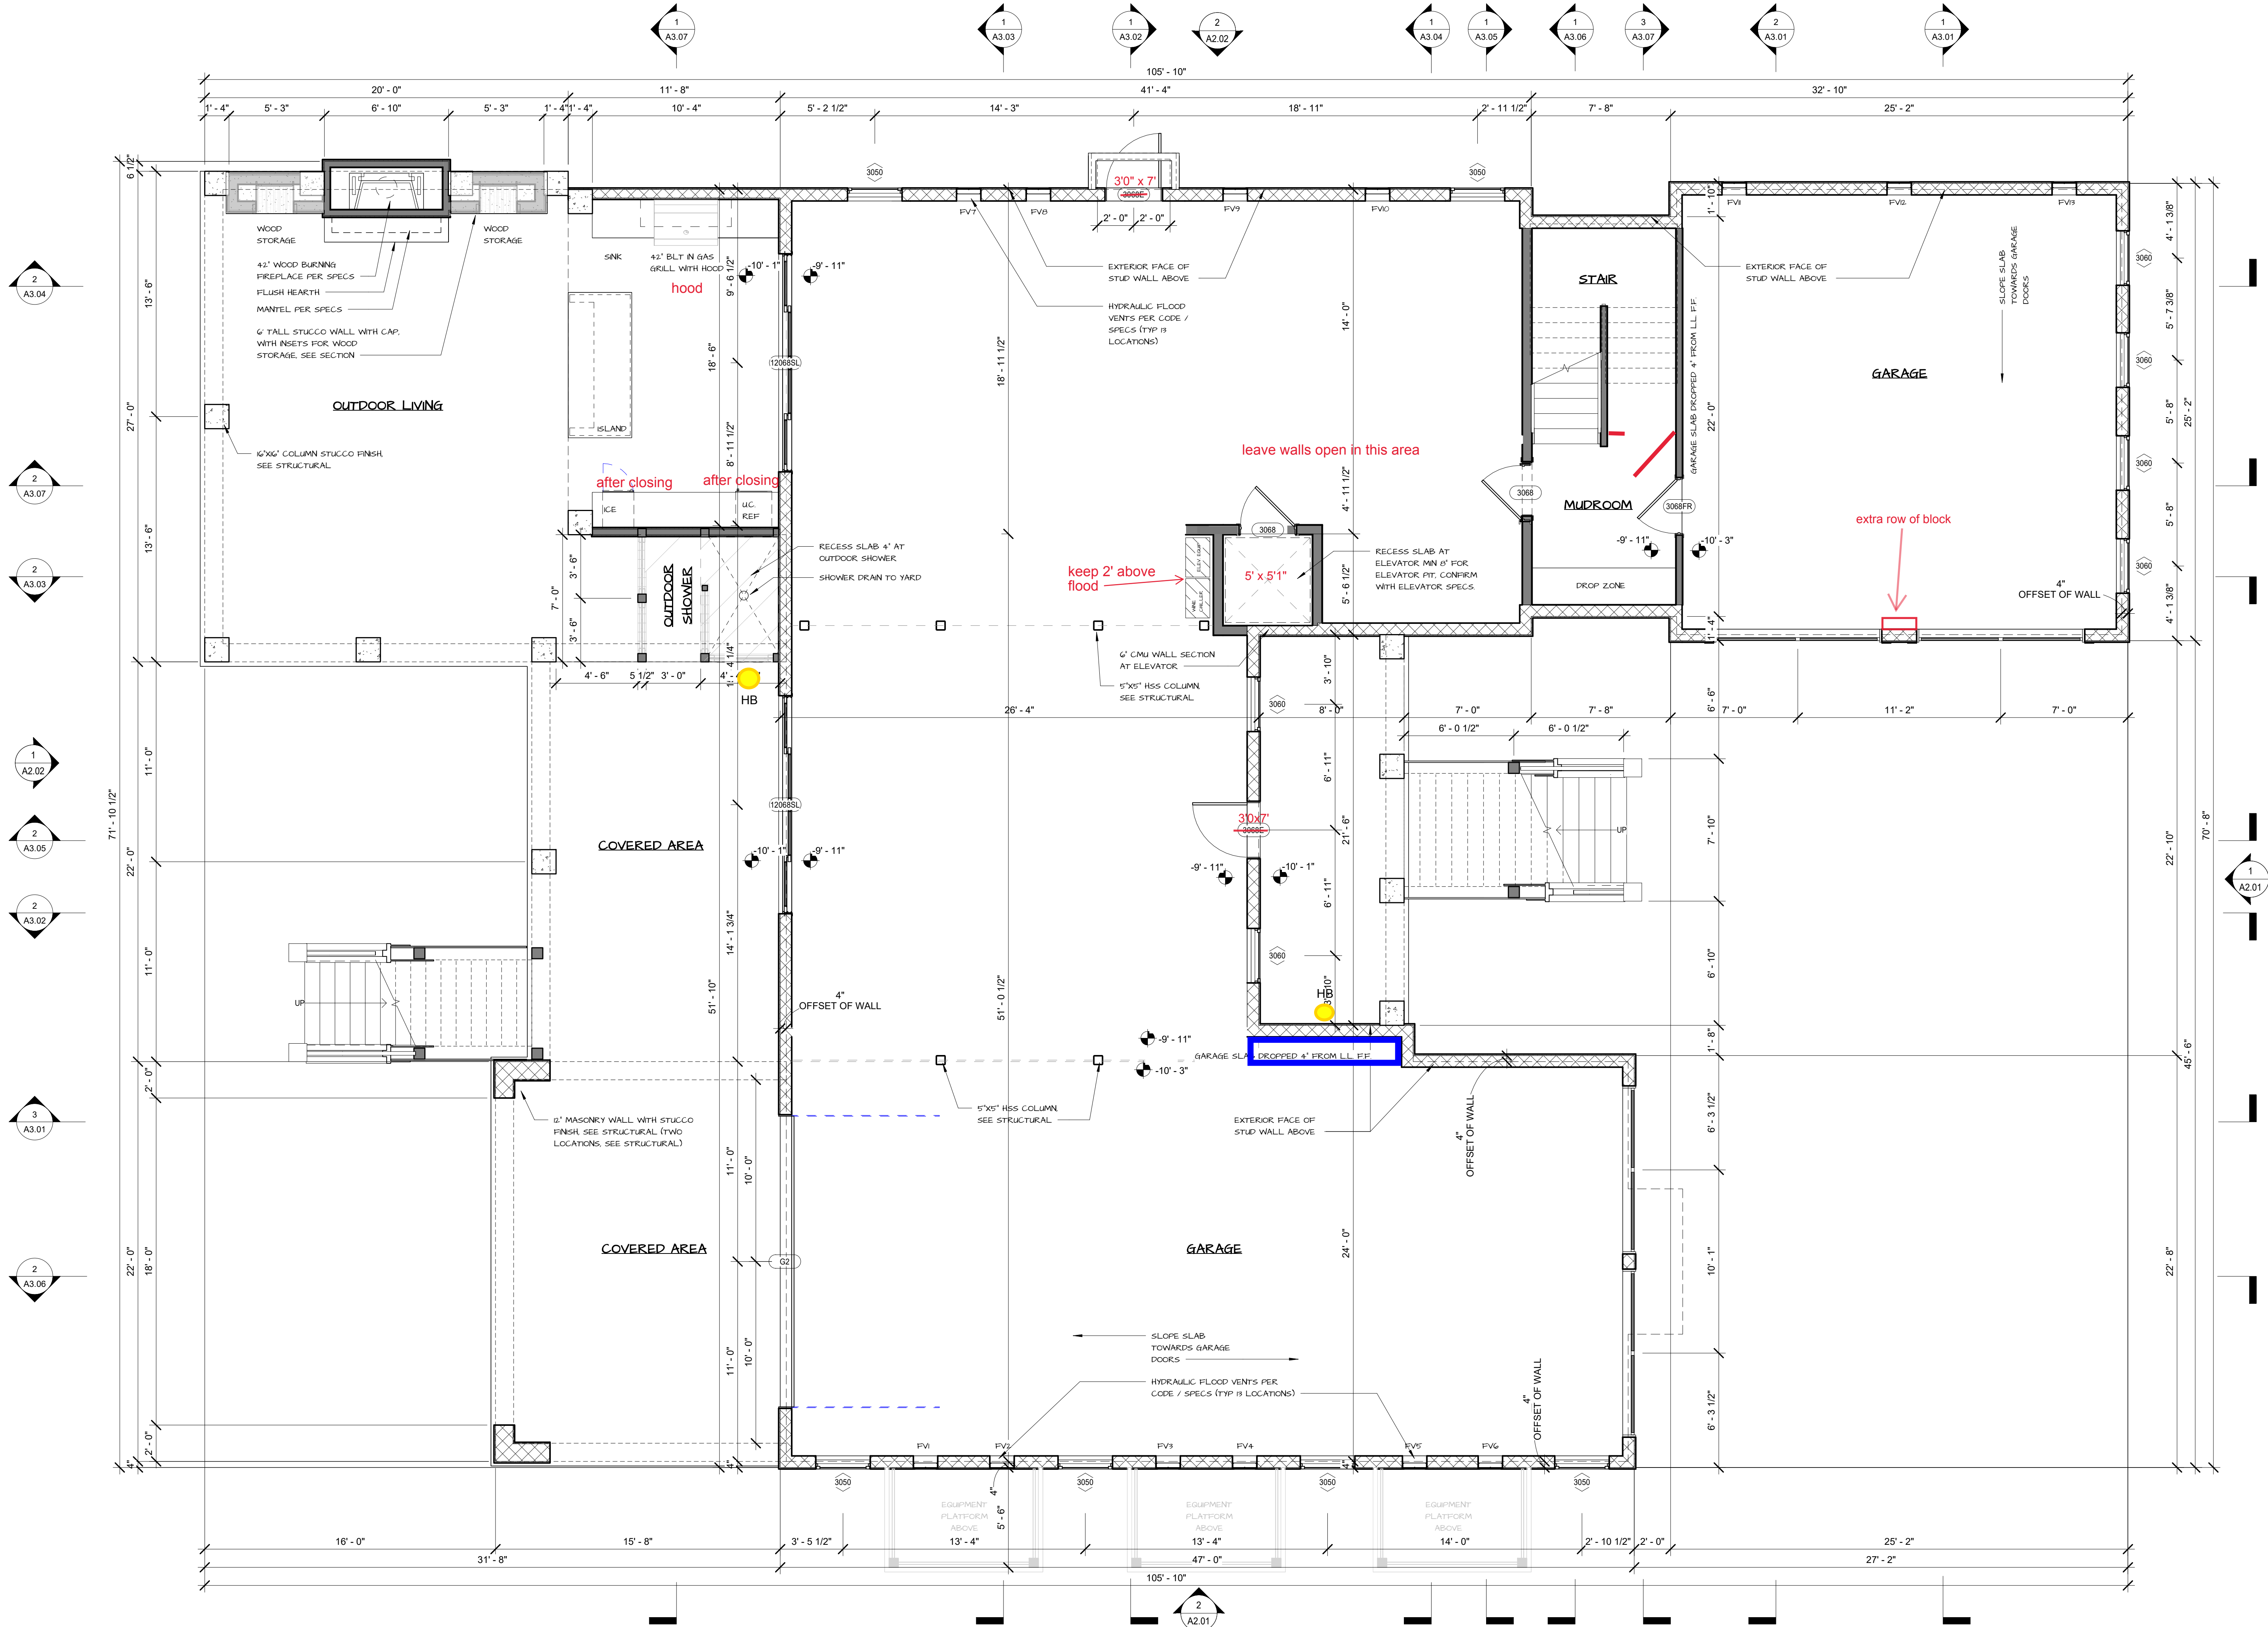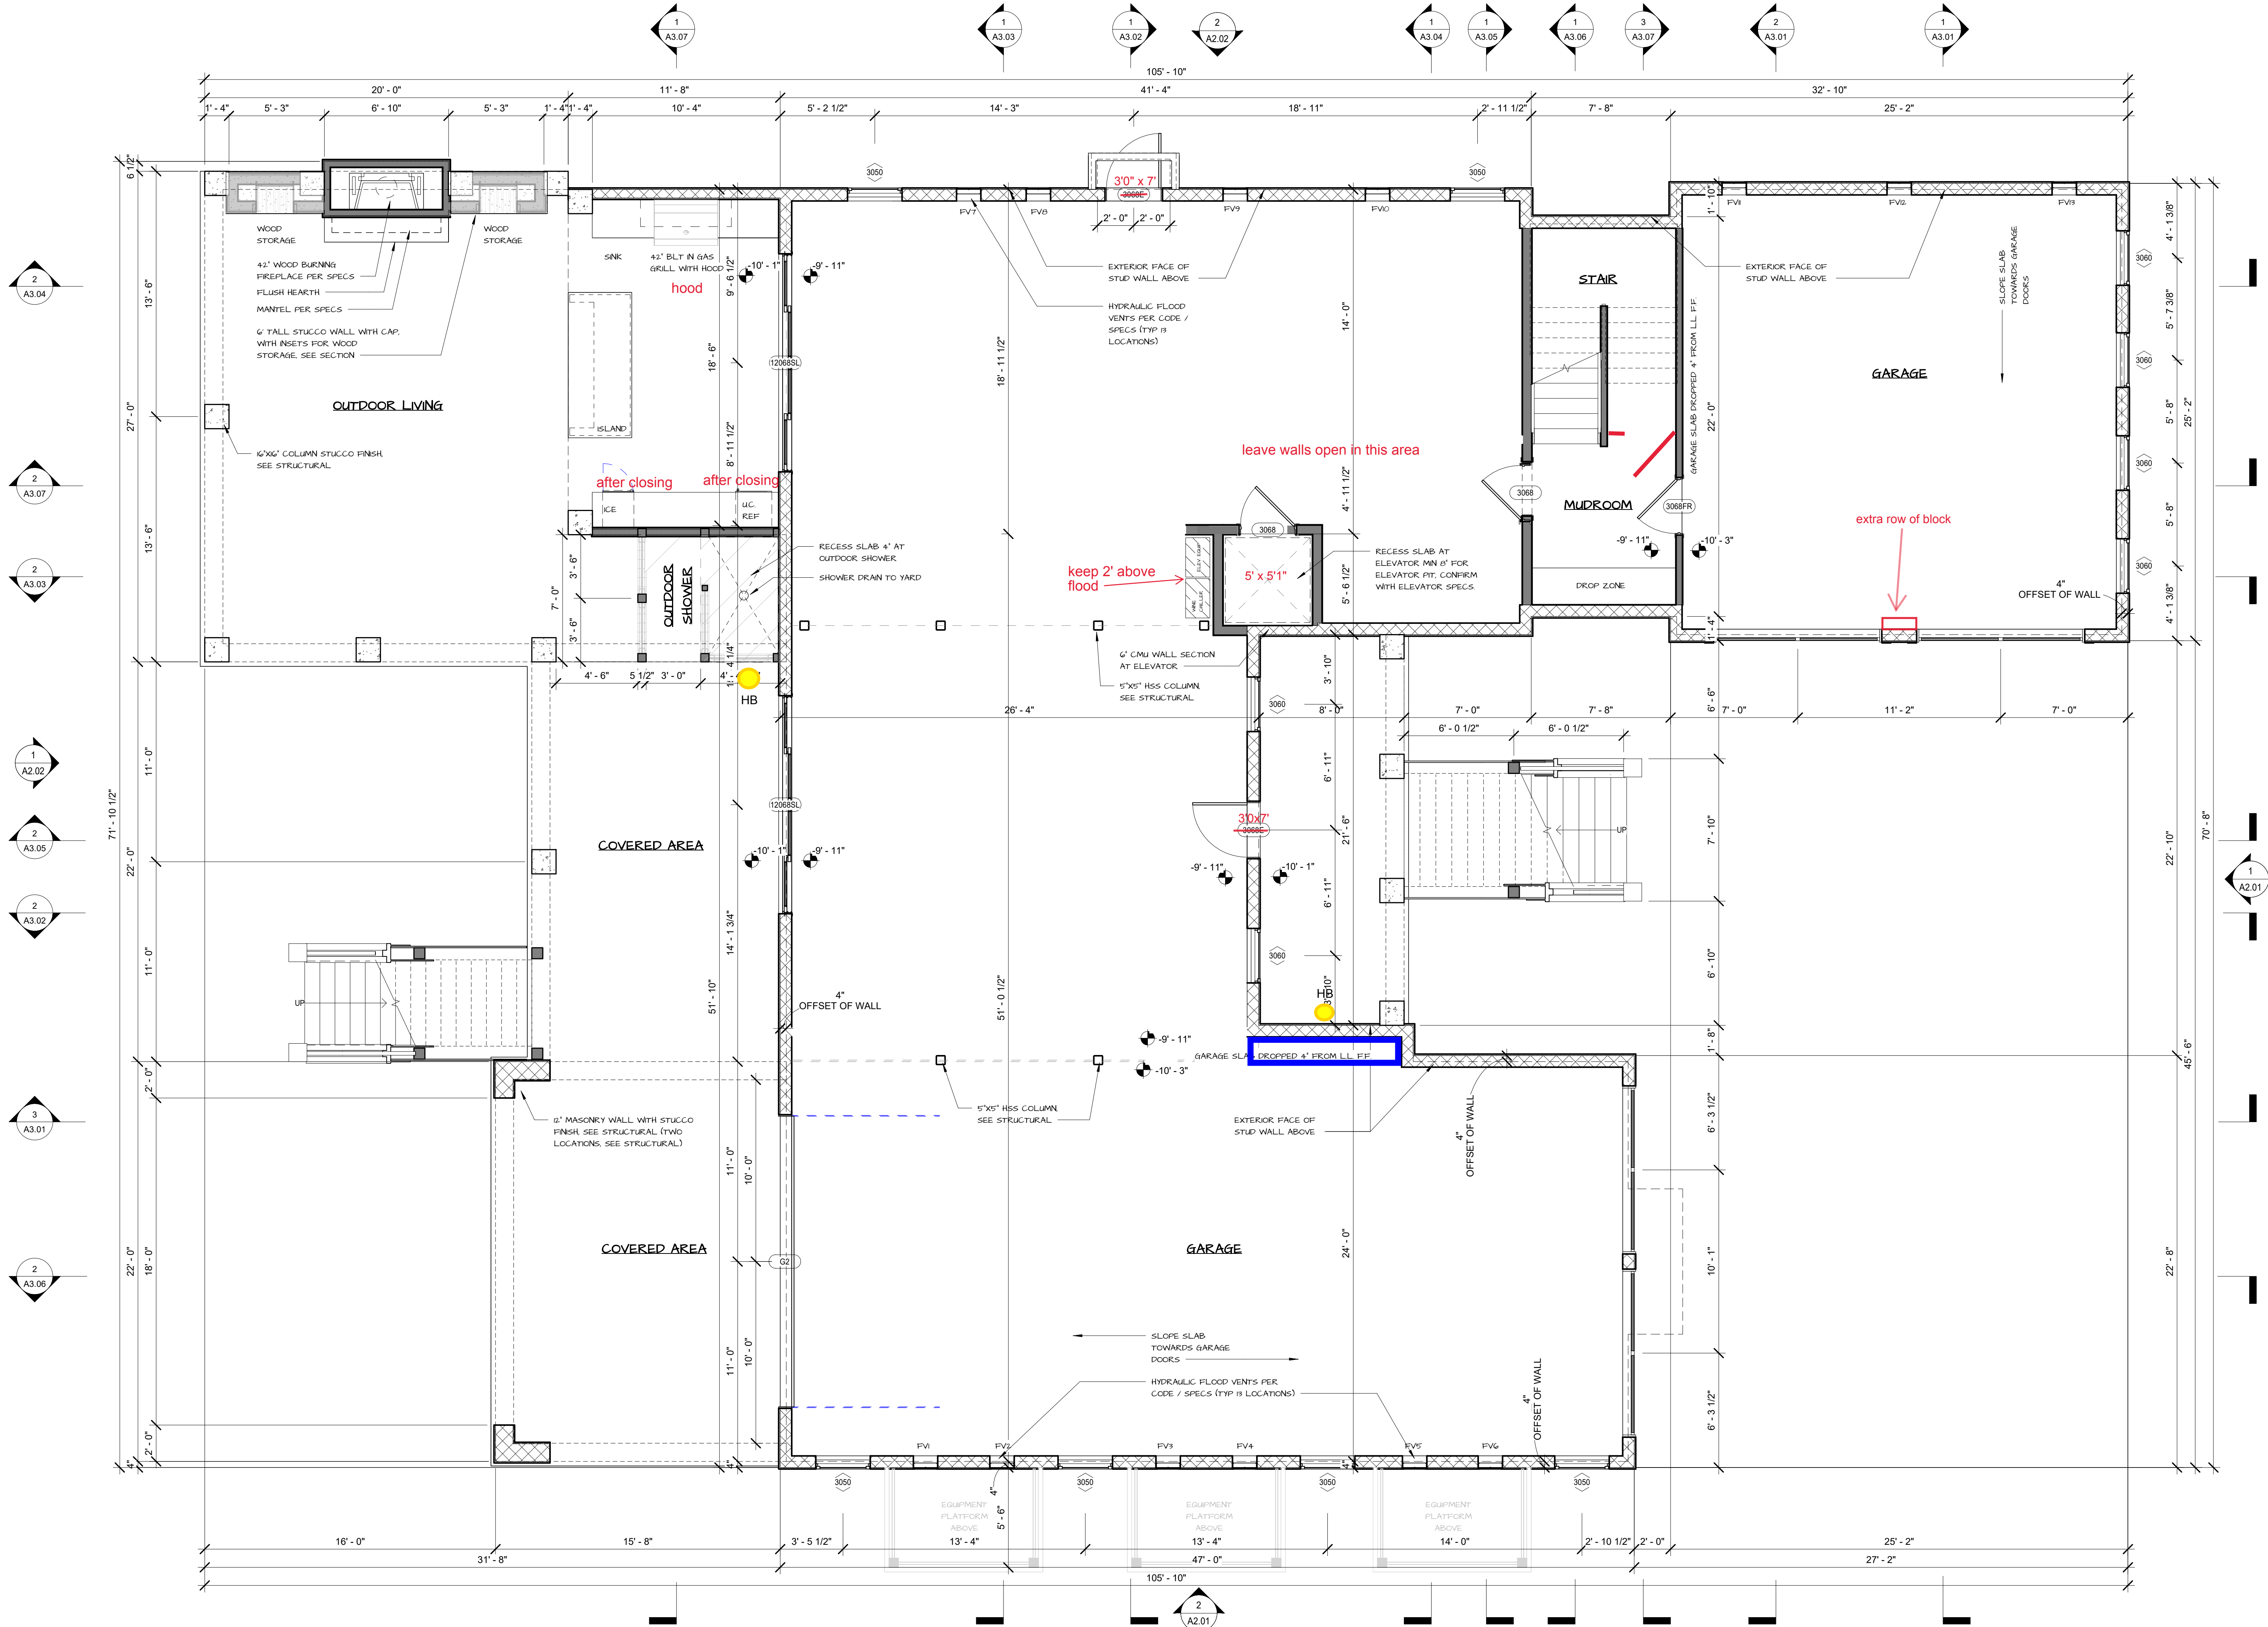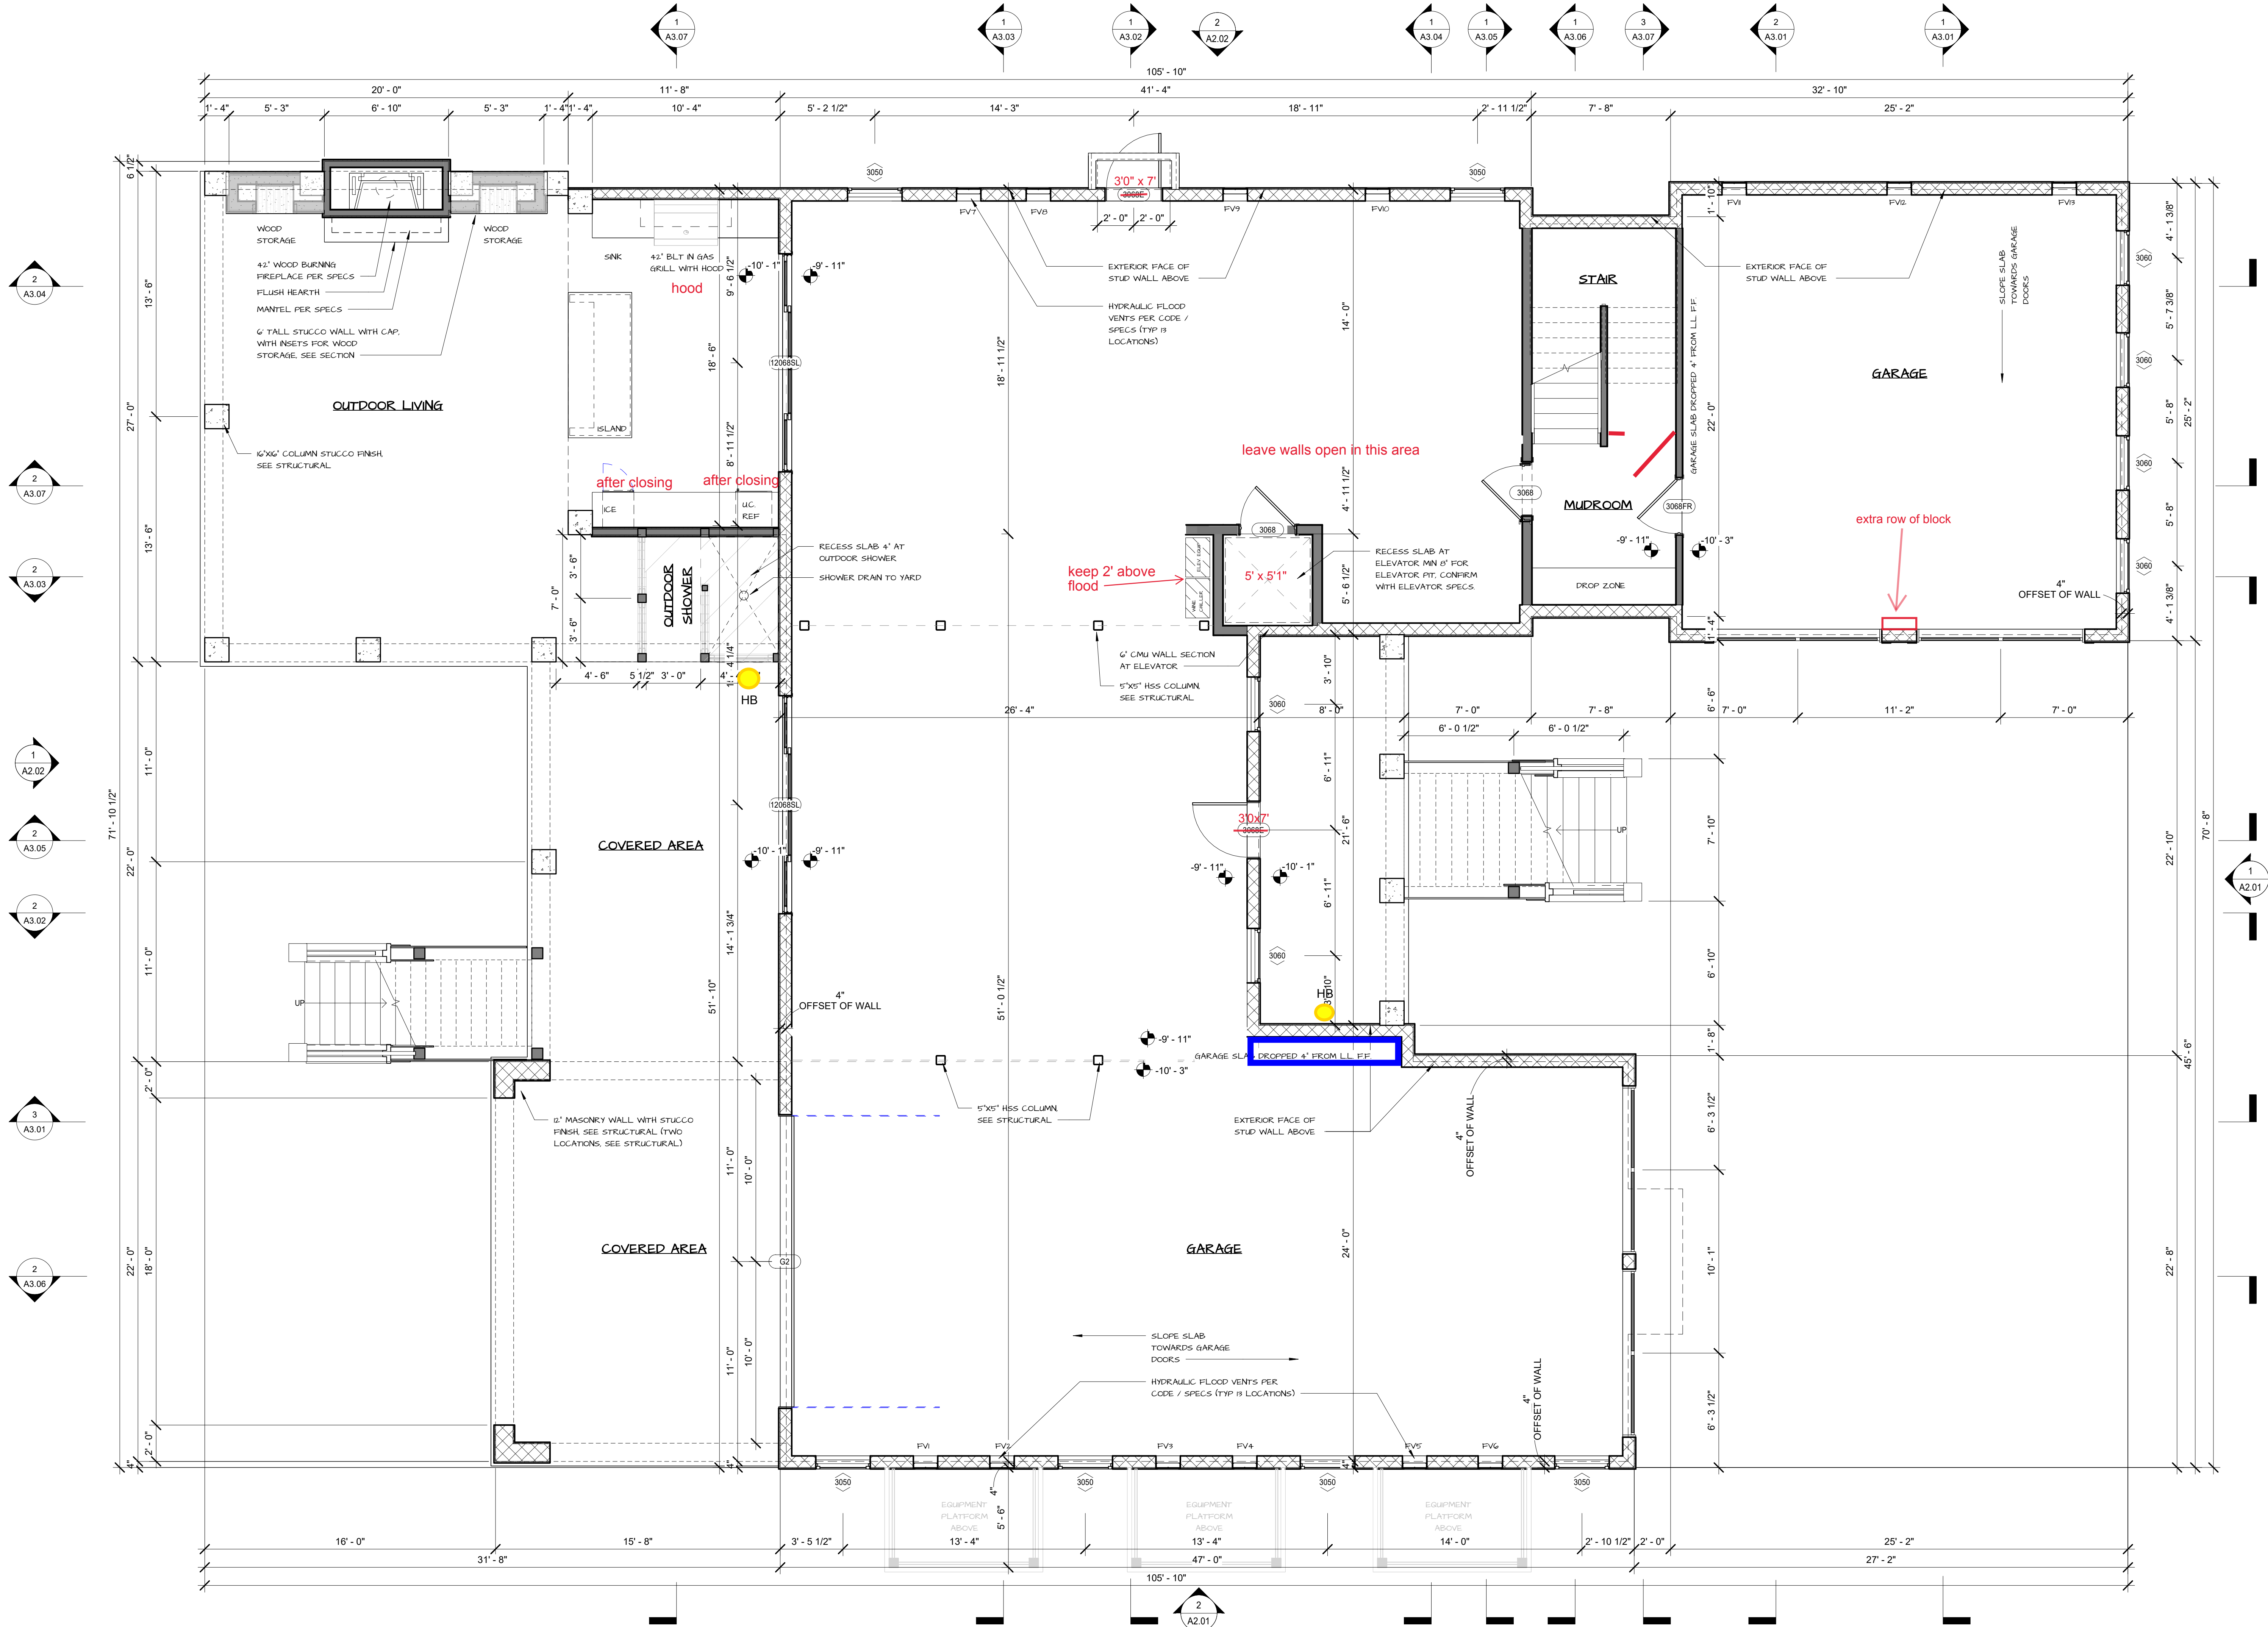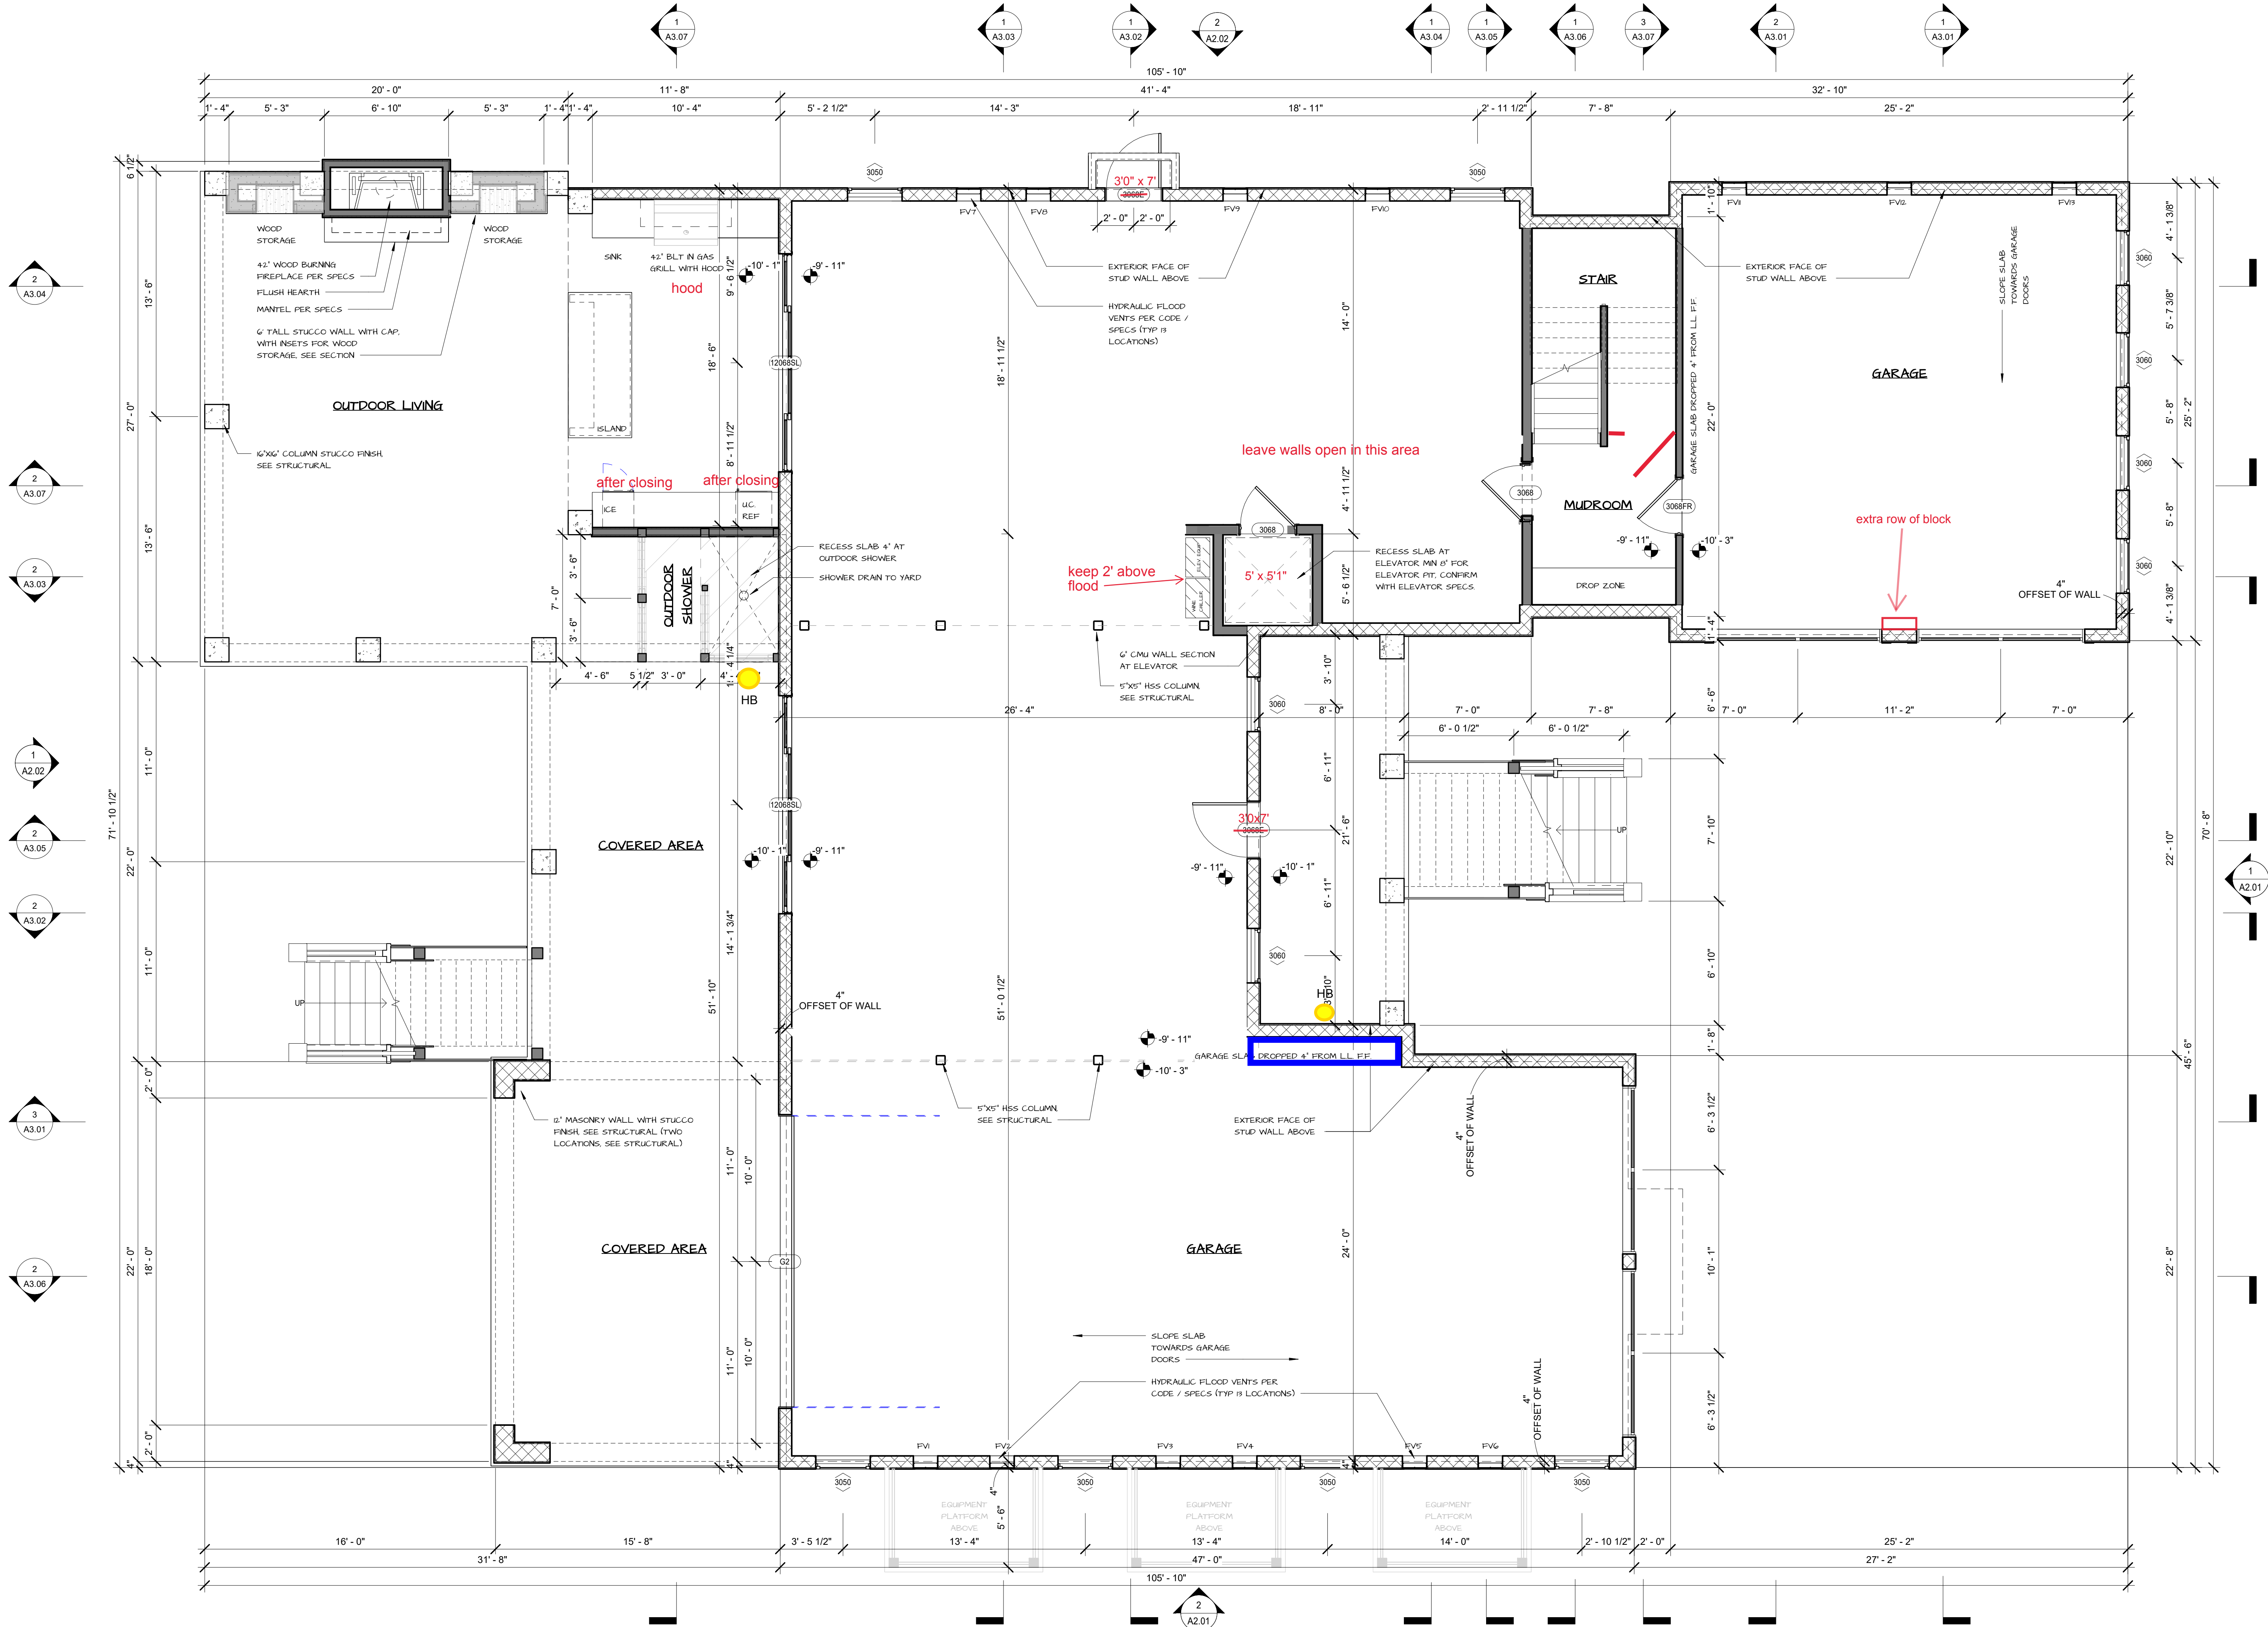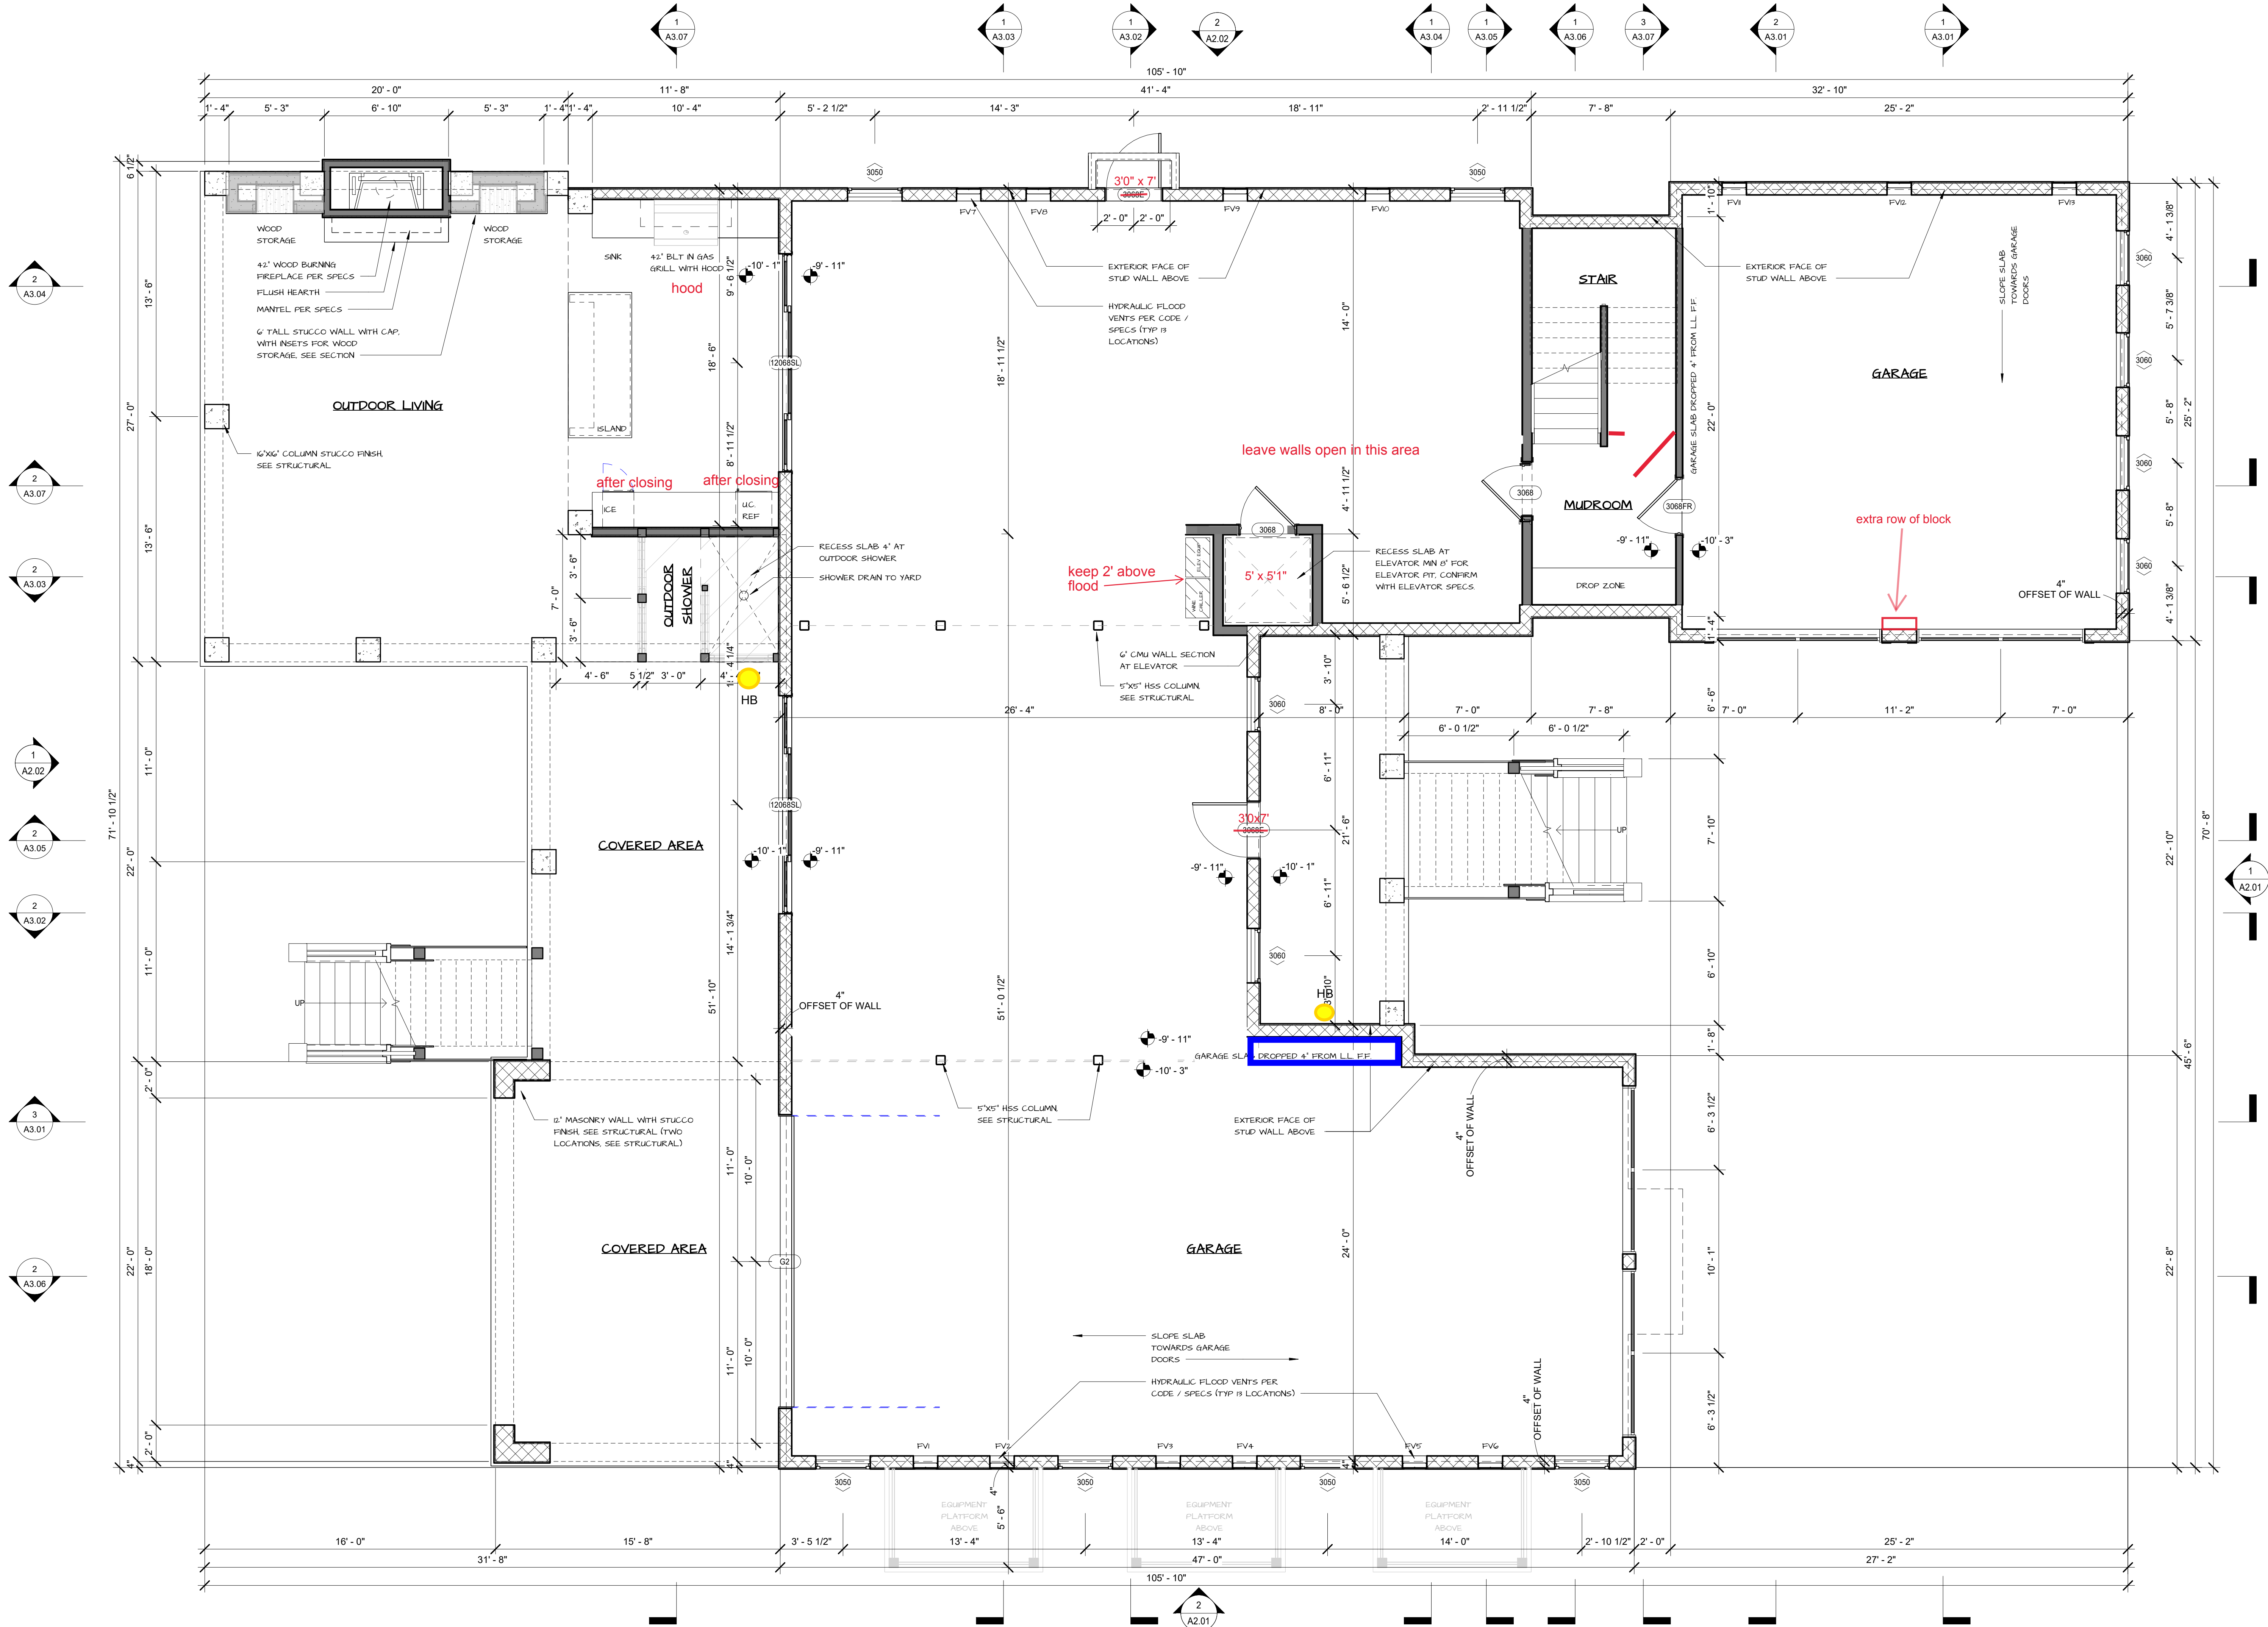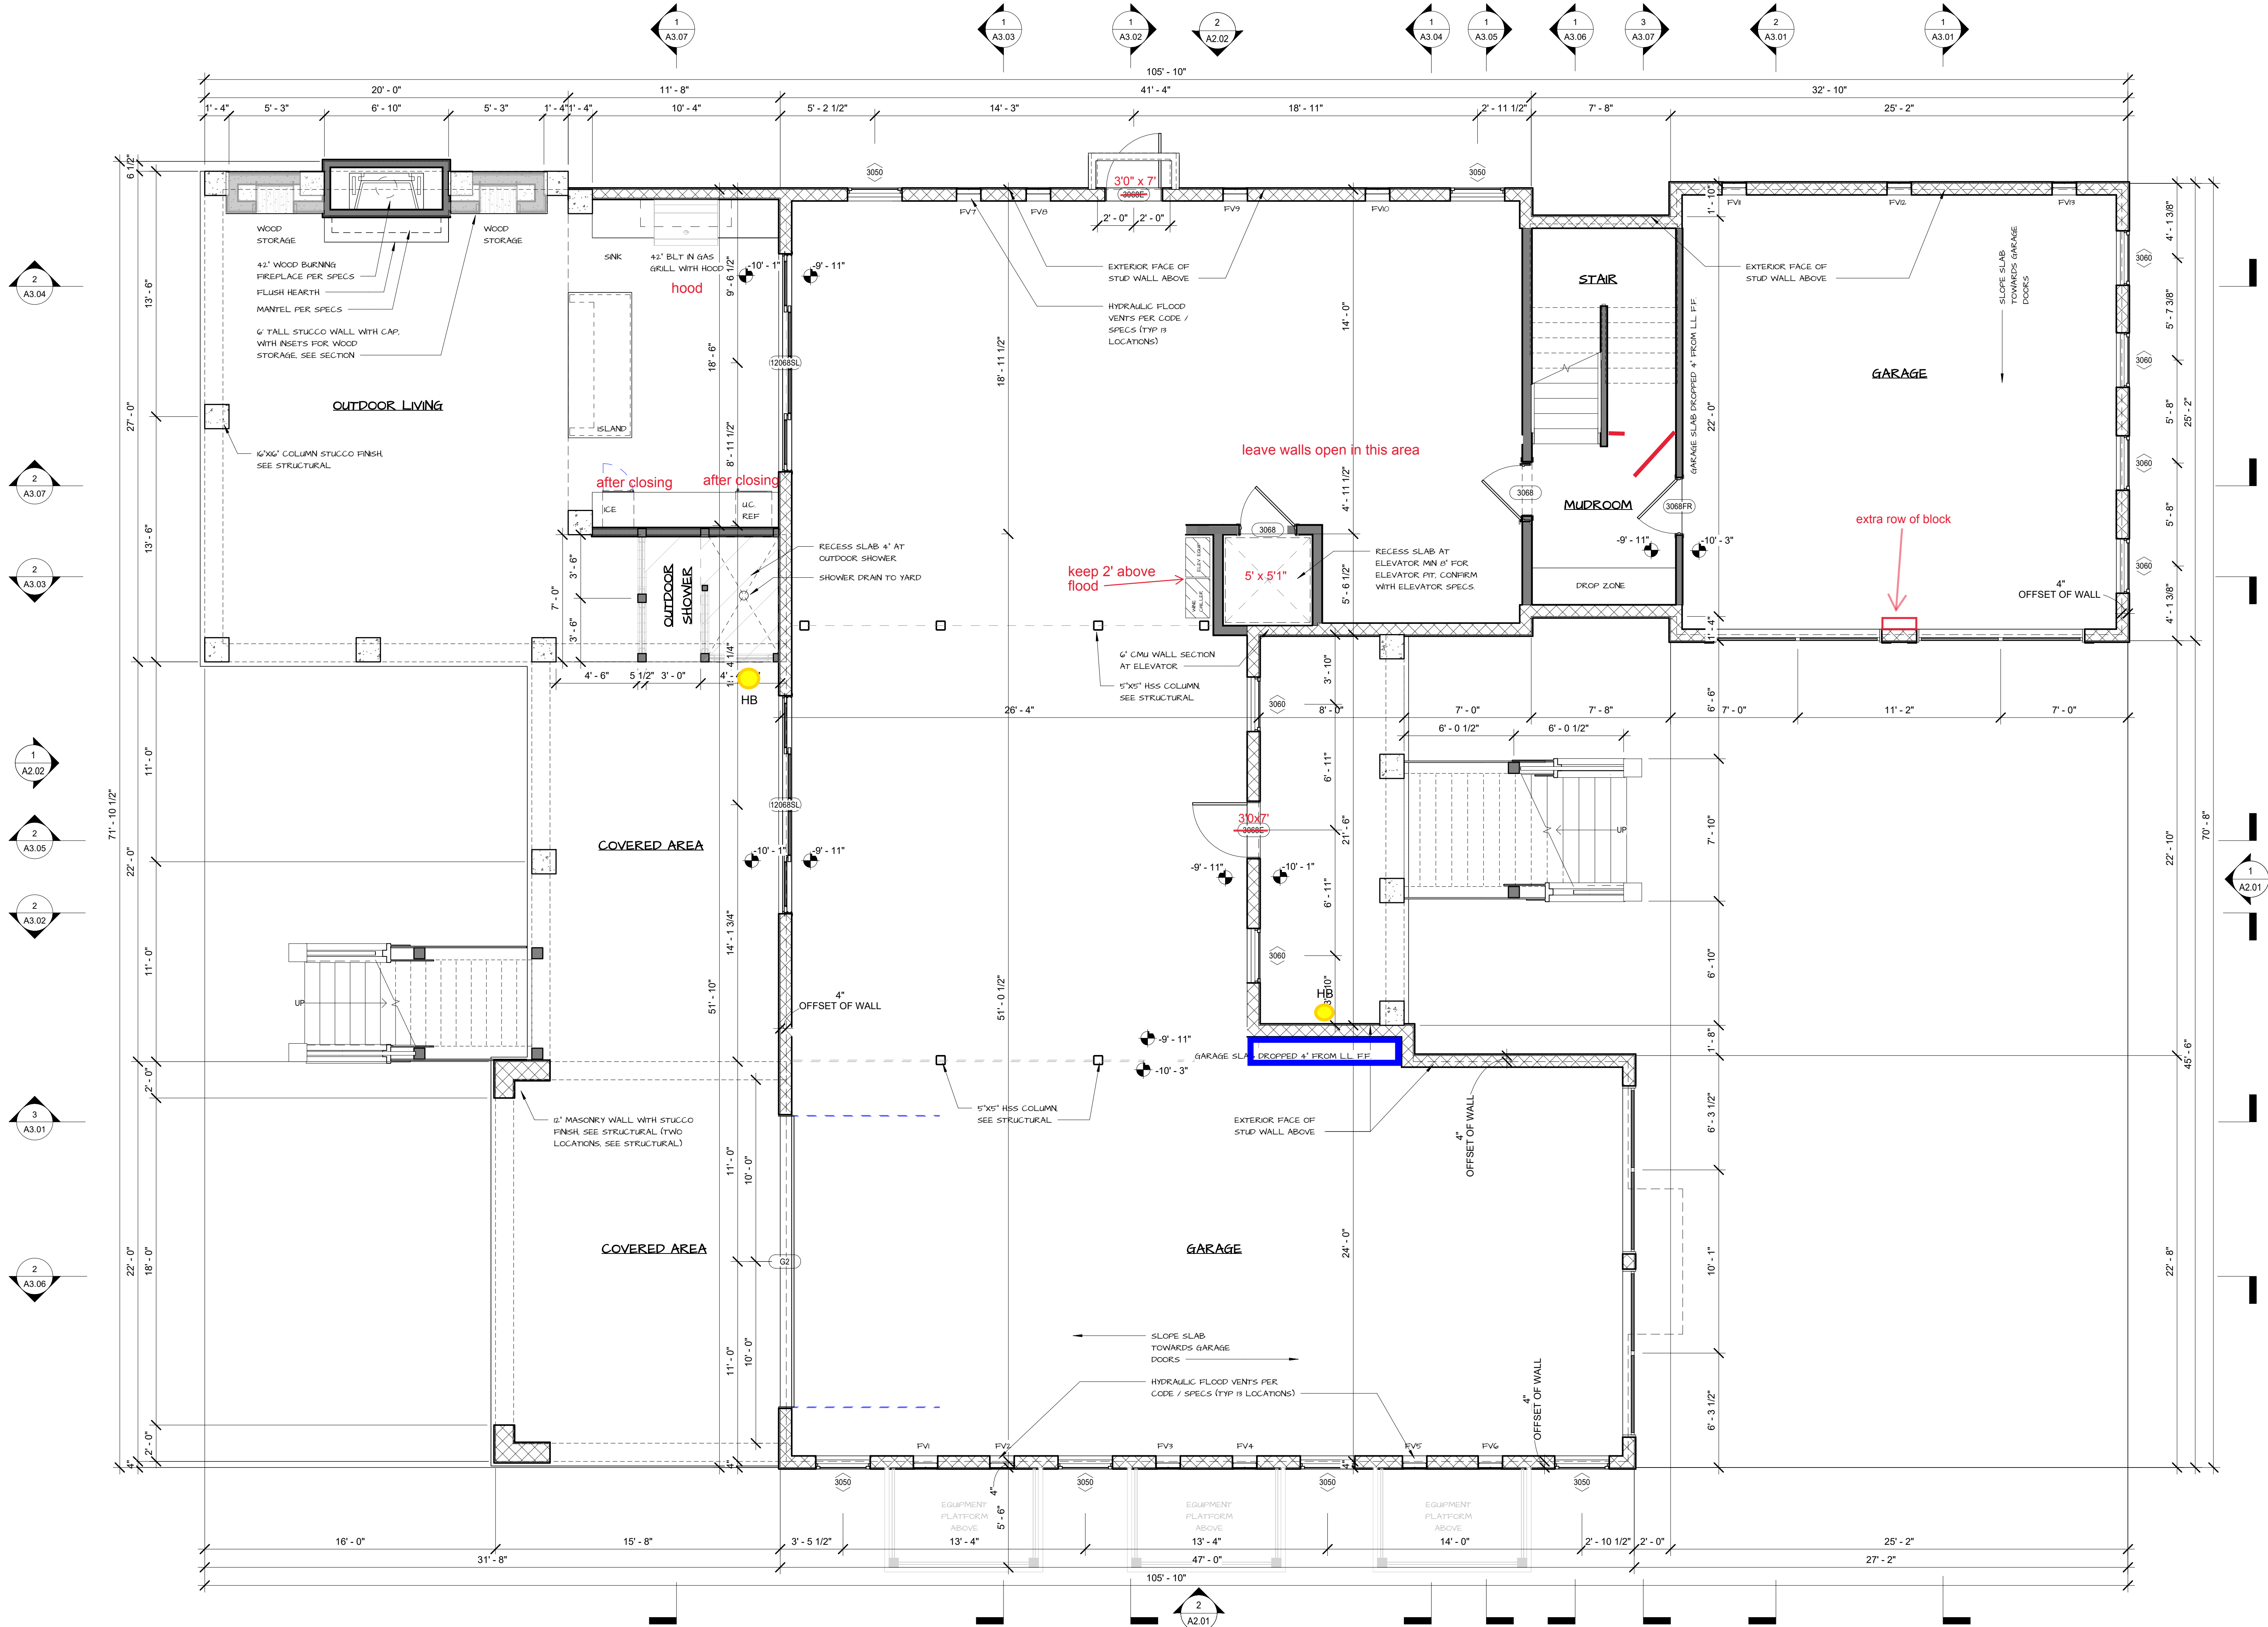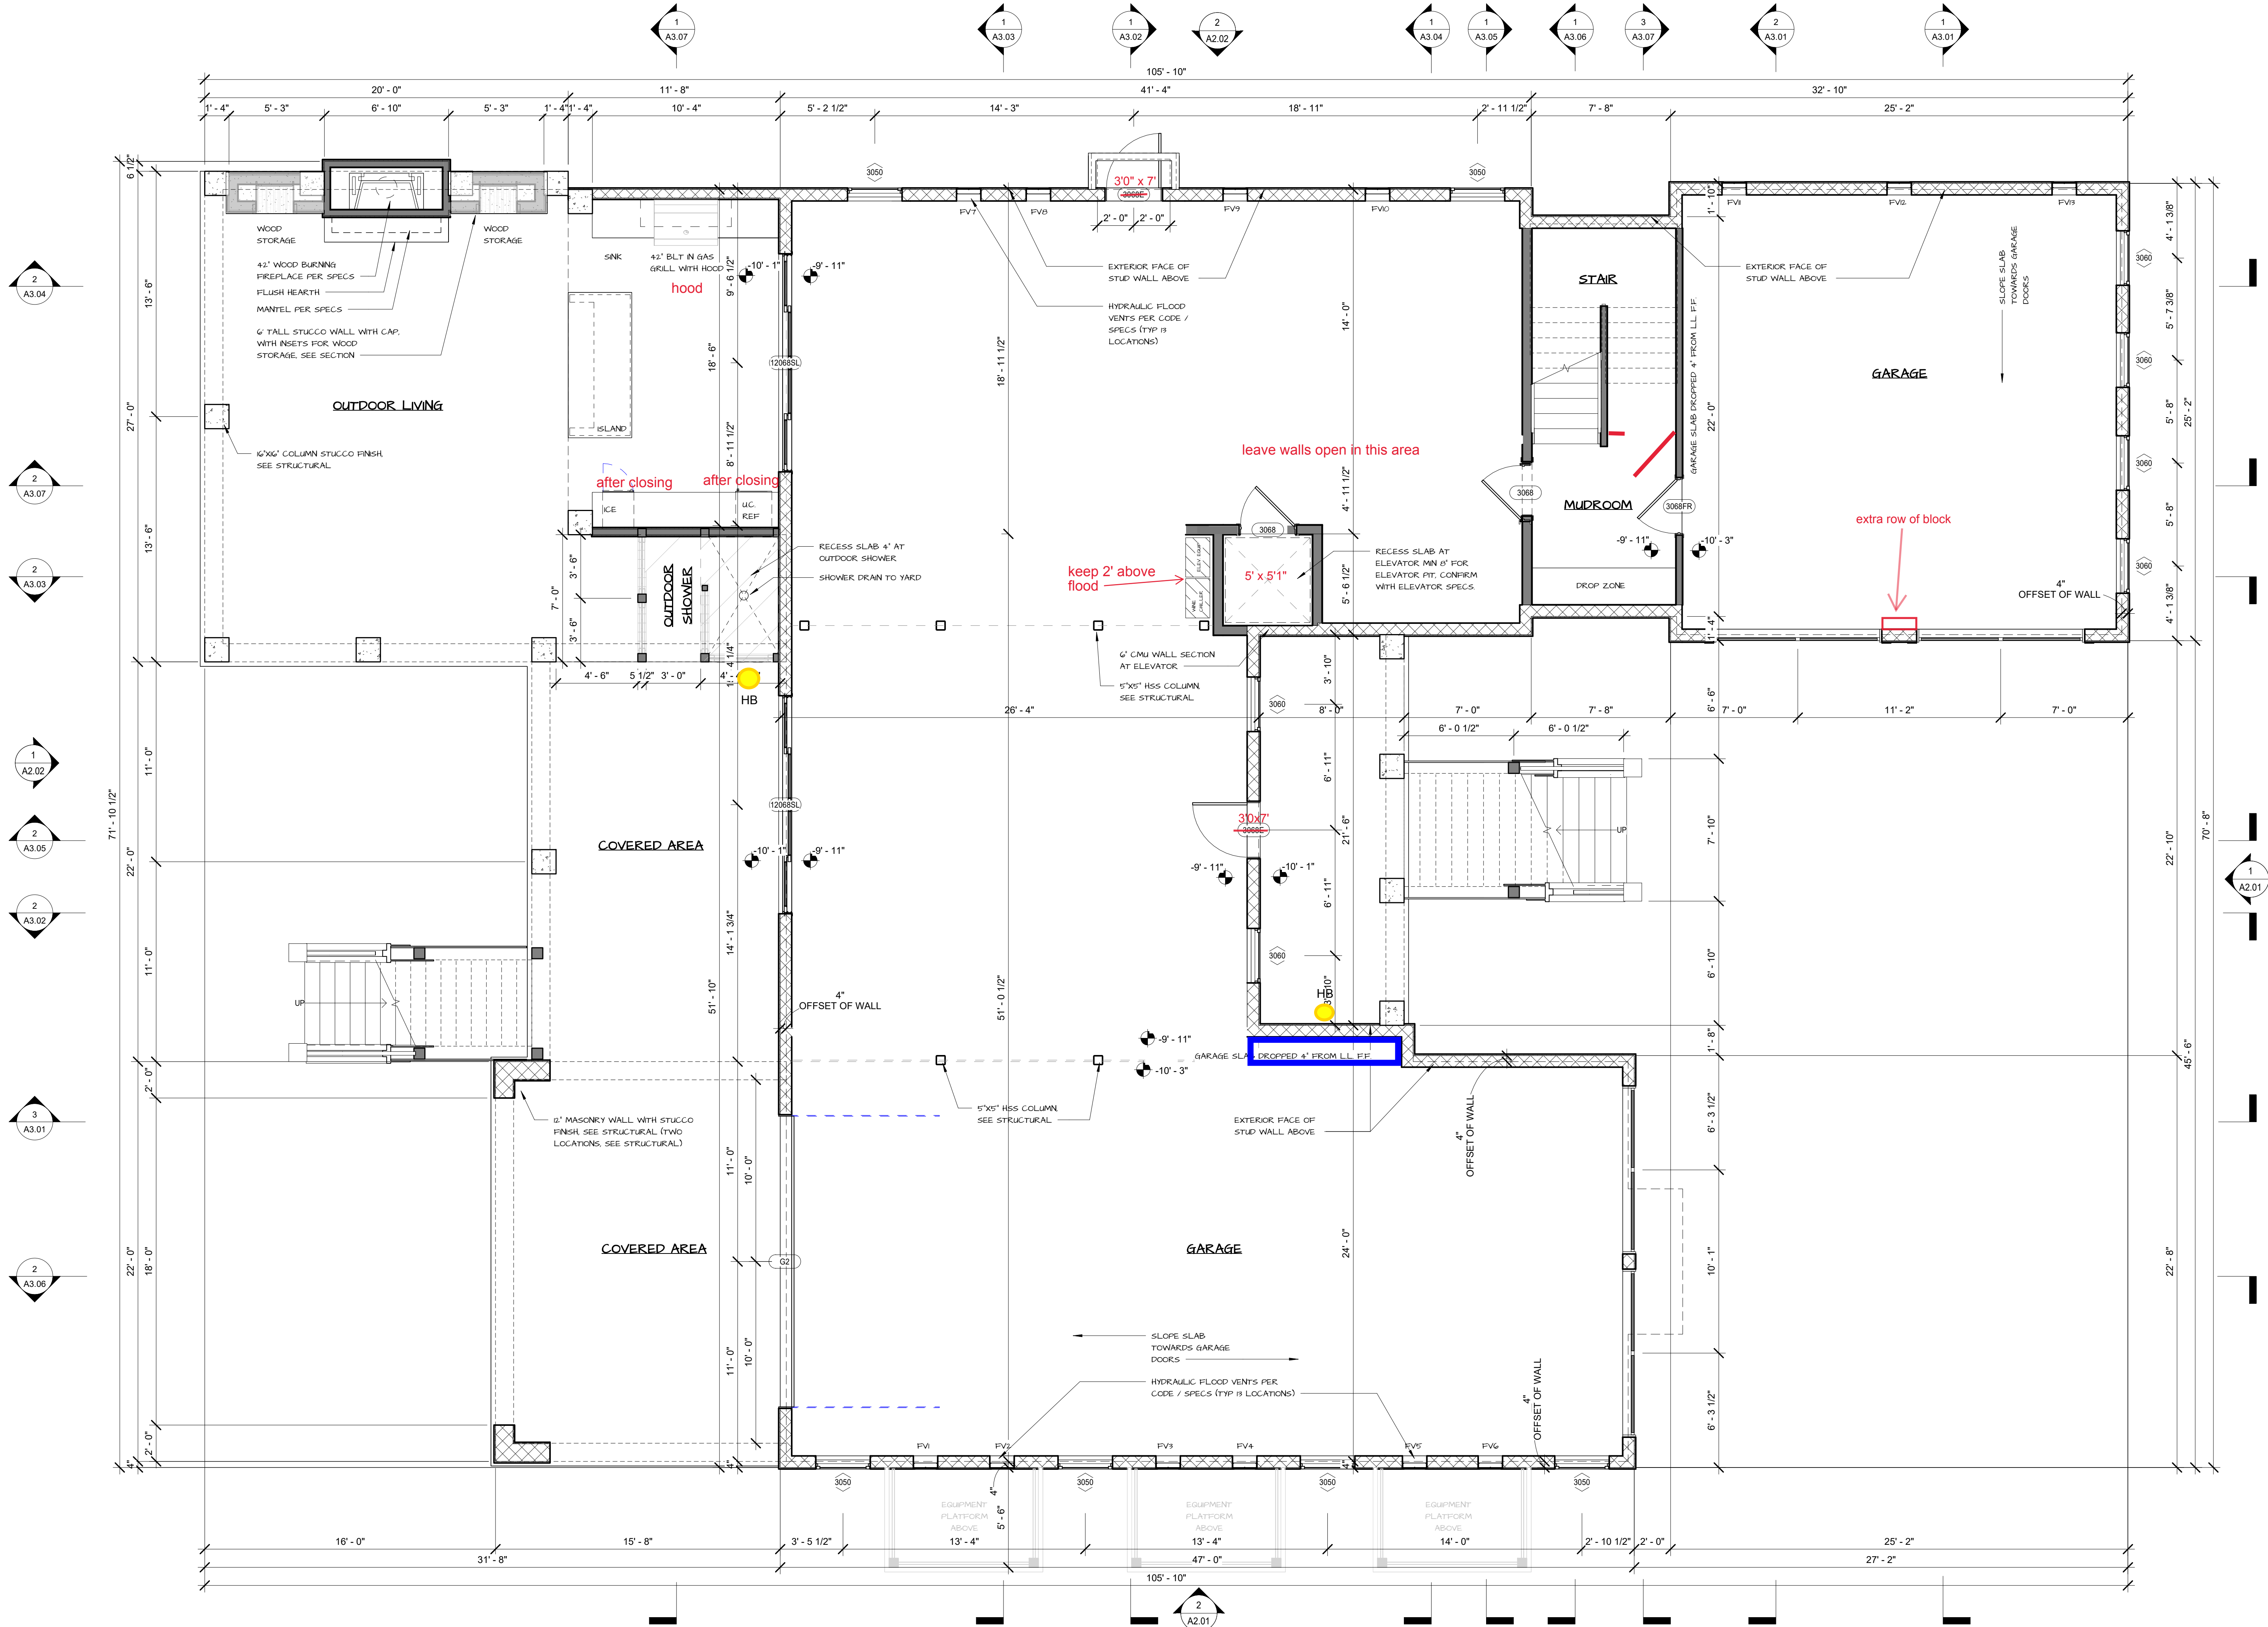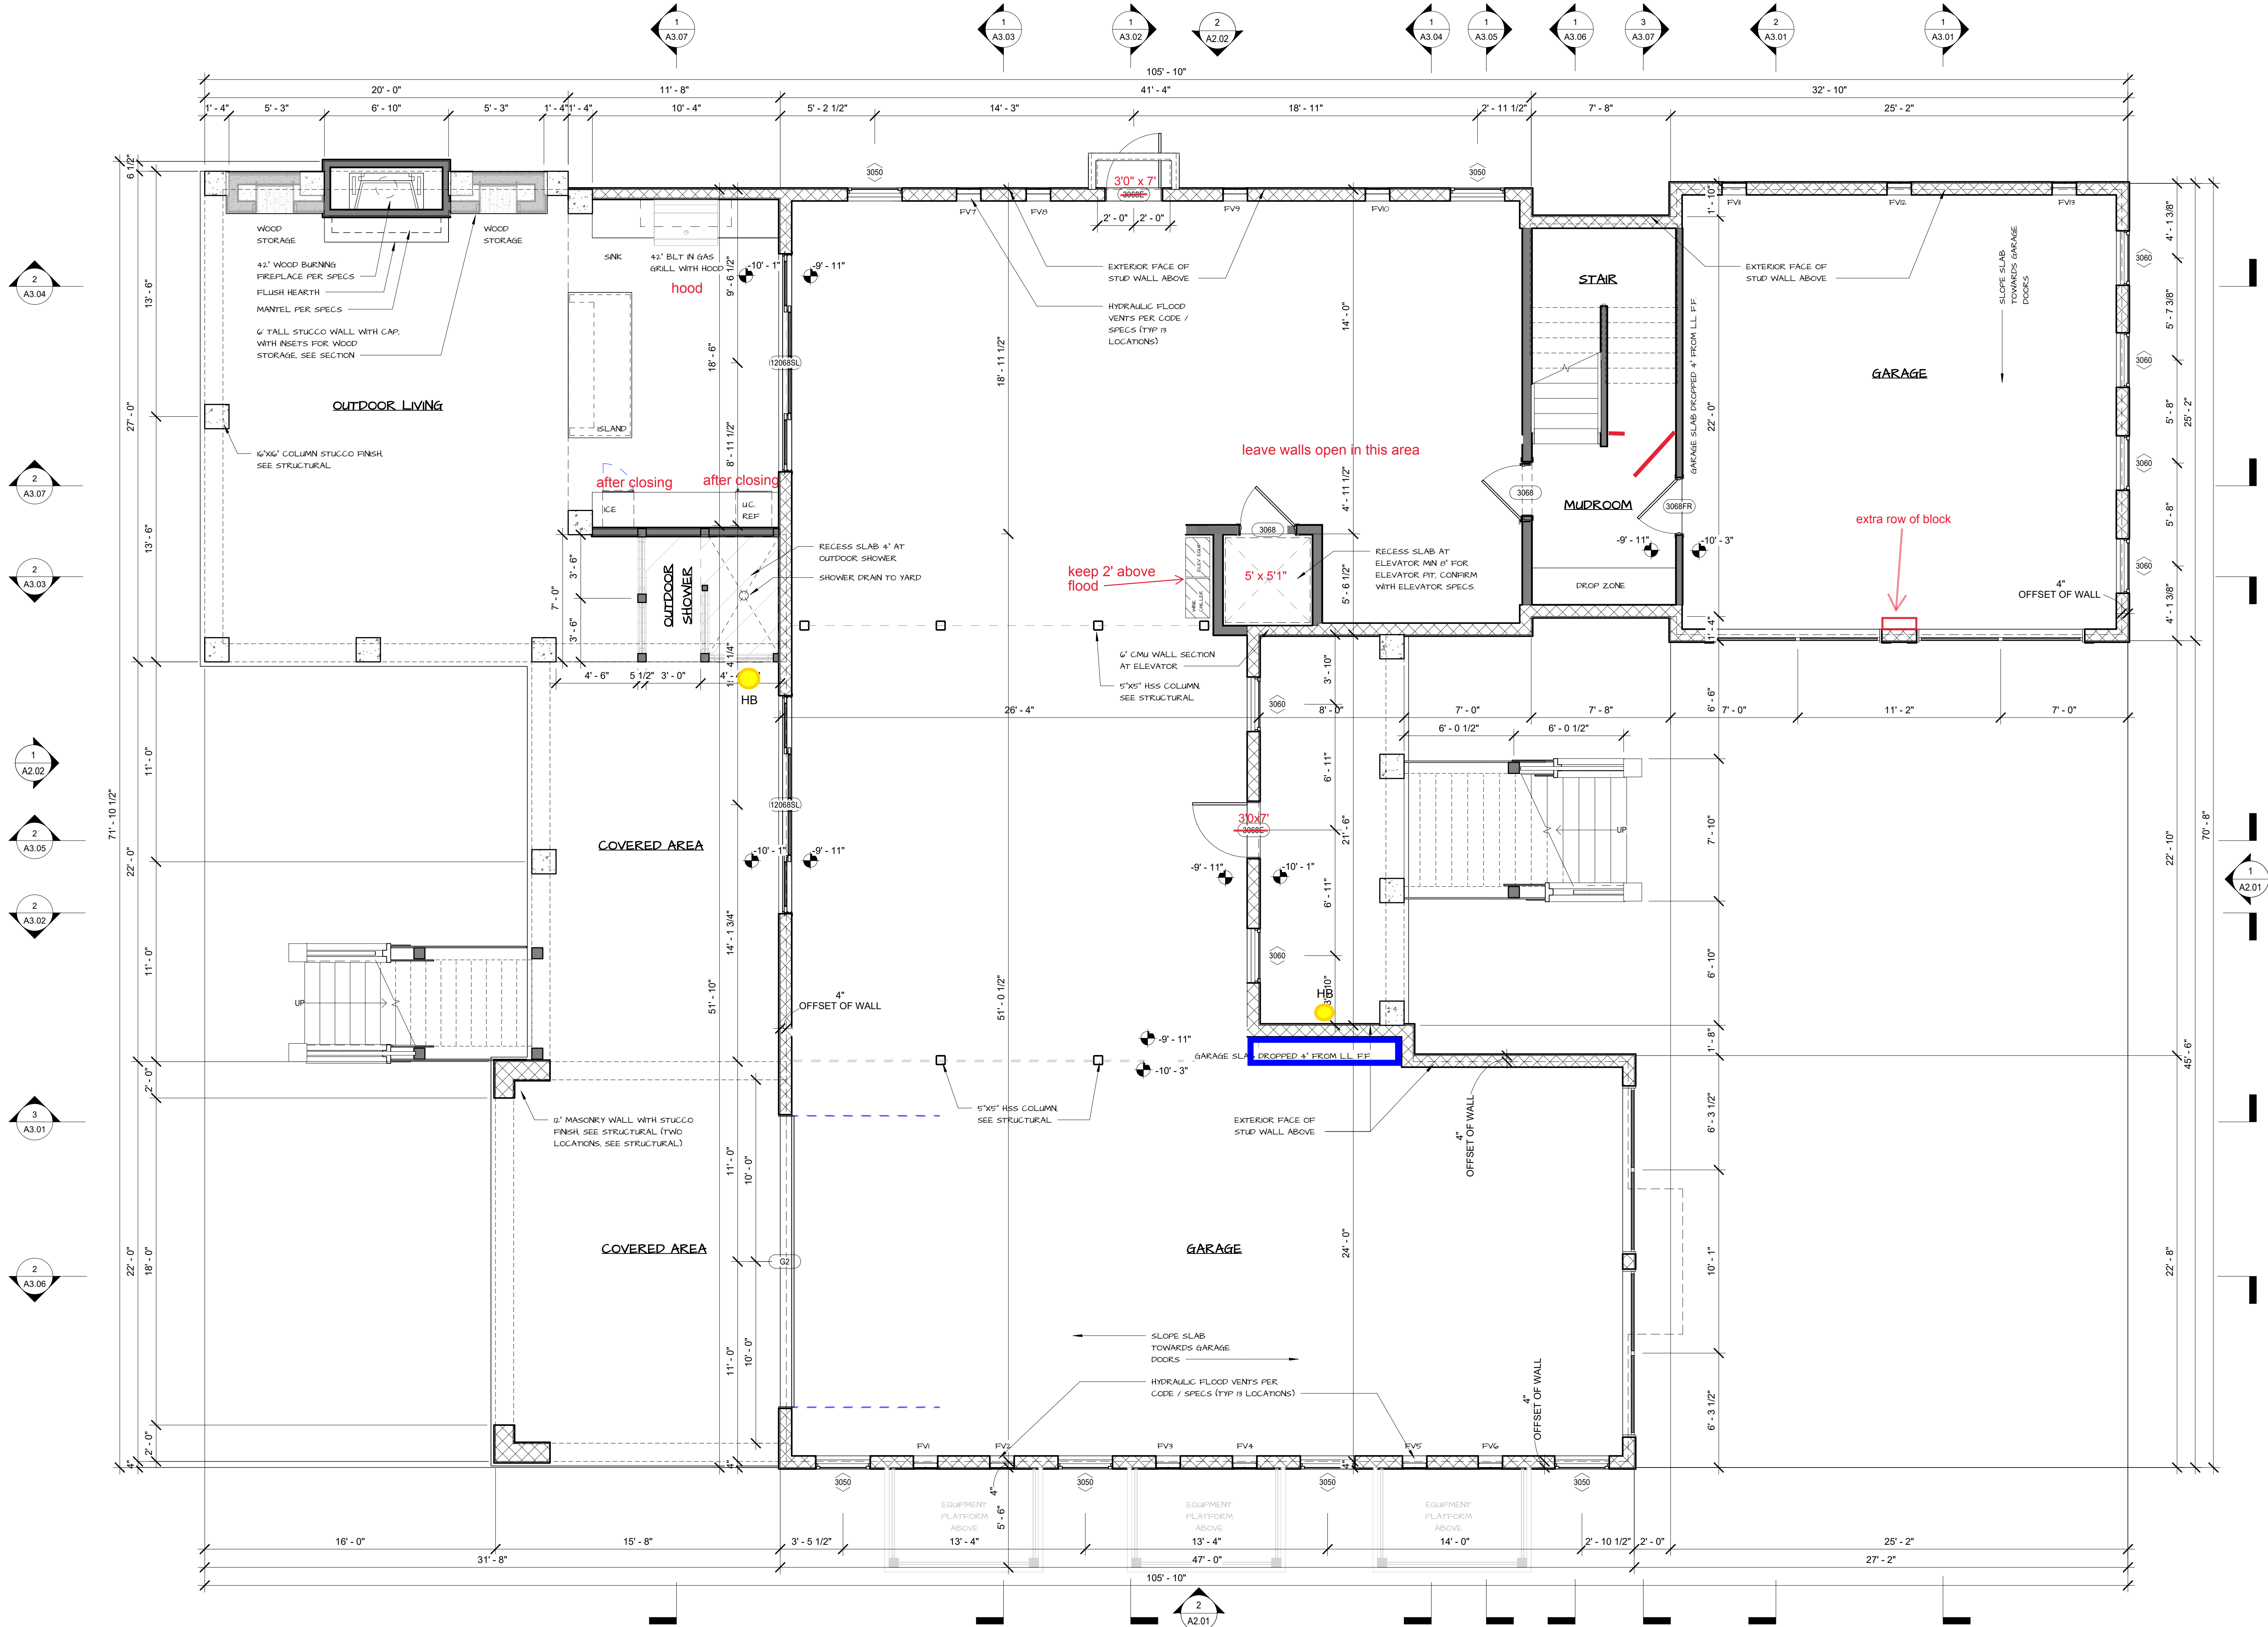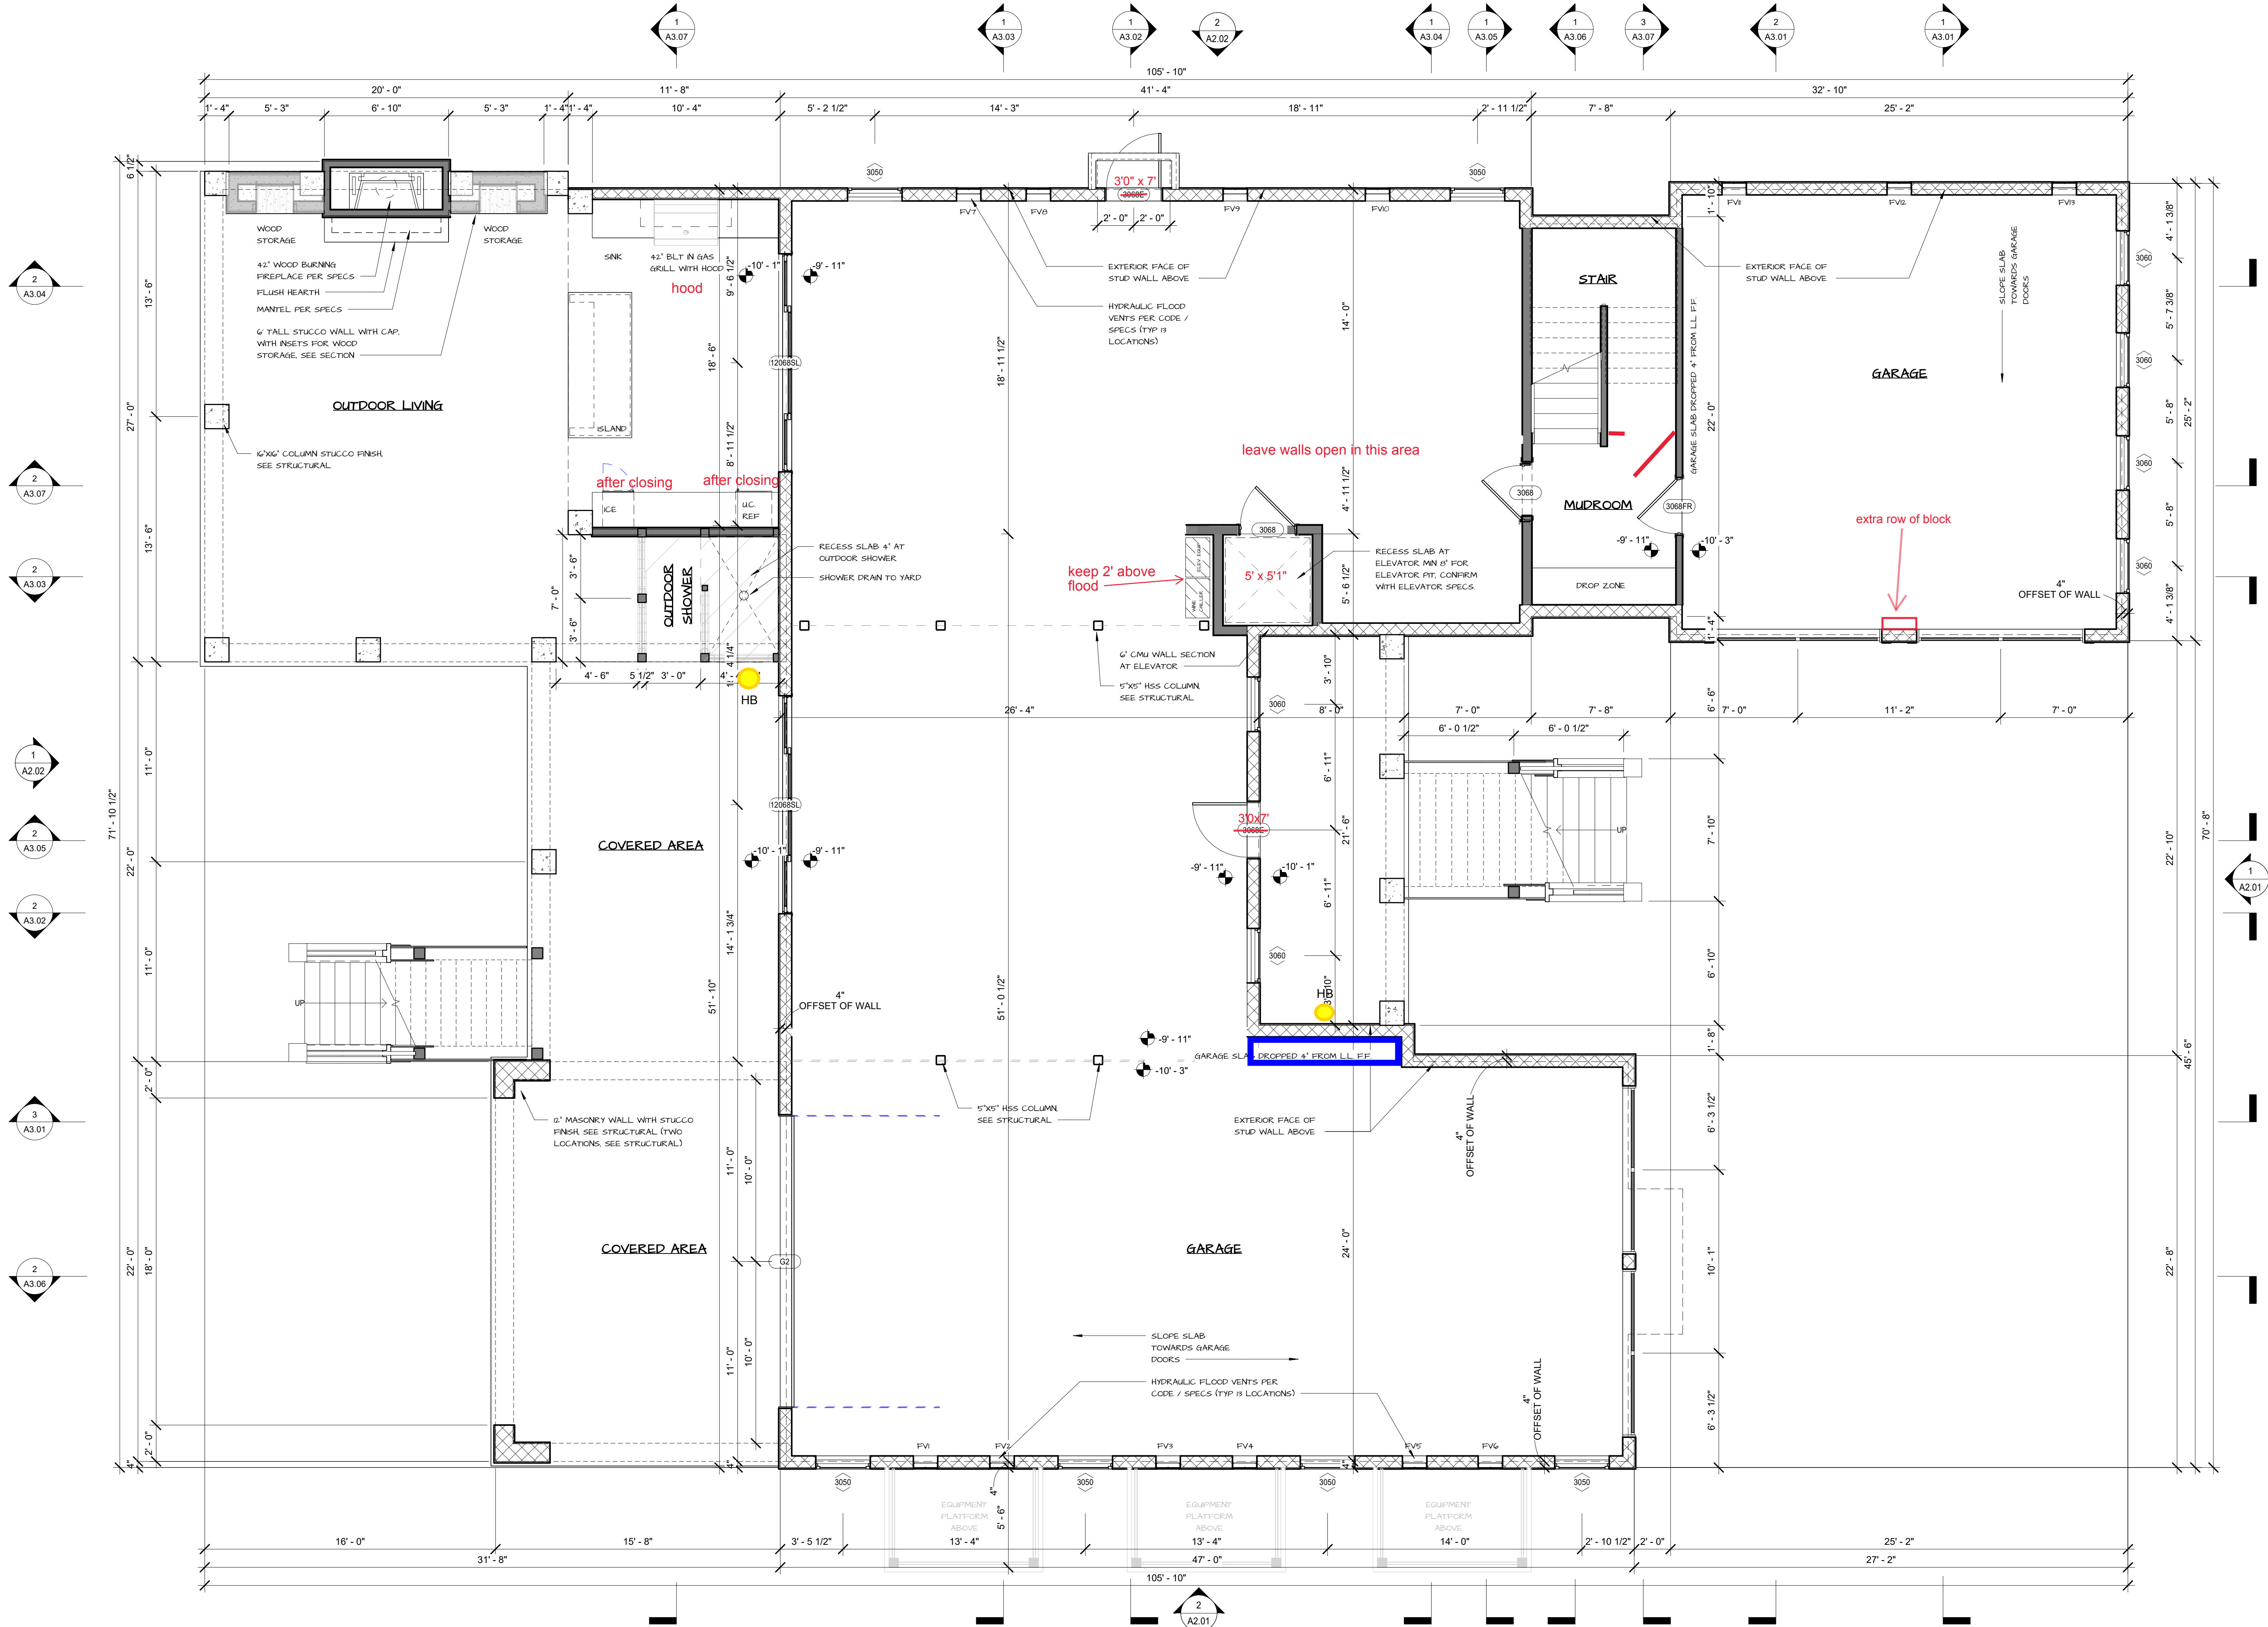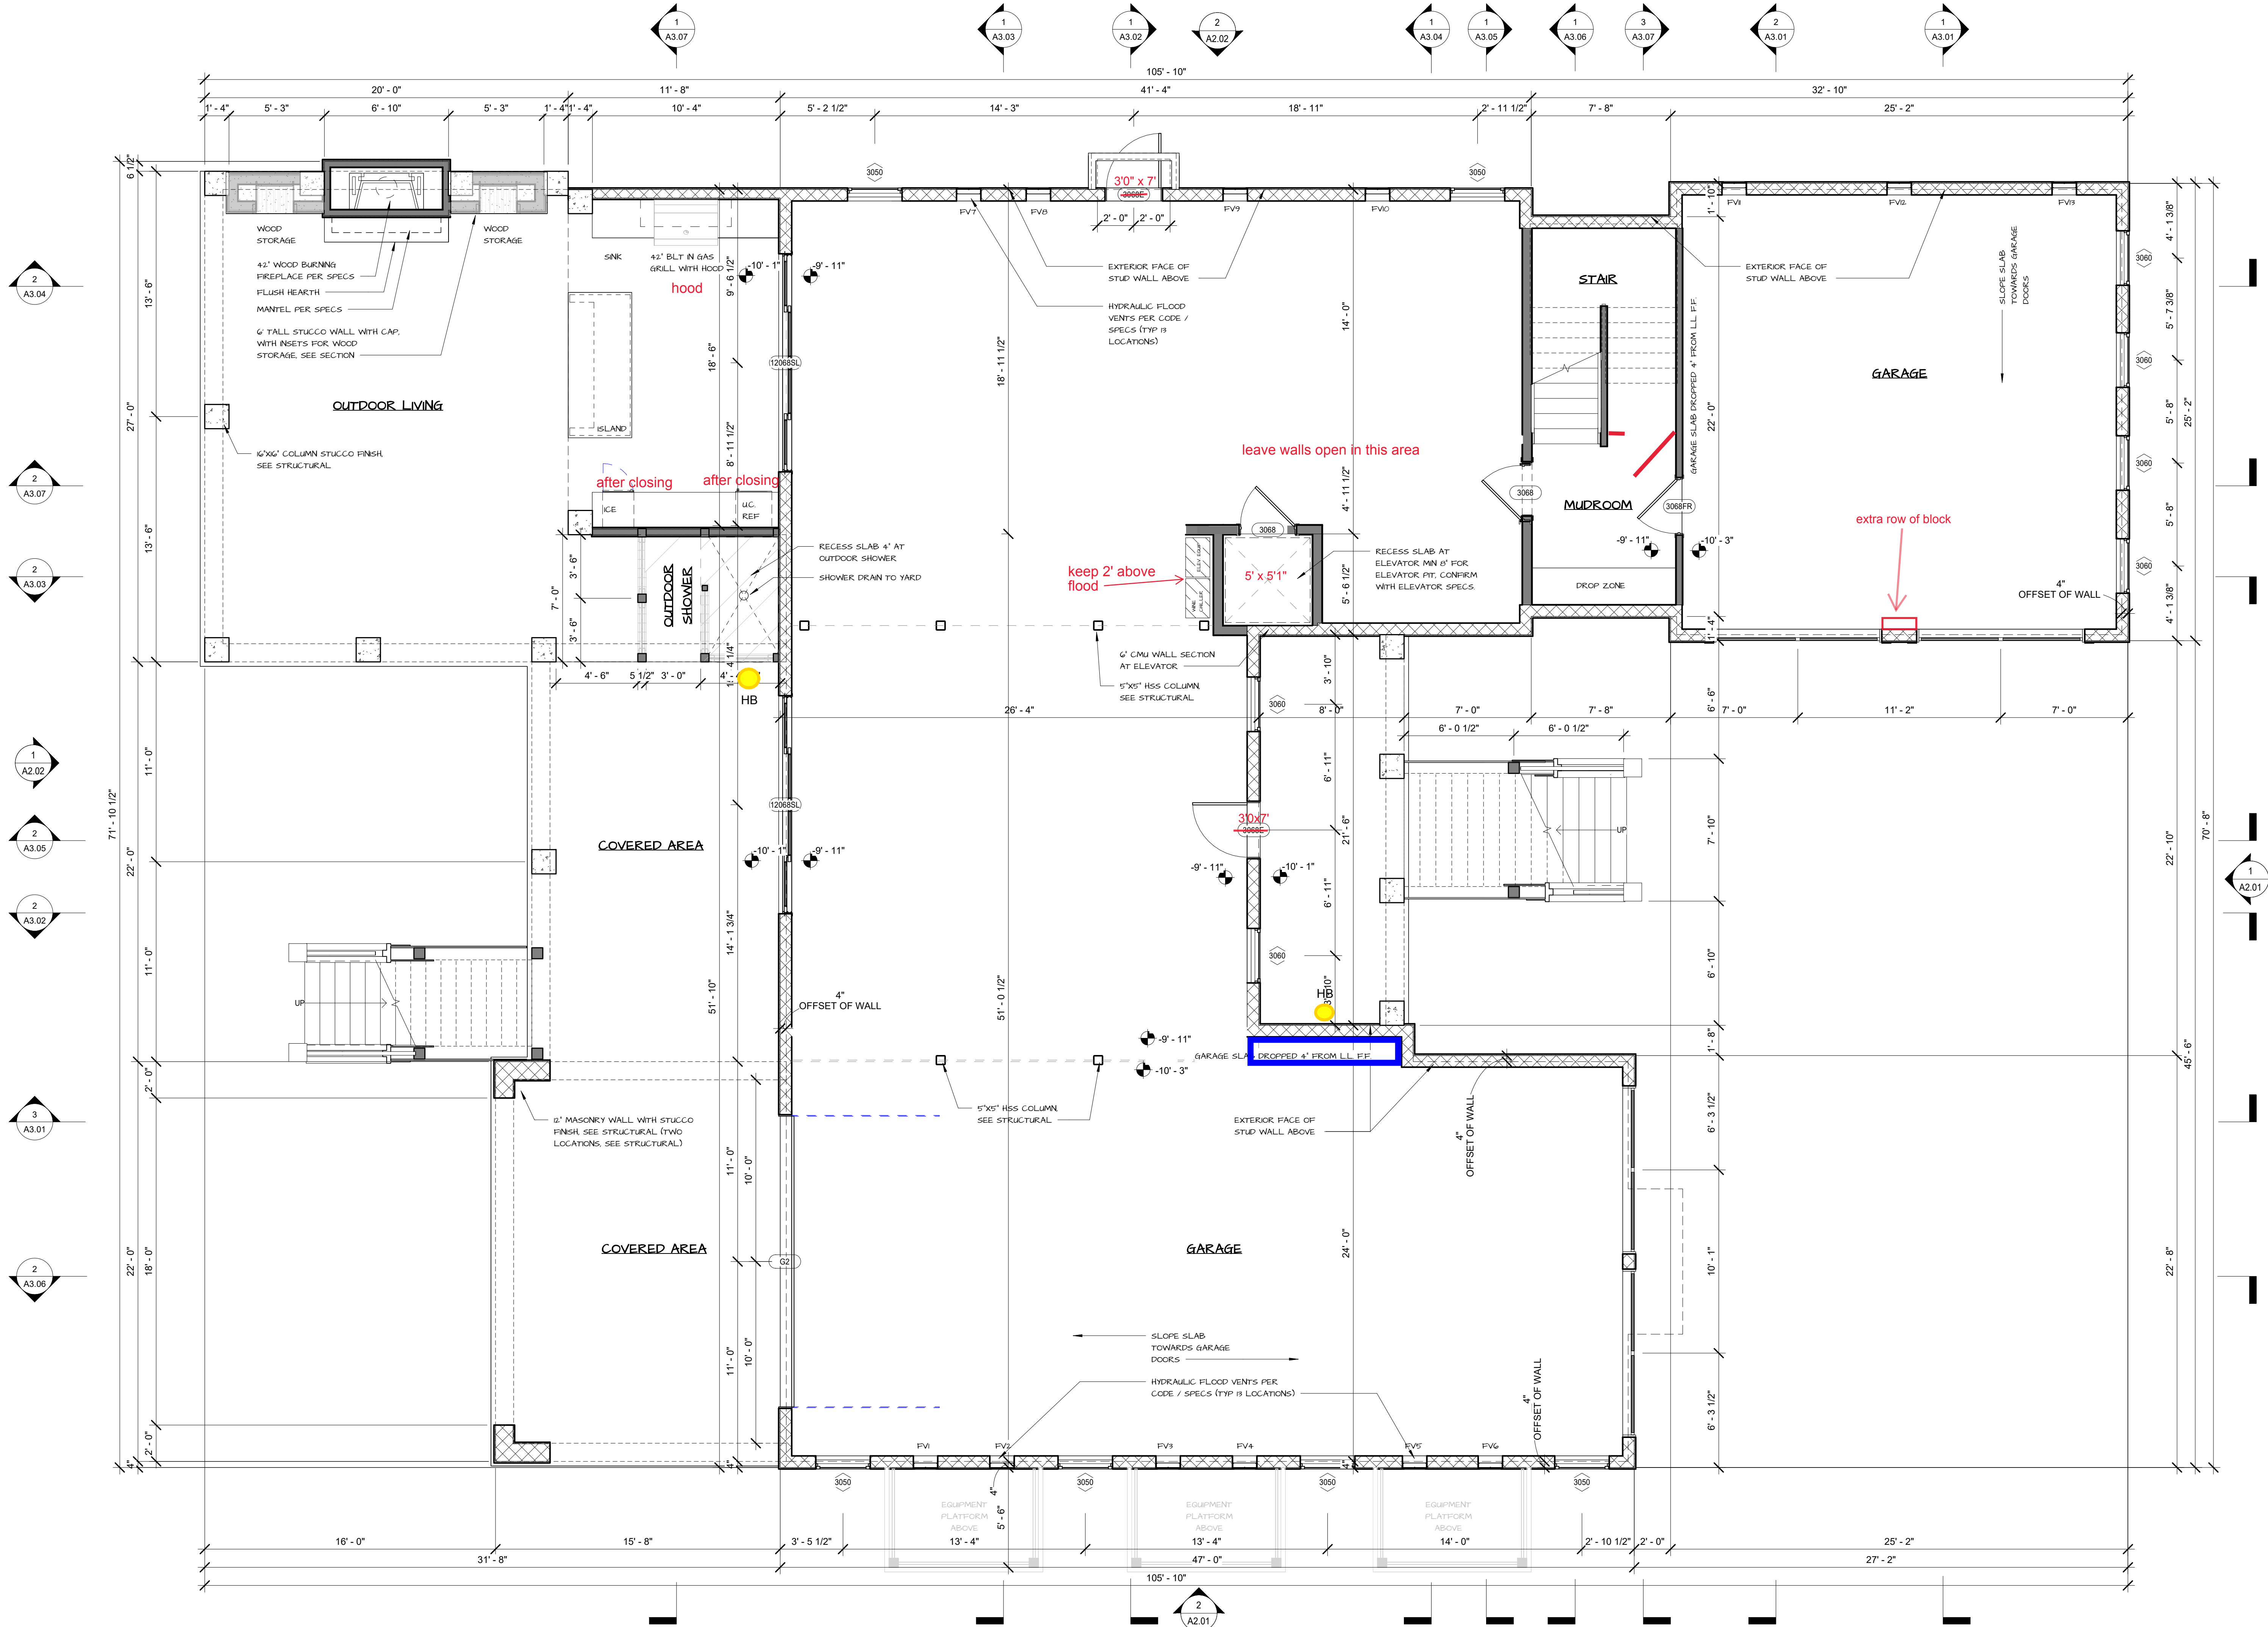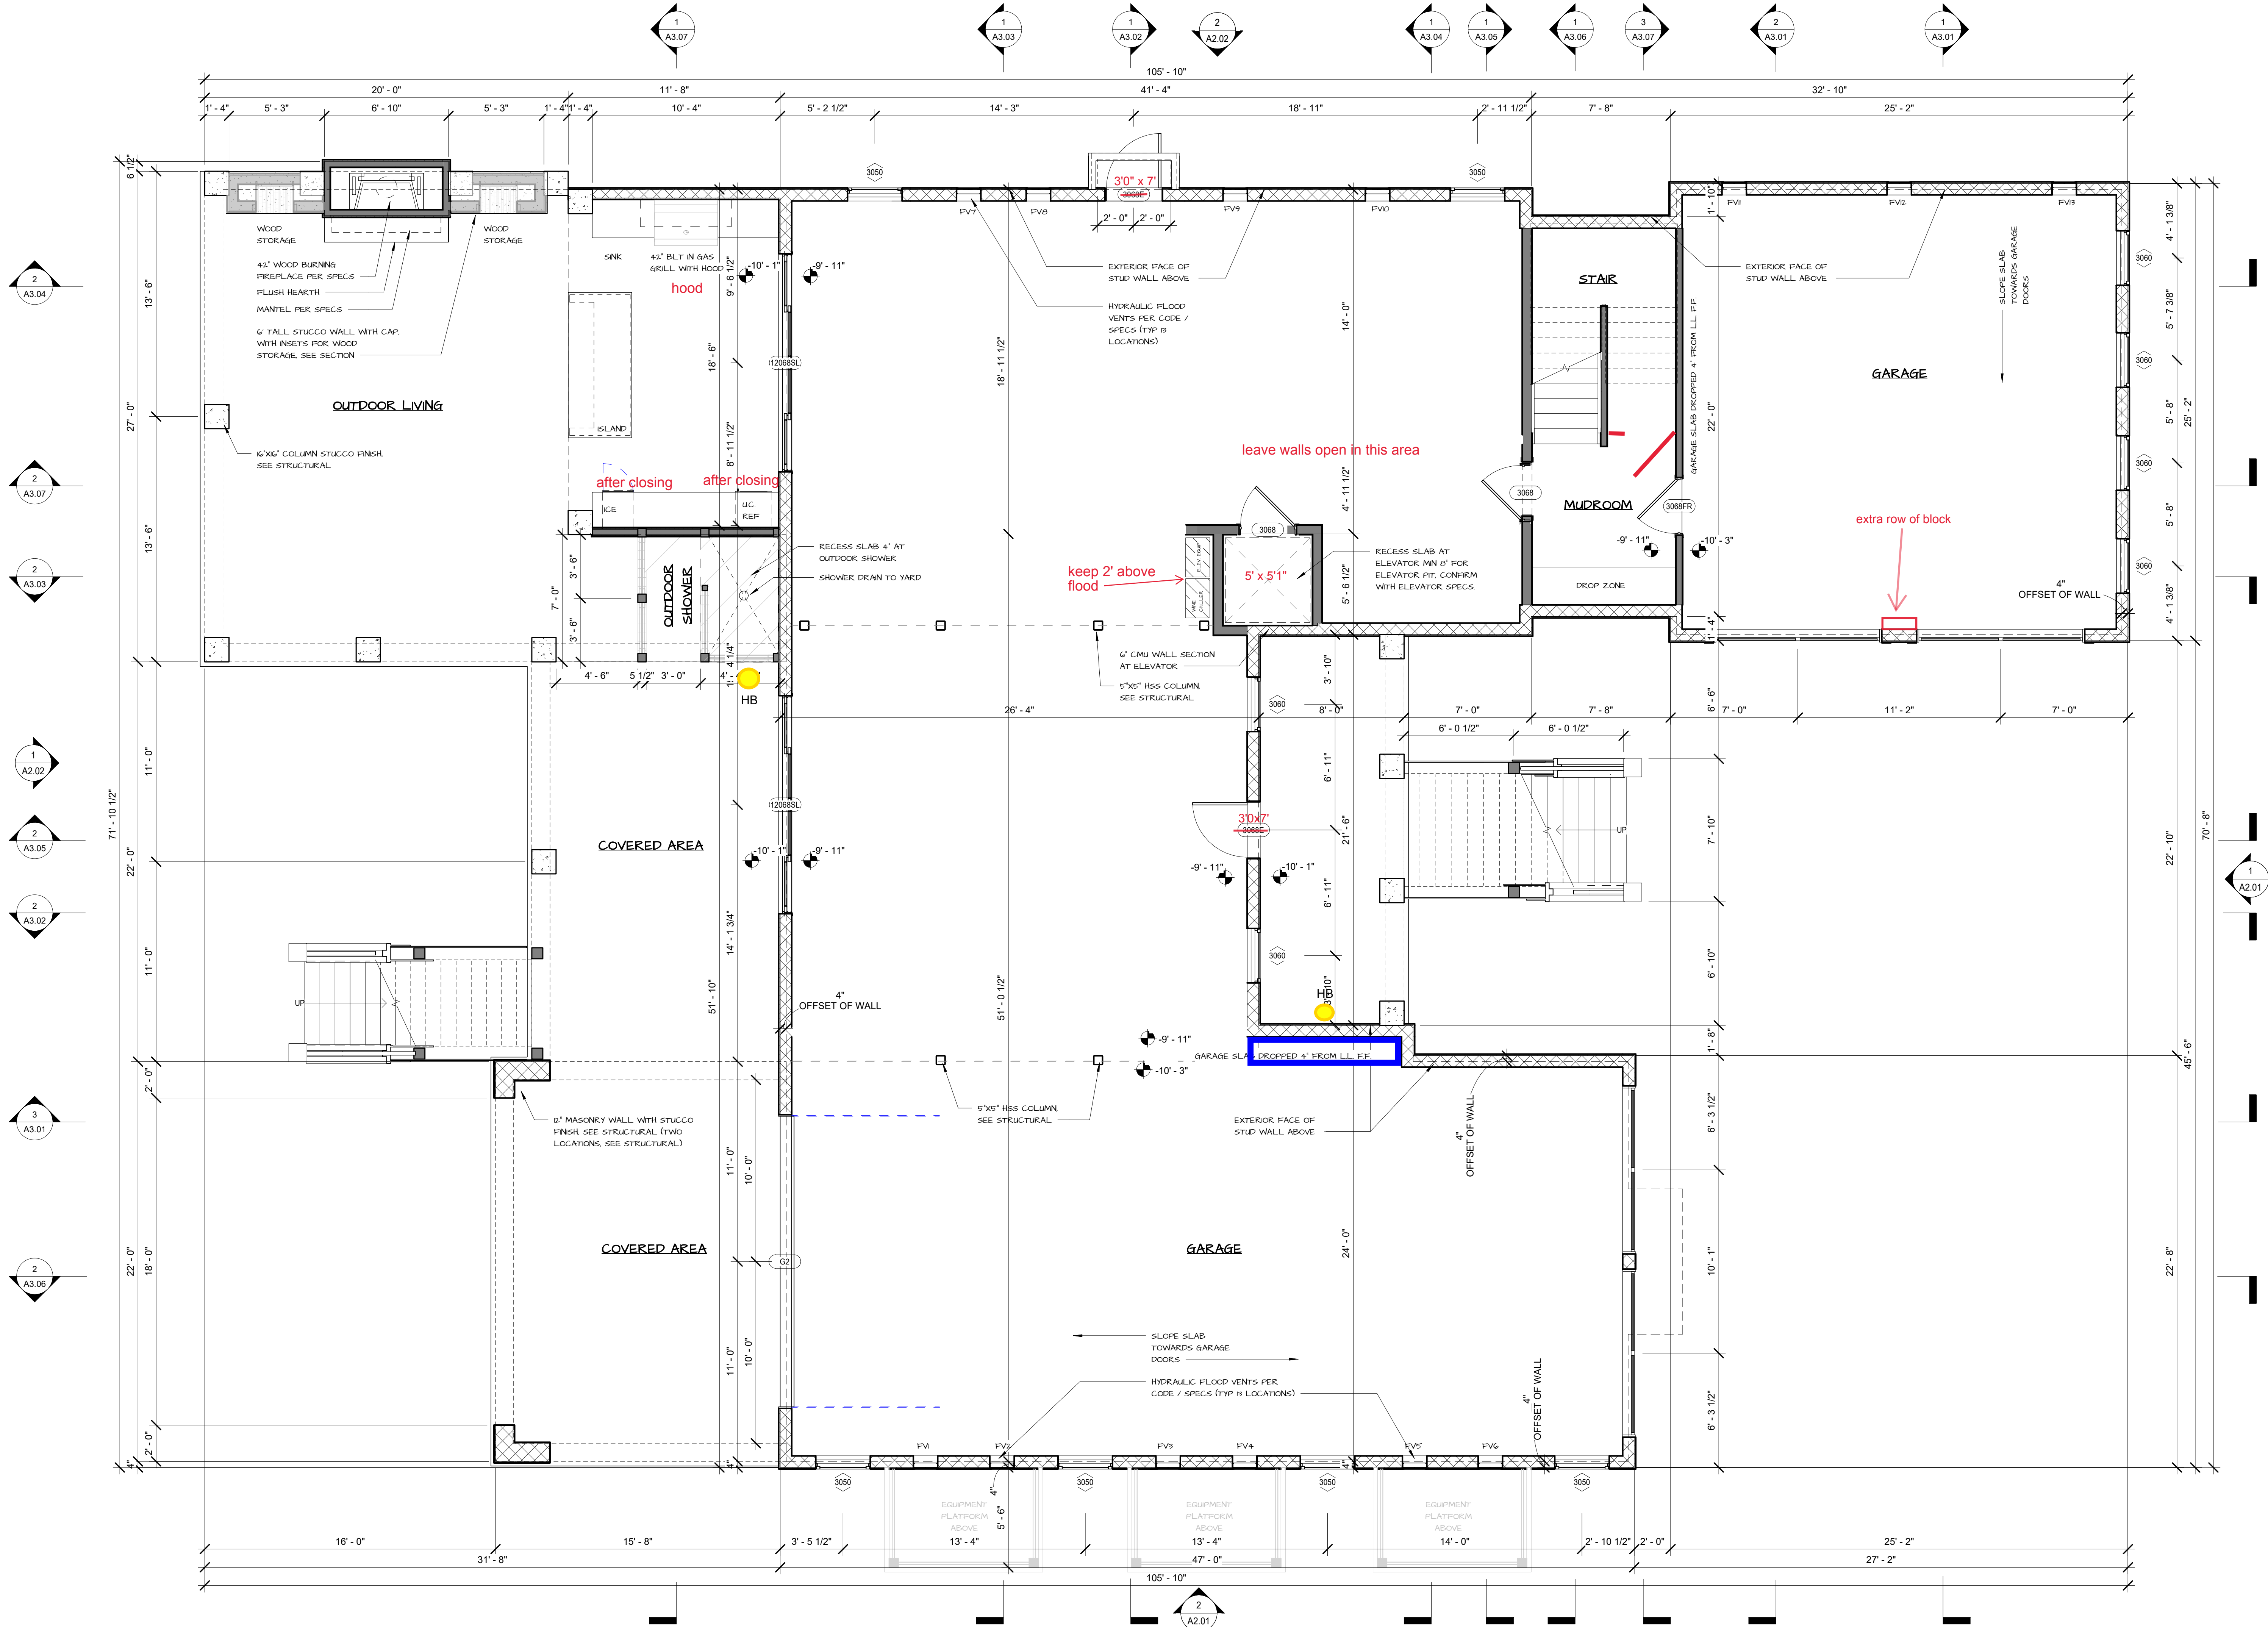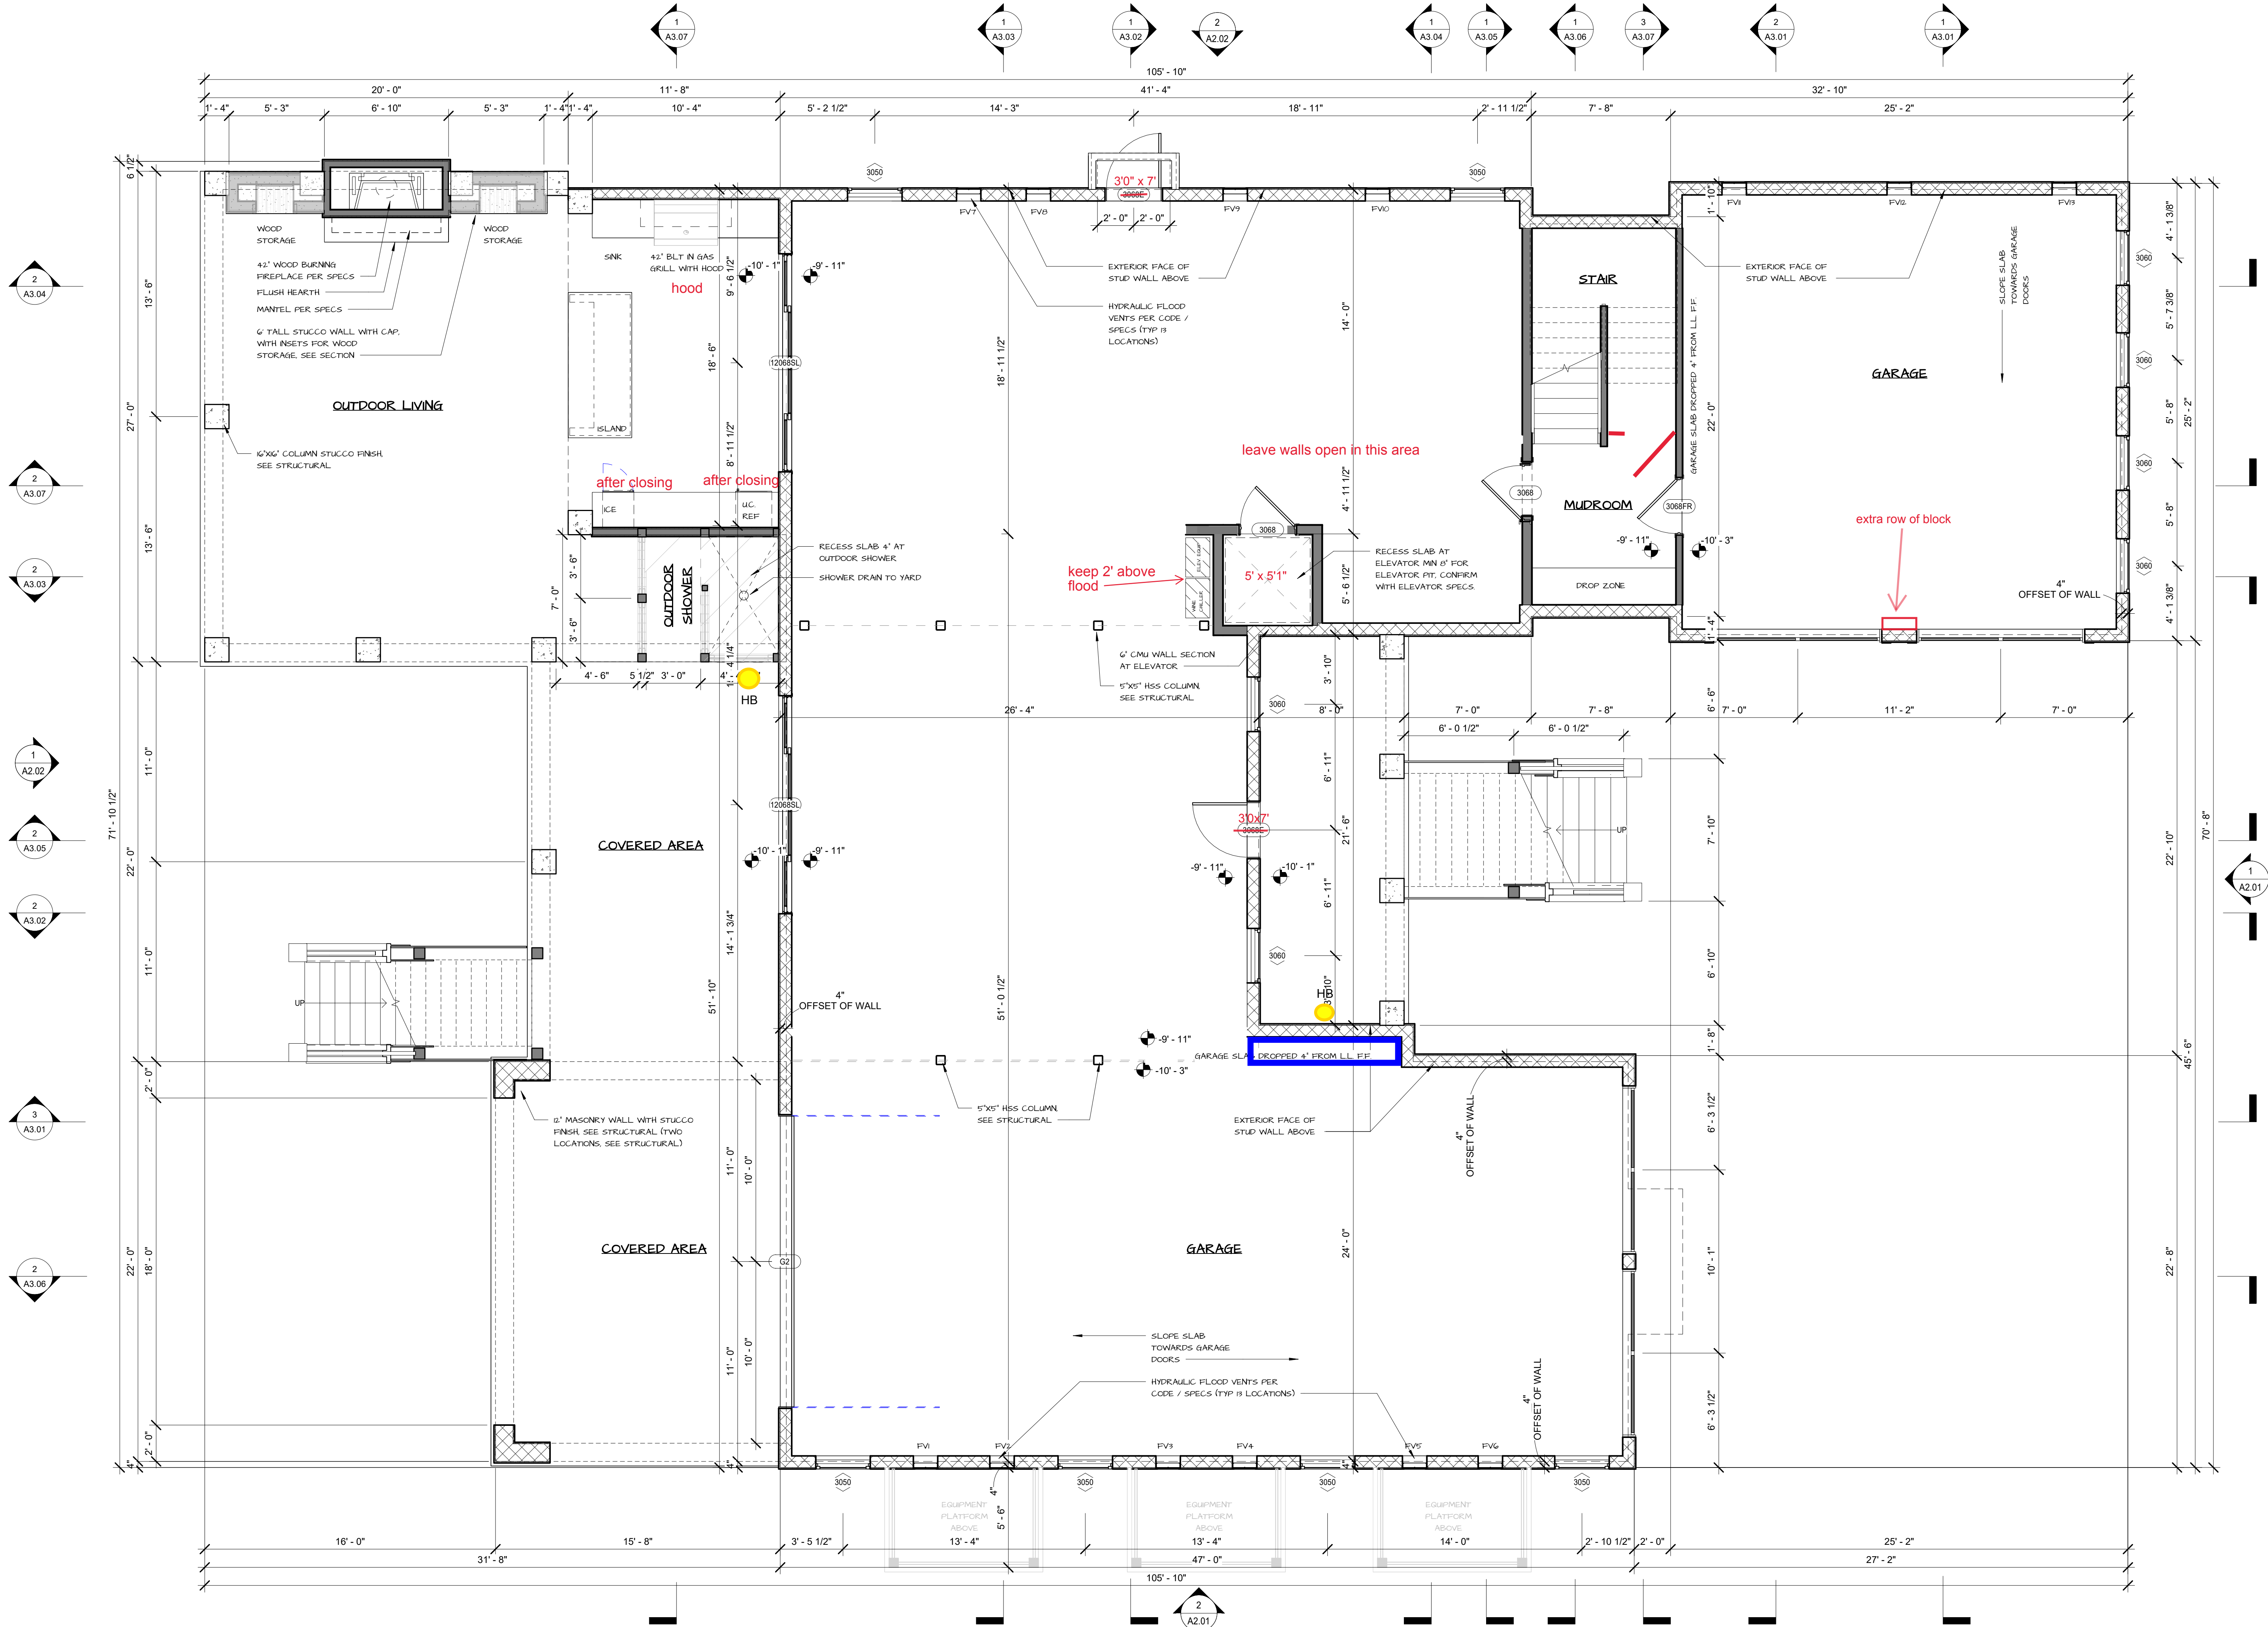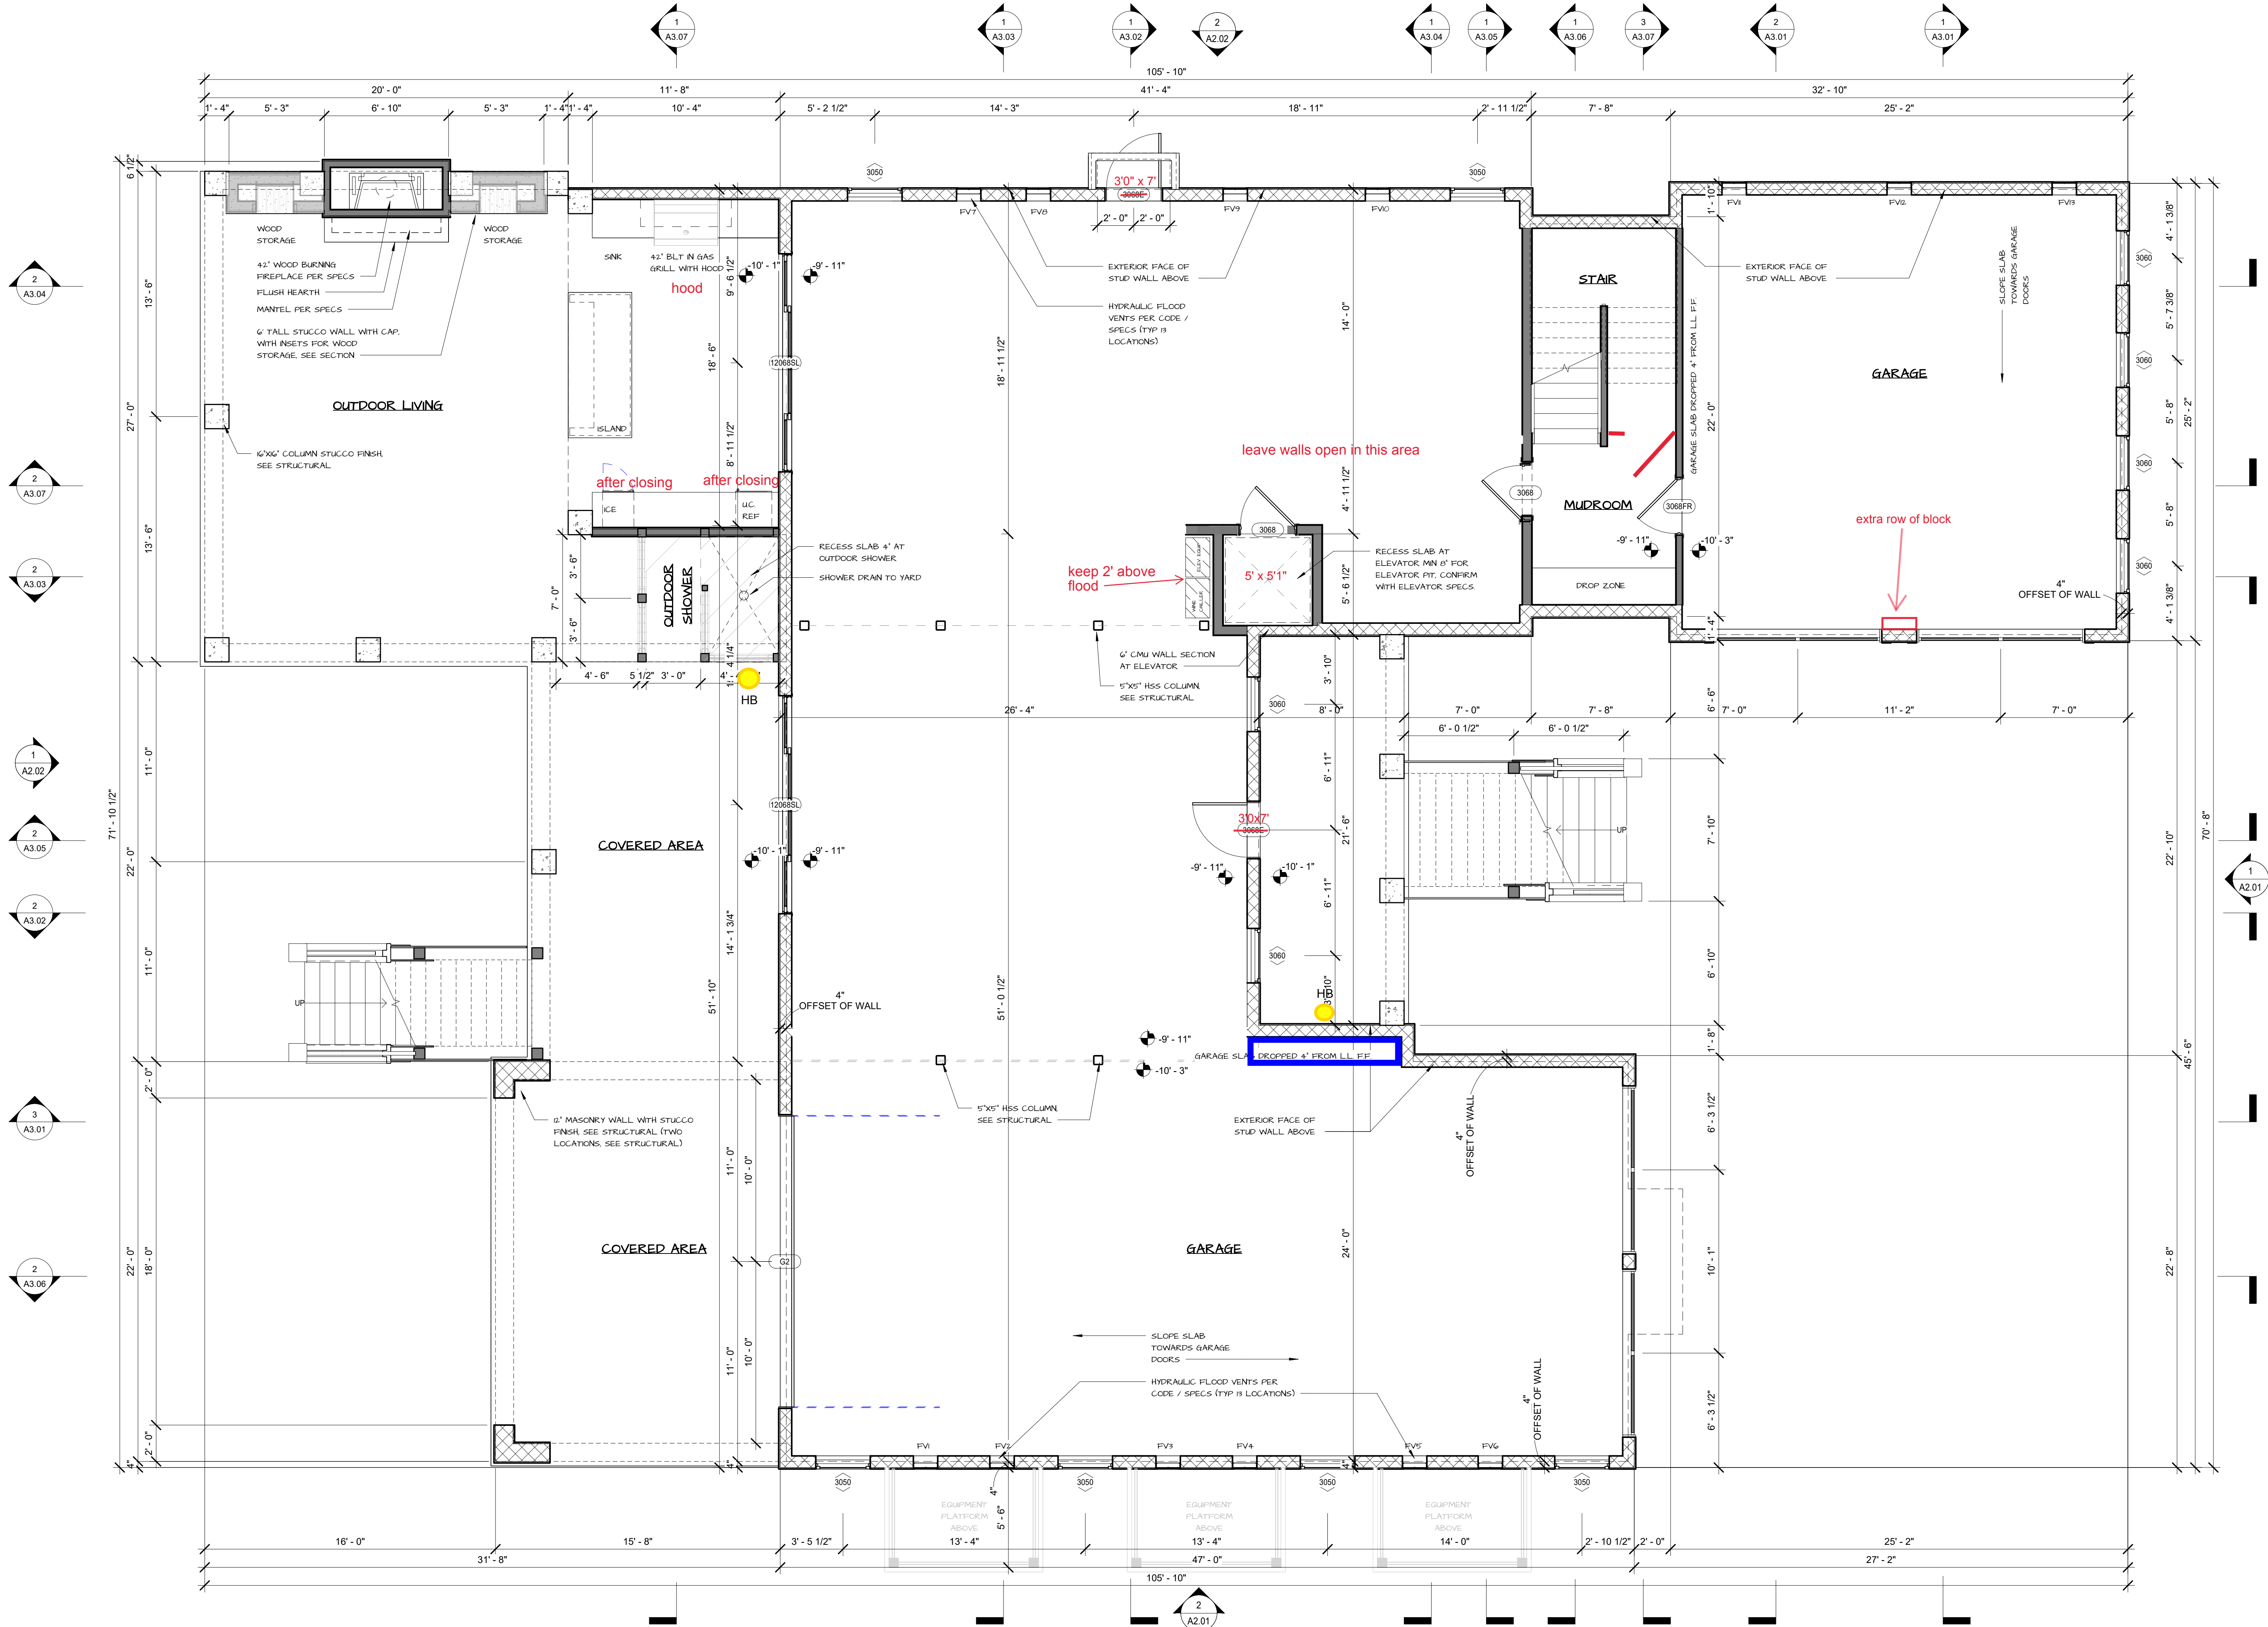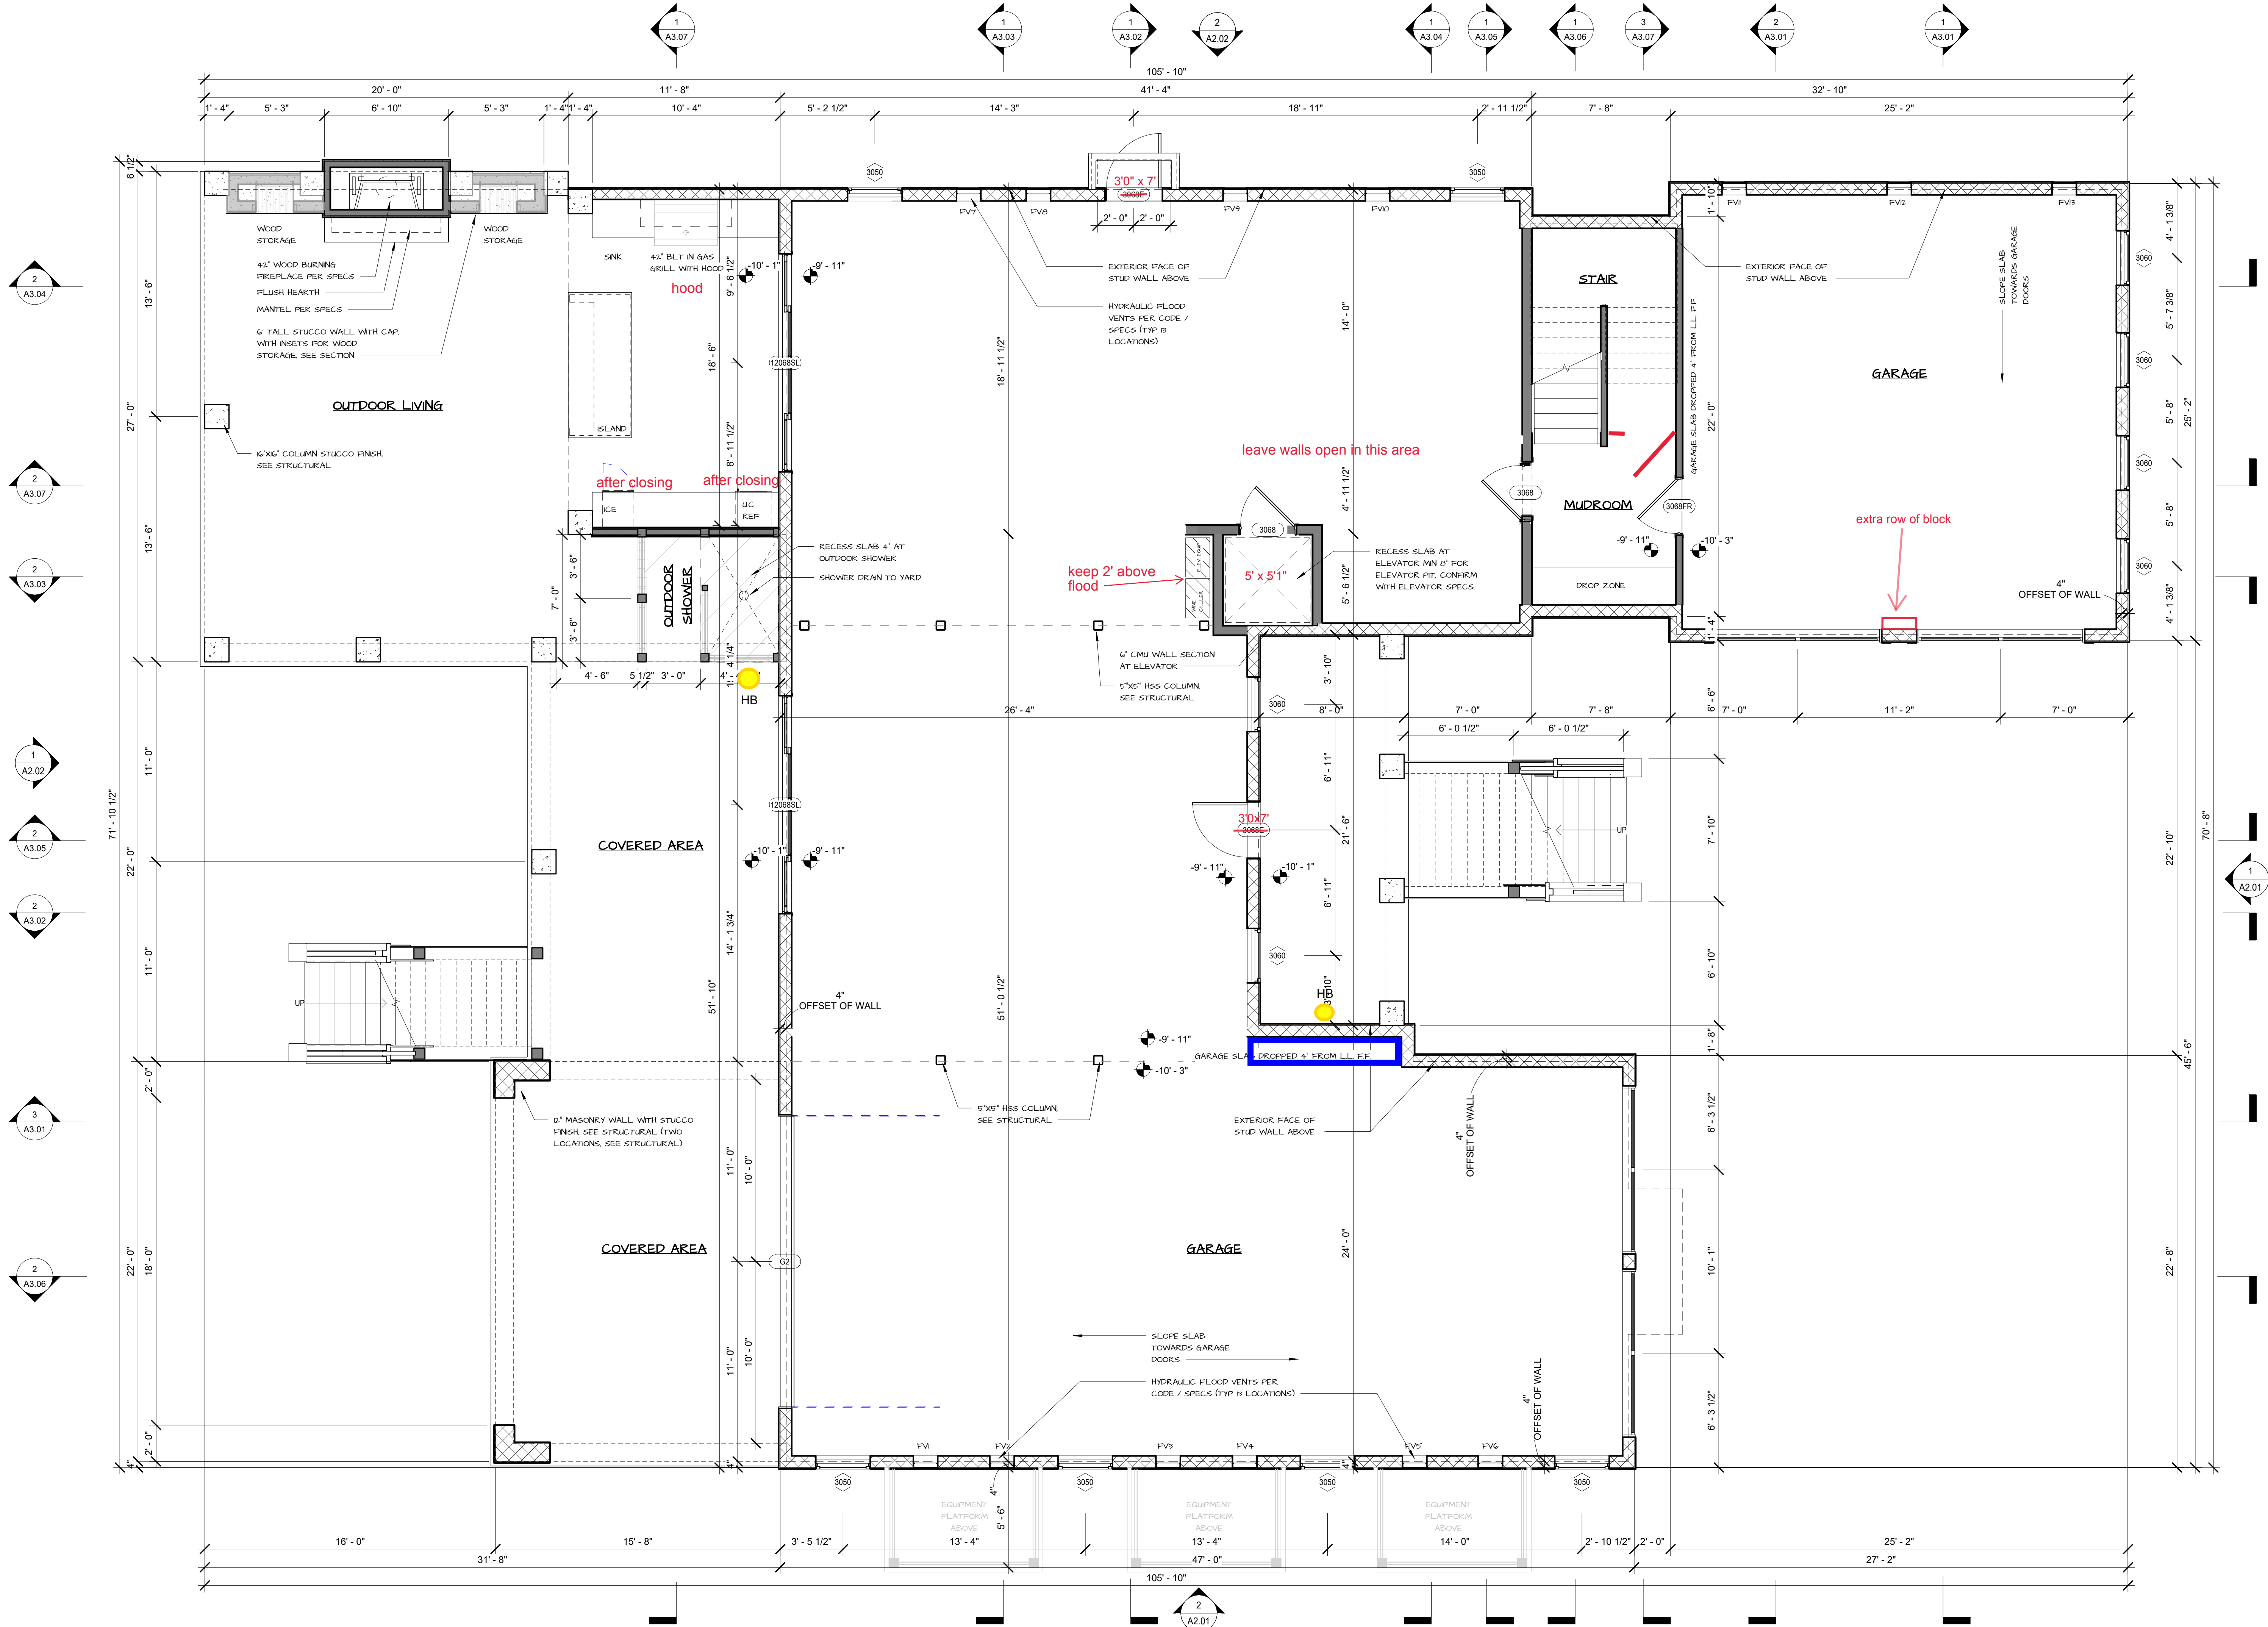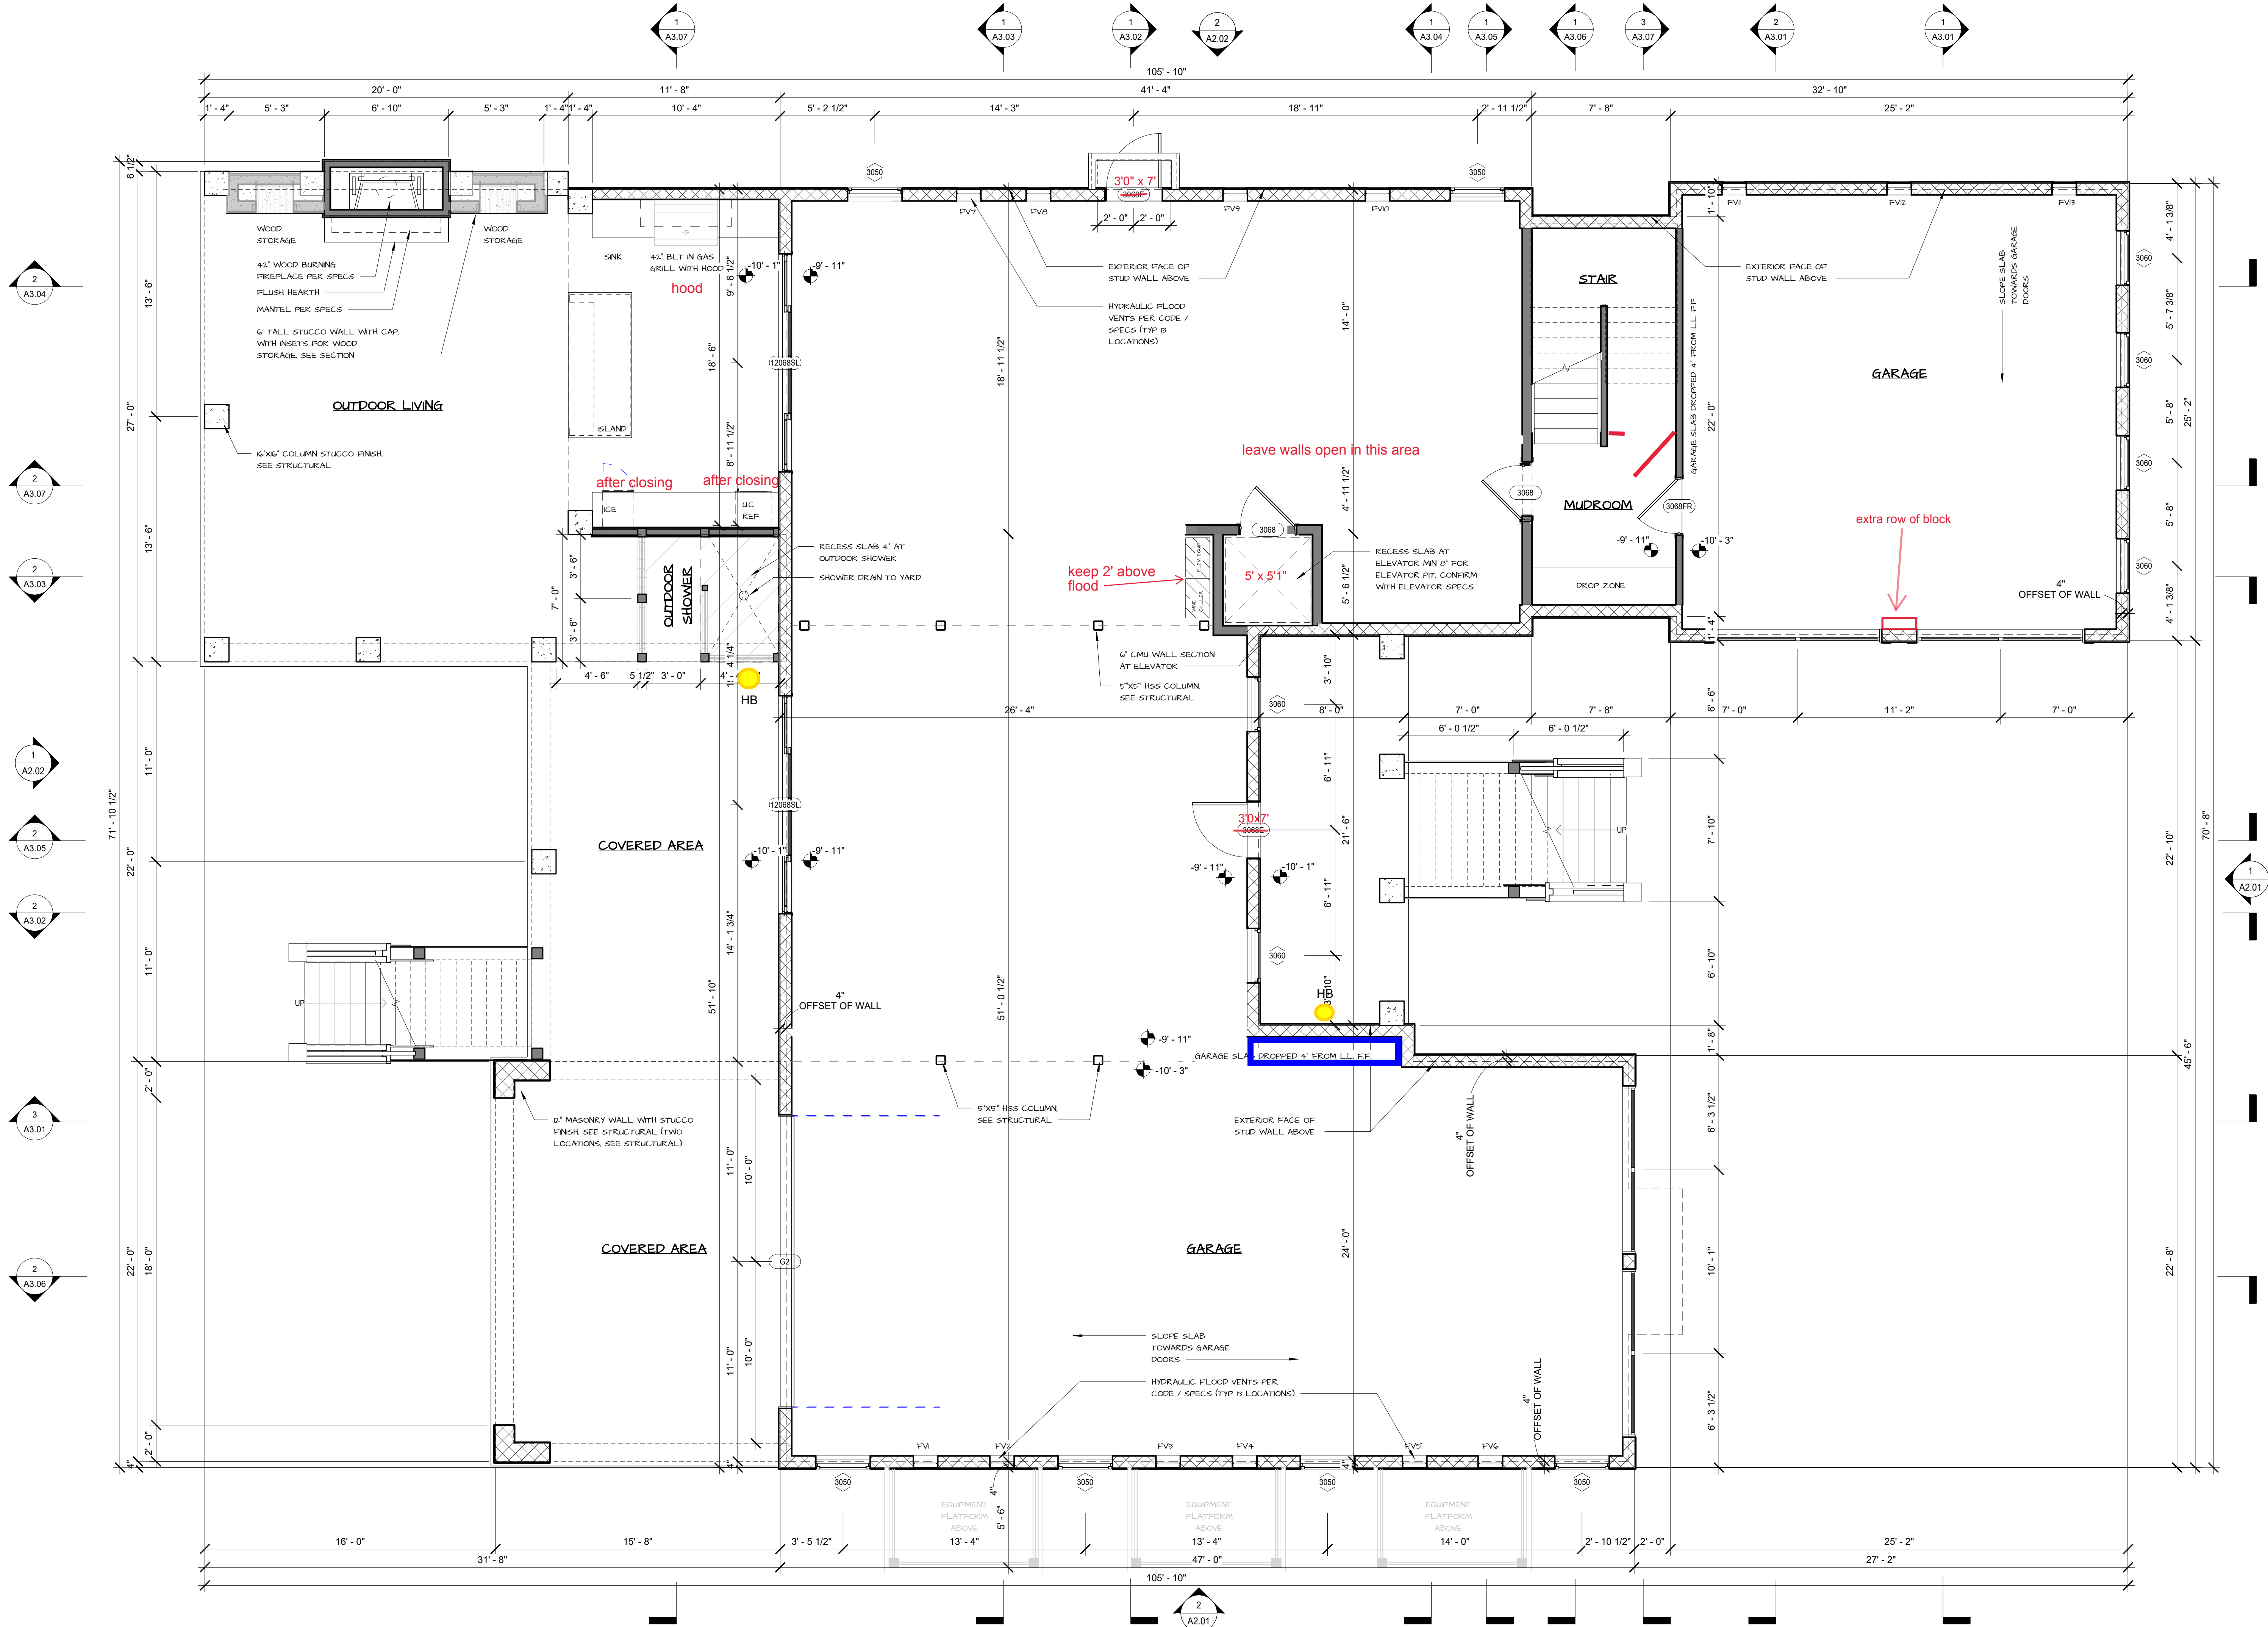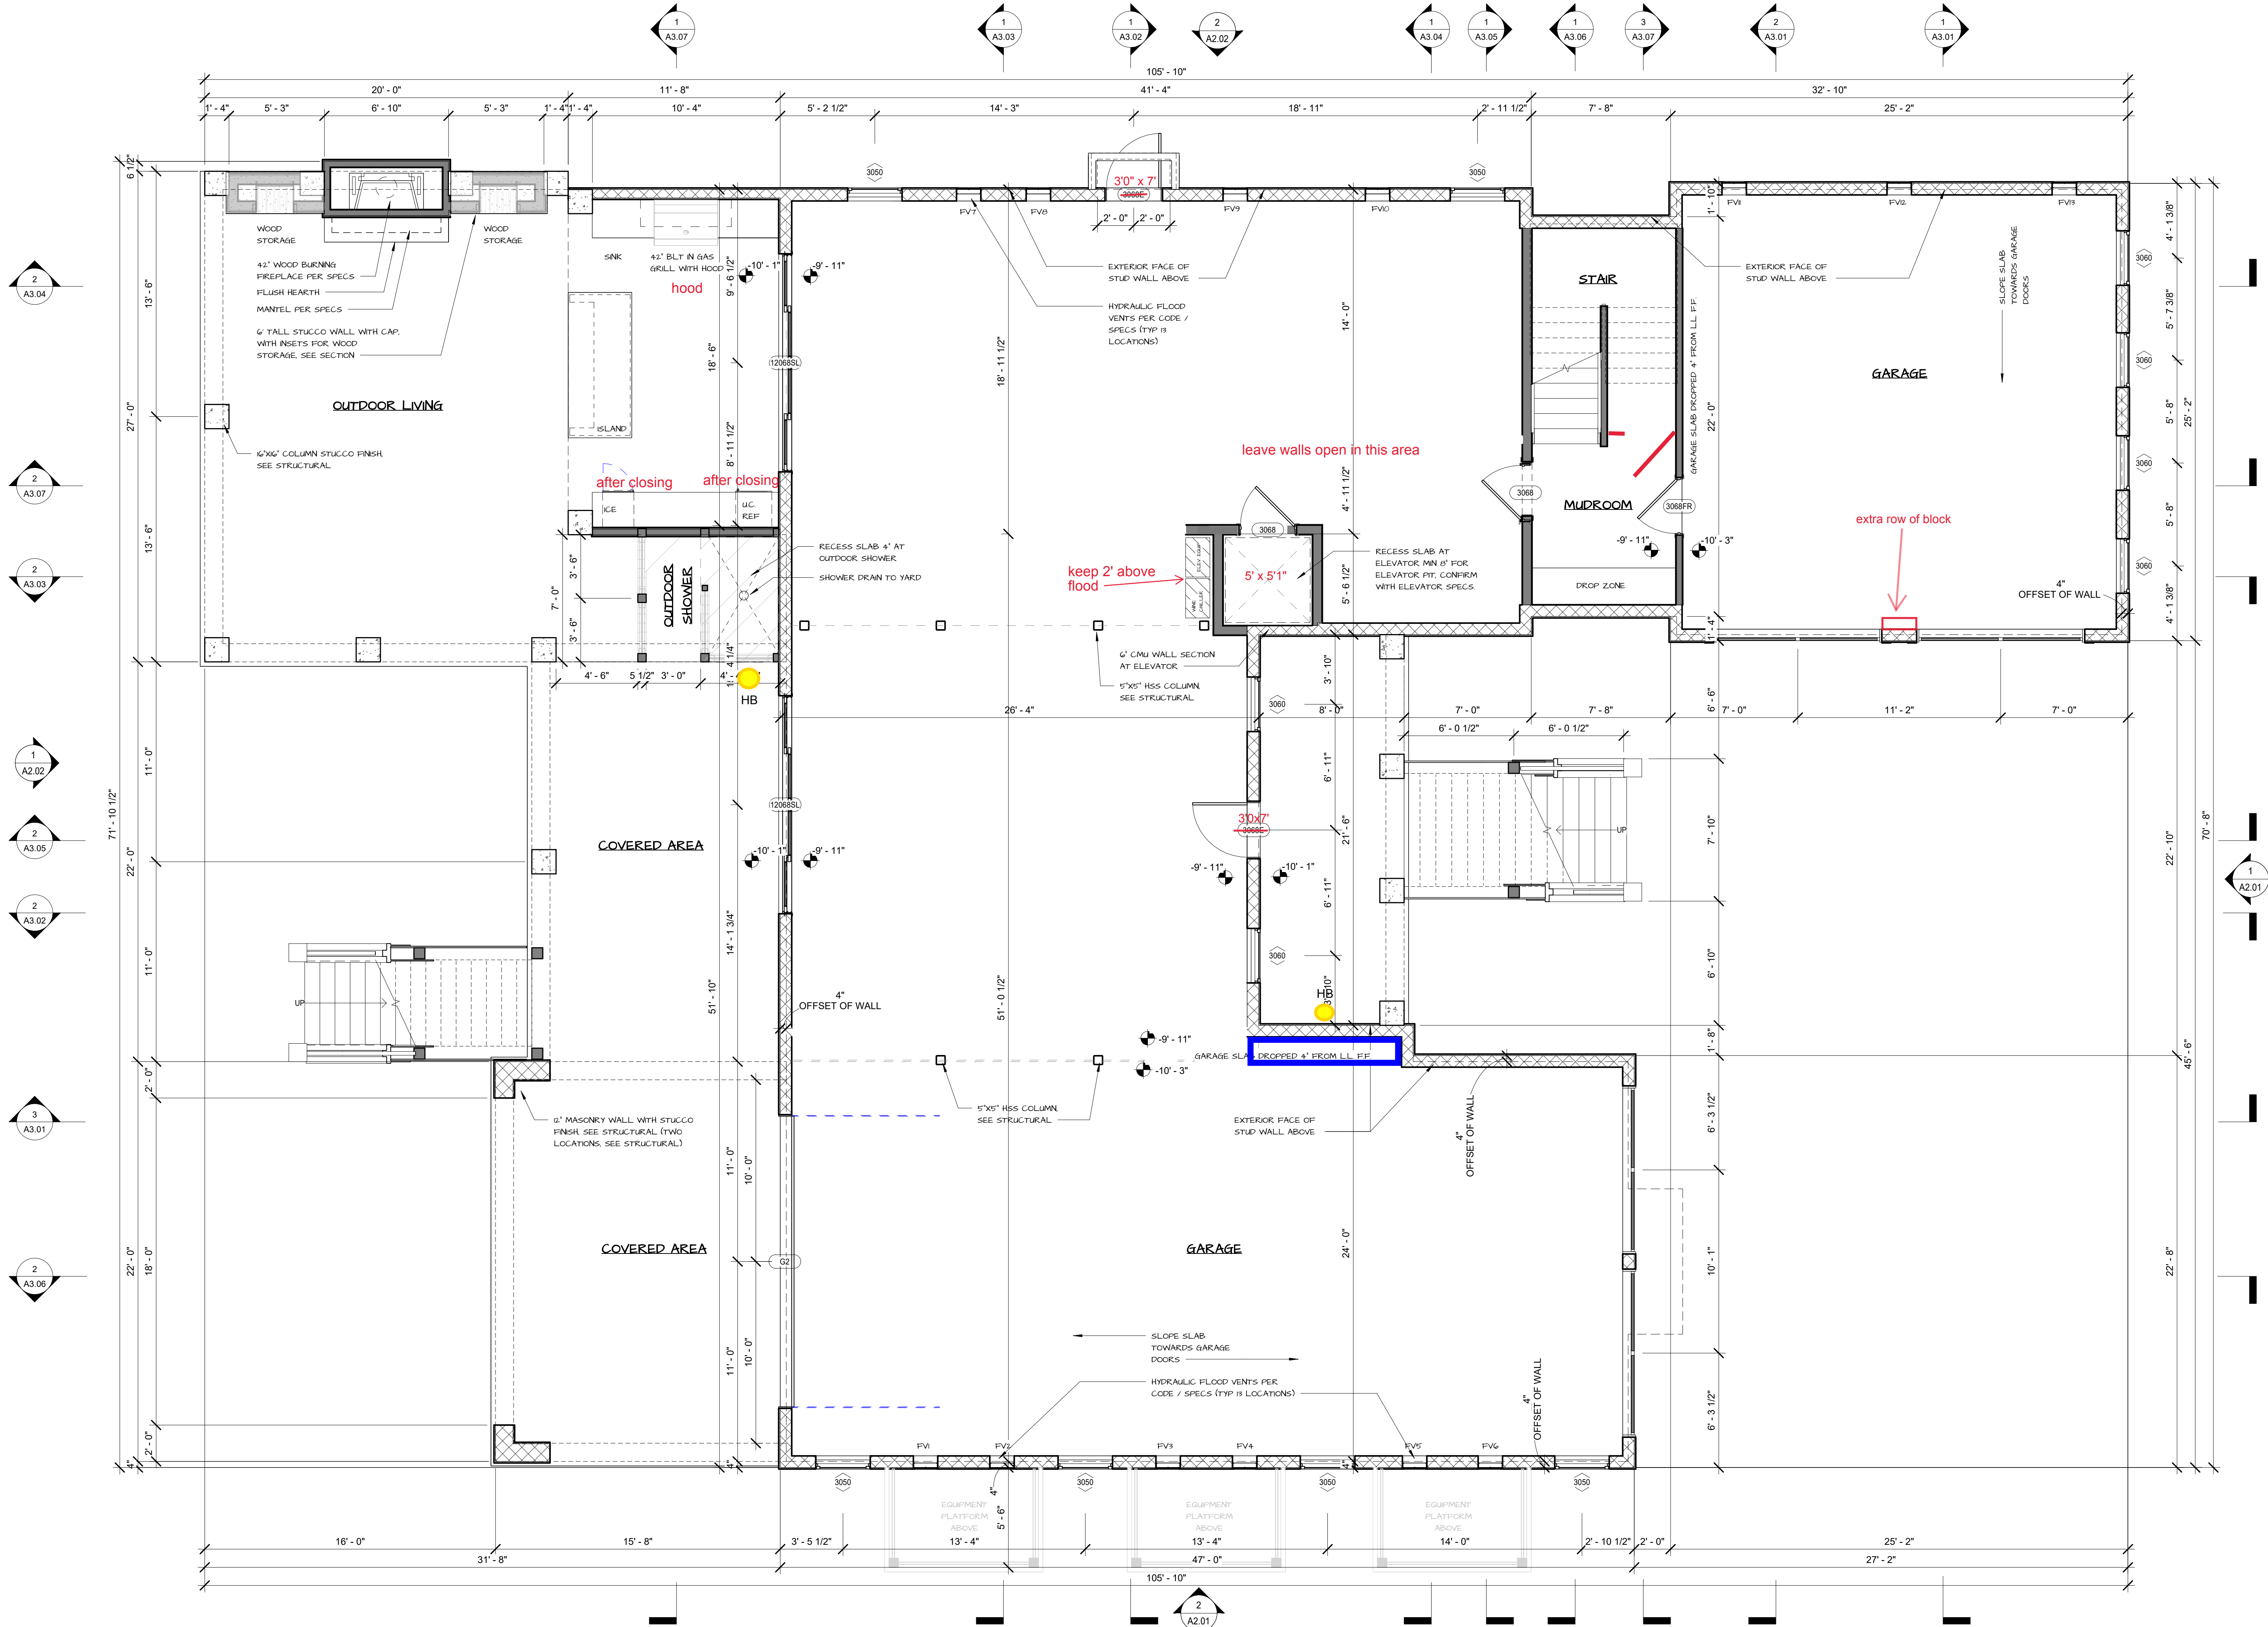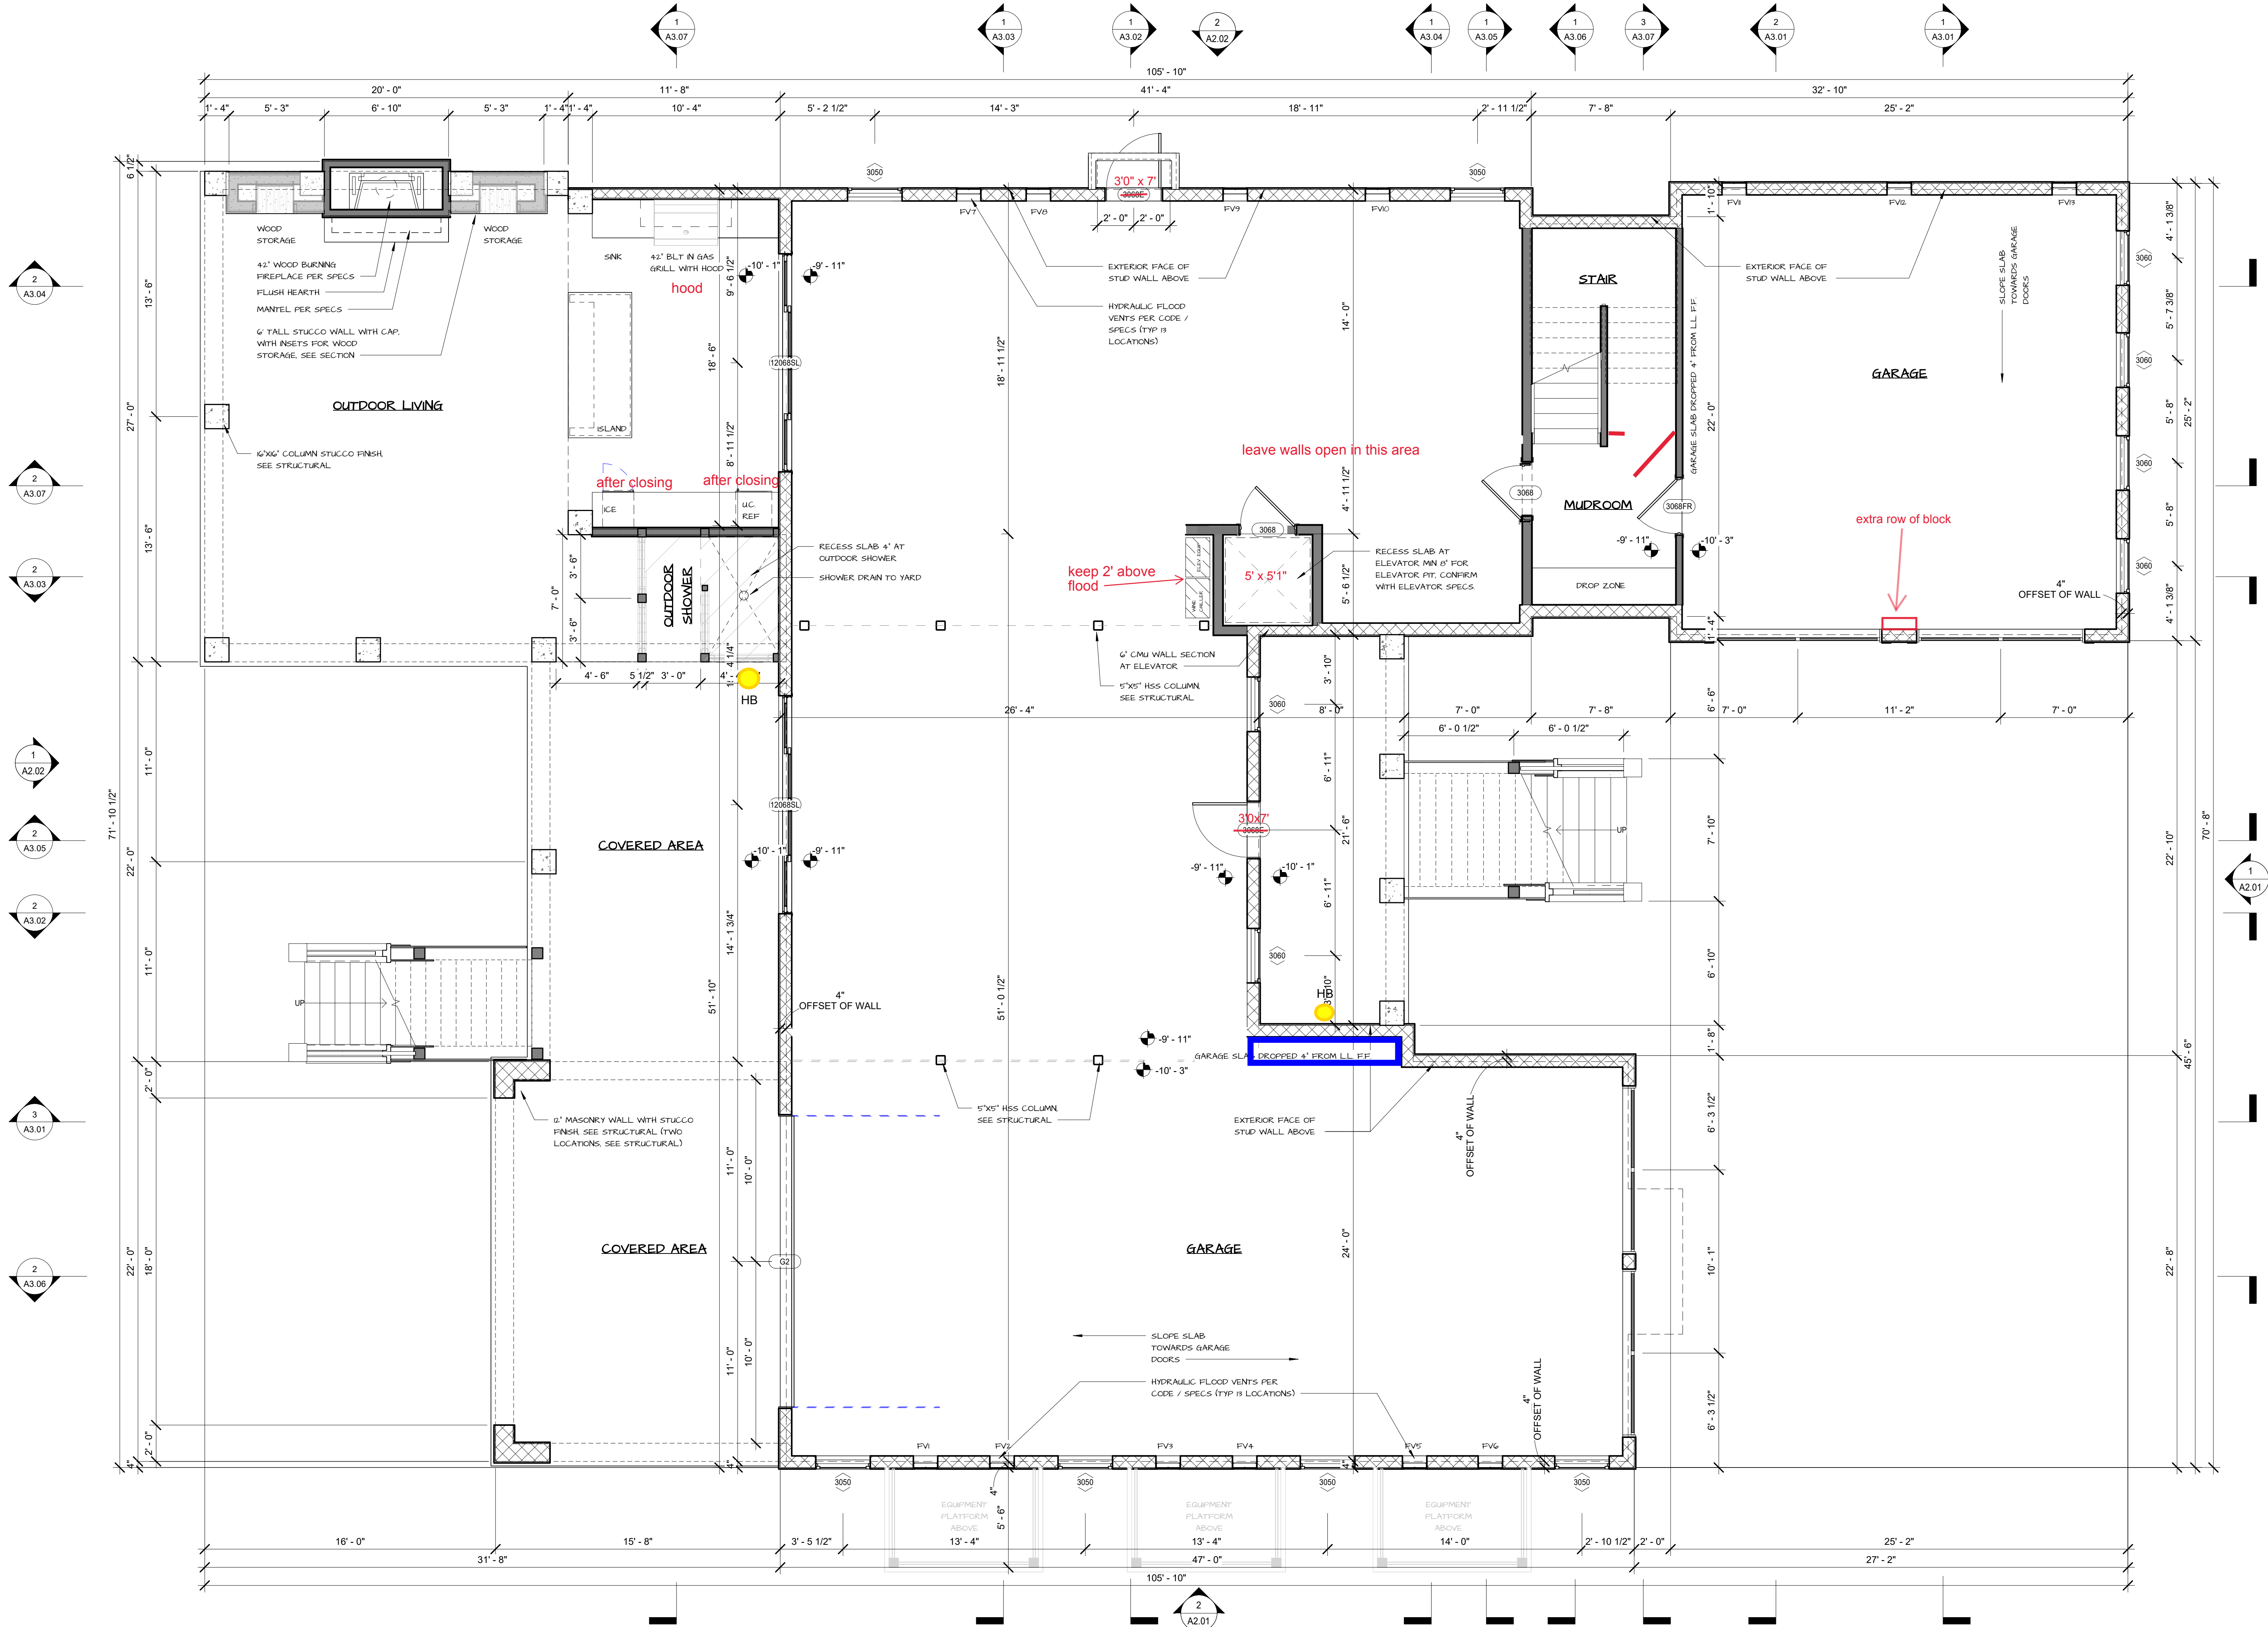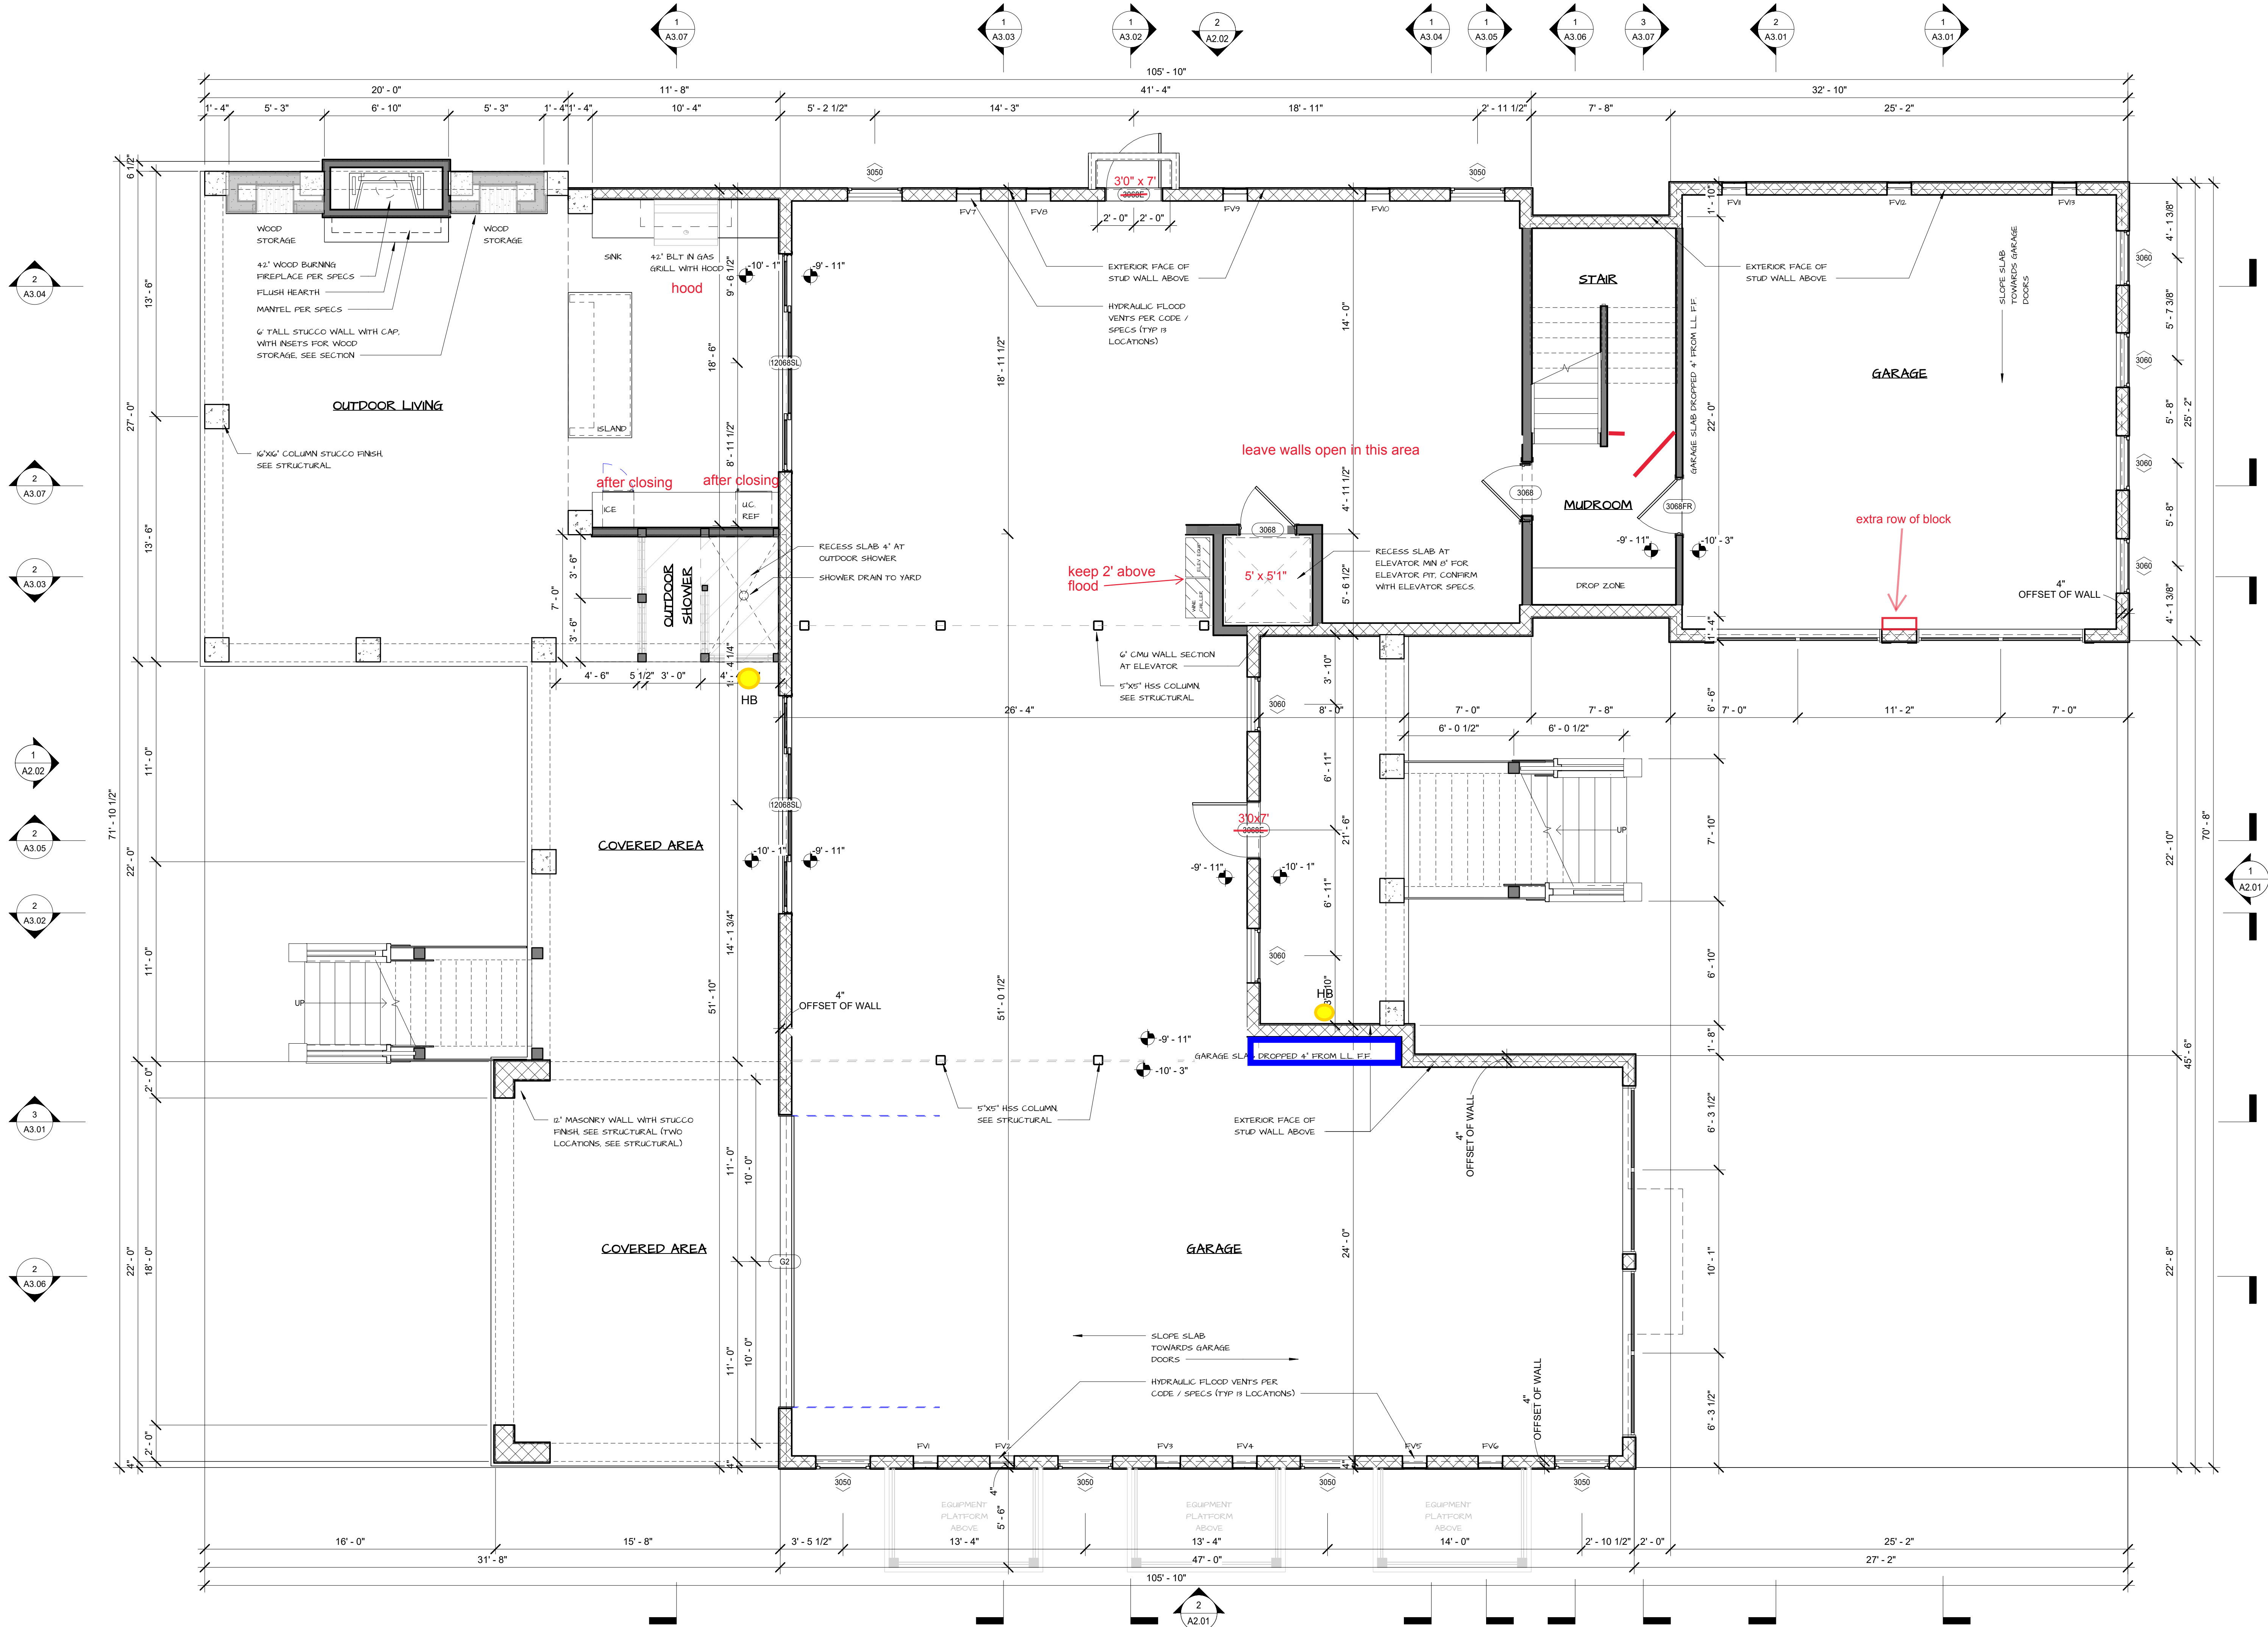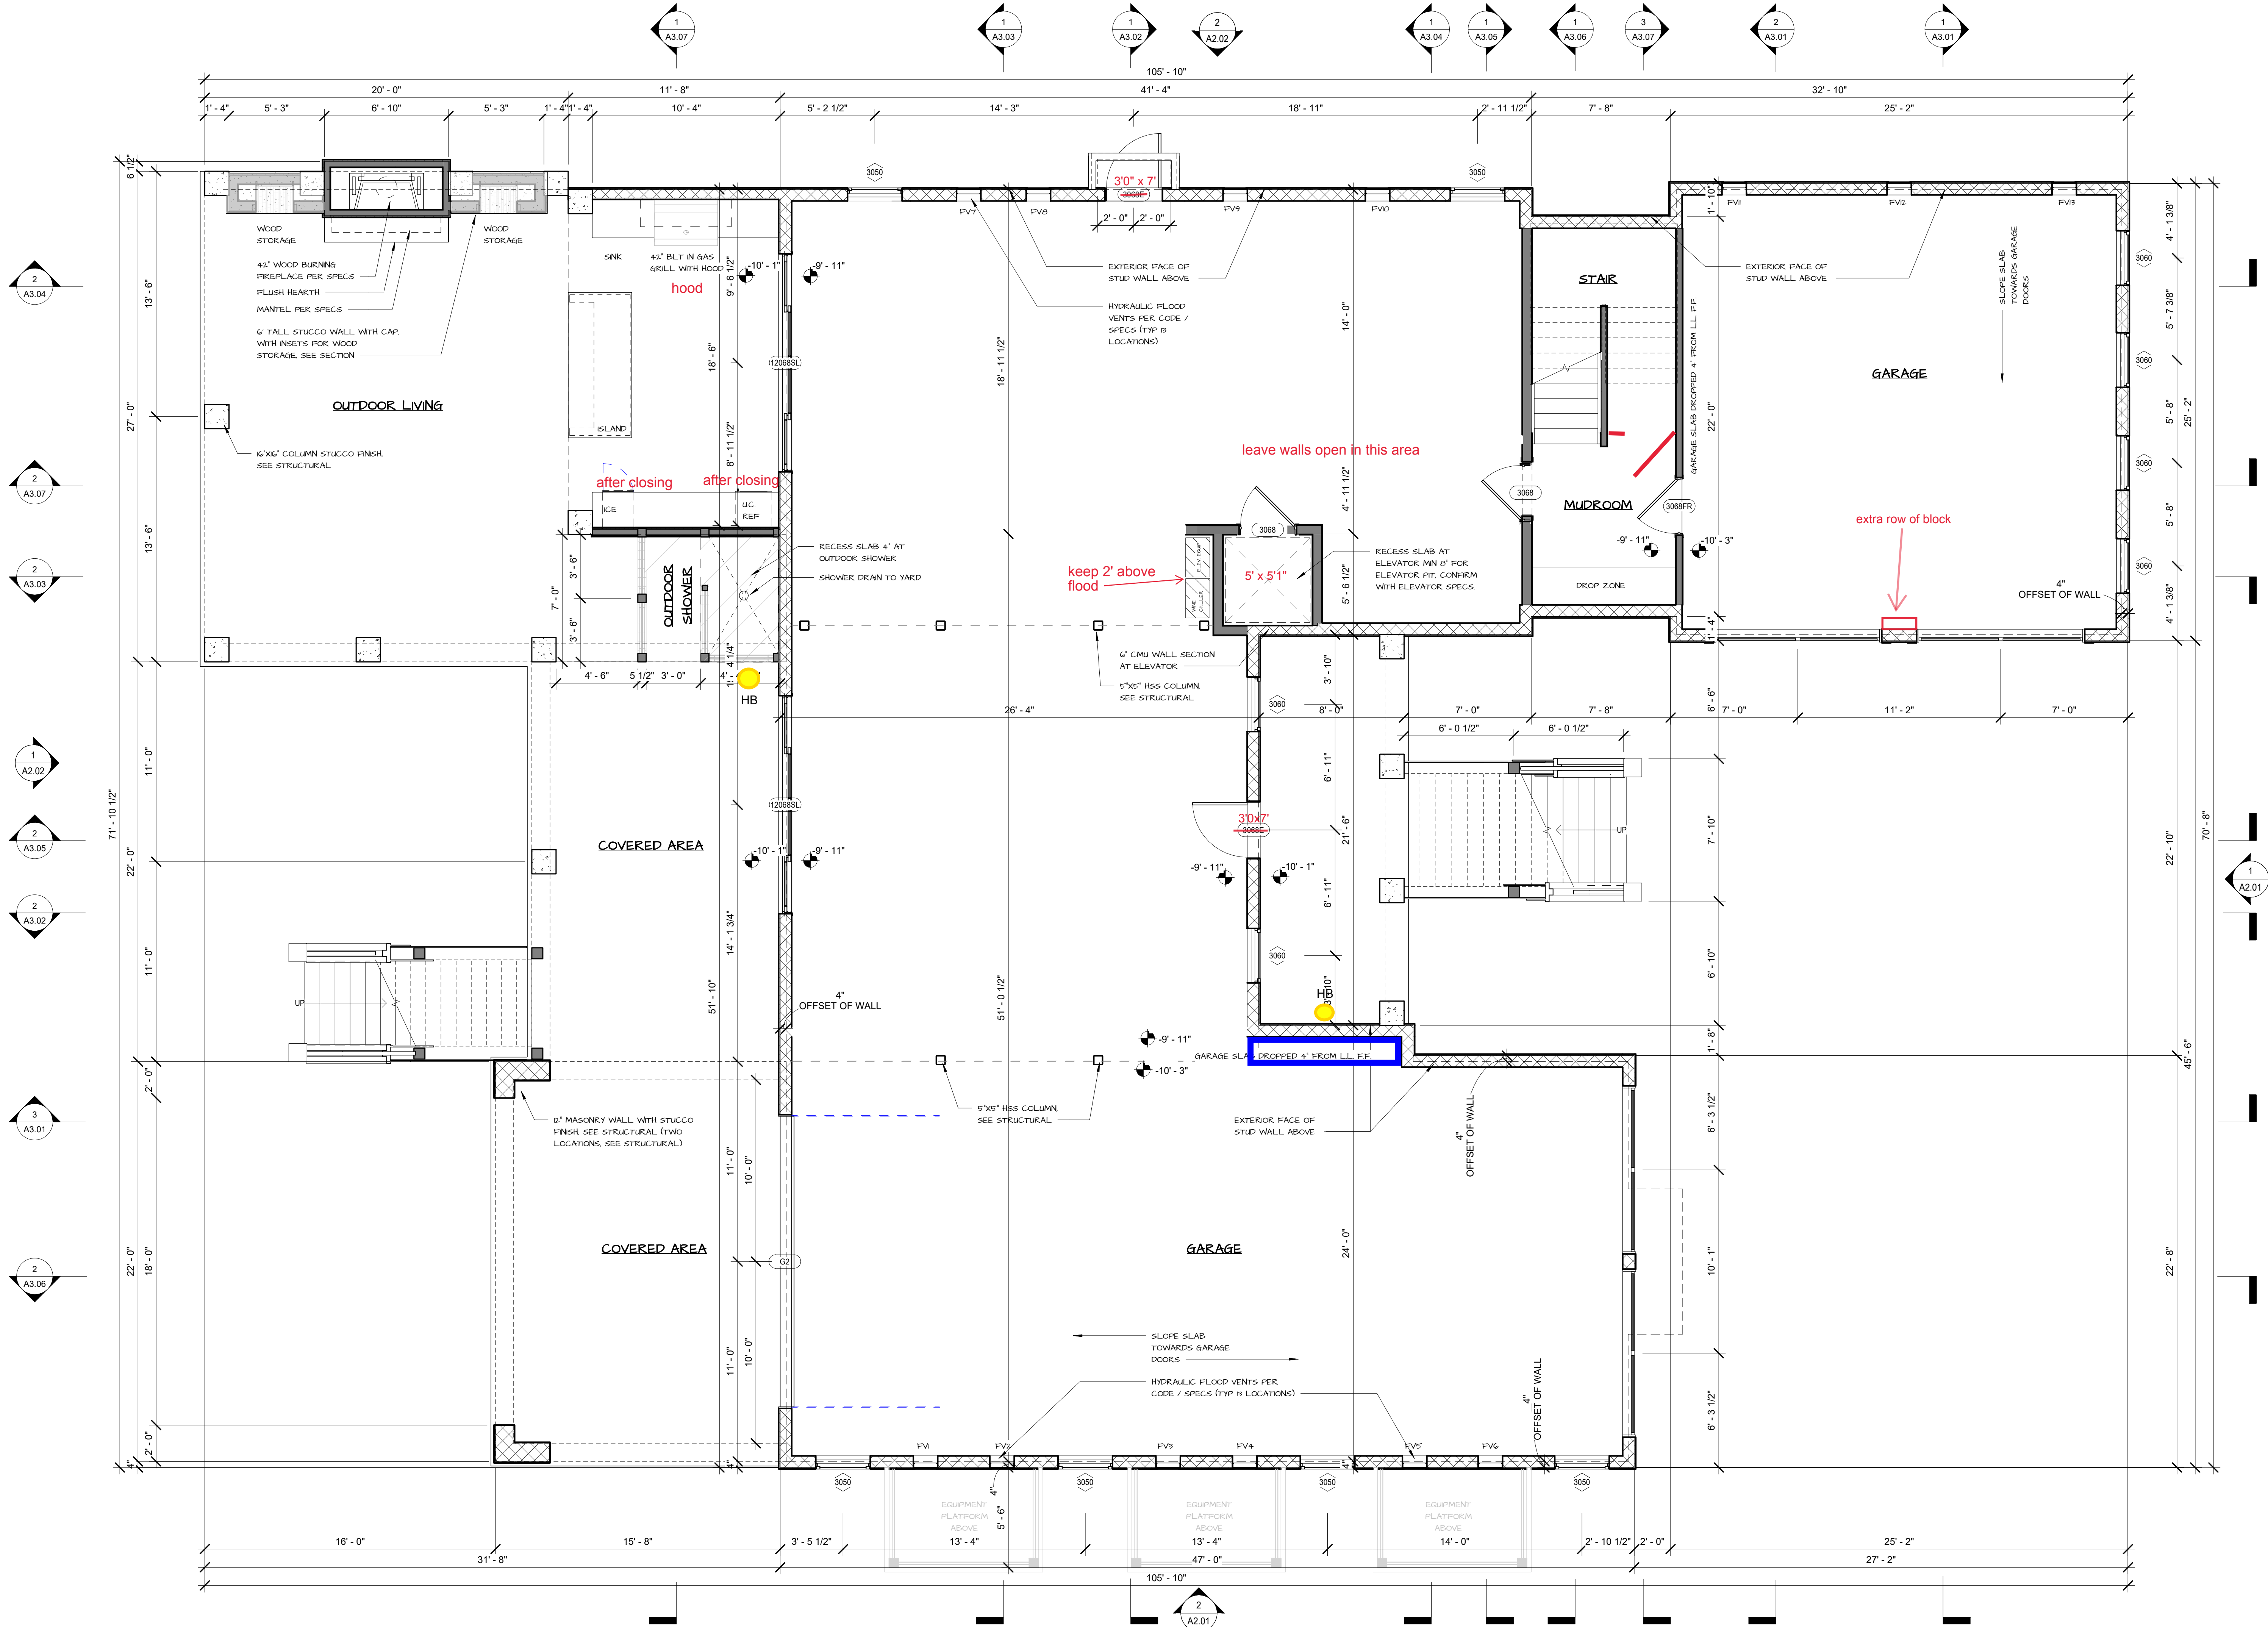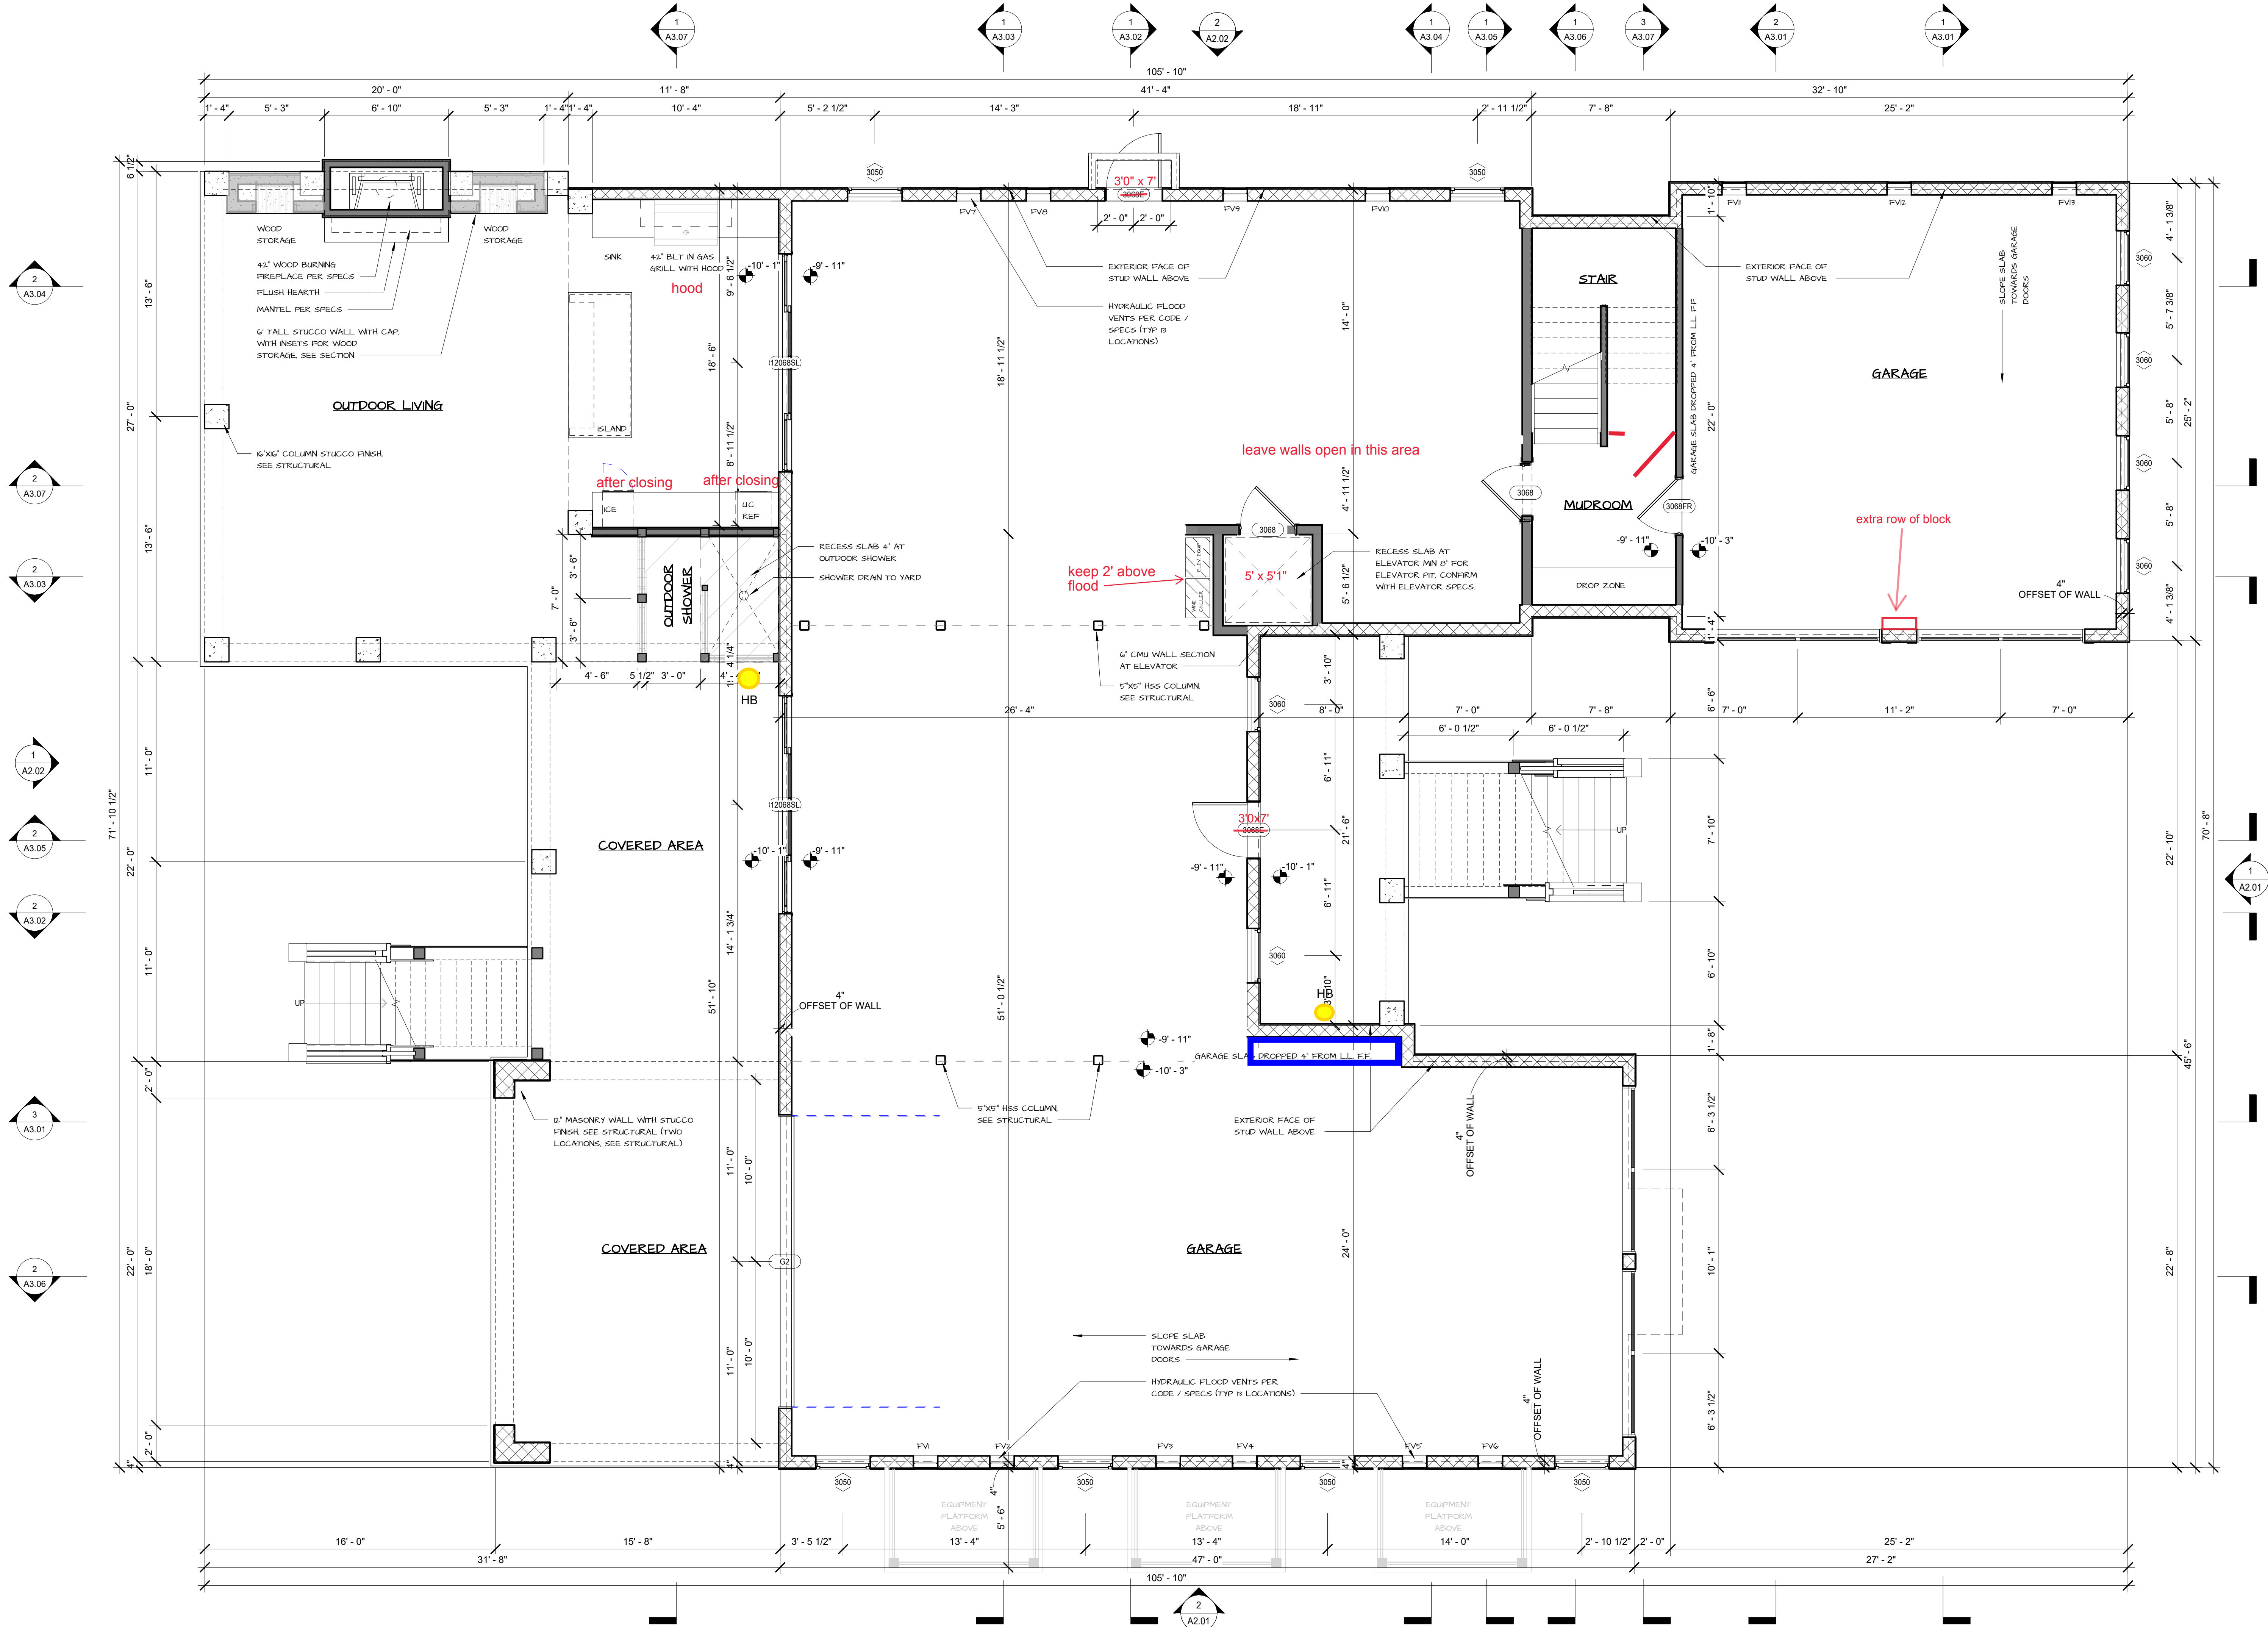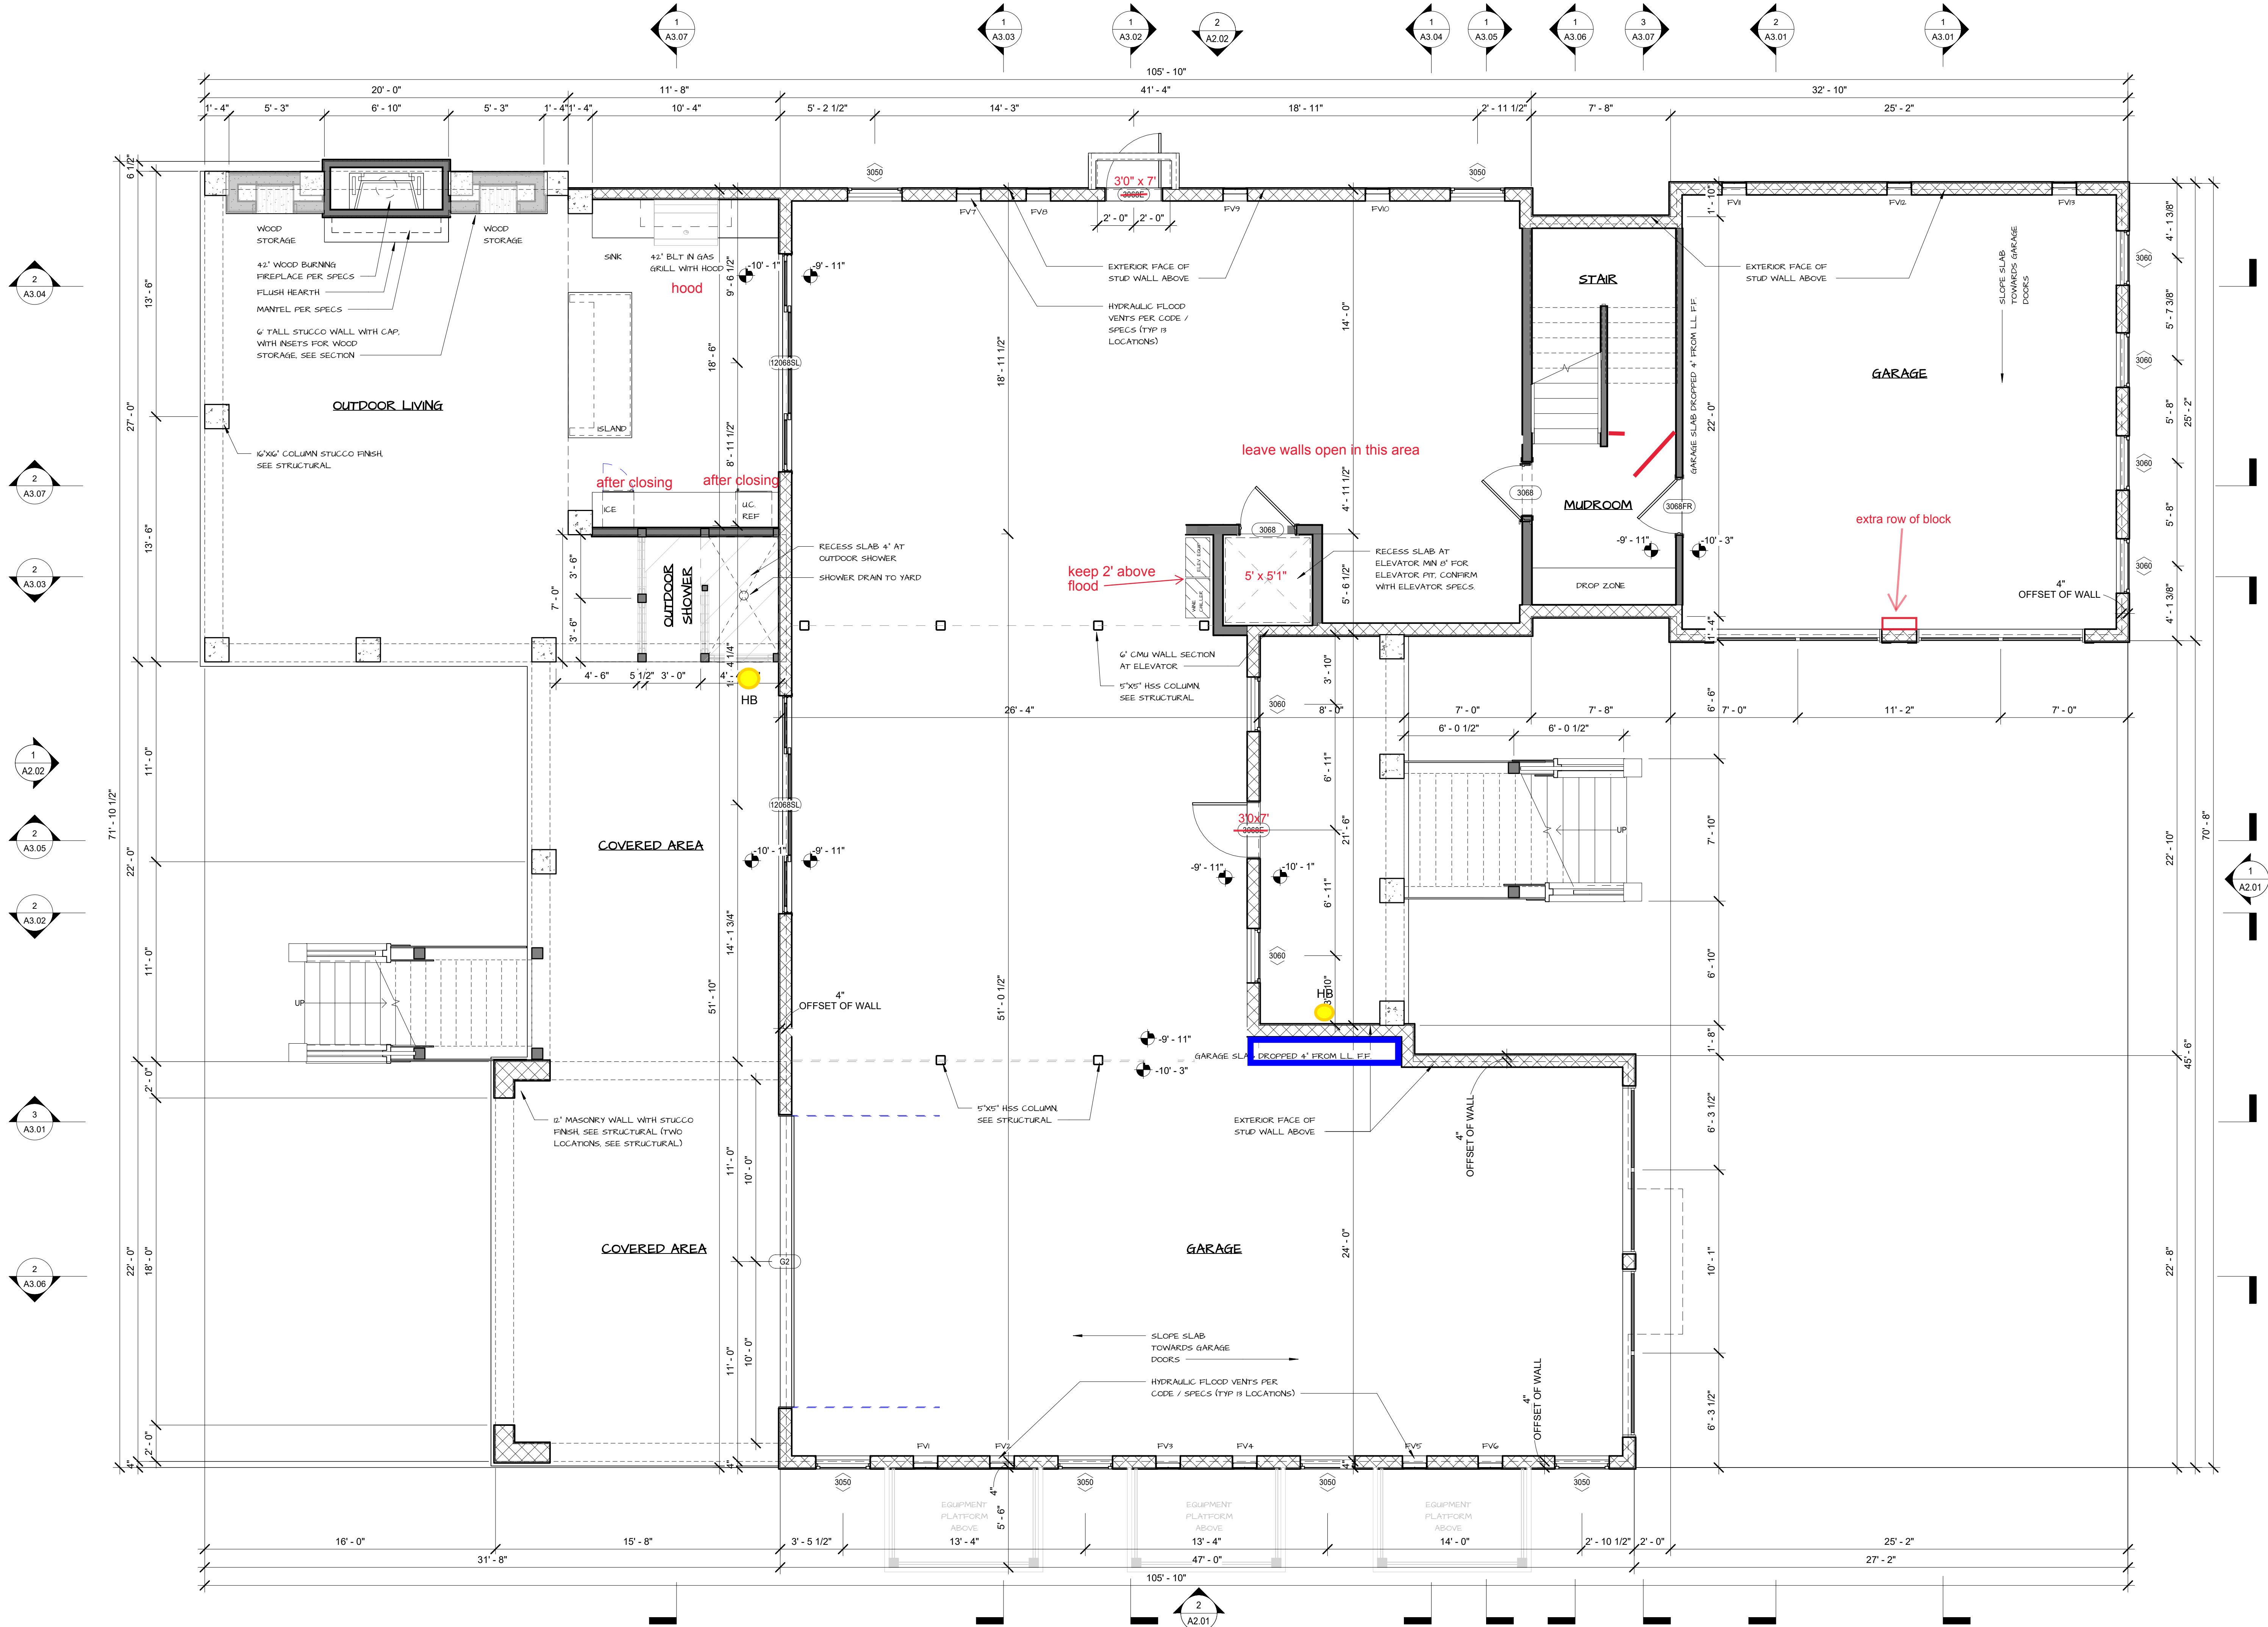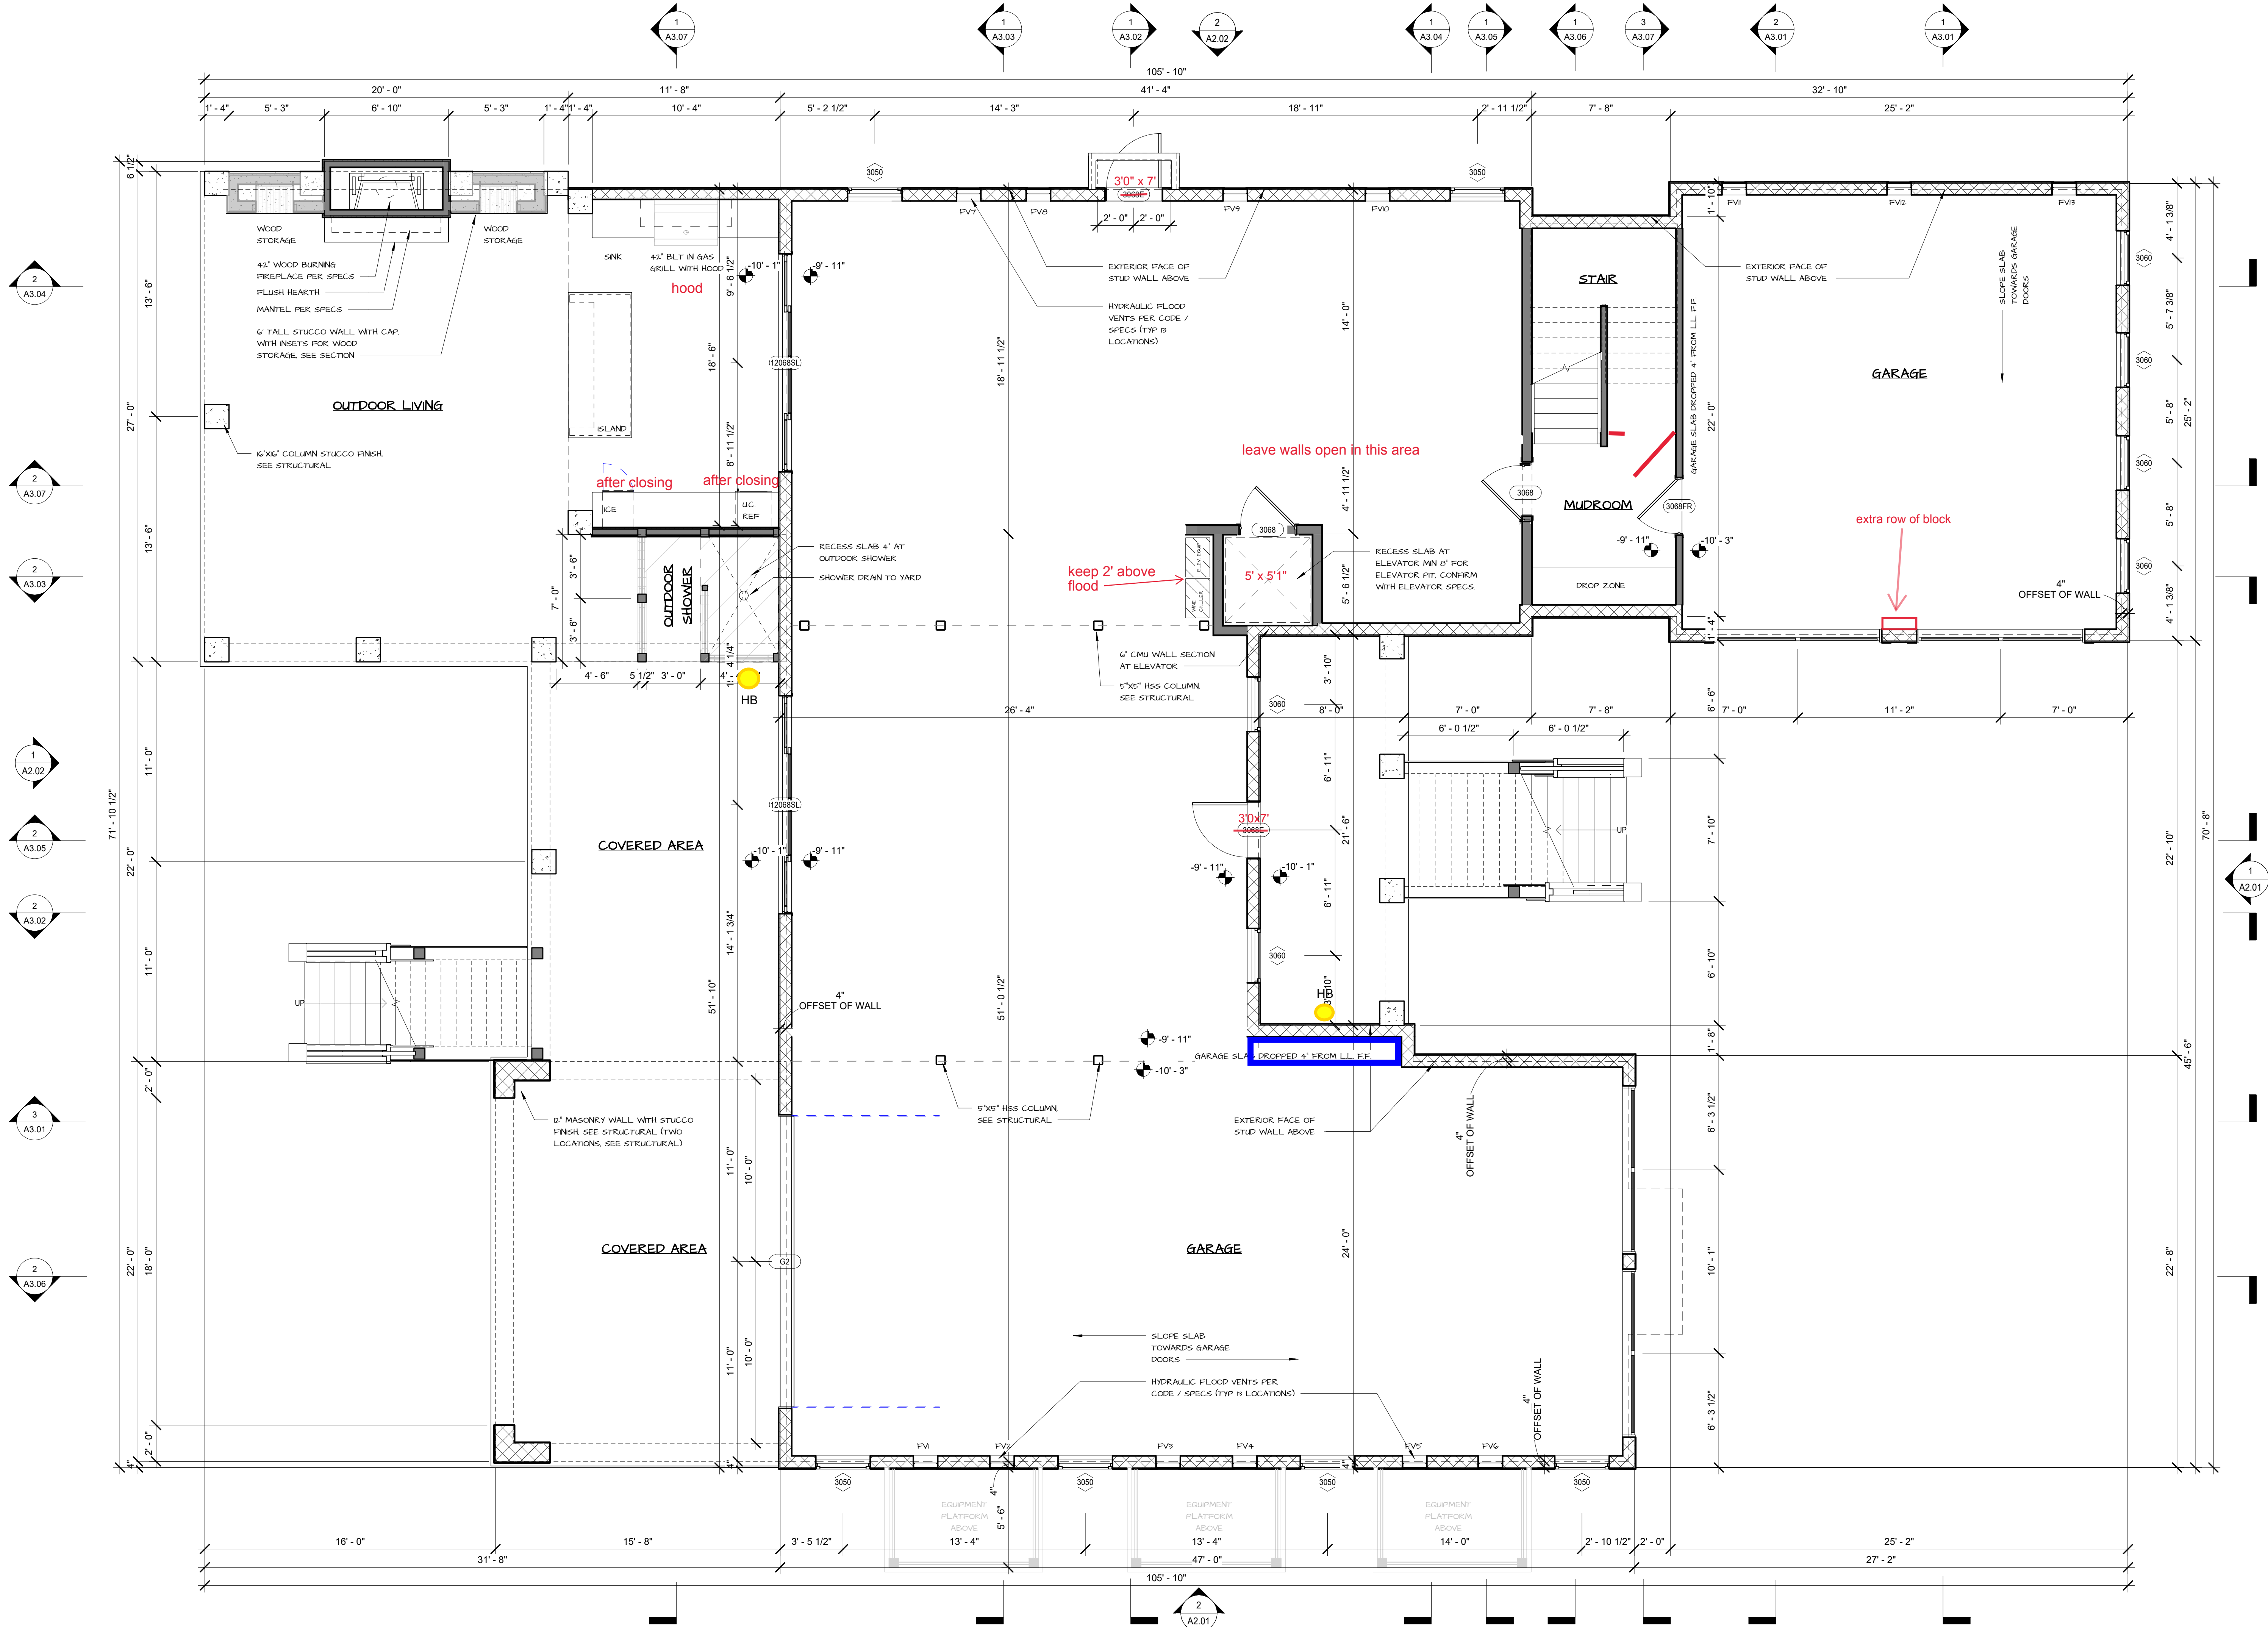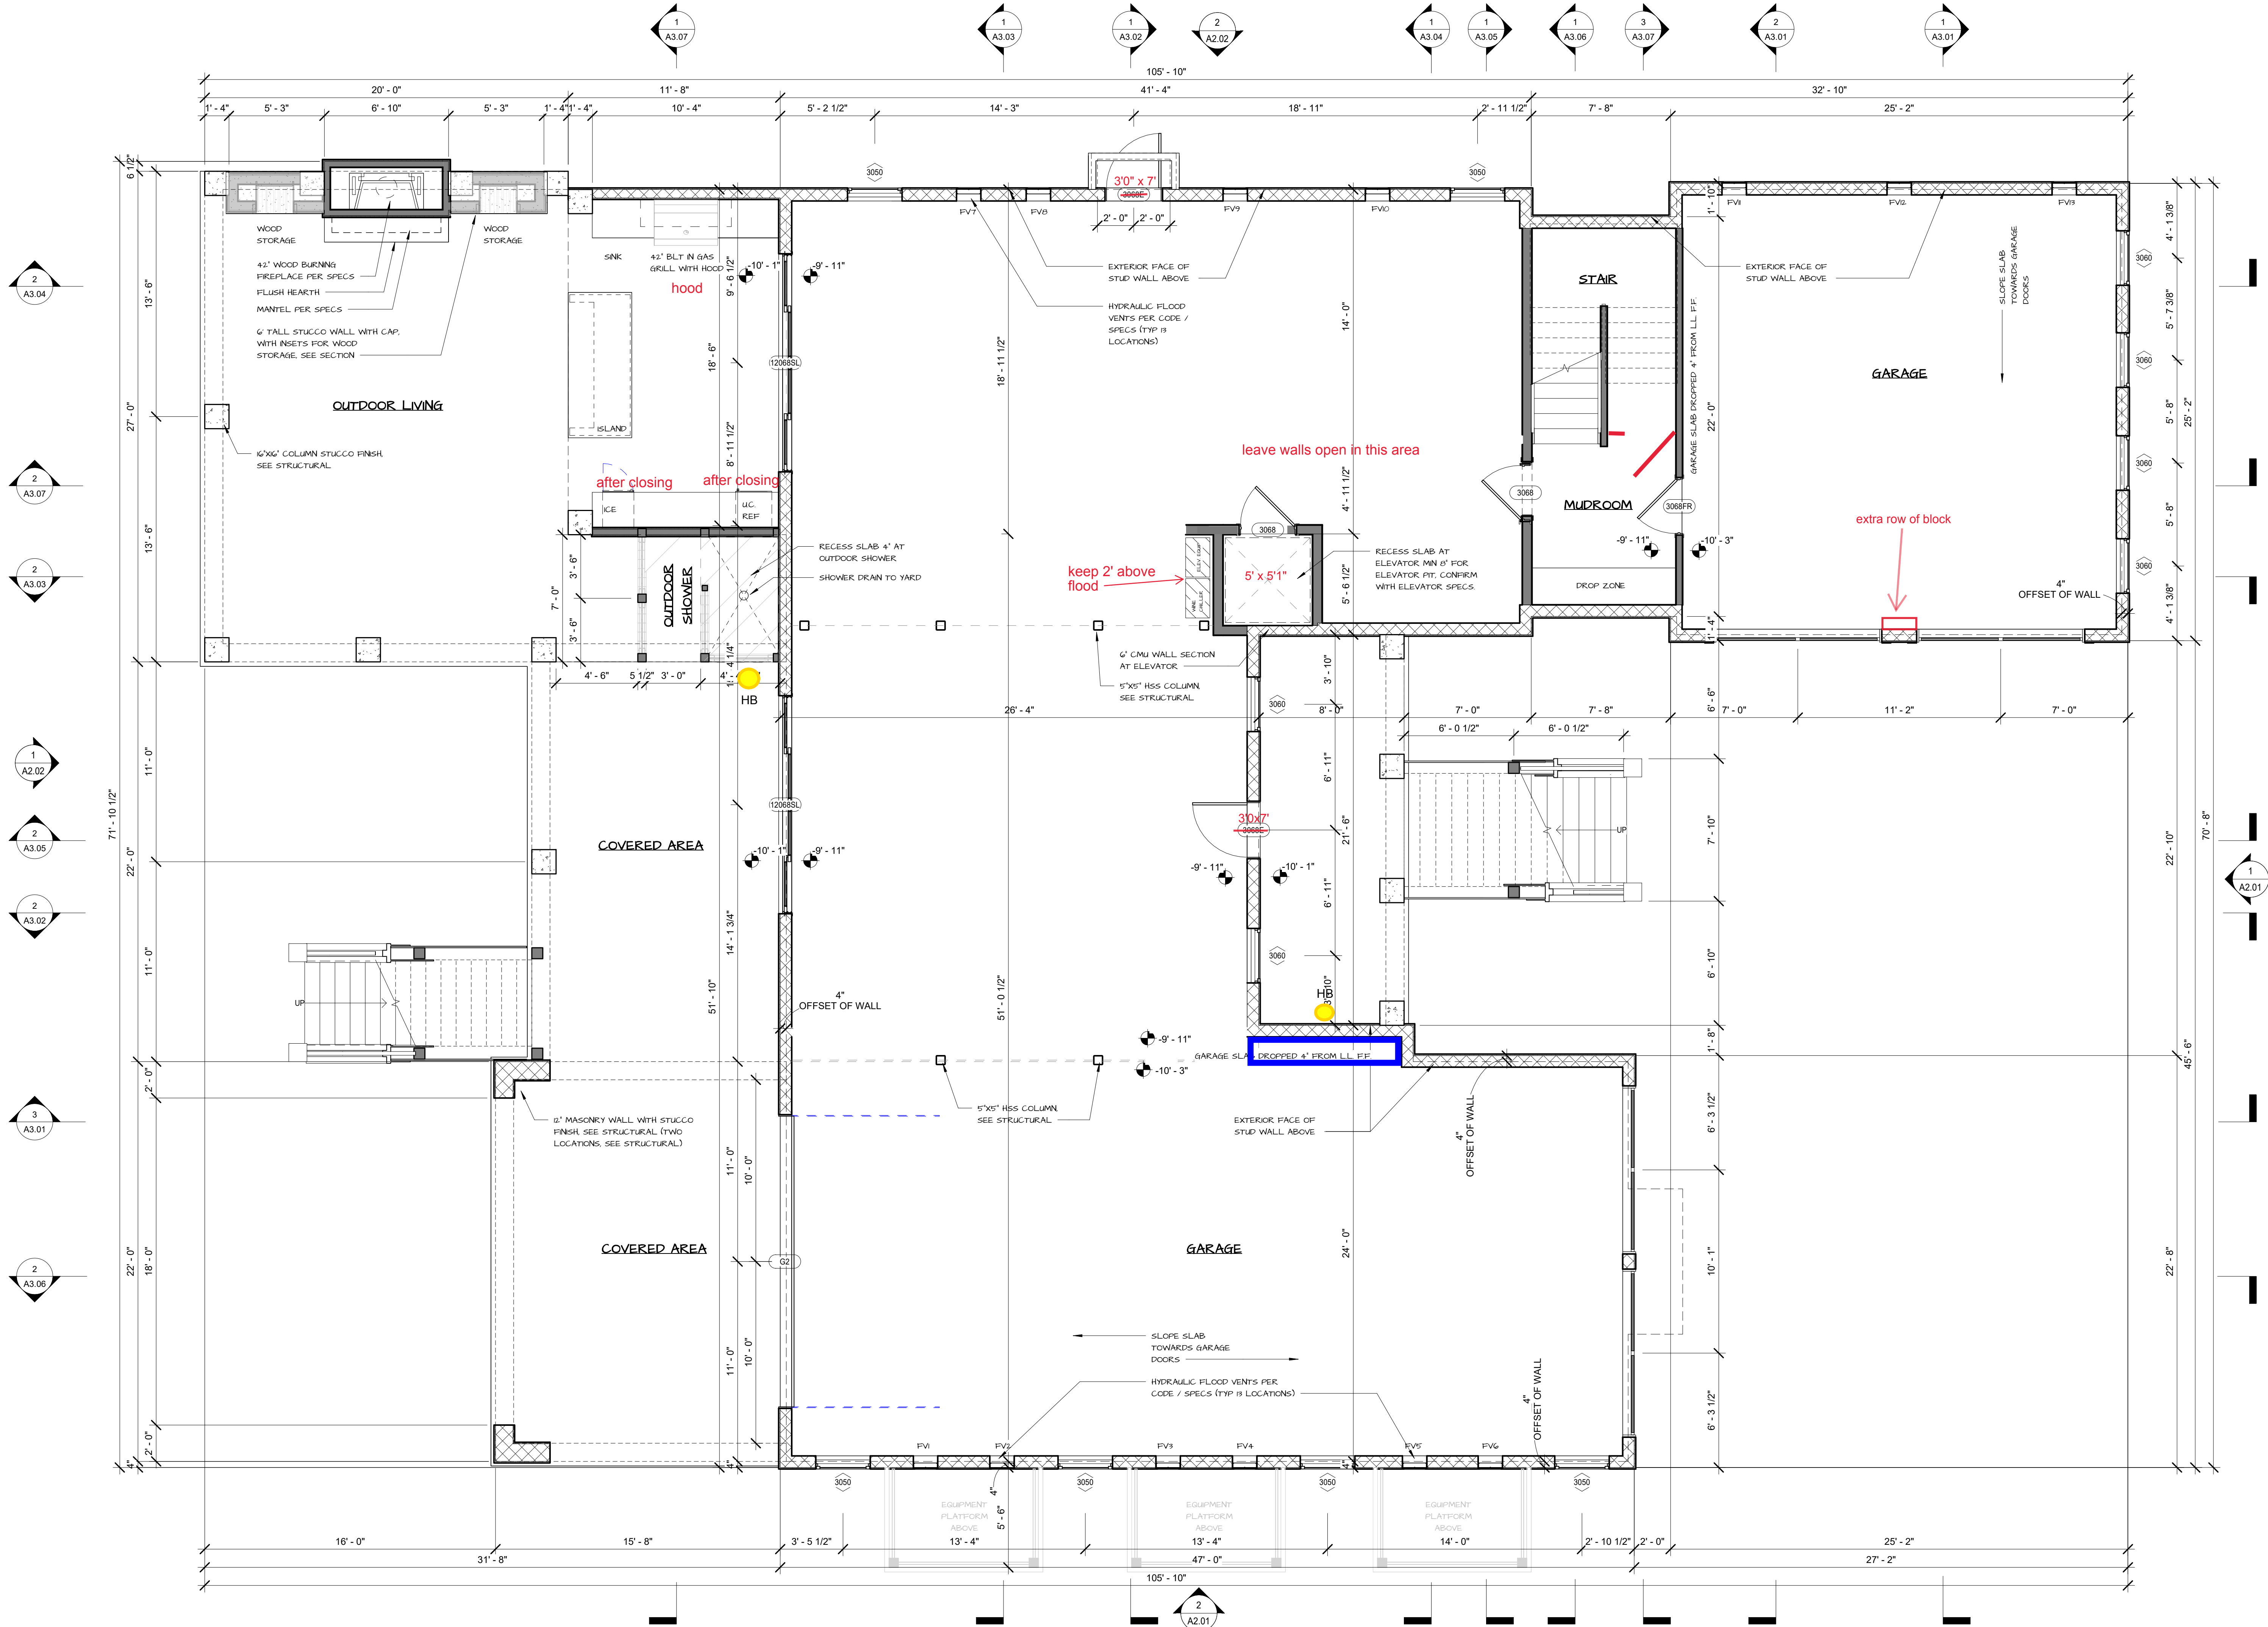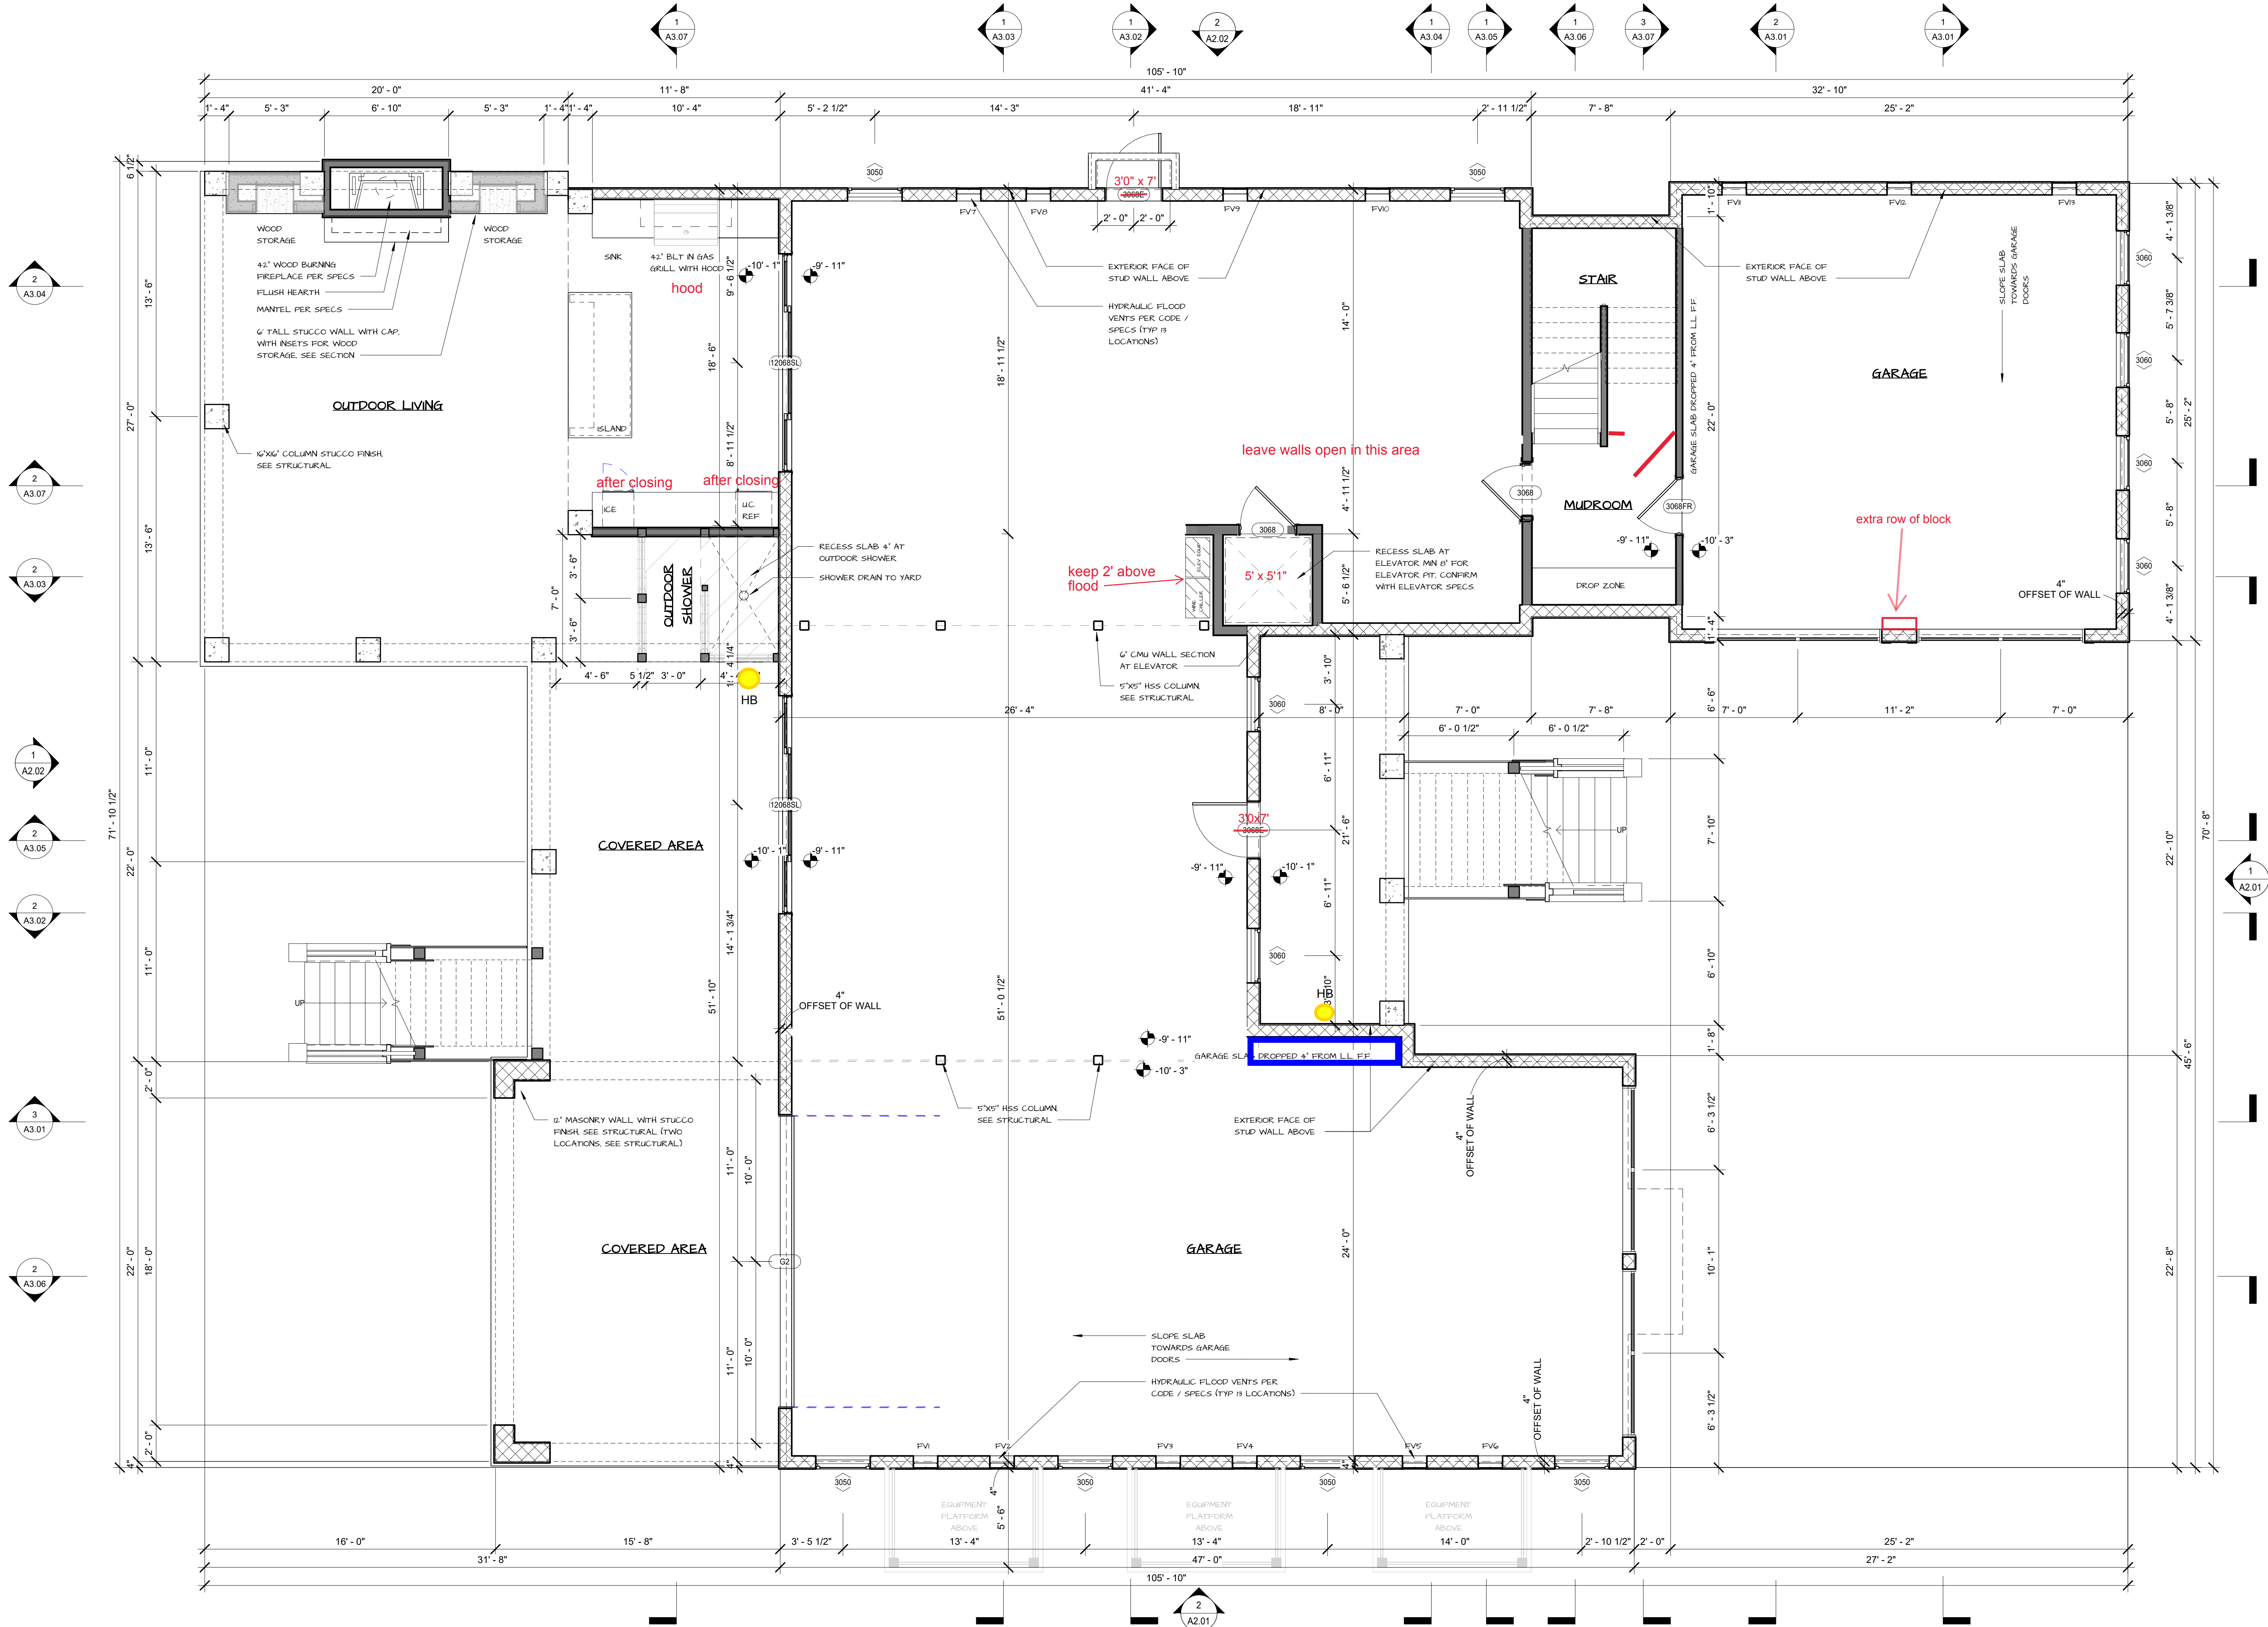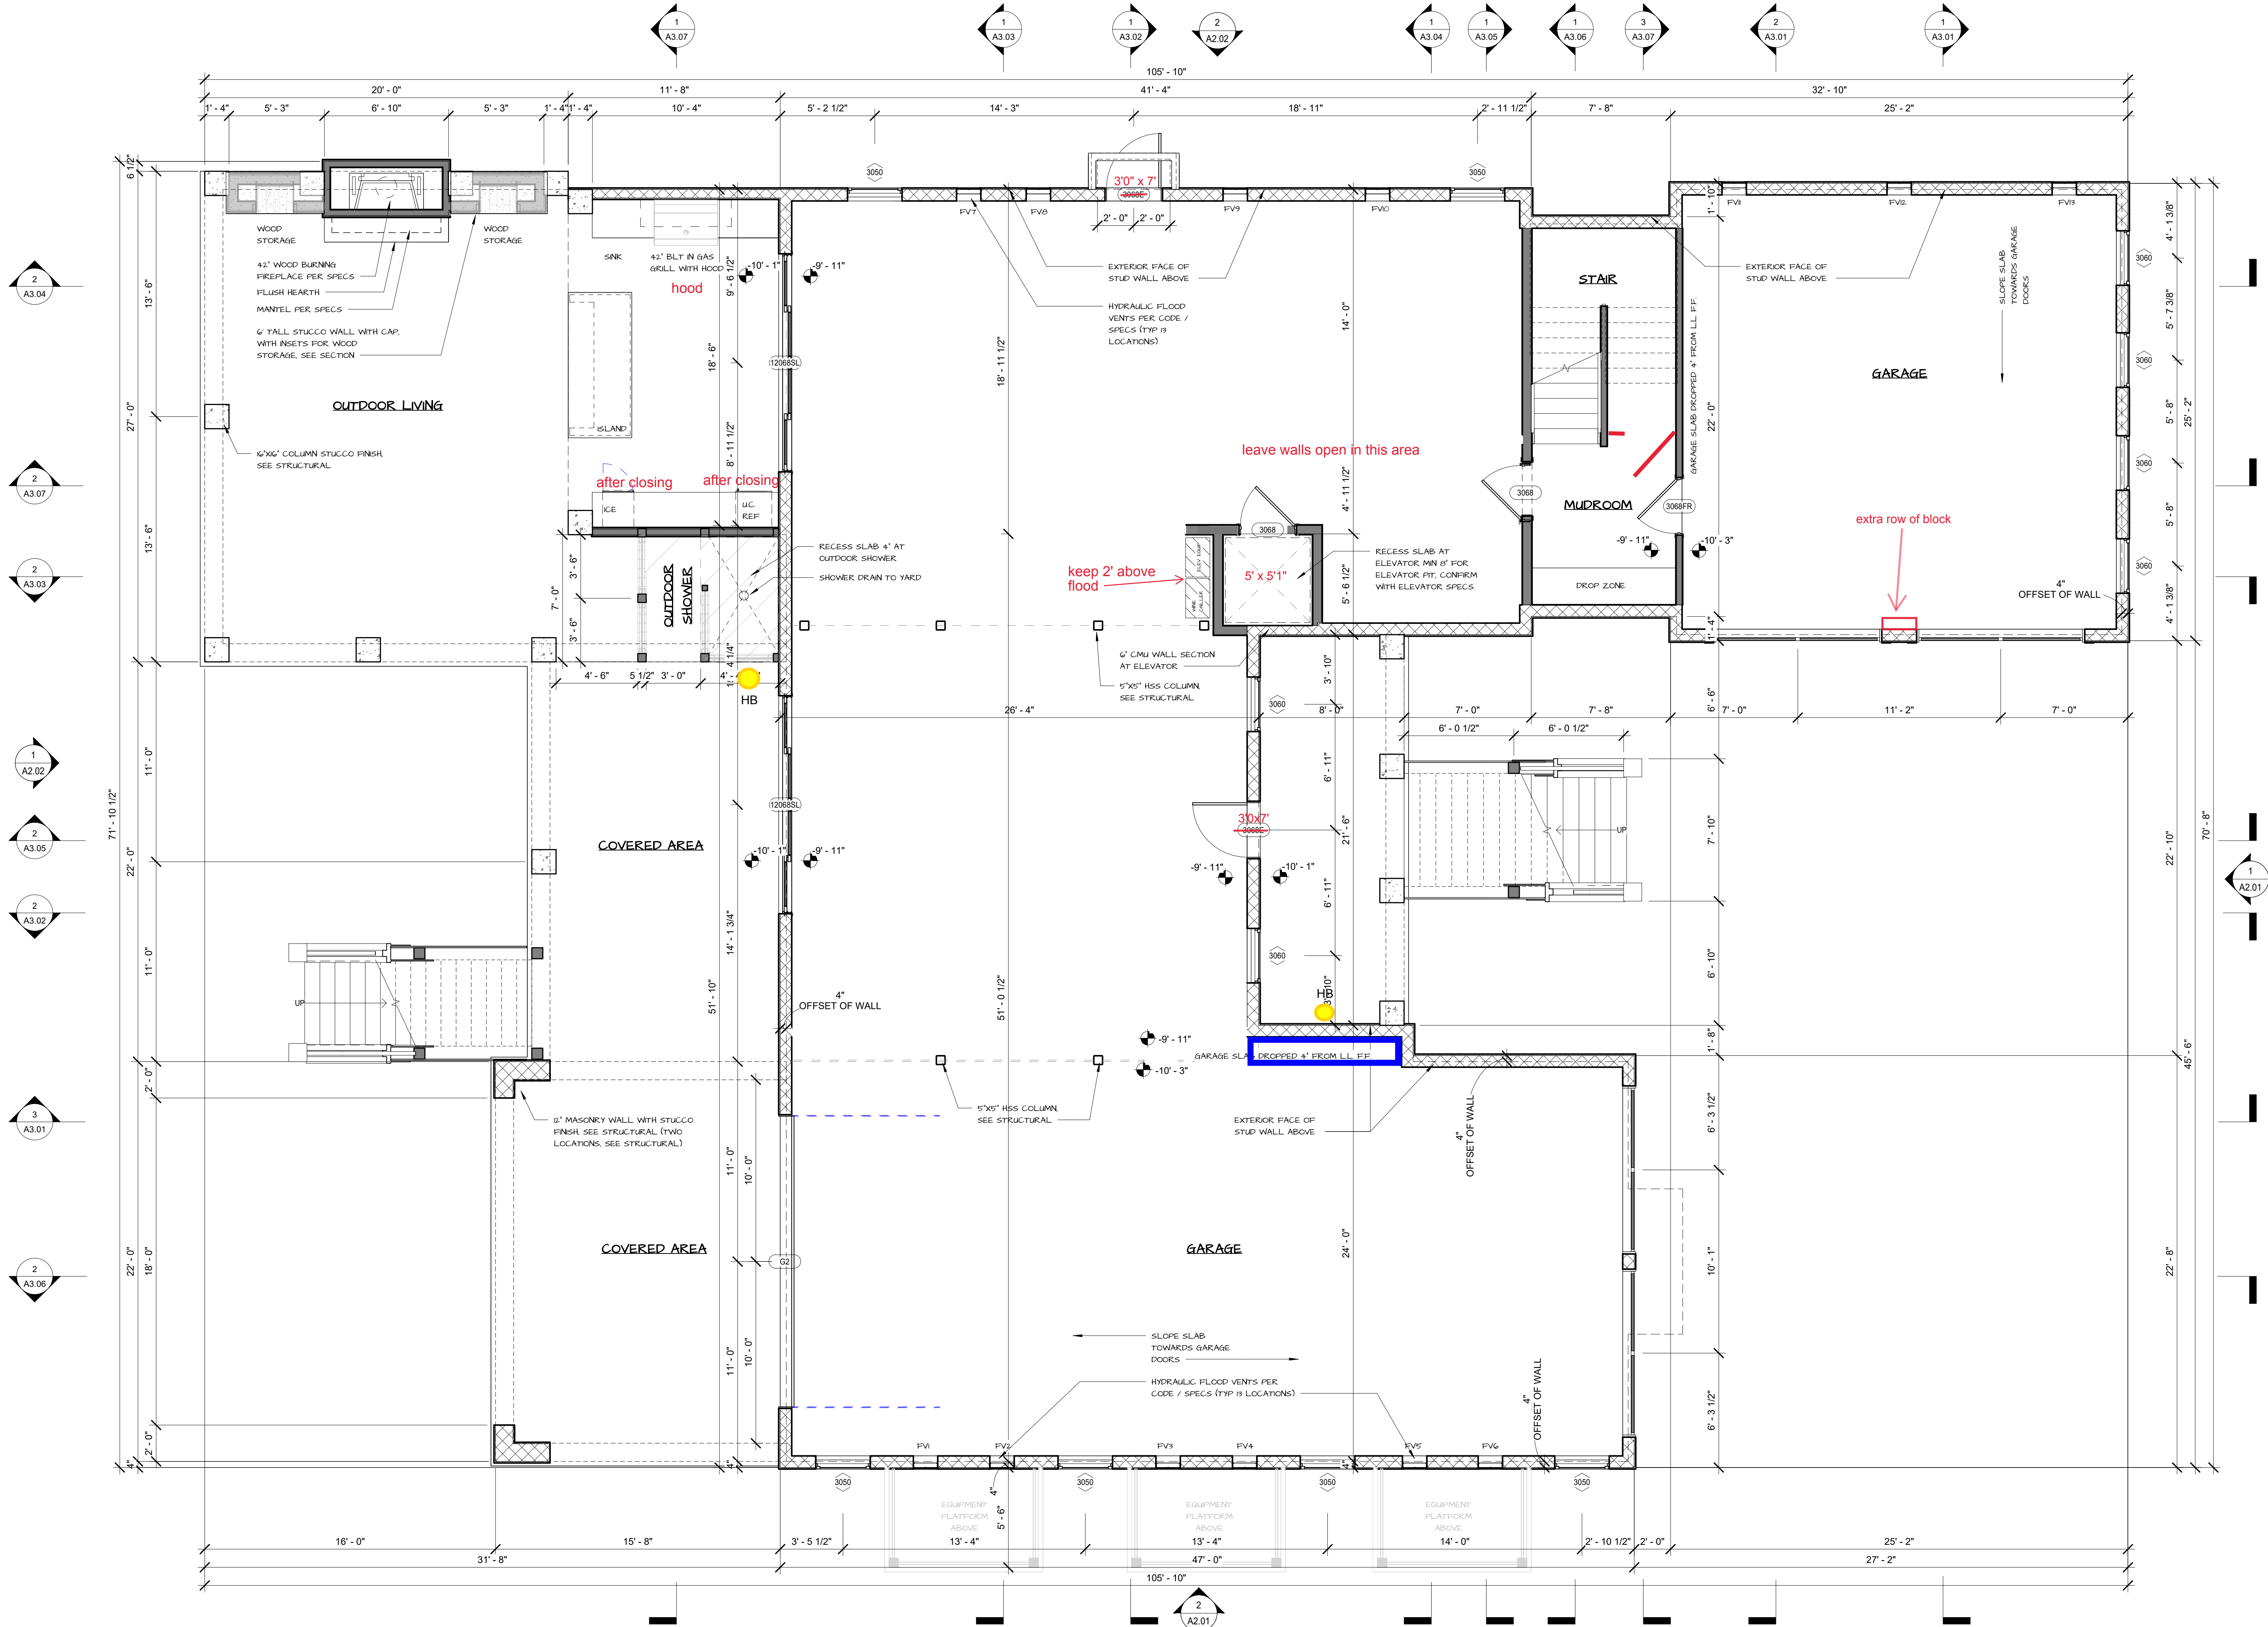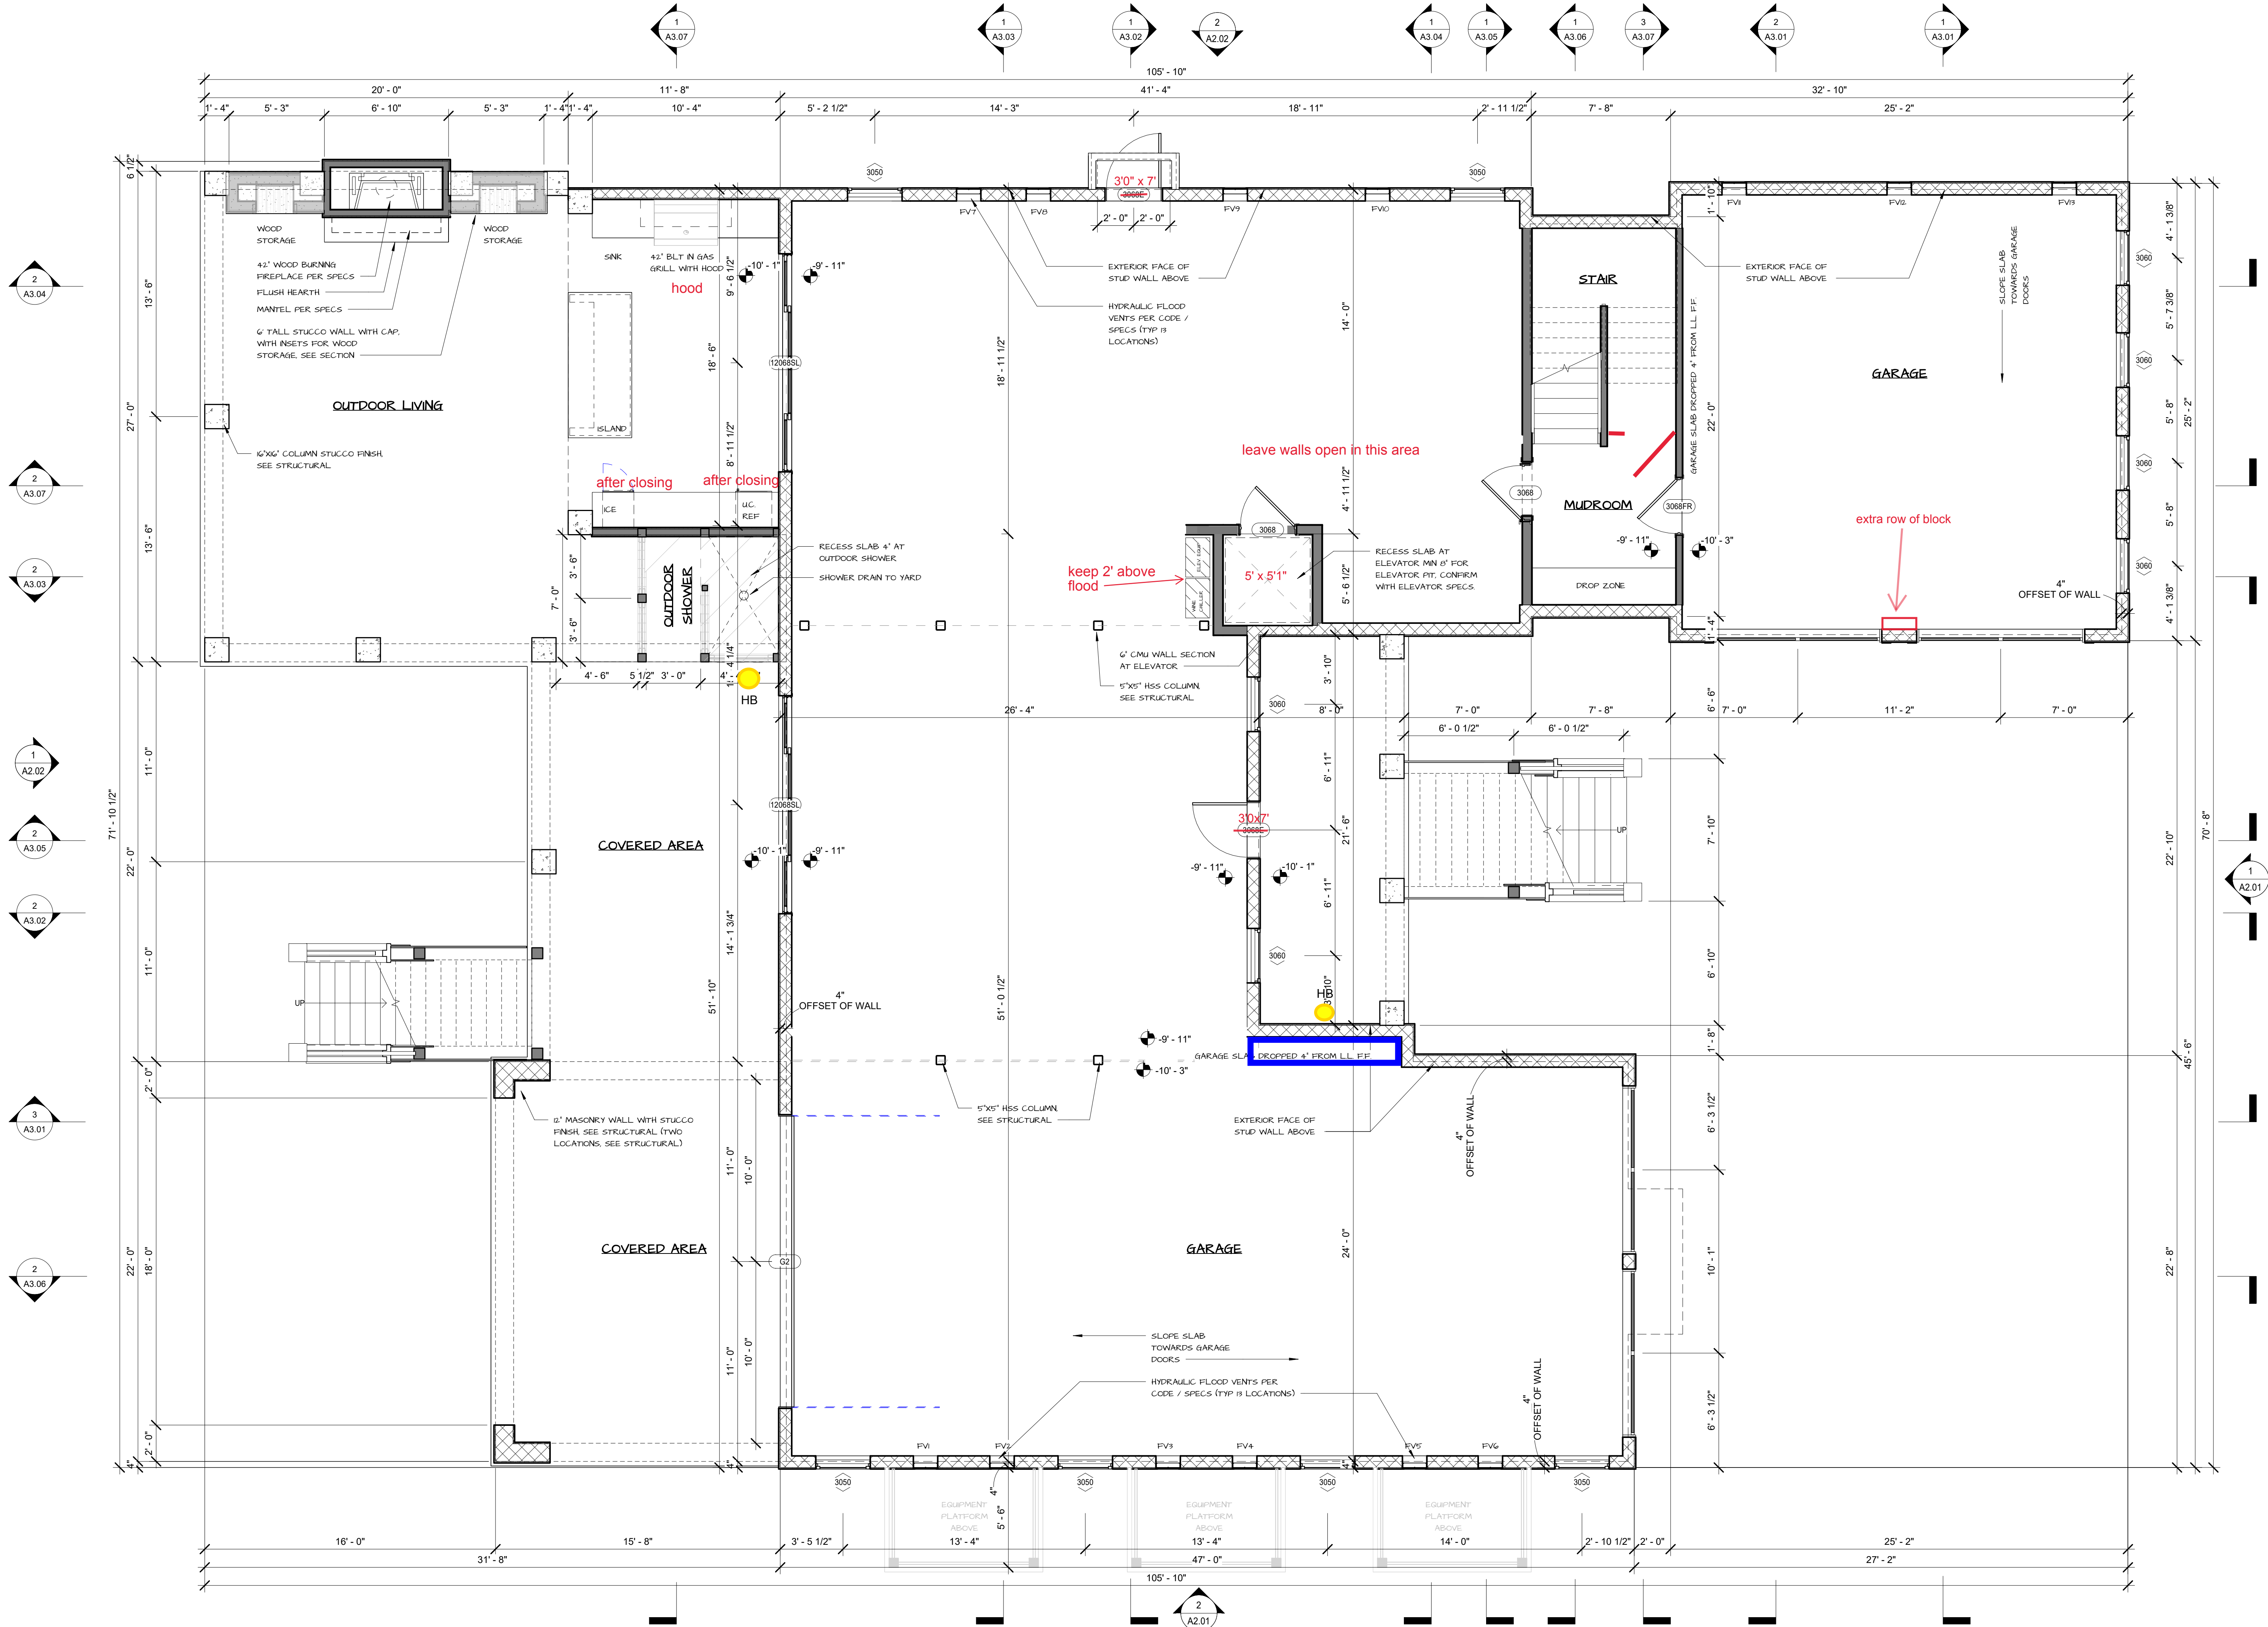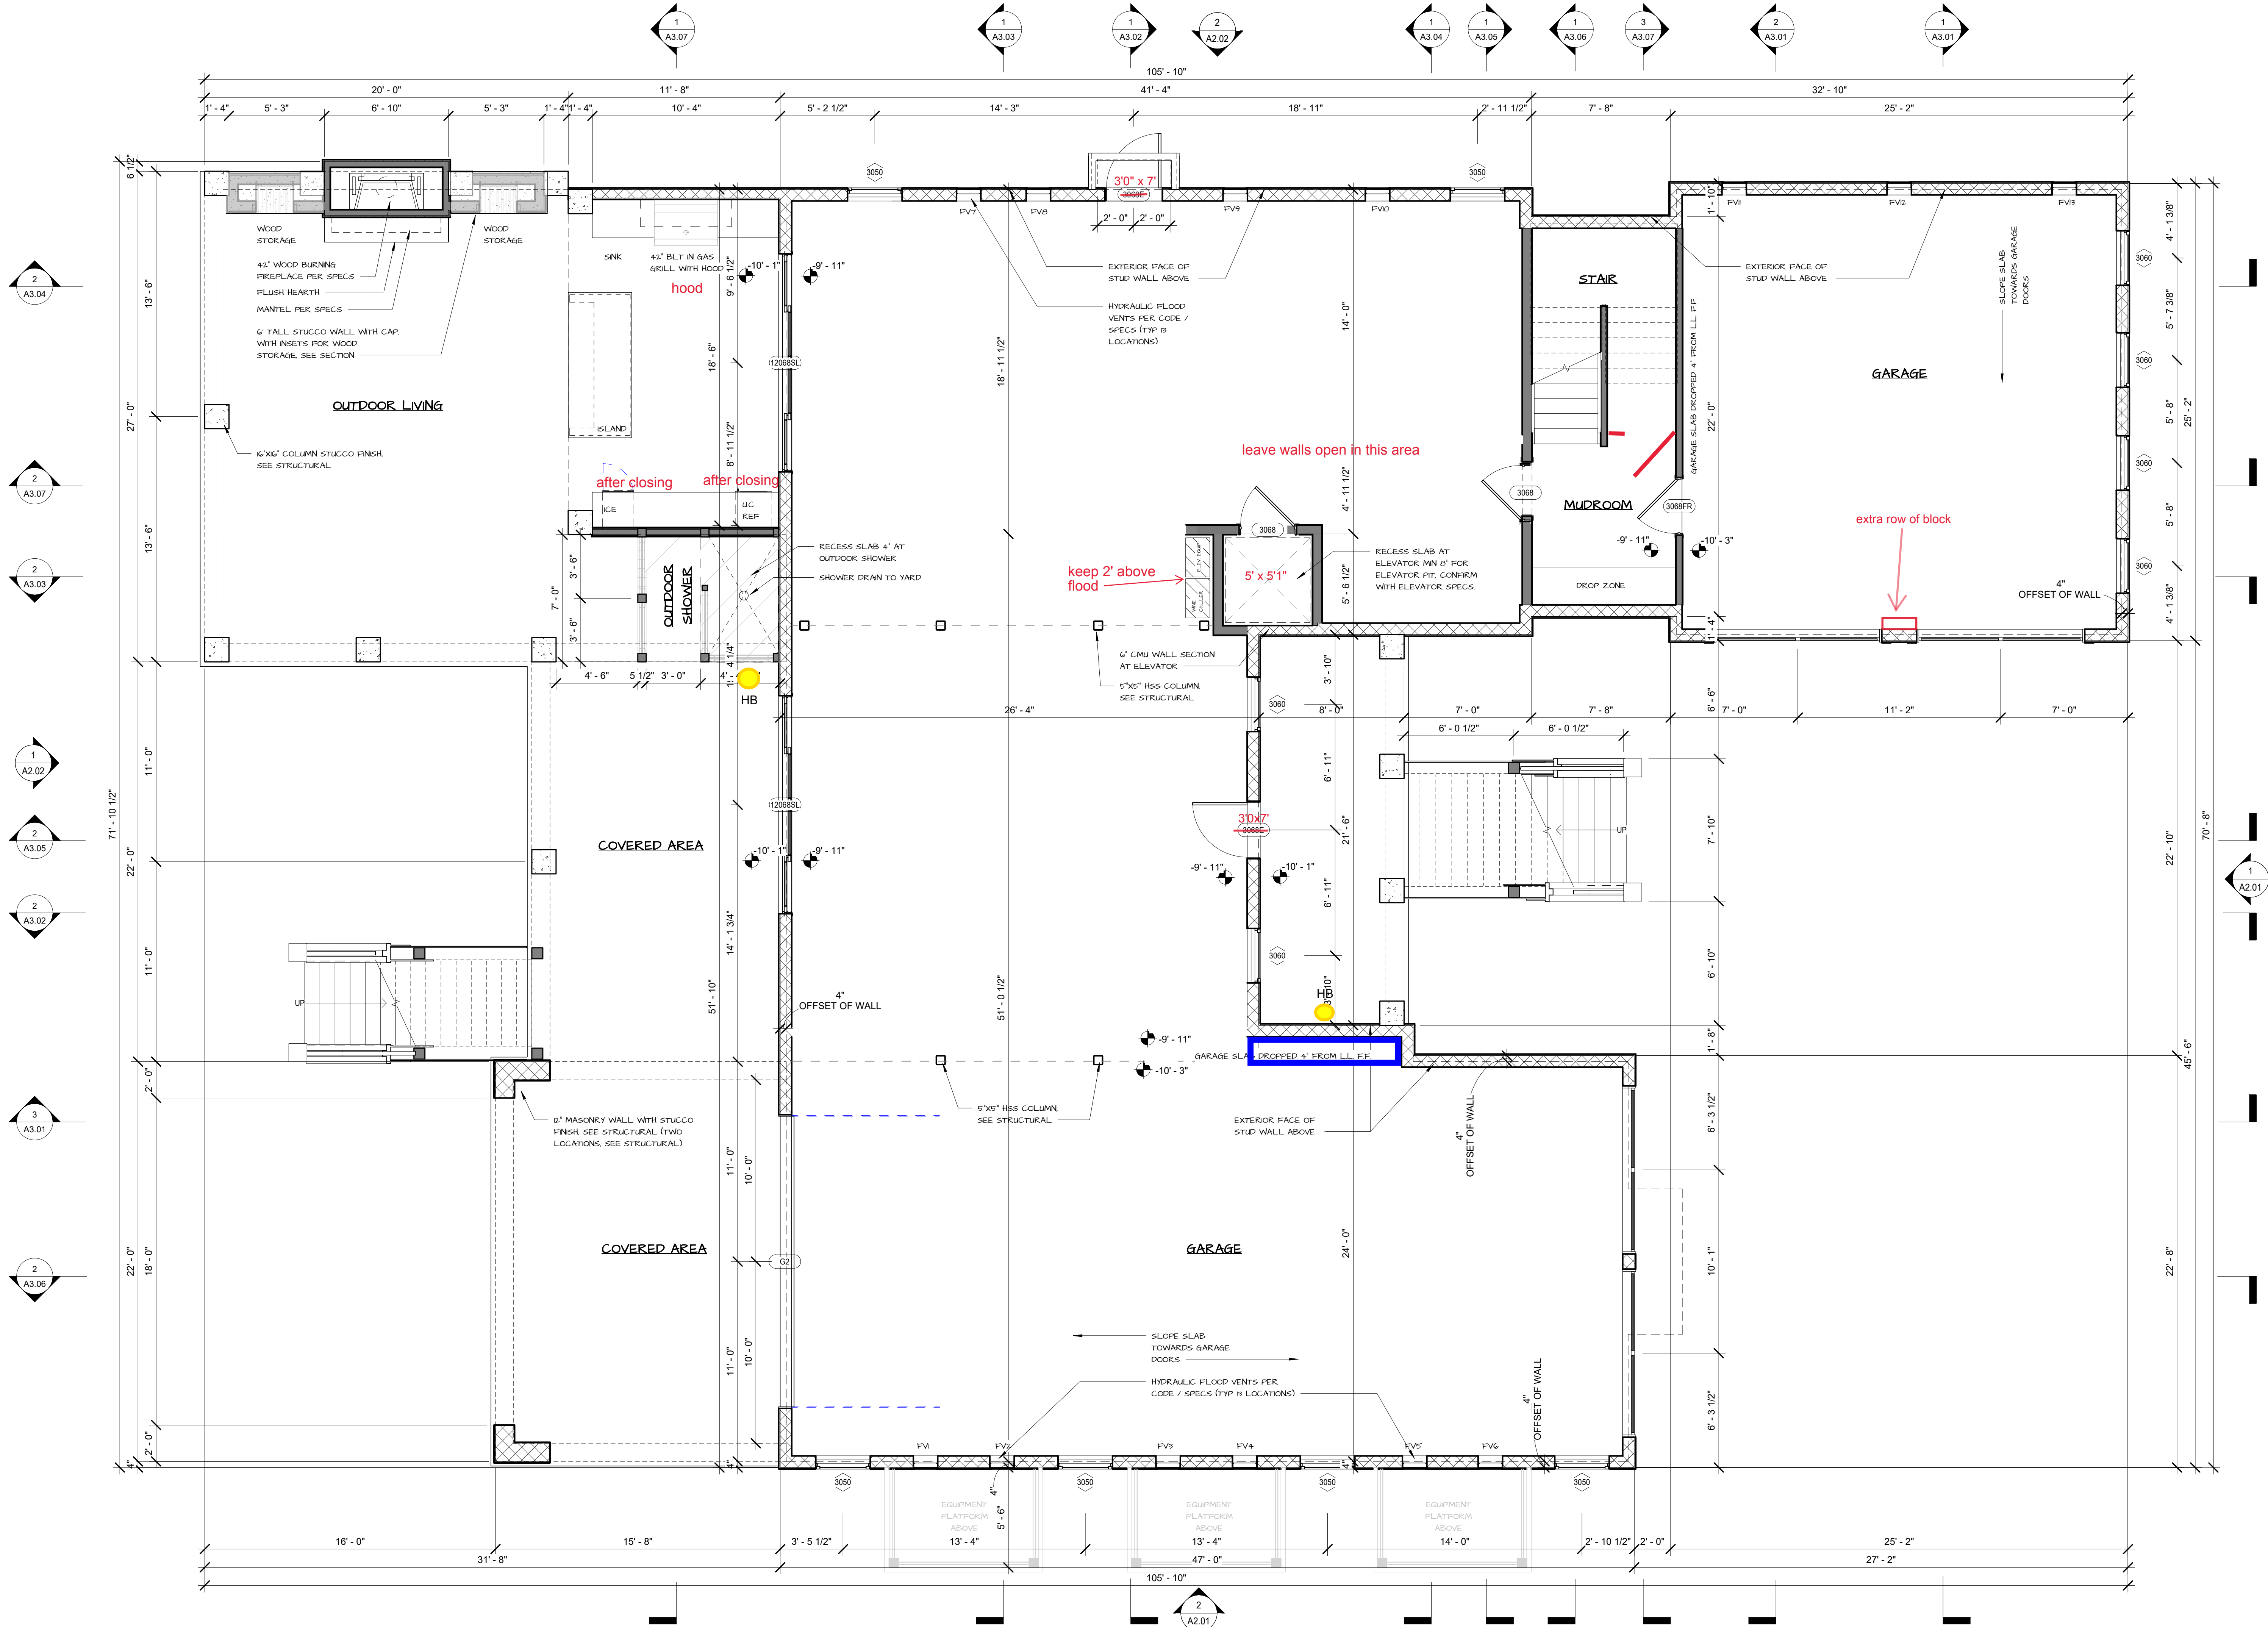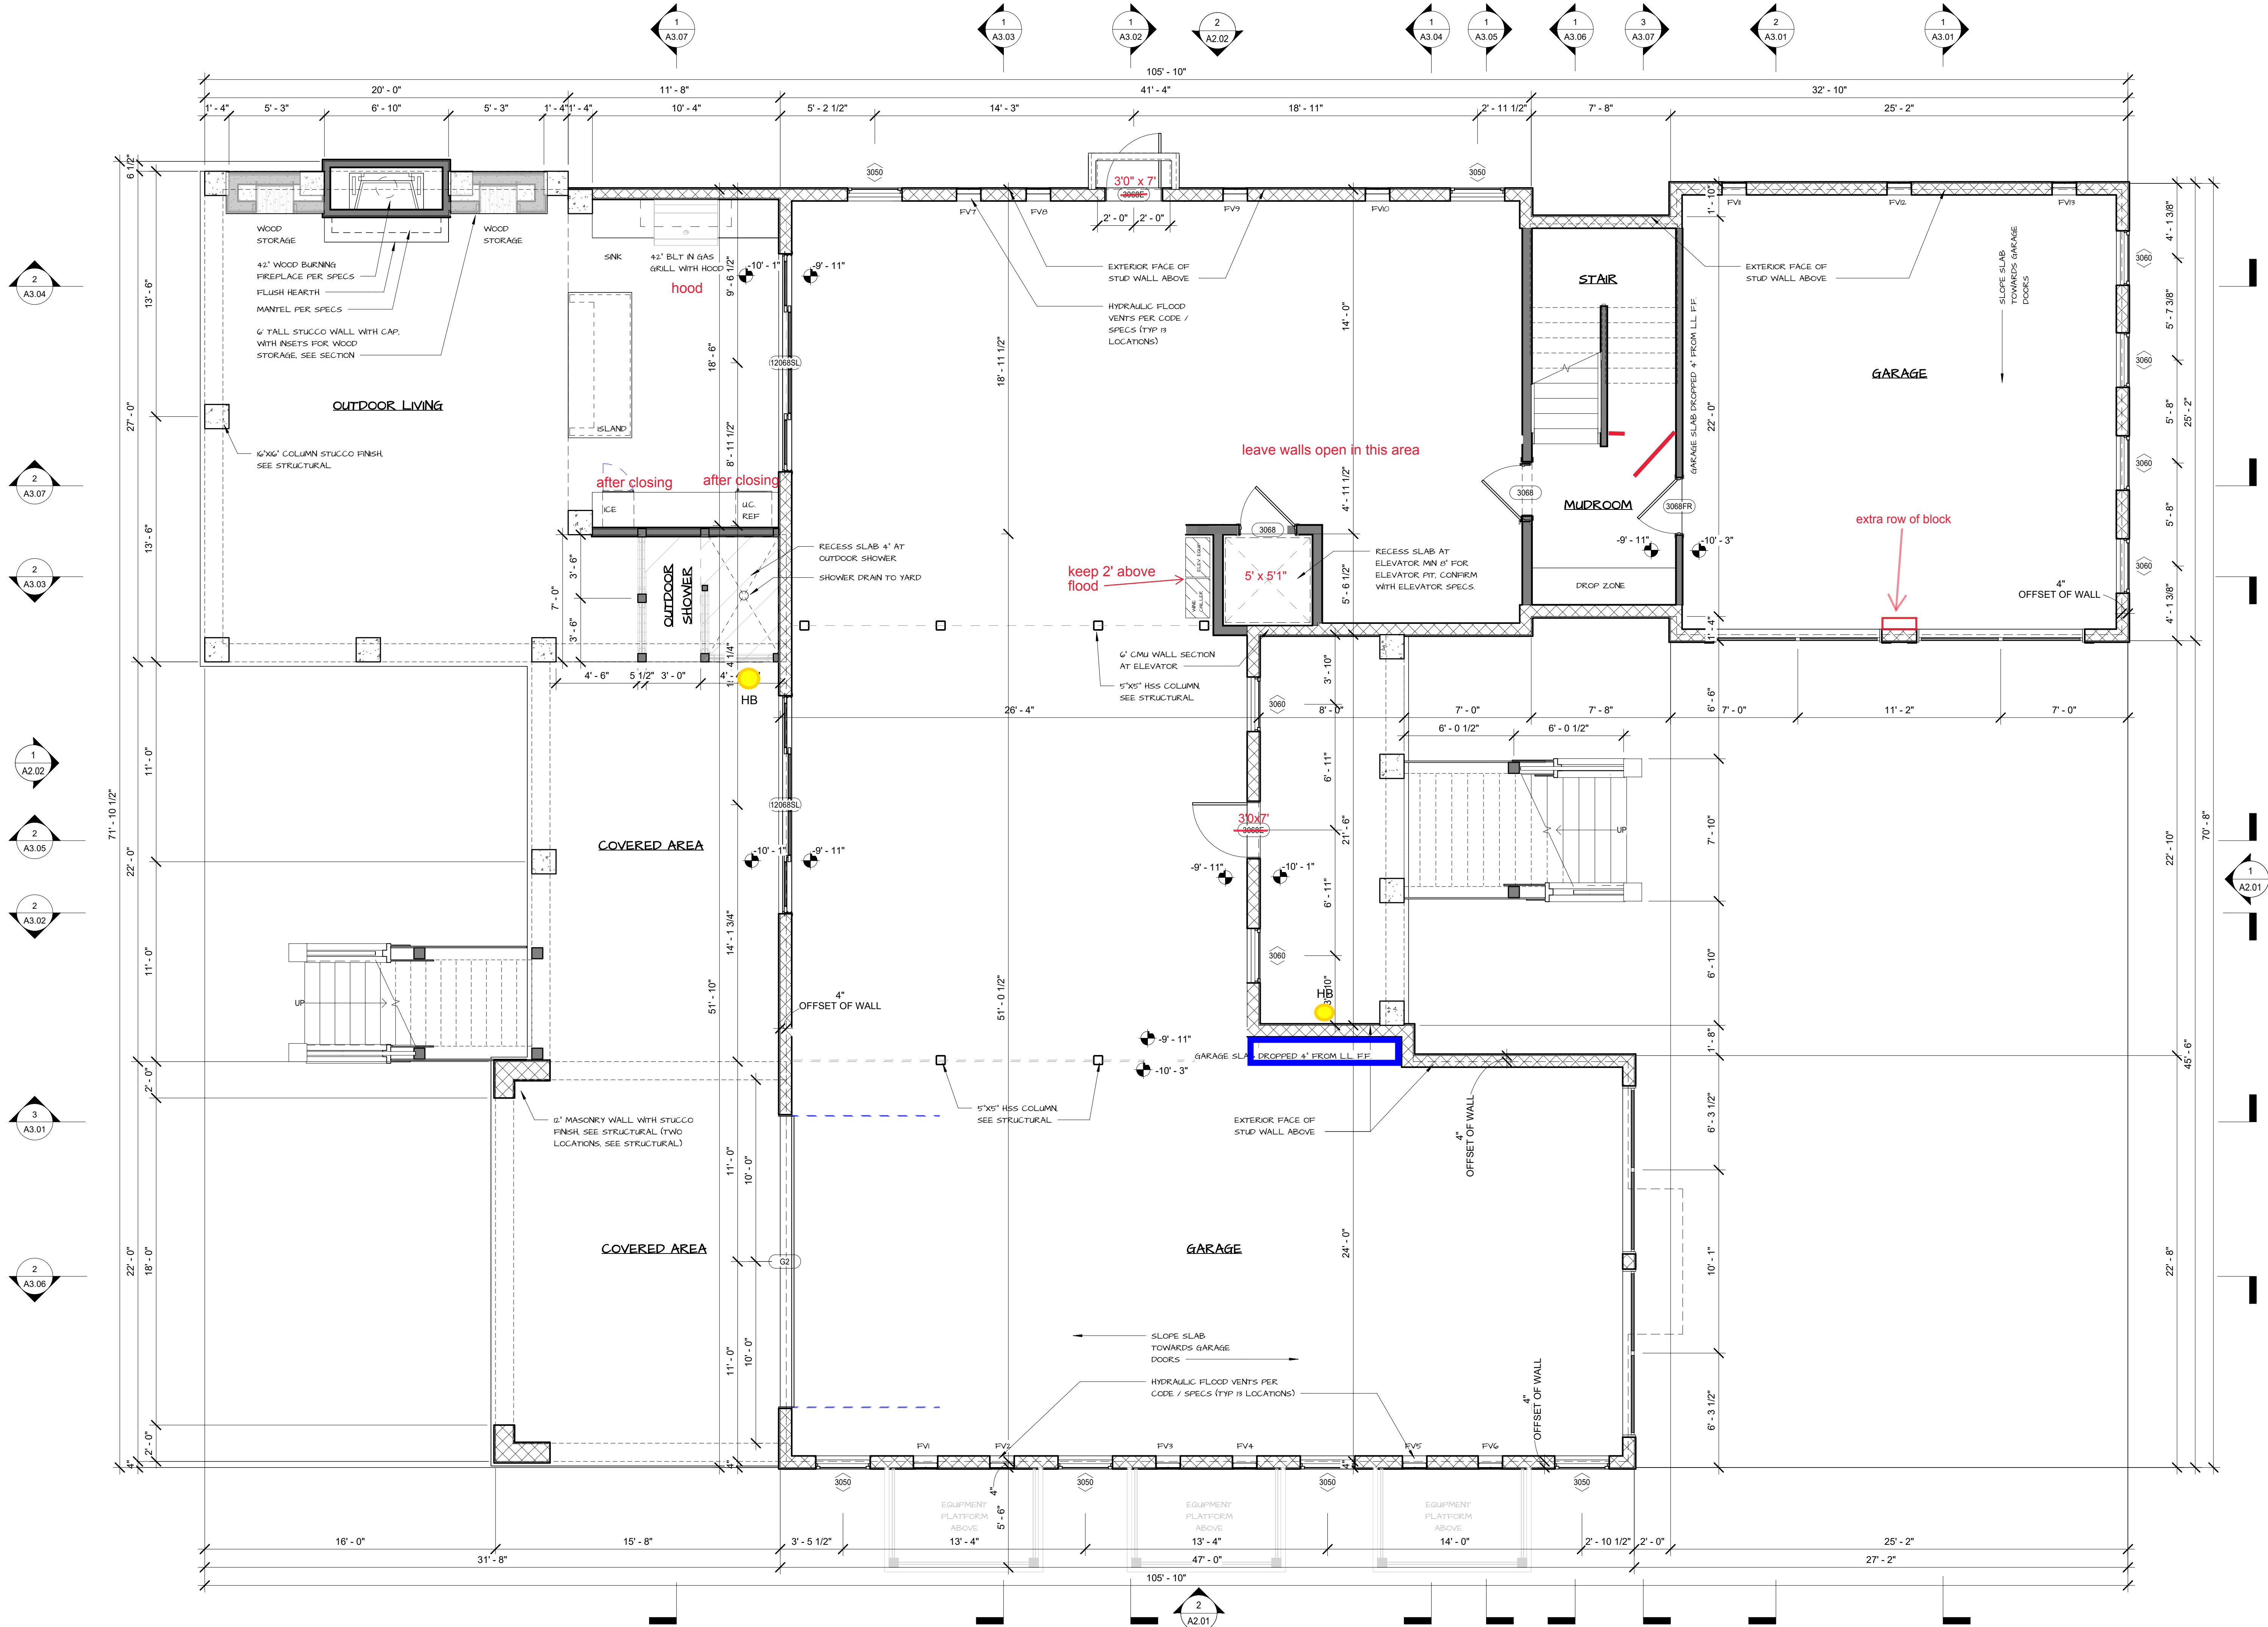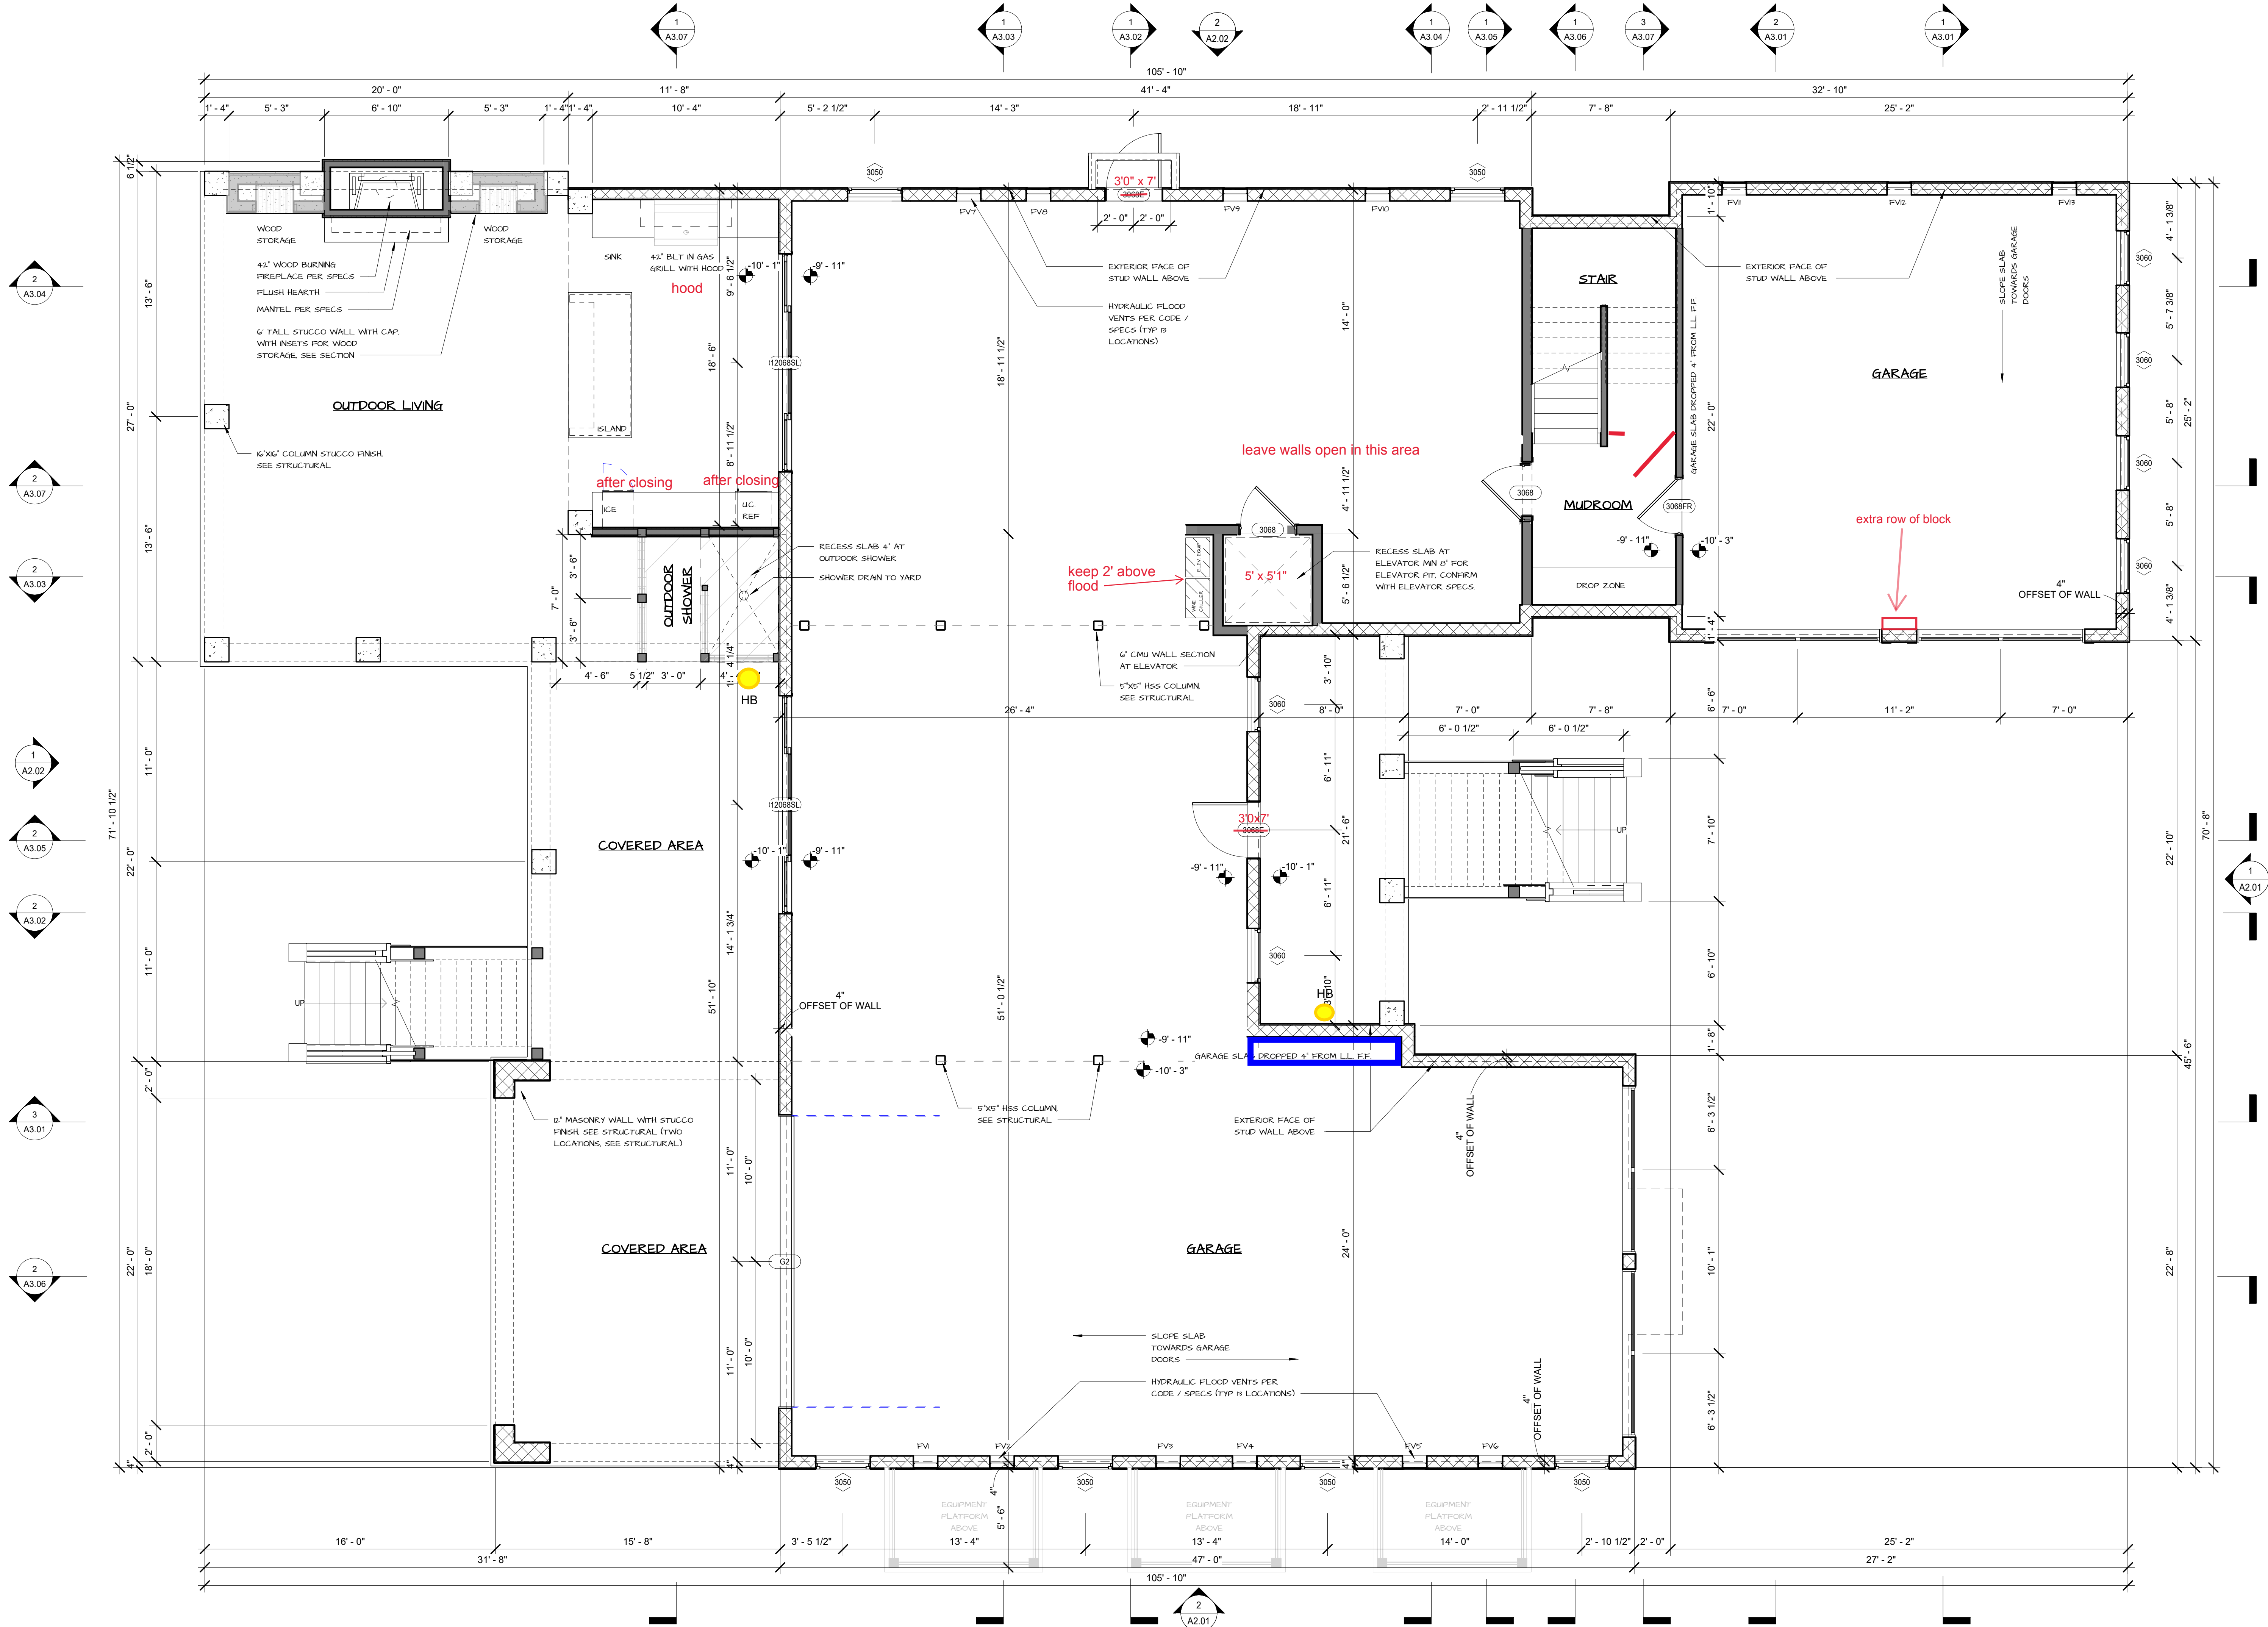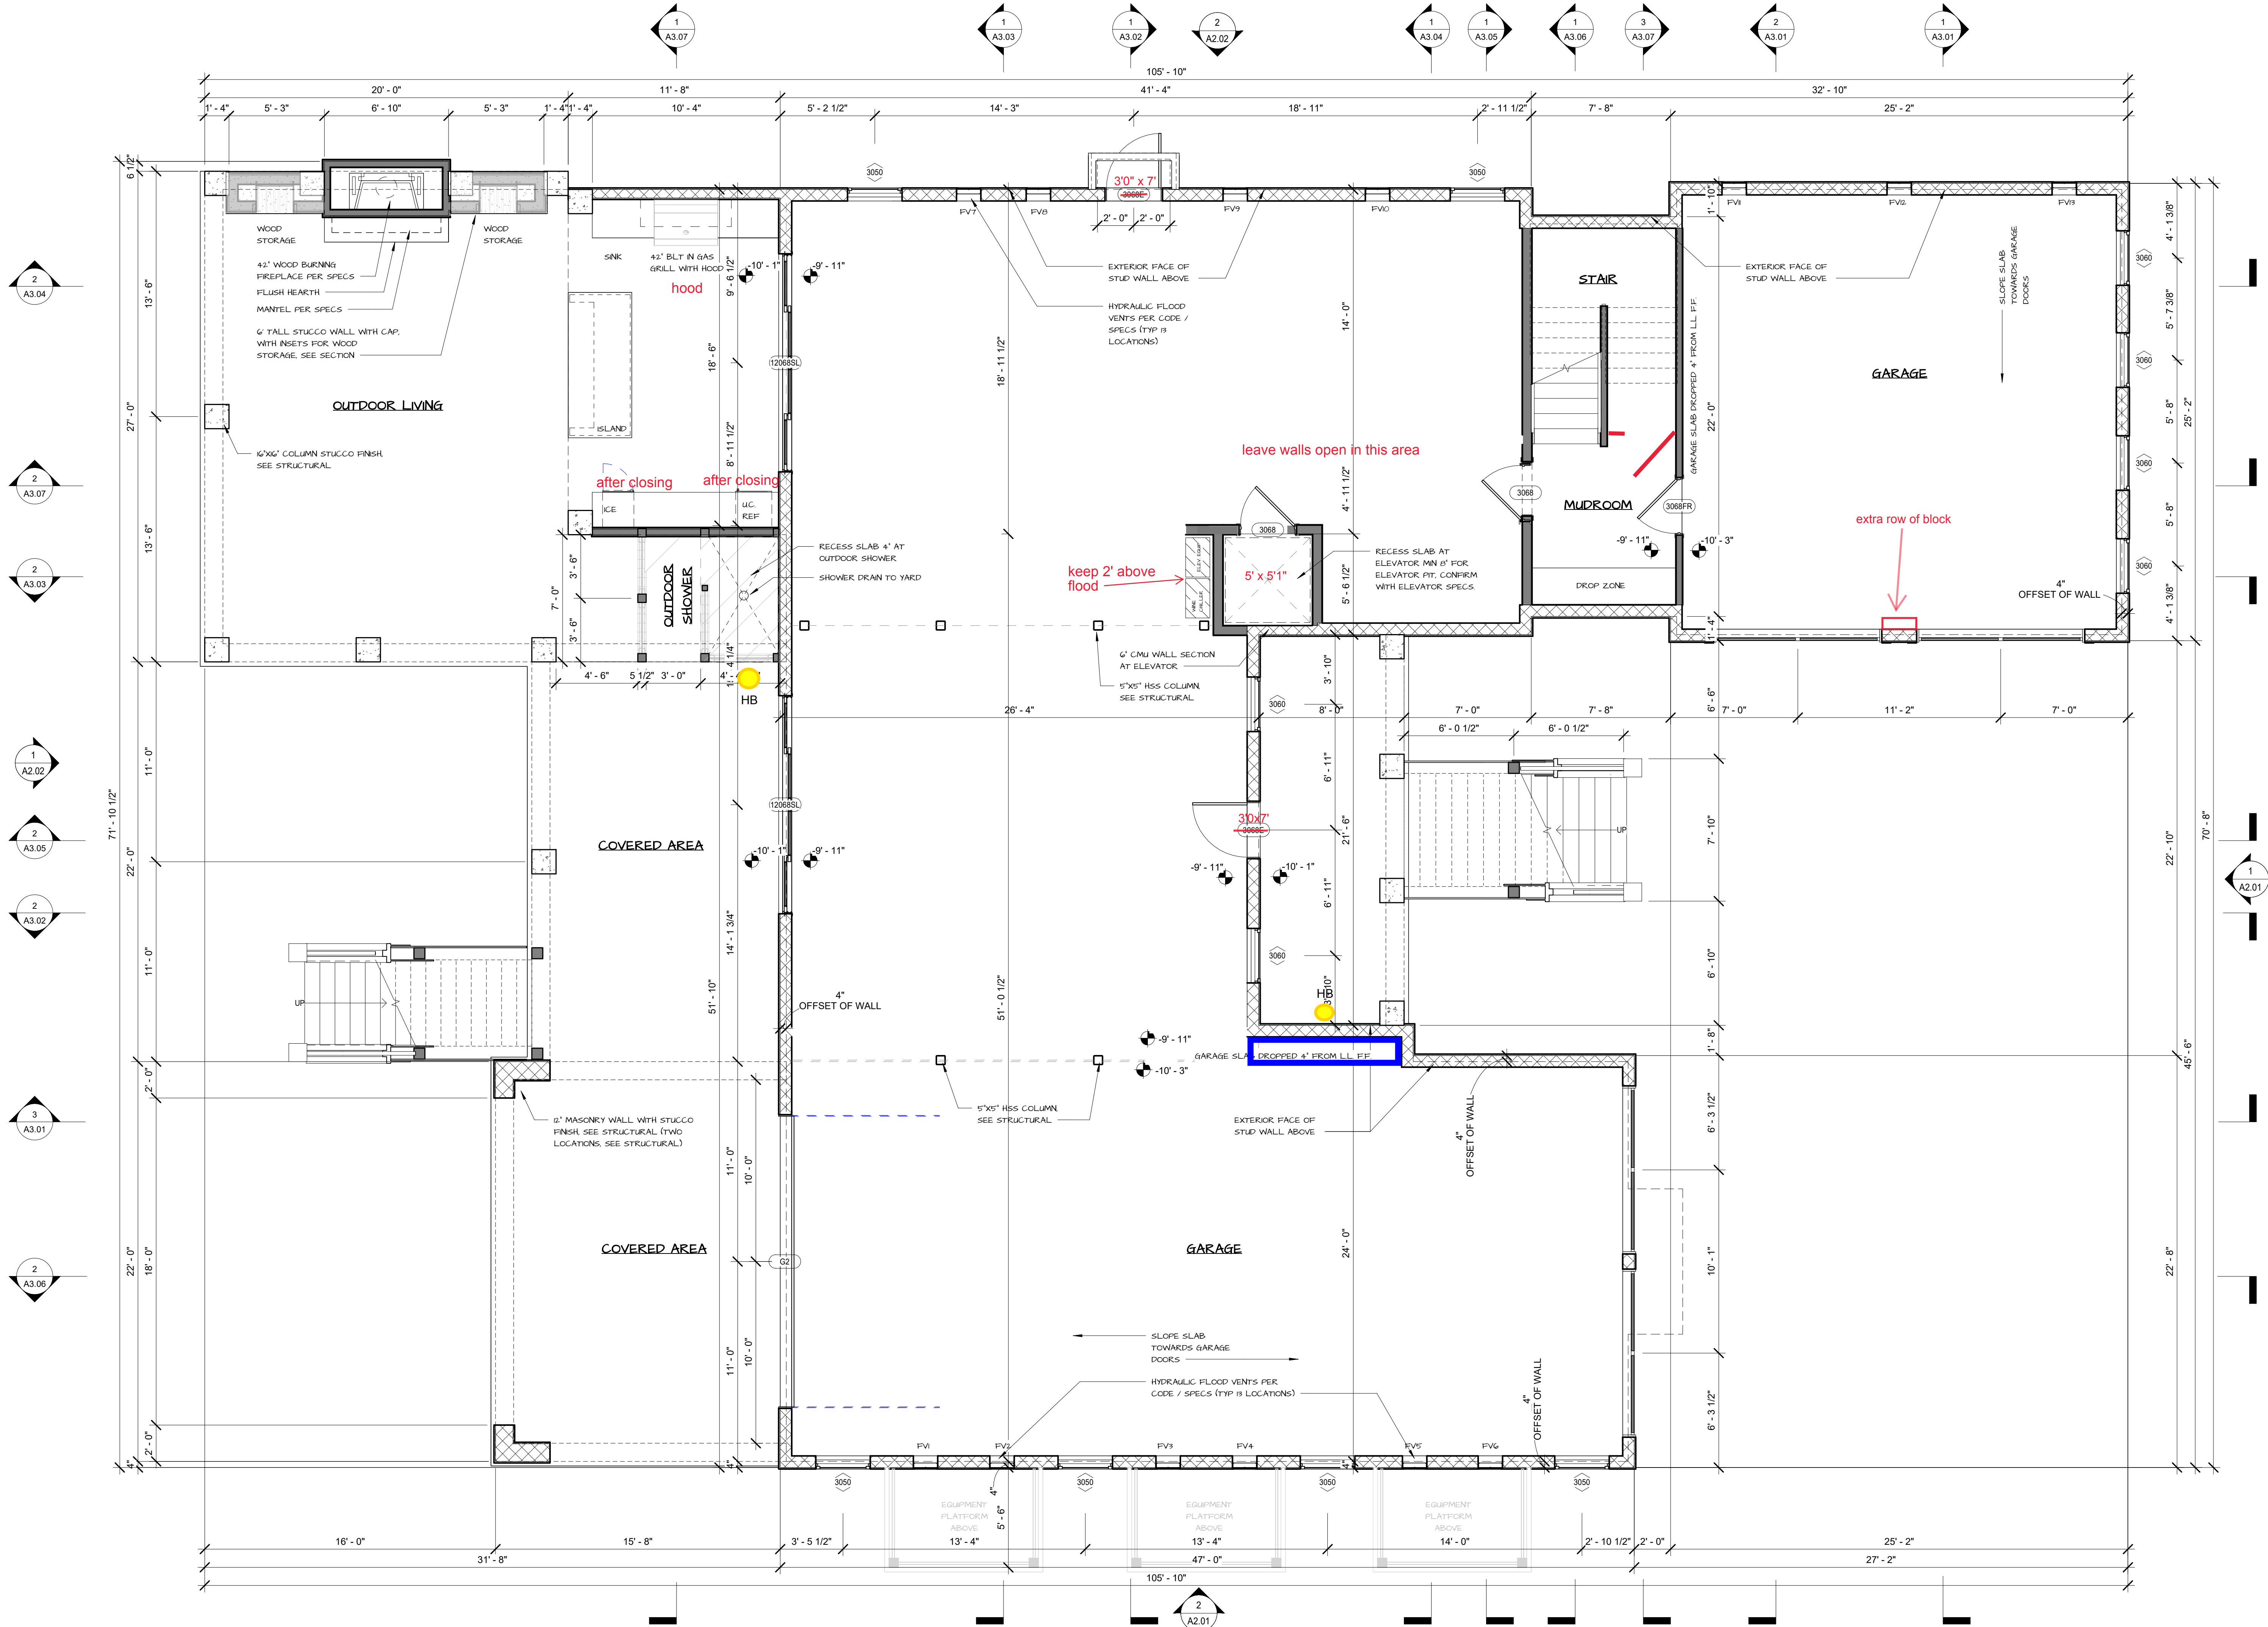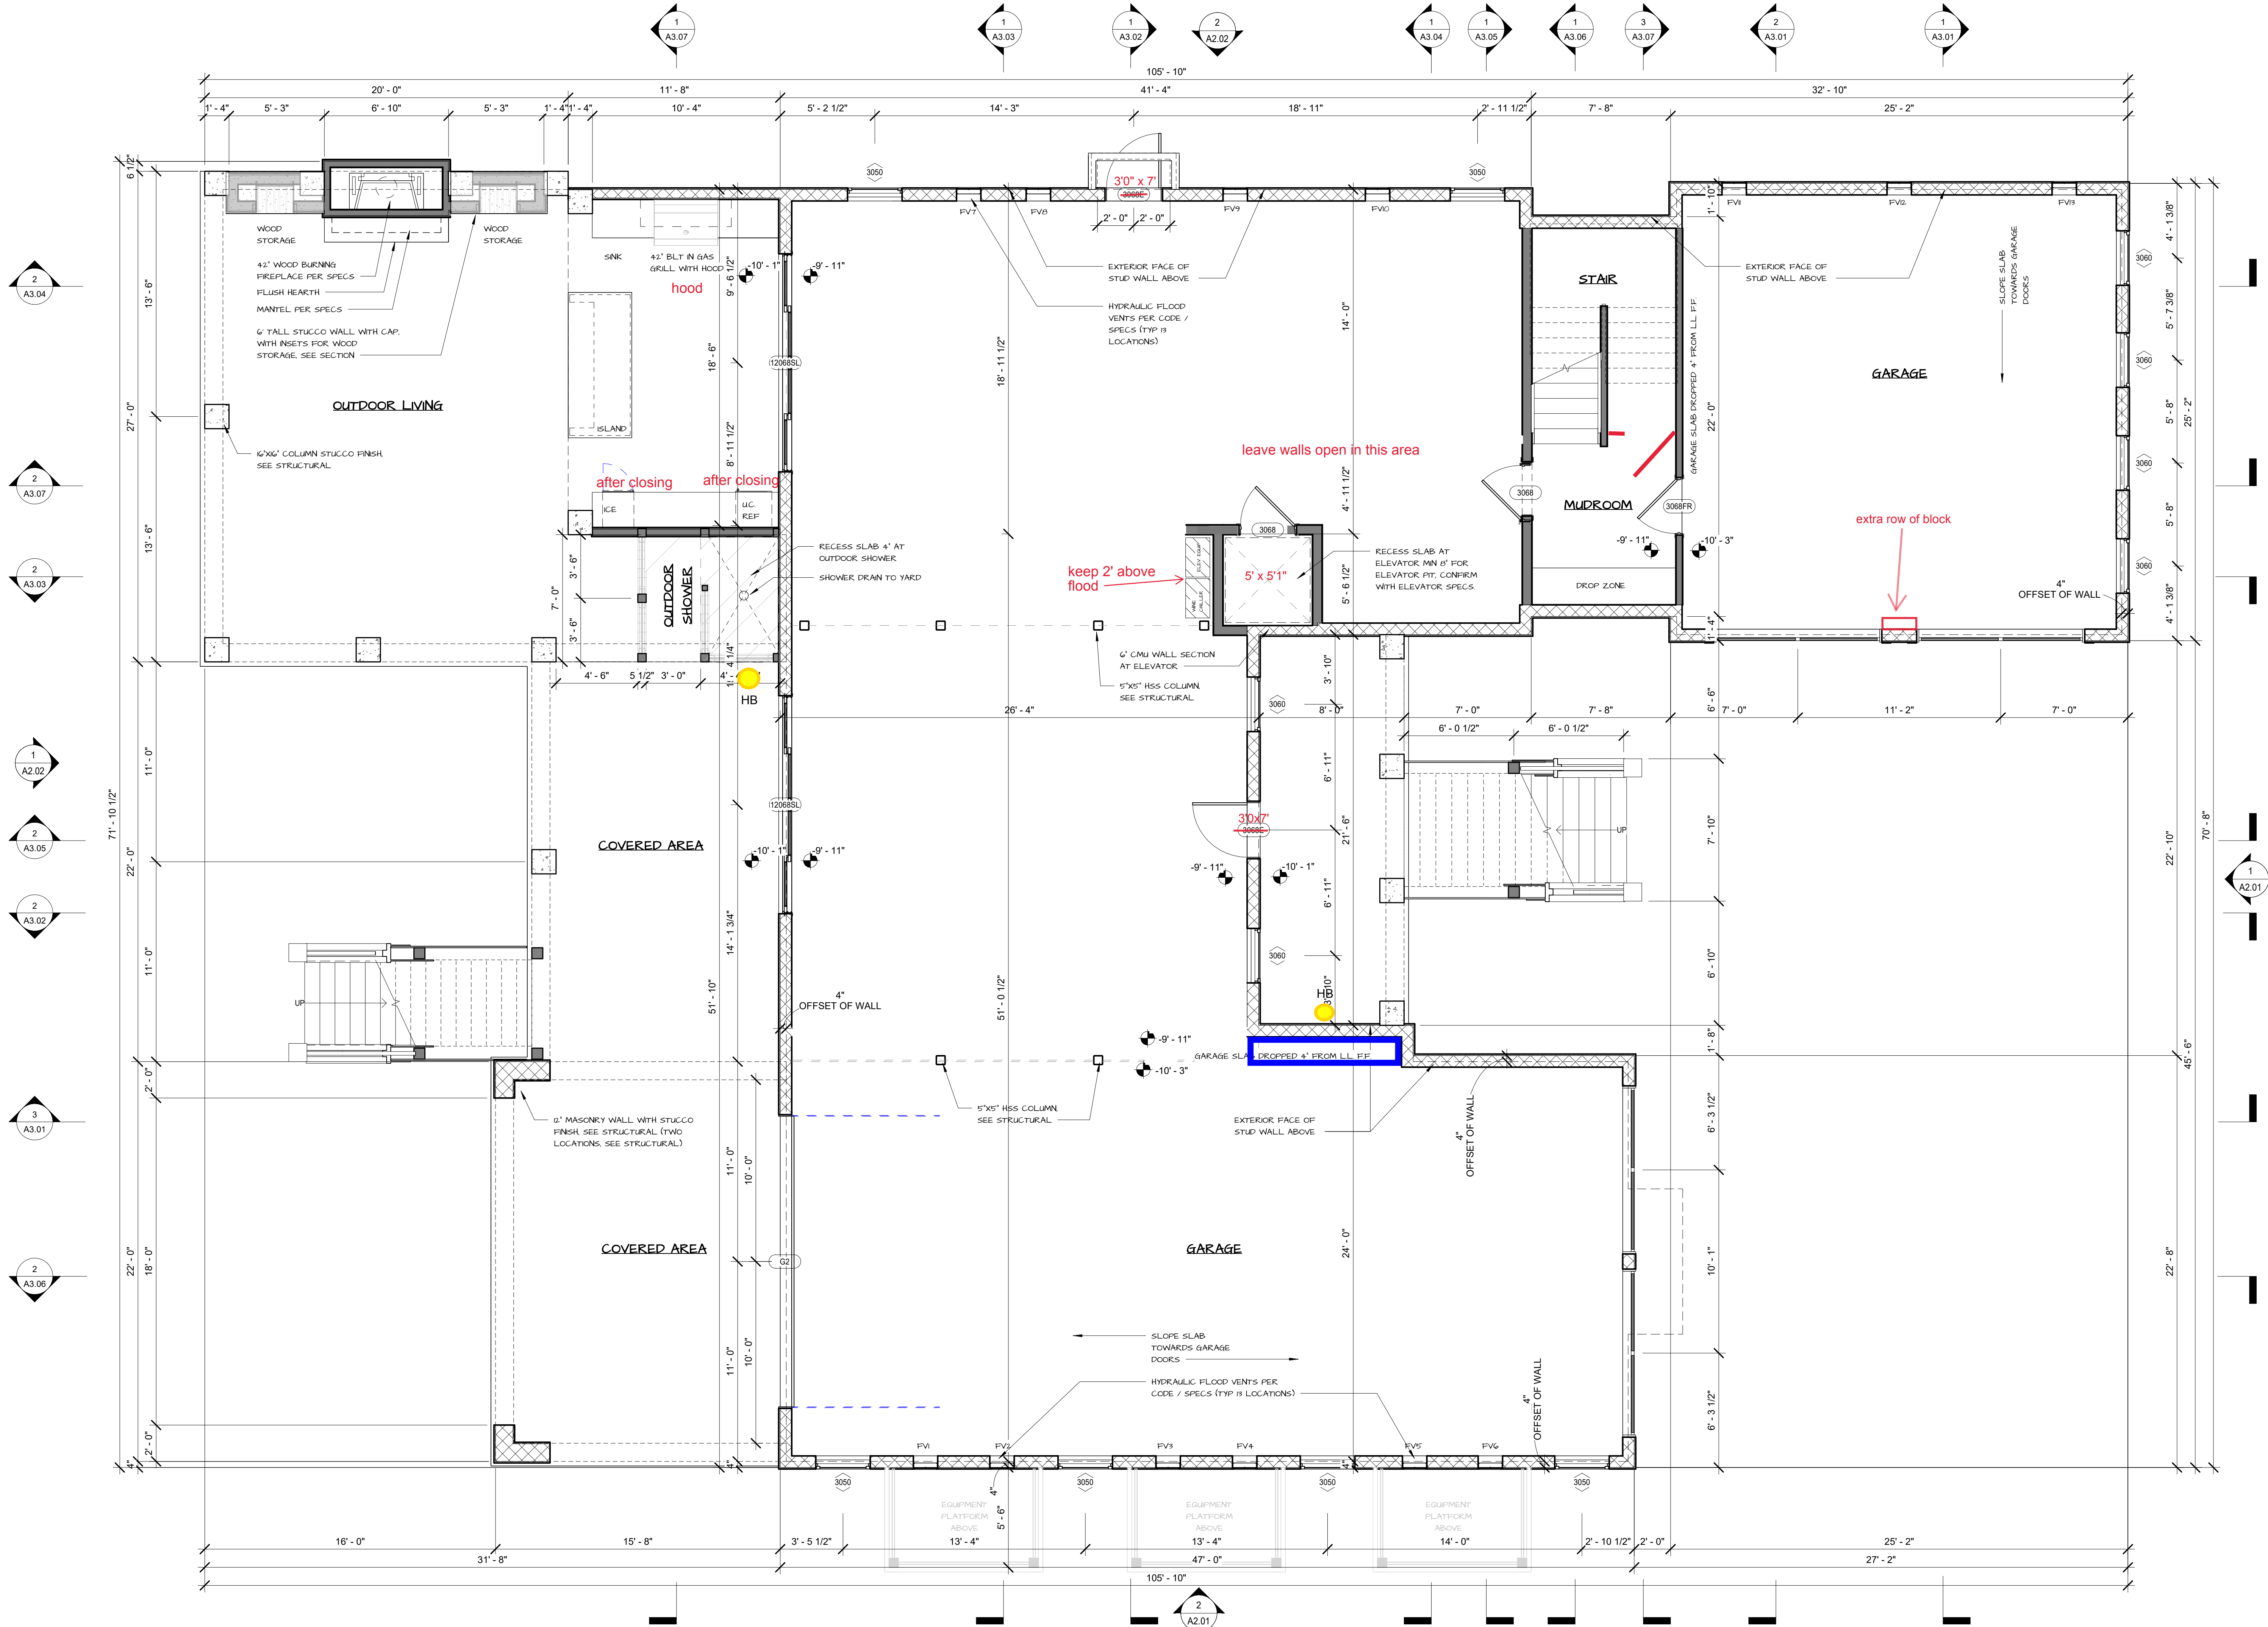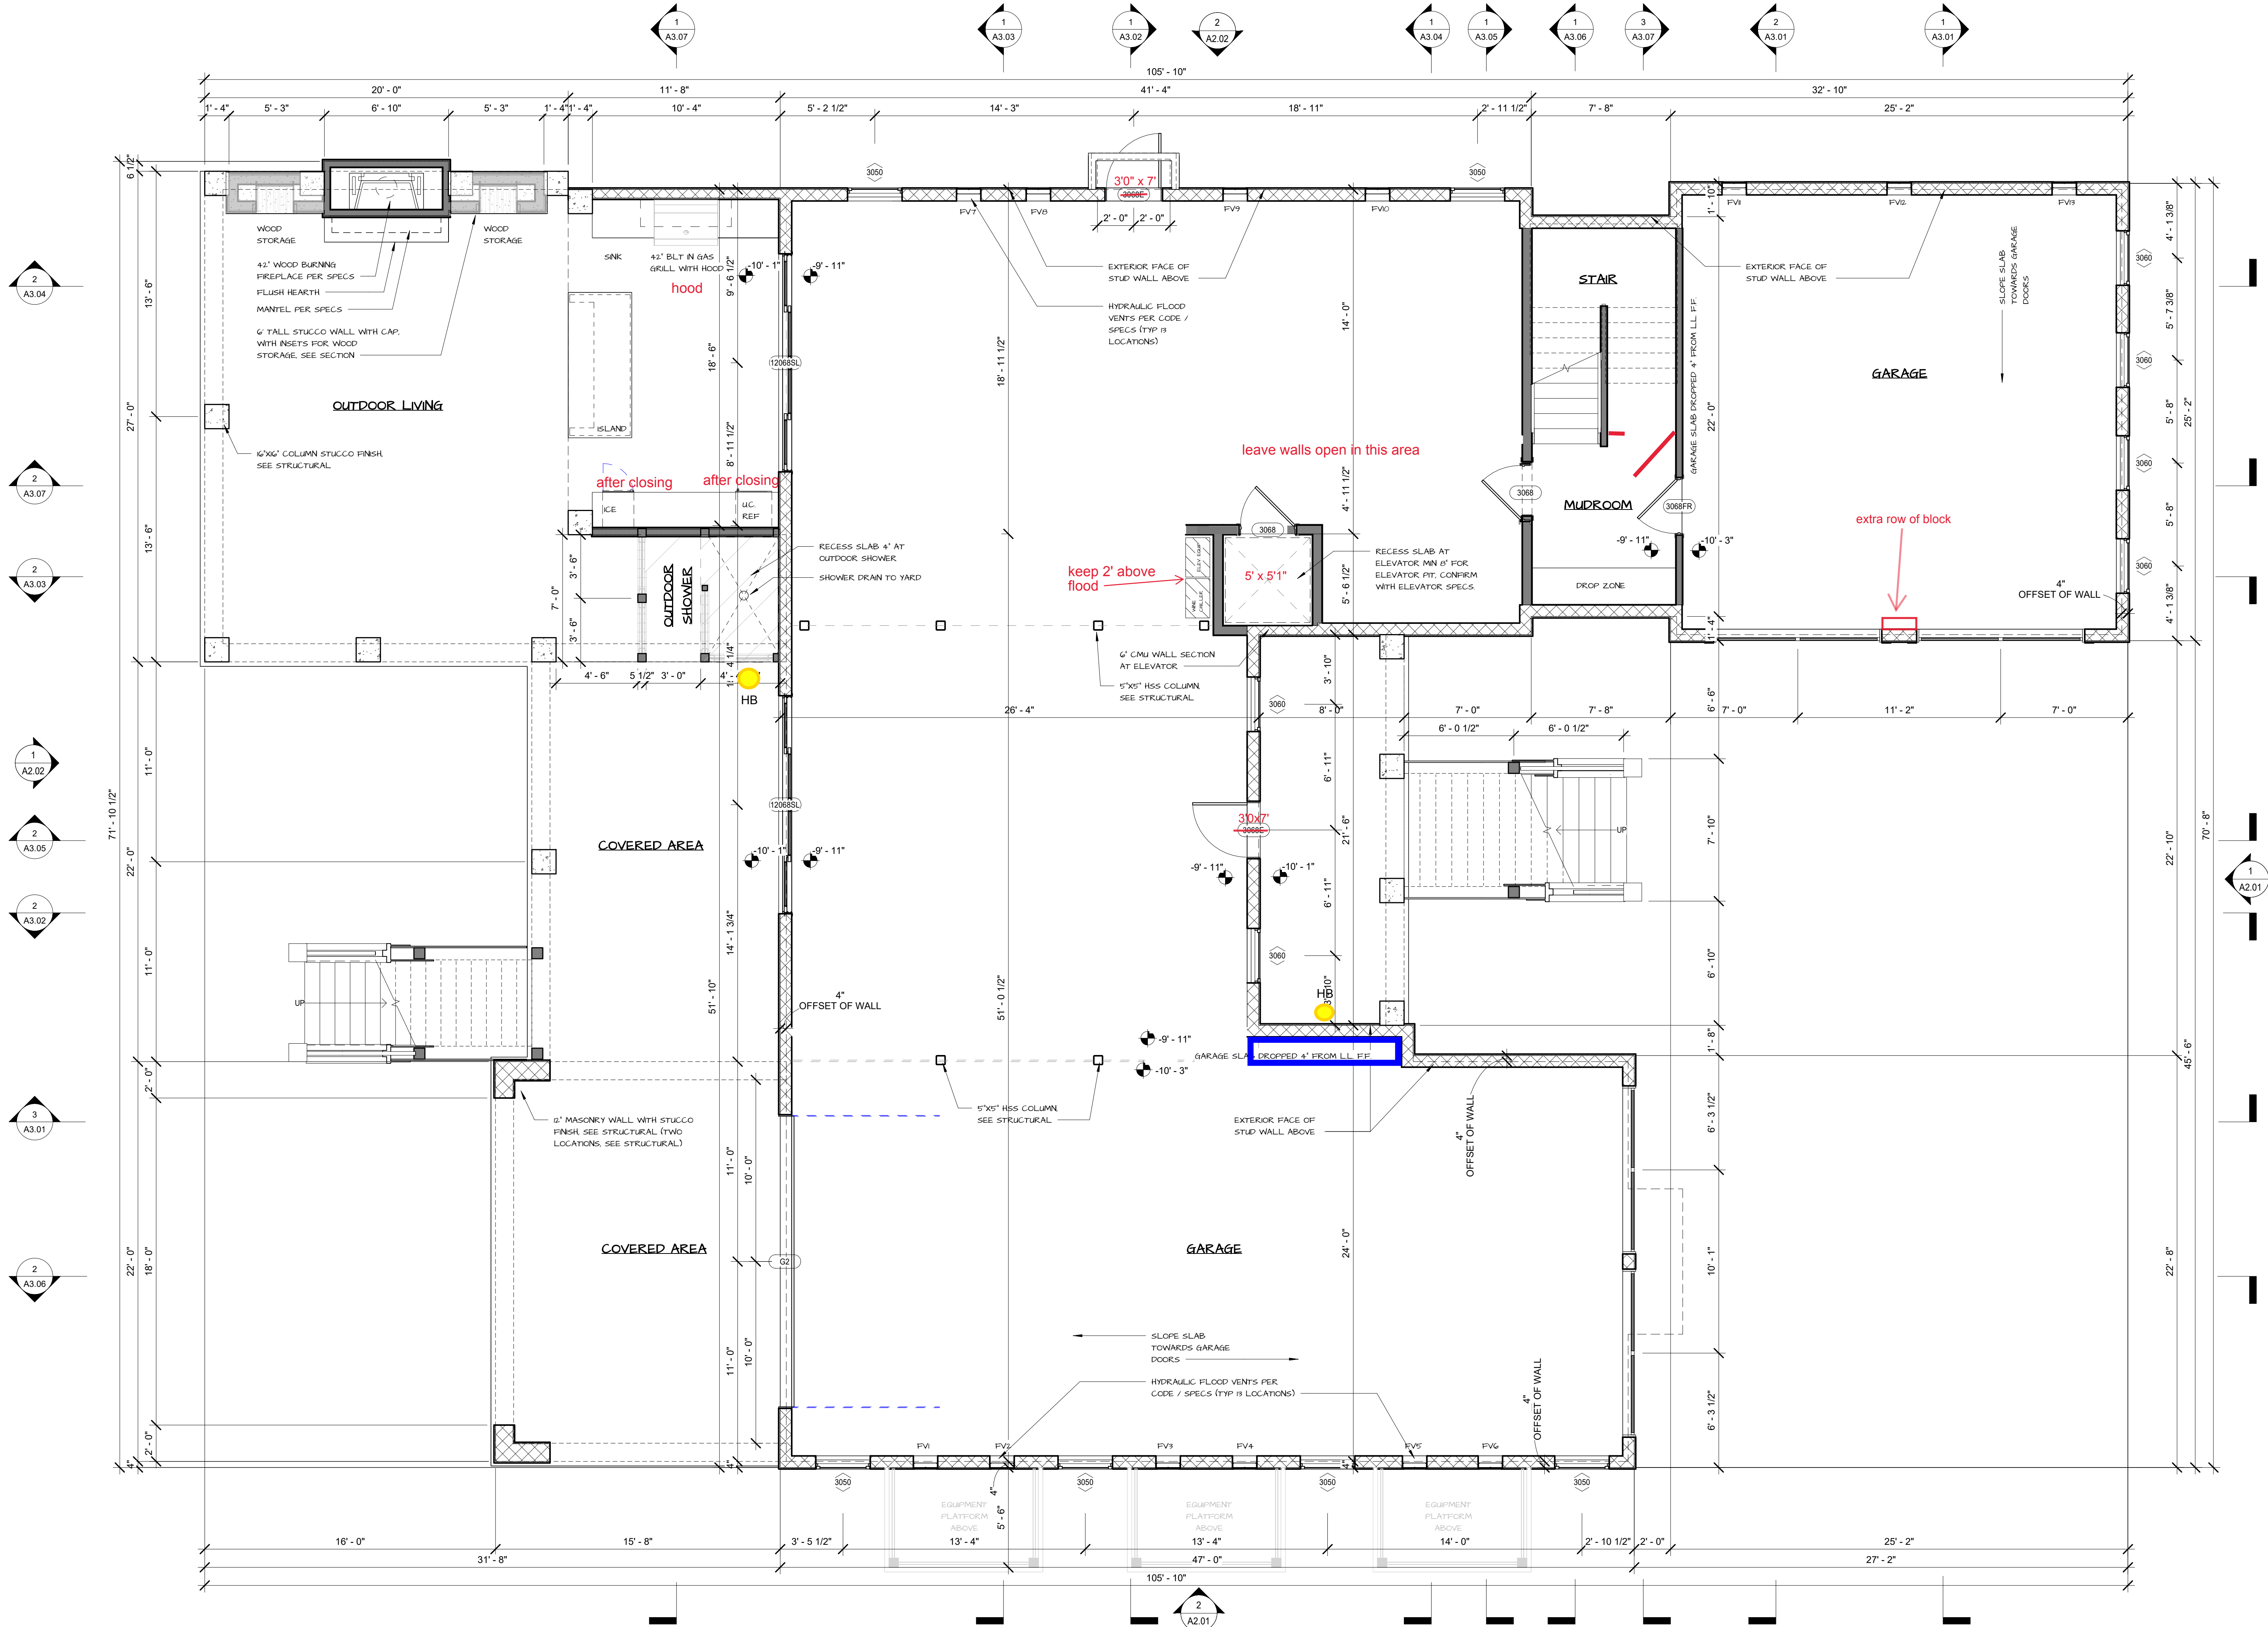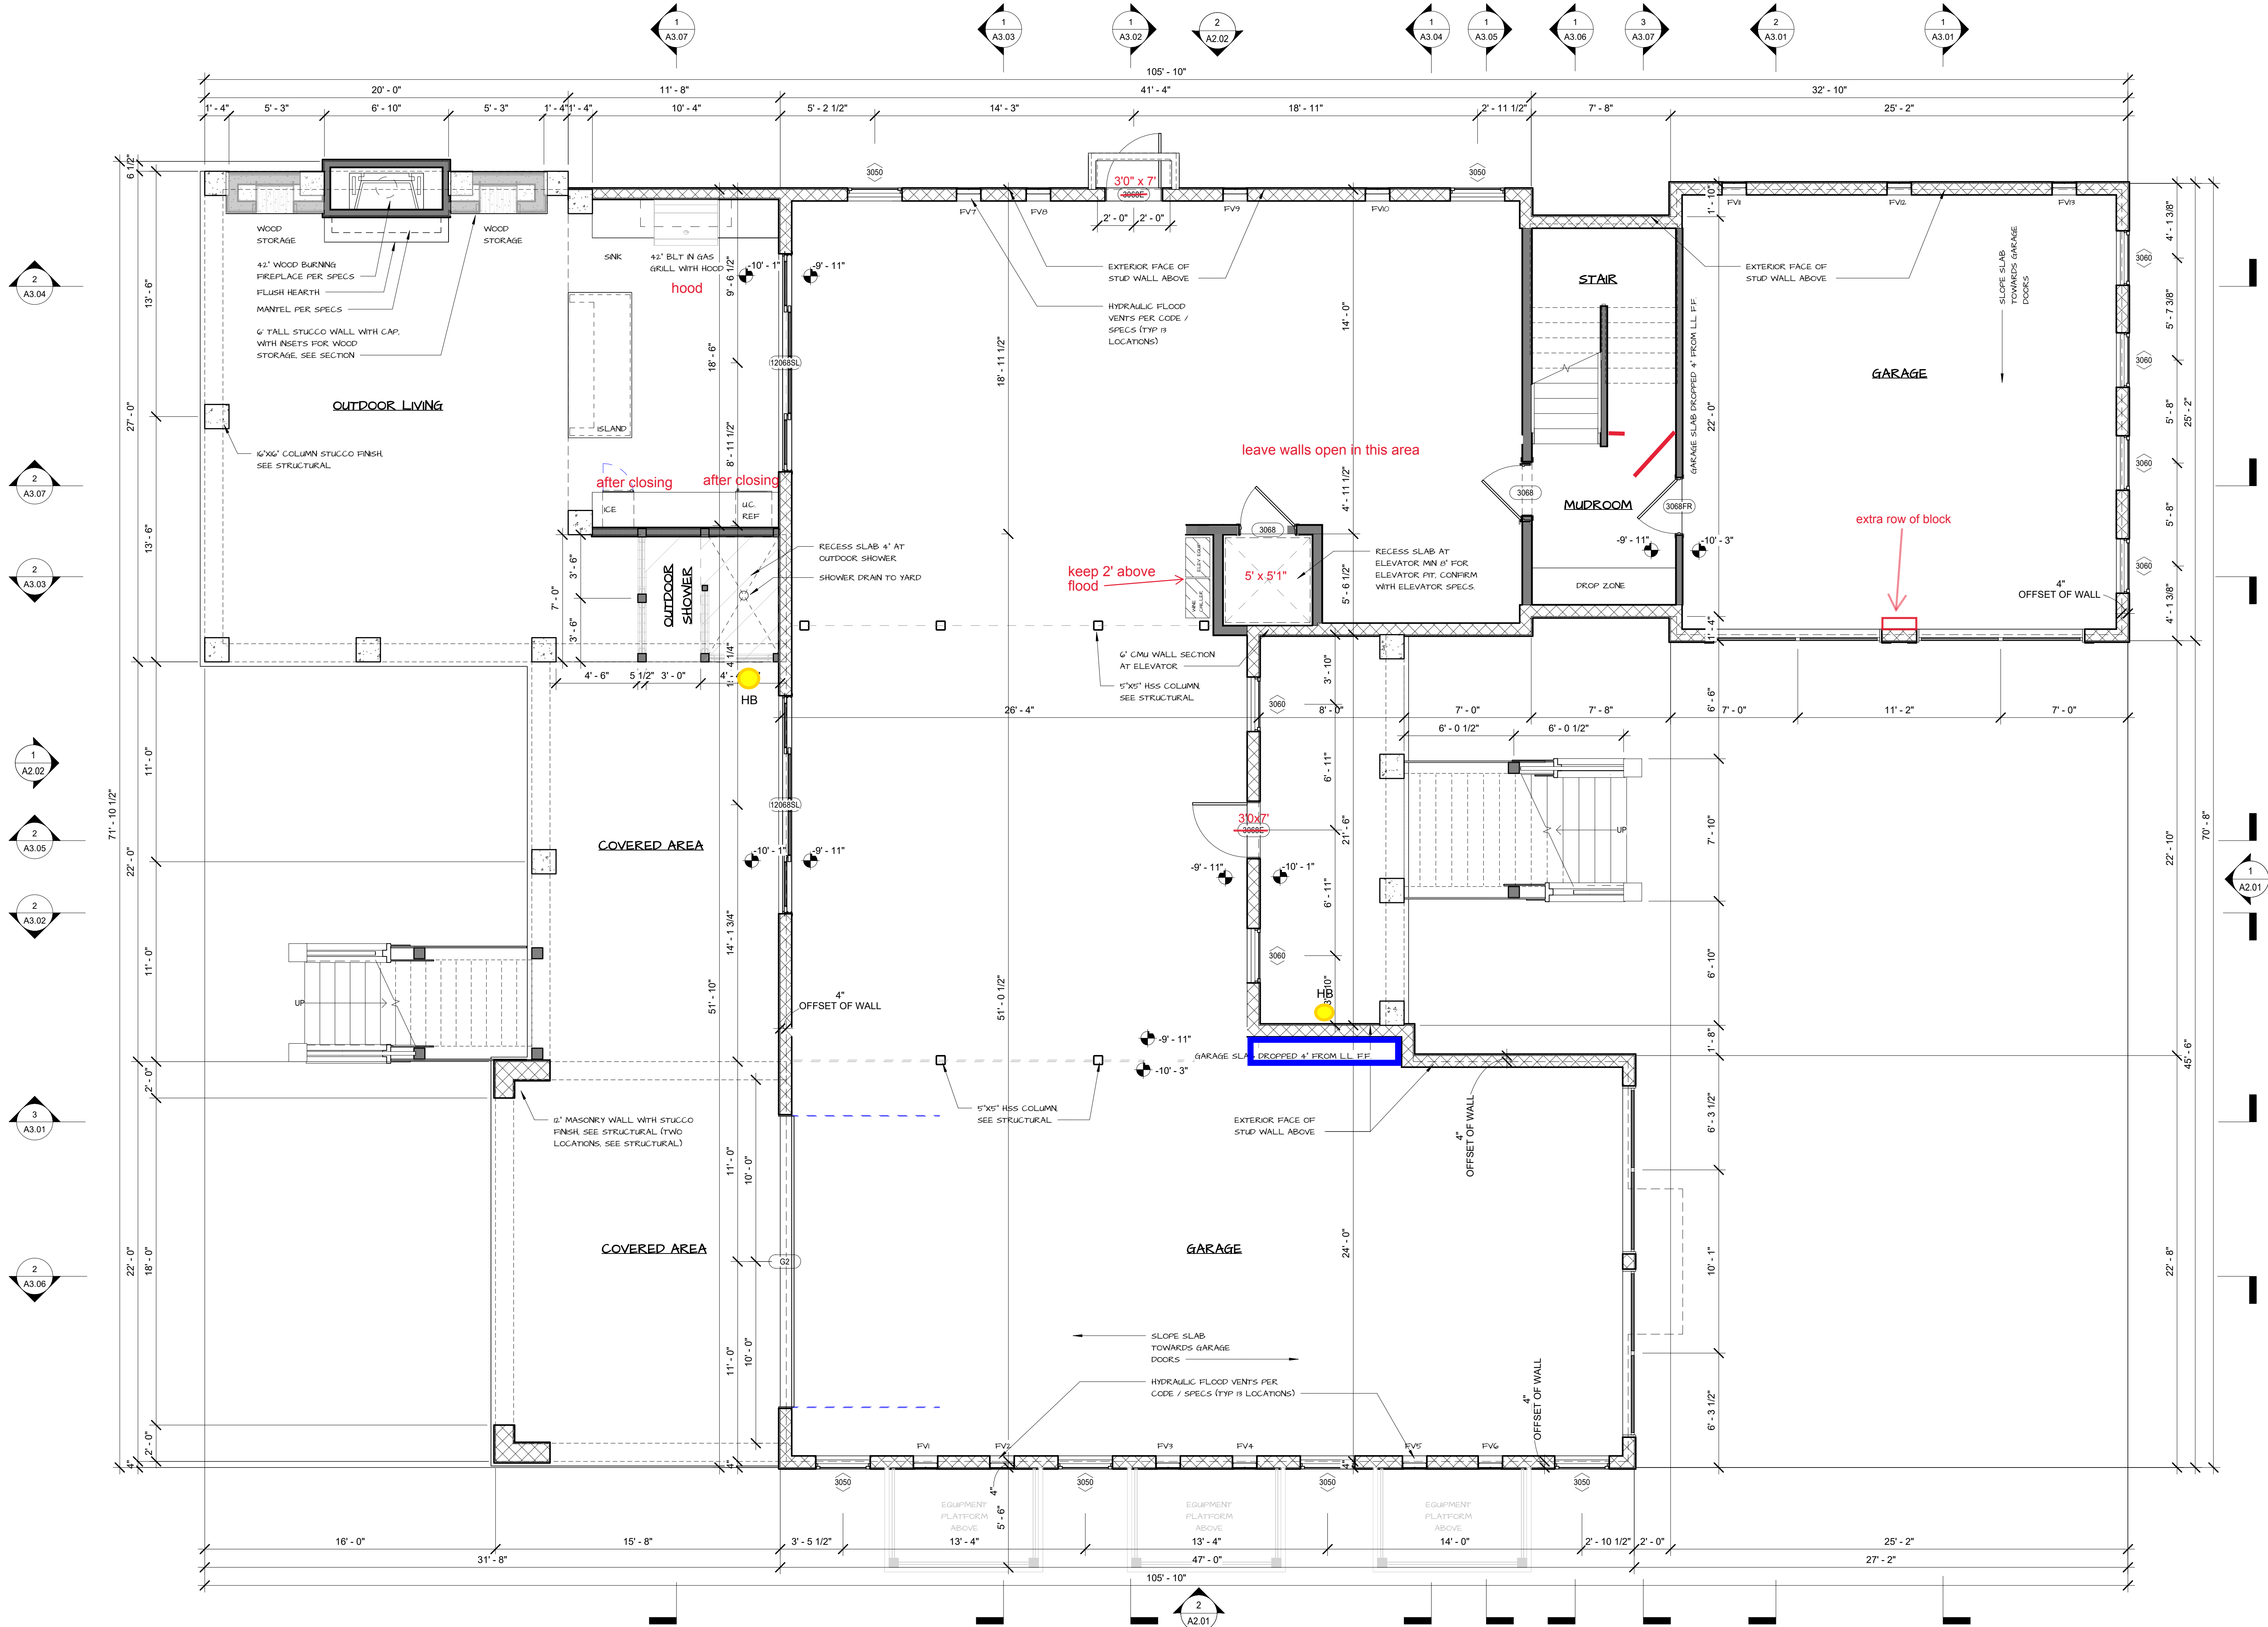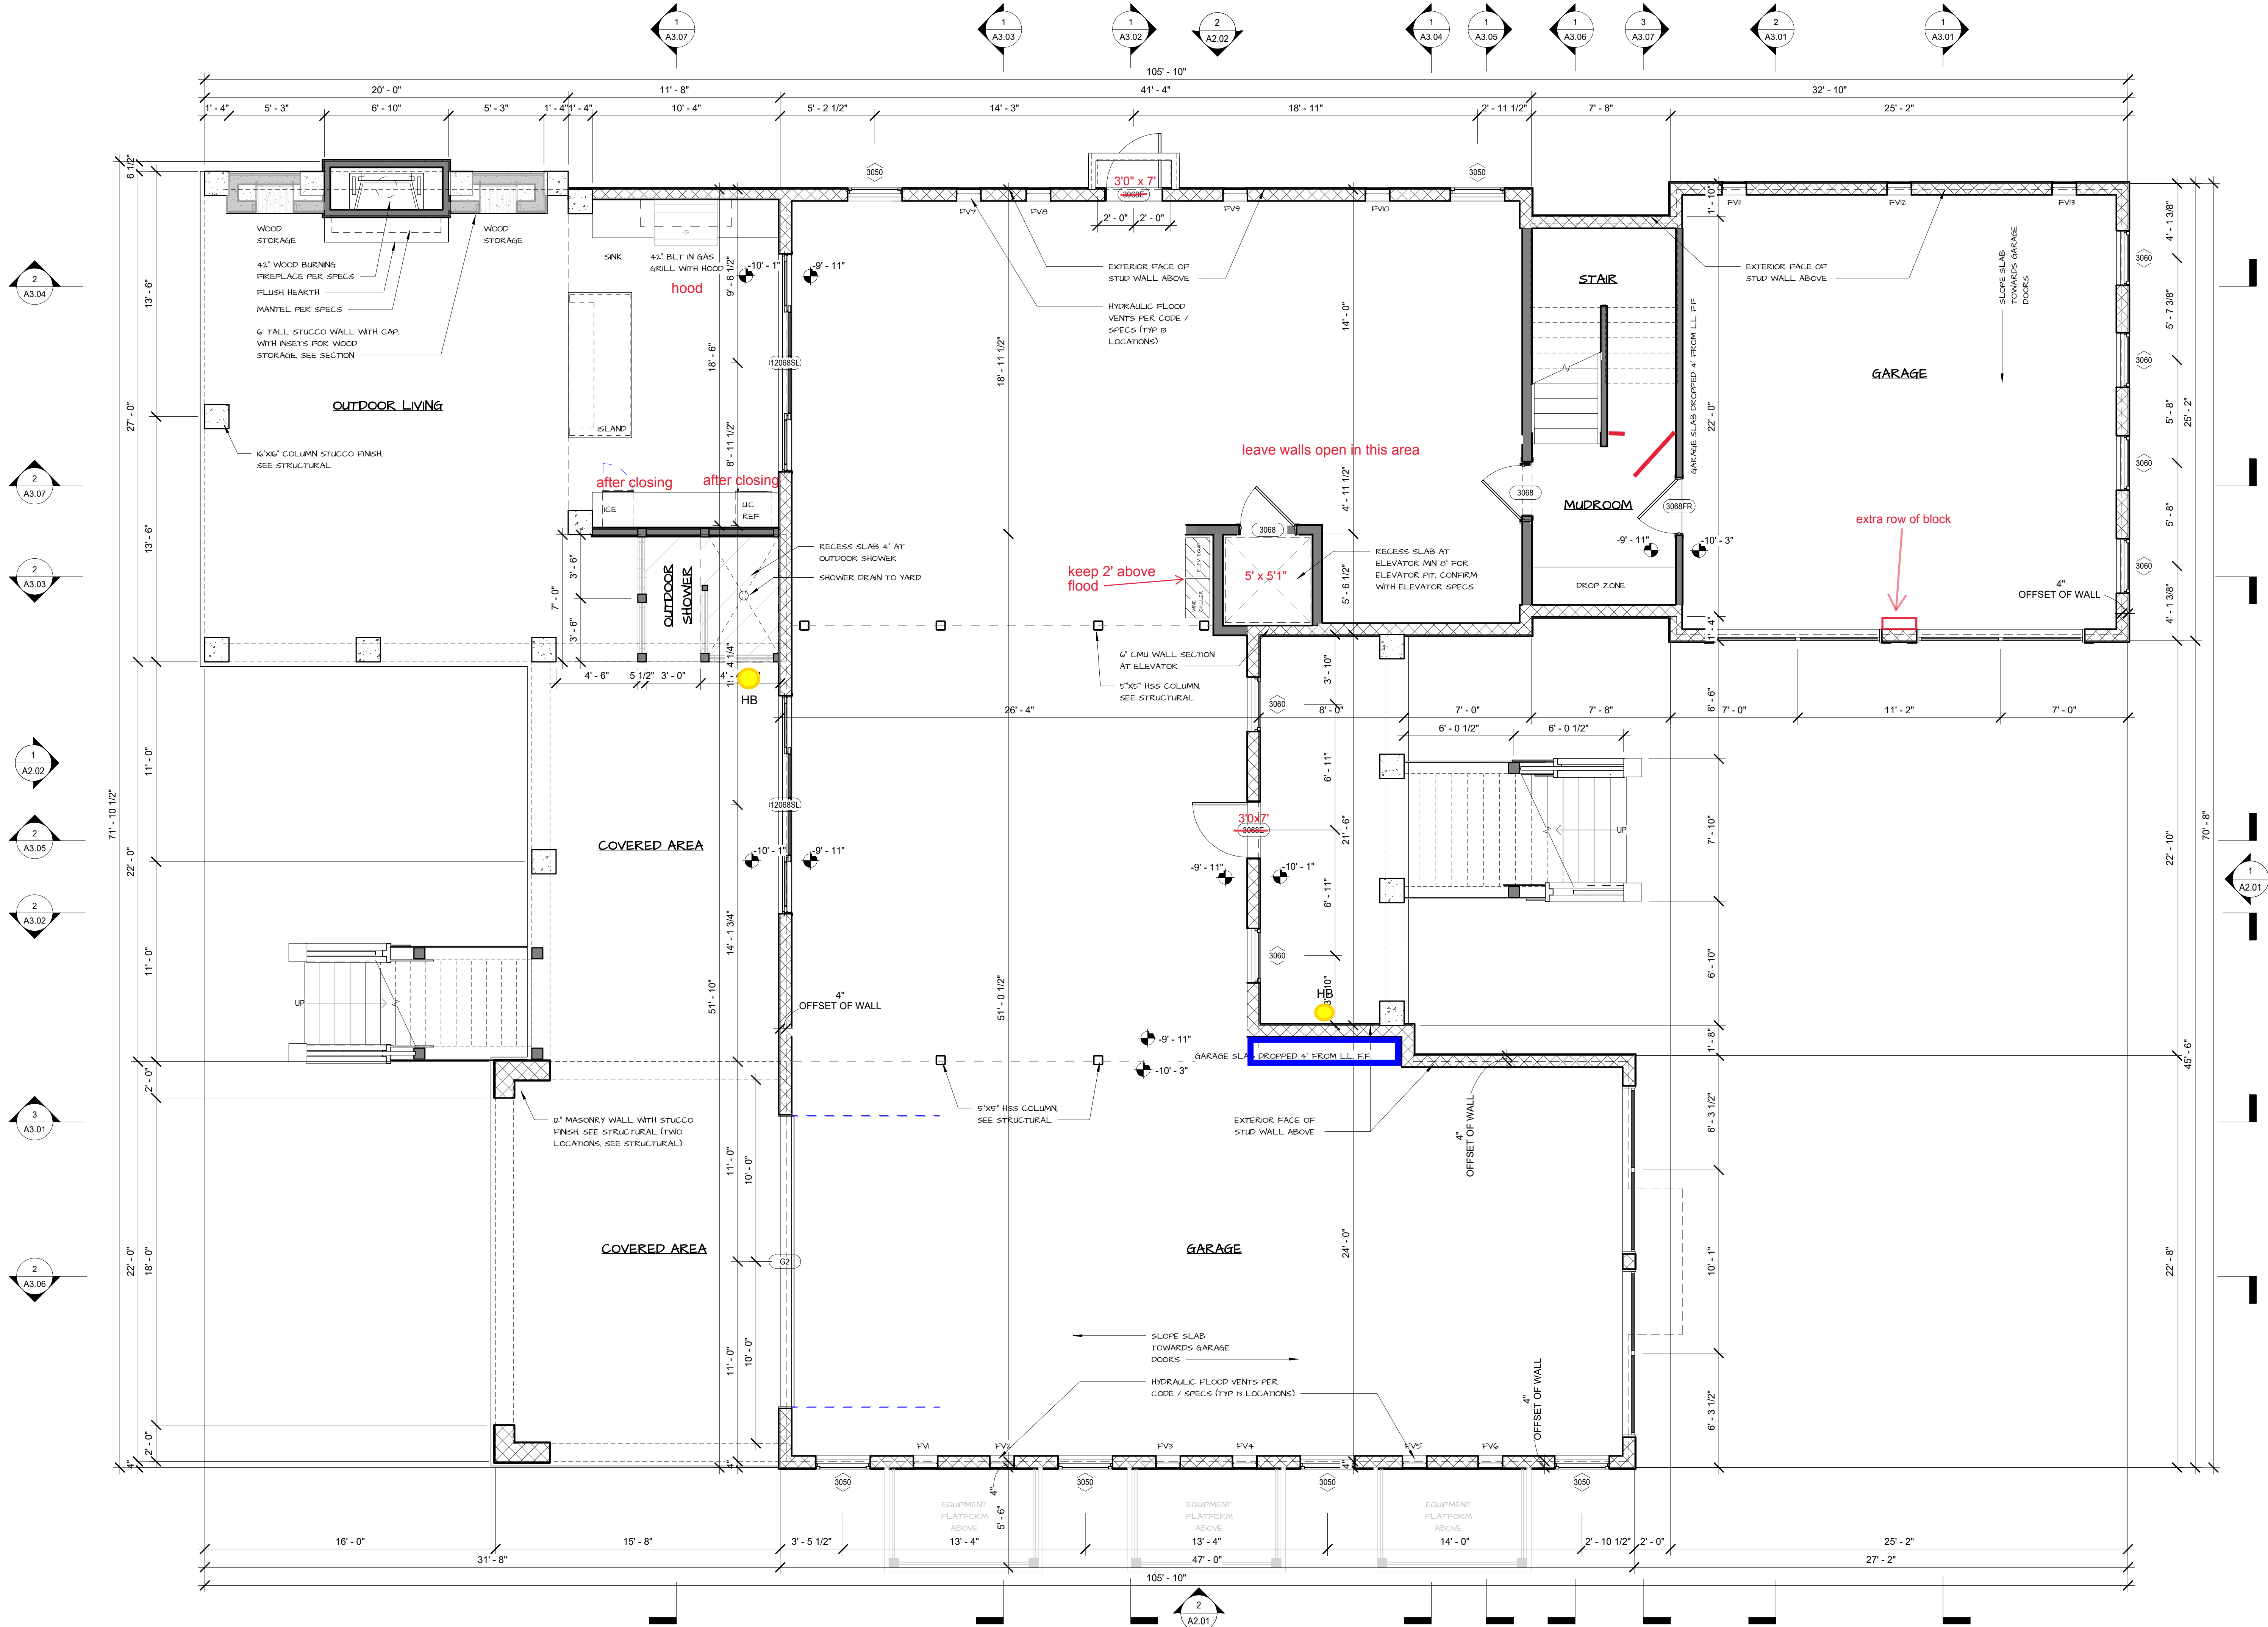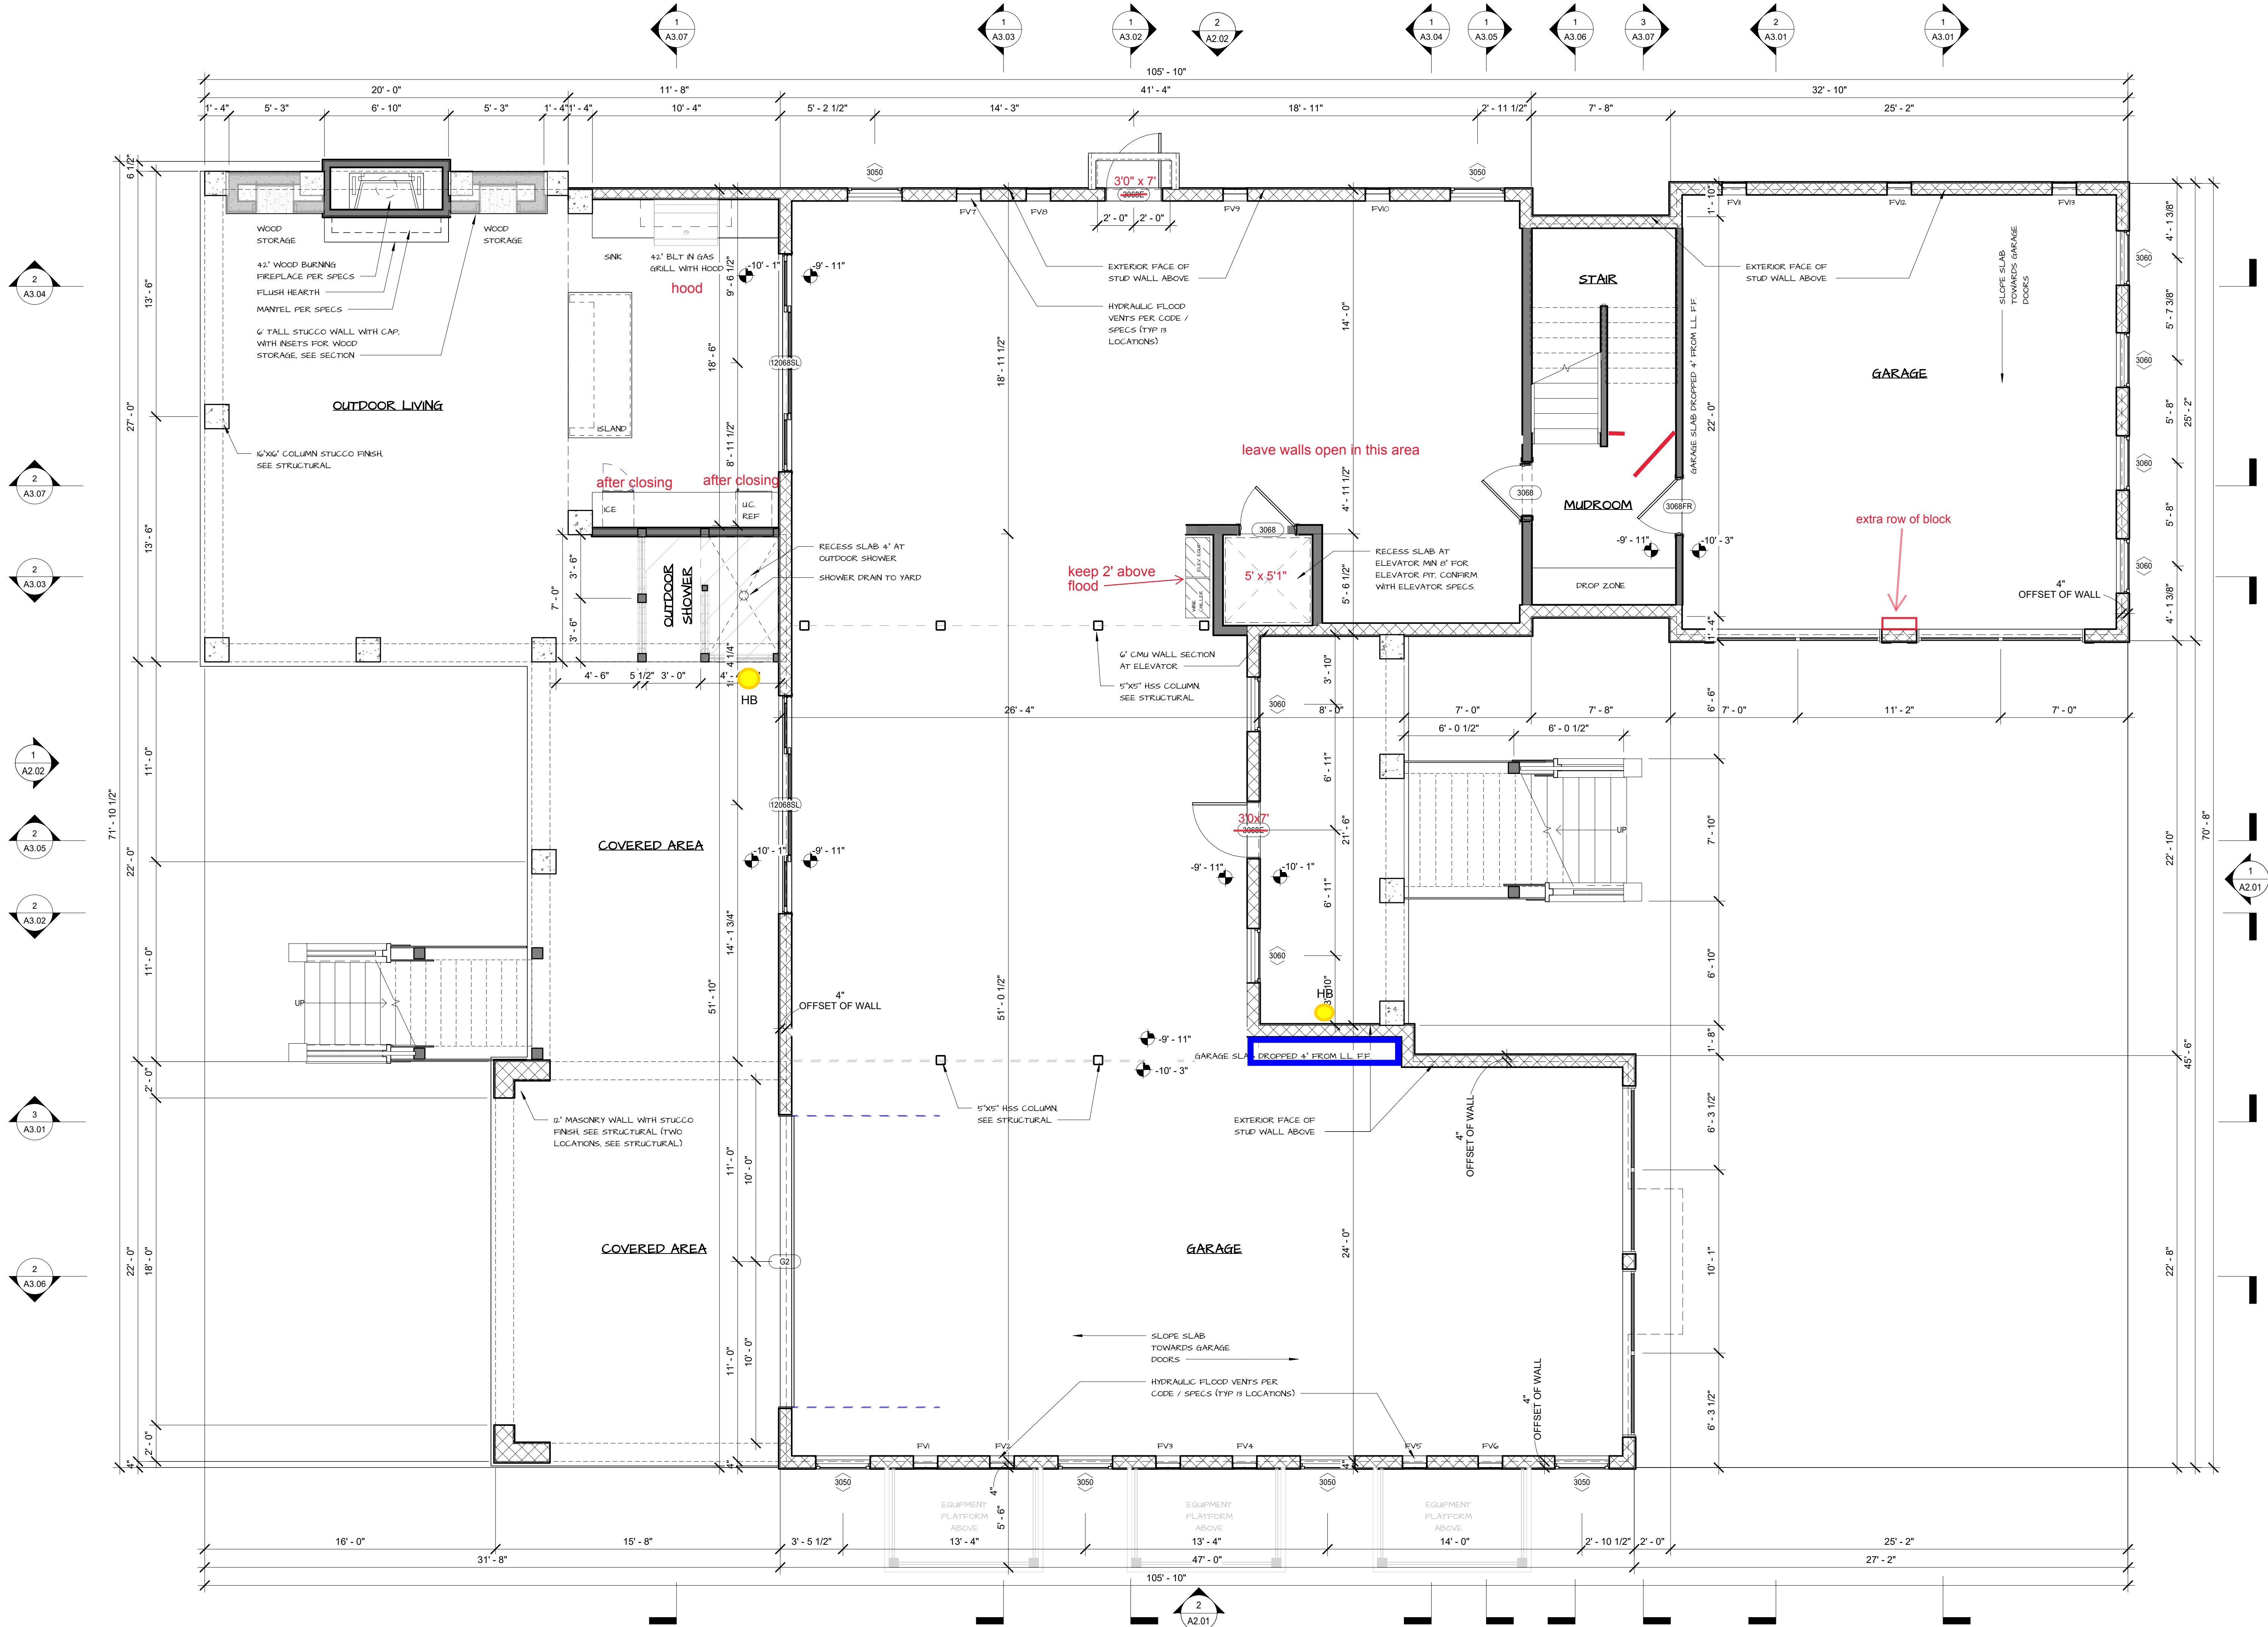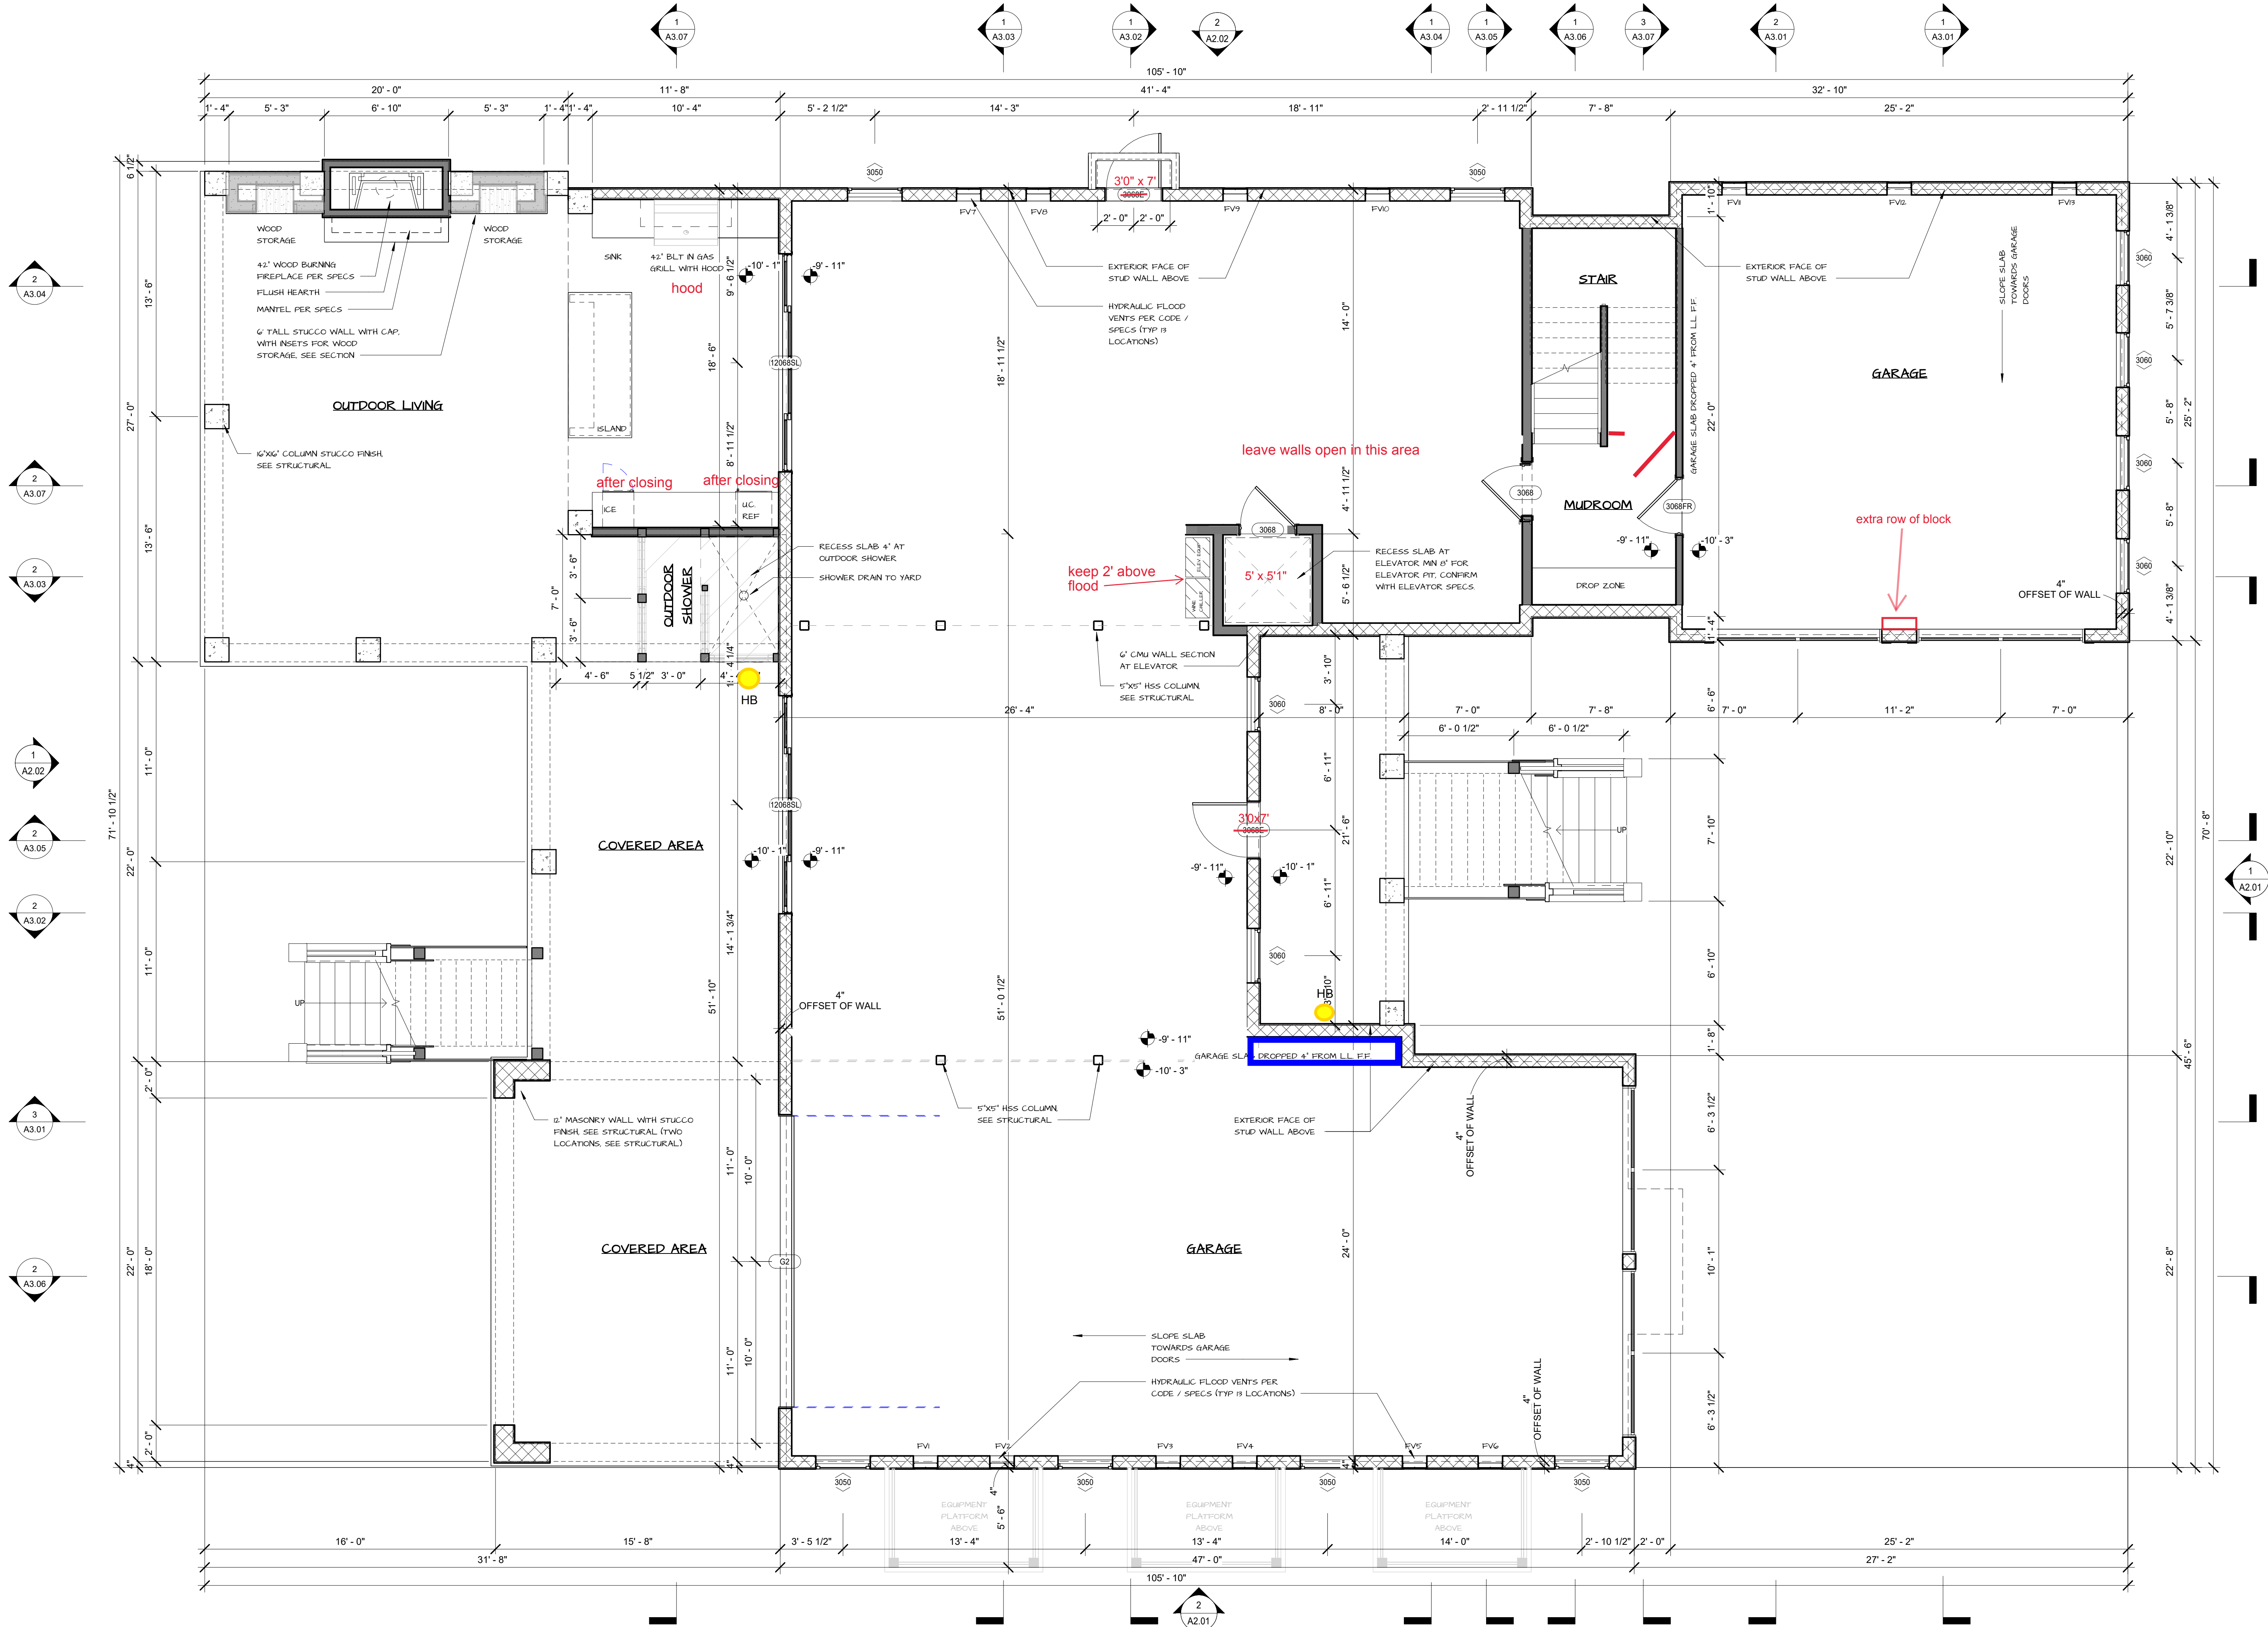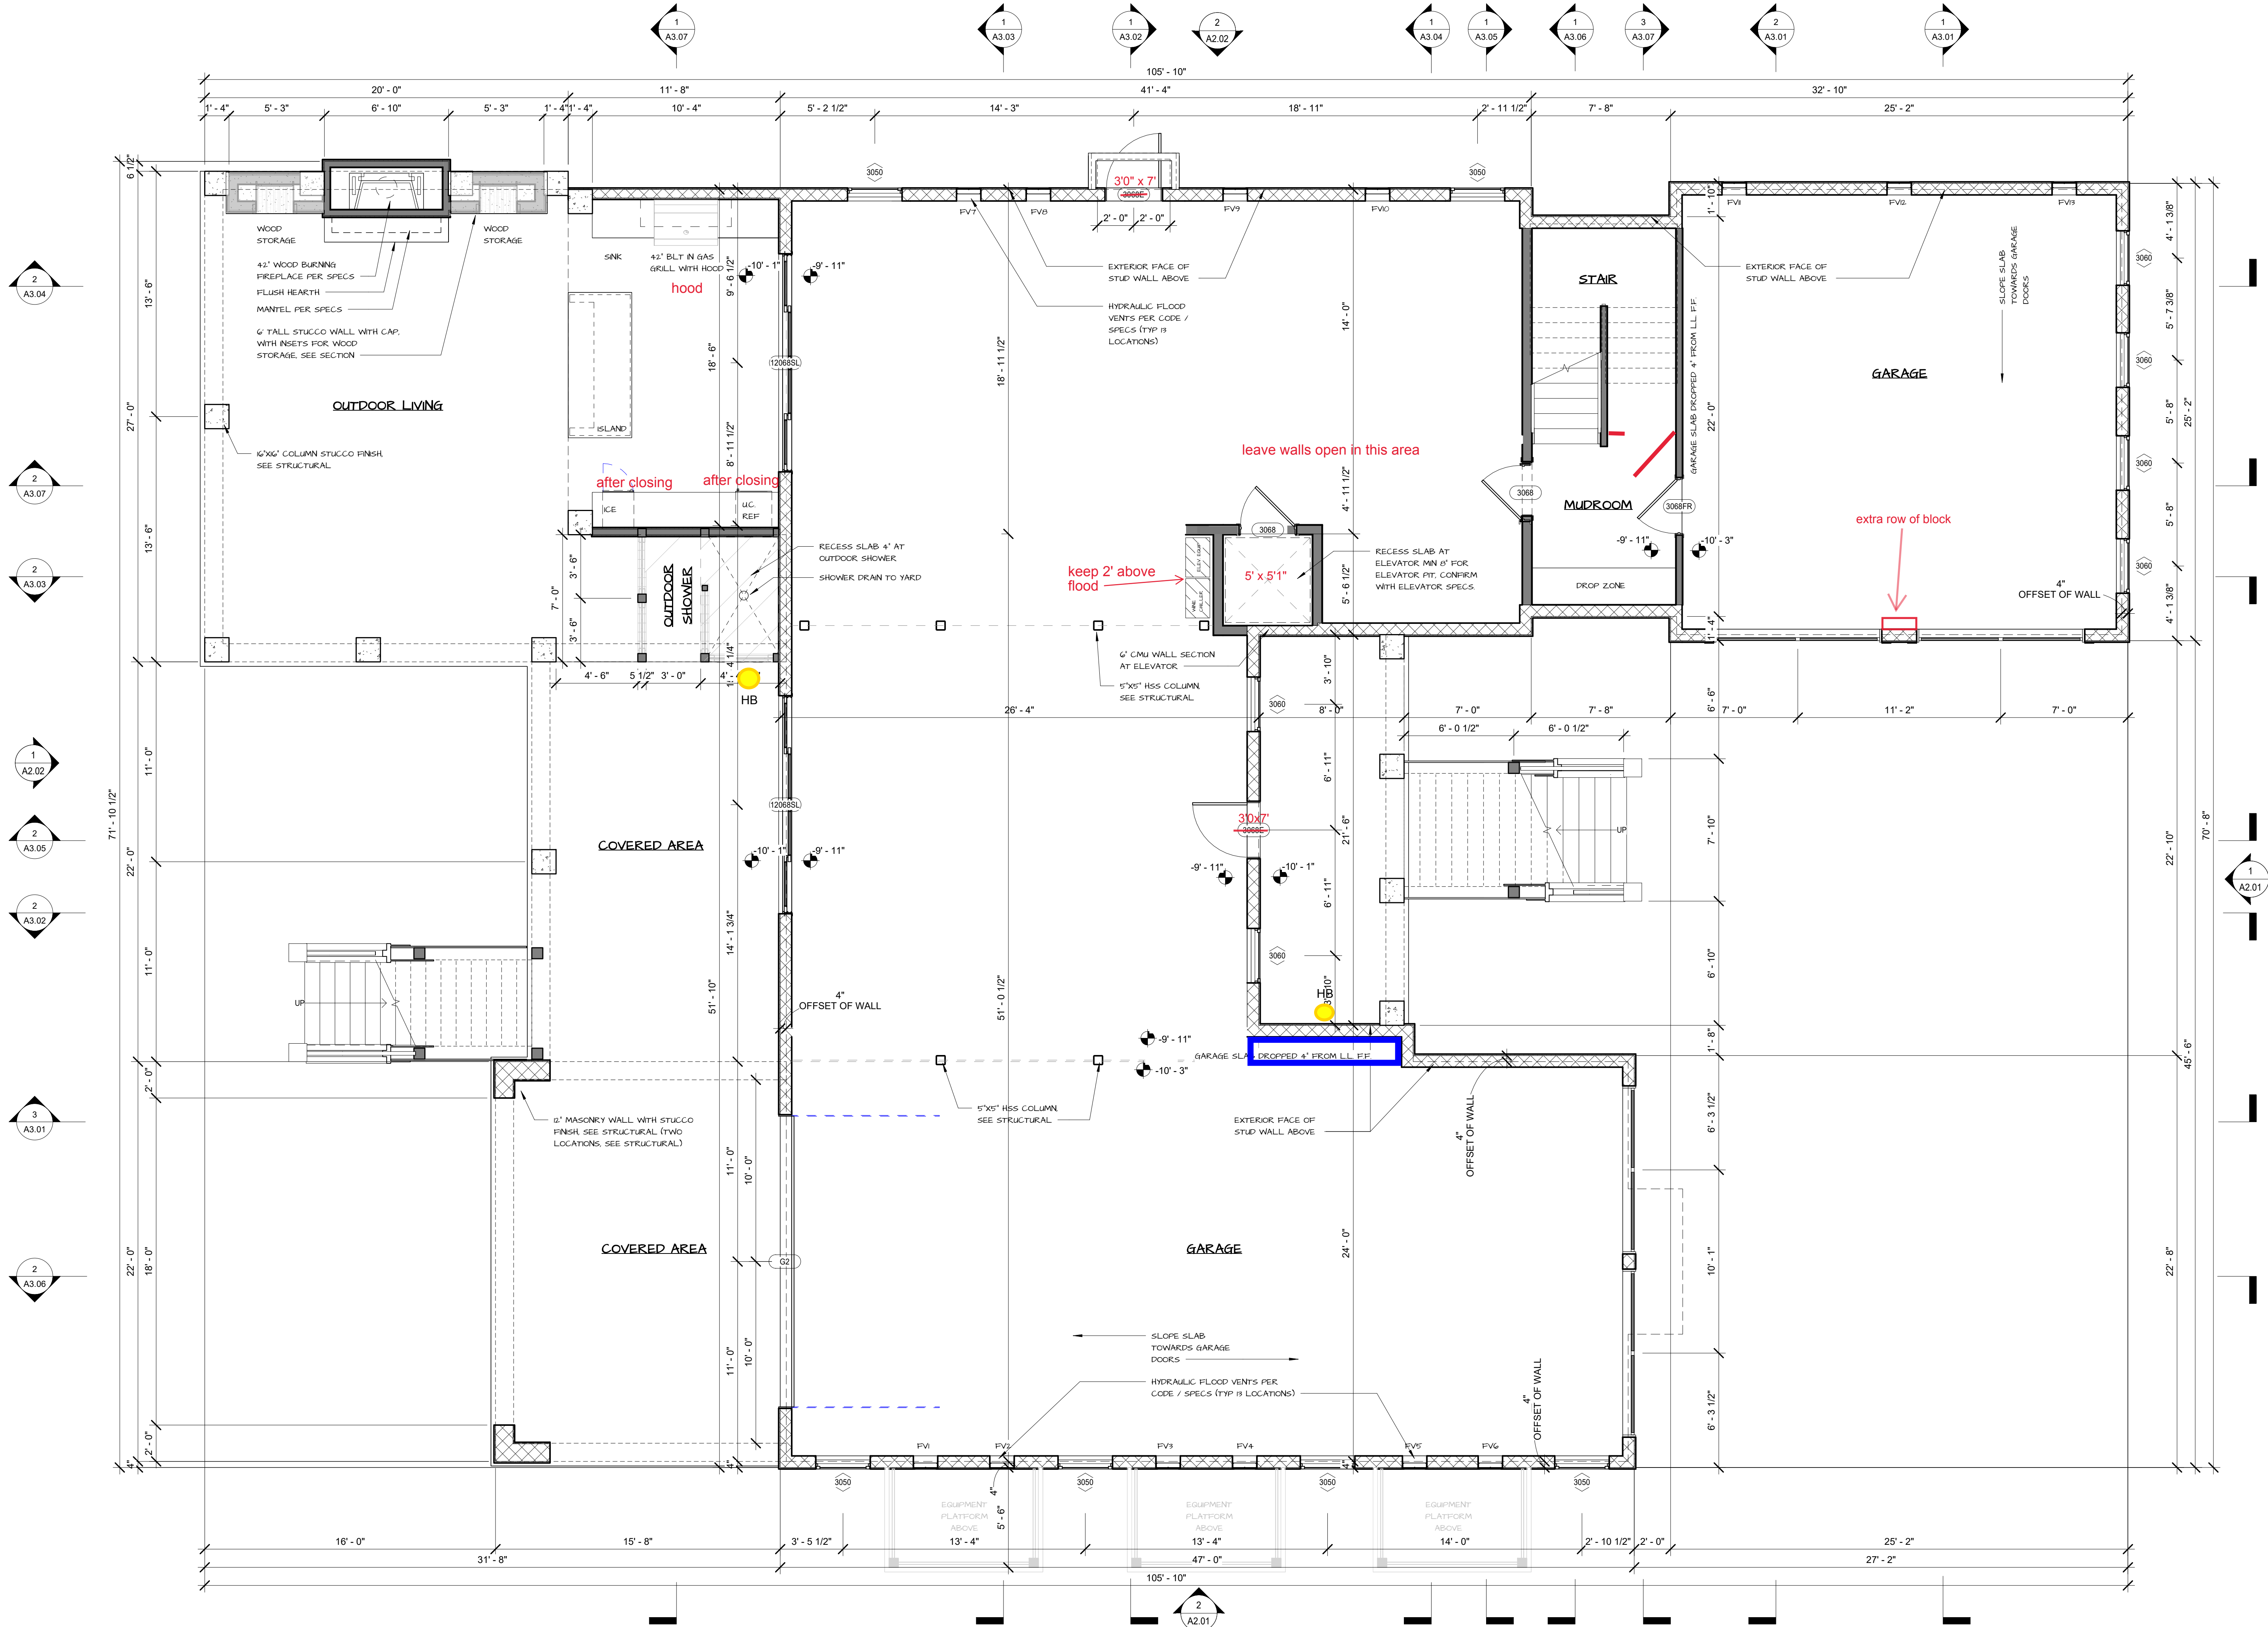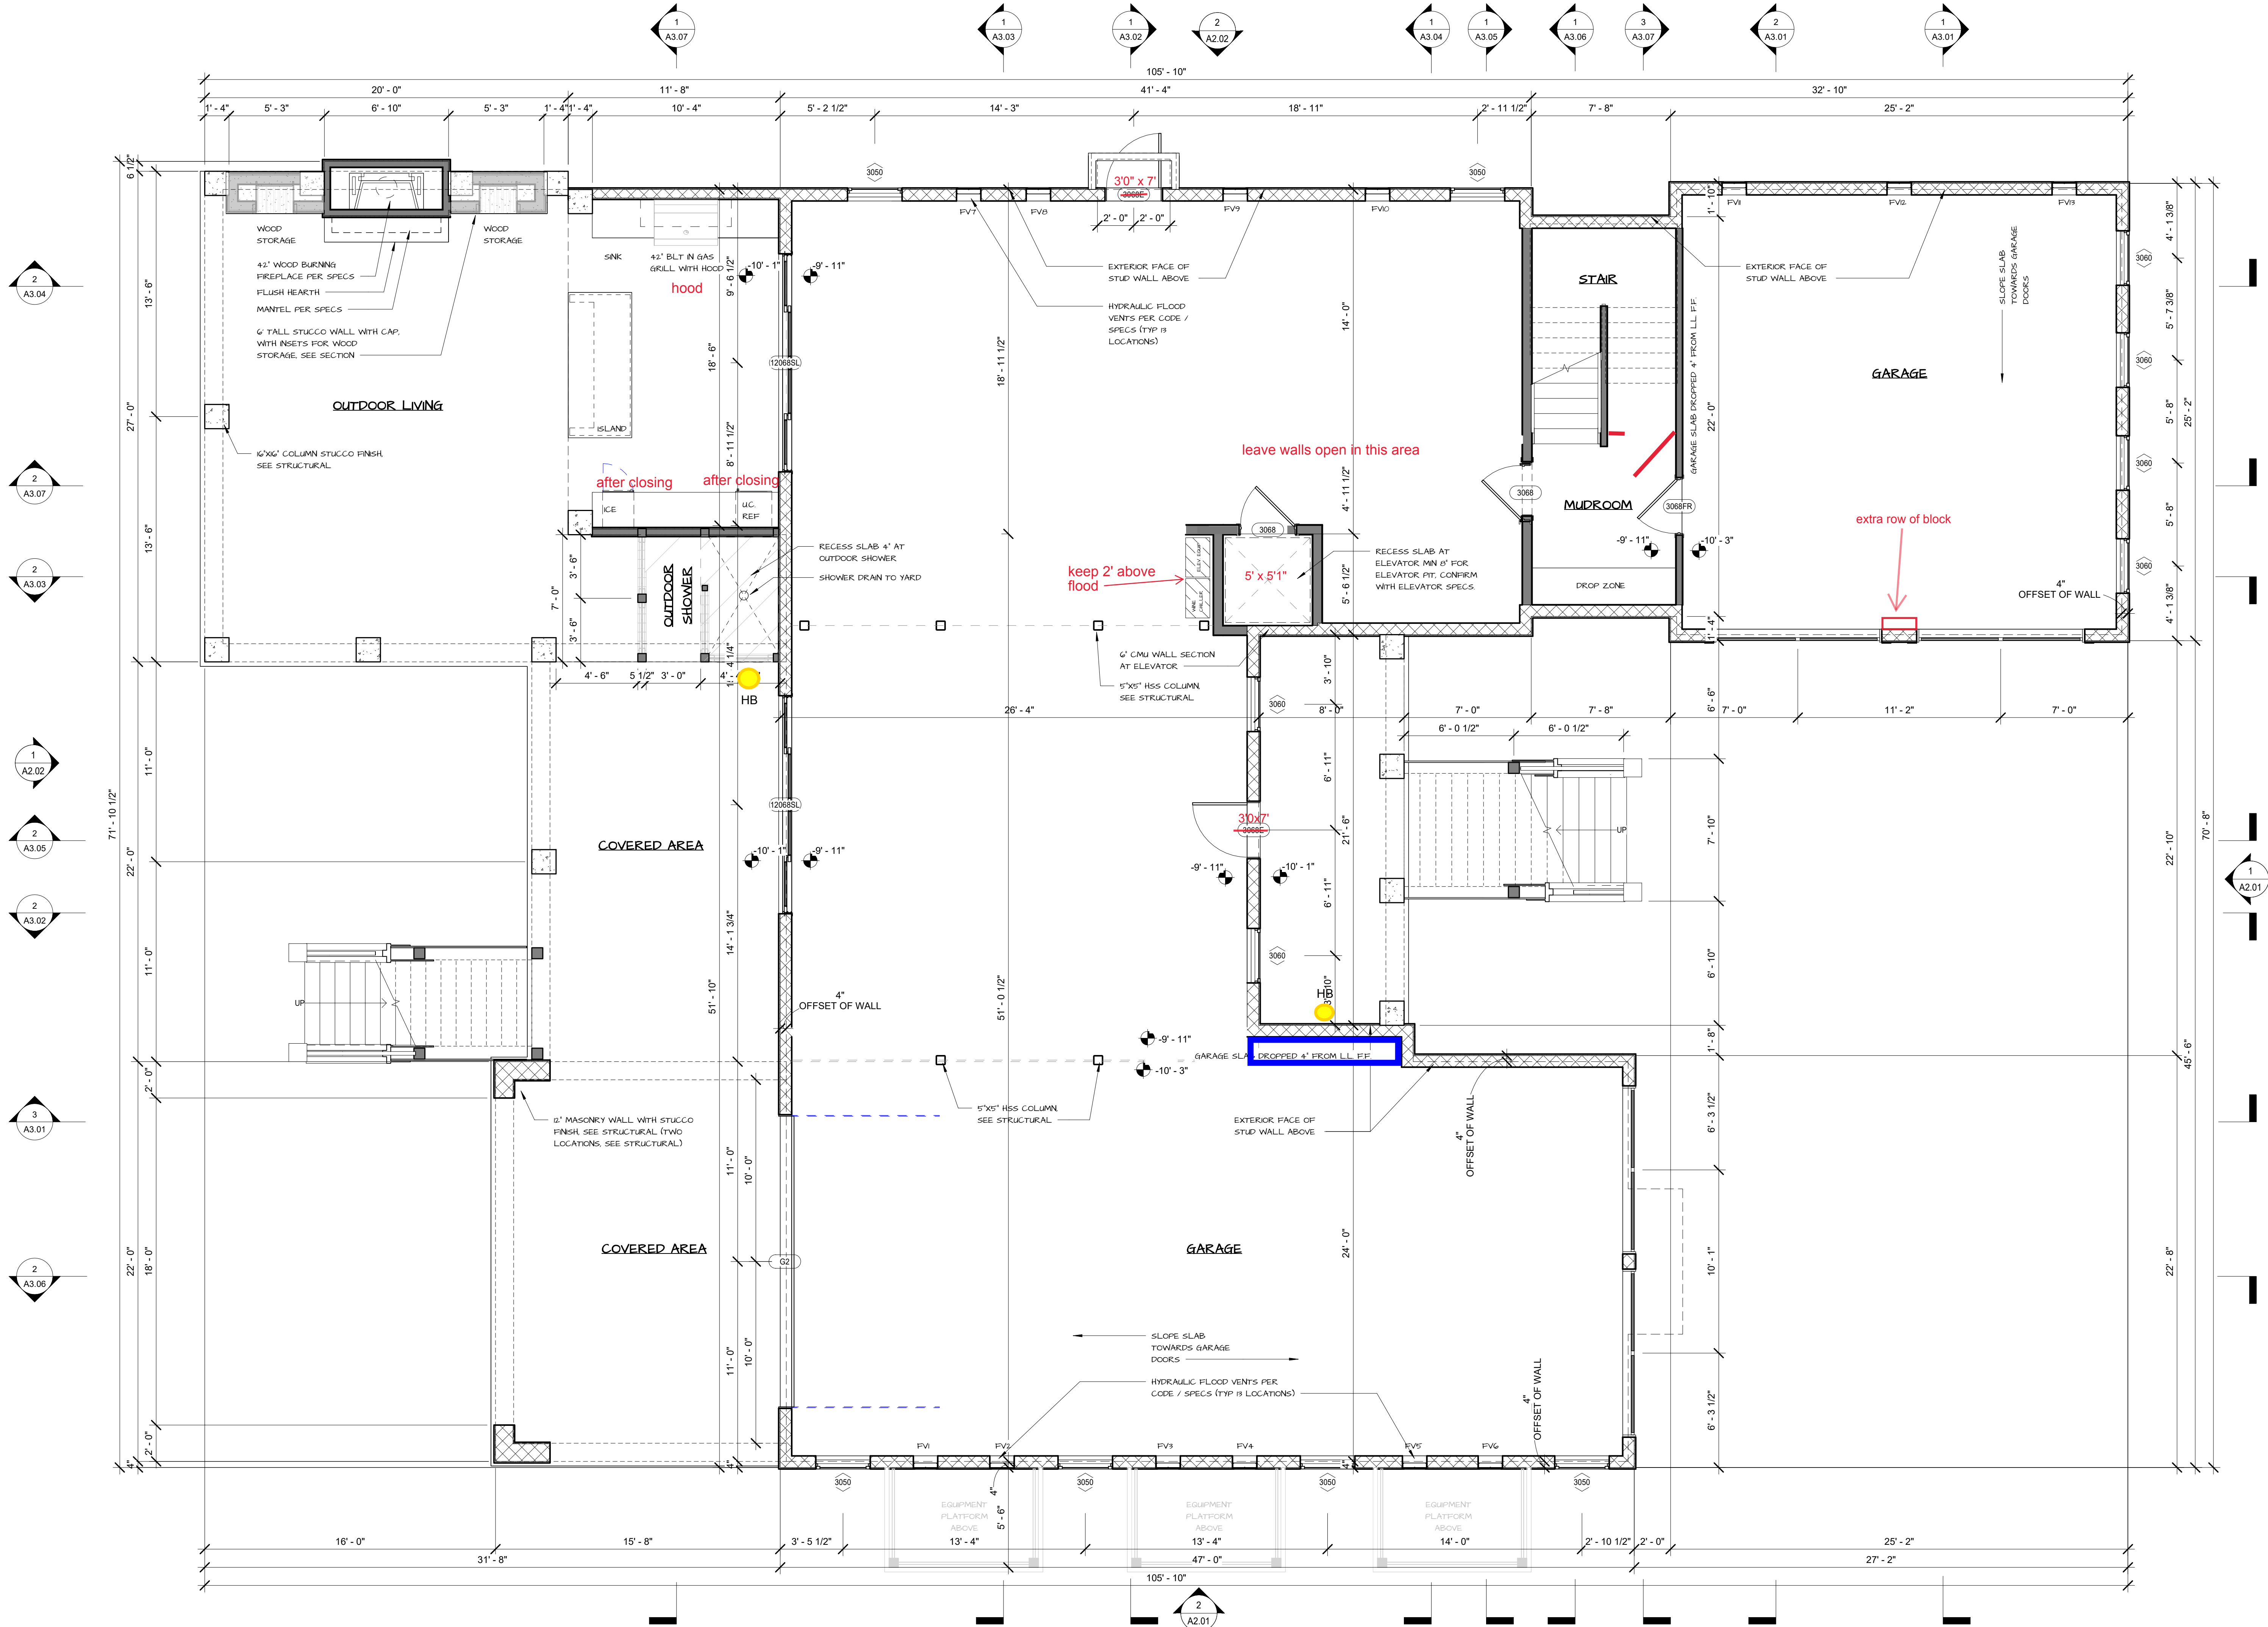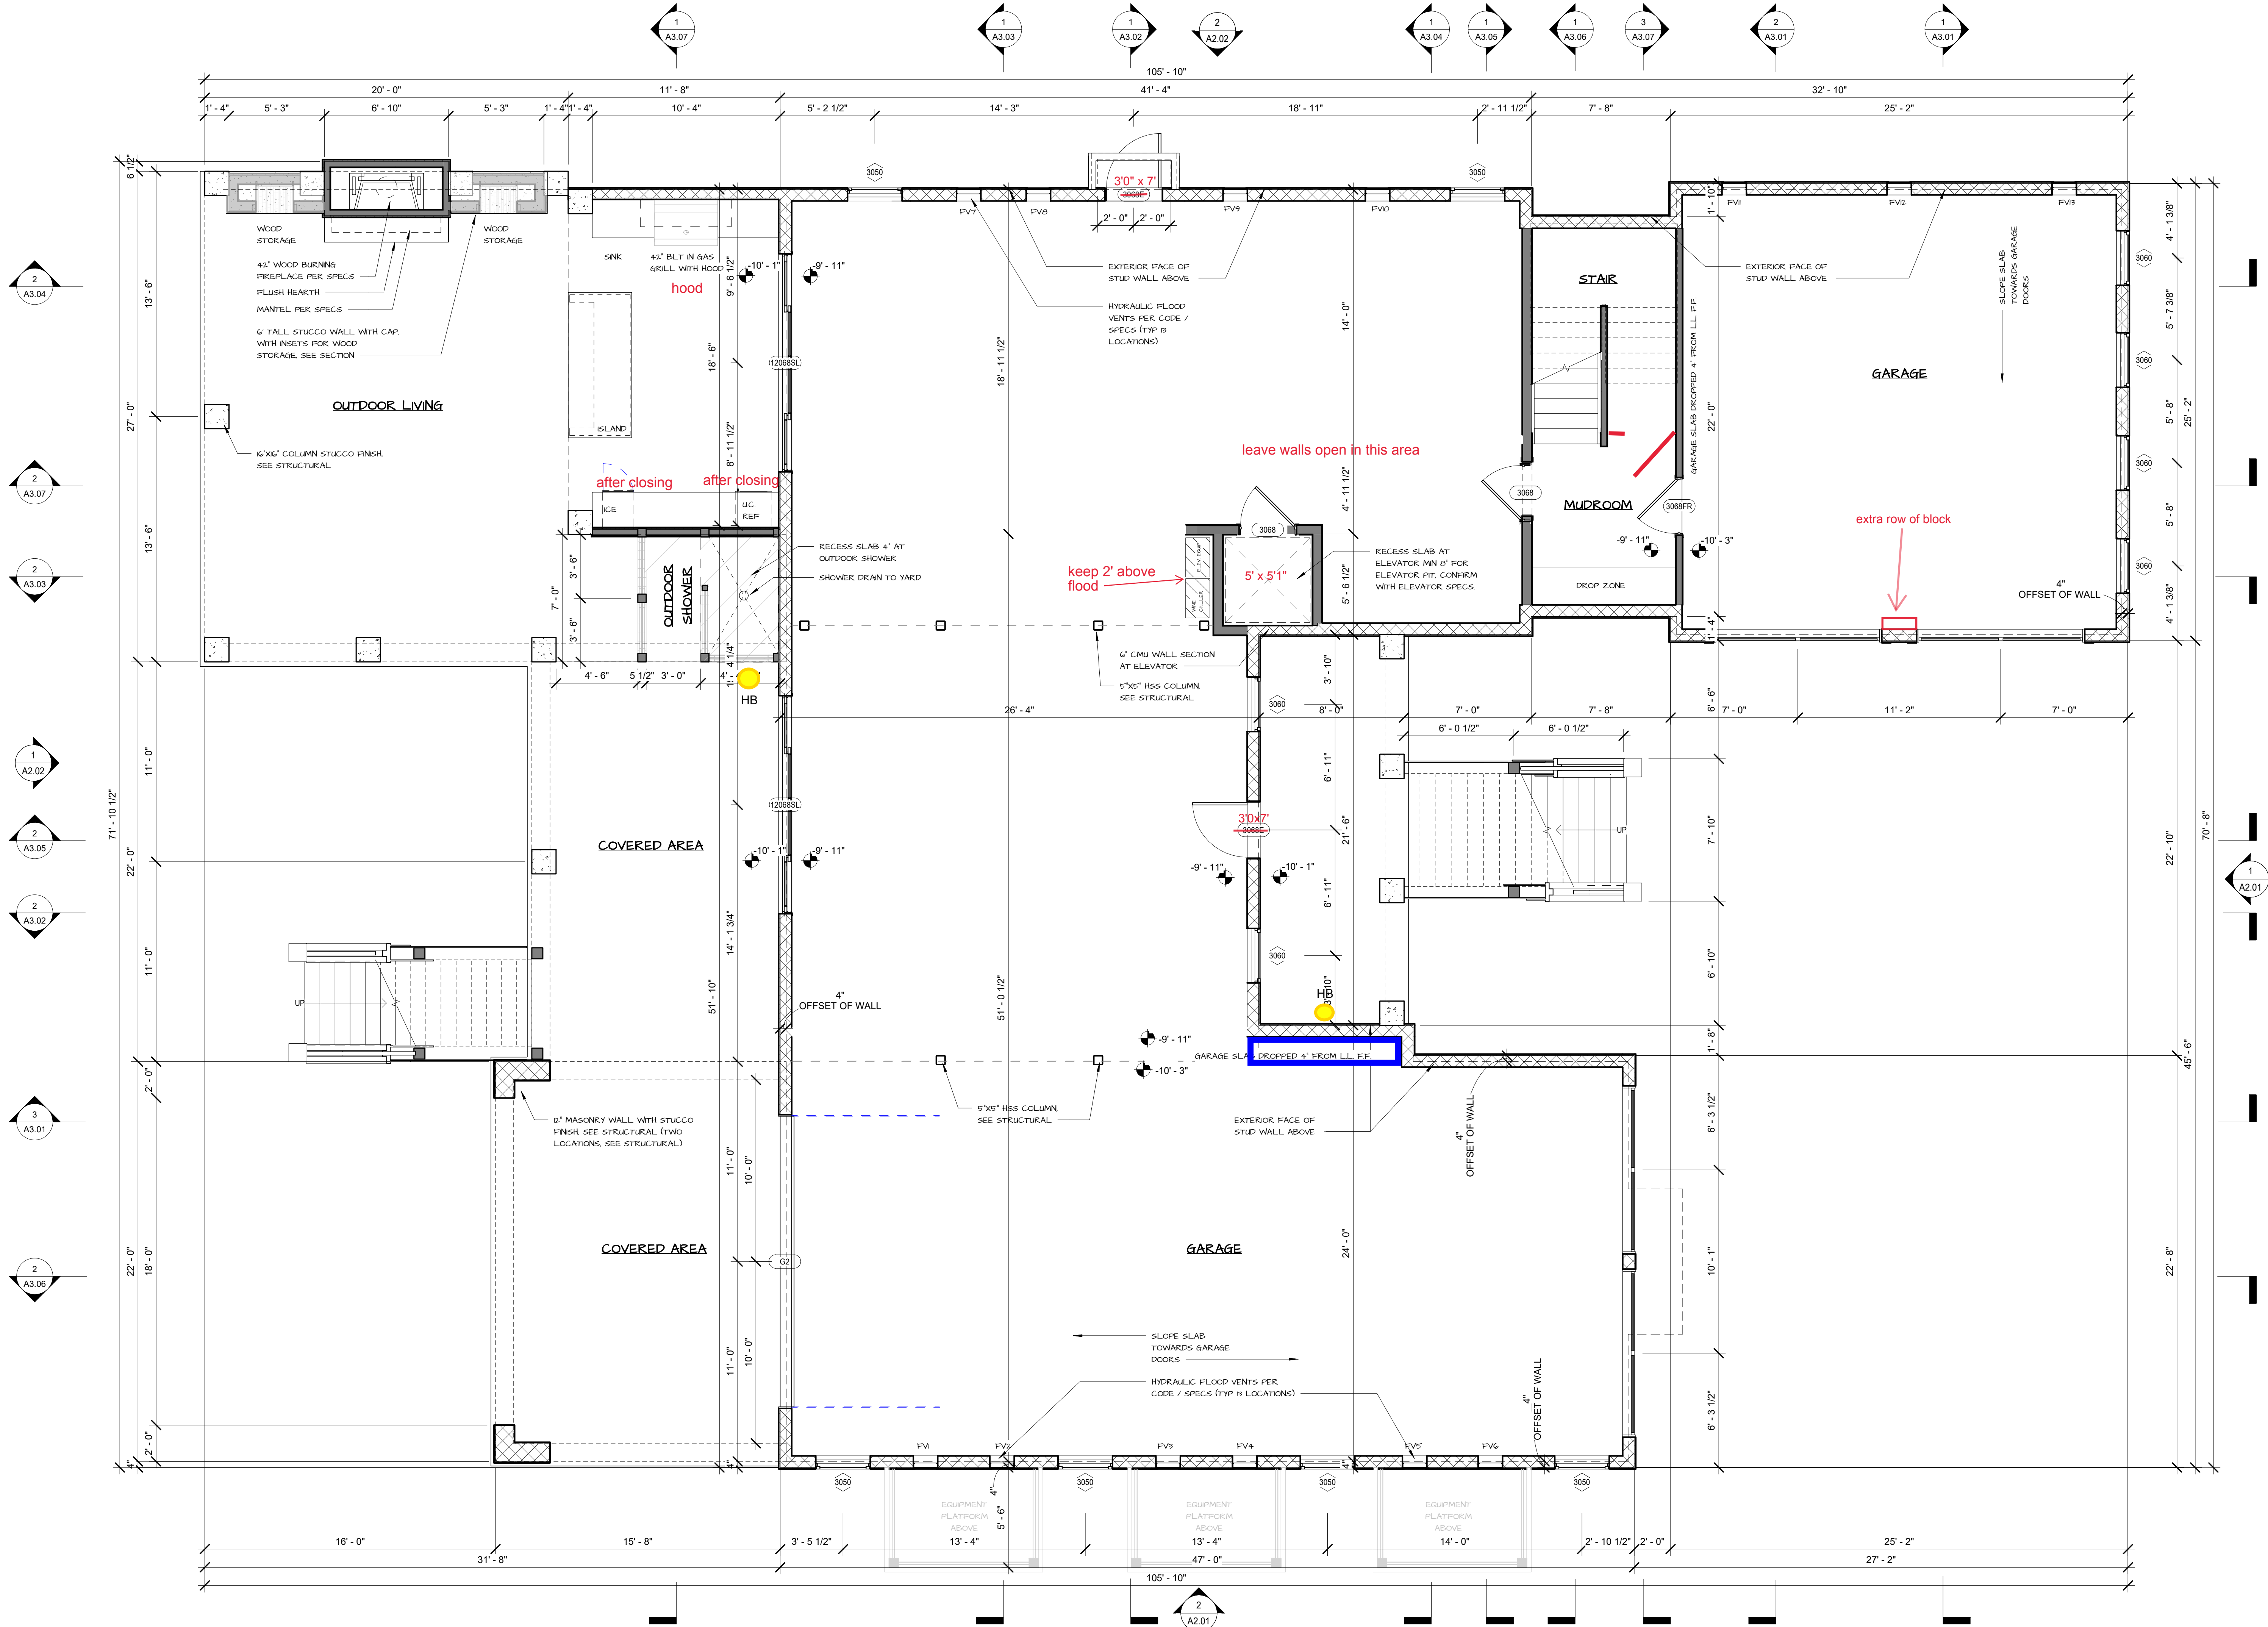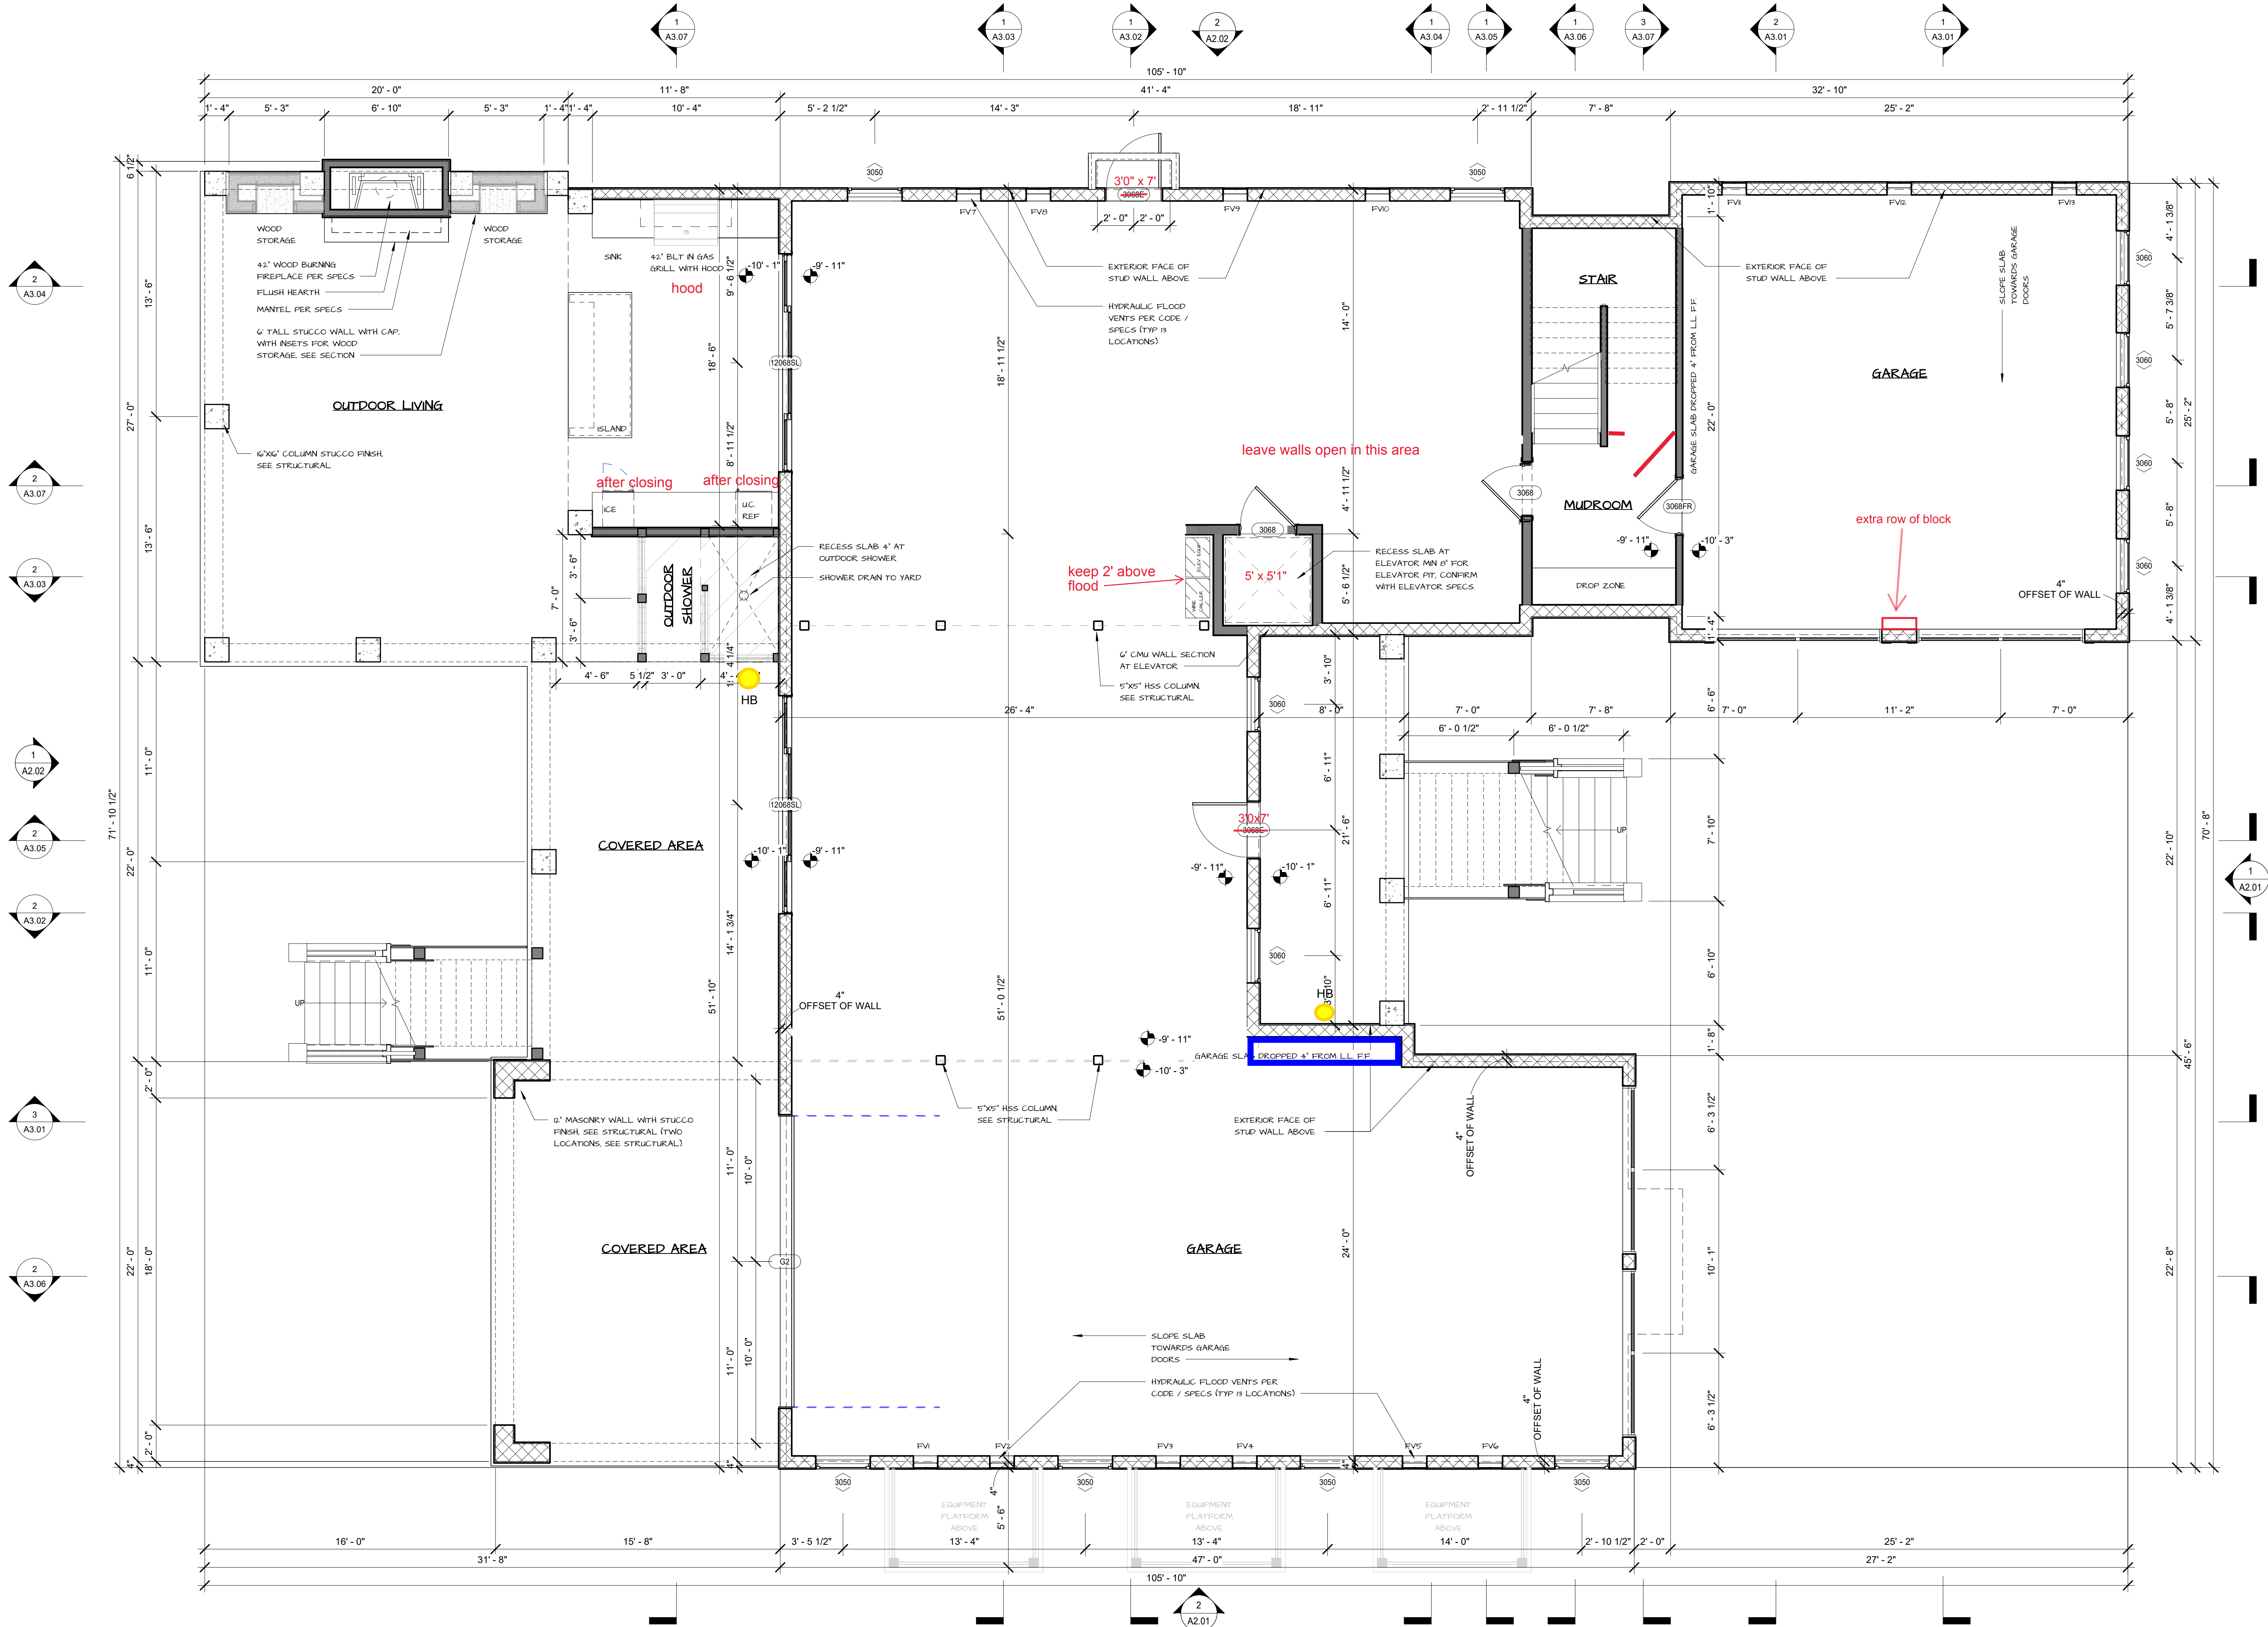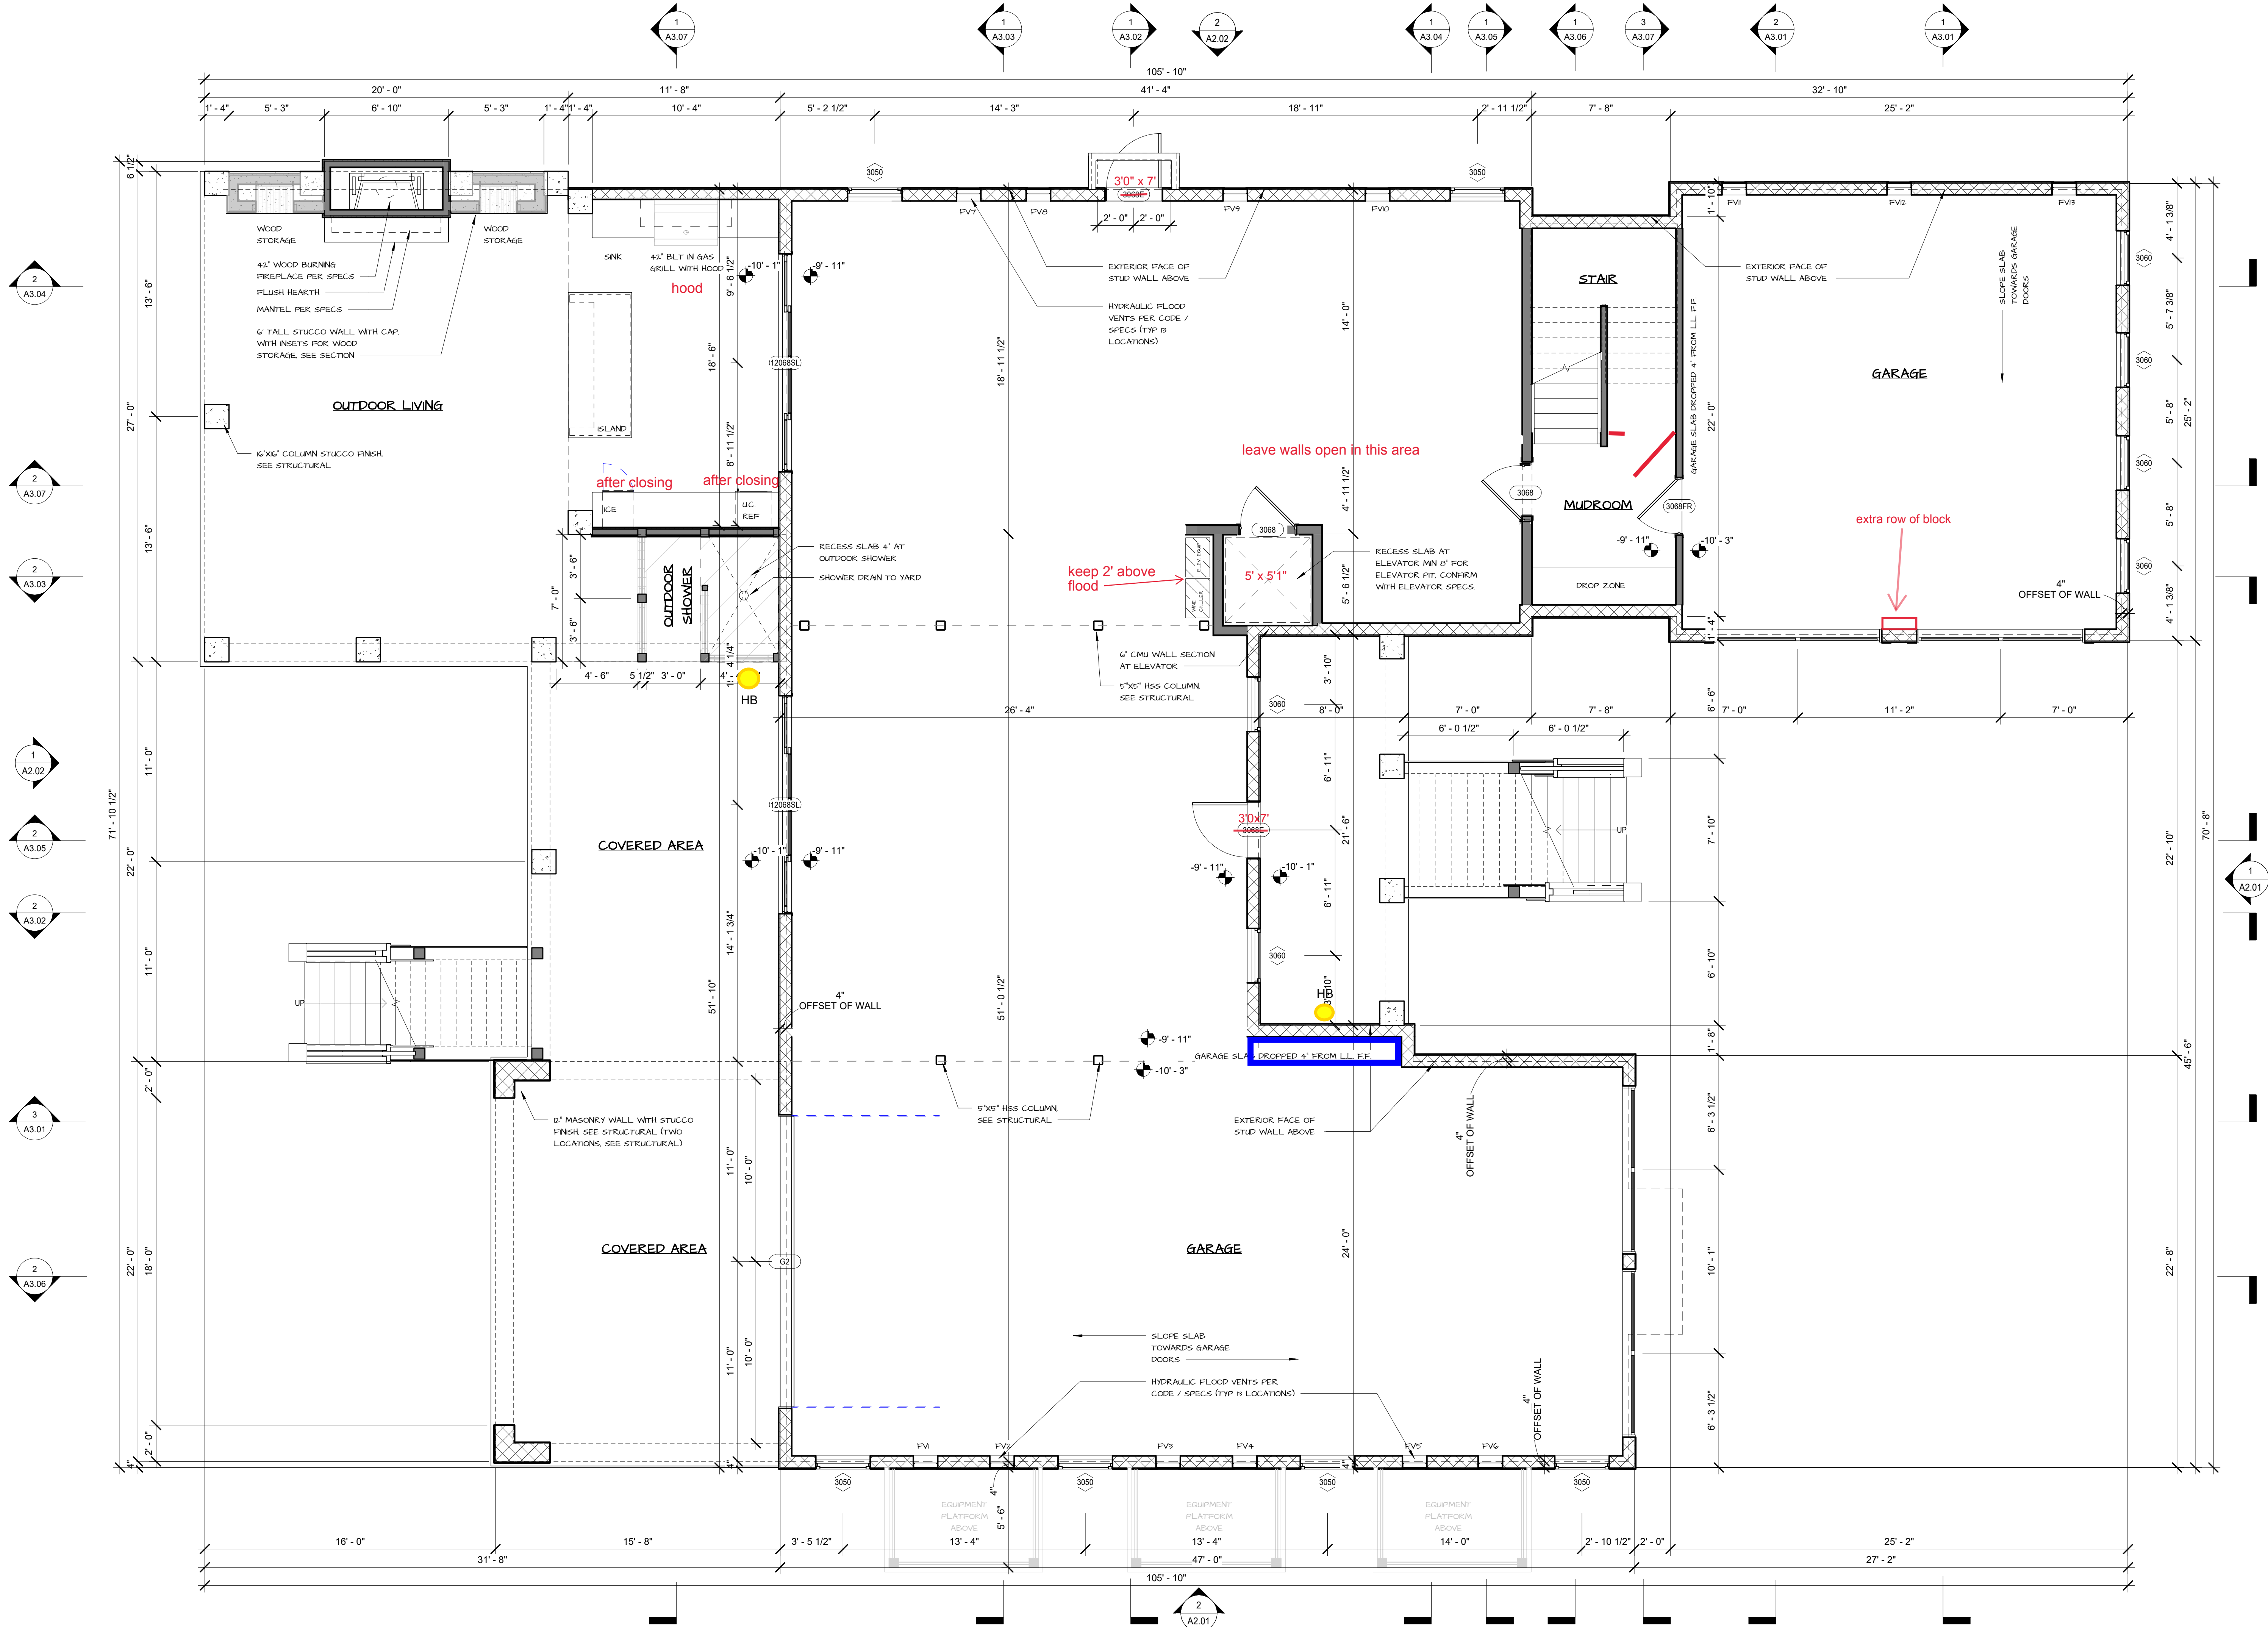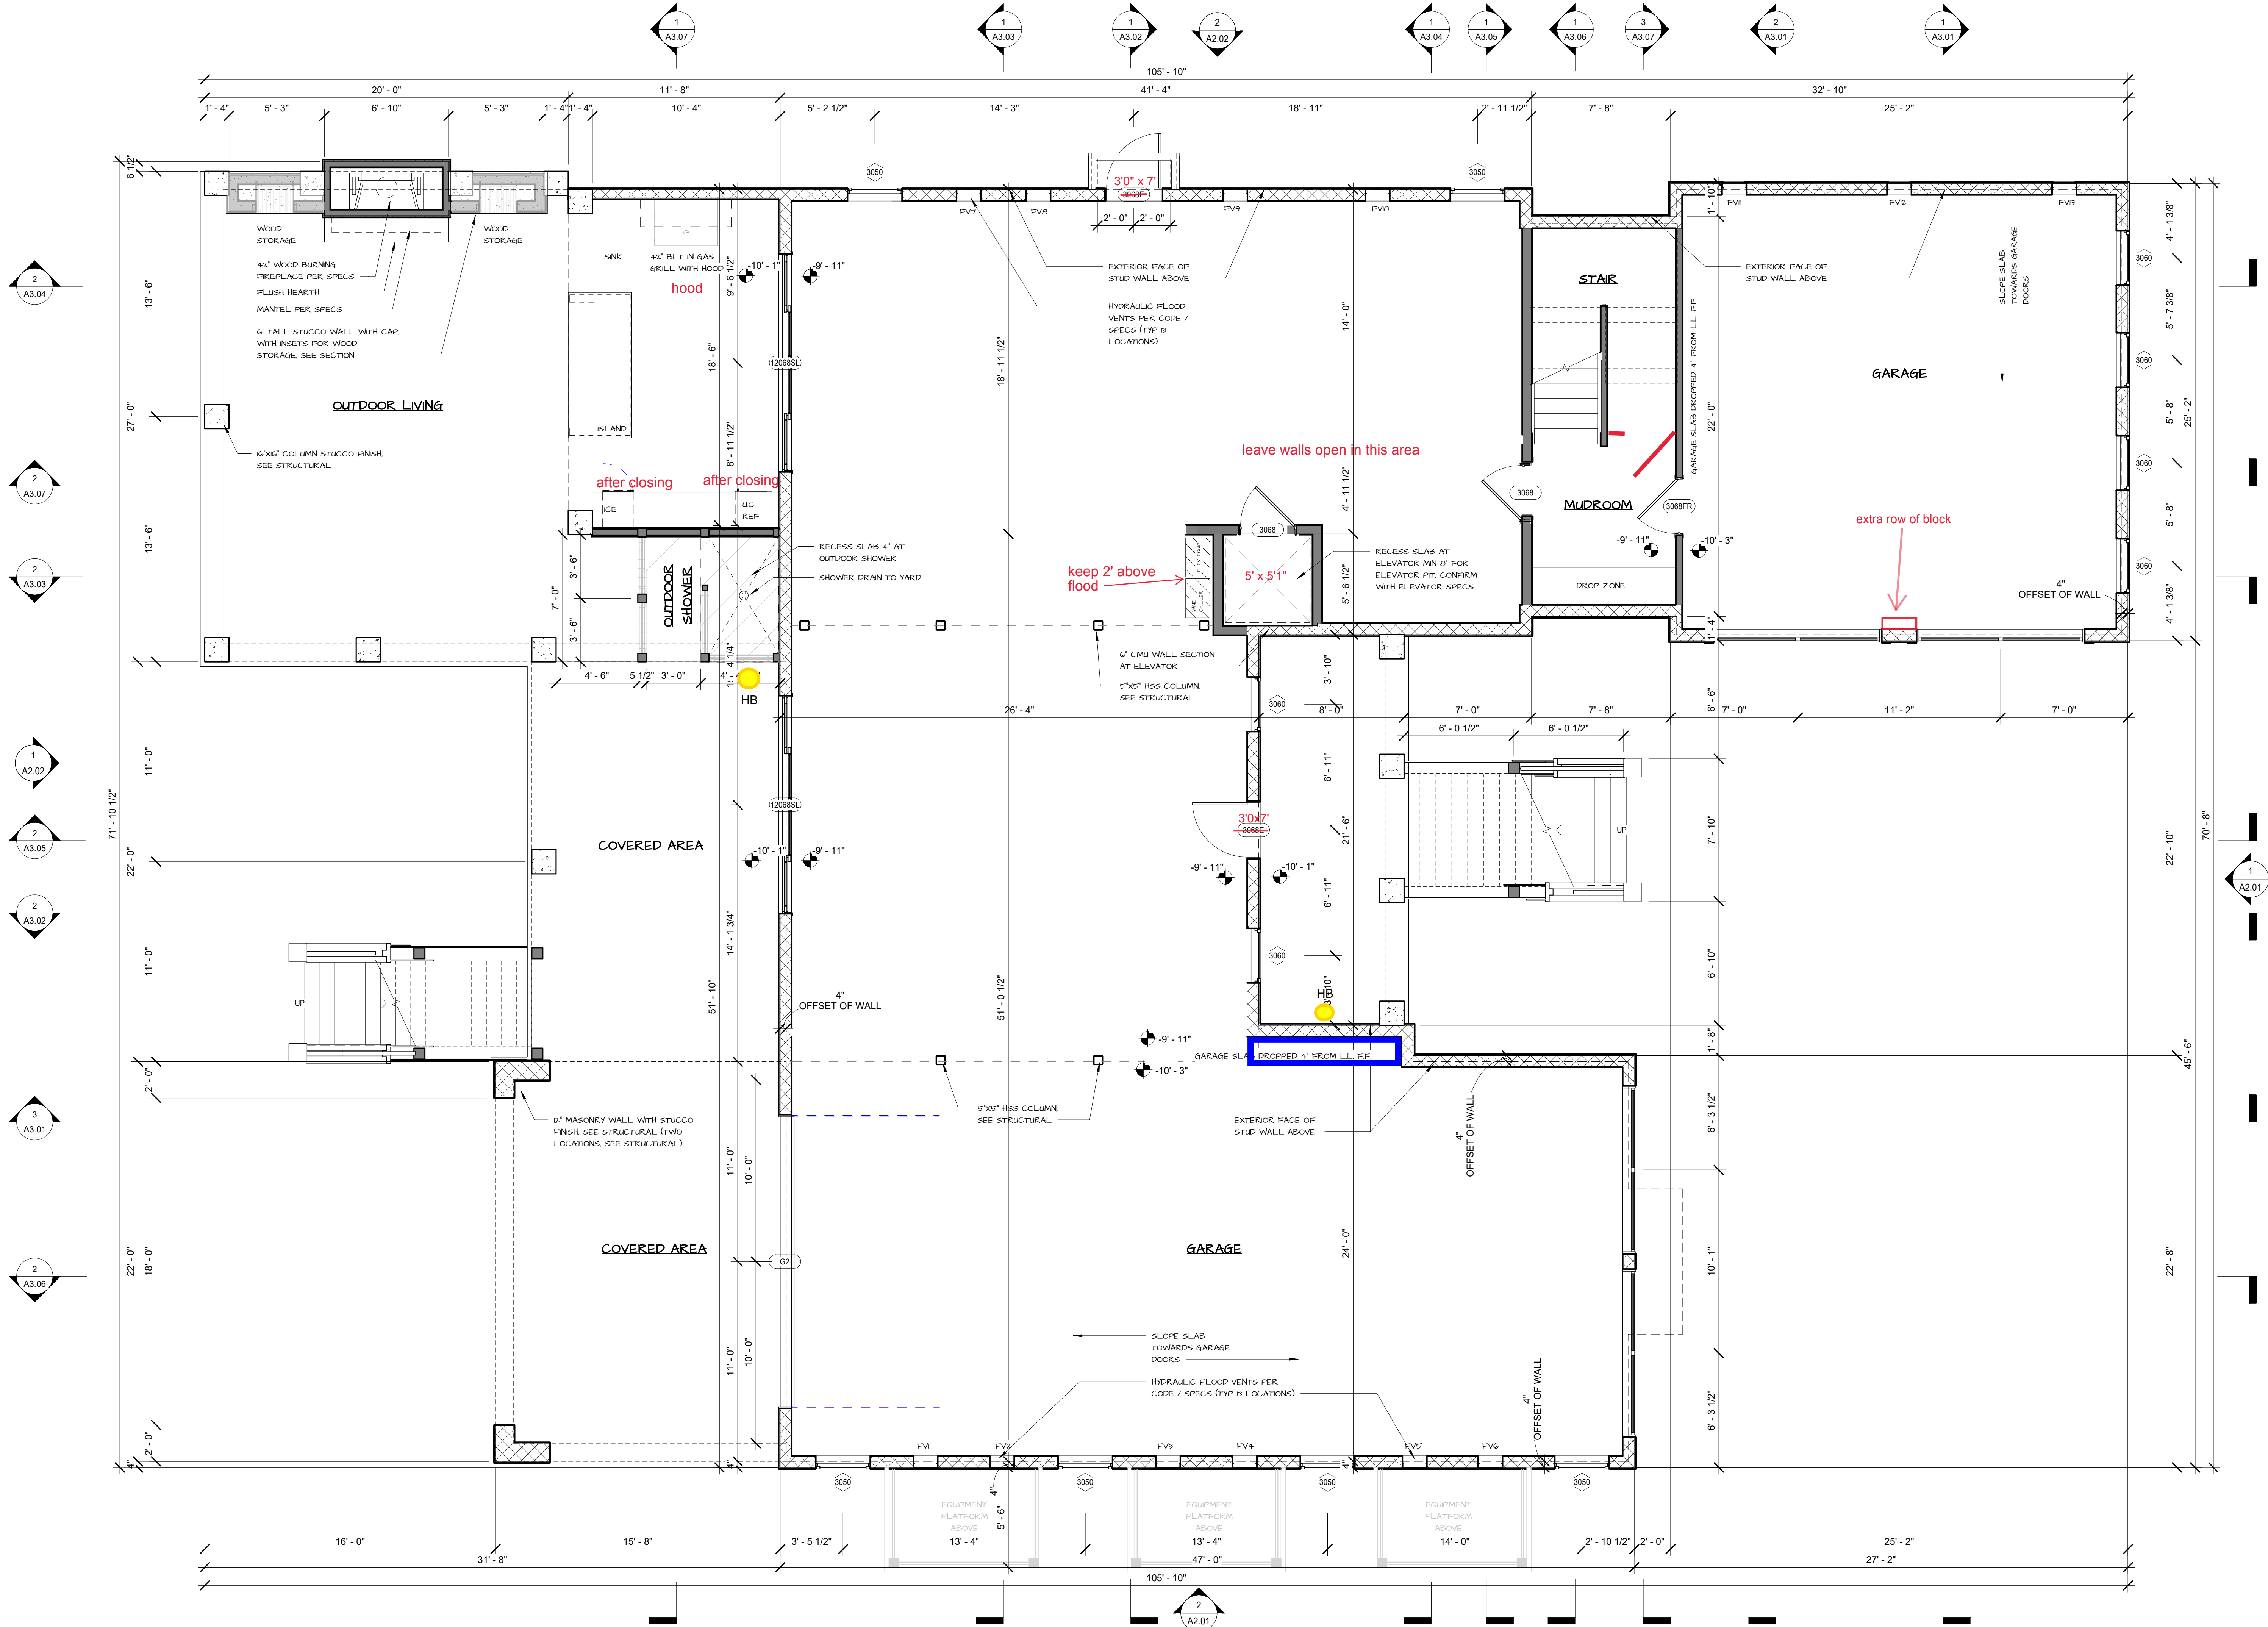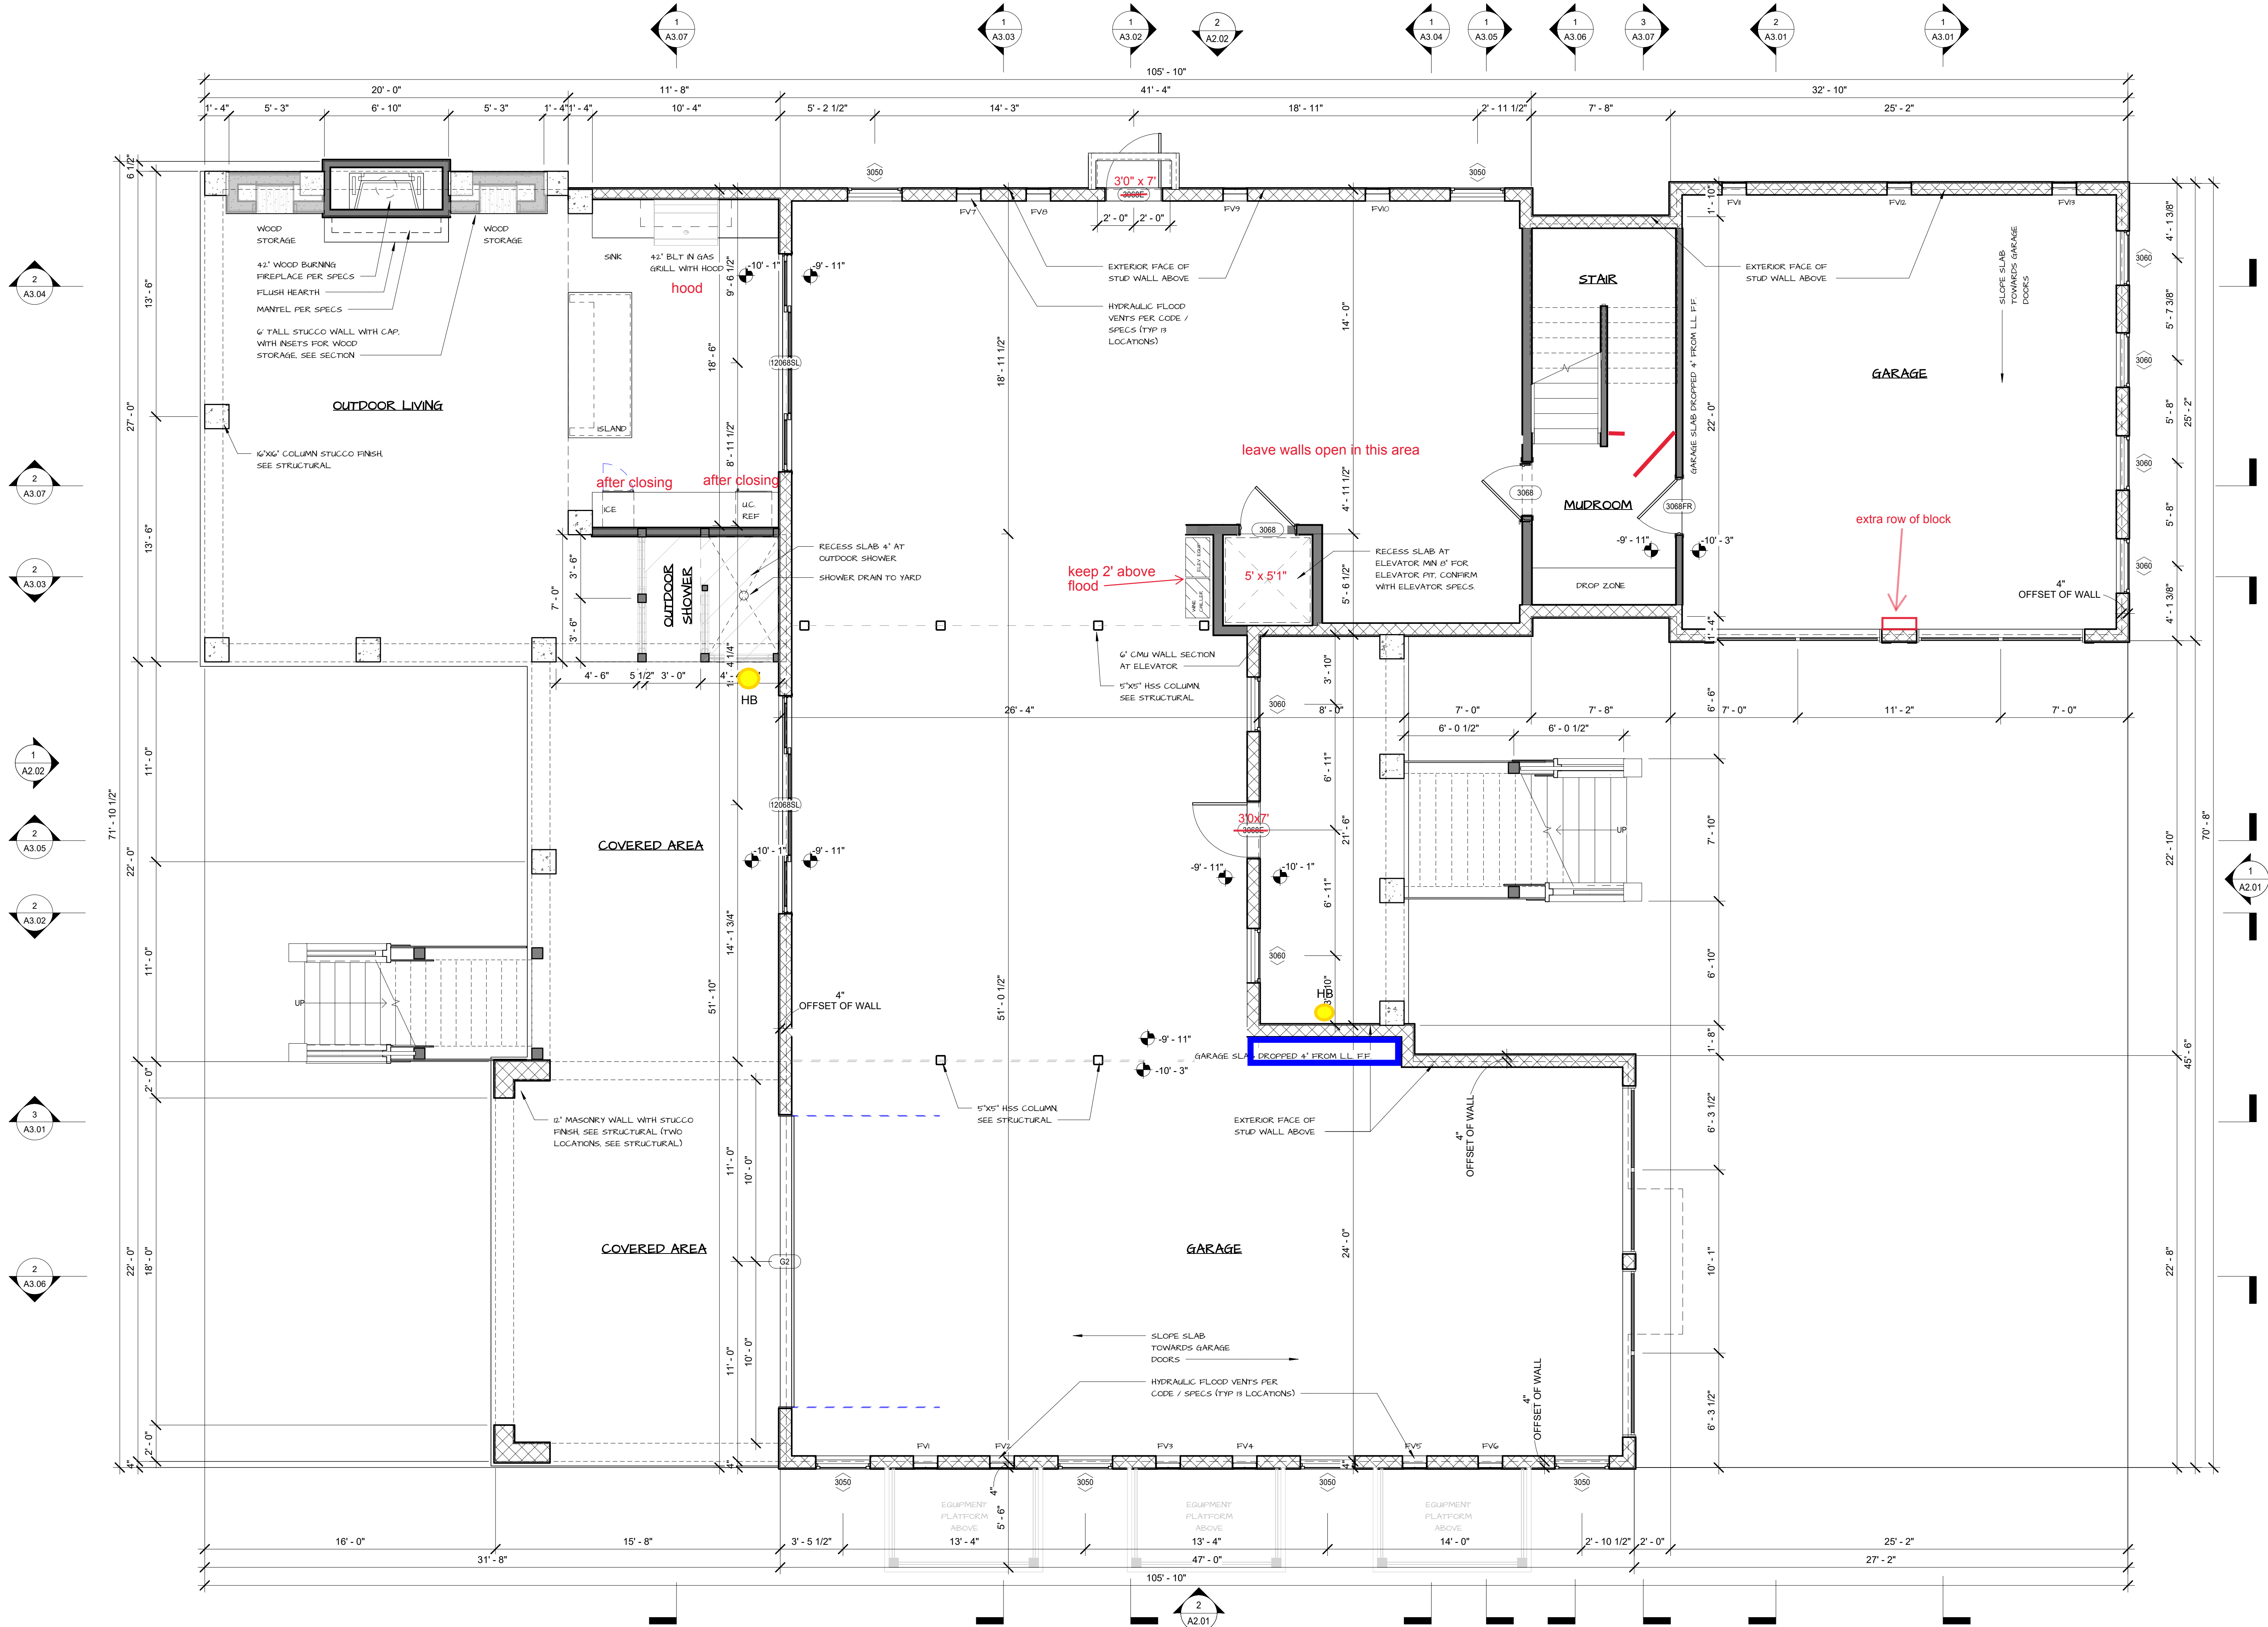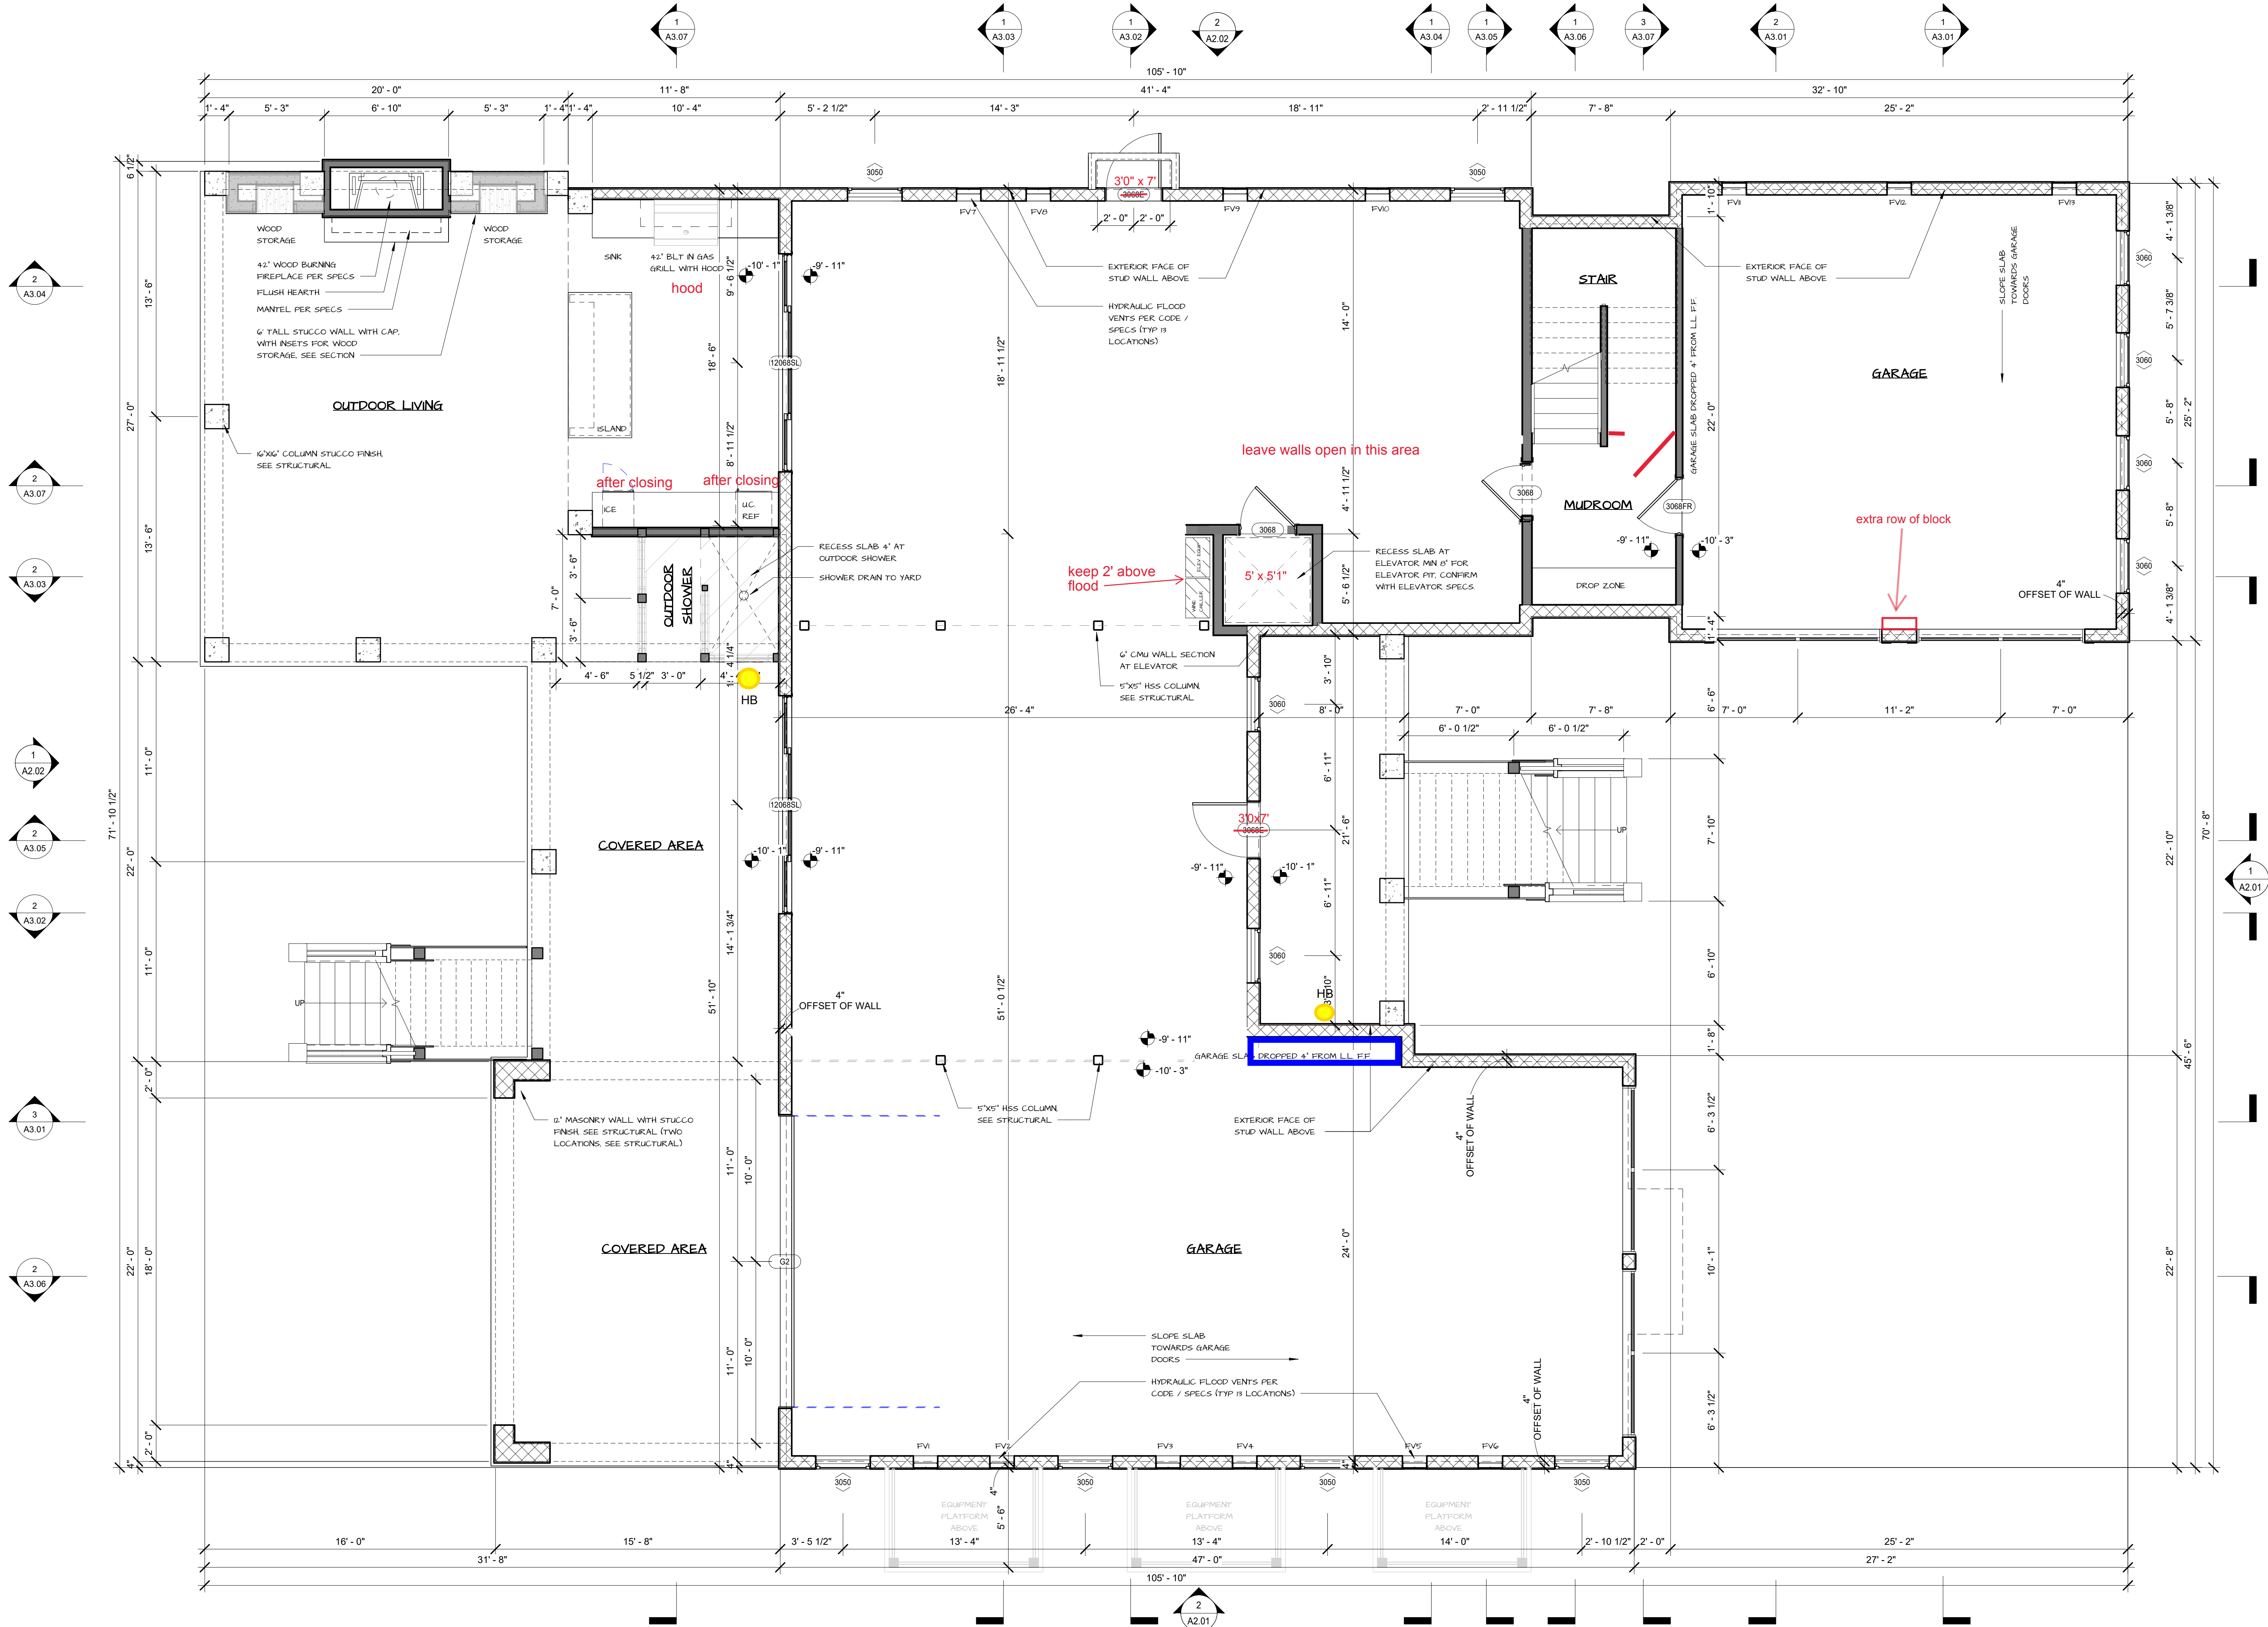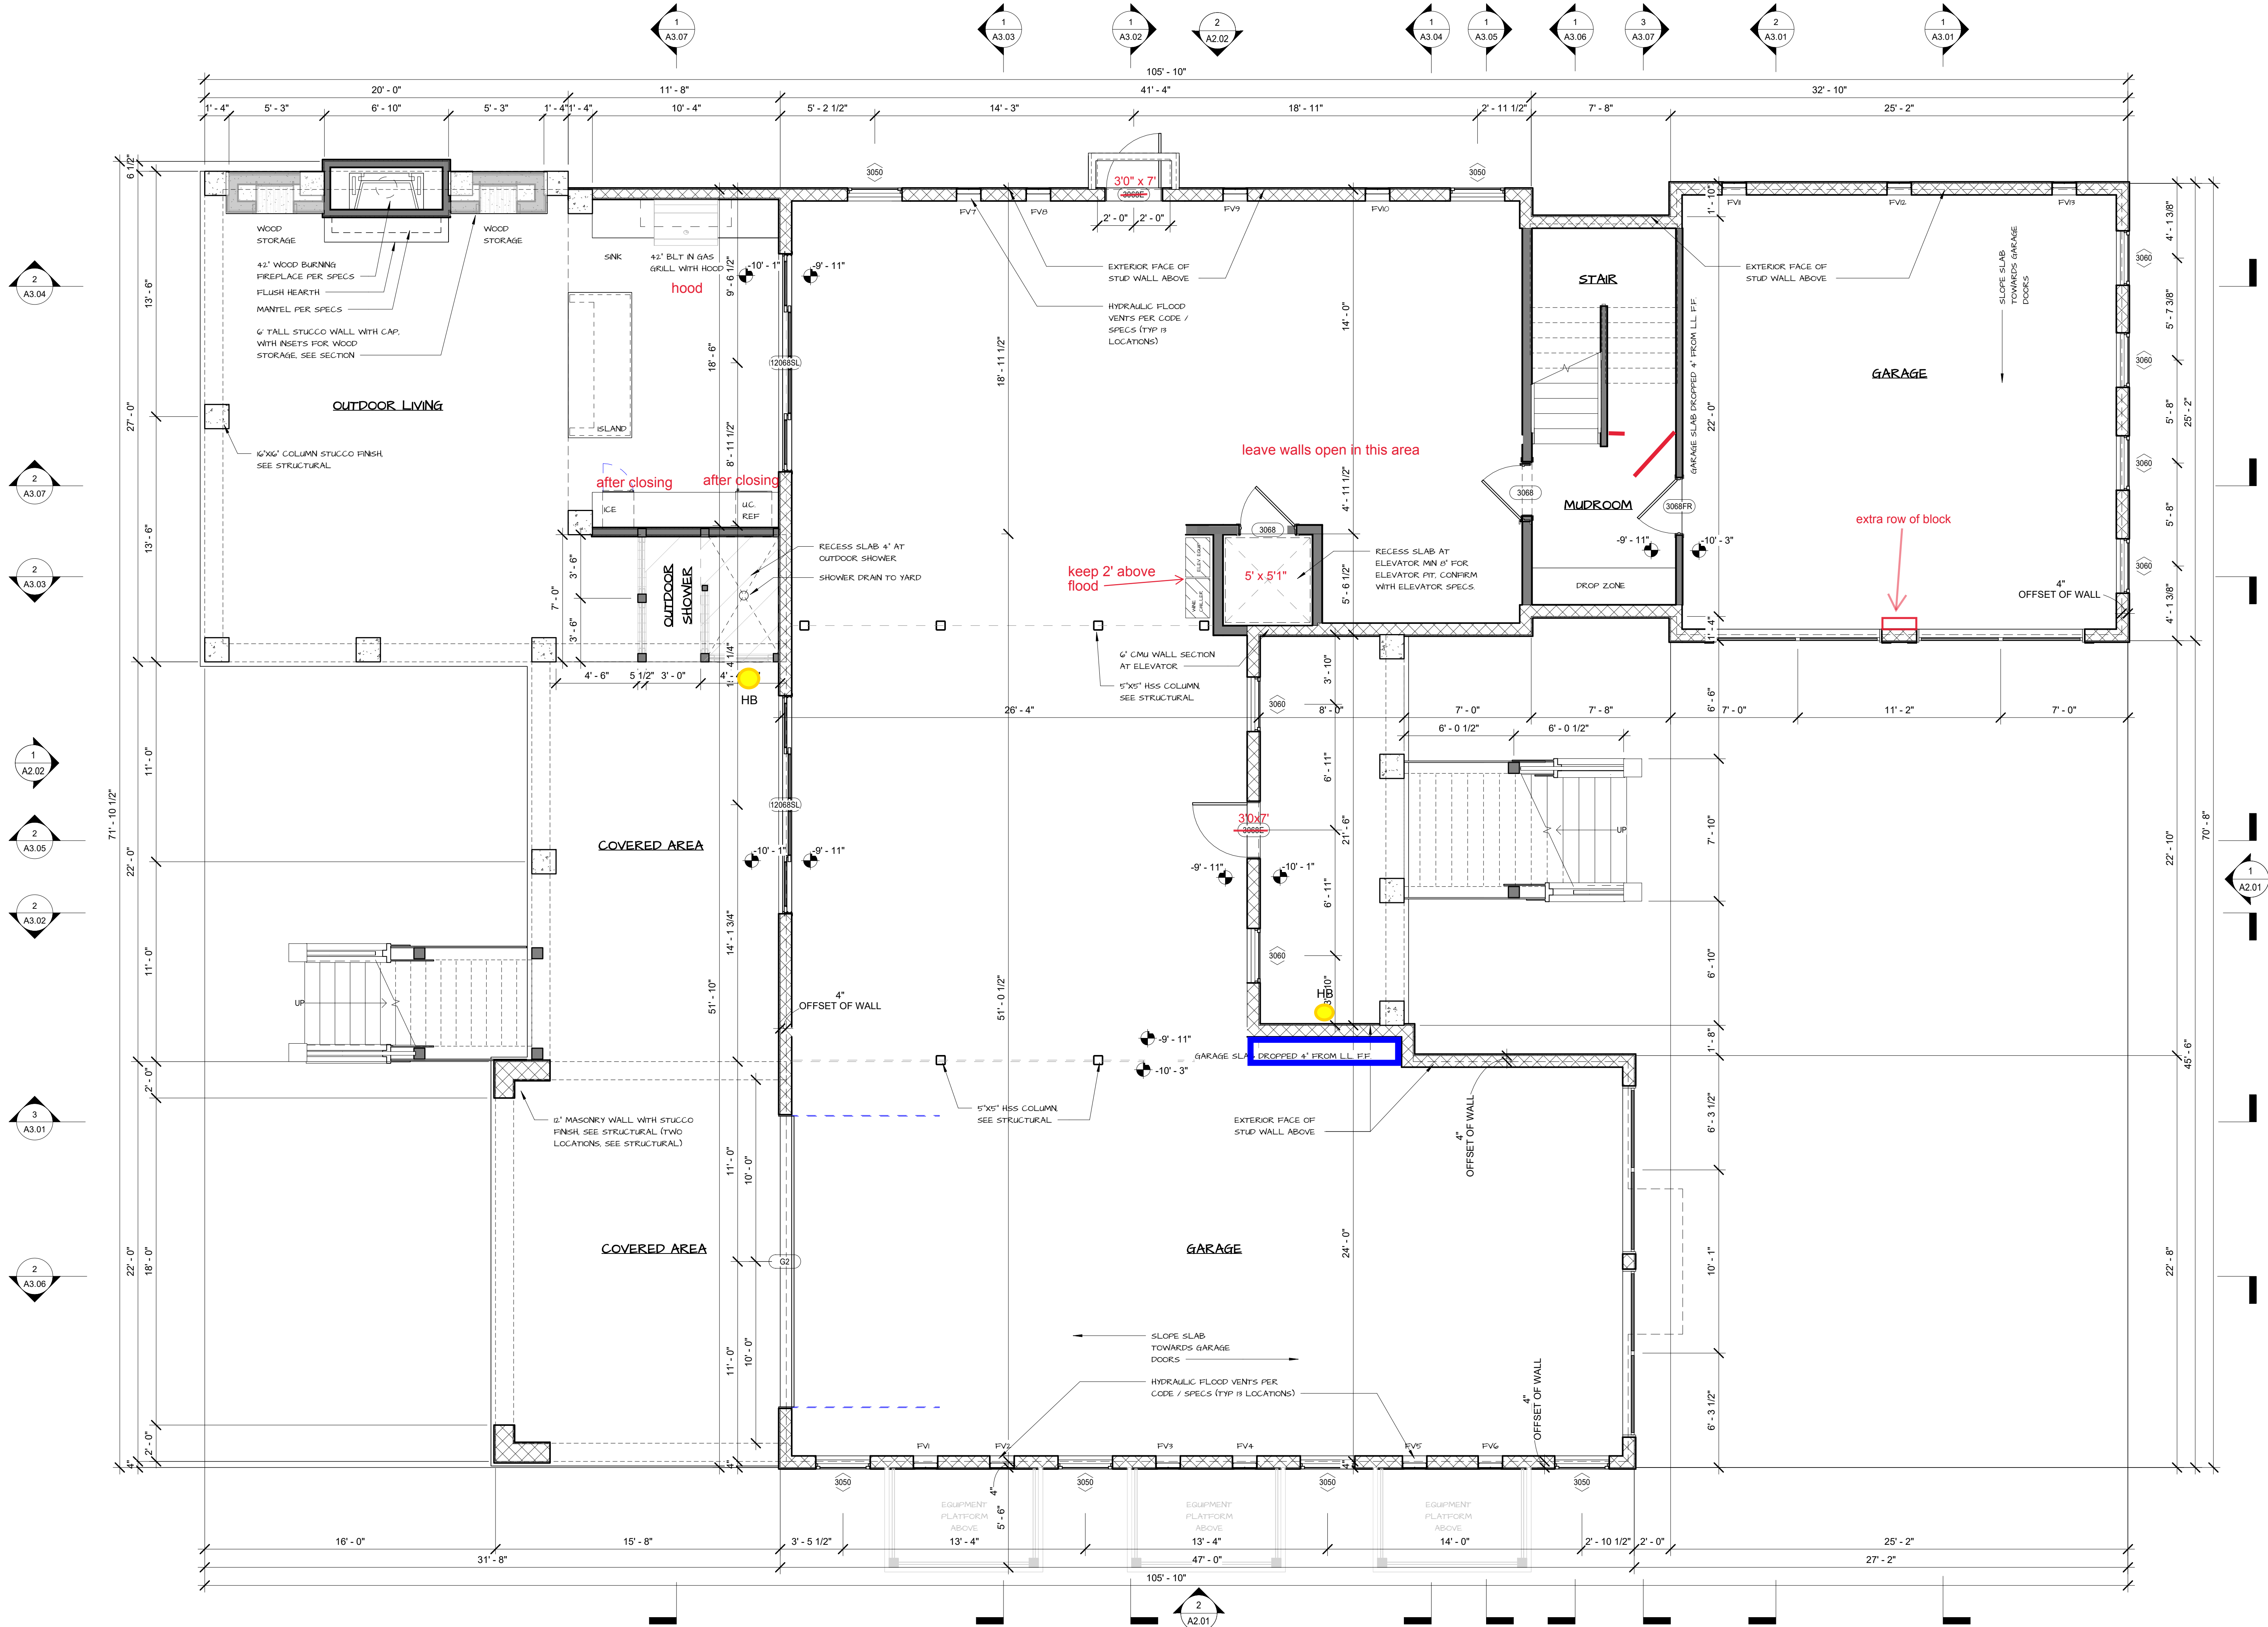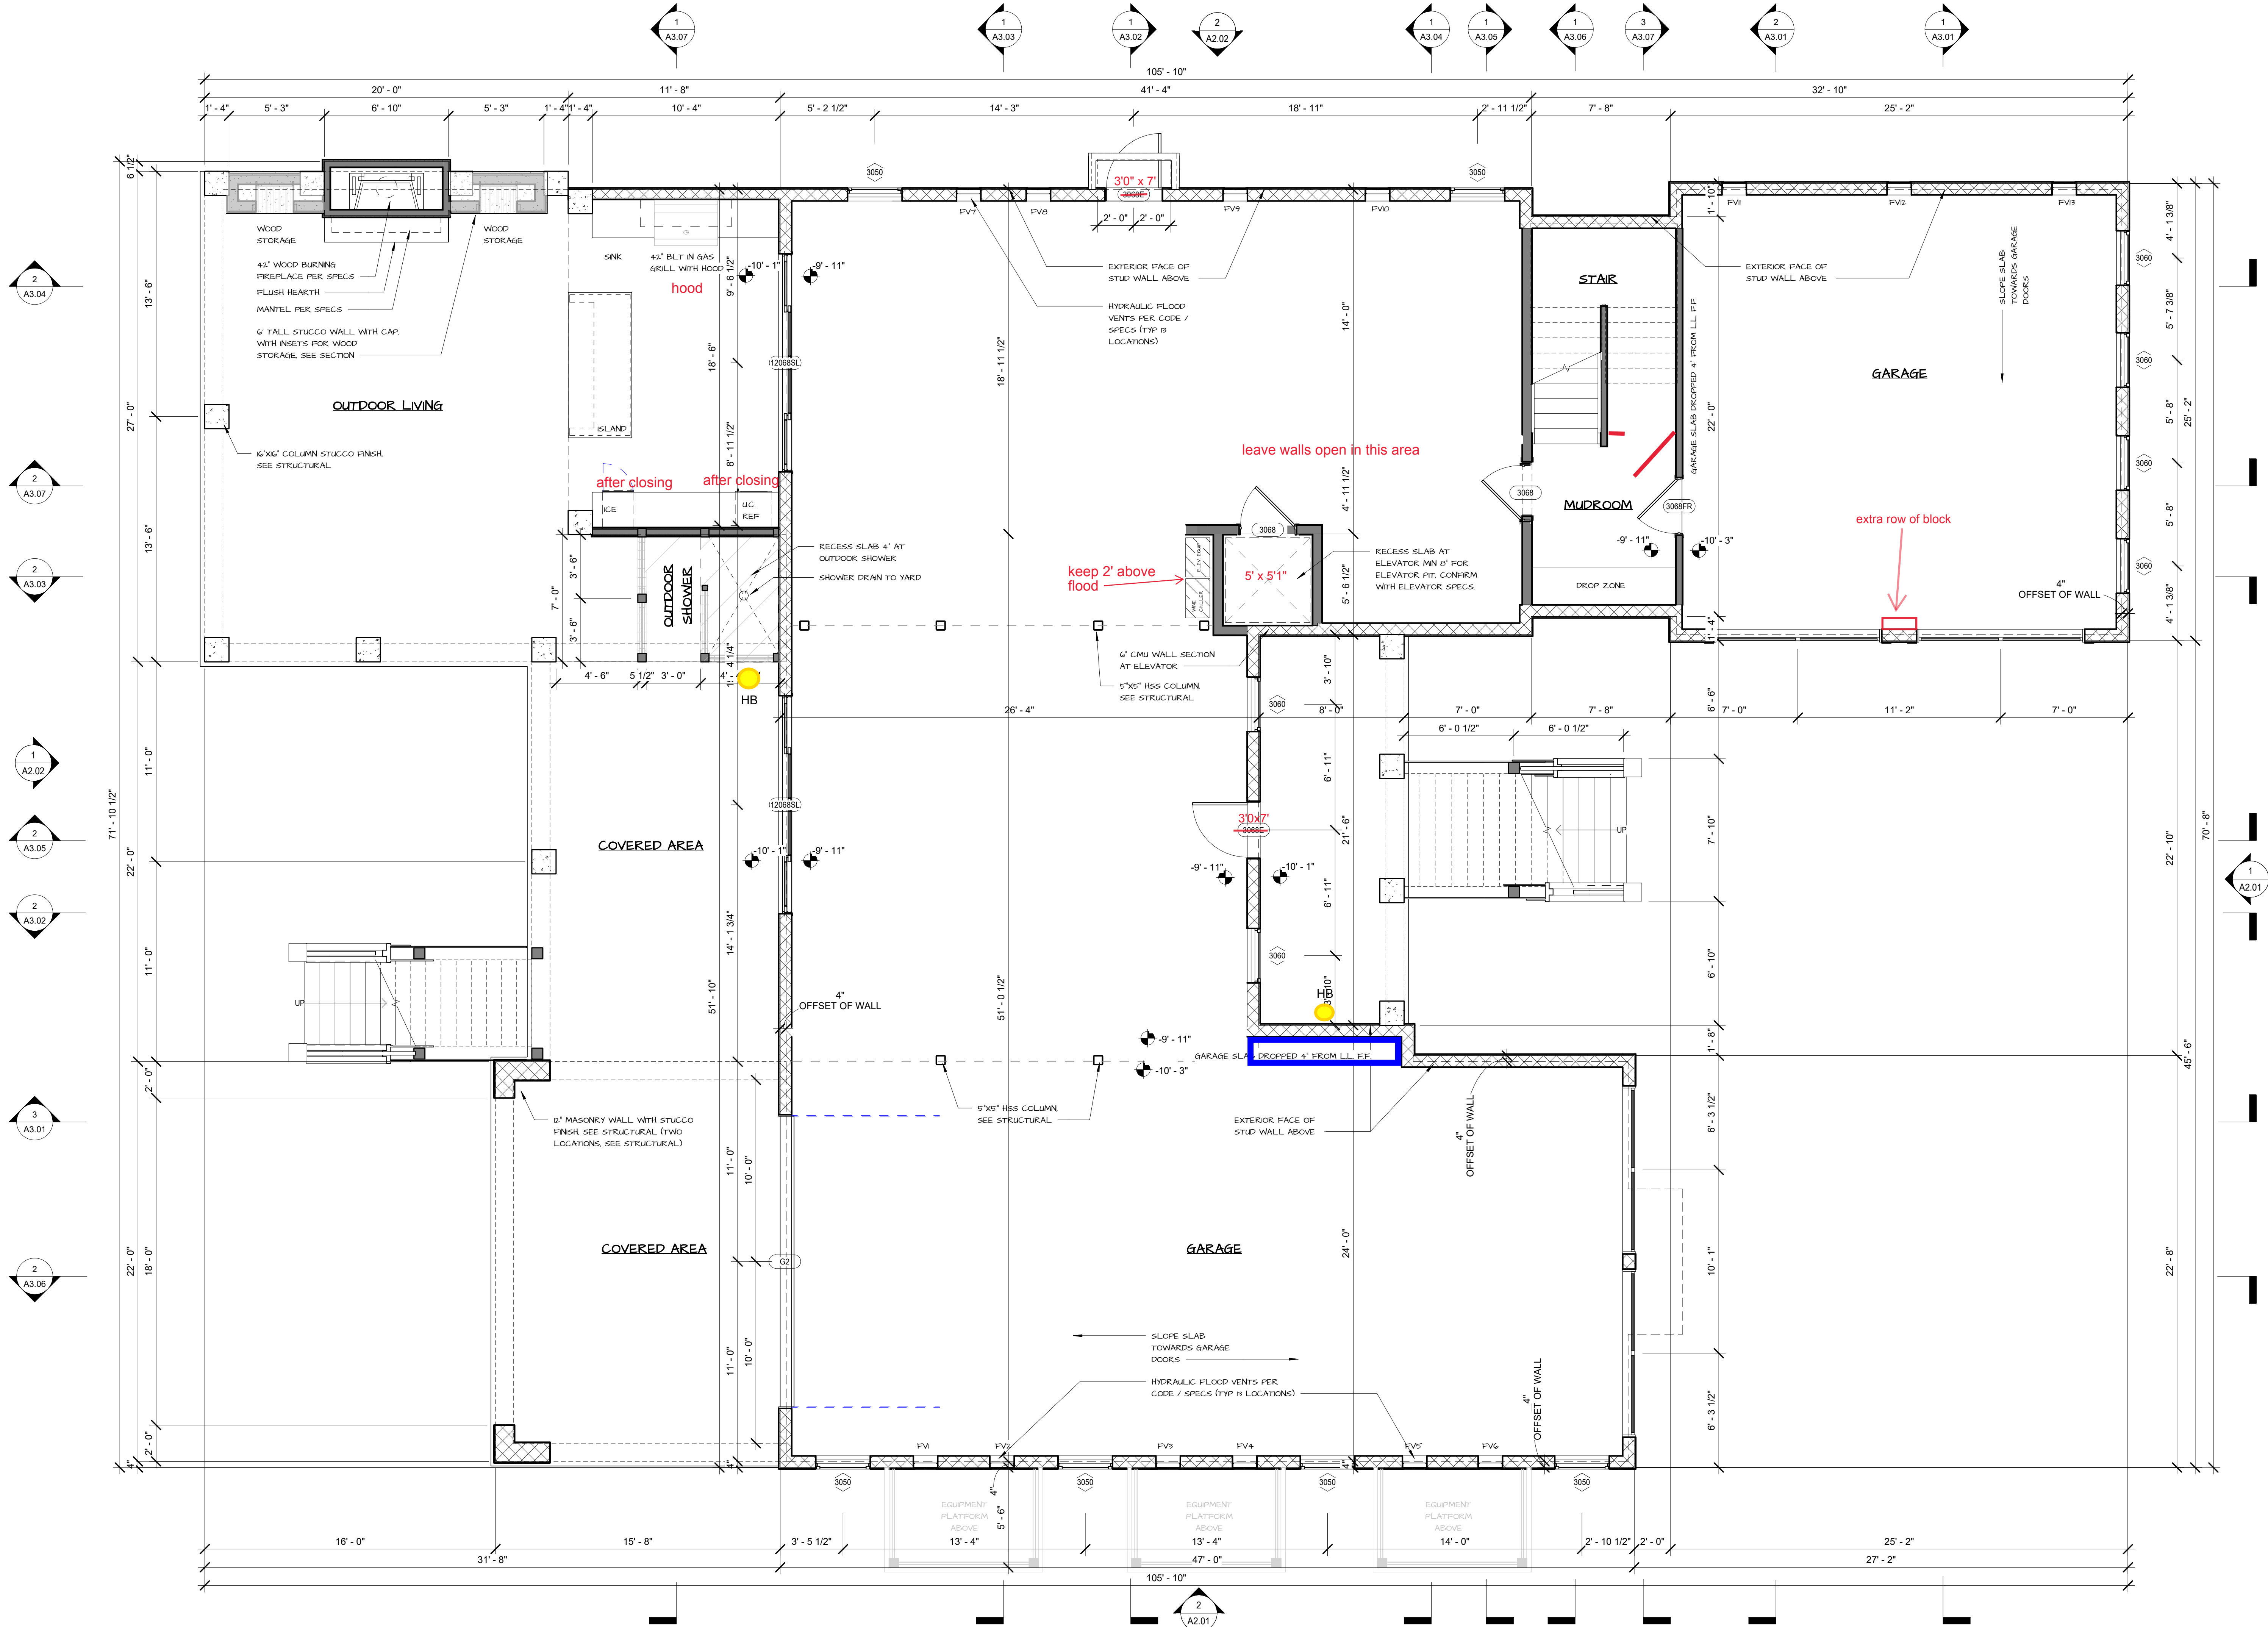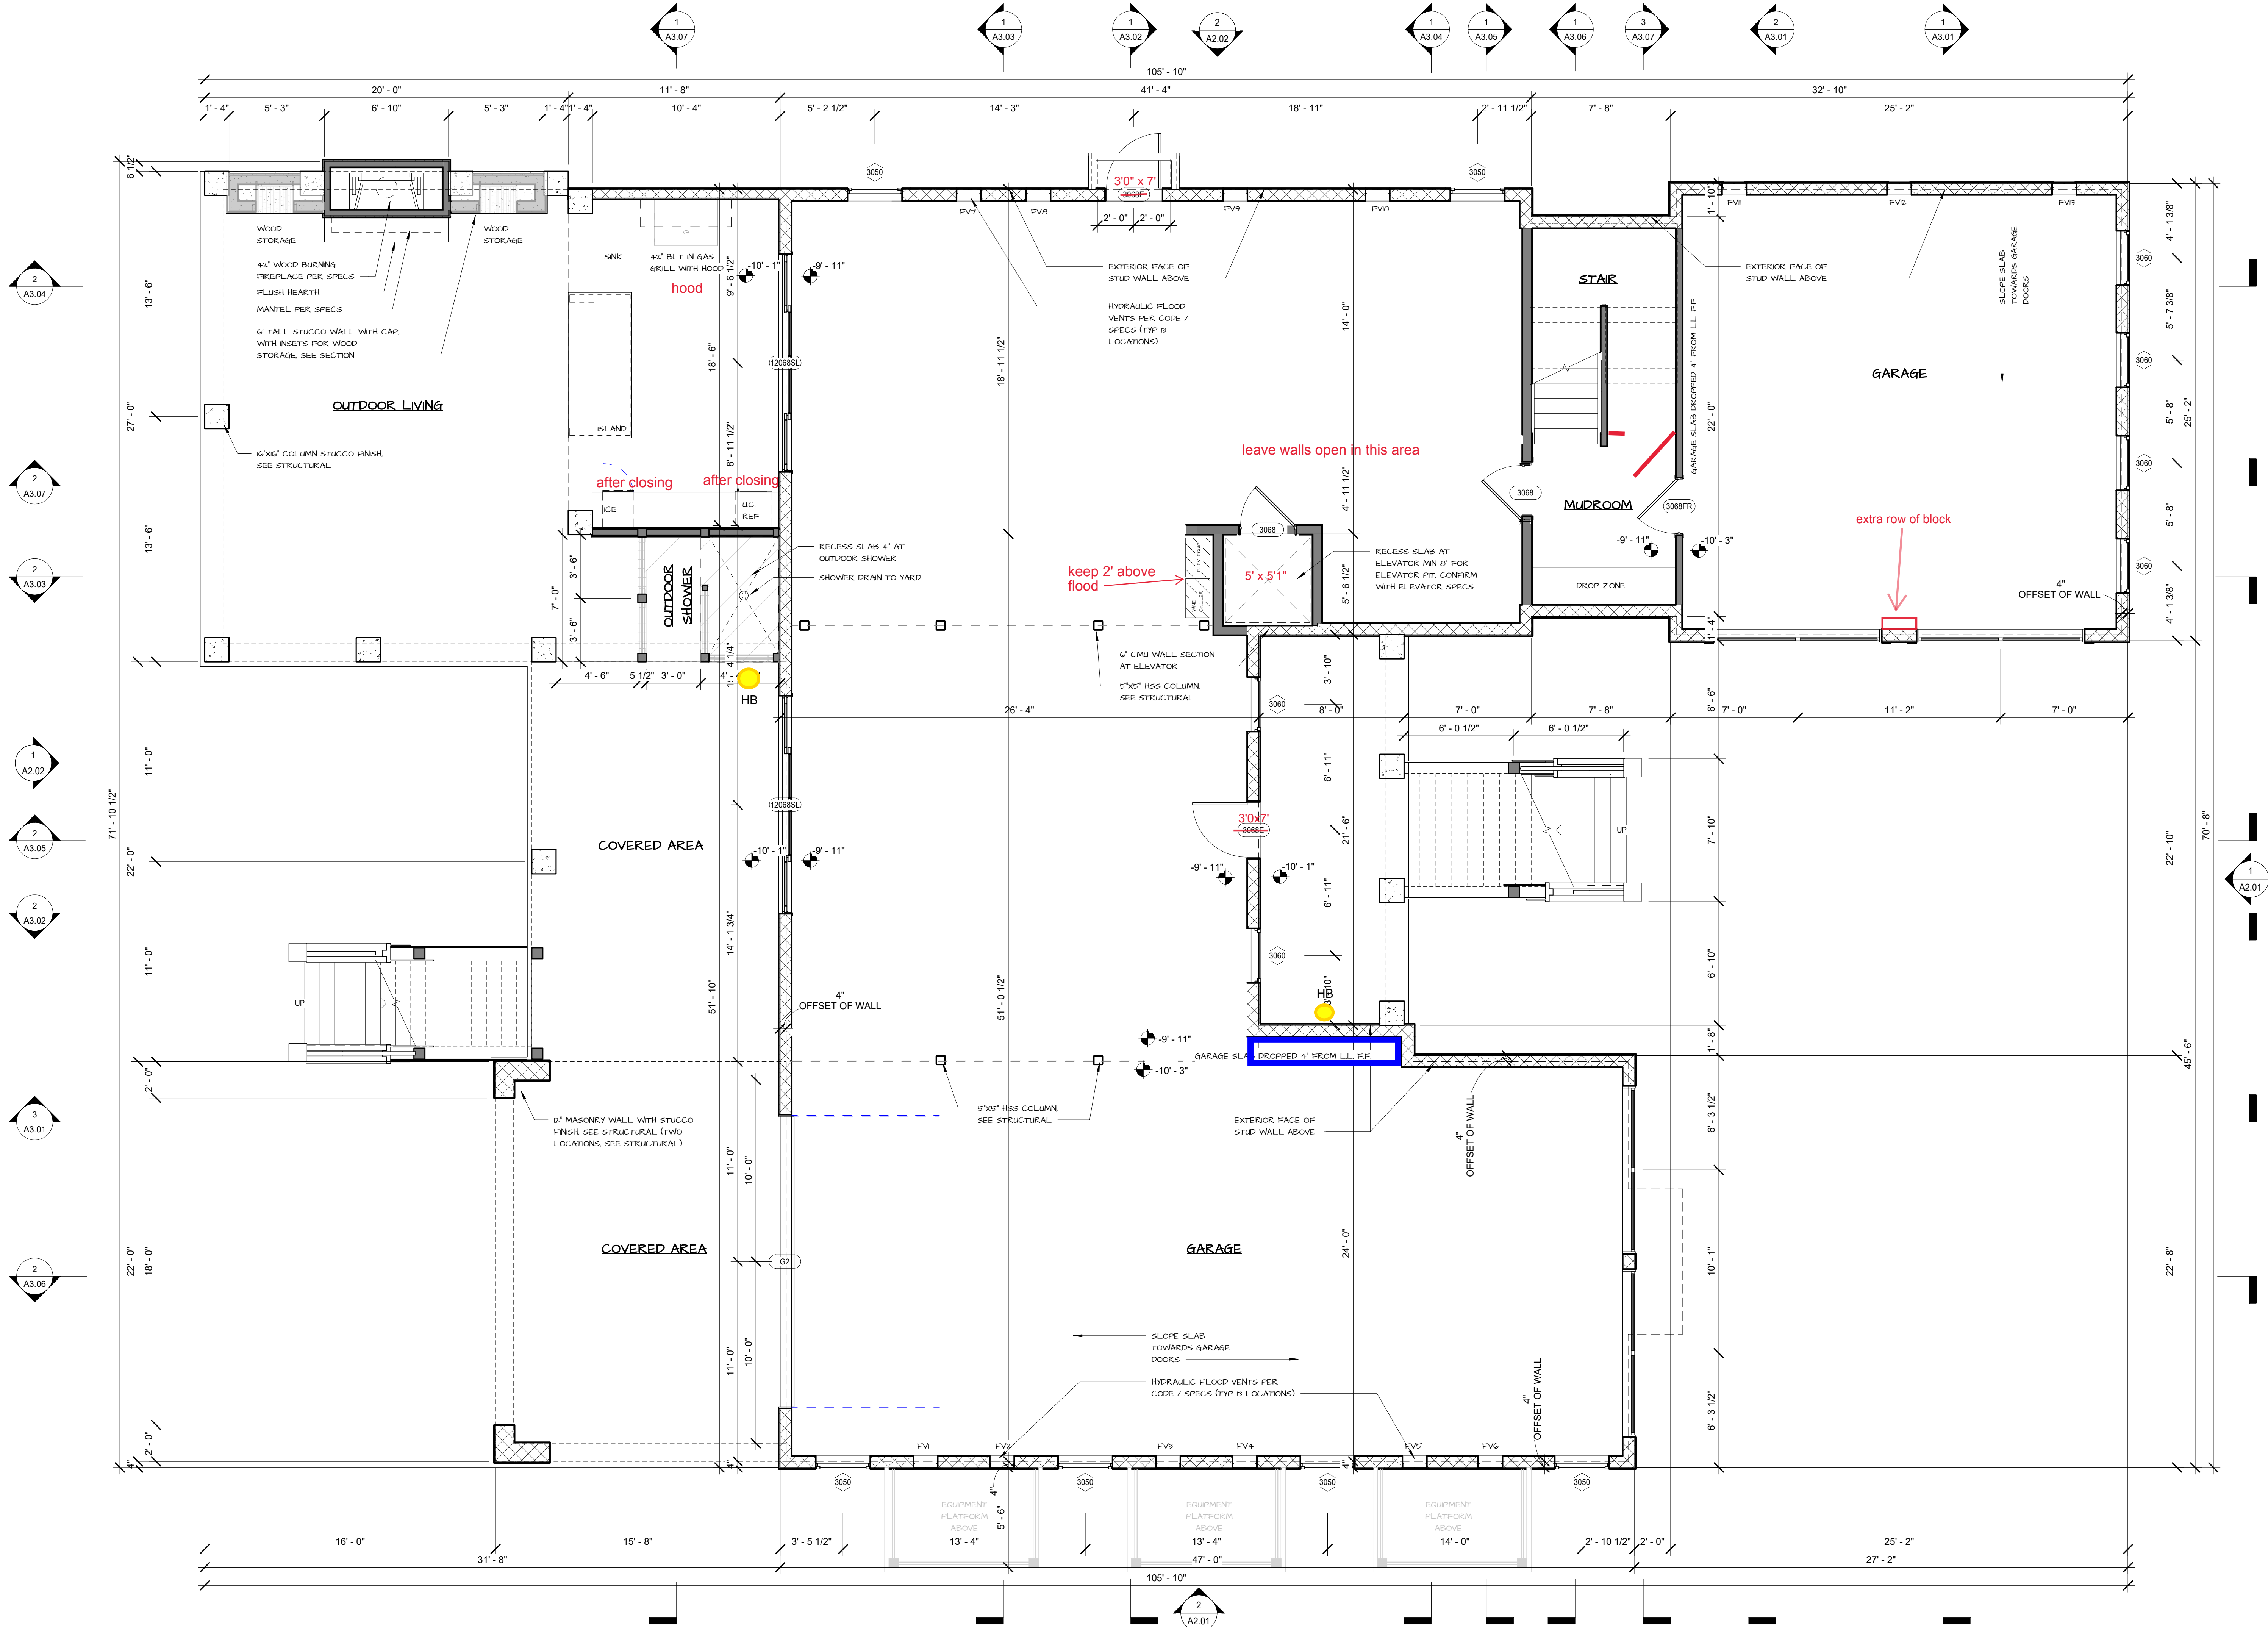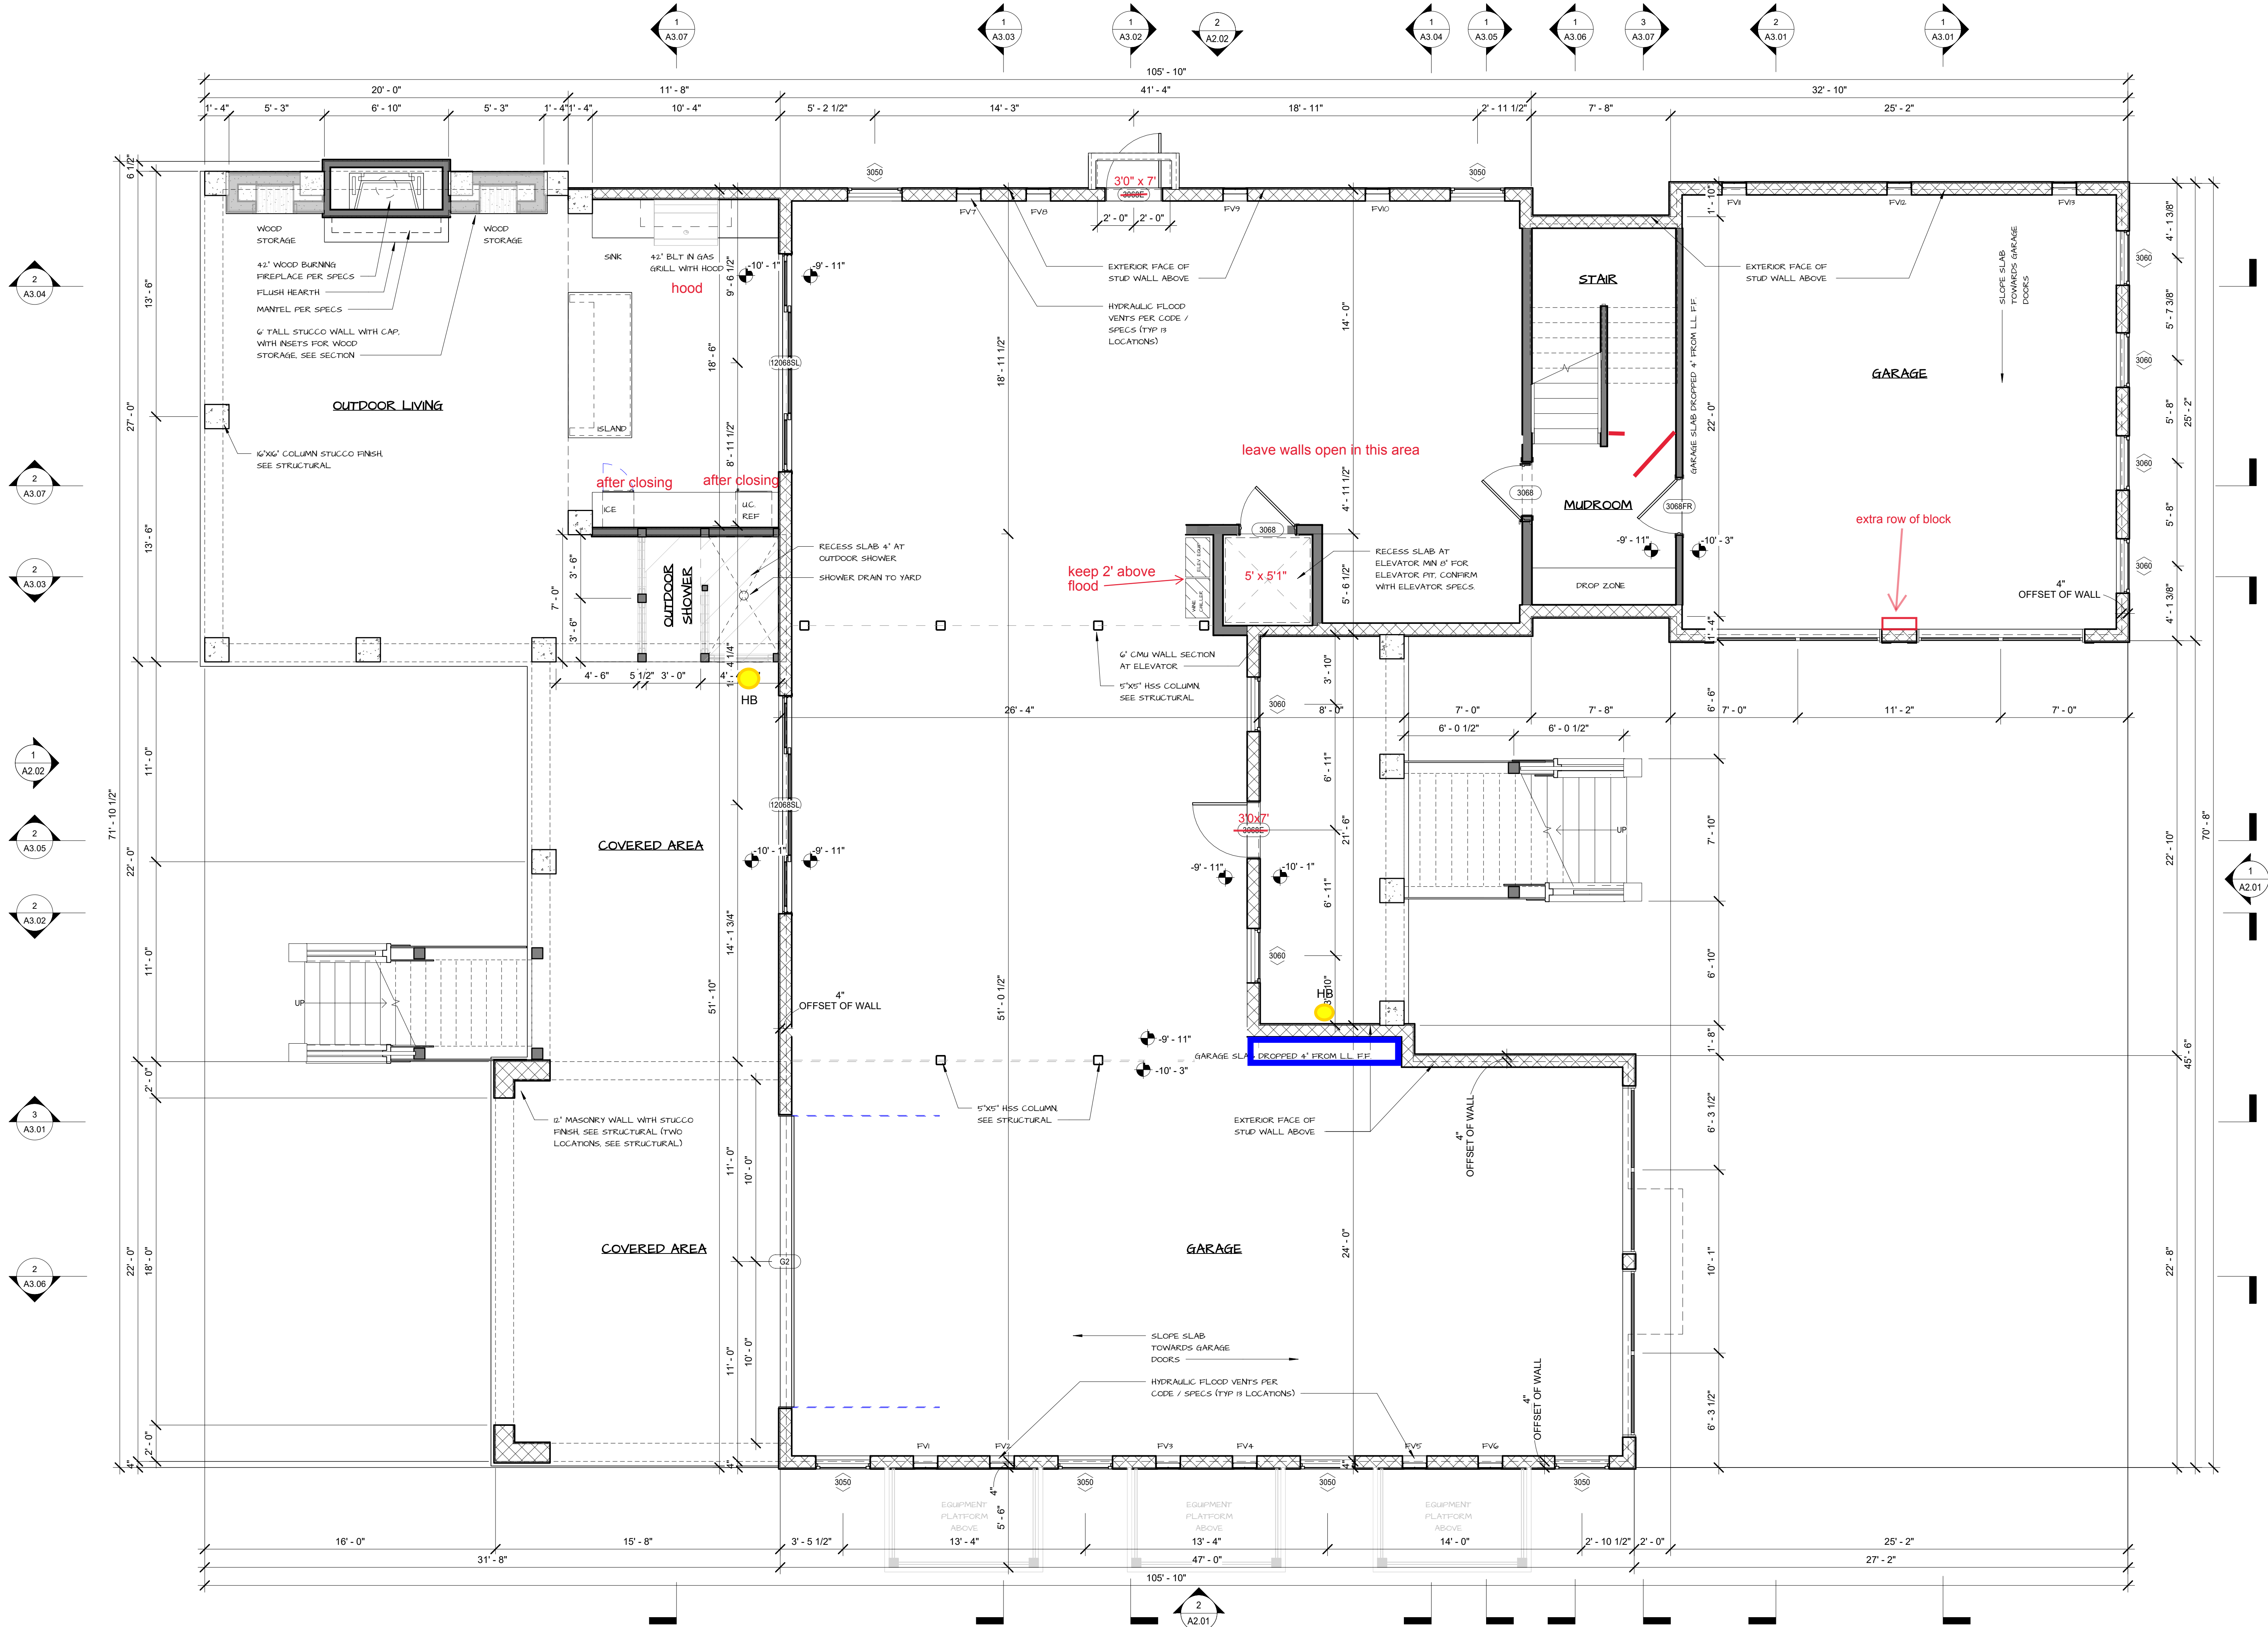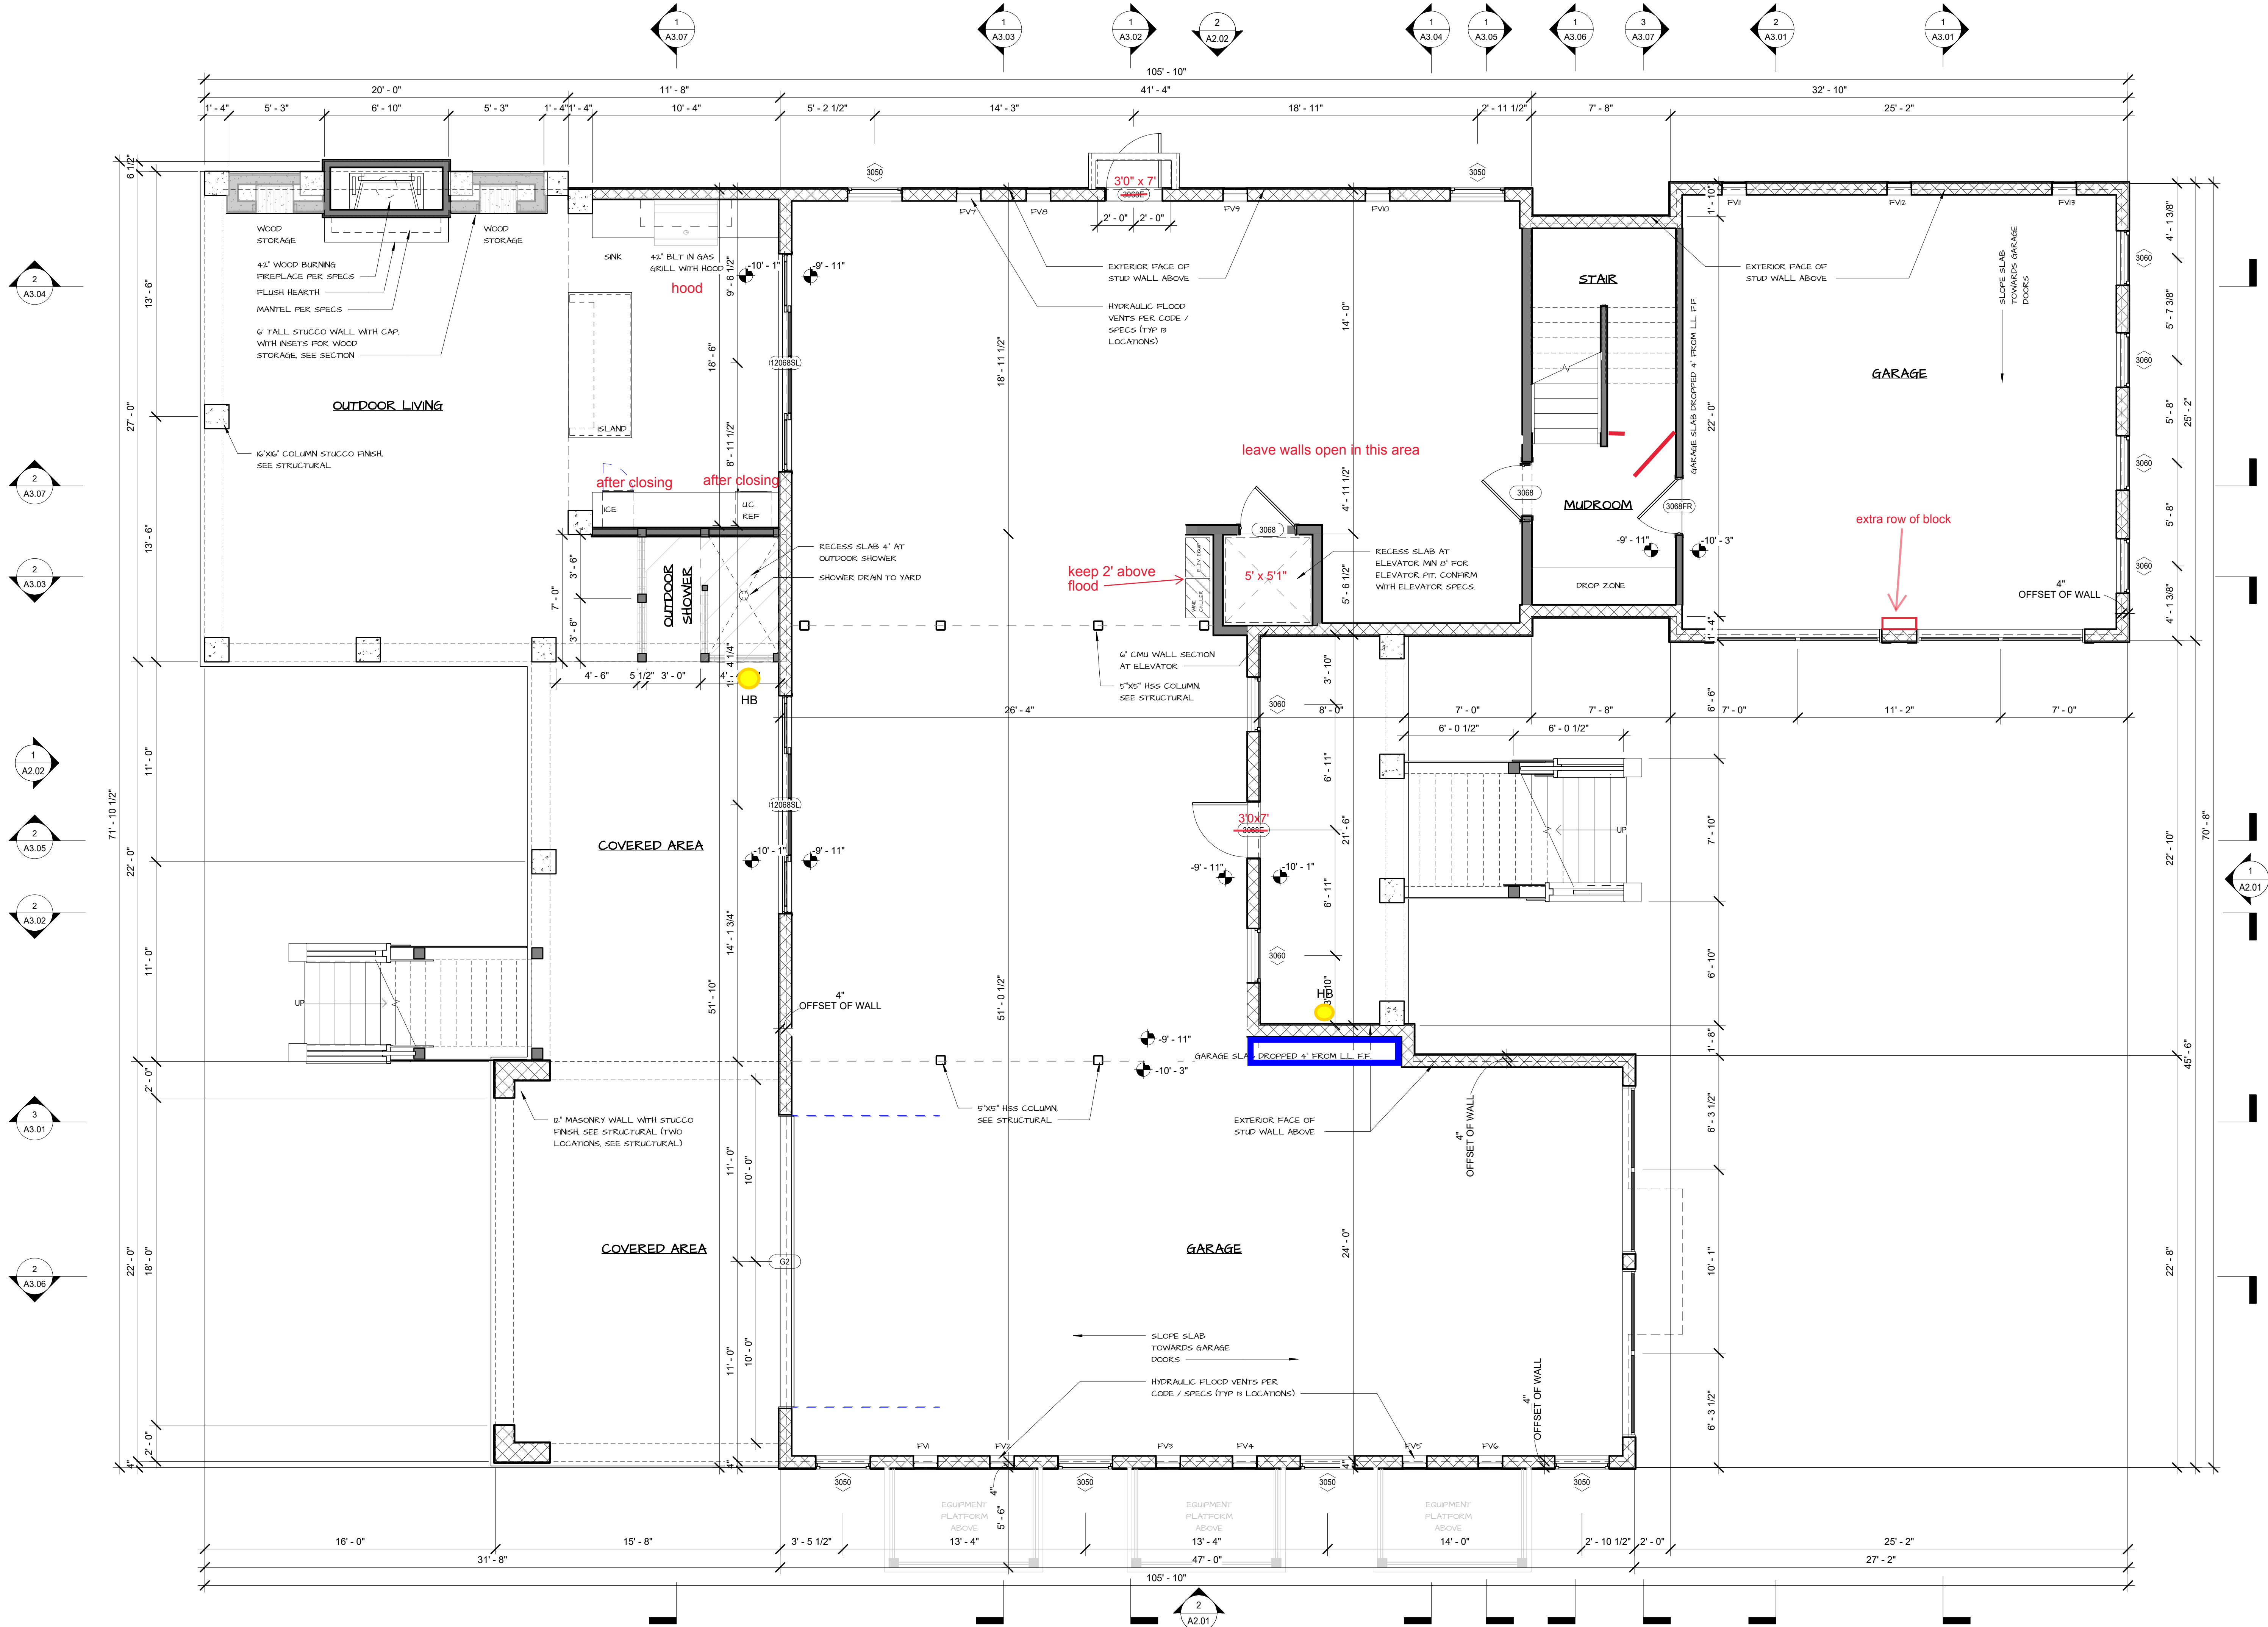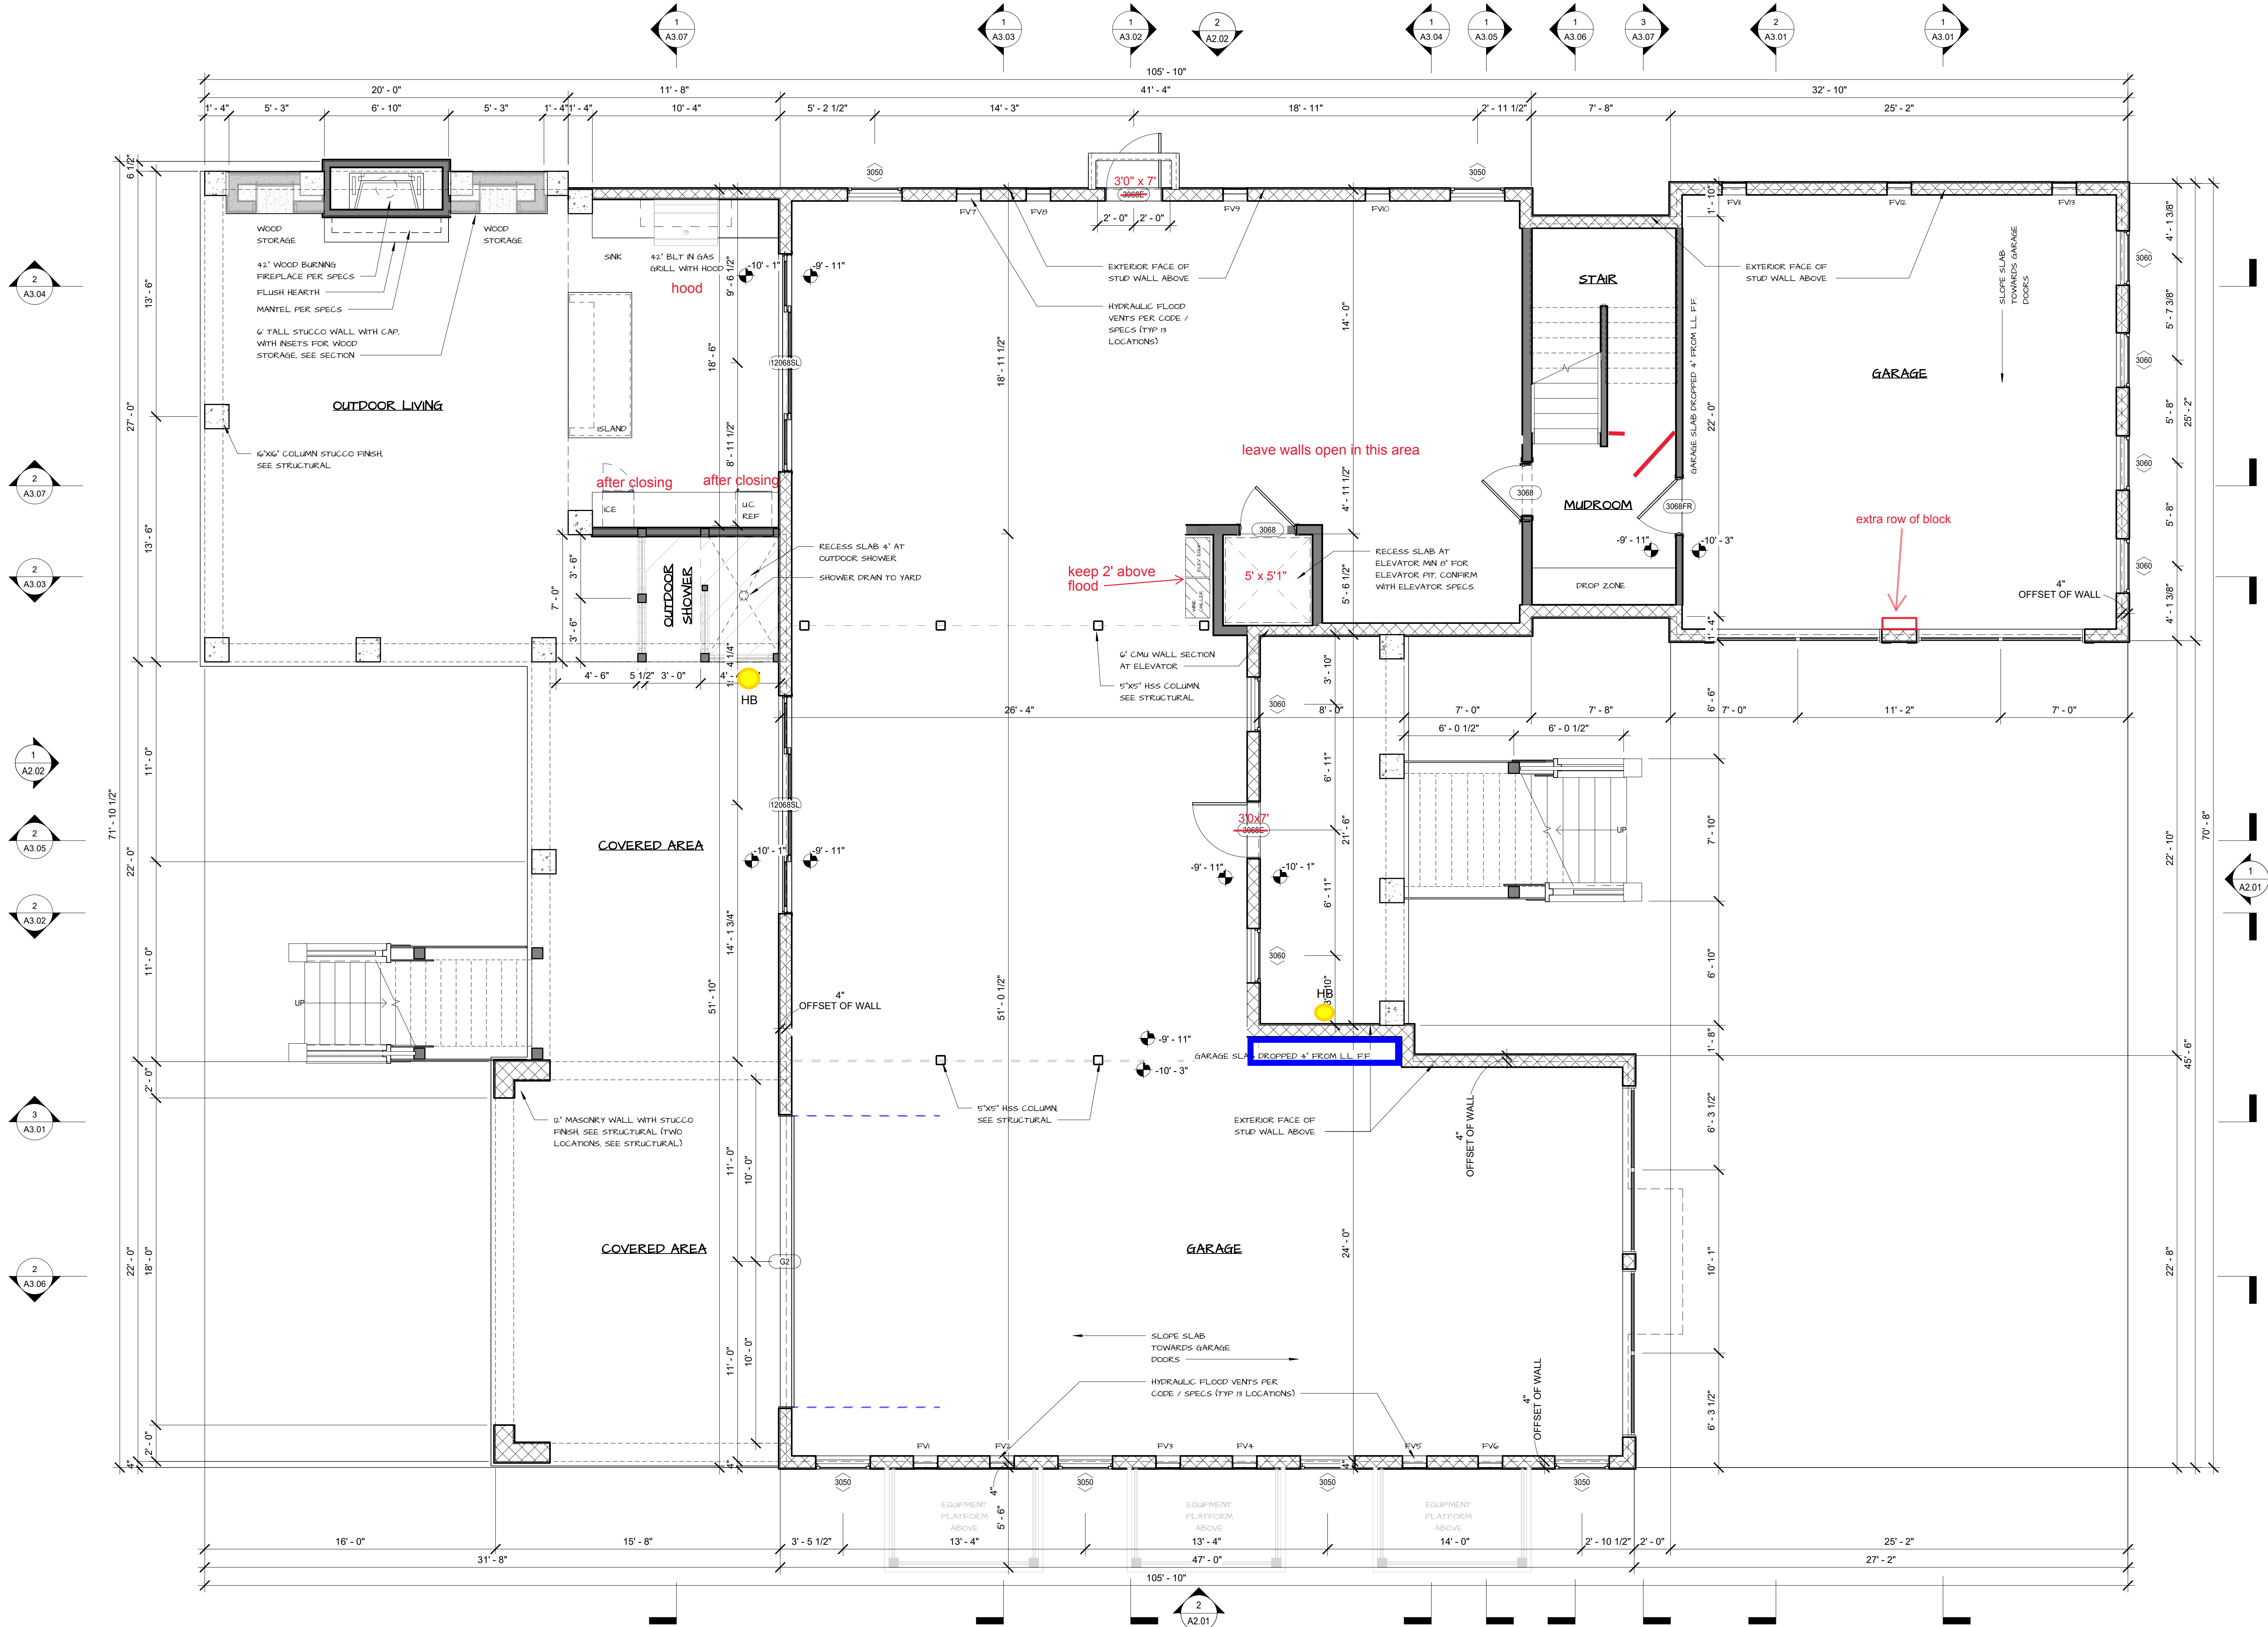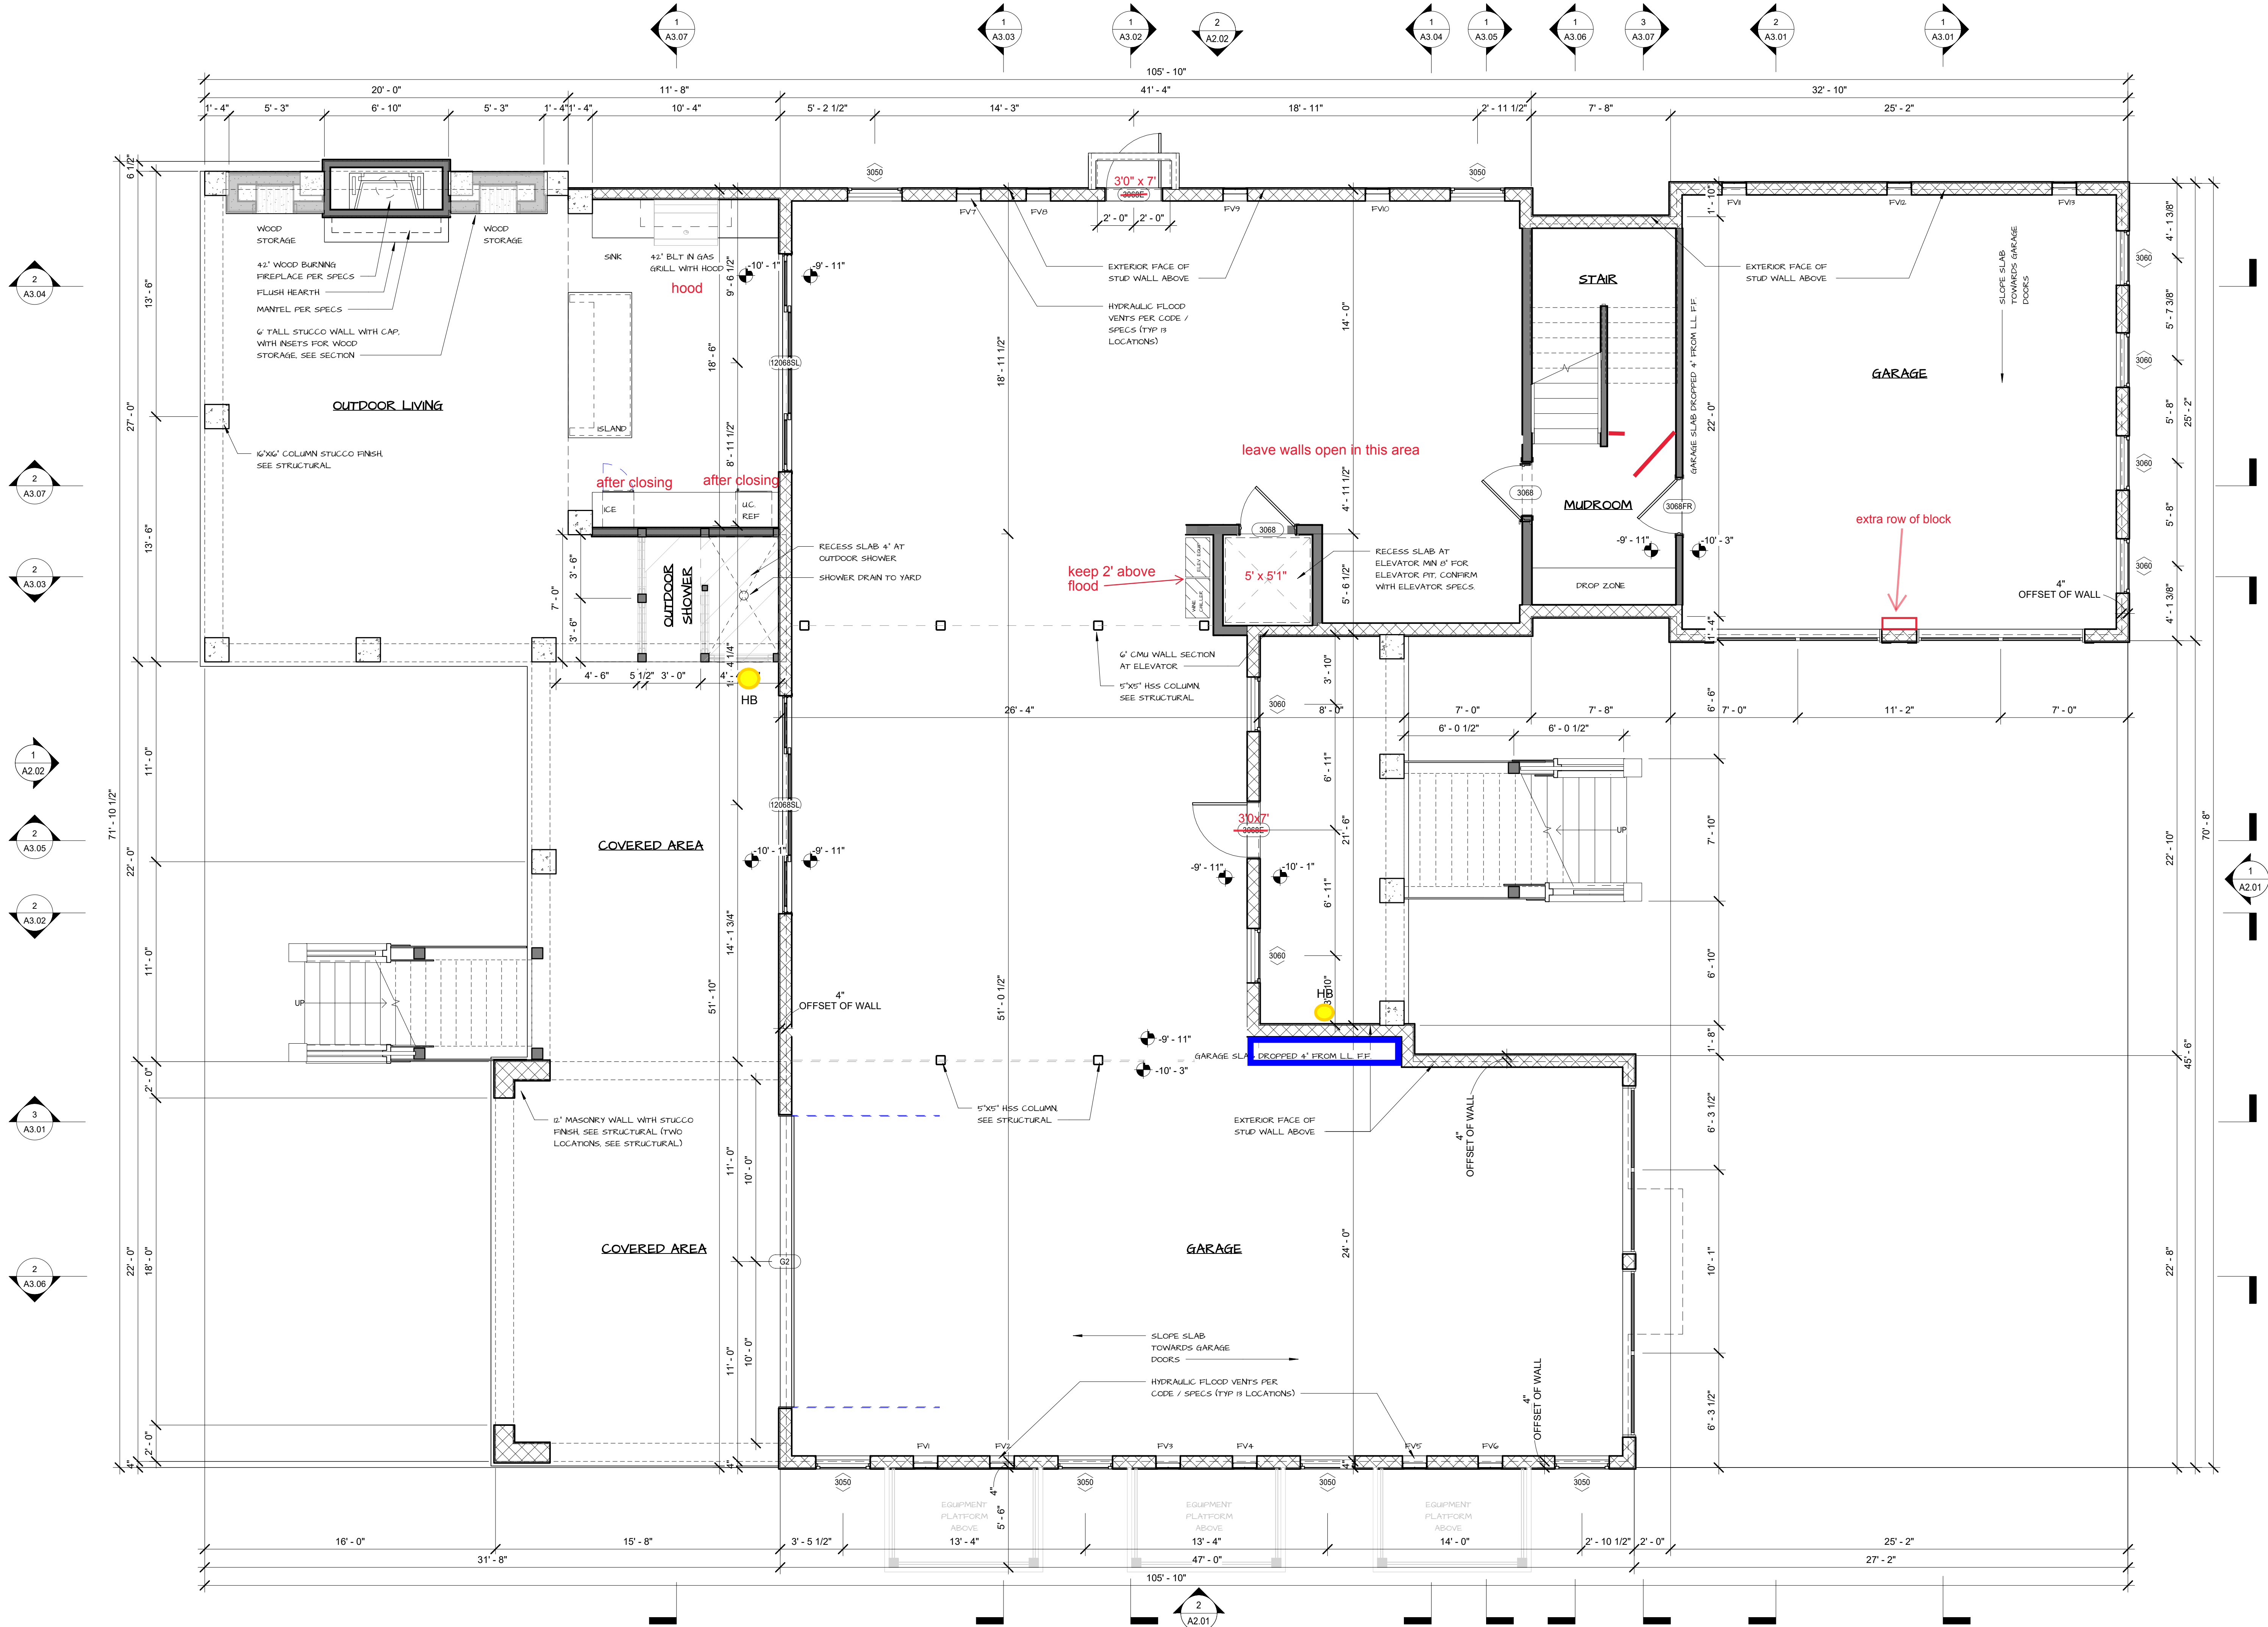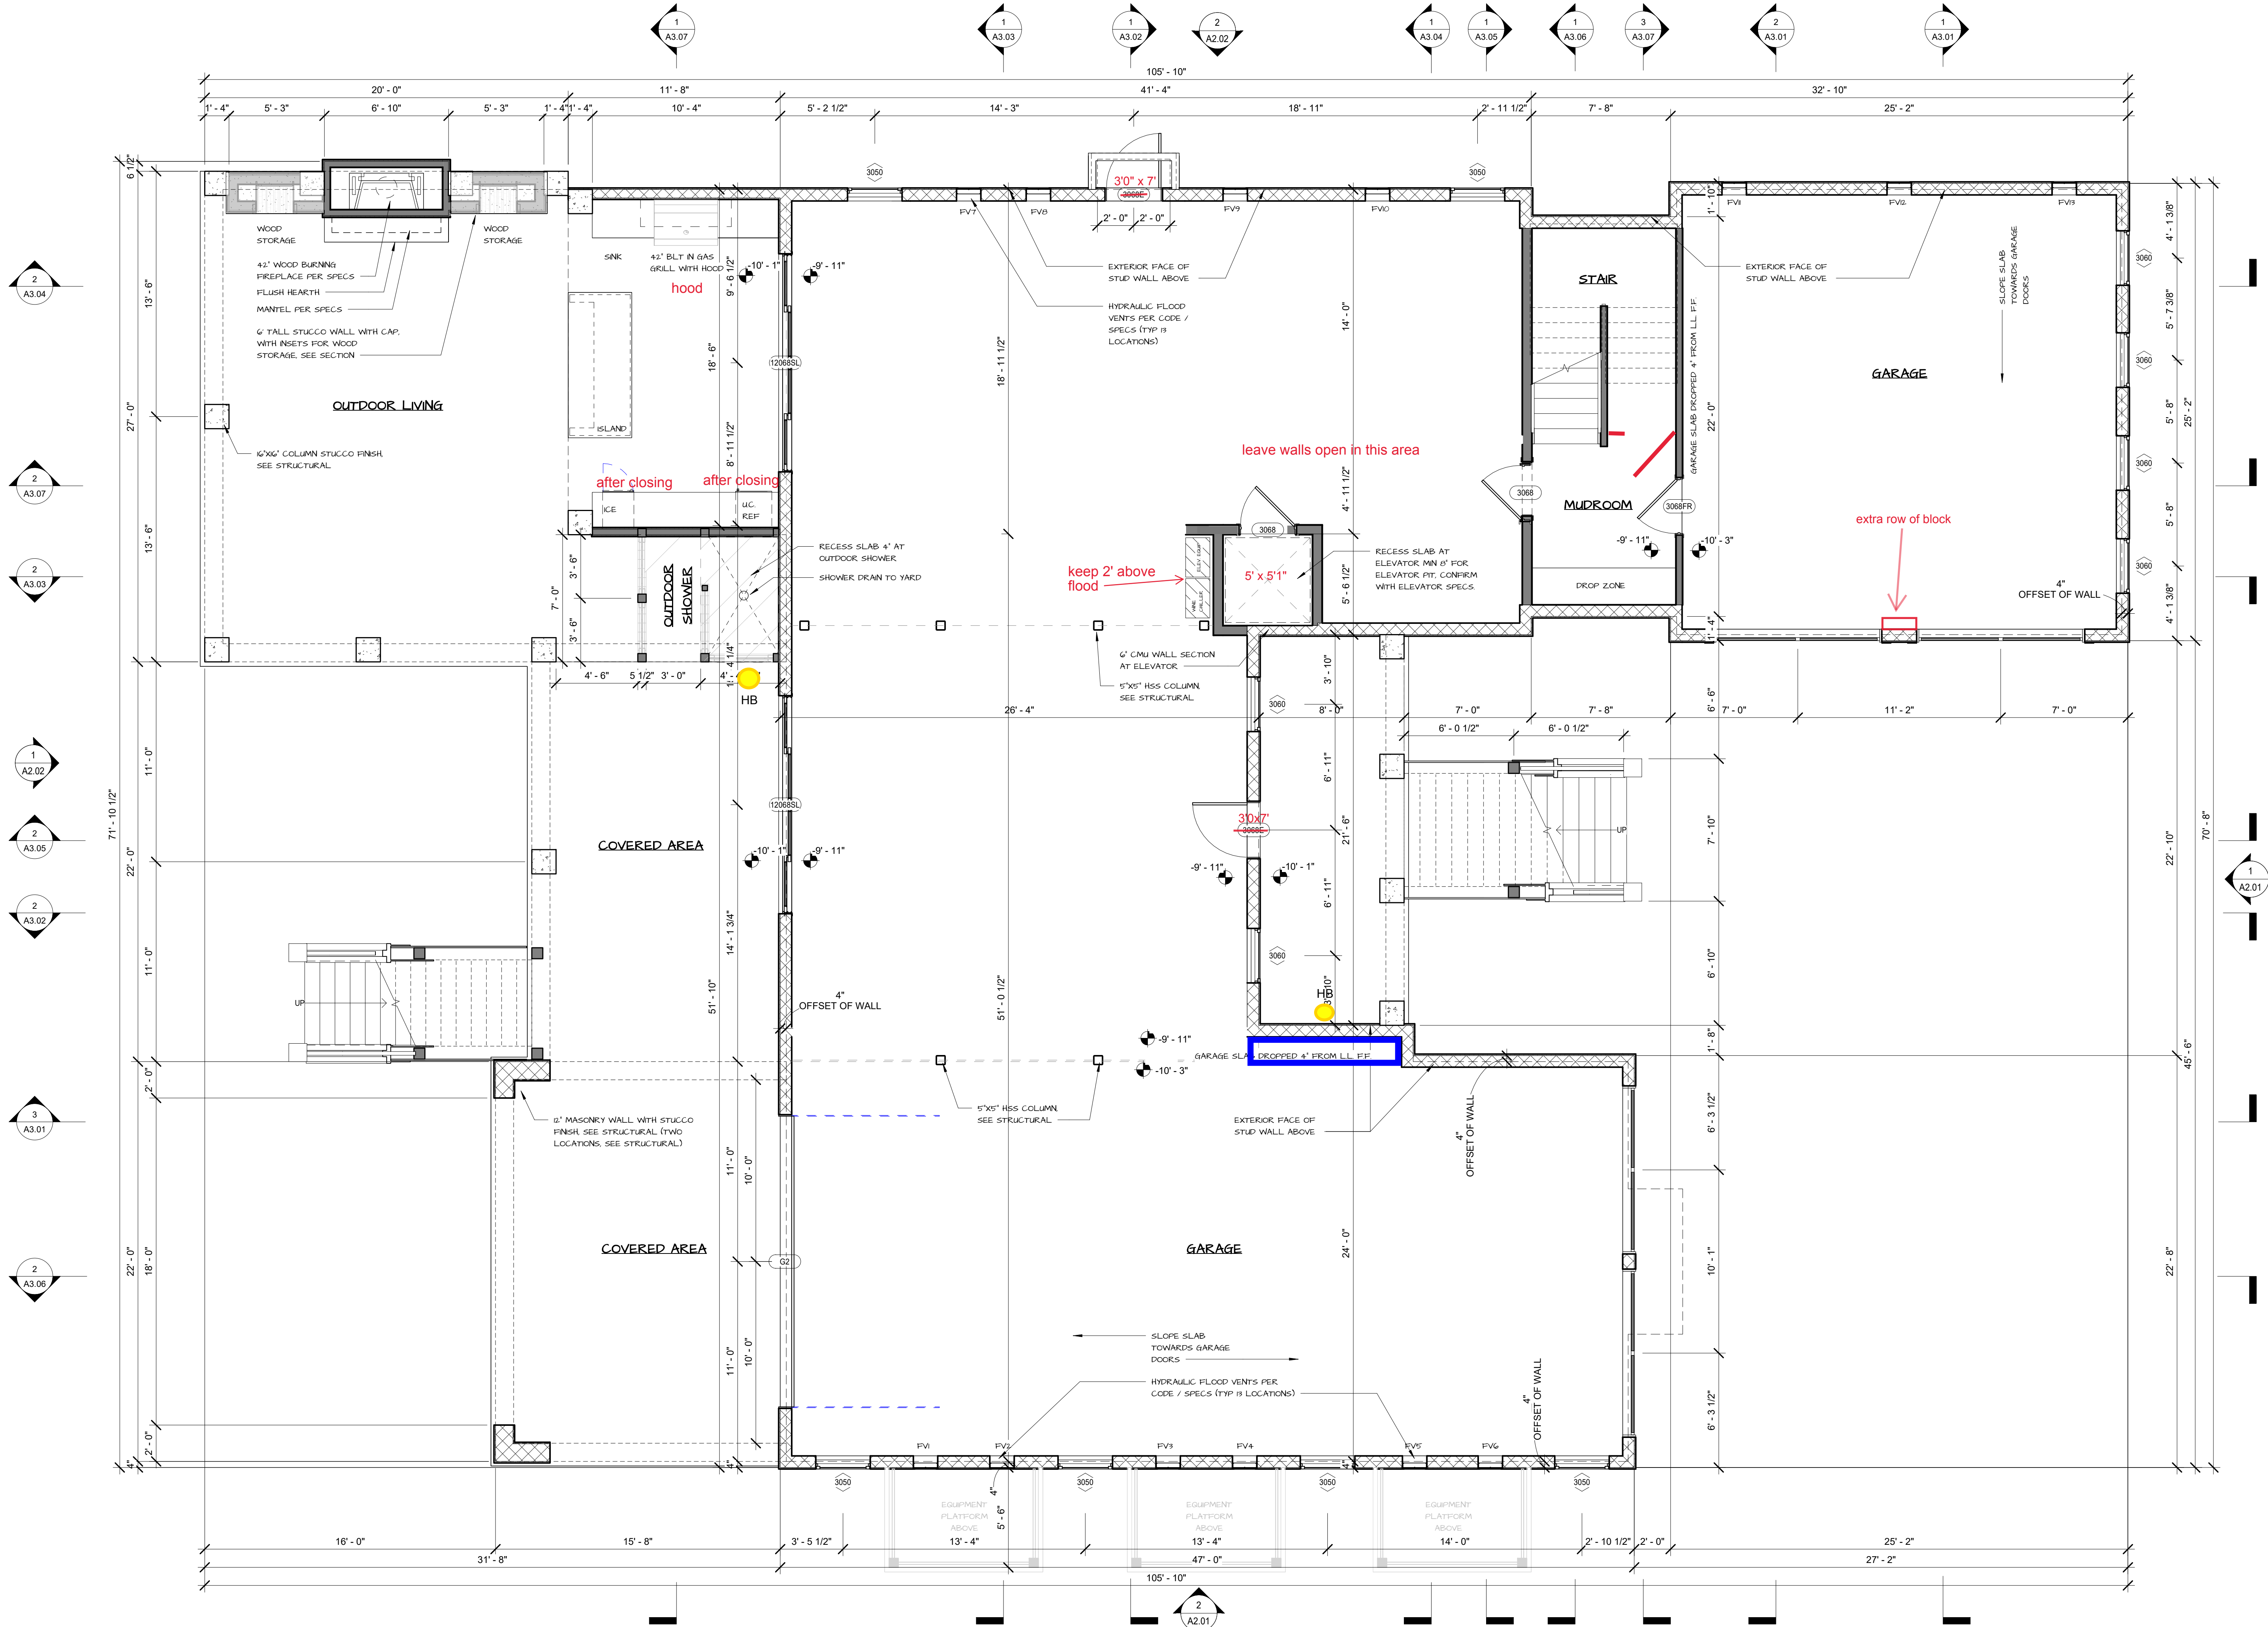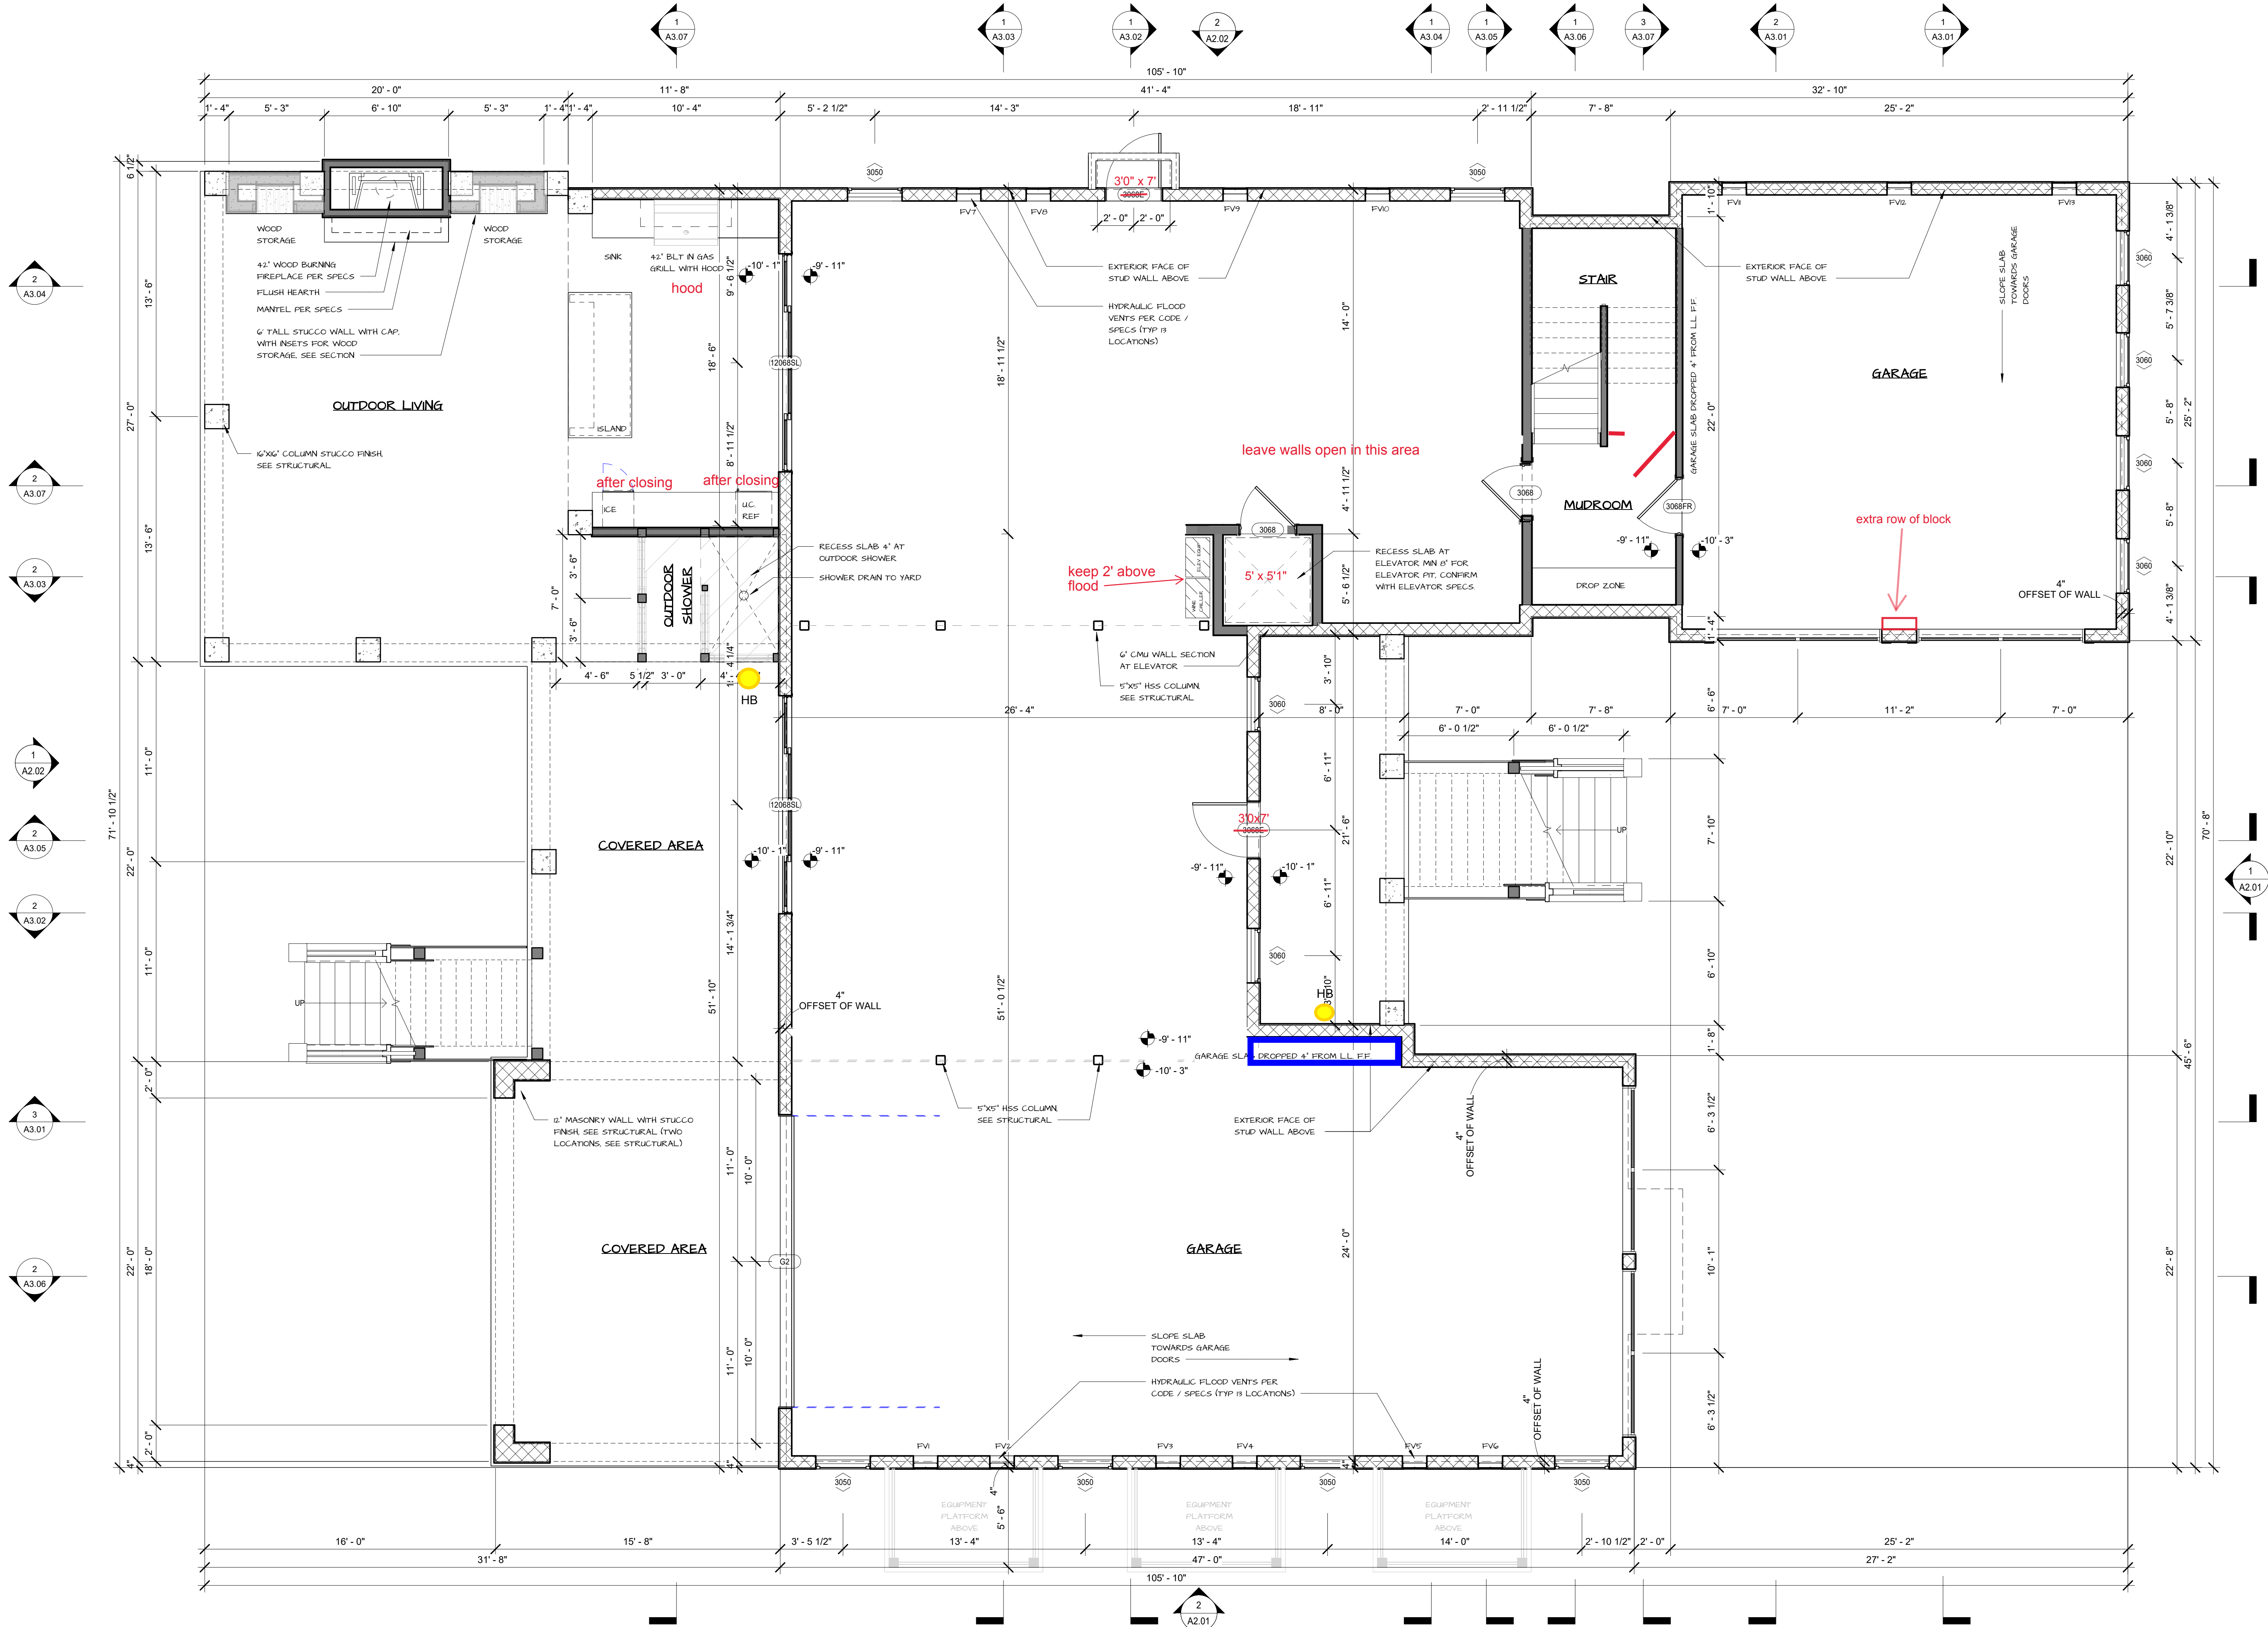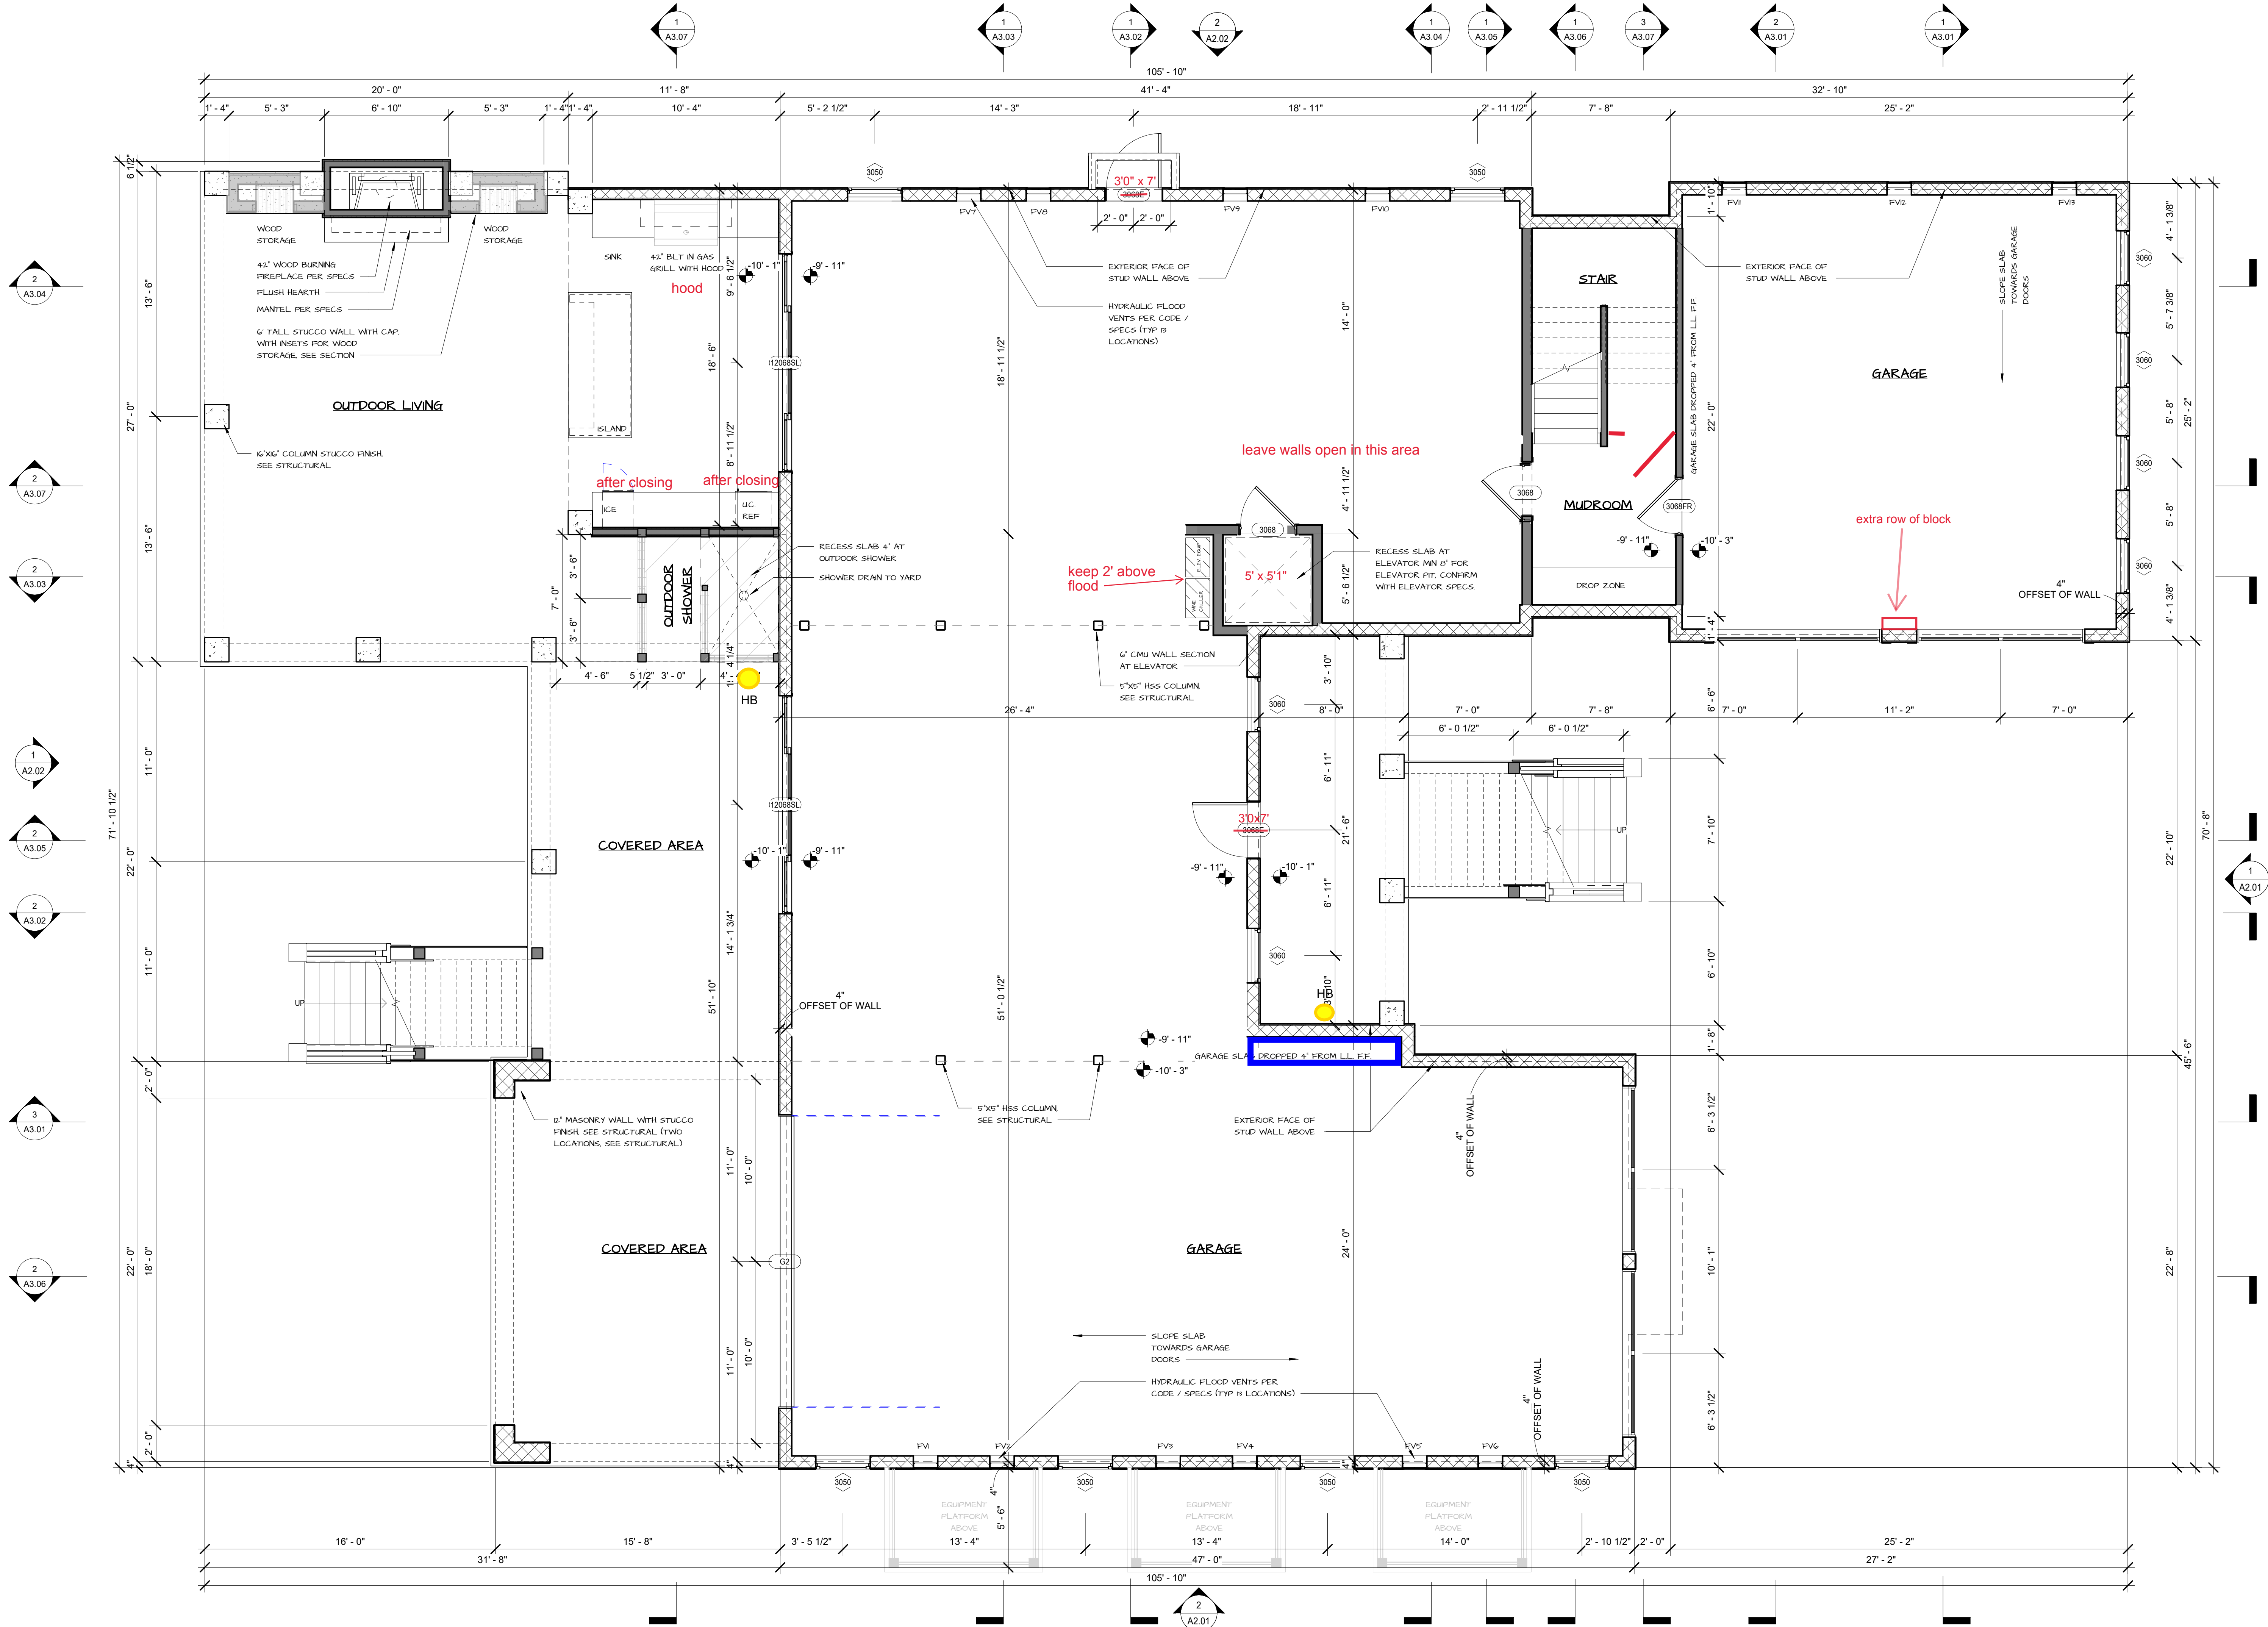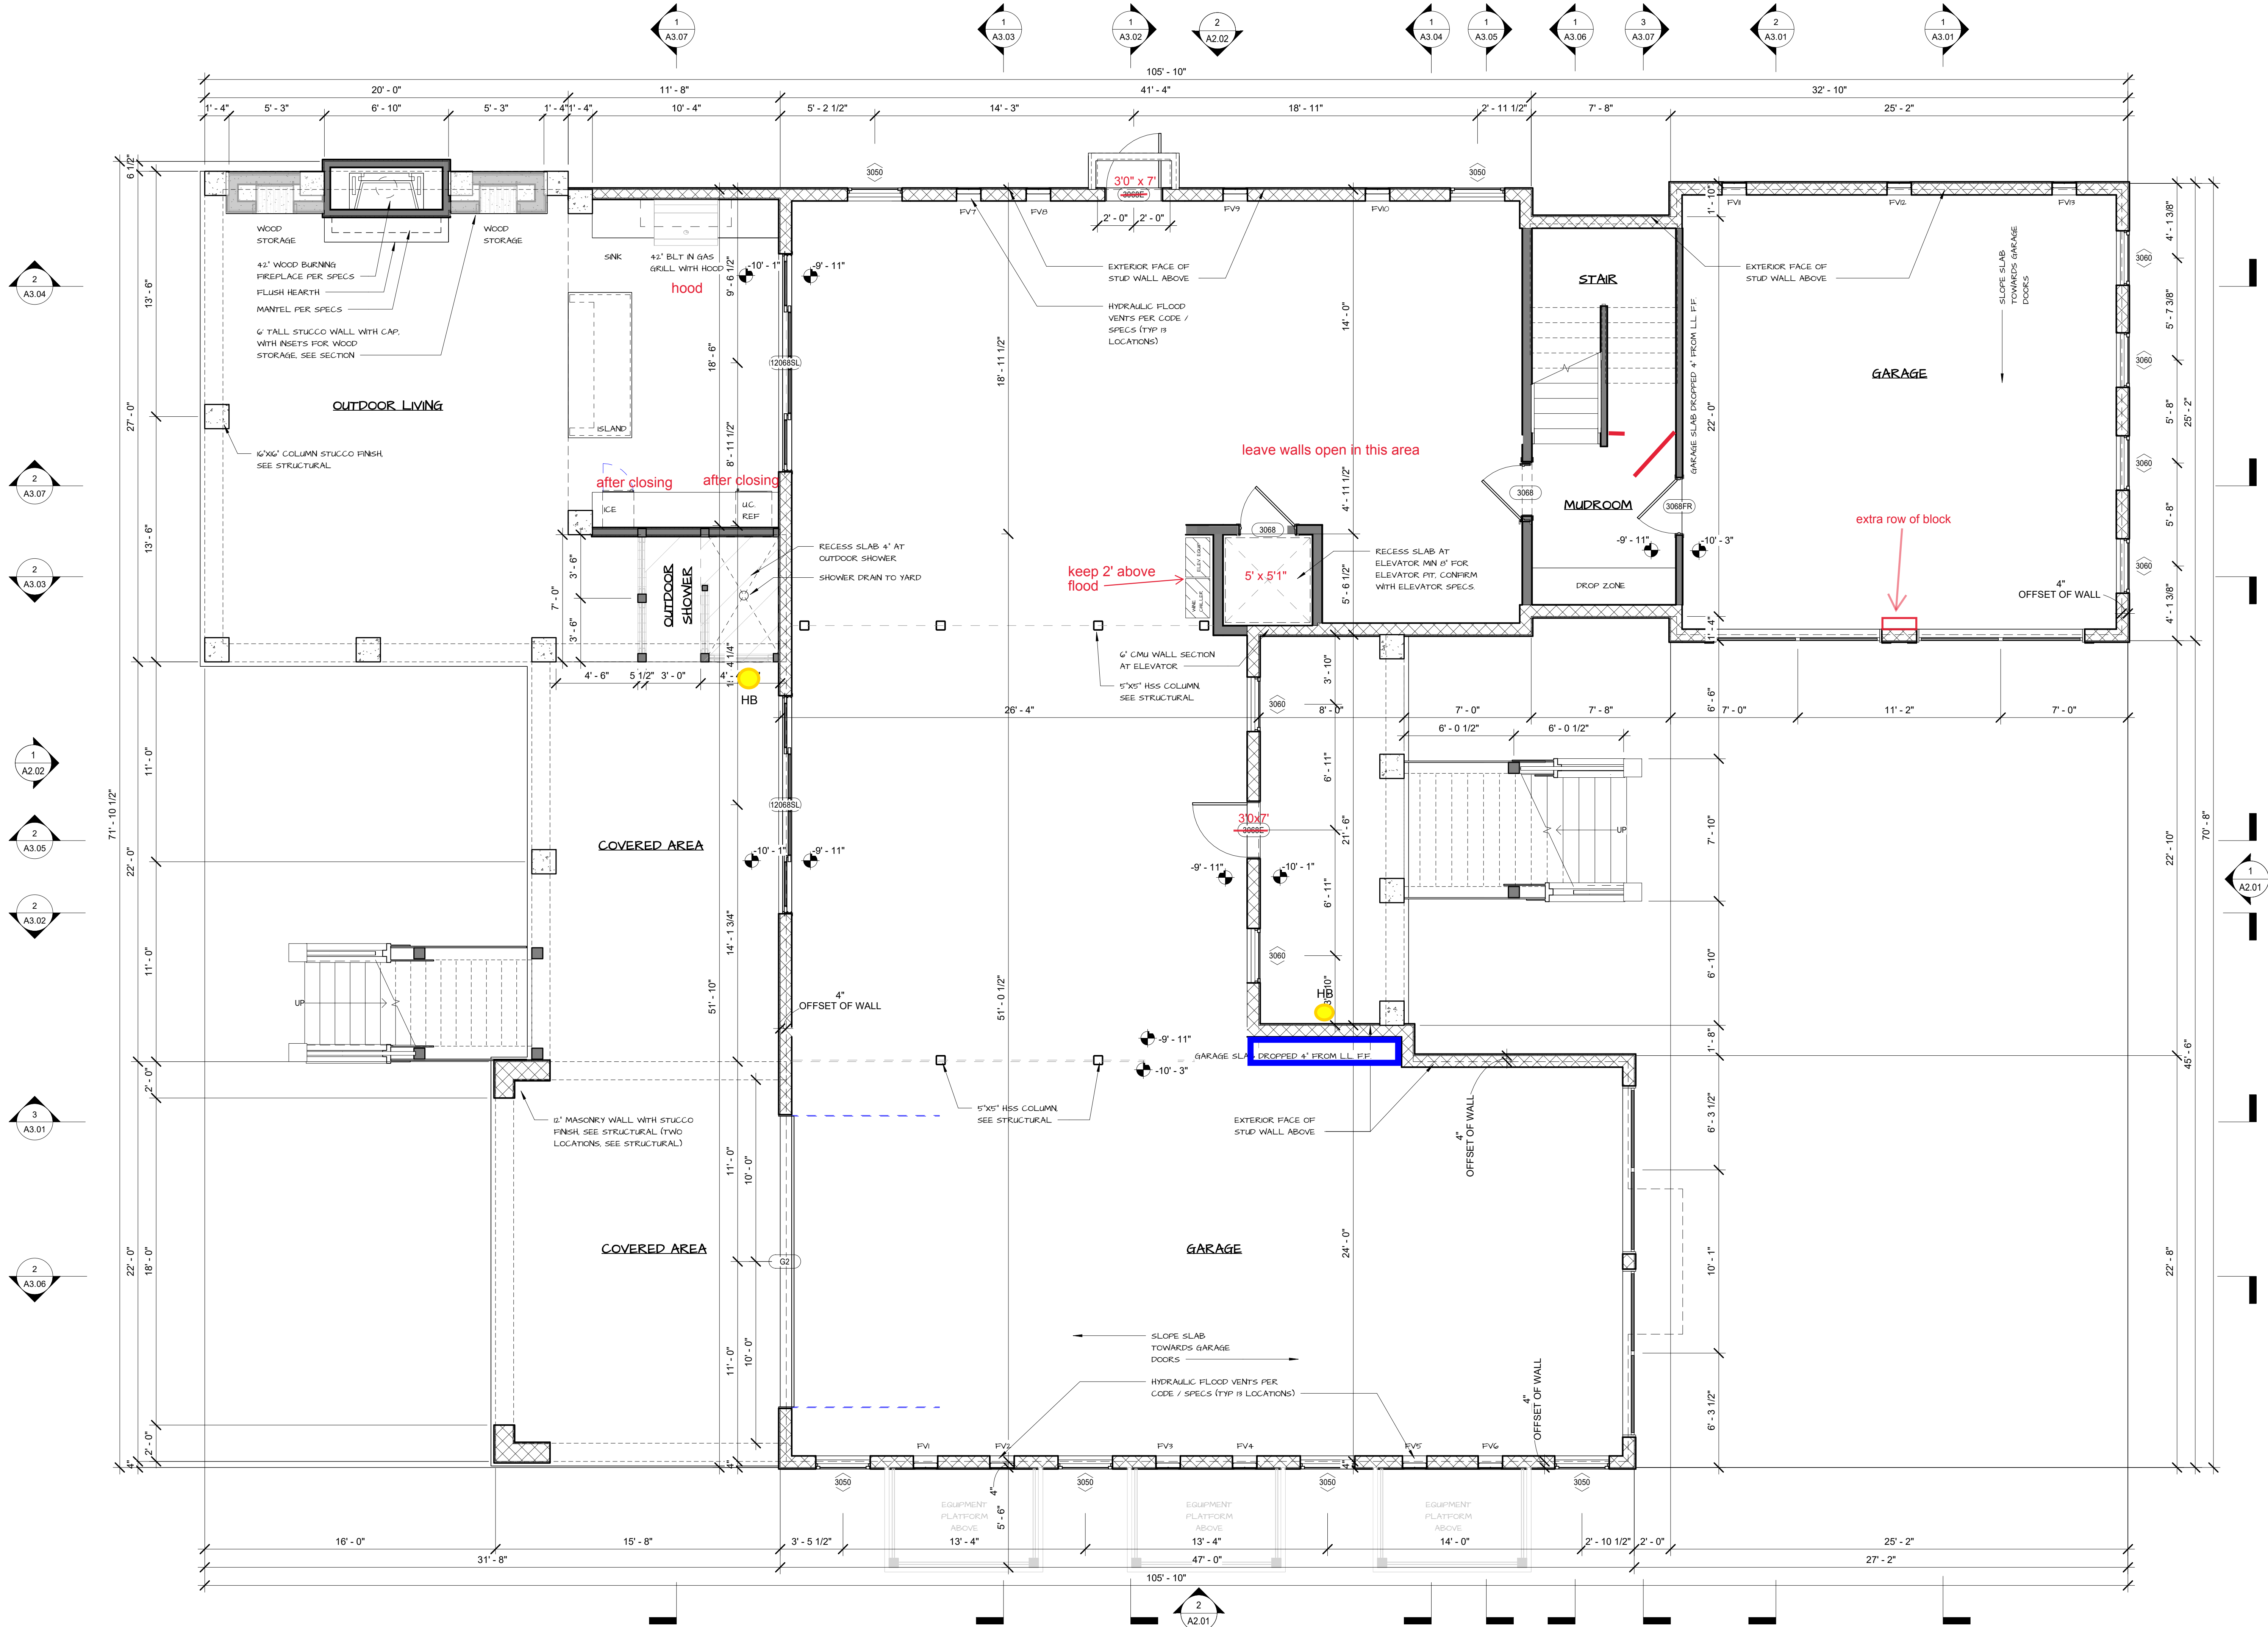

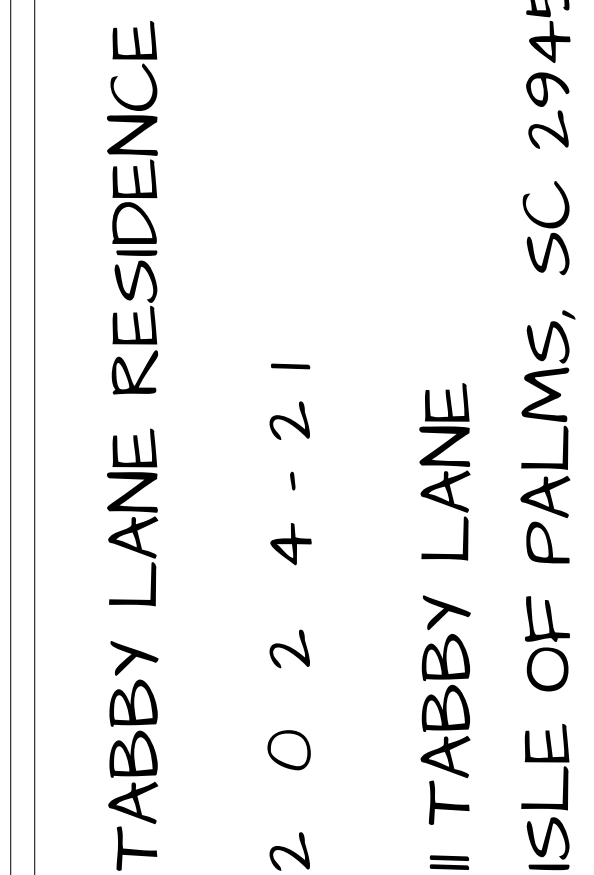 

AI.02

MAIN FLOOR PLAN



WINDOW SCHEDULE				
Type Mark	WIDTH	HEIGHT	TYPE	COMMENTS
2036	2'-0"	3'-6"	CASEMENT	
2650	2'-6"	5'-0"	CASEMENT	
2850	2'-8"	5'-0"	CASEMENT	
2860	2'-8"	6'-0"	CASEMENT	
3030	3'-0"	3'-0"	CASEMENT	
3050	3'-0"	5'-0"	CASEMENT	
3060	3'-0"	6'-0"	CASEMENT	
3080	3'-0"	8'-0"	CASEMENT	
3646AW	3'-6"	4'-6"	AWNING	BAR WINDOW
4046	4'-0"	4'-6"	CASEMENT	
4050	4'-0"	5'-0"	CASEMENT	
4060	4'-0"	6'-0"	CASEMENT	
4080	4'-0"	8'-0"	CASEMENT	
4880	4'-8"	8'-0"	CASEMENT	