
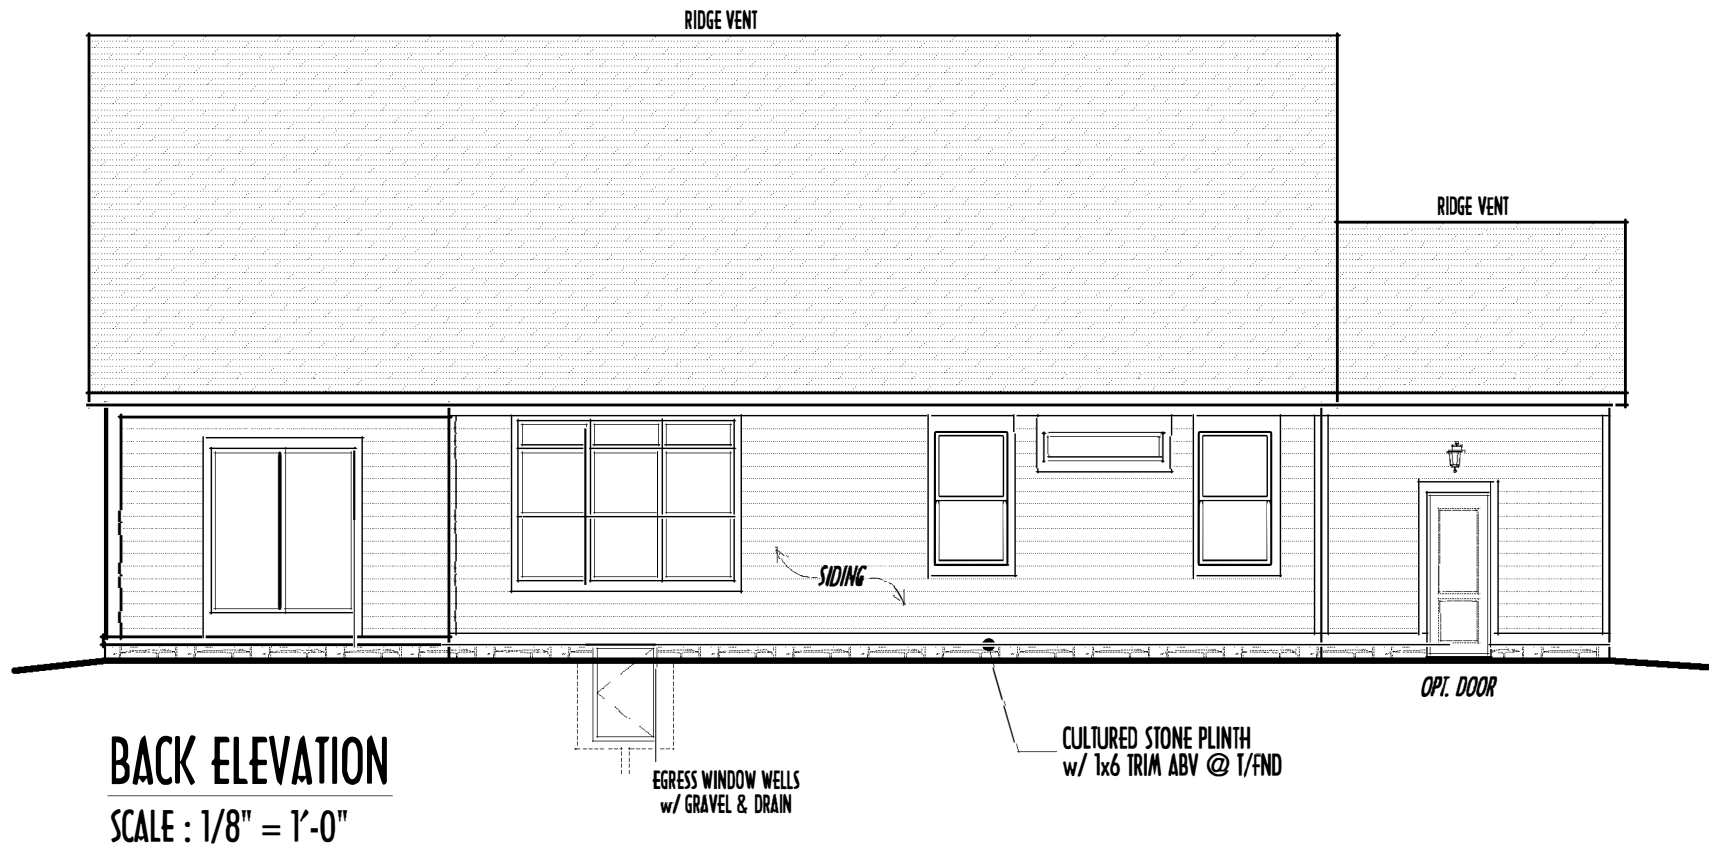


FIRST FLOOR CEILINGS @ 9'-1 1/8" UNLESS NOTED OTHERWISE
FIRST FLOOR WINDOW HEADERS @ 7'-6" UNLESS NOTED OTHERWISE
SECOND FLOOR CEILINGS @ 8'-1 1/8" UNLESS NOTED OTHERWISE
SECOND FLOOR WINDOW HEADERS @ 6'-10" UNLESS NOTED OTHERWISE
EMERGENCY EGRESS OPERABLE (E.E.O.) WINDOWS IN ALL BEDROOMS
SEE ROOF PLAN FOR SOFFIT & RAKE SIZES
RUN BRICK VENEER 1" PAST FRAMING CORNERS
CULTURED STONE VENEER WRAPS FRONT CORNERS MIN 6" INTO 1X6 WOOD TRIM UNLESS NOTED
FLASH & CAULK ELEVATIONS AS NECESSARY TO PROVIDE A WEATHER-TIGHT SEAL BETWEEN MATERIALS, FRAMING & TRIM
WINDOWS & DOORS (BRAND & DESIGN) PER CONTRACT
WINDOWS & DOORS ARE TO BE INSTALLED PER MANUFACTURERS SPECIFICATIONS CONFORM WINDOW SIZES & ROUGH-OPENINGS WITH SUPPLIER
RUN STUCCO, STONE & BRICK VENEER TO GRADE UNLESS NOTED
WEEP SCREDS FOR STUCCO EXTERIORS SHALL COMPLY WITH R-703.6.2.1 (#26 GALV CORROSION-RESISTANT SCREW AT/ABV FOUNDATION PLATE (3.5" FLANGE) PLACED AT MIN 4" ABV EARTH / 2" ABV PAVING, ALLOWING TRAP'D WATER TO DRAIN)
SLOPE GRADE AWAY FROM FOUNDATION FOR PROPER DRAINAGE

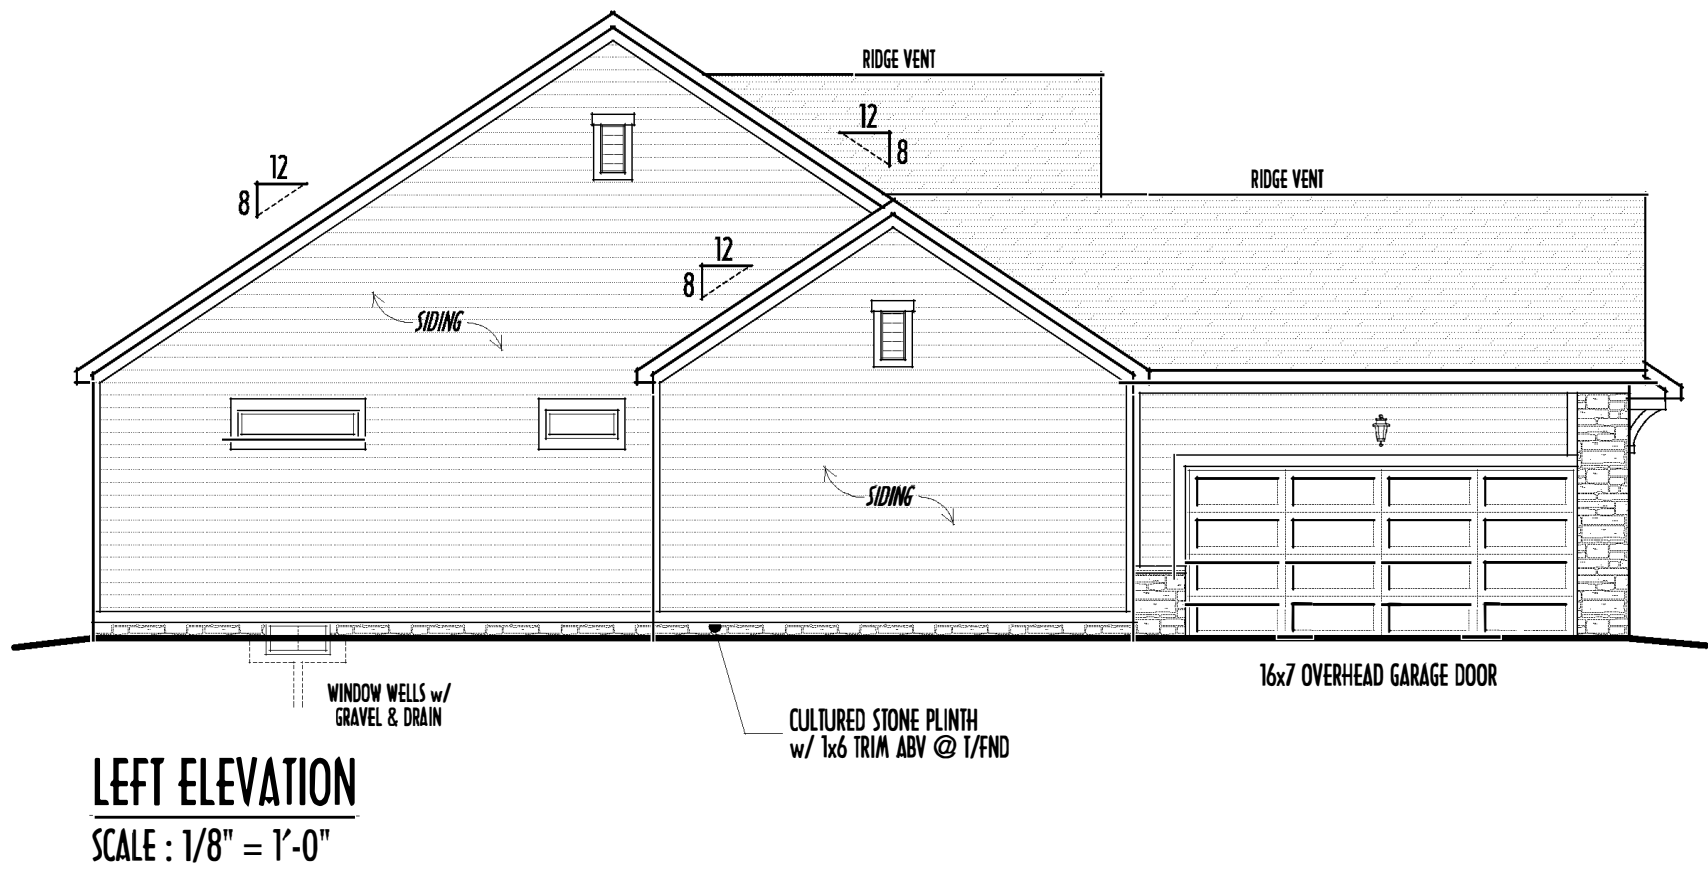

- DIMENSIONAL SHINGLES
- FAUX STONE VENEER
- HORIZ. LAP HARDPLANK C.B. SIDING
- BOARD & BATTEN SIDING

PRELIMINARY DESIGN
NOT TO SCALE - NOT FOR CONSTRUCTION

P&D Builders Ltd.
59 Greif Parkway Suite 100
Delaware, Ohio 43015
(740) 201-8079
Fax (740) 201-8084
www.pndbuilders.com

ALL DESIGNS ARE THE EXCLUSIVE PROPERTY OF P&D BUILDERS LTD.
NO REPRODUCTION OR USE OF THESE PLANS OR ANY PART THEREOF WITHOUT WRITTEN CONSENT BY THE HOLDER OF THE PLANS.

1361

RONALD W. DANNE
1717085
RONALD W. DANNE LICENSE #1717085
EXPIRATION DATE 12/31/2019

Danne
Residential Design & Drafting
614.207.6266 danneand@gmail.com

REVISION DATE:	BY:	DATE/CD
10/4/18	rwd	concepts
1/8/19	"	prelims
1/17/19	"	prelim rev
1/23/19	"	prelim rev
3/2/19	"	@ QTO

TO SCALE WHEN PRINTED 24x36 - PAPER SIZE 11"
0 4 8 12
FEET
1" = 4'-0"
FULL-SIZE DRAWINGS - DO NOT SCALE PRINTS

DESIGNED BY: **P&D / rwd**

PAGE : **5 of 8**

P&D BUILDERS LTD.
59 Greif Parkway Suite 100
Delaware, Ohio 43015
(740) 201-8079
Fax (740) 201-8084
www.pndbuilders.com


ALL DESIGNS ARE THE EXCLUSIVE PROPERTY OF P&D BUILDERS LTD.
NO REPRODUCTION OR USE OF THESE PLANS WITHOUT WRITTEN
CONSENT FROM P&D BUILDERS LTD. IS PERMITTED.

PRELIMINARY DESIGN
NOT TO SCALE - NOT FOR CONSTRUCTION


STATE OF OHIO
REGISTERED ARCHITECT
RONALD W. DANNE
1717085
RONALD W. DANNE LICENSE #1717085
EXPIRATION DATE 12/31/2019

Danne
Residential Design & Drafting, LLC
614.207.6266 danneand@gmail.com

REVISION DATE:	BY:	DESCRIPTION
10/4/18	rwd	concepts
1/8/19	"	prelims
1/17/19	"	prelim rev
1/23/19	"	prelim rev
3/2/19	"	QTO

 


DESIGNED BY: P&D / rwd

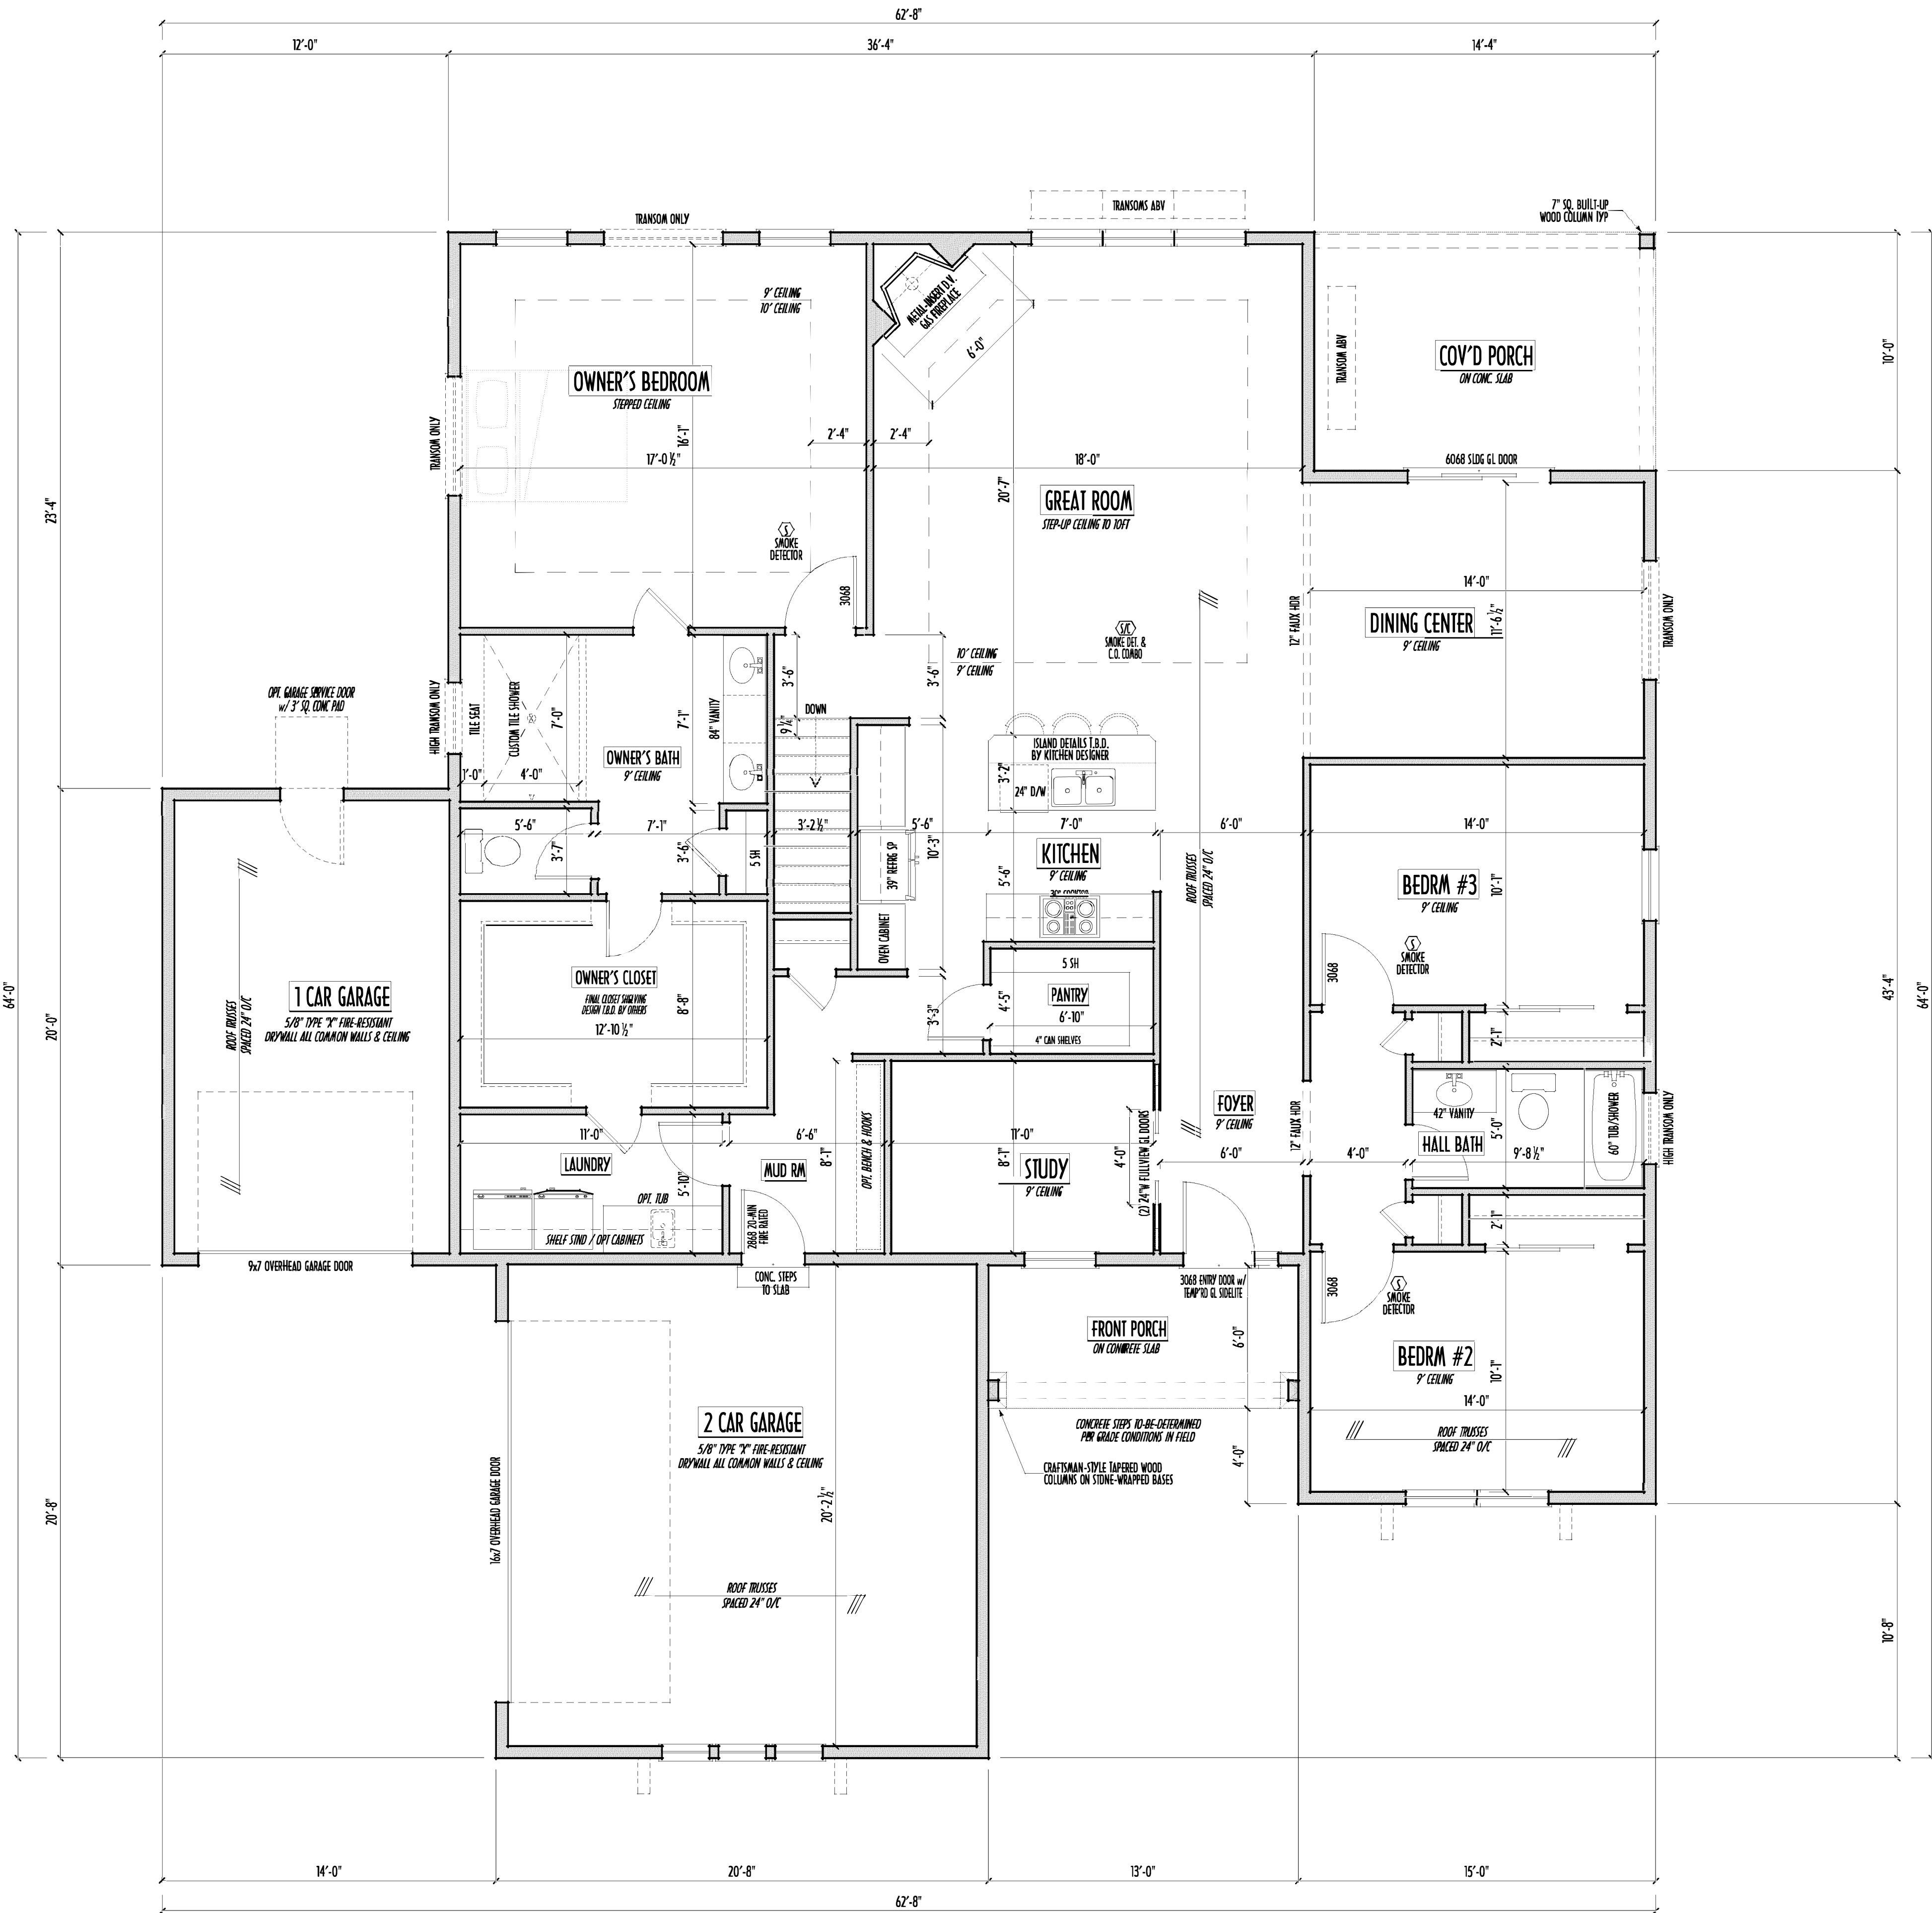

FIRST FLOOR CEILINGS AT 9'-1 1/8" UNLESS NOTED OTHERWISE
FIRST FLOOR WINDOWS HEADERS AT 7'-6" UNLESS NOTED OTHERWISE
CONTRACTORS TO SITE VERIFY ALL DIMENSIONS AND REPORT ANY DISCREPANCIES WITH THE PLANS TO THE JOB SUPERVISOR ASAP
FIRST FLOOR DESIGN LIVE LOAD = 40 PSF
ALL FRAMING AND STRUCTURAL CONSTRUCTION IS TO CONFORM TO 2013 I.C.C. AND/OR APPLICABLE LOCAL CODES
WINDOWS & DOORS (BRAND & DESIGN) PER CONTRACT
CONFIRM WINDOW ROUGH-OPENINGS AND HEADER HGT'S W/ PROVIDER
CONFIRM FLOORING & FINISH MATERIALS W/ JOB SUPERVISOR (PER CONTRACT)
ALL DIMENSIONS CORRESPOND TO EITHER CENTERLINES OR CORNERS OF WOOD FRAMING LENGTHS AND/OR PENETRATION
AVOID FLOORJOISTS LOCATED DIRECTLY BELOW PLUMBING DRAINS
BLOCK BETWEEN FLOORJOISTS BELOW STRUCTURAL POINTS (CRUSH ZONES)
BRACE FLOORJOISTS AT MIDSPAN PER CODE
INTERIOR DOORS SHOWN 4" OFF CORNERS UNLESS NOTED
NOTE: DIMENSIONS FOR ANGLED WALLS MAY CONTAIN ROUNDING ERRORS OF LESS THAN 1/8" TYPICALLY
FINAL/INSTALLED INSULATION VALUES SHOULD MATCH R-VALUE SHEETS FROM TACOMA ENERGY (CHOICE SHOWN ON THESE PLANS ARE PRELIMINARY/REFERENCE ONLY)
INSTALL ALL LVL & LSL BEAMS WITH LABELS VISIBLE FOR BLDG INSPECTION


FIRST FLOOR PLAN
SCALE: 1/4" = 1'-0"

FIRST FLR LIVING SP = 2,201 SQ.FT.
OPT. FINISHED BSMT = 890 SQ.FT.

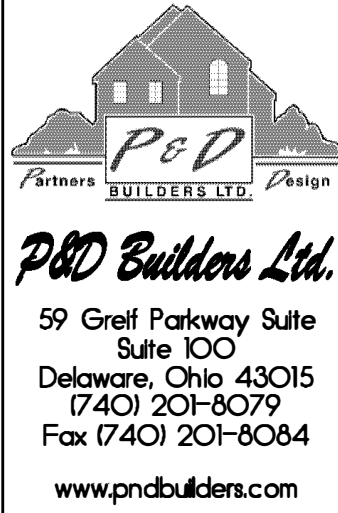


ALL DESIGNS ARE THE EXCLUSIVE PROPERTY OF P&D BUILDERS LTD. NO REPRODUCTION OR COPIES ARE TO BE MADE WITHOUT THE WRITTEN CONSENT OF THE AUTHOR OF THE PLAN.

PRELIMINARY DESIGN
NOT TO SCALE - NOT FOR CONSTRUCTION

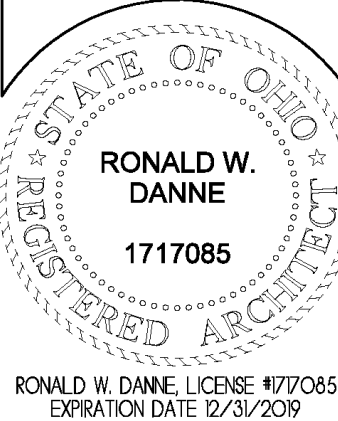


Danne Residential Design & Drafting, Inc.
614.207.6266 danneand@gmail.com

REVISION DATE:	BY:	DATE
10/4/18	rwd	concepts
1/8/19	"	prelims
1/17/19	"	prelim rev
1/23/19	"	prelim rev
3/2/19	"	QTO

 

DESIGNED BY: P&D / rwd

MAX. UNBALANCED FILL FOR 8" THICK POURED CONC. WALL OR C.A.L.L. BLOCK WALL = 7'-0" ABOVE SLAB
WATERPROOFING / DAMPROOFING PER CODE
ALL STRUCTURAL LUMBER IS MIN. CANADIAN SPECIES #2 SPRUCE-PINE-FIR, UNLESS NOTED OTHERWISE
FIRST FLOOR DESIGN LIVE LOAD = 40 PSF
BASEMENT ELECTRICAL LAYOUT FOR REFERENCE ONLY - CONSULT WITH HOMEOWNER PRIOR TO INSTALLATION FOR EXACT LOCATIONS
GRADE MIN. 8" BELOW TOP OF FOUNDATION, SLOPING AWAY FOR PROPER DRAINAGE MIN. 6" DROP IN FIRST 10FT OF RUN
AVOID FLOORJOISTS LOCATED DIRECTLY BELOW PLUMBING DRAINS & TRAPS
BLOCK BETWEEN FLOORJOISTS BELOW STRUCTURAL POINTS (CRUSH ZONES) WITH APPROPRIATE 2X FILL
SEE COVER SHEET FOR GENERAL FOUNDATION CONSTRUCTION NOTES
STEP DOWN FOOTING AS NECESSARY TO REMAIN MIN. 36" BELOW GRADE
USE PRES-TREATED EXTERIOR-GRADE LUMBER WHERE EXPOSED TO WEATHER OR IN CONTACT WITH CONCRETE
FOUNDATION WALL ENGINEERING & REINFORCEMENT PER SHEPHERD EXCAVATING DESIGN-DETAIL RC-16
INSTALL ALL LVL & LSL BEAMS WITH LABELS VISIBLE FOR BLDG INSPECTION

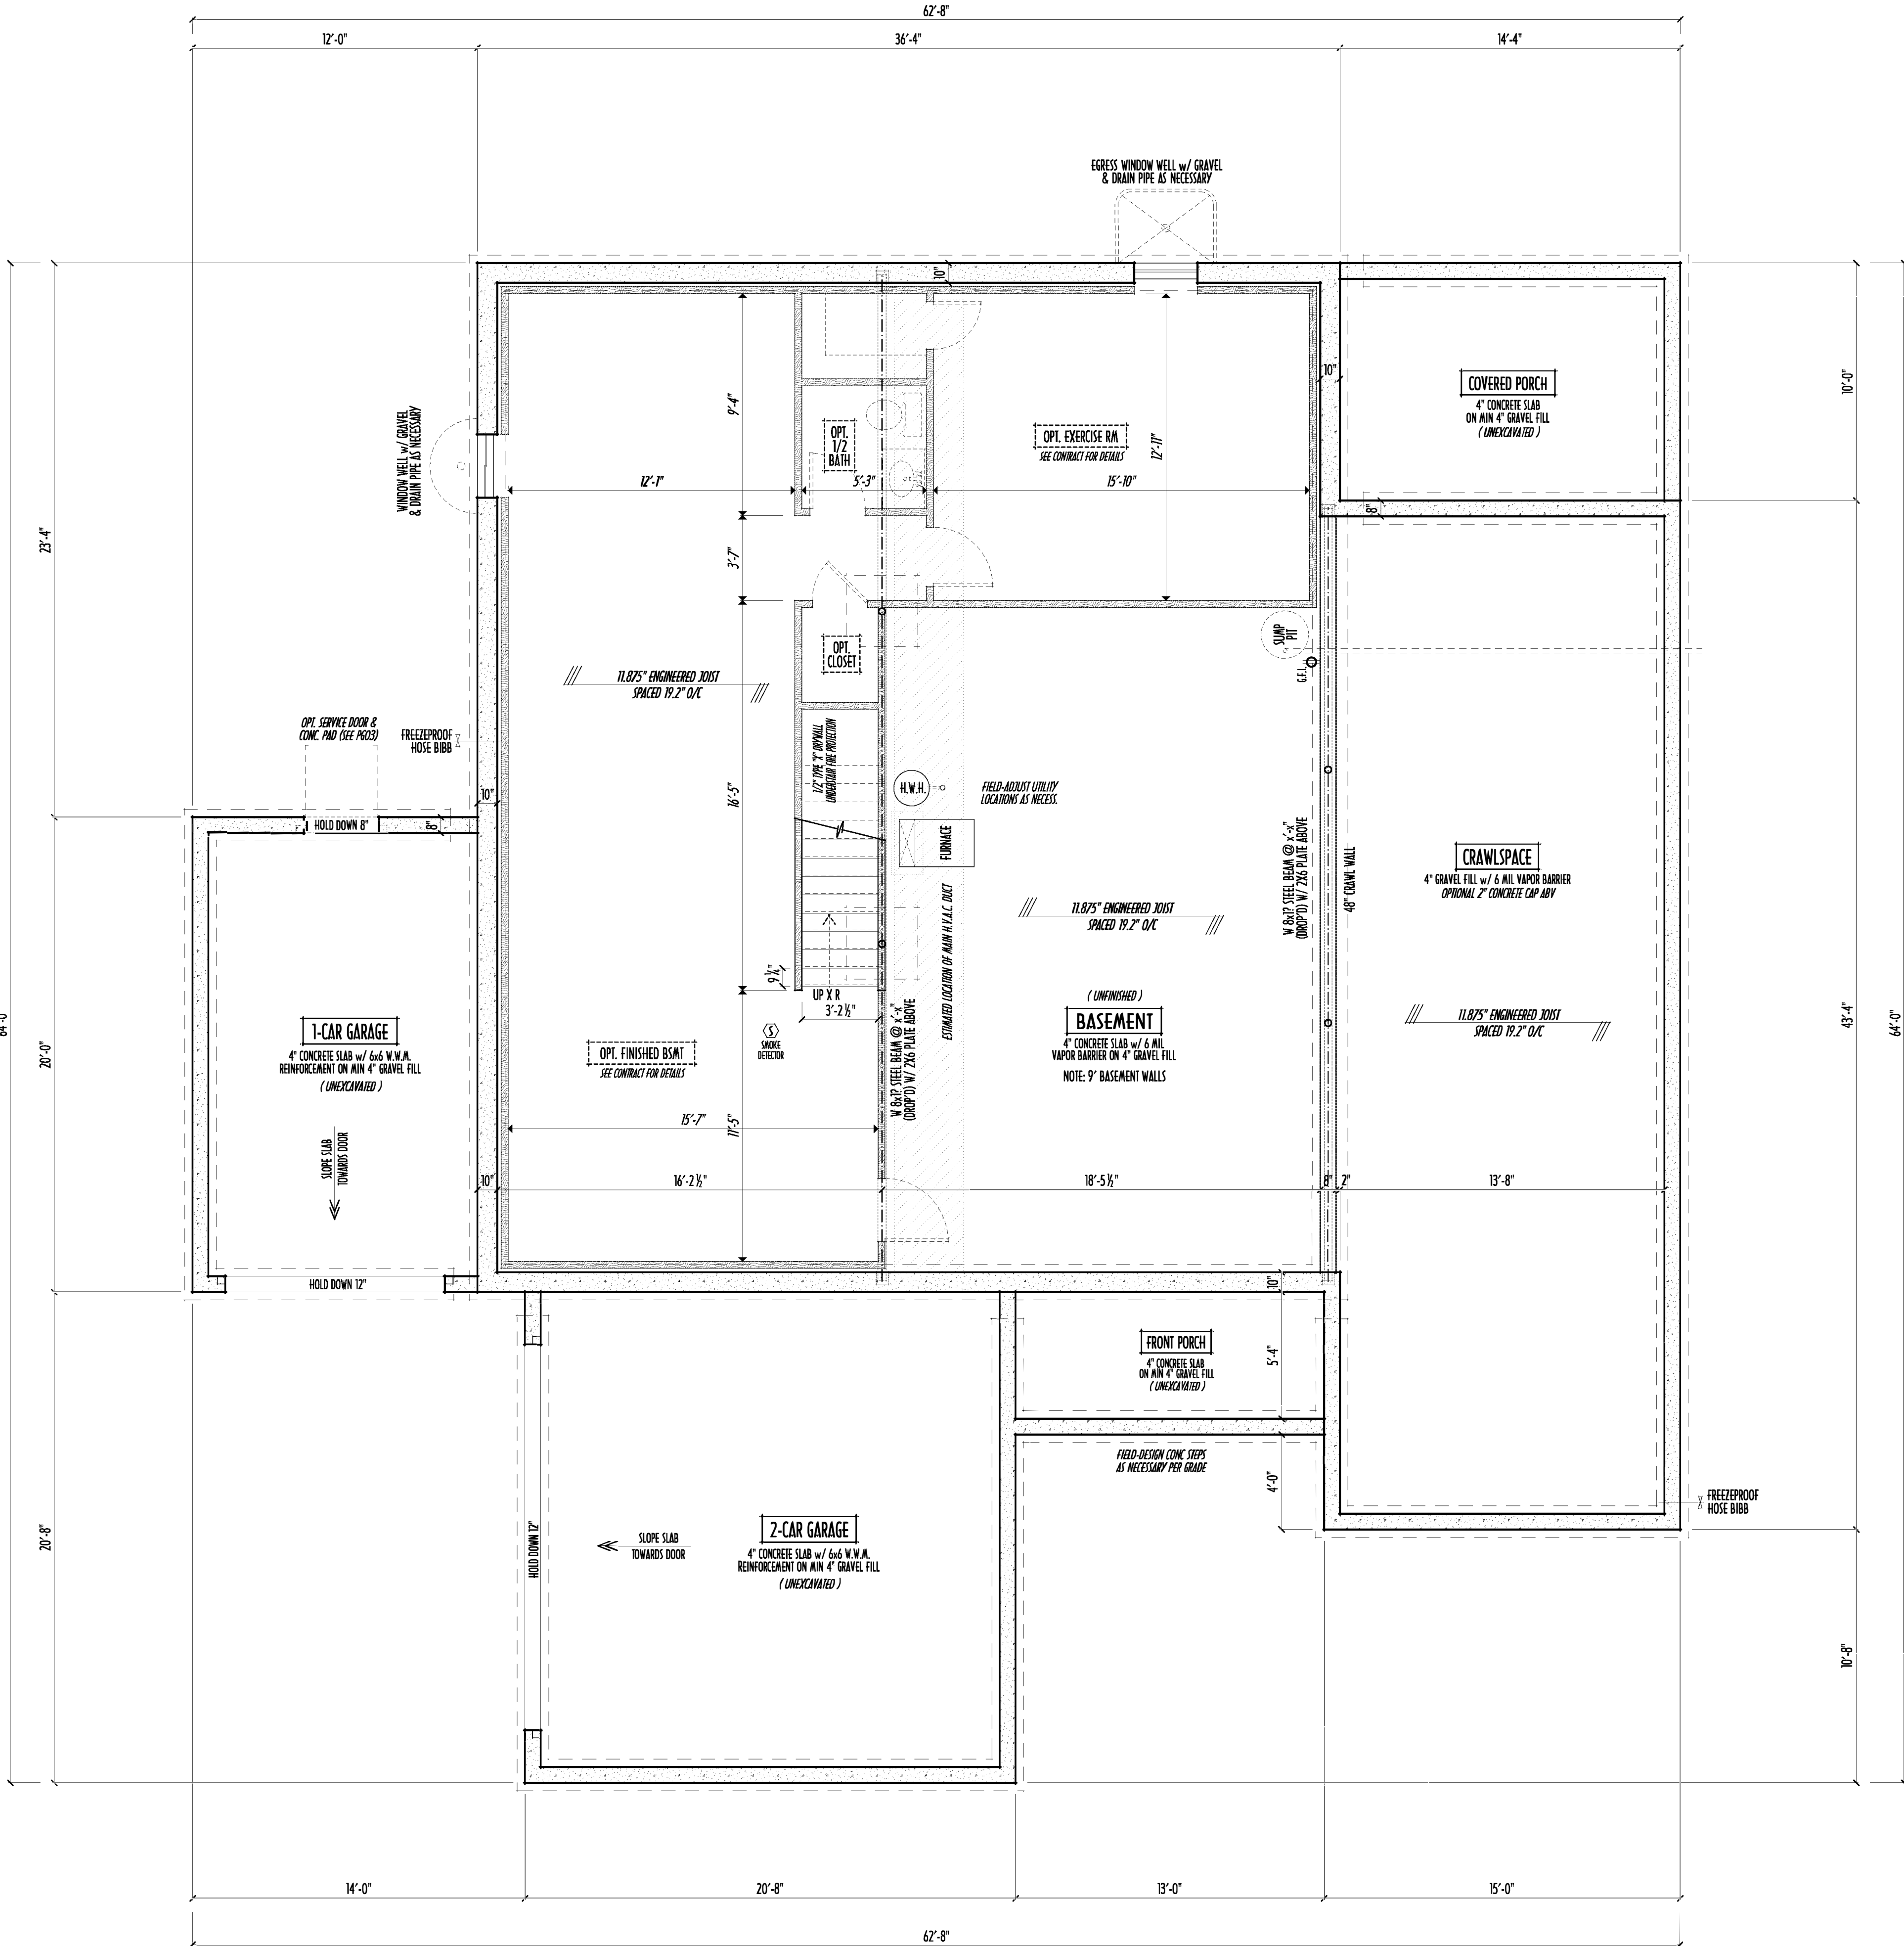

FOUNDATION / BASEMENT PLAN
SCALE: 1/4" = 1'-0"

FIRST FLR LIVING SP = 2,201 SQ.FT.
OPT. FINISHED BSMT = 890 SQ.FT.