
 


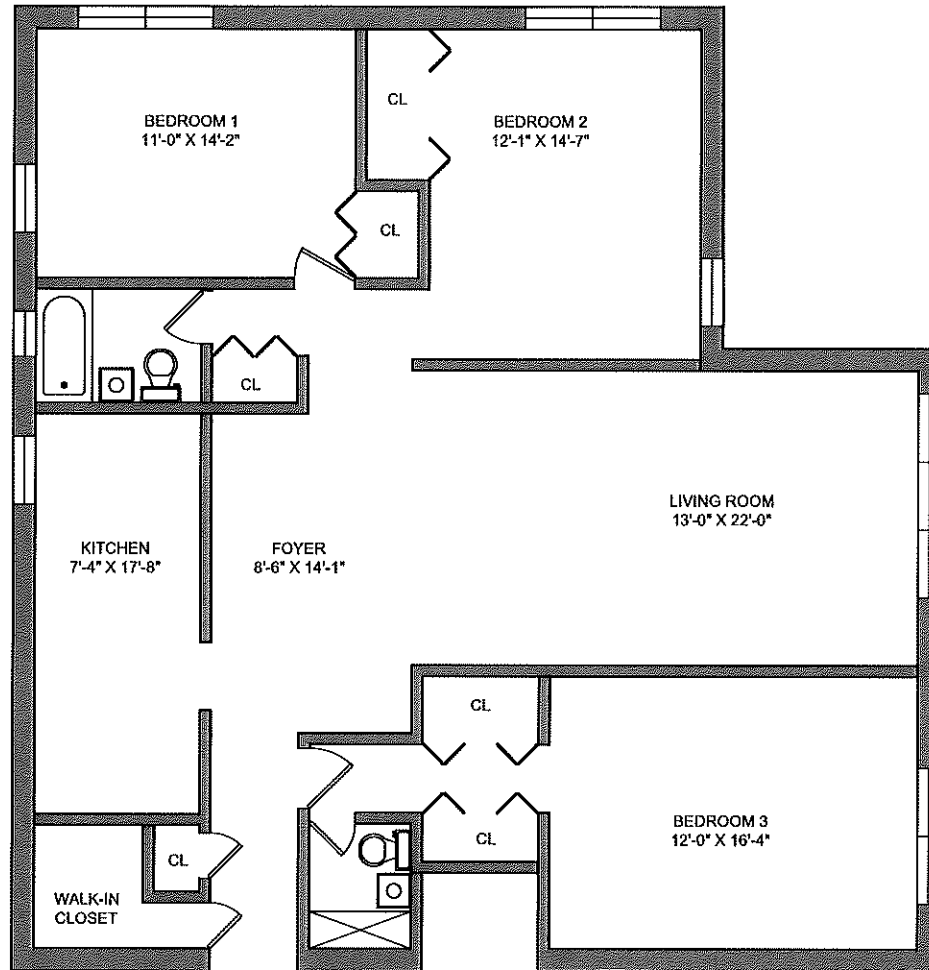

1 **APARTMENT "E" - FLOOR PLAN**
SCALE: 1/8" = 1'-0"



MERRITT
ENGINEERING CONSULTANTS, P.C.
28-08 Bayside Lane
Bayside, NY 11358
Tel 718.767.0923
Fax 718.767.4920
www.merrittengineering.com

PROJECT
KENNEDY ST. QUAD
18-35, 18-55, 18-75
CORPORAL KENNEDY ST.
209-28 23RD AVENUE

DRAWING TITLE
APARTMENT "E"

DATE: 05.01.13
PROJECT No.: 061250
DRAWING BY: M.A.
CHECKED BY: M.C.
DWG No.: **SK-5**
5 of 10