
 


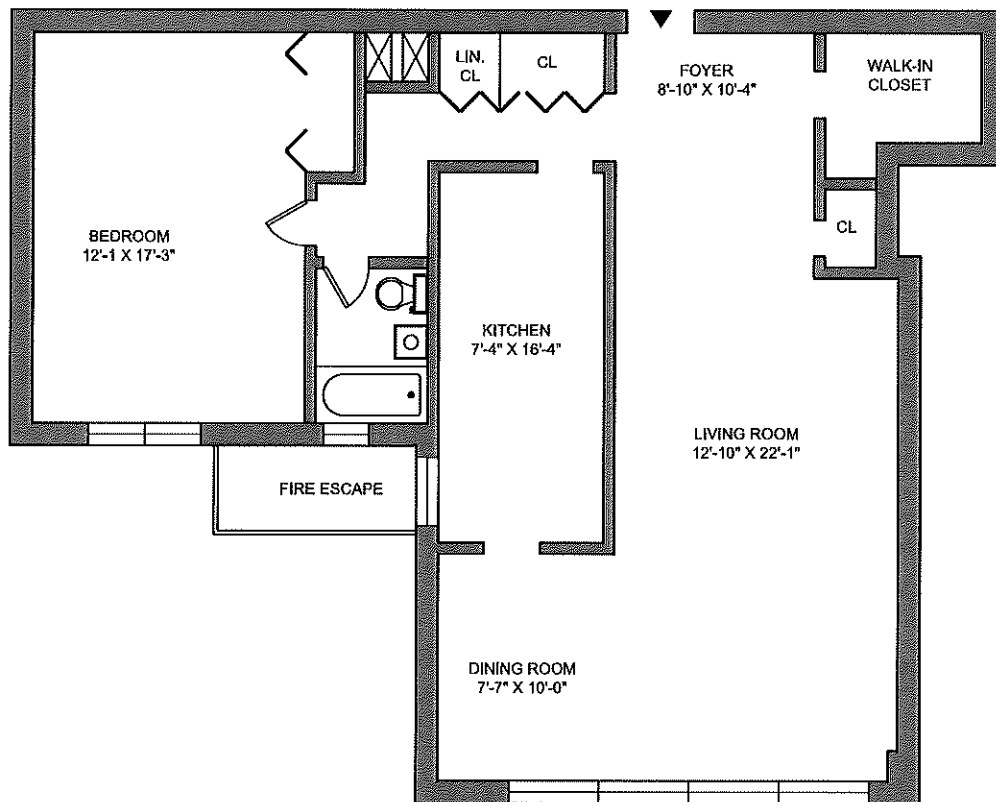


1 APARTMENT "G" - FLOOR PLAN
 SCALE: 1/8" = 1'-0"



MERRITT
 ENGINEERING CONSULTANTS, P.C.
 28-08 Bayside Lane
 Bayside, NY 11358
 Tel 718.767.0923
 Fax 718.767.4920
 www.merrittengineering.com

PROJECT
KENNEDY ST. QUAD
 18-35, 18-55, 18-75
CORPORAL KENNEDY ST.
 209-28 23RD AVENUE

DRAWING TITLE
APARTMENT "G"

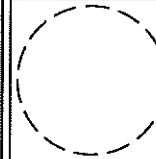

DATE: 05.01.13
 PROJECT No.: 061250
 DRAWING BY: M.A.
 CHECKED BY: M.C.
 DWG No.: **SK-7**
 7 of 10