


PLOT DATE: 6/18/2021 12:27 PM
PLOT SCALE: 1/2"=50'
DRAWING FILE: P:\2019\02062\4 drawings\Civil\Construction documents\Building 15\2019.02062 CE C400.dwg
EDITED BY: JRODGERS
DATE: 6/18/2021

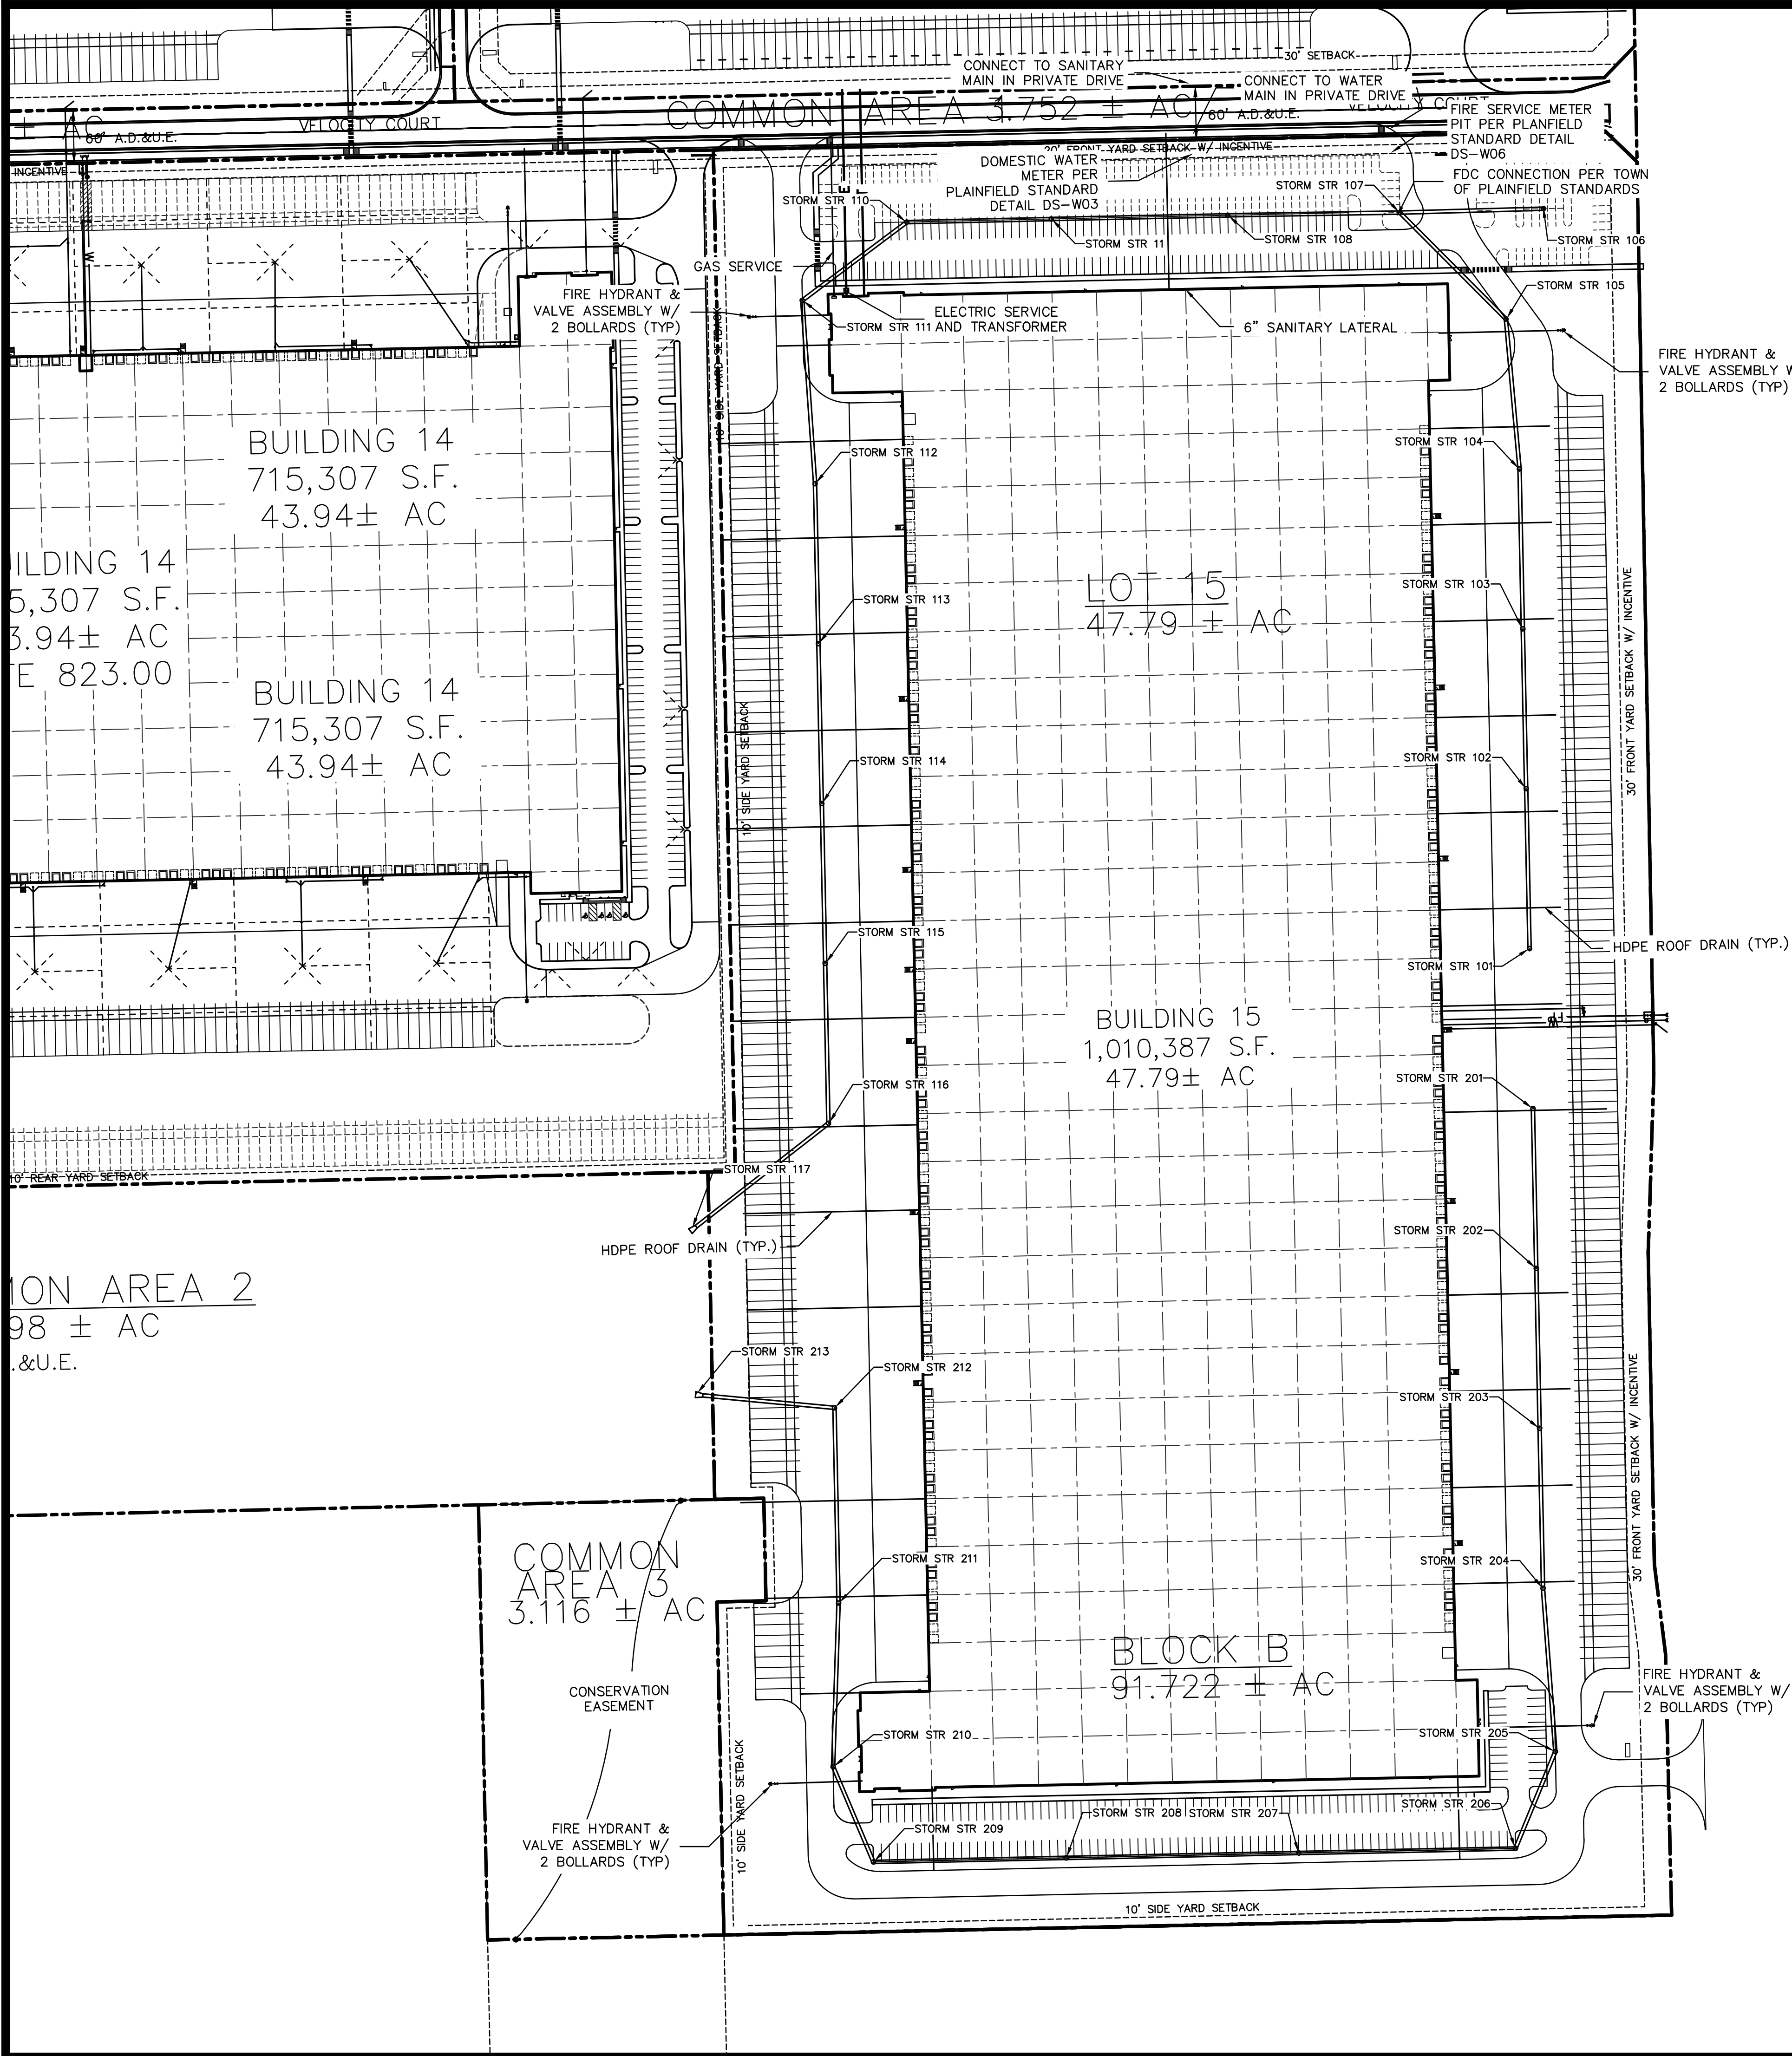

EXISTING LEGEND

BEEHIVE INLET	PINE
BUSH	POST
CURB INLET	POWER POLE
COMBINATION POLE	SIGN
DELINEATOR	SANITARY MANHOLE
DRAINAGE MANHOLE	STAND PIPE
ELECTRIC HANDHOLE	STUMP
ELECTRIC METER BOX	TELEPHONE HANDHOLE
FIRE HYDRANT	TELEPHONE POLE
GAS MARKER SIGN	TELEPHONE PEDESTAL
GAS VALVE	TREE
GUY WIRE	VENT

UTILITY LEGEND

ETC	ELECTRIC / TELECOMMUNICATIONS LINE
W	WATER LINE
FP	FIRE PROTECTION LINE
RD	ROOF DRAIN LINE
G	GAS LINE
SS	SANITARY SEWER LINE
	STORM SEWER LINE
	PAVEMENT UNDERDRAIN
	GAS METER
	ELECTRICAL TRANSFORMER
	VALVE
	WATER FITTINGS
	WATER METER PIT
	FIRE HYDRANT W/ ASSEMBLY

UTILITY CONTACTS			
UTILITY	COMPANY	CONTACT	PHONE NO.
CABLE TELEVISION	COMCAST	MICHELLE MINDRUP	(317)-716-4151
ELECTRIC	DUKE ENERGY	YARTO BLEAH	(317)-385-8175
FIBER OPTIC			
GAS	VECTREN	RANDY CRUTCHFIELD	(317)-776-5560
SANITARY SEWER	TOWN OF PLAINFIELD	TIMOTHY BELCHER	(317)-839-2561
STORM SEWER	TOWN OF PLAINFIELD	TIMOTHY BELCHER	(317)-839-2561
TELEPHONE	AT&T	MICHAEL CARTER	(317)-722-2299
WATER	TOWN OF PLAINFIELD	JASON CASTETTER	(317)-839-3490

GENERAL NOTES:

- CONTRACTOR SHALL PROTECT AND NOT DESTROY THE PROPERTY CORNER MONUMENTS DURING CONSTRUCTION.
- CONTRACTOR TO VERIFY LOCATION, SIZE AND DEPTH OF EXISTING UTILITIES PRIOR TO COMMENCING ANY CONSTRUCTION. CONTACT ENGINEER IF VARIATION EXISTS.
- SEE SHEET C002 GENERAL NOTES FOR MORE INFORMATION.

!! CAUTION !!

THE LOCATIONS OF ALL EXISTING UNDERGROUND UTILITIES SHOWN ON THIS PLAN ARE BASED UPON ABOVE GROUND EVIDENCE (including, but not limited to, manholes, inlets, valves, and marks made upon the ground by others) AND ARE SPECULATIVE IN NATURE. THERE MAY ALSO BE OTHER EXISTING UNDERGROUND UTILITIES FOR WHICH THERE IS NO ABOVE GROUND EVIDENCE OR FOR WHICH NO ABOVE GROUND EVIDENCE WAS OBSERVED. THE EXACT LOCATIONS OF SAID EXISTING UNDERGROUND UTILITIES SHALL BE VERIFIED BY THE CONTRACTOR PRIOR TO ANY AND ALL CONSTRUCTION.

CALL TOLL FREE
"811" OR 1-800-382-5544
- INDIANA UNDERGROUND -

Revisions:

Scale:	Date:	Drawn By:	Checked By:
	06/18/21	PD	NW

ALLPOINTS MIDWEST BUILDING 15
C.R. 100 S & SMITH ROAD
PLAINFIELD, INDIANA
OVERALL UTILITY PLAN

Certified By:

APPROVAL PENDING
NOT FOR CONSTRUCTION

Drawing Number:

C400
Of Sheets

Browning/Duke Job Number:

APM 15

A/E Job Number:

2019.02062