


This document, together with the concepts and designs presented herein, as an instrument of service, is intended only for the specific purpose and client for which it was prepared. Reuse of and improper reliance on this document without written authorization and adaptation by Kinney-Horn and Associates, Inc. shall be without liability to Kinney-Horn and Associates, Inc.

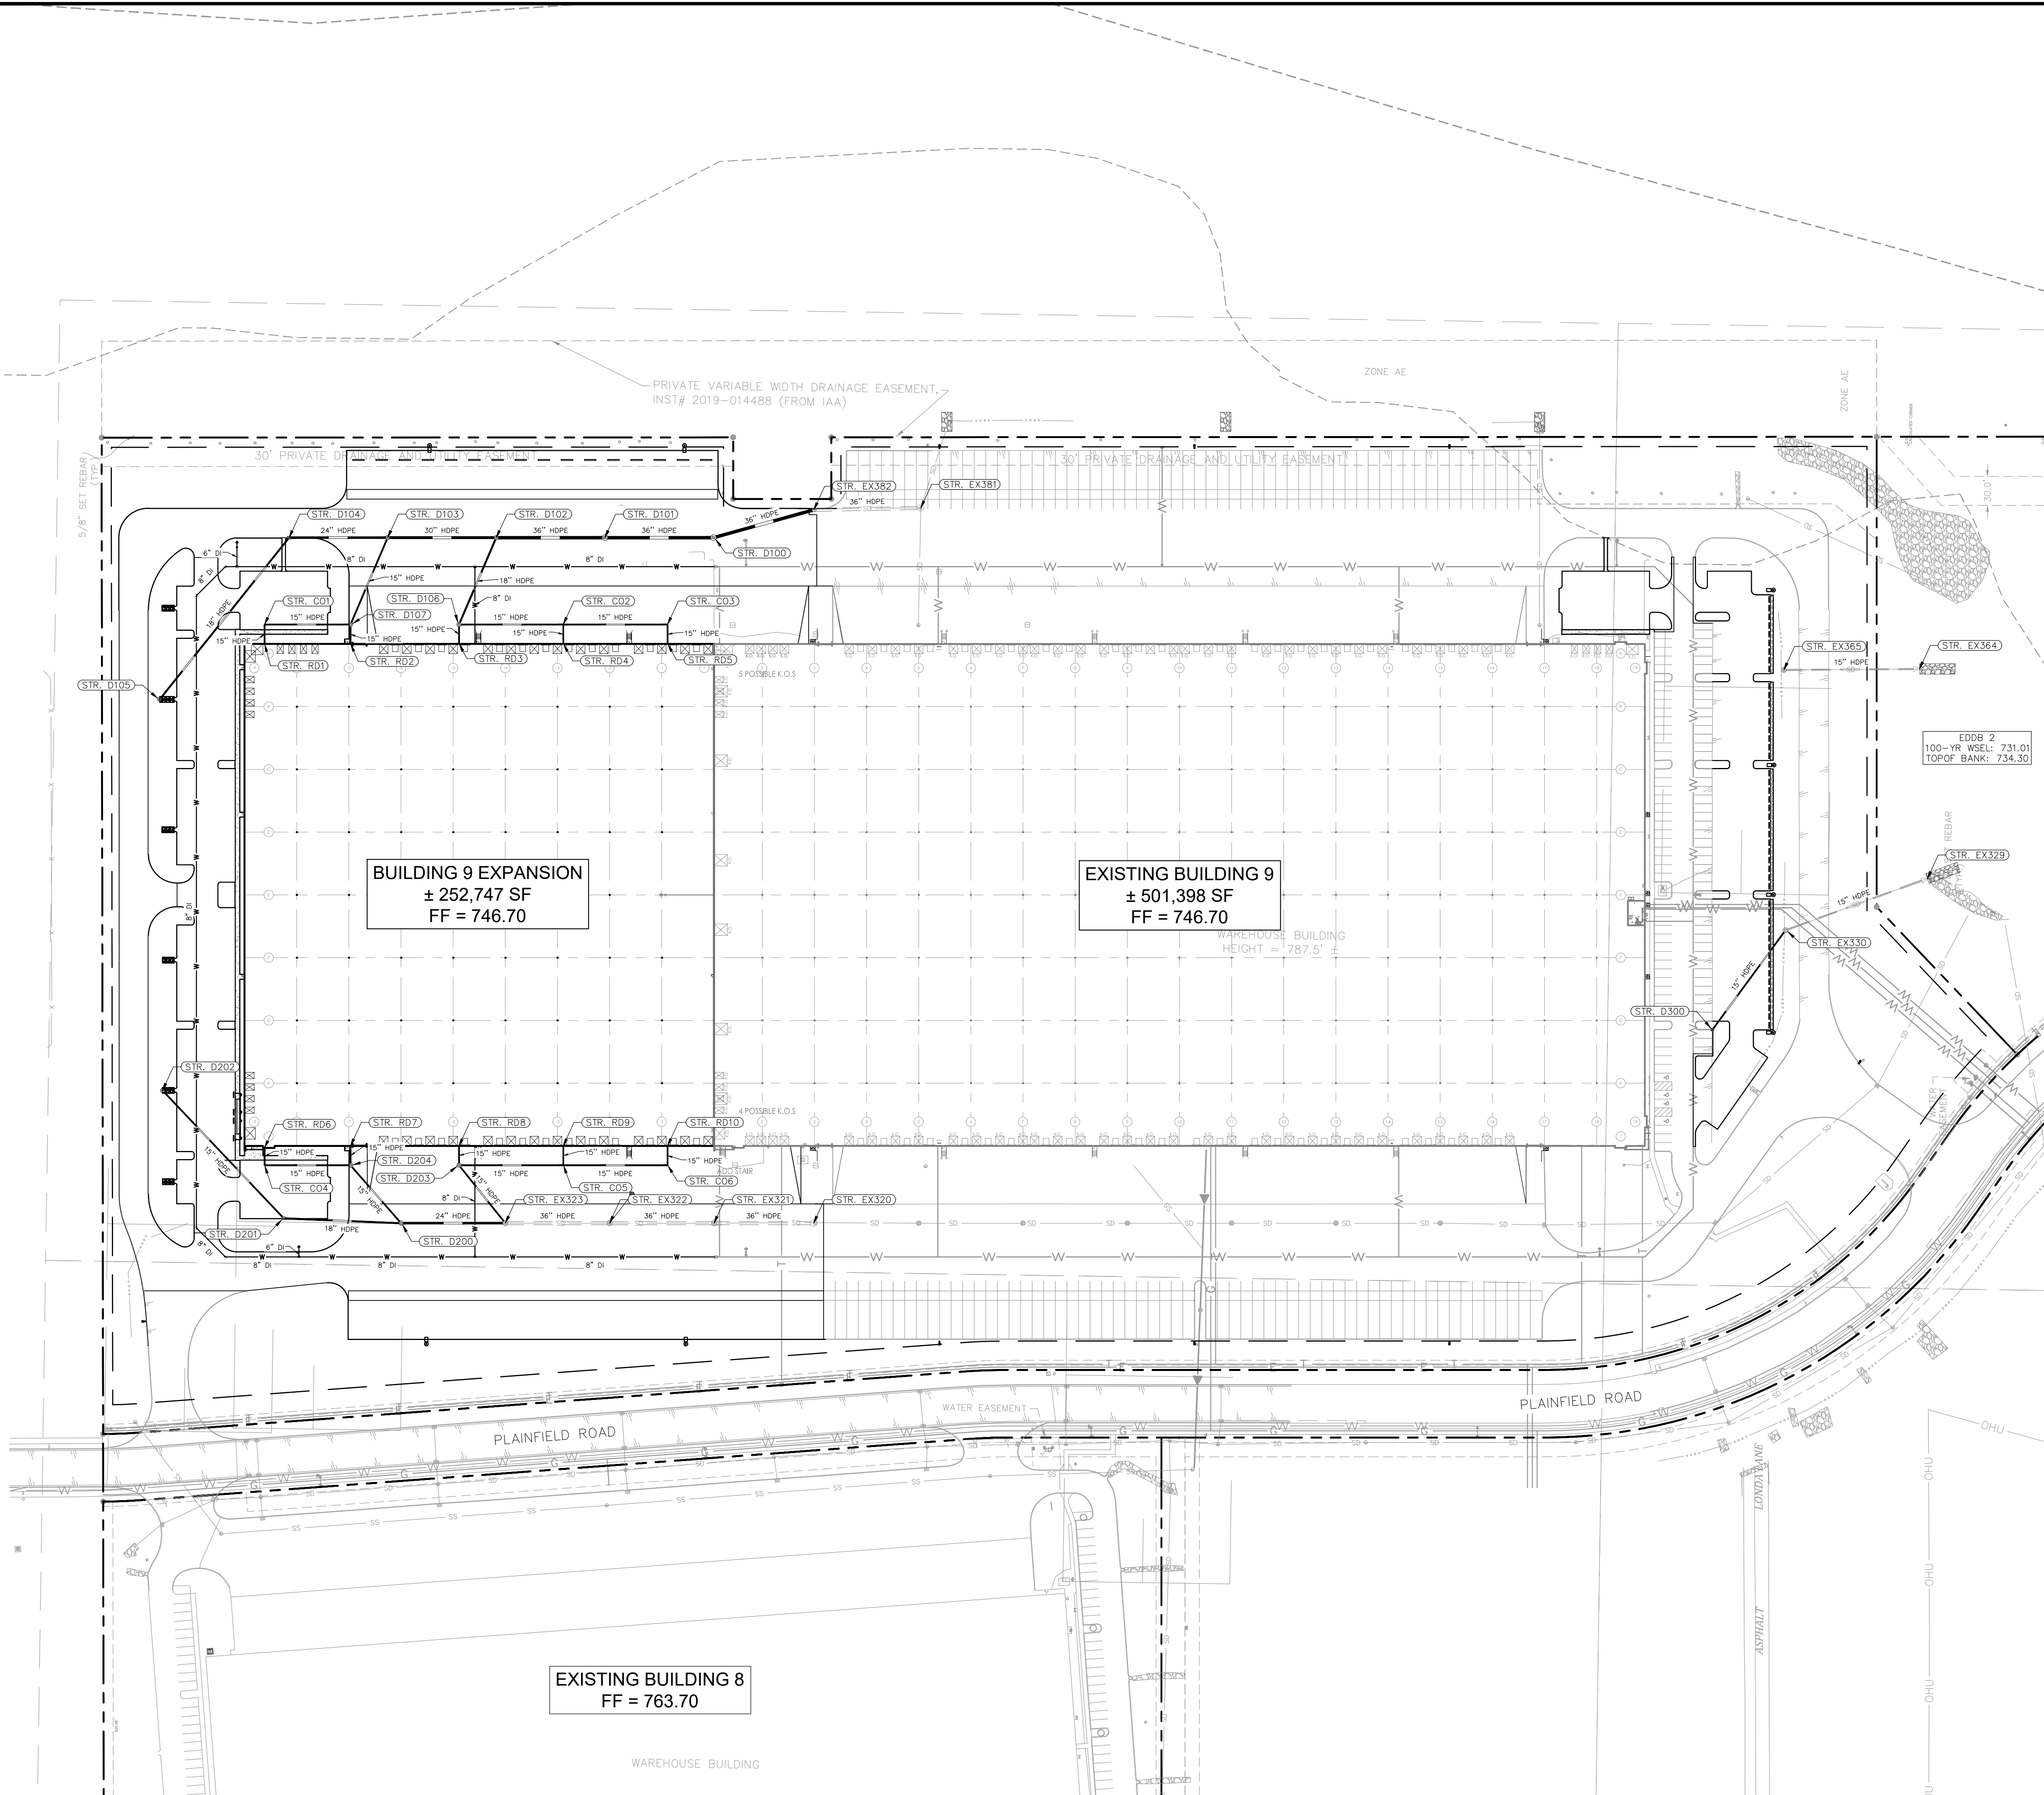


	PROPOSED UNDERGROUND ELECTRIC LINE
	PROPOSED GAS LINE (BY GAS COMPANY)
	PROPOSED PHONE LINE
	PROPOSED ROOF DRAIN LINE
	PROPOSED UNDERDRAIN
	PROPOSED SWALE
	PROPOSED STORM SEWER LINE
	STRUCTURE ID
	PROPOSED STORM STRUCTURES
	PROPOSED SANITARY SEWER LINE
	PROPOSED SANITARY LATERAL LINE
	PROPOSED SANITARY MANHOLE
	PROPOSED STORM/SANITARY CLEANOUT
	PROPOSED WATER LINE
	PROPOSED FIRE PROTECTION LINE
	PROPOSED WATER VALVE BOX, PIV, METER FIRE HYDRANT, FIRE DEPT CONN. & VAULT
	PROPOSED WATER BENDS & TEE
	PROPOSED LIGHT POLE
	PROPOSED TRANSFORMER PAD (BY OTHERS)

	STORM INLET		PARKING SPACE
	CURB INLET		H/C PARKING SPACE
	SANITARY SEWER MANHOLE (SSMH)		TRAFFIC SIGNAL POLE
	STORM DRAIN MANHOLE (SDMH)		LIGHT POLE
	TELEPHONE MANHOLE (TMH)		TREE
	RIGHT OF WAY MONUMENT		MAILBOX
	WATER VALVE		MONITOR WELL
	POWER POLE		
	POWER METER		
	TELEPHONE BOX/PEDESTAL		
	ELECTRICAL MANHOLE		
	FIB		
	UFO		
	[E]		
	...		
	SD		
	SS		
	G		
	W		

[illegible]

SCALE:	AS NOTED	 © 2021 KIMLEY-HORN AND ASSOCIATES, INC. 500 KAPLAN BLVD., SUITE 580, ALBUQUERQUE, NM 87102 PHONE: 317-218-9550 WWW.KIMLEY-HORN.COM
DESIGNED BY:	BAS	
DRAWN BY:	TWH	
CHECKED BY:	BAS	

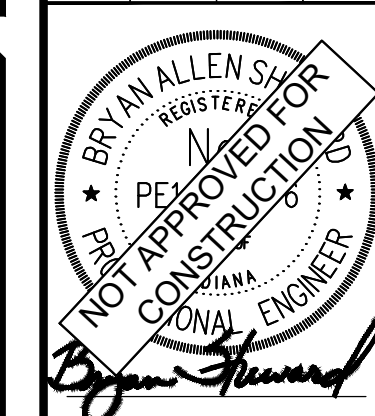

STRATEGIC CAPITAL
PARTNERS

OVERALL UTILITY PLAN

**METROAIR BUSINESS
PARK BUILDING 9
EXPANSION**
4241 PLAINFIELD ROAD, PLAINFIELD, IN 46168

ORIGINAL ISSUE: 08/20/21
KHA PROJECT NO. 170022016
SHEET NUMBER

C6.0