


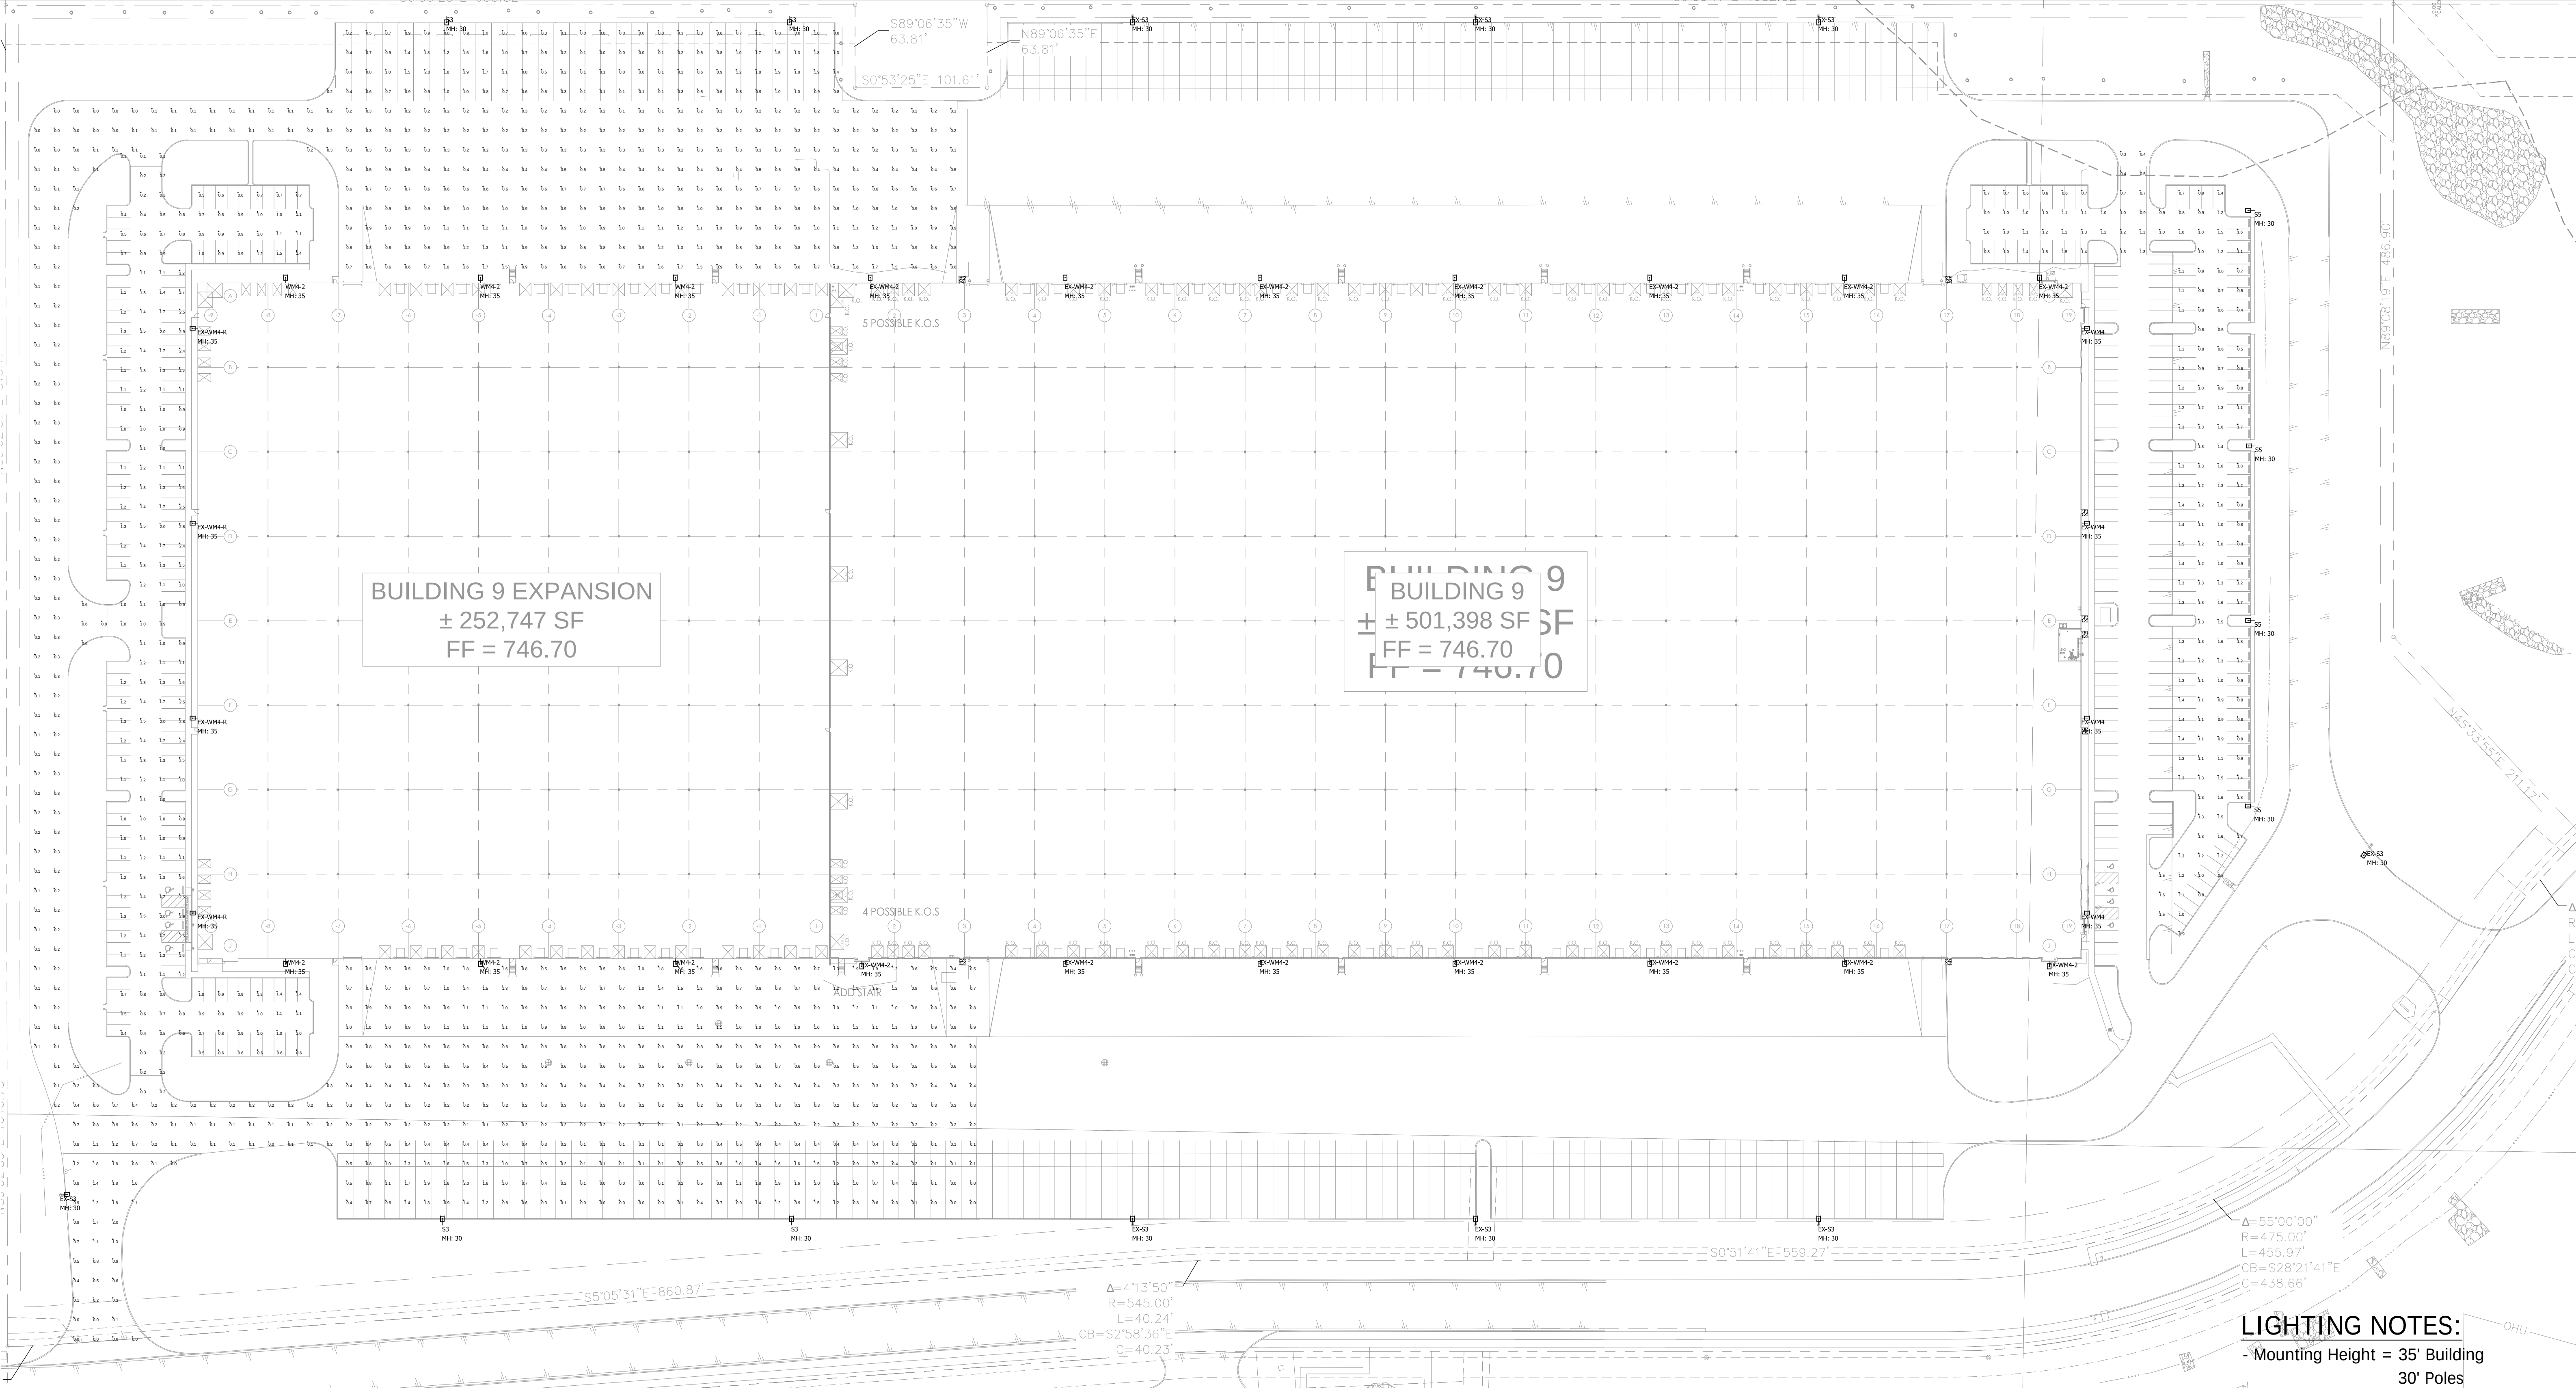

- LIGHTING NOTES:**
- Mounting Height = 35' Building
30' Poles
 - Light Loss Factor = 0.90
 - Footcandle Values Calculated @ Grade
 - Reflectance Values - 80/50/20 (office spaces)
50/30/20 (warehouse areas)

National Lighting Vendor:
For pricing and technical assistance contact:
Russ Miller of CBMC INC, tel# 317-697-7510,
rmiller@cbmcinc.com

"MUST MATCH
EXISTING
DESIGN"

Luminaire Schedule						
Symbol	Qty	Label	Arrangement	Lum. Lumens	LLF	Lum. Watts
	6	WM4-2	WALL MOUNT	19557	0.900	150
	4	S3	SINGLE	13423	0.900	94
	4	EX-WM4	WALL MOUNT	25652	0.900	187
	4	EX-WM4-R	WALL MOUNT	25652	0.900	187
	8	EX-S3	SINGLE	13423	0.900	94
	14	EX-WM4-2	WALL MOUNT	19557	0.900	150
	4	S5	SINGLE	19138	0.900	150
Description						
MRM-LED-18L-SIL-FT-50-70CRI						
MRM-LED-12L-SIL-3-50-70CRI						
MRM-LED-24L-SIL-FT-50-70CRI						
MRM-LED-24L-SIL-FT-50-70CRI (RELOCATED)						
MRM-LED-12L-SIL-3-50-70CRI						
MRM-LED-18L-SIL-FT-50-70CRI						
MRM-LED-18L-SIL-5W-50-70CRI						

Calculation Summary						
Label	CalcType	Units	Avg	Max	Min	Avg/Min
Exp Car Parking & Drives (Left)	Illuminance	Fc	1.12	2.9	0.1	11.20
Exp Car Parking & Drives (Right)	Illuminance	Fc	1.11	1.8	0.3	3.70
Exp Trailer Paved Areas & Drives	Illuminance	Fc	0.57	2.0	0.0	N.A.

This lighting pattern represents illumination levels calculated from laboratory data taken under controlled conditions in accordance with IESNA approved methods. Actual performance of any manufacturer's luminaire may vary due to variation in electrical voltage, tolerance in lamps and LED lumen package, location adjustments, and other variable field conditions.

Contractor to check and verify all dimensions on site before commencing any work shown.

All electrical work shall comply with National, State, and Local codes including and not limited to the National Electric Code, NFPA 101 Life Safety Code, ASHREA and /or IECC Energy Codes.

The information contained in this document is proprietary to CBMC Lighting Solutions. This document is prepared for a specific site and incorporates calculations based on data available from the client at this time. By accepting and using this document, the recipient agrees to protect its contents from further dissemination, (other than that within the organization necessary to evaluate such specification) without the written permission of CBMC Lighting Solutions. The contents of this document are not to be reproduced or copied in whole or in part without the written permission of CBMC Lighting Solutions. copyright © 2018 CBMC Lighting Solutions all rights reserved.



5855 KOPETSKY DR. SUITE G. | INDIANAPOLIS, IN 46217
317-780-8350| WWW.CBMCINC.COM

SEE MORE



Metro Air Bldg 8 & 9

SITE EXP LAYOUT

Scale: 1" = 60' Drawing No: LP1
Date: 8/17/21 Project No:
Drawn By: SJM
CB19126-SITE-B9-EXP