


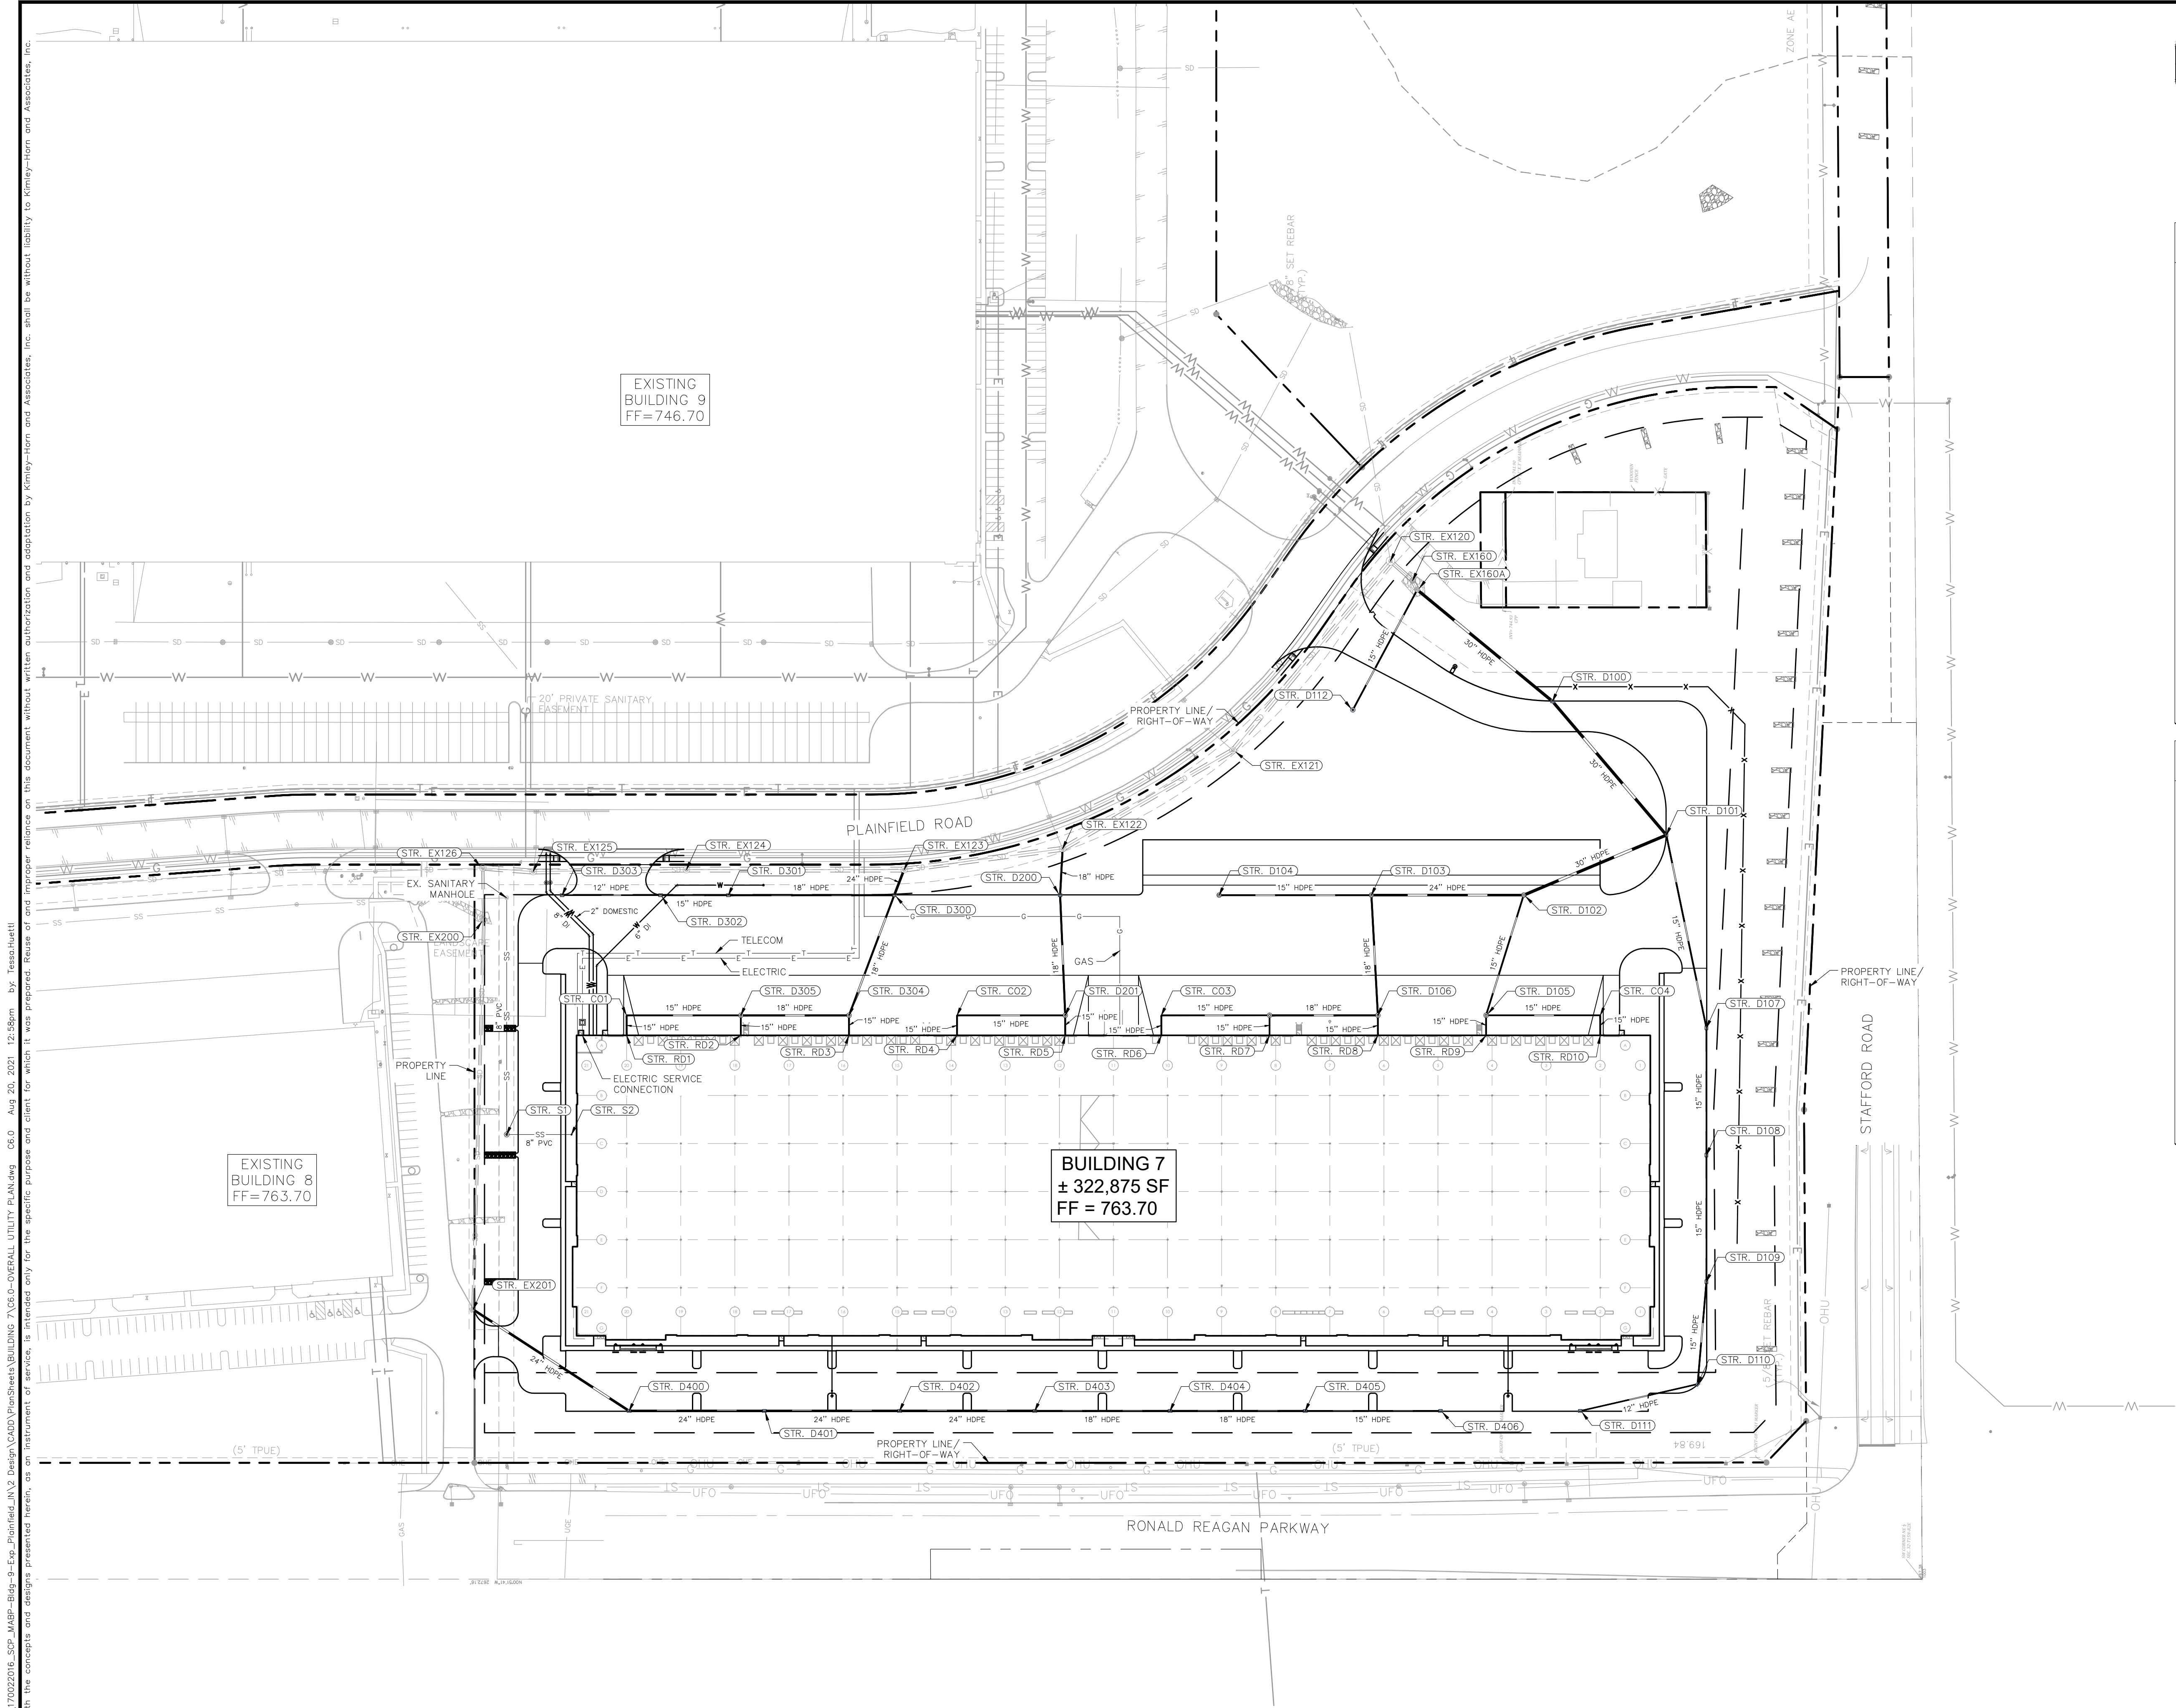

Indiana Utilities Protection Service

Call 811

before you dig

NORTH

GRAPHIC SCALE IN FEET

0 40' 80' 160'

UTILITY LEGEND

—E—	PROPOSED UNDERGROUND ELECTRIC LINE
—G—	PROPOSED GAS LINE (BY GAS COMPANY)
—T—	PROPOSED PHONE LINE
—RD—	PROPOSED ROOF DRAIN LINE
—	PROPOSED UNDERDRAIN
—	PROPOSED SWALE
—	PROPOSED STORM SEWER LINE
STR XX	STRUCTURE ID
—	PROPOSED STORM STRUCTURES
—SS—	PROPOSED SANITARY SEWER LINE
—LAT—	PROPOSED SANITARY LATERAL LINE
—	PROPOSED SANITARY MANHOLE
—	PROPOSED STORM/SANITARY CLEANOUT
—	PROPOSED WATER LINE
—FP—	PROPOSED FIRE PROTECTION LINE
—	PROPOSED WATER VALVE BOX, PIV, METER
—	FIRE HYDRANT, FIRE DEPT CONN. & VAULT
—	PROPOSED WATER BENDS & TEE
—	PROPOSED LIGHT POLE
—	PROPOSED TRANSFORMER PAD (BY OTHERS)

EXISTING LEGEND

—	STORM INLET	PS	PARKING SPACE
—	CURB INLET	—	H/C PARKING SPACE
—	SANITARY SEWER MANHOLE (SSMH)	—	TRAFFIC SIGNAL POLE
—	STORM DRAIN MANHOLE (SDMH)	—	LIGHT POLE
—	TELEPHONE MANHOLE (TMH)	—	TREE
—	RIGHT OF WAY MONUMENT	—	MAILBOX
—	WATER VALVE	—	MONITOR WELL
—	POWER POLE		
—	POWER METER		
—	TELEPHONE BOX/PEDESTAL		
—	ELECTRICAL MANHOLE		
—FIB—	UNDERGROUND FIBER OPTIC		
—UFO—	UNDERGROUND CABLE		
—[E]—	UNDERGROUND ELECTRIC		
—....—	DITCH FLOWLINE		
—SD—	STORM DRAIN		
—SS—	SEWER LINE		
—G—	GAS LINE		
—W—	WATER LINE		

AS NOTED

DESIGNED BY: BAS

DRAWN BY: TNH

CHECKED BY: BAS

Kimley»Horn

©2021 KIMLEY-HORN AND ASSOCIATES, INC.
250 EAST 96TH STREET, SUITE 580,
INDIANAPOLIS, IN 46240
WWW.KIMLEY-HORN.COM

NO CONSTRUCTION

REGISTERED PROFESSIONAL ENGINEER

Bryan Hummel

STRATEGIC CAPITAL PARTNERS

OVERALL UTILITY PLAN

BUILDING 7

METROAIR BUSINESS PARK

4334 PLAINFIELD ROAD, PLAINFIELD, IN 46168

ORIGINAL ISSUE: 08/20/21

KHA PROJECT NO. 170022017

SHEET NUMBER

C6.0