


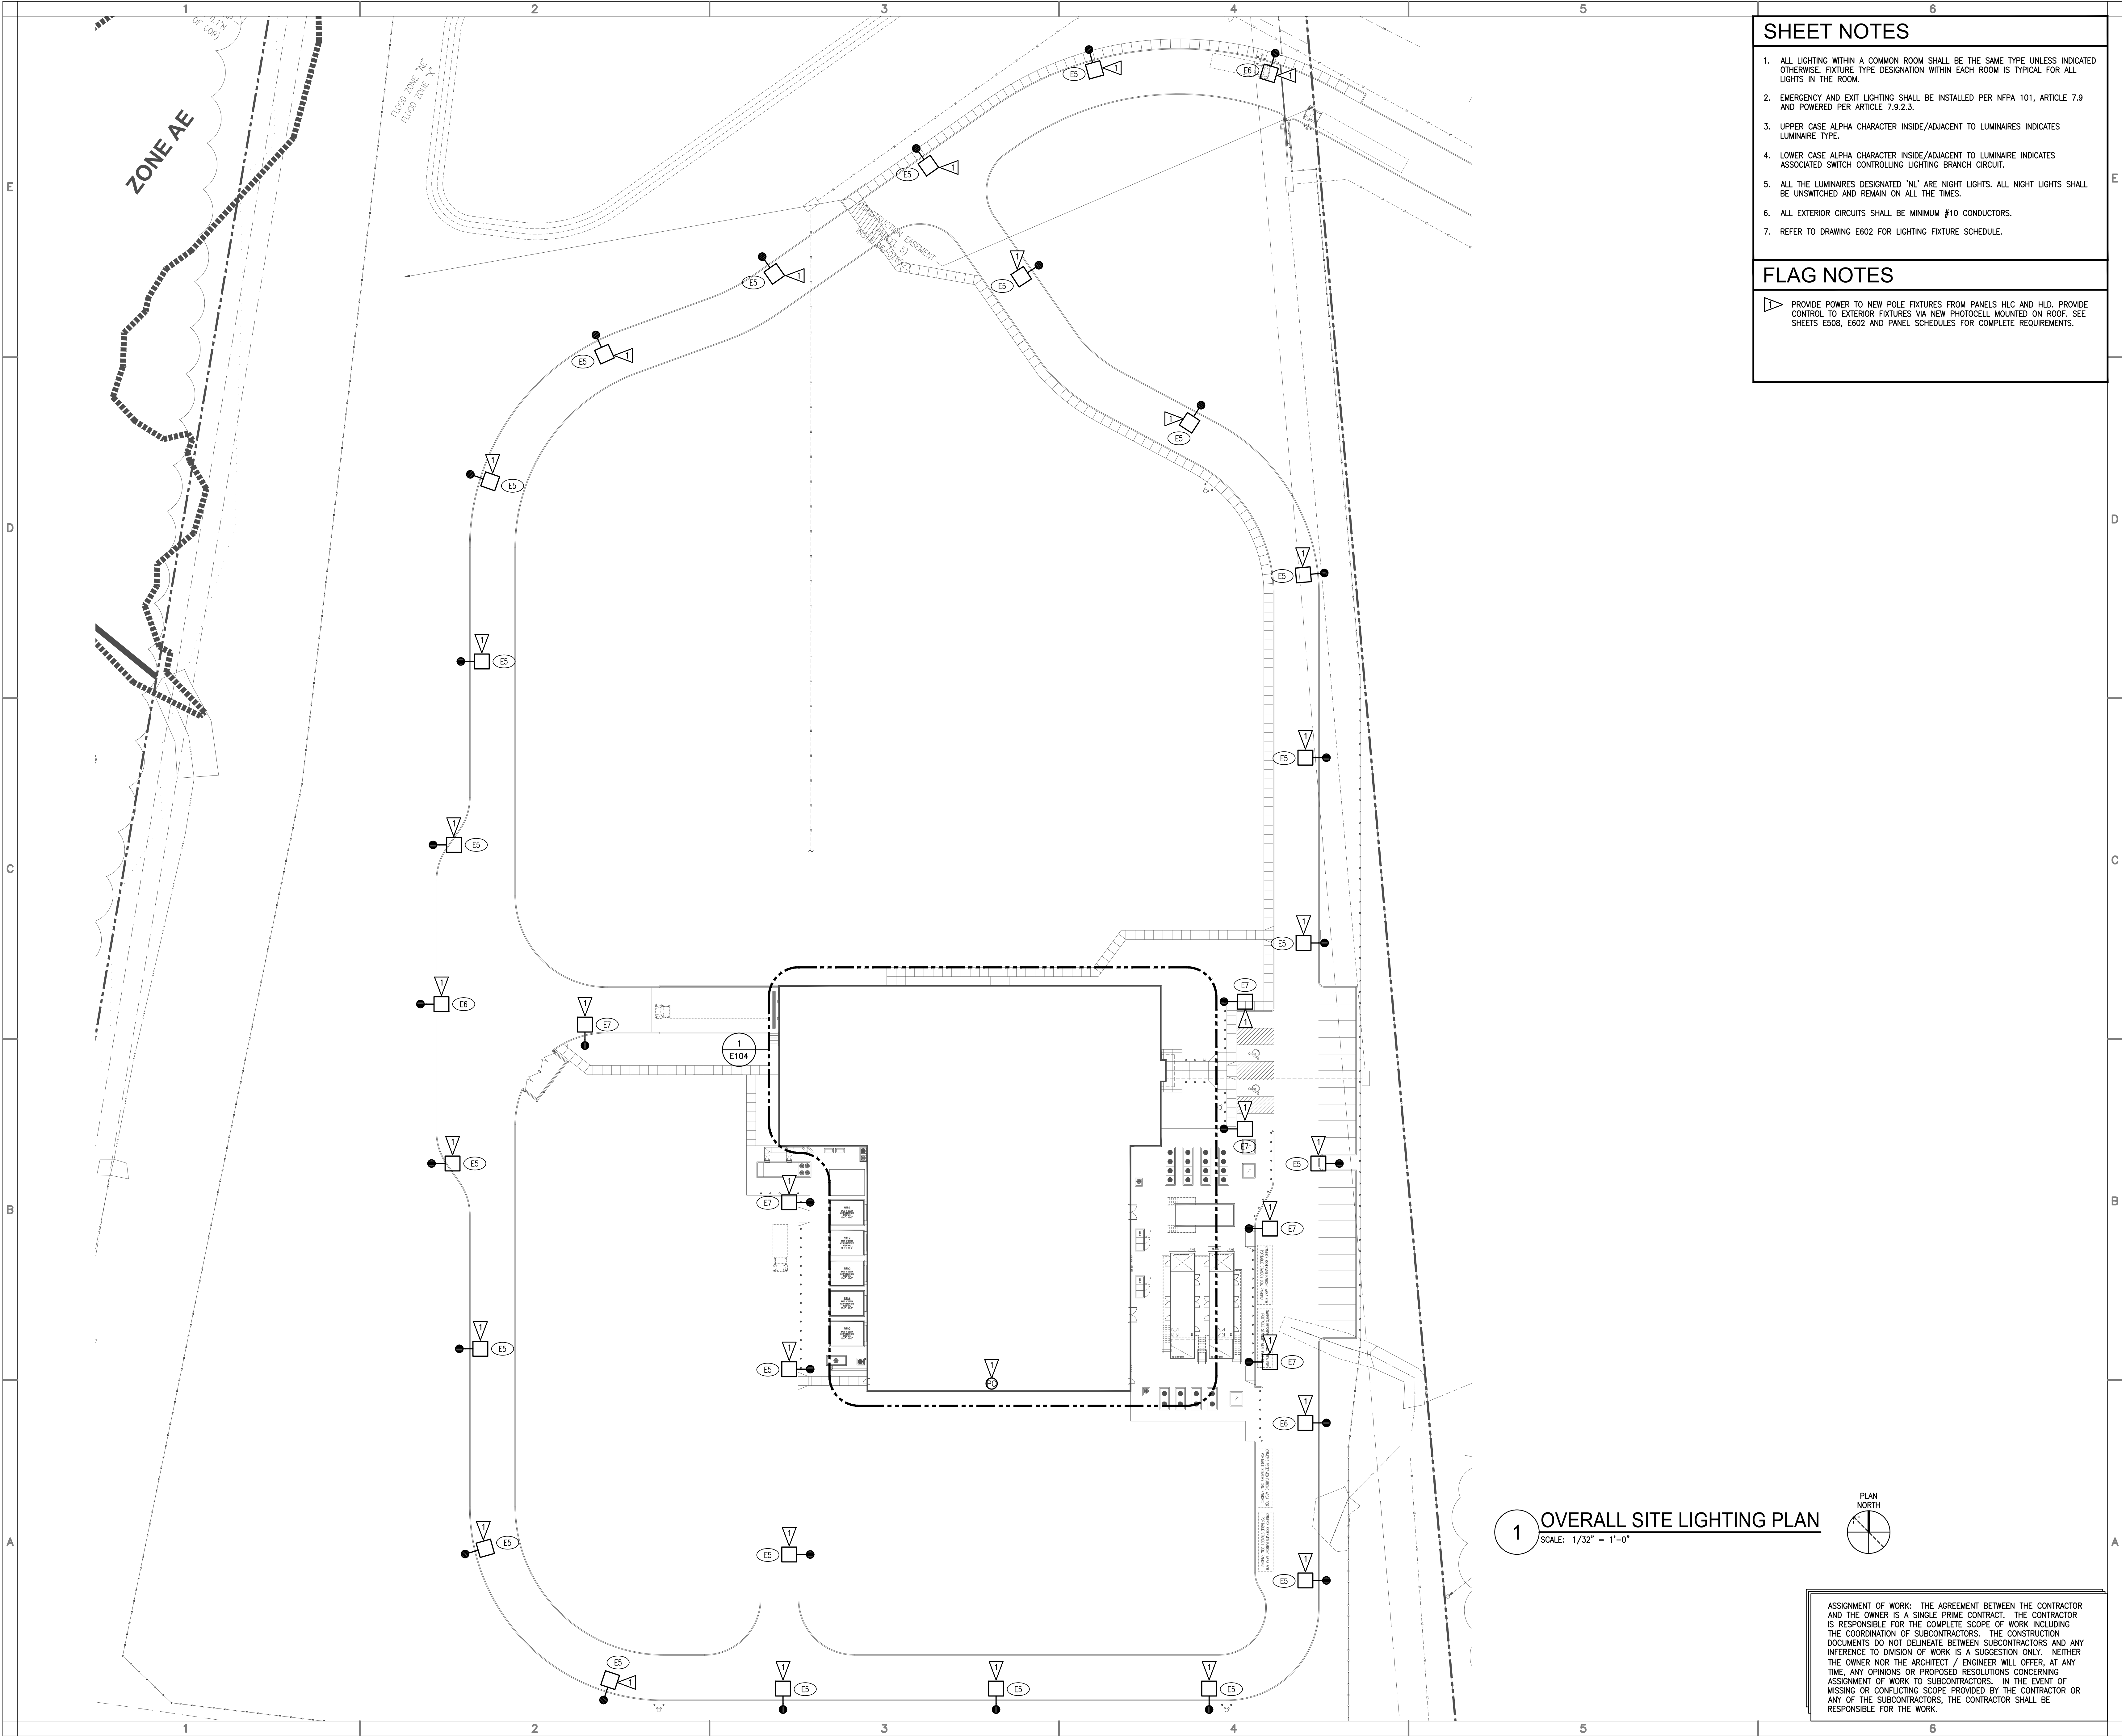

SHEET NOTES

1. ALL LIGHTING WITHIN A COMMON ROOM SHALL BE THE SAME TYPE UNLESS INDICATED OTHERWISE. FIXTURE TYPE DESIGNATION WITHIN EACH ROOM IS TYPICAL FOR ALL LIGHTS IN THE ROOM.
2. EMERGENCY AND EXIT LIGHTING SHALL BE INSTALLED PER NFPA 101, ARTICLE 7.9 AND POWERED PER ARTICLE 7.9.2.3.
3. UPPER CASE ALPHA CHARACTER INSIDE/ADJACENT TO LUMINAIRES INDICATES LUMINAIRE TYPE.
4. LOWER CASE ALPHA CHARACTER INSIDE/ADJACENT TO LUMINAIRE INDICATES ASSOCIATED SWITCH CONTROLLING LIGHTING BRANCH CIRCUIT.
5. ALL THE LUMINAIRES DESIGNATED 'NL' ARE NIGHT LIGHTS. ALL NIGHT LIGHTS SHALL BE UNSWITCHED AND REMAIN ON ALL THE TIMES.
6. ALL EXTERIOR CIRCUITS SHALL BE MINIMUM #10 CONDUCTORS.
7. REFER TO DRAWING E602 FOR LIGHTING FIXTURE SCHEDULE.

FLAG NOTES

- ▶ PROVIDE POWER TO NEW POLE FIXTURES FROM PANELS HLC AND HLD. PROVIDE CONTROL TO EXTERIOR FIXTURES VIA NEW PHOTOCELL MOUNTED ON ROOF. SEE SHEETS E508, E602 AND PANEL SCHEDULES FOR COMPLETE REQUIREMENTS.



This drawing was prepared solely for the use of Verizon Wireless and must only be used by Verizon Wireless employees, contractors, and vendors while performing the work shown on this drawing. Any other use of this drawing is forbidden.

Madden + McMillan Architects

1900 South Highland Avenue, Suite 206
Lombard, IL 60148
(630) 495-8400 Fax: (630) 495-9504



GRUMMAN|BUTKUS
ENERGY EFFICIENCY CONSULTANTS AND SUSTAINABLE DESIGN ENGINEERS
1011 North Mayfair Road, Suite 300
Wauwatosa, Wisconsin 53229
414 476.8980 www.grummanbutkus.com
Copyright © 2021 Grumman|Butkus Associates

verizon
PLAINFIELD SAP
NEW GREENFIELD SAP PROJECT
6295 GATEWAY BLVD.
PLAINFIELD, INDIANA 46168

Δ REV	DESCRIPTION	DATE
1		
2		
3		
4		
5		
6		
7		
8		
9		

NETWORK COMPLIANCE SUBMITTALS	DATE
PRELIMINARY SUBMISSION	10/1/21
30% SUBMISSION	
60% SUBMISSION	12/20/21
90% SUBMISSION	
100% SUBMISSION	
CONSTRUCTION DESIGN SUBMISSION	
RECORD SET (AS-BUILTS)	


PROJECT NO: 2137	STAMP
CAD DWG FILE:	
DESIGNED BY: CJA	
DRAWN BY: JMV	
CHECKED BY: KJL	
COPYRIGHT: 2021	

SHEET TITLE

OVERALL SITE LIGHTING PLAN

SHEET NUMBER
E103

1 OVERALL SITE LIGHTING PLAN
SCALE: 1/32" = 1'-0"

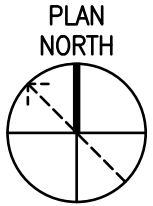

ASSIGNMENT OF WORK: THE AGREEMENT BETWEEN THE CONTRACTOR AND THE OWNER IS A SINGLE PRIME CONTRACT. THE CONTRACTOR IS RESPONSIBLE FOR THE COMPLETE SCOPE OF WORK INCLUDING THE COORDINATION OF SUBCONTRACTORS. THE CONSTRUCTION DOCUMENTS DO NOT DELINEATE BETWEEN SUBCONTRACTORS AND ANY INFERENCE TO DIVISION OF WORK IS A SUGGESTION ONLY. NEITHER THE OWNER NOR THE ARCHITECT / ENGINEER WILL OFFER, AT ANY TIME, ANY OPINIONS OR PROPOSED RESOLUTIONS CONCERNING ASSIGNMENT OF WORK TO SUBCONTRACTORS. IN THE EVENT OF MISSING OR CONFLICTING SCOPE PROVIDED BY THE CONTRACTOR OR ANY OF THE SUBCONTRACTORS, THE CONTRACTOR SHALL BE RESPONSIBLE FOR THE WORK.