


2 UPPER PLENUM ROOM 123 LIGHTING PLAN
SCALE: 1/8" = 1'-0"

SHEET NOTES

1. ALL LIGHTING WITHIN A COMMON ROOM SHALL BE THE SAME TYPE UNLESS INDICATED OTHERWISE. FIXTURE TYPE DESIGNATION WITHIN EACH ROOM IS TYPICAL FOR ALL LIGHTS IN THE ROOM.
2. EMERGENCY AND EXIT LIGHTING SHALL BE INSTALLED PER NFPA 101, ARTICLE 7.9 AND POWERED PER ARTICLE 7.9.2.3.
3. UPPER CASE ALPHA CHARACTER INSIDE/ADJACENT TO LUMINAIRES INDICATES ASSOCIATED SWITCH CONTROLLING LIGHTING BRANCH CIRCUIT.
4. LOWER CASE ALPHA CHARACTER INSIDE/ADJACENT TO LUMINAIRE INDICATES ASSOCIATED SWITCH CONTROLLING LIGHTING BRANCH CIRCUIT.
5. ALL THE LUMINAIRES DESIGNATED 'NL' ARE NIGHT LIGHTS. ALL NIGHT LIGHTS SHALL BE UNSWITCHED AND REMAIN ON ALL THE TIMES.
6. REFER TO DRAWING E602 FOR LIGHTING FIXTURE SCHEDULE.

FLAG NOTES

1. INSTALL LIGHTS IN ROOM 7'-0" ABOVE PLENUM ACCESS FLOOR. COORDINATE WITH ARCHITECTURAL DRAWINGS AND ELEVATIONS.
2. PROVIDE PILOT LIGHT SWITCH FOR PLENUM UPPER LEVEL LIGHTS. MOUNT AT 6'-0" AFF NEAR THE ACCESS DOOR. LIGHT SWITCH SHALL BE ILLUMINATED WHEN LIGHT FIXTURES ARE ON.
3. LIGHT FIXTURES TYPE F1 INSTALLED IN NETWORK ROOM COLD & HOT AISLES SHALL BE STRUT MOUNTED AT 12'-0" AFF. REFER TO DETAILS ON ARCHITECTURAL Q-SERIES DRAWINGS FOR MORE INFORMATION.

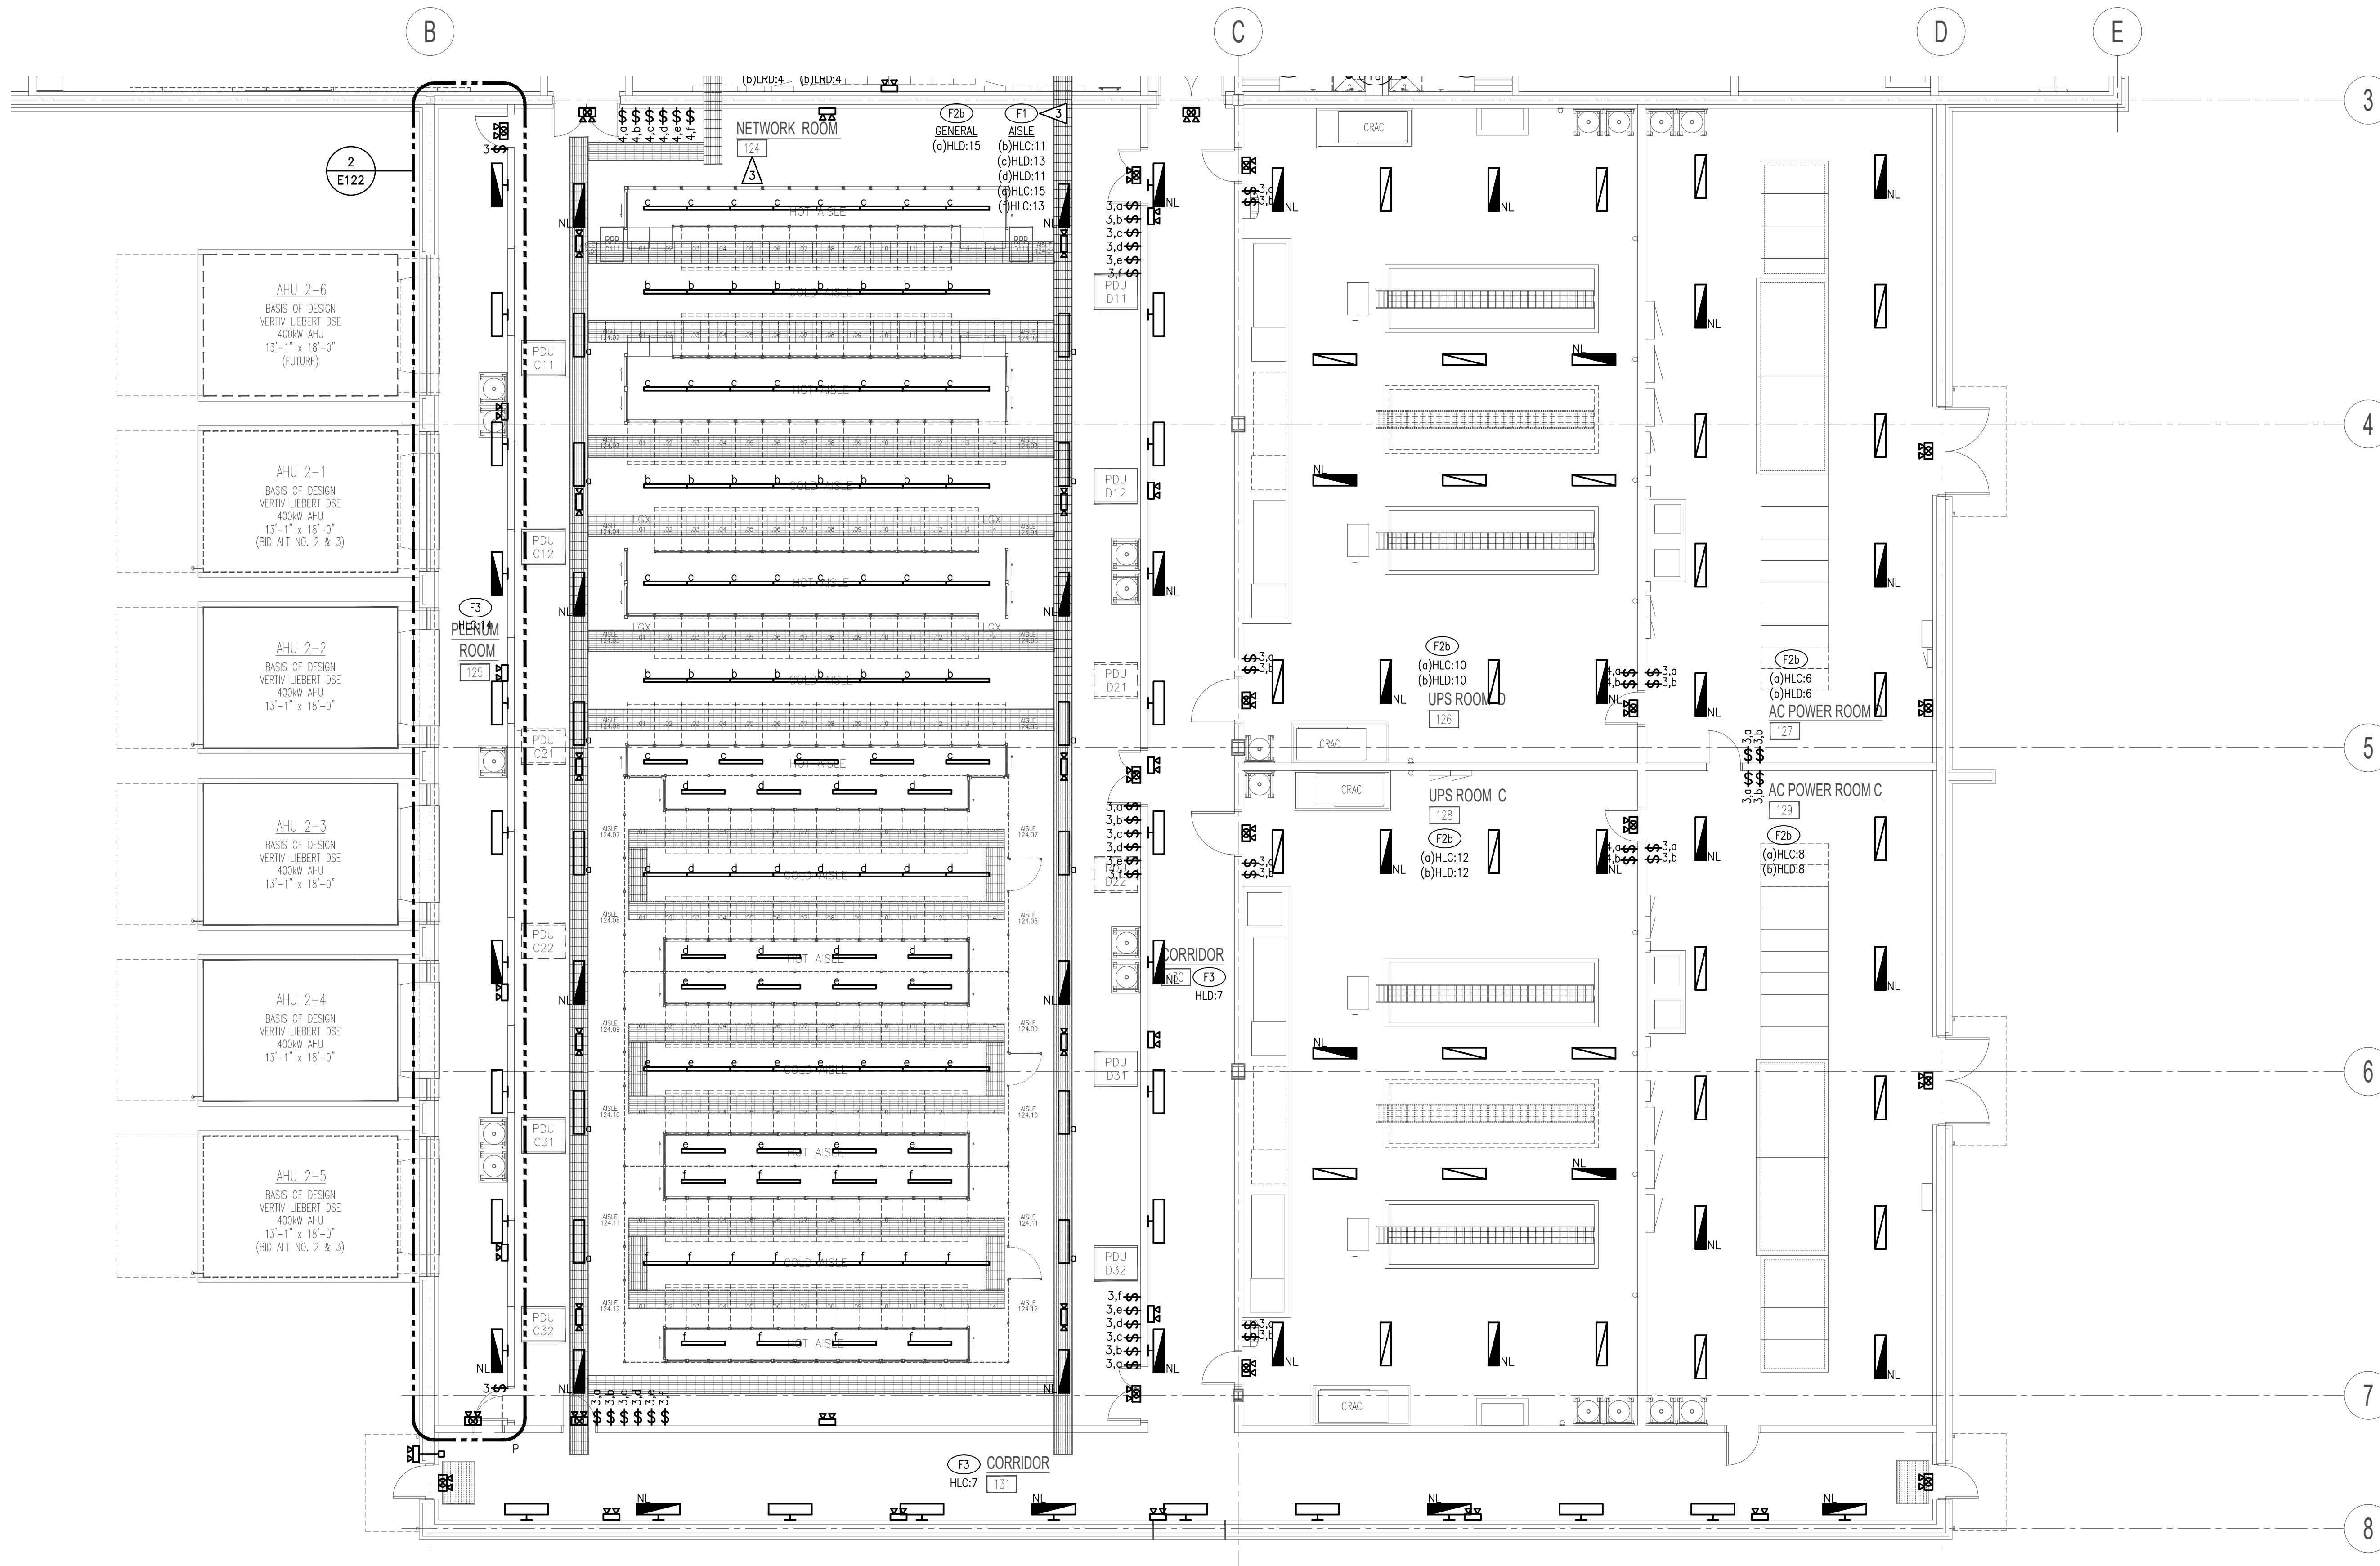

1 LIGHTING FLOOR PLAN - AREA 2
SCALE: 1/8" = 1'-0"

KEYPLAN

AREA 1

AREA 2

ASSIGNMENT OF WORK: THE AGREEMENT BETWEEN THE CONTRACTOR AND THE OWNER IS A SINGLE PRIME CONTRACT. THE CONTRACTOR IS RESPONSIBLE FOR THE COMPLETE SCOPE OF WORK INCLUDING THE COORDINATION OF SUBCONTRACTORS. THE CONSTRUCTION DOCUMENTS DO NOT DELINEATE BETWEEN SUBCONTRACTORS AND ANY INFERENCE TO DIVISION OF WORK IS A SUGGESTION ONLY. NEITHER THE OWNER NOR THE ARCHITECT / ENGINEER WILL OFFER, AT ANY TIME, ANY OPINIONS OR PROPOSED RESOLUTIONS CONCERNING ASSIGNMENT OF WORK TO SUBCONTRACTORS. IN THE EVENT OF MISSING OR CONFLICTING SCOPE PROVIDED BY THE CONTRACTOR OR ANY OF THE SUBCONTRACTORS, THE CONTRACTOR SHALL BE RESPONSIBLE FOR THE WORK.




This drawing was prepared solely for the use of Verizon Wireless and must only be used by Verizon Wireless employees, contractors, and vendors while performing the work shown on this drawing. Any other use of this drawing is forbidden.

Madden + McMillan Architects

1900 South Highland Avenue, Suite 206
Lombard, IL 60148
(630) 495-8400 Fax: (630) 495-9504



GRUMMAN|BUTKUS
ENERGY EFFICIENCY CONSULTANTS AND SUSTAINABLE DESIGN ENGINEERS
1011 North Mayfair Road, Suite 300
Wauwatosa, Wisconsin 53229
414 476-9980 www.grummanbutkus.com
Copyright © 2021 Grumman|Butkus Associates

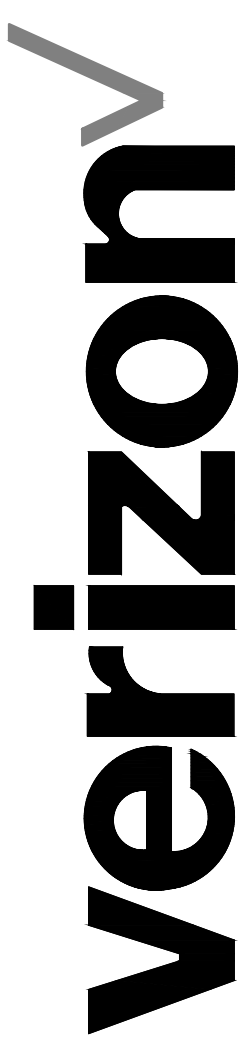

PLAINFIELD SAP
NEW GREENFIELD SAP PROJECT
6295 GATEWAY BLVD.
PLAINFIELD, INDIANA 46168

REV	DESCRIPTION	DATE
1		
2		
3		
4		
5		
6		
7		
8		
9		

NETWORK COMPLIANCE SUBMITTALS	DATE
PRELIMINARY SUBMISSION	10/1/21
30% SUBMISSION	
60% SUBMISSION	12/20/21
90% SUBMISSION	
100% SUBMISSION	
CONSTRUCTION DESIGN SUBMISSION	
RECORD SET (AS-BUILTS)	

PROJECT NO: 2137	STAMP
CAD DWG FILE:	
DESIGNED BY: CIA	
DRAWN BY: JMV	
CHECKED BY: KJL	
COPYRIGHT: 2021	

SHEET TITLE
LIGHTING FLOOR PLAN - AREA 2

SHEET NUMBER
E122