

Drawing name: K:\IND\170278002_Bipastorekuretz_Wawa_Plainfield_V2_Design\CADD\PlanSheets\C60-UTILITY PLAN.dwg C60 Mar 31, 2026 3:07pm by ColinNicoski
 This document, together with the concepts and designs presented herein, is intended only for the specific purpose and client for which it was prepared. Reuse of and improper reliance on this document without written authorization and adaptation by Kimley-Horn and Associates, Inc. shall be without liability to Kimley-Horn and Associates, Inc.

Indiana Utilities Protection Service


Call 811

before you dig

GRAPHIC SCALE IN FEET
0 15' 30' 60'

UTILITY LEGEND

	PROPOSED UNDERGROUND ELECTRIC LINE
	PROPOSED GAS LINE (BY GAS COMPANY)
	PROPOSED PHONE LINE
	PROPOSED ROOF DRAIN LINE
	PROPOSED UNDERDRAIN
	PROPOSED SWALE
	PROPOSED STORM SEWER LINE
	STRUCTURE ID
	PROPOSED STORM STRUCTURES
	PROPOSED SANITARY SEWER LINE
	PROPOSED SANITARY LATERAL LINE
	PROPOSED SANITARY MANHOLE
	PROPOSED STORM/SANITARY CLEANOUT
	PROPOSED WATER LINE
	PROPOSED FIRE PROTECTION LINE
	PROPOSED WATER VALVE BOX, PIV, METER, FIRE HYDRANT, FIRE DEPT CONN. & VAULT
	PROPOSED WATER BENDS & TEE
	PROPOSED LIGHT POLE
	PROPOSED TRANSFORMER PAD (BY OTHERS)

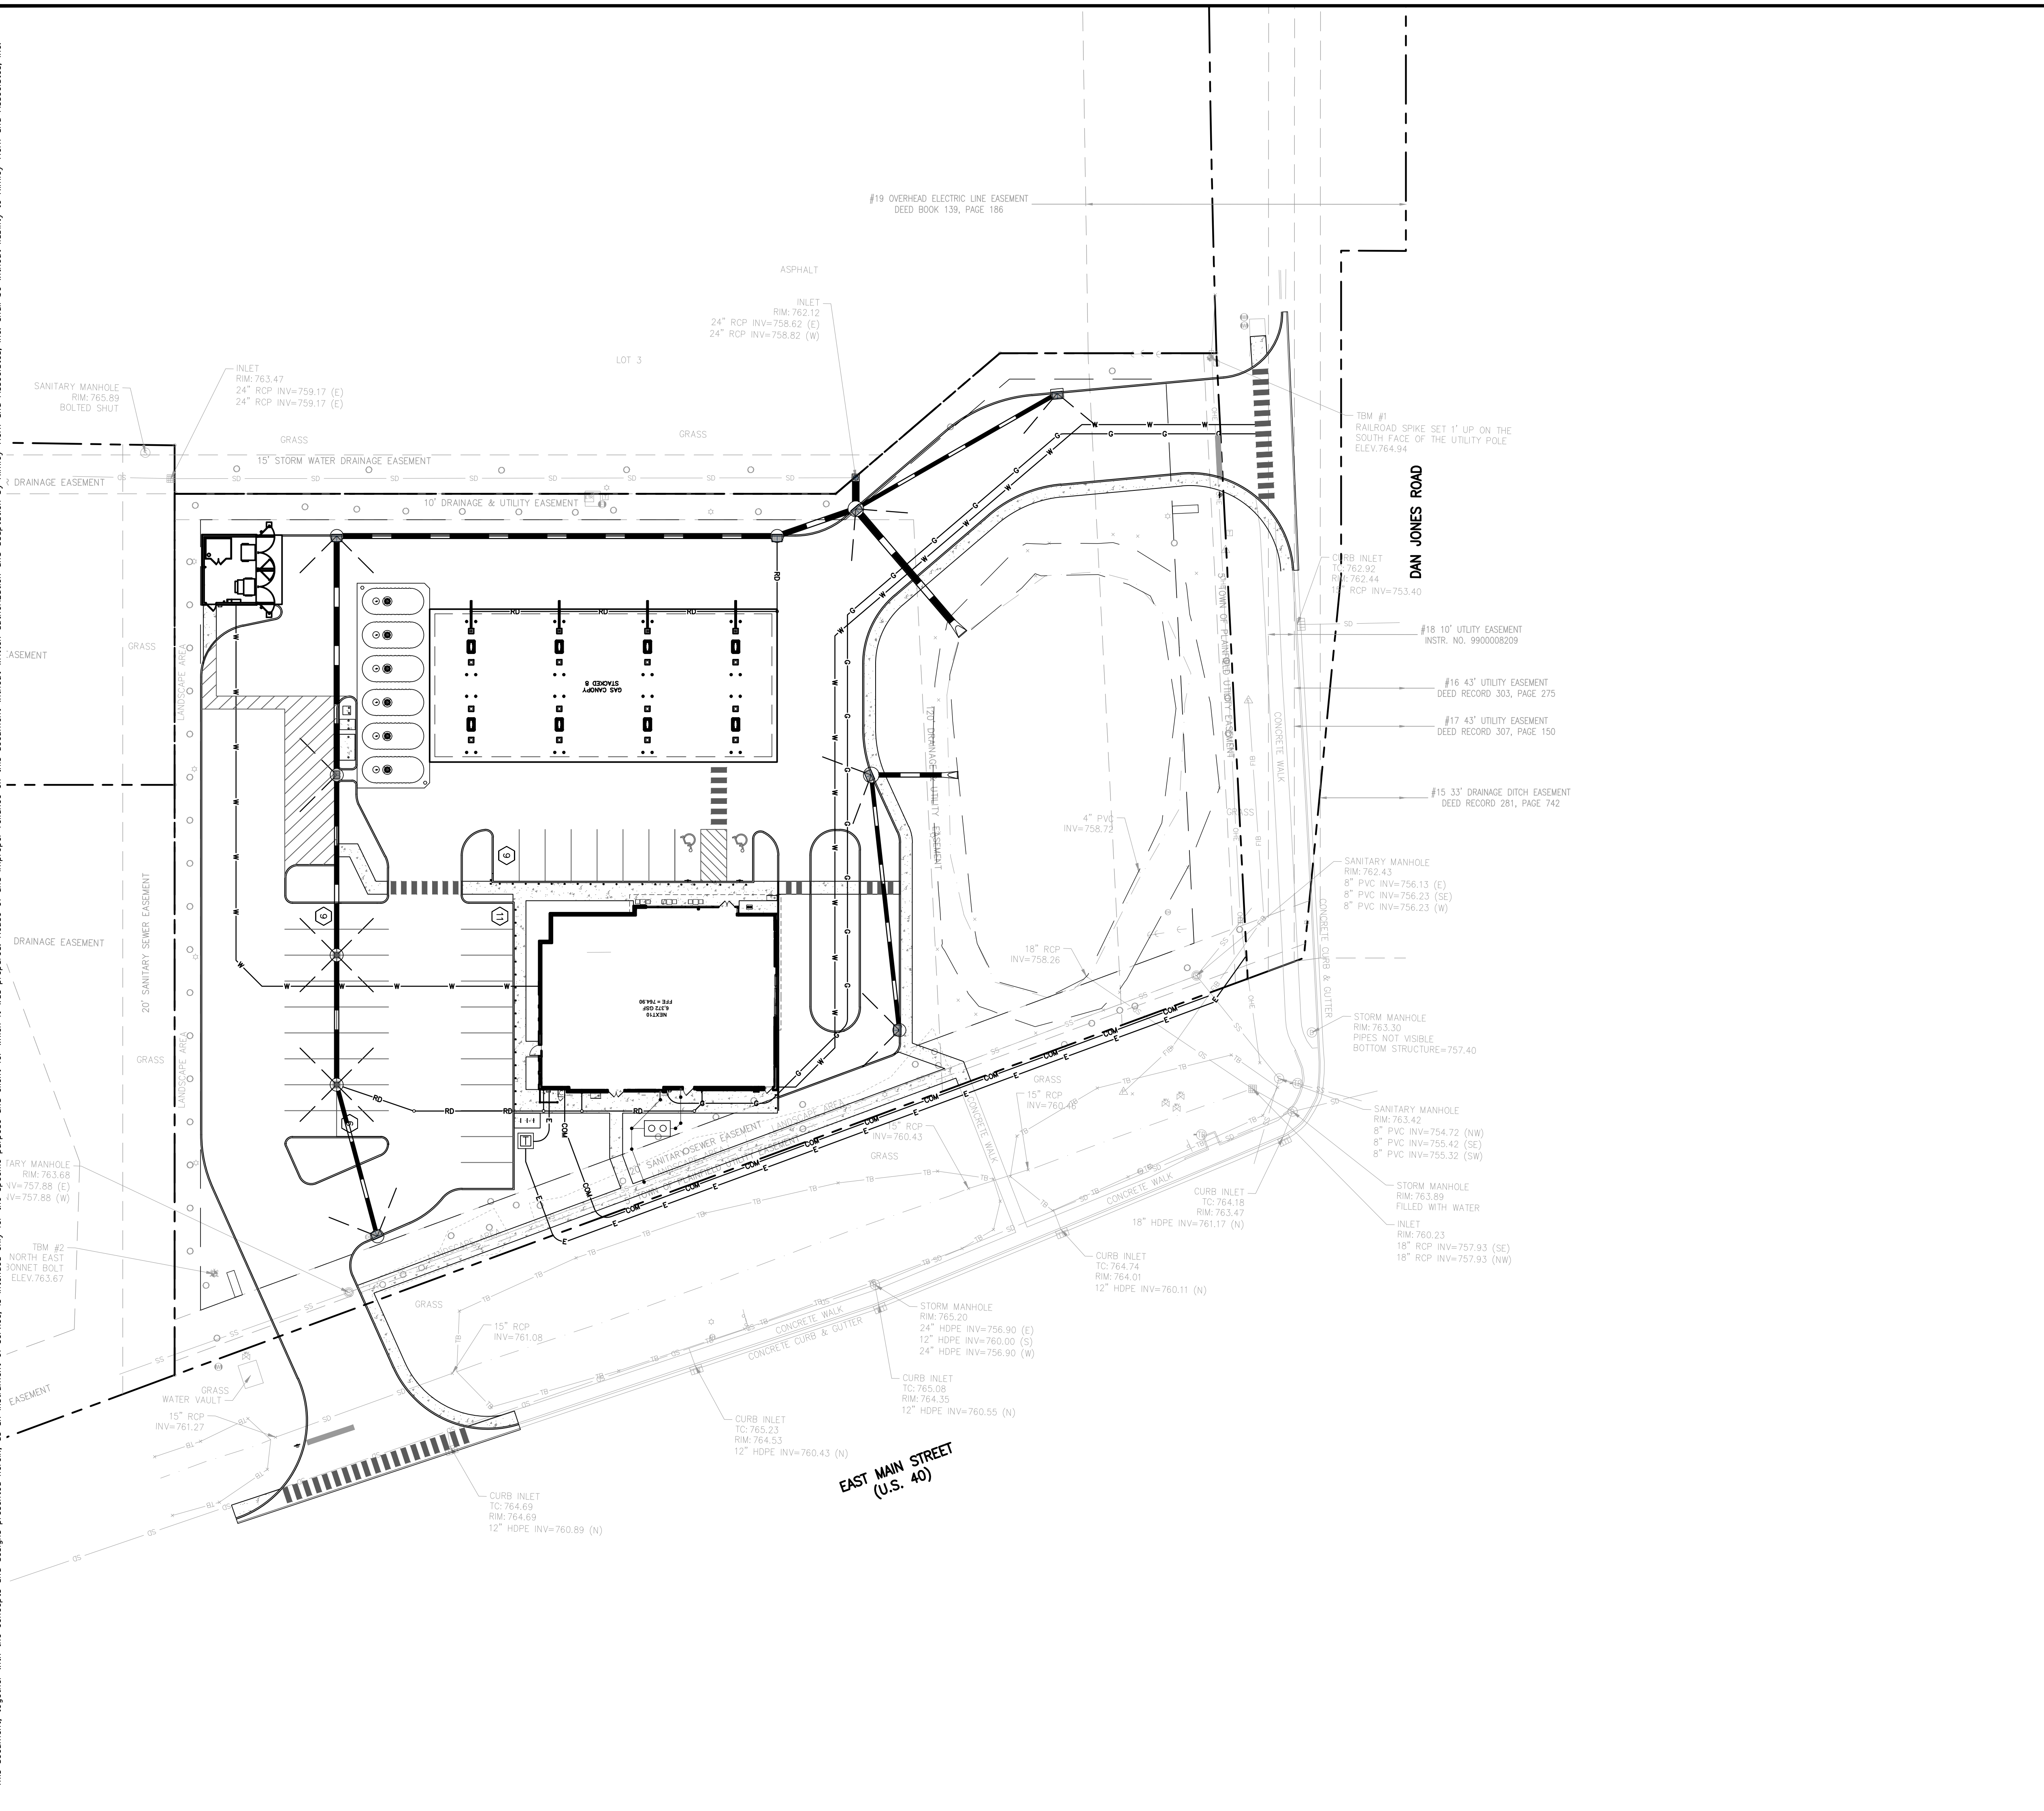

<p>©2026 KIMLEY-HORN AND ASSOCIATES, INC. 500 EAST 86TH STREET, SUITE 300, INDIANAPOLIS, IN 46240 WWW.KIMLEY-HORN.COM</p>	<p>SCALE: AS NOTED</p> <p>DESIGNED BY: CAN</p> <p>DRAWN BY: CAN</p> <p>CHECKED BY: CSM</p>
<p>CHAD STEVEN HORN REGISTERED PROFESSIONAL ENGINEER STATE OF INDIANA NO. 12222</p>	
<h2>UTILITY PLAN</h2>	
<p>WAWA PLAINFIELD 1516 EAST MAIN STREET, PLAINFIELD, IN 46168</p>	
<p>ORIGINAL ISSUE: 12/26/2025</p> <p>KHA PROJECT NO. 170278002</p> <p>SHEET NUMBER</p>	
<h3>GENERAL PLAN NOTES</h3> <p>REFER TO GENERAL NOTES SHEET FOR MORE INFORMATION INCLUDING THE FOLLOWING: (EXISTING LEGEND, BENCHMARK INFORMATION, AND SPECIFIC GENERAL PLAN NOTES.)</p>	
<h1>C6.0</h1>	