


**NOTE: THIS IS THE PREVIOUS SITE PLAN PROVIDED SOLELY AS A REFERENCE, SHOWING UPDATED ENTRANCE LIGHTING. THE UPDATED SITE PHOTOMETRIC PLAN WILL BE SENT OVER 4/3/26 DUE TO PROVIDER DELAY.**

THIS SITE IS LOCATED IN A REGION WHERE LIGHTING IS REGULATED BY LOCAL ORDINANCES

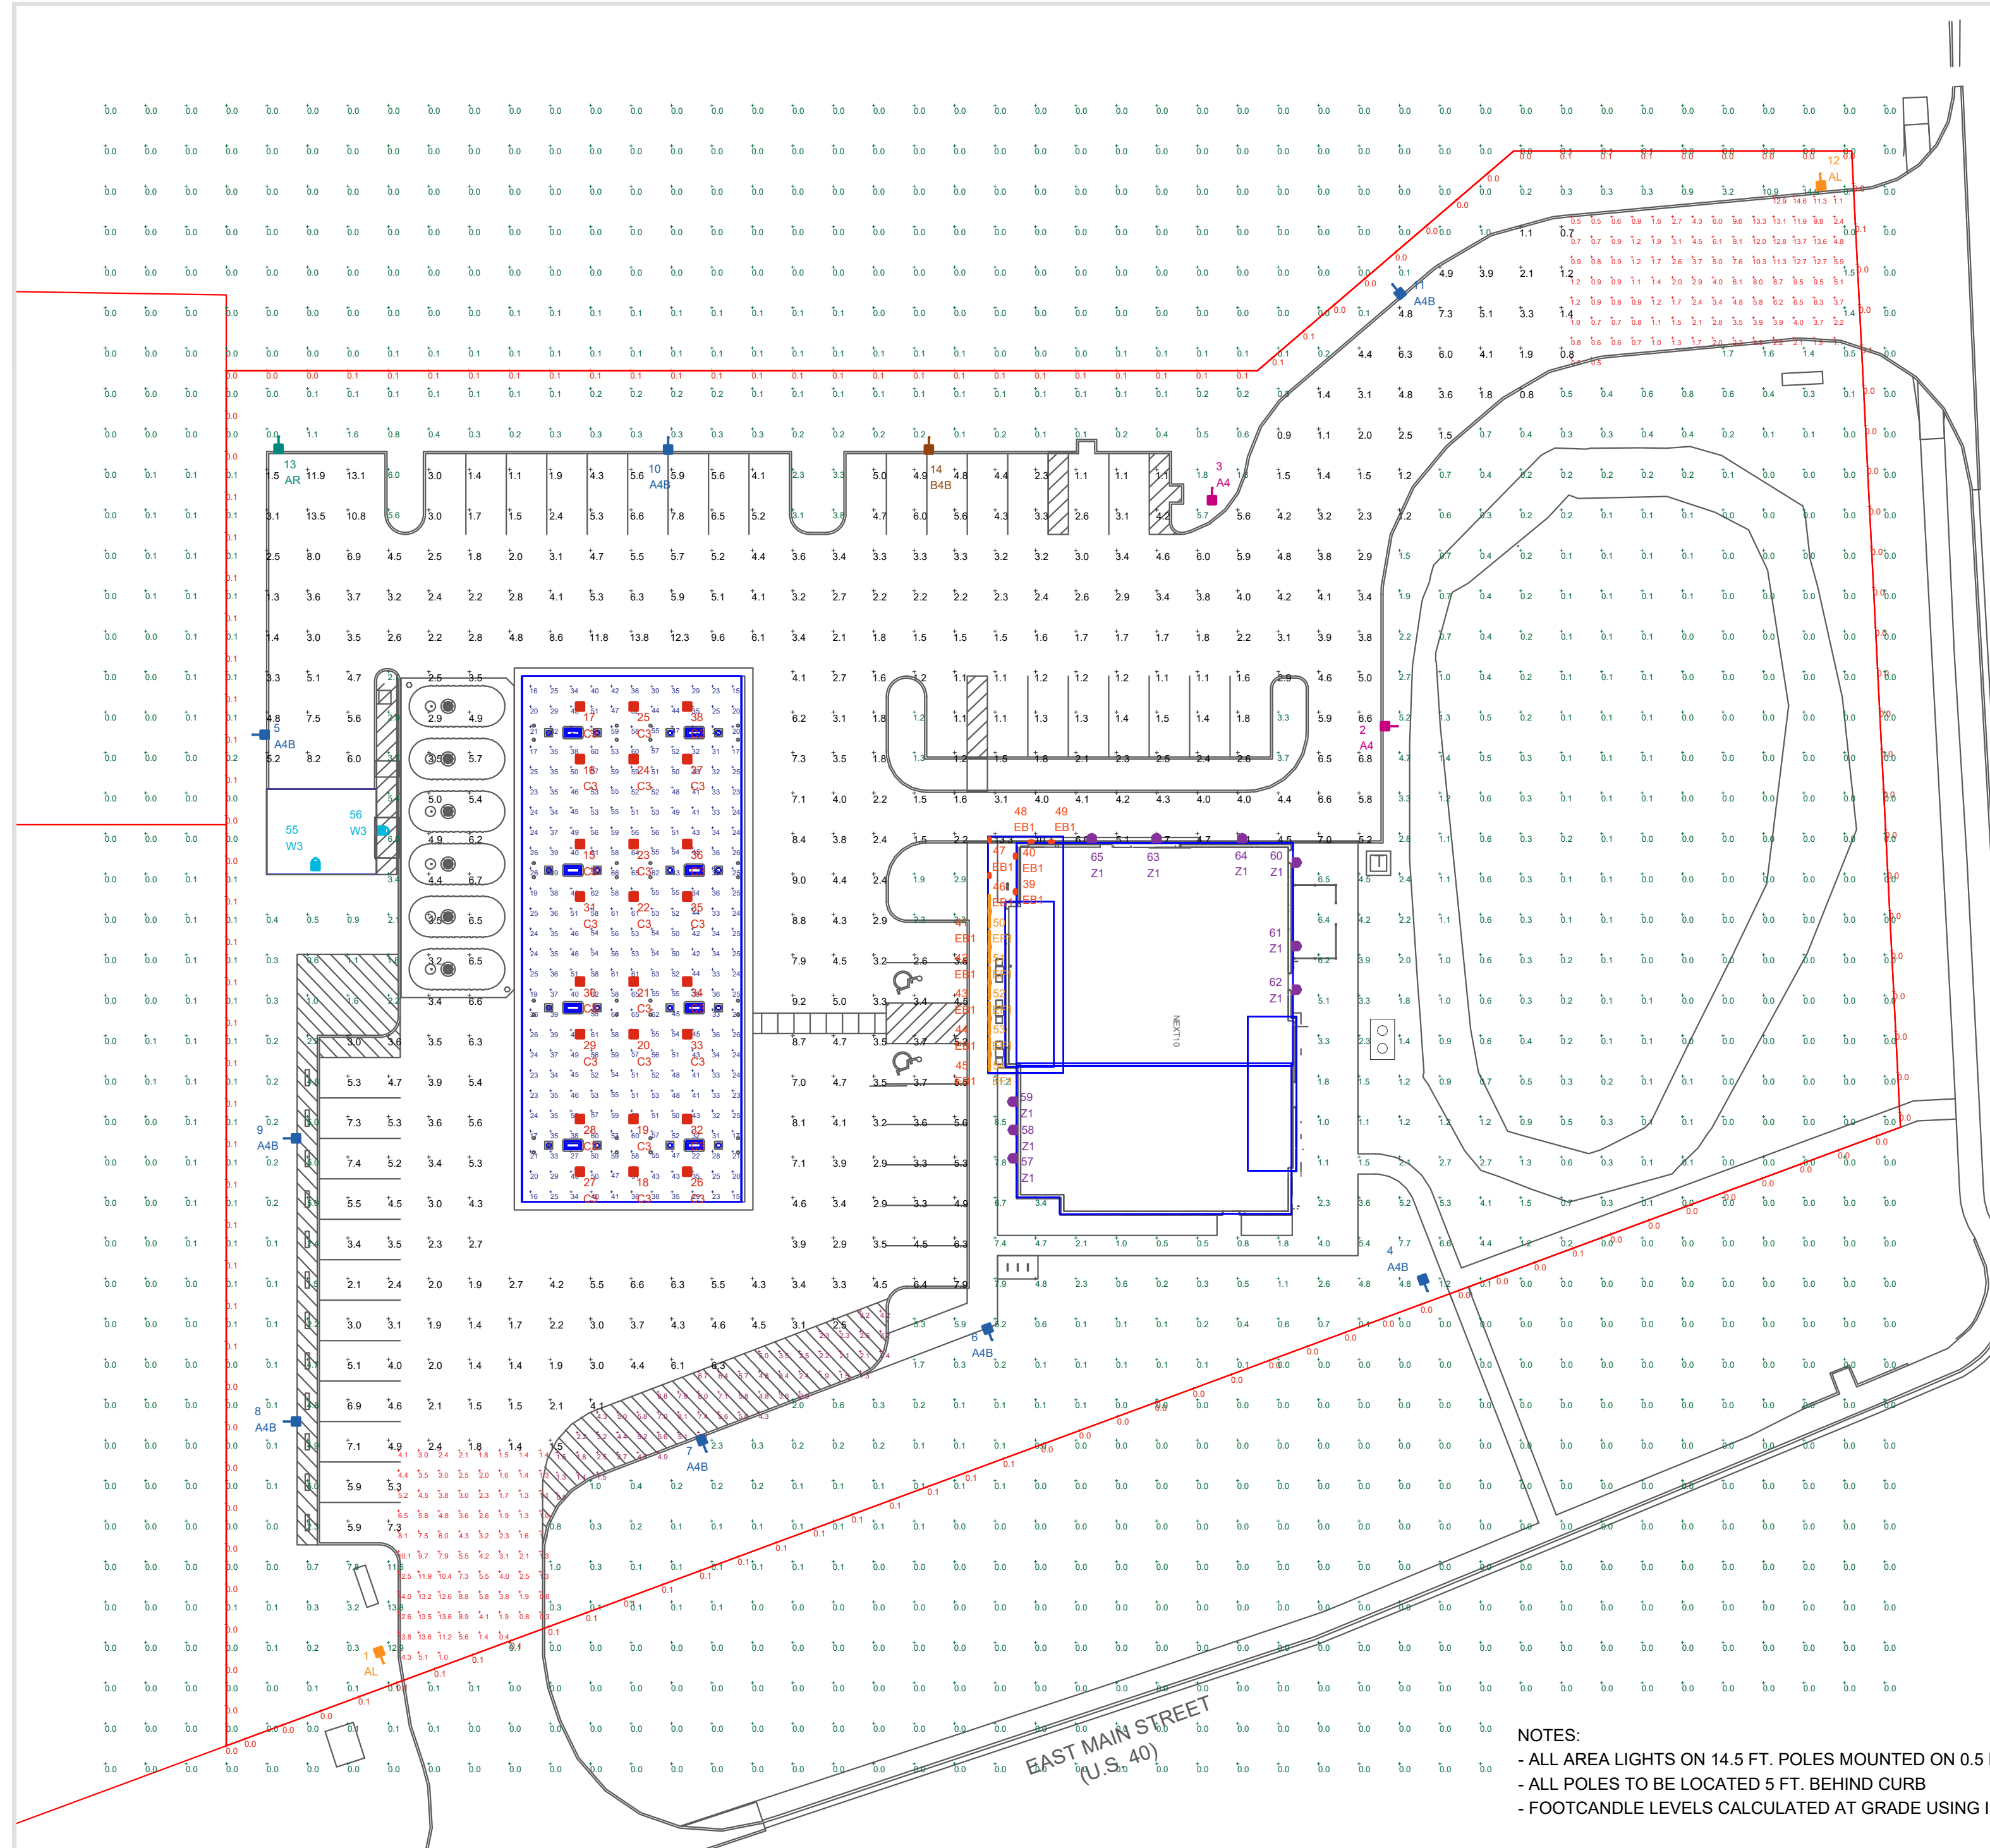

**NOTES:**  
 - ALL AREA LIGHTS ON 14.5 FT. POLES MOUNTED ON 0.5 FT. CONCRETE BASES  
 - ALL POLES TO BE LOCATED 5 FT. BEHIND CURB  
 - FOOTCANDLE LEVELS CALCULATED AT GRADE USING INITIAL LUMEN VALUES

LUM. NO.	LABEL	MTG. HT.
1	AL	15
2	A4	15
3	A4	15
4	A4B	15
5	A4B	15
6	A4B	15
7	A4B	15
8	A4B	15
9	A4B	15
10	A4B	15
11	A4B	15
12	AL	15
13	AR	15
14	B4B	15
15	C3	17.11
16	C3	17.11
17	C3	17.11
18	C3	19.32
19	C3	19.32
20	C3	19.32
21	C3	19.32
22	C3	19.32
23	C3	19.32
24	C3	19.32
25	C3	19.32
26	C3	21.53
27	C3	17.11
28	C3	17.11
29	C3	17.11
30	C3	17.11
31	C3	17.11
32	C3	21.53

LUM. NO.	LABEL	MTG. HT.
33	C3	21.53
34	C3	21.53
35	C3	21.53
36	C3	21.53
37	C3	21.53
38	C3	21.53
39	EB1	10.5
40	EB1	10.5
41	EB1	10.5
42	EB1	10.5
43	EB1	10.5
44	EB1	10.5
45	EB1	10.5
46	EB1	10.5
47	EB1	10.5
48	EB1	10.5
49	EB1	10.5
50	EF1	12
51	EF1	12
52	EF1	12
53	EF1	12
54	EF1	12
55	W3	8
56	W3	8
57	Z1	15
58	Z1	15
59	Z1	15
60	Z1	15
61	Z1	15
62	Z1	15
63	Z1	15
64	Z1	15
65	Z1	15

LABEL	AVG	MAX	MIN	AVG/MIN	MAX/MIN
CANOPY	41.73	67	15	2.78	4.47
DELIVERY AREA	4.03	8.1	0.9	4.48	9.00
ENTRANCES & EXIT DRIVES	4.56	14.6	0.3	15.20	48.67
PARKING & INTERIOR DRIVE AISLES	4.00	13.8	0.7	5.71	19.71
PROPERTY LINES	0.05	0.1	0.0	N.A.	N.A.
UNDEFINED	0.45	14.9	0.0	N.A.	N.A.

SYMBOL	QTY	LABEL	ARRANGEMENT	LUMENS	LLF	DIMMING FACTOR	BUG RATINGS	WATTS/LUMINAIRE	TOTAL WATTS	MANUFACTURER	CATALOG LOGIC
[Symbol]	2	A4	SINGLE	15141	1.030	0.730	B2-U0-G3	90.42	180.84	Lithonia Lighting	DSX0LED-P6-50K-70CRI-T3M-MVOLT-FAO-HS-XX (SW. POS. 5)
[Symbol]	8	A4B	SINGLE	12704	1.030	0.730	B0-U0-G3	90.42	723.36	Lithonia Lighting	DSX0LED-P6-50K-70CRI-BLC3-MVOLT-FAO-XX (SW. POS. 5)
[Symbol]	2	AL	Single	12822	1.030	1.000	B1-U0-G3	137	274	Lithonia Lighting	DSX0LED-P6-50K-70CRI-LCCO-MVOLT-FAO-XX
[Symbol]	1	AR	Single	12822	1.000	1.000	B1-U0-G3	137	137	Lithonia Lighting	DSX0LED-P6-50K-70CRI-RCCO-MVOLT-FAO-XX
[Symbol]	1	B4B	SINGLE	13121	1.030	0.730	B0-U0-G4	90.42	90.42	Lithonia Lighting	DSX0LED-P6-50K-70CRI-BLC4-MVOLT-FAO-XX (SW. POS. 5)
[Symbol]	24	C3	Single	15758	1.030	1.000	B3-U0-G1	89.4982	2147.957	Lithonia Lighting	RCNYLED-AL02-50K-80CRI-SYMC-MVOLT-BZS-XX (SW. POS. 5)
[Symbol]	11	EB1	Single	1388	1.000	1.000	B1-U1-G0	19	209	WAC Lighting	WP-LED119-30
[Symbol]	5	EF1	SSL-4_1	992	1.000	1.000	B1-U1-G0	17.444	348.88	FC Lighting	CVLWET1.5-4-4K-80CRI-1040
[Symbol]	2	W3	Single	1994	1.010	1.000	B0-U0-G1	14.58	29.16	Lithonia Lighting	DSXW1 LED- P2-50K-70CRI-T3M-MVOLT-XXX-HS
[Symbol]	9	Z1	Single	3348	1.000	1.000	B1-U0-G1	25.4	228.6	COOPER LIGHTING SOLUTIONS - McGRAW-EDISON	ISC-SA18-740-U-SL4-WH

REV.	BY	DATE	DESCRIPTION
R1	LMP	02/25/26	REVISED TO REDUCE LIGHT SPILL AT DRIVES

**DISCLAIMER**  
 ANY SITE PLAN(S), FLOOR PLAN(S), RENDERING(S), LIGHTING LAYOUT(S) AND PHOTOMETRIC PLAN(S) INCLUDING BUT NOT LIMITED TO ANY PROJECT(S) CREATED/PRODUCED BY RED LEONARD ASSOCIATES INC., ARE ONLY INTENDED FOR ILLUSTRATION AND QUOTING PURPOSES ONLY. RED LEONARD ASSOCIATES HAS THE RIGHT TO USE THIRD PARTY LASERS, SCANNERS, AND CAMERAS BUT ACTUAL PROJECT CONDITIONS, DIMENSIONS, AND ACCURACY OF MEASUREMENTS MAY DIFFER FROM THESE OR ANY PARAMETERS. RED LEONARD ASSOCIATES INC. ASSUMES NO LIABILITY FOR WHAT IS CREATED/PRODUCED IN THESE RENDERINGS. THIS INCLUDES BUT IS NOT LIMITED TO THE USE OF, INSTALLATION OF AND/OR INTEGRITY OF EXISTING BUILDING(S), SURROUNDING AREA FOR PROJECT(S) SUCH AS EXISTING POLES(S), ANCHOR BOLTS(S), BASE(S), ARCHITECTURAL AND SIGNAGE STRUCTURE(S), LANDSCAPING PLAN(S), LIGHTING PLAN(S), FIXTURE SELECTION(S) AND PLACEMENT, MATERIAL(S), COLOR ACCURACY, TEXTURE(S), AND ANYTHING ATTRIBUTED TO PHOTO REALISM THAT IS CREATED. FURTHERMORE, RED LEONARD ASSOCIATES INC. DOES NOT ASSUME LIABILITY WHATSOEVER FOR ANY PURCHASES MADE BY CLIENT BEFORE, DURING, OR AT THE CONCLUSION OF THE PUBLISHED WORK. THE CUSTOMER, ITS RELATIVE AFFILIATES, AS WELL AS ANY OTHER PERSON(S) IN VIEWING OF THIS PRODUCT IS RESPONSIBLE FOR VERIFYING COMPLIANCE WITH ANY BUT NOT LIMITED TO ALL CODES, PERMITS, RESTRICTIONS, INSTRUCTIONS, PURCHASES, AND INSTALLATIONS OF OBJECTS VIEWED WITHIN THIS DOCUMENT(S) OR PROJECT(S). SYMBOLS ARE NOT DRAWN TO SCALE. SIZE IS FOR CLARITY PURPOSES ONLY. SIZES AND DIMENSIONS ARE APPROXIMATE. ACTUAL MEASUREMENTS MAY VARY. DRAWINGS ARE NOT INTENDED FOR ENGINEERING OR CONSTRUCTION USE. THIS DOCUMENT, ANY RED LEONARD DRAWING(S) OR PROJECT(S) IS NOT TO BE USED AND/OR INTENDED FOR ENGINEERING OR CONSTRUCTION PURPOSES, BUT FOR ILLUSTRATIVE PURPOSES ONLY. ANY LOCATIONS OF EMERGENCY LIGHTING SHOWN WERE PROVIDED BY OTHERS. RED LEONARD ASSOCIATES IS NOT RESPONSIBLE FOR INSUFFICIENT LIGHTING DURING AN EMERGENCY EVENT. ANY USE OF THIS DOCUMENTATION AND/OR OTHER ARTICLES PRODUCED BY RED LEONARD WITHOUT WRITTEN AUTHORIZATION FROM JAVINE J. LEONARD IS STRICTLY PROHIBITED.

SCALE: 1" = 30'  
 LAYOUT BY: LMP  
 DWG SIZE: D  
 DATE: 01/15/26

PROJECT NAME:  
**WAWA #7433**  
**PLAINFIELD, IN**  
 DRAWING NUMBER:  
**RL-10941-S1-R1**

