


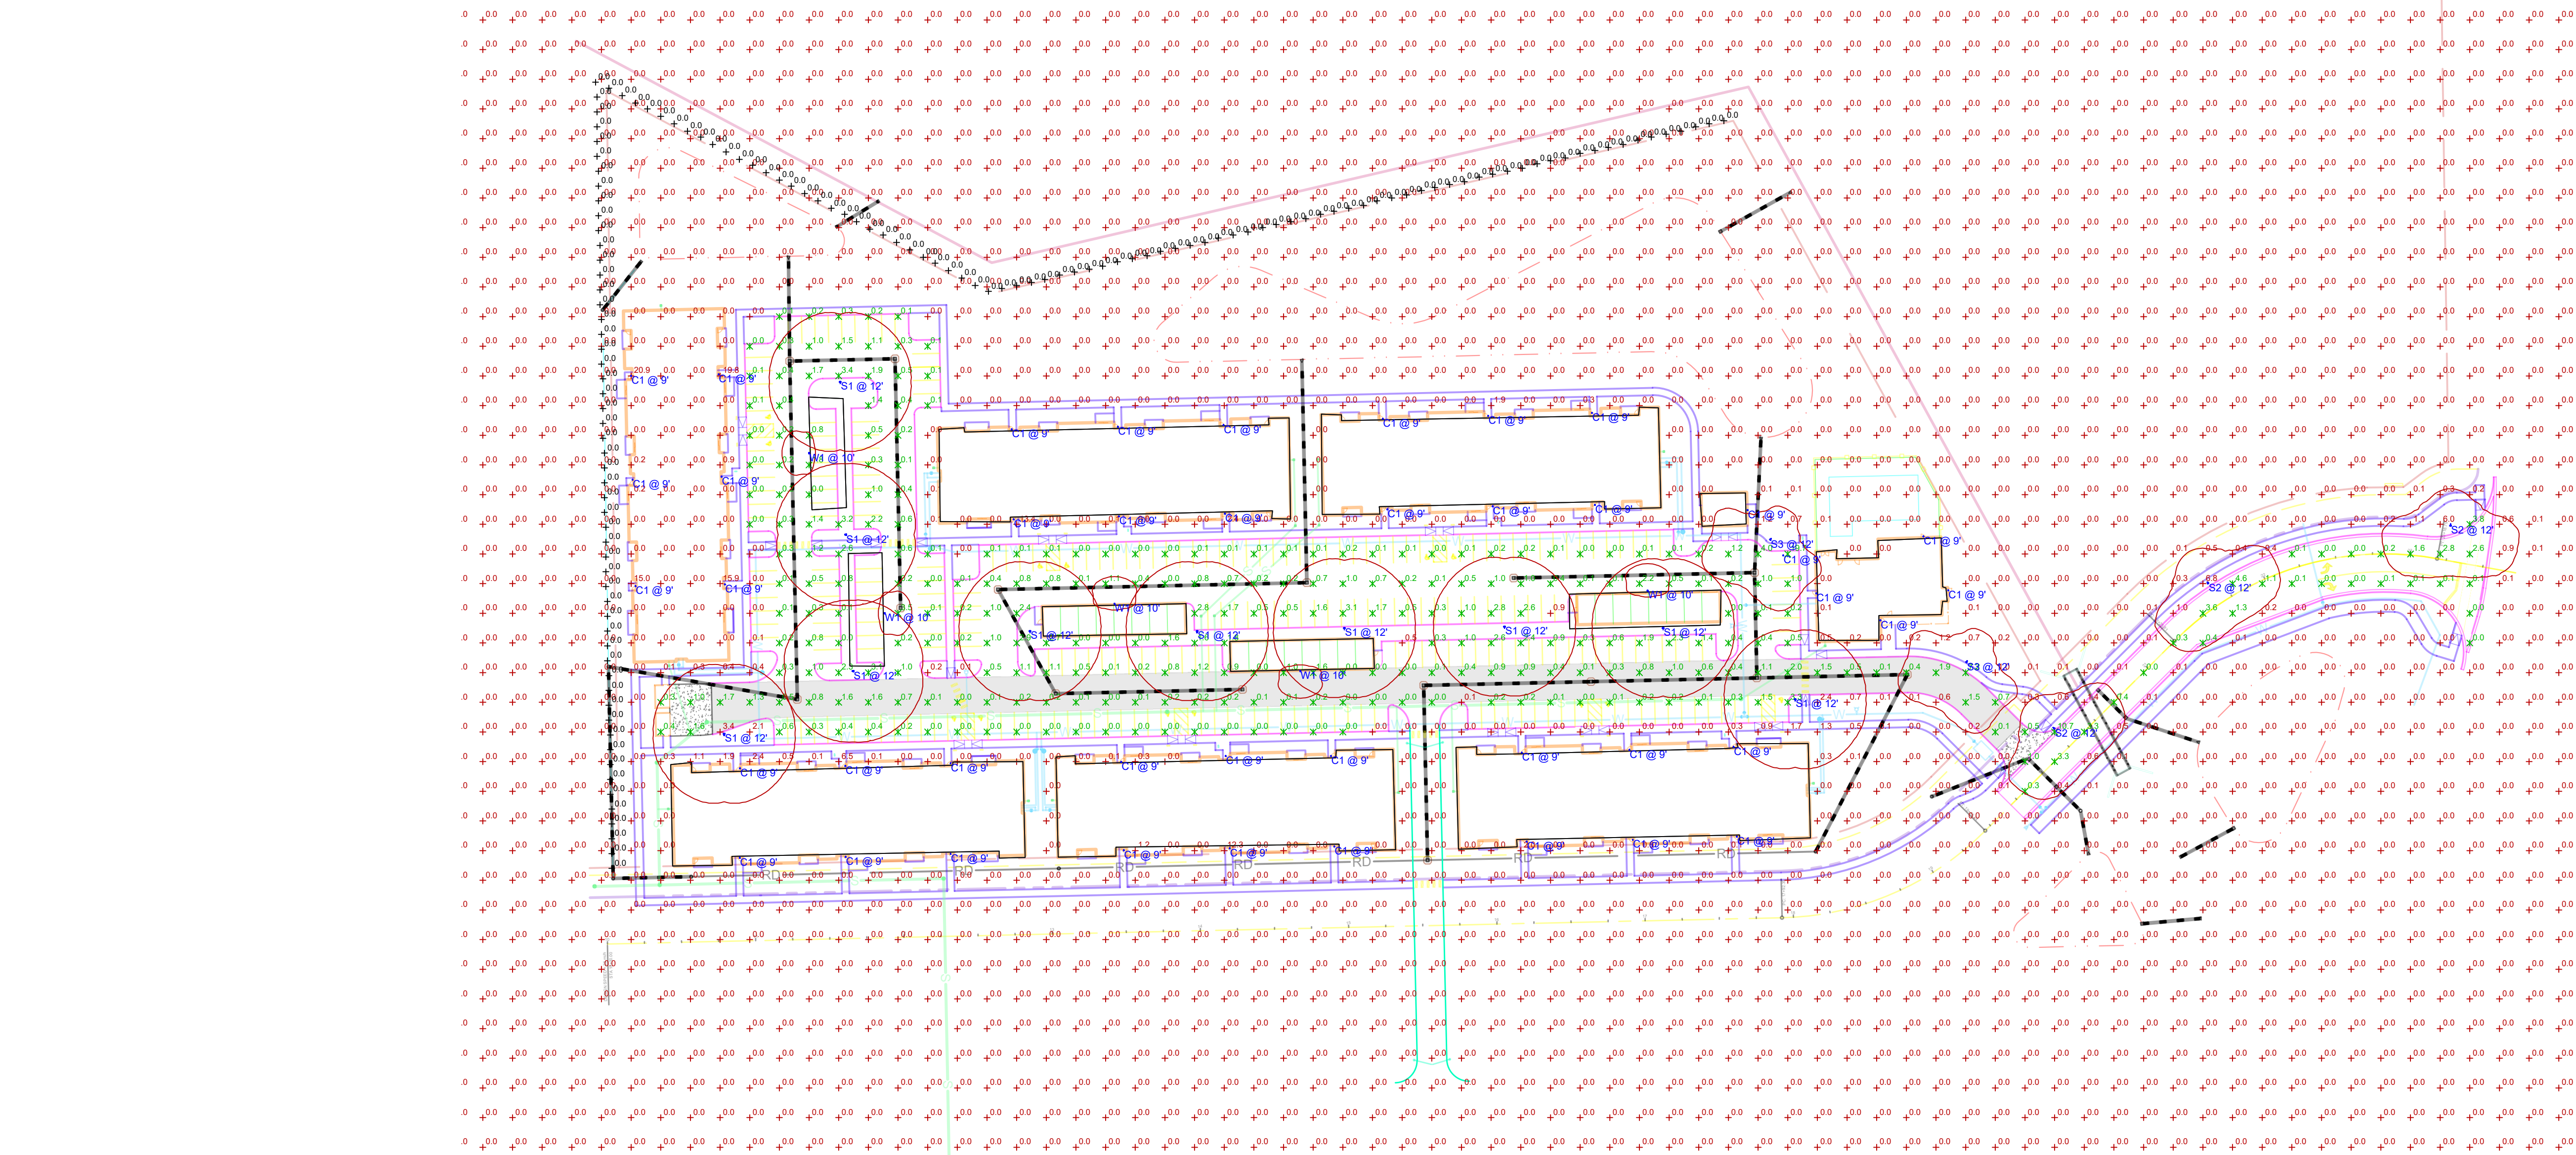

LIGHTING PHOTOMETRIC
SCALE : $\frac{1}{64}$ " = 1FT

Statistics						
Description	Symbol	Avg	Max	Min	Max/Min	Avg/Min
Paved Areas_Grade	✕	0.8 fc	19.7 fc	0.0 fc	N/A	N/A
Property Line_Grade	+	0.0 fc	0.0 fc	0.0 fc	N/A	N/A
Site_Grade	+	0.0 fc	20.9 fc	0.0 fc	N/A	N/A

Schedule						
Symbol	Label	Quantity	Manufacturer	Catalog Number	Description	Lumens Per Lamp
	S1	10	Lithonia Lighting	RSX1 LED P2 30K R5 MVOLT SPA XXXXX/ MOUNTED AT 12'-0" ON 9'-6" SSS 4C DM18A8 XXXXX POLE WITH 2'-6" BASE	RSX Area Fixture Size 1 P2 Lumen Package 3000K CCT Type R5 Distribution	9198
	S2	3	Lithonia Lighting	RSX1 LED P2 30K R3 MVOLT SPA XXXXX/ MOUNTED AT 12'-0" ON 9'-6" SSS 4C DM18A8 XXXXX POLE WITH 2'-6" BASE	RSX Area Fixture Size 1 P2 Lumen Package 3000K CCT Type R3 Distribution	8959
	S3	2	Lithonia Lighting	RSX1 LED P1 30K R4 MVOLT SPA XXXXX/ MOUNTED AT 12'-0" ON 9'-6" SSS 4C DM18A8 XXXXX POLE WITH 2'-6" BASE	RSX Area Fixture Size 1 P1 Lumen Package 3000K CCT Type R4 Distribution	6543
	W1	5	Lithonia Lighting	WEDGE2 LED P1 30K 80CRI VW	WEDGE2 LED WITH P1 - PERFORMANCE PACKAGE, 3000K, 80CRI, VISUAL COMFORT WIDE OPTIC	1241
	C1	42	Gotham Architectural Lighting	EVORSH 30/20 DFF SMO	EVO 6IN SHOWER, 3000K, 2000LM, FLUSH CLEAR, 80CRI	1729
						Light Loss Factor
						Wattage

Disclaimer:
This lighting submital is strictly based on the information provided to L&L Source, and is provided without warranty as to accuracy, completeness, reliability or otherwise. If the information (including but not limited to floor plans, reflected ceiling plans, electrical plans and specifications) provided to L&L Source is incomplete or not current (i.e., newer versions exist), the accuracy of proposed design may be adversely affected. Once this lighting submital is received by the customer or end-user (as applicable) it is the obligation of the customer or end-user (as applicable) to consult with a professional engineering advisor to determine whether the proposed design meets the applicable project requirements for lighting system performance, code compliance, safety, suitability and effectiveness for use in a particular application. In no event will L&L Source be responsible for any loss resulting from any use of any information contained in this lighting submital.

GENERAL NOTES

GENERAL PLAN NOTES:

- MH: AS NOTED
- POINTS CALCULATED AT: GRADE
- LIGHT LOSS FACTOR: AS NOTED

No.	Revision/Issue	Date

Firm Name and Address

LIGHT|source

THE LIGHTING & CONTROLS EXPERTS

8719 CASTLE PARK DRIVE
INDIANAPOLIS, IN 46256
WWW.LIGHTSOURCEINDIANA.COM
p.317-598-6900

Project Name and Address

VILLAGE AT PLANK
ROAD

EXTERIOR LIGHTING PHOTOMETRIC

Drawn By

ARH

Scale

As Noted

Date

7/7/2026

Drawing #

LS-22-2418 SITE R5

Sheet No.

E101