




○ **DUMPSTER PLAN**
SCALE: 1/4"=1'-0"

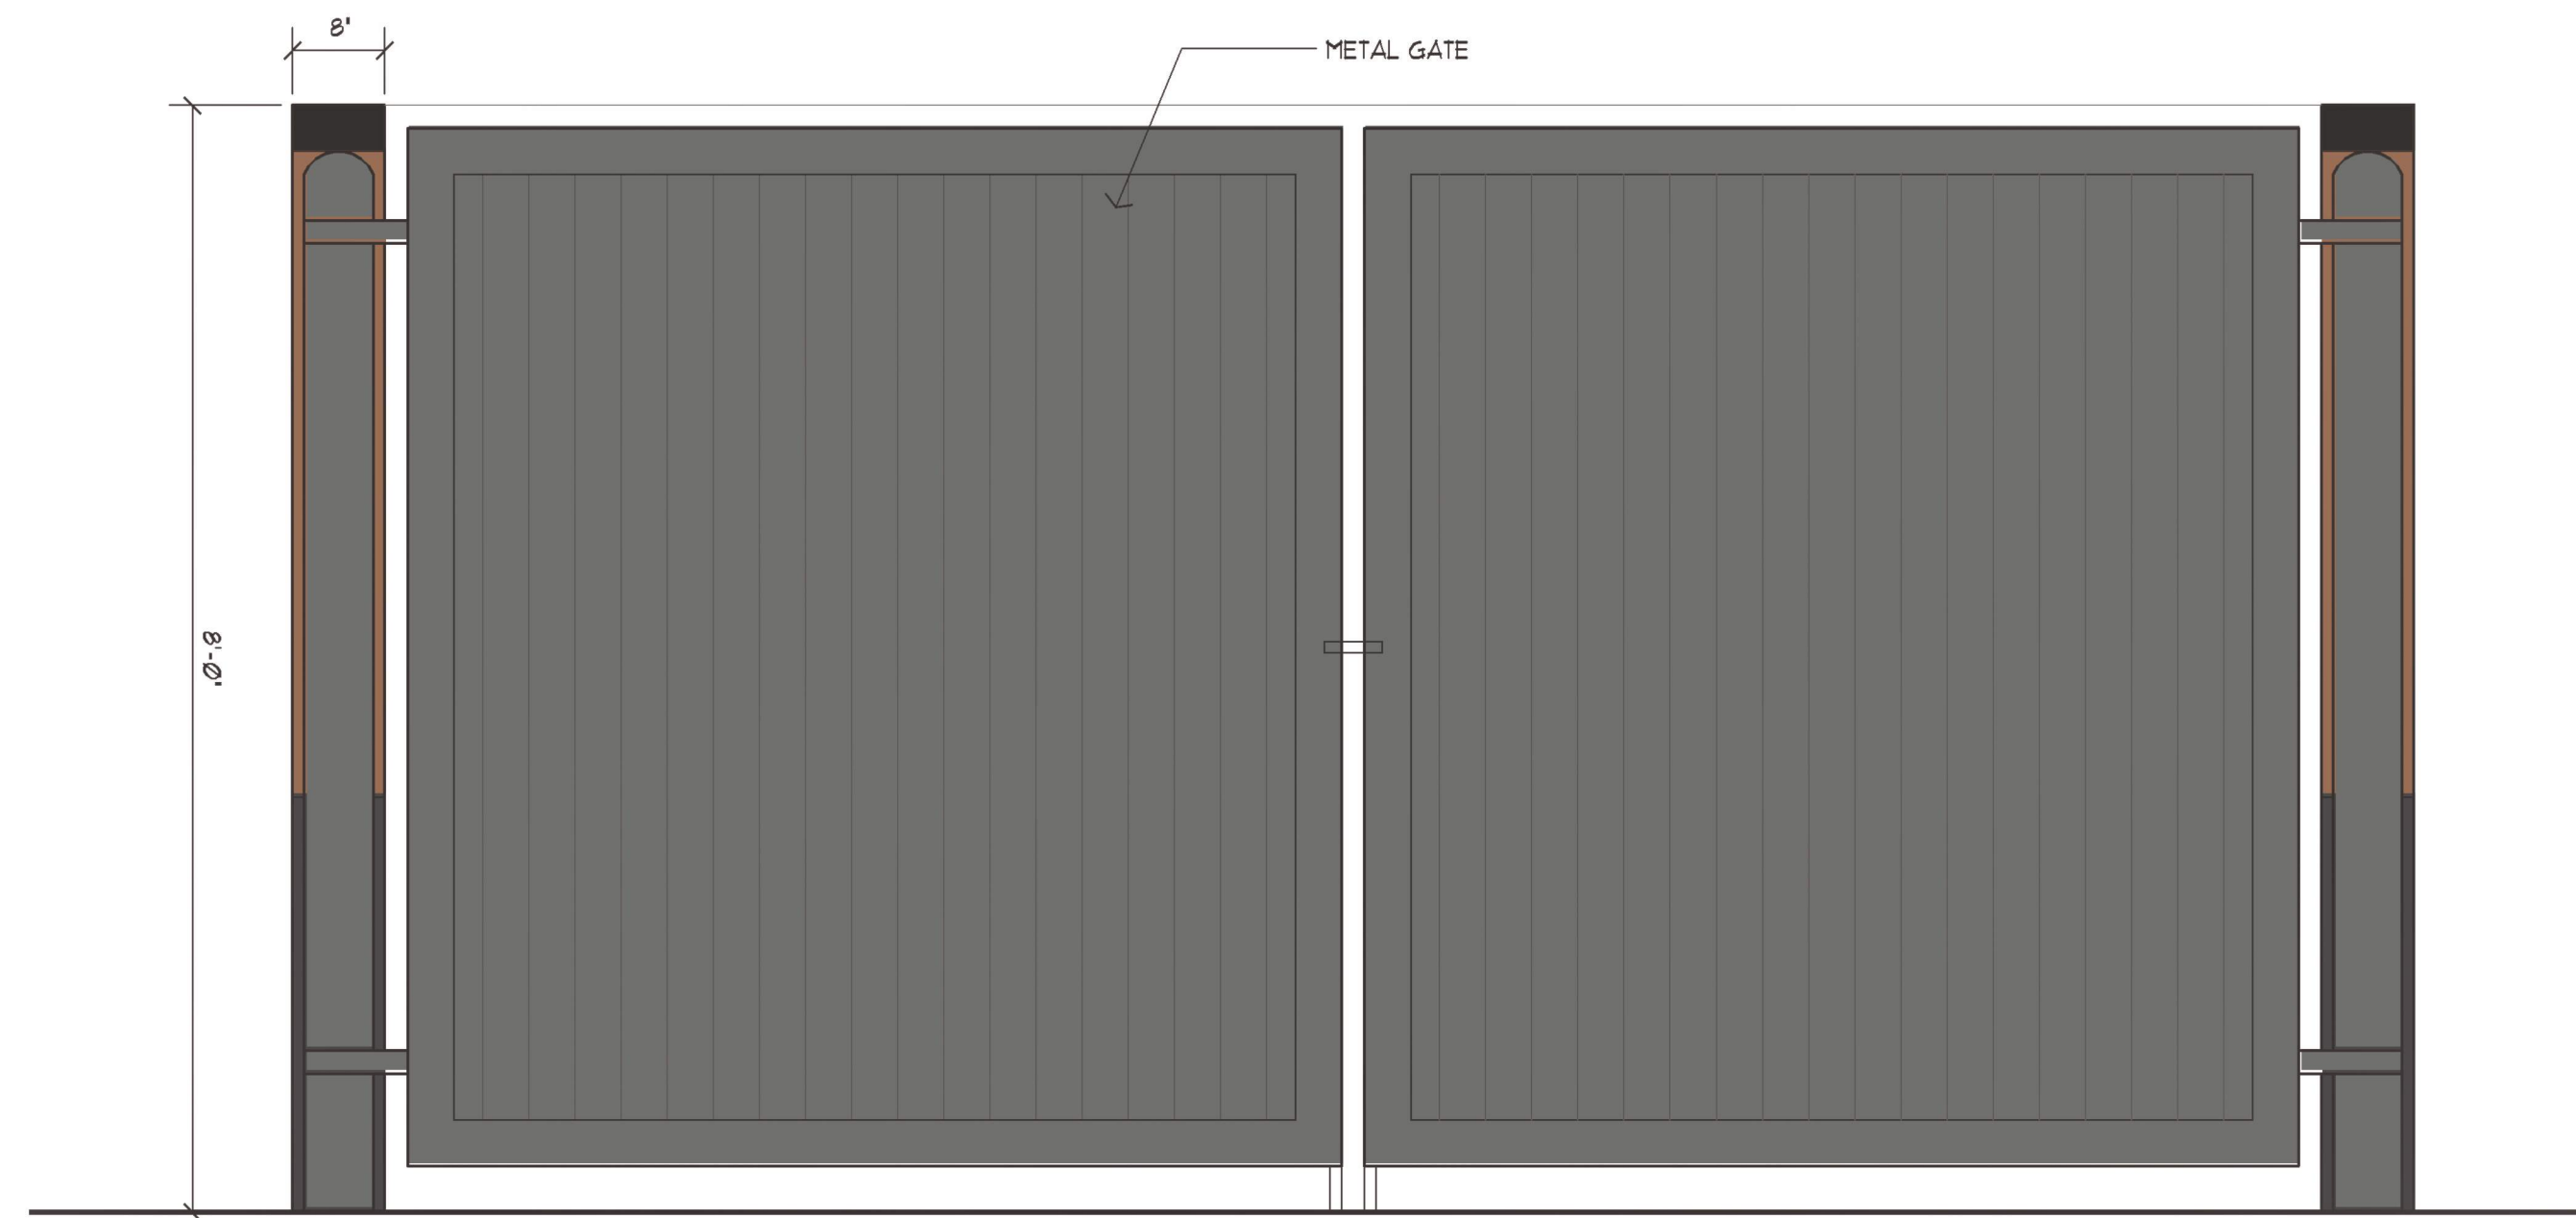

○ **FRONT ELEVATION**
SCALE: 3/4"=1'-0"

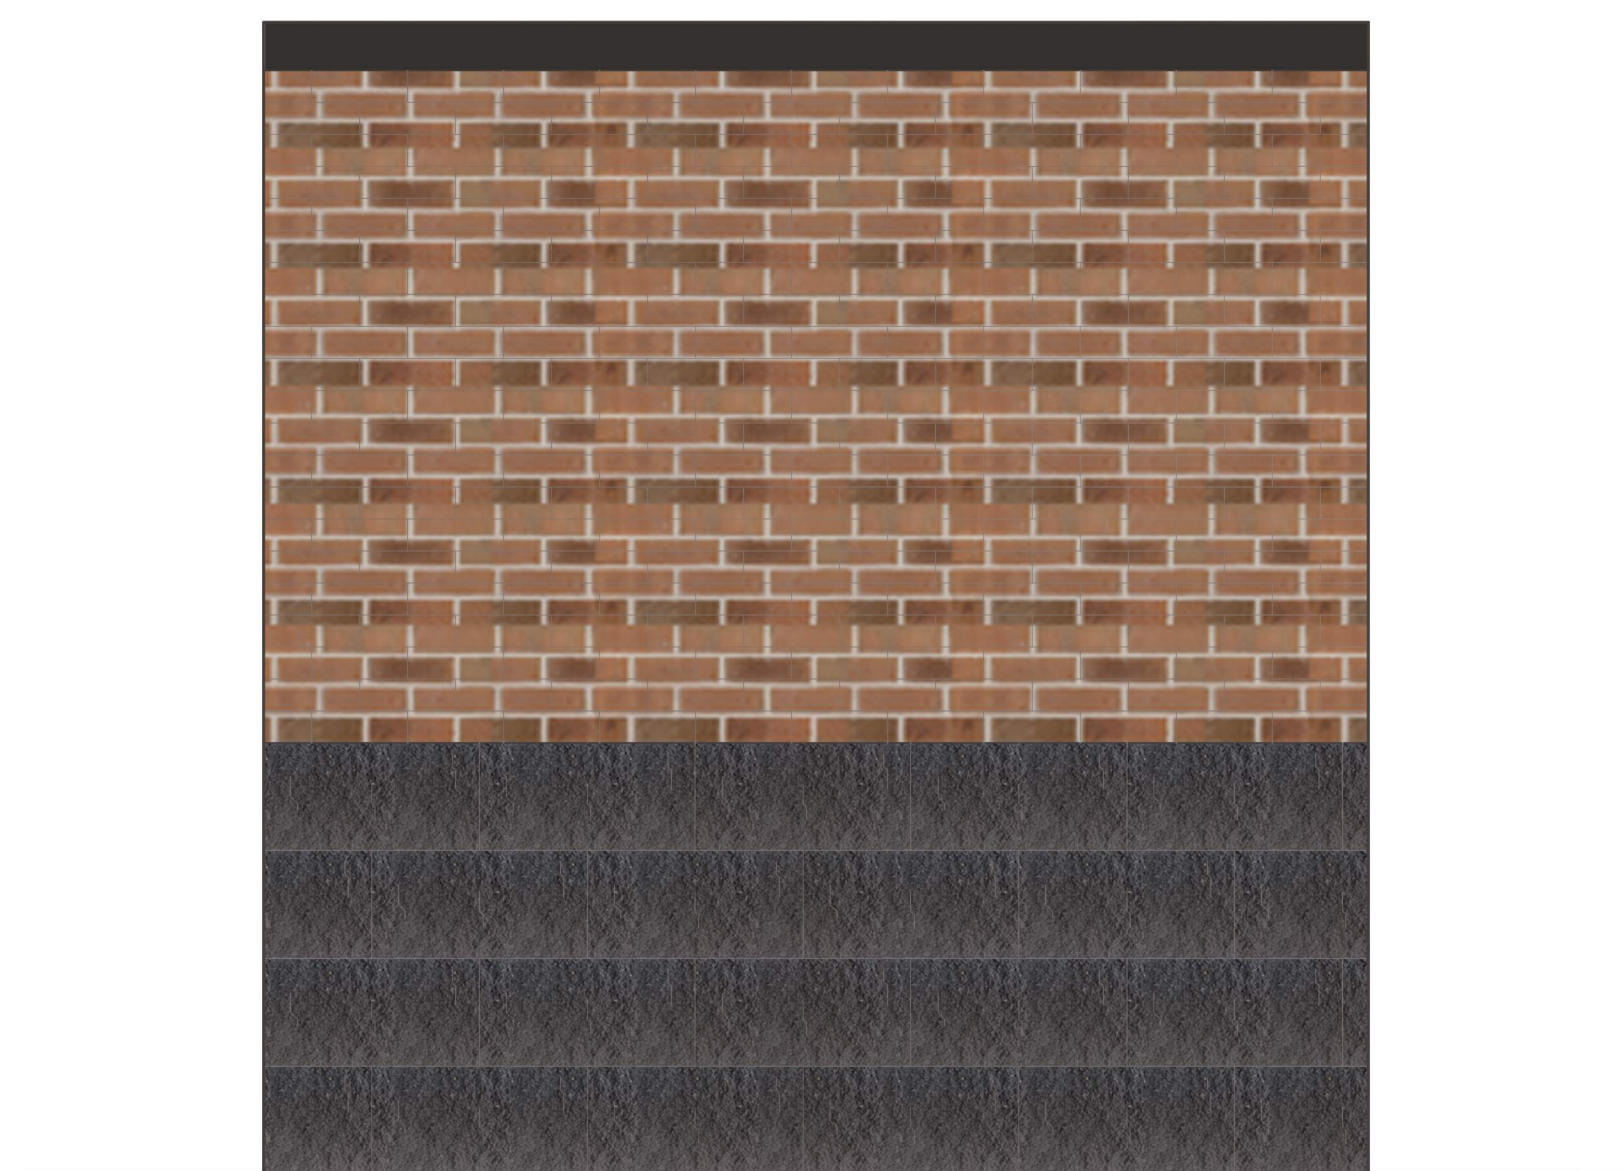

○ **SIDE ELEVATION**
SCALE: 3/4"=1'-0"

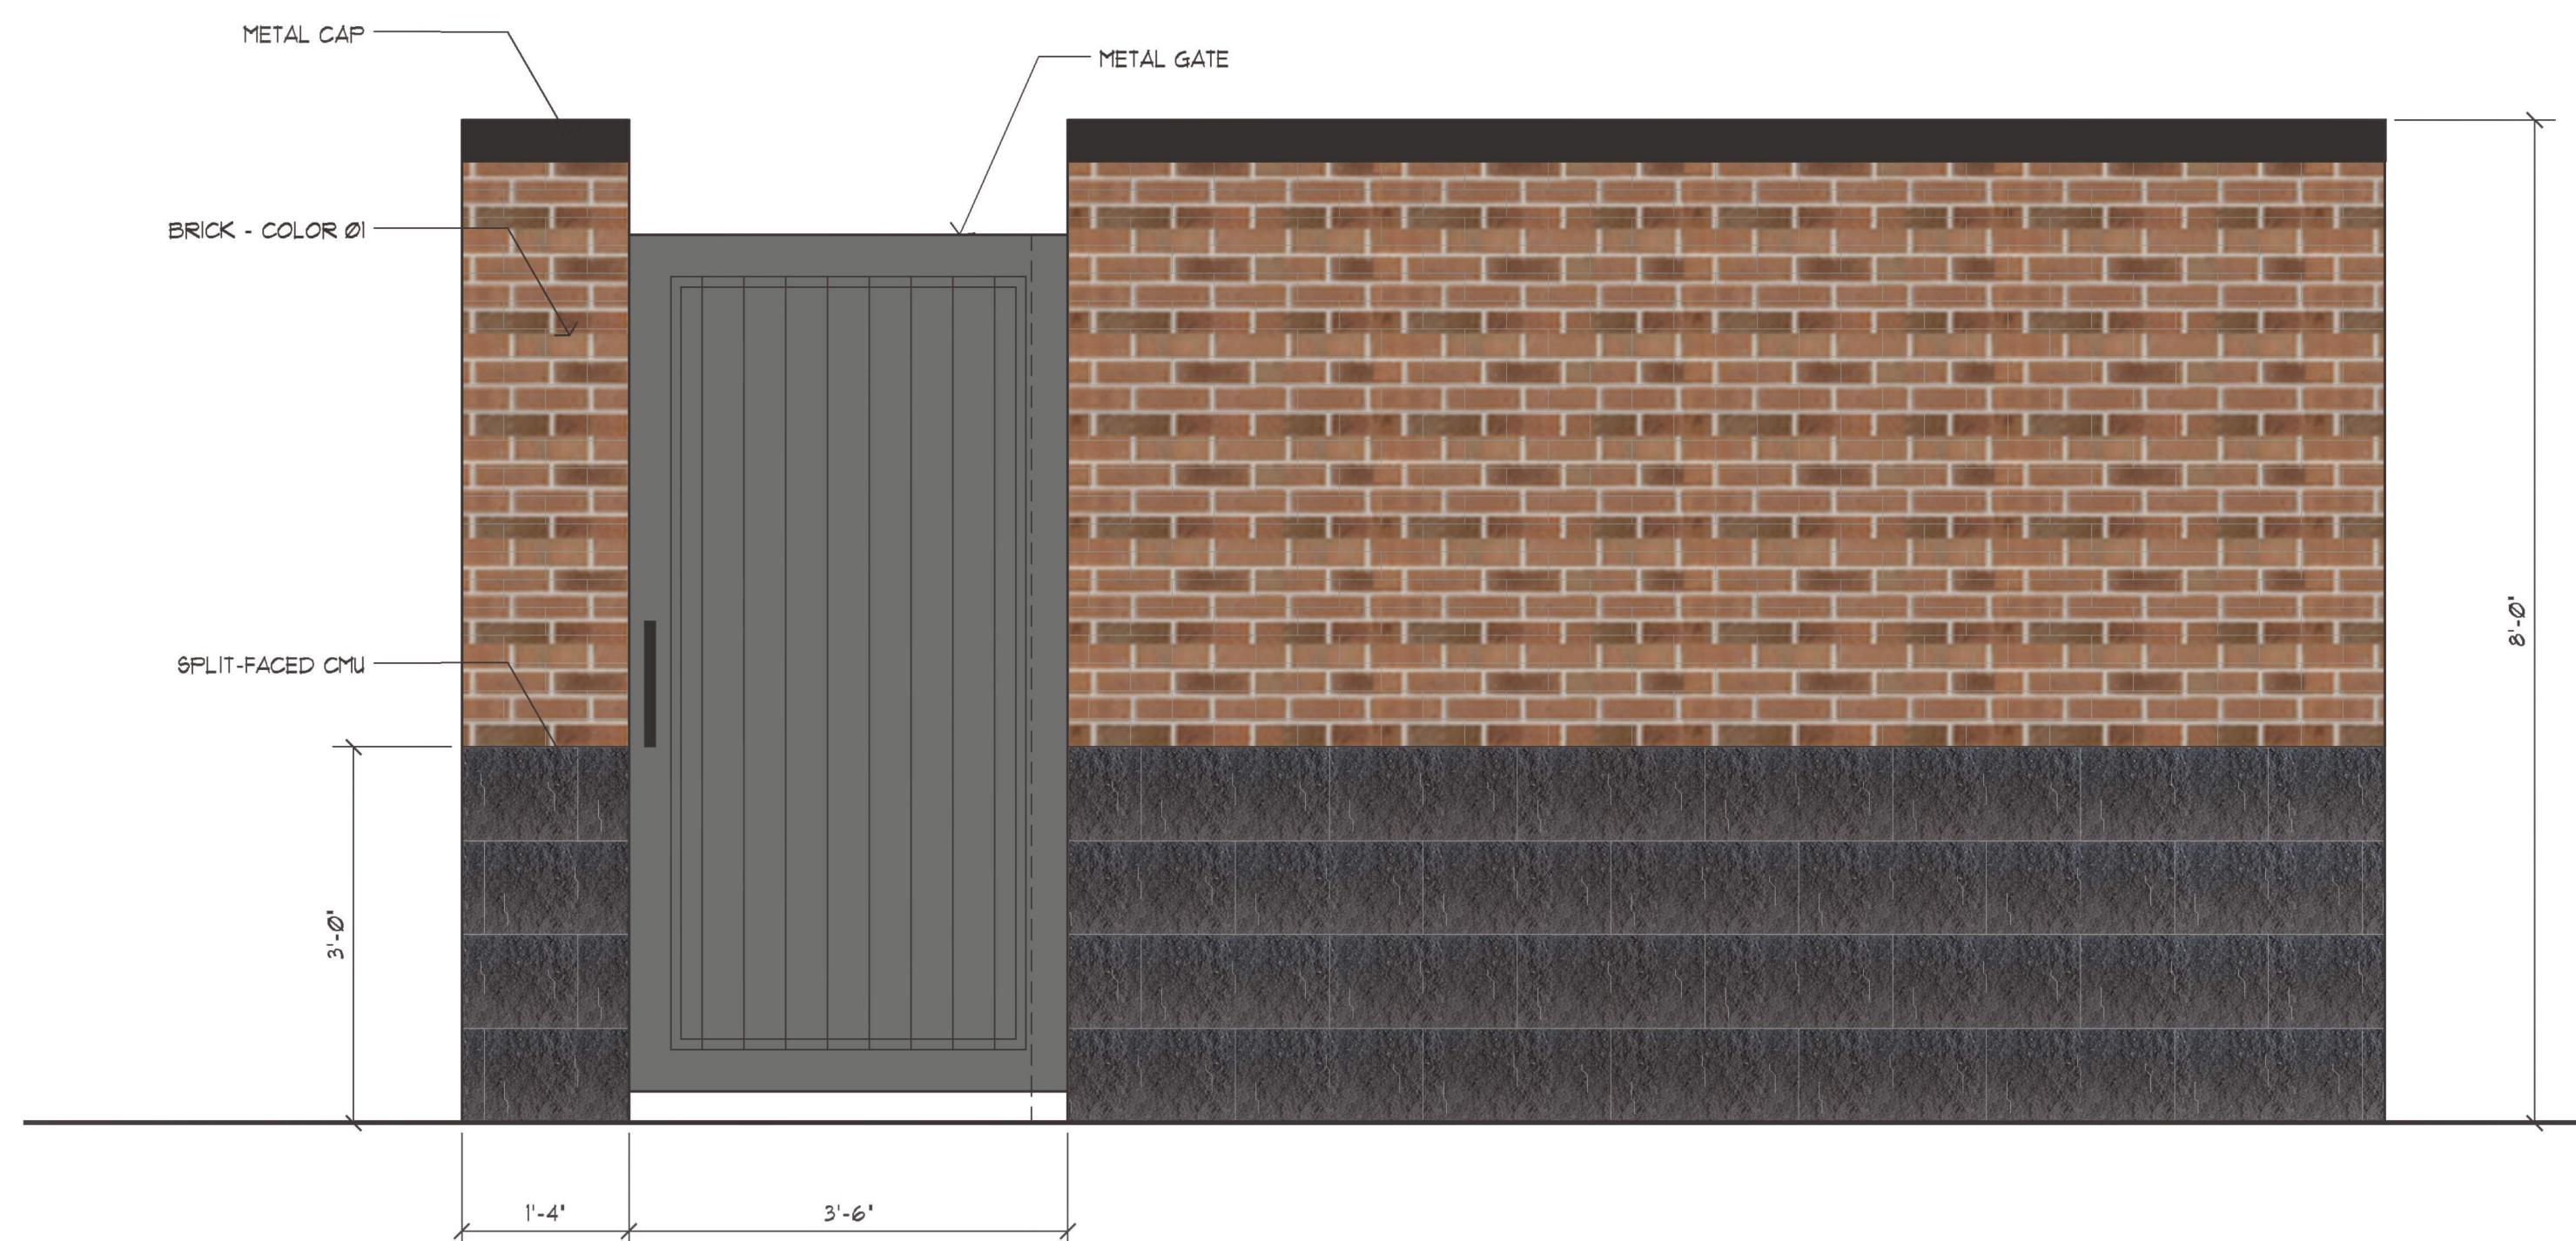

○ **REAR ELEVATION**
SCALE: 3/4"=1'-0"

petersonARCHITECTURE
298 South 10th Street Suite 500
Noblesville, IN 46060
p 317.770.9714
f 317.770.9718
petersonarchitecture.com

NEW CONSTRUCTION
KID CITY
140 E MAIN STREET
PLAINFIELD, INDIANA
JRF CONSTRUCTION

PRELIMINARY DESIGN

DECEMBER 2023

REVISIONS:

- △ REVISION DATE
- △ REVISION DATE
- △ REVISION DATE
- △ REVISION DATE
- △ REVISION DATE

PLOT DATE: 2024-01-04

DRAWN BY: TANKER

CHECKED BY: -

PROJECT NUMBER: 23-0104

DUMPSTER ENCLOSURE

A202

THESE DRAWINGS ARE GIVEN IN CONFIDENCE AND SHALL BE USED ONLY IN PURSUANT TO THE AGREEMENT WITH PETERSON ARCHITECTURE, P.C. NO OTHER USE OR REPLICATION MAY BE MADE WITHOUT THE PRIOR WRITTEN CONSENT OF PETERSON ARCHITECTURE, P.C. ALL OTHER COPYRIGHT AND COMMON LAW RIGHTS ARE HEREBY SPECIFICALLY RESERVED.