

**NOTES**

1. MOUNTING HEIGHT (MH) VARIES. SEE FIXTURE LABEL ON PLAN.
2. HORIZONTAL MEASUREMENTS TAKEN ALONG A HORIZONTAL PLANE AT GRADE.
3. REFER TO ARCHITECTURAL DESIGN PLANS FOR LIGHT POLE BASE DETAIL.

ISSUANCE SCHEDULE	DESCRIPTION
NUMBER	DATE



PACE AIR FREIGHT HQ  
**INDIANA LIFE SCIENCES PARK**

PLAINFIELD, INDIANA

PROJECT NO: 82429.12  
DATE ISSUED: 10/18/2024  
DESIGNED BY:  
DRAWN BY:  
CHECKED BY: JGM

SHEET NAME:  
PHOTOMETRIC PLAN

SHEET NO:  
**C-701**

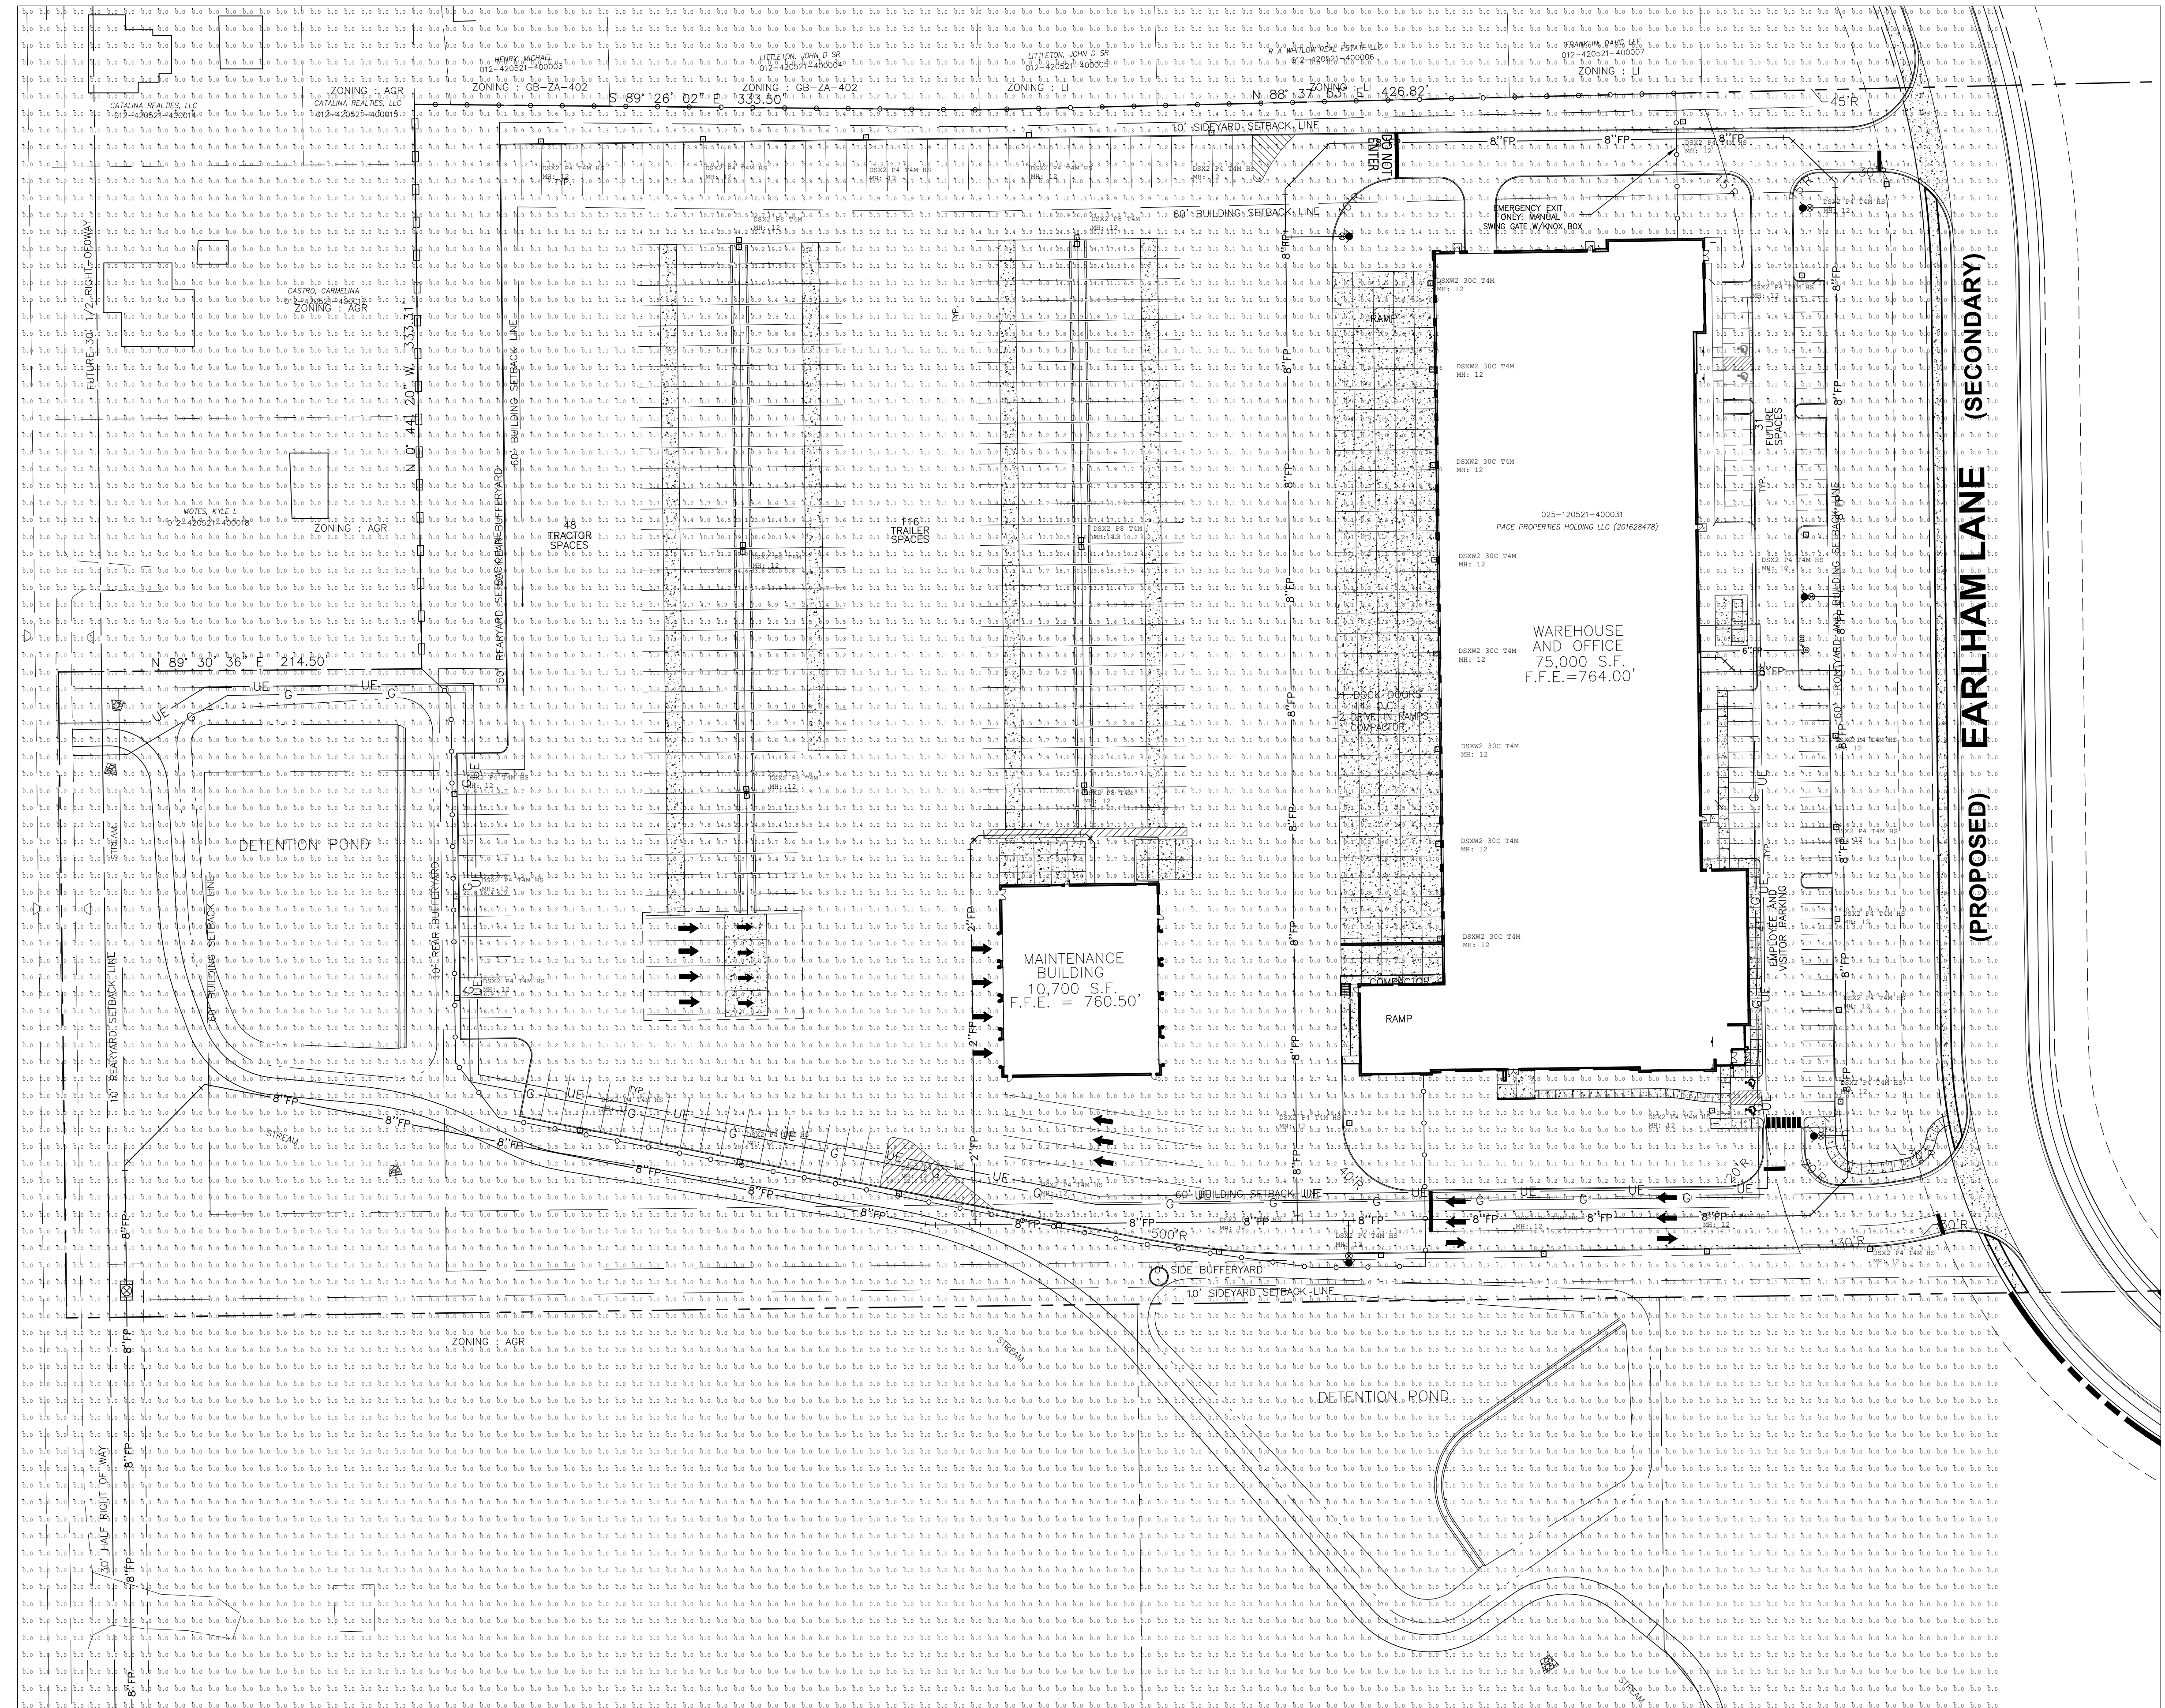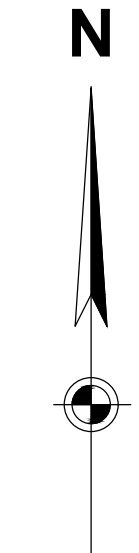

Luminaire Schedule			Arrangement	Description	LLF	Luminaire Lumens	Luminaire Watts	Total Watts
Symbol	Qty	Tag						
□	28	DSX2 P4 T4M HS	Single	DSX2 LED P4 40K T4M MVOLT HS	0.900	25365	270	7560
□	8	DSXW2 30C T4M	Single	DSXW2 LED 30C 1000 40K T4M MVOLT	0.900	11128	109	872
□	6	DSX2 P8 T4M	Back-Back	DSX2 LED P8 40K T4M MVOLT	0.900	48142	431	5172