


UTILITY PROVIDERS


- | | |
|--|--|
| <p>WATER
Plainfield Water Dept.
986 South Center Street
Plainfield, IN 46168
(317) 839-3490
Attn: Shannon Swan</p> <p>SEWERS
Plainfield Sewer Dept.
206 West Main St.
Plainfield, IN 46168
(317) 839-2561
Attn: Tim Belcher</p> <p>GAS
Vectren
8399 Zionsville Rd
Indianapolis, IN 46268
(317) 718-3604
Attn: Gerry Jones</p> <p>INDOT
Indiana Department of Transportation
Leetha Coffey
leetha@indot.in.gov
41 West 300 North
Crawfordsville, IN 47933
PH 765-362-9484</p> | <p>ELECTRIC
Duke Energy
5055 East Main Street
Danville, IN 46122
(317) 745-1006
Attn: Brian Bantley</p> <p>CABLE TELEVISION
Brighthouse
3030 Roosevelt Ave.
Indianapolis, IN 46218
(317) 632-9077 ext 291
Attn: Design Department</p> <p>TELEPHONE
AT&T
240 N Meridian St. Room 280
Indianapolis, IN 46204
(317) 610-5423
Attn: Michael Carter</p> <p>ELECTRIC
Duke Energy Asset Protection
2727 Central Ave.
Columbus, IN 47201
(812) 375-2021
Attn: Gary McKamee</p> |
|--|--|

UTILITY HOTLINE: 1-800-362-5444 within Indiana 1-800-428-5200 outside Indiana
 Note: The nature, size and location of utilities are per plans and locations provided by the respective utility companies together with field observation. The above list constitutes some, if not all, of the utility companies which provide service in the area; and adjacent to, the subject property, based upon information available through such plans and locations, by incidental visual inspection. All utility companies should be notified prior to any excavation for field location of services and verification of size and nature of services.

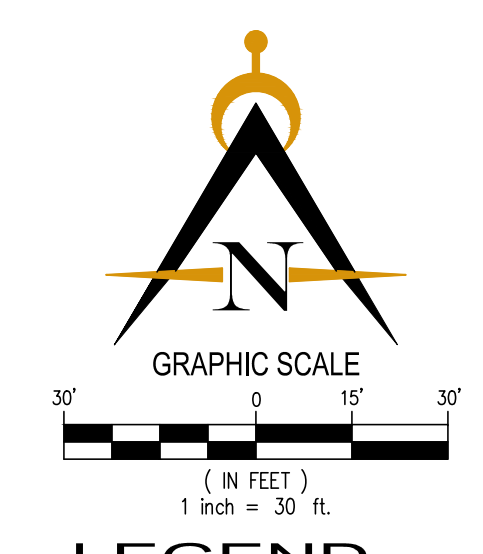

- LEGEND**
- Existing Storm Sewer
 - New Storm Sewer Downspout Drain
 - Existing Sanitary Sewer
 - Existing Underground Gas Main
 - Existing Underground Telephone
 - Existing Water Main
 - Existing Underground Electric
 - Existing Flowline
 - Existing Overhead Utilities
 - New Water Service
 - New Telephone Service
 - New Electric Service
 - New Gas Service
 - New Cable TV Service
 - ▨ New Pavement Construction
 - ▨ New Building Expansion

NOTE
 IT SHALL BE THE RESPONSIBILITY OF EACH SUBCONTRACTOR TO VERIFY ALL EXISTING UTILITIES AND CONDITIONS THAT PERTAIN TO THEIR PHASE OF WORK PRIOR TO START OF WORK. IT SHALL ALSO BE THE RESPONSIBILITY OF EACH SUBCONTRACTOR TO CONTACT THE OWNERS OF THE UTILITIES FOR PROPER STAKE LOCATIONS PRIOR TO START OF WORK.

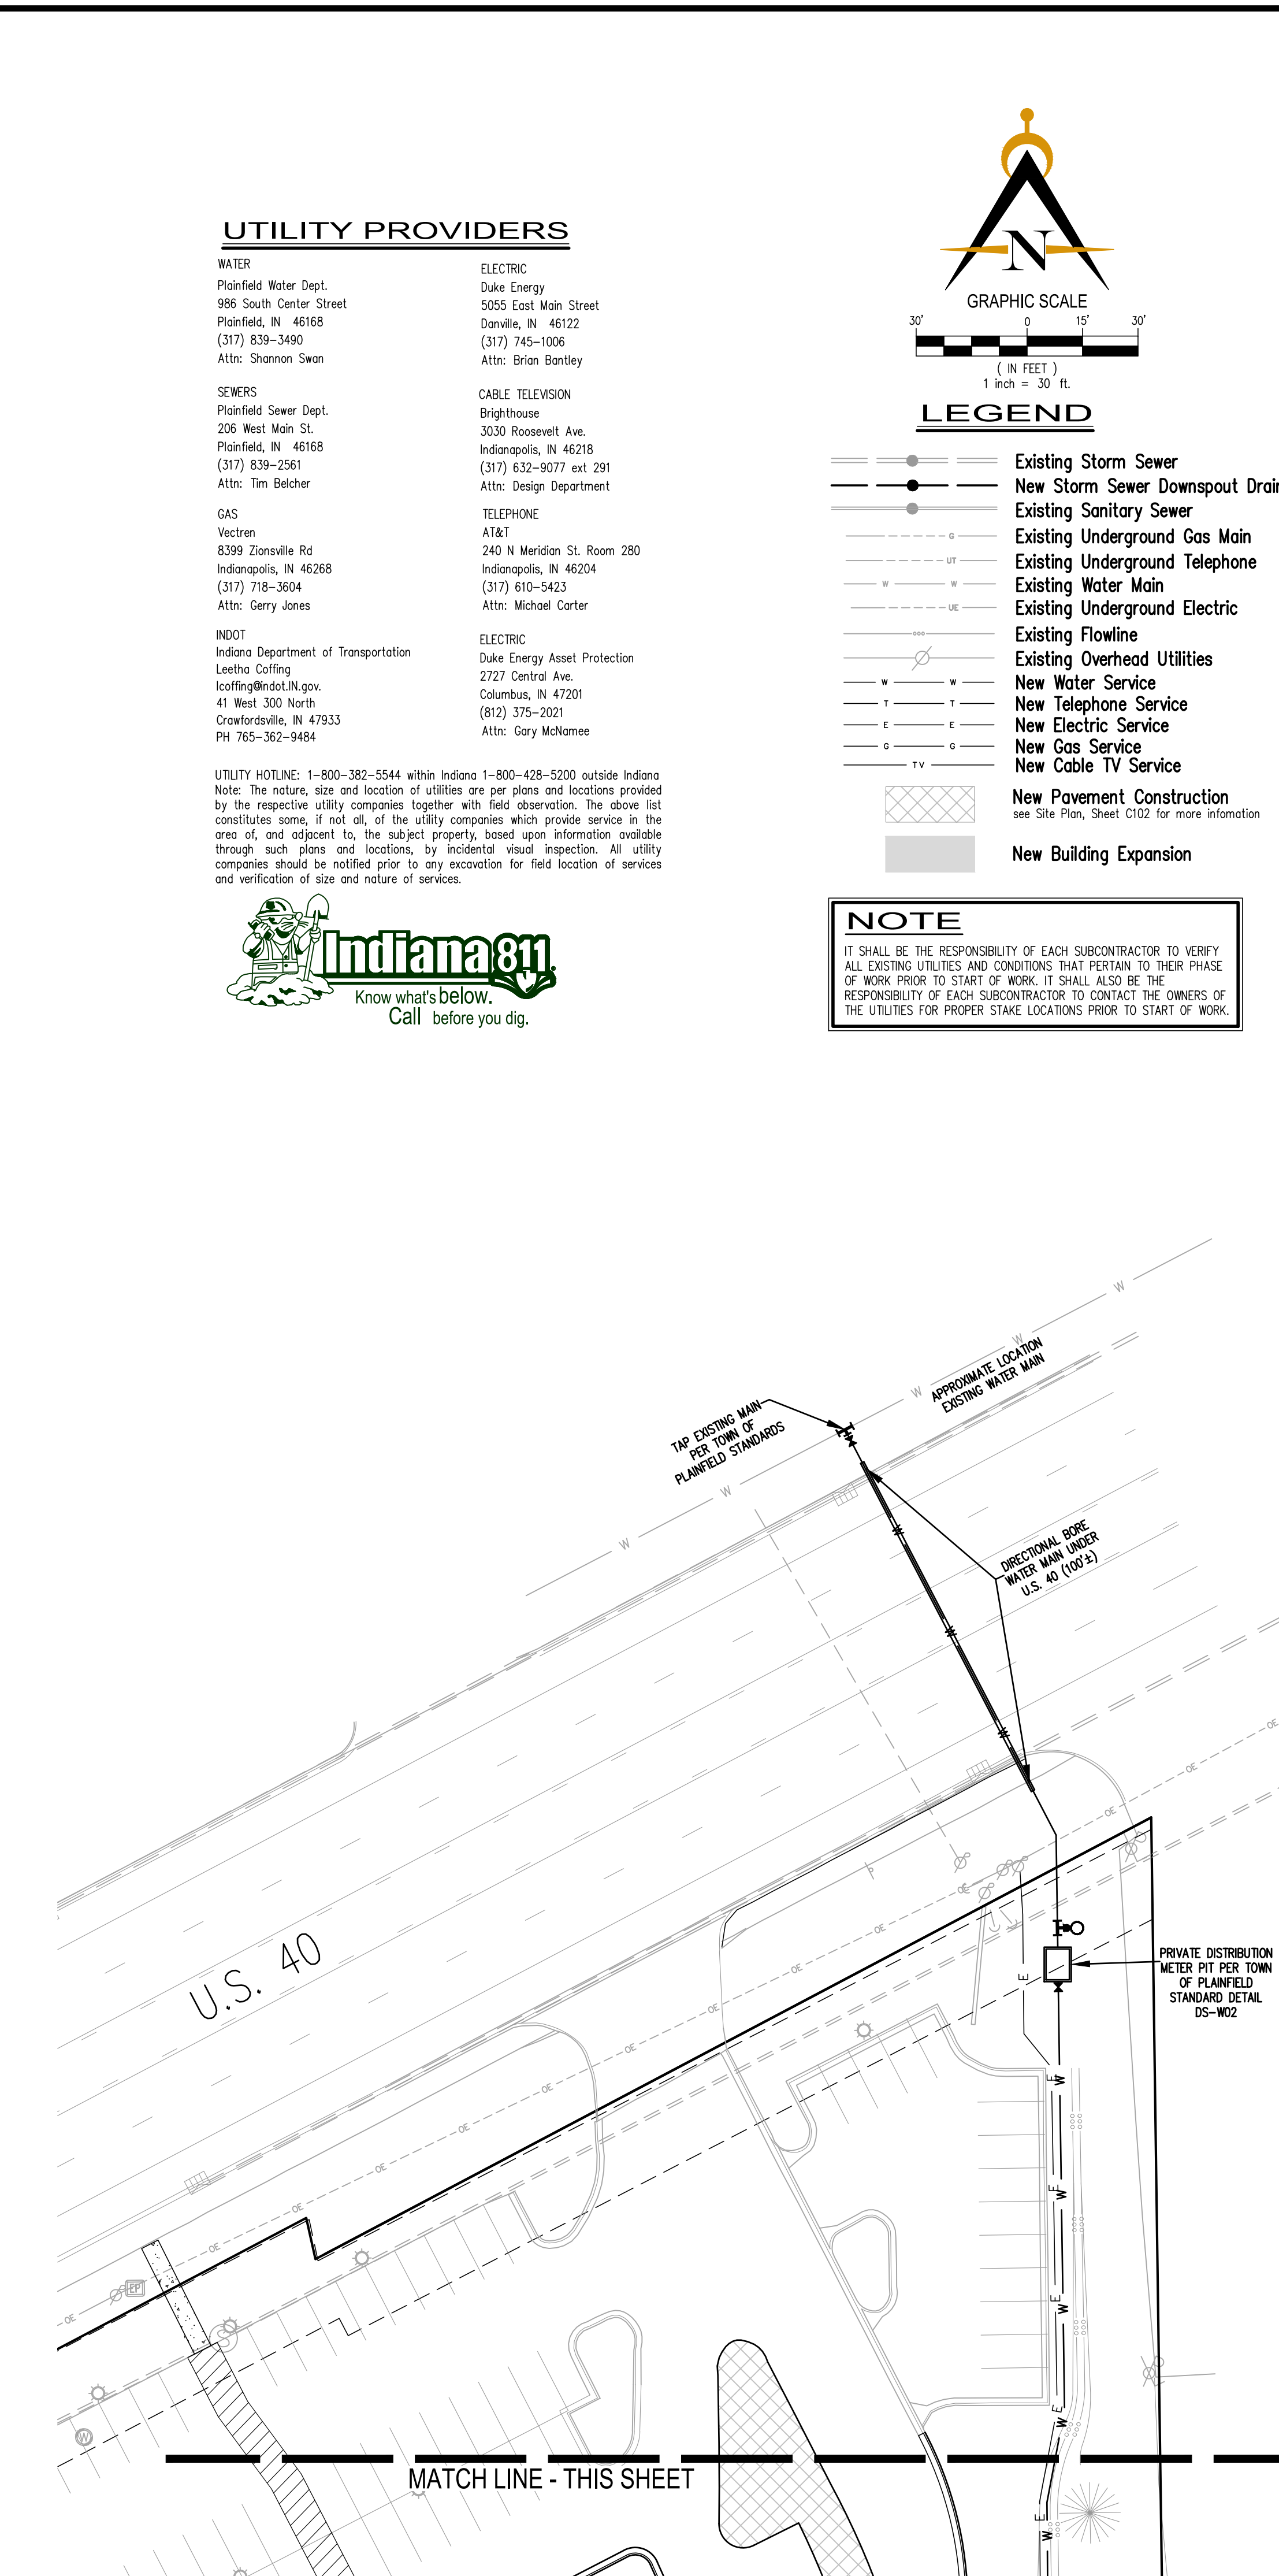

REVISIONS:

PREPARED FOR:
Andy Mohr Automotive
 8941 East Highway 36
 Avon, IN 46123
 317-715-8181

AMAG Commercial Truck Sales
 Building Addition
 Plainfield, Indiana
 Utility Plan

PRELIMINARY PENDING AGENCY APPROVAL

DATE: 11/21/23
 DRAWN BY: kwk
 ISSUED: CHECKED BY:
 JOB NUMBER: 23116
 SHEET # C104