



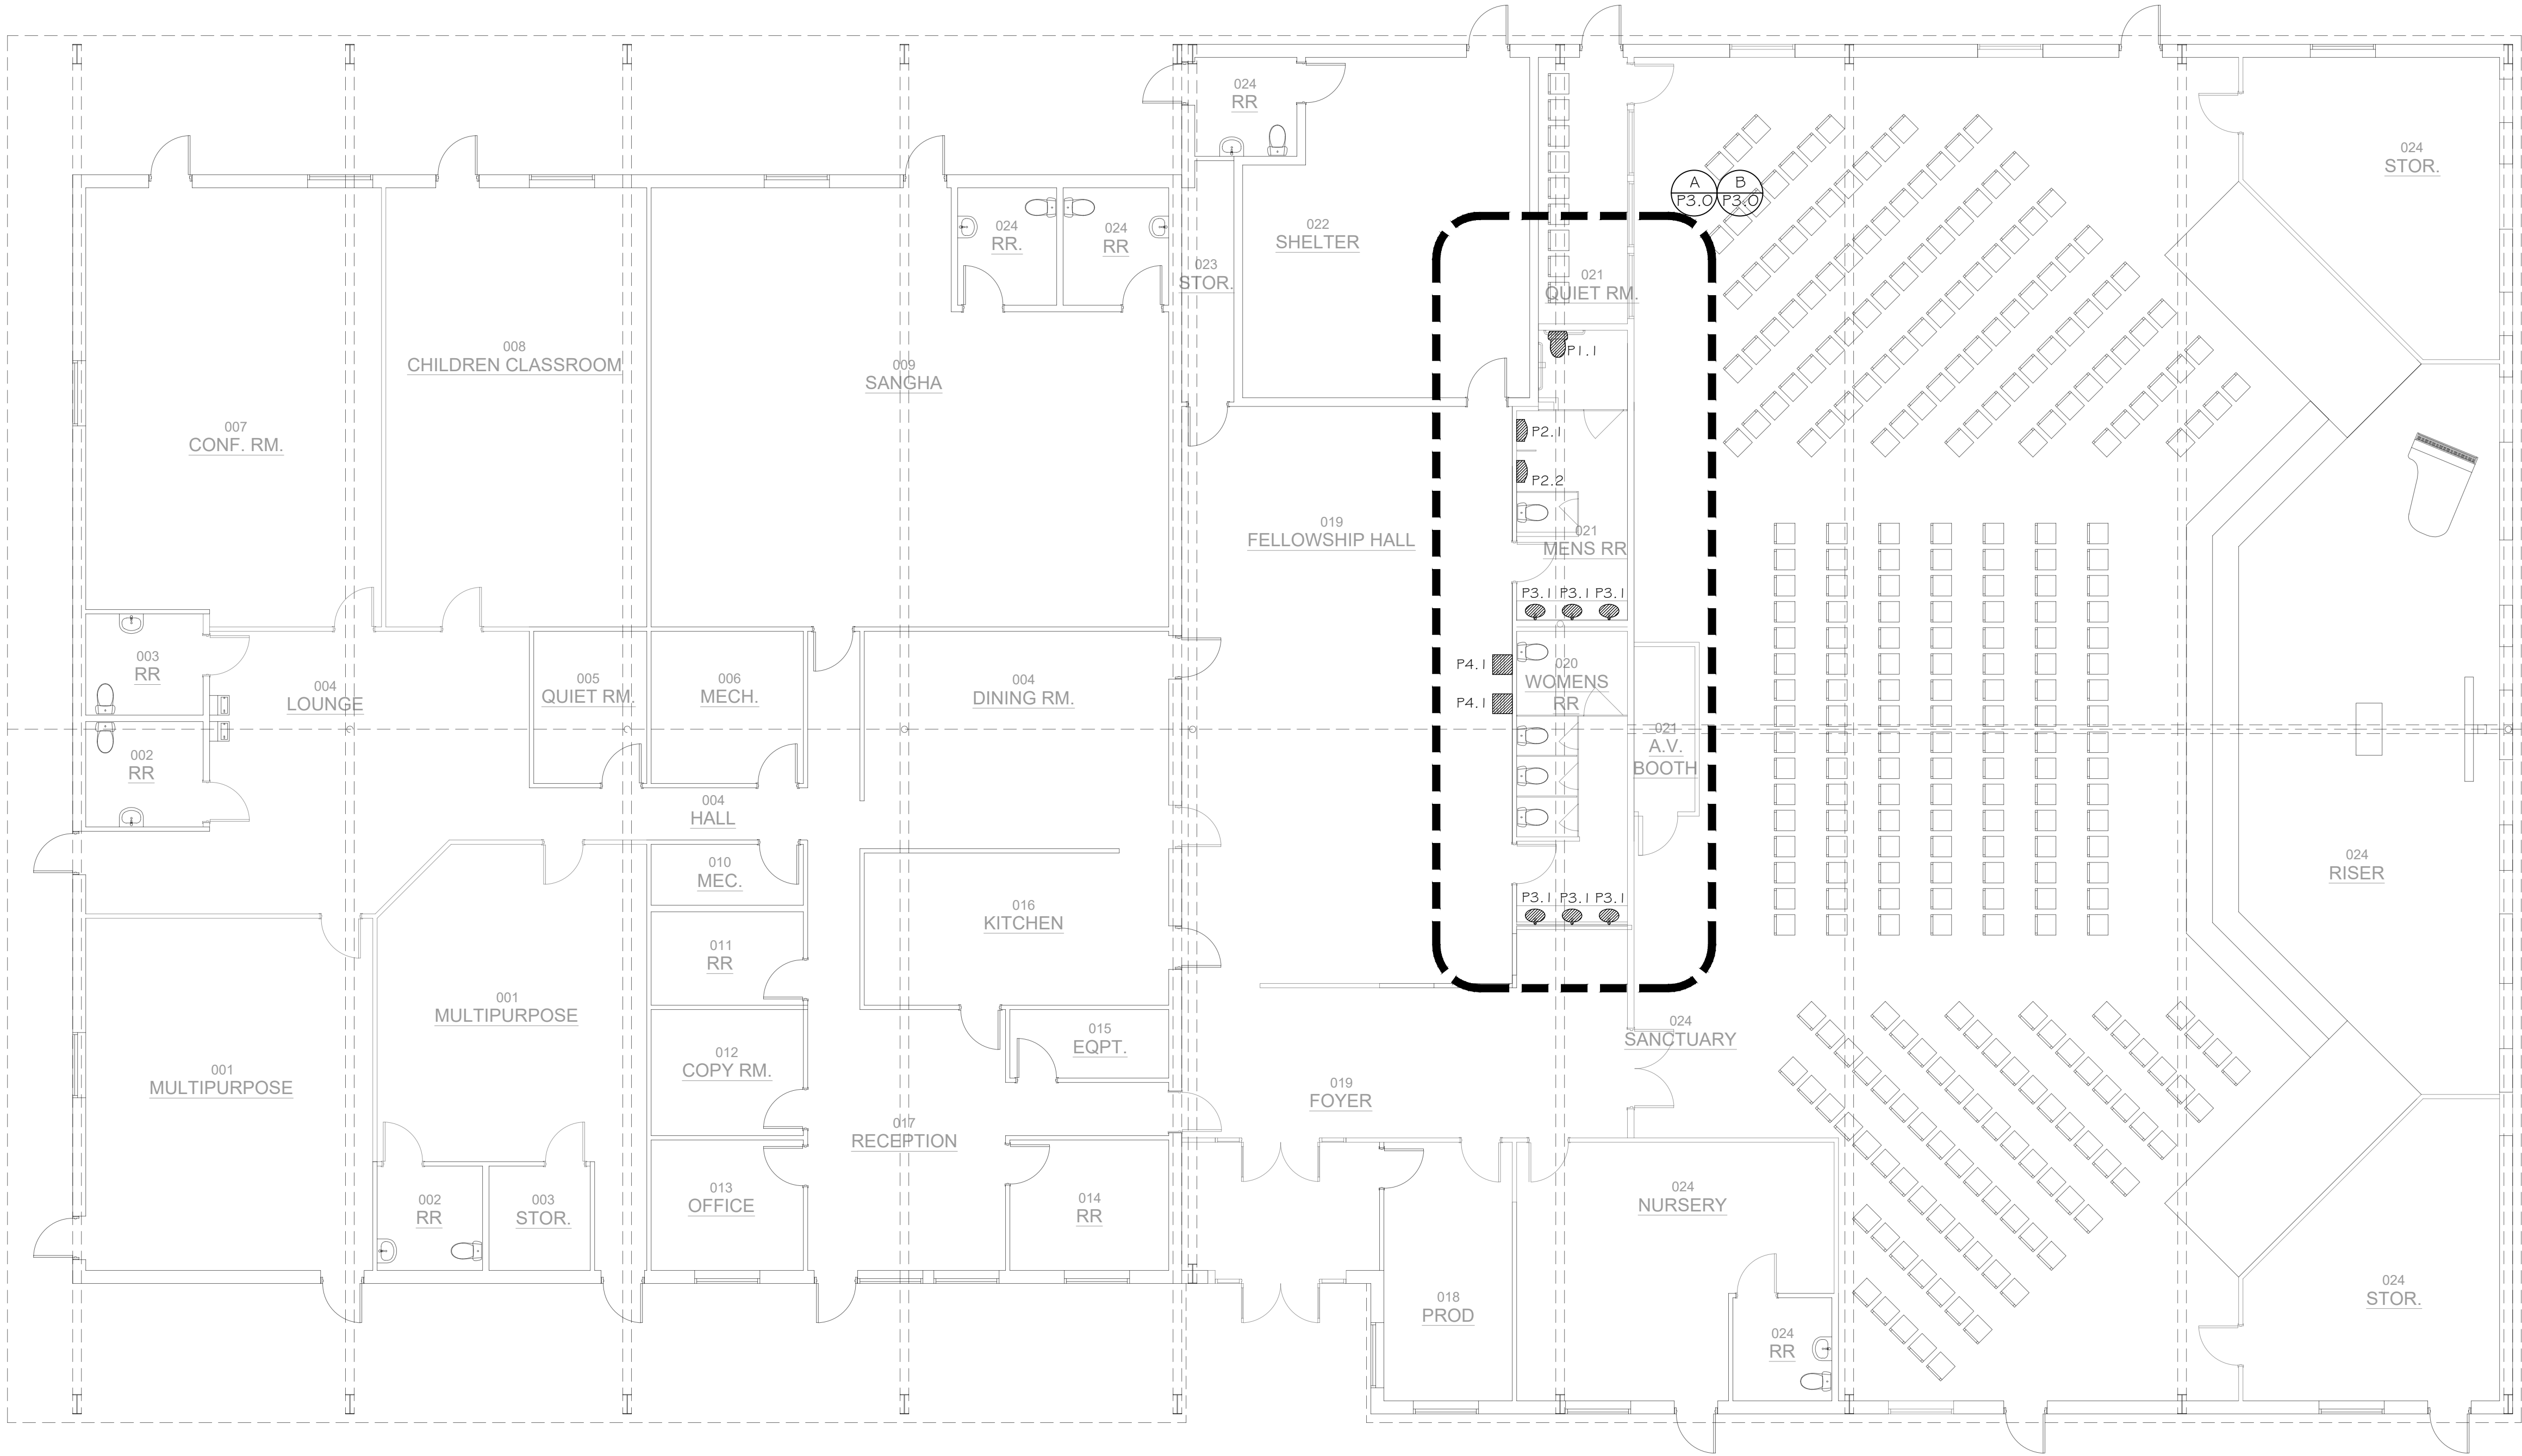

 **A** PLUMBING FLOOR PLAN - NEW WORK
SCALE: 1/8" = 1'-0"
0 2 4 8 16

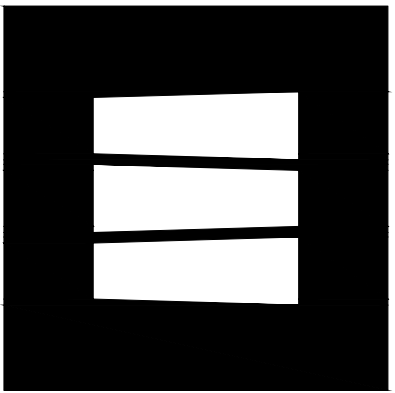

STUDIUW

151 N. Rock Island, Suite 18
Wichita, Kansas 67202
studiumwichita.com
316.295.4563

NOT FOR CONSTRUCTION

Wichita United
Church of Christ

5200 E 32nd St., Wichita, KS 67210

owner

contact:
p:
e:

architect

STUDIUW
151 N Rock Island, 18
Wichita, KS 67202
p: 316.295.4563
contact: Tony Jacobs
email: tony@studiumwichita.com

general contractor

contact:
email:

00.00.21

Project #

P2.0

