


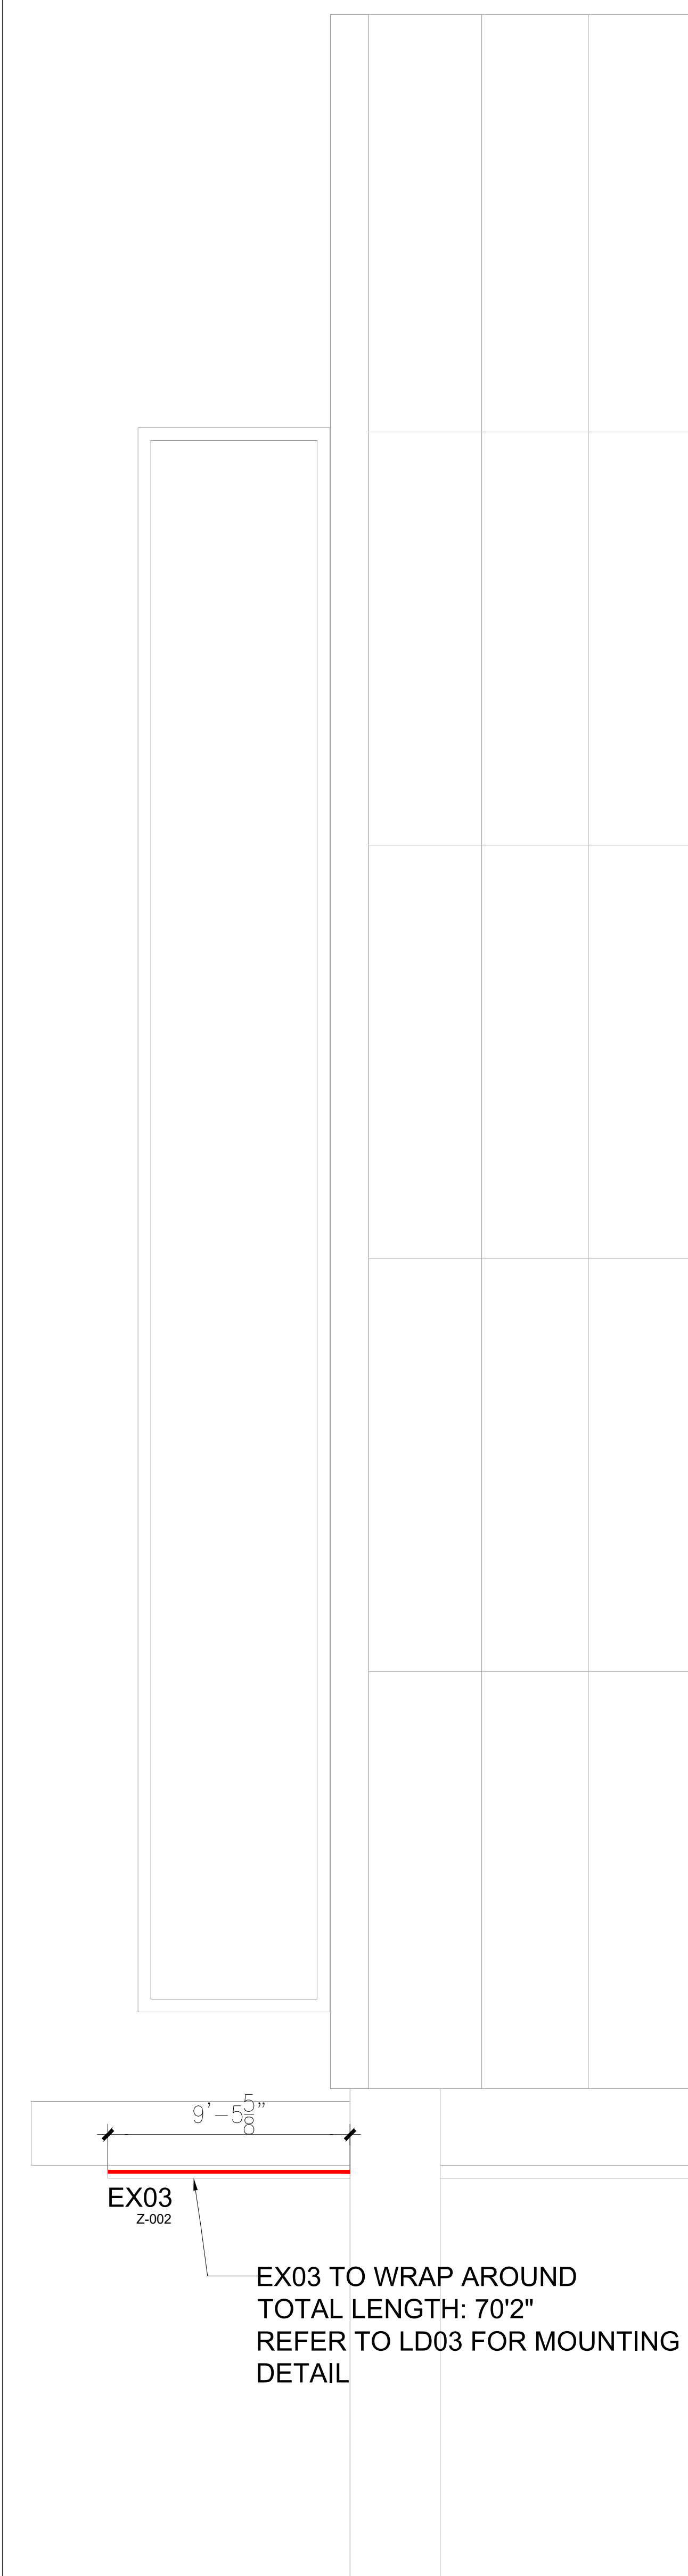



LIGHTING LEGEND

LIGHTING NOTES

Paramount Group Inc.
1633 Broadway
Suite 1801
New York, NY, U.S.A. 10019

MdeAS Architects
80 Broad street
New York, NY, U.S.A. 10004

The Office of James Rudderman LLP
237 W 35th Street
New York, NY, U.S.A. 10001

CANY
134 W 29th street, 12th floor
New York, NY, U.S.A. 10001

Design One Lighting Design
417 Grand street
New York, NY, U.S.A. 10002

design one
lighting design
architecture + entertainment
p + 1 917.754.7071 | o christen@d1ny.com | www.d1ny.com

△ Date	Revision Type
02.28.2020	90% DESIGN DEVELOPMENT
05.13.2020	100% DESIGN DEVELOPMENT
05.19.2020	100% DESIGN DEVELOPMENT

**PROGRESS SET
NOT FOR
CONSTRUCTION**

Project Name
1633 BROADWAY

Project Location
New York, New York, U.S.A.

Date
11.27.2019

Drawn by
BR

Drawing Location
FACADE ON 51ST ST.

Drawing Title
**EXTERIOR FACADE
(51ST ST.)
LIGHTING LAYOUT**
AERIAL SITE PLAN

L-101


Scale
AS NOTED

DRAWING NO. 2 OF 1


© 2019 design one corporation. All rights reserved.

1

EXTERIOR FACADE LIGHTING ON 51ST STREET
1/14"=1'-0"

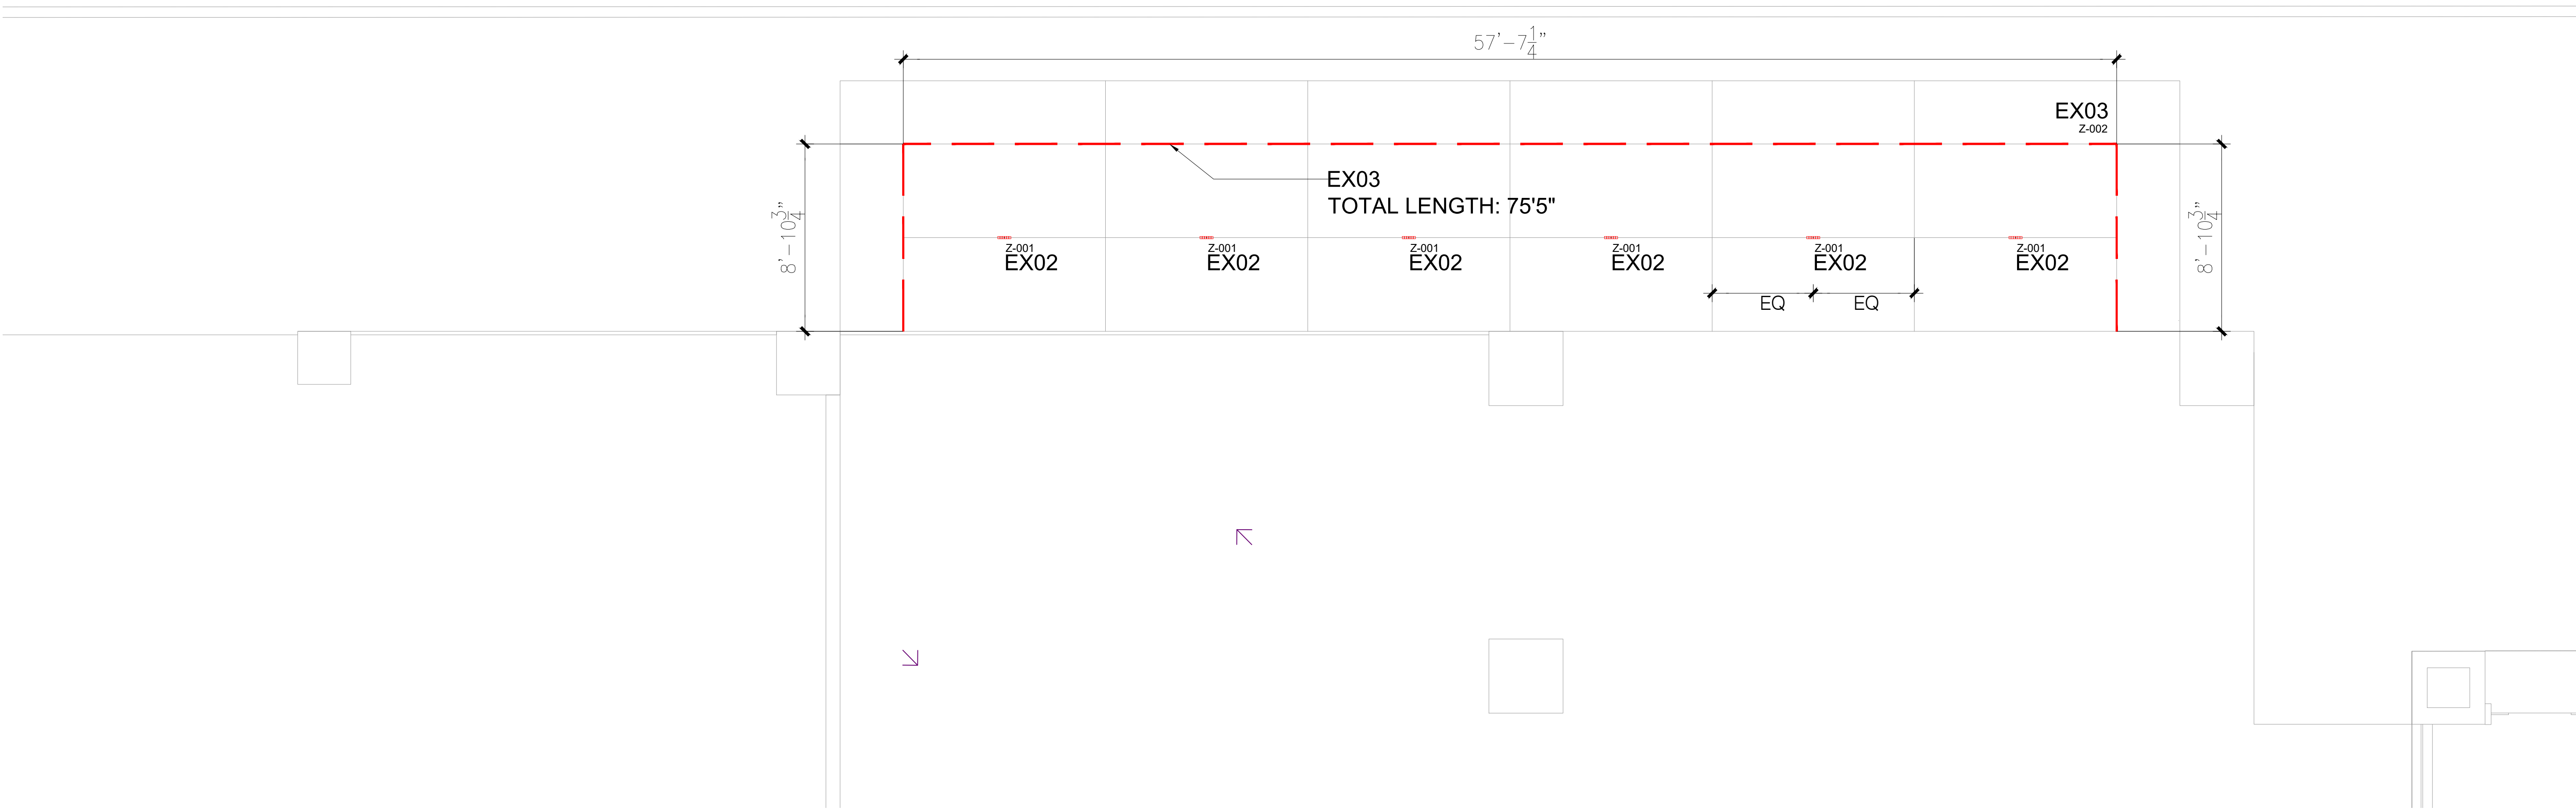

2 LIGHTING AT ENTRY CANOPY ON 51ST STREET
1/14"=1'-0"

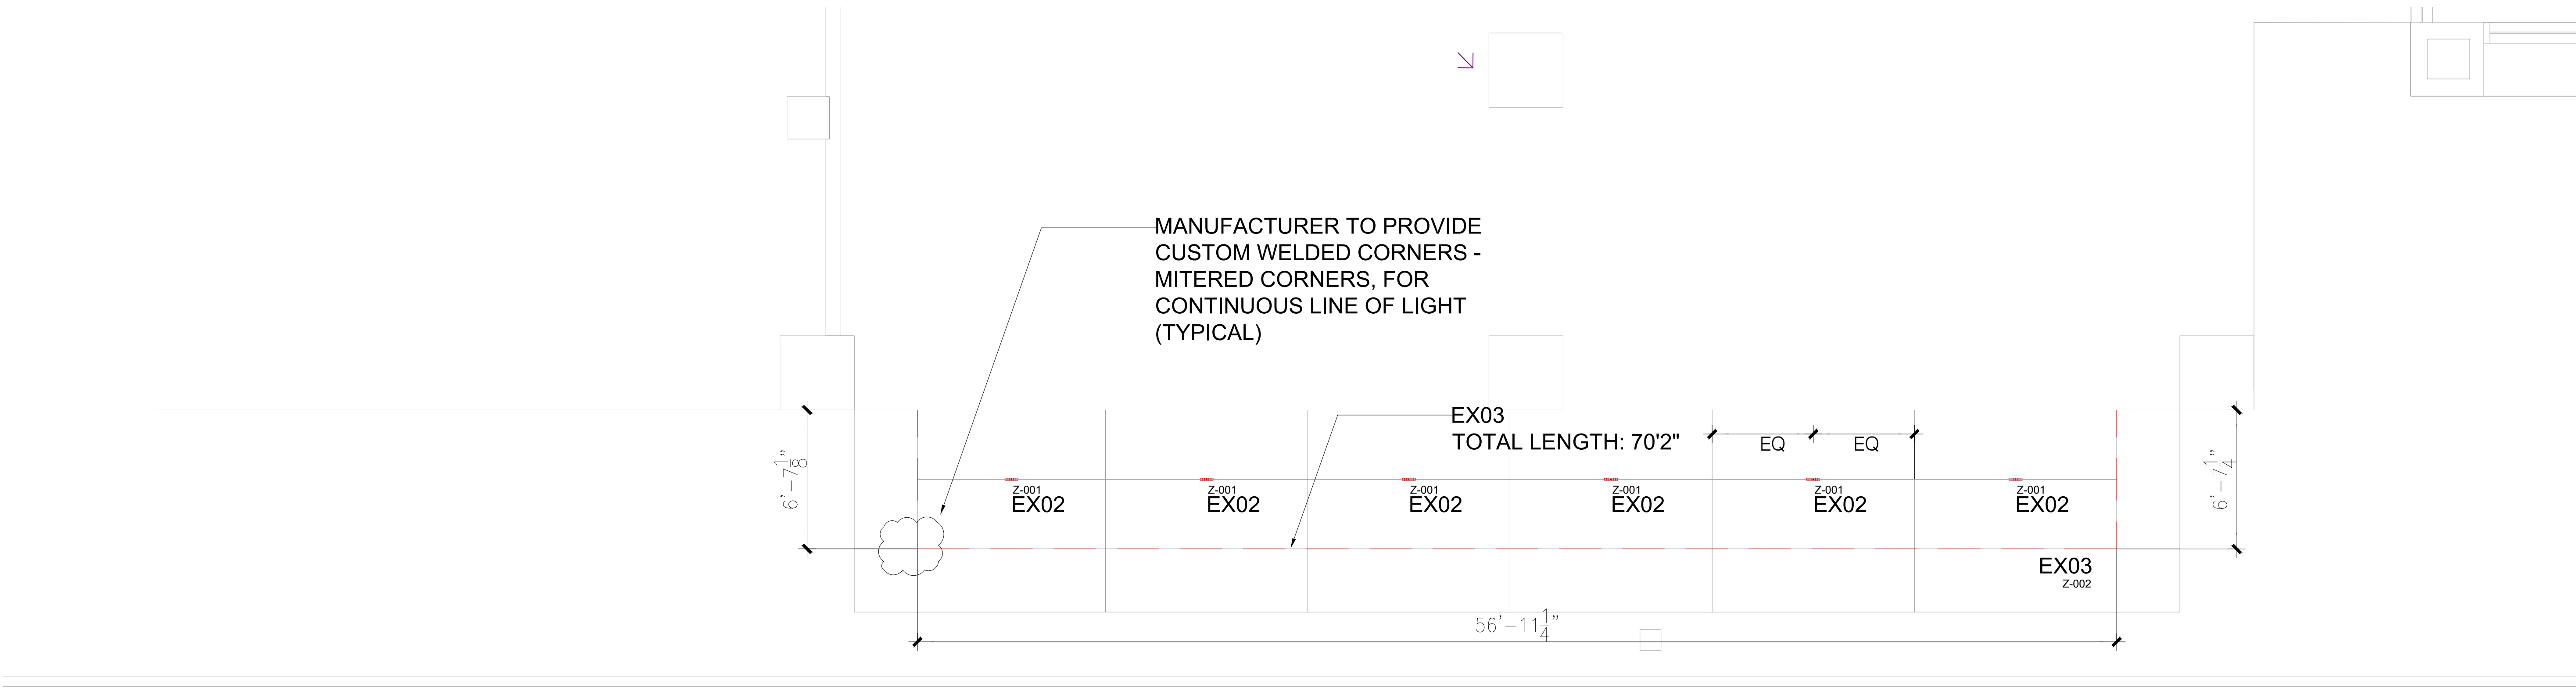

1 LIGHTING AT ENTRY CANOPY ON 50TH STREET
1/14"=1'-0"

LIGHTING LEGEND

LIGHTING NOTES

Paramount Group Inc.
1633 Broadway
Suite 1801
New York, NY, U.S.A. 10019

MdeAS Architects
80 Broad street
New York, NY, U.S.A. 10004

The Office of James Rudderman LLP
237 W 35th Street
New York, NY, U.S.A. 10001

CANY
134 W 29th street, 12th floor
New York, NY, U.S.A. 10001

Design One Lighting Design
417 Grand street
New York, NY, U.S.A. 10002

design one
lighting design
architecture + entertainment
0 +1 917.754.7071 | d.christen@d1ny.com | www.d1ny.com

△	Date	Revision Type
	02.28.2020	90% DESIGN DEVELOPMENT
	05.13.2020	100% DESIGN DEVELOPMENT
	05.19.2020	100% DESIGN DEVELOPMENT

**PROGRESS SET
NOT FOR
CONSTRUCTION**

Project Name
1633 BROADWAY

Project Location
New York, New York, U.S.A.

Date
11.27.2019

Drawn by
BR

Drawing Location
CANOPY ON 50TH AND 51ST ST.

Drawing Title
**ENTRY ON 50TH & 51ST
STREET
LIGHTING LAYOUT**



AERIAL SITE PLAN

L-102



Scale
AS NOTED

DRAWING NO. 3 OF 3




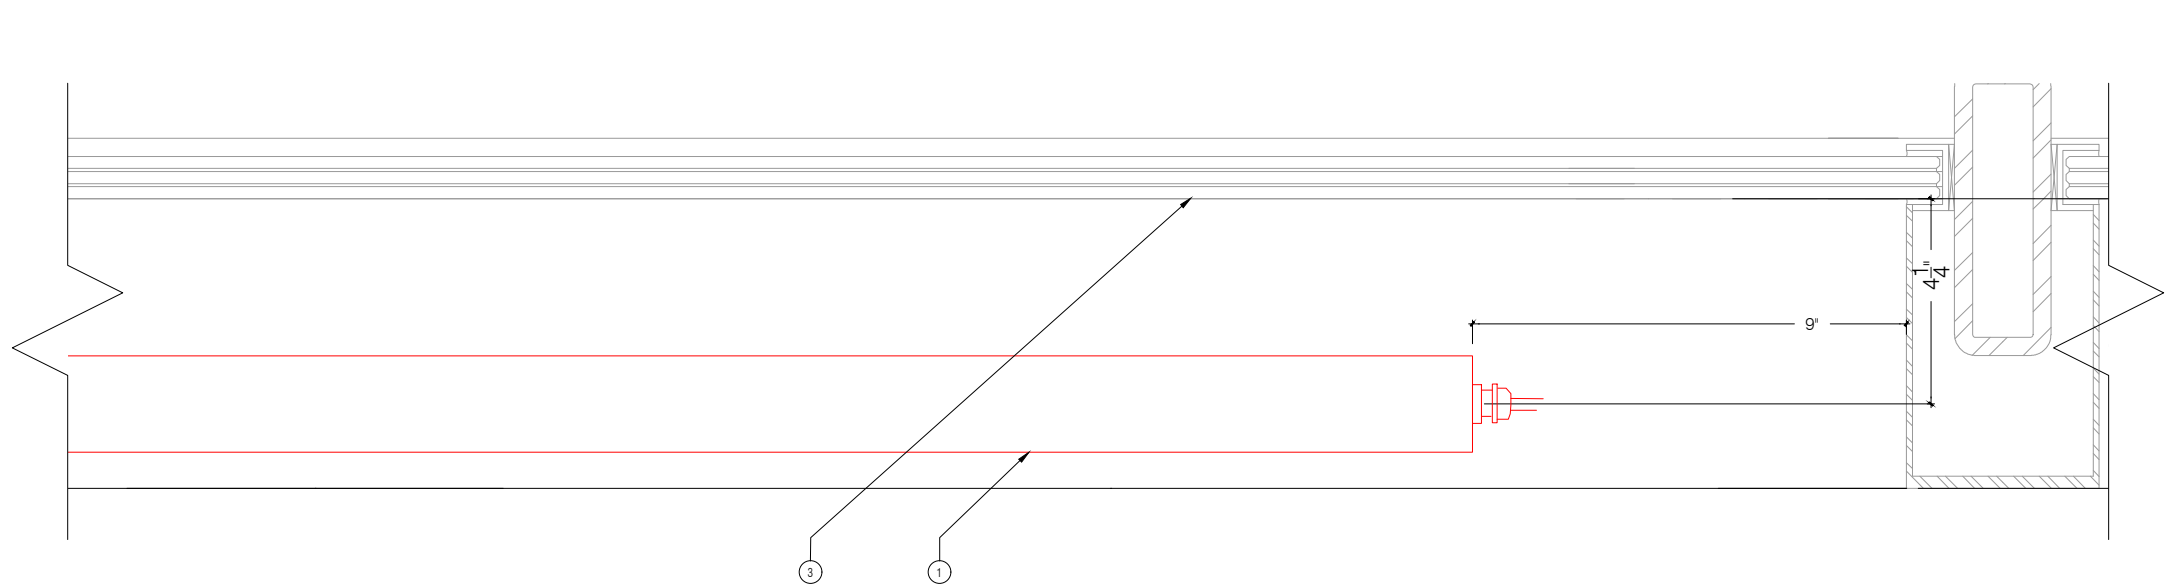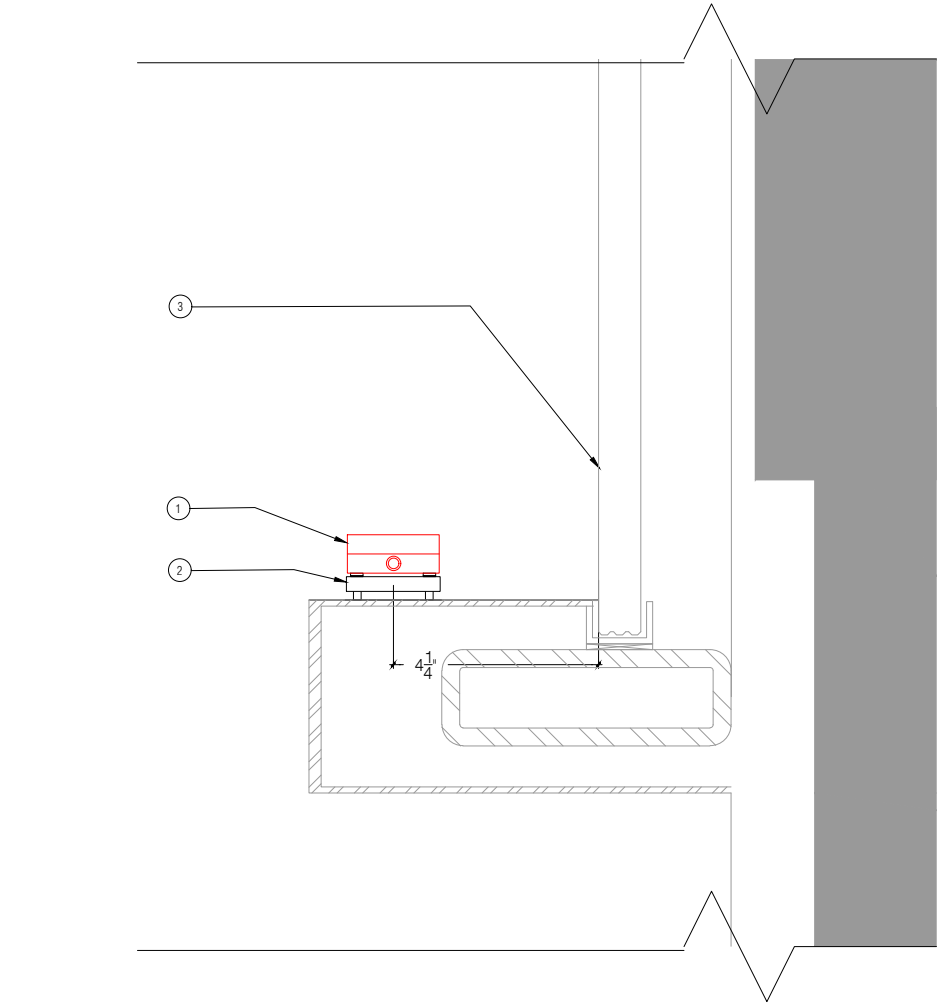

- 1 TYPE EX01, DMX RGBW FIXTURE
- 2 MOUNTING PLATE FOR FIXTURE MOUNTING TO STRUCTURAL METAL BEAM (MANUFACTURER TO CONFIRM)
- 3 METAL FASCIA OF FACADE (WHITE FINISH)

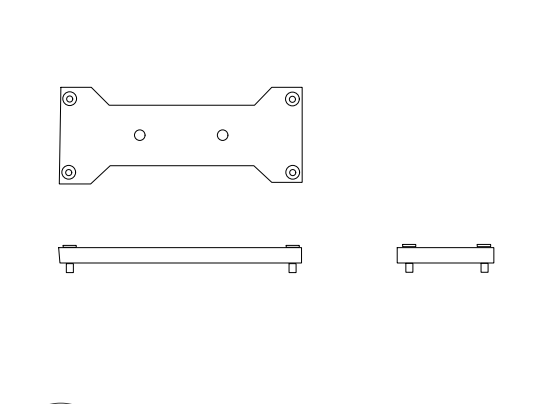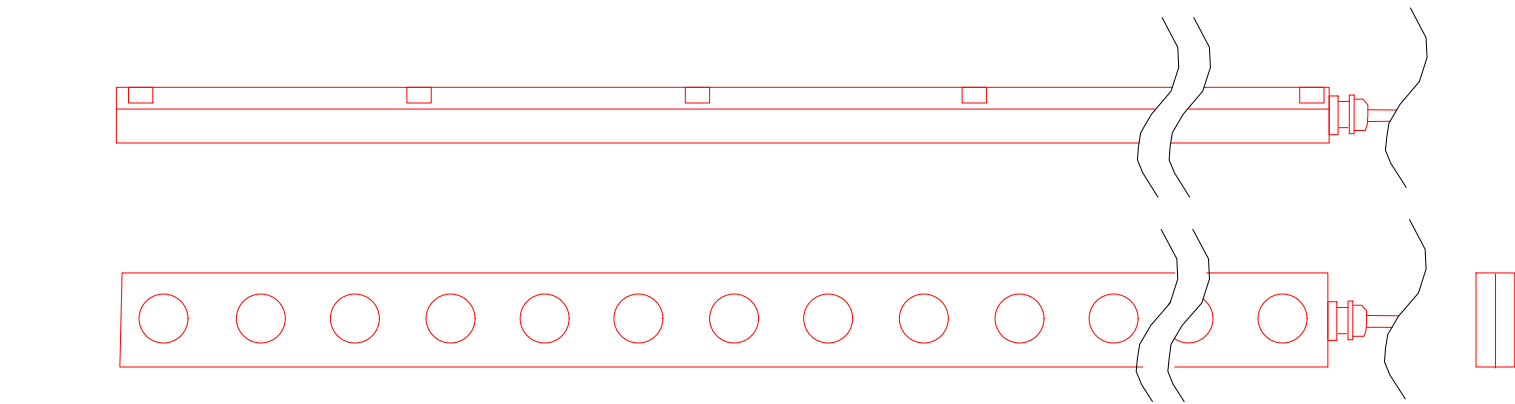


design one lighting design ☎+1 917.754.7071 ✉christien@d1ny.com 🌐www.d1ny.com	
DRAWING TITLE	EX01 MOUNTING DETAIL FOR FACADE LIGHTING
PROJECT TITLE	1633 BROADWAY
PROJECT LOCATION	New York, NY, U.S.A.
VERSION/PHASE	100% DESIGN DEVELOPMENT
DATE	13 MAY 2020
DRAWN BY	BR
SCALE: 3"=1'-0"	LD01

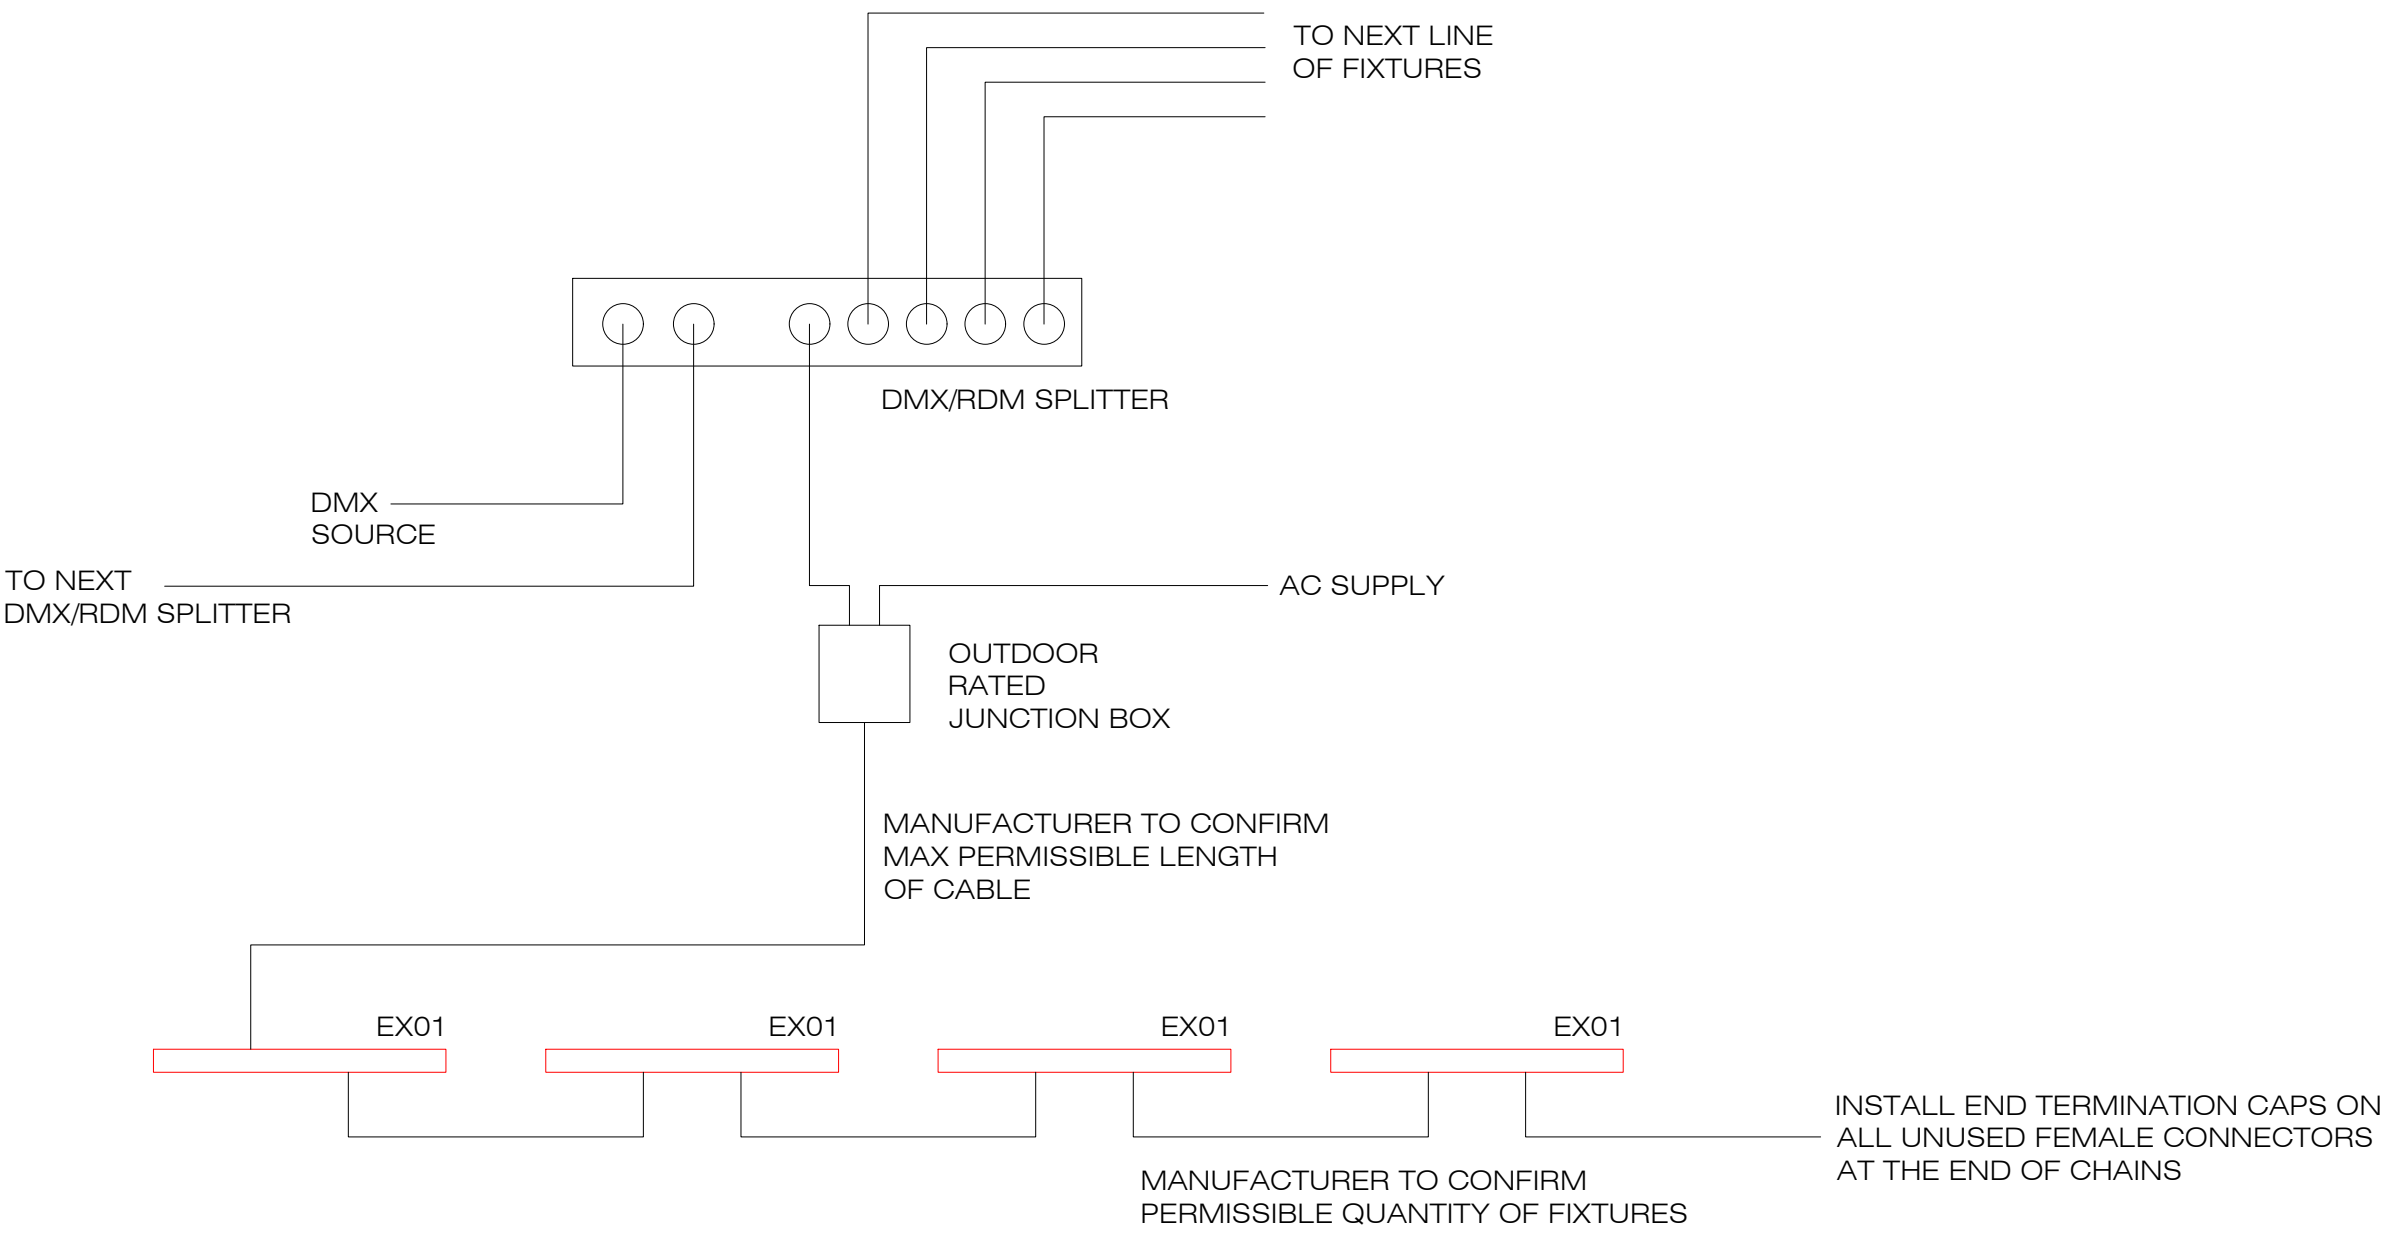


1 DMX WIRING DIAGRAM FOR EX01
NTS

design one lighting design +1 917.754.7071 christien@d1ny.com www.d1ny.com	
DRAWING TITLE	EX01 DMX WIRING DIAGRAM
PROJECT TITLE	1633 BROADWAY
PROJECT LOCATION	New York, NY, U.S.A.
VERSION/PHASE	100% DESIGN DEVELOPMENT
DATE	13 MAY 2020
DRAWN BY	BR
SCALE:NTS	LD02

- 1 EX03, LINEAR LED TAPE WITHIN ALUMINUM EXTRUSION, REGRESSED TO THE UNDERSIDE OF MARQUEE
- 2 WET RATED LED TAPE MOUNTED INSIDE ALUMINUM EXTRUSION
- 3 POLYCARBONATE LENS
- 4 MOUNTING HOLES MIN 30" APART (MANUFACTURER RECOMMENDED)
- 5 MARQUEE OVERHANG
- 6 POWER SUPPLY (PS), LOCATED IN CEILING CANOPY, EVERY 10 LINEAR FT. OF FIXTURE EX03

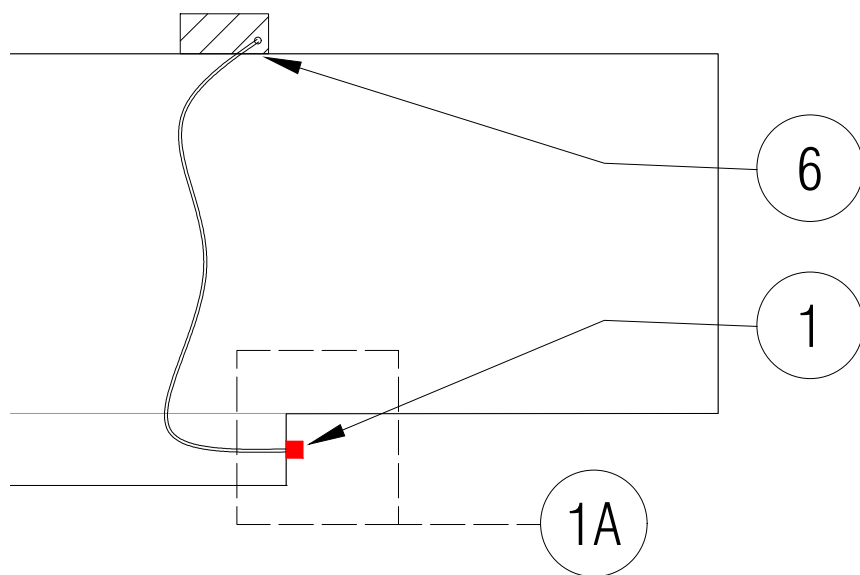

1B EX03 FIXTURE AND POWER SUPPLY
3/4"=1'-0"

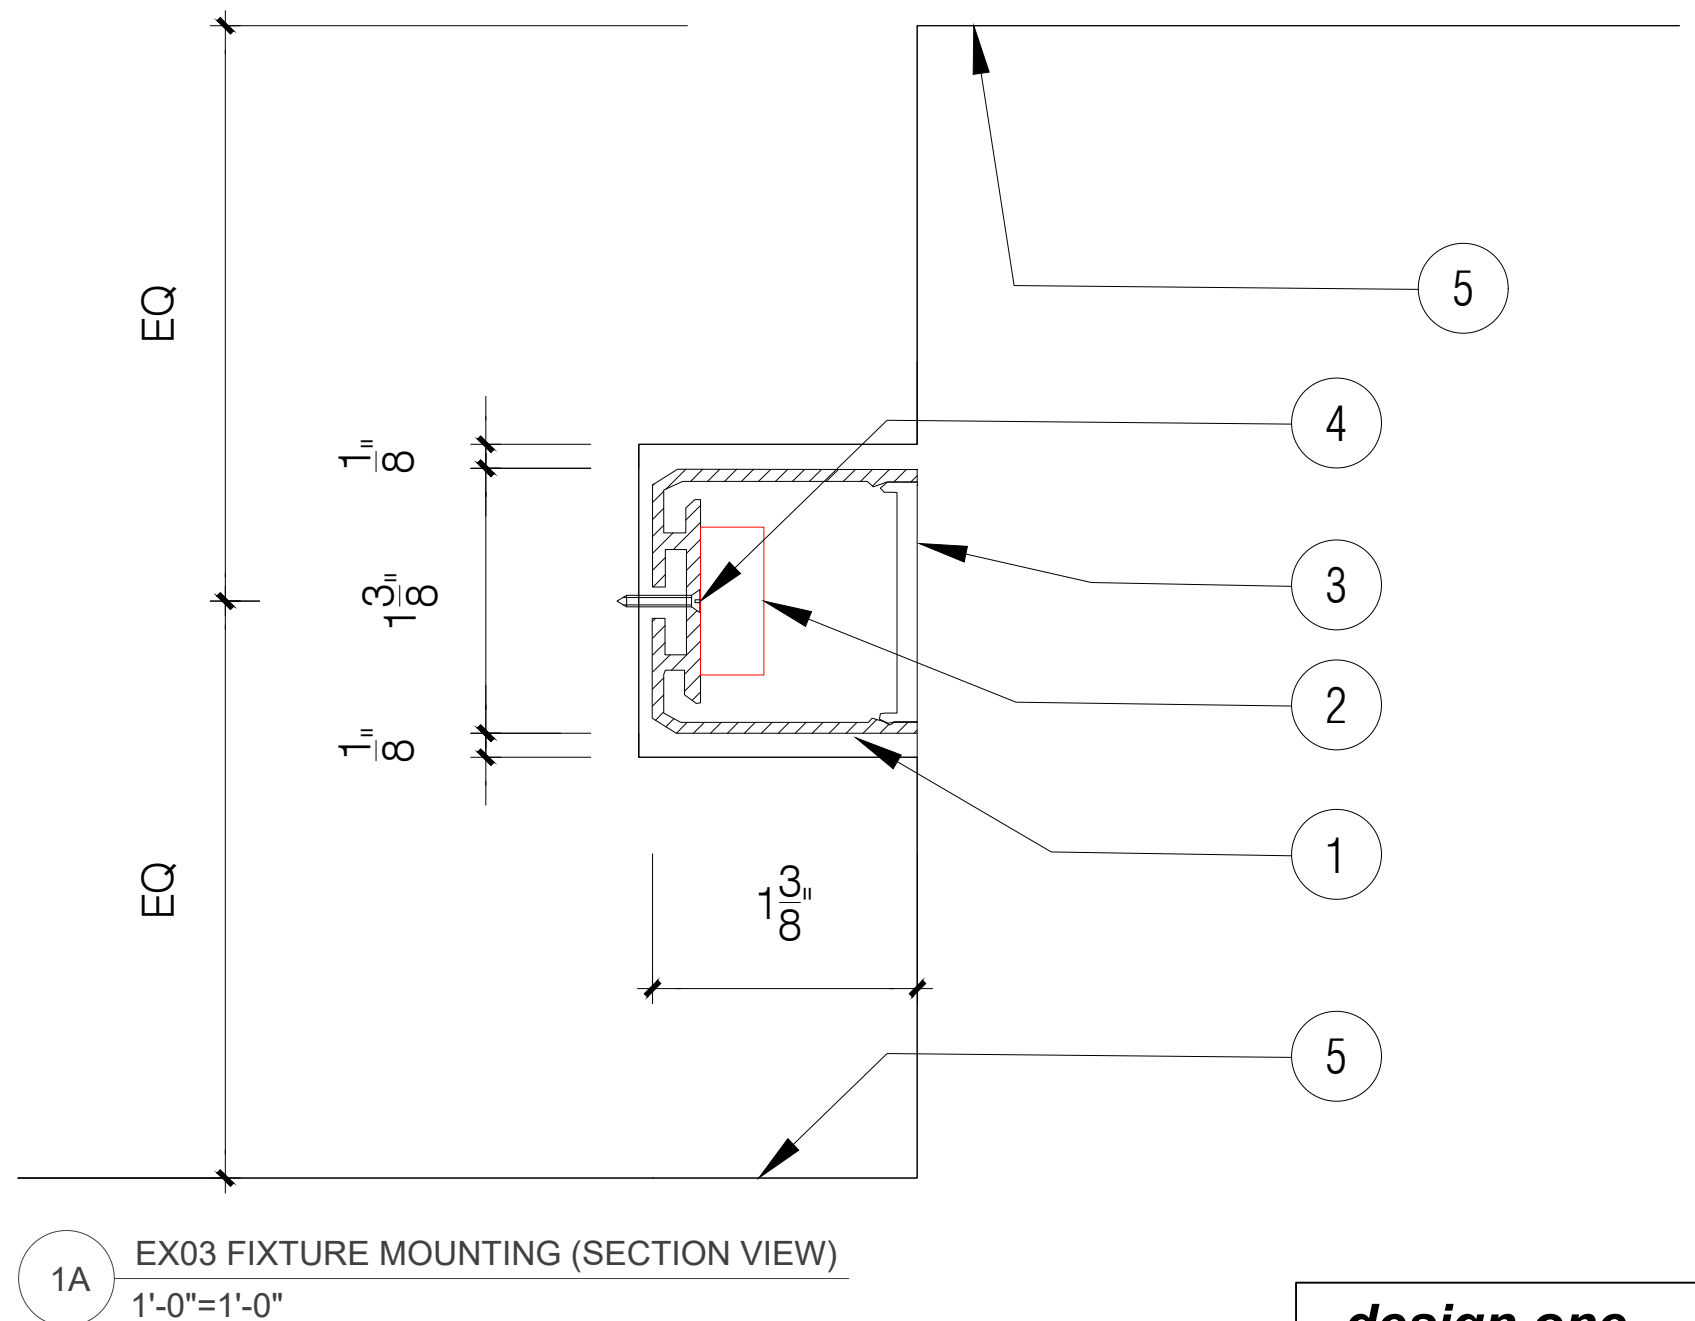

1A EX03 FIXTURE MOUNTING (SECTION VIEW)
1'-0"=1'-0"

NOTE:

- 1) MANUFACTURER TO CONFIRM MAX PERMISSIBLE DISTANCE BETWEEN EX03 AND POWER SUPPLY
- 2) MANUFACTURER TO PROVIDE CUSTOM WELDED CORNERS - MITERED CORNERS, FOR CONTINUOUS LINE OF LIGHT
- 3) LED TAPE SHALL BE PERMANENTLY ADHERED TO THE EXTRUSION (MANUFACTURER TO CONFIRM)

design one <i>lighting design</i>	
+1 917.754.7071 ✉ christien@d1ny.com 🌐 www.d1ny.com	
DRAWING TITLE EX03 MOUNTING DETAIL UNDER MARQUEE	
PROJECT TITLE 1633 BROADWAY	
PROJECT LOCATION New York, NY, U.S.A.	
VERSION/PHASE 100% DESIGN DEVELOPMENT	
DATE 19 MAY 2020	DRAWING NO.
DRAWN BY BR	
SCALE:VARIES	LD03