



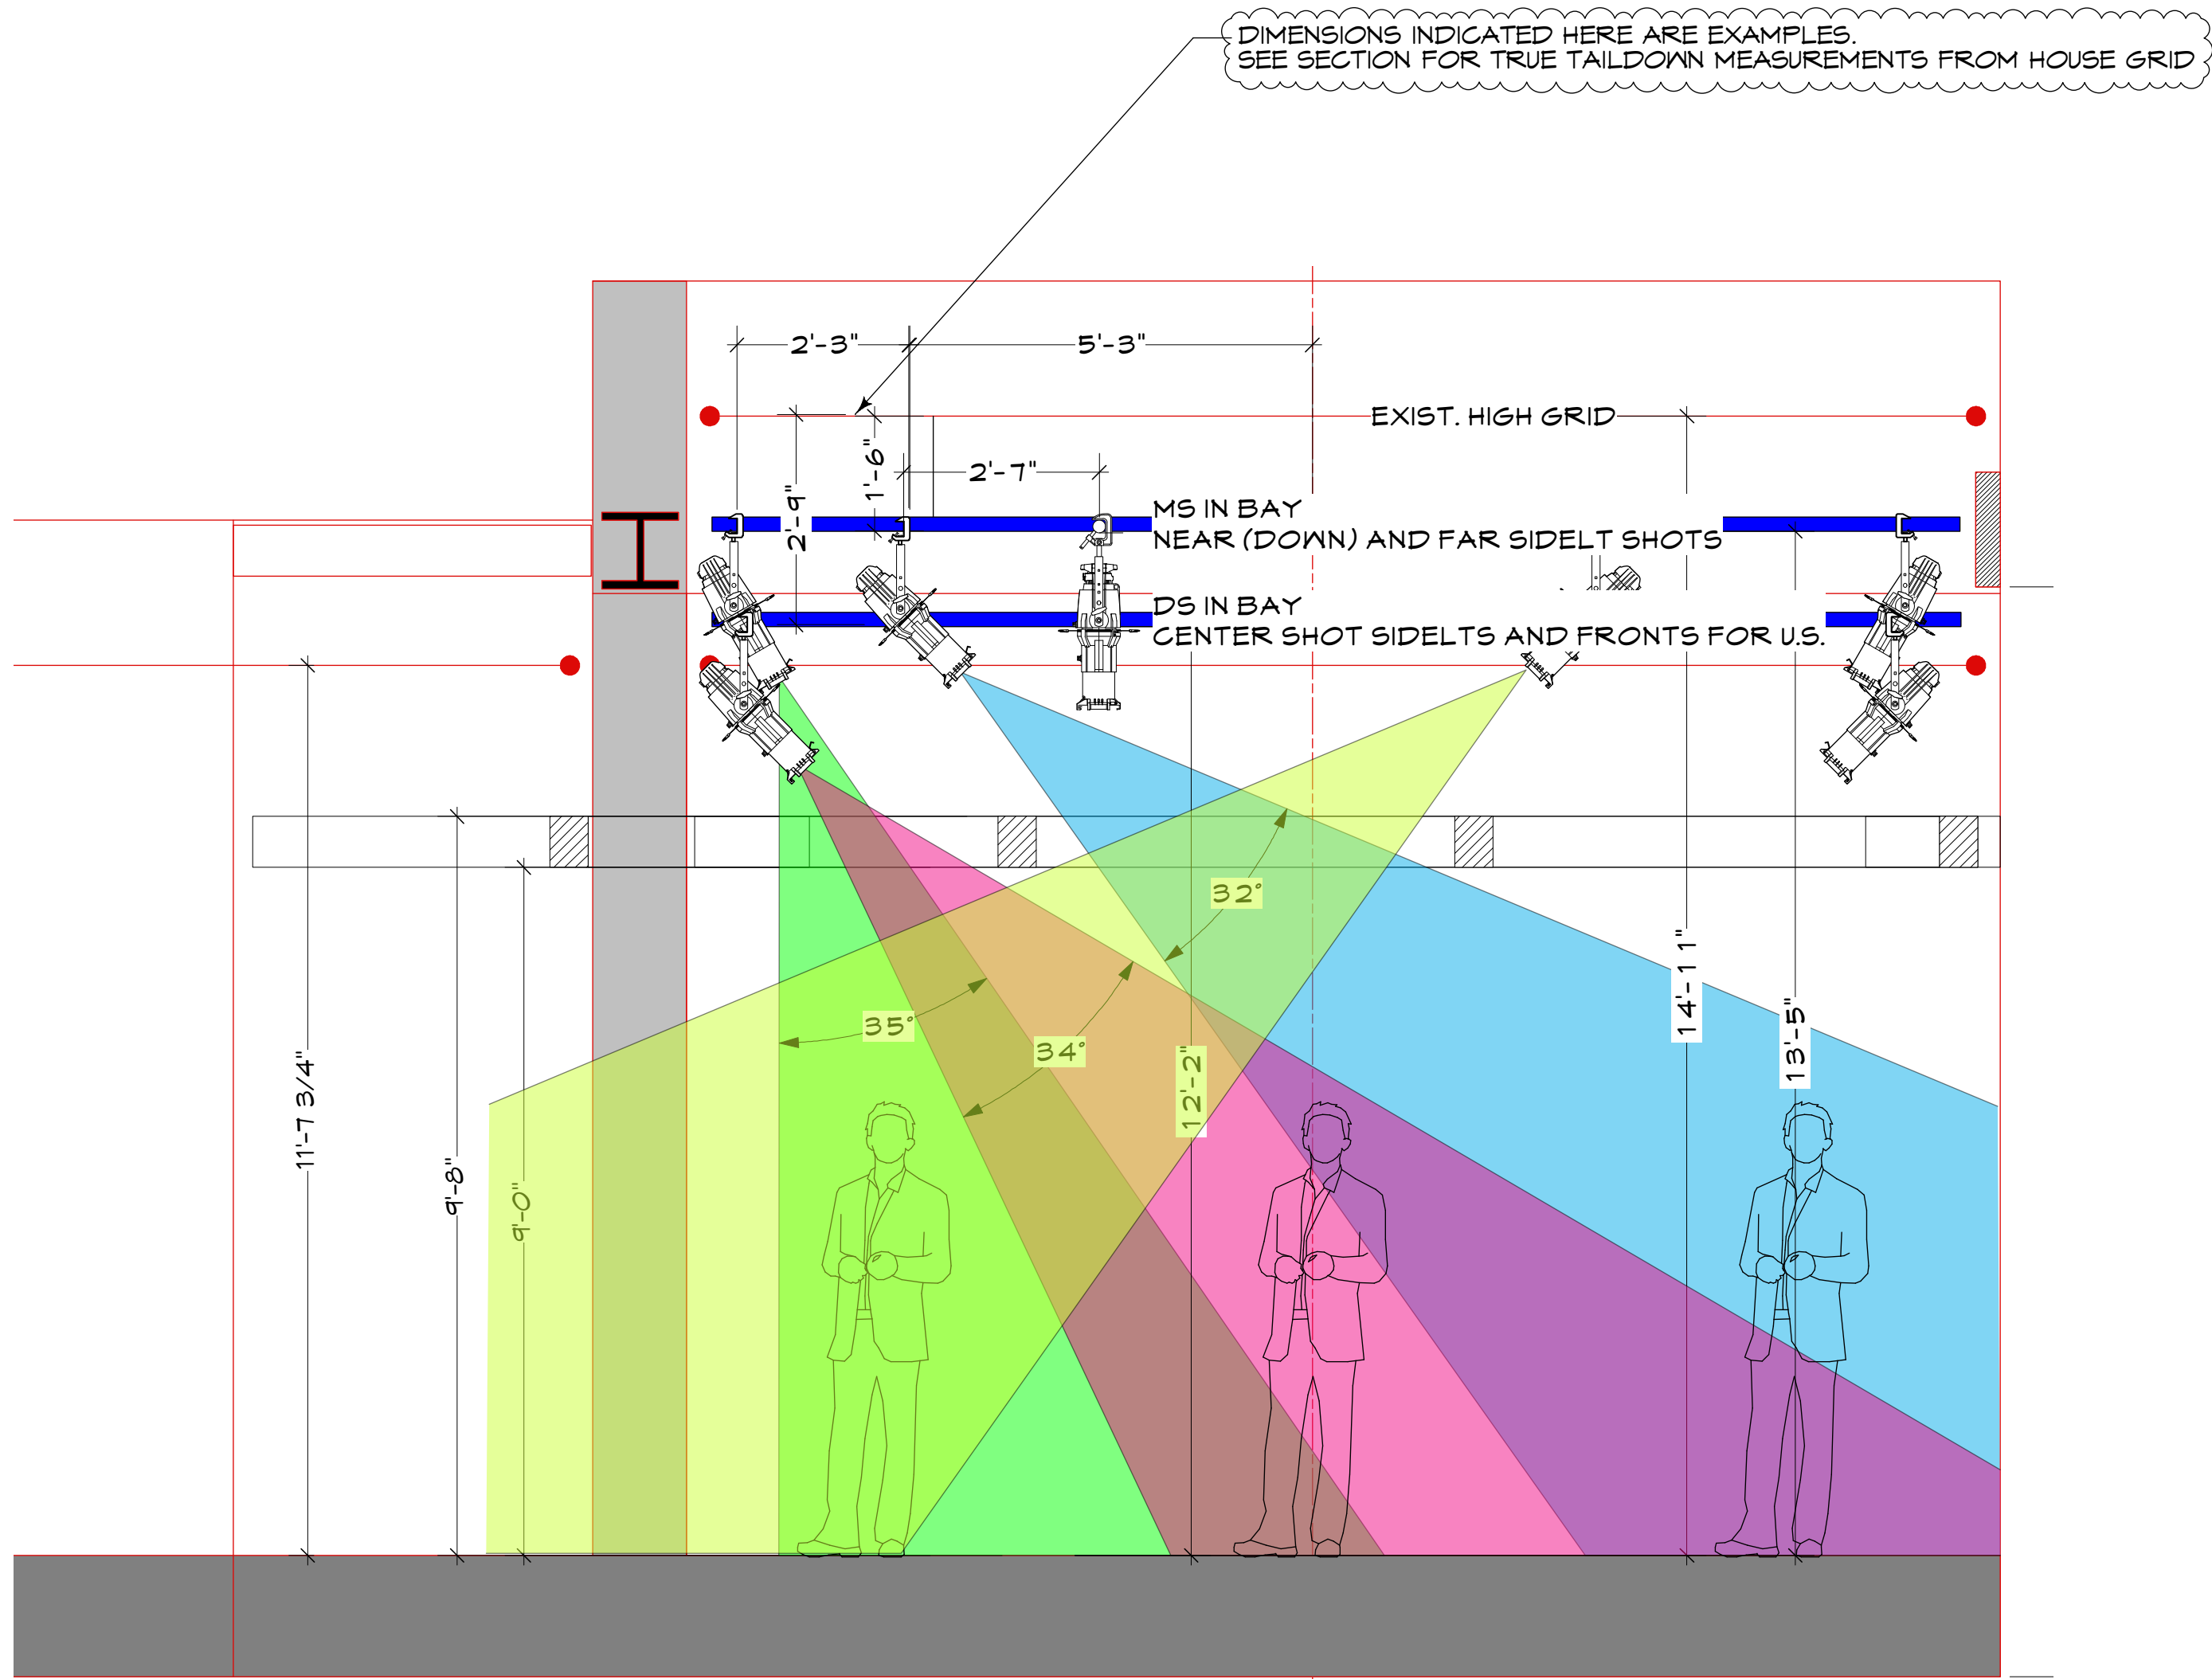

FRONT ELEVATION

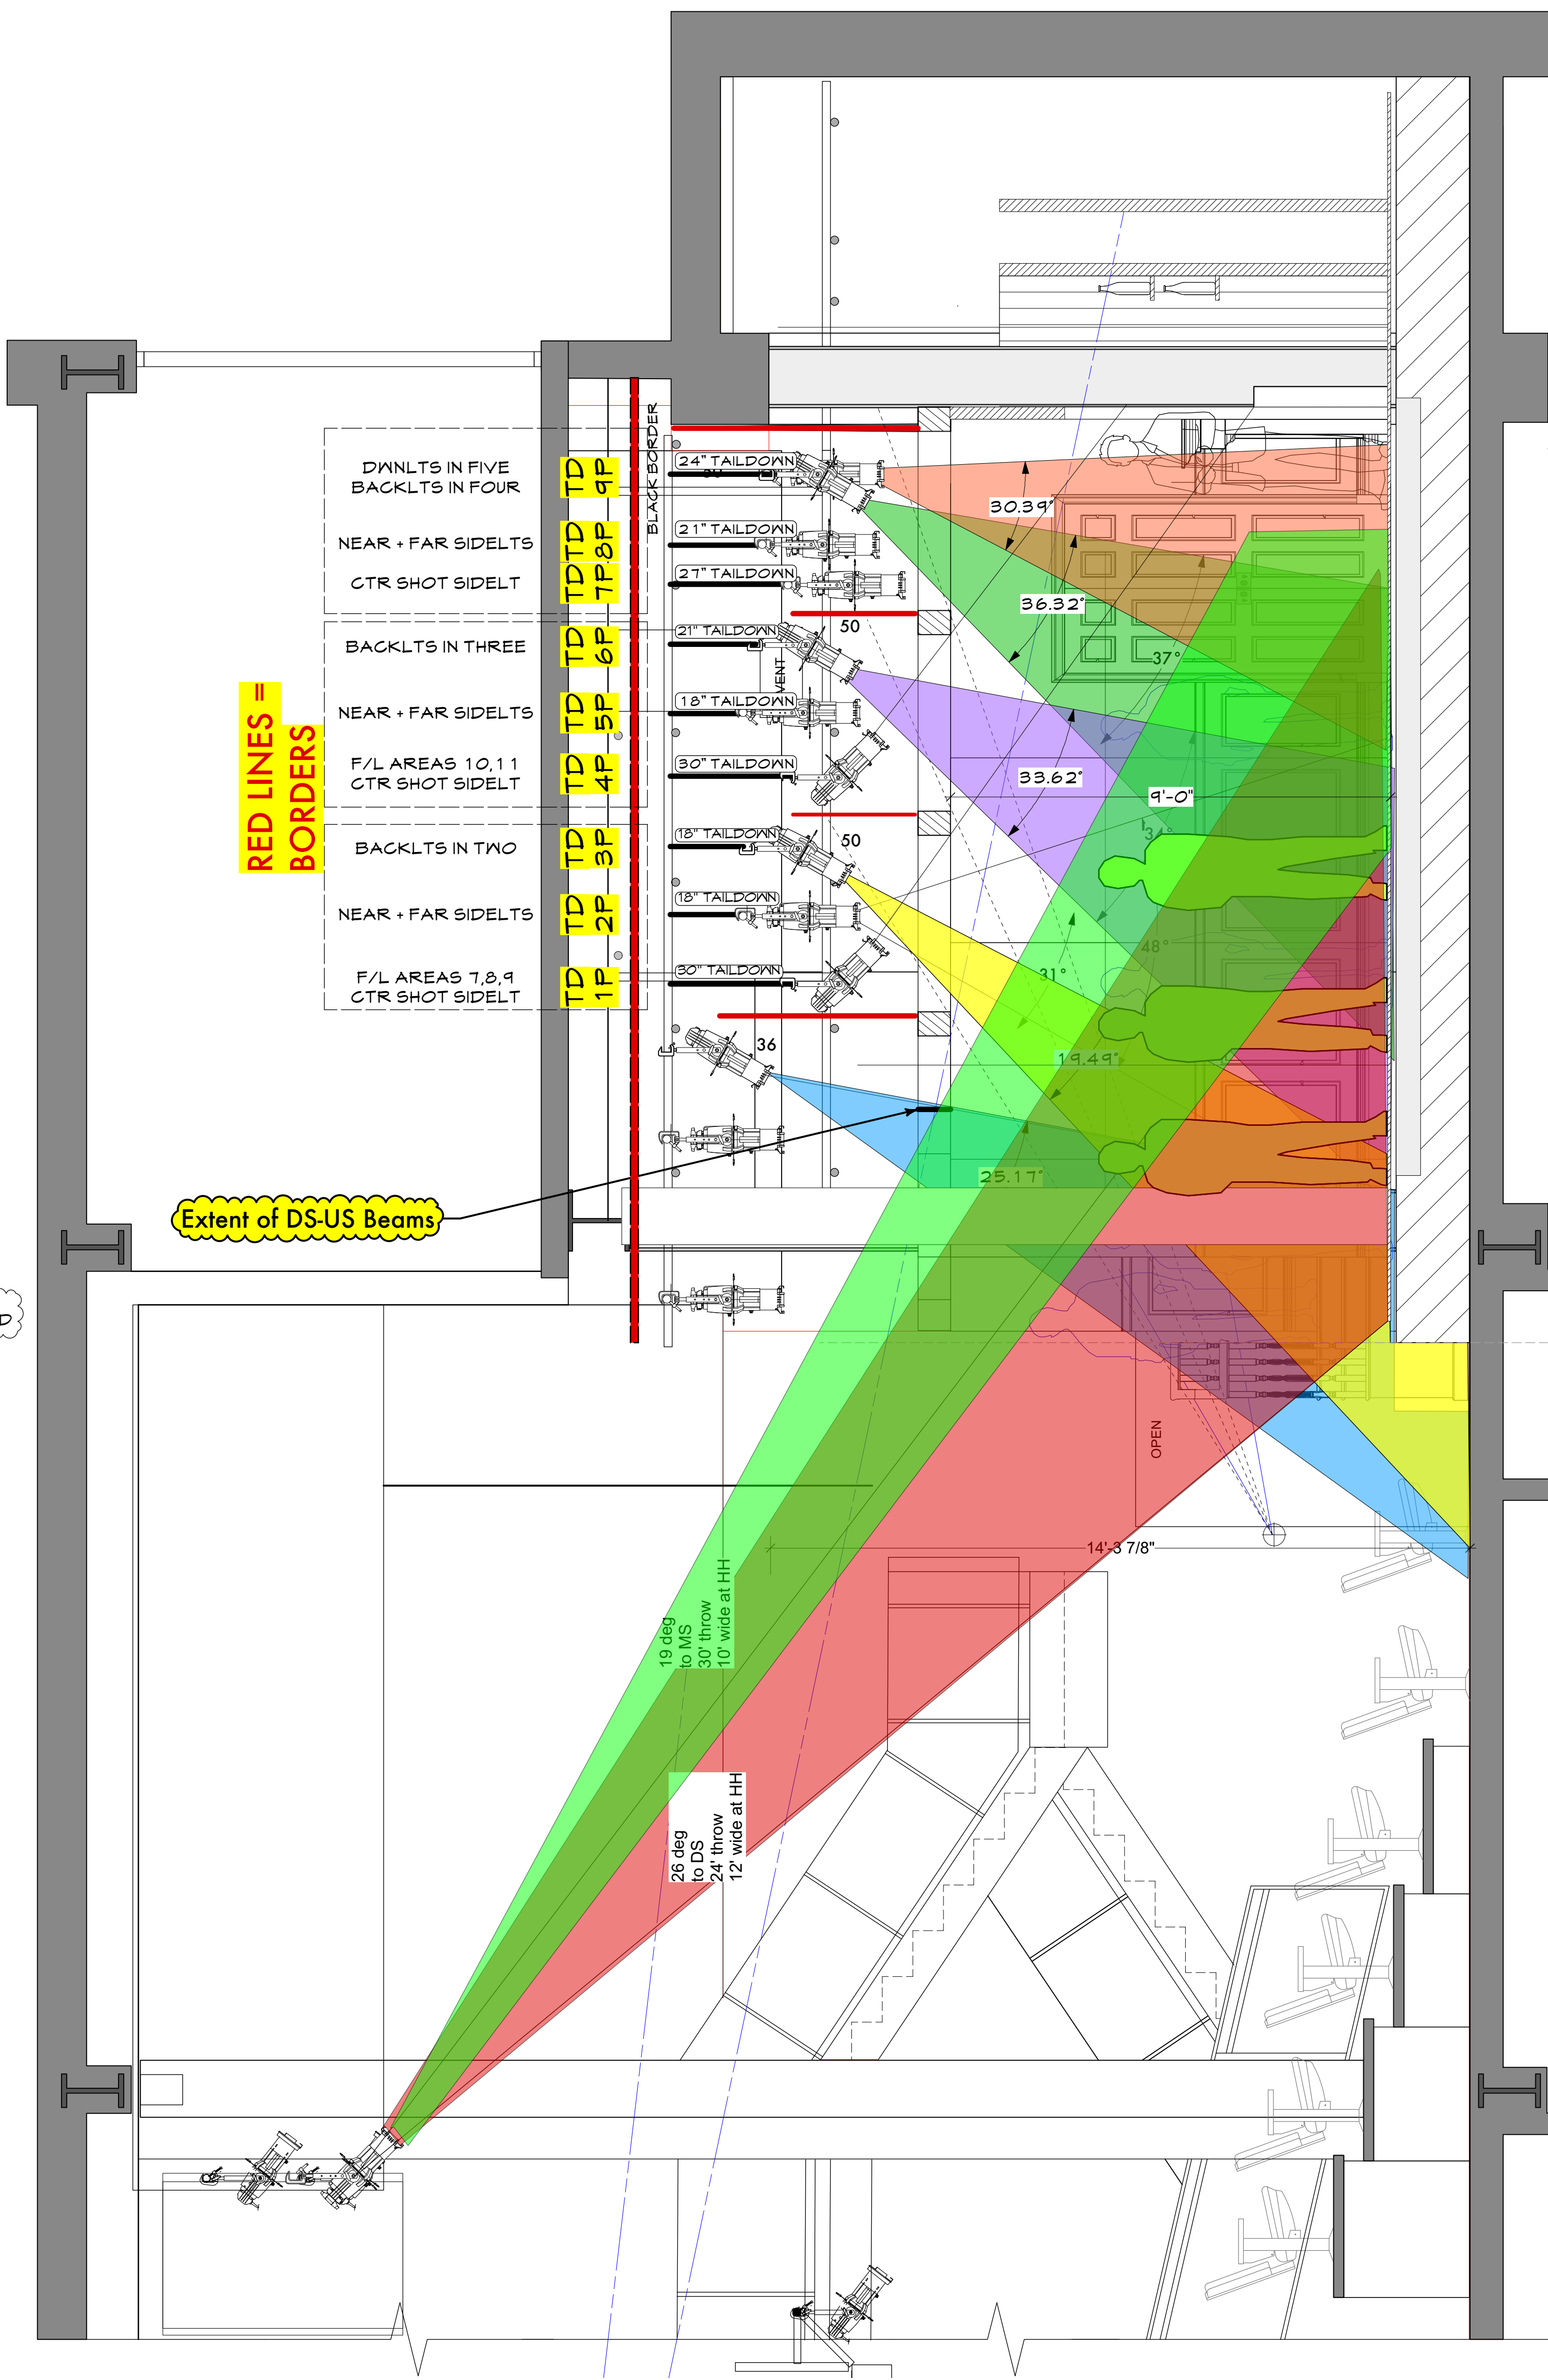

CENTERLINE LIGHTING SECTION TOWARDS S.R.

- SYMT
- | | | |
|-------------|----------------------|--------------------------------------|
| S4-19' 575W | S4-10' 575W | 26' LUSTRE 2 LED |
| S4-26' 575W | 2K FRESNEL 6.4" LENS | 36' LUSTRE 2 LED |
| S4-36' 575W | S4 PAR MFL 575W | 50' LUSTRE 2 LED |
| S4-50' 575W | S4 PAR WFL 575W | PRAC OR SET ELECTRIC |
| | | BIRDIE EZK/JCR 120V 150W FLANGE BASE |

PREVIEWS
3/1/22 AT 4:50 PM

THIS DRAWING REPRESENTS
VISUAL CONCEPTS AND
CONSTRUCTION SUGGESTIONS
ONLY.

L.D. 451
LIGHTING DESIGNER

The designer is unqualified to determine the structural appropriateness and safety of this design and will not assume responsibility for damages or injury resulting from improper engineering, construction, rigging, handling, installation or use of the lighting equipment. All materials must comply with the most stringent applicable electrical and safety codes.

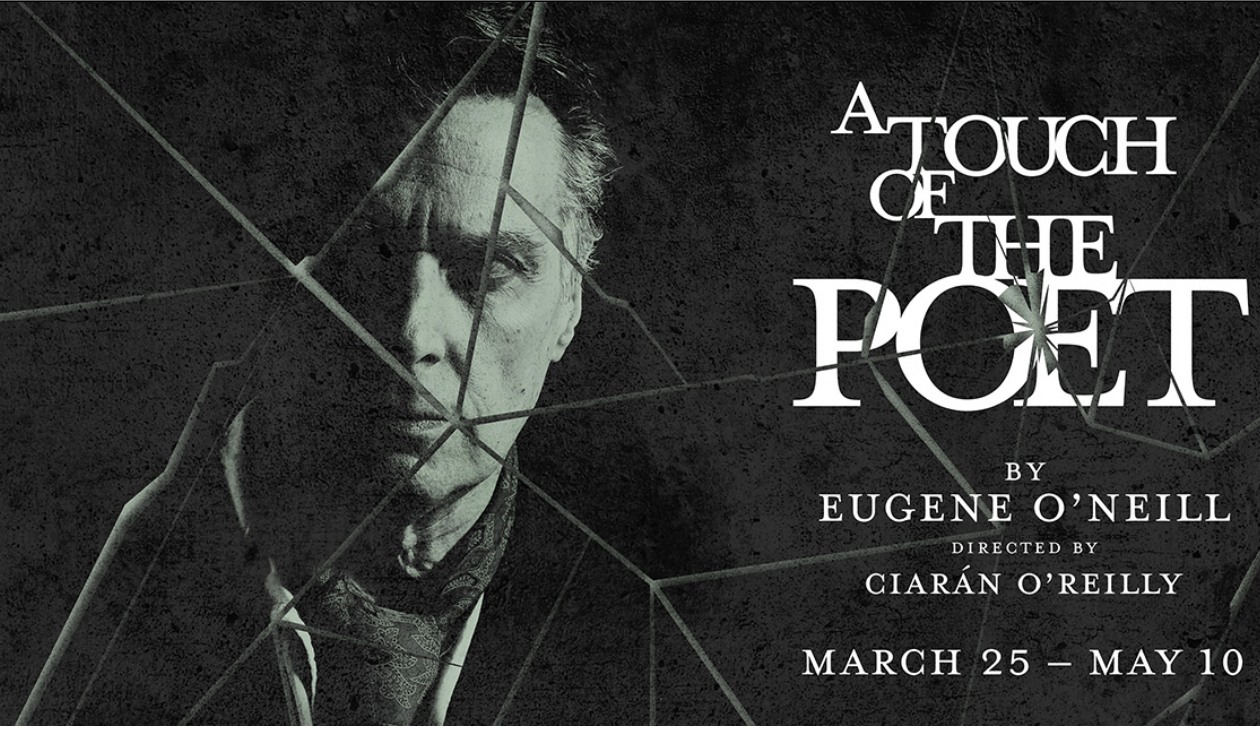


PLATE 2 OF 2

THE IRISH REP PRESENTS

A TOUCH OF
THE POET

DIRECTION: CIARAN O'REILLY

SCENERY: CHARLIE CORCORAN

LTG. ELEVATIONS

LIGHTING BY: MICHAEL GOTTLIEB

ELEC. MEGAN PETI

SCALE: 1/2" = 1'-0" • 12 MAR 2020