
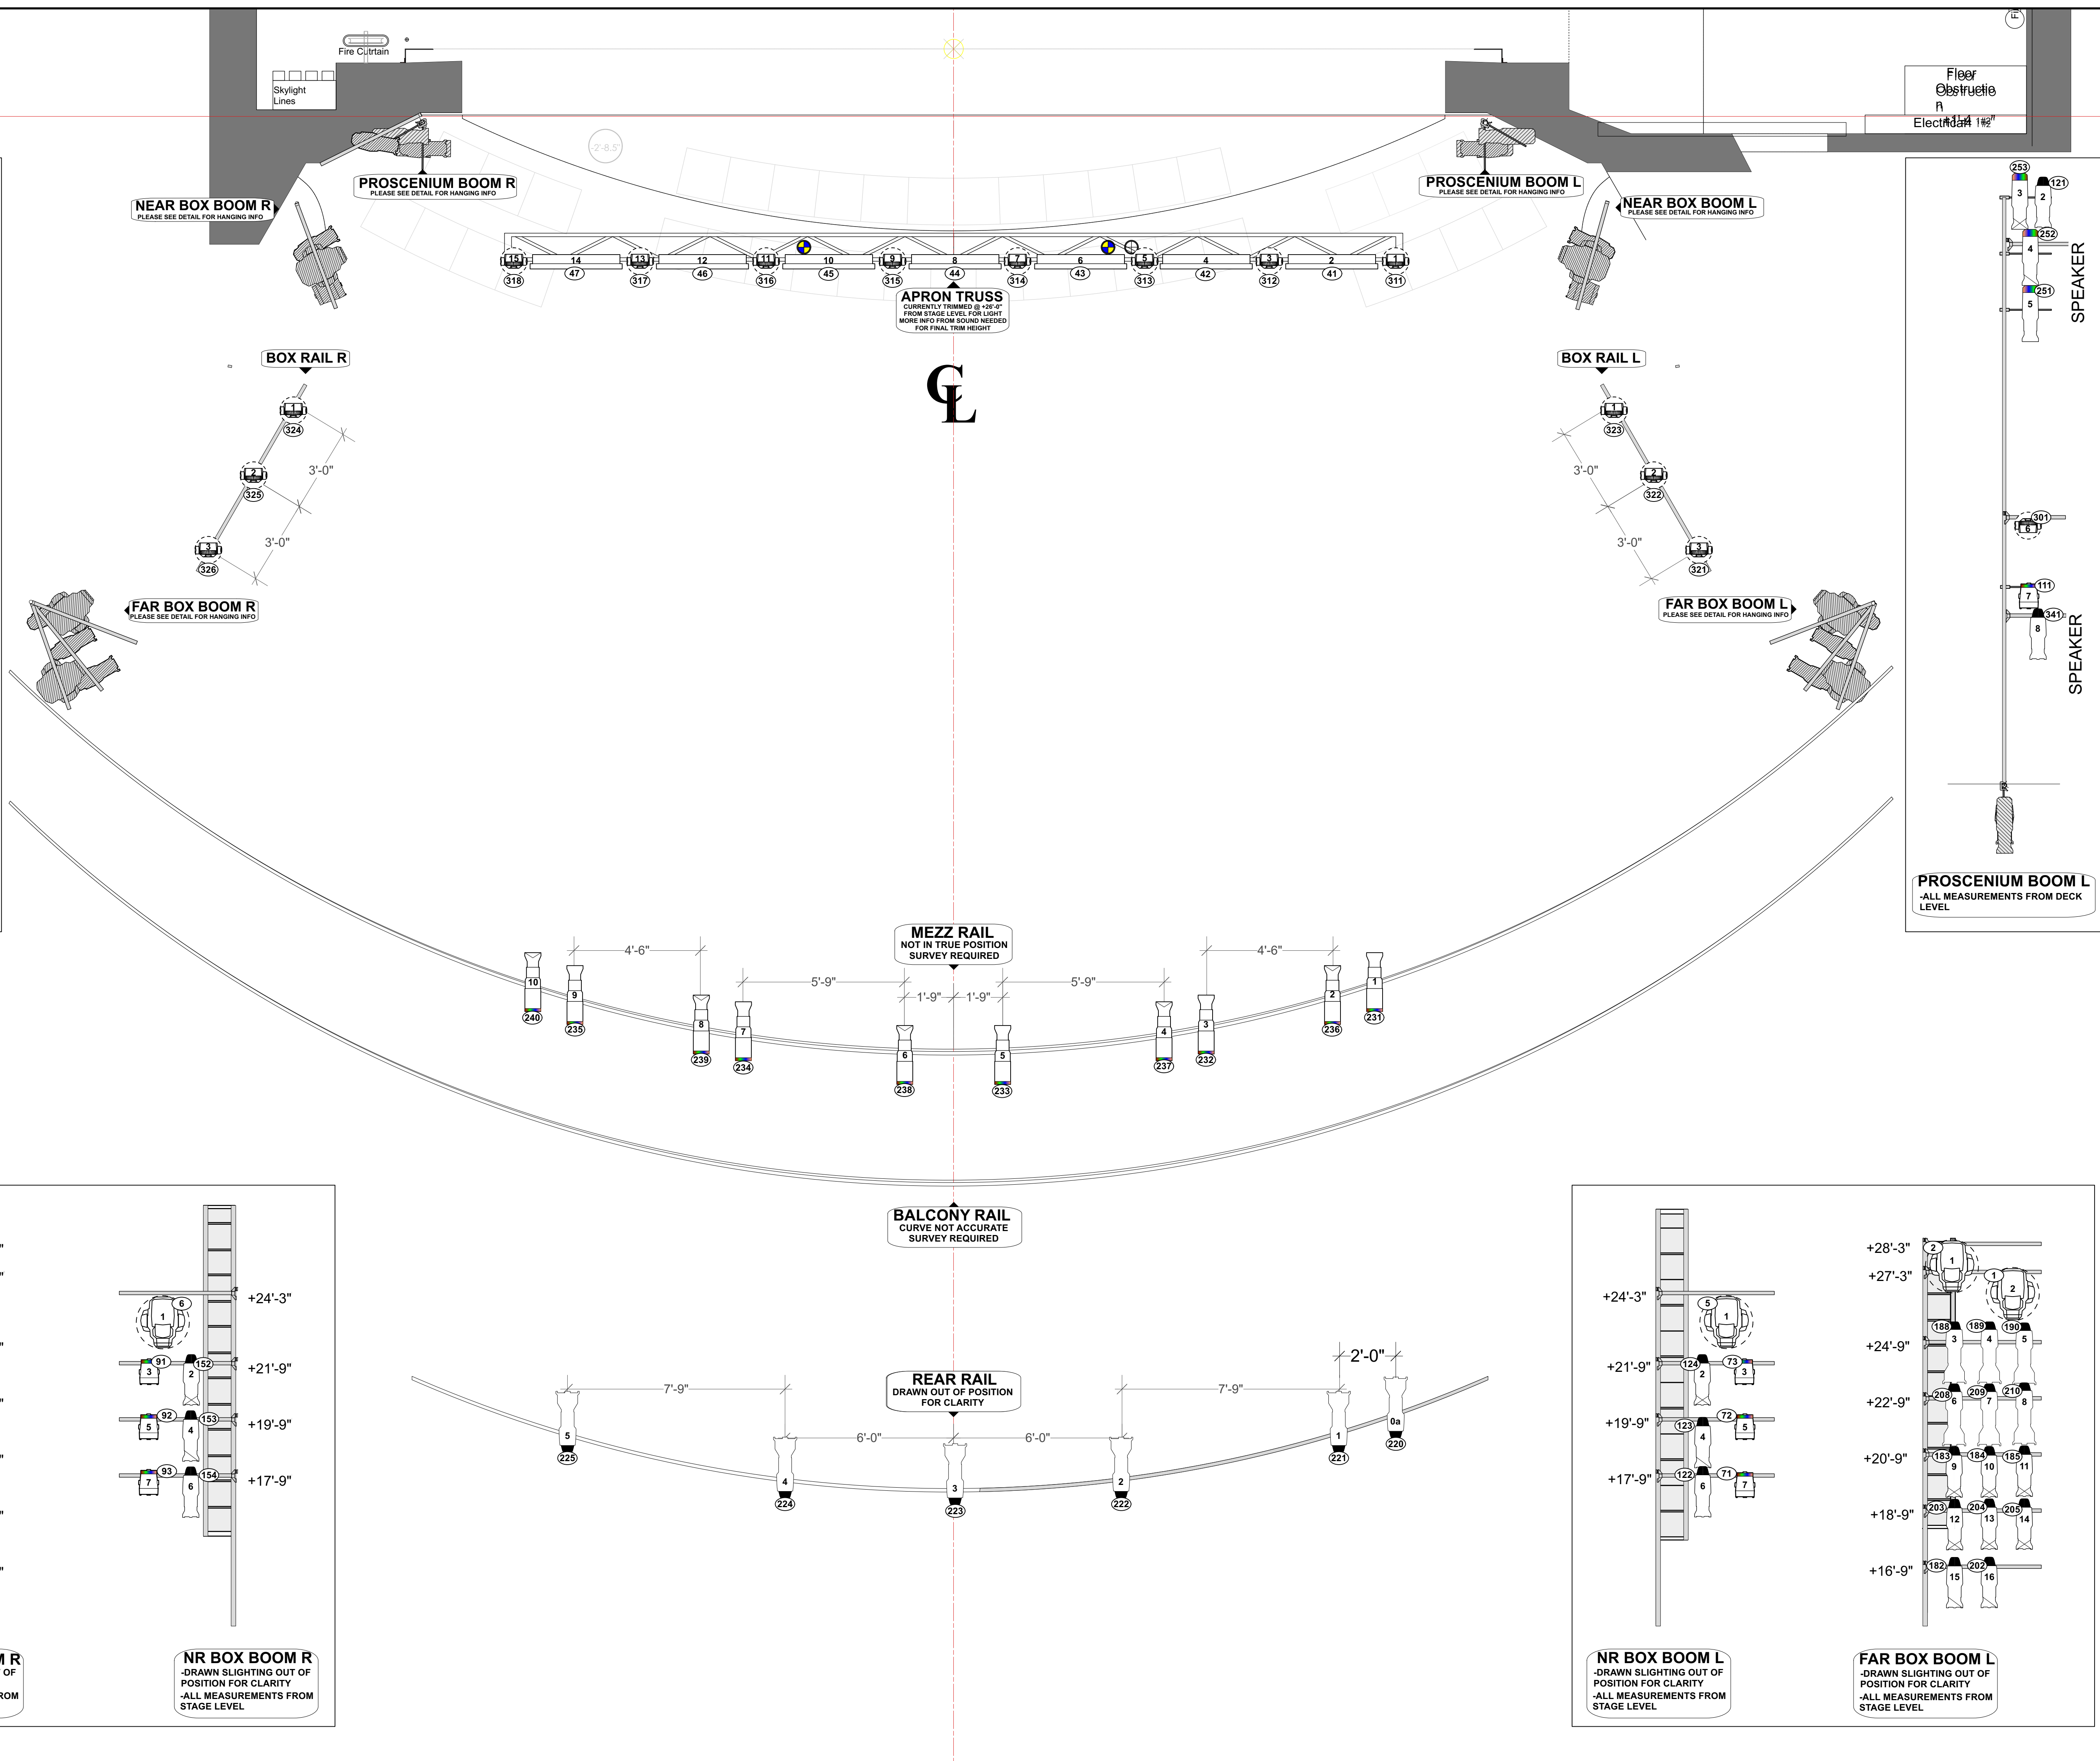


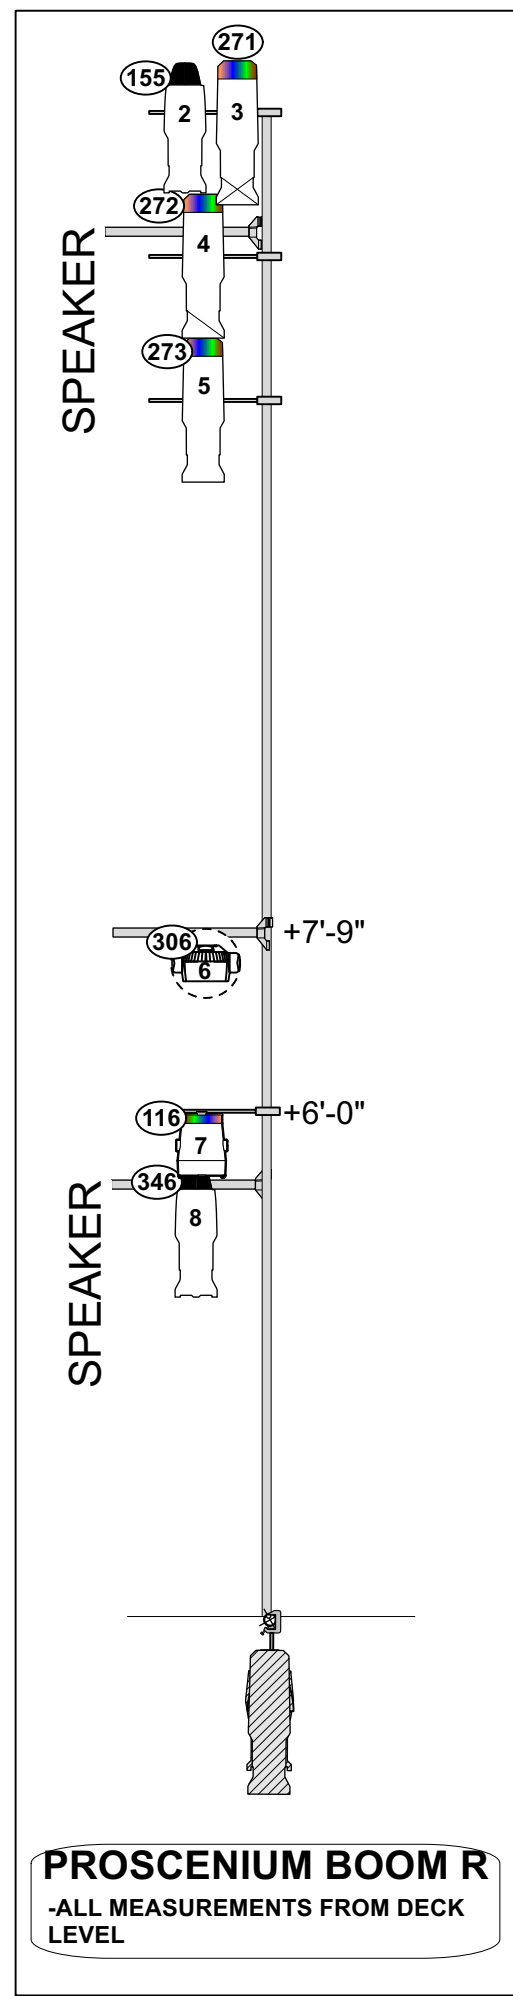

INSTRUMENTATION

- ETC SOURCE 4 14°@575W
- ETC SOURCE 4 19°@575W
- ETC SOURCE 4 26°@575W
- ETC SOURCE 4 36°@575W
- ETC LUSTR 2 19°@171W
- ETC LUSTR 2 26°@171W
- ETC LUSTR 2 36°@171W
- ETC COLORSOURCE SPOT 36°@160W
- ETC COLORSOURCE SPOT 50°@160W
- ETC SOURCE 4 PAR NSP@750W
- ETC SOURCE 4 PAR MFL@750W
- ETC SOURCE 4 PAR WFL@750W
- ELATION ZW-19@250W
- ELATION SIXPAR 300@220W
- CHAVET PRO COLORADO 2 @130W
- GANTOM LIGHTS@24W
- ELATION PALADIN PANEL@800W
- ROCKVILLE LED WIRELESS STRIP@60W
- MARTIN ENCORE PERFORMANCE CLD @600W
- MARTIN AURA XB @236W
- GLP IMPRESSION X4 BAR @450W
- CLIPLIGHT W/BUE BULB @25W
- JAR LANTERN W/REDBULB @25W
- GHOSTLIGHT @100W

TYPICAL UNIT

TEMPLATE — # — UNIT NUMBER
CHANNEL — # —

NOTES

- ALL DIMENSIONS ARE FROM CENTER LINE & PLASTER LINE UNLESS OTHERWISE NOTED
- ALL TRIMS ARE FROM STAGE FLOOR TO SIDEARM/PIPE UNLESS NOTED
- ALL UNITS HUNG ON 18" CENTERS UNLESS OTHERWISE DIMENSIONED
- WRITTEN DIMENSIONS TAKE PRECEDENCE OVER SCALE MEASUREMENTS
- PLEASE SEE HOOKUP FOR COLOR AND ACCESSORY INFORMATION - TOPHAT & BARNDORS ARE NOT DRAWN ON PLOT
- PLEASE DROP ALL ACCESSORIES & COLOR PRIOR TO START OF FOCUS

REVISIONS

NO.	REVISION	DATE

DISCLAIMER

THIS DRAWING REPRESENTS VISUAL CONCEPTS AND CONSTRUCTION SUGGESTIONS ONLY.

THE NEW CONSTRUCTION OF THIS LIGHTING DESIGN BY THE CURRENT DESIGN COMPANY IS ONLY WITH THE MOST EXTENSIVE APPLICABLE FEDERAL AND LOCAL SAFETY AND FIRE CODES. ALL DIMENSIONS, EQUIPMENT LISTS, AND LIGHTING PLANT REPRESENTATIONS ARE VISUAL CONCEPTS ONLY. THE LIGHTING DESIGNER IS NOT RESPONSIBLE FOR DETERMINING STRUCTURAL SUPPORTS AND WEIGHTS OF THE DESIGN. THE LIGHTING DESIGNER IS NOT RESPONSIBLE FOR DETERMINING ENGINEERING, CONSTRUCTION, HANDLING, OR USE OF THE LIGHTING EQUIPMENT VEHICLE OR ACCESSORIES.

THE THEATRICAL EVENT OF THE SEASON | 15 WEEKS ONLY

DANIEL CRAIG **RUTH NEGGA**

MACBETH

DIRECTED BY **SAM GOLD**

LONGACRE THEATRE
NEW YORK BROADWAY THEATER

DIRECTED BY Sam Gold
SCENIC DESIGN BY Christine Jones
COSTUME DESIGN BY Suttirat Larlarb
SOUND DESIGN BY Mikael Sulaiman
LIGHTING DESIGN BY Jane Cox

FOH PLOT

SCALE: 3/8" = 1'-0"

PLATE **2**

DRAFTED BY Tess James O.F.F. FOUR