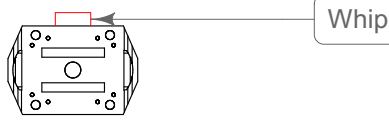
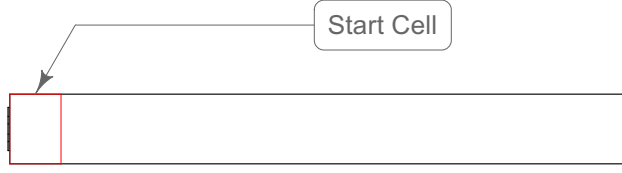






GENERAL NOTES	
1.	All substitutions are accepted upon approval by designer.
2.	Do not substitute LED strobes with SGM fixtures.
3.	Do not substitute hazer with DF-50.
4.	All LED strobes must have a white LED chip.
5.	All atmospheric effect placement to be finalized on site by designer.
6.	Vendor to supply PDF of the plot with fixture IDs, PDF of the patch, and a patched MA3D showfile no less than 2 weeks prior to first show date.







CONSOLE NOTES	
1.	All GrandMA console and NPU software versions: 3.9.60.37.
2.	All consoles and NPUs to have specified software version installed prior to designer arrival.
3.	All consoles to include canned air, microfiber cloth, and clean soft paint brush.
4.	All consoles and NPUs must be in 100% working condition.
5.	No lighting control substitutions will be accepted.
6.	All MA Lighting products must be genuine and purchased from an authorized MA Lighting dealer.

FOH NOTES	
1.	Vendor must supply competent, english speaking, FOH tech who is knowledgeable about the installed system, networking, troubleshooting, and MA Lighting products available whenever the designer is on site.
2.	All consoles and networking to be installed and working prior to designer arrival.
3.	Vendor to provide network switch and spare CAT5e cables for desgner to connect to MANet, ArtNet, sACN, KiNet, ect. networks.
4.	Vendor to provide long range wireless access point located at FOH for designer to remotely control the console.
5.	All passwords and login information should be clearly labeled at location of the wireless access point.
6.	FOH must have enough desk space for two (2) GrandMA Full-Size consoles (main and backup), as well as other equipment provided by the designer.
7.	Vendor to provide two (2) office chairs compatable with the height of the console.
8.	Main and backup console to be set on top of the smaller road case lid (flipped upside down.) Refer to FOH detail page.
9.	If FOH is not center- A console must be placed in the middle of the venue for programming prior to designer arrival.

STAGING NOTES	
1.	All ballasting, staging, substructure, etc. to be painted black, unless otherwise specified.
2.	Invert hoists whenever possible.
3.	Cable swags should never be hung in front of any visable truss or hanging positions.
4.	Structure is for reference only. Refer to vendor's drawings for an accurate representation. Structure shoould never be built based on these designer drawings.

TYPICAL FIXTURE	
	Moving Light
	Multicell Fixture

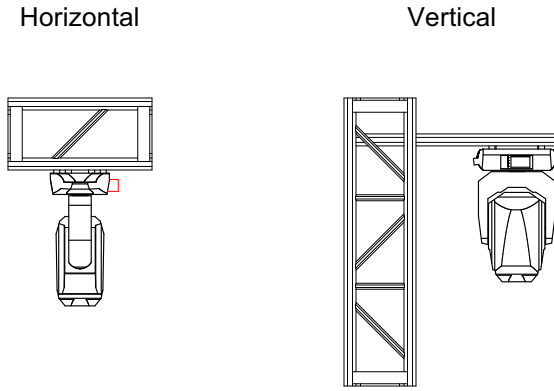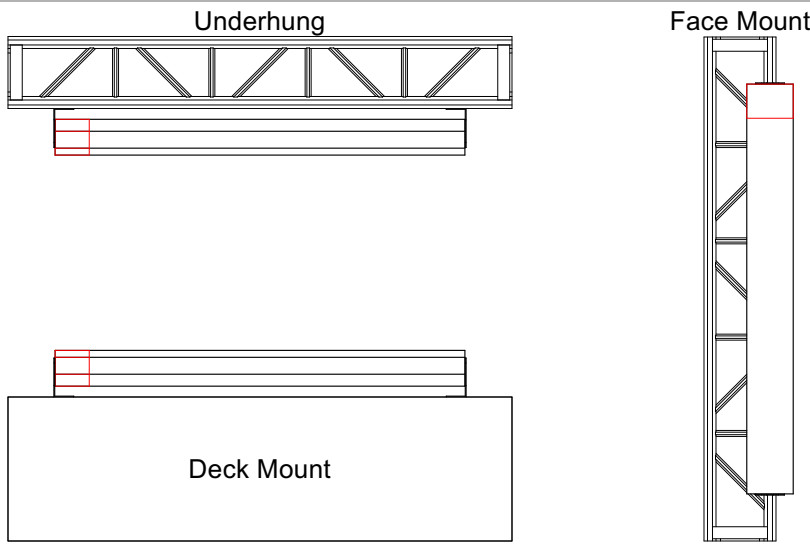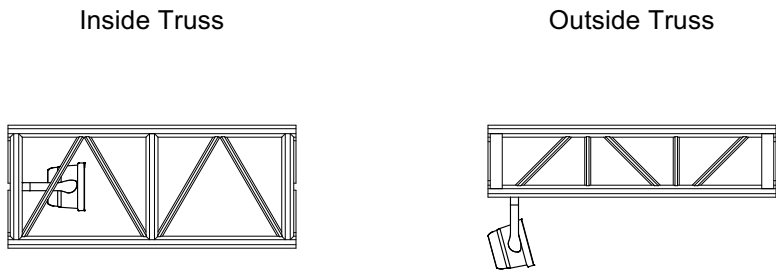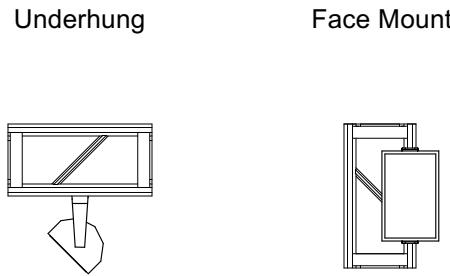TYPICAL FIXTURE ORIENTATION	
	Moving Light -To be hung so home position allows fixture to tilt US/DS.
	Multicell Fixture -To be focused perpendicular to truss. -Start cell always SR or on top. -DSE mounted LED strips focused US to light performers.
	Truss Toner -To be mounted inside truss if possible, otherwise mounted outside to graze truss.
	Static Fixture -Underhung fixtures to be focused 45° towards audience. -Face mount fixtures to be focused perpendicular to truss.

    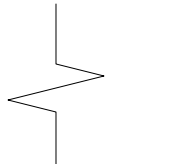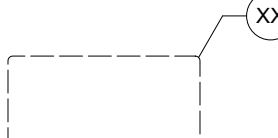ANNOTATION LEGEND	
	Datum Marker -Measured from CL/PL Origin
	Hoist Rig Point -Measured from CL/PL Origin
	Platform Height Marker
	Detail Marker
	Break Line
	Detail Selection

EQUIPMENT LIST		
LIGHTING		
Item	Qty	Mode (ch)
Ayrton Perseo Beam	132	Standard (40ch)
Chauvet Color Strike M	86	13 Channel (13ch)
Chauvet Maverick MK2 Wash	8	Single-Basic (20ch)
Chauvet Strike Saber	61	27 Channel (Dimmer Mode=Dimmer 1) (27ch)
GLP Impression X4 Bar 20	28	Single Pixel High Res (89ch)
GLP JDC Line 1000	28	MultiPix Advanced (316ch)
Martin Scepton-1000mm	481	P3 - Pixel Map (10 Segments)/Square Smoked Lens (30ch)
Robe MegaPointe	8	Mode 1 (39ch)
SGM P-2 + Barn Doors	4	5.2.0 (22ch)
VIDEO		
Item	Qty	Pixel Pitch
600mm Triple Video Header	6	N/A
ROE CB8 600mmx 1200mm	396	8.3mm
Video Tile-600mmx600mm	204	8mm
Video Tile-1200mmx1200mm	280	25mm Blow Through
~762 M² Total		
SFX		
Item	Qty	Mode (ch)
Blower Fan	12	N/A (0ch)
Co2 Valve	14	N/A (0ch)
Flame Head	20	N/A (0ch)
Generic Laser	18	Beyond 5.0 Mid (32ch)
Hazer	12	2 Channel (2ch)
Martin AF 1 DMX Fan	4	5.2.0 (1ch)
CONTROL		
Item	Qty	Software Version
GrandMA2 Full-Size	2	3.9.60.37
Martin P3 Computer	1	Martin P3
Beyond Computer	1	Beyond 5.0 Ultimate
Generic Cooling/Heating Fan	2	https://a.co/d/hTWl56b
RIGGING		
Item	Qty	Color
12inx12in Box Truss-10ft (Black)	24	Black
19inx19in Pipe Base (Black)	4	Black
2in Sched. 40 Pipe-06ft (Black)	4	Black
Tyler Truss GT-10ft (Black)	54	Black
Tyler Truss GT-CB 2-Way (Black)	24	Black
Tyler Truss GT-05ft (Black)	18	Black
Tyler Truss GT-CB 3-Way (Black)	12	Black
Container Bracket - Bottom (Black)	12	Black
20inx20in Box Truss-10ft (Black)	30	Black
12inx12in Box Truss-CB (Black)	10	Black
12inx12in Box Truss-05ft (Black)	5	Black
30inx30in Truss Base (Black)	6	Black
20inx20in Box Truss-08ft (Black)	6	Black
I Beam-06ft (Black)	2	Black
I Beam-20ft (Black)	4	Black
2in Sched. 40 Pipe-03ft (Black)	12	Black
SCENIC		
Item	Qty	
20ft Standard Shipping Container	22	

IP ALLOCATIONS	
Device	IP Range
Main Console Port 1	192.168.0.1
Main Console Port 2	10.0.0.1
Main Console Port 3 (MA3)	Keep Empty
Backup Console Port 1	192.168.0.2
Backup Console Port 2	10.0.0.2
Backup Console Port 3 (MA3)	Keep Empty
Additional Consoles Port 1	192.168.0.3 - 192.168.0.10
Additional Consoles Port 2	10.0.0.3 - 10.0.0.10
NPU/MA-Net Devices	192.168.0.11 - 192.168.0.200
Artnet/sACN Nodes	10.0.0.11 - 10.0.0.50
Artnet/sACN Devices	10.0.0.51 - 10.0.0.255
Network Switches	192.168.0.201 - 192.168.0.255

FOLLOWSPOT COLORS			
WHEN APPLICABLE			
Frame	Name	Manufacturer	Color
1	1/4 Hamburg Frost	Roscolux	132
2	1/8 Minus Green	Lee Filters	279
3	1/4 Minus Green	Lee Filters	249
4	Pale Amber Gold	Roscolux	09
5	Suprise Pink	Roscolux	51
6	Dark Steel Blue	Lee Filters	174
TBD	Light Red	Roscolux	26


 
 
 
 
 
 
 
 
 
 
 
 
 
 
 
 
 
 
 
 
KEY TO SYMBOLS		
SUBSTITUTIONS ARE ACCEPTED UPON APPROVAL		
LIGHTING		
Thumbnail	Item	Qty
	Ayrton Perseo Beam - Standard (40ch)	132
	Chauvet Color Strike M - 13 Channel (13ch)	86
	Chauvet Maverick MK2 Wash - Single-Basic (20ch)	8
	Chauvet Strike Saber - 27 Channel (Dimmer Mode=Dimmer 1) (27ch)	61
	GLP Impression X4 Bar 20 - Single Pixel High Res (89ch)	28
	GLP JDC Line 1000 - MultiPix Advanced (316ch)	28
	Martin Scepton-1000mm - P3 - Pixel Map (10 Segments)/Square Smoked Lens (30ch)	481
	Robe MegaPointe - Mode 1 (39ch)	8
	SGM P-2 + Barn Doors - 5.2.0 (22ch)	4
VIDEO		
Thumbnail	Item	Qty
	600mm Triple Video Header (N/A)	6
	ROE CB8 600mmx 1200mm (8.3mm)	396
	Video Tile-600mmx600mm (8mm)	204
	Video Tile-1200mmx1200mm (25mm Blow Through)	280
~762 M² Total		
SFX		
Thumbnail	Item	Qty
	Blower Fan - N/A (0ch)	12
	Co2 Valve - N/A (0ch)	14
	Flame Head - N/A (0ch)	20
	Generic Laser - Beyond 5.0 Mid (32ch)	18
	Hazer - 2 Channel (2ch)	12
	Martin AF 1 DMX Fan - 5.2.0 (1ch)	4
CONTROL		
Thumbnail	Item	Qty
	Beyond Computer (Beyond 5.0 Ultimate)	1
	Generic Cooling/Heating Fan (https://a.co/d/hTWl56b)	2
	GrandMA2 Full-Size (3.9.60.37)	2
	Martin P3 Computer (Martin P3)	1
RIGGING		
	Item	Qty
	2in Sched. 40 Pipe-03ft (Black)	12
	2in Sched. 40 Pipe-06ft (Black)	4
	12inx12in Box Truss-05ft (Black)	5
	12inx12in Box Truss-10ft (Black)	24
	12inx12in Box Truss-CB (Black)	10
	19inx19in Pipe Base (Black)	4
	20inx20in Box Truss-08ft (Black)	6
	20inx20in Box Truss-10ft (Black)	30
	30inx30in Truss Base (Black)	6
	Container Bracket - Bottom (Black)	12
	I Beam-06ft (Black)	2
	I Beam-20ft (Black)	4
	Tyler Truss GT-05ft	18

TABLE OF CONTENTS	
Sheet Title	Page
Cover Page	1
Saturday/Sunday Rendering	2
Saturday/Sunday Plan	3
Saturday/Sunday Front Elevation/CL Section	4
Saturday/Sunday Deck Detail	5
Detail A	6
Detail B	7
Detail C,D,E,F	8
Detail G,N	9
Saturday/Sunday DJ Booth & FOH Detail	10
Friday Rendering	11
Friday Plan	12
Friday Front Elevation/CL Section	13
Friday Deck Detail	14

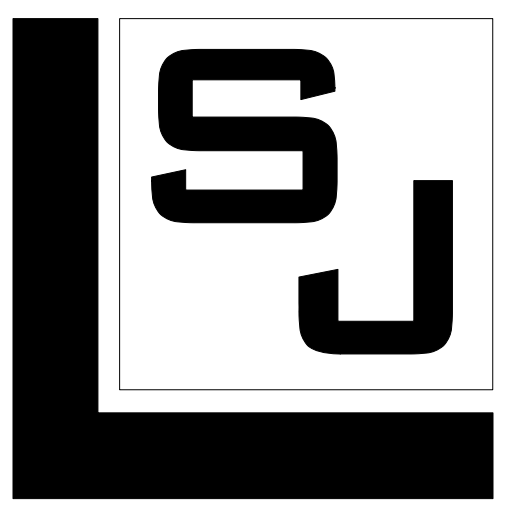

SJ LIGHTING, INC.

WESTLAKE VILLAGE, CA

818.874.9779

INFO@SJLIGHTING.NET

WWW.SJLIGHTING.NET

THE DESIGN AND ALL ASSOCIATED PAPERWORK IS COPYRIGHTED MATERIAL AND REMAINS THE PROPERTY OF THE DESIGNER.

THIS DESIGN IS FOR ONE TIME USE ONLY AT THE SPECIFIED LOCATION AND IS NOT TO BE USED FOR ANY OTHER PURPOSE OR EVENT WITHOUT SPECIFIC WRITTEN PERMISSION OF THE DESIGNER.

DESIGNER IS NOT A STRUCTURAL ENGINEER AND THESE DRAWINGS REPRESENT DESIGN CONCEPTS ONLY AND ARE NOT INTENDED AS ENGINEERING DRAWINGS. THE DESIGNER ASSUMES NO RESPONSIBILITY FOR THE SAFETY OR STRUCTURAL INTEGRITY OF ANY EQUIPMENT PROVIDED BY ANYONE.



ARC MUSIC FESTIVAL

REV #	REMARKS	DATE	INT.
001	-Initial Design	4/6/2023	AHT
002	-Update Saturday Deck Detail	4/21/2023	AHT
003	-Update Friday DJ Booth	5/30/2023	AHT
004	-Add Detail M	7/6/2023	AHT
005	-Update Friday DJ Booth	7/19/2023	AHT
	-Add Detail N		
	-Update Detail A,B,C,D		
	-Update Friday & Saturday DJ Booth		
	-Update Friday & Saturday Deck Detail		
006	-Update Audio Hangs	8/3/2023	AHT
007	-Update Deck Size	8/11/2023	AHT
008	-Update Detail A,B	8/22/2023	AHT

AURIS PRESENTS

ARC MUSIC FESTIVAL

CHICAGO, IL

UNION PARK

SEPTEMBER 1-3, 2023

STAGE 1

ISSUE DATE

Wednesday, August 23, 2023

DRAWN BY

MTR
SUL


SCALE

SEE DRAWING
ARCH D (24"x36")


Cover Page

DD

1 OF 20

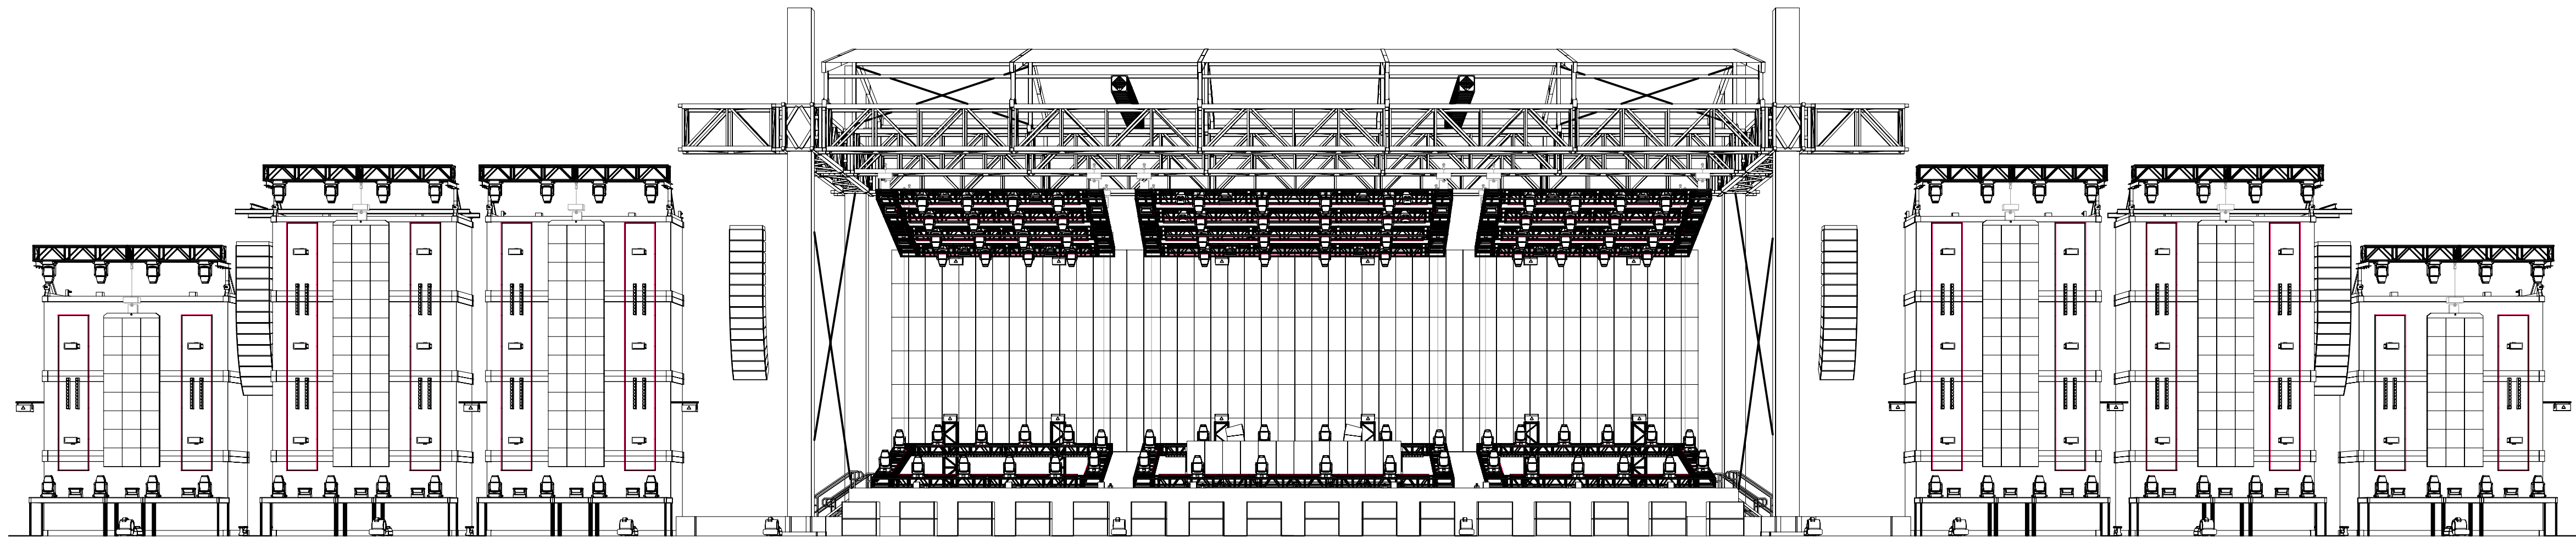

1 Front Perspective
Scale: 3/8" = 1'-0"

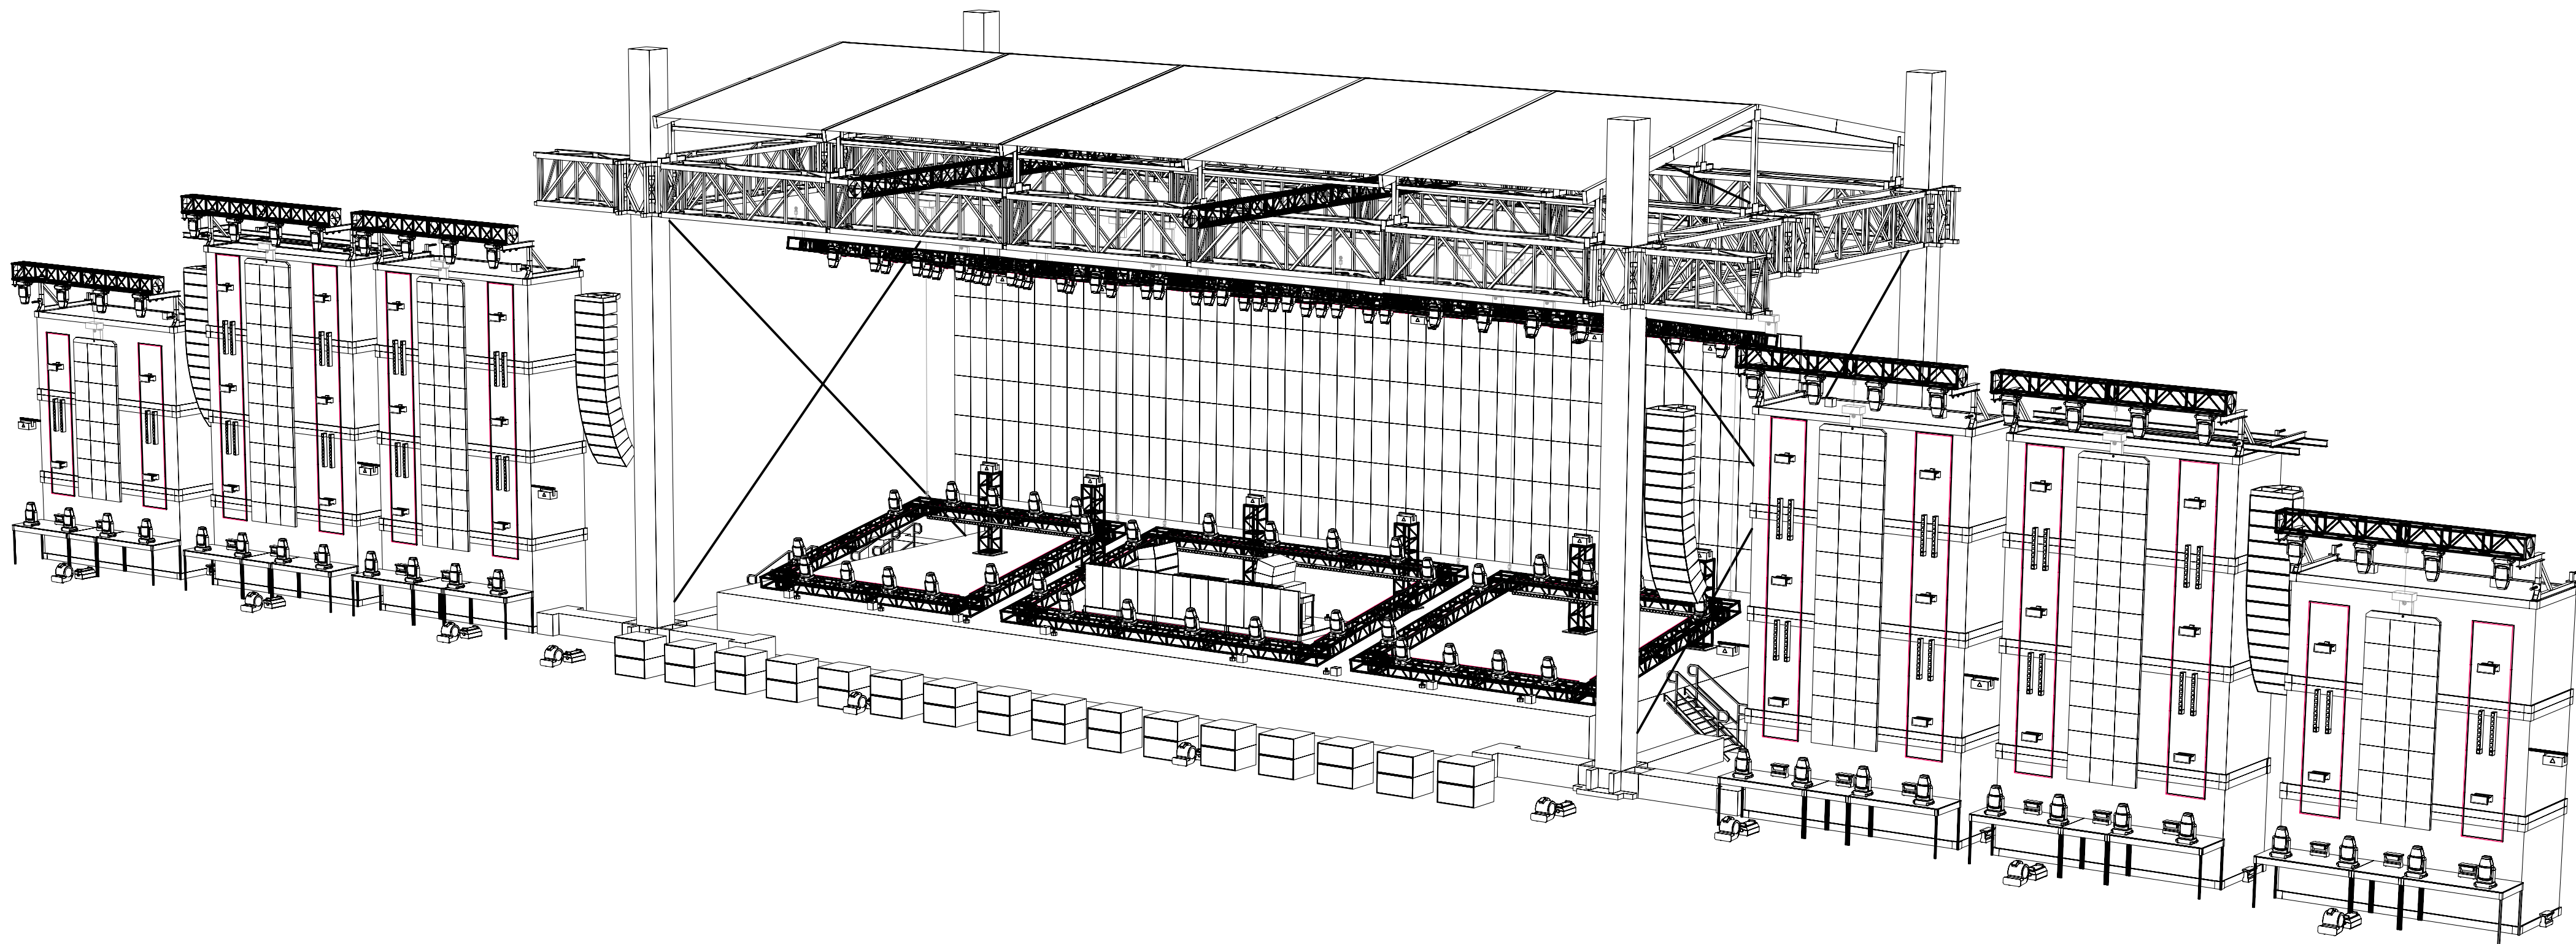

2 Isometric
Scale: 1/2" = 1'-0"

KEY TO SYMBOLS

SUBSTITUTIONS ARE ACCEPTED UPON APPROVAL

LIGHTING

Thumbnail	Item	Qty
	Ayrton Perseo Beam - Standard (40ch)	132
	Chauvet Color Strike M - 13 Channel (13ch)	86
	Chauvet Maverick MK2 Wash - Single-Basic (20ch)	8
	Chauvet Strike Saber - 27 Channel (Dimmer Mode=Dimmer 1) (27ch)	61
	GLP Impression X4 Bar 20 - Single Pixel High Res (89ch)	28
	GLP JDC Line 1000 - MultiPix Advanced (316ch)	28
	Martin Scepton-1000mm - P3 - Pixel Map (10 Segments)/Square Smoked Lens (30ch)	481
	Robe MegaPointe - Mode 1 (39ch)	8
	SGM P-2 + Barn Doors - 5.2.0 (22ch)	4

VIDEO

Thumbnail	Item	Qty
	600mm Triple Video Header (N/A)	6
	ROE CB8 600mmx1200mm (8.3mm)	396
	Video Tile-600mmx600mm (8mm)	204
	Video Tile-1200mmx1200mm (25mm Blow Through)	280

~762 M² Total

SFX

Thumbnail	Item	Qty
	Blower Fan - N/A (0ch)	12
	Co2 Valve - N/A (0ch)	14
	Flame Head - N/A (0ch)	20
	Generic Laser - Beyond 5.0 Mid (32ch)	18
	Hazer - 2 Channel (2ch)	12
	Martin AF 1 DMX Fan - 5.2.0 (1ch)	4

CONTROL

Thumbnail	Item	Qty
	Beyond Computer (Beyond 5.0 Ultimate)	1
	Generic Cooling/Heating Fan (https://a.co/d/hTWf56b)	2
	GrandMA2 Full-Size (3.9.60.37)	2
	Martin P3 Computer (Martin P3)	1

RIGGING

Item	Qty
2in Sched. 40 Pipe-03ft (Black)	12
2in Sched. 40 Pipe-06ft (Black)	4
12inx12in Box Truss-05ft (Black)	5
12inx12in Box Truss-10ft (Black)	24
12inx12in Box Truss-CB (Black)	10
19inx19in Pipe Base (Black)	4
20inx20in Box Truss-08ft (Black)	6
20inx20in Box Truss-10ft (Black)	30
30inx30in Truss Base (Black)	6
Container Bracket - Bottom (Black)	12
1 Beam-06ft (Black)	2
1 Beam-20ft (Black)	4
Tyler Truss GT-05ft	

TABLE OF CONTENTS

Sheet Title	Page
Cover Page	1
Saturday/Sunday Rendering	2
Saturday/Sunday Plan	3
Saturday/Sunday Front Elevation/CL Section	4
Saturday/Sunday Deck Detail	5
Detail A	6
Detail B	7
Detail C,D,E,F	8
Detail G,N	9
Saturday/Sunday DJ Booth & FOH Detail	10
Friday Rendering	11
Friday Plan	12
Friday Front Elevation/CL Section	13
Friday Deck Detail	14



SJ LIGHTING, INC.
WESTLAKE VILLAGE, CA
818.874.9779
INFO@SJLIGHTING.NET
WWW.SJLIGHTING.NET

THE DESIGN AND ALL ASSOCIATED PAPERWORK IS COPYRIGHTED MATERIAL AND REMAINS THE PROPERTY OF THE DESIGNER.

THIS DESIGN IS FOR ONE TIME USE ONLY AT THE SPECIFIED LOCATION AND IS NOT TO BE USED FOR ANY OTHER PURPOSE OR EVENT WITHOUT SPECIFIC WRITTEN PERMISSION OF THE DESIGNER.

DESIGNER IS NOT A STRUCTURAL ENGINEER AND THESE DRAWINGS REPRESENT DESIGN CONCEPTS ONLY AND ARE NOT INTENDED AS ENGINEERING DRAWINGS. THE DESIGNER ASSUMES NO RESPONSIBILITY FOR THE SAFETY OR STRUCTURAL INTEGRITY OF ANY EQUIPMENT PROVIDED BY ANYONE.



REVISIONS

REV #	REMARKS	DATE	INT.
001	-Initial Design	4/6/2023	AHT
002	-Update Saturday Deck Detail	4/21/2023	AHT
003	-Update Friday DJ Booth	5/30/2023	AHT
004	-Add Detail M	7/6/2023	AHT
005	-Update Friday DJ Booth	7/19/2023	AHT
	-Add Detail N		
	-Update Detail A,B,C,D		
	-Update Friday & Saturday DJ Booth		
	-Update Friday & Saturday Deck Detail		
006	-Update Audio Hangs	8/3/2023	AHT
007	-Update Deck Size	8/11/2023	AHT
008	-Update Detail B	8/22/2023	AHT

AURIS PRESENTS

ARC MUSIC
FESTIVAL

CHICAGO, IL

UNION PARK

SEPTEMBER 1-3, 2023

STAGE 1

ISSUE DATE

Wednesday, August 23, 2023

DRAWN BY

MTR
S.J.L.


SCALE

SEE DRAWING
ARCH D (24"x36")

Saturday/Sunday
Rendering

DD

2 OF 20

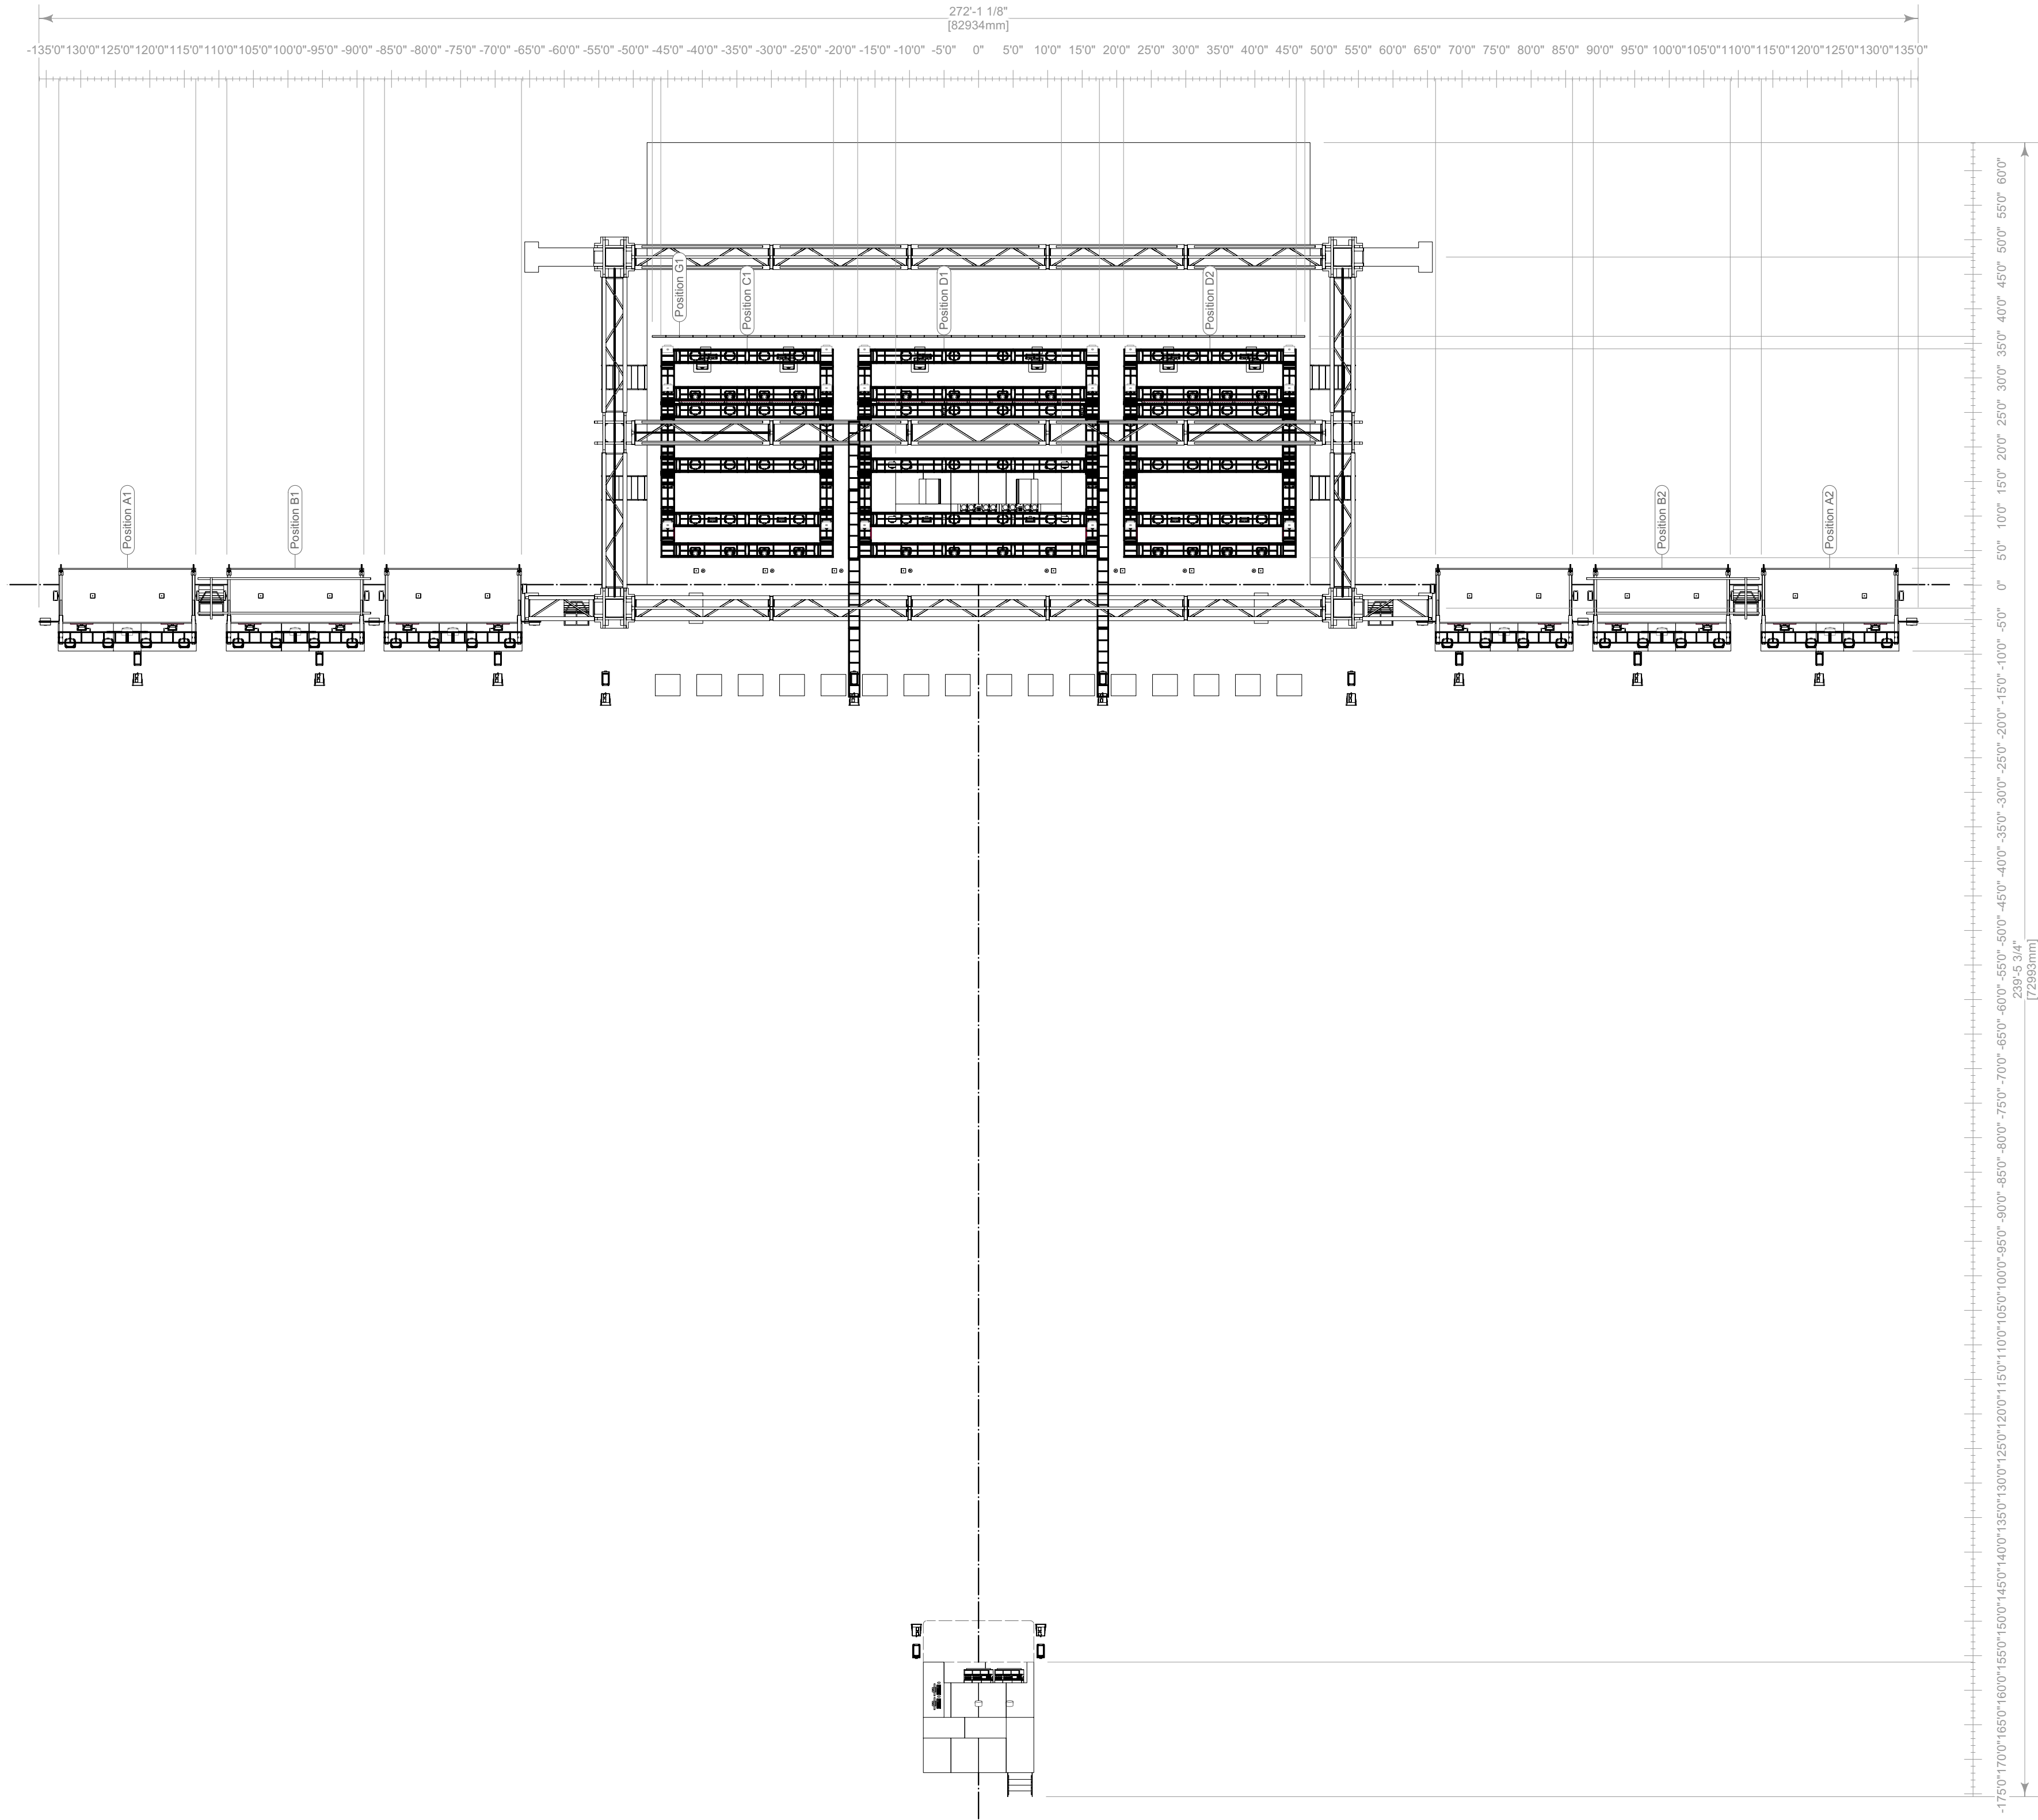

KEY TO SYMBOLS

LIGHTING		
Thumbnail	Item	Qty
	Ayrton Perseo Beam - Standard (40ch)	132
	Chauvet Color Strike M - 13 Channel (13ch)	86
	Chauvet Maverick MK2 Wash - Single-Basic (20ch)	8
	Chauvet Strike Saber - 27 Channel (Dimmer Mode=Dimmer 1) (27ch)	61
	GLP Impression X4 Bar 20 - Single Pixel High Res (89ch)	28
	GLP JDC Line 1000 - MultiPix Advanced (316ch)	28
	Martin Scepton-1000mm - P3 - Pixel Map (10 Segments)/Square Smoked Lens (30ch)	481
	Robe MegaPointe - Mode 1 (39ch)	8
	SGM P-2 + Barn Doors - 5.2.0 (22ch)	4
VIDEO		
Thumbnail	Item	Qty
	600mm Triple Video Header (N/A)	6
	ROE CB8 600mmx1200mm (8.3mm)	396
	Video Tile-600mmx600mm (8mm)	204
	Video Tile-1200mmx1200mm (25mm Blow Through)	280
~762 M² Total		


SFX		
Thumbnail	Item	Qty
	Blower Fan - N/A (0ch)	12
	Co2 Valve - N/A (0ch)	14
	Flame Head - N/A (0ch)	20
	Generic Laser - Beyond 5.0 Mid (32ch)	18
	Hazer - 2 Channel (2ch)	12
	Martin AF 1 DMX Fan - 5.2.0 (1ch)	4

CONTROL		
Thumbnail	Item	Qty
	Beyond Computer (Beyond 5.0 Ultimate)	1
	Generic Cooling/Heating Fan (https://a.co/d/hTwf56b)	2
	GrandMA2 Full-Size (3.9.60.37)	2
	Martin P3 Computer (Martin P3)	1

RIGGING		
Item	Qty	
2in Sched. 40 Pipe-03ft (Black)	12	
2in Sched. 40 Pipe-06ft (Black)	4	
12inx12in Box Truss-05ft (Black)	5	
12inx12in Box Truss-10ft (Black)	24	
12inx12in Box Truss-CB (Black)	10	
19inx19in Pipe Base (Black)	4	
20inx20in Box Truss-08ft (Black)	6	
20inx20in Box Truss-10ft (Black)	30	
30inx30in Truss Base (Black)	6	
Container Bracket - Bottom (Black)	12	
1 Beam-06ft (Black)	2	
1 Beam-20ft (Black)	4	
Tyler Truss GT-05ft		

TABLE OF CONTENTS

Sheet Title	Page
Cover Page	1
Saturday/Sunday Rendering	2
Saturday/Sunday Plan	3
Saturday/Sunday Front Elevation/CL Section	4
Saturday/Sunday Deck Detail	5
Detail A	6
Detail B	7
Detail C,D,E,F	8
Detail G,N	9
Saturday/Sunday DJ Booth & FOH Detail	10
Friday Rendering	11
Friday Plan	12
Friday Front Elevation/CL Section	13
Friday Deck Detail	14

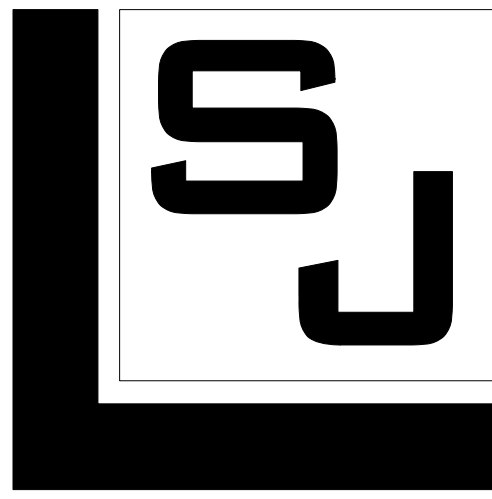

SJ LIGHTING, INC.
WESTLAKE VILLAGE, CA
818.874.9779
INFO@SJLIGHTING.NET
WWW.SJLIGHTING.NET

THE DESIGN AND ALL ASSOCIATED PAPERWORK IS COPYRIGHTED MATERIAL AND REMAINS THE PROPERTY OF THE DESIGNER.
THIS DESIGN IS FOR ONE TIME USE ONLY AT THE SPECIFIED LOCATION AND IS NOT TO BE USED FOR ANY OTHER PURPOSE OR EVENT WITHOUT SPECIFIC WRITTEN PERMISSION OF THE DESIGNER.
DESIGNER IS NOT A STRUCTURAL ENGINEER AND THESE DRAWINGS REPRESENT DESIGN CONCEPTS ONLY AND ARE NOT INTENDED AS ENGINEERING DRAWINGS. THE DESIGNER ASSUMES NO RESPONSIBILITY FOR THE SAFETY OR STRUCTURAL INTEGRITY OF ANY EQUIPMENT PROVIDED BY ANYONE.



REVISIONS

REV #	REMARKS	DATE	INT.
001	-Initial Design	4/6/2023	AHT
002	-Update Saturday Deck Detail	4/21/2023	AHT
003	-Update Friday DJ Booth	5/30/2023	AHT
004	-Add Detail M	7/6/2023	AHT
005	-Update Friday DJ Booth	7/19/2023	AHT
	-Add Detail N		
	-Update Detail A,B,C,D		
	-Update Friday & Saturday DJ Booth		
	-Update Friday & Saturday Deck Detail		
006	-Update Audio Hangs	8/3/2023	AHT
007	-Update Deck Size	8/11/2023	AHT
008	-Update Detail B	8/22/2023	AHT

AURIS PRESENTS

ARC MUSIC
FESTIVAL

CHICAGO, IL

UNION PARK

SEPTEMBER 1-3, 2023

STAGE 1

ISSUE DATE

Wednesday, August 23, 2023

DRAWN BY

MTR
S.J.L.


SCALE

SEE DRAWING
ARCH D (24"x36")


Saturday/Sunday
Plan

DD

3 OF 20

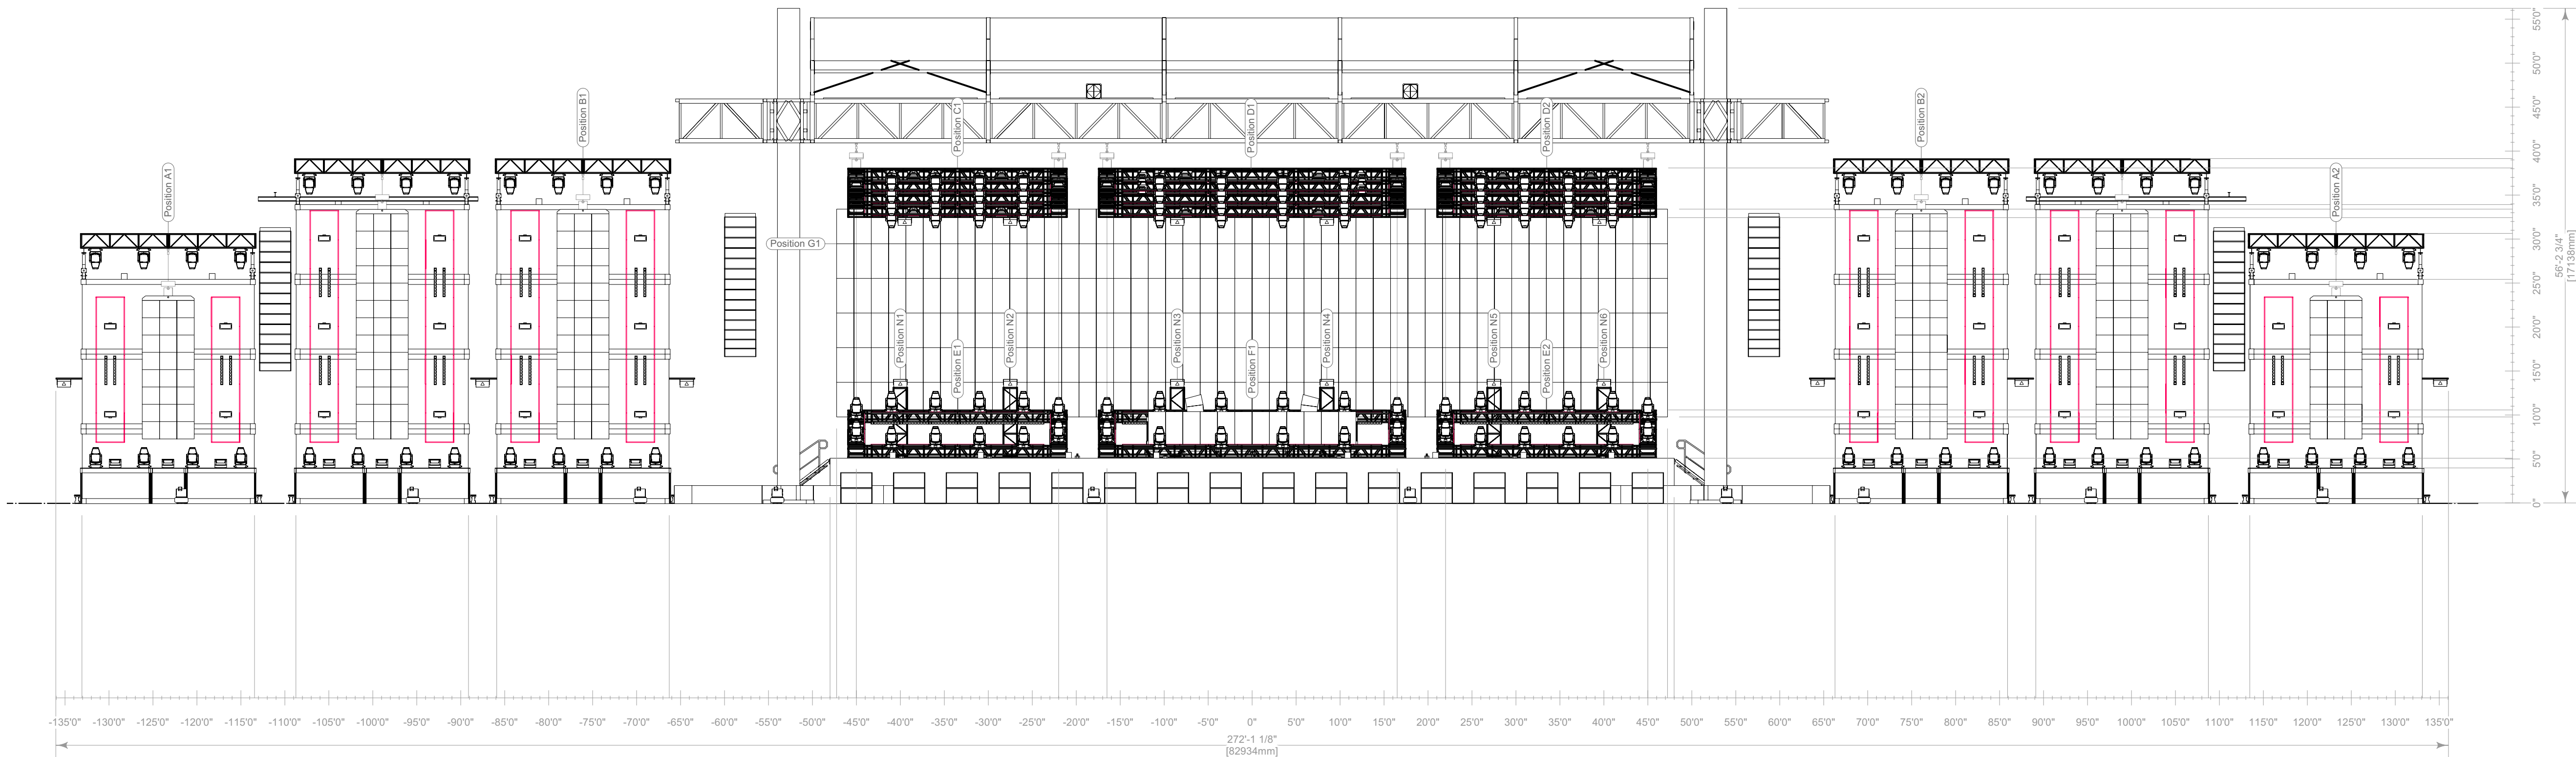

1 Front Elevation
Scale: 3/32" = 1'-0"

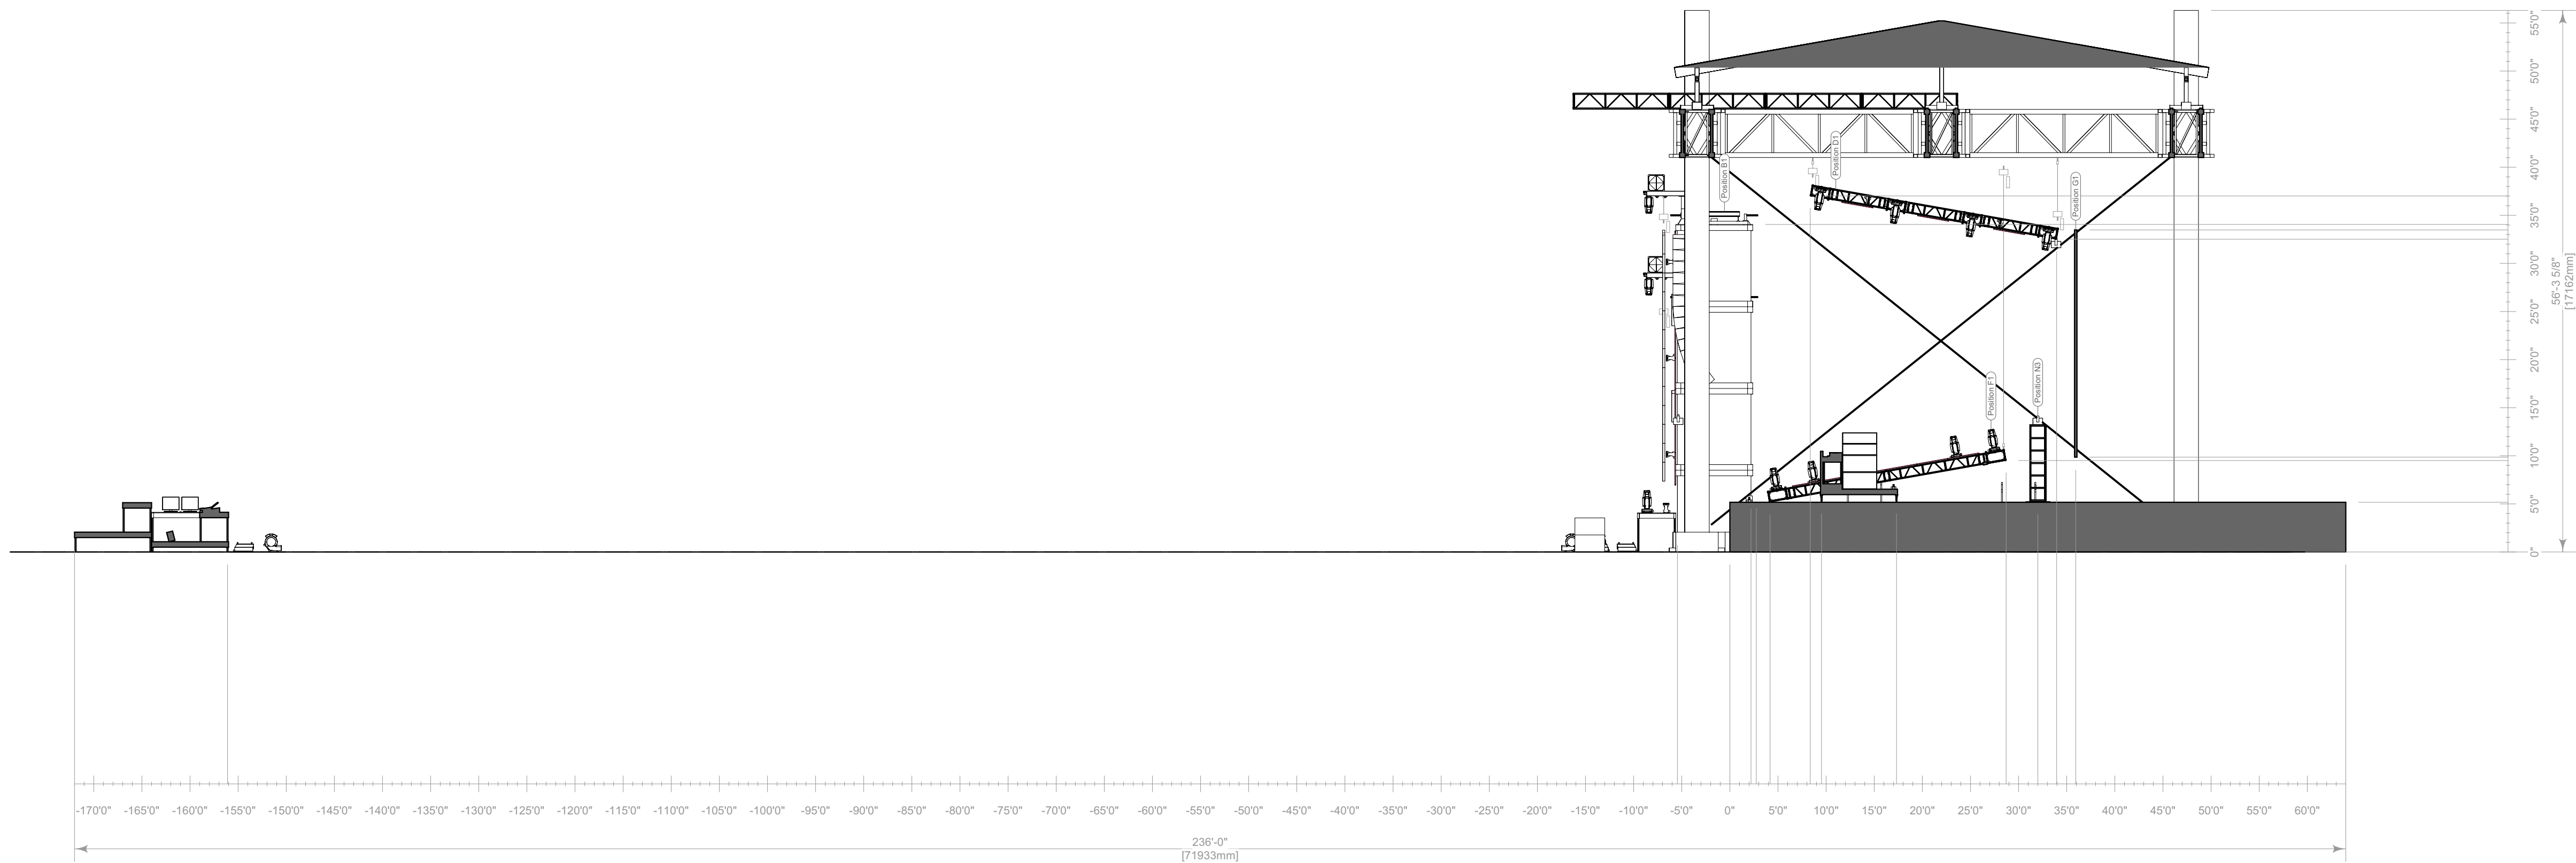


2 CL Section
Scale: 3/32" = 1'-0"

KEY TO SYMBOLS

LIGHTING		
Thumbnail	Item	Qty
	Ayrton Perseo Beam - Standard (40ch)	132
	Chauvet Color Strike M - 13 Channel (13ch)	86
	Chauvet Maverick MK2 Wash - Single-Basic (20ch)	8
	Chauvet Strike Saber - 27 Channel (Dimmer Mode=Dimmer 1) (27ch)	61
	GLP Impression X4 Bar 20 - Single Pixel High Res (89ch)	28
	GLP JDC Line 1000 - MultiPix Advanced (316ch)	28
	Martin Scepter-1000mm - P3 - Pixel Map (10 Segments)/Square Smoked Lens (30ch)	481
	Robe MegaPointe - Mode 1 (39ch)	8
	SGM P-2 + Barn Doors - 5.2.0 (22ch)	4
VIDEO		
Thumbnail	Item	Qty
	600mm Triple Video Header (N/A)	6
	ROE CB8 600mmx1200mm (8.3mm)	396
	Video Tile-600mmx600mm (8mm)	204
	Video Tile-1200mmx1200mm (25mm Blow Through)	280
~762 M² Total		
SFX		
Thumbnail	Item	Qty
	Blower Fan - N/A (0ch)	12
	Co2 Valve - N/A (0ch)	14
	Flame Head - N/A (0ch)	20
	Generic Laser - Beyond 5.0 Mid (32ch)	18
	Hazer - 2 Channel (2ch)	12
	Martin AF 1 DMX Fan - 5.2.0 (1ch)	4
CONTROL		
Thumbnail	Item	Qty
	Beyond Computer (Beyond 5.0 Ultimate)	1
	Generic Cooling/Heating Fan (https://a.co/d/hTWf56b)	2
	GrandMA2 Full-Size (3.9.60.37)	2
	Martin P3 Computer (Martin P3)	1
RIGGING		
Item		Qty
2in Sched. 40 Pipe-03ft (Black)		12
2in Sched. 40 Pipe-06ft (Black)		4
12inx12in Box Truss-05ft (Black)		5
12inx12in Box Truss-10ft (Black)		24
12inx12in Box Truss-CB (Black)		10
19inx19in Pipe Base (Black)		4
20inx20in Box Truss-08ft (Black)		6
20inx20in Box Truss-10ft (Black)		30
30inx30in Truss Base (Black)		6
Container Bracket - Bottom (Black)		12
I Beam-06ft (Black)		2
I Beam-20ft (Black)		4
Tyler Truss CT-05ft		4

TABLE OF CONTENTS

Sheet Title	Page
Cover Page	1
Saturday/Sunday Rendering	2
Saturday/Sunday Plan	3
Saturday/Sunday Front Elevation/CL Section	4
Saturday/Sunday Deck Detail	5
Detail A	6
Detail B	7
Detail C,D,E,F	8
Detail G,N	9
Saturday/Sunday DJ Booth & FOH Detail	10
Friday Rendering	11
Friday Plan	12
Friday Front Elevation/CL Section	13
Friday Deck Detail	14

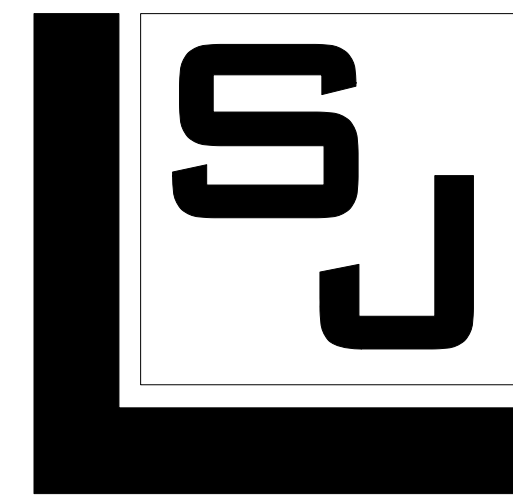

SJ LIGHTING, INC.
WESTLAKE VILLAGE, CA
818.874.9779
INFO@SJLIGHTING.NET
WWW.SJLIGHTING.NET

THE DESIGN AND ALL ASSOCIATED PAPERWORK IS COPYRIGHTED MATERIAL AND REMAINS THE PROPERTY OF THE DESIGNER.
THIS DESIGN IS FOR ONE TIME USE ONLY AT THE SPECIFIED LOCATION AND IS NOT TO BE USED FOR ANY OTHER PURPOSE OR EVENT WITHOUT SPECIFIC WRITTEN PERMISSION OF THE DESIGNER.
DESIGNER IS NOT A STRUCTURAL ENGINEER AND THESE DRAWINGS REPRESENT DESIGN CONCEPTS ONLY AND ARE NOT INTENDED AS ENGINEERING DRAWINGS. THE DESIGNER ASSUMES NO RESPONSIBILITY FOR THE SAFETY OR STRUCTURAL INTEGRITY OF ANY EQUIPMENT PROVIDED BY ANYONE.



REVISIONS

REV #	REMARKS	DATE	INT.
001	-Initial Design	4/6/2023	AHT
002	-Update Saturday Deck Detail	4/21/2023	AHT
003	-Update Friday DJ Booth	5/30/2023	AHT
004	-Add Detail M	7/6/2023	AHT
005	-Update Friday DJ Booth	7/19/2023	AHT
006	-Add Detail N		
007	-Update Detail A,B,C,D		
008	-Update Friday & Saturday DJ Booth		
009	-Update Friday & Saturday Deck Detail		
010	-Update Audio Hangs	8/3/2023	AHT
011	-Update Deck Size	8/11/2023	AHT
012	-Update Detail B	8/22/2023	AHT

AURIS PRESENTS

ARC MUSIC FESTIVAL

CHICAGO, IL

UNION PARK

SEPTEMBER 1-3, 2023

STAGE 1

ISSUE DATE

Wednesday, August 23, 2023

DRAWN BY


MTR
S.J.L.

SCALE

SEE DRAWING
ARCH D (24"x36")

Saturday/Sunday Front Elevation/CL Section

DD

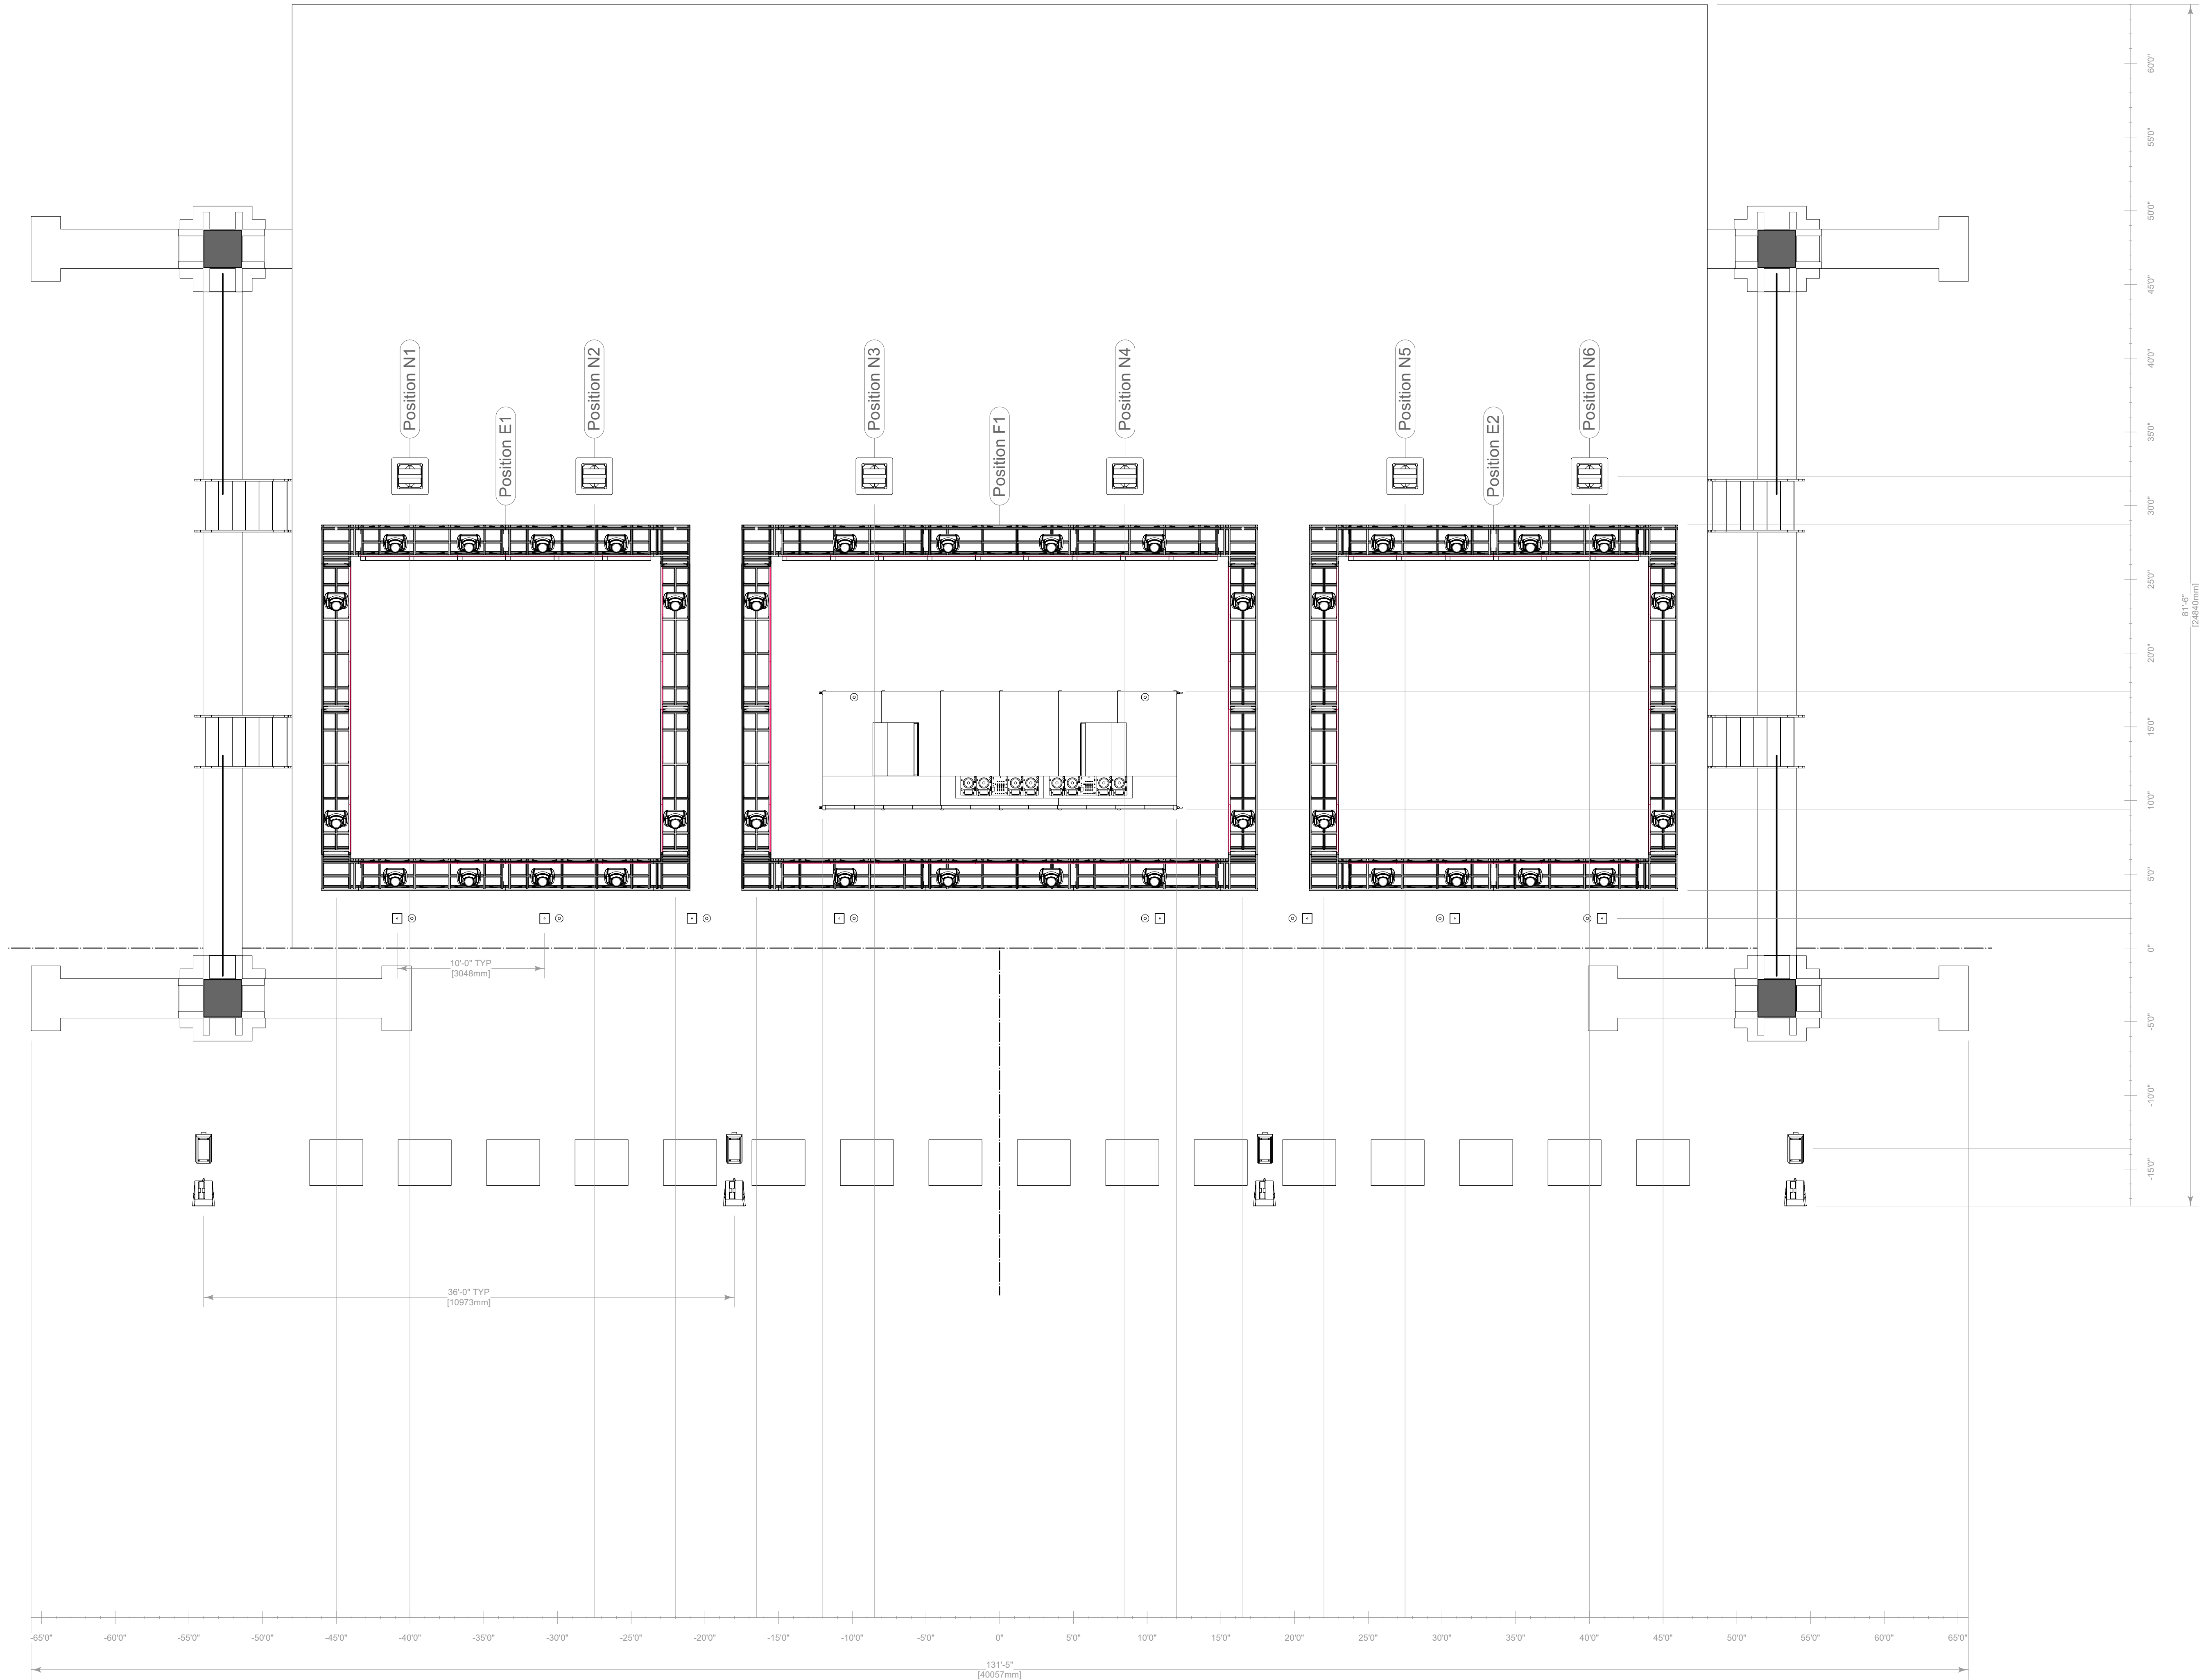


1 Deck Detail
Scale: 3/16" = 1'-0"

KEY TO SYMBOLS

LIGHTING		
Thumbnail	Item	Qty
	Ayrton Perseo Beam - Standard (40ch)	132
	Chauvet Color Strike M - 13 Channel (13ch)	86
	Chauvet Maverick MK2 Wash - Single-Basic (20ch)	8
	Chauvet Strike Saber - 27 Channel (Dimmer Mode=Dimmer 1) (27ch)	61
	GLP Impression X4 Bar 20 - Single Pixel High Res (89ch)	28
	GLP JDC Line 1000 - MultiPix Advanced (316ch)	28
	Martin Scepter-1000mm - P3 - Pixel Map (10 Segments)/Square Smoked Lens (30ch)	481
	Robe MegaPointe - Mode 1 (39ch)	8
	SGM P-2 + Barn Doors - 5.2.0 (22ch)	4
VIDEO		
Thumbnail	Item	Qty
	600mm Triple Video Header (N/A)	6
	ROE CB8 600mmx1200mm (8.3mm)	396
	Video Tile-600mmx600mm (8mm)	204
	Video Tile-1200mmx1200mm (25mm Blow Through)	280
~762 M² Total		
SFX		
Thumbnail	Item	Qty
	Blower Fan - N/A (0ch)	12
	Co2 Valve - N/A (0ch)	14
	Flame Head - N/A (0ch)	20
	Generic Laser - Beyond 5.0 Mid (32ch)	18
	Hazer - 2 Channel (2ch)	12
	Martin AF 1 DMX Fan - 5.2.0 (1ch)	4
CONTROL		
Thumbnail	Item	Qty
	Beyond Computer (Beyond 5.0 Ultimate)	1
	Generic Cooling/Heating Fan (https://a.co/d/hTwf56b)	2
	GrandMA2 Full-Size (3.9.60.37)	2
	Martin P3 Computer (Martin P3)	1
RIGGING		
Item	Qty	
2in Sched. 40 Pipe-03ft (Black)	12	
2in Sched. 40 Pipe-06ft (Black)	4	
12inx12in Box Truss-05ft (Black)	5	
12inx12in Box Truss-10ft (Black)	24	
12inx12in Box Truss-CB (Black)	10	
19inx19in Pipe Base (Black)	4	
20inx20in Box Truss-08ft (Black)	6	
20inx20in Box Truss-10ft (Black)	30	
30inx30in Truss Base (Black)	6	
Container Bracket - Bottom (Black)	12	
I Beam-06ft (Black)	2	
I Beam-20ft (Black)	4	
Tyler Truss GT-05ft		

TABLE OF CONTENTS

Sheet Title	Page
Cover Page	1
Saturday/Sunday Rendering	2
Saturday/Sunday Plan	3
Saturday/Sunday Front Elevation/CL Section	4
Saturday/Sunday Deck Detail	5
Detail A	6
Detail B	7
Detail C,D,E,F	8
Detail G,N	9
Saturday/Sunday DJ Booth & FOH Detail	10
Friday Rendering	11
Friday Plan	12
Friday Front Elevation/CL Section	13
Friday Deck Detail	14

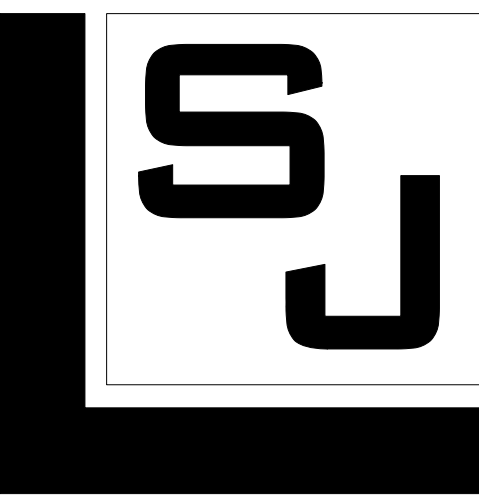

SJ LIGHTING, INC.
WESTLAKE VILLAGE, CA
818.874.9779
INFO@SJLIGHTING.NET
WWW.SJLIGHTING.NET

THE DESIGN AND ALL ASSOCIATED PAPERWORK IS COPYRIGHTED MATERIAL AND REMAINS THE PROPERTY OF THE DESIGNER.
THIS DESIGN IS FOR ONE TIME USE ONLY AT THE SPECIFIED LOCATION AND IS NOT TO BE USED FOR ANY OTHER PURPOSE OR EVENT WITHOUT SPECIFIC WRITTEN PERMISSION OF THE DESIGNER.
DESIGNER IS NOT A STRUCTURAL ENGINEER AND THESE DRAWINGS REPRESENT DESIGN CONCEPTS ONLY AND ARE NOT INTENDED AS ENGINEERING DRAWINGS. THE DESIGNER ASSUMES NO RESPONSIBILITY FOR THE SAFETY OR STRUCTURAL INTEGRITY OF ANY EQUIPMENT PROVIDED BY ANYONE.



REVISIONS

REV #	REMARKS	DATE	INT.
001	-Initial Design	4/6/2023	AHT
002	-Update Saturday Deck Detail	4/21/2023	AHT
003	-Update Friday DJ Booth	5/30/2023	AHT
004	-Add Detail M	7/6/2023	AHT
005	-Update Friday DJ Booth	7/19/2023	AHT
006	-Add Detail N		
007	-Update Detail A,B,C,D		
008	-Update Friday & Saturday DJ Booth		
009	-Update Audio Hangs	8/3/2023	AHT
010	-Update Deck Size	8/11/2023	AHT
011	-Update Detail B		
012	-Update Detail A,B	8/22/2023	AHT

AURIS PRESENTS

ARC MUSIC FESTIVAL

CHICAGO, IL

UNION PARK

SEPTEMBER 1-3, 2023

STAGE 1

ISSUE DATE

Wednesday, August 23, 2023

DRAWN BY

MTR
S.J.L.


SCALE

SEE DRAWING
ARCH D (24"x36")

Saturday/Sunday Deck Detail


DD

5 OF 20

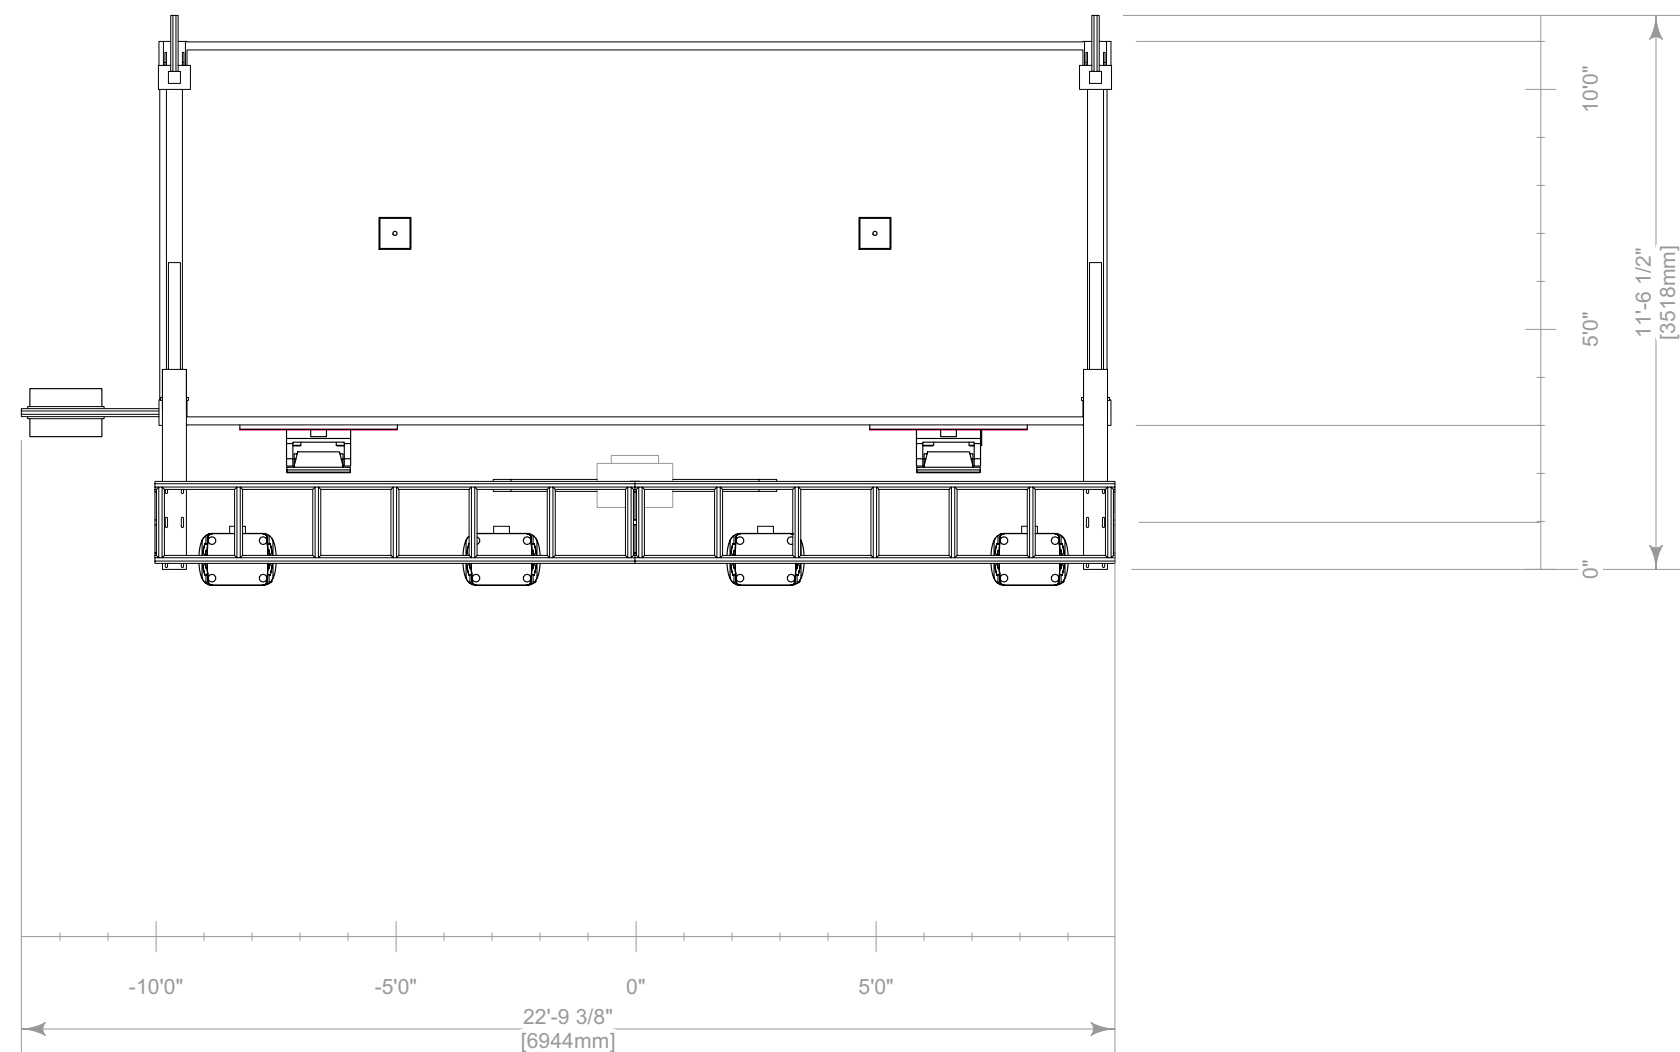


1

Detail A Overhead Detail
Scale: 1/4" = 1'-0"

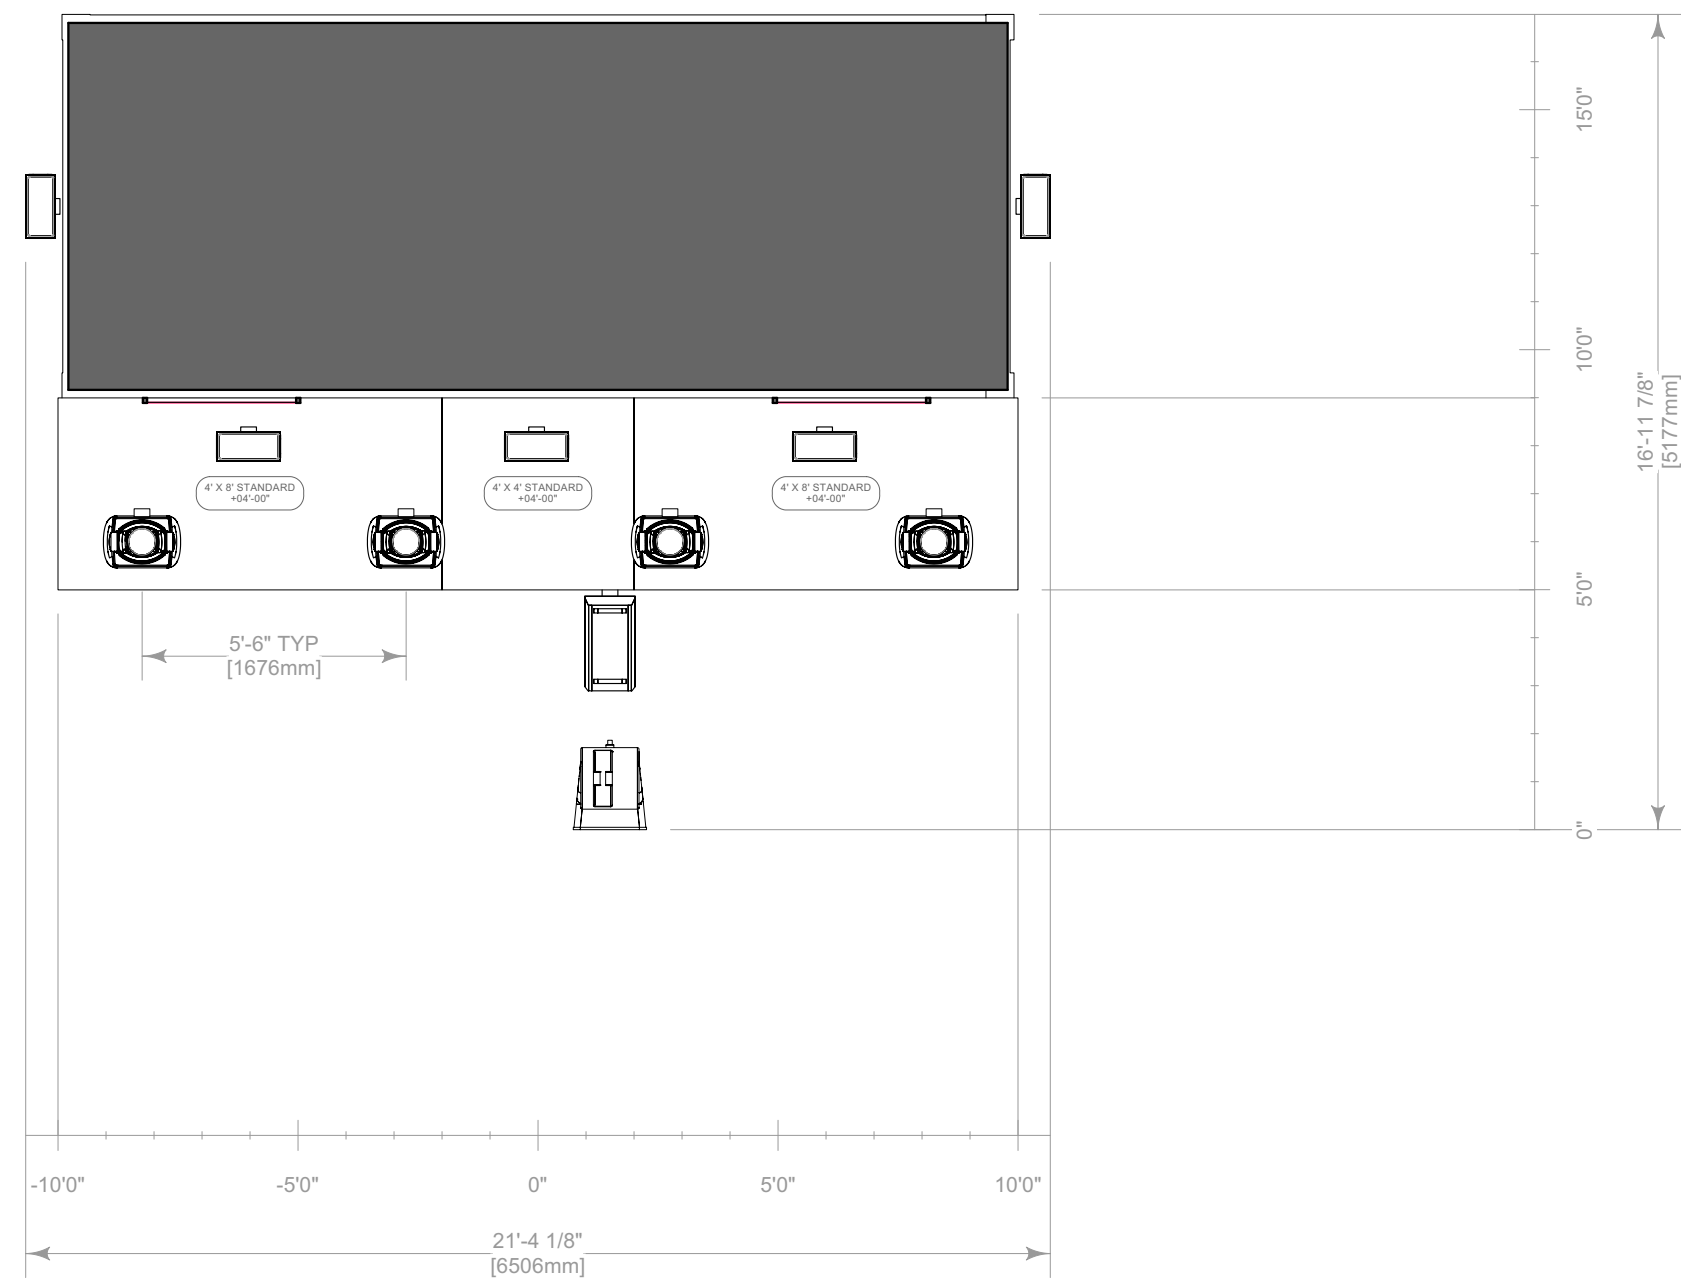


3

Detail A Floor Detail
Scale: 1/4" = 1'-0"

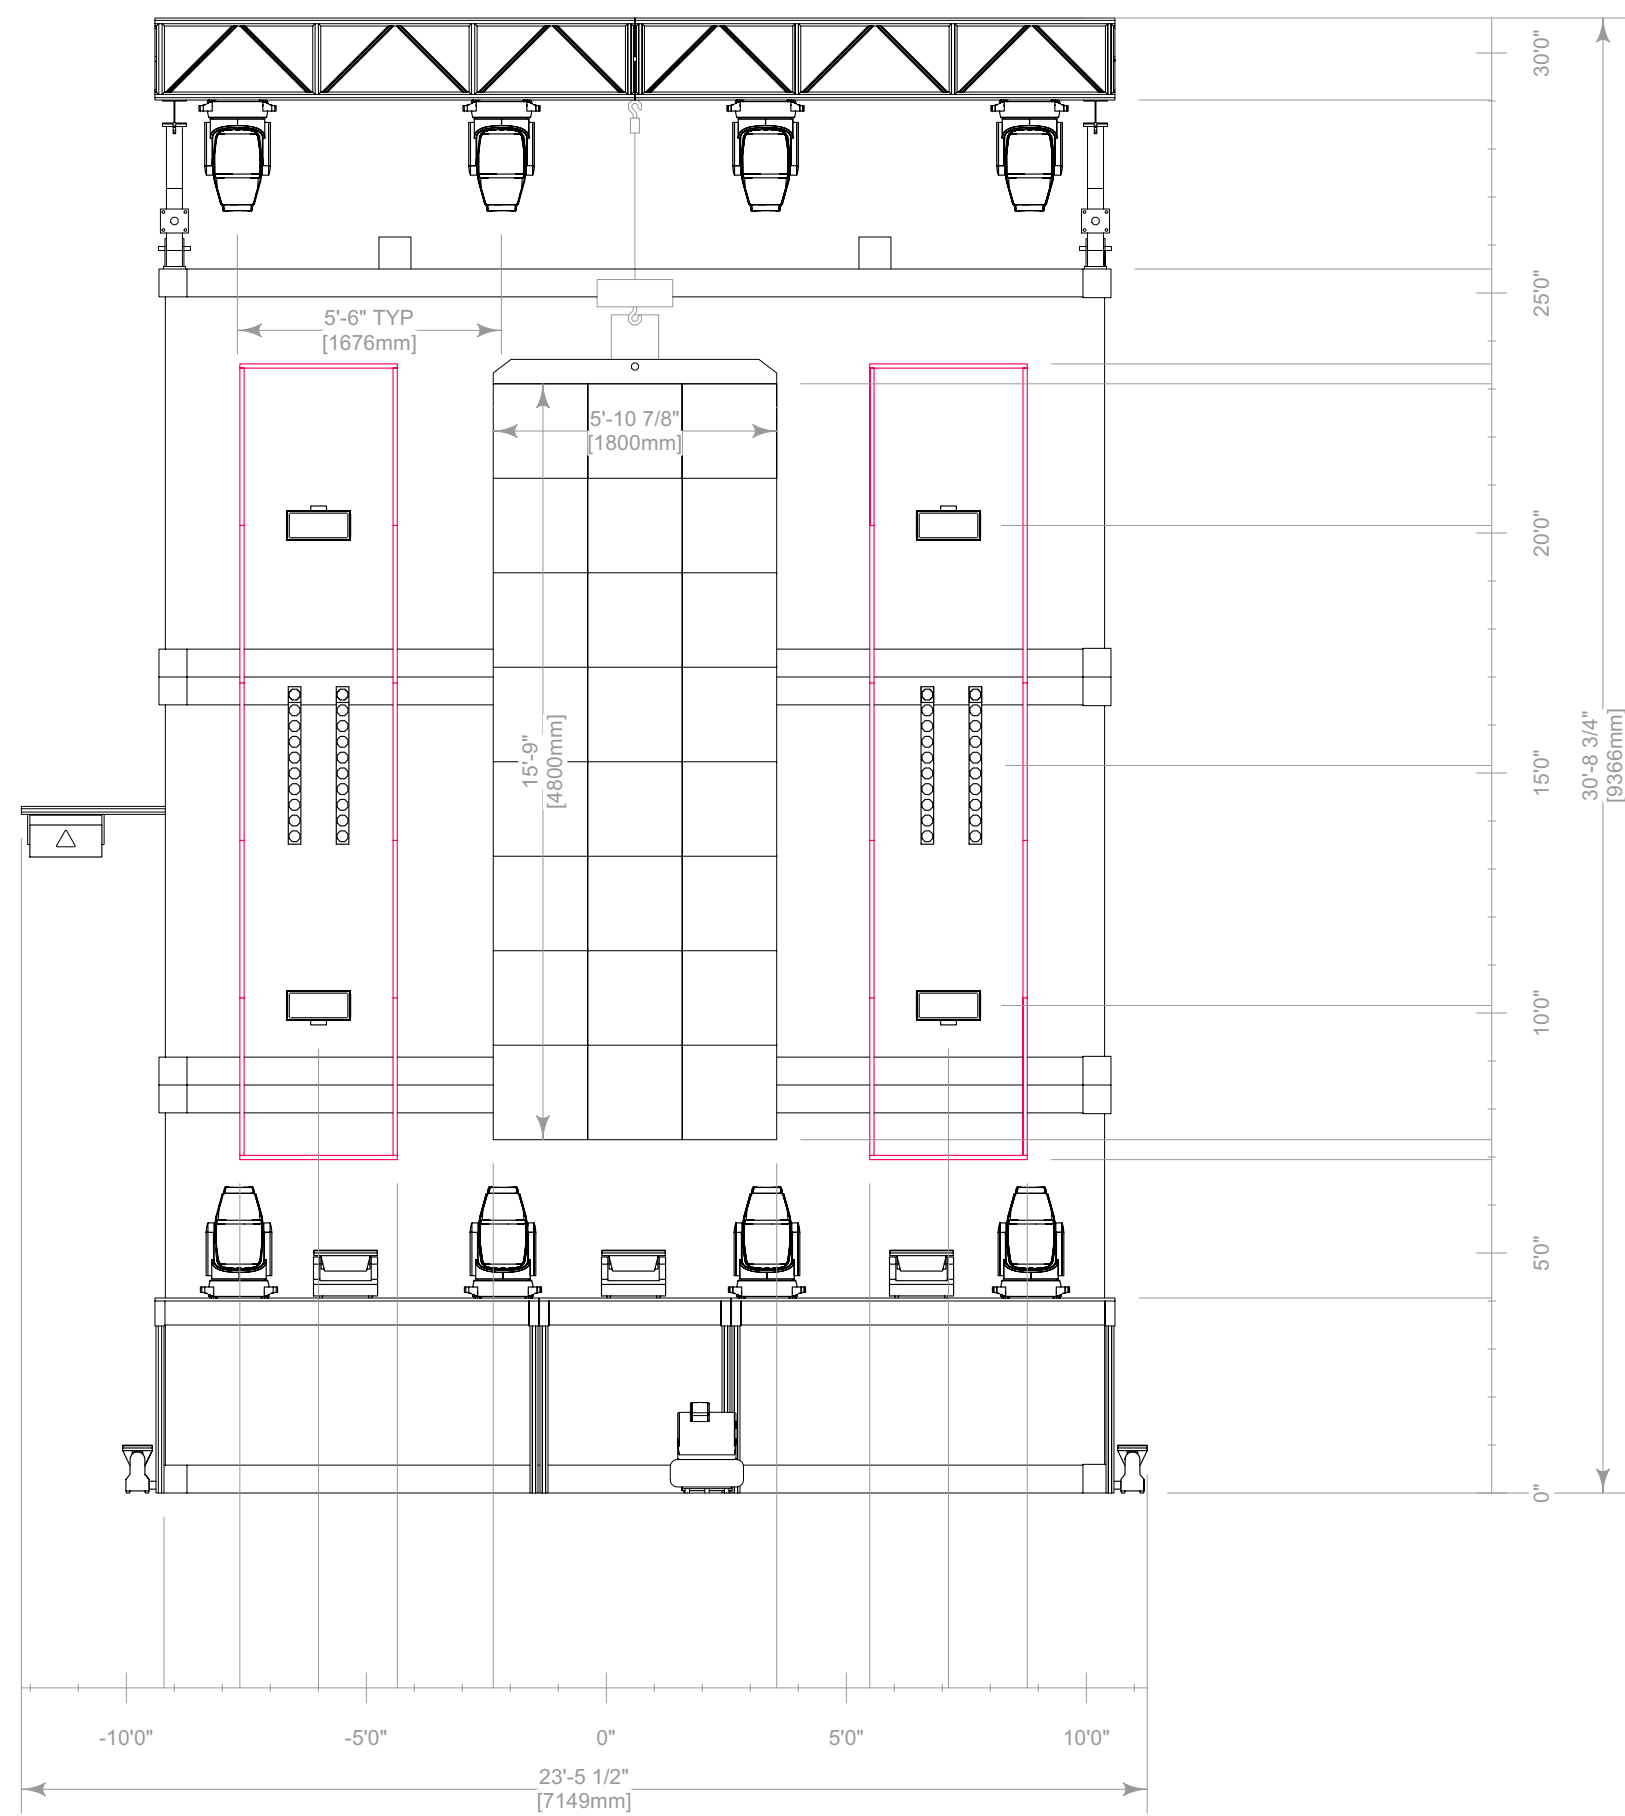

2

Detail A Front
Scale: 1/4" = 1'-0"

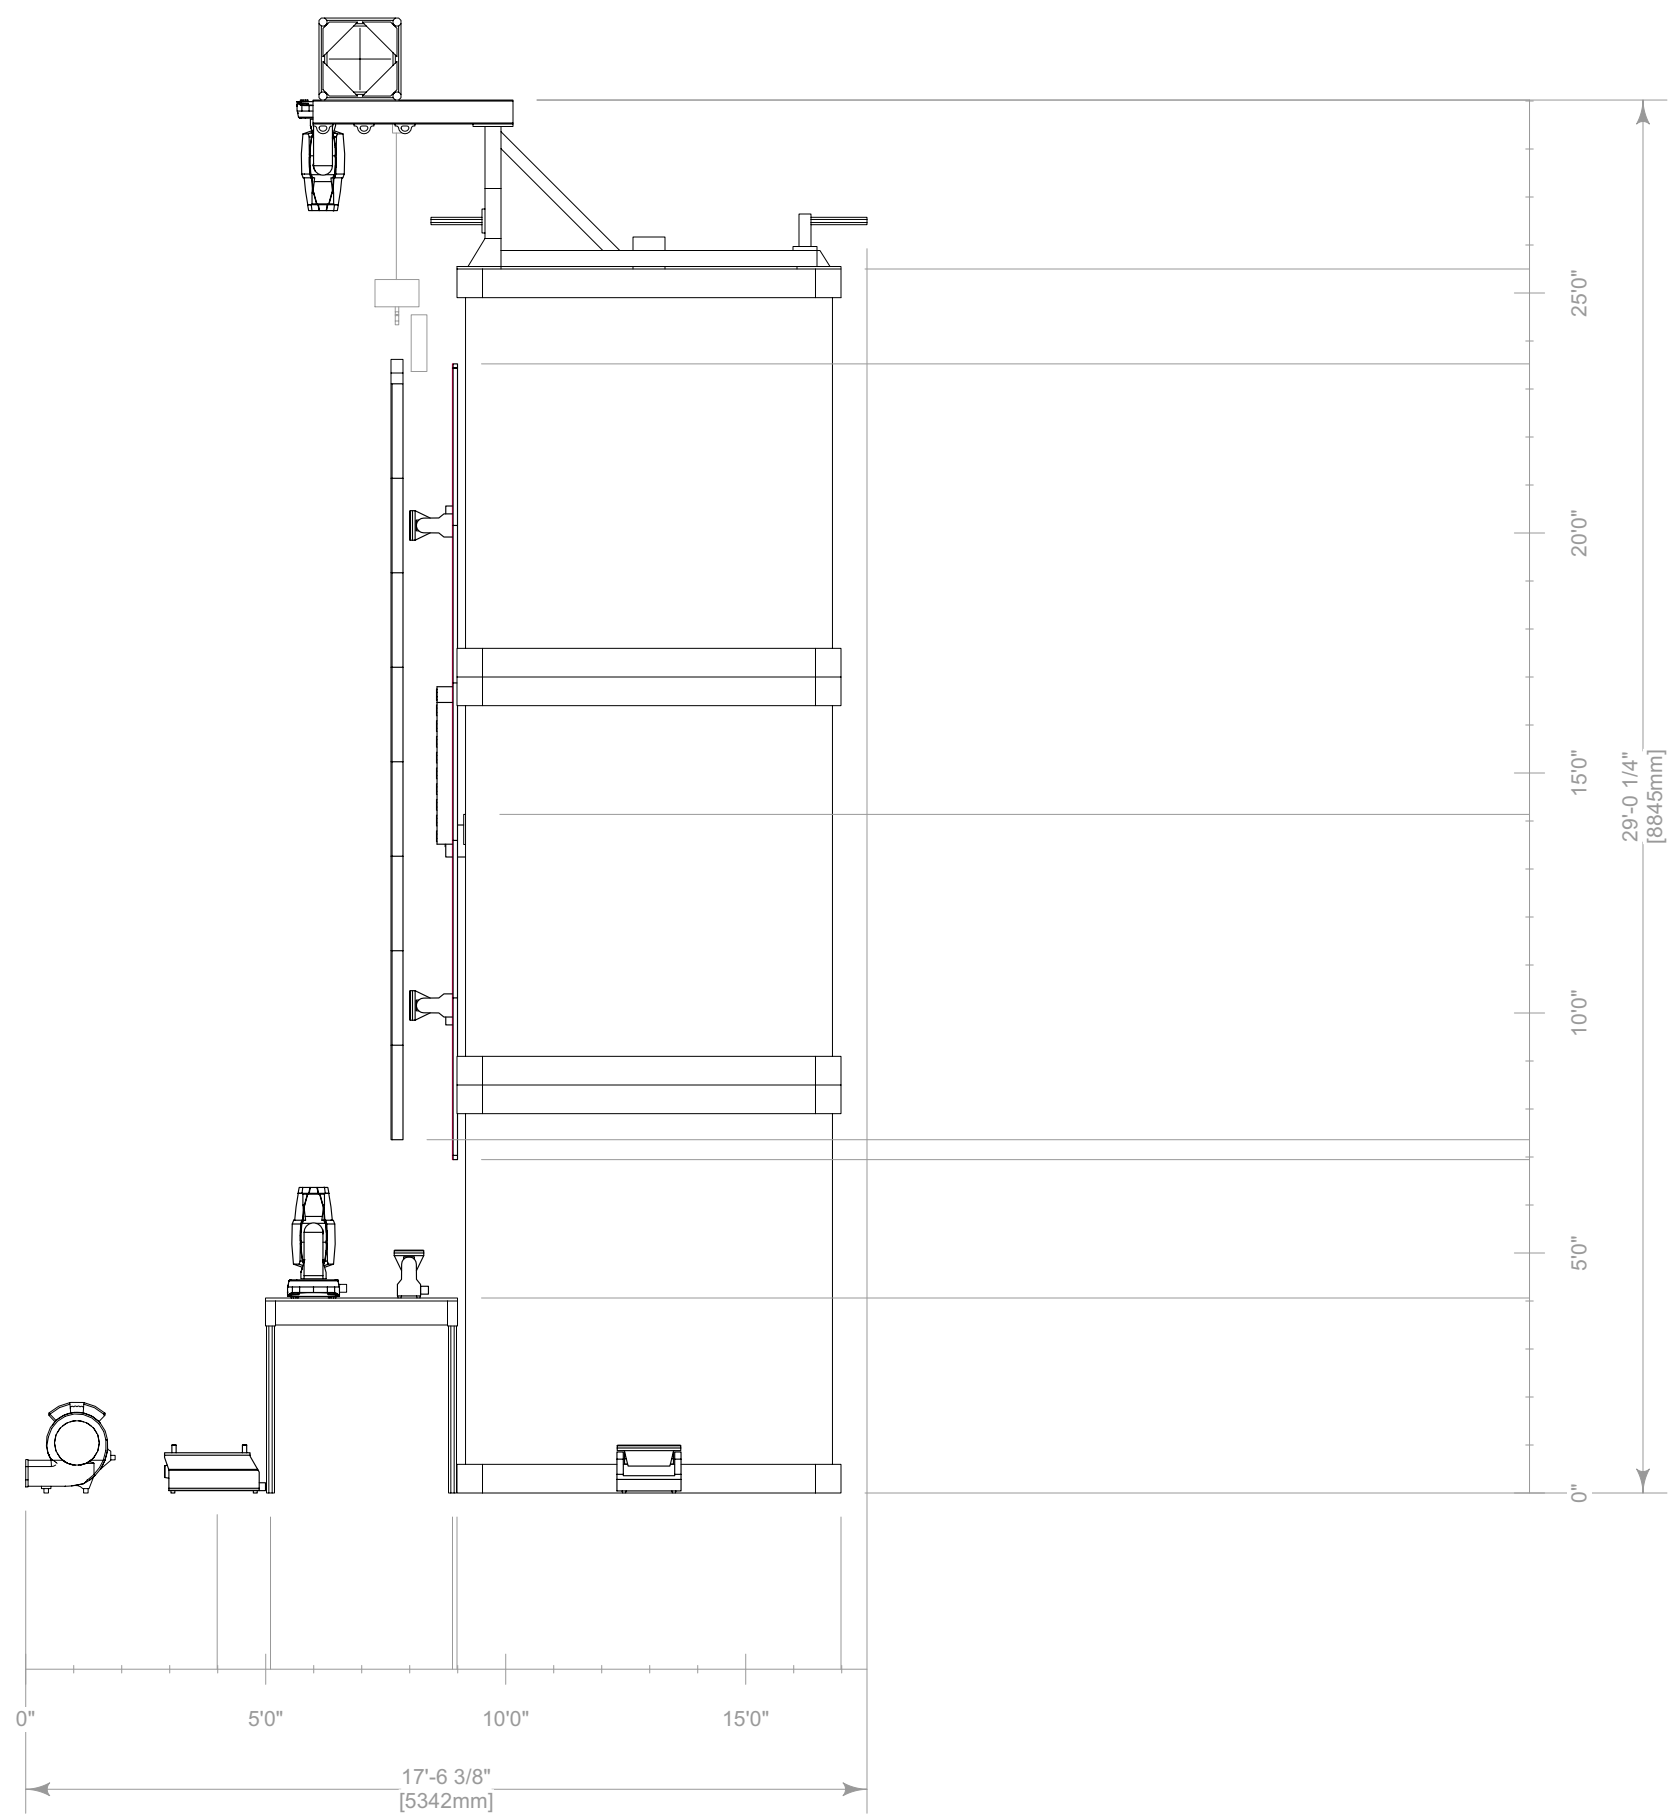

4

Detail A Right
Scale: 1/4" = 1'-0"


KEY TO SYMBOLS

SUBSTITUTIONS ARE ACCEPTED UPON APPROVAL

LIGHTING		
Thumbnail	Item	Qty
	Ayrton Perseo Beam - Standard (40ch)	132
	Chauvet Color Strike M - 13 Channel (13ch)	86
	Chauvet Maverick MK2 Wash - Single-Basic (20ch)	8
	Chauvet Strike Saber - 27 Channel (Dimmer Mode=Dimmer 1) (27ch)	61
	GLP Impression X4 Bar 20 - Single Pixel High Res (89ch)	28
	GLP JDC Line 1000 - MultiPix Advanced (316ch)	28
	Martin Scepton-1000mm - P3 - Pixel Map (10 Segments)/Square Smoked Lens (30ch)	481
	Robe MegaPointe - Mode 1 (39ch)	8
	SGM P-2 + Barn Doors - 5.2.0 (22ch)	4
VIDEO		
Thumbnail	Item	Qty
	600mm Triple Video Header (N/A)	6
	ROE CB8 600mmx1200mm (8.3mm)	396
	Video Tile-600mmx600mm (8mm)	204
	Video Tile-1200mmx1200mm (25mm Blow Through)	280
~762 M² Total		
SFX		
Thumbnail	Item	Qty
	Blower Fan - N/A (0ch)	12
	Co2 Valve - N/A (0ch)	14
	Flame Head - N/A (0ch)	20
	Generic Laser - Beyond 5.0 Mid (32ch)	18
	Hazer - 2 Channel (2ch)	12
	Martin AF 1 DMX Fan - 5.2.0 (1ch)	4
CONTROL		
Thumbnail	Item	Qty
	Beyond Computer (Beyond 5.0 Ultimate)	1
	Generic Cooling/Heating Fan (https://a.co/d/hTWf56b)	2
	GrandMA2 Full-Size (3.9.60.37)	2
	Martin P3 Computer (Martin P3)	1
RIGGING		
Item	Qty	
2in Sched. 40 Pipe-03ft (Black)	12	
2in Sched. 40 Pipe-06ft (Black)	4	
12inx12in Box Truss-05ft (Black)	5	
12inx12in Box Truss-10ft (Black)	24	
12inx12in Box Truss-CB (Black)	10	
19inx19in Pipe Base (Black)	4	
20inx20in Box Truss-08ft (Black)	6	
20inx20in Box Truss-10ft (Black)	30	
30inx30in Truss Base (Black)	6	
Container Bracket - Bottom (Black)	12	
1 Beam-06ft (Black)	2	
1 Beam-20ft (Black)	4	
Tyler Truss GT-05ft		

TABLE OF CONTENTS

Sheet Title	Page
Cover Page	1
Saturday/Sunday Rendering	2
Saturday/Sunday Plan	3
Saturday/Sunday Front Elevation/CL Section	4
Saturday/Sunday Deck Detail	5
Detail A	6
Detail B	7
Detail C,D,E,F	8
Detail G,N	9
Saturday/Sunday DJ Booth & FOH Detail	10
Friday Rendering	11
Friday Plan	12
Friday Front Elevation/CL Section	13
Friday Deck Detail	14

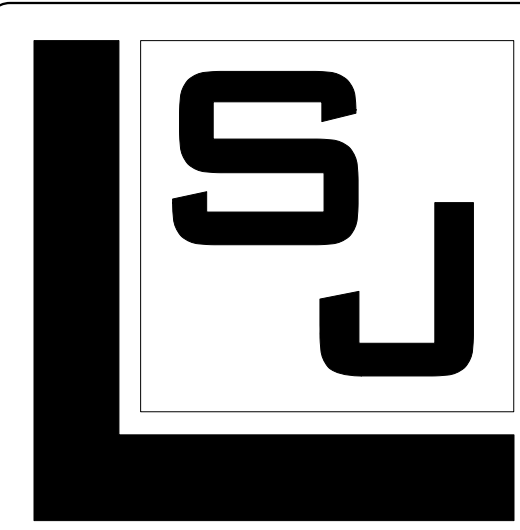

SJ LIGHTING, INC.
WESTLAKE VILLAGE, CA
818.874.9779
INFO@SJLIGHTING.NET
WWW.SJLIGHTING.NET

THE DESIGN AND ALL ASSOCIATED PAPERWORK IS COPYRIGHTED MATERIAL AND REMAINS THE PROPERTY OF THE DESIGNER.
THIS DESIGN IS FOR ONE TIME USE ONLY AT THE SPECIFIED LOCATION AND IS NOT TO BE USED FOR ANY OTHER PURPOSE OR EVENT WITHOUT SPECIFIC WRITTEN PERMISSION OF THE DESIGNER.
DESIGNER IS NOT A STRUCTURAL ENGINEER AND THESE DRAWINGS REPRESENT DESIGN CONCEPTS ONLY AND ARE NOT INTENDED AS ENGINEERING DRAWINGS. THE DESIGNER ASSUMES NO RESPONSIBILITY FOR THE SAFETY OR STRUCTURAL INTEGRITY OF ANY EQUIPMENT PROVIDED BY ANYONE.



REVISIONS

REV #	REMARKS	DATE	INT.
001	-Initial Design	4/6/2023	AHT
002	-Update Saturday Deck Detail	4/21/2023	AHT
003	-Update Friday DJ Booth	5/30/2023	AHT
004	-Add Detail M	7/6/2023	AHT
005	-Update Friday DJ Booth	7/19/2023	AHT
	-Add Detail N		
	-Update Detail A,B,C,D		
	-Update Friday & Saturday DJ Booth		
	-Update Friday & Saturday Deck Detail		
006	-Update Audio Hangs	8/3/2023	AHT
007	-Update Deck Size	8/11/2023	AHT
008	-Update Detail B	8/22/2023	AHT

AURIS PRESENTS

ARC MUSIC FESTIVAL

CHICAGO, IL

UNION PARK

SEPTEMBER 1-3, 2023

STAGE 1

ISSUE DATE

Wednesday, August 23, 2023

DRAWN BY

MTR
S.J.L.



SCALE

SEE DRAWING
ARCH D (24"x36")

Detail A

DD

6 OF 20

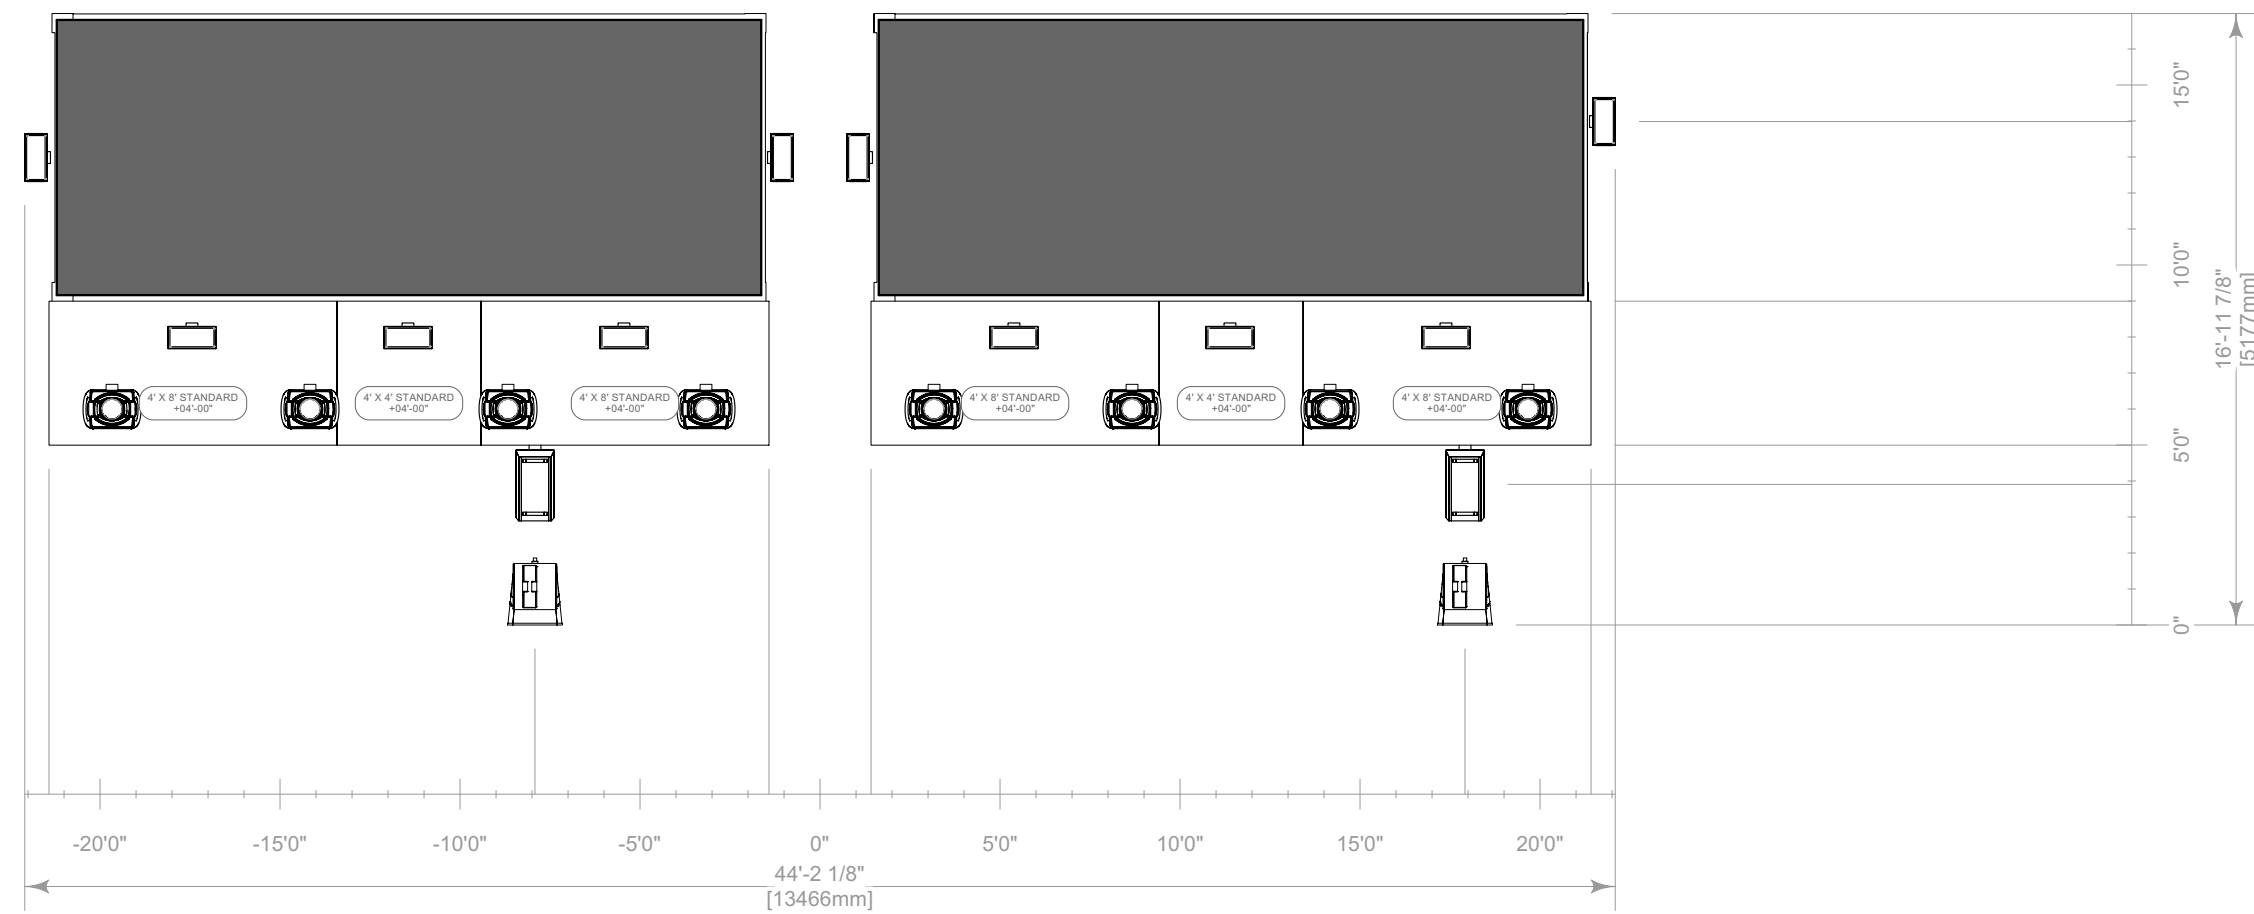
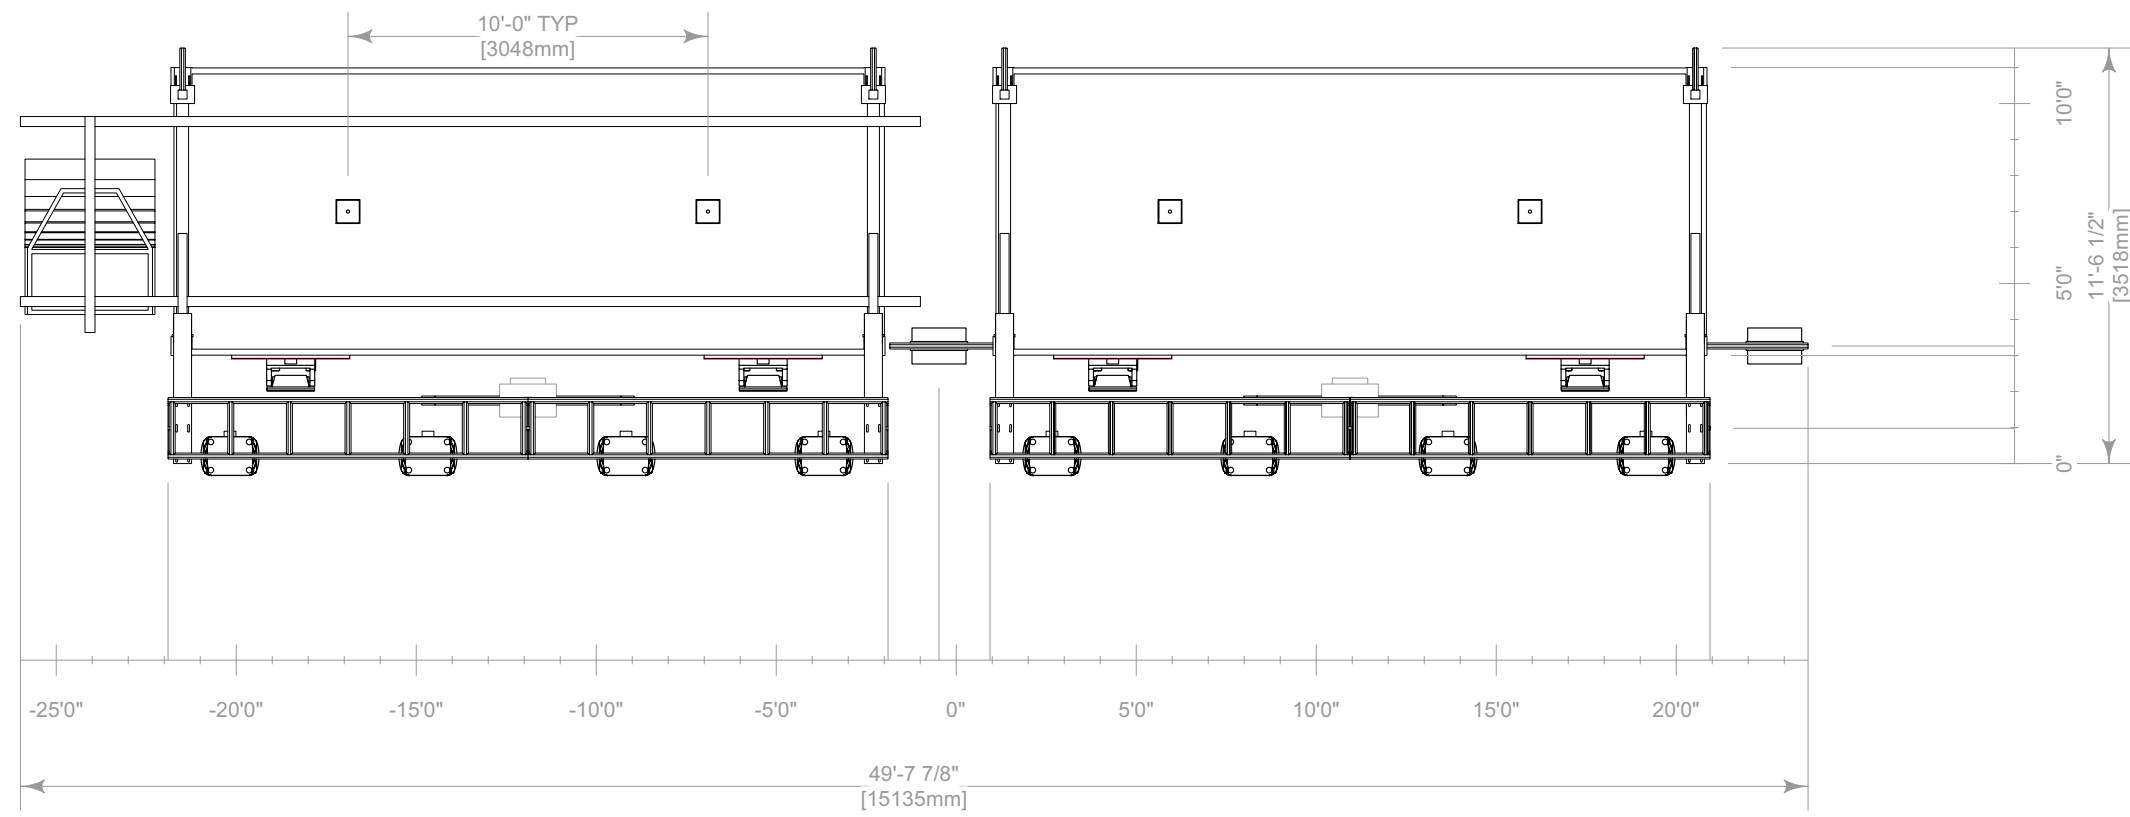


1

Detail B Overhead Detail
Scale: 3/16" = 1'-0"

2

Detail B Floor Detail
Scale: 3/16" = 1'-0"

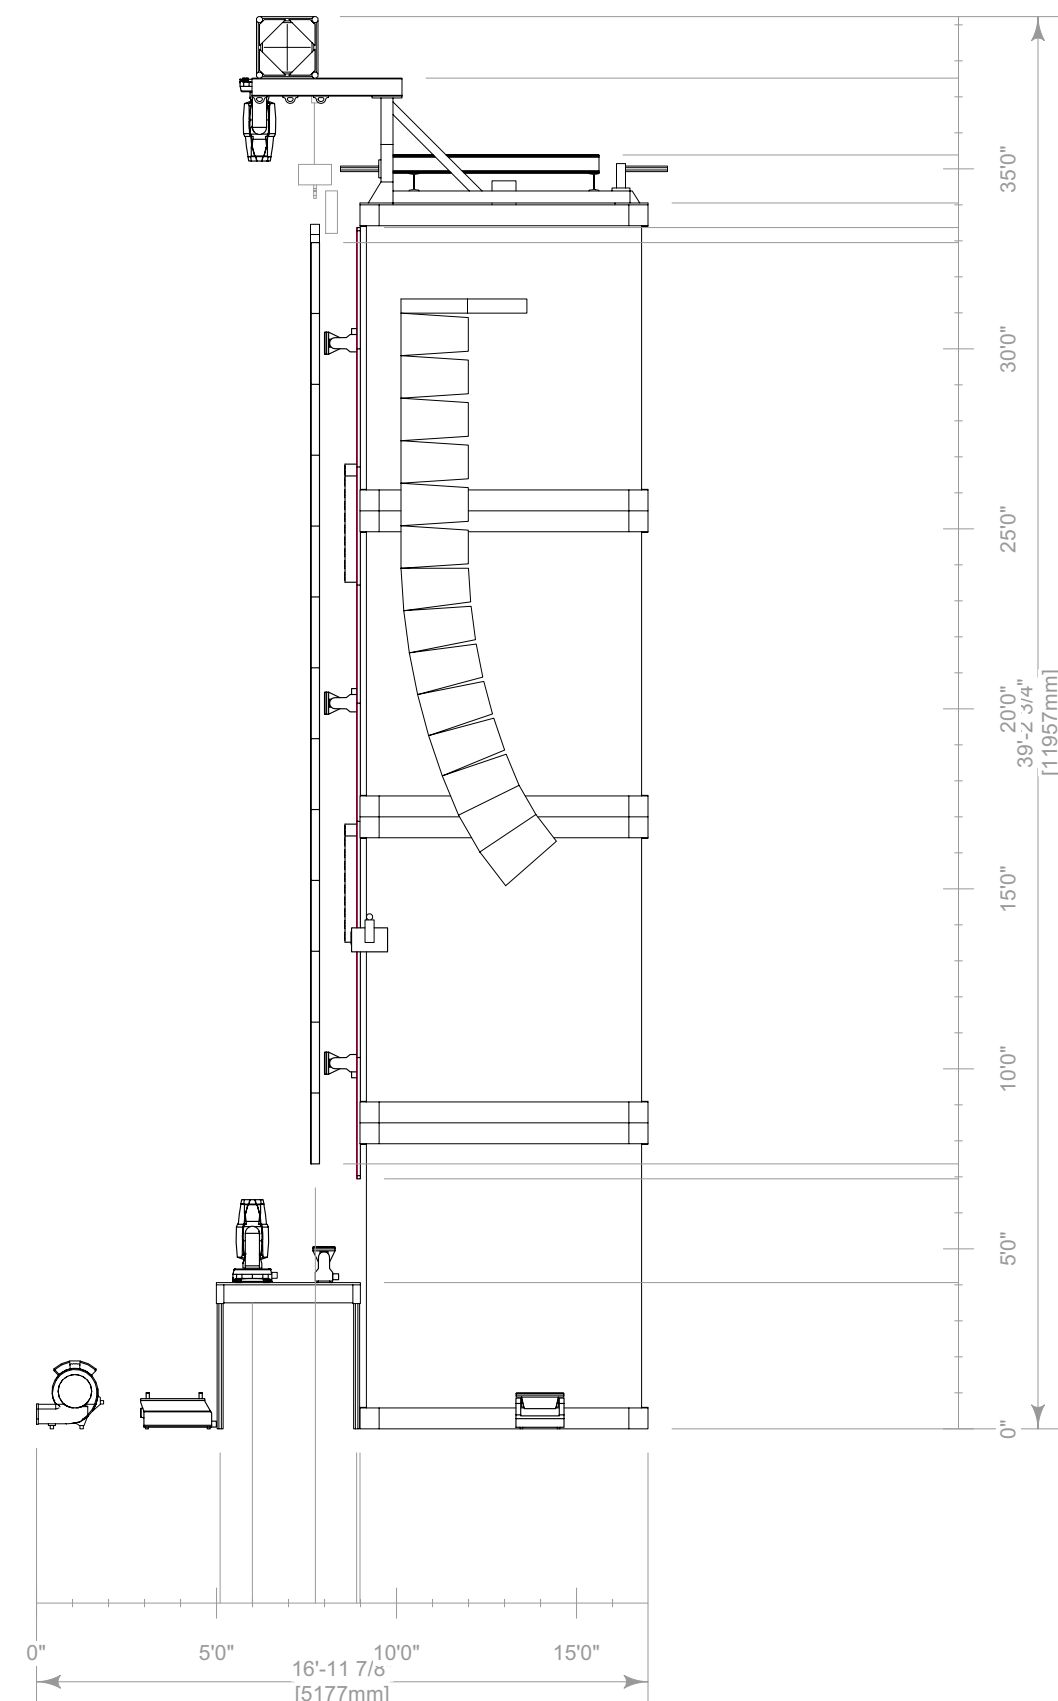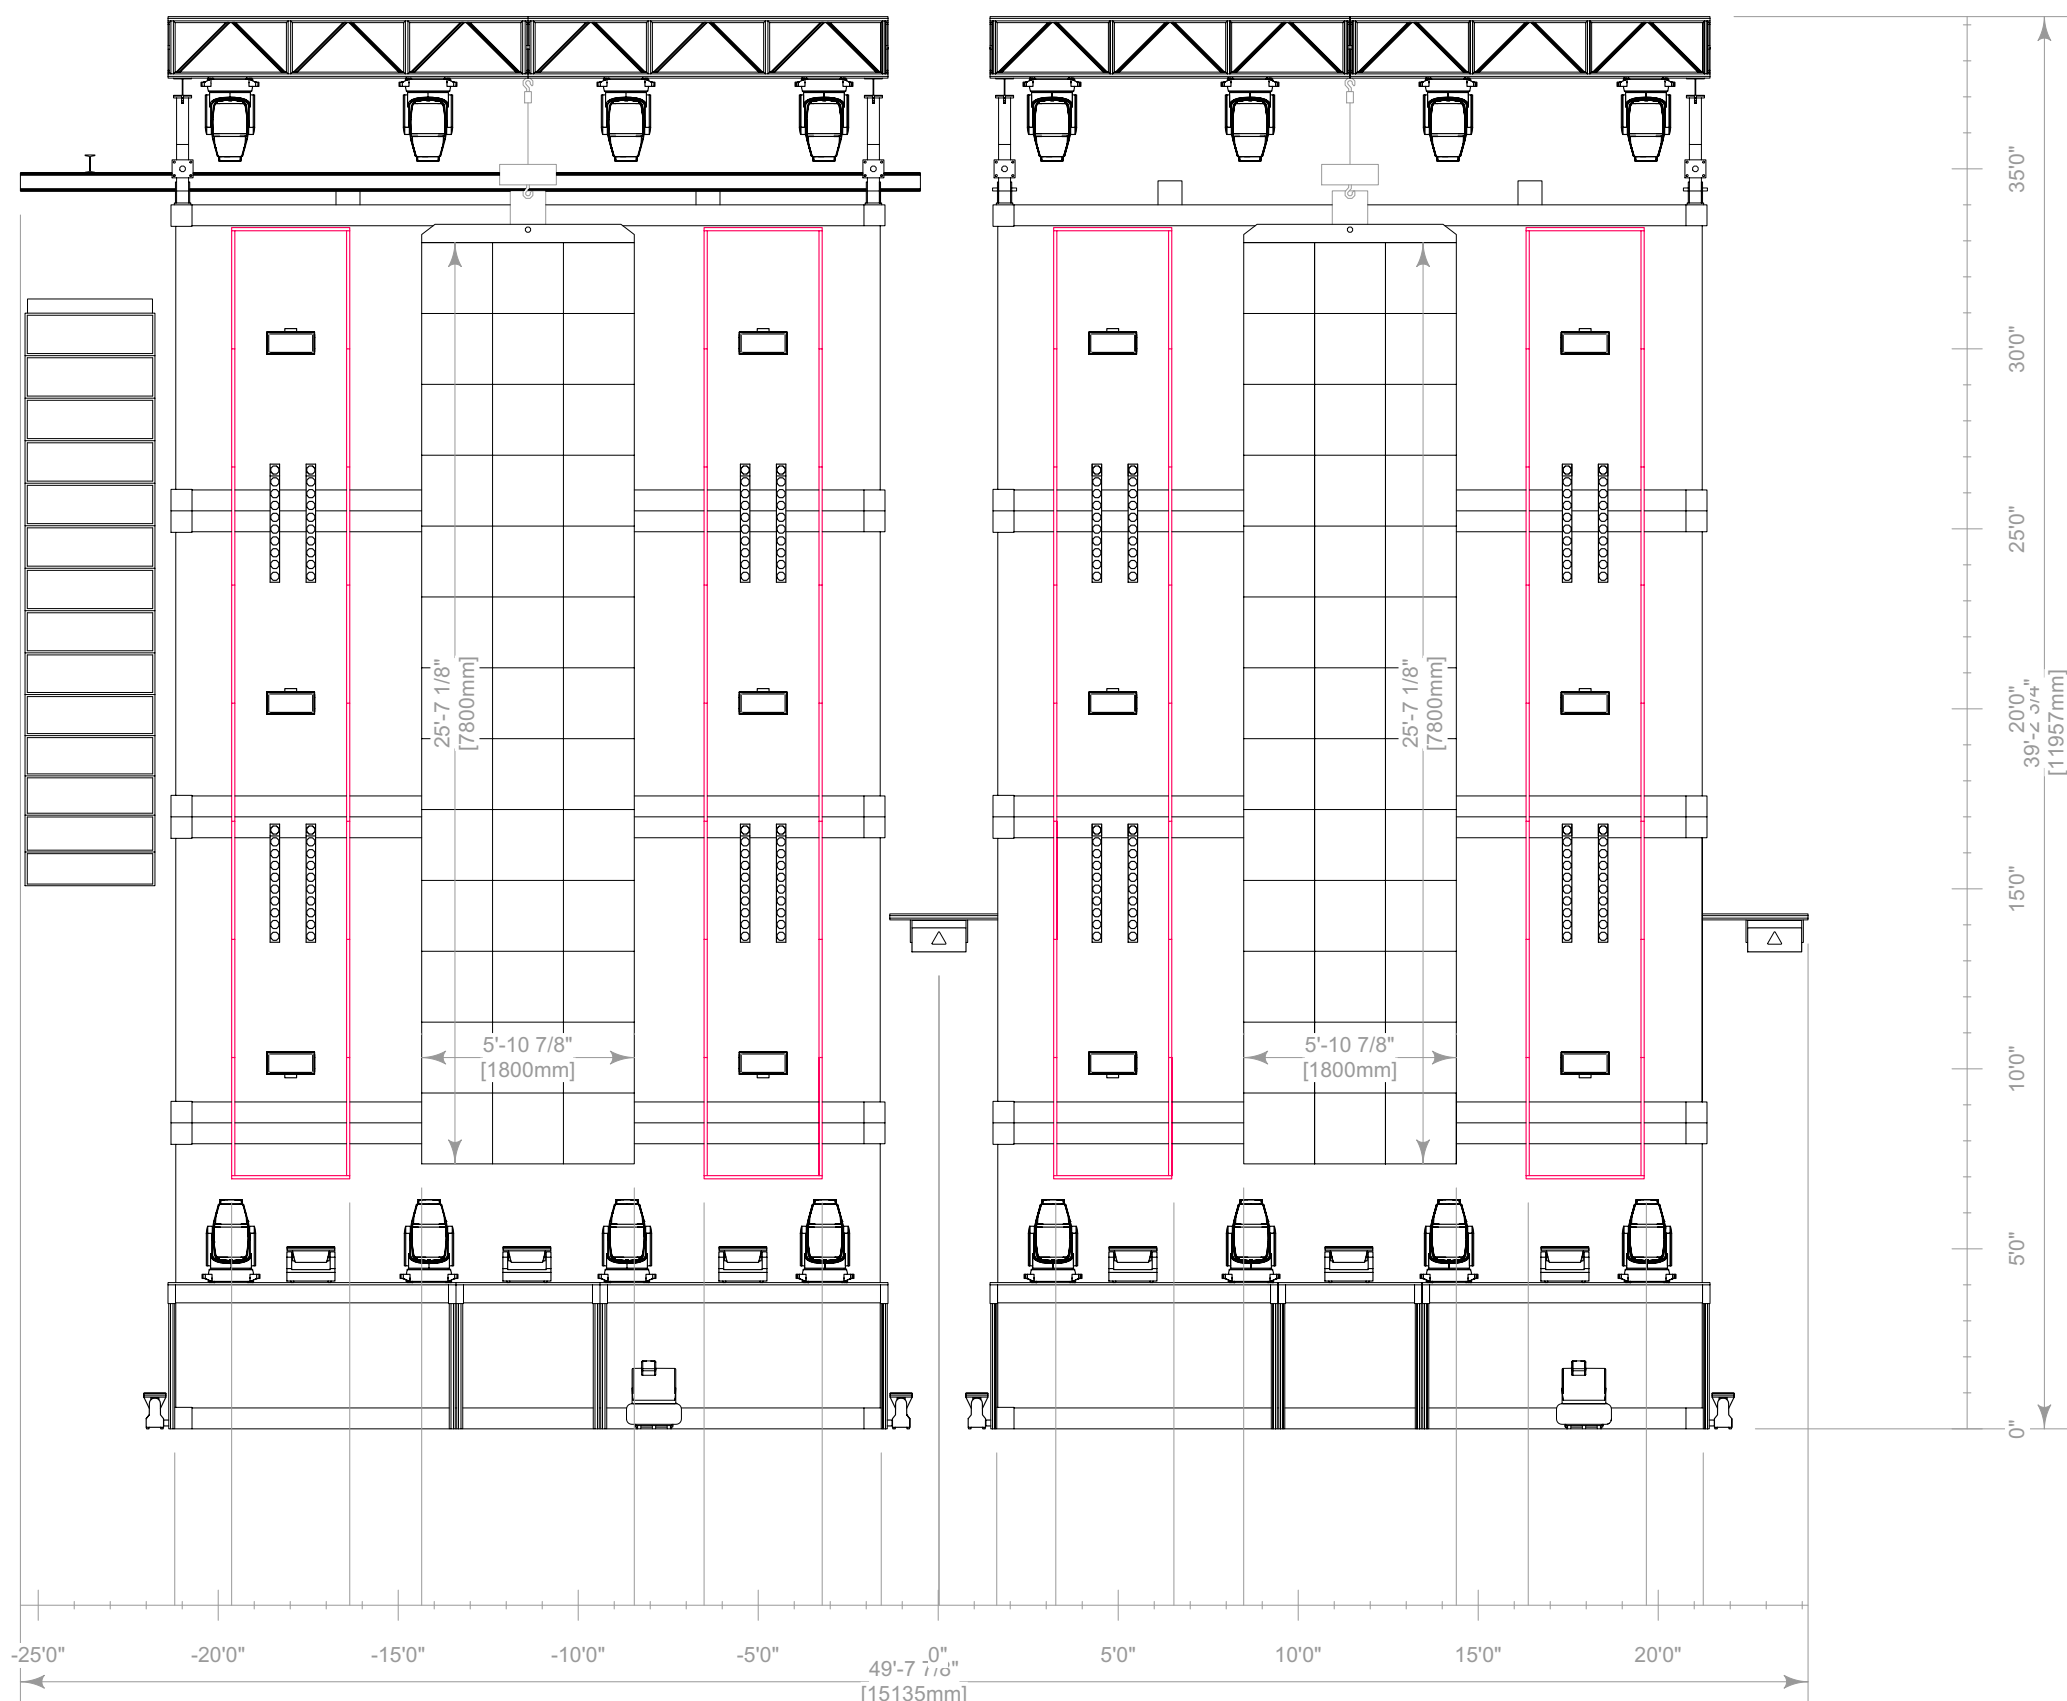

3

Detail B Front
Scale: 3/16" = 1'-0"

4

Detail B Right
Scale: 3/16" = 1'-0"

KEY TO SYMBOLS		
LIGHTING		
Thumbnail	Item	Qty
	Ayrton Perseo Beam - Standard (40ch)	132
	Chauvet Color Strike M - 13 Channel (13ch)	86
	Chauvet Maverick Single-Basic (20ch)	8
	Chauvet Strike Saber - 27 Channel (Dimmer Mode=Dimmer 1) (27ch)	61
	GLP Impression X4 Bar 20 - Single Pixel High Res (89ch)	28
	GLP JDC Line 1000 - MultiPix Advanced (316ch)	28
	Martin Scepton-1000mm - P3 - Pixel Map (10 Segments)/Square Smoked Lens (30ch)	481
	Robe MegaPointe - Mode 1 (39ch)	8
	SGM P-2 + Barn Doors - 5.2.0 (22ch)	4


VIDEO		
Thumbnail	Item	Qty
	600mm Triple Video Header (N/A)	6
	ROE CB8 600mmx1200mm (8.3mm)	396
	Video Tile-600mmx600mm (8mm)	204
	Video Tile-1200mmx1200mm (25mm Blow Through)	280

SFX		
Thumbnail	Item	Qty
	Blower Fan - N/A (0ch)	12
	Co2 Valve - N/A (0ch)	14
	Flame Head - N/A (0ch)	20
	Generic Laser - Beyond 5.0 Mid (32ch)	18
	Hazer - 2 Channel (2ch)	12
	Martin AF 1 DMX Fan - 5.2.0 (1ch)	4

CONTROL		
Thumbnail	Item	Qty
	Beyond Computer (Beyond 5.0 Ultimate)	1
	Generic Cooling/Heating Fan (https://a.co/d/hTWf56b)	2
	GrandMA2 Full-Size (3.9.60.37)	2
	Martin P3 Computer (Martin P3)	1

RIGGING		
Item	Qty	
2in Sched. 40 Pipe-03ft (Black)	12	
2in Sched. 40 Pipe-06ft (Black)	4	
12inx12in Box Truss-05ft (Black)	5	
12inx12in Box Truss-10ft (Black)	24	
12inx12in Box Truss-CB (Black)	10	
19inx19in Pipe Base (Black)	4	
20inx20in Box Truss-08ft (Black)	6	
20inx20in Box Truss-10ft (Black)	30	
30inx30in Truss Base (Black)	6	
Container Bracket - Bottom (Black)	12	
I Beam-06ft (Black)	2	
I Beam-20ft (Black)	4	
Tyler Truss GT-05ft		

TABLE OF CONTENTS	
Sheet Title	Page
Cover Page	1
Saturday/Sunday Rendering	2
Saturday/Sunday Plan	3
Saturday/Sunday Front Elevation/CL Section	4
Saturday/Sunday Deck Detail	5
Detail A	6
Detail B	7
Detail C,D,E,F	8
Detail G,N	9
Saturday/Sunday DJ Booth & FOH Detail	10
Friday Rendering	11
Friday Plan	12
Friday Front Elevation/CL Section	13
Friday Deck Detail	14

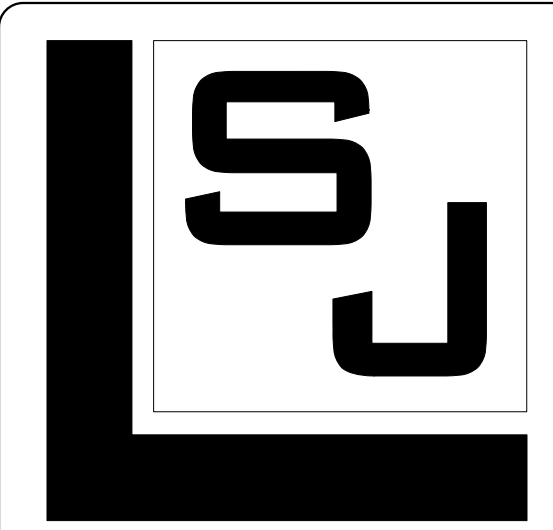

SJ LIGHTING, INC.
WESTLAKE VILLAGE, CA
818.874.9779
INFO@SJLIGHTING.NET
WWW.SJLIGHTING.NET

THE DESIGN AND ALL ASSOCIATED PAPERWORK IS COPYRIGHTED MATERIAL AND REMAINS THE PROPERTY OF THE DESIGNER.
THIS DESIGN IS FOR ONE TIME USE ONLY AT THE SPECIFIED LOCATION AND IS NOT TO BE USED FOR ANY OTHER PURPOSE OR EVENT WITHOUT SPECIFIC WRITTEN PERMISSION OF THE DESIGNER.
DESIGNER IS NOT A STRUCTURAL ENGINEER AND THESE DRAWINGS REPRESENT DESIGN CONCEPTS ONLY AND ARE NOT INTENDED AS ENGINEERING DRAWINGS. THE DESIGNER ASSUMES NO RESPONSIBILITY FOR THE SAFETY OR STRUCTURAL INTEGRITY OF ANY EQUIPMENT PROVIDED BY ANYONE.



REVISIONS			
REV #	REMARKS	DATE	INT.
001	-Initial Design	4/6/2023	AHT
002	-Update Saturday Deck Detail	4/21/2023	AHT
003	-Update Friday DJ Booth	5/30/2023	AHT
004	-Add Detail M	7/6/2023	AHT
005	-Update Friday DJ Booth	7/19/2023	AHT
	-Add Detail N		
	-Update Detail A,B,C,D		
	-Update Friday & Saturday DJ Booth		
	-Update Friday & Saturday Deck Detail		
006	-Update Audio Hangs	8/3/2023	AHT
007	-Update Deck Size	8/11/2023	AHT
008	-Update Detail B	8/22/2023	AHT


AURIS PRESENTS
ARC MUSIC FESTIVAL
CHICAGO, IL
UNION PARK
SEPTEMBER 1-3, 2023

STAGE 1

ISSUE DATE
Wednesday, August 23, 2023

DRAWN BY MTR
SCALE SEE DRAWING ARCH D (24"x36")

Detail B

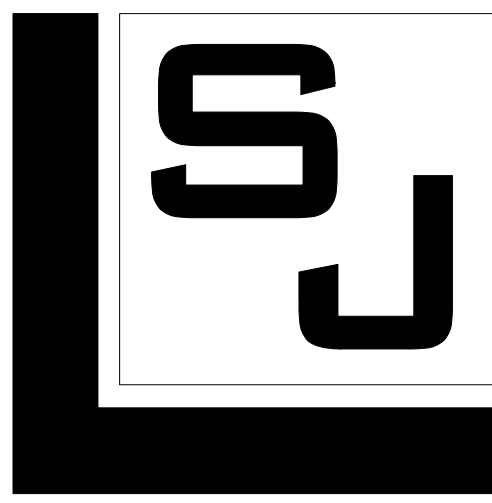

SJ LIGHTING, INC.
WESTLAKE VILLAGE, CA
818.874.9779
INFO@SJLIGHTING.NET
WWW.SJLIGHTING.NET

THE DESIGN AND ALL ASSOCIATED PAPERWORK IS
COPYRIGHTED MATERIAL AND REMAINS THE PROPERTY OF
THE DESIGNER.
THIS DESIGN IS FOR ONE TIME USE ONLY AT THE SPECIFIED
LOCATION AND IS NOT TO BE USED FOR ANY OTHER
PURPOSE OR EVENT WITHOUT SPECIFIC WRITTEN
PERMISSION OF THE DESIGNER.
DESIGNER IS NOT A STRUCTURAL ENGINEER AND THESE
DRAWINGS REPRESENT DESIGN CONCEPTS ONLY AND ARE
NOT INTENDED AS ENGINEERING DRAWINGS. THE
DESIGNER ASSUMES NO RESPONSIBILITY FOR THE SAFETY
OR STRUCTURAL INTEGRITY OF ANY EQUIPMENT PROVIDED
BY ANYONE.



REVISIONS

REV #	REMARKS	DATE	INT.
001	-Initial Design	4/6/2023	AHT
002	-Update Saturday Deck Detail	4/21/2023	AHT
003	-Update Friday DJ Booth	5/30/2023	AHT
004	-Add Detail M -Update Friday DJ Booth	7/6/2023	AHT
005	-Add Detail N -Update Detail A,B,C,D -Update Friday & Saturday DJ Booth	7/19/2023	AHT
006	-Update Friday & Saturday Deck Detail	8/3/2023	AHT
007	-Update Deck Size	8/11/2023	AHT
008	-Update Detail A,B	8/22/2023	AHT

AURIS PRESENTS

ARC MUSIC
FESTIVAL

CHICAGO, IL

UNION PARK

SEPTEMBER 1-3, 2023

STAGE 1

ISSUE DATE

Wednesday, August 23, 2023

DRAWN BY

MTR
S.J.L

SCALE

SEE DRAWING
ARCH D (24"x36")

Detail C,D,E,F

DD

8 OF 20


KEY TO SYMBOLS

SUBSTITUTIONS ARE ACCEPTED UPON APPROVAL

LIGHTING		
Thumbnail	Item	Qty
	Ayrton Perseo Beam - Standard (40ch)	132
	Chauvet Color Strike M - 13 Channel (13ch)	86
	Chauvet Maverick MK2 Wash - Single-Basic (20ch)	8
	Chauvet Strike Saber - 27 Channel (Dimmer Mode=Dimmer 1) (27ch)	61
	GLP Impression X4 Bar 20 - Single Pixel High Res (89ch)	28
	GLP JDC Line 1000 - MultiPix Advanced (316ch)	28
	Martin Scepter-1000mm - P3 - Pixel Map (10 Segments)/Square Smoked Lens (30ch)	481
	Robe MegaPointe - Mode 1 (39ch)	8
	SGM P-2 + Barn Doors - 5.2.0 (22ch)	4
VIDEO		
Thumbnail	Item	Qty
	600mm Triple Video Header (N/A)	6
	ROE CB8 600mmx1200mm (8.3mm)	396
	Video Tile-600mmx600mm (8mm)	204
	Video Tile-1200mmx1200mm (25mm Blow Through)	280
~762 M² Total		
SFX		
Thumbnail	Item	Qty
	Blower Fan - N/A (0ch)	12
	Co2 Valve - N/A (0ch)	14
	Flame Head - N/A (0ch)	20
	Generic Laser - Beyond 5.0 Mid (32ch)	18
	Hazer - 2 Channel (2ch)	12
	Martin AF 1 DMX Fan - 5.2.0 (1ch)	4
CONTROL		
Thumbnail	Item	Qty
	Beyond Computer (Beyond 5.0 Ultimate)	1
	Generic Cooling/Heating Fan (https://a.co/d/hTWf56b)	2
	GrandMA2 Full-Size (3.9.60.37)	2
	Martin P3 Computer (Martin P3)	1
RIGGING		
Item		Qty
2in Sched. 40 Pipe-03ft (Black)		12
2in Sched. 40 Pipe-06ft (Black)		4
12inx12in Box Truss-05ft (Black)		5
12inx12in Box Truss-10ft (Black)		24
12inx12in Box Truss-CB (Black)		10
19inx19in Pipe Base (Black)		4
20inx20in Box Truss-08ft (Black)		6
20inx20in Box Truss-10ft (Black)		30
30inx30in Truss Base (Black)		6
Container Bracket - Bottom (Black)		12
I Beam-06ft (Black)		2
I Beam-20ft (Black)		4
Twyler Truss GT-05ft		4


TABLE OF CONTENTS

Sheet Title	Page
Cover Page	1
Saturday/Sunday Rendering	2
Saturday/Sunday Plan	3
Saturday/Sunday Front Elevation/CL Section	4
Saturday/Sunday Deck Detail	5
Detail A	6
Detail B	7
Detail C,D,E,F	8
Detail G,N	9
Saturday/Sunday DJ Booth & FOH Detail	10
Friday Rendering	11
Friday Plan	12
Friday Front Elevation/CL Section	13
Friday Deck Detail	14

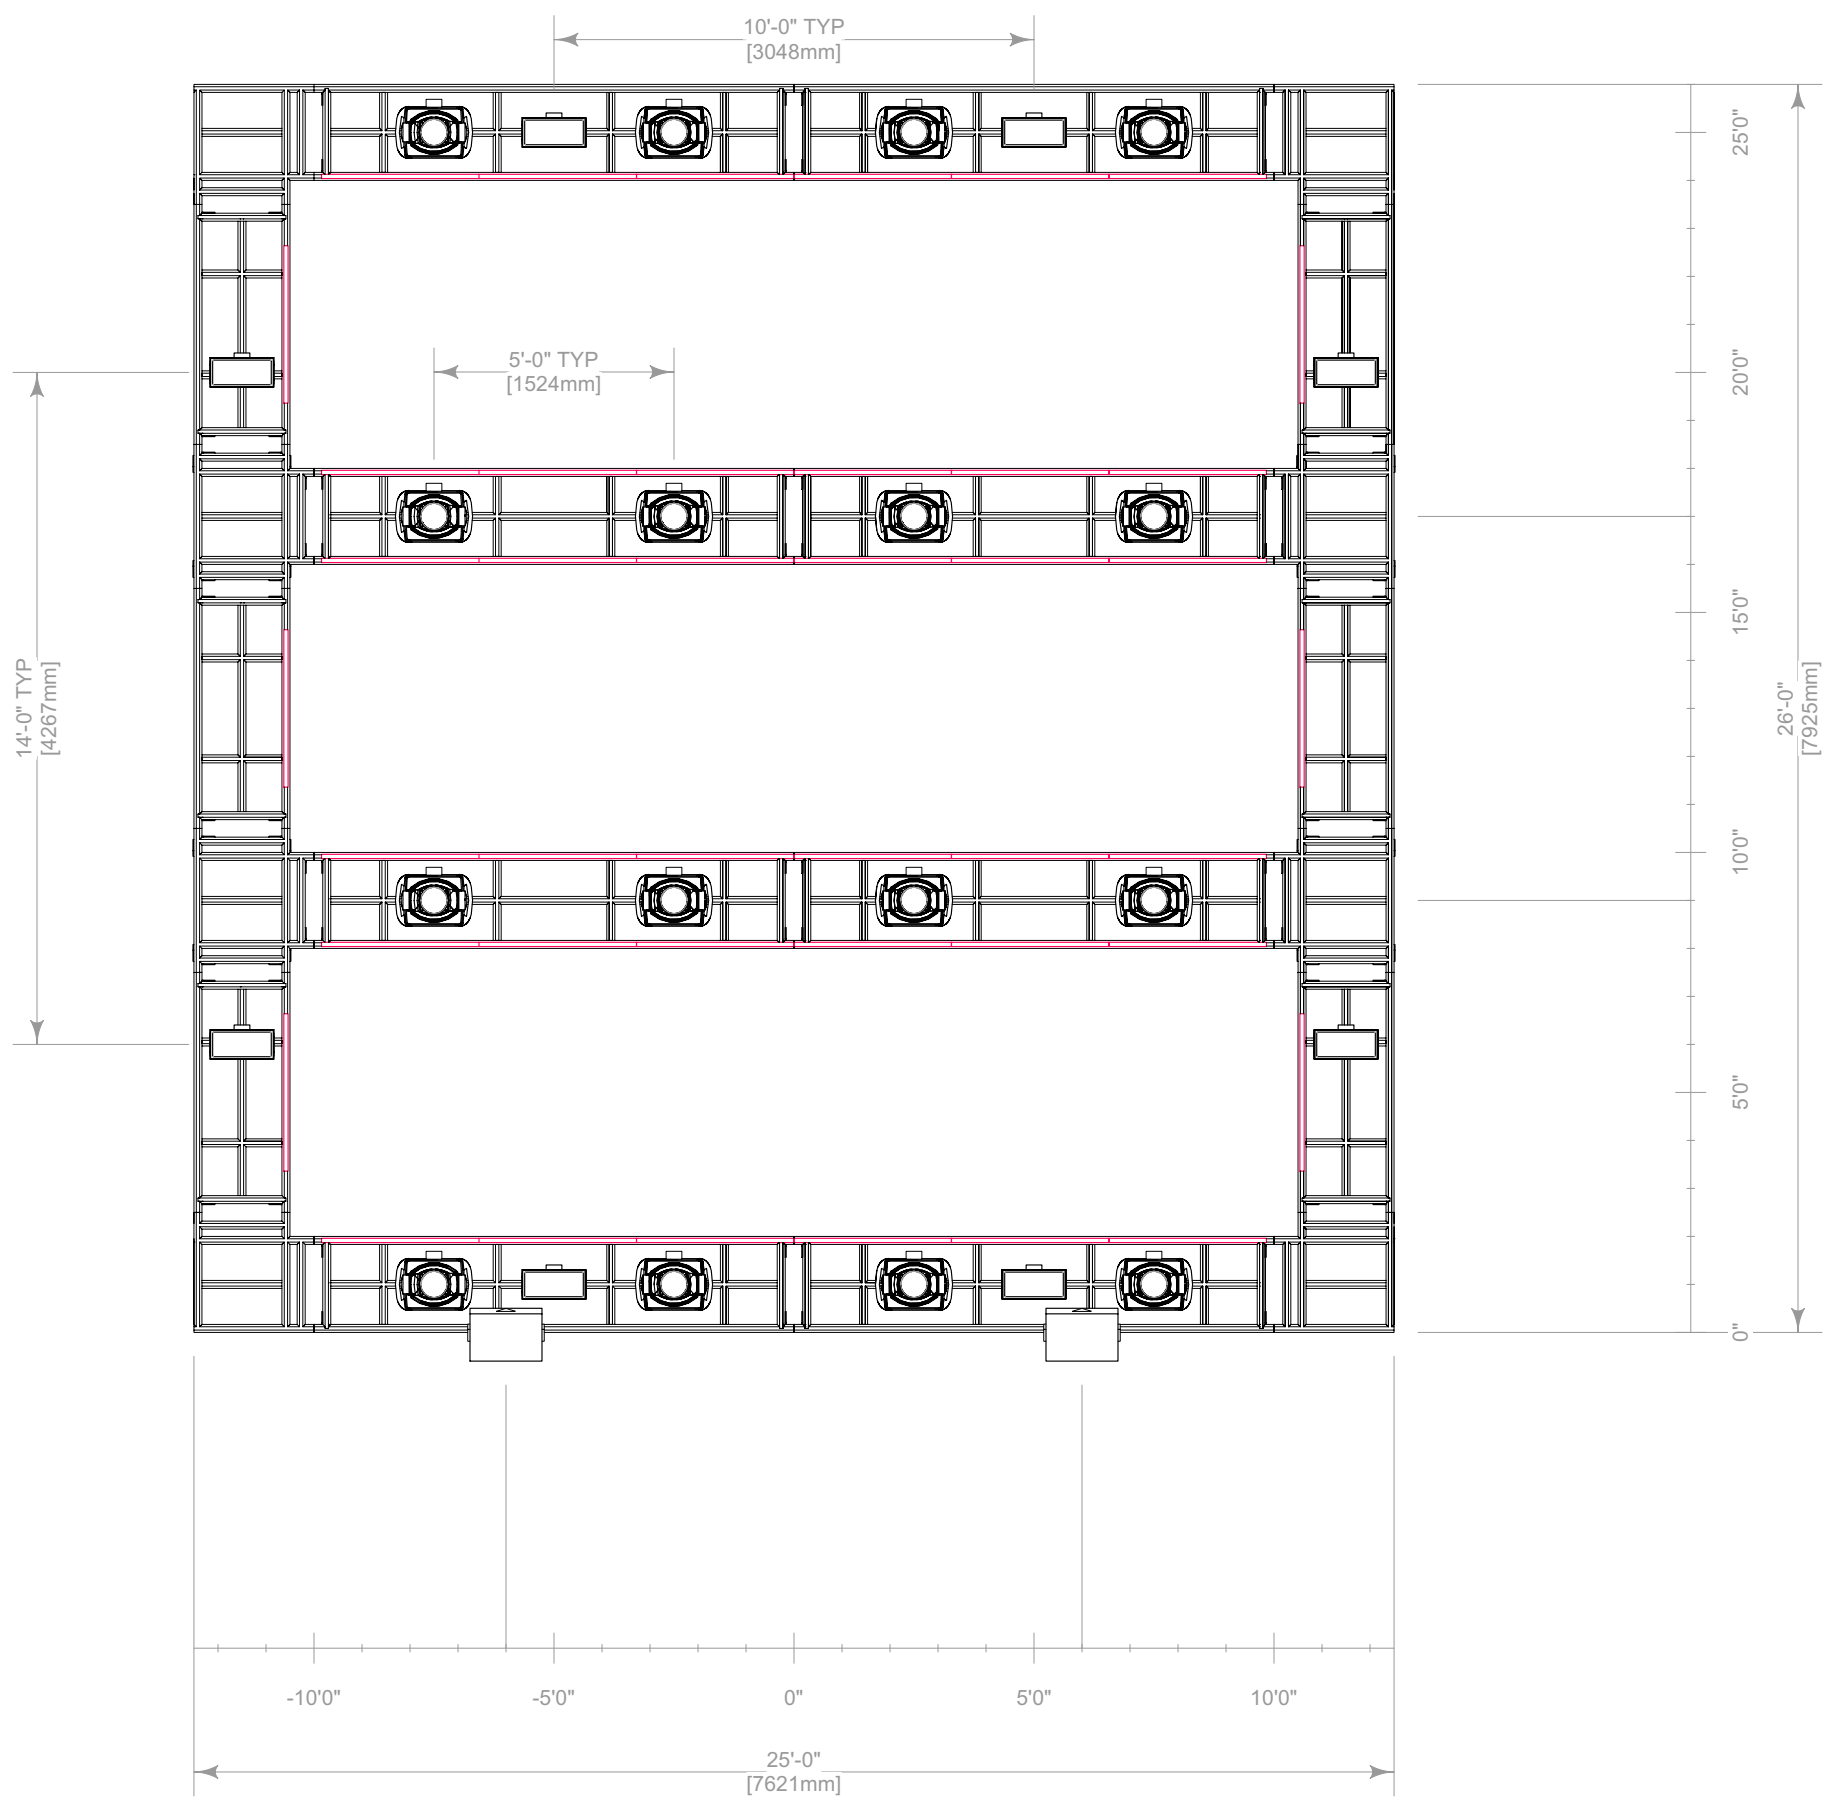


1

Detail C
Scale: 1/4" = 1'-0"

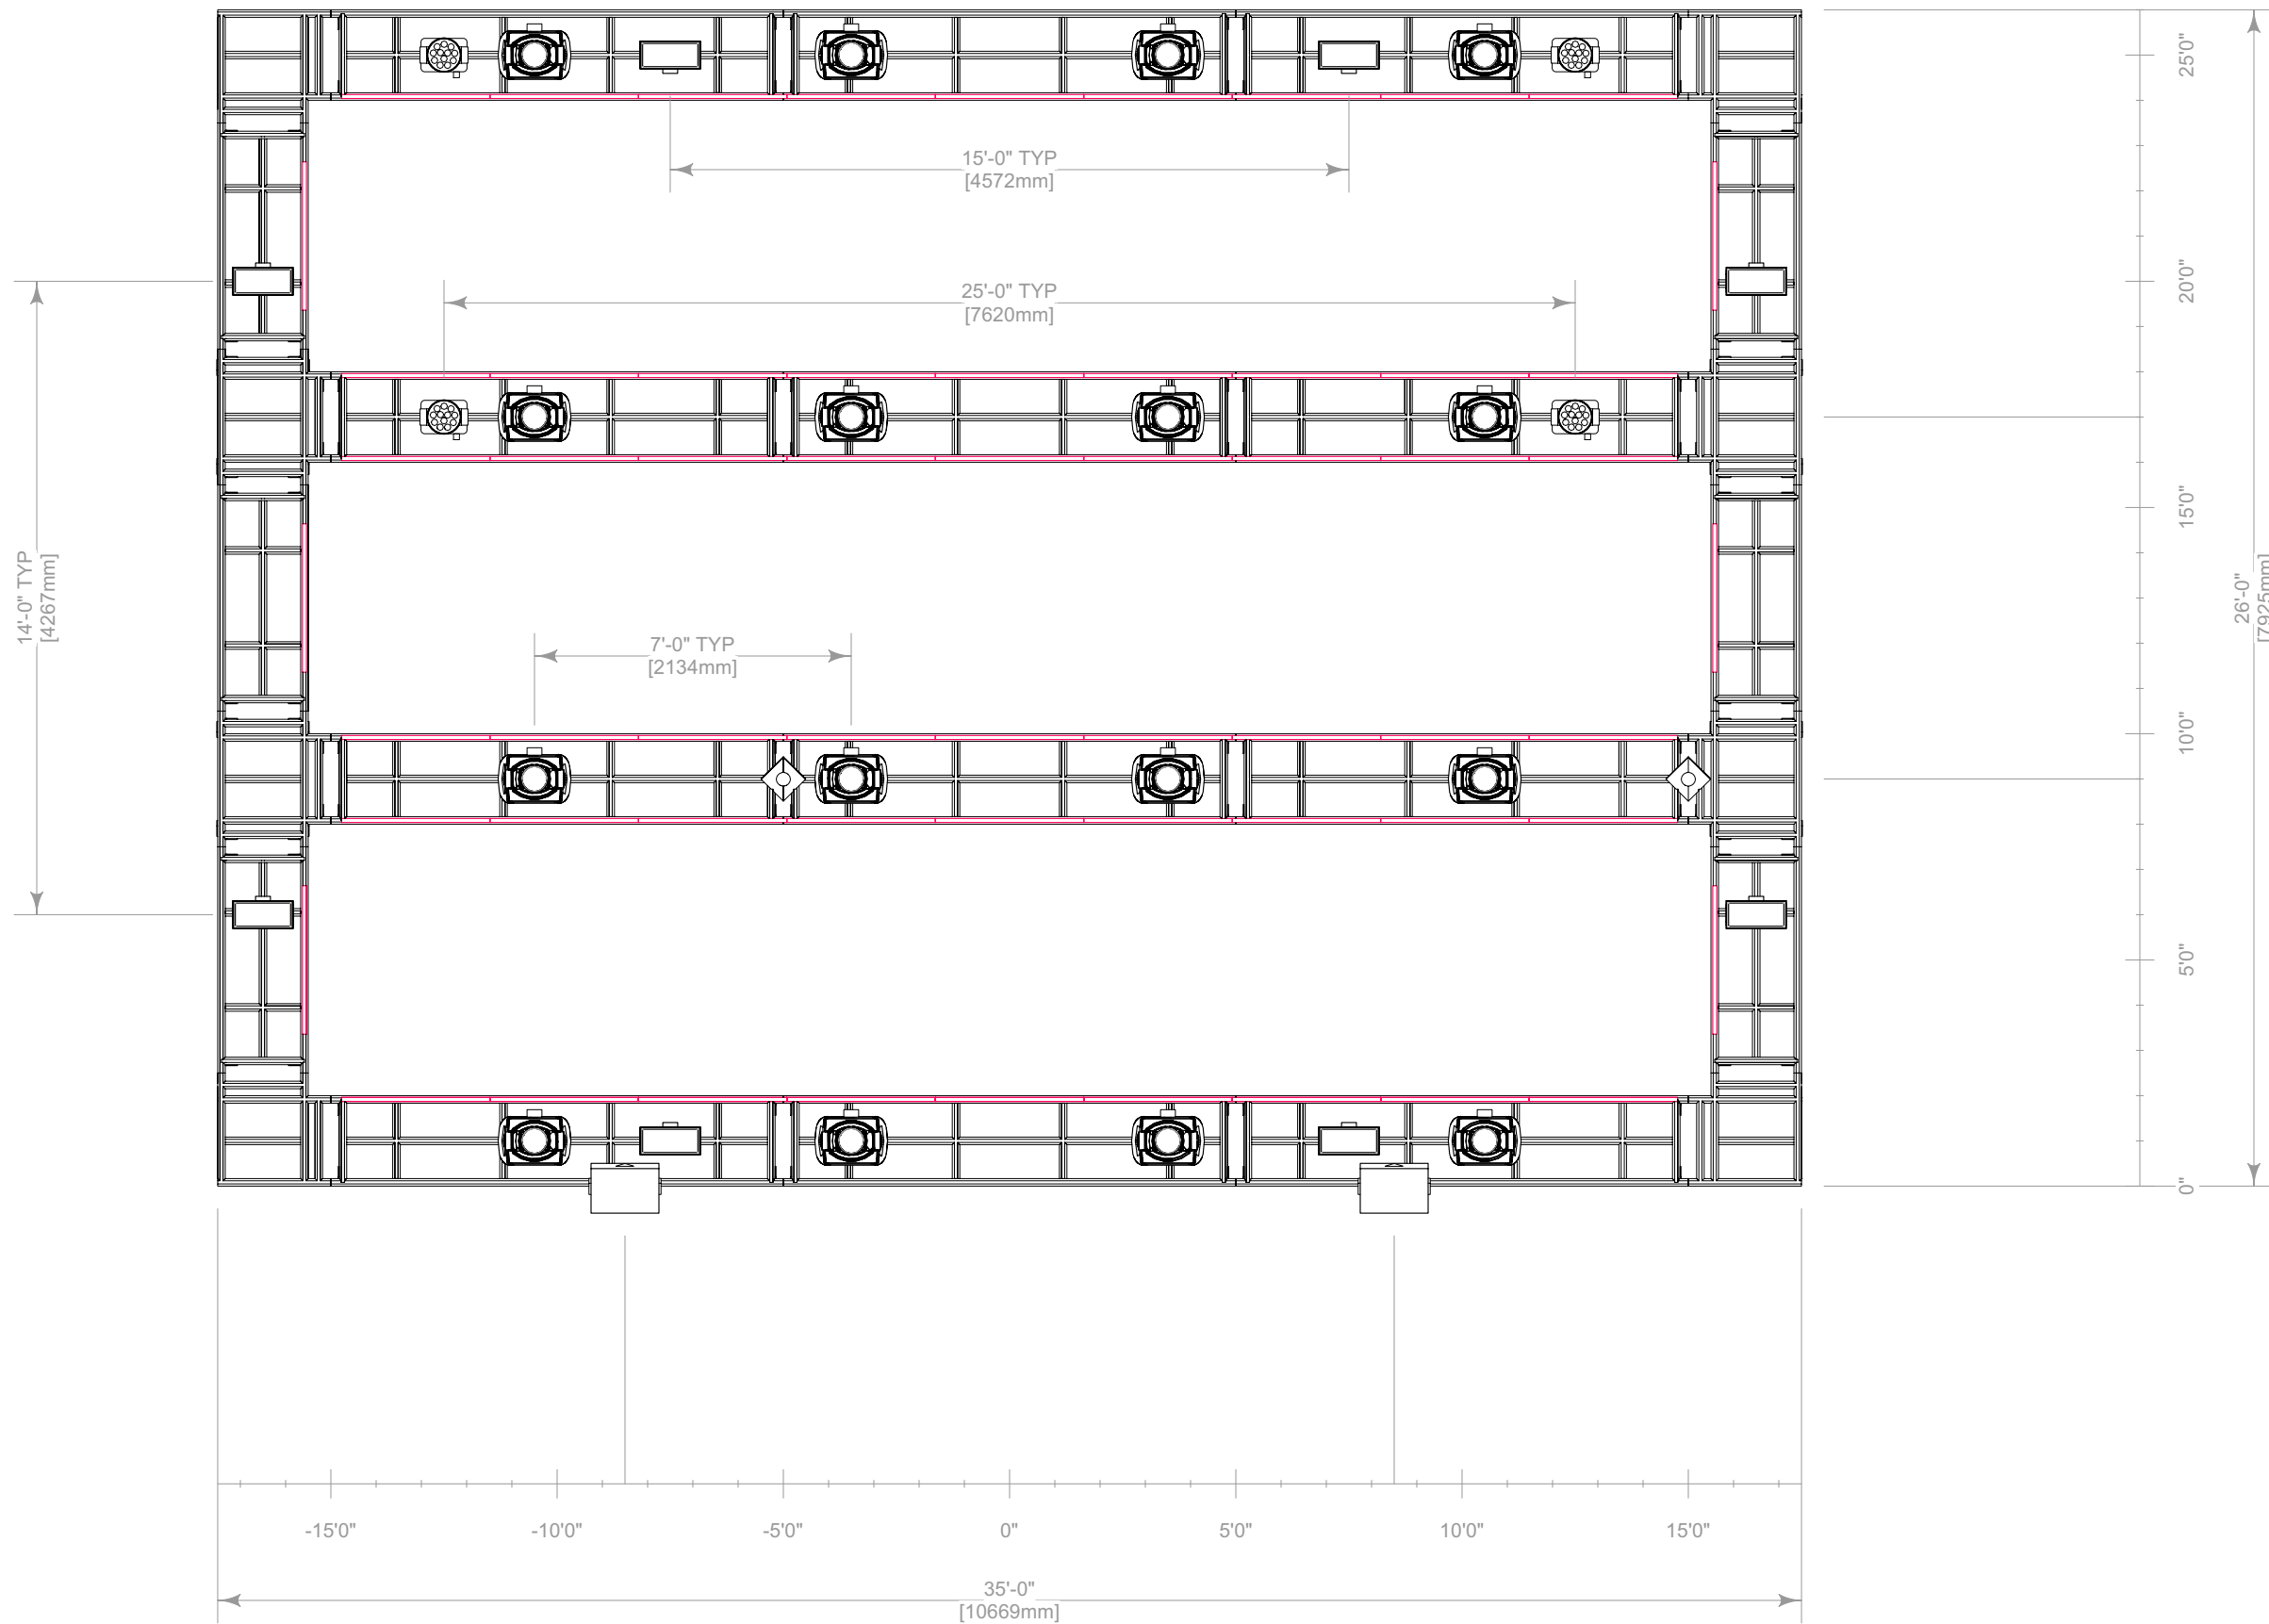


2

Detail D
Scale: 1/4" = 1'-0"

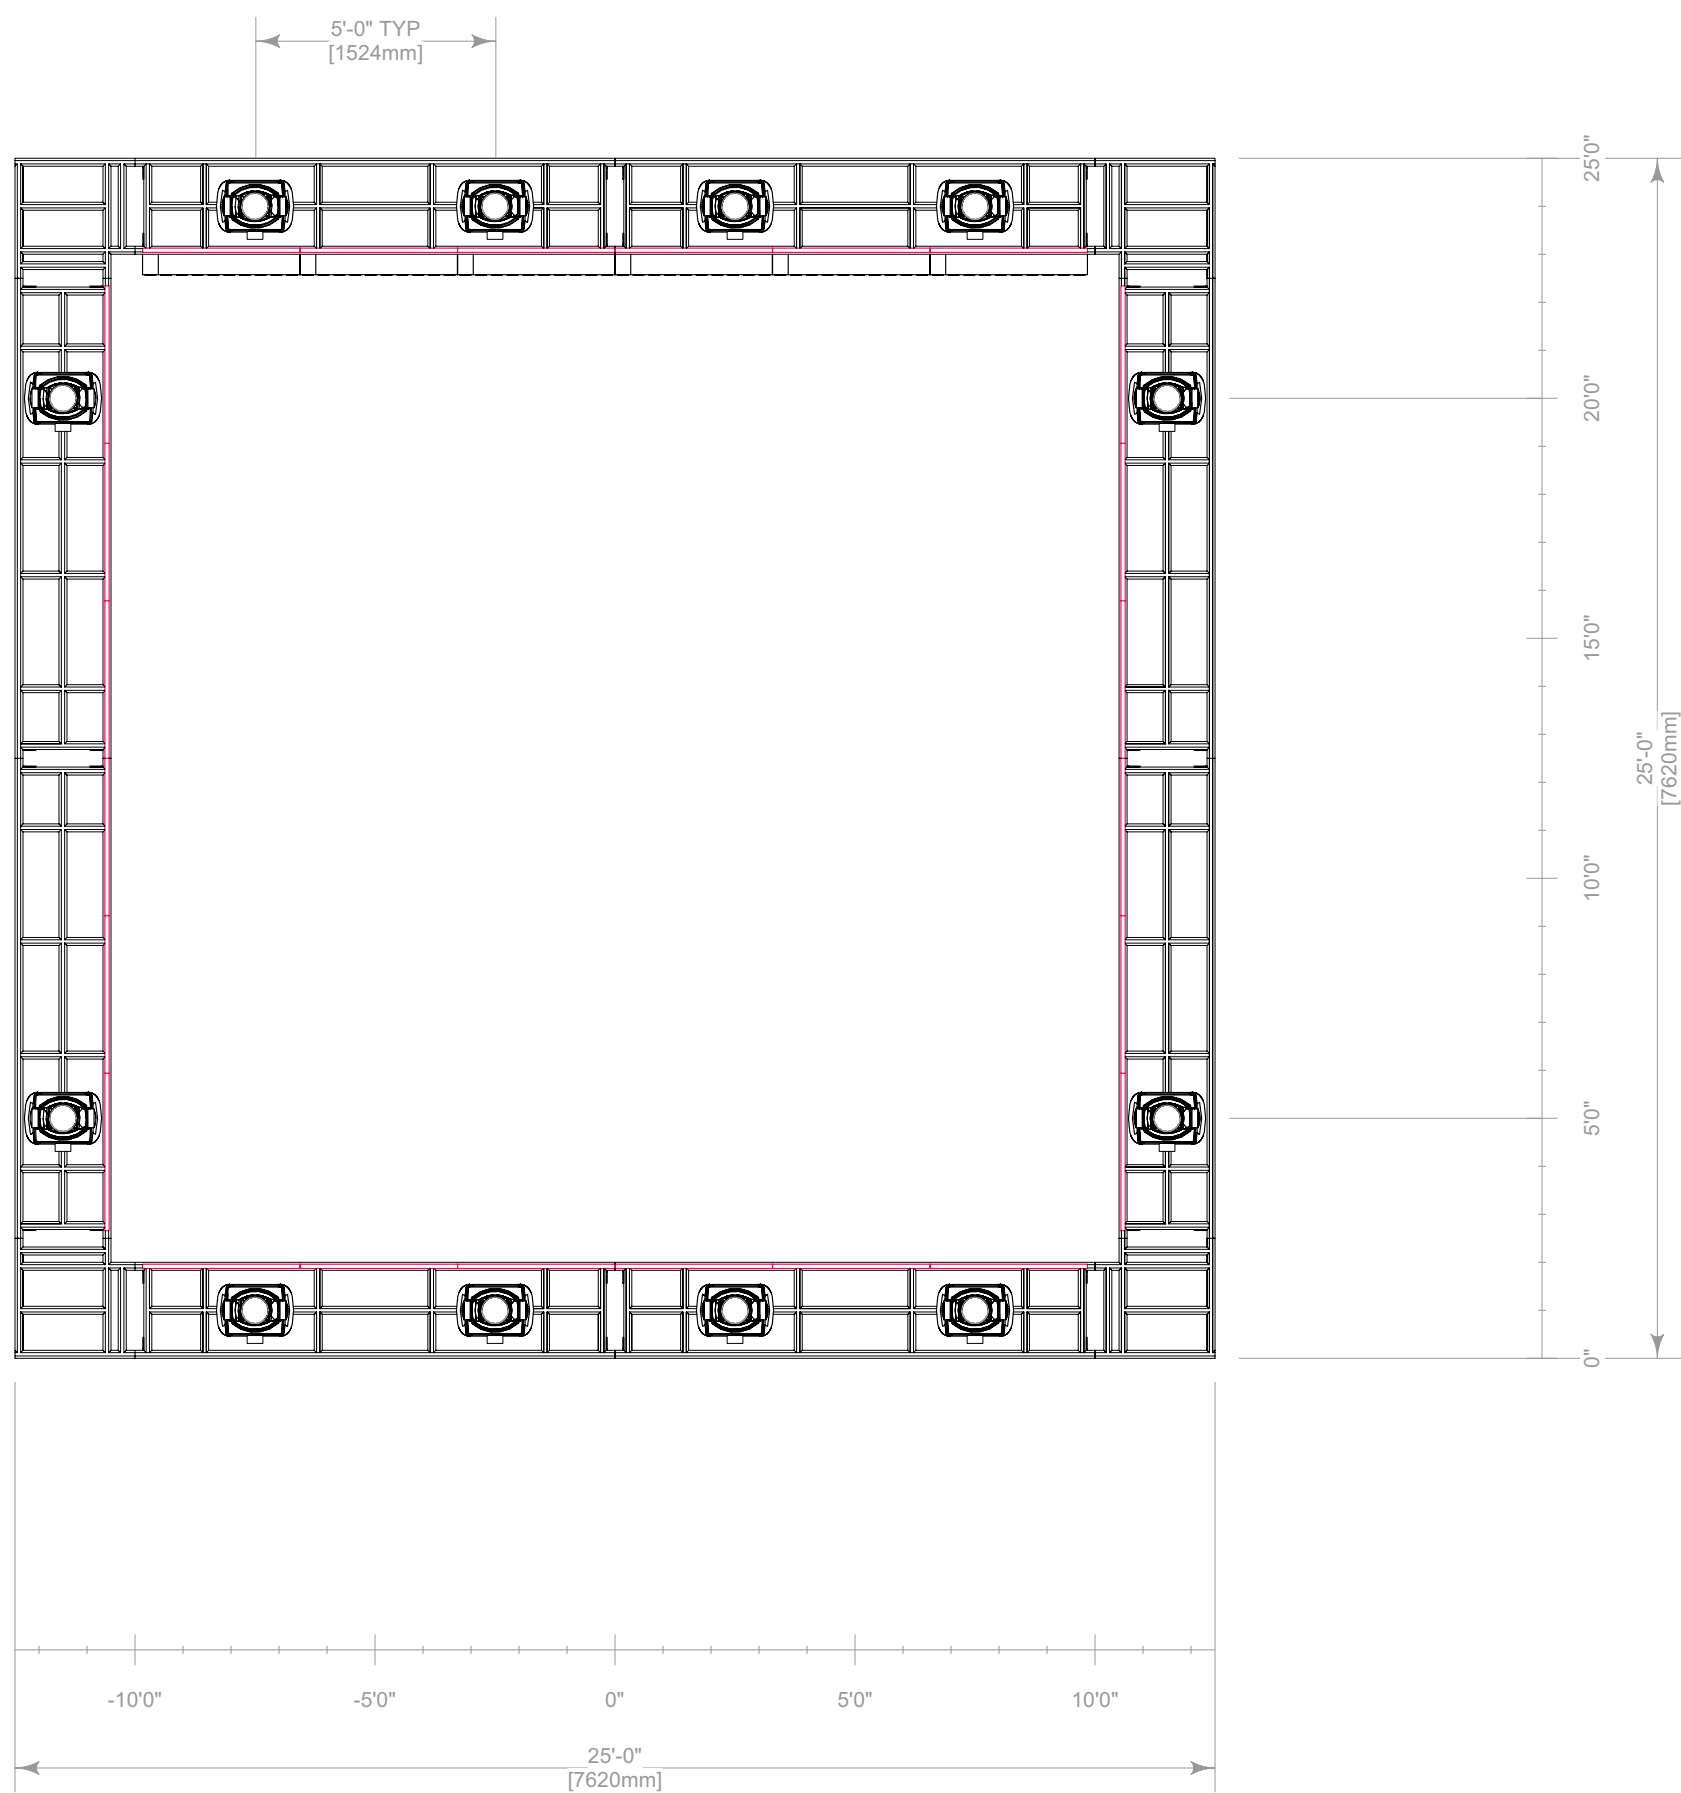

3

Detail E
Scale: 1/4" = 1'-0"



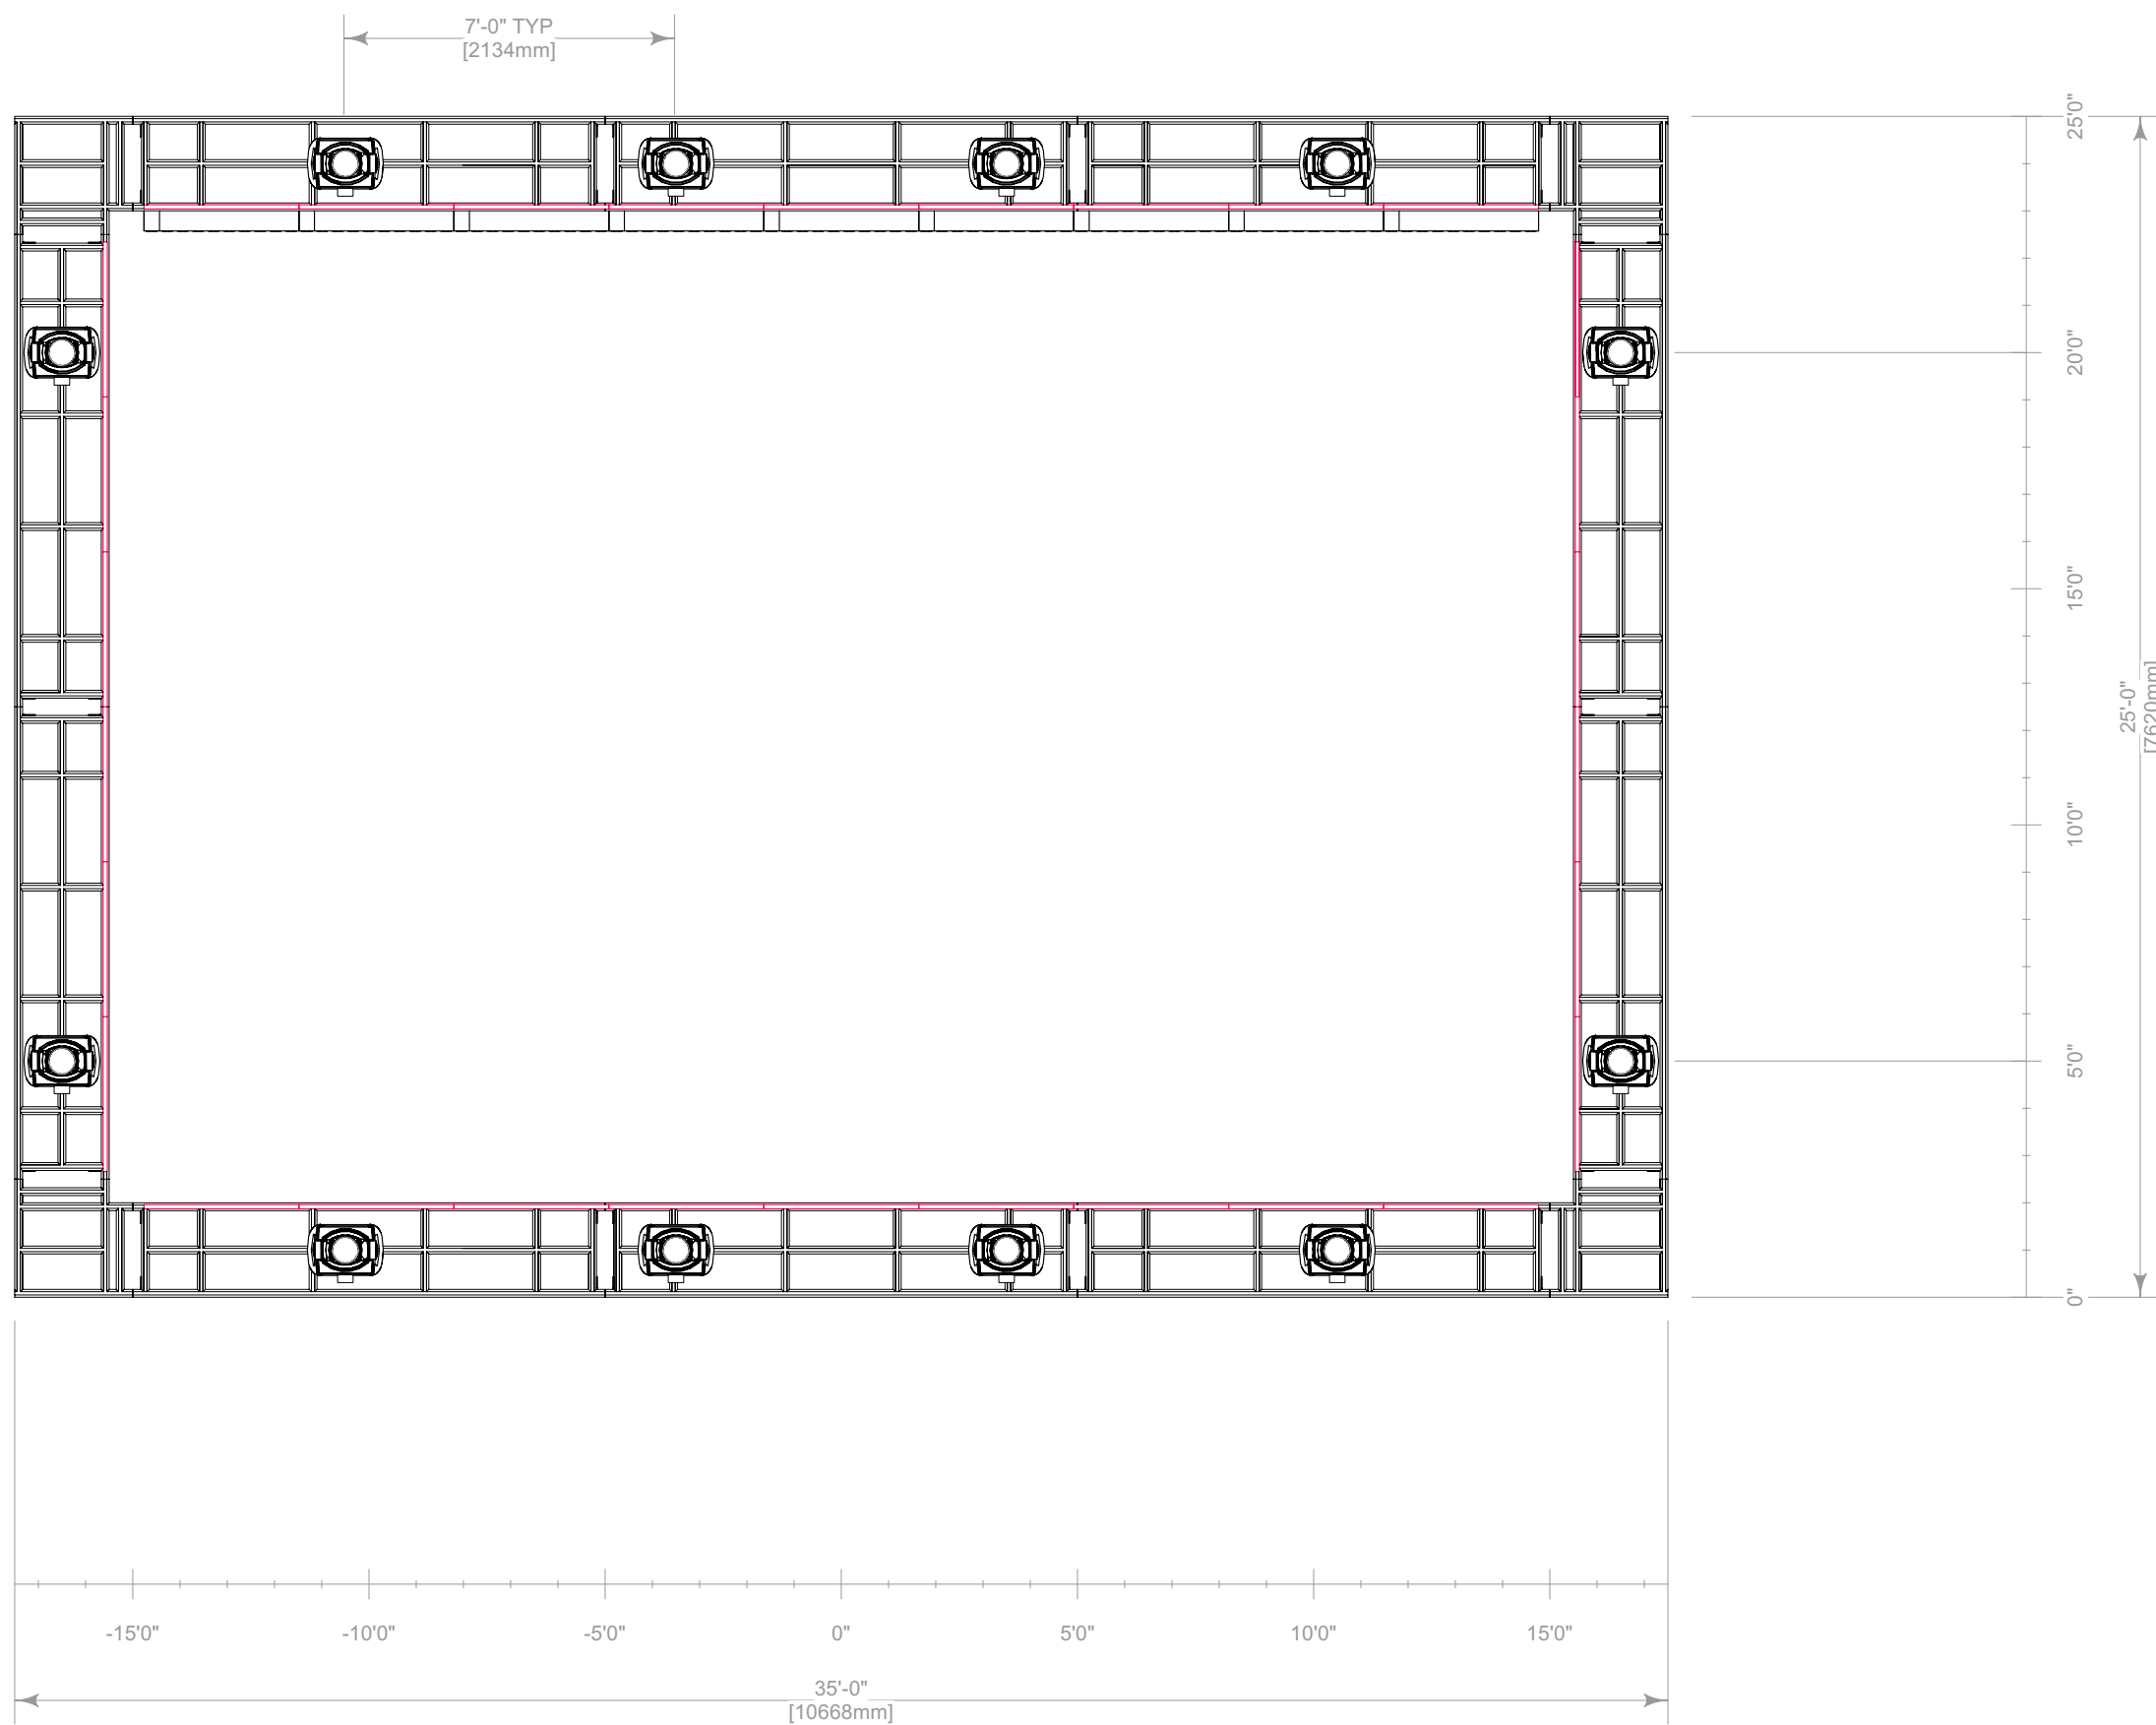


4

Detail F
Scale: 1/4" = 1'-0"

1

Detail G
Scale: 1/4" = 1'-0"

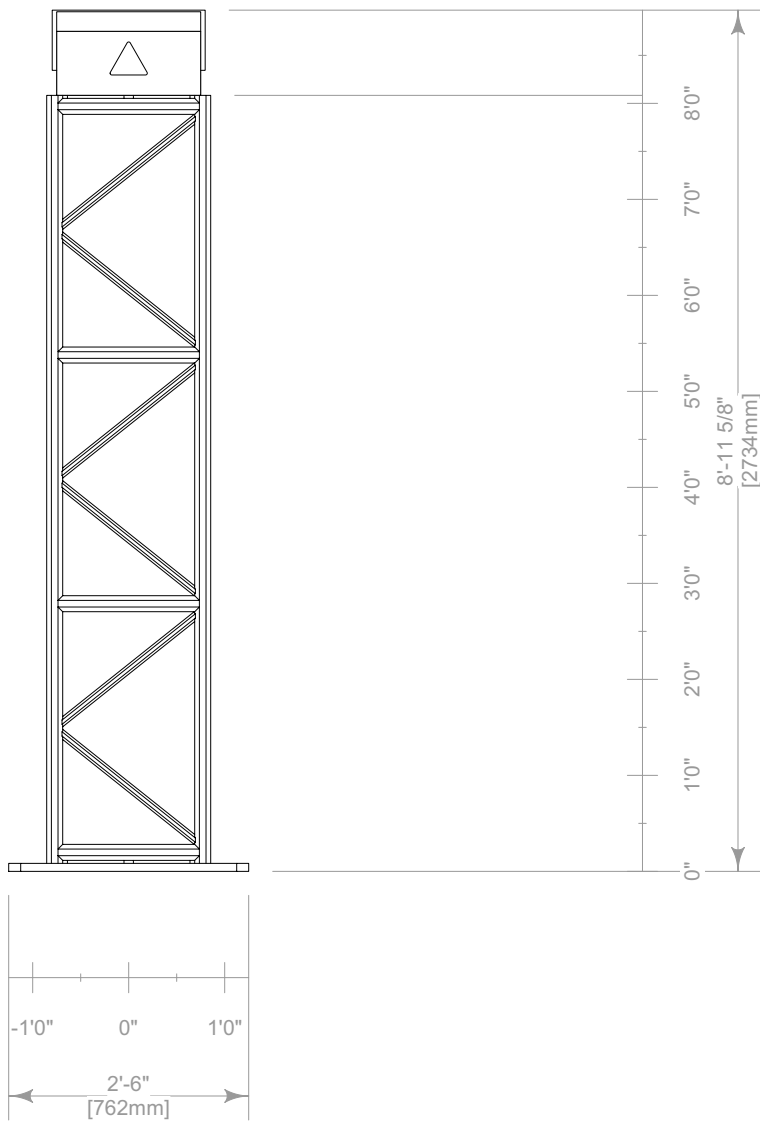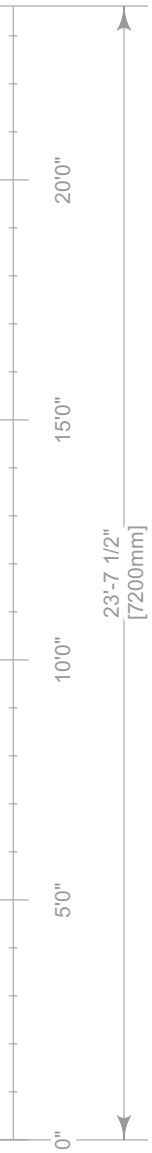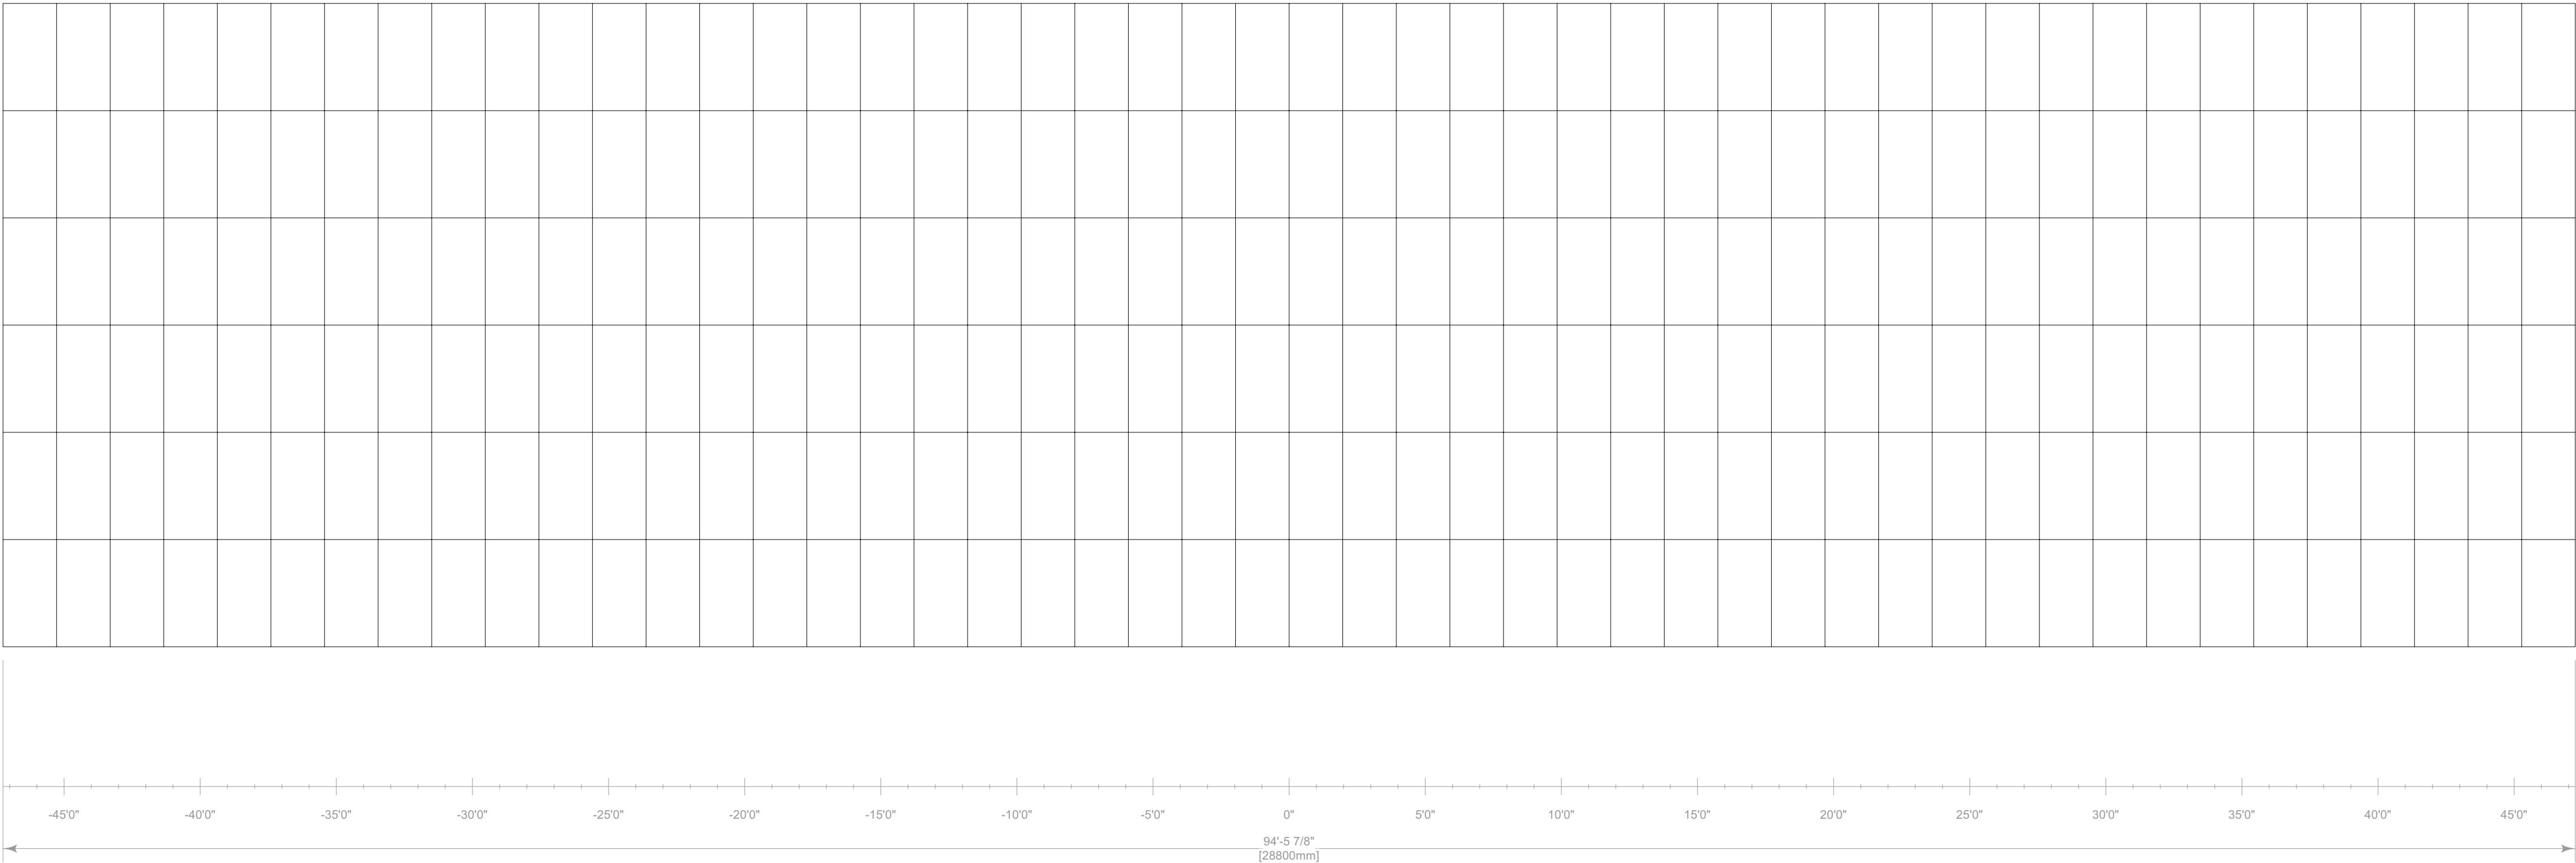

2

Detail N
Scale: 1/2" = 1'-0"

KEY TO SYMBOLS

SUBSTITUTIONS ARE ACCEPTED UPON APPROVAL

LIGHTING

Thumbnail	Item	Qty
	Ayrton Perseo Beam - Standard (40ch)	132
	Chauvet Color Strike M - 13 Channel (13ch)	86
	Chauvet Maverick MK2 Wash - Single-Basic (20ch)	8
	Chauvet Strike Saber - 27 Channel (Dimmer Mode=Dimmer 1) (27ch)	61
	GLP Impression X4 Bar 20 - Single Pixel High Res (89ch)	28
	GLP JDC Line 1000 - MultiPix Advanced (316ch)	28
	Martin Scepton-1000mm - P3 - Pixel Map (10 Segments)/Square Smoked Lens (30ch)	481
	Robe MegaPointe - Mode 1 (39ch)	8
	SGM P-2 + Barn Doors - 5.2.0 (22ch)	4

VIDEO

Thumbnail	Item	Qty
	600mm Triple Video Header (N/A)	6
	ROE CB8 600mmx1200mm (8.3mm)	396
	Video Tile-600mmx600mm (8mm)	204
	Video Tile-1200mmx1200mm (25mm Blow Through)	280

~762 M² Total

SFX

Thumbnail	Item	Qty
	Blower Fan - N/A (0ch)	12
	Co2 Valve - N/A (0ch)	14
	Flame Head - N/A (0ch)	20
	Generic Laser - Beyond 5.0 Mid (32ch)	18
	Hazer - 2 Channel (2ch)	12
	Martin AF 1 DMX Fan - 5.2.0 (1ch)	4

CONTROL


Thumbnail	Item	Qty
	Beyond Computer (Beyond 5.0 Ultimate)	1
	Generic Cooling/Heating Fan (https://a.co/d/hTwf56b)	2
	GrandMA2 Full-Size (3.9.60.37)	2
	Martin P3 Computer (Martin P3)	1

RIGGING

Item	Qty
2in Sched. 40 Pipe-03ft (Black)	12
2in Sched. 40 Pipe-06ft (Black)	4
12inx12in Box Truss-05ft (Black)	5
12inx12in Box Truss-10ft (Black)	24
12inx12in Box Truss-CB (Black)	10
19inx19in Pipe Base (Black)	4
20inx20in Box Truss-08ft (Black)	6
20inx20in Box Truss-10ft (Black)	30
30inx30in Truss Base (Black)	6
Container Bracket - Bottom (Black)	12
I Beam-06ft (Black)	2
I Beam-20ft (Black)	4
Tyler Truss GT-05ft	

TABLE OF CONTENTS

Sheet Title	Page
Cover Page	1
Saturday/Sunday Rendering	2
Saturday/Sunday Plan	3
Saturday/Sunday Front Elevation/CL Section	4
Saturday/Sunday Deck Detail	5
Detail A	6
Detail B	7
Detail C, D, E, F	8
Detail G, N	9
Saturday/Sunday DJ Booth & FOH Detail	10
Friday Rendering	11
Friday Plan	12
Friday Front Elevation/CL Section	13
Friday Deck Detail	14

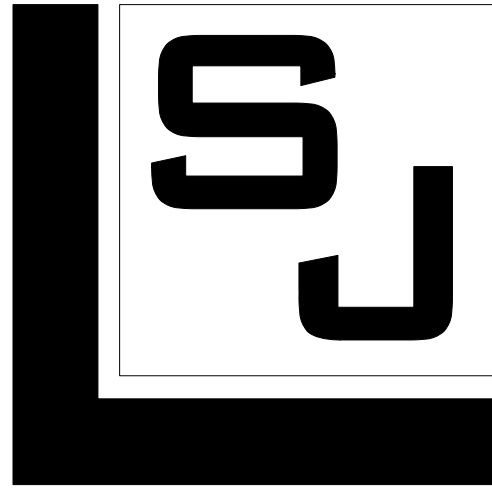

SJ LIGHTING, INC.
WESTLAKE VILLAGE, CA
818.874.9779
INFO@SJLIGHTING.NET
WWW.SJLIGHTING.NET

THE DESIGN AND ALL ASSOCIATED PAPERWORK IS COPYRIGHTED MATERIAL AND REMAINS THE PROPERTY OF THE DESIGNER.
THIS DESIGN IS FOR ONE TIME USE ONLY AT THE SPECIFIED LOCATION AND IS NOT TO BE USED FOR ANY OTHER PURPOSE OR EVENT WITHOUT SPECIFIC WRITTEN PERMISSION OF THE DESIGNER.
DESIGNER IS NOT A STRUCTURAL ENGINEER AND THESE DRAWINGS REPRESENT DESIGN CONCEPTS ONLY AND ARE NOT INTENDED AS ENGINEERING DRAWINGS. THE DESIGNER ASSUMES NO RESPONSIBILITY FOR THE SAFETY OR STRUCTURAL INTEGRITY OF ANY EQUIPMENT PROVIDED BY ANYONE.



REVISIONS

REV #	REMARKS	DATE	INT.
001	-Initial Design	4/6/2023	AHT
002	-Update Saturday Deck Detail	4/21/2023	AHT
003	-Update Friday DJ Booth	5/30/2023	AHT
004	-Add Detail M	7/6/2023	AHT
005	-Update Friday DJ Booth	7/19/2023	AHT
006	-Add Detail N		
007	-Update Friday & Saturday DJ Booth	8/3/2023	AHT
008	-Update Audio Hangs	8/11/2023	AHT
	-Update Deck Size	8/22/2023	AHT
	-Update Detail B		

AURIS PRESENTS

ARC MUSIC FESTIVAL

CHICAGO, IL

UNION PARK

SEPTEMBER 1-3, 2023

STAGE 1

ISSUE DATE

Wednesday, August 23, 2023

DRAWN BY


MTR
SUL

SCALE


SEE DRAWING
ARCH D (24"x36")

Detail G,N


DD

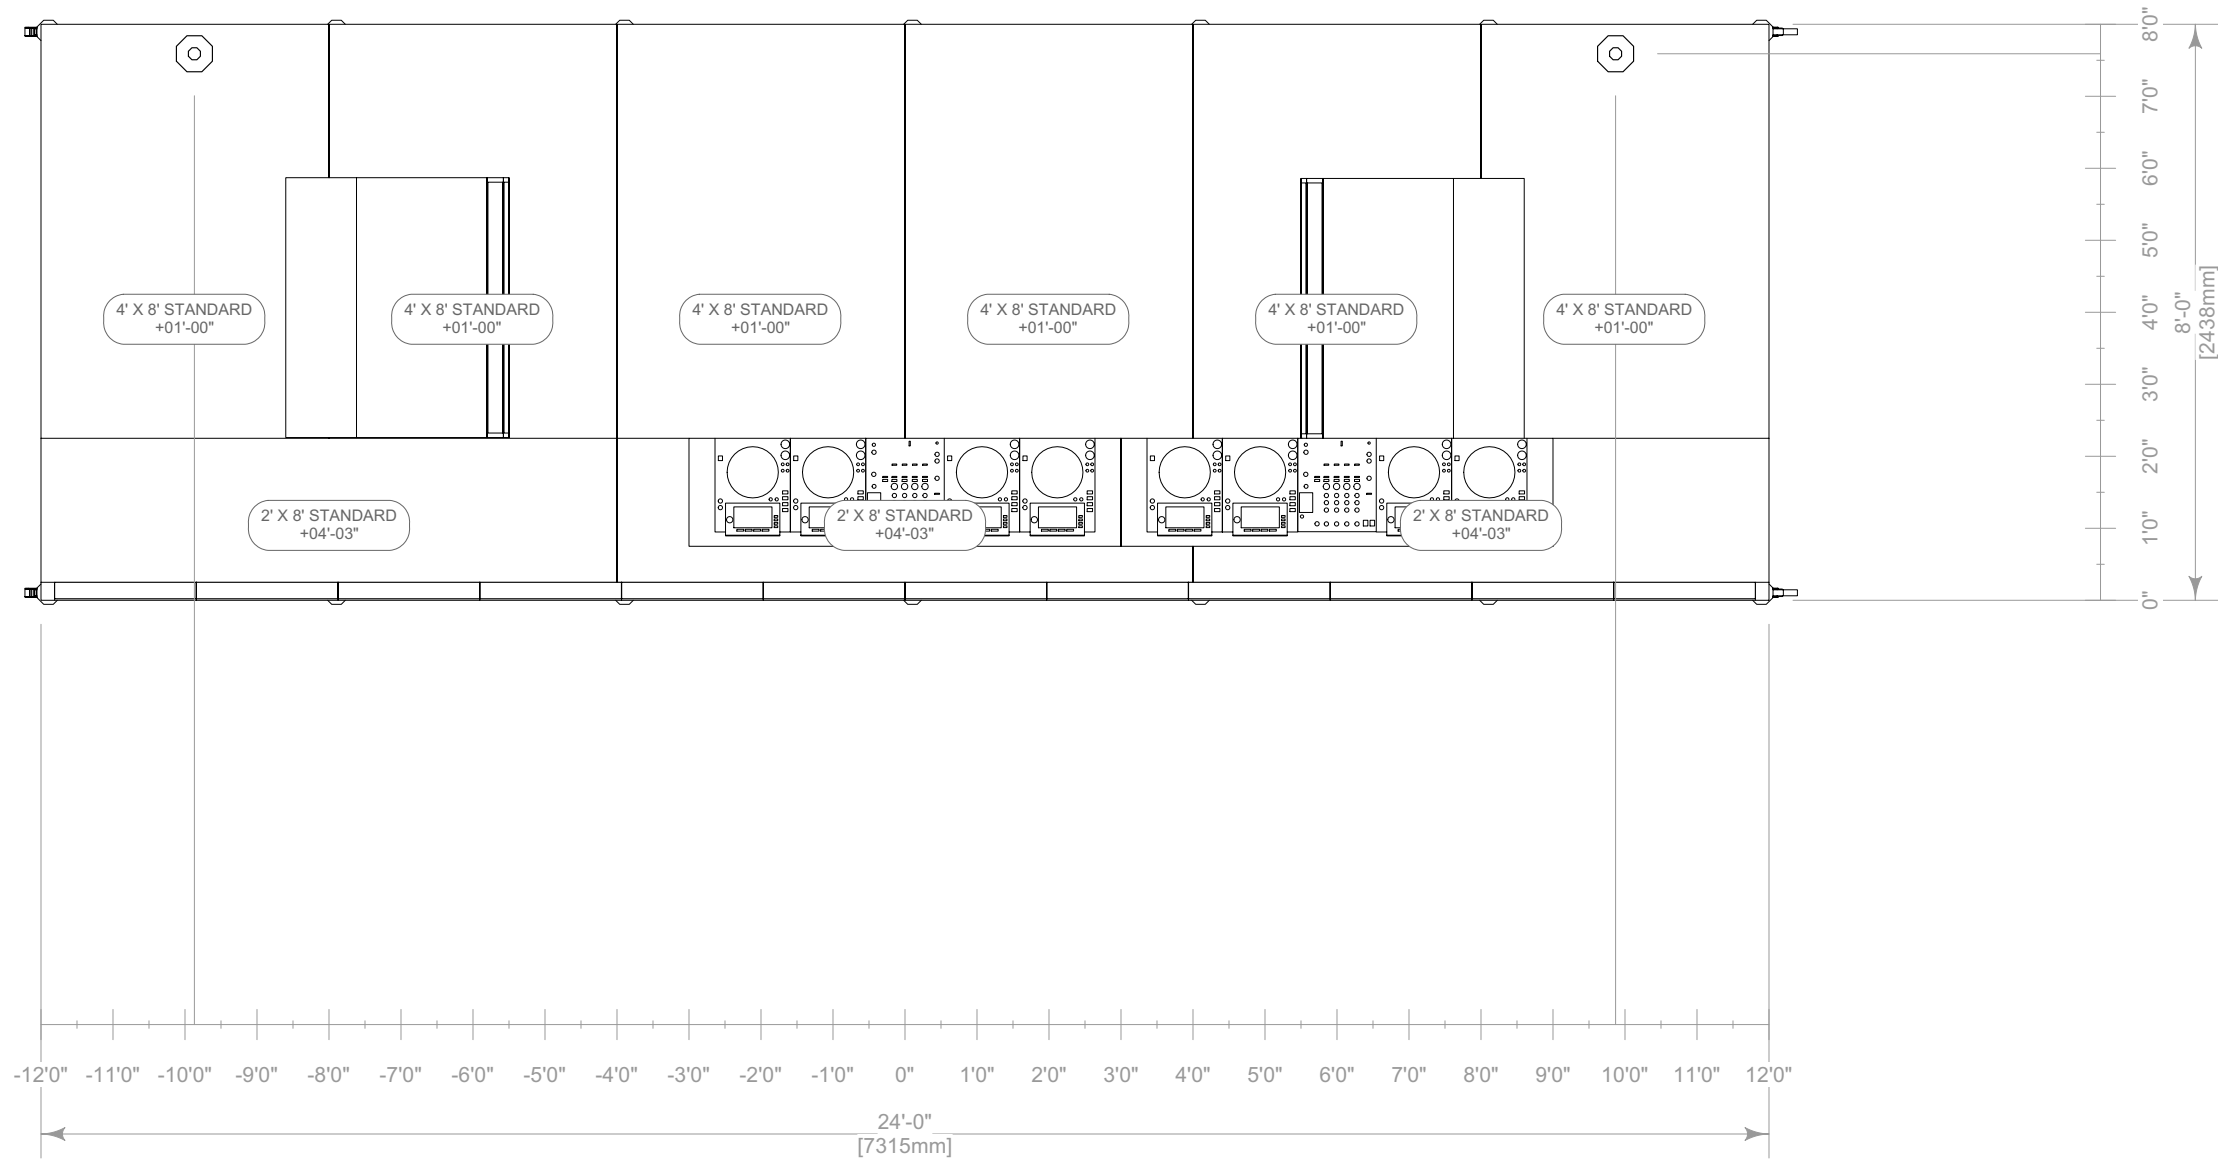

1 Saturday/Sunday DJ Booth Detail Top
Scale: 3/8" = 1'-0"

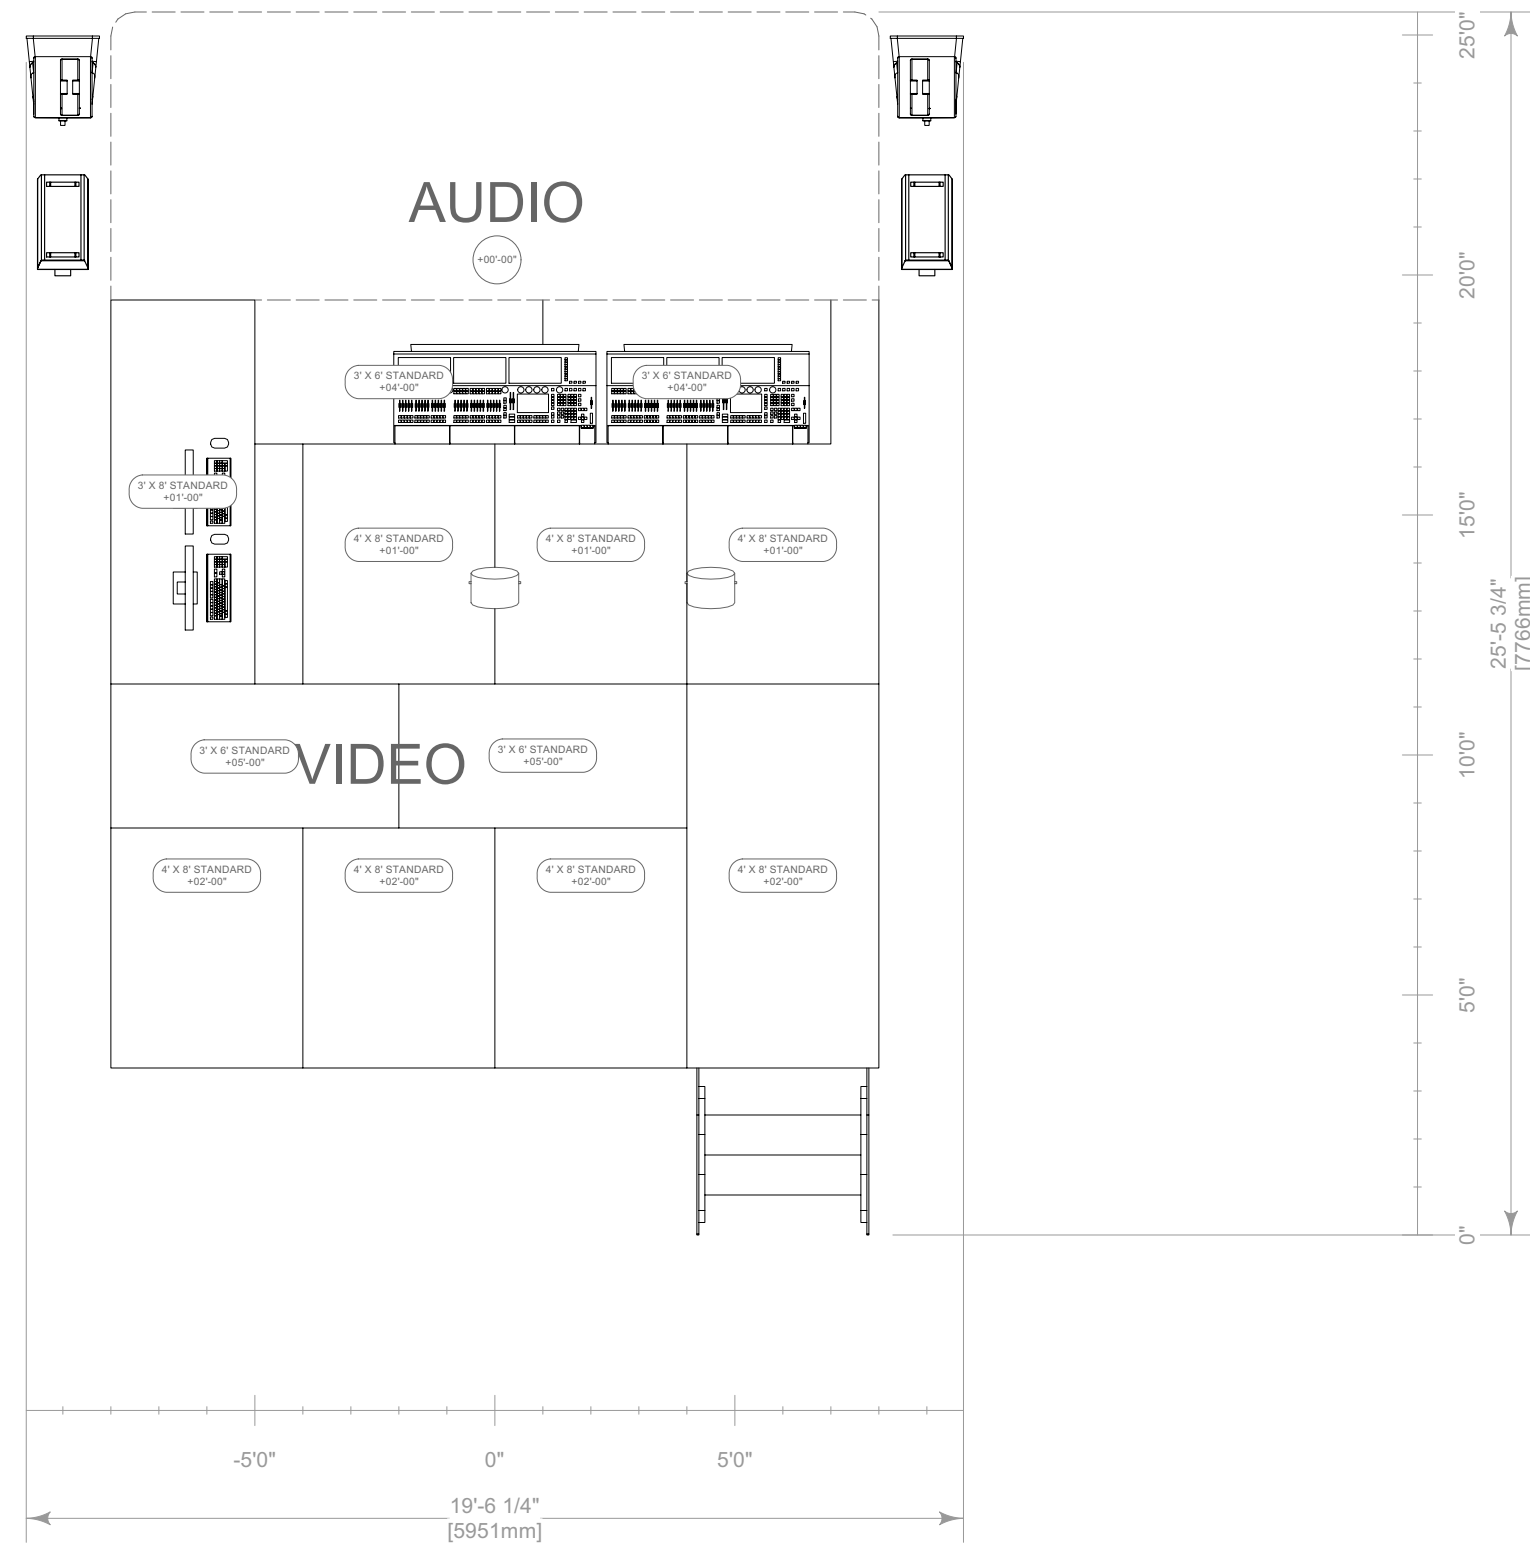

3 FOH Detail
Scale: 1/4" = 1'-0"

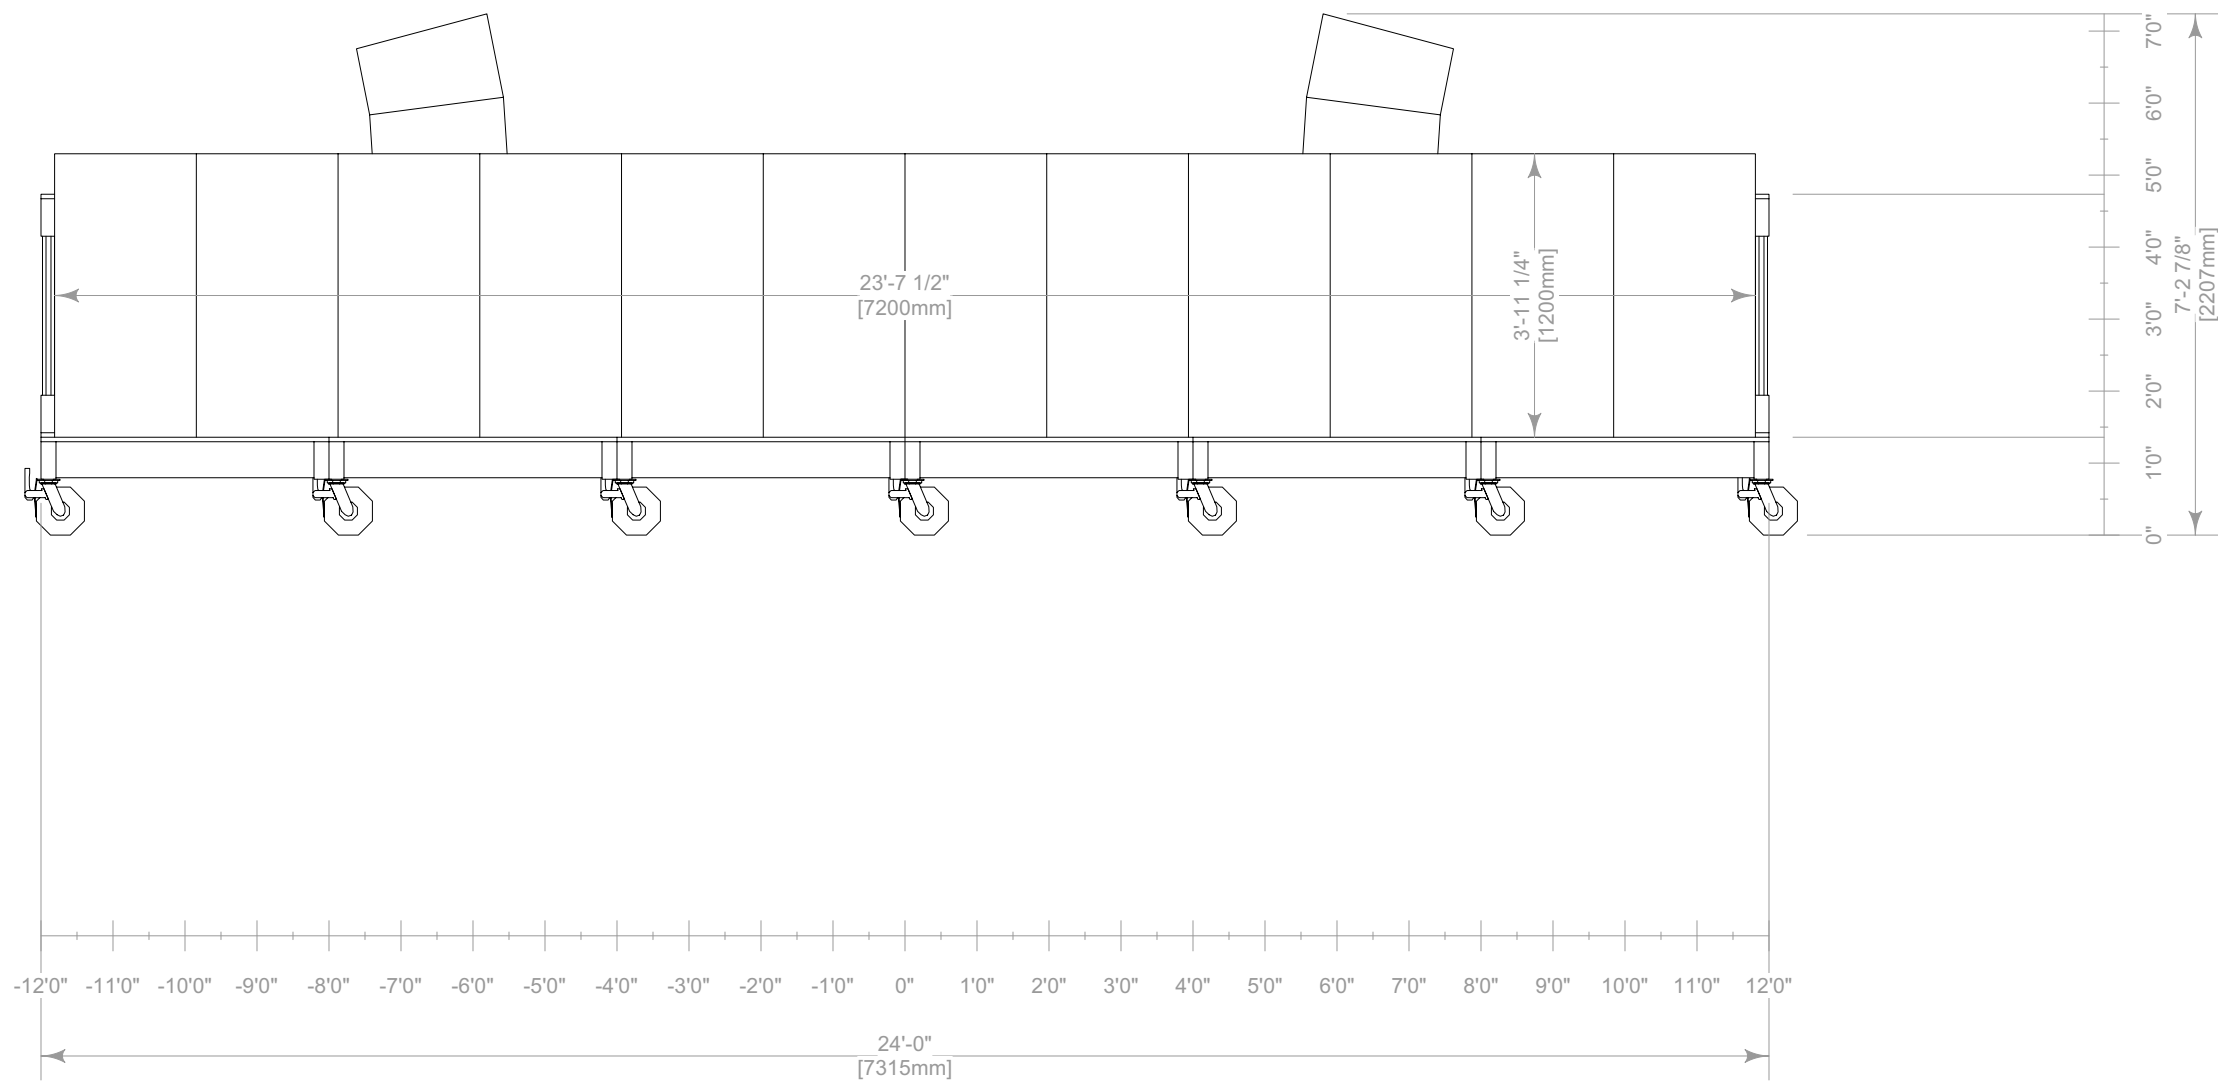

2 Saturday/Sunday DJ Booth Detail Front
Scale: 3/8" = 1'-0"

KEY TO SYMBOLS		
SUBSTITUTIONS ARE ACCEPTED UPON APPROVAL		
LIGHTING		
Thumbnail	Item	Qty
	Ayrton Perseo Beam - Standard (40ch)	132
	Chauvet Color Strike M - 13 Channel (13ch)	86
	Chauvet Maverick MK2 Wash - Single-Basic (20ch)	8
	Chauvet Strike Saber - 27 Channel (Dimmer Mode=Dimmer 1) (27ch)	61
	GLP Impression X4 Bar 20 - Single Pixel High Res (89ch)	28
	GLP JDC Line 1000 - MultiPix Advanced (316ch)	28
	Martin Scepton-1000mm - P3 - Pixel Map (10 Segments)/Square Smoked Lens (30ch)	481
	Robe MegaPointe - Mode 1 (39ch)	8
	SGM P-2 + Barn Doors - 5.2.0 (22ch)	4


VIDEO		
Thumbnail	Item	Qty
	600mm Triple Video Header (N/A)	6
	ROE CB8 600mmx1200mm (8.3mm)	396
	Video Tile-600mmx600mm (8mm)	204
	Video Tile-1200mmx1200mm (25mm Blow Through)	280

SFX		
Thumbnail	Item	Qty
	Blower Fan - N/A (0ch)	12
	Co2 Valve - N/A (0ch)	14
	Flame Head - N/A (0ch)	20
	Generic Laser - Beyond 5.0 Mid (32ch)	18
	Hazer - 2 Channel (2ch)	12
	Martin AF 1 DMX Fan - 5.2.0 (1ch)	4

CONTROL		
Thumbnail	Item	Qty
	Beyond Computer (Beyond 5.0 Ultimate)	1
	Generic Cooling/Heating Fan (https://a.co/d/hTWf56b)	2
	GrandMA2 Full-Size (3.9.60.37)	2
	Martin P3 Computer (Martin P3)	1

RIGGING		
Item	Qty	
2in Sched. 40 Pipe-03ft (Black)	12	
2in Sched. 40 Pipe-06ft (Black)	4	
12inx12in Box Truss-05ft (Black)	5	
12inx12in Box Truss-10ft (Black)	24	
12inx12in Box Truss-CB (Black)	10	
19inx19in Pipe Base (Black)	4	
20inx20in Box Truss-08ft (Black)	6	
20inx20in Box Truss-10ft (Black)	30	
30inx30in Truss Base (Black)	6	
Container Bracket - Bottom (Black)	12	
1 Beam-06ft (Black)	2	
1 Beam-20ft (Black)	4	
Tyler Truss GT-05ft		

TABLE OF CONTENTS	
Sheet Title	Page
Cover Page	1
Saturday/Sunday Rendering	2
Saturday/Sunday Plan	3
Saturday/Sunday Front Elevation/CL Section	4
Saturday/Sunday Deck Detail	5
Detail A	6
Detail B	7
Detail C,D,E,F	8
Detail G,N	9
Saturday/Sunday DJ Booth & FOH Detail	10
Friday Rendering	11
Friday Plan	12
Friday Front Elevation/CL Section	13
Friday Deck Detail	14

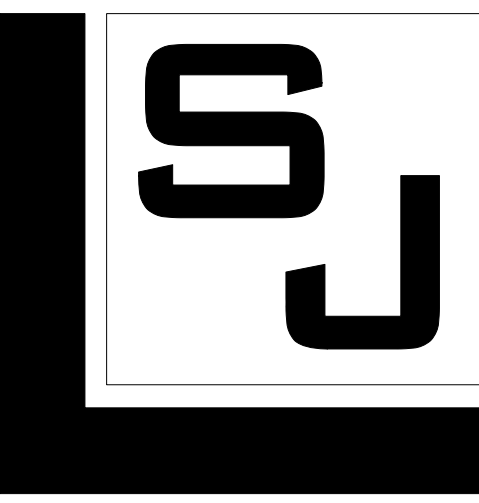

SJ LIGHTING, INC.
WESTLAKE VILLAGE, CA
818.874.9779
INFO@SJLIGHTING.NET
WWW.SJLIGHTING.NET

THE DESIGN AND ALL ASSOCIATED PAPERWORK IS COPYRIGHTED MATERIAL AND REMAINS THE PROPERTY OF THE DESIGNER.
THIS DESIGN IS FOR ONE TIME USE ONLY AT THE SPECIFIED LOCATION AND IS NOT TO BE USED FOR ANY OTHER PURPOSE OR EVENT WITHOUT SPECIFIC WRITTEN PERMISSION OF THE DESIGNER.
DESIGNER IS NOT A STRUCTURAL ENGINEER AND THESE DRAWINGS REPRESENT DESIGN CONCEPTS ONLY AND ARE NOT INTENDED AS ENGINEERING DRAWINGS. THE DESIGNER ASSUMES NO RESPONSIBILITY FOR THE SAFETY OR STRUCTURAL INTEGRITY OF ANY EQUIPMENT PROVIDED BY ANYONE.



REVISIONS

REV #	REMARKS	DATE	INT.
001	-Initial Design	4/6/2023	AHT
002	-Update Saturday Deck Detail	4/21/2023	AHT
003	-Update Friday DJ Booth	5/30/2023	AHT
004	-Add Detail M	7/6/2023	AHT
005	-Update Friday DJ Booth	7/19/2023	AHT
006	-Add Detail N		
007	-Update Detail A,B,C,D		
008	-Update Friday & Saturday DJ Booth		
	-Update Friday & Saturday Deck Detail		
	-Update Audio Hangs	8/3/2023	AHT
	-Update Deck Size	8/11/2023	AHT
	-Update Detail B	8/22/2023	AHT

AURIS PRESENTS

ARC MUSIC FESTIVAL

CHICAGO, IL

UNION PARK

SEPTEMBER 1-3, 2023

STAGE 1

ISSUE DATE

Wednesday, August 23, 2023

DRAWN BY

MTR
SUL


SCALE

SEE DRAWING
ARCH D (24"x36")



Saturday/Sunday DJ Booth & FOH Detail

DD

10 OF 20

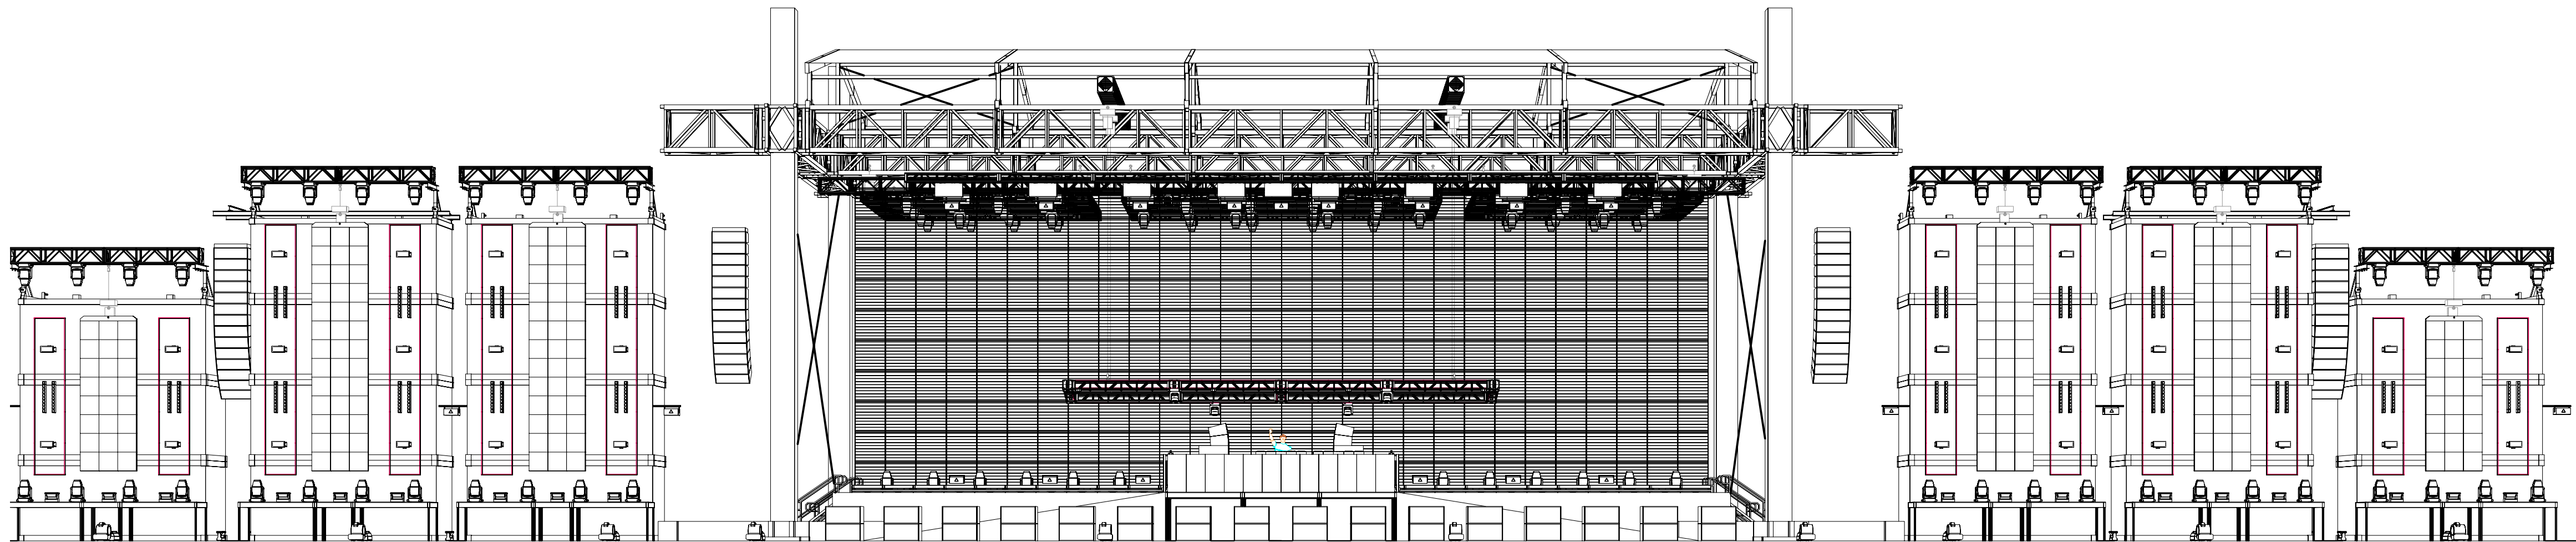

1 Front Perspective
Scale: 3/8" = 1'-0"

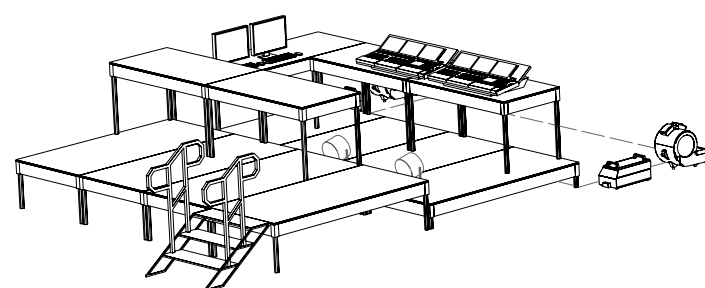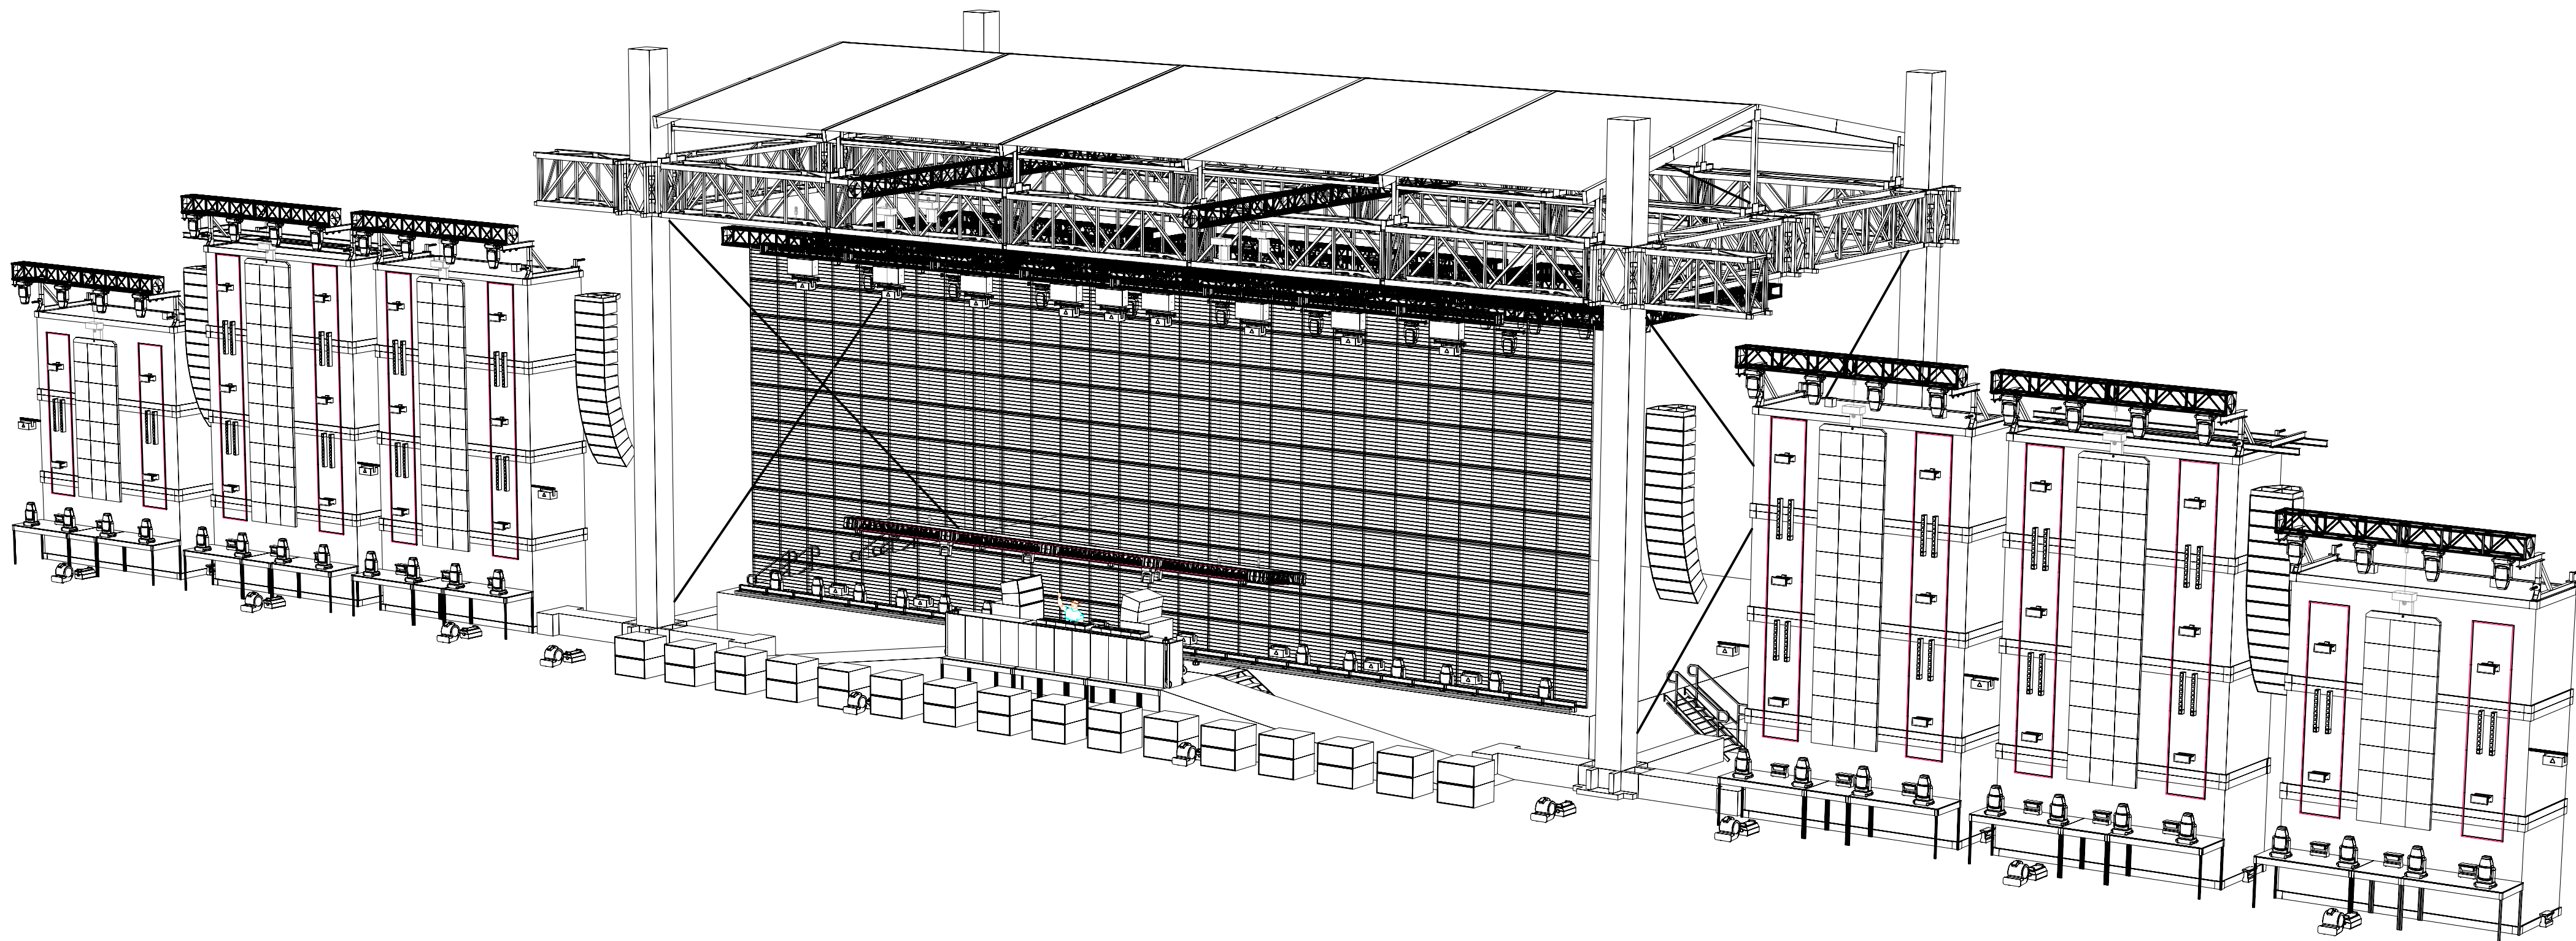

2 Isometric
Scale: 1/2" = 1'-0"

KEY TO SYMBOLS

SUBSTITUTIONS ARE ACCEPTED UPON APPROVAL

LIGHTING

Thumbnail	Item	Qty
	Ayrton Perseo Beam - Standard (40ch)	132
	Chauvet Color Strike M - 13 Channel (13ch)	86
	Chauvet Maverick MK2 Wash - Single-Basic (20ch)	8
	Chauvet Strike Saber - 27 Channel (Dimmer Mode=Dimmer 1) (27ch)	61
	GLP Impression X4 Bar 20 - Single Pixel High Res (89ch)	28
	GLP JDC Line 1000 - MultiPix Advanced (316ch)	28
	Martin Scepton-1000mm - P3 - Pixel Map (10 Segments)/Square Smoked Lens (30ch)	481
	Robe MegaPointe - Mode 1 (39ch)	8
	SGM P-2 + Barn Doors - 5.2.0 (22ch)	4

VIDEO

Thumbnail	Item	Qty
	600mm Triple Video Header (N/A)	6
	ROE CB8 600mmx1200mm (8.3mm)	396
	Video Tile-600mmx600mm (8mm)	204
	Video Tile-1200mmx1200mm (25mm Blow Through)	280

~762 M² Total

SFX

Thumbnail	Item	Qty
	Blower Fan - N/A (0ch)	12
	Co2 Valve - N/A (0ch)	14
	Flame Head - N/A (0ch)	20
	Generic Laser - Beyond 5.0 Mid (32ch)	18
	Hazer - 2 Channel (2ch)	12
	Martin AF 1 DMX Fan - 5.2.0 (1ch)	4

CONTROL


Thumbnail	Item	Qty
	Beyond Computer (Beyond 5.0 Ultimate)	1
	Generic Cooling/Heating Fan (https://a.co/d/hTWf56b)	2
	GrandMA2 Full-Size (3.9.60.37)	2
	Martin P3 Computer (Martin P3)	1

RIGGING

Item	Qty
2in Sched. 40 Pipe-03ft (Black)	12
2in Sched. 40 Pipe-06ft (Black)	4
12inx12in Box Truss-05ft (Black)	5
12inx12in Box Truss-10ft (Black)	24
12inx12in Box Truss-CB (Black)	10
19inx19in Pipe Base (Black)	4
20inx20in Box Truss-08ft (Black)	6
20inx20in Box Truss-10ft (Black)	30
30inx30in Truss Base (Black)	6
Container Bracket - Bottom (Black)	12
1 Beam-06ft (Black)	2
1 Beam-20ft (Black)	4
Tyler Truss GT-05ft	

TABLE OF CONTENTS

Sheet Title	Page
Cover Page	1
Saturday/Sunday Rendering	2
Saturday/Sunday Plan	3
Saturday/Sunday Front Elevation/CL Section	4
Saturday/Sunday Deck Detail	5
Detail A	6
Detail B	7
Detail C,D,E,F	8
Detail G,N	9
Saturday/Sunday DJ Booth & FOH Detail	10
Friday Rendering	11
Friday Plan	12
Friday Front Elevation/CL Section	13
Friday Deck Detail	14

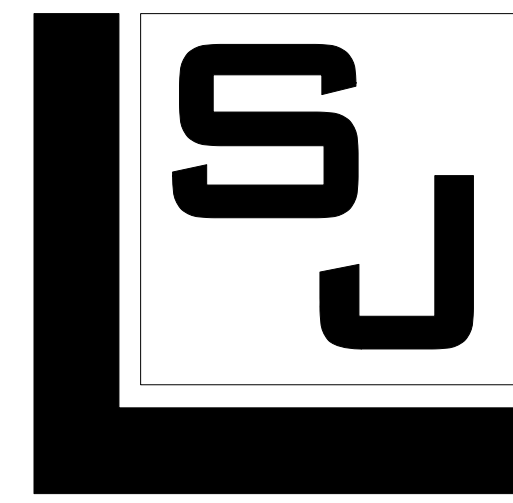

SJ LIGHTING, INC.
WESTLAKE VILLAGE, CA
818.874.9779
INFO@SJLIGHTING.NET
WWW.SJLIGHTING.NET

THE DESIGN AND ALL ASSOCIATED PAPERWORK IS COPYRIGHTED MATERIAL AND REMAINS THE PROPERTY OF THE DESIGNER.

THIS DESIGN IS FOR ONE TIME USE ONLY AT THE SPECIFIED LOCATION AND IS NOT TO BE USED FOR ANY OTHER PURPOSE OR EVENT WITHOUT SPECIFIC WRITTEN PERMISSION OF THE DESIGNER.

DESIGNER IS NOT A STRUCTURAL ENGINEER AND THESE DRAWINGS REPRESENT DESIGN CONCEPTS ONLY AND ARE NOT INTENDED AS ENGINEERING DRAWINGS. THE DESIGNER ASSUMES NO RESPONSIBILITY FOR THE SAFETY OR STRUCTURAL INTEGRITY OF ANY EQUIPMENT PROVIDED BY ANYONE.



REVISIONS

REV #	REMARKS	DATE	INT.
001	-Initial Design	4/6/2023	AHT
002	-Update Saturday Deck Detail	4/21/2023	AHT
003	-Update Friday DJ Booth	5/30/2023	AHT
004	-Add Detail M	7/6/2023	AHT
005	-Update Friday DJ Booth	7/19/2023	AHT
	-Add Detail N		
	-Update Detail A,B,C,D		
	-Update Friday & Saturday DJ Booth		
	-Update Friday & Saturday Deck Detail		
006	-Update Audio Hangs	8/3/2023	AHT
007	-Update Deck Size	8/11/2023	AHT
008	-Update Detail B	8/22/2023	AHT

AURIS PRESENTS

ARC MUSIC
FESTIVAL

CHICAGO, IL

UNION PARK

SEPTEMBER 1-3, 2023

STAGE 1

ISSUE DATE

Wednesday, August 23, 2023


DRAWN BY
MTR
S.J.L.

SCALE
SEE DRAWING
ARCH D (24"x36")

Friday Rendering

DD

11 OF 20

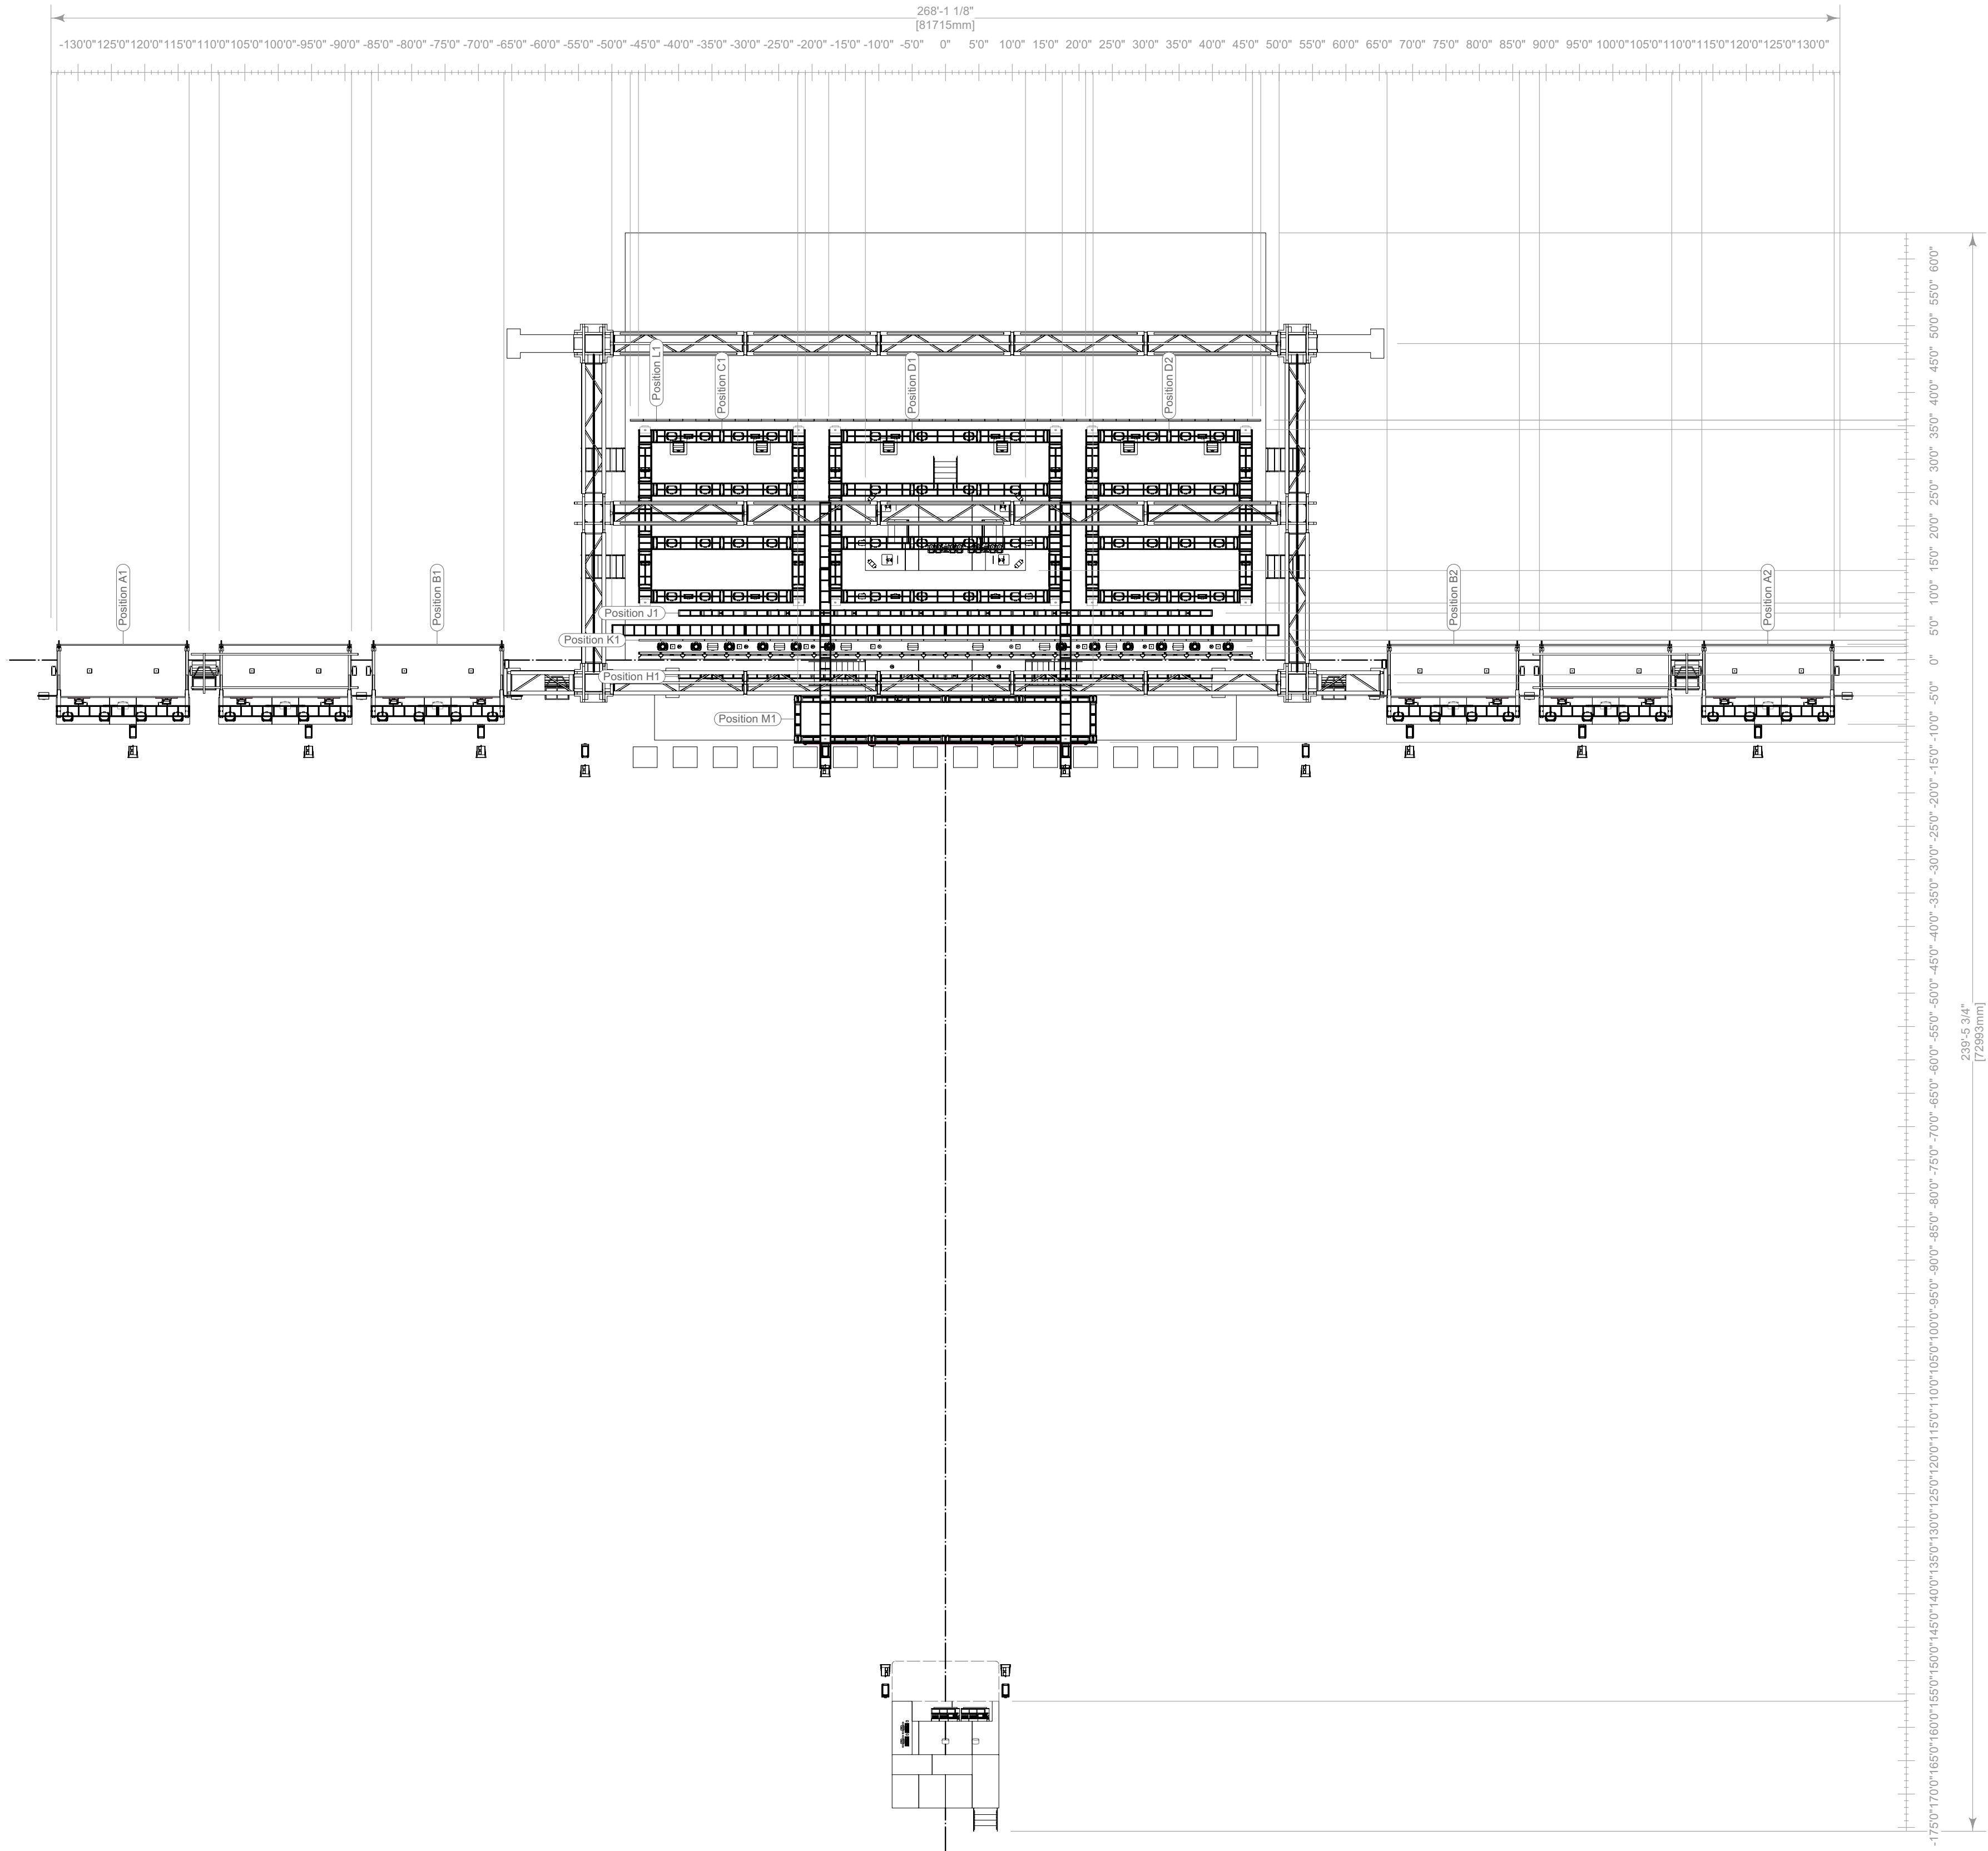

KEY TO SYMBOLS

LIGHTING

Thumbnail	Item	Qty
	Ayrton Perseo Beam - Standard (40ch)	132
	Chauvet Color Strike M - 13 Channel (13ch)	86
	Chauvet Maverick MK2 Wash - Single-Basic (20ch)	8
	Chauvet Strike Saber - 27 Channel (Dimmer Mode=Dimmer 1) (27ch)	61
	GLP Impression X4 Bar 20 - Single Pixel High Res (89ch)	28
	GLP JDC Line 1000 - MultiPix Advanced (316ch)	28
	Martin Scepton-1000mm - P3 - Pixel Map (10 Segments)/Square Smoked Lens (30ch)	481
	Robe MegaPointe - Mode 1 (39ch)	8
	SGM P-2 + Barn Doors - 5.2.0 (22ch)	4

VIDEO

Thumbnail	Item	Qty
	600mm Triple Video Header (N/A)	6
	ROE CB8 600mmx1200mm (8.3mm)	396
	Video Tile-600mmx600mm (8mm)	204
	Video Tile-1200mmx1200mm (25mm Blow Through)	280

~762 M² Total

SFX

Thumbnail	Item	Qty
	Blower Fan - N/A (0ch)	12
	Co2 Valve - N/A (0ch)	14
	Flame Head - N/A (0ch)	20
	Generic Laser - Beyond 5.0 Mid (32ch)	18
	Hazer - 2 Channel (2ch)	12
	Martin AF 1 DMX Fan - 5.2.0 (1ch)	4

CONTROL


Thumbnail	Item	Qty
	Beyond Computer (Beyond 5.0 Ultimate)	1
	Generic Cooling/Heating Fan (https://a.co/d/hTWf56b)	2
	GrandMA2 Full-Size (3.9.60.37)	2
	Martin P3 Computer (Martin P3)	1

RIGGING

Item	Qty
2in Sched. 40 Pipe-03ft (Black)	12
2in Sched. 40 Pipe-06ft (Black)	4
12inx12in Box Truss-05ft (Black)	5
12inx12in Box Truss-10ft (Black)	24
12inx12in Box Truss-CB (Black)	10
19inx19in Pipe Base (Black)	4
20inx20in Box Truss-08ft (Black)	6
20inx20in Box Truss-10ft (Black)	30
30inx30in Truss Base (Black)	6
Container Bracket - Bottom (Black)	12
I Beam-06ft (Black)	2
I Beam-20ft (Black)	4
Tyler Truss GT-05ft	

TABLE OF CONTENTS

Sheet Title	Page
Cover Page	1
Saturday/Sunday Rendering	2
Saturday/Sunday Plan	3
Saturday/Sunday Front Elevation/CL Section	4
Saturday/Sunday Deck Detail	5
Detail A	6
Detail B	7
Detail C, D, E, F	8
Detail G, N	9
Saturday/Sunday DJ Booth & FOH Detail	10
Friday Rendering	11
Friday Plan	12
Friday Front Elevation/CL Section	13
Friday Deck Detail	14

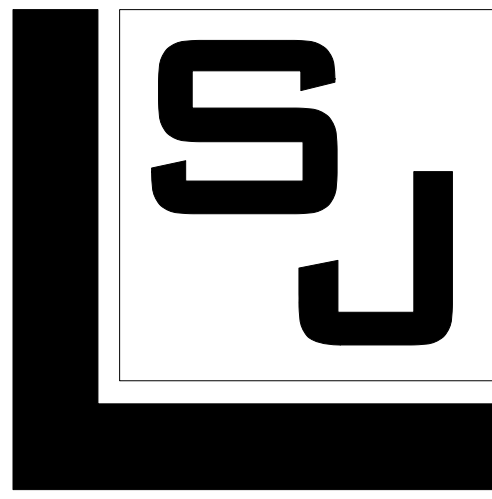

SJ LIGHTING, INC.
WESTLAKE VILLAGE, CA
818.874.9779
INFO@SJLIGHTING.NET
WWW.SJLIGHTING.NET

THE DESIGN AND ALL ASSOCIATED PAPERWORK IS COPYRIGHTED MATERIAL AND REMAINS THE PROPERTY OF THE DESIGNER.

THIS DESIGN IS FOR ONE TIME USE ONLY AT THE SPECIFIED LOCATION AND IS NOT TO BE USED FOR ANY OTHER PURPOSE OR EVENT WITHOUT SPECIFIC WRITTEN PERMISSION OF THE DESIGNER.

DESIGNER IS NOT A STRUCTURAL ENGINEER AND THESE DRAWINGS REPRESENT DESIGN CONCEPTS ONLY AND ARE NOT INTENDED AS ENGINEERING DRAWINGS. THE DESIGNER ASSUMES NO RESPONSIBILITY FOR THE SAFETY OR STRUCTURAL INTEGRITY OF ANY EQUIPMENT PROVIDED BY ANYONE.



REVISIONS

REV #	REMARKS	DATE	INT.
001	-Initial Design	4/6/2023	AHT
002	-Update Saturday Deck Detail	4/21/2023	AHT
003	-Update Friday DJ Booth	5/30/2023	AHT
004	-Add Detail M	7/6/2023	AHT
005	-Update Friday DJ Booth	7/19/2023	AHT
	-Add Detail N		
	-Update Detail A,B,C,D		
	-Update Friday & Saturday DJ Booth		
	-Update Friday & Saturday Deck Detail		
006	-Update Audio Hangs	8/3/2023	AHT
007	-Update Deck Size	8/11/2023	AHT
008	-Update Detail B	8/22/2023	AHT

AURIS PRESENTS

ARC MUSIC FESTIVAL

CHICAGO, IL

UNION PARK

SEPTEMBER 1-3, 2023

STAGE 1

ISSUE DATE

Wednesday, August 23, 2023

DRAWN BY

MTR
S.J.L.


SCALE

SEE DRAWING
ARCH D (24"x36")


Friday Plan

DD

12 OF 20

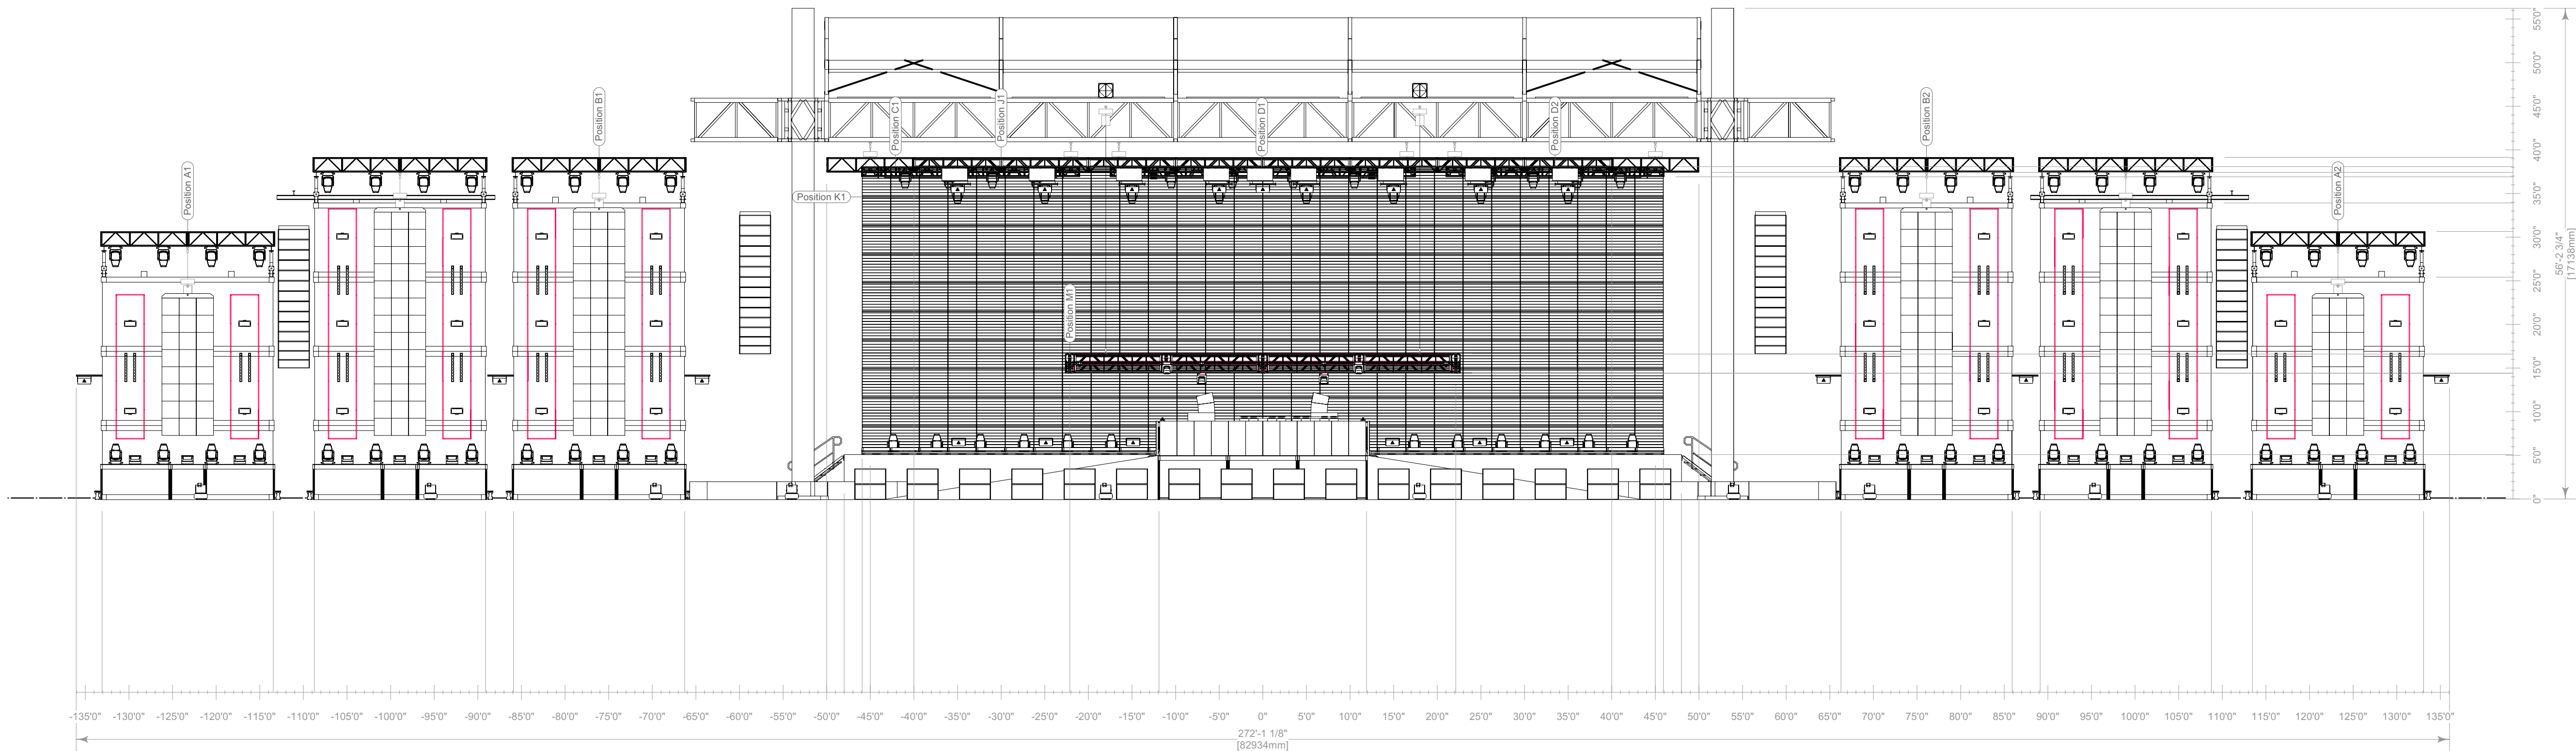

1 Front Elevation
Scale: 3/32" = 1'-0"

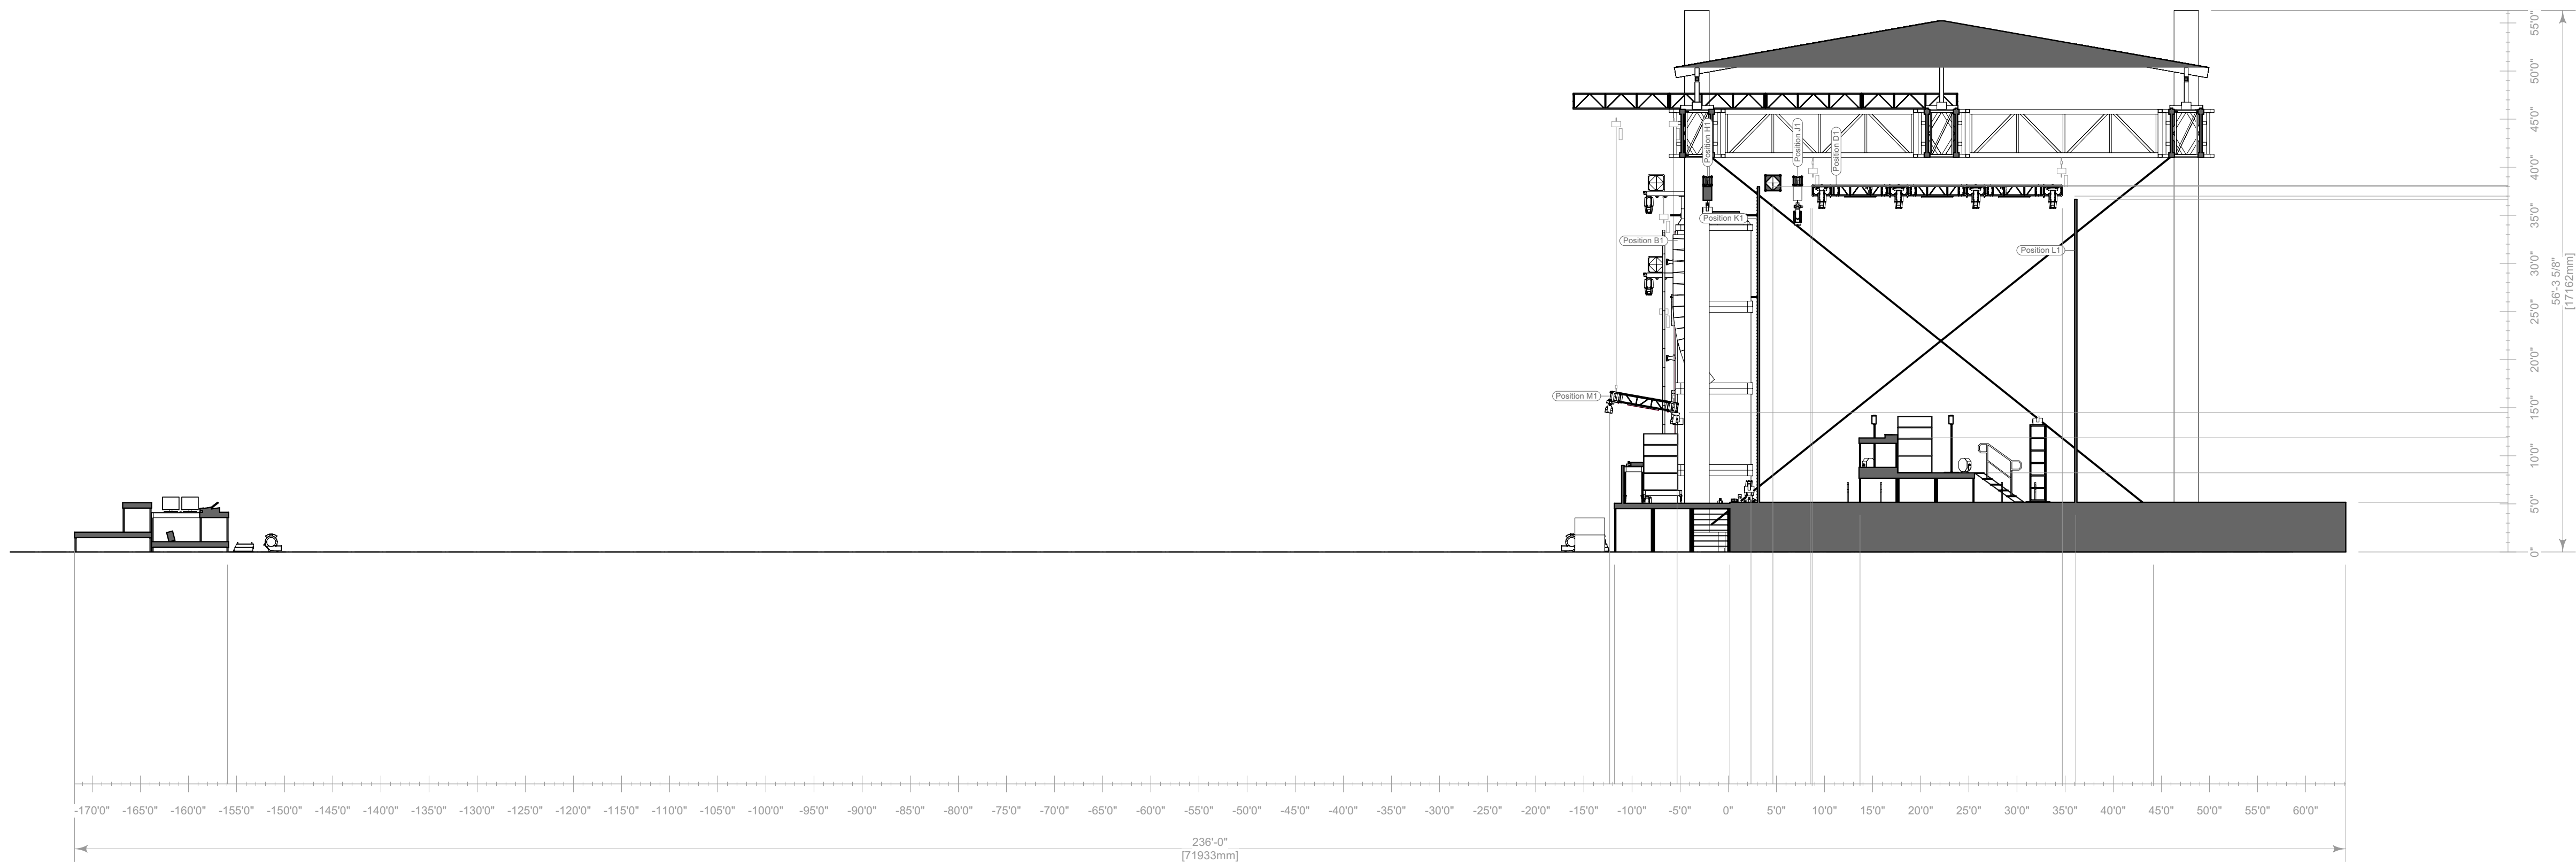

2 CL Section
Scale: 3/32" = 1'-0"

KEY TO SYMBOLS

SUBSTITUTIONS ARE ACCEPTED UPON APPROVAL

LIGHTING

Thumbnail	Item	Qty
	Ayrton Perseo Beam - Standard (40ch)	132
	Chauvet Color Strike M - 13 Channel (13ch)	86
	Chauvet Maverick MK2 Wash - Single-Basic (20ch)	8
	Chauvet Strike Saber - 27 Channel (Dimmer Mode=Dimmer 1) (27ch)	61
	GLP Impression X4 Bar 20 - Single Pixel High Res (89ch)	28
	GLP JDC Line 1000 - MultiPix Advanced (316ch)	28
	Martin Scepter-1000mm - P3 - Pixel Map (10 Segments)/Square Smoked Lens (30ch)	481
	Robe MegaPointe - Mode 1 (39ch)	8
	SGM P-2 + Barn Doors - 5.2.0 (22ch)	4

VIDEO

Thumbnail	Item	Qty
	600mm Triple Video Header (N/A)	6
	ROE CB8 600mmx1200mm (8.3mm)	396
	Video Tile-600mmx600mm (8mm)	204
	Video Tile-1200mmx1200mm (25mm Blow Through)	280

~762 M² Total

SFX

Thumbnail	Item	Qty
	Blower Fan - N/A (0ch)	12
	Co2 Valve - N/A (0ch)	14
	Flame Head - N/A (0ch)	20
	Generic Laser - Beyond 5.0 Mid (32ch)	18
	Hazer - 2 Channel (2ch)	12
	Martin AF 1 DMX Fan - 5.2.0 (1ch)	4

CONTROL


Thumbnail	Item	Qty
	Beyond Computer (Beyond 5.0 Ultimate)	1
	Generic Cooling/Heating Fan (https://a.co/d/hTWf56b)	2
	GrandMA2 Full-Size (3.9.60.37)	2
	Martin P3 Computer (Martin P3)	1

RIGGING

Item	Qty
2in Sched. 40 Pipe-03ft (Black)	12
2in Sched. 40 Pipe-06ft (Black)	4
12inx12in Box Truss-05ft (Black)	5
12inx12in Box Truss-10ft (Black)	24
12inx12in Box Truss-CB (Black)	10
19inx19in Pipe Base (Black)	4
20inx20in Box Truss-08ft (Black)	6
20inx20in Box Truss-10ft (Black)	30
30inx30in Truss Base (Black)	6
Container Bracket - Bottom (Black)	12
1 Beam-06ft (Black)	2
1 Beam-20ft (Black)	4
Tyler Truss CT-05ft	

TABLE OF CONTENTS

Sheet Title	Page
Cover Page	1
Saturday/Sunday Rendering	2
Saturday/Sunday Plan	3
Saturday/Sunday Front Elevation/CL Section	4
Saturday/Sunday Deck Detail	5
Detail A	6
Detail B	7
Detail C,D,E,F	8
Detail G,N	9
Saturday/Sunday DJ Booth & FOH Detail	10
Friday Rendering	11
Friday Plan	12
Friday Front Elevation/CL Section	13
Friday Deck Detail	14

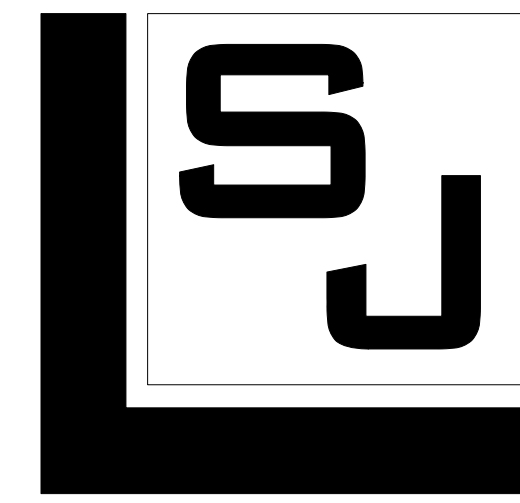

SJ LIGHTING, INC.
WESTLAKE VILLAGE, CA
818.874.9779
INFO@SJLIGHTING.NET
WWW.SJLIGHTING.NET

THE DESIGN AND ALL ASSOCIATED PAPERWORK IS COPYRIGHTED MATERIAL AND REMAINS THE PROPERTY OF THE DESIGNER.
THIS DESIGN IS FOR ONE TIME USE ONLY AT THE SPECIFIED LOCATION AND IS NOT TO BE USED FOR ANY OTHER PURPOSE OR EVENT WITHOUT SPECIFIC WRITTEN PERMISSION OF THE DESIGNER.
DESIGNER IS NOT A STRUCTURAL ENGINEER AND THESE DRAWINGS REPRESENT DESIGN CONCEPTS ONLY AND ARE NOT INTENDED AS ENGINEERING DRAWINGS. THE DESIGNER ASSUMES NO RESPONSIBILITY FOR THE SAFETY OR STRUCTURAL INTEGRITY OF ANY EQUIPMENT PROVIDED BY ANYONE.



REVISIONS

REV #	REMARKS	DATE	INT.
001	-Initial Design	4/6/2023	AHT
002	-Update Saturday Deck Detail	4/21/2023	AHT
003	-Update Friday DJ Booth	5/30/2023	AHT
004	-Add Detail M	7/6/2023	AHT
005	-Update Friday DJ Booth	7/19/2023	AHT
	-Add Detail N		
	-Update Detail A,B,C,D		
	-Update Friday & Saturday DJ Booth		
	-Update Friday & Saturday Deck Detail		
006	-Update Audio Hangs	8/3/2023	AHT
007	-Update Deck Size	8/11/2023	AHT
008	-Update Detail B	8/22/2023	AHT

AURIS PRESENTS

ARC MUSIC FESTIVAL

CHICAGO, IL

UNION PARK

SEPTEMBER 1-3, 2023

STAGE 1

ISSUE DATE

Wednesday, August 23, 2023


DRAWN BY
MTR
S.J.L.

SCALE
SEE DRAWING
ARCH D (24"x36")

Friday Front Elevation/CL Section

DD

13 OF 20

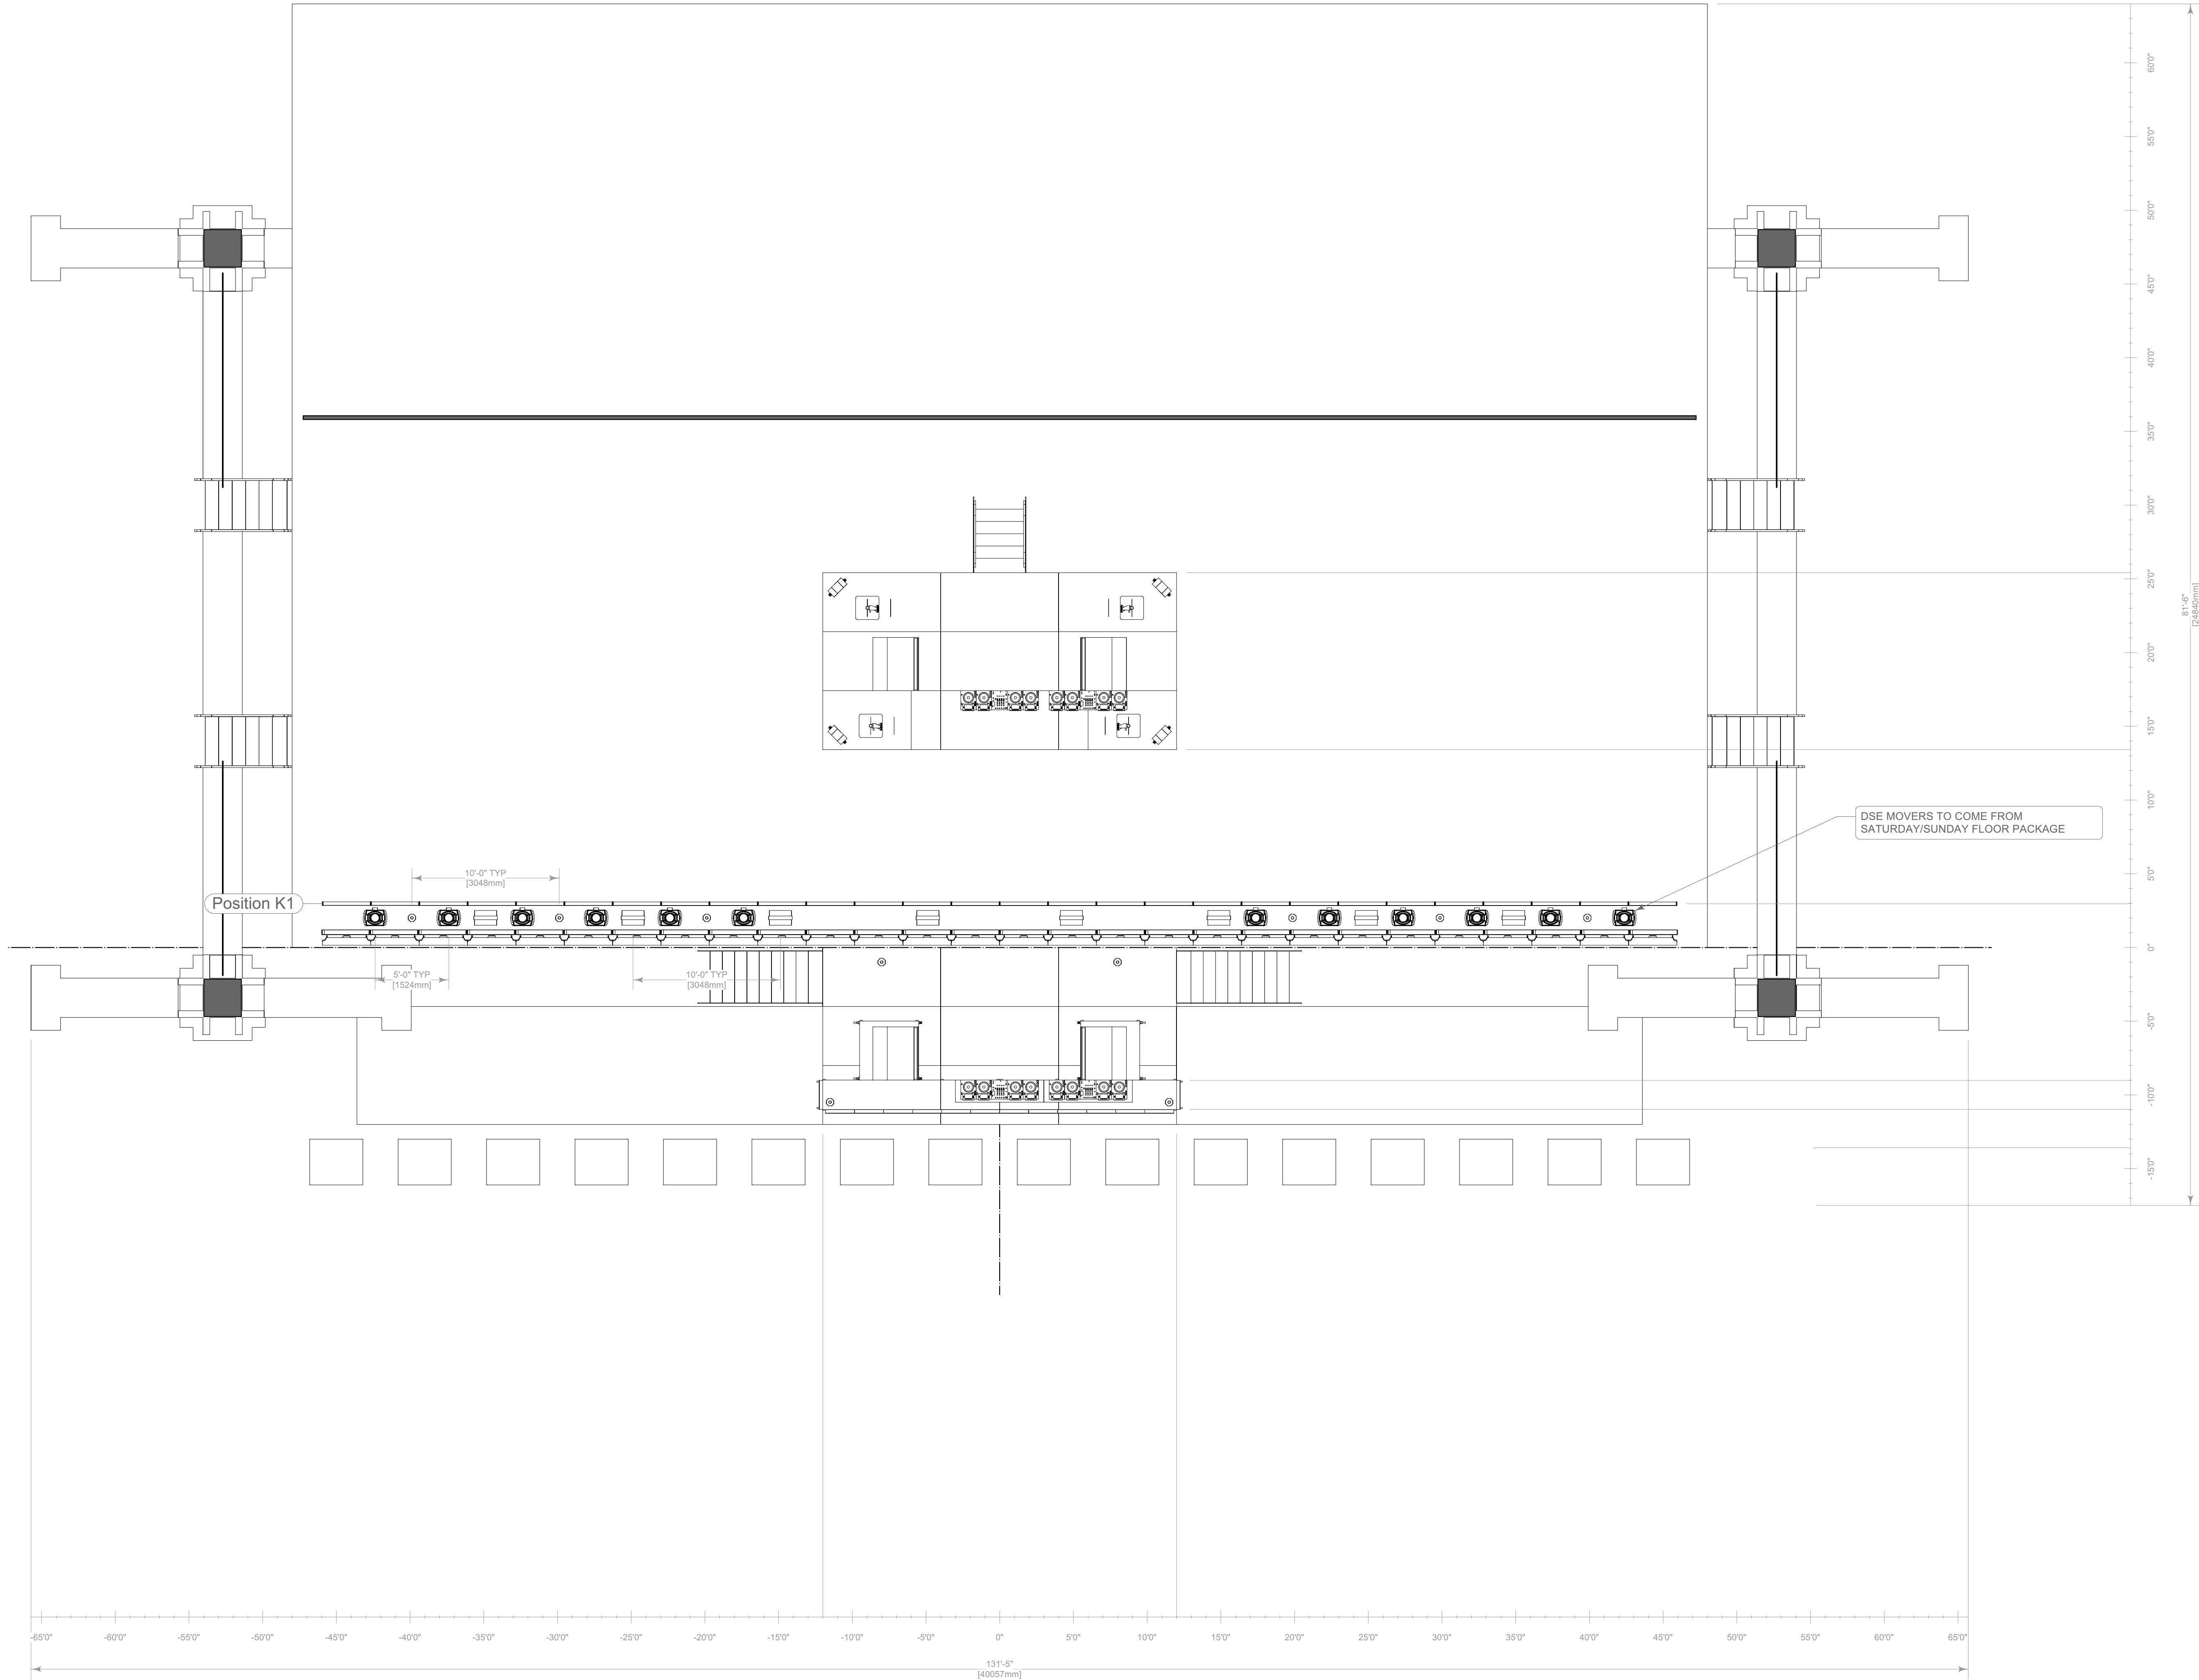

1 Deck Detail
Scale: 3/16" = 1'-0"

KEY TO SYMBOLS

SUBSTITUTIONS ARE ACCEPTED UPON APPROVAL

LIGHTING

Thumbnail	Item	Qty
	Ayrton Perseo Beam - Standard (40ch)	132
	Chauvet Color Strike M - 13 Channel (13ch)	86
	Chauvet Maverick MK2 Wash - Single-Basic (20ch)	8
	Chauvet Strike Saber - 27 Channel (Dimmer Mode=Dimmer 1) (27ch)	61
	GLP Impression X4 Bar 20 - Single Pixel High Res (89ch)	28
	GLP JDC Line 1000 - MultiPix Advanced (316ch)	28
	Martin Scepton-1000mm - P3 - Pixel Map (10 Segments)/Square Smoked Lens (30ch)	481
	Robe MegaPointe - Mode 1 (39ch)	8
	SGM P-2 + Barn Doors - 5.2.0 (22ch)	4

Thumbnail	Item	Qty
	600mm Triple Video Header (N/A)	6
	ROE CB8 600mmx1200mm (8.3mm)	396
	Video Tile-600mmx600mm (8mm)	204
	Video Tile-1200mmx1200mm (25mm Blow Through)	280

~762 M² Total

Thumbnail	Item	Qty
	Blower Fan - N/A (0ch)	12
	Co2 Valve - N/A (0ch)	14
	Flame Head - N/A (0ch)	20
	Generic Laser - Beyond 5.0 Mid (32ch)	18
	Hazer - 2 Channel (2ch)	12
	Martin AF 1 DMX Fan - 5.2.0 (1ch)	4

CONTROL

Thumbnail	Item	Qty
	Beyond Computer (Beyond 5.0 Ultimate)	1
	Generic Cooling/Heating Fan (https://a.co/d/hTWf56b)	2
	GrandMA2 Full-Size (3.9.60.37)	2
	Martin P3 Computer (Martin P3)	1

RIGGING

Item	Qty
2in Sched. 40 Pipe-03ft (Black)	12
2in Sched. 40 Pipe-06ft (Black)	4
12inx12in Box Truss-05ft (Black)	5
12inx12in Box Truss-10ft (Black)	24
12inx12in Box Truss-CB (Black)	10
19inx19in Pipe Base (Black)	4
20inx20in Box Truss-08ft (Black)	6
20inx20in Box Truss-10ft (Black)	30
30inx30in Truss Base (Black)	6
Container Bracket - Bottom (Black)	12
I Beam-06ft (Black)	2
I Beam-20ft (Black)	4
Tyler Truss GT-05ft	

TABLE OF CONTENTS

Sheet Title	Page
Cover Page	1
Saturday/Sunday Rendering	2
Saturday/Sunday Plan	3
Saturday/Sunday Front Elevation/CL Section	4
Saturday/Sunday Deck Detail	5
Detail A	6
Detail B	7
Detail C, D, E, F	8
Detail G, N	9
Saturday/Sunday DJ Booth & FOH Detail	10
Friday Rendering	11
Friday Plan	12
Friday Front Elevation/CL Section	13
Friday Deck Detail	14



SJ LIGHTING, INC.
WESTLAKE VILLAGE, CA
818.874.9779
INFO@SJLIGHTING.NET
WWW.SJLIGHTING.NET

THE DESIGN AND ALL ASSOCIATED PAPERWORK IS COPYRIGHTED MATERIAL AND REMAINS THE PROPERTY OF THE DESIGNER.

THIS DESIGN IS FOR ONE TIME USE ONLY AT THE SPECIFIED LOCATION AND IS NOT TO BE USED FOR ANY OTHER PURPOSE OR EVENT WITHOUT SPECIFIC WRITTEN PERMISSION OF THE DESIGNER.

DESIGNER IS NOT A STRUCTURAL ENGINEER AND THESE DRAWINGS REPRESENT DESIGN CONCEPTS ONLY AND ARE NOT INTENDED AS ENGINEERING DRAWINGS. THE DESIGNER ASSUMES NO RESPONSIBILITY FOR THE SAFETY OR STRUCTURAL INTEGRITY OF ANY EQUIPMENT PROVIDED BY ANYONE.



REVISIONS

REV #	REMARKS	DATE	INT.
001	-Initial Design	4/6/2023	AHT
002	-Update Saturday Deck Detail	4/21/2023	AHT
003	-Update Friday DJ Booth	5/30/2023	AHT
004	-Add Detail M	7/6/2023	AHT
005	-Update Friday DJ Booth	7/19/2023	AHT
006	-Add Detail N		
007	-Update Detail A,B,C,D		
008	-Update Friday & Saturday DJ Booth		
	-Update Friday & Saturday Deck Detail		
	-Update Audio Hangs	8/3/2023	AHT
	-Update Deck Size	8/11/2023	AHT
	-Update Detail B	8/22/2023	AHT

AURIS PRESENTS

ARC MUSIC FESTIVAL

CHICAGO, IL

UNION PARK

SEPTEMBER 1-3, 2023

STAGE 1

ISSUE DATE

Wednesday, August 23, 2023

DRAWN BY

MTR
S.J.L.


SCALE

SEE DRAWING
ARCH D (24"x36")


Friday Deck Detail

DD

14 OF 20

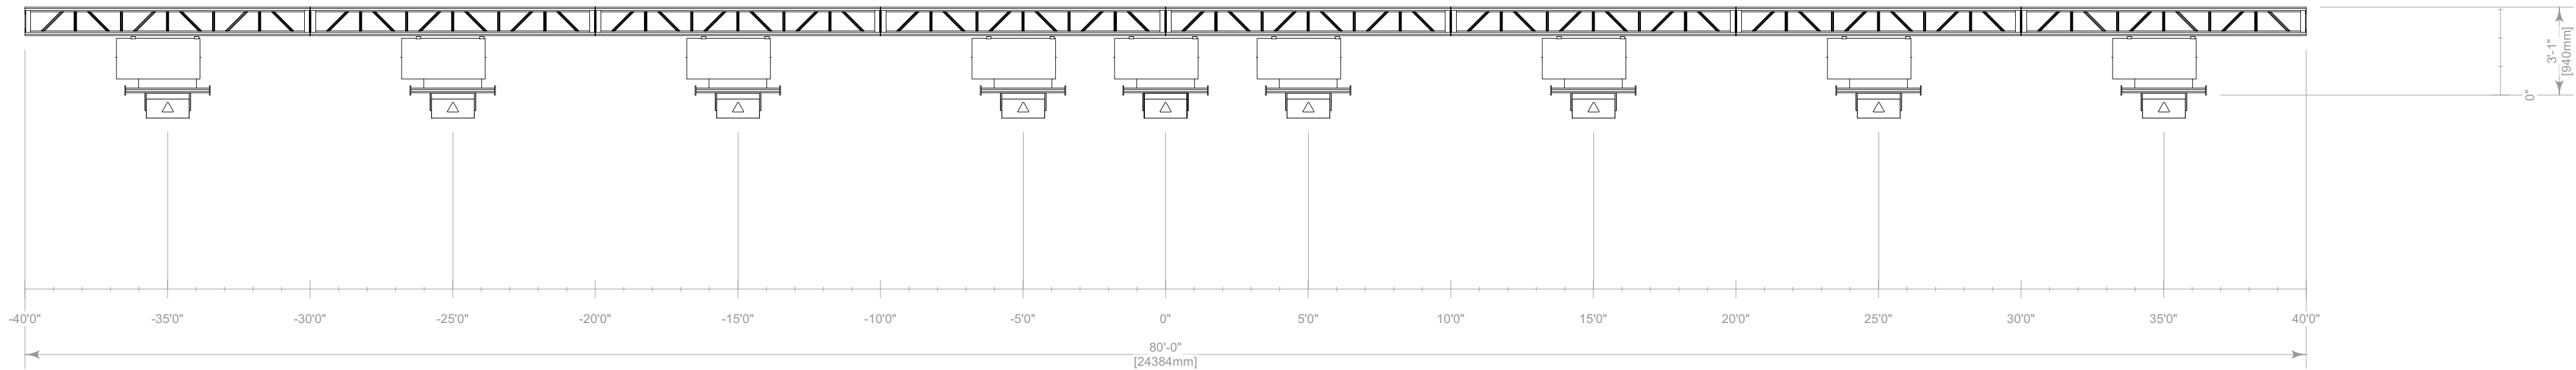

1 Detail H
Scale: 1/4" = 1'-0"

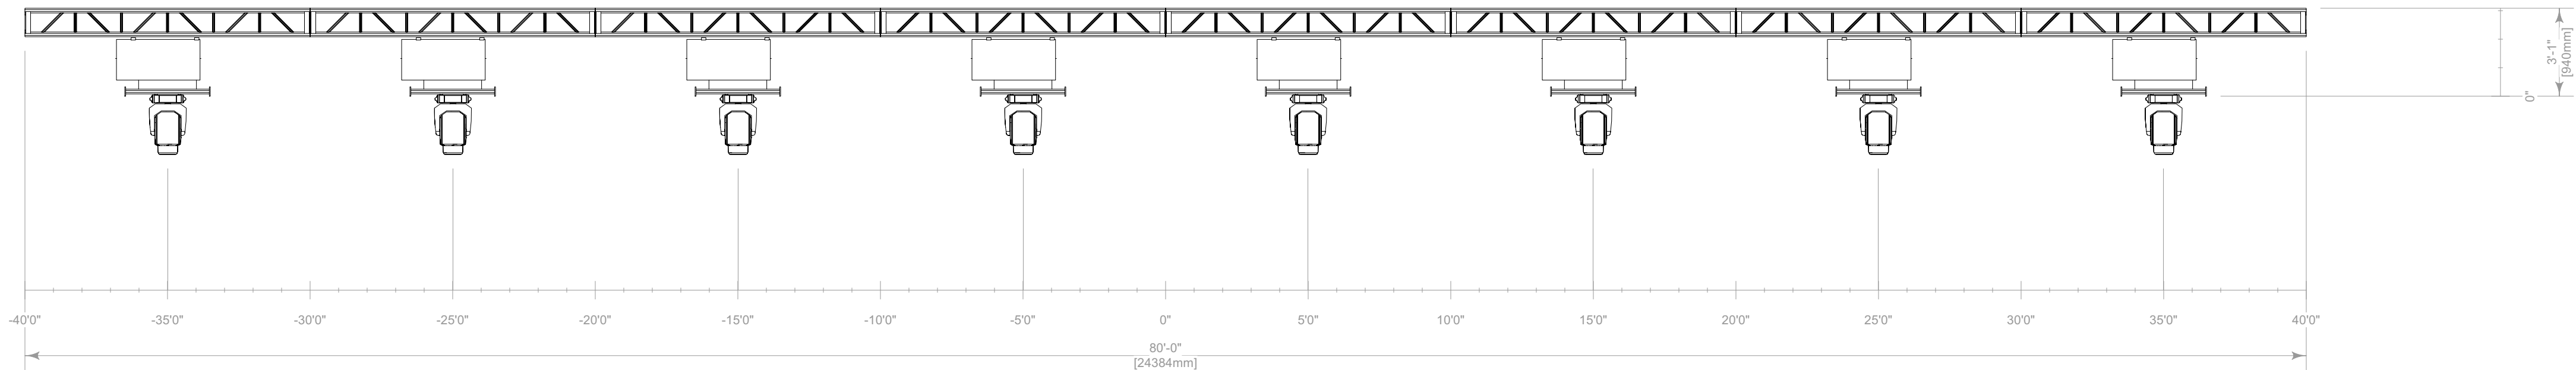

2 Detail J
Scale: 1/4" = 1'-0"

KEY TO SYMBOLS

SUBSTITUTIONS ARE ACCEPTED UPON APPROVAL

LIGHTING

Thumbnail	Item	Qty
	Ayrton Perseo Beam - Standard (40ch)	132
	Chauvet Color Strike M - 13 Channel (13ch)	86
	Chauvet Maverick Single-Basic (20ch)	8
	Chauvet Strike Saber - 27 Channel (Dimmer Mode=Dimmer 1) (27ch)	61
	GLP Impression X4 Bar 20 - Single Pixel High Res (89ch)	28
	GLP JDC Line 1000 - MultiPix Advanced (316ch)	28
	Martin Scepton-1000mm - P3 - Pixel Map (10 Segments)/Square Smoked Lens (30ch)	481
	Robe MegaPointe - Mode 1 (39ch)	8
	SGM P-2 + Barn Doors - 5.2.0 (22ch)	4

VIDEO

Thumbnail	Item	Qty
	600mm Triple Video Header (N/A)	6
	ROE CB8 600mmx 1200mm (8.3mm)	396
	Video Tile-600mmx600mm (8mm)	204
	Video Tile-1200mmx1200mm (25mm Blow Through)	280

~762 M² Total

SFX

Thumbnail	Item	Qty
	Blower Fan - N/A (0ch)	12
	Co2 Valve - N/A (0ch)	14
	Flame Head - N/A (0ch)	20
	Generic Laser - Beyond 5.0 Mid (32ch)	18
	Hazer - 2 Channel (2ch)	12
	Martin AF 1 DMX Fan - 5.2.0 (1ch)	4

CONTROL


Thumbnail	Item	Qty
	Beyond Computer (Beyond 5.0 Ultimate)	1
	Generic Cooling/Heating Fan (https://a.co/d/hTWf56b)	2
	GrandMA2 Full-Size (3.9.60.37)	2
	Martin P3 Computer (Martin P3)	1

RIGGING

Item	Qty
2in Sched. 40 Pipe-03ft (Black)	12
2in Sched. 40 Pipe-06ft (Black)	4
12inx12in Box Truss-05ft (Black)	5
12inx12in Box Truss-10ft (Black)	24
12inx12in Box Truss-CB (Black)	10
19inx19in Pipe Base (Black)	4
20inx20in Box Truss-08ft (Black)	6
20inx20in Box Truss-10ft (Black)	30
30inx30in Truss Base (Black)	6
Container Bracket - Bottom (Black)	12
I Beam-06ft (Black)	2
I Beam-20ft (Black)	4
Tyler Truss CT-05ft	1

TABLE OF CONTENTS

Sheet Title	Page
Cover Page	1
Saturday/Sunday Rendering	2
Saturday/Sunday Plan	3
Saturday/Sunday Front Elevation/CL Section	4
Saturday/Sunday Deck Detail	5
Detail A	6
Detail B	7
Detail C,D,E,F	8
Detail G,N	9
Saturday/Sunday DJ Booth & FOH Detail	10
Friday Rendering	11
Friday Plan	12
Friday Front Elevation/CL Section	13
Friday Deck Detail	14

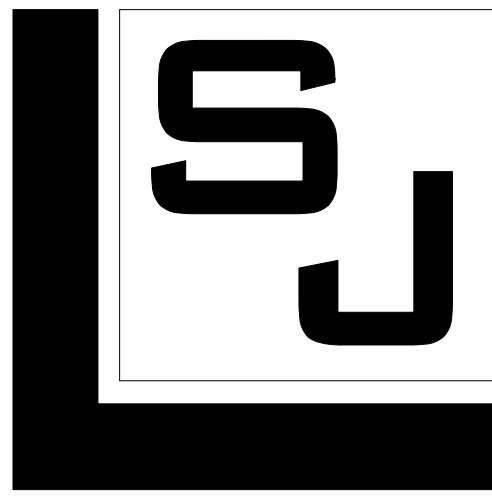

SJ LIGHTING, INC.
WESTLAKE VILLAGE, CA
818.874.9779
INFO@SJLIGHTING.NET
WWW.SJLIGHTING.NET

THE DESIGN AND ALL ASSOCIATED PAPERWORK IS COPYRIGHTED MATERIAL AND REMAINS THE PROPERTY OF THE DESIGNER.
THIS DESIGN IS FOR ONE TIME USE ONLY AT THE SPECIFIED LOCATION AND IS NOT TO BE USED FOR ANY OTHER PURPOSE OR EVENT WITHOUT SPECIFIC WRITTEN PERMISSION OF THE DESIGNER.
DESIGNER IS NOT A STRUCTURAL ENGINEER AND THESE DRAWINGS REPRESENT DESIGN CONCEPTS ONLY AND ARE NOT INTENDED AS ENGINEERING DRAWINGS. THE DESIGNER ASSUMES NO RESPONSIBILITY FOR THE SAFETY OR STRUCTURAL INTEGRITY OF ANY EQUIPMENT PROVIDED BY ANYONE.



REVISIONS

REV #	REMARKS	DATE	INT.
001	-Initial Design	4/6/2023	AHT
002	-Update Saturday Deck Detail	4/21/2023	AHT
003	-Update Friday DJ Booth	5/30/2023	AHT
004	-Add Detail M	7/6/2023	AHT
005	-Update Friday DJ Booth	7/19/2023	AHT
006	-Add Detail N	7/19/2023	AHT
007	-Update Detail A,B,C,D	8/3/2023	AHT
008	-Update Friday & Saturday DJ Booth	8/11/2023	AHT
	-Update Audio Hangs	8/22/2023	AHT
	-Update Deck Size		
	-Update Detail B		
	-Update Detail A,B		

AURIS PRESENTS

ARC MUSIC FESTIVAL

CHICAGO, IL

UNION PARK

SEPTEMBER 1-3, 2023

STAGE 1

ISSUE DATE

Wednesday, August 23, 2023

DRAWN BY

MTR
S.J.L.


SCALE

SEE DRAWING
ARCH D (24"x36")


Detail H,J

DD

15 OF 20

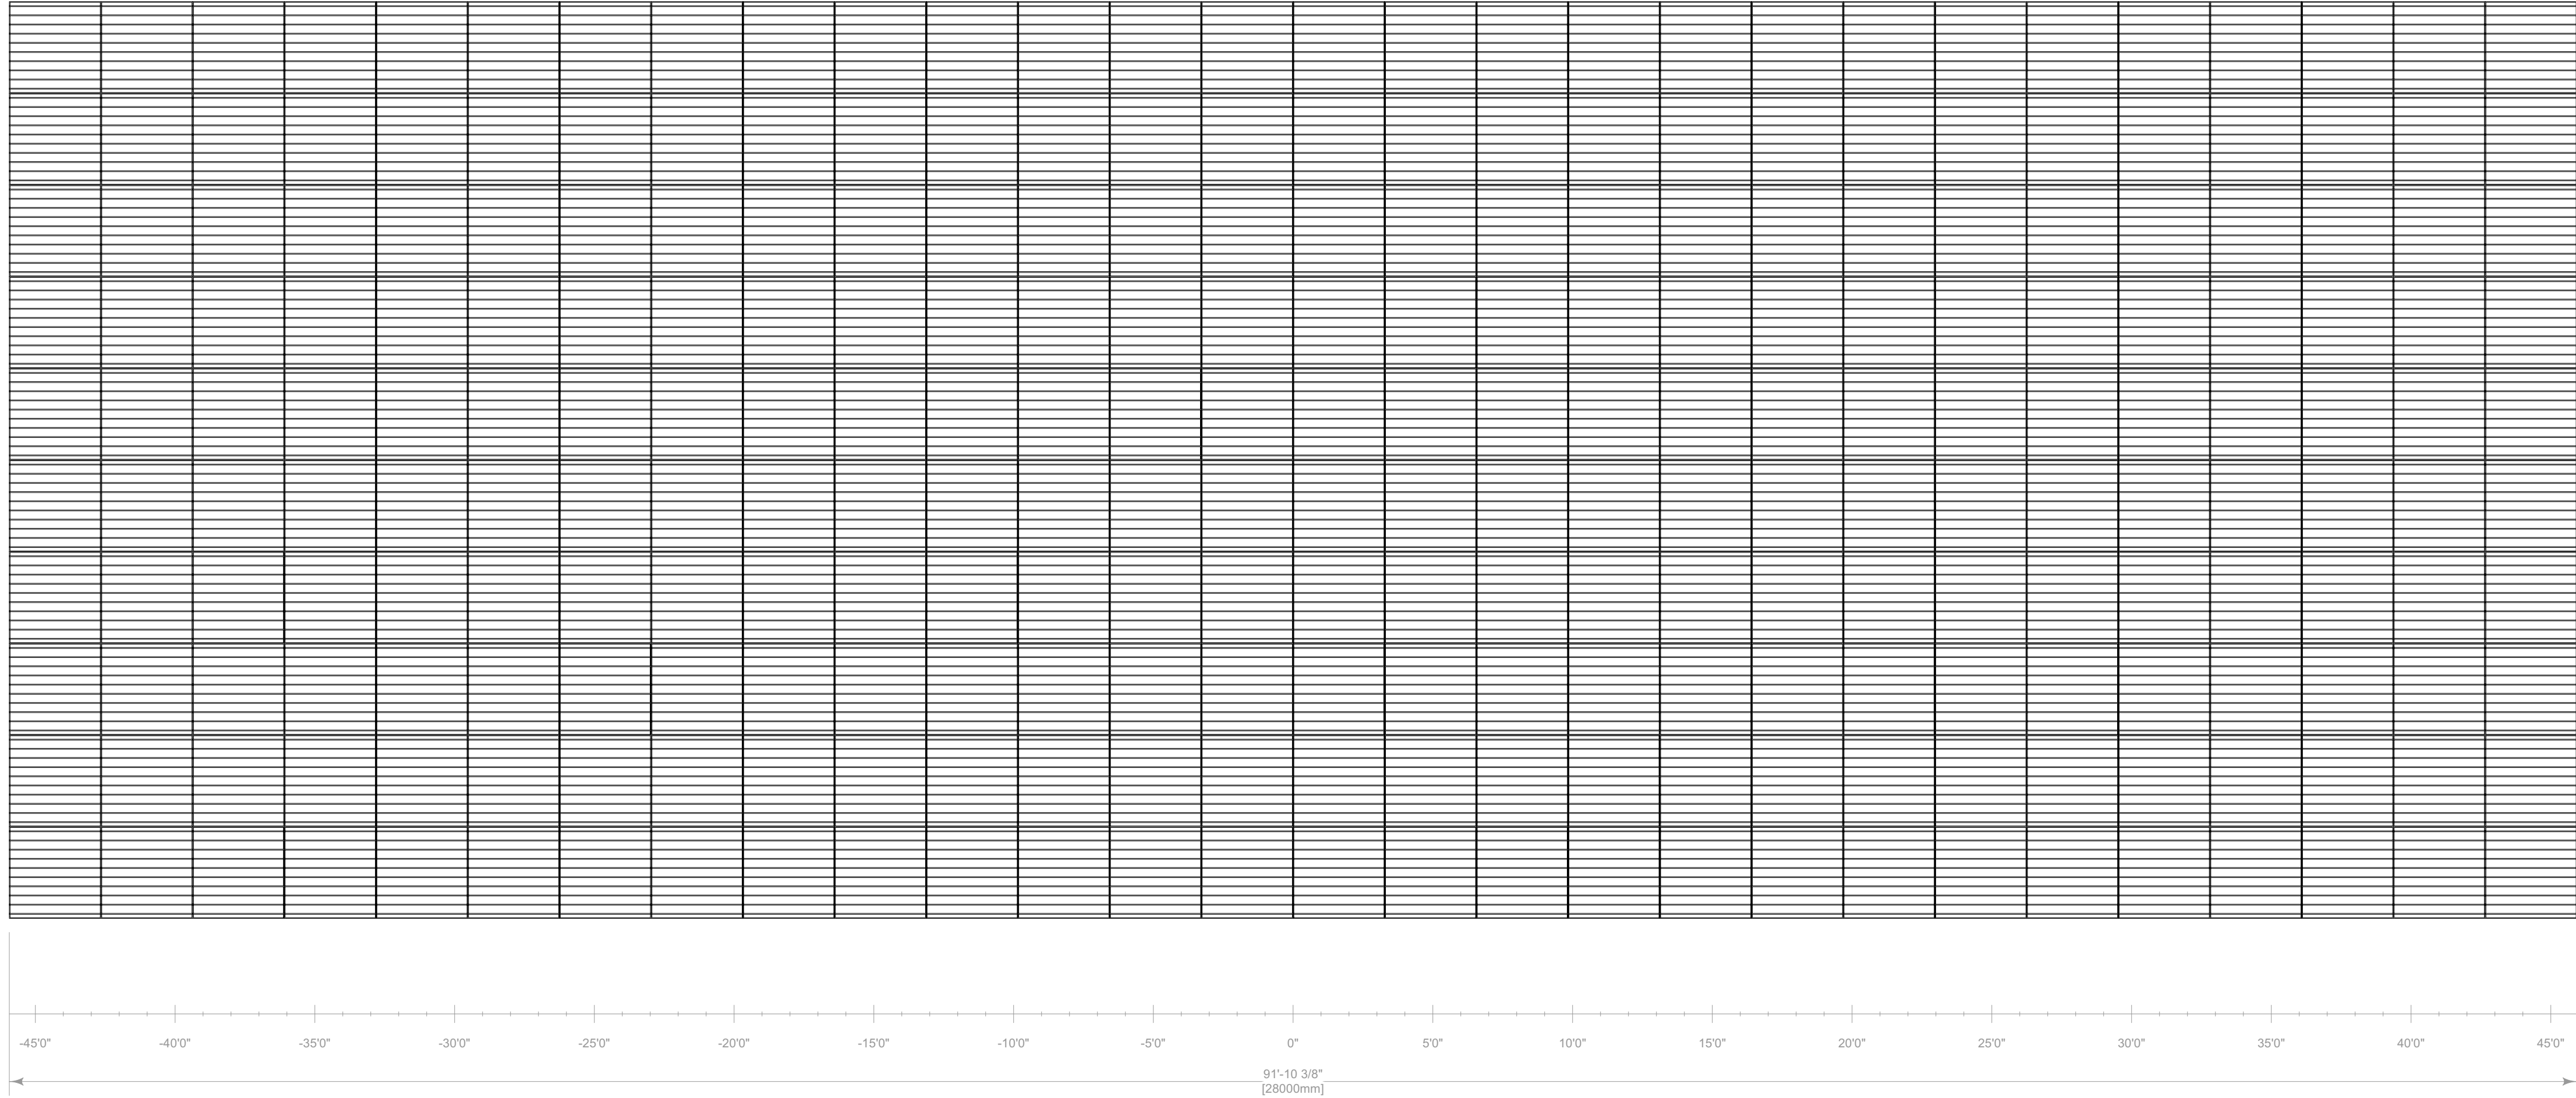

1
Detail K
Scale: 1/4" = 1'-0"

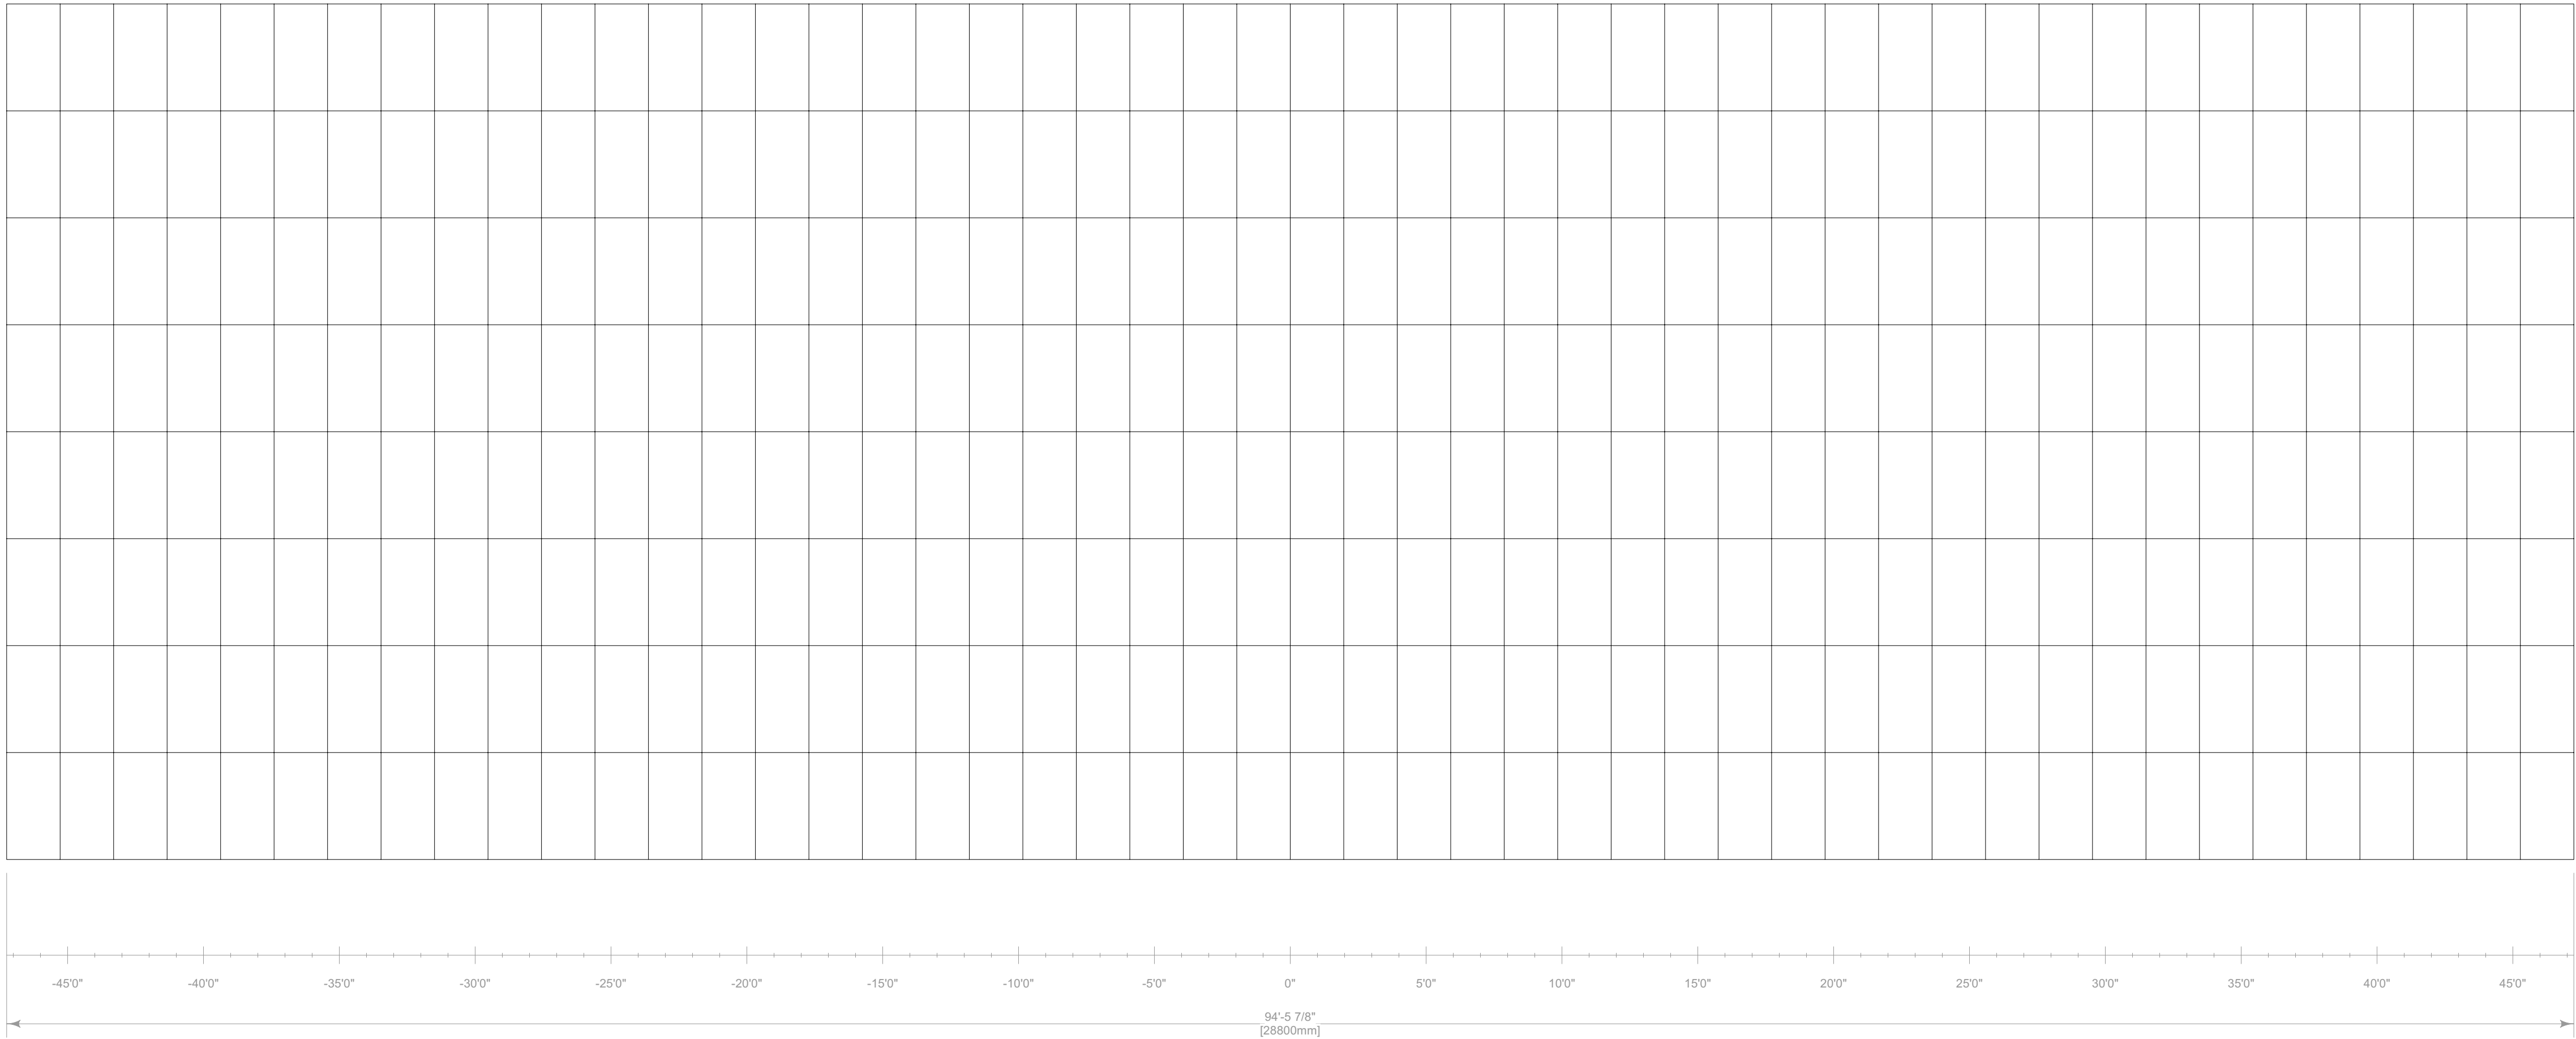

2
Detail N
Scale: 1/4" = 1'-0"

KEY TO SYMBOLS

LIGHTING		
Thumbnail	Item	Qty
	Ayrton Perseo Beam - Standard (40ch)	132
	Chauvet Color Strike M - 13 Channel (13ch)	86
	Chauvet Maverick MK2 Wash - Single-Basic (20ch)	8
	Chauvet Strike Saber - 27 Channel (Dimmer Mode=Dimmer 1) (27ch)	61
	GLP Impression X4 Bar 20 - Single Pixel High Res (89ch)	28
	GLP JDC Line 1000 - MultiPix Advanced (316ch)	28
	Martin Scepton-1000mm - P3 - Pixel Map (10 Segments)/Square Smoked Lens (30ch)	481
	Robe MegaPointe - Mode 1 (39ch)	8
	SGM P-2 + Barn Doors - 5.2.0 (22ch)	4
VIDEO		
Thumbnail	Item	Qty
	600mm Triple Video Header (N/A)	6
	ROE CB8 600mmx1200mm (8.3mm)	396
	Video Tile-600mmx600mm (8mm)	204
	Video Tile-1200mmx1200mm (25mm Blow Through)	280

~762 M² Total


SFX		
Thumbnail	Item	Qty
	Blower Fan - N/A (0ch)	12
	Co2 Valve - N/A (0ch)	14
	Flame Head - N/A (0ch)	20
	Generic Laser - Beyond 5.0 Mid (32ch)	18
	Hazer - 2 Channel (2ch)	12
	Martin AF 1 DMX Fan - 5.2.0 (1ch)	4

CONTROL		
Thumbnail	Item	Qty
	Beyond Computer (Beyond 5.0 Ultimate)	1
	Generic Cooling/Heating Fan (https://a.co/d/hTwf56b)	2
	GrandMA2 Full-Size (3.9.60.37)	2
	Martin P3 Computer (Martin P3)	1

RIGGING		
Item	Qty	
2in Sched. 40 Pipe-03ft (Black)	12	
2in Sched. 40 Pipe-06ft (Black)	4	
12inx12in Box Truss-05ft (Black)	5	
12inx12in Box Truss-10ft (Black)	24	
12inx12in Box Truss-CB (Black)	10	
19inx19in Pipe Base (Black)	4	
20inx20in Box Truss-08ft (Black)	6	
20inx20in Box Truss-10ft (Black)	30	
30inx30in Truss Base (Black)	6	
Container Bracket - Bottom (Black)	12	
I Beam-06ft (Black)	2	
I Beam-20ft (Black)	4	
Tyler Truss CT-05ft		

TABLE OF CONTENTS

Sheet Title	Page
Cover Page	1
Saturday/Sunday Rendering	2
Saturday/Sunday Plan	3
Saturday/Sunday Front Elevation/CL Section	4
Saturday/Sunday Deck Detail	5
Detail A	6
Detail B	7
Detail C,D,E,F	8
Detail G,N	9
Saturday/Sunday DJ Booth & FOH Detail	10
Friday Rendering	11
Friday Plan	12
Friday Front Elevation/CL Section	13
Friday Deck Detail	14

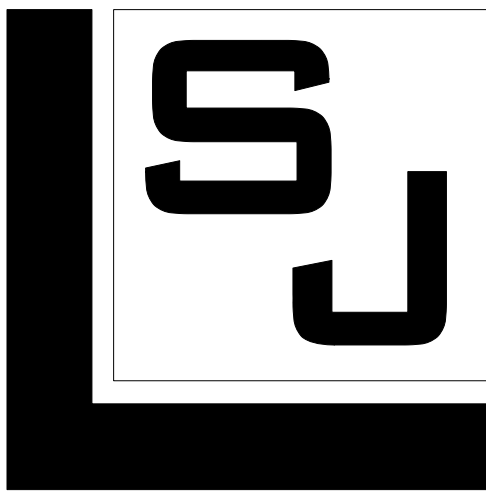

SJ LIGHTING, INC.
WESTLAKE VILLAGE, CA
818.874.9779
INFO@SJLIGHTING.NET
WWW.SJLIGHTING.NET

THE DESIGN AND ALL ASSOCIATED PAPERWORK IS COPYRIGHTED MATERIAL AND REMAINS THE PROPERTY OF THE DESIGNER.

THIS DESIGN IS FOR ONE TIME USE ONLY AT THE SPECIFIED LOCATION AND IS NOT TO BE USED FOR ANY OTHER PURPOSE OR EVENT WITHOUT SPECIFIC WRITTEN PERMISSION OF THE DESIGNER.

DESIGNER IS NOT A STRUCTURAL ENGINEER AND THESE DRAWINGS REPRESENT DESIGN CONCEPTS ONLY AND ARE NOT INTENDED AS ENGINEERING DRAWINGS. THE DESIGNER ASSUMES NO RESPONSIBILITY FOR THE SAFETY OR STRUCTURAL INTEGRITY OF ANY EQUIPMENT PROVIDED BY ANYONE.



REVISIONS

REV #	REMARKS	DATE	INT.
001	-Initial Design	4/6/2023	AHT
002	-Update Saturday Deck Detail	4/21/2023	AHT
003	-Update Friday DJ Booth	5/30/2023	AHT
004	-Add Detail M	7/6/2023	AHT
005	-Update Friday DJ Booth	7/19/2023	AHT
006	-Add Detail N		
007	-Update Detail A,B,C,D		
008	-Update Friday & Saturday DJ Booth		
	-Update Friday & Saturday Deck Detail		
	-Update Audio Hangs	8/3/2023	AHT
	-Update Deck Size	8/11/2023	AHT
	-Update Detail B		
	-Update Detail A,B	8/22/2023	AHT

AURIS PRESENTS

ARC MUSIC
FESTIVAL

CHICAGO, IL

UNION PARK

SEPTEMBER 1-3, 2023

STAGE 1

ISSUE DATE

Wednesday, August 23, 2023

DRAWN BY

MTR
S.J.L.


SCALE

SEE DRAWING
ARCH D (24"x36")


Detail K,L

DD

16 OF 20

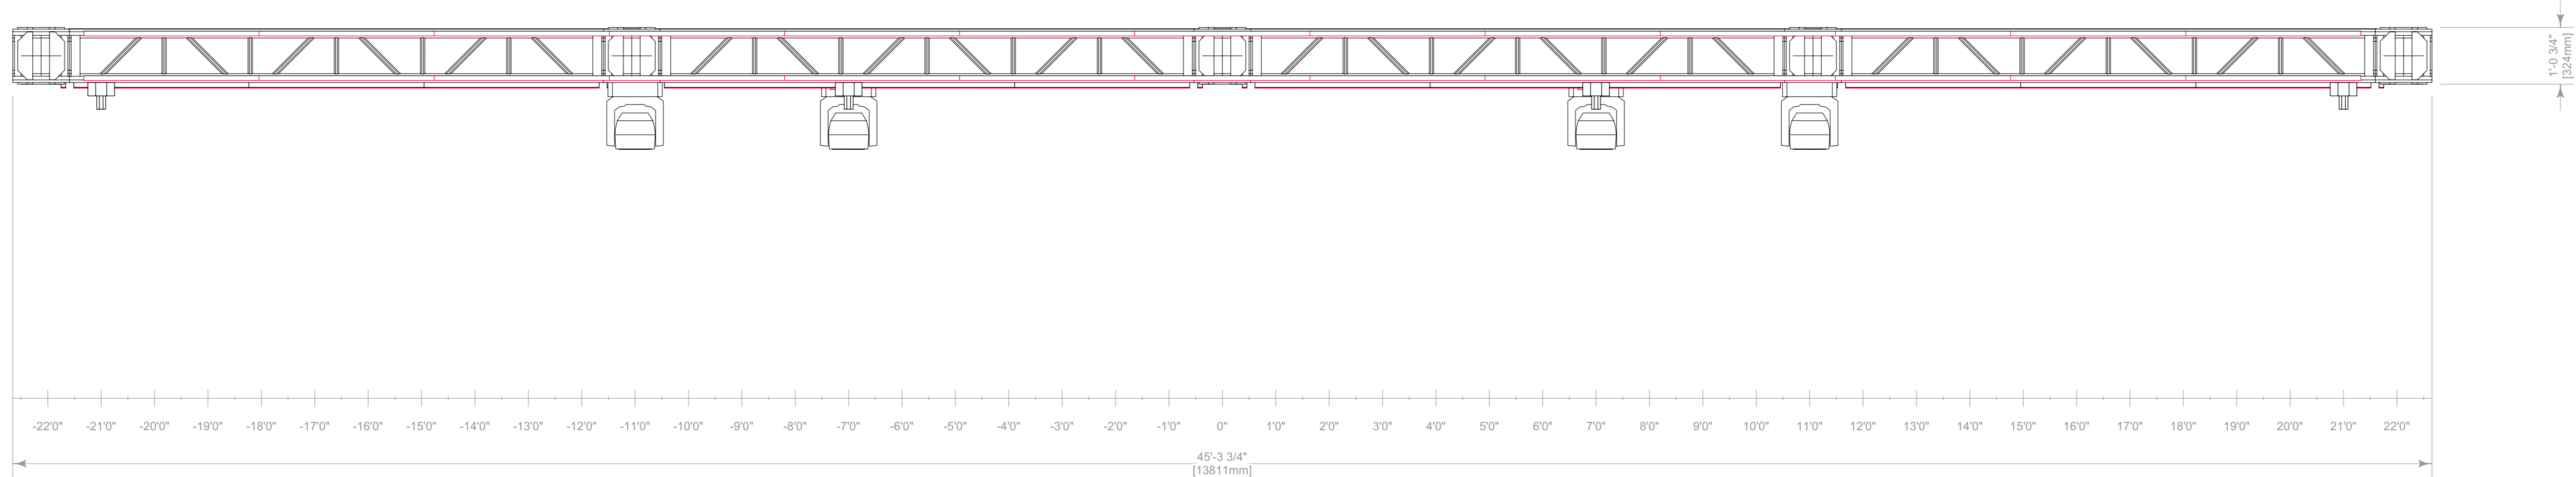

1
Detail M Front
Scale: 1/2" = 1'-0"

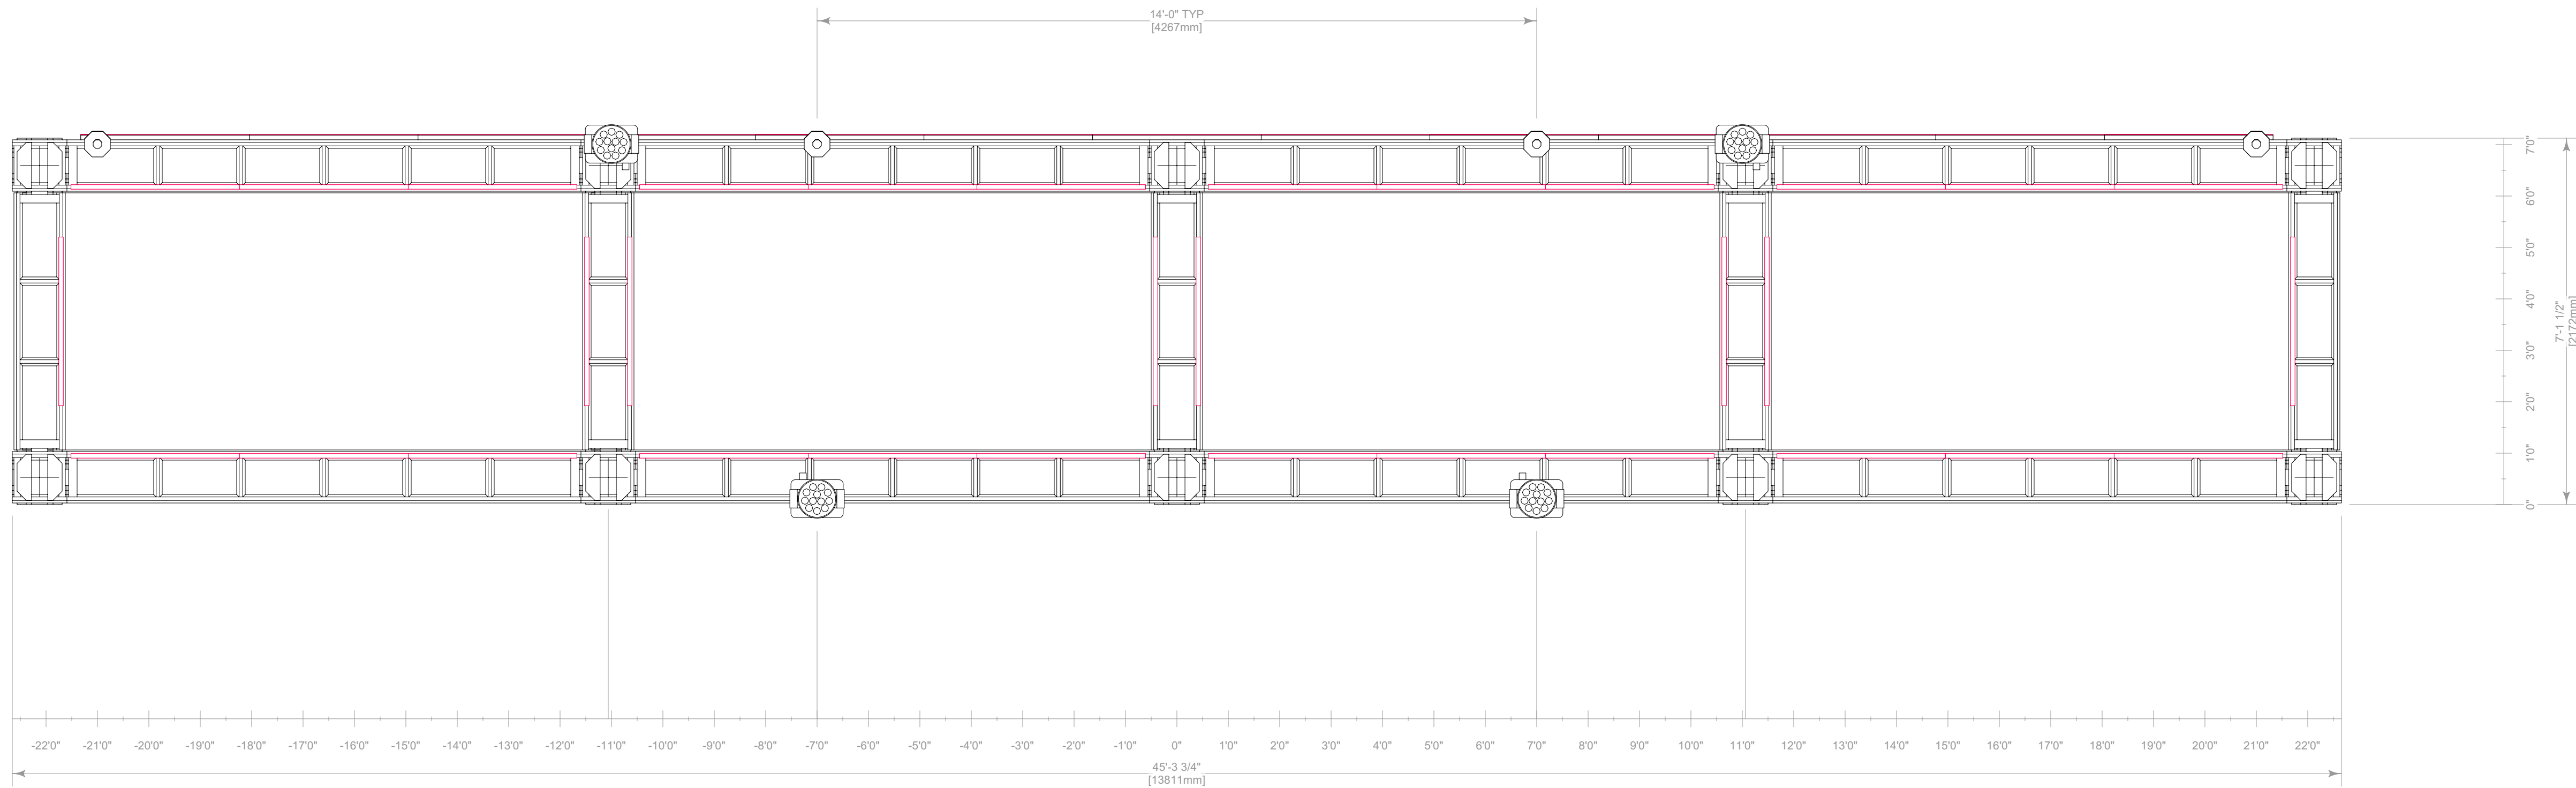


2
Detail M Bottom
Scale: 1/2" = 1'-0"

KEY TO SYMBOLS

LIGHTING		
Thumbnail	Item	Qty
	Ayrton Perseo Beam - Standard (40ch)	132
	Chauvet Color Strike M - 13 Channel (13ch)	86
	Chauvet Maverick MK2 Wash - Single-Basic (20ch)	8
	Chauvet Strike Saber - 27 Channel (Dimmer Mode=Dimmer 1) (27ch)	61
	GLP Impression X4 Bar 20 - Single Pixel High Res (89ch)	28
	GLP JDC Line 1000 - MultiPix Advanced (316ch)	28
	Martin Scepton-1000mm - P3 - Pixel Map (10 Segments)/Square Smoked Lens (30ch)	481
	Robe MegaPointe - Mode 1 (39ch)	8
	SGM P-2 + Barn Doors - 5.2.0 (22ch)	4
VIDEO		
Thumbnail	Item	Qty
	600mm Triple Video Header (N/A)	6
	ROE CB8 600mmx1200mm (8.3mm)	396
	Video Tile-600mmx600mm (8mm)	204
	Video Tile-1200mmx1200mm (25mm Blow Through)	280
~762 M² Total		
SFX		
Thumbnail	Item	Qty
	Blower Fan - N/A (0ch)	12
	Co2 Valve - N/A (0ch)	14
	Flame Head - N/A (0ch)	20
	Generic Laser - Beyond 5.0 Mid (32ch)	18
	Hazer - 2 Channel (2ch)	12
	Martin AF 1 DMX Fan - 5.2.0 (1ch)	4
CONTROL		
Thumbnail	Item	Qty
	Beyond Computer (Beyond 5.0 Ultimate)	1
	Generic Cooling/Heating Fan (https://a.co/d/hTWf56b)	2
	GrandMA2 Full-Size (3.9.60.37)	2
	Martin P3 Computer (Martin P3)	1
RIGGING		
Item	Qty	
2in Sched. 40 Pipe-03ft (Black)	12	
2in Sched. 40 Pipe-06ft (Black)	4	
12inx12in Box Truss-05ft (Black)	5	
12inx12in Box Truss-10ft (Black)	24	
12inx12in Box Truss-CB (Black)	10	
19inx19in Pipe Base (Black)	4	
20inx20in Box Truss-08ft (Black)	6	
20inx20in Box Truss-10ft (Black)	30	
30inx30in Truss Base (Black)	6	
Container Bracket - Bottom (Black)	12	
1 Beam-06ft (Black)	2	
1 Beam-20ft (Black)	4	
Tyler Truss CT-05ft	4	

TABLE OF CONTENTS

Sheet Title	Page
Cover Page	1
Saturday/Sunday Rendering	2
Saturday/Sunday Plan	3
Saturday/Sunday Front Elevation/CL Section	4
Saturday/Sunday Deck Detail	5
Detail A	6
Detail B	7
Detail C,D,E,F	8
Detail G,N	9
Saturday/Sunday DJ Booth & FOH Detail	10
Friday Rendering	11
Friday Plan	12
Friday Front Elevation/CL Section	13
Friday Deck Detail	14

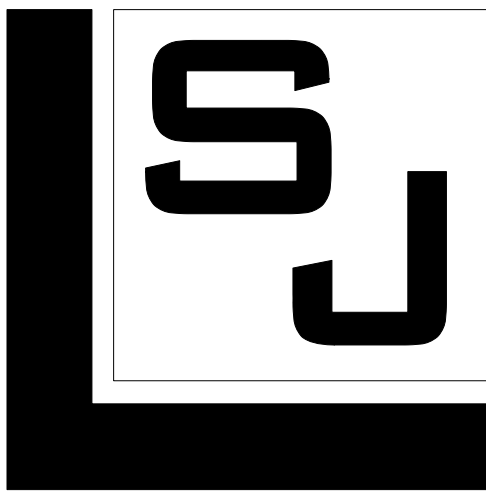

SJ LIGHTING, INC.
WESTLAKE VILLAGE, CA
818.874.9779
INFO@SJLIGHTING.NET
WWW.SJLIGHTING.NET

THE DESIGN AND ALL ASSOCIATED PAPERWORK IS COPYRIGHTED MATERIAL AND REMAINS THE PROPERTY OF THE DESIGNER.
THIS DESIGN IS FOR ONE TIME USE ONLY AT THE SPECIFIED LOCATION AND IS NOT TO BE USED FOR ANY OTHER PURPOSE OR EVENT WITHOUT SPECIFIC WRITTEN PERMISSION OF THE DESIGNER.
DESIGNER IS NOT A STRUCTURAL ENGINEER AND THESE DRAWINGS REPRESENT DESIGN CONCEPTS ONLY AND ARE NOT INTENDED AS ENGINEERING DRAWINGS. THE DESIGNER ASSUMES NO RESPONSIBILITY FOR THE SAFETY OR STRUCTURAL INTEGRITY OF ANY EQUIPMENT PROVIDED BY ANYONE.



REVISIONS

REV #	REMARKS	DATE	INT.
001	-Initial Design	4/6/2023	AHT
002	-Update Saturday Deck Detail	4/21/2023	AHT
003	-Update Friday DJ Booth	5/30/2023	AHT
004	-Add Detail M	7/6/2023	AHT
005	-Update Friday DJ Booth	7/19/2023	AHT
	-Add Detail N		
	-Update Detail A,B,C,D		
	-Update Friday & Saturday DJ Booth		
	-Update Friday & Saturday Deck Detail		
006	-Update Audio Hangs	8/3/2023	AHT
007	-Update Deck Size	8/11/2023	AHT
008	-Update Detail B	8/22/2023	AHT

AURIS PRESENTS

ARC MUSIC FESTIVAL

CHICAGO, IL

UNION PARK

SEPTEMBER 1-3, 2023

STAGE 1

ISSUE DATE

Wednesday, August 23, 2023

DRAWN BY

MTR

S.J.L.

SCALE


SEE DRAWING

ARCH D (24"x36")


Detail M

DD

17 OF 20

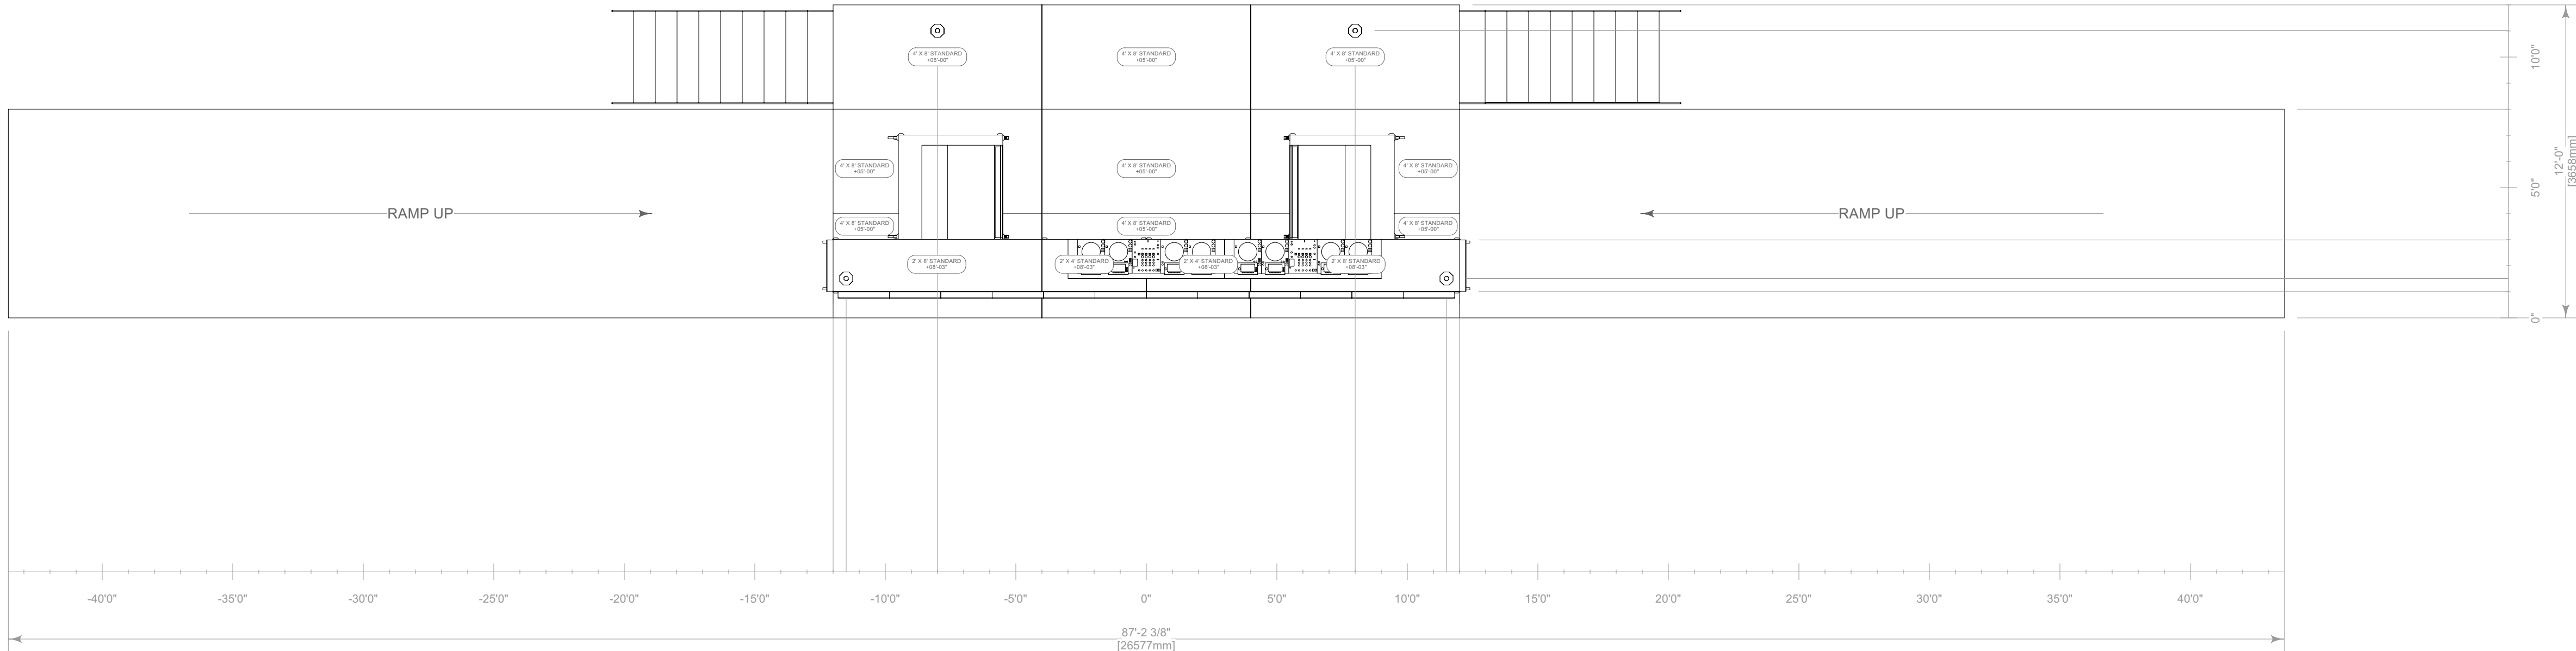

1 Friday DJ Booth Detail Top
Scale: 1/4" = 1'-0"

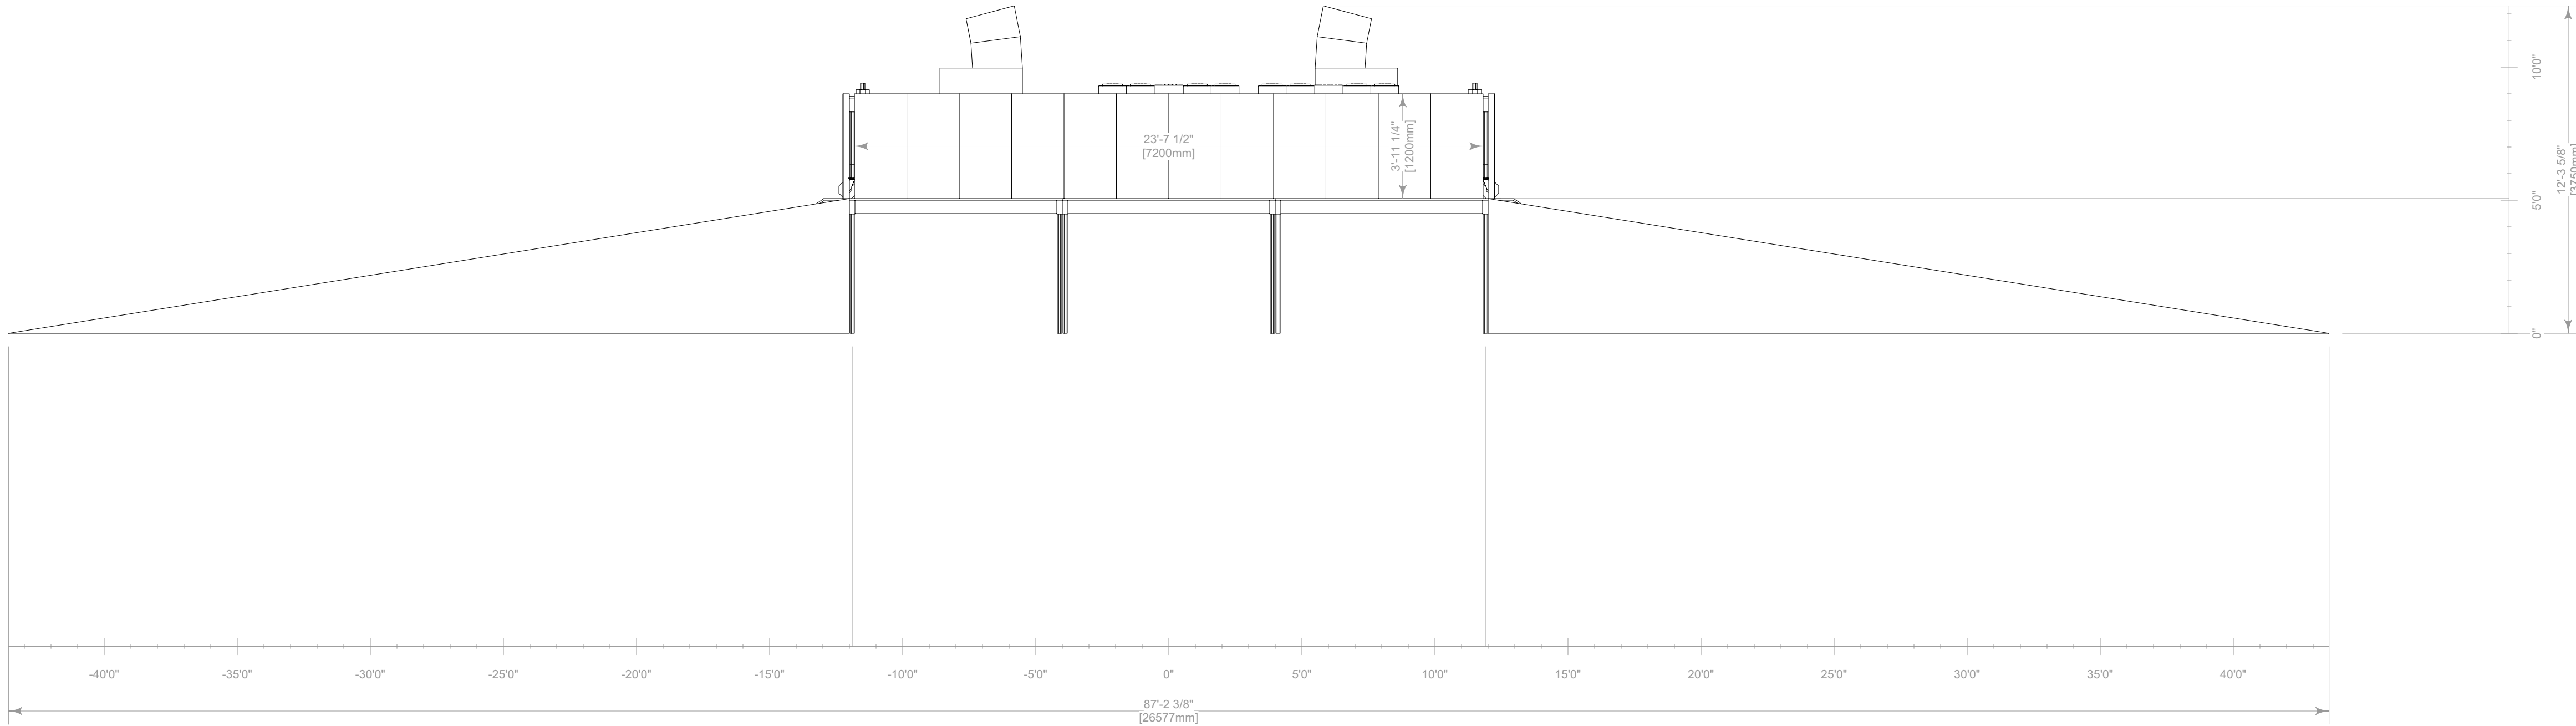

2 Friday DJ Booth Detail Front
Scale: 1/4" = 1'-0"


KEY TO SYMBOLS

SUBSTITUTIONS ARE ACCEPTED UPON APPROVAL

LIGHTING		
Thumbnail	Item	Qty
	Ayrton Perseo Beam - Standard (40ch)	132
	Chauvet Color Strike M - 13 Channel (13ch)	86
	Chauvet Maverick MK2 Wash - Single-Basic (20ch)	8
	Chauvet Strike Saber - 27 Channel (Dimmer Mode=Dimmer 1) (27ch)	61
	GLP Impression X4 Bar 20 - Single Pixel High Res (89ch)	28
	GLP JDC Line 1000 - MultiPix Advanced (316ch)	28
	Martin Scepter-1000mm - P3 - Pixel Map (10 Segments)/Square Smoked Lens (30ch)	481
	Robe MegaPointe - Mode 1 (39ch)	8
	SGM P-2 + Barn Doors - 5.2.0 (22ch)	4
VIDEO		
Thumbnail	Item	Qty
	600mm Triple Video Header (N/A)	6
	ROE CB8 600mmx1200mm (8.3mm)	396
	Video Tile-600mmx600mm (8mm)	204
	Video Tile-1200mmx1200mm (25mm Blow Through)	280
~762 M² Total		
SFX		
Thumbnail	Item	Qty
	Blower Fan - N/A (0ch)	12
	Co2 Valve - N/A (0ch)	14
	Flame Head - N/A (0ch)	20
	Generic Laser - Beyond 5.0 Mid (32ch)	18
	Hazer - 2 Channel (2ch)	12
	Martin AF 1 DMX Fan - 5.2.0 (1ch)	4
CONTROL		
Thumbnail	Item	Qty
	Beyond Computer (Beyond 5.0 Ultimate)	1
	Generic Cooling/Heating Fan (https://a.co/d/hTwf56b)	2
	GrandMA2 Full-Size (3.9.60.37)	2
	Martin P3 Computer (Martin P3)	1
RIGGING		
Item	Qty	
2in Sched. 40 Pipe-03ft (Black)	12	
2in Sched. 40 Pipe-06ft (Black)	4	
12inx12in Box Truss-05ft (Black)	5	
12inx12in Box Truss-10ft (Black)	24	
12inx12in Box Truss-CB (Black)	10	
19inx19in Pipe Base (Black)	4	
20inx20in Box Truss-08ft (Black)	6	
20inx20in Box Truss-10ft (Black)	30	
30inx30in Truss Base (Black)	6	
Container Bracket - Bottom (Black)	12	
1 Beam-06ft (Black)	2	
1 Beam-20ft (Black)	4	
Tyler Truss GT-05ft		

TABLE OF CONTENTS

Sheet Title	Page
Cover Page	1
Saturday/Sunday Rendering	2
Saturday/Sunday Plan	3
Saturday/Sunday Front Elevation/CL Section	4
Saturday/Sunday Deck Detail	5
Detail A	6
Detail B	7
Detail C, D, E, F	8
Detail G, N	9
Saturday/Sunday DJ Booth & FOH Detail	10
Friday Rendering	11
Friday Plan	12
Friday Front Elevation/CL Section	13
Friday Deck Detail	14

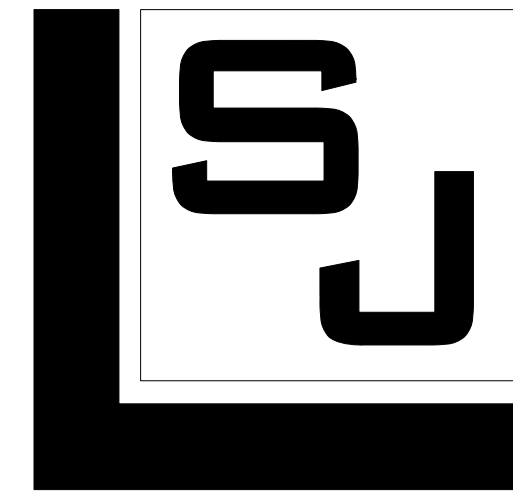

SJ LIGHTING, INC.
WESTLAKE VILLAGE, CA
818.874.9779
INFO@SJLIGHTING.NET
WWW.SJLIGHTING.NET

THE DESIGN AND ALL ASSOCIATED PAPERWORK IS COPYRIGHTED MATERIAL AND REMAINS THE PROPERTY OF THE DESIGNER.
THIS DESIGN IS FOR ONE TIME USE ONLY AT THE SPECIFIED LOCATION AND IS NOT TO BE USED FOR ANY OTHER PURPOSE OR EVENT WITHOUT SPECIFIC WRITTEN PERMISSION OF THE DESIGNER.
DESIGNER IS NOT A STRUCTURAL ENGINEER AND THESE DRAWINGS REPRESENT DESIGN CONCEPTS ONLY AND ARE NOT INTENDED AS ENGINEERING DRAWINGS. THE DESIGNER ASSUMES NO RESPONSIBILITY FOR THE SAFETY OR STRUCTURAL INTEGRITY OF ANY EQUIPMENT PROVIDED BY ANYONE.



REVISIONS

REV #	REMARKS	DATE	INT.
001	-Initial Design	4/6/2023	AHT
002	-Update Saturday Deck Detail	4/21/2023	AHT
003	-Update Friday DJ Booth	5/30/2023	AHT
004	-Add Detail M	7/6/2023	AHT
005	-Update Friday DJ Booth	7/19/2023	AHT
	-Add Detail N		
	-Update Detail A,B,C,D		
	-Update Friday & Saturday DJ Booth		
	-Update Friday & Saturday Deck Detail		
006	-Update Audio Hangs	8/3/2023	AHT
007	-Update Deck Size	8/11/2023	AHT
008	-Update Detail B	8/22/2023	AHT

AURIS PRESENTS

ARC MUSIC FESTIVAL

CHICAGO, IL

UNION PARK

SEPTEMBER 1-3, 2023

STAGE 1

ISSUE DATE

Wednesday, August 23, 2023

DRAWN BY
MTR
SUL

SCALE
SEE DRAWING
ARCH D (24"x36")


Friday DJ Booth Detail

DD

18 OF 20


1

Eric Prydz DJ Booth Detail Top
Scale: 3/8" = 1'-0"

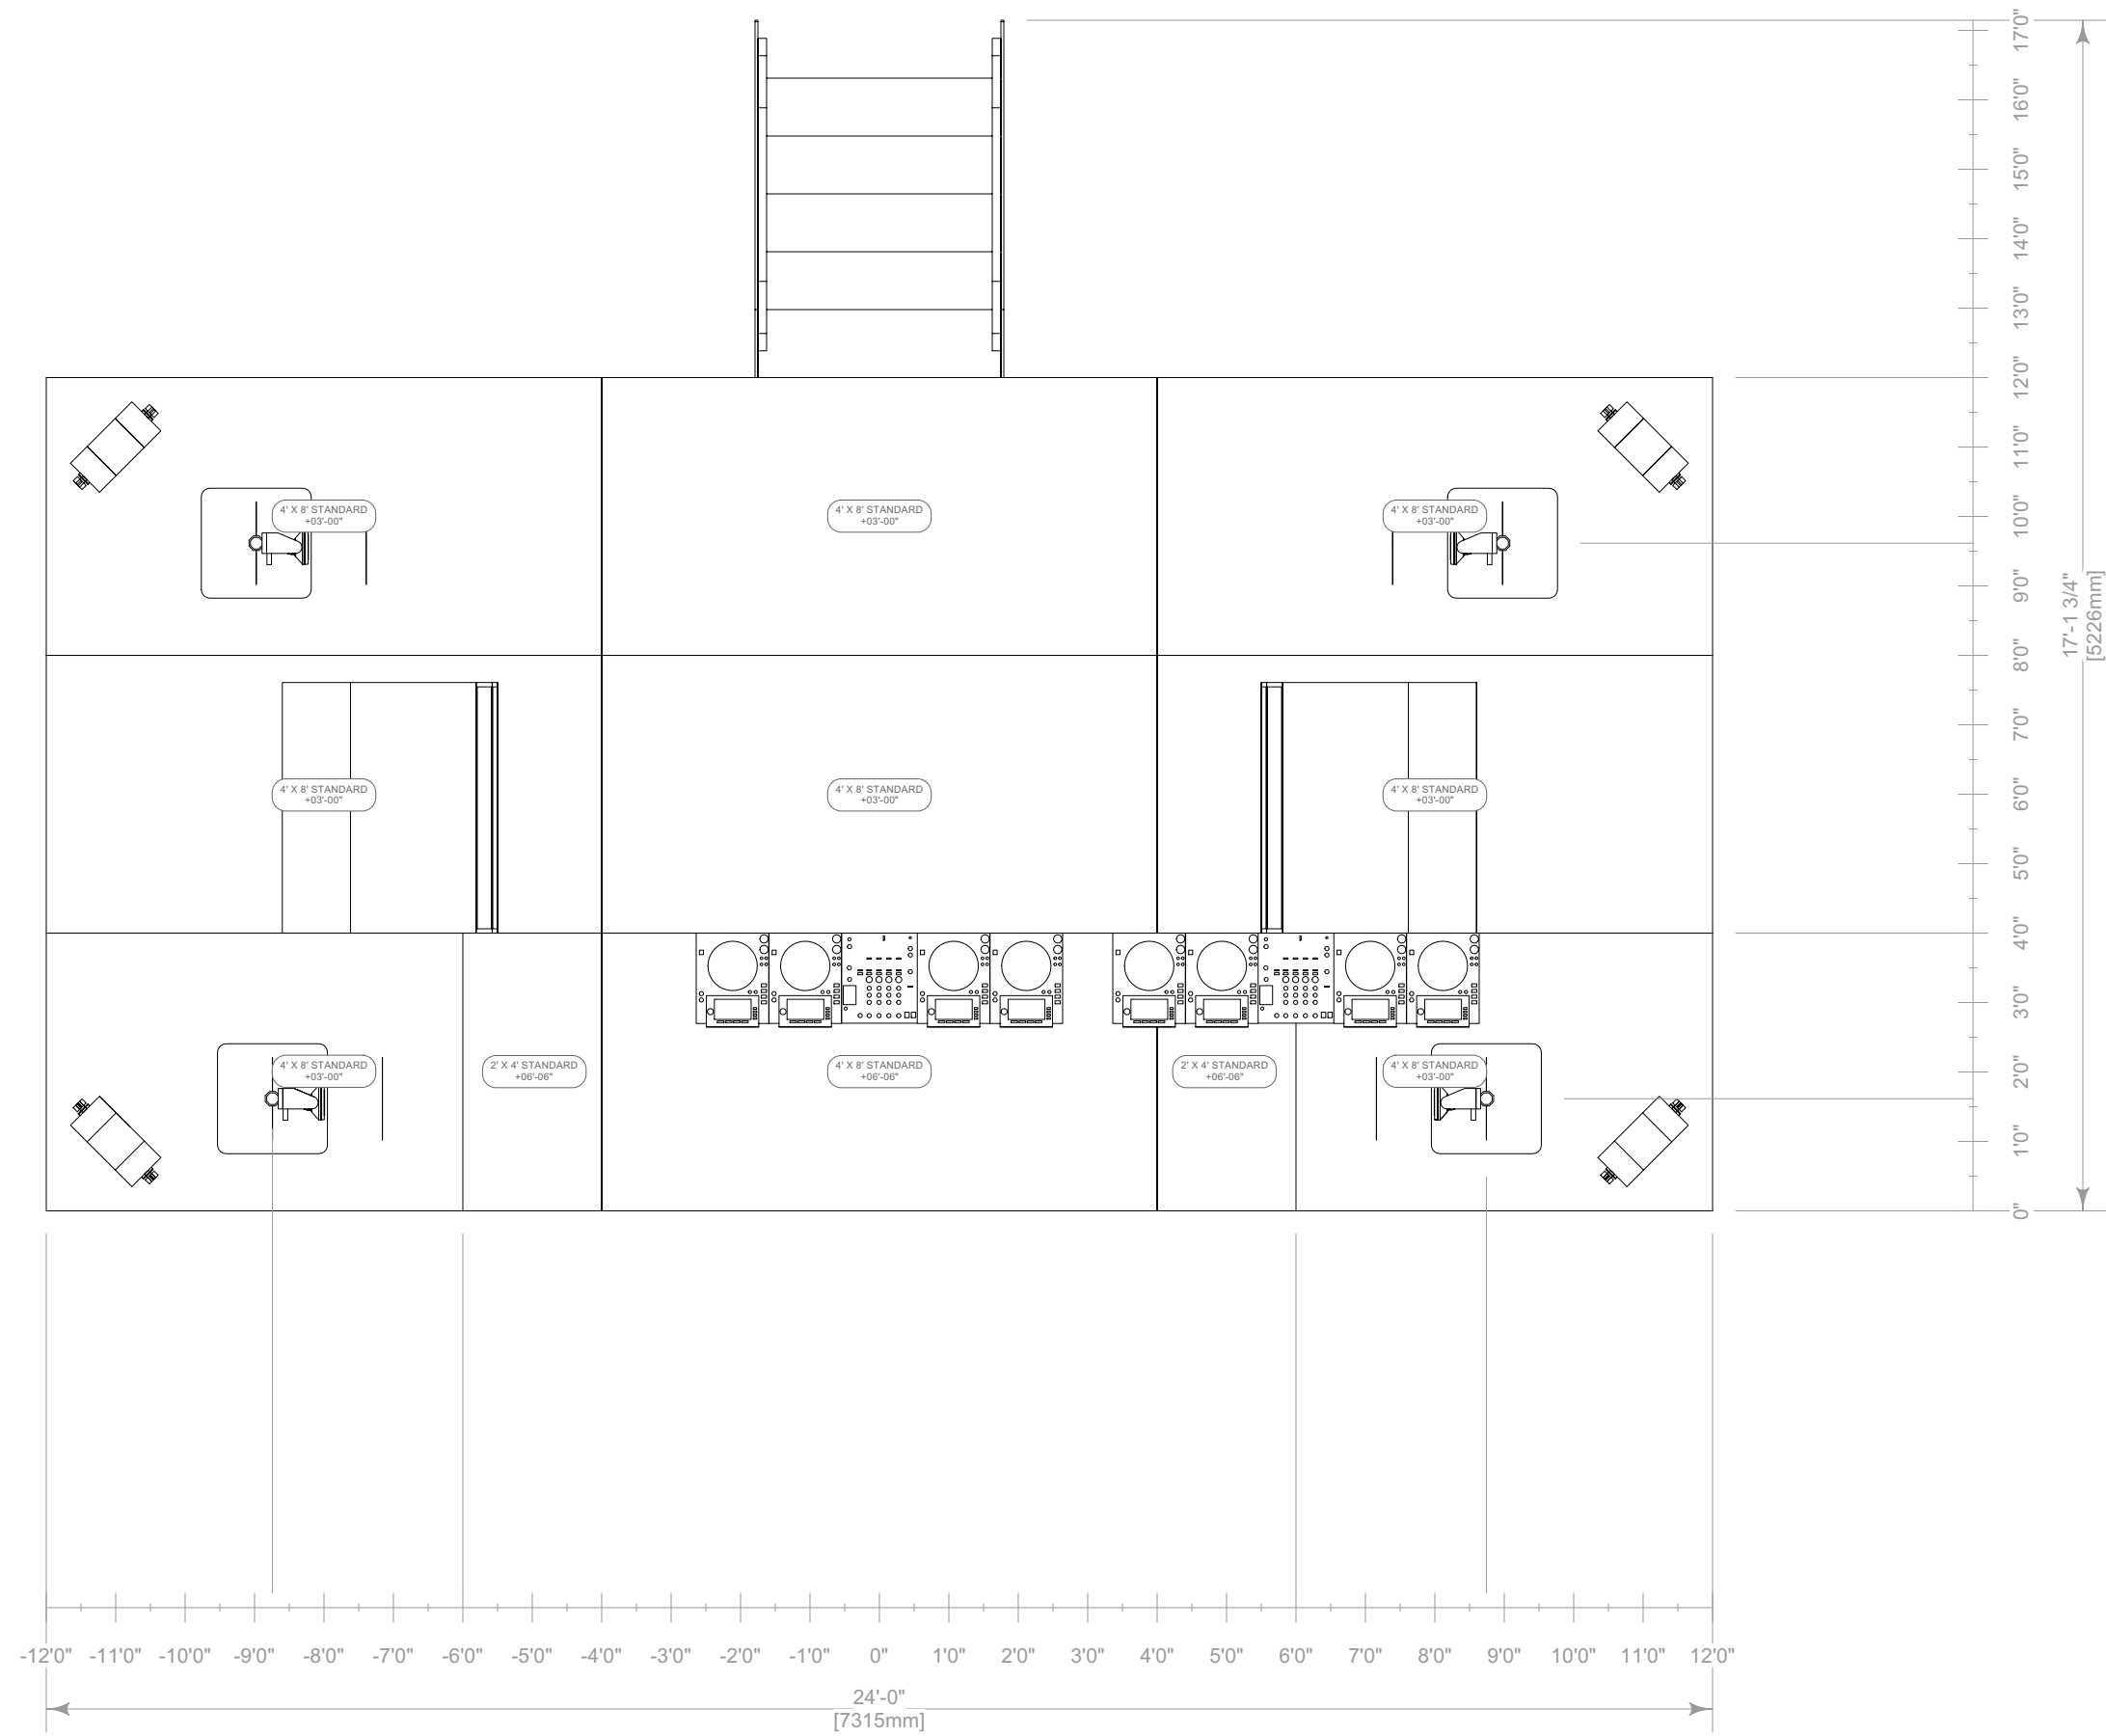

2

Eric Prydz DJ Booth Detail Front
Scale: 3/8" = 1'-0"

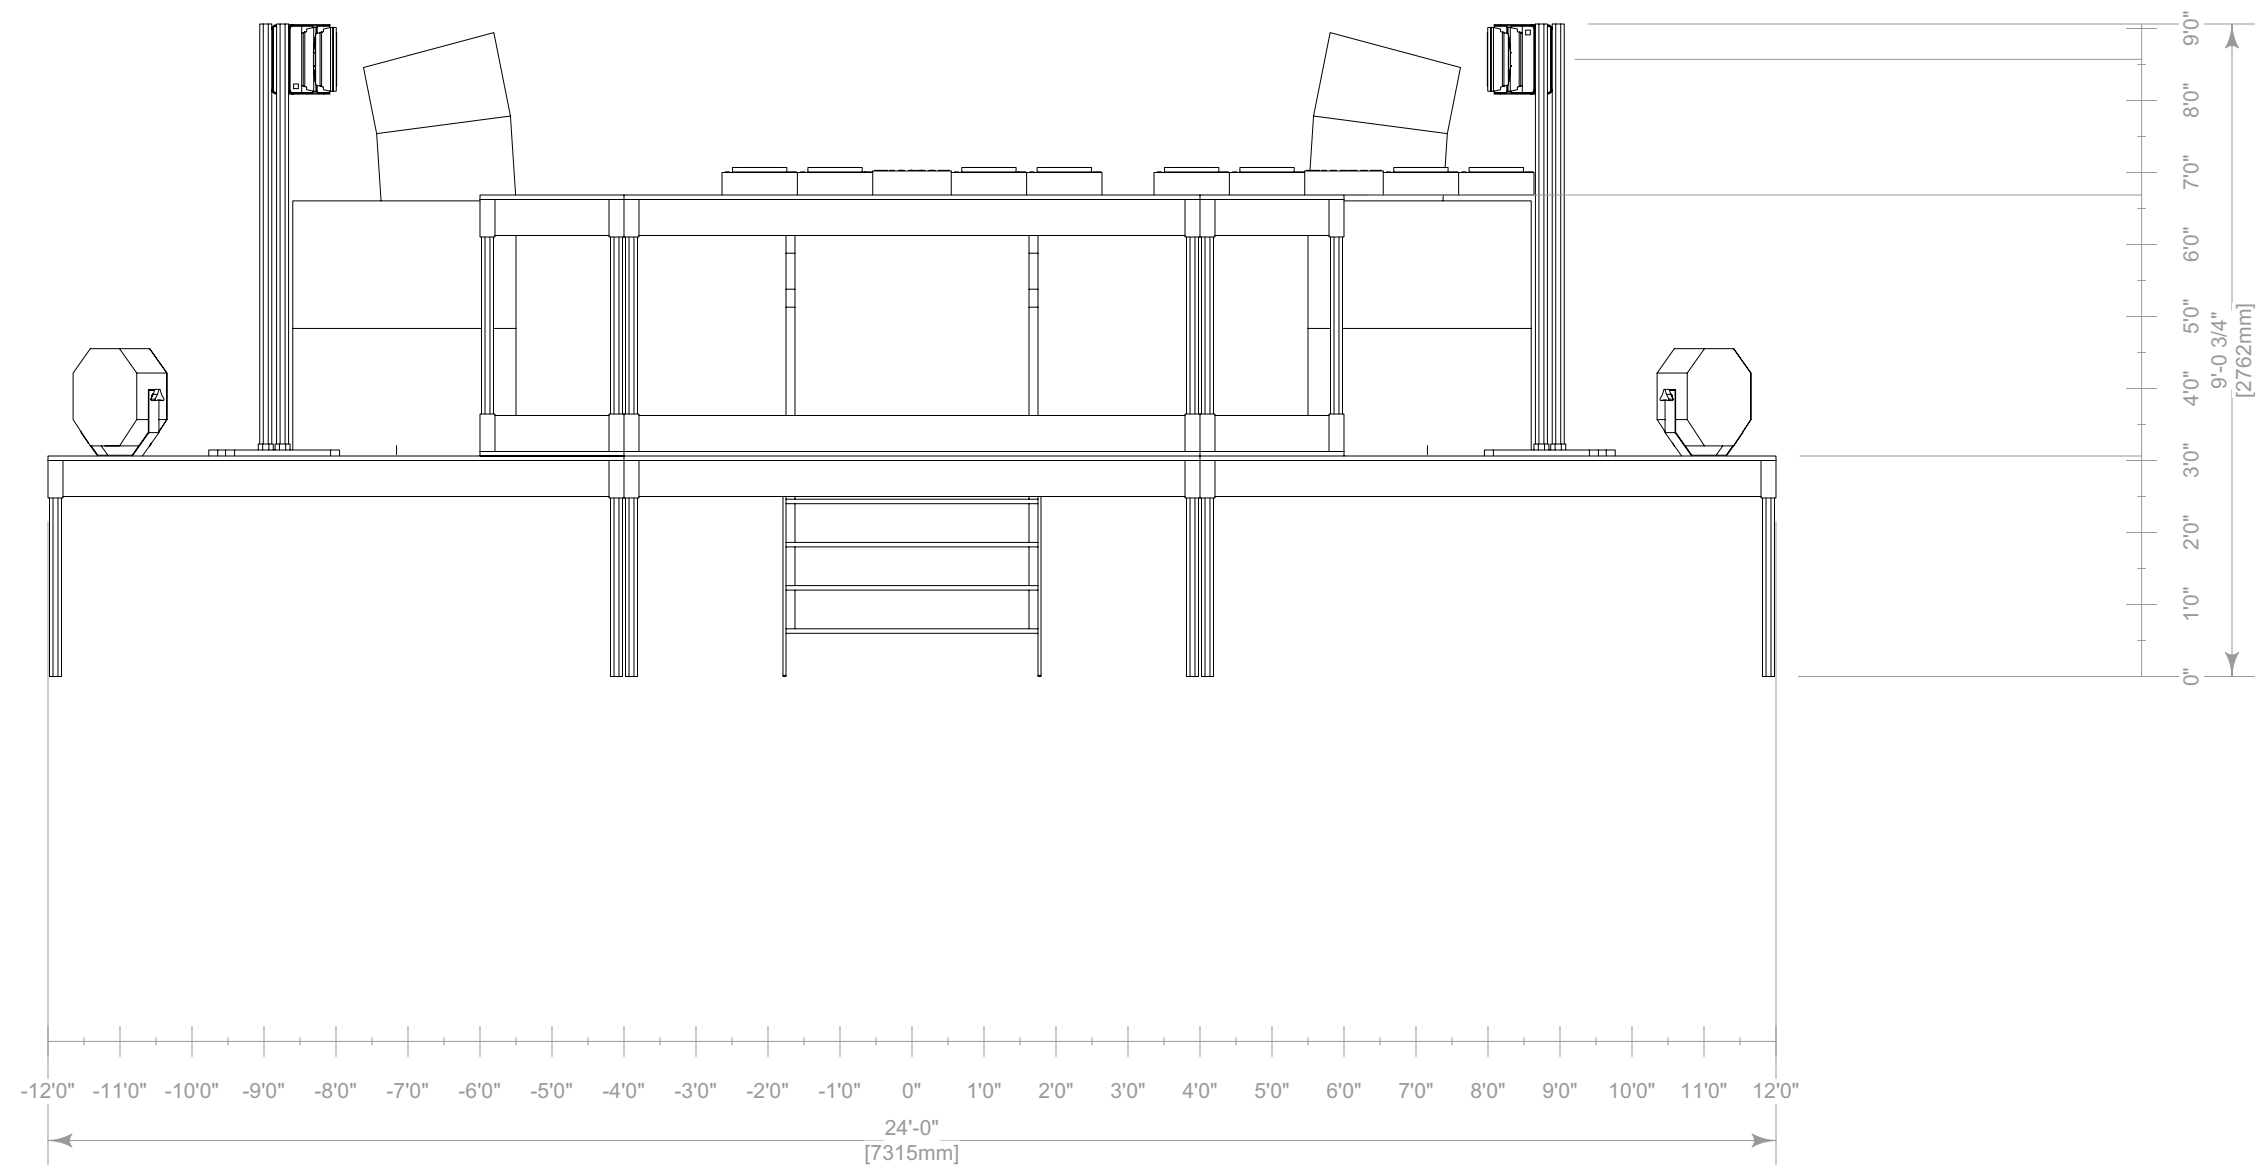

KEY TO SYMBOLS

SUBSTITUTIONS ARE ACCEPTED UPON APPROVAL

LIGHTING

Thumbnail	Item	Qty
	Ayrton Perseo Beam - Standard (40ch)	132
	Chauvet Color Strike M - 13 Channel (13ch)	86
	Chauvet Maverick MK2 Wash - Single-Basic (20ch)	8
	Chauvet Strike Saber - 27 Channel (Dimmer Mode=Dimmer 1) (27ch)	61
	GLP Impression X4 Bar 20 - Single Pixel High Res (89ch)	28
	GLP JDC Line 1000 - MultiPix Advanced (316ch)	28
	Martin Scepton-1000mm - P3 - Pixel Map (10 Segments)/Square Smoked Lens (30ch)	481
	Robe MegaPointe - Mode 1 (39ch)	8
	SGM P-2 + Barn Doors - 5.2.0 (22ch)	4

VIDEO

Thumbnail	Item	Qty
	600mm Triple Video Header (N/A)	6
	ROE CB8 600mmx1200mm (8.3mm)	396
	Video Tile-600mmx600mm (8mm)	204
	Video Tile-1200mmx1200mm (25mm Blow Through)	280

~762 M² Total

SFX

Thumbnail	Item	Qty
	Blower Fan - N/A (0ch)	12
	Co2 Valve - N/A (0ch)	14
	Flame Head - N/A (0ch)	20
	Generic Laser - Beyond 5.0 Mid (32ch)	18
	Hazer - 2 Channel (2ch)	12
	Martin AF 1 DMX Fan - 5.2.0 (1ch)	4

CONTROL


Thumbnail	Item	Qty
	Beyond Computer (Beyond 5.0 Ultimate)	1
	Generic Cooling/Heating Fan (https://a.co/d/hTwf56b)	2
	GrandMA2 Full-Size (3.9.60.37)	2
	Martin P3 Computer (Martin P3)	1

RIGGING

Item	Qty
2in Sched. 40 Pipe-03ft (Black)	12
2in Sched. 40 Pipe-06ft (Black)	4
12inx12in Box Truss-05ft (Black)	5
12inx12in Box Truss-10ft (Black)	24
12inx12in Box Truss-CB (Black)	10
19inx19in Pipe Base (Black)	4
20inx20in Box Truss-08ft (Black)	6
20inx20in Box Truss-10ft (Black)	30
30inx30in Truss Base (Black)	6
Container Bracket - Bottom (Black)	12
1 Beam-06ft (Black)	2
1 Beam-20ft (Black)	4
Tyler Truss GT-05ft	4

TABLE OF CONTENTS

Sheet Title	Page
Cover Page	1
Saturday/Sunday Rendering	2
Saturday/Sunday Plan	3
Saturday/Sunday Front Elevation/CL Section	4
Saturday/Sunday Deck Detail	5
Detail A	6
Detail B	7
Detail C, D, E, F	8
Detail G, N	9
Saturday/Sunday DJ Booth & FOH Detail	10
Friday Rendering	11
Friday Plan	12
Friday Front Elevation/CL Section	13
Friday Deck Detail	14

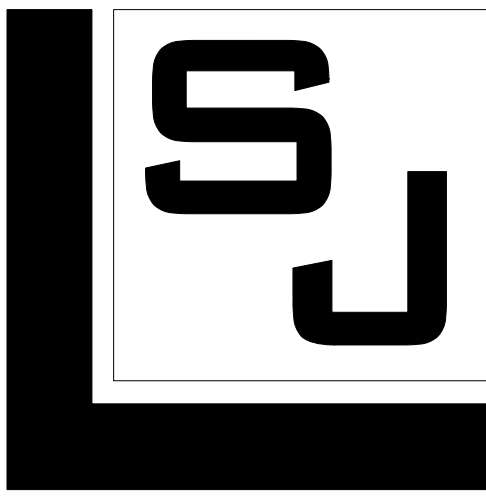

SJ LIGHTING, INC.
WESTLAKE VILLAGE, CA
818.874.9779
INFO@SJLIGHTING.NET
WWW.SJLIGHTING.NET

THE DESIGN AND ALL ASSOCIATED PAPERWORK IS COPYRIGHTED MATERIAL AND REMAINS THE PROPERTY OF THE DESIGNER.

THIS DESIGN IS FOR ONE TIME USE ONLY AT THE SPECIFIED LOCATION AND IS NOT TO BE USED FOR ANY OTHER PURPOSE OR EVENT WITHOUT SPECIFIC WRITTEN PERMISSION OF THE DESIGNER.

DESIGNER IS NOT A STRUCTURAL ENGINEER AND THESE DRAWINGS REPRESENT DESIGN CONCEPTS ONLY AND ARE NOT INTENDED AS ENGINEERING DRAWINGS. THE DESIGNER ASSUMES NO RESPONSIBILITY FOR THE SAFETY OR STRUCTURAL INTEGRITY OF ANY EQUIPMENT PROVIDED BY ANYONE.



REVISIONS

REV #	REMARKS	DATE	INT.
001	-Initial Design	4/6/2023	AHT
002	-Update Saturday Deck Detail	4/21/2023	AHT
003	-Update Friday DJ Booth	5/30/2023	AHT
004	-Add Detail M	7/6/2023	AHT
005	-Update Friday DJ Booth	7/19/2023	AHT
006	-Add Detail N	7/19/2023	AHT
007	-Update Detail A,B,C,D	8/3/2023	AHT
008	-Update Friday & Saturday DJ Booth	8/11/2023	AHT
	-Update Audio Hangs	8/22/2023	AHT
	-Update Deck Size		
	-Update Detail B		

AURIS PRESENTS

ARC MUSIC FESTIVAL

CHICAGO, IL

UNION PARK

SEPTEMBER 1-3, 2023

STAGE 1

ISSUE DATE

Wednesday, August 23, 2023

DRAWN BY

MTR
S.J.L.

SCALE

SEE DRAWING
ARCH D (24"x36")

Eric Prydz DJ Booth Detail

DD

19 OF 20

	AURIS PRESENTS UNION PARK CHICAGO, IL SEPTEMBER 1-3, 2023	EQUIPMENT LIST ARC MUSIC FESTIVAL STAGE 1 --- SUBSTITUTIONS ARE ACCEPTED UPON APPROVAL	SJ LIGHTING, INC. WESTLAKE VILLAGE, CA 818.874.9779 INFO@SJLIGHTING.NET WWW.SJLIGHTING.NET	
---	--	---	--	--

LIGHTING		
Item	Qty	Mode (ch)
Ayrton Perseo Beam	132	Standard (40ch)
Chauvet Color Strike M	86	13 Channel (13ch)
Chauvet Maverick MK2 Wash	8	Single-Basic (20ch)
Chauvet Strike Saber	61	27 Channel (Dimmer Mode=Dimmer 1) (27ch)
GLP Impression X4 Bar 20	28	Single Pixel High Res (89ch)
GLP JDC Line 1000	28	MultiPix Advanced (316ch)
Martin Scepton-1000mm	481	P3 - Pixel Map (10 Segments)/Square Smoked Lens (30ch)
Robe MegaPointe	8	Mode 1 (39ch)
SGM P-2 + Barn Doors	4	5.2.0 (22ch)
VIDEO		
Item	Qty	Pixel Pitch
600mm Triple Video Header	6	N/A
ROE CB8 600mmx 1200mm	396	8.3mm
Video Tile-600mmx600mm	204	8mm
Video Tile-1200mmx1200mm	280	25mm Blow Through
	~762 M² Total	
SFX		
Item	Qty	Mode (ch)
Blower Fan	12	N/A (0ch)
Co2 Valve	14	N/A (0ch)
Flame Head	20	N/A (0ch)
Generic Laser	18	Beyond 5.0 Mid (32ch)
Hazer	12	2 Channel (2ch)
Martin AF 1 DMX Fan	4	5.2.0 (1ch)
CONTROL		
Item	Qty	Software Version
GrandMA2 Full-Size	2	3.9.60.37
Martin P3 Computer	1	Martin P3
Beyond Computer	1	Beyond 5.0 Ultimate
Generic Cooling/Heating Fan	2	https://a.co/d/hTwl56b
RIGGING		
Item	Qty	Color
12inx12in Box Truss-10ft (Black)	24	Black
19inx19in Pipe Base (Black)	4	Black
2in Sched. 40 Pipe-06ft (Black)	4	Black
Tyler Truss GT-10ft (Black)	54	Black
Tyler Truss GT-CB 2-Way (Black)	24	Black
Tyler Truss GT-05ft (Black)	18	Black
Tyler Truss GT-CB 3-Way (Black)	12	Black
Container Bracket - Bottom (Black)	12	Black
20inx20in Box Truss-10ft (Black)	30	Black