


← DASHER TRUSSES ADJUSTED TO 120'
TO MATCH MASTER SHOW DWG BY CHRIS NYFIELD →


	Robe MegaPointe	42
	Chauvet Strike 4	52
	Elation Artiste Monet	28
	Elation Proteus Maximus	32
	GLP JDC1 Strobe	43
	High End SolaPix 19	40
	Robe BMFL Followspot	8
	Robe BMFL Washbeam	54
	Robe Robin LED Beam 350	184
	Robe Robin Pointe	36
	Robe Spider	48
	30i Laser	3
	AIM Double Barrel Cannon	16
	AIM Silent Storm	4
	Atom 12 AS	30
	Club Cannon Pro Jet	23
	Kvant 30w-3D	12
	Elation ACL 360i	24
	LSG	2
	Smoke Factory Carpet Crawler	1
	Crown Beam	0

Aerosmith Peace Out 2023

OVERVIEW LIGHTING PLAN	Date : 7/28/23
Event location	Scale : 1/8" = 1'-0"
Director :	1 OF 10
Designer : Cosmo Wilson	
Revisions :	

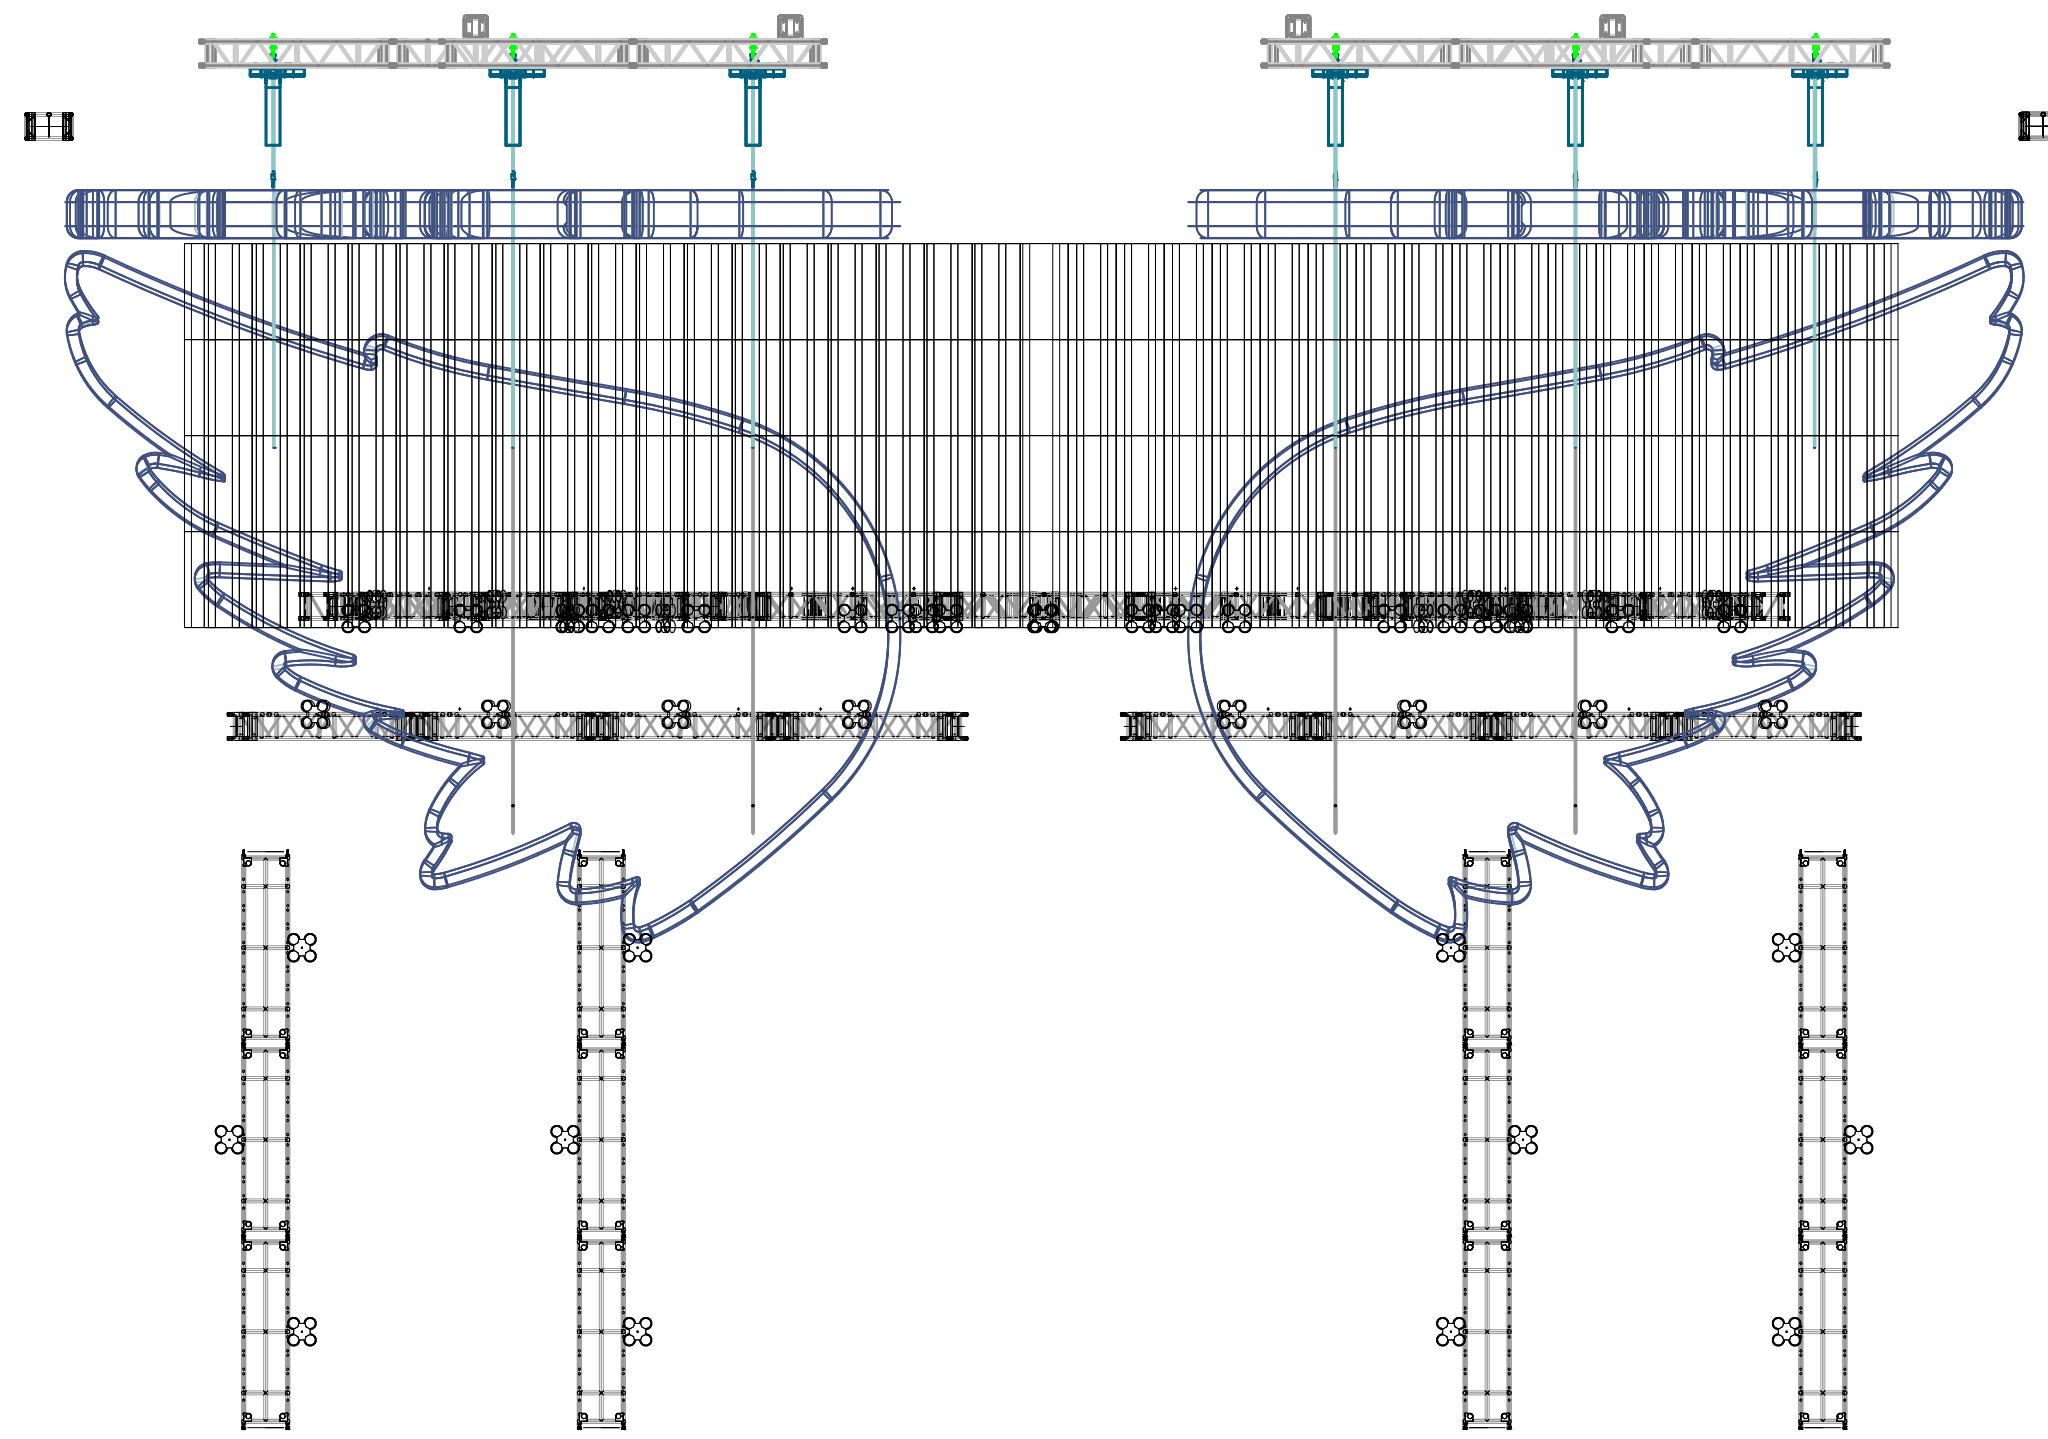

2 Front Elev
Scale: 1/8" = 1'-0"

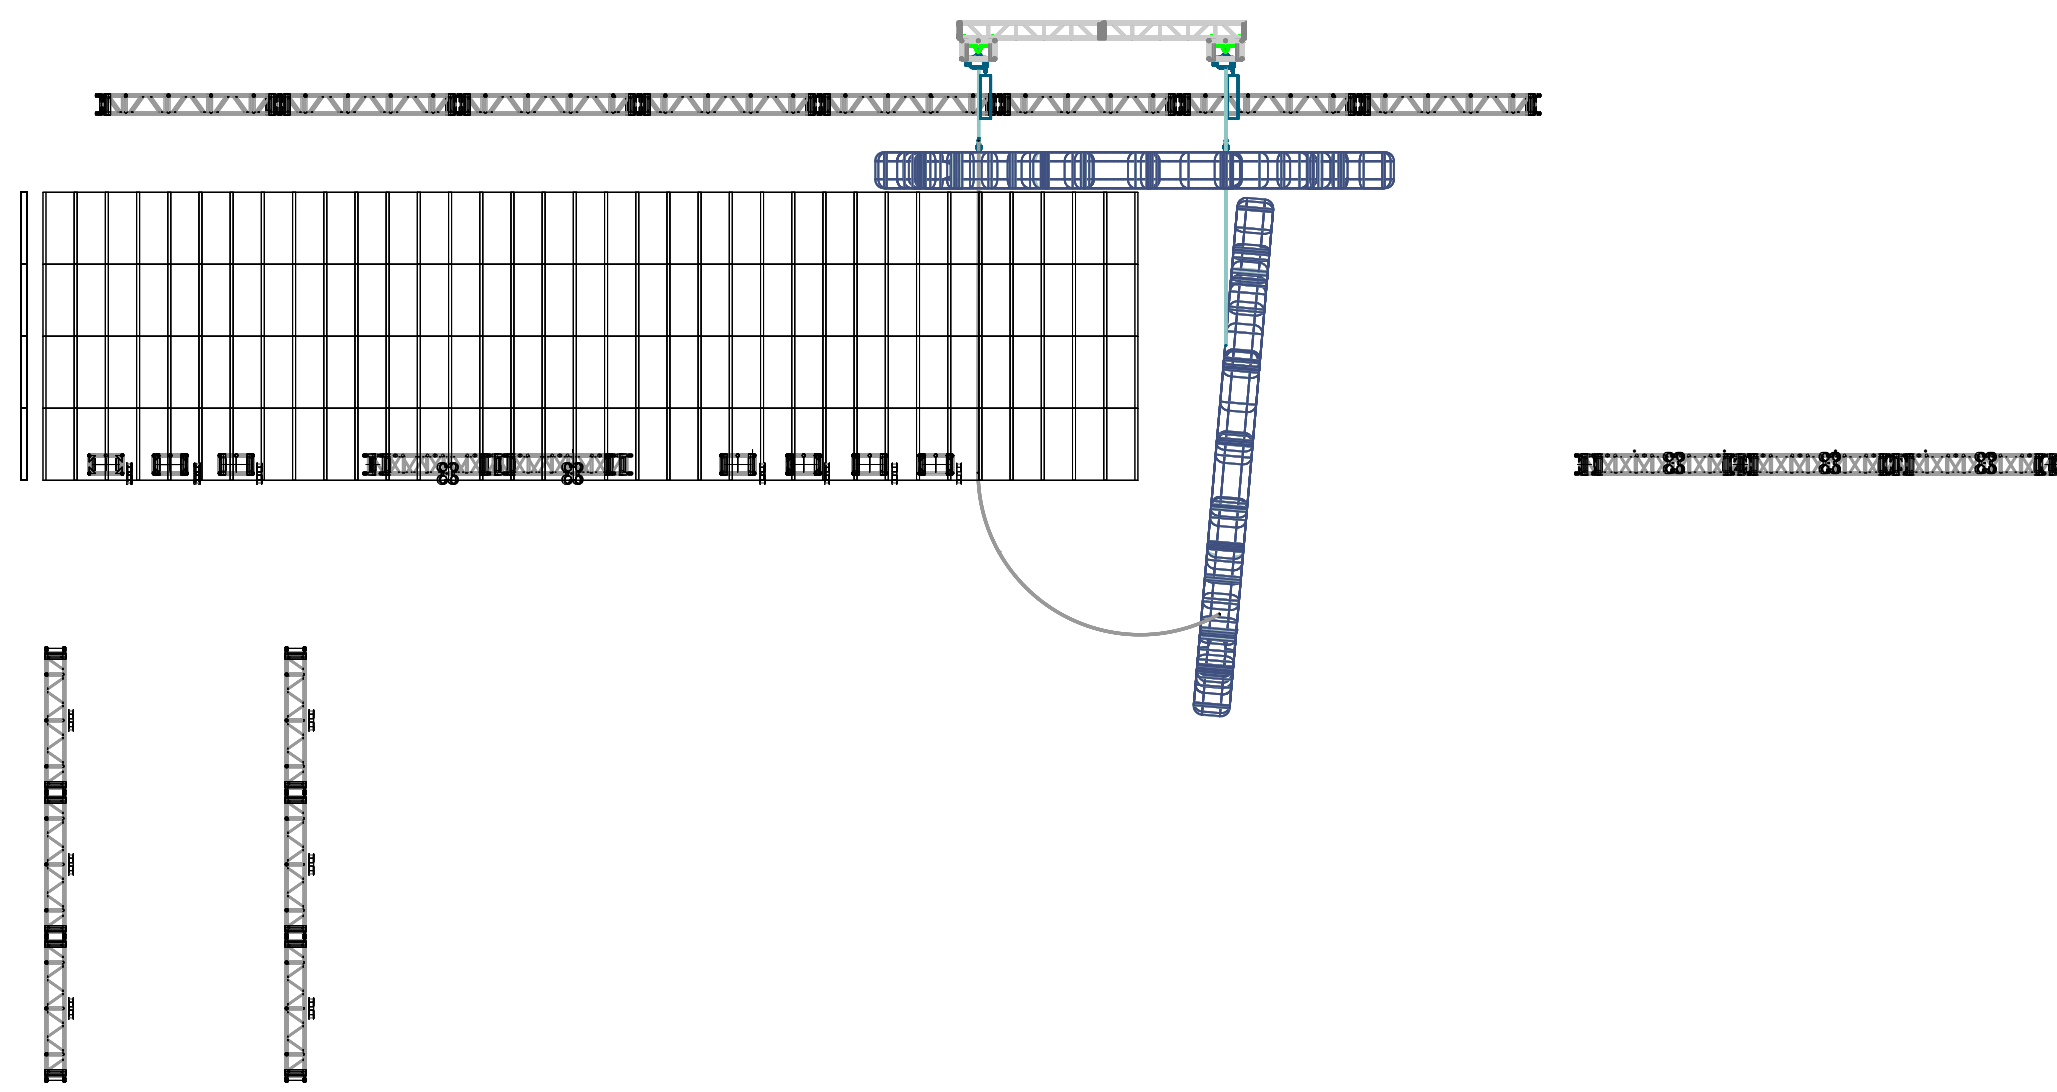


1 side elevation
Scale: 3/32" = 1'-0"


	Robe MegaPointe	42
	Chauvet Strike 4	52
	Elation Artiste Monet	28
	Elation Proteus Maximus	32
	GLP JDC1 Strobe	43
	High End SolaPix 19	40
	Robe BMFL Followspot	8
	Robe BMFL Washbeam	54
	Robe Robin LED Beam 350	184
	Robe Robin Pointe	36
	Robe Spider	48
	301 Laser	3
	AIM Double Barrel Cannon	16
	AIM Silent Storm	4
	Atom 12 AS	30
	Club Cannon Pro Jet	23
	Kvant 30w- 3D	12
	Elation ACL 360i	24
	LSG	2
	Smoke Factory Carpet Crawler	1
	Curtain Beam	0

Aerosmith Peace Out 2023

Multi View Lighting	Date : 7/28/23
Event location	Scale : 1/8" = 1'-0"
Director :	2 OF 10
Designer : Cosmo Wilson	
Revisions :	

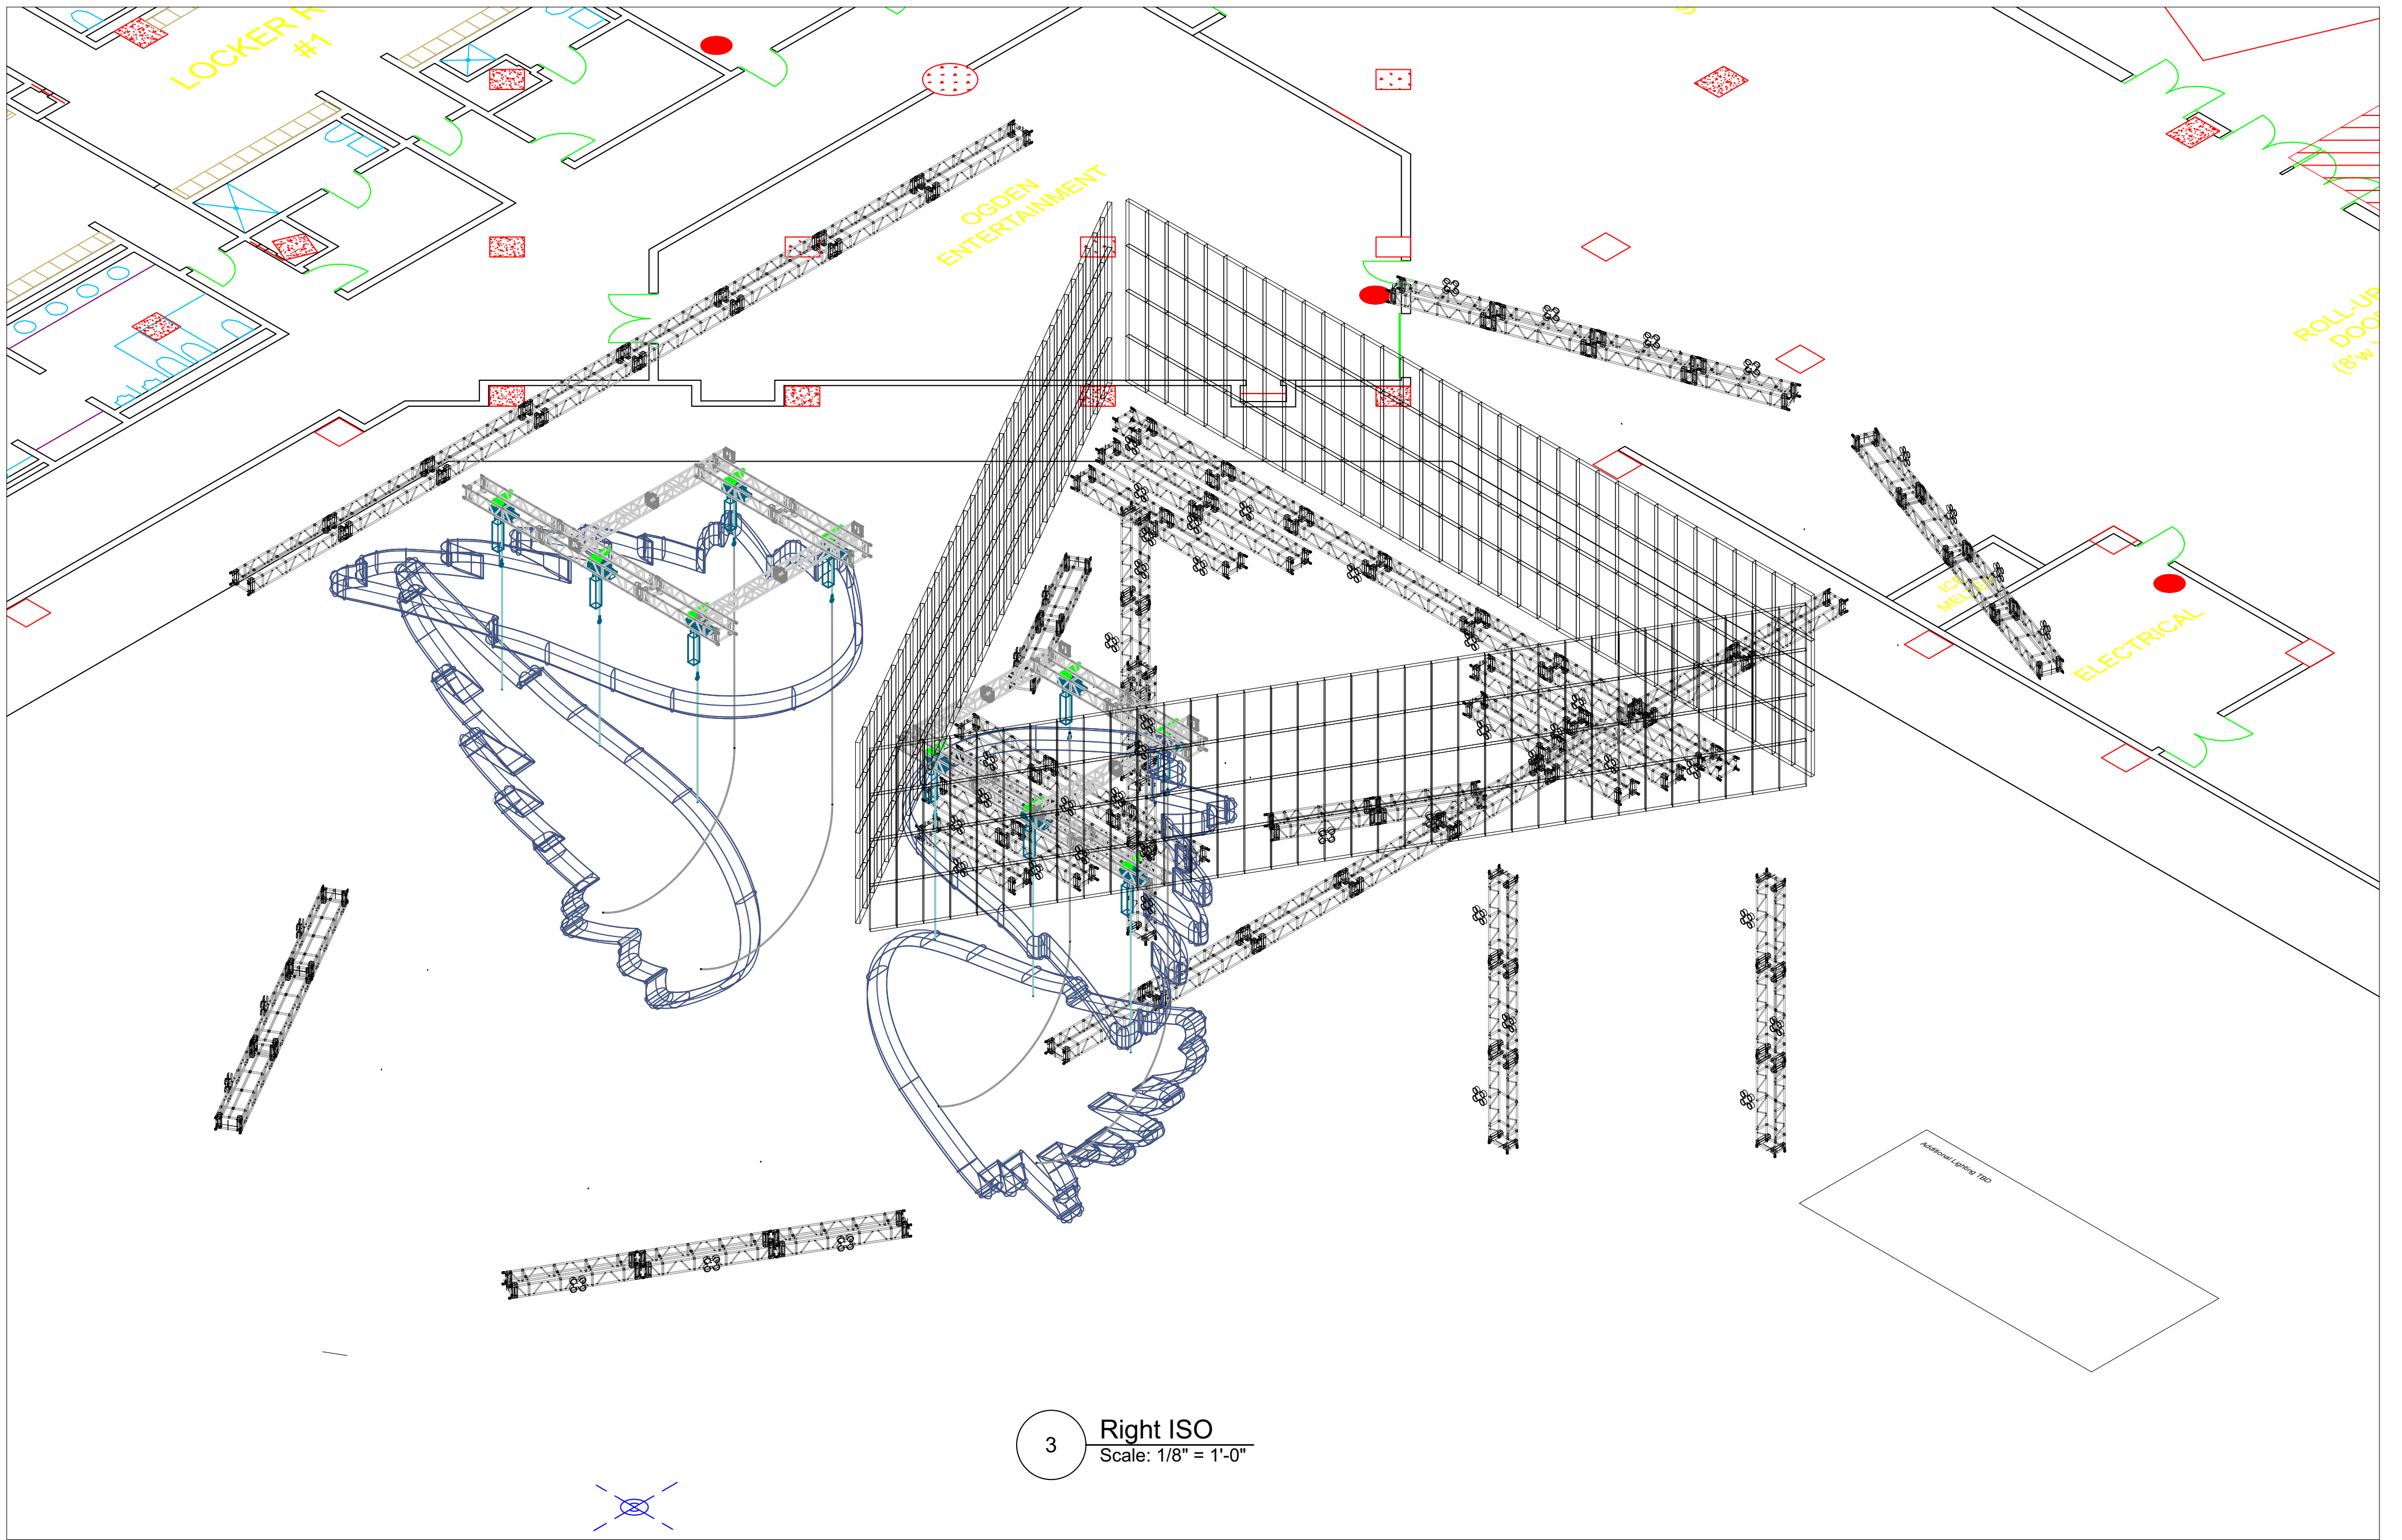

3 Right ISO
Scale: 1/8" = 1'-0"

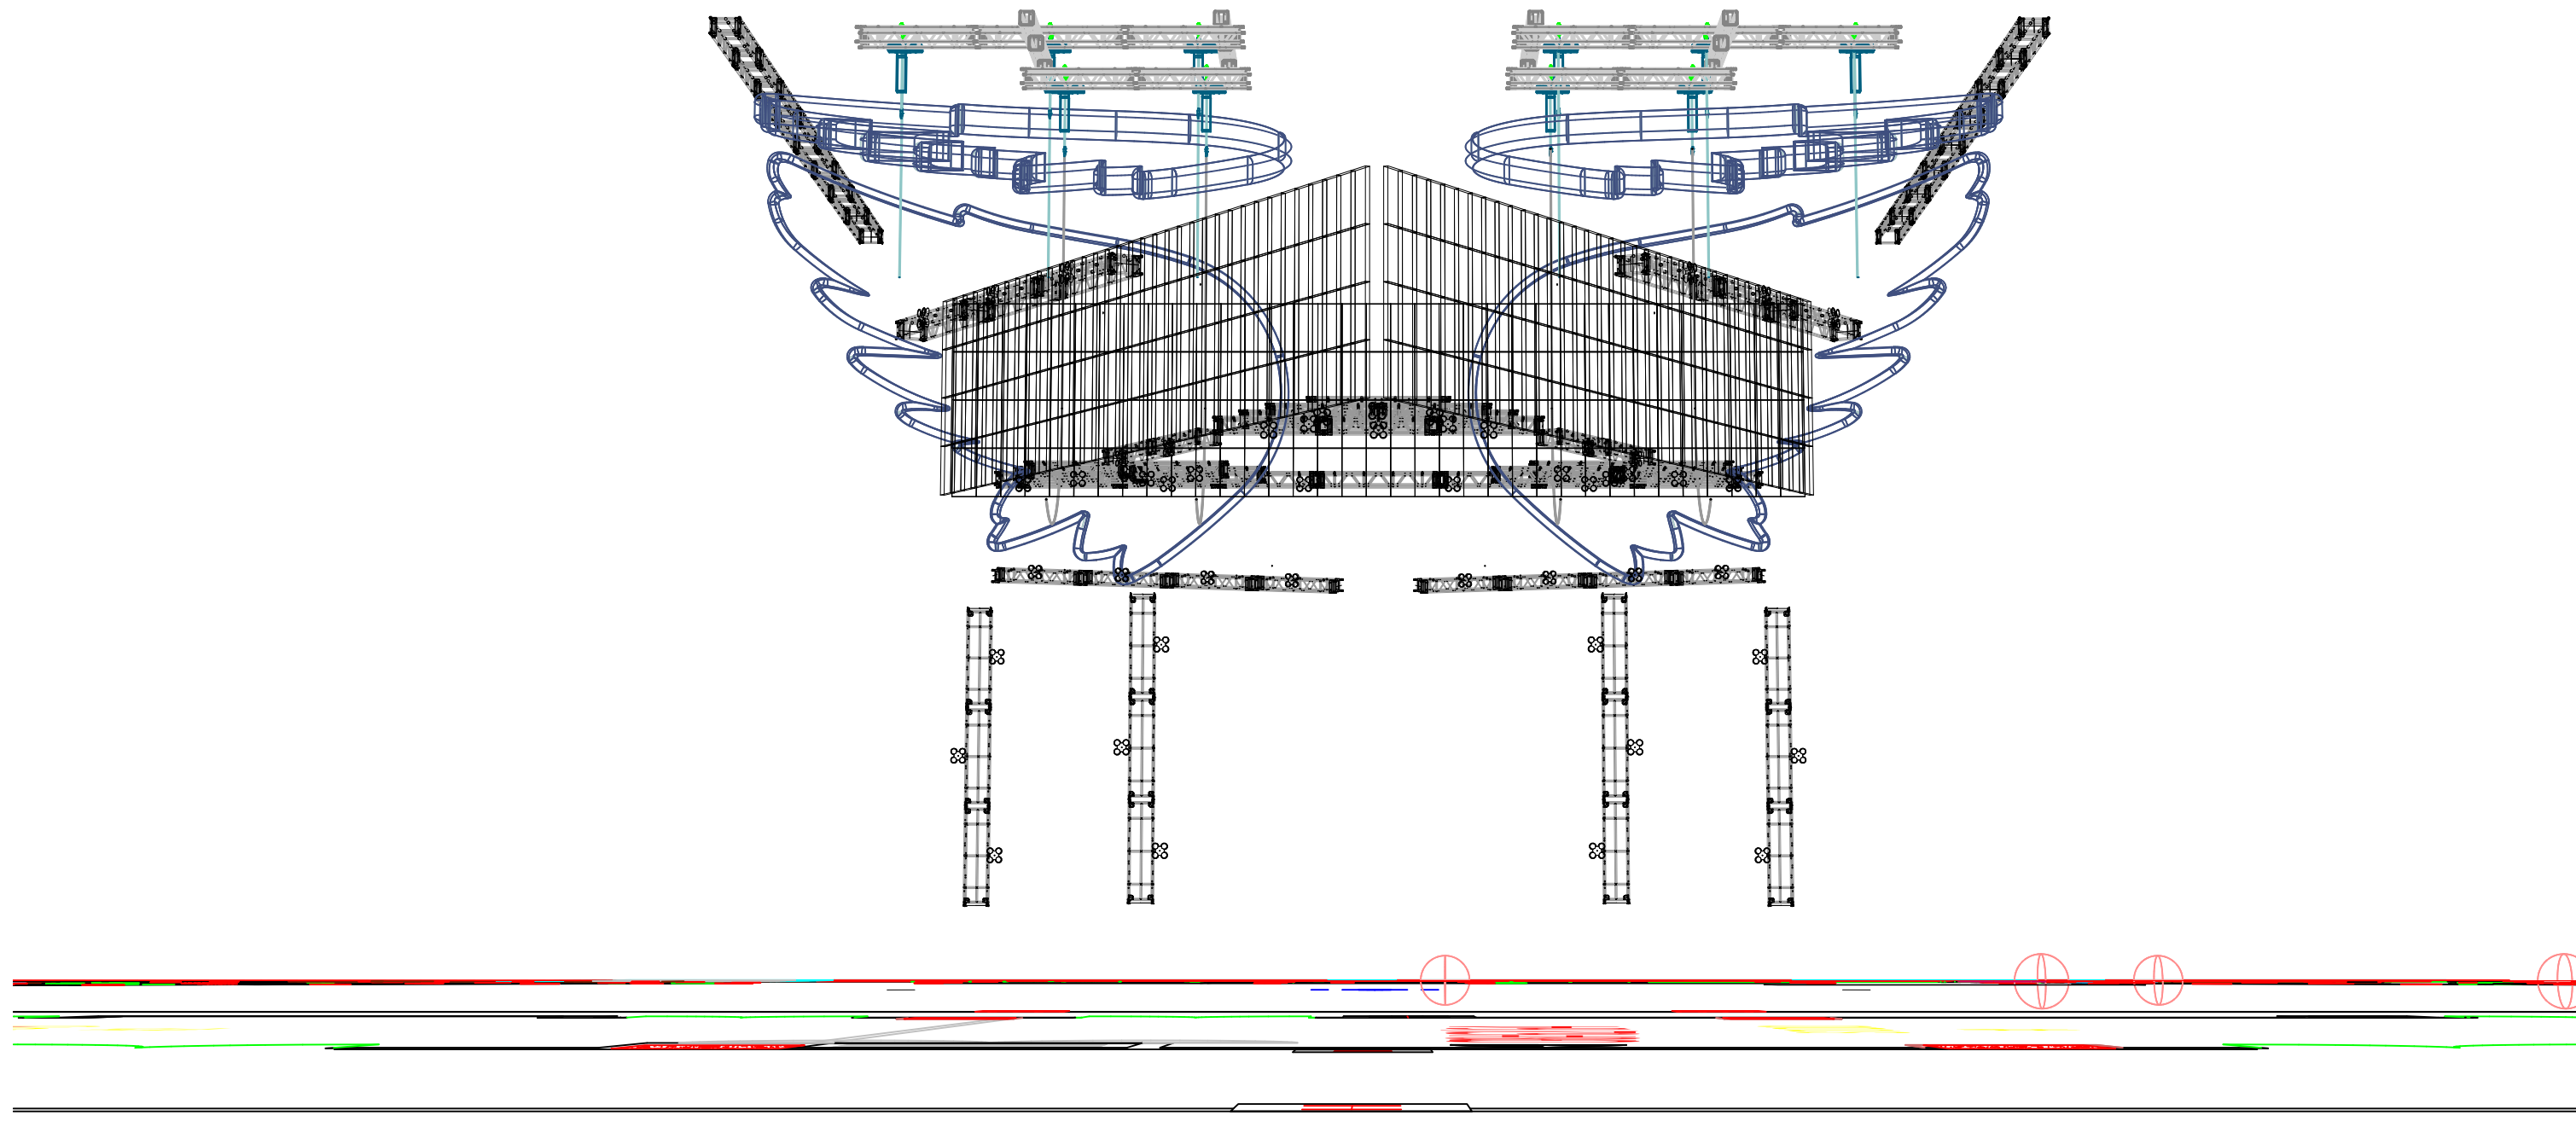


2 Perspective front view
Scale: 3/8" = 1'-0"


	Robe MegaPointe	42
	Chauvet Strike 4	52
	Elation Artiste Monet	28
	Elation Proteus Maximus	32
	GLP JDC1 Strobe	43
	High End SoloPix 19	40
	Robe BMFL Followspot	8
	Robe BMFL Washbeam	54
	Robe Robin LED Beam 350	184
	Robe Robin Pointe	36
	Robe Spider	48
	30i Laser	3
	AIM Double Barrel Cannon	16
	AIM Silent Storm	4
	Atom 12 AS	30
	Club Cannon Pro Jet	23
	Kvant 30w- 3D	12
	Elation ACL 360i	24
	LSG	2
	Smoke Factory Carpet Crawler	1
	Cable Dancer	6

Aerosmith Peace Out 2023

Orthogonal Lighting View	Date : 7/28/23
Event location	Scale : 1/8" = 1'-0"
Director :	3 OF 10
Designer : Cosmo Wilson	
Revisions :	

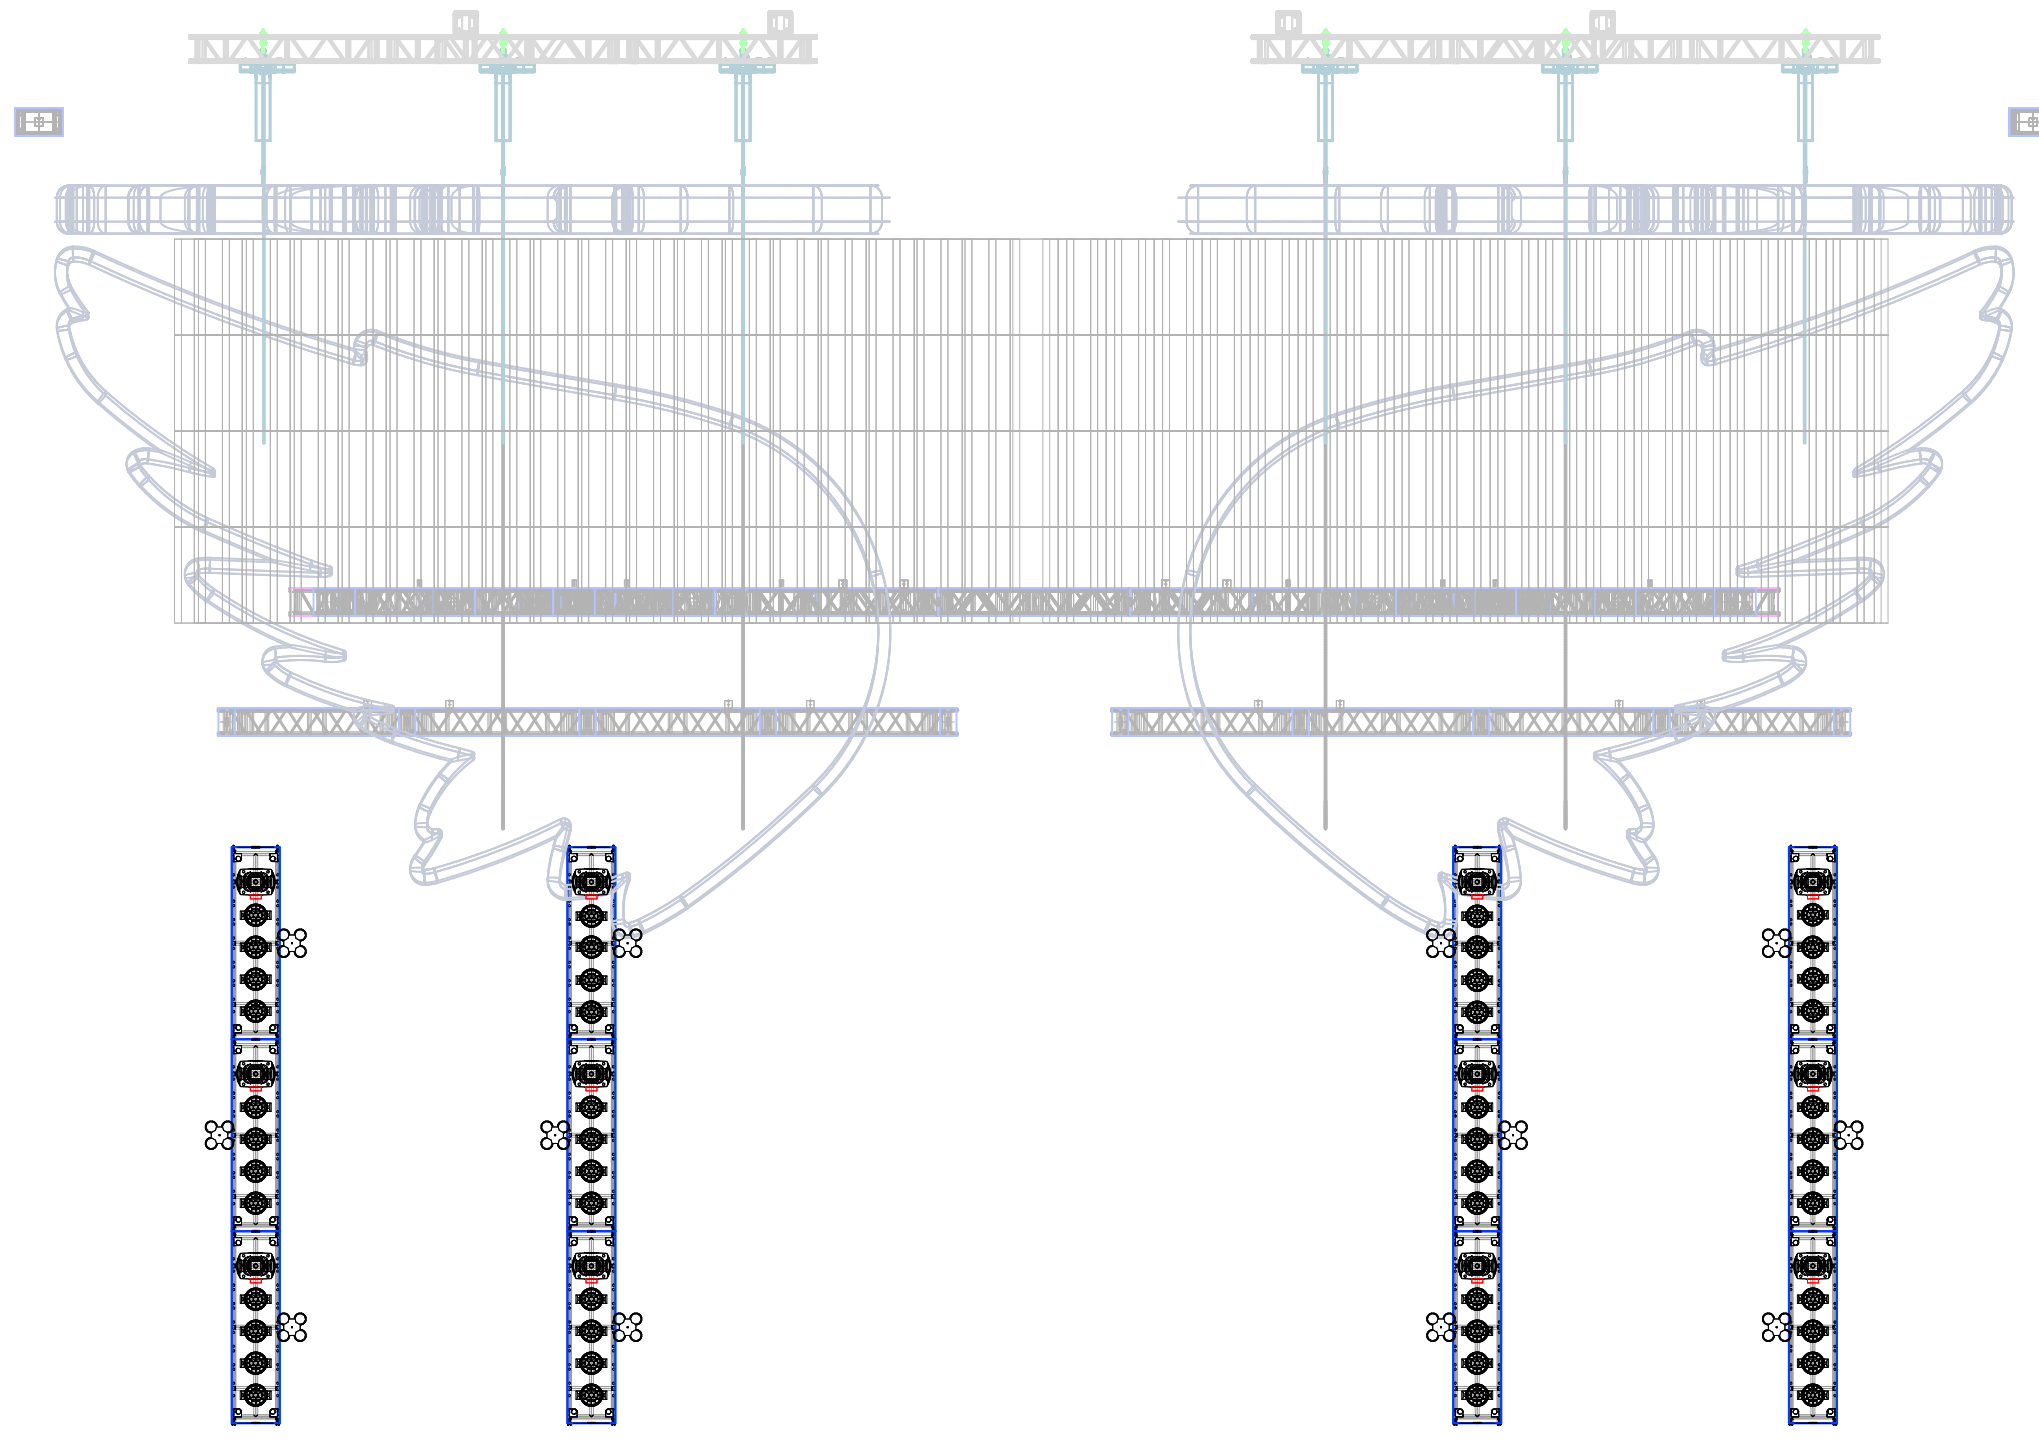


1 20' Solid ladder US
Scale: 1/8" = 1'-0"

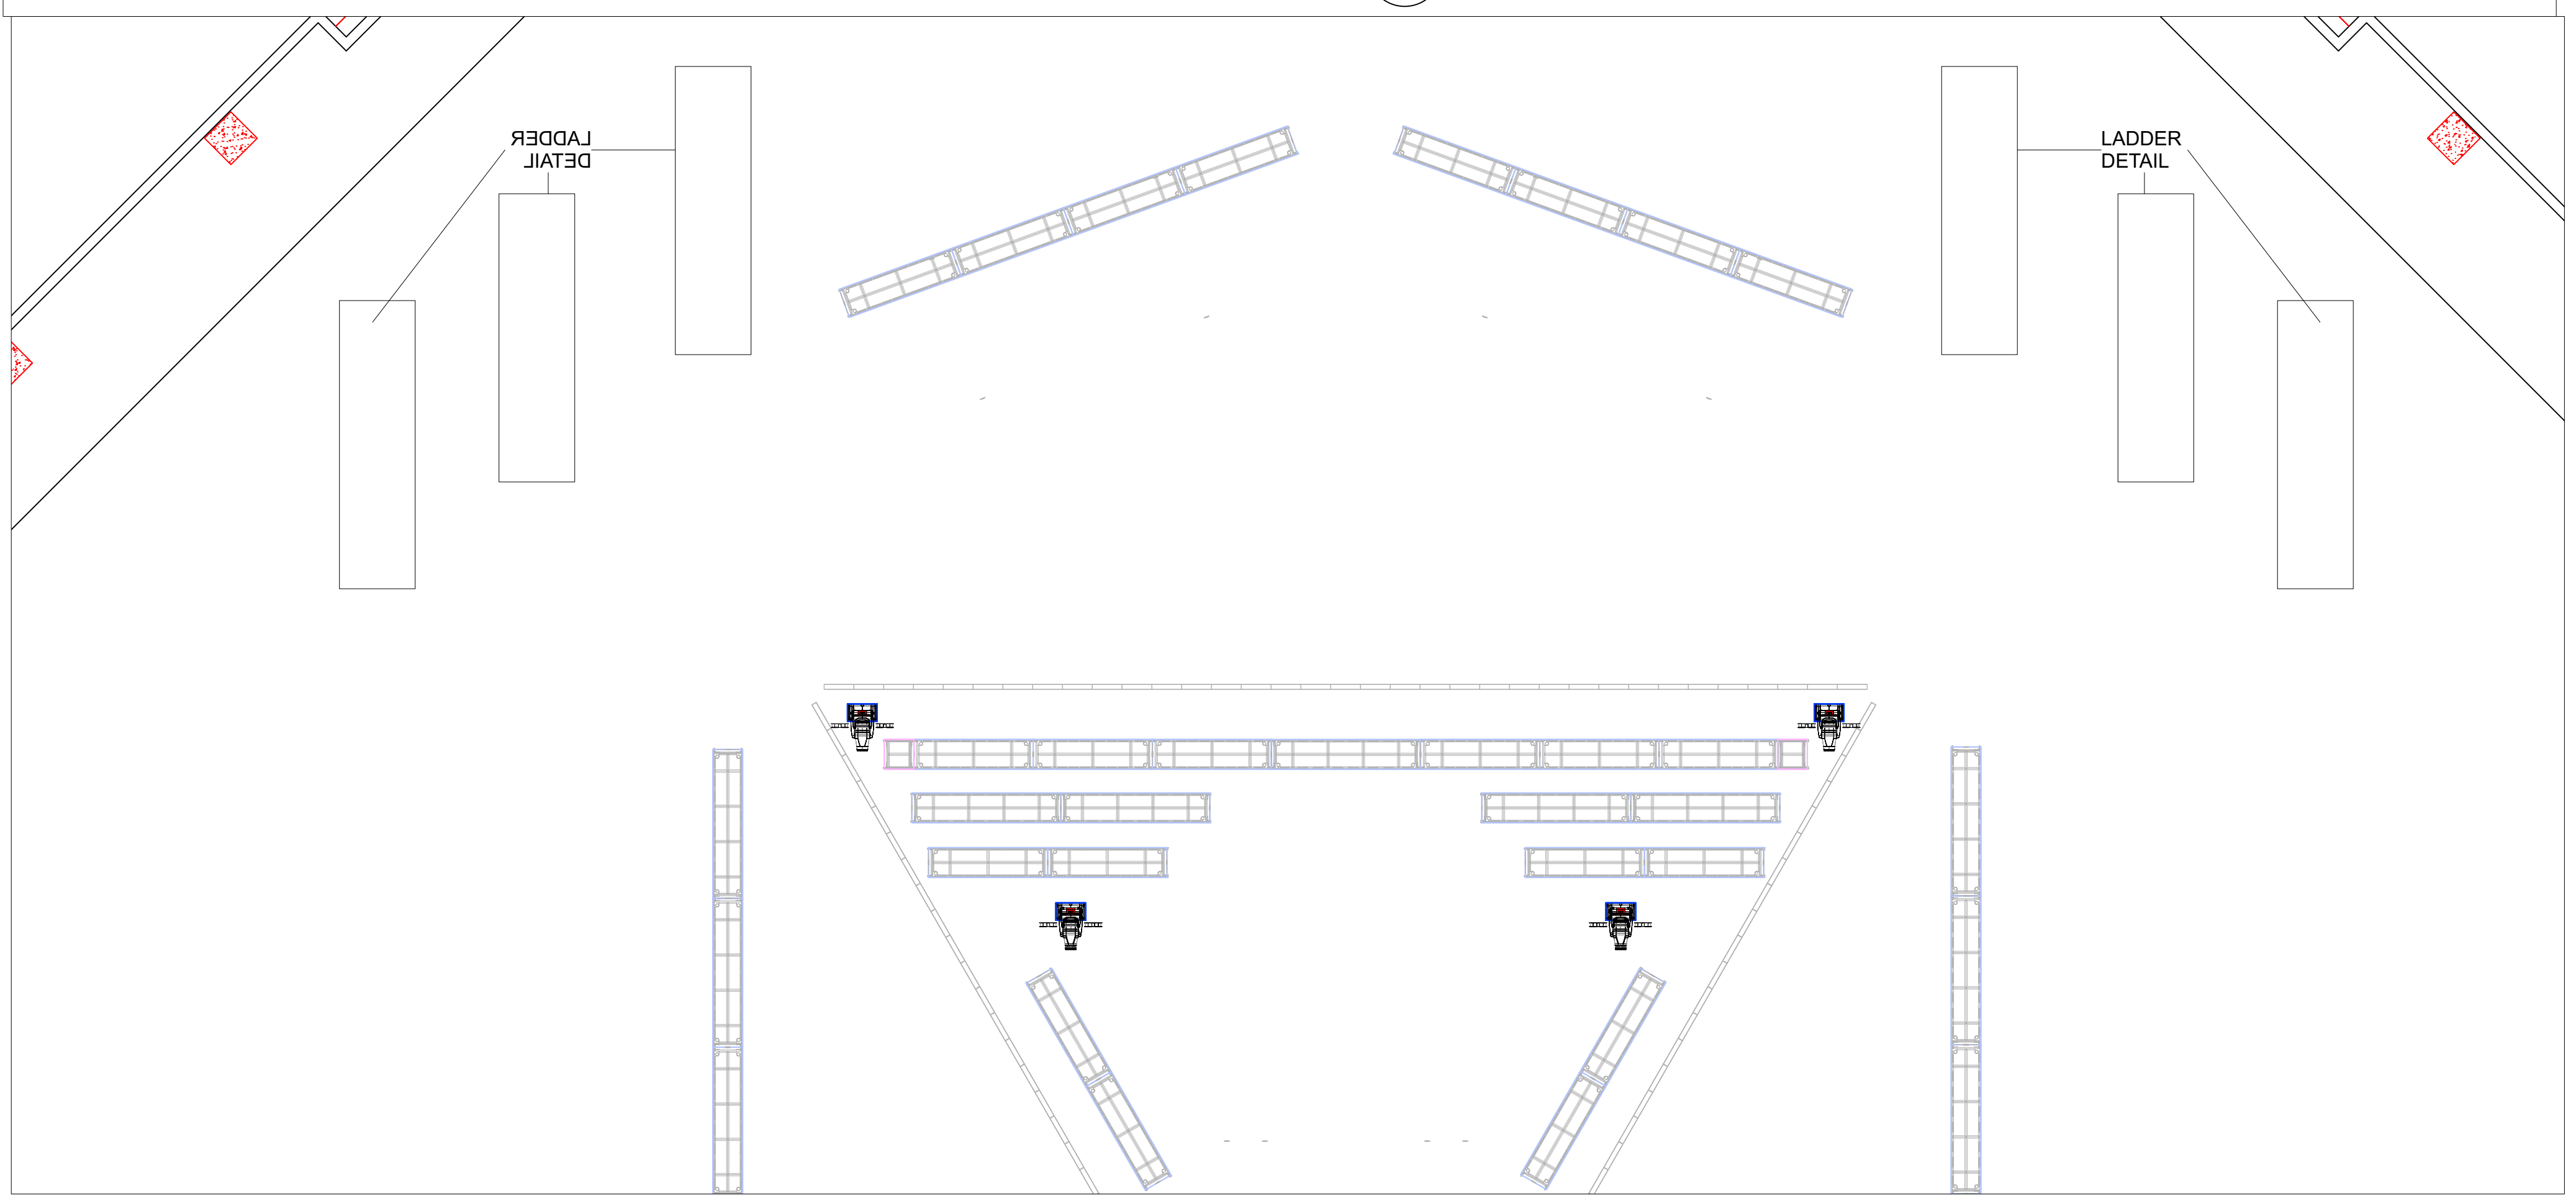

4 20' single ladders
Scale: 1/8" = 1'-0"

5 Detail 20' ladder
Scale: 1/2" = 1'-0"

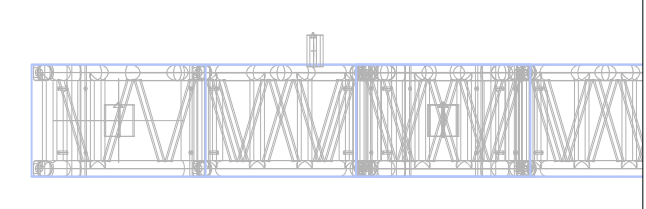


2 20' Solid ladder US Plan view
Scale: 1/8" = 1'-0"

	Robe MegaPointe	42
	Chauvet Strike 4	52
	Elation Artiste Monet	28
	Elation Proteus Maximus	32
	GLP JDC1 Strobe	43
	High End SolaPix 19	40
	Robe BMFL Followspot	8
	Robe BMFL Washbeam	54
	Robe Robin LED Beam 350	184
	Robe Robin Pointe	36
	Robe Spider	48
	30i Laser	3
	AIM Double Barrel Cannon	16
	AIM Silent Storm	4
	Atom 12 AS	30
	Club Cannon Pro Jet	23
	Kvant 30w- 3D	12
	Elation ACL 360i	24
	LSG	2
	Smoke Factory Carpet Crawler	1
		0


Aerosmith Peace Out 2023

Lighting ladders US	Date : 7/28/23
Event location	Scale : 1/8" = 1'-0"
Director :	4 OF 10
Designer : Cosmo Wilson	
Revisions :	

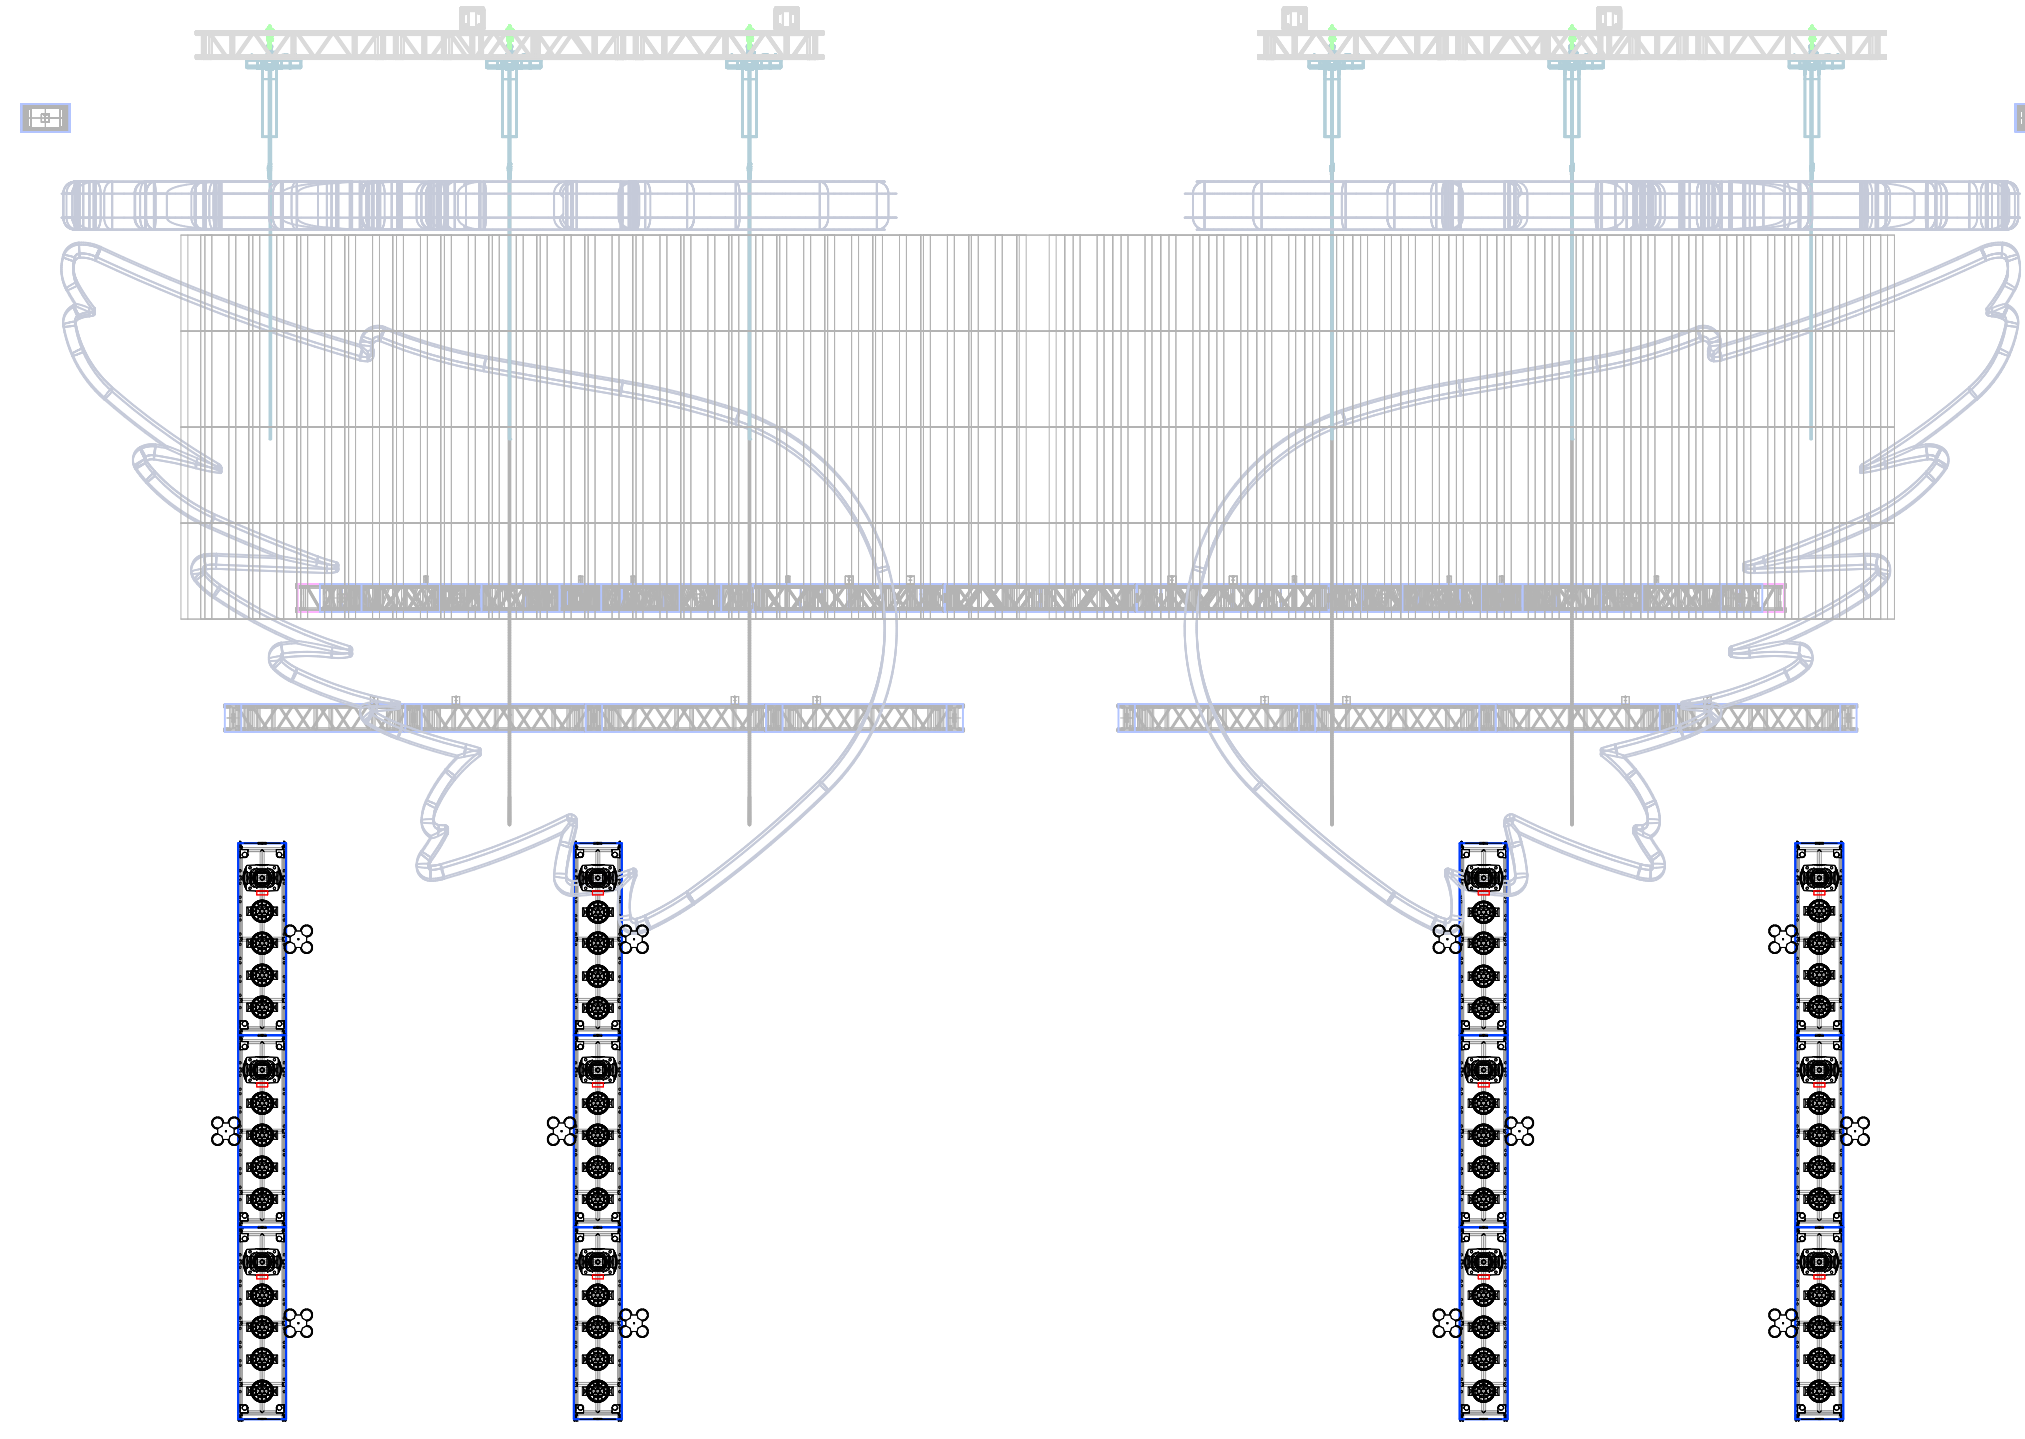


1 20' Solid ladder US
Scale: 1/8" = 1'-0"


4 SR LADDERS SINGLE 24' OPTION
Scale: 1/4" = 1'-0"

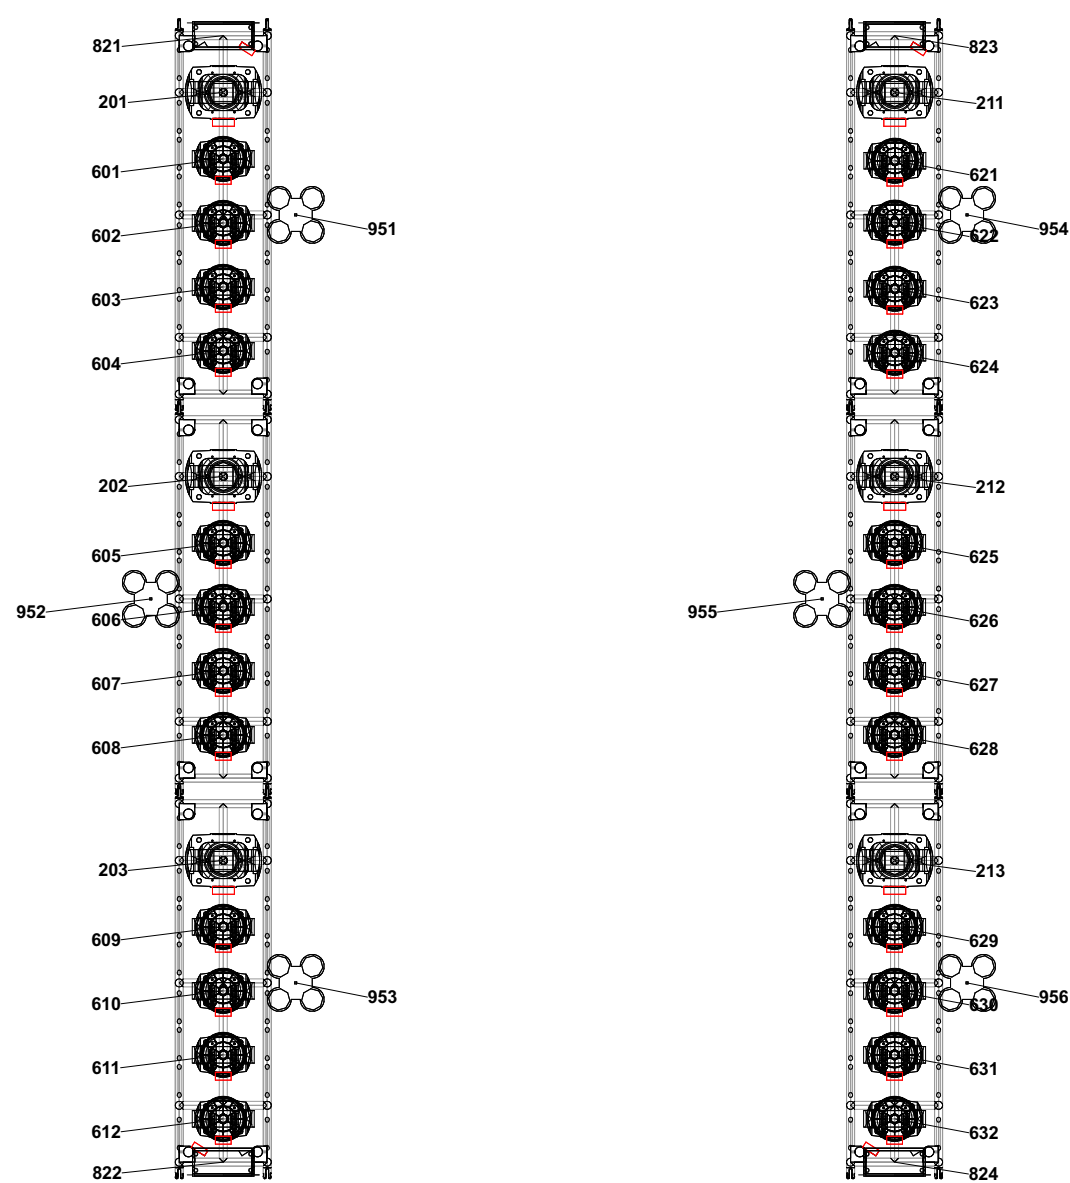

3 SL LADDERS SINGLE 24' OPTION
Scale: 1/4" = 1'-0"

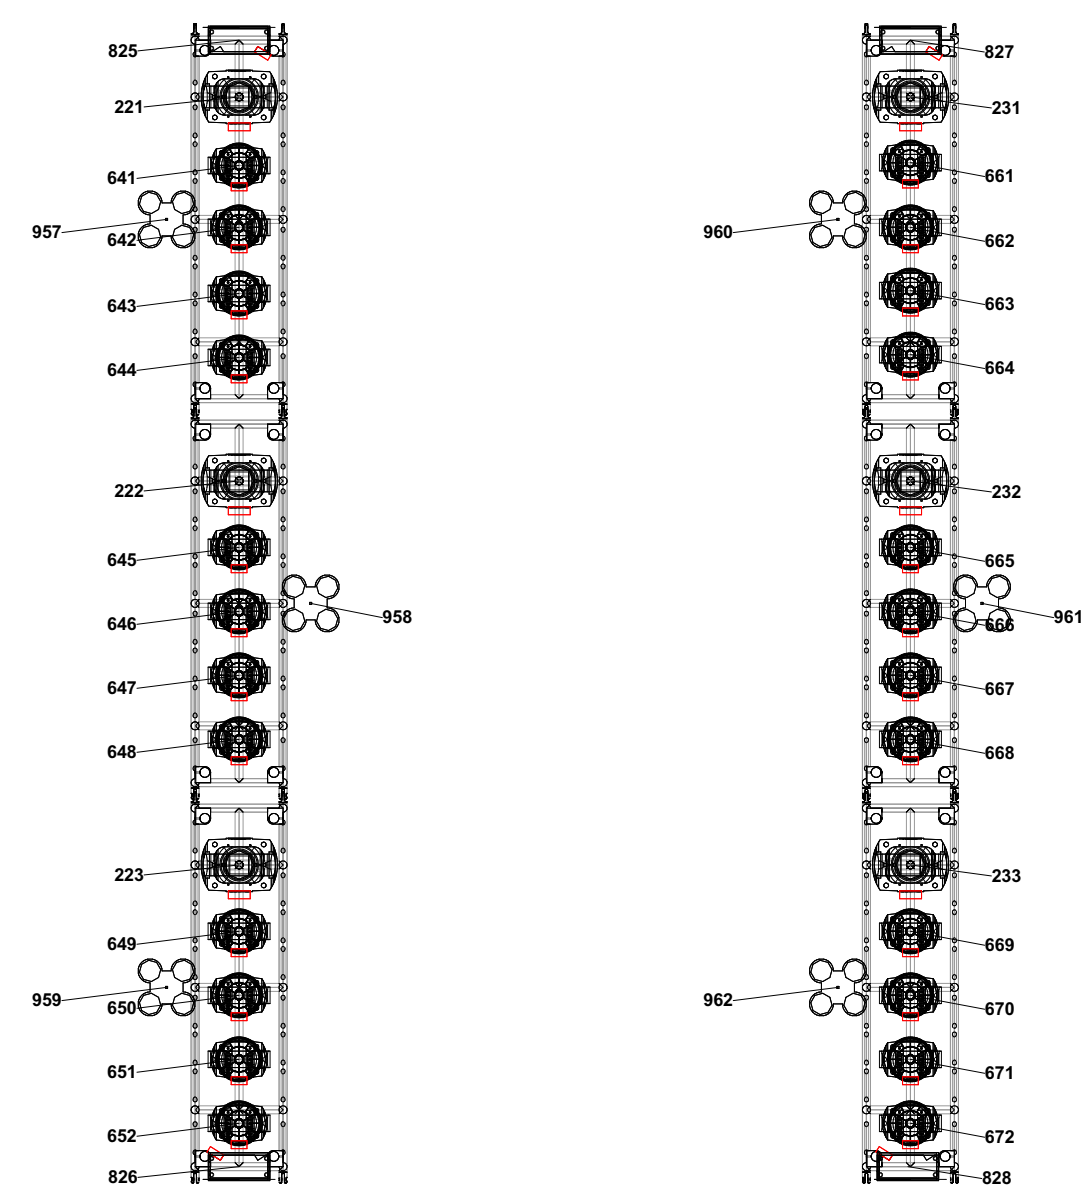


	Robe MegaPointe	42
	Chauvet Strike 4	52
	Elation Artiste Monet	28
	Elation Proteus Maximus	32
	GLP JDC1 Strobe	43
	High End SolaPix 19	40
	Robe BMFL Followspot	8
	Robe BMFL Washbeam	54
	Robe Robin LED Beam 350	184
	Robe Robin Pointe	36
	Robe Spider	48
	30i Laser	3
	AIM Double Barrel Cannon	16
	AIM Silent Storm	4
	Atom 12 AS	30
	Club Cannon Pro Jet	23
	Kvant 30w- 3D	12
	Elation ACL 360i	24
	LSG	2
	Smoke Factory Carpet Crawler	1
	Curtain Beam	0

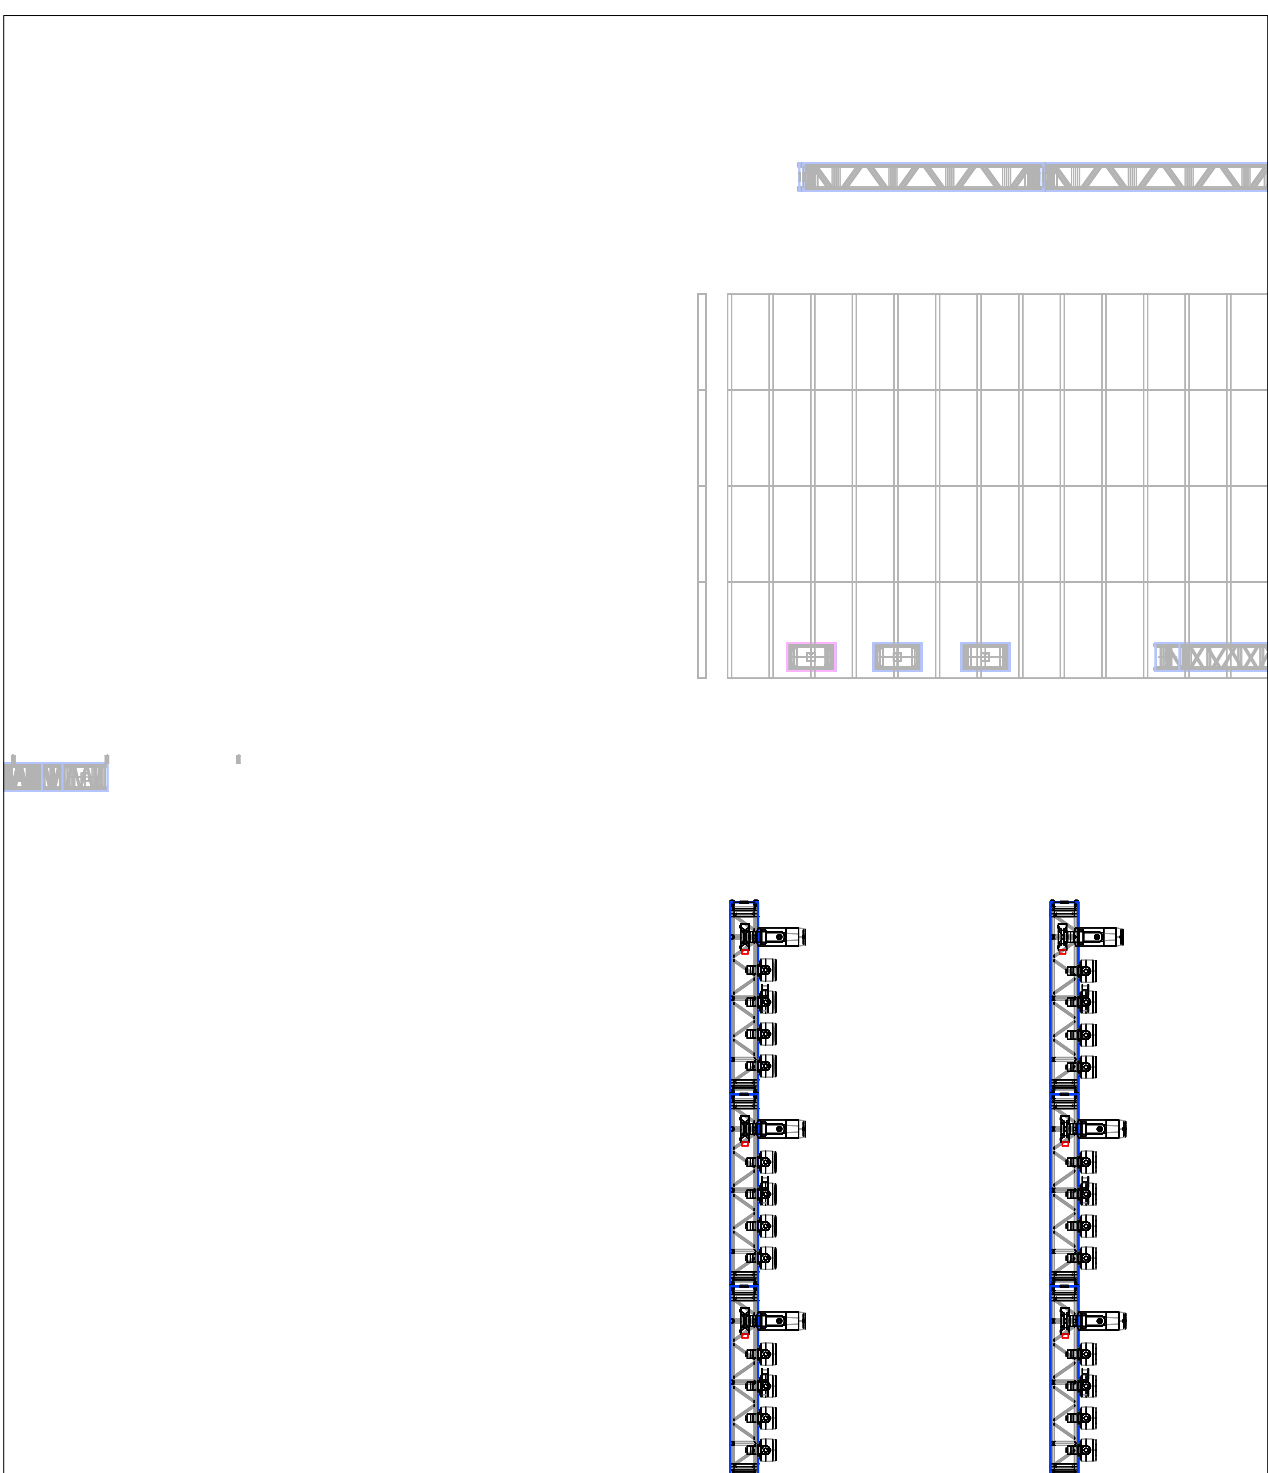

10 20' single ladders
Scale: 1/8" = 1'-0"

Aerosmith Peace Out 2023	
Lighting ladder DETAIL	Date : 7/28/23
Event location	Scale : 1/8" = 1'-0"
Director :	5 OF 10
Designer : Cosmo Wilson	
Revisions :	

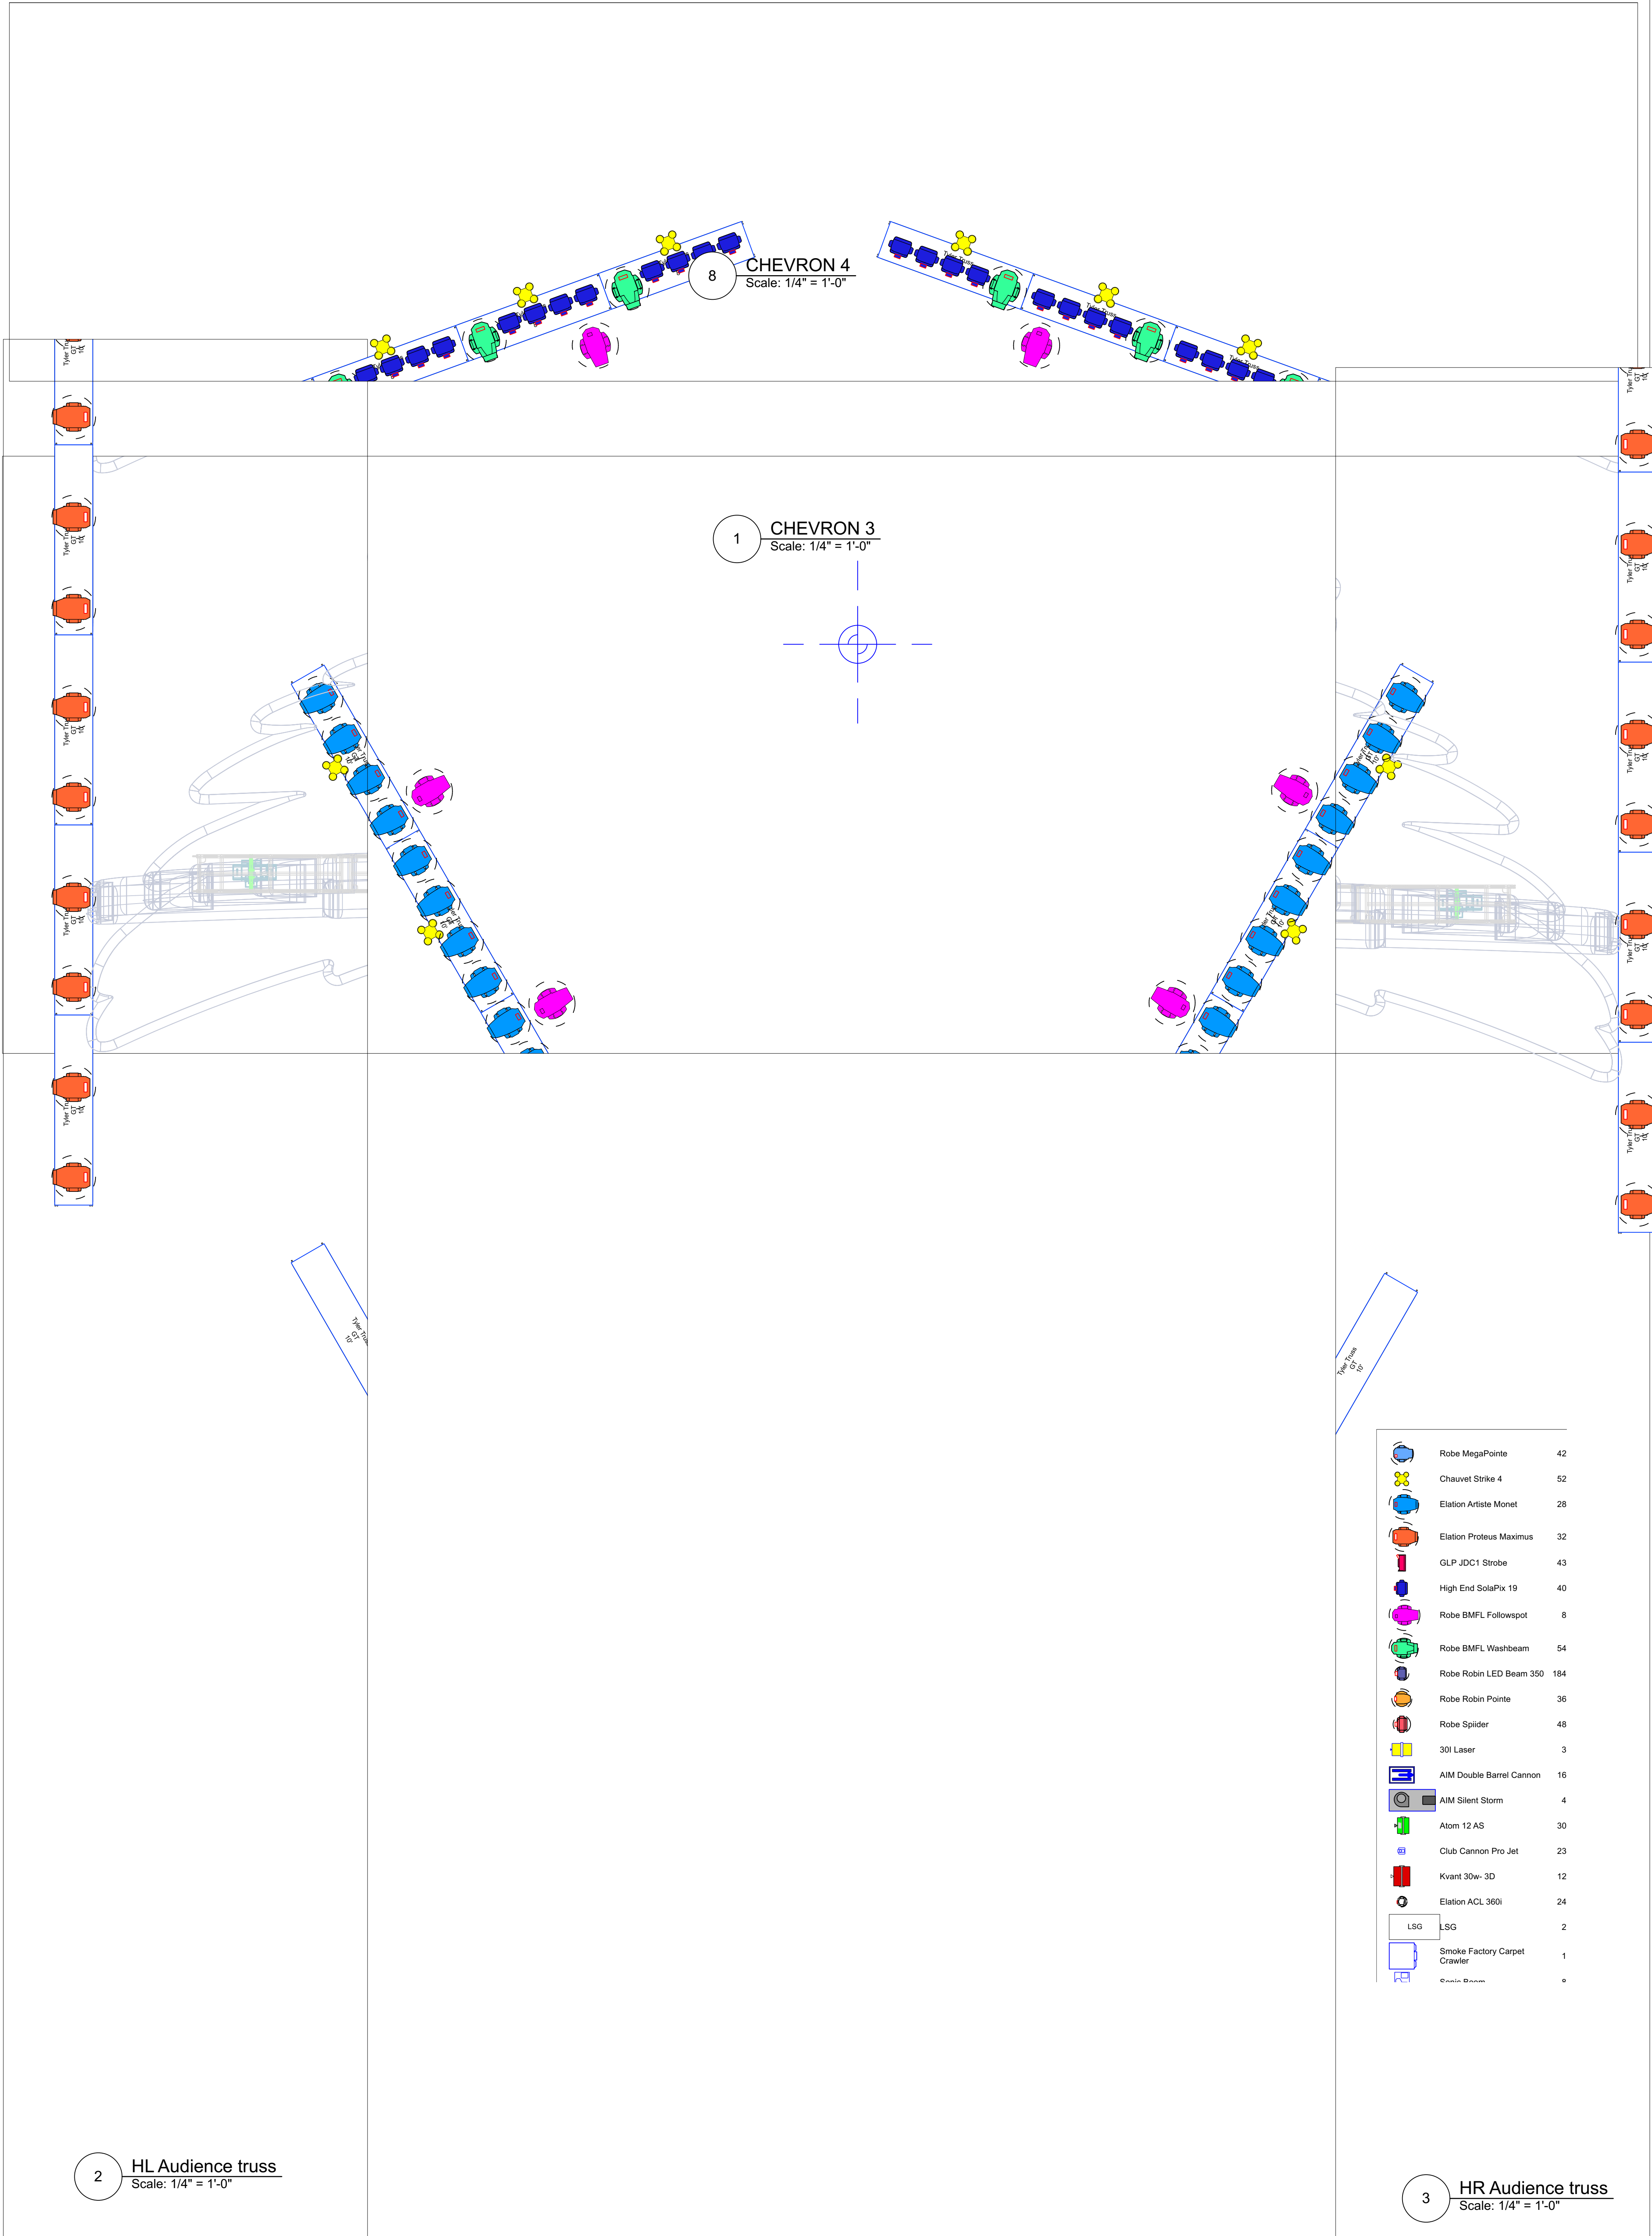

1 CHEVRON 3
Scale: 1/4" = 1'-0"

8 CHEVRON 4
Scale: 1/4" = 1'-0"


2 HL Audience truss
Scale: 1/4" = 1'-0"

3 HR Audience truss
Scale: 1/4" = 1'-0"




 



 

 
 
 
 


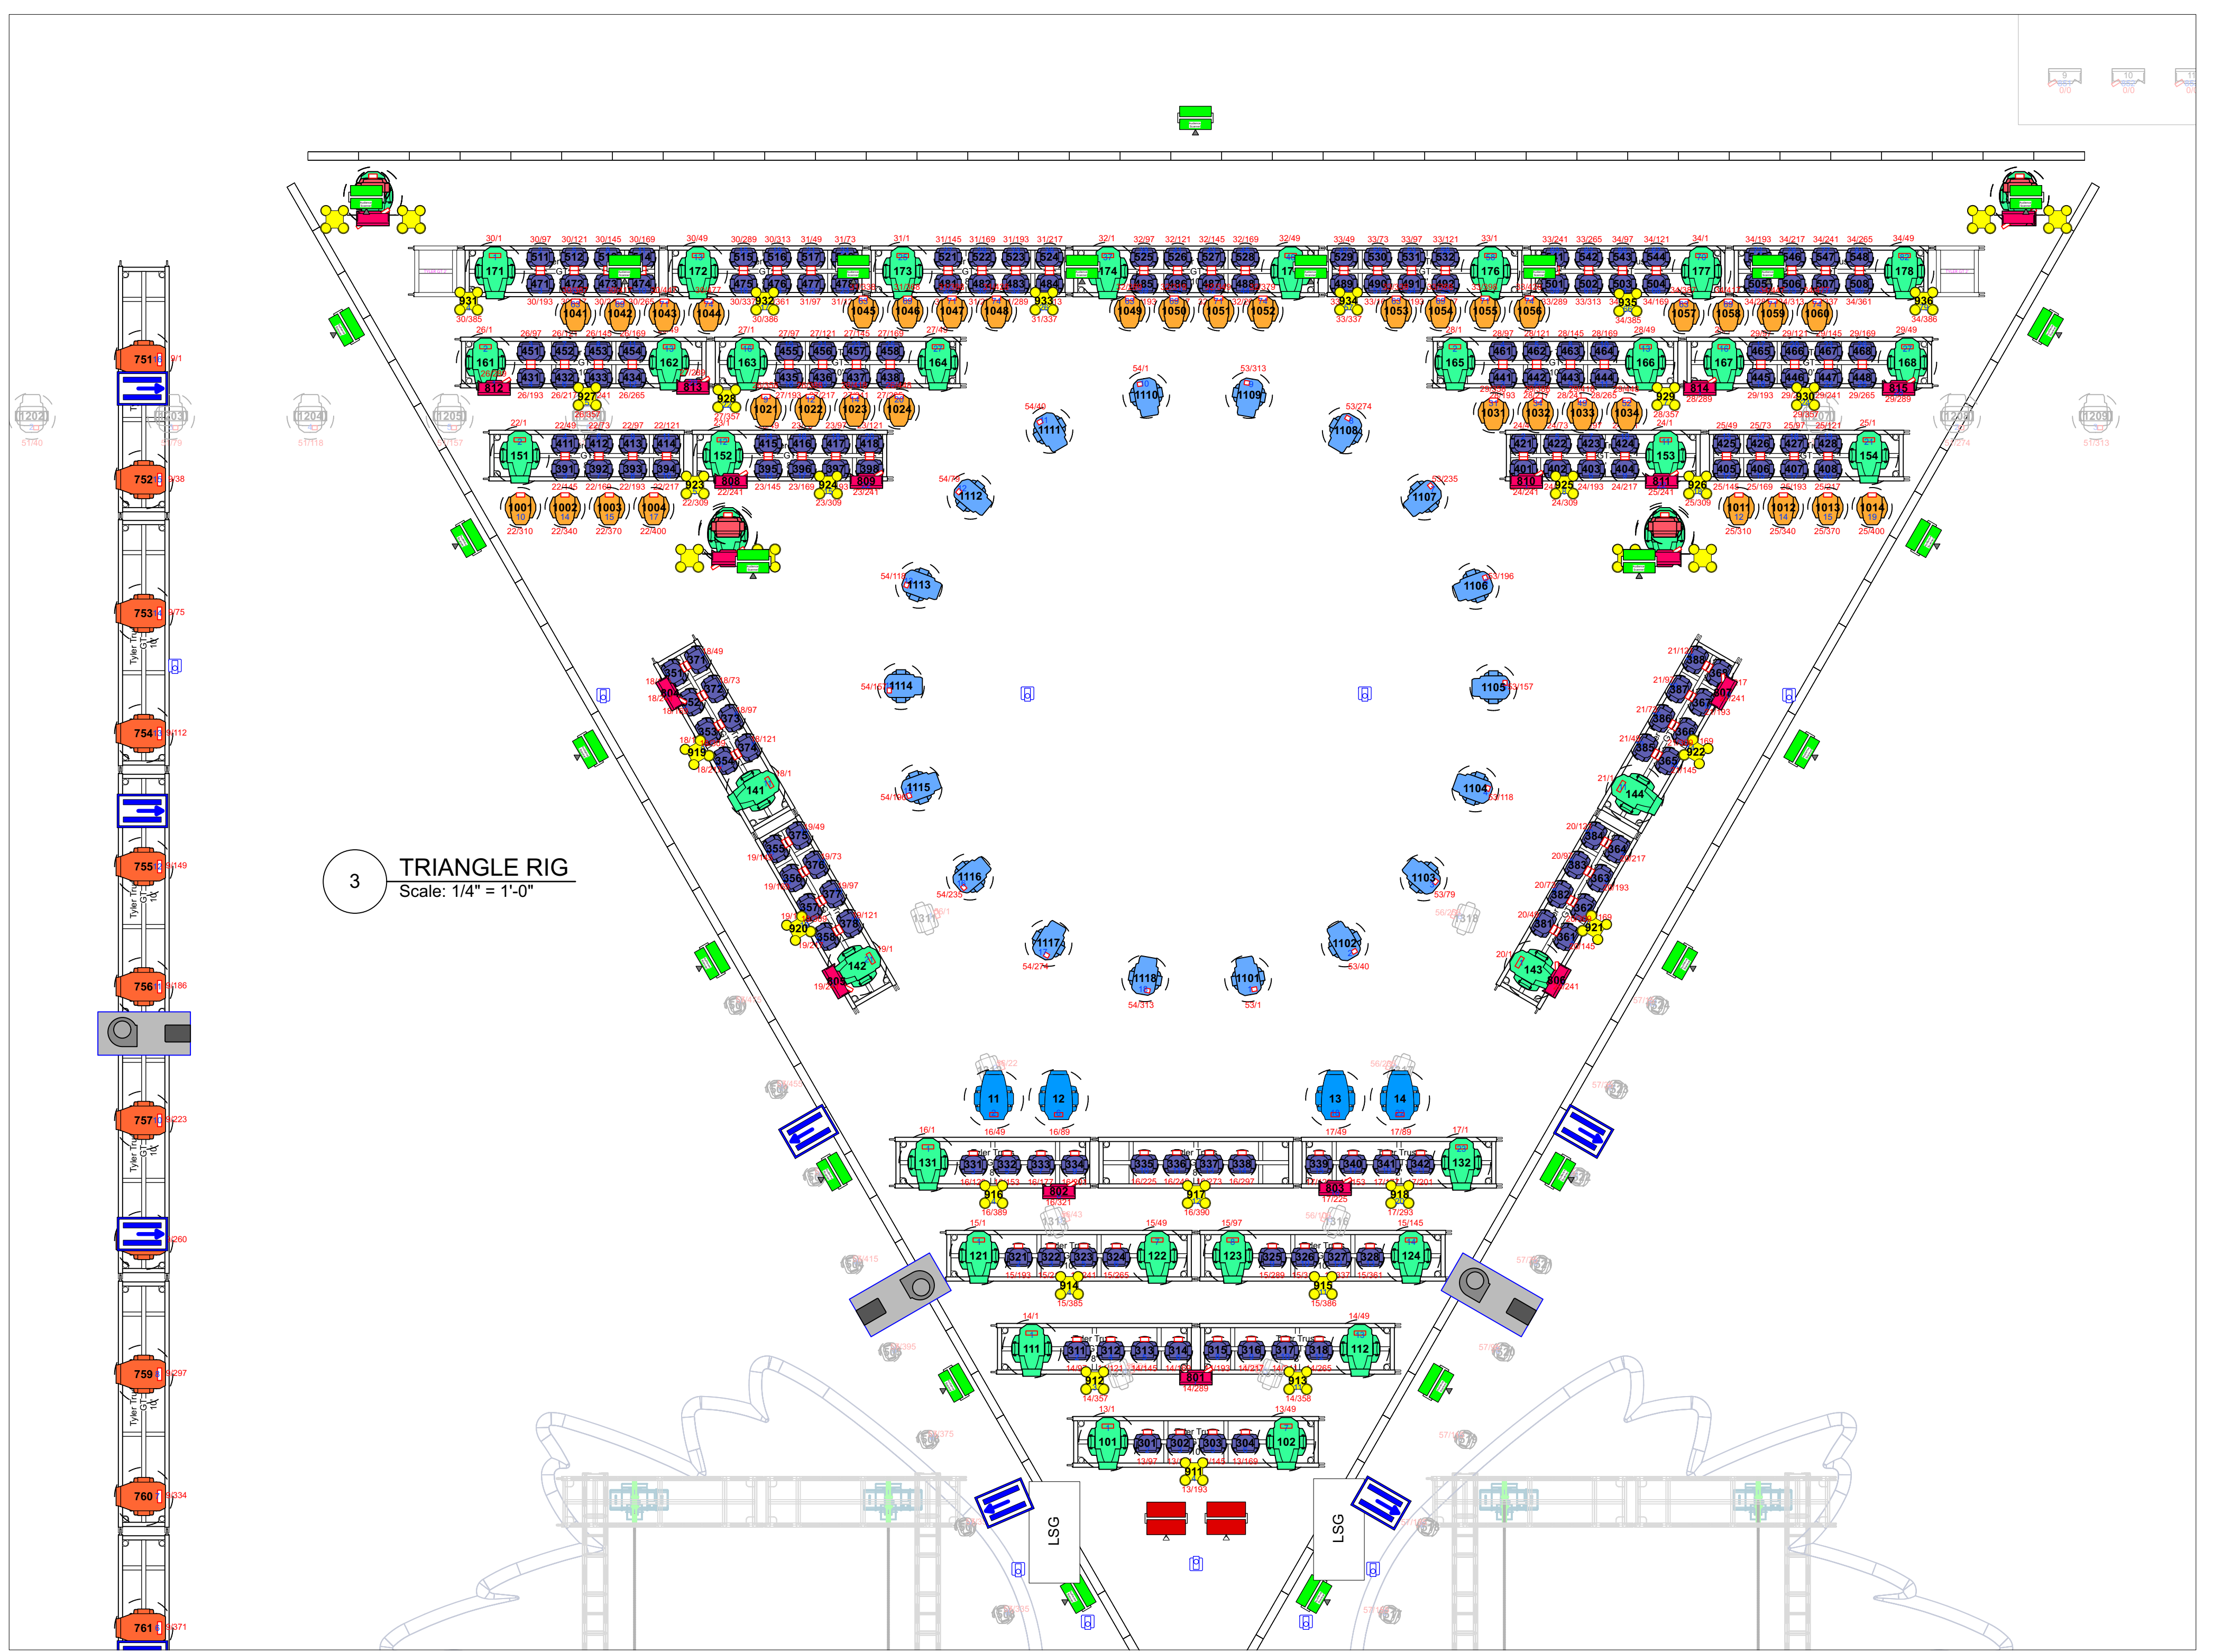

 
 
 
 
	Robe MegaPoint	42
	Chauvet Strike 4	52
	Elation Artiste Monet	28
	Elation Proteus Maximus	32
	GLP JDC1 Strobe	43
	High End SolaPix 19	40
	Robe BMFL Followspot	8
	Robe BMFL Washbeam	54
	Robe Robin LED Beam 350	184
	Robe Robin Pointe	36
	Robe Spider	48
	30i Laser	3
	AIM Double Barrel Cannon	16
	AIM Silent Storm	4
	Atom 12 AS	30
	Club Cannon Pro Jet	23
	Kvant 30w- 3D	12
	Elation ACL 360i	24
	LSG	2
	Smoke Factory Carpet Crawler	1
	Smoke Factory	9

Aerosmith Peace Out 2023

CHEVRON OH AND ELEV	Date : 7/28/23
Event location	Scale : 1/8" = 1'-0"
Director :	6 OF 10
Designer : Cosmo Wilson	
Revisions :	



3 TRIANGLE RIG
Scale: 1/4" = 1'-0"

-  Robe MegaPointe 42
-  Chauvet Strike 4 52
-  Elation Artiste Monet 28
-  Elation Proteus Maximus 32
-  GLP JDC1 Strobe 43
-  High End SolaPix 19 40
-  Robe BMFL Followspot 8
-  Robe BMFL Washbeam 54
-  Robe Robin LED Beam 350 184
-  Robe Robin Pointe 36
-  Robe Spider 48
-  30i Laser 3
-  AIM Double Barrel Cannon 16
-  AIM Silent Storm 4
-  Atom 12 AS 30
-  Club Cannon Pro Jet 23
-  Kvant 30w- 3D 12
-  Elation ACT 360i 24
-  LSG LSG 2
-  Smoke Factory Carpet Crawler 1
-  Cable Bunch 0

Aeromsmith Peace Out 2023	
PLAN VIEW OH LIGHTING	Date : 7/28/23
Event location	Scale : 1/8" = 1'-0"
Director :	7 OF 10
Designer : Cosmo Wilson	
Revisions :	