




BALCONY BOOM R
Note: Position on 2nd floor; see Deck Detail for placement info.
Approx Position: +22'-3" @ 3'-6" SR

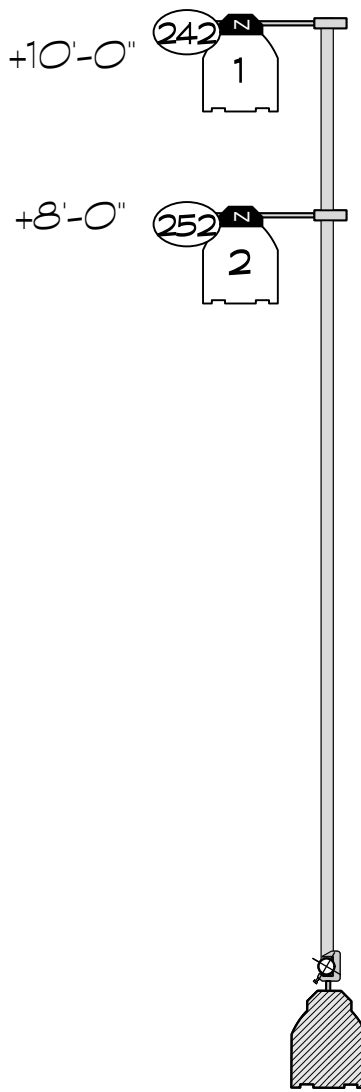


#7 BOOM R
Approx Position: +23'-0" @ 2'-6" SR

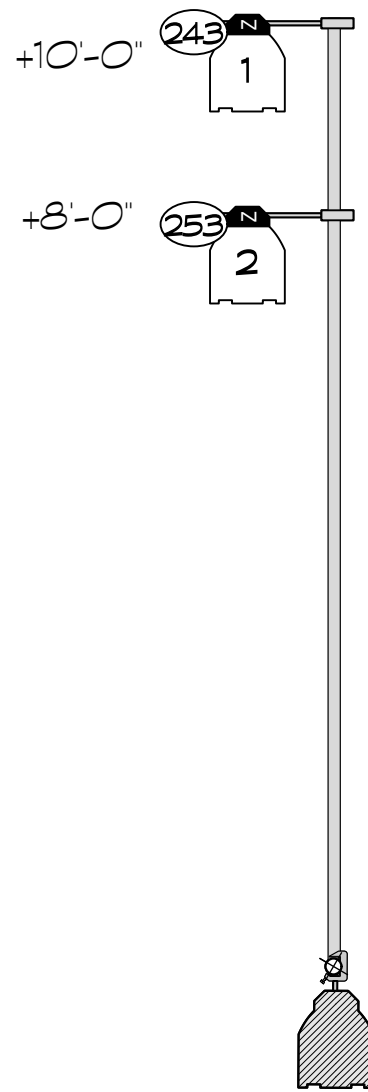


#6 BOOM R
Approx Position: +18'-9" @ 5'-0" SR

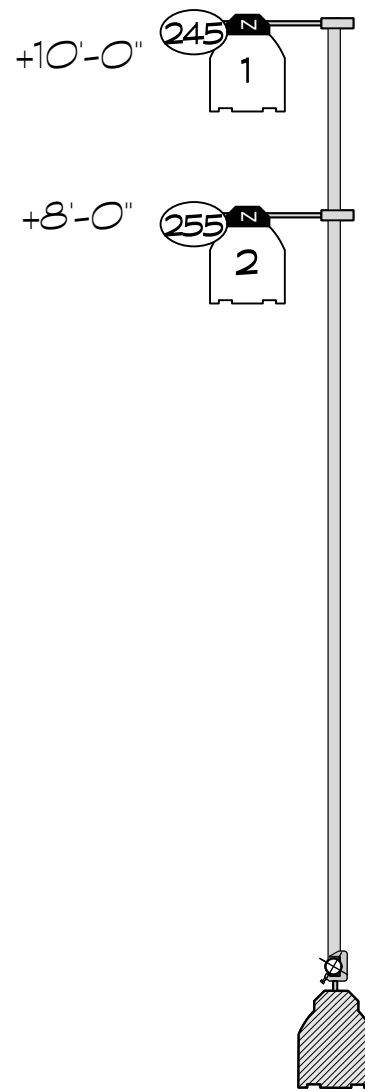


#5 BOOM R
Approx Position: +19'-0" @ 15'-0" SR

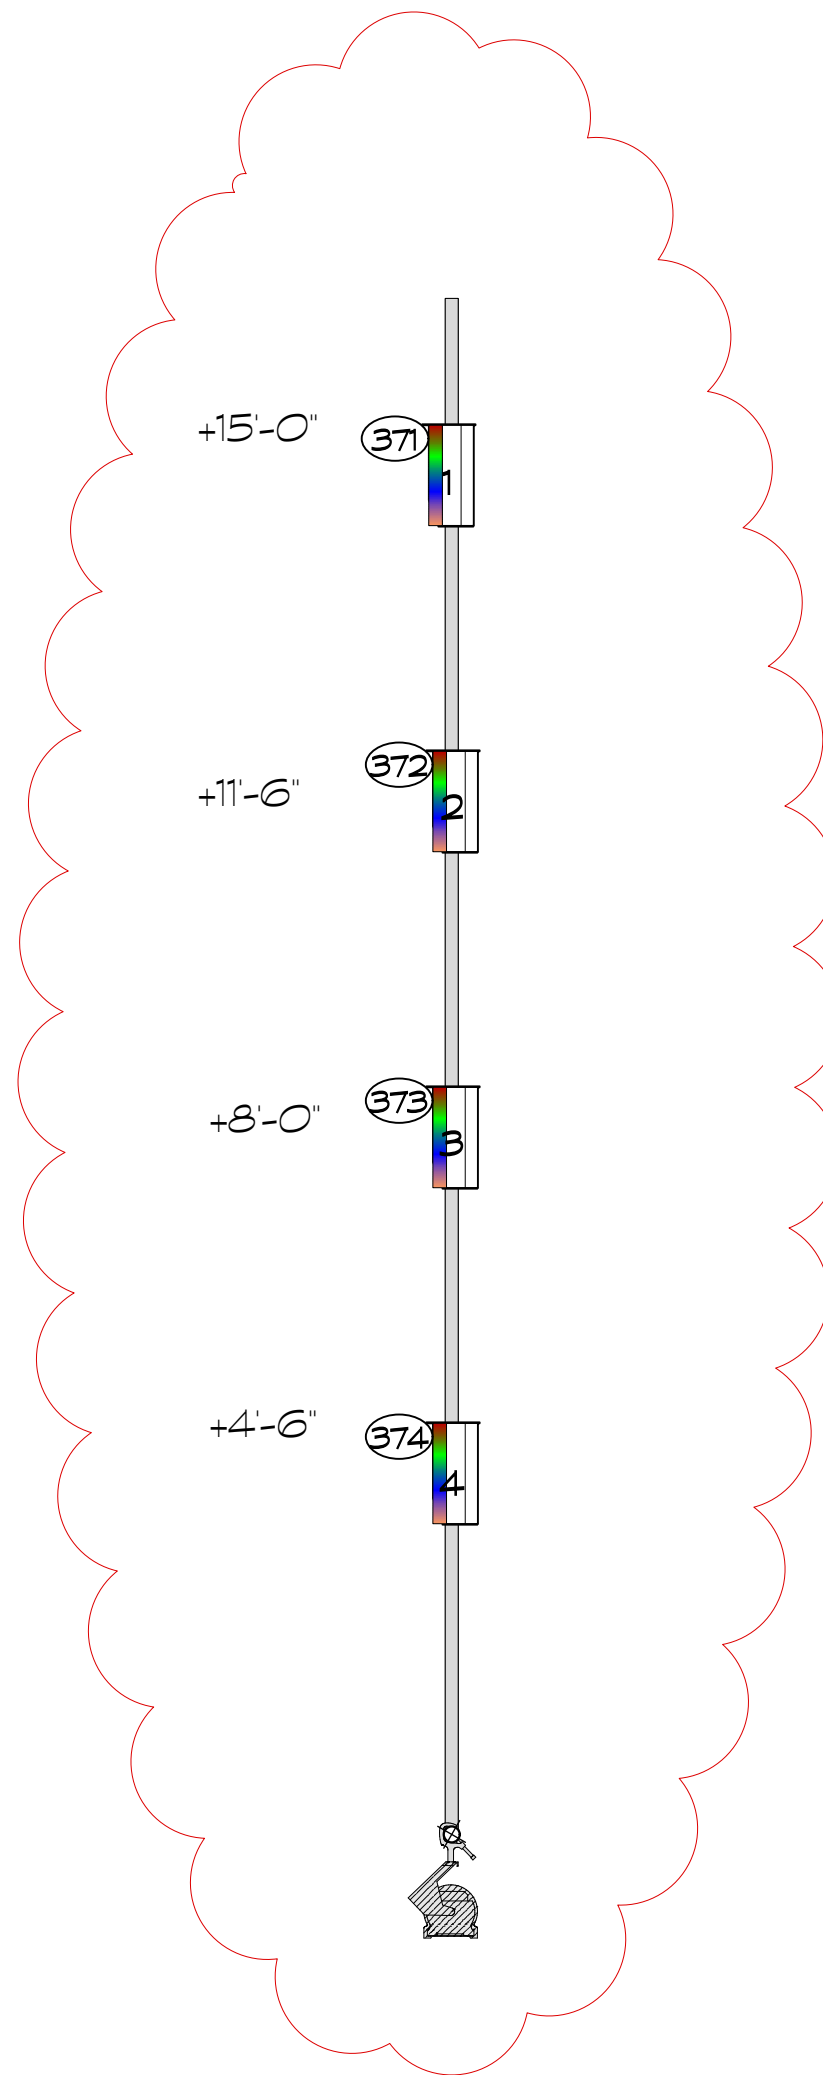


#4 BOOM R
Approx Position: +13'-3" @ 26'-6" SR

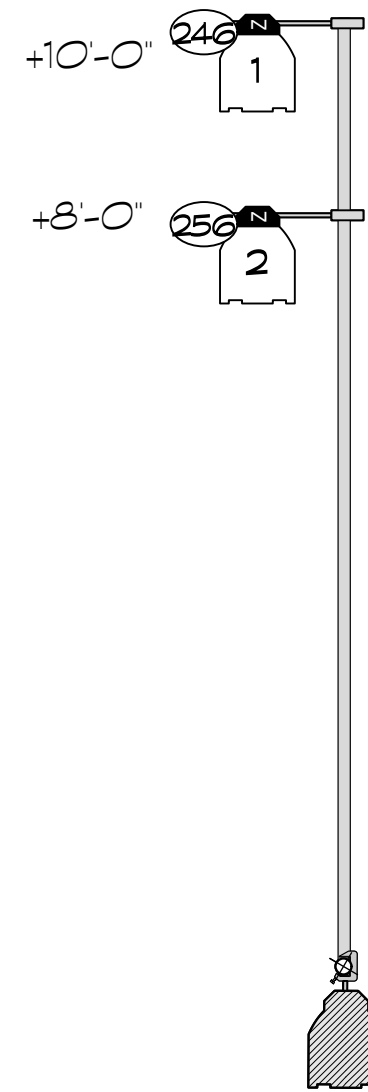

#3 BOOM R
Approx Position: +10'-3" @ 25'-0" SR

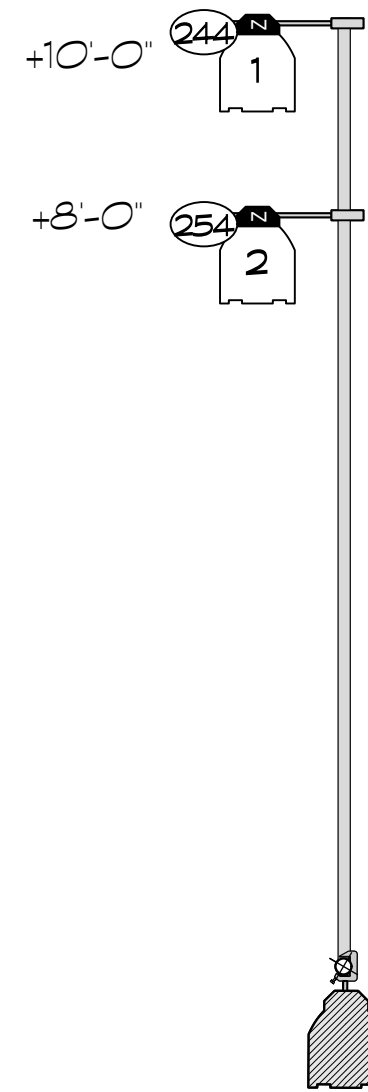

#2 BOOM R
Approx Position: +6'-0" @ 20'-3" SR

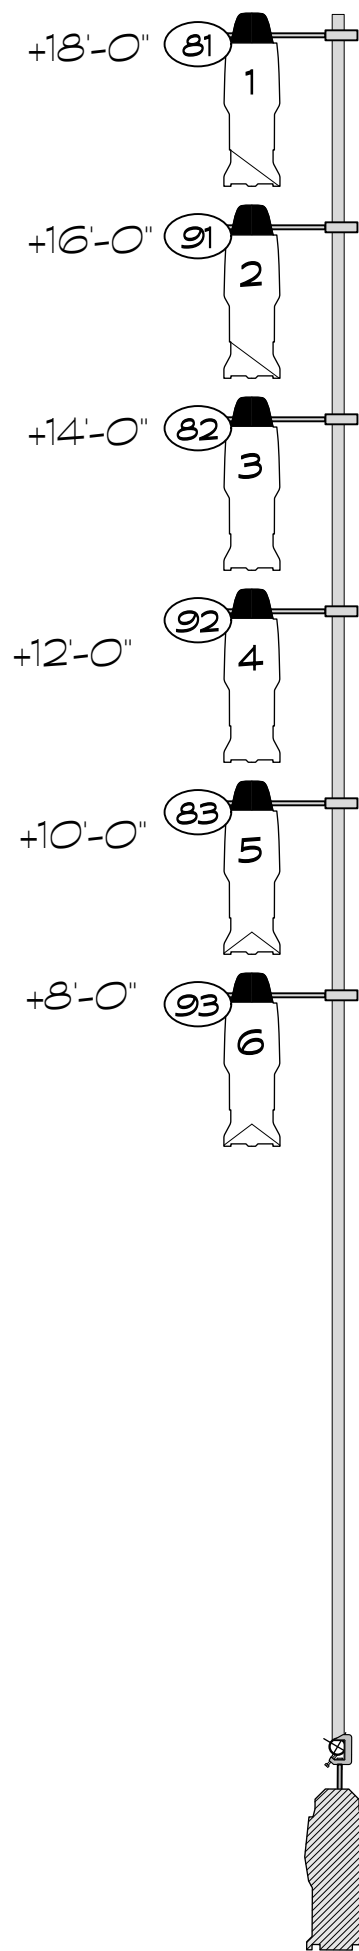

#1 BOOM R
Approx Position: +1'-0" @ 18'-0" SR

INSTRUMENTATION	
	ETC SOURCE 4 19° @750W
	ETC SOURCE 4 26° @750W
	ETC SOURCE 4 36° @750W
	ETC SOURCE 4 50° @750W
	ETC LUSTR 2 19° @81W
	ETC LUSTR 2 26° @81W
	ETC LUSTR 2 36° @81W
	ETC SOURCE 4 PAR NSP @750W
	ETC SOURCE 4 PAR MFL @750W
	ETC SOURCE 4 PAR WFL @750W

	ETC SOURCE 4 PARnel @750W
	ETC COLORSOURCE DEEP BLUE PAR @90W
	ELATION FUZE Z175 @200W
	3" FRESNEL @300W
	LED FLOOD LIGHT FIXTURE @140W
	MAC ENCORE PERFORMANCE CLD @700W
	PRG ICON STAGE @536W
	LED TAPE - RGBWW
	COLORFORCE 12

TYPICAL UNIT
DISCLAIMER
THIS DRAWING REPRESENTS VISUAL CONCEPTS AND CONSTRUCTION SUGGESTIONS ONLY.
<small>THE IMPLEMENTATION OF THE LIGHTING DESIGN BY THE COMPANY MUST COMPLY WITH THE MOST STRINGENT APPLICABLE FEDERAL, AND LOCAL, SAFETY AND FIRE CODES. ALL DRAWINGS, EQUIPMENT LISTS, AND LIGHTING PLANS REPRESENT DESIGN INTENT AND VISUAL CONCEPTS ONLY. THE LIGHTING DESIGNER IS UNQUALIFIED TO DETERMINE SPECIFIC RISK, AND THEREFORE OF THE DESIGN, AND WILL NOT ASSUME RESPONSIBILITY FOR PROPER ENGINEERING, CONSTRUCTION, HANDLING, OR USE OF THE LIGHTING EQUIPMENT WHICH IMPLICATES THIS DESIGN.</small>

NOTES
- ALL DIMENSIONS ARE FROM CENTER LINE & PLASTER LINE UNLESS OTHERWISE NOTED
- ALL TRIMS ARE FROM STAGE FLOOR TO SIDEARM/PIPE UNLESS NOTED
- OVERSTAGE ELECTRIC TRIMS FROM SYSTEM PIPE TO DECK; BORDERS FROM BOTTOM OF BORDERS TO DECK
- ALL UNITS HUNG ON 18" CENTERS UNLESS OTHERWISE DIMENSIONED
- WRITTEN DIMENSIONS TAKE PRECEDENCE OVER SCALE MEASUREMENTS
- PLEASE SEE HOOKUP FOR COLOR AND ACCESSORY INFORMATION - TOPHAT & BARNDOORS ARE NOT DRAWN ON PLOT
- PLEASE DROP ALL ACCESSORIES & COLOR PRIOR TO START OF FOCUS

REVISIONS		
NO.	REVISION	DATE
4.5	COLORFORCE 12s ADDED	11/08/23

APPROPRIATE

by BRANDEN JACOBS-JENKINS

2NDSTAGE

THE HOME OF LIVING AMERICAN PLAYWRIGHTS

DIRECTED BY Lila Neugebauer
SCENIC DESIGN BY DOTS
COSTUME DESIGN BY Dede Ayite
SOUND DESIGN BY ... Bray Poor and Will Pickens
LIGHTING DESIGN BY Jane Cox

SR BOOM DETAIL
SCALE: 1/2" = 1'-0"

DRAFTED BY Tess James
REVISIONS BY Bailey Costa

PLATE
6
OF ELEVEN