

KEY



	ETC Halcyon Titanium	36
	ETC High End Lonestar	36
	S4 LED Lustr 14 deg	2
	S4 LED Lustr 19 deg	9
	S4 LED Lustr 26 deg	6
	Arri S60-C Skypanel	0
	Arri S30-C Skypanel	0
	Litepanels Astra 1x1 Bi-Color	2
	Chroma Q Studio Force V12	2
	ARRI LS-C LED Fresnel 14-50 deg	0
	ETC ColorSource PAR	0
	Asteria AX5	15
	Rolling Floor Stand	2

House Fixtures

	Robe Robin DL7S	18
	Martin MAC Aura LED Wash	15
	ColorSource Spot 14°	0
	PAR38 LED	80

TYPICAL

Stimpup
 12" Extension
 6" Extension
 1/1 Address

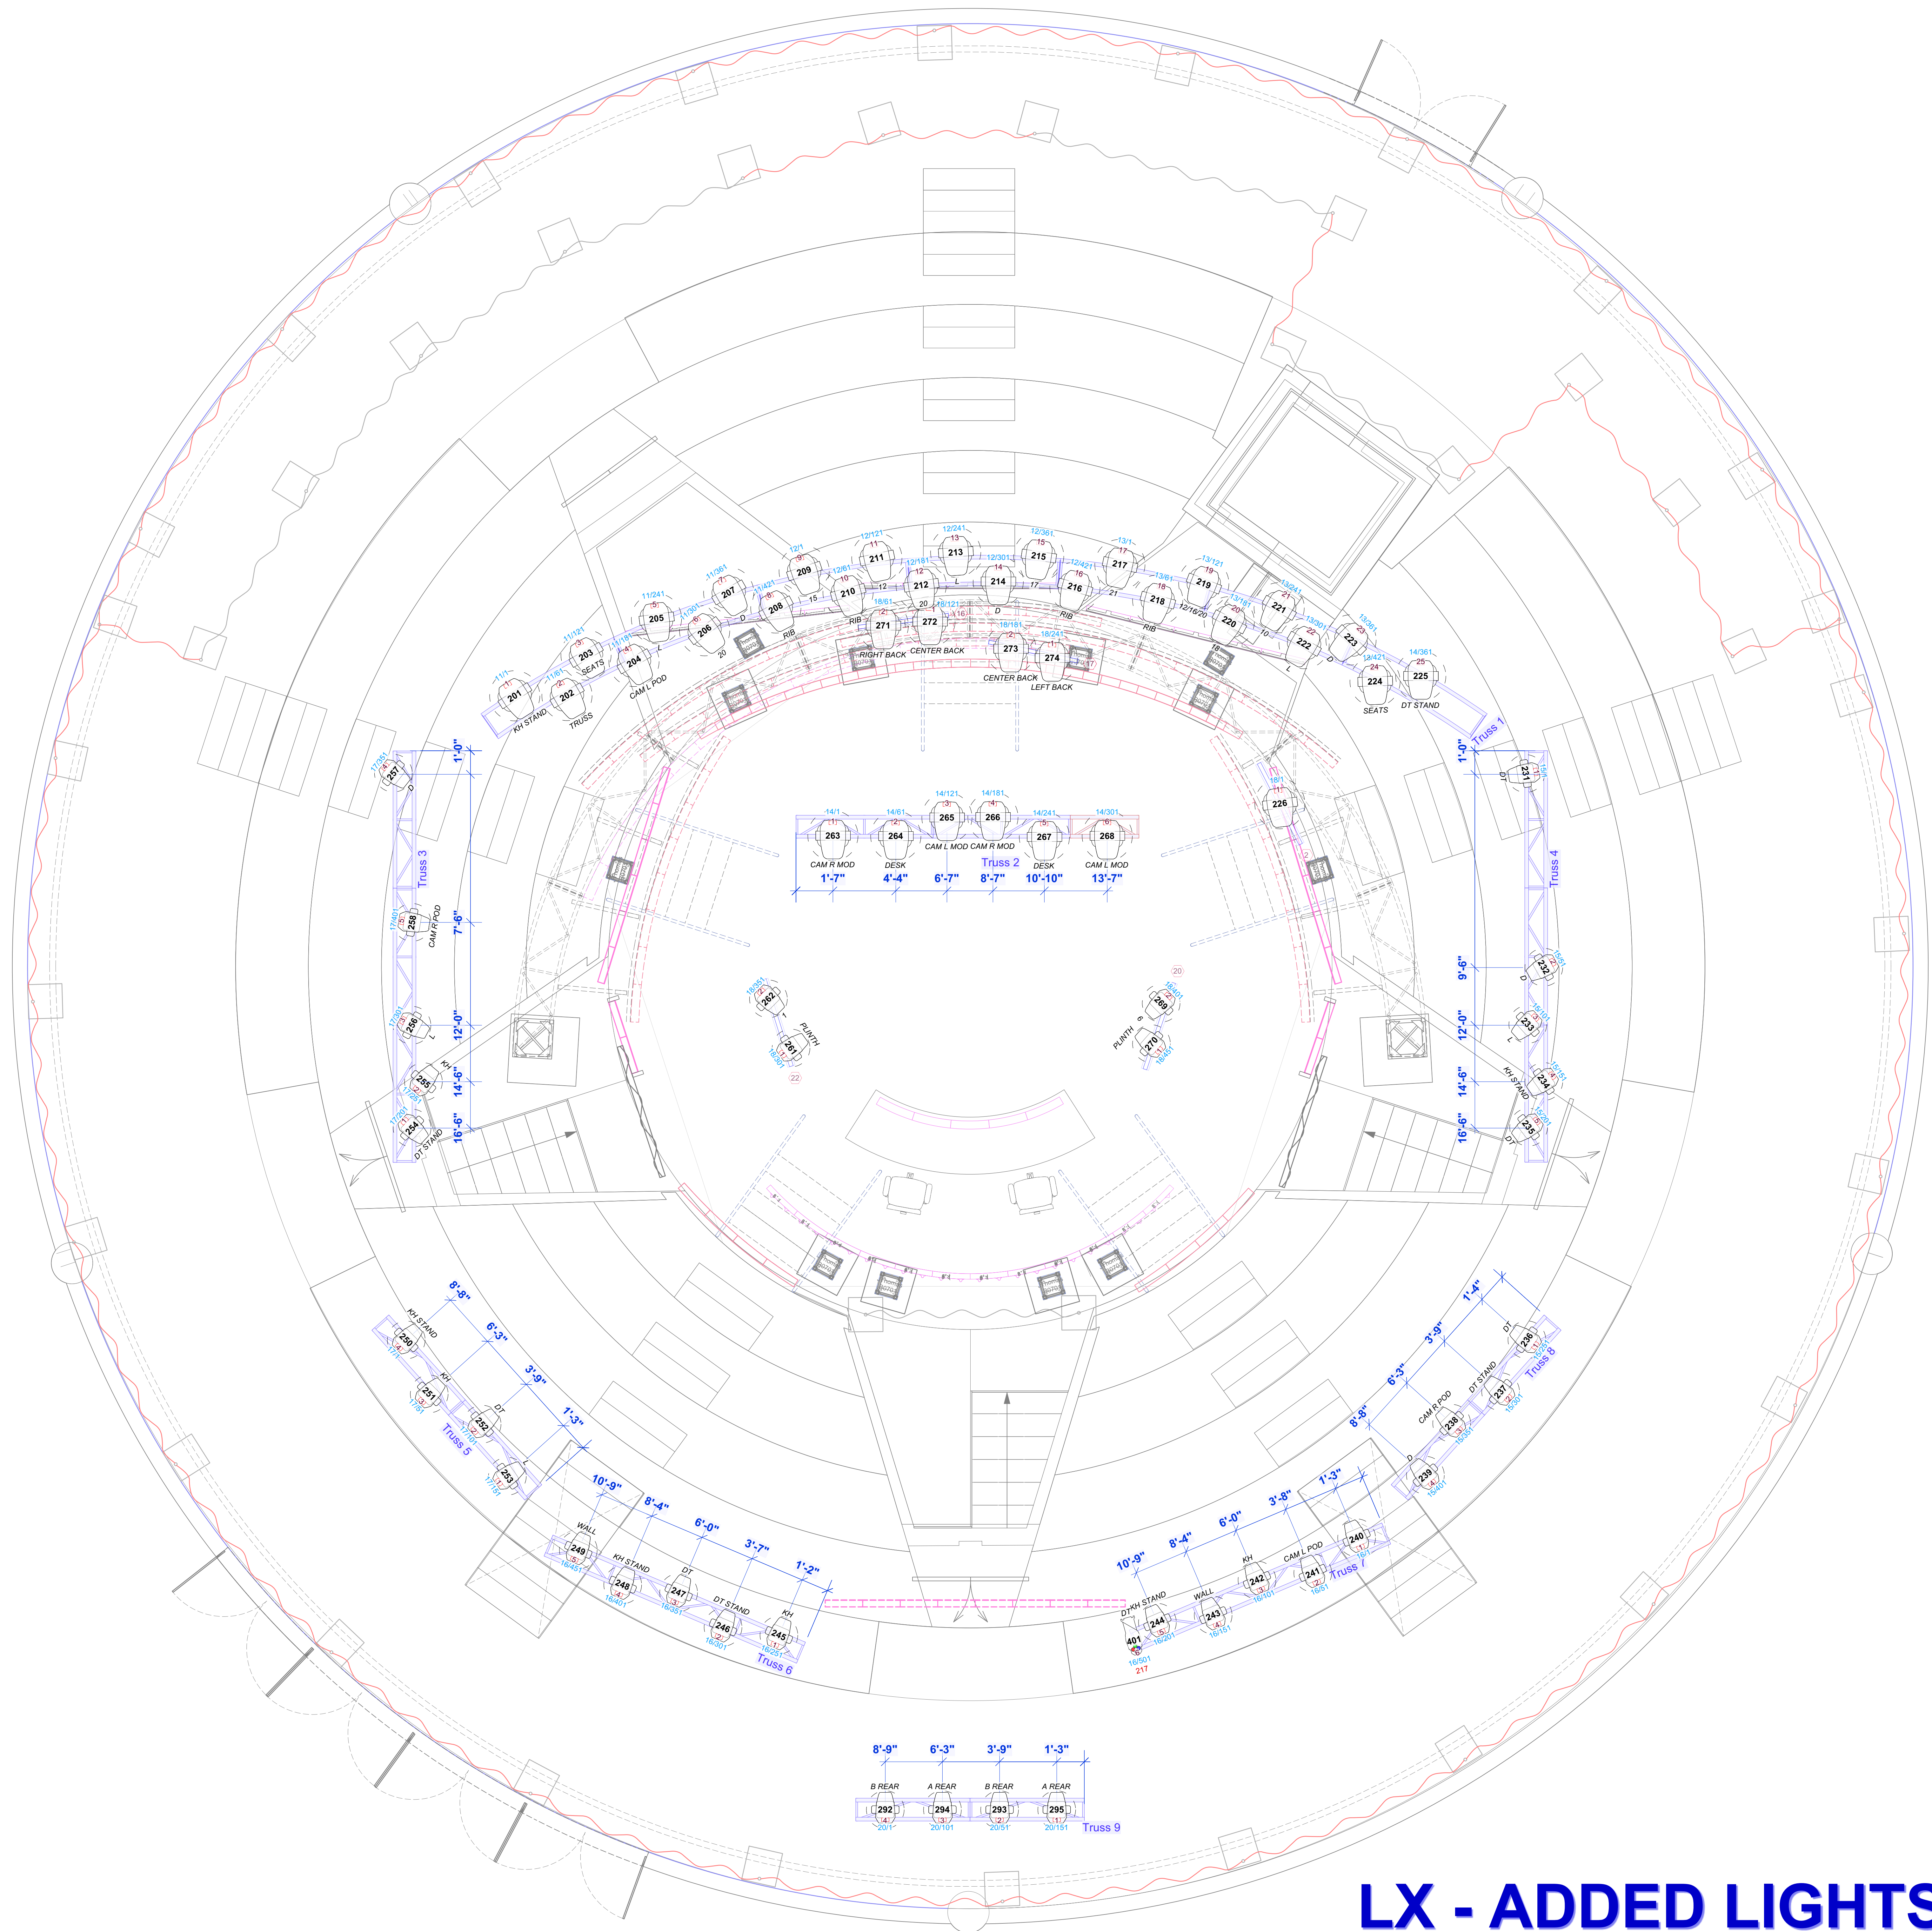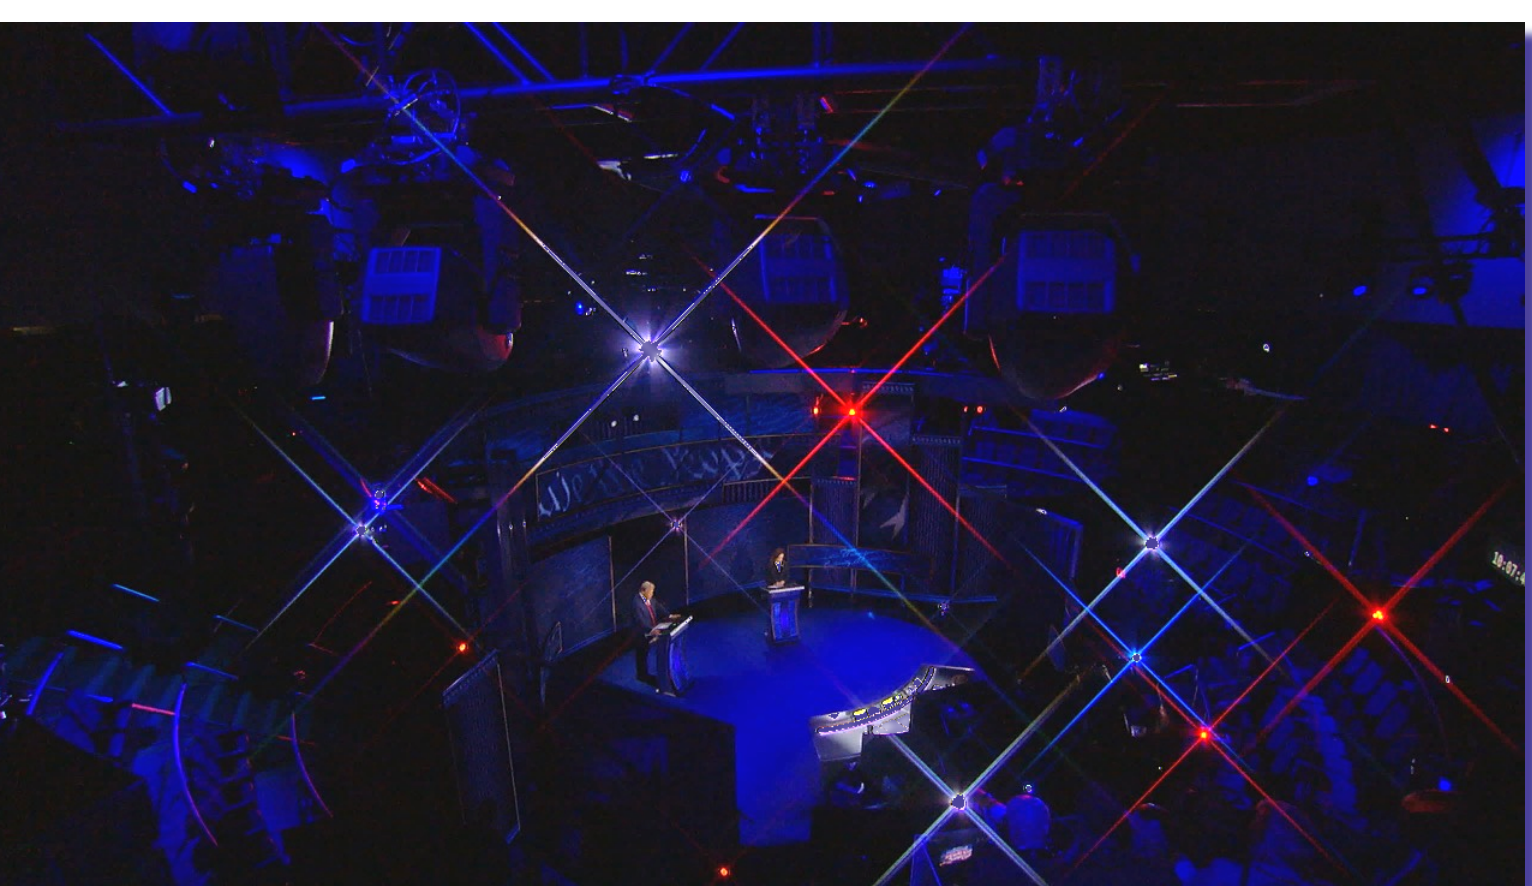

LX - ADDED LIGHTS

LDG The Lighting Design Group
 49 West 27th Street, Suite 920
 New York, NY 10001
 Tel: 212.855.4943
 www.ldg.com

abc NEWS

YOUR VOICE YOUR VOTE 2024

NATIONAL CONSTITUTION CENTER
 VISIT · LEARN · DEBATE

REVISIONS

#	BY	DATE	DESCRIPTION
1	STK	08/16/2024	2020 LX ADAPTATION
2	STK	08/21/2024	NEW GROUND PLAN
3	STK	08/22/2024	UPDATED SCENIC
4	KNOTH	08/25/2024	REDLINES/UPDATES
5	STK	09/14/2024	ARCHIVAL

DRAWING TITLE
DEBATE LX - ADDED LIGHTS



PRODUCER	DESIGNER
ABC NEWS	DENNIS SIZE
SCALE	GAFFER
3/8" = 10"	JON GOSS
PROJECT ID	DRAWN BY
ABCN2408	STK
FILE NAME	FACILITY
20240905-ABCN2408-PLO T-VS.vwx	525 ARCH ST, INDEPENDENCE MALL, PHILADELPHIA, PA 19106-1595

PLATE

S1

/06

KEY		Counts
	ETC Halcyon Titanium	36
	ETC High End Lonestar	36
	S4 LED Lustr 14 deg	2
	S4 LED Lustr 19 deg	9
	S4 LED Lustr 26 deg	6
	Arri S60-C Skypanel	0
	Arri S30-C Skypanel	0
	Litepanels Astra 1x1 Bi-Color	2
	Chroma Q Studio Force V12	2
	ARRI LS-C LED Fresnel 14-50 deg	0
	ETC ColorSource PAR	0
	Asteria AX5	15
	Rolling Floor Stand	2
House Fixtures		
	Robe Robin DL7S	18
	Martin MAC Aura LED Wash	15
	ColorSource Spot 14°	0
	PAR38 LED	80
TYPICAL		
	Purpose	
	Color	
	Channel	
	Stirrup	
	12' Extension	
	6' Extension	
	Address	

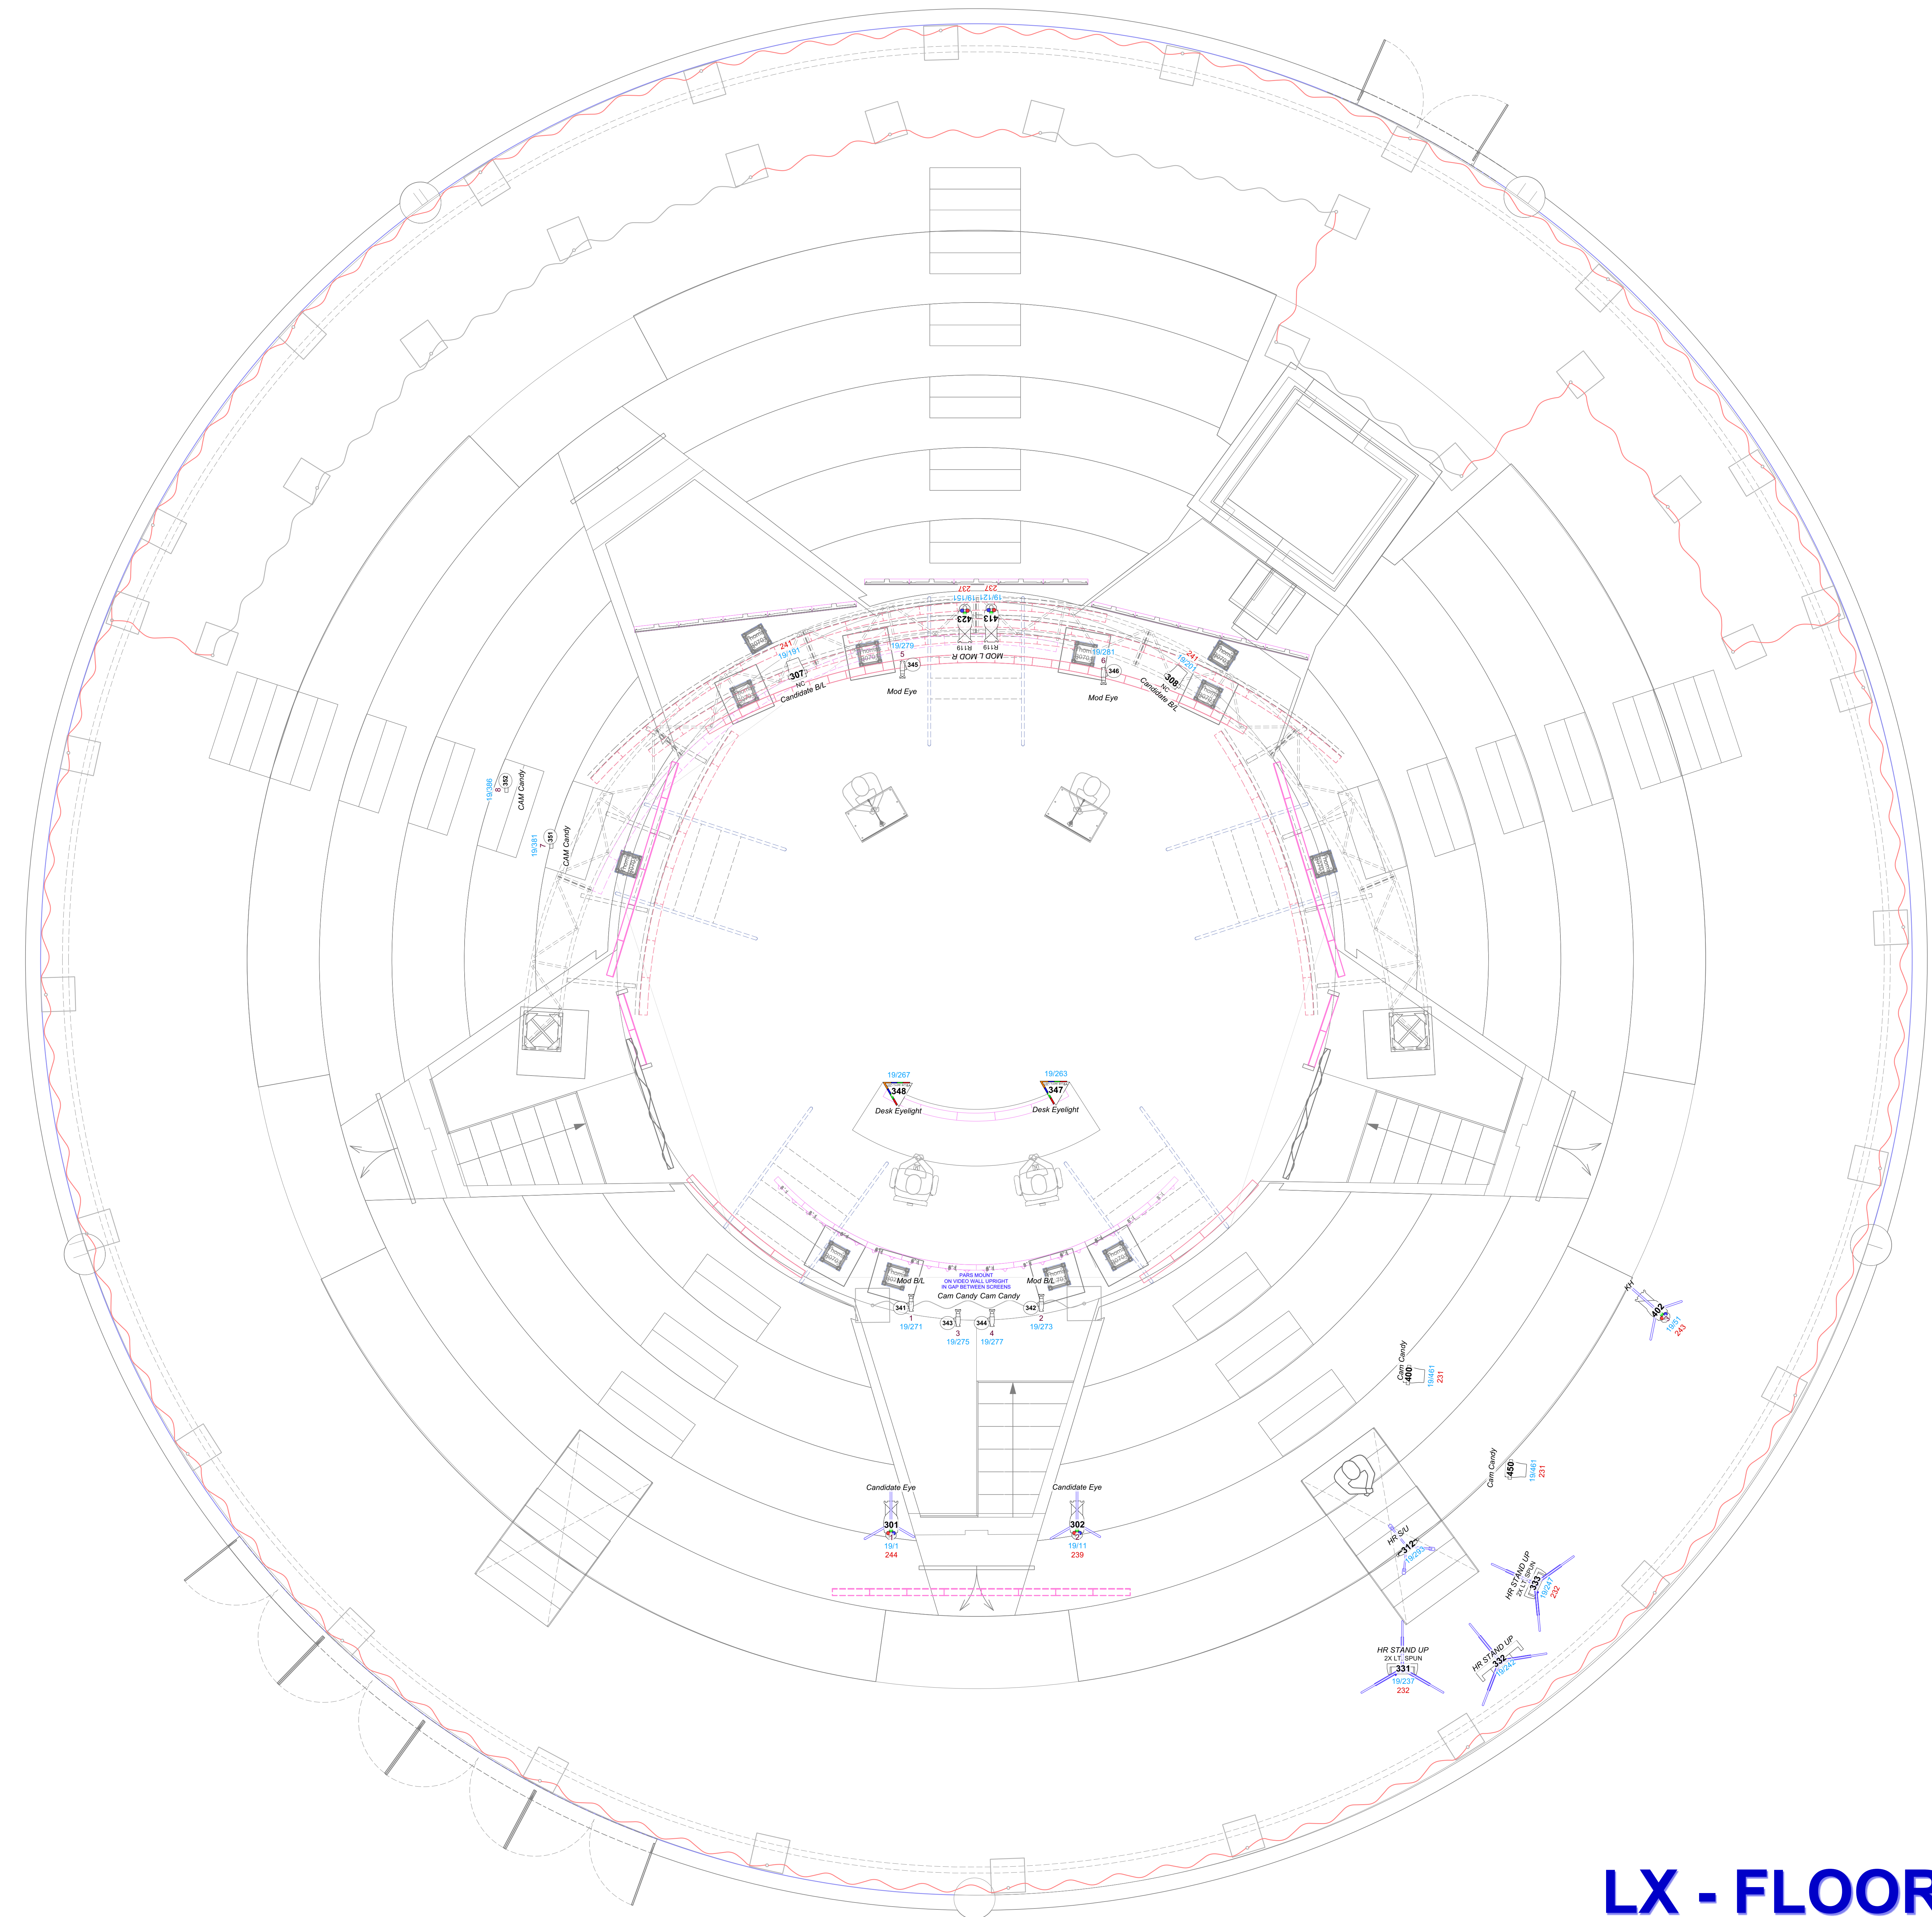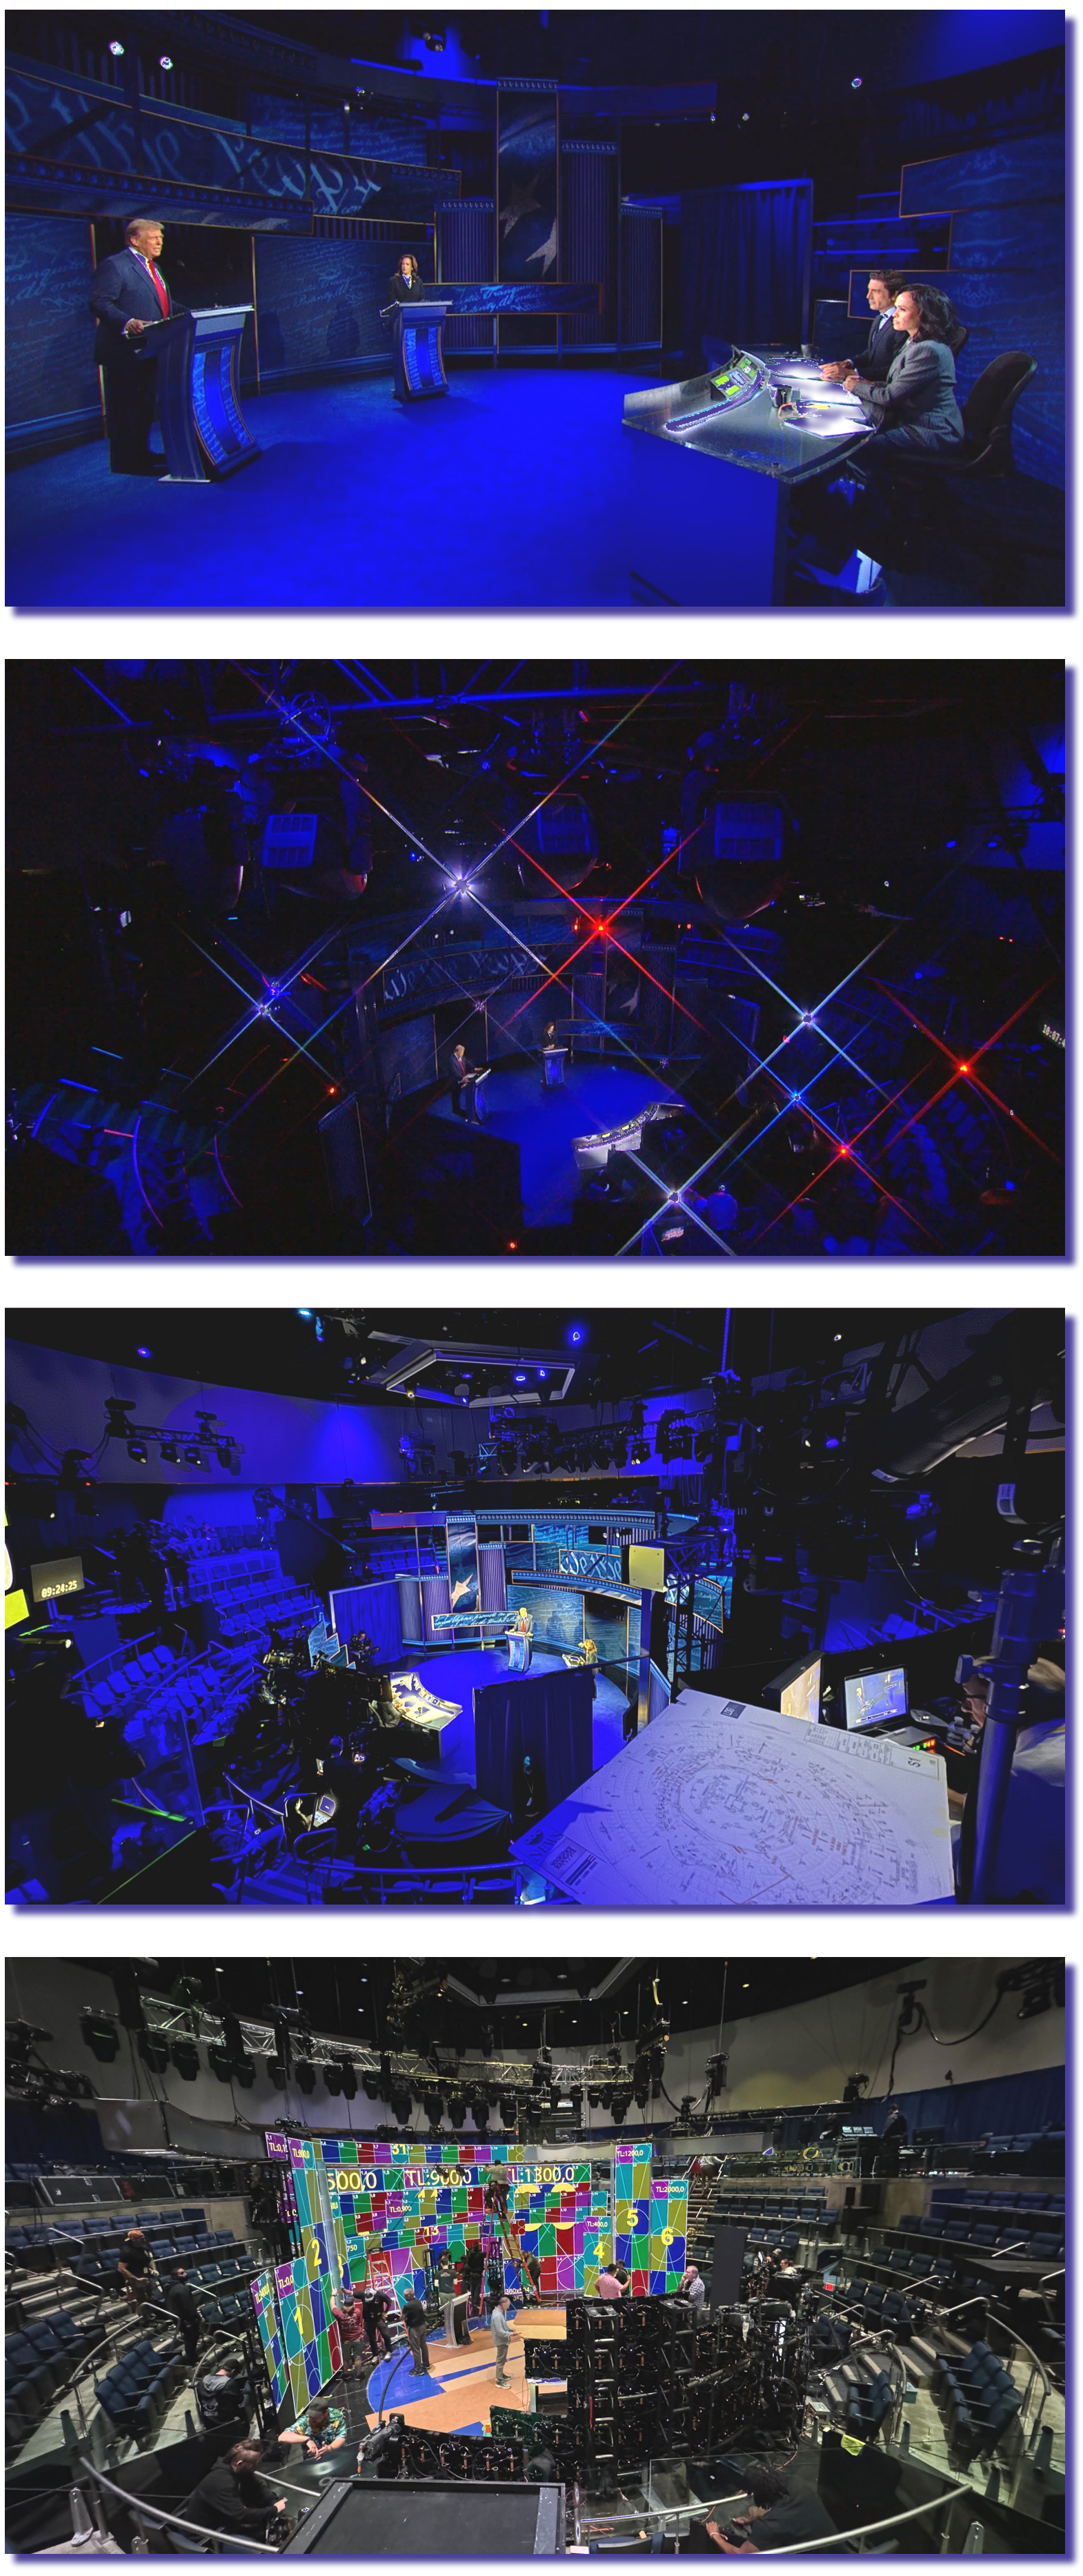

LX - FLOOR

THIS DRAWING AND THE IDEAS, ARRANGEMENT, DESIGNS AND PLANS INDICATED HEREON OR REPRESENTED HERE ARE OWNED BY AND REMAIN THE EXCLUSIVE PROPERTY OF THE LIGHTING DESIGN GROUP (LDG). THEY HAVE BEEN CREATED AND DEVELOPED FOR USE ON AND IN CONNECTION WITH THIS SPECIFIC PROJECT ONLY AND MAY NOT BE REPRODUCED OR TRANSMITTED IN ANY FORM OR BY ANY MEANS, ELECTRONIC OR MECHANICAL, INCLUDING PHOTOCOPYING, RECORDING, OR BY ANY INFORMATION STORAGE AND RETRIEVAL SYSTEM, WITHOUT THE EXPRESS WRITTEN PERMISSION OF LDG. WRITTEN DIMENSIONS ON DRAWINGS SHALL TAKE PRECEDENCE OVER DIMENSIONS SHOWN ON THE DRAWINGS. MANUFACTURERS SHALL VERIFY AND BE RESPONSIBLE FOR ALL DIMENSIONS AND ASSEMBLY CONDITIONS. ANY VARIATIONS OR DISCREPANCIES IN THE DRAWINGS SHALL BE REPORTED TO LDG PRIOR TO BEGINNING WORK. THESE DRAWINGS REPRESENT VISUAL CONCEPTS ONLY. RESPONSIBILITY FOR STRUCTURAL, ROOMING AND RELATED ENGINEERING IS BY OTHERS. ALL MEANS, METHODS AND MATERIALS TO MEET OR EXCEED APPLICABLE CODES AND INDUSTRY STANDARDS.





NATIONAL CONSTITUTION CENTER
 VISIT · LEARN · DEBATE

REVISIONS		
#	BY	DATE DESCRIPTION
1	STK	08/16/2024 2020 LX ADAPTATION
2	STK	08/21/2024 NEW GROUND PLAN
3	STK	08/22/2024 UPDATED SCENIC
4	KNOTH	08/25/2024 REDLINES/UPDATES
5	STK	09/14/2024 ARCHIVAL

DRAWING TITLE	
DEBATE LX - FLOOR	
PRODUCER	DESIGNER
ABC NEWS	DENNIS SIZE
SCALE	GAFFER
3/8" = 10"	JON GOSS
PROJECT ID	DRAWN BY
ABCN2408	STK
FILE NAME	FACILITY
20240905-ABCN2408-PLO T-VS.vwx	525 ARCH ST, INDEPENDENCE MALL, PHILADELPHIA, PA 19106-1595

KEY	Counts
	ETC Halcyon Titanium 36
	ETC High End Lonestar 36
	S4 LED Lustr 14 deg 2
	S4 LED Lustr 19 deg 9
	S4 LED Lustr 26 deg 6
	Arri S60-C Skypanel 0
	Arri S30-C Skypanel 0
	Litepanels Astra 1x1 Bi-Color 2
	Chroma Q Studio Force V12 2
	ARRI LS-C LED Fresnel 14-50 deg 0
	ETC ColorSource PAR 0
	Asteria AX5 15
	Rolling Floor Stand 2
House Fixtures	
	Robe Robin DL7S 18
	Martin MAC Aura LED Wash 15
	ColorSource Spot 14° 0
	PAR38 LED 80
TYPICAL	
	Purpose
	Color
	Channel
	Stripup
	12" Extension
	6" Extension
	Address

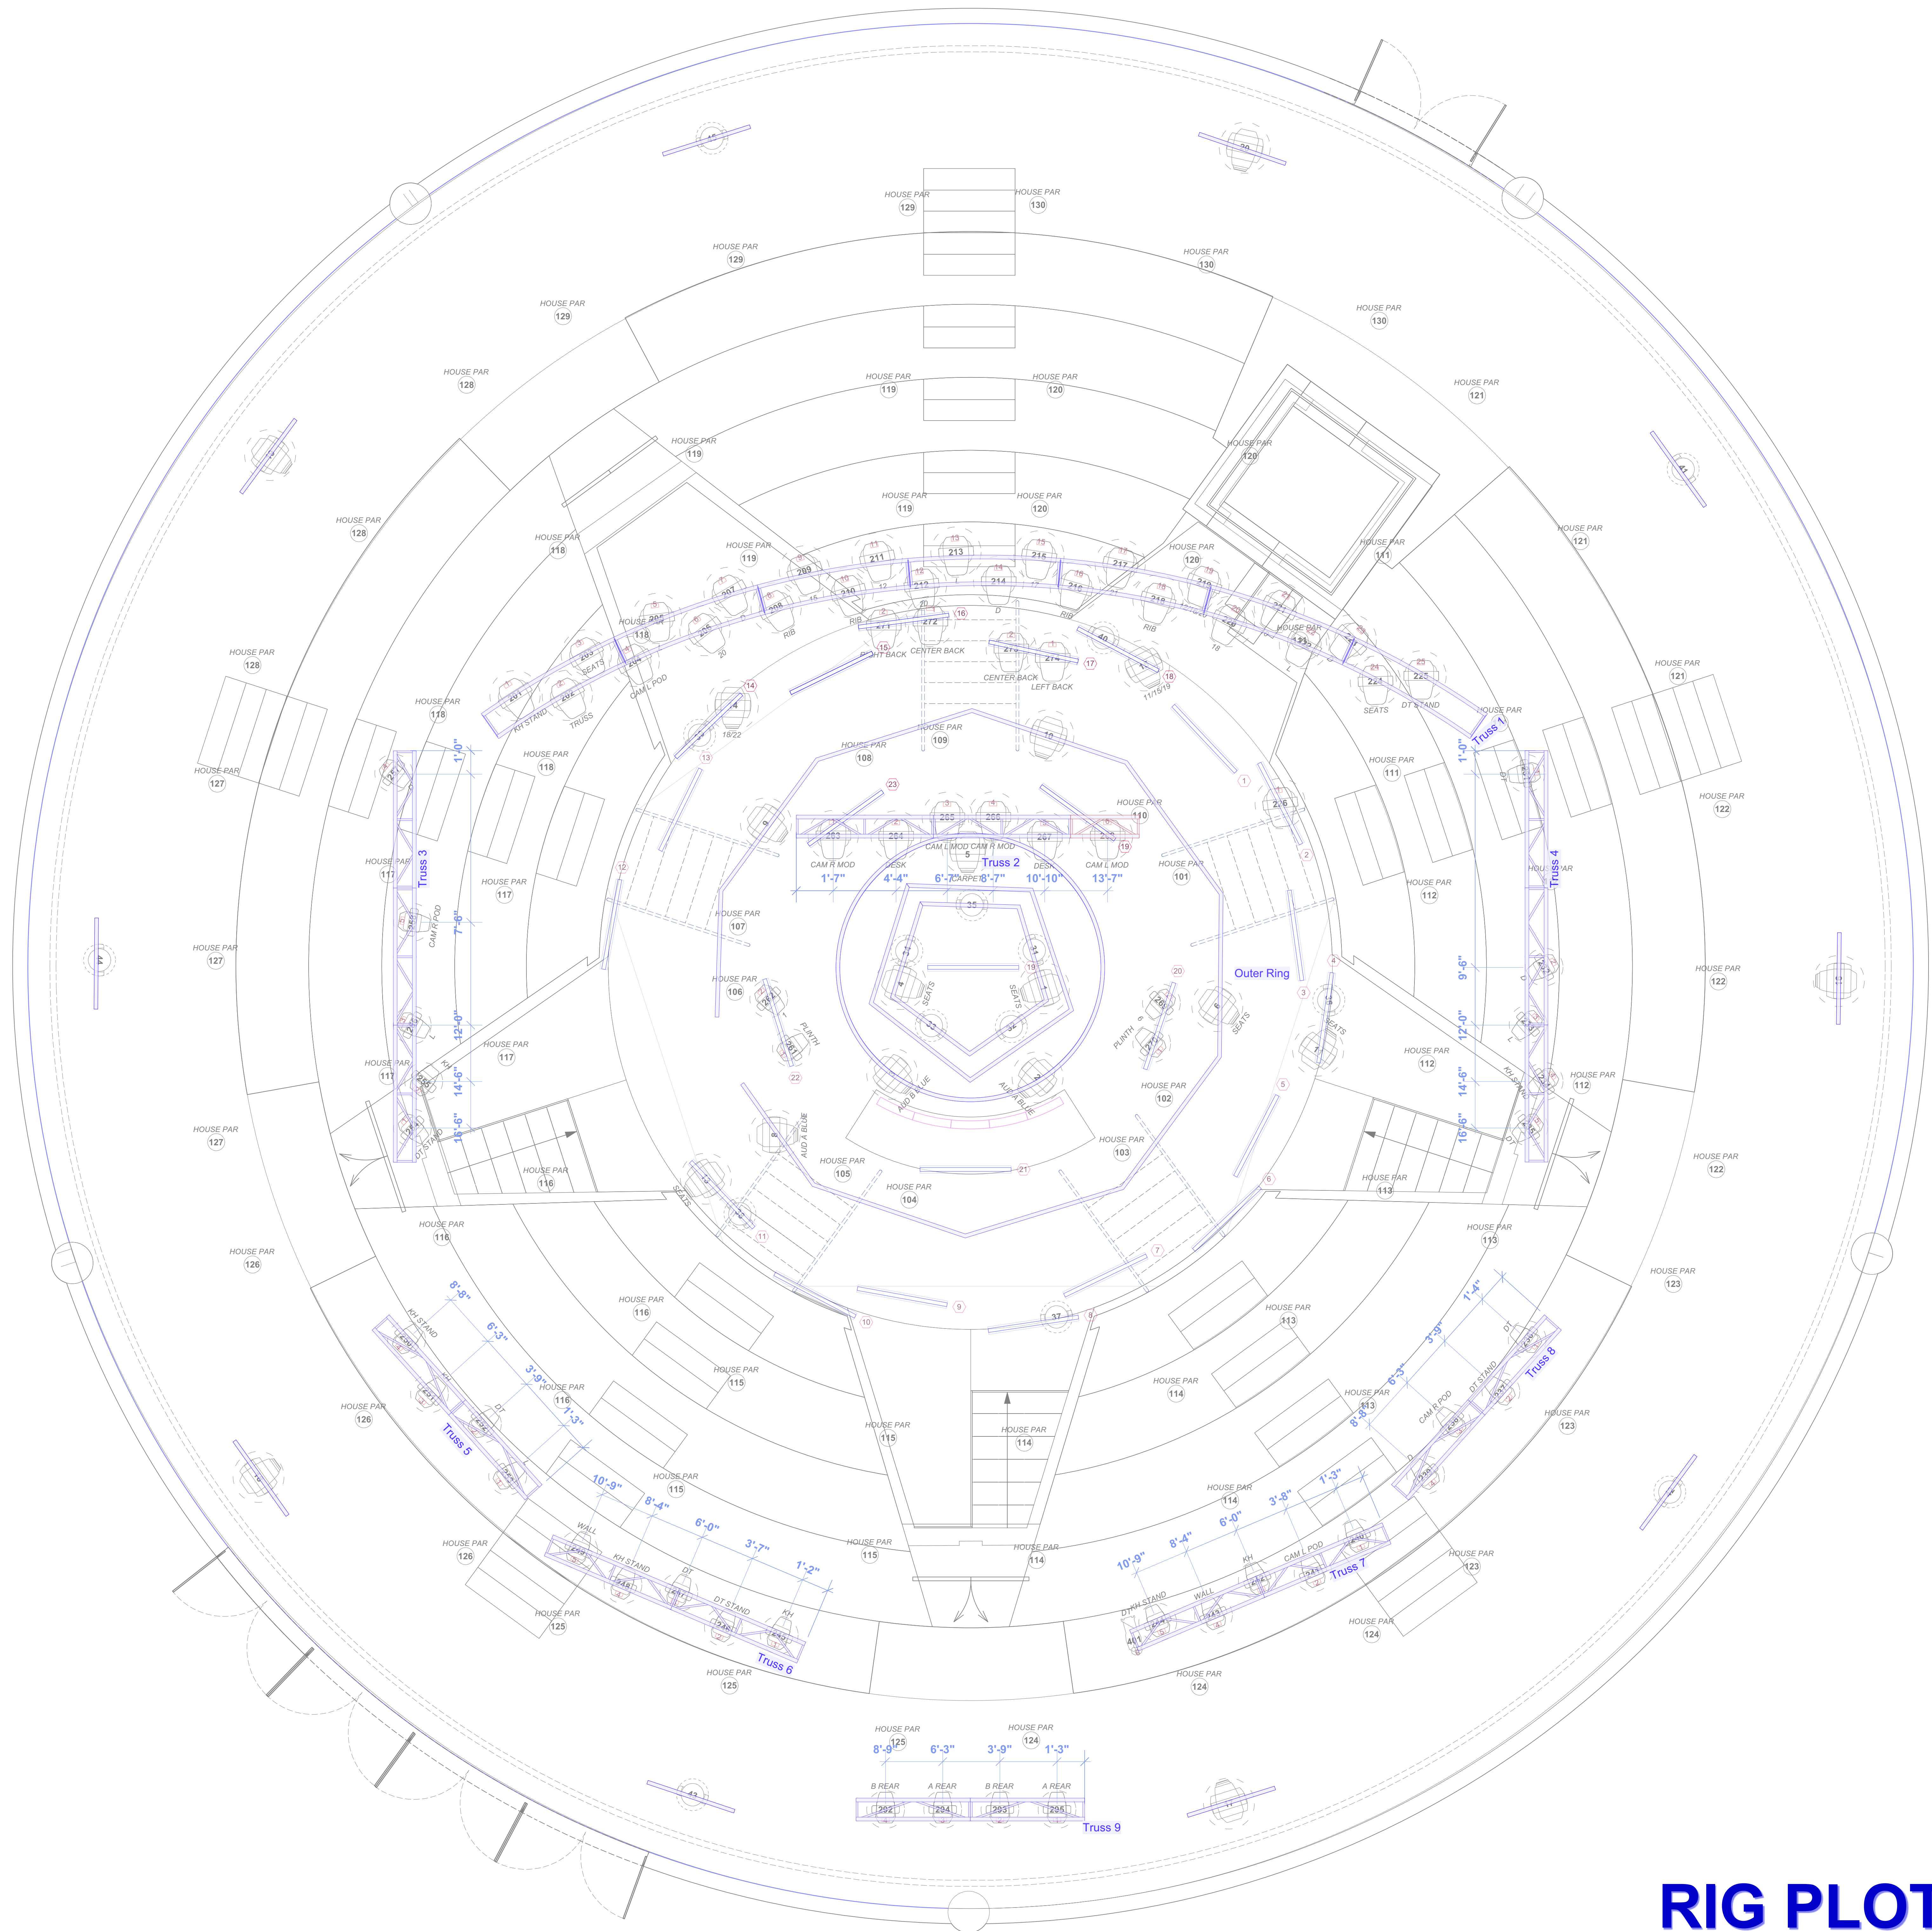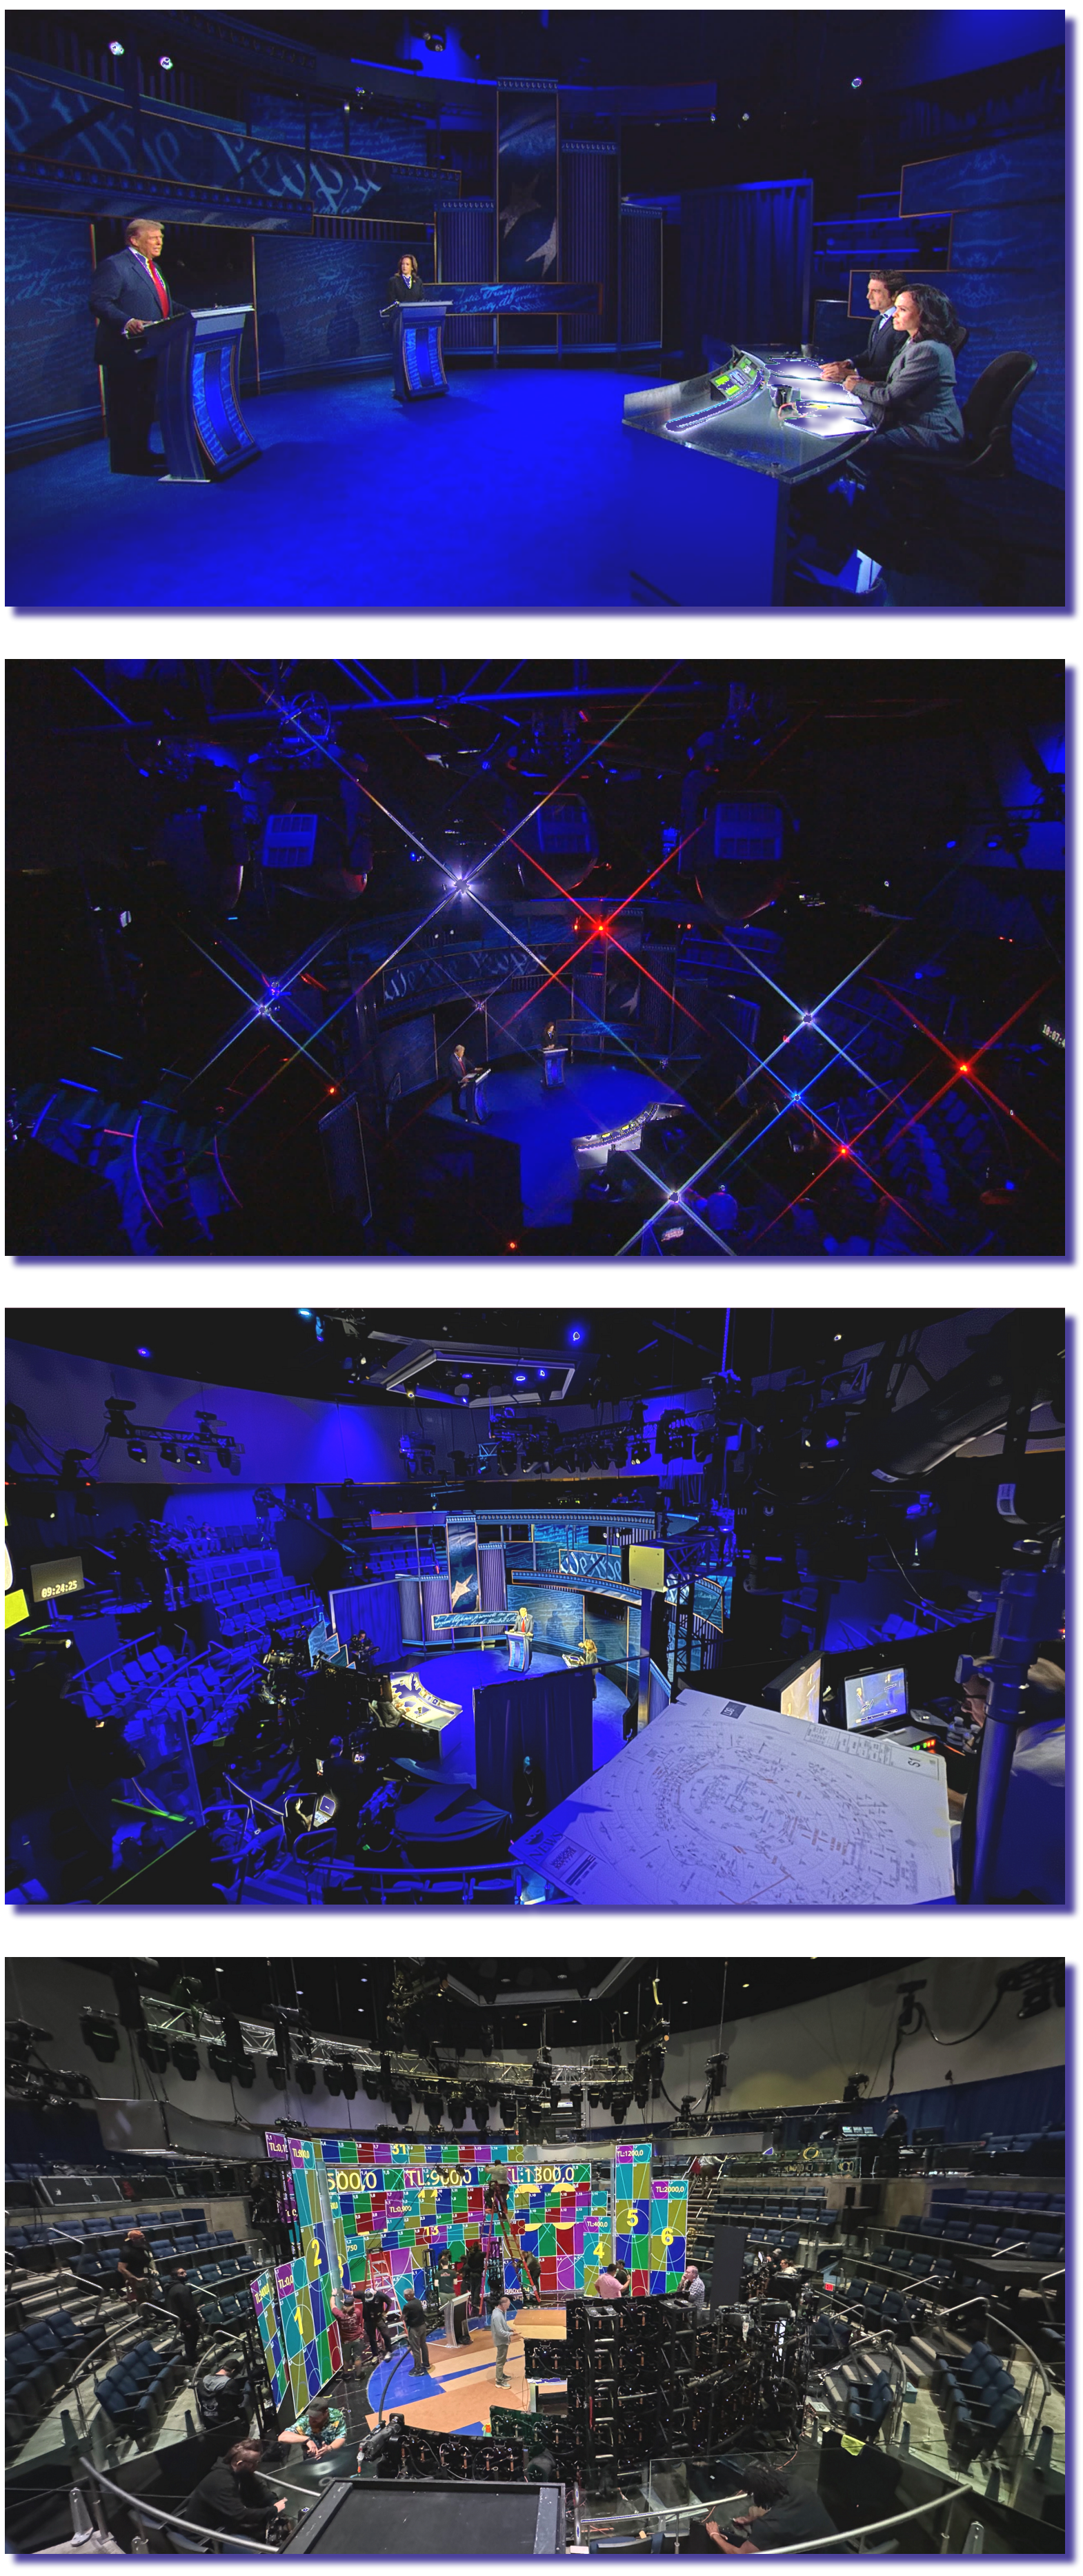

RIG PLOT

LDG The Lighting Design Group
 49 West 27th Street, Suite 900
 New York, NY 10001
 Tel: (212) 685-6462
 www.ldg.com

THIS DRAWING AND THE IDEAS, ARRANGEMENT, DESIGNS AND PLANS INDICATED HEREON OR REPRESENTED HEREON ARE OWNED BY AND REMAIN THE EXCLUSIVE PROPERTY OF THE LIGHTING DESIGN GROUP (LDG). THEY HAVE BEEN CREATED AND DEVELOPED FOR USE ON AND IN CONNECTION WITH THIS SPECIFIC PROJECT ONLY AND MAY NOT BE REPRODUCED OR TRANSMITTED IN ANY FORM OR BY ANY MEANS, ELECTRONIC OR MECHANICAL, INCLUDING PHOTOCOPYING, RECORDING, OR BY ANY INFORMATION STORAGE AND RETRIEVAL SYSTEM, WITHOUT THE EXPRESS WRITTEN PERMISSION OF LDG. WRITTEN DIMENSIONS ON DRAWINGS SHALL HAVE PRECEDENCE OVER SCALE DIMENSIONS. CONTRACTORS AND MANUFACTURERS SHALL VERIFY AND BE RESPONSIBLE FOR ALL DIMENSIONS AND AS-BUILT CONDITIONS. ANY VARIATIONS OR DISCREPANCIES IN THE DRAWINGS SHALL BE REPORTED TO LDG PRIOR TO BEGINNING WORK. THESE DRAWINGS REPRESENT VISUAL CONCEPTS ONLY. RESPONSIBILITY FOR STRUCTURAL, RIGGING AND RELATED ENGINEERING IS BY OTHERS. ALL MEANS, METHODS AND MATERIALS TO MEET OR EXCEED APPLICABLE CODES AND INDUSTRY STANDARDS.

abc NEWS

YOUR VOICE YOUR VOTE 2024

NATIONAL CONSTITUTION CENTER
 VISIT · LEARN · DEBATE

REVISIONS		
#	BY	DATE DESCRIPTION
1	STK	08/16/2024 2020 LX ADAPTATION
2	STK	08/21/2024 NEW GROUND PLAN
3	STK	08/22/2024 UPDATED SCENIC
4	KNOTH	08/25/2024 REDLINES/UPDATES
5	STK	09/14/2024 ARCHIVAL



DRAWING TITLE	
DEBATE - RIG PLOT	
PRODUCER	DESIGNER
ABC NEWS	DENNIS SIZE
SCALE	GAFFER
3/8" = 10"	JON GOSS
PROJECT ID	DRAWN BY
ABCN2408	STK
FILE NAME	FACILITY
20240905-ABCN2408-PLO T-VS-vxx	525 ARCH ST, INDEPENDENCE MALL, PHILADELPHIA, PA 19106-1595

PLATE

S4

/06

KEY		Counts
	ETC Halcyon Titanium	36
	ETC High End Lonestar	36
	S4 LED Lustr 14 deg	2
	S4 LED Lustr 19 deg	9
	S4 LED Lustr 26 deg	6
	Arri S60-C Skypanel	0
	Arri S30-C Skypanel	0
	Litepanels Astra 1x1 Bi-Color	2
	Chroma Q Studio Force V12	2
	ARRI LS-C LED Fresnel 14-50 deg	0
	ETC ColorSource PAR	0
	Asteria AX5	15
	Rolling Floor Stand	2
House Fixtures		
	Robe Robin DL7S	18
	Martin MAC Aura LED Wash	15
	ColorSource Spot 14°	0
	PAR38 LED	80
TYPICAL		
	Purpose	
	Color	
	Channel	
	Address	

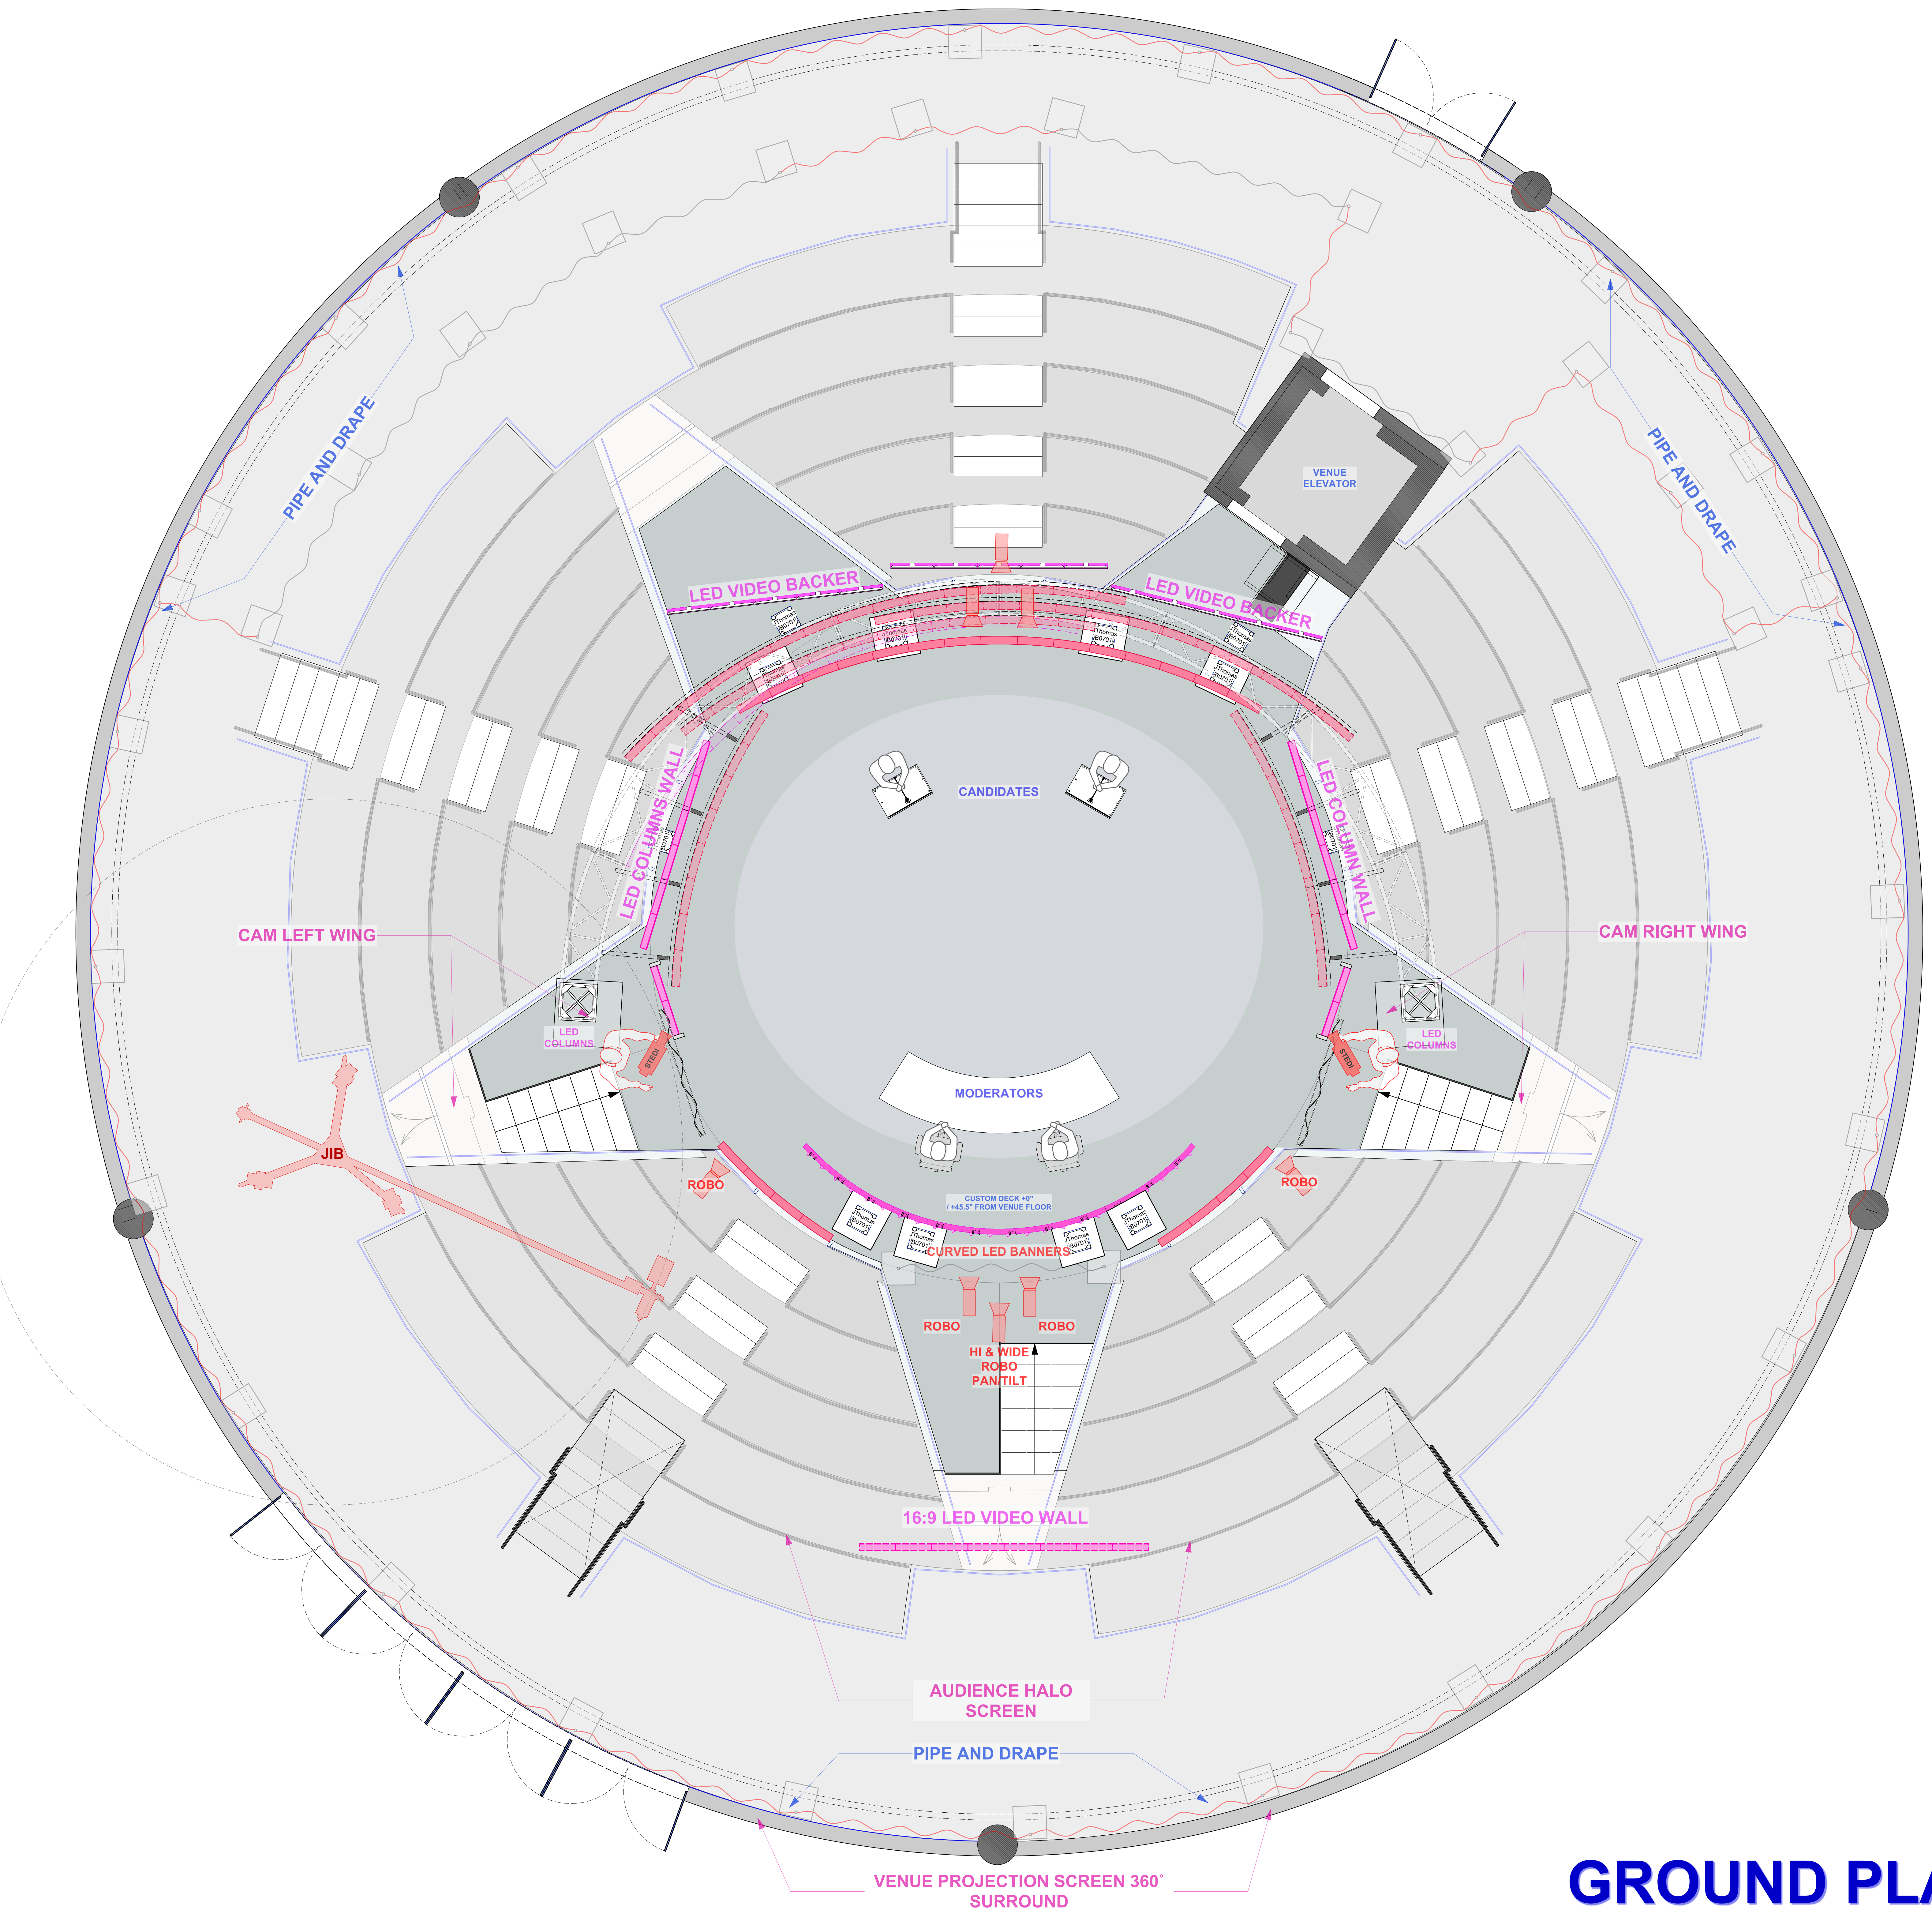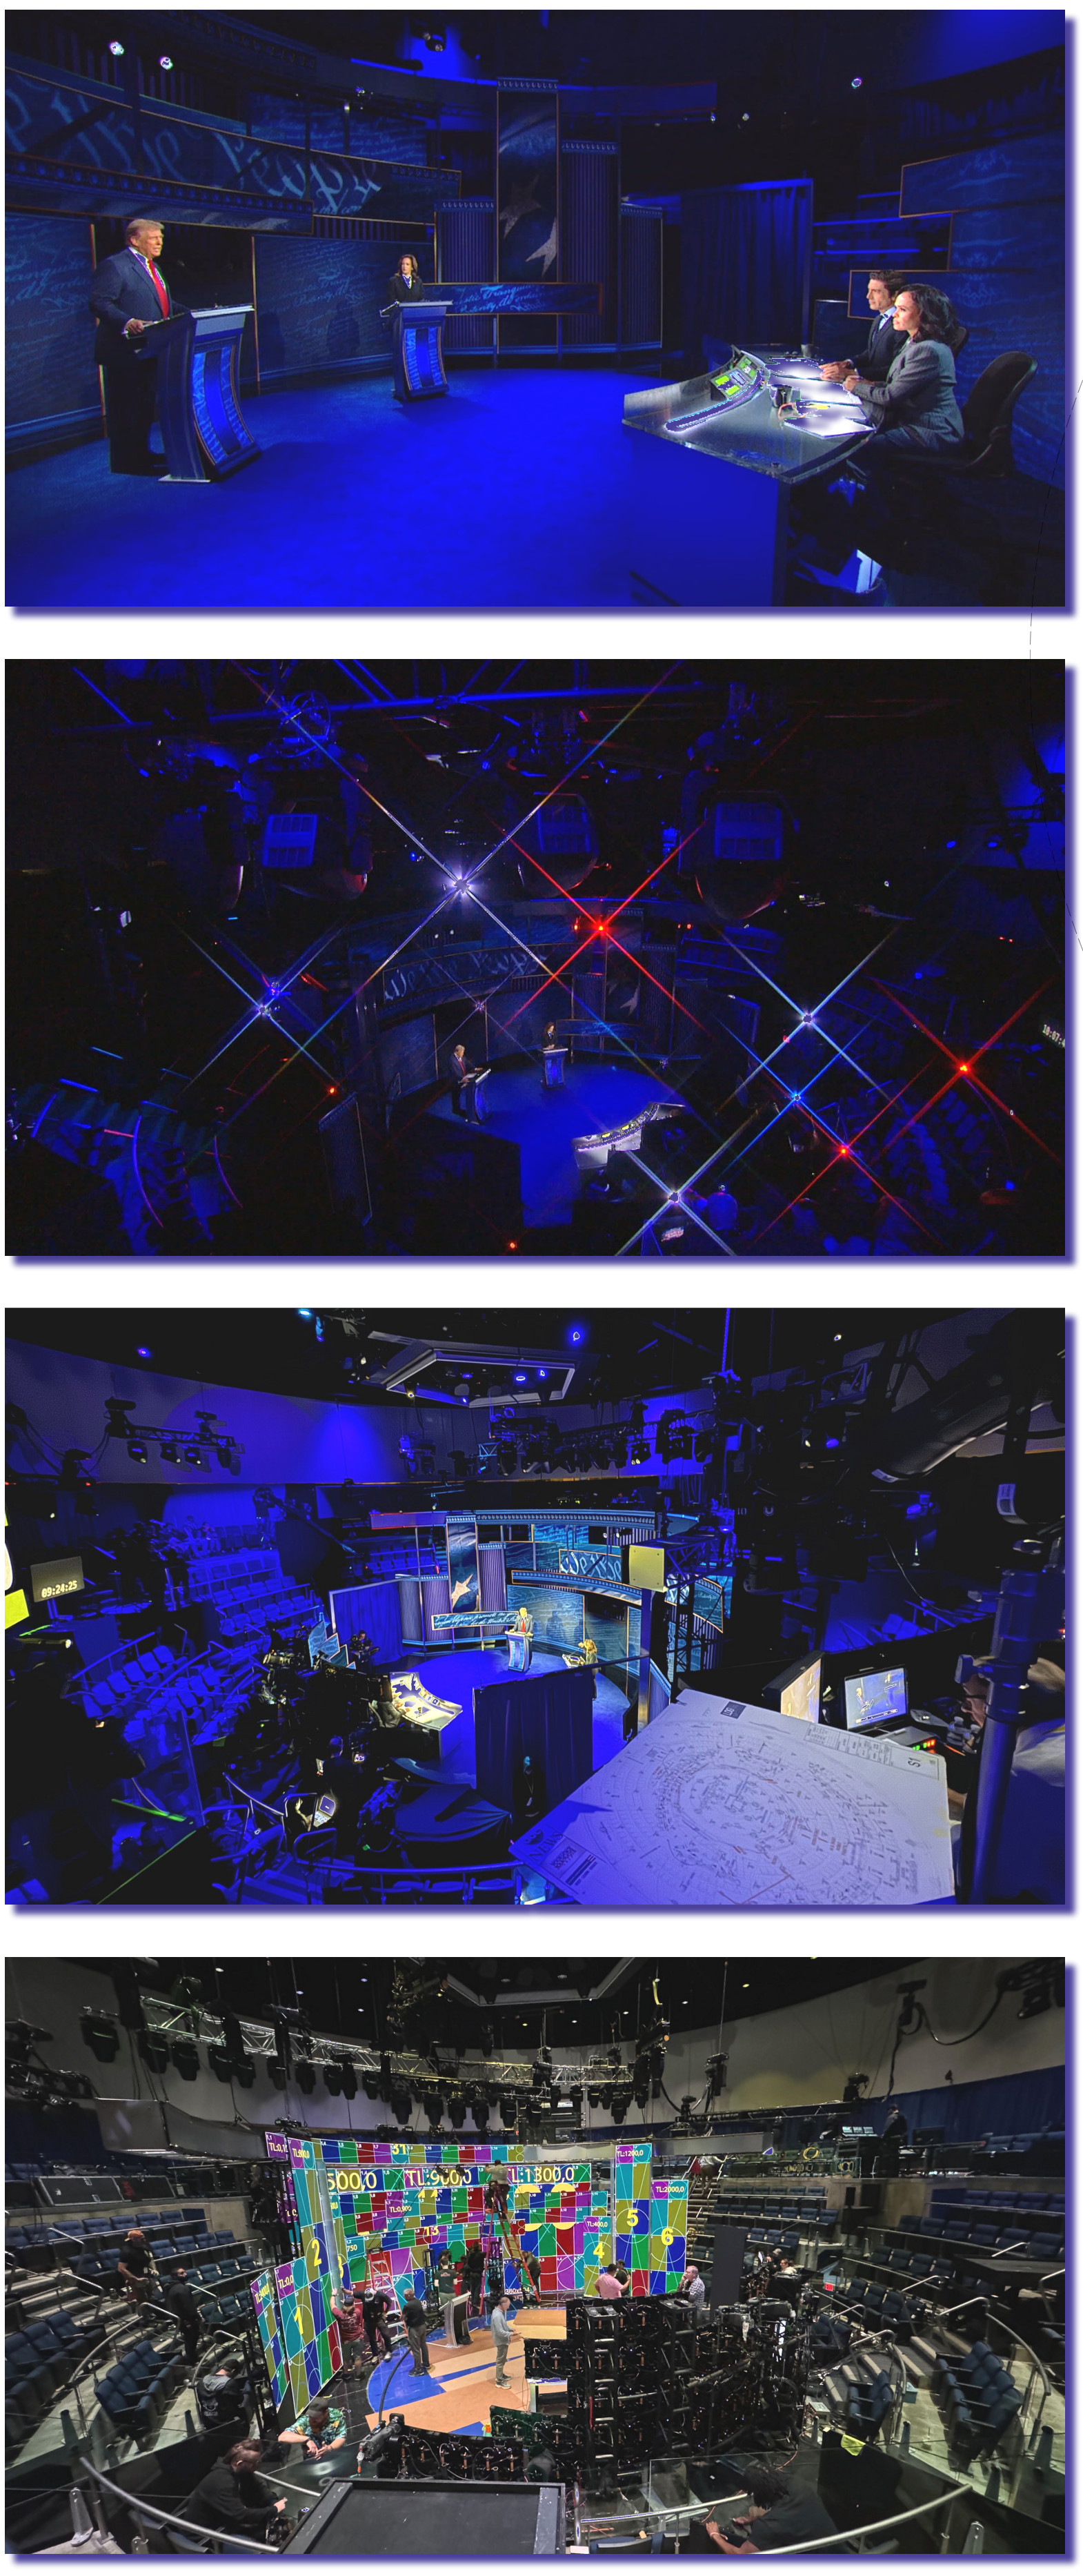

GROUND PLAN

THIS DRAWING AND THE IDEAS, ARRANGEMENT, DESIGN AND PLANS INDICATED HEREON OR REPRESENTED HERE ARE OWNED BY AND REMAIN THE EXCLUSIVE PROPERTY OF THE LIGHTING DESIGN GROUP (LDG). THEY HAVE BEEN CREATED AND DEVELOPED FOR USE ON AND IN CONNECTION WITH THIS SPECIFIC PROJECT ONLY AND MAY NOT BE REPRODUCED OR TRANSMITTED IN ANY FORM OR BY ANY MEANS, ELECTRONIC OR MECHANICAL, INCLUDING PHOTOCOPYING, RECORDING, OR BY ANY INFORMATION STORAGE AND RETRIEVAL SYSTEM, WITHOUT THE EXPRESS WRITTEN PERMISSION OF LDG. WRITTEN DIMENSIONS ON DRAWINGS SHALL HAVE PRECEDENCE OVER DIMENSIONS SHOWN ON DRAWINGS. CONTRACTORS AND MANUFACTURERS SHALL VERIFY AND BE RESPONSIBLE FOR ALL DIMENSIONS AND ASSEMBLY CONDITIONS. ANY VARIATIONS OR DISCREPANCIES IN THE DRAWINGS SHALL BE REPORTED TO LDG PRIOR TO BEGINNING WORK. THESE DRAWINGS REPRESENT VISUAL CONCEPTS ONLY. RESPONSIBILITY FOR STRUCTURAL, ROOMING AND RELATED ENGINEERING IS BY OTHERS. ALL MEANS, METHODS AND MATERIALS TO MEET OR EXCEED APPLICABLE CODES AND INDUSTRY STANDARDS.




NATIONAL CONSTITUTION CENTER
 VISIT · LEARN · DEBATE


REVISIONS			
#	BY	DATE	DESCRIPTION
1	STK	08/16/2024	2020 LX ADAPTATION
2	STK	08/21/2024	NEW GROUND PLAN
3	STK	08/22/2024	UPDATED SCENIC
4	KNOTH	08/25/2024	REDLINES/UPDATES
5	STK	09/14/2024	ARCHIVAL

DRAWING TITLE	
DEBATE - GROUND PLAN	
PRODUCER	DESIGNER
ABC NEWS	DENNIS SIZE
SCALE	GAFFER
3/8" = 10"	JON GOSS
PROJECT ID	DRAWN BY
ABCN2408	STK
FILE NAME	FACILITY
20240905-ABCN2408-PLO T-VS.vwx	525 ARCH ST, INDEPENDENCE MALL, PHILADELPHIA, PA 19106-1595
PLATE	


FRONT ELEVATION - SHADED

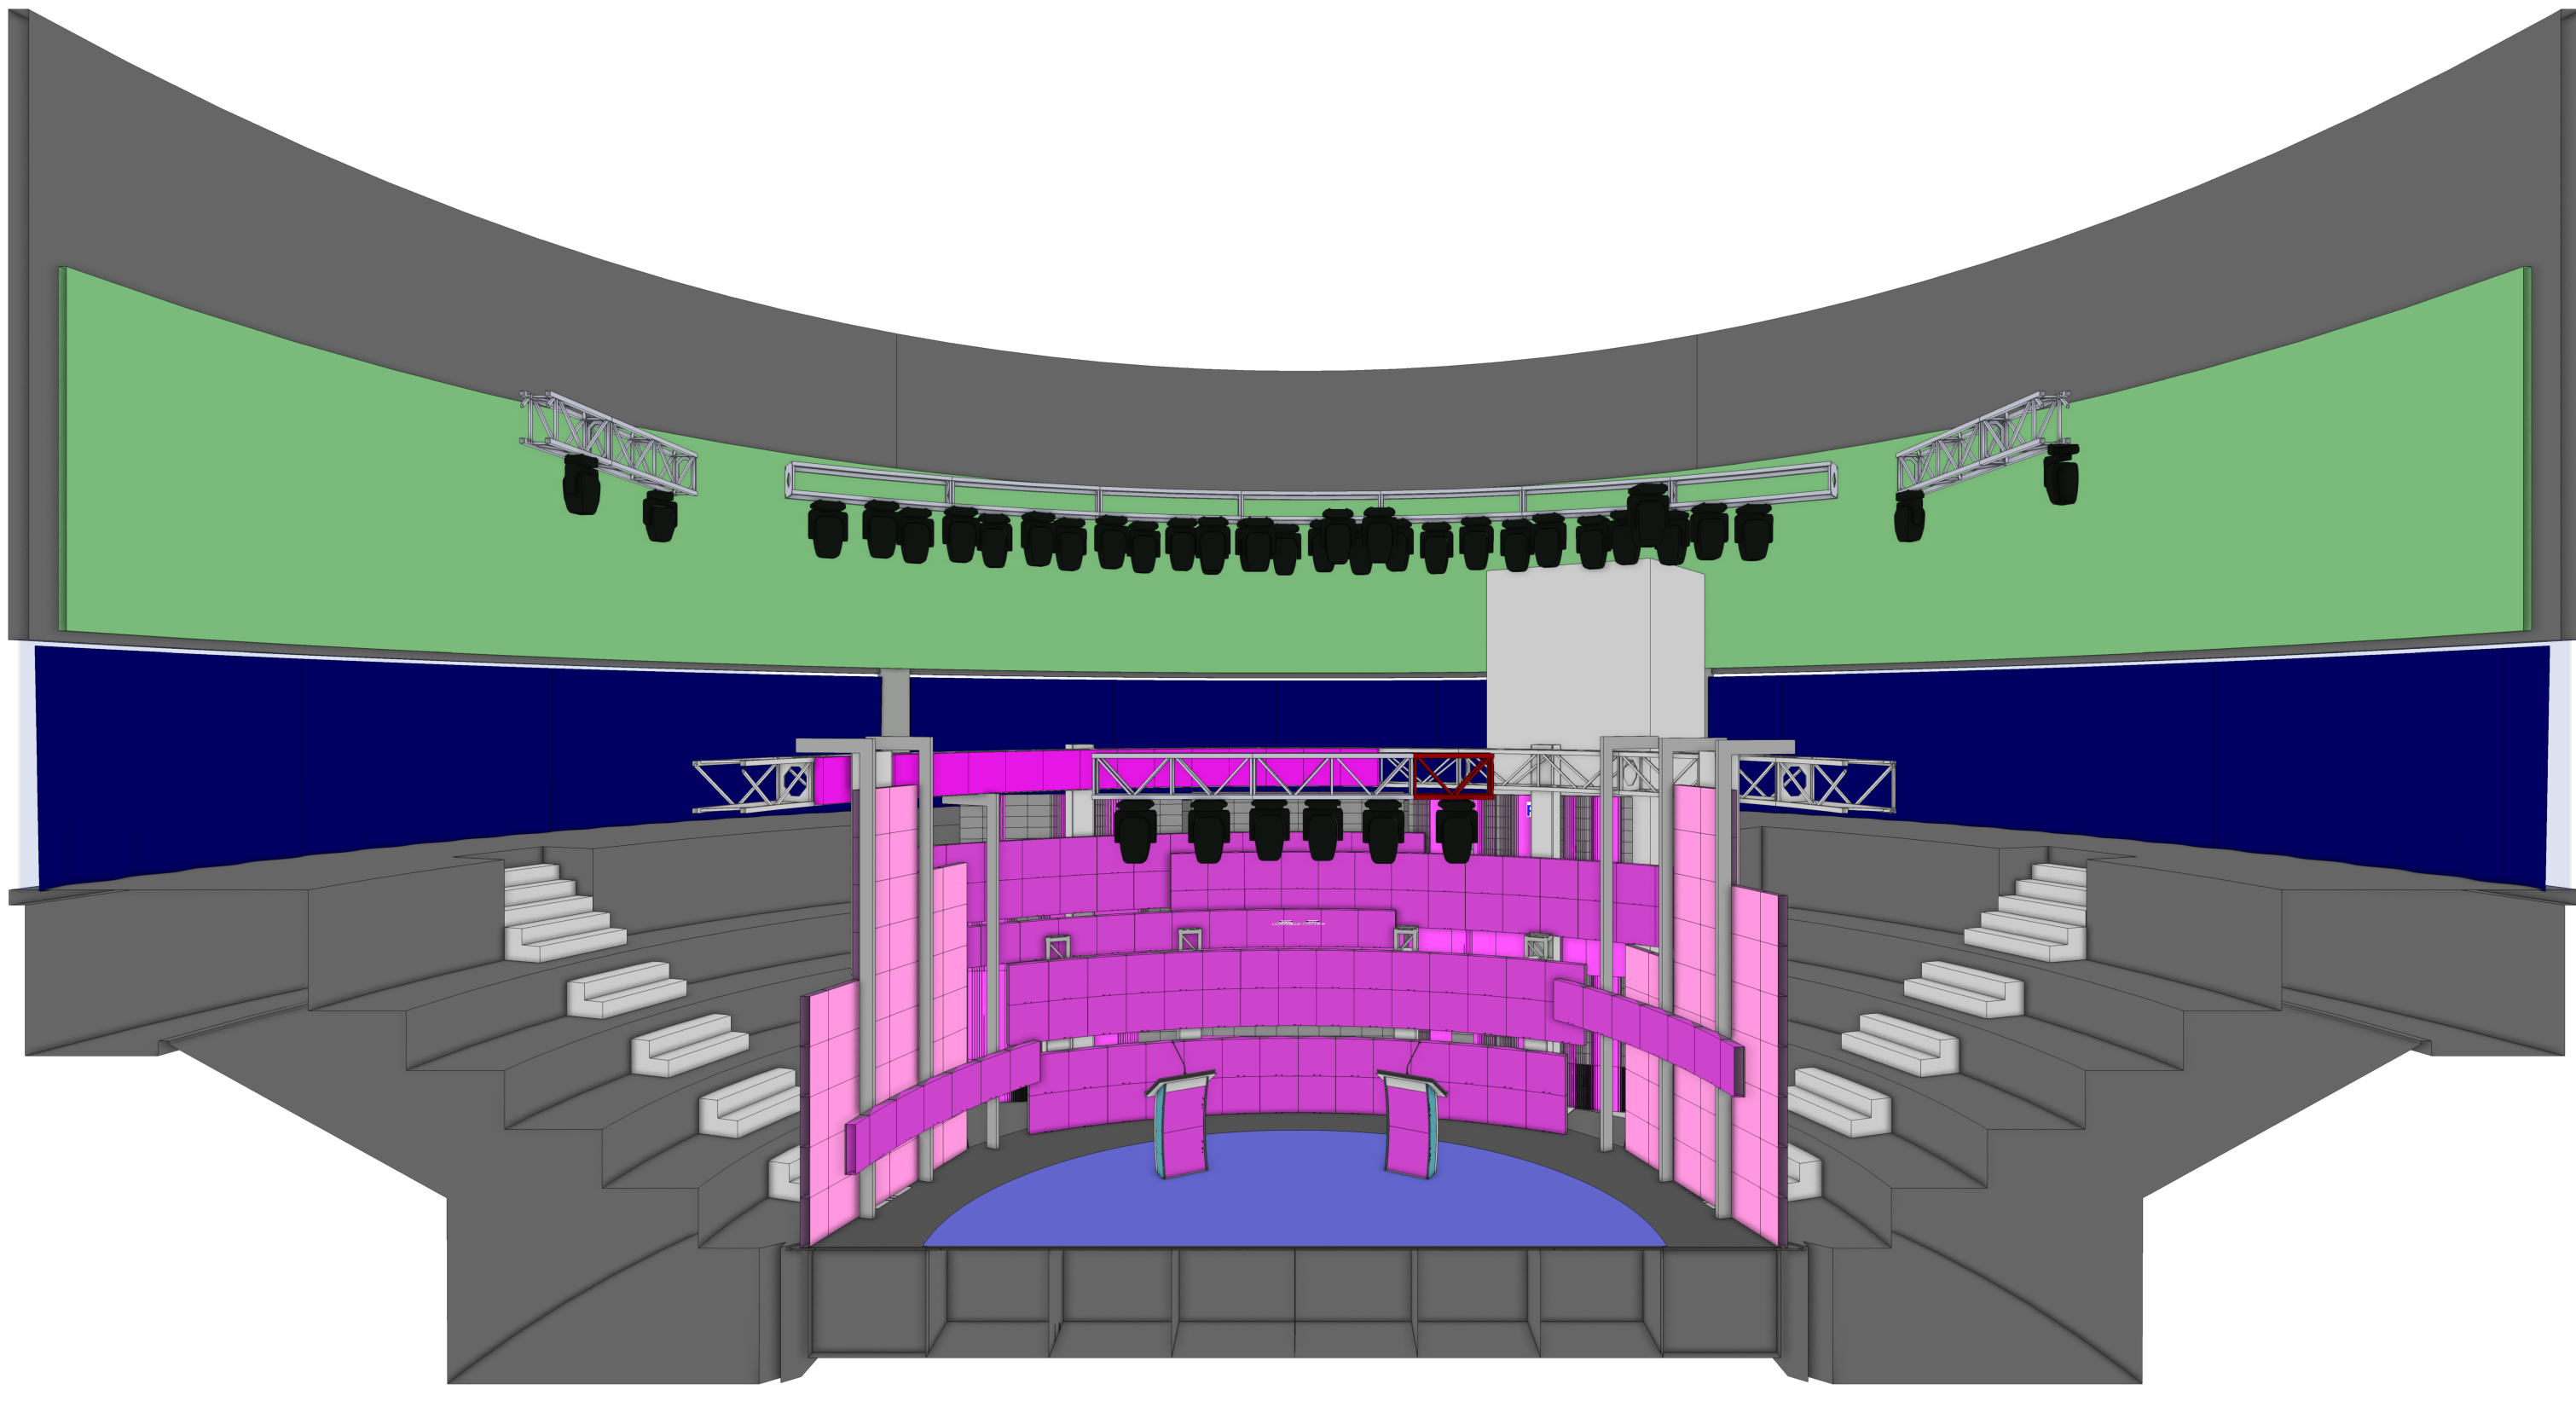


FRONT ELEVATION - HIDDEN LINE

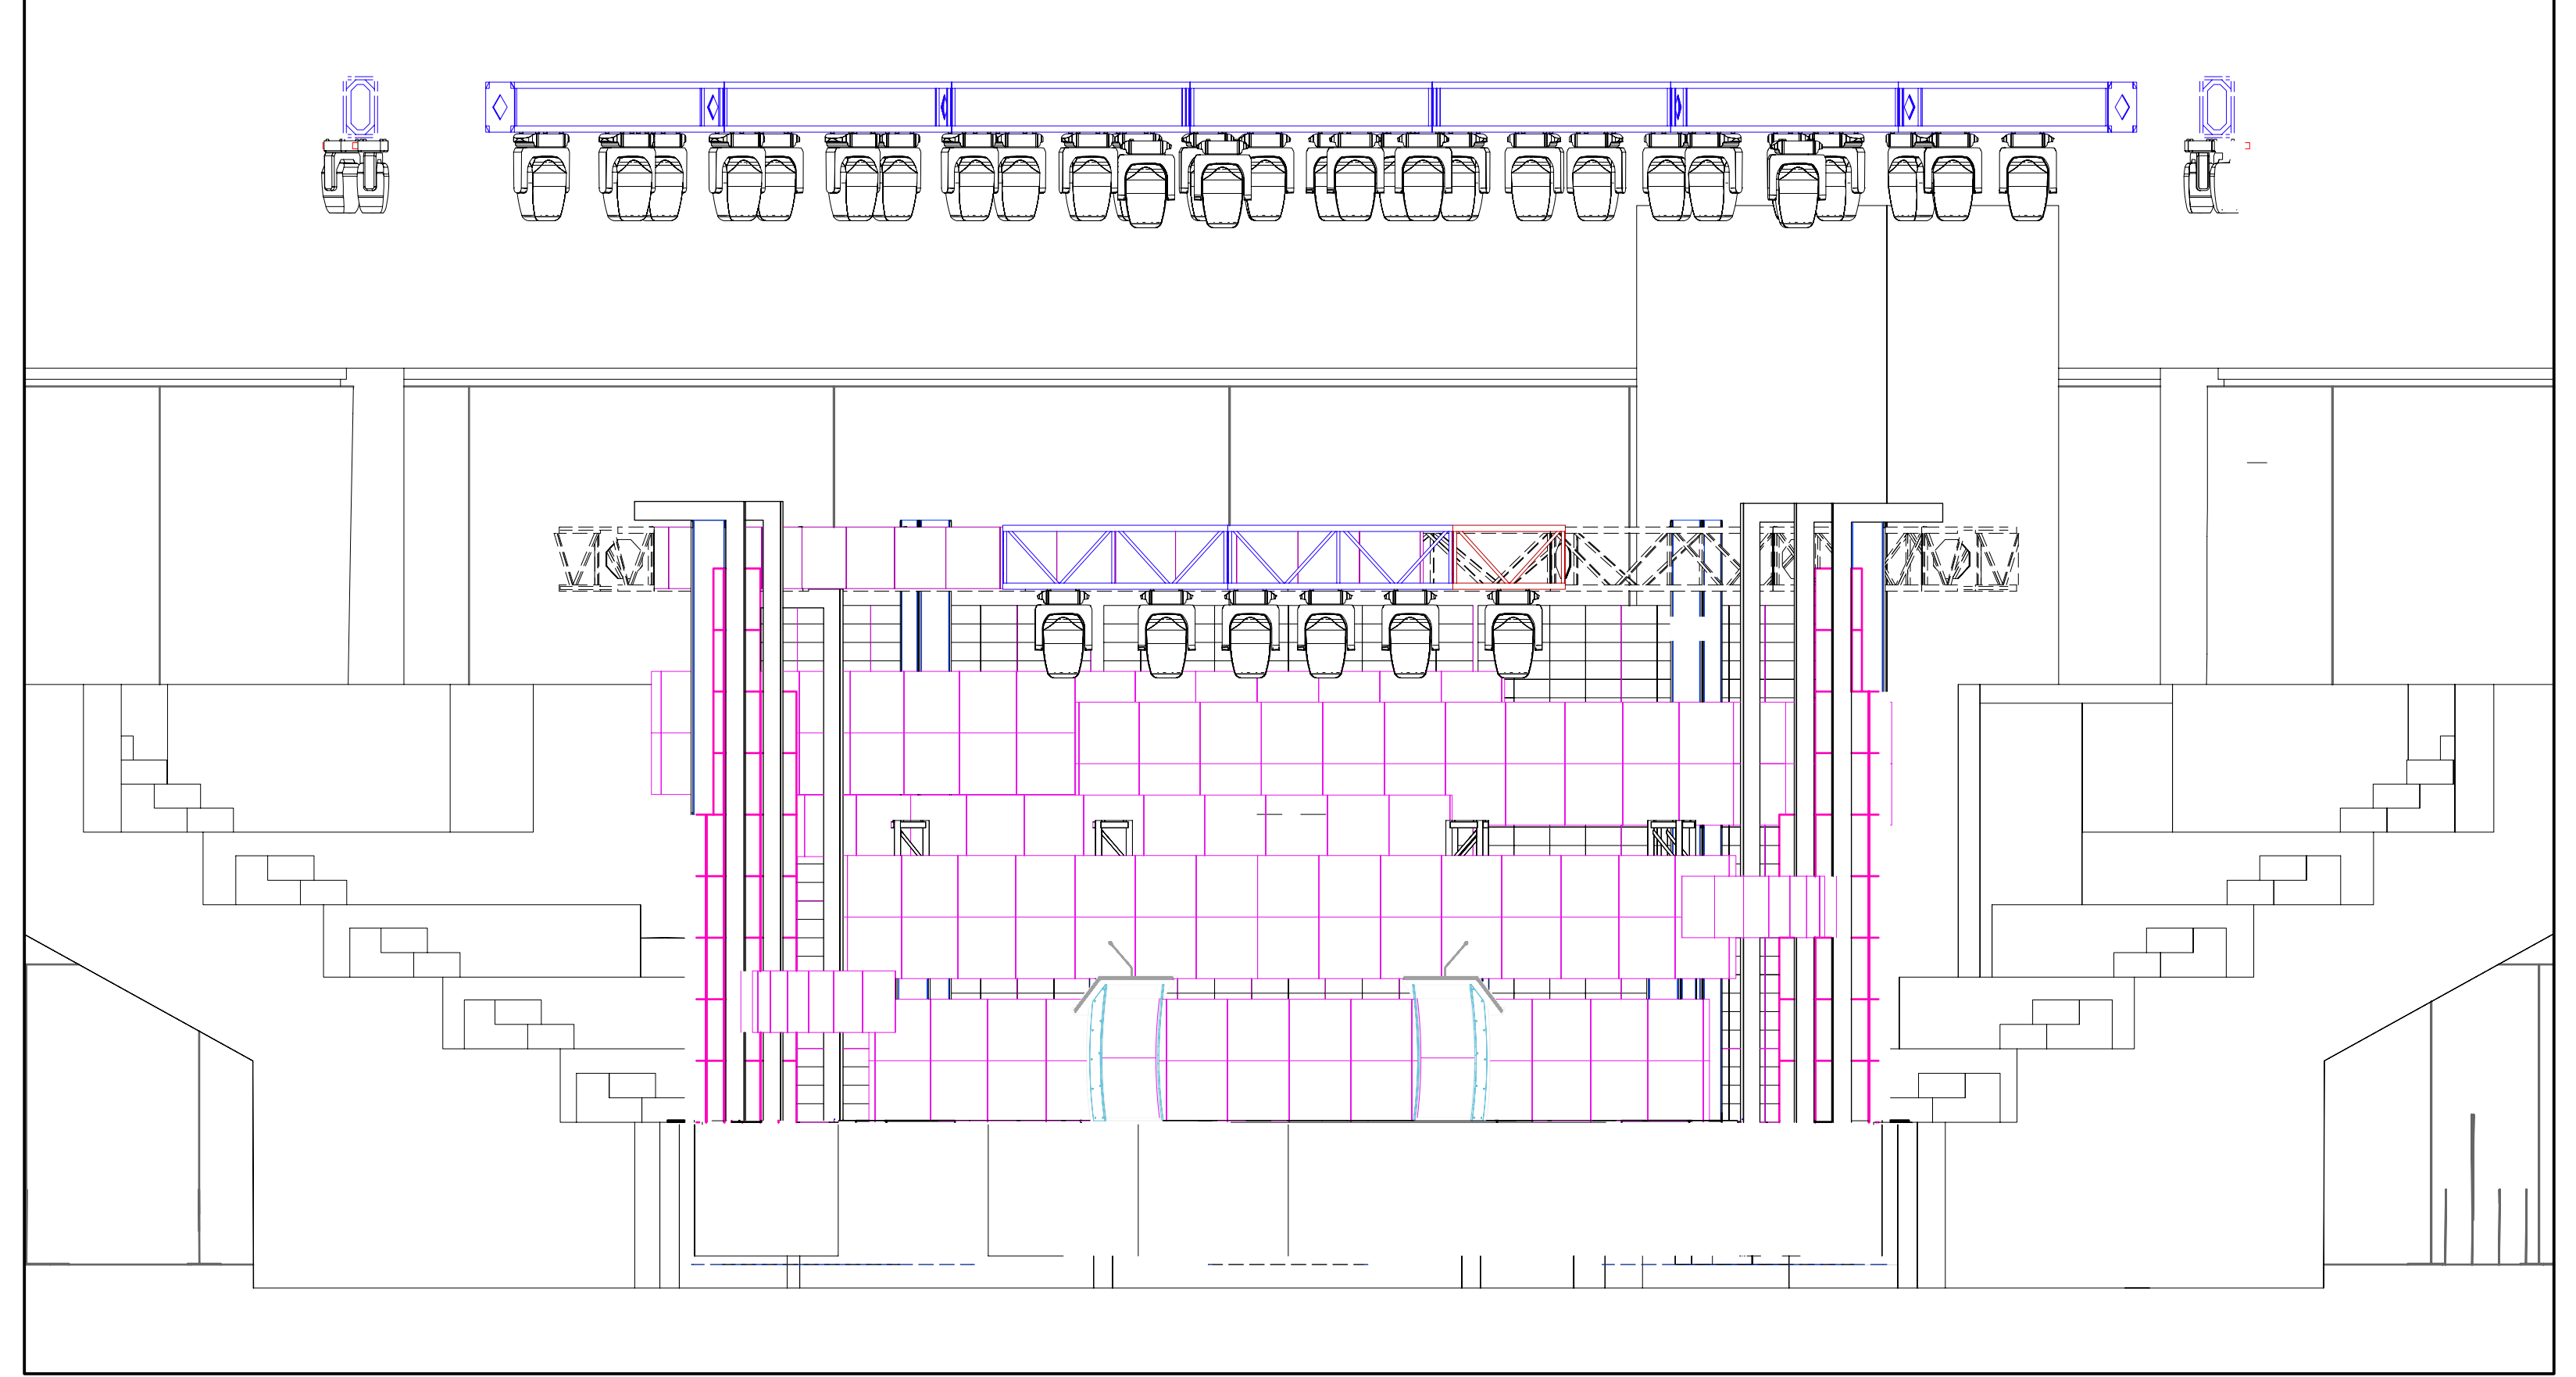


LEFT SECTION - SHADED

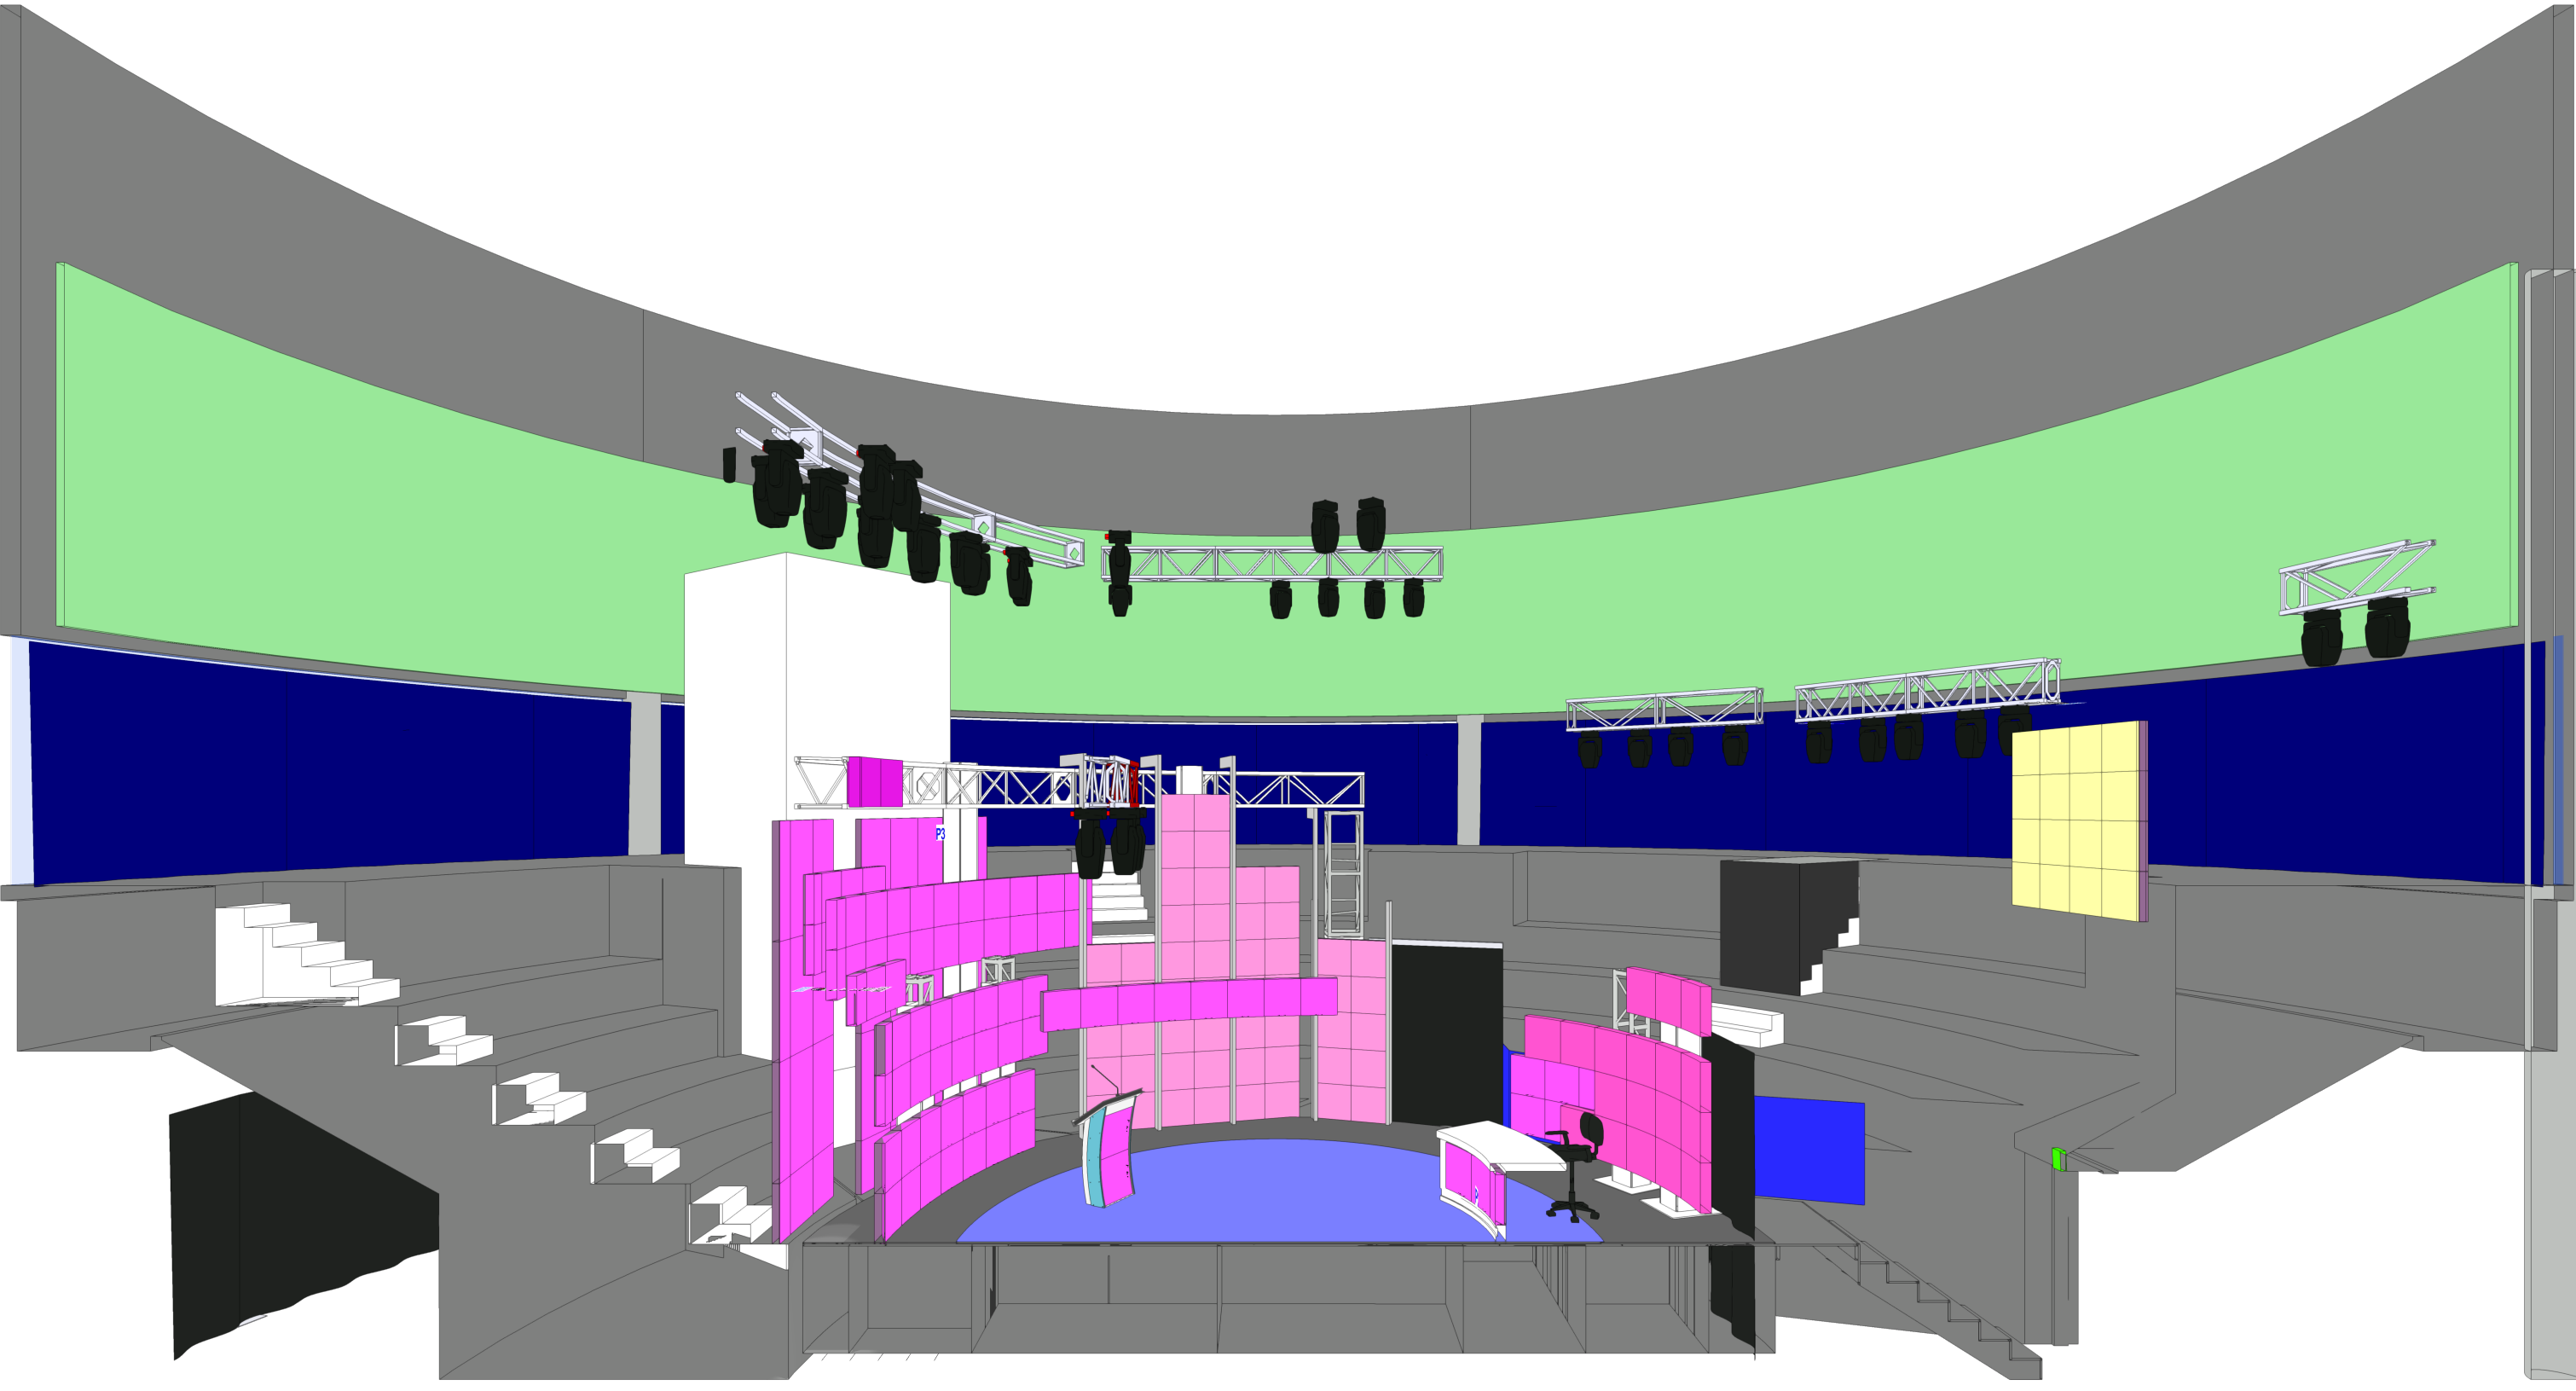


LEFT SECTION - HIDDEN LINE

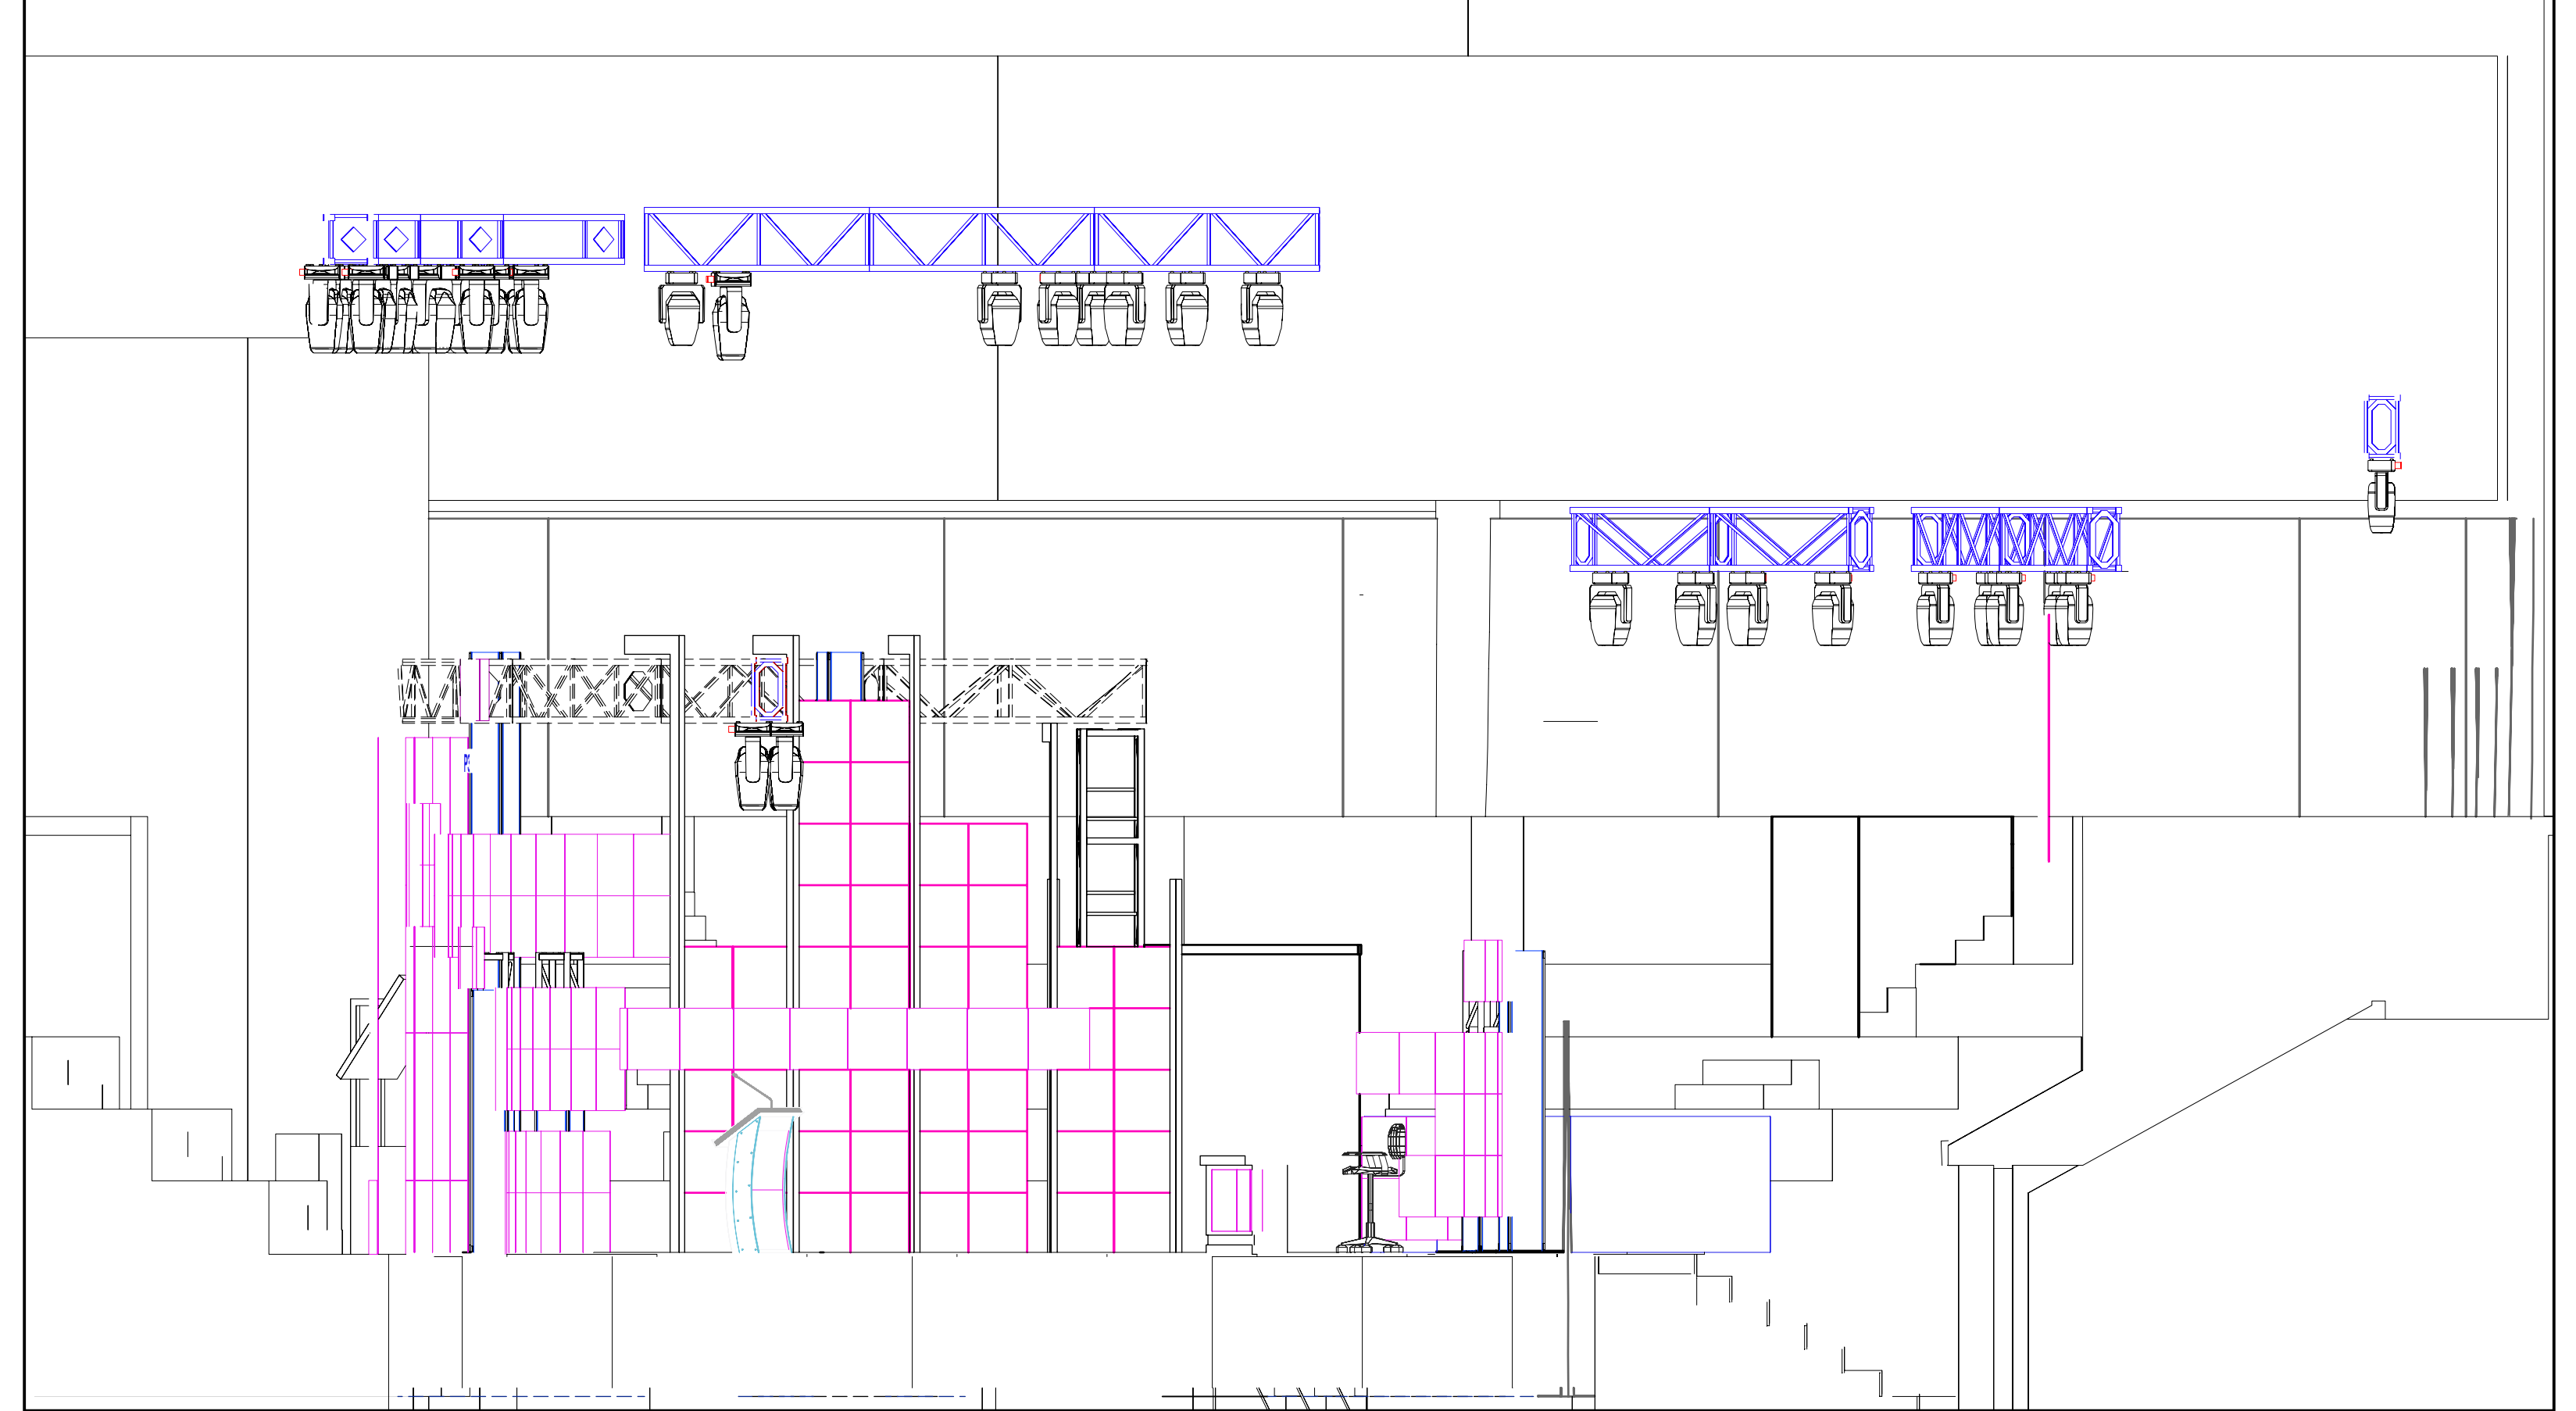


BACK ELEVATION - SHADED

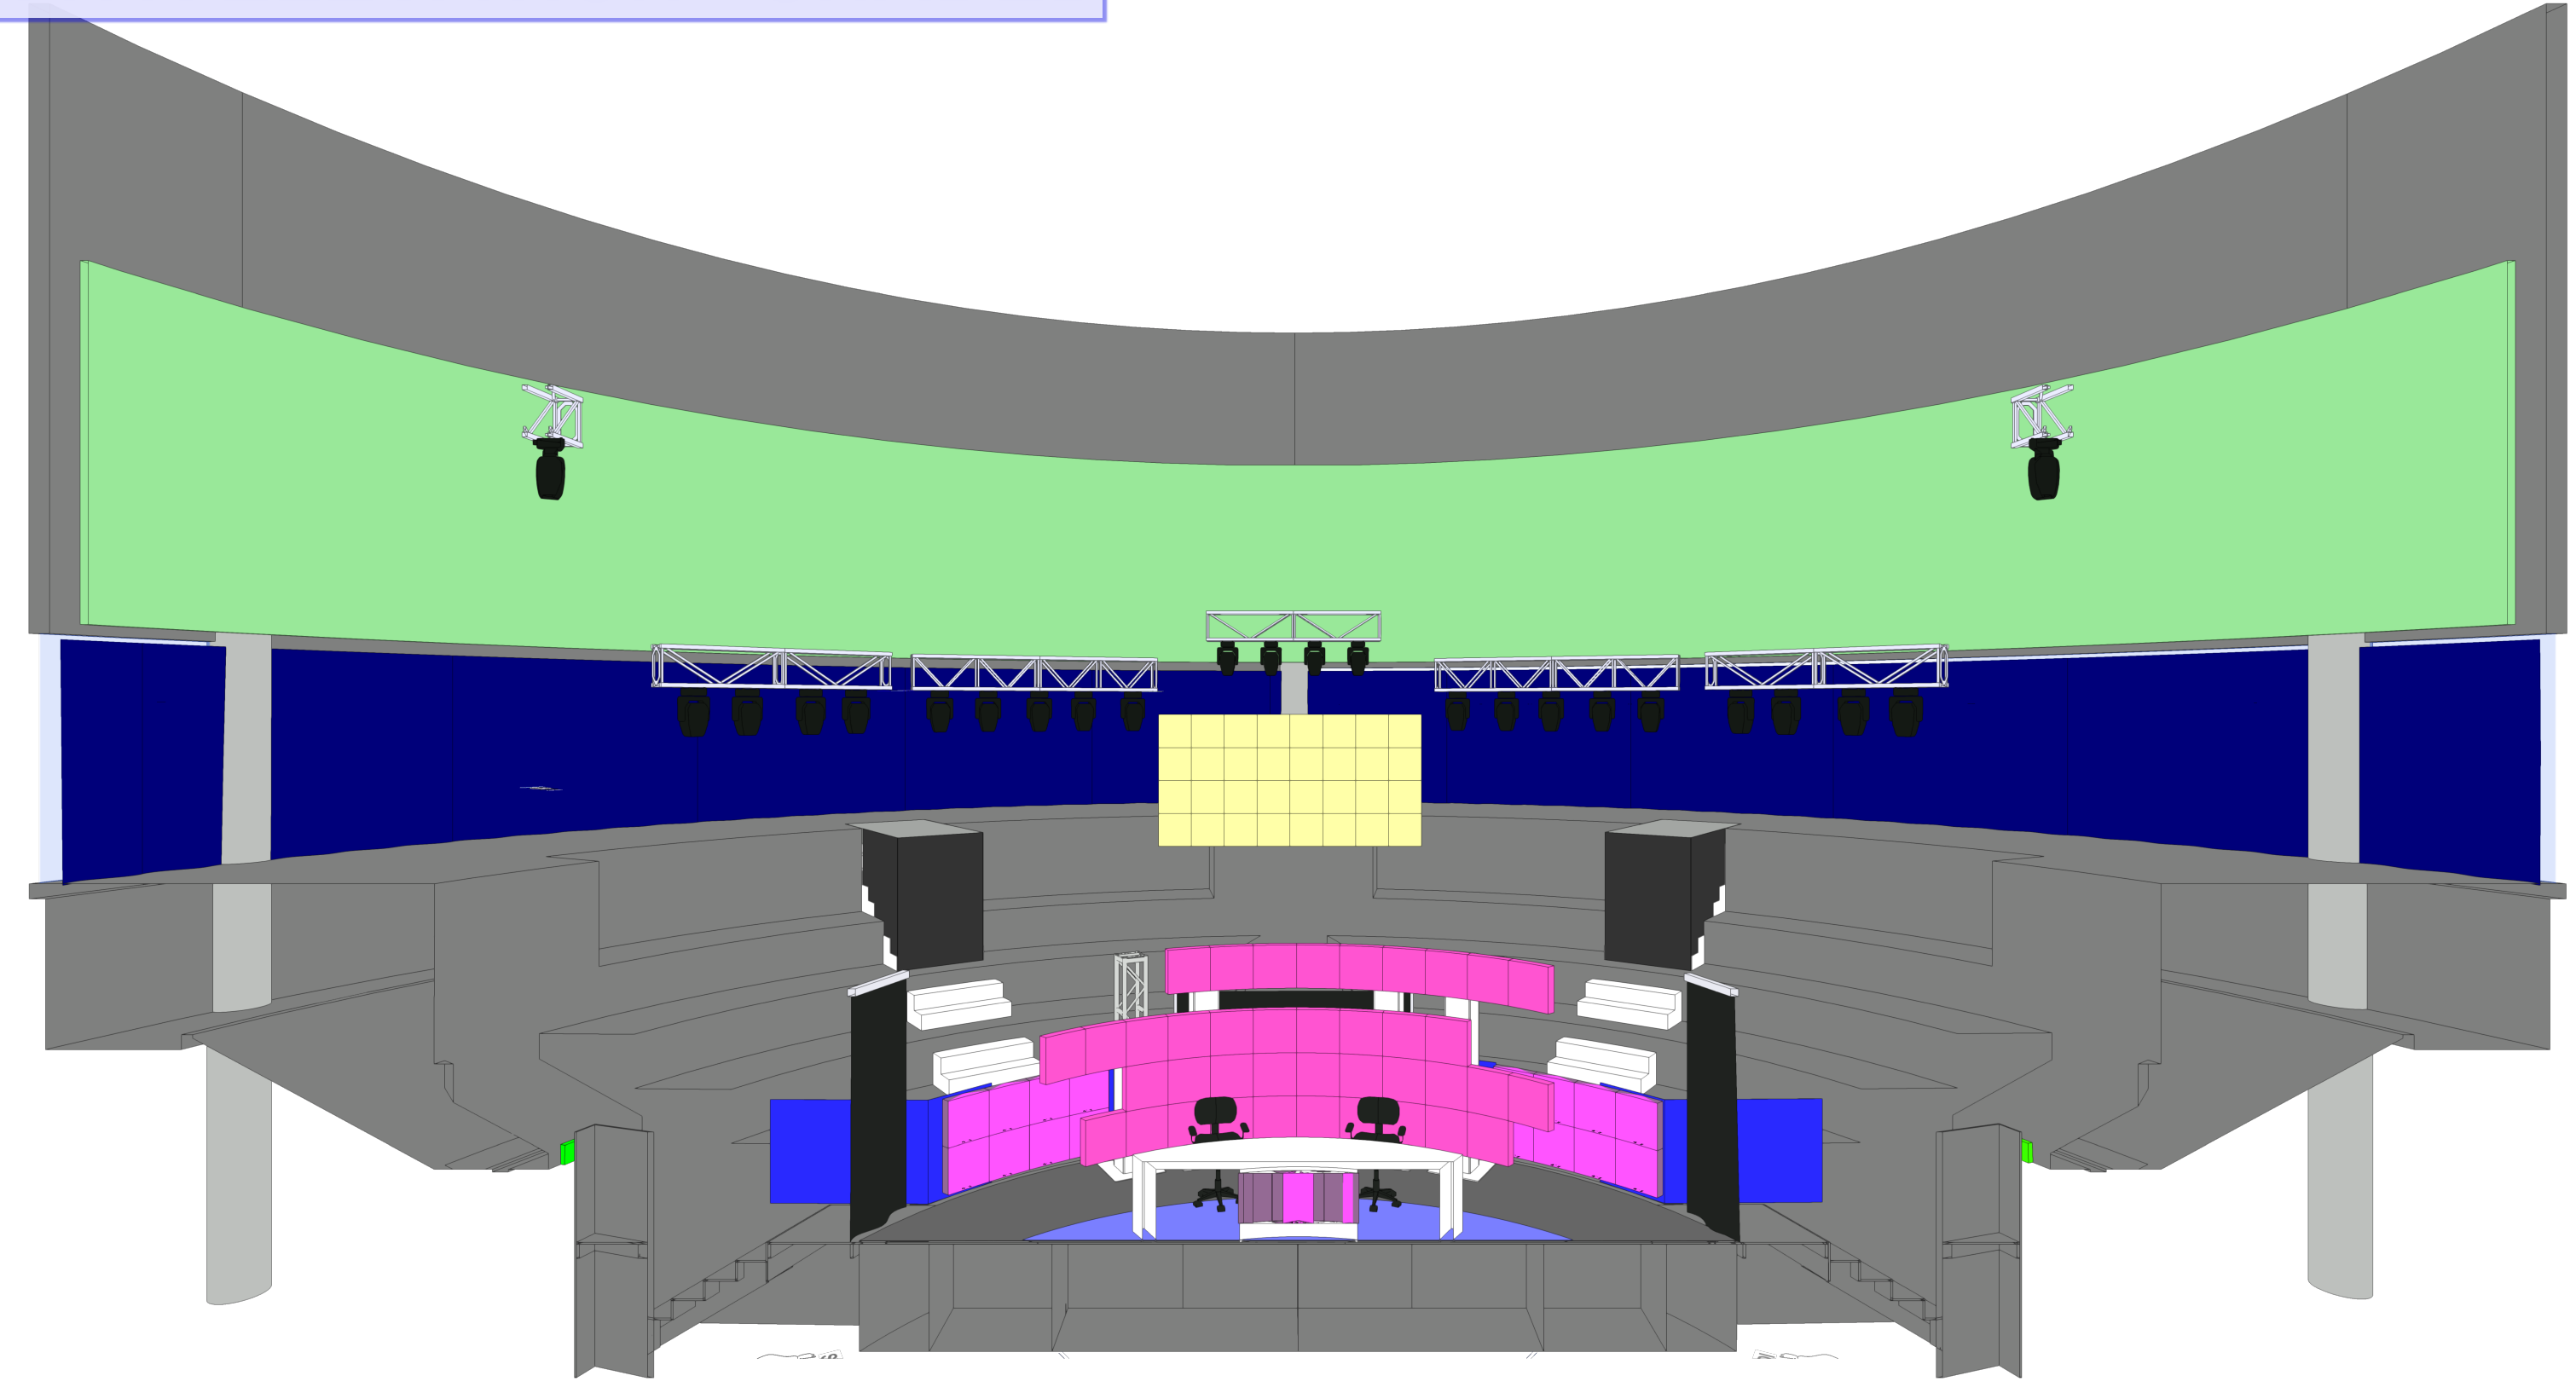


BACK ELEVATION - HIDDEN LINE

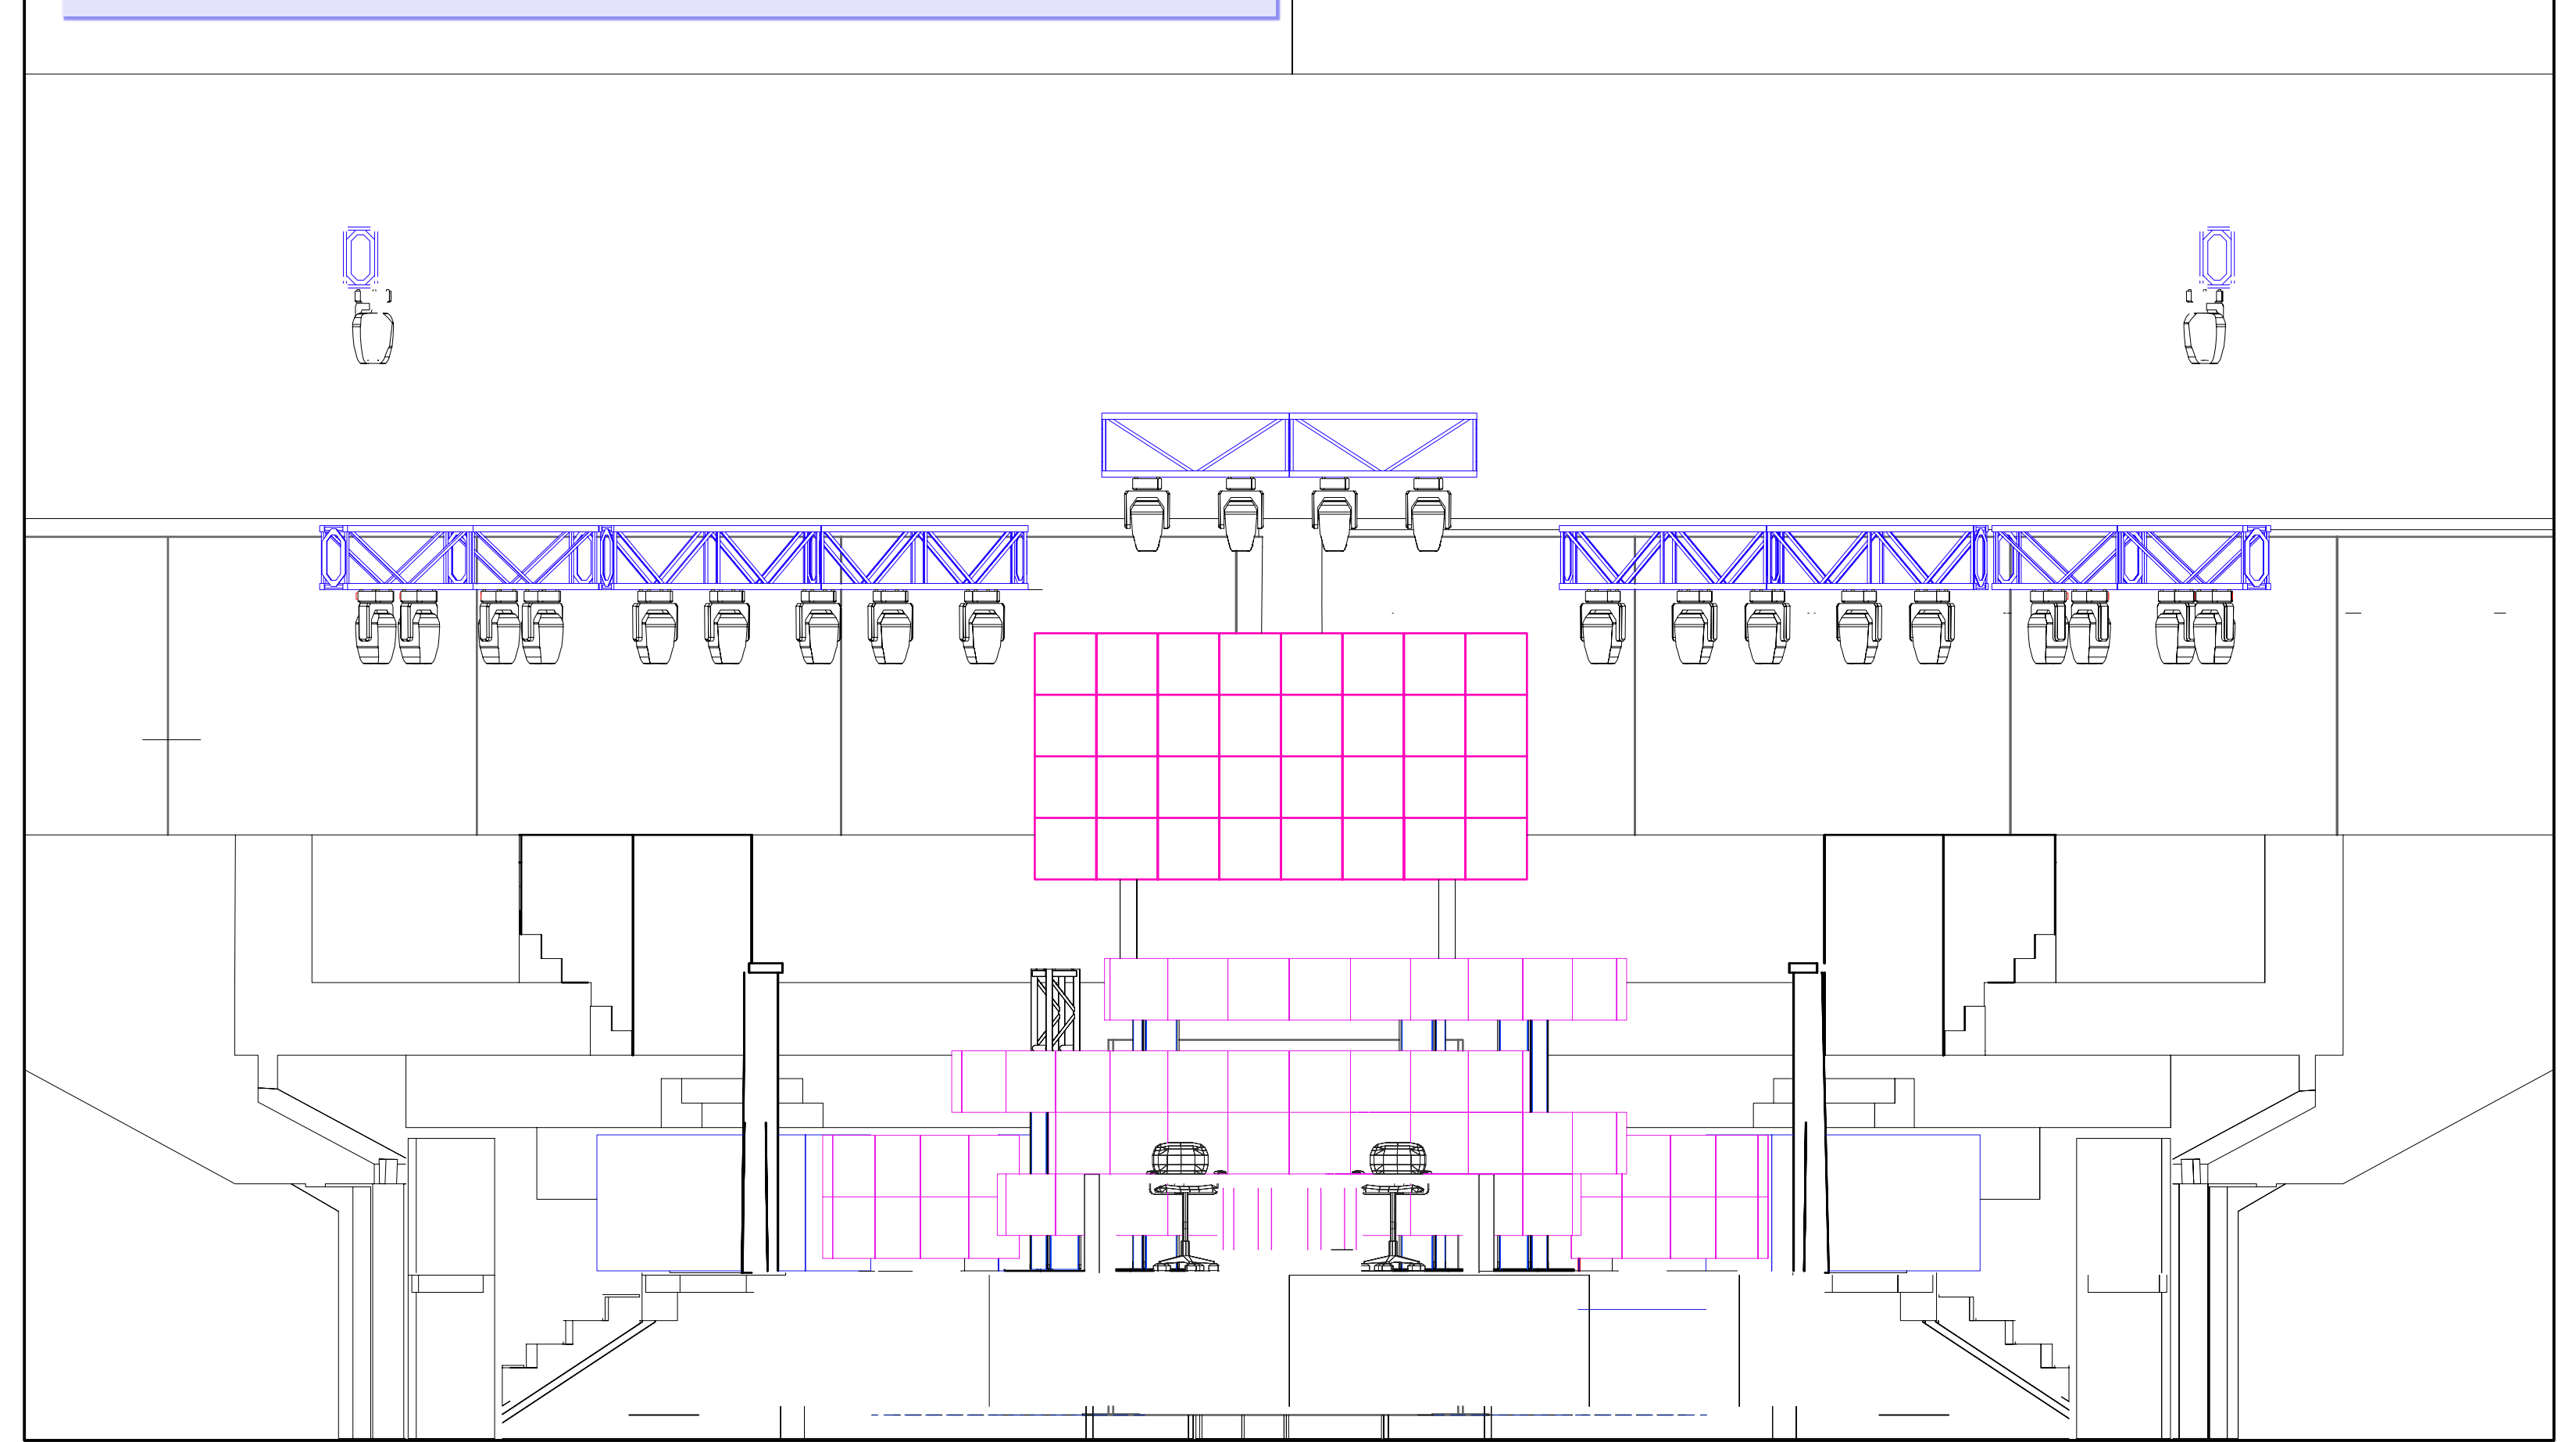

RIGHT SECTION - SHADED


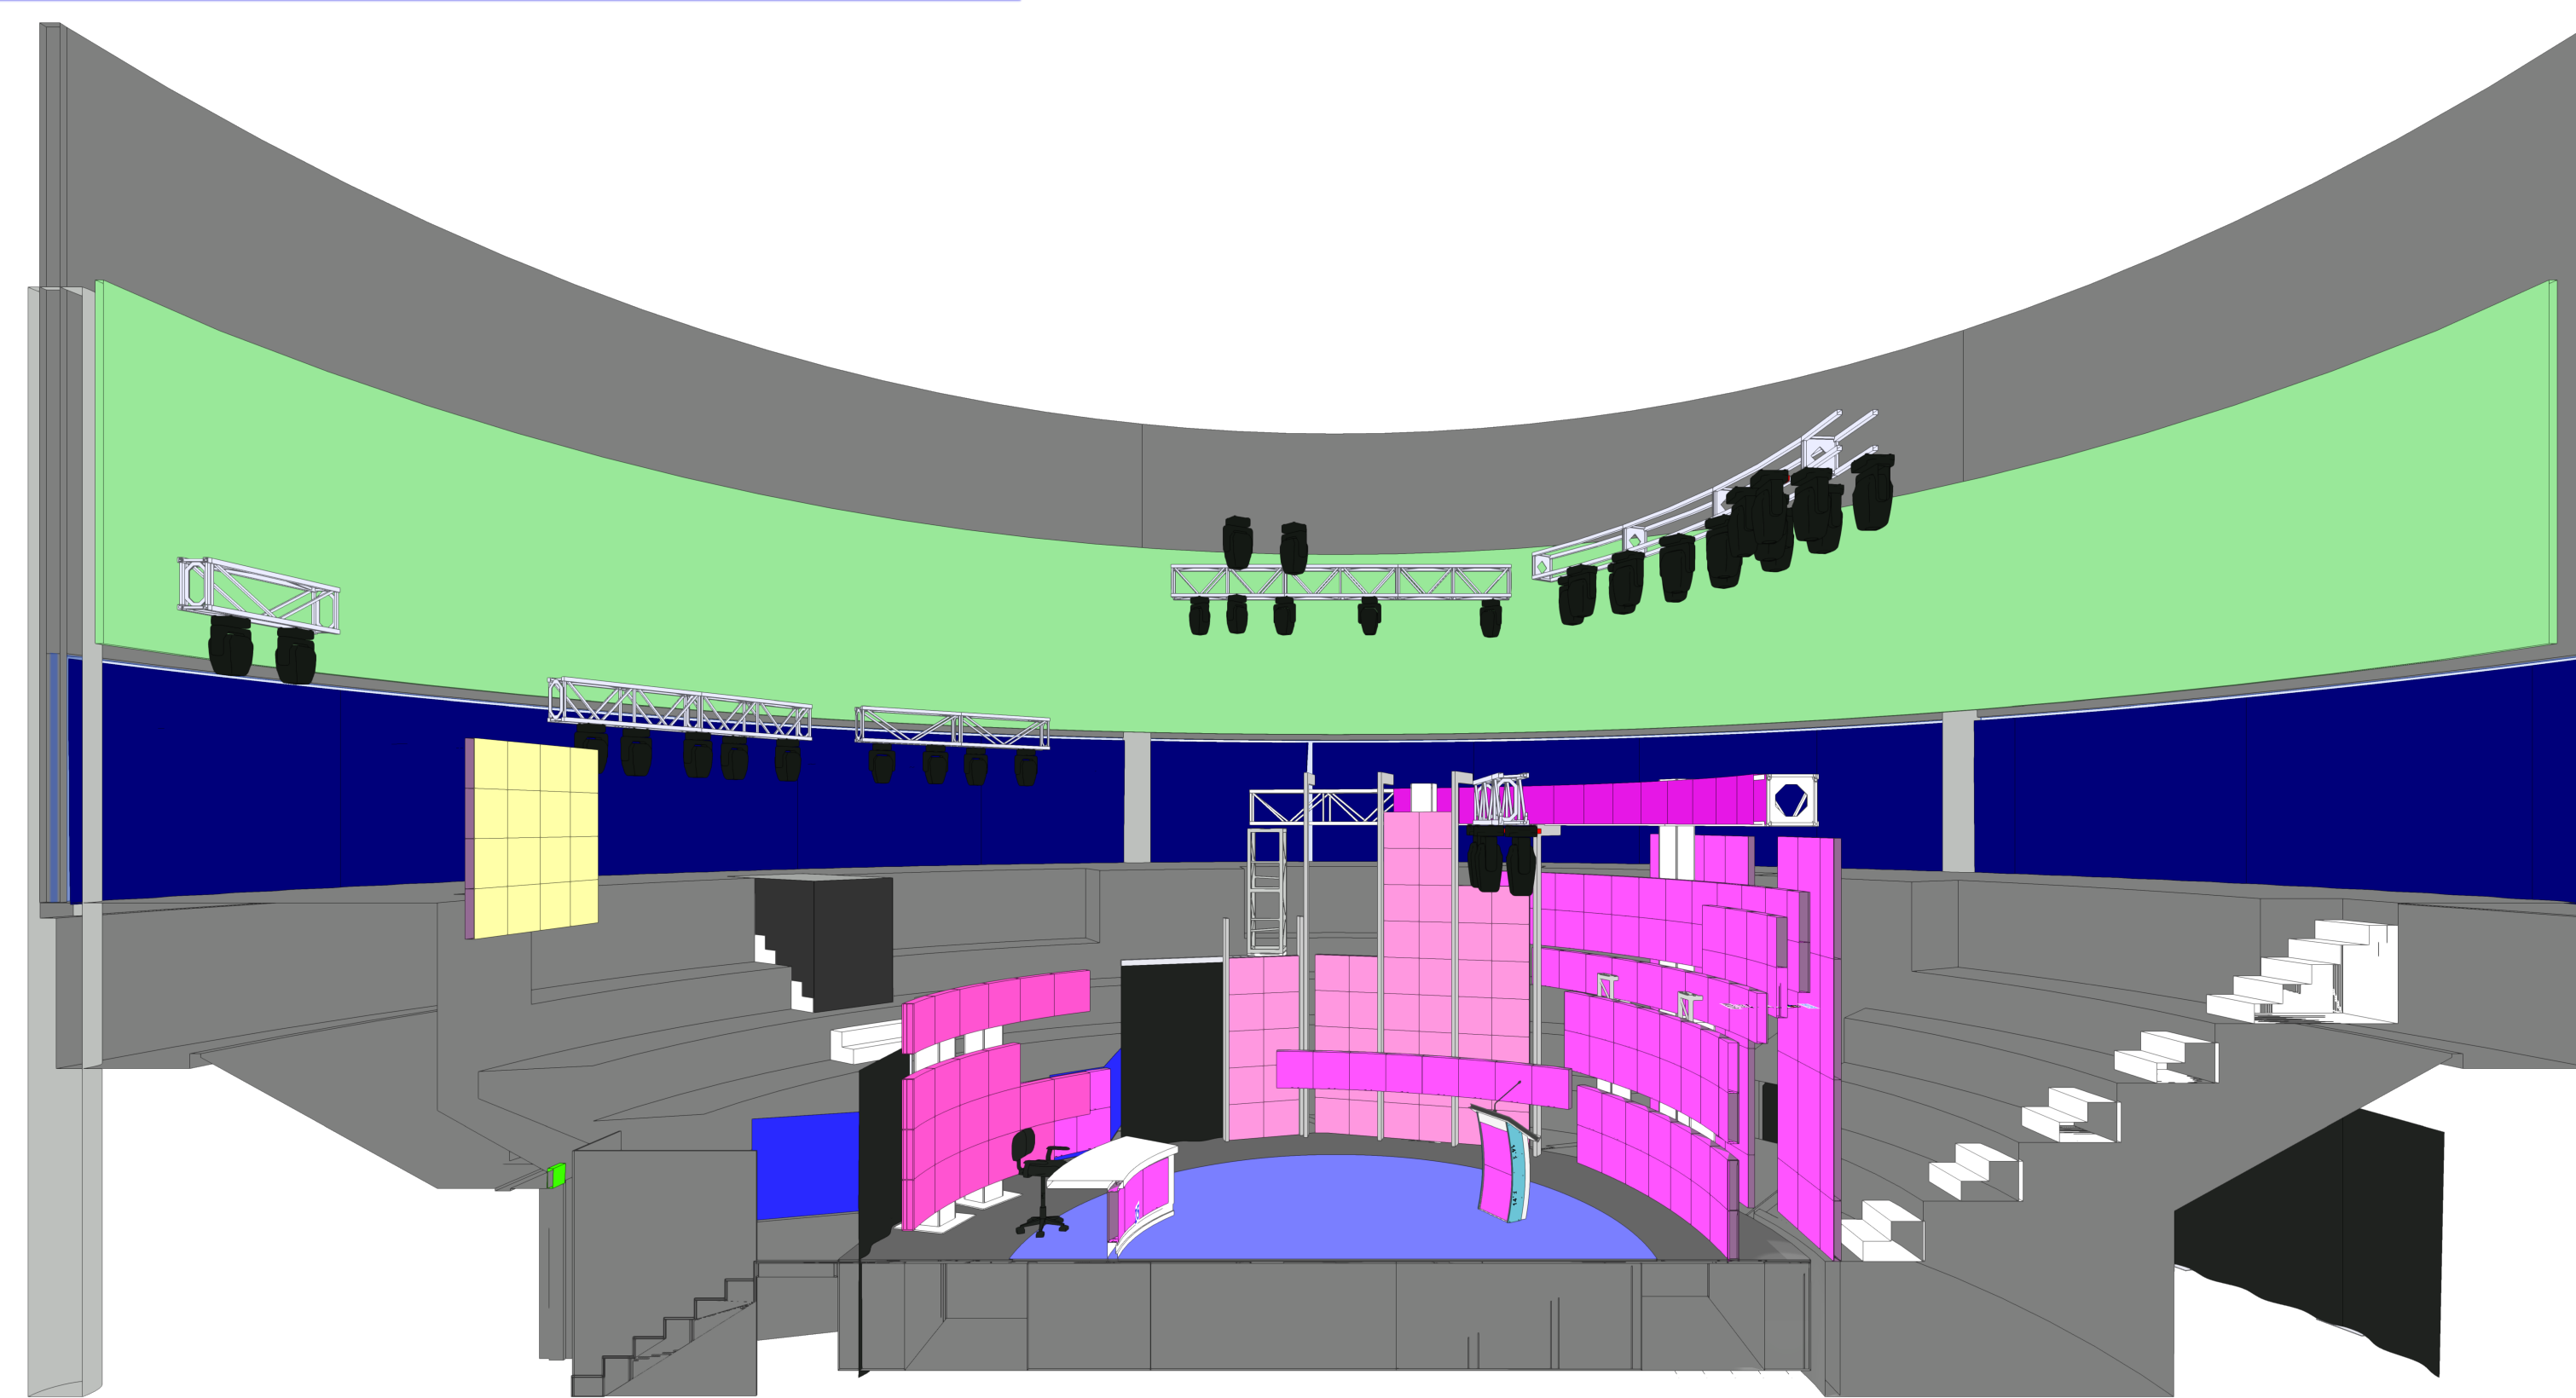


RIGHT SECTION - HIDDEN LINE

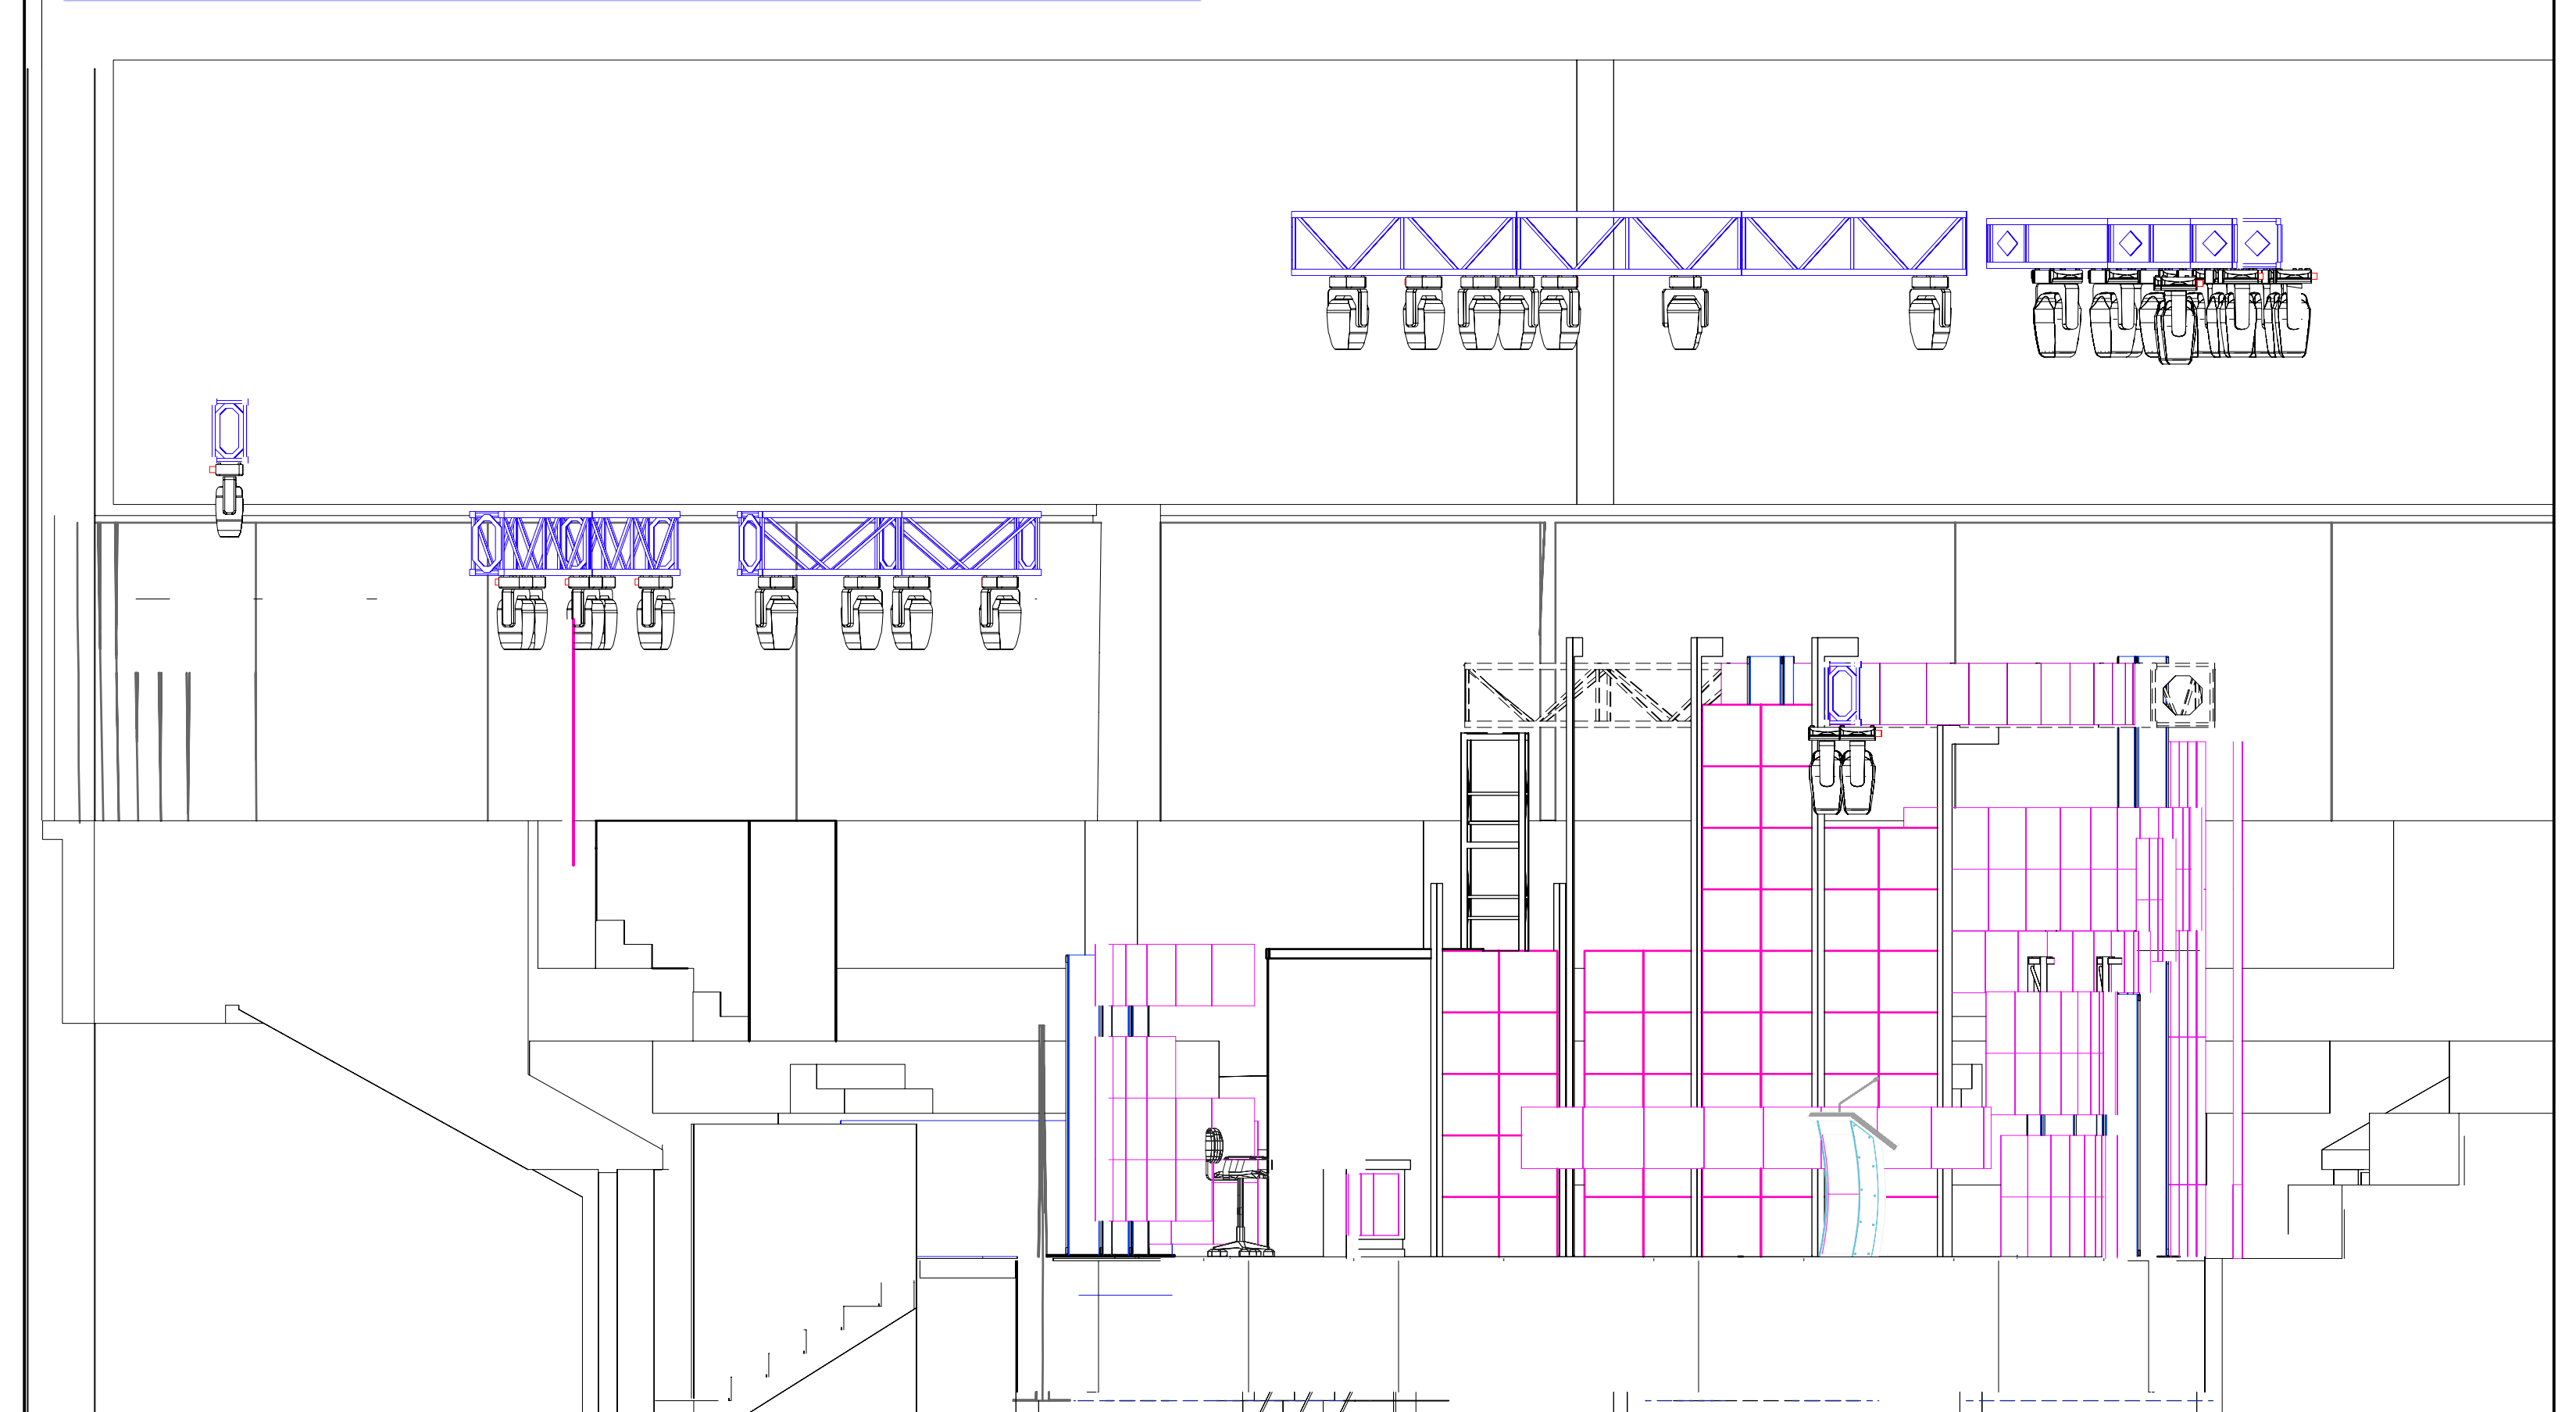

REVISIONS			
#	BY	DATE	DESCRIPTION
1	STK	08/16/2024	2020 LX ADAPTATION
2	STK	08/21/2024	NEW GROUND PLAN
3	STK	08/22/2024	UPDATED SCENIC
4	KNOTH	08/25/2024	REDLINES/UPDATES
5	STK	09/14/2024	ARCHIVAL

DRAWING TITLE			
DEBATE - ELEVATIONS/SECTIONS		FILE NAME	
PRODUCER	DESIGNER	20240905-ABCN2408-PLO	
ABC NEWS	DENNIS SIZE	T-VS.wvx	
SCALE	GAFFER	FILE NAME	
1/4" = 1'0"	JON GOSS	20240905-ABCN2408-PLO	
PROJECT ID	DRAWN BY	FACILITY	
ABCN2408	STK	525 ARCH ST. INDEPENDENCE MALL, PHILADELPHIA, PA 19106-1595	

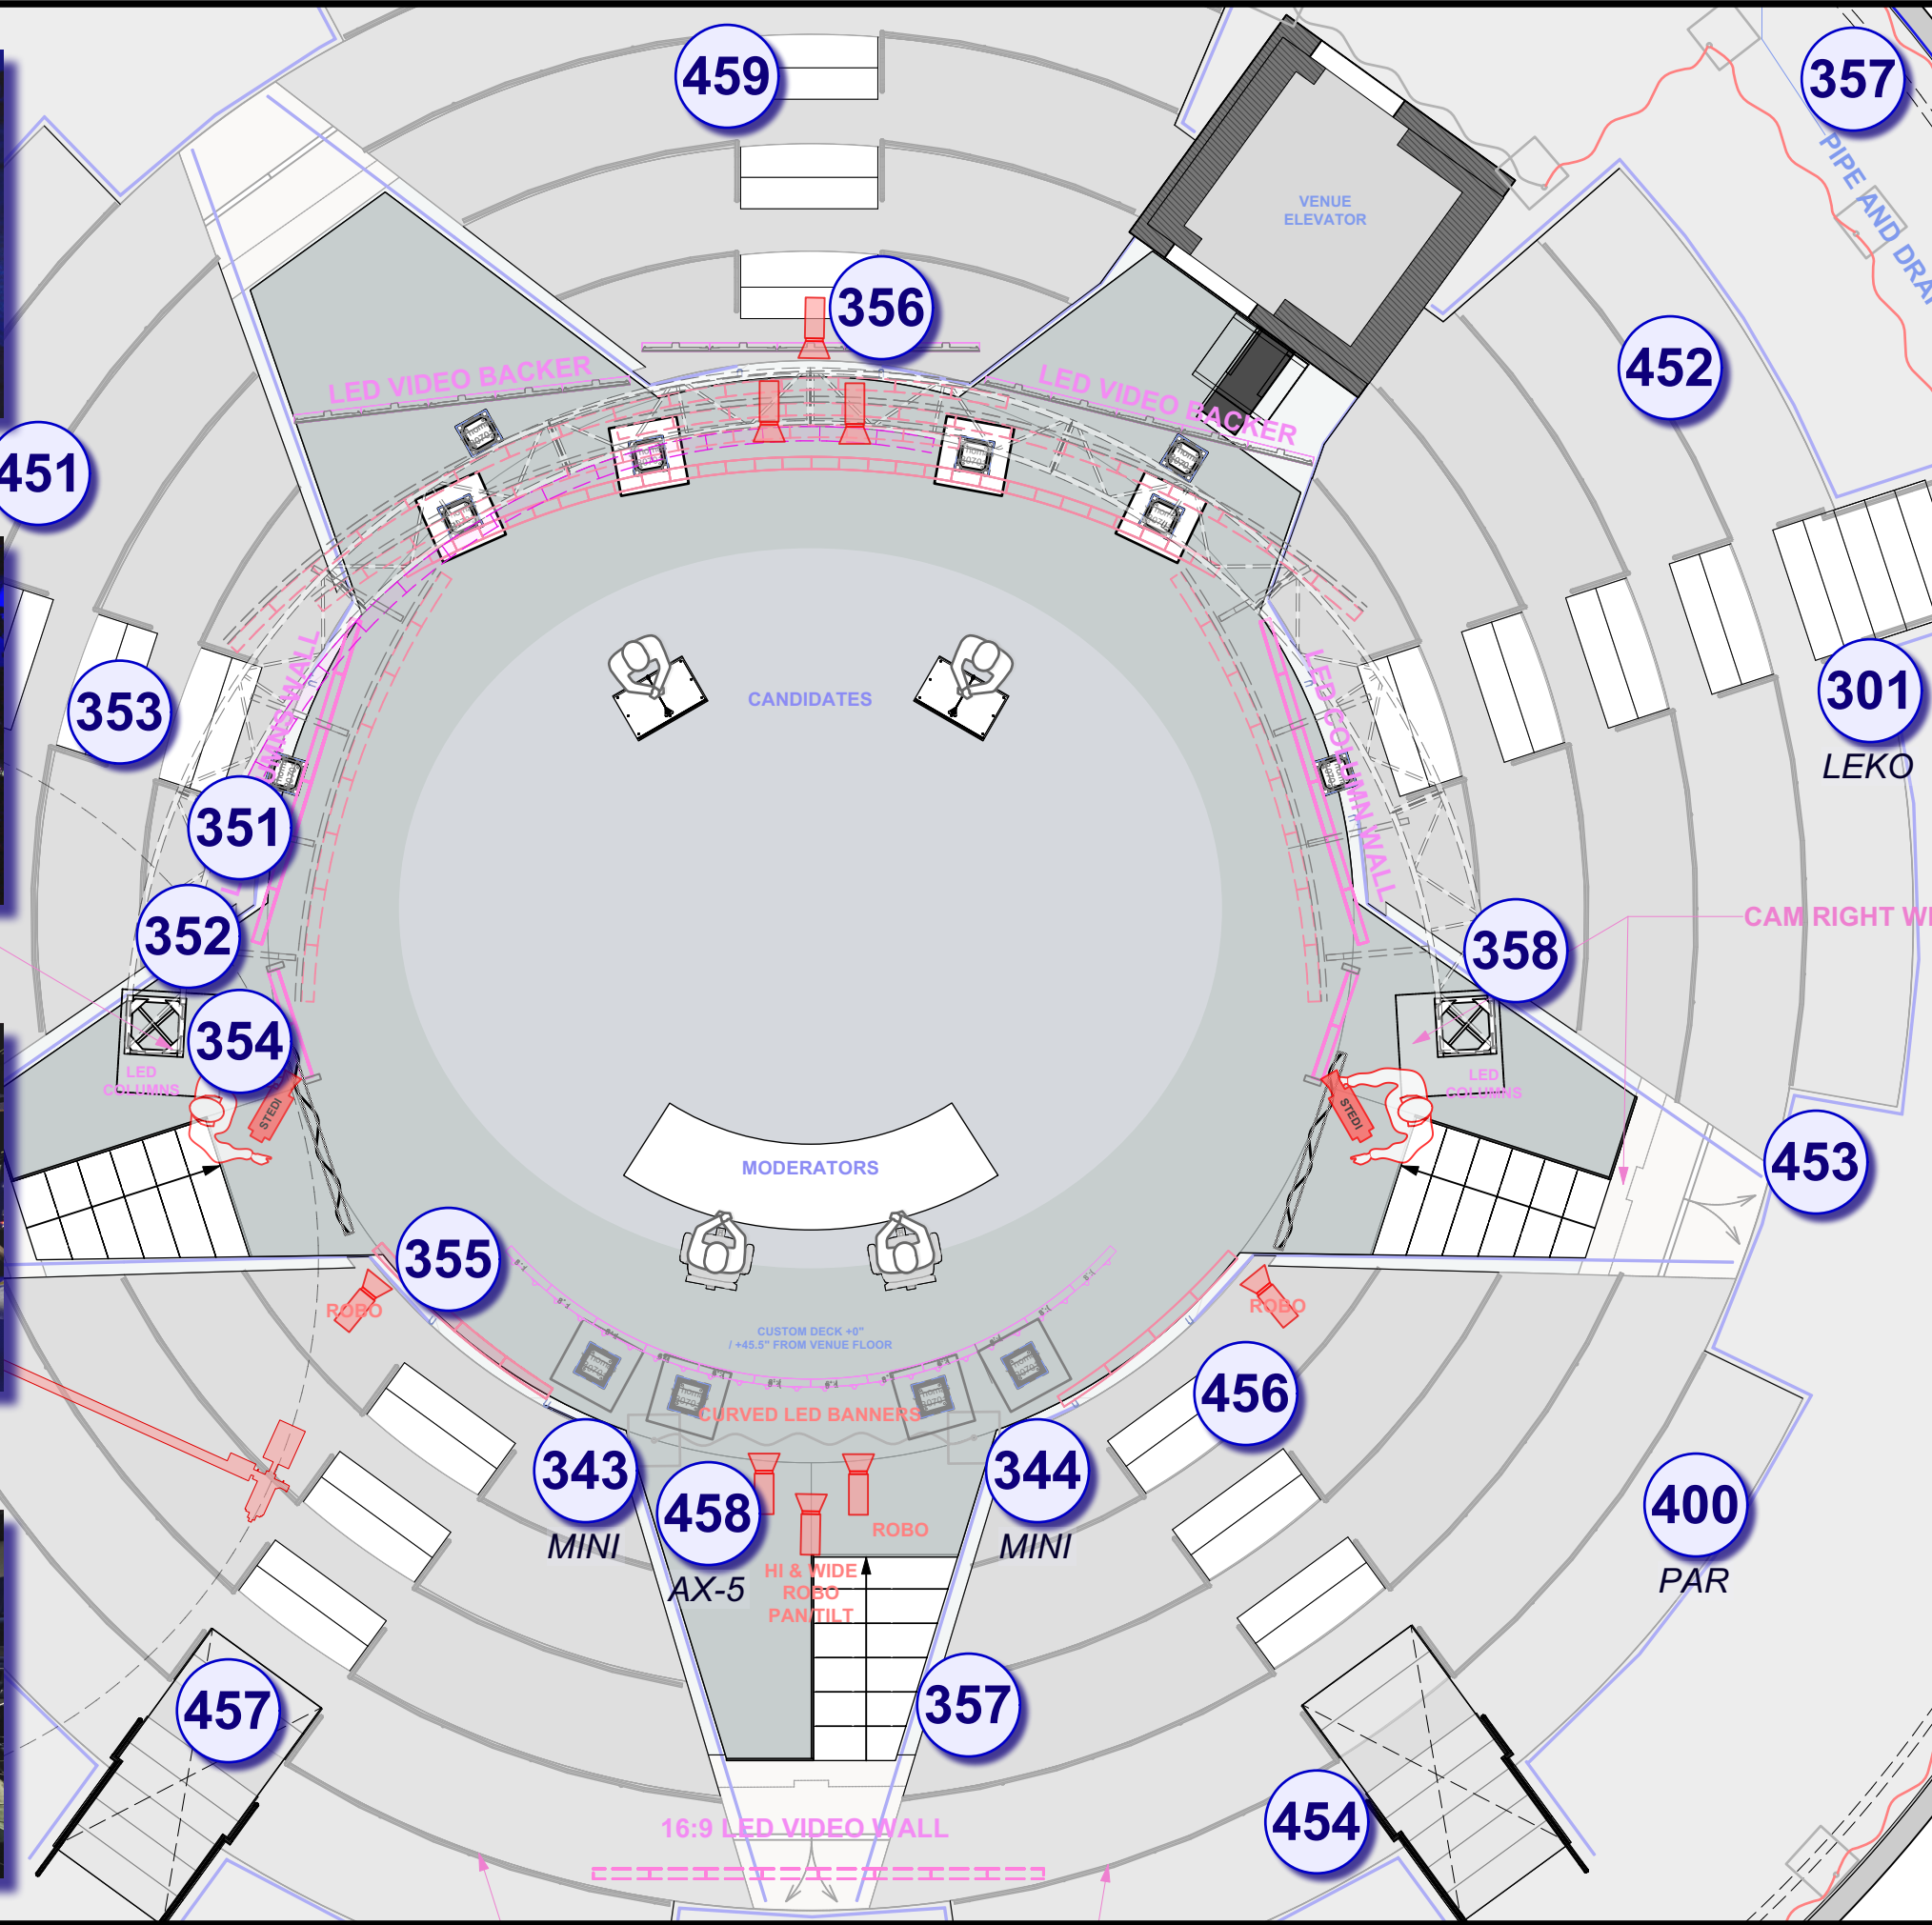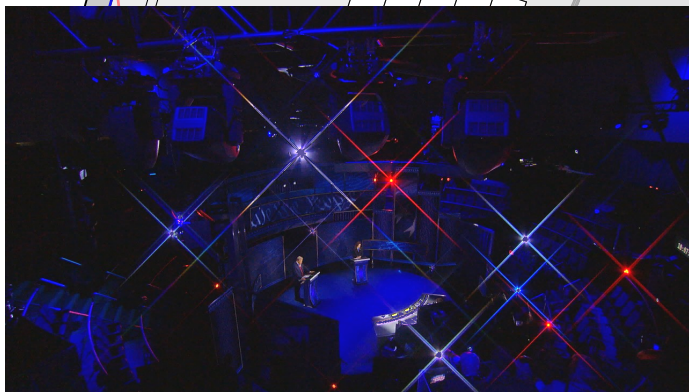

THIS DRAWING AND THE IDEAS, ARRANGEMENT, DESIGNS AND PLANS INDICATED HEREON OR REPRESENTED HERE ARE OWNED BY AND REMAIN THE EXCLUSIVE PROPERTY OF THE LIGHTING DESIGN GROUP (LDG). THEY HAVE BEEN CREATED AND DEVELOPED FOR USE ON AND IN CONNECTION WITH THIS SPECIFIED PROJECT ONLY AND MAY NOT BE USED FOR ANY OTHER PROJECT WITHOUT THE EXPRESS WRITTEN PERMISSION OF LDG. WRITTEN DIMENSIONS ON DRAWINGS SHALL HAVE AUTHORITY OVER SCALED DIMENSIONS. CONTRACTORS AND MANUFACTURERS SHALL VERIFY AND BE RESPONSIBLE FOR ALL DIMENSIONS AND JOBSITE CONDITIONS. ANY VARIATIONS OR DISCREPANCIES IN THE DRAWINGS SHALL BE REPORTED TO LDG PRIOR TO BEGINNING WORK. THESE DRAWINGS REPRESENT VISUAL CONCEPTS ONLY. RESPONSIBILITY FOR STRUCTURAL, RIGGING AND RELATED ENGINEERING IS BY OTHERS. ALL MEANS, METHODS AND MATERIALS TO MEET OR EXCEED APPLICABLE CODES AND INDUSTRY STANDARDS.



NATIONAL CONSTITUTION CENTER
 VISIT • LEARN • DEBATE



REVISIONS

#	BY	DATE	DESCRIPTION
1	STK	08/16/2024	2020 LX ADAPTATION
2	STK	08/21/2024	NEW GROUND PLAN
3	STK	08/22/2024	UPDATED SCENIC
4	KNOTH	08/25/2024	REDLINES/UPDATES
5	STK	09/14/2024	ARCHIVAL

DRAWING TITLE
**DEBATE - AUDIENCE
 MAGIC SHEET**

PRODUCER	DESIGNER
ABC NEWS	DENNIS SIZE

SCALE	GAFFER
3/16" = 1'-0"	JON GOSS


PROJECT ID	DRAWN BY
ABCN2408	STK

FILE NAME	FACILITY
20240905-ABCN2408-PL0 T-V5.vwx	525 ARCH ST, INDEPENDENCE MALL, PHILADELPHIA, PA 19106-1595

PLATE

MAGIC SHEET - DONALD TRUMP

307

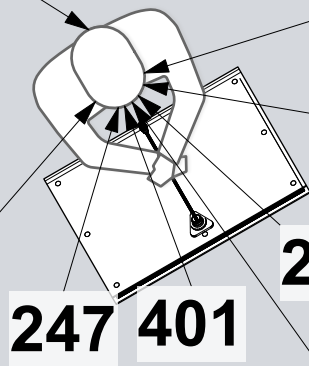

231

235

250

247

401

236

303



MAGIC SHEET - KAMALA HARRIS


308

255

256

251



302

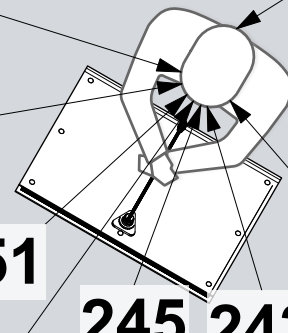

245

242

402

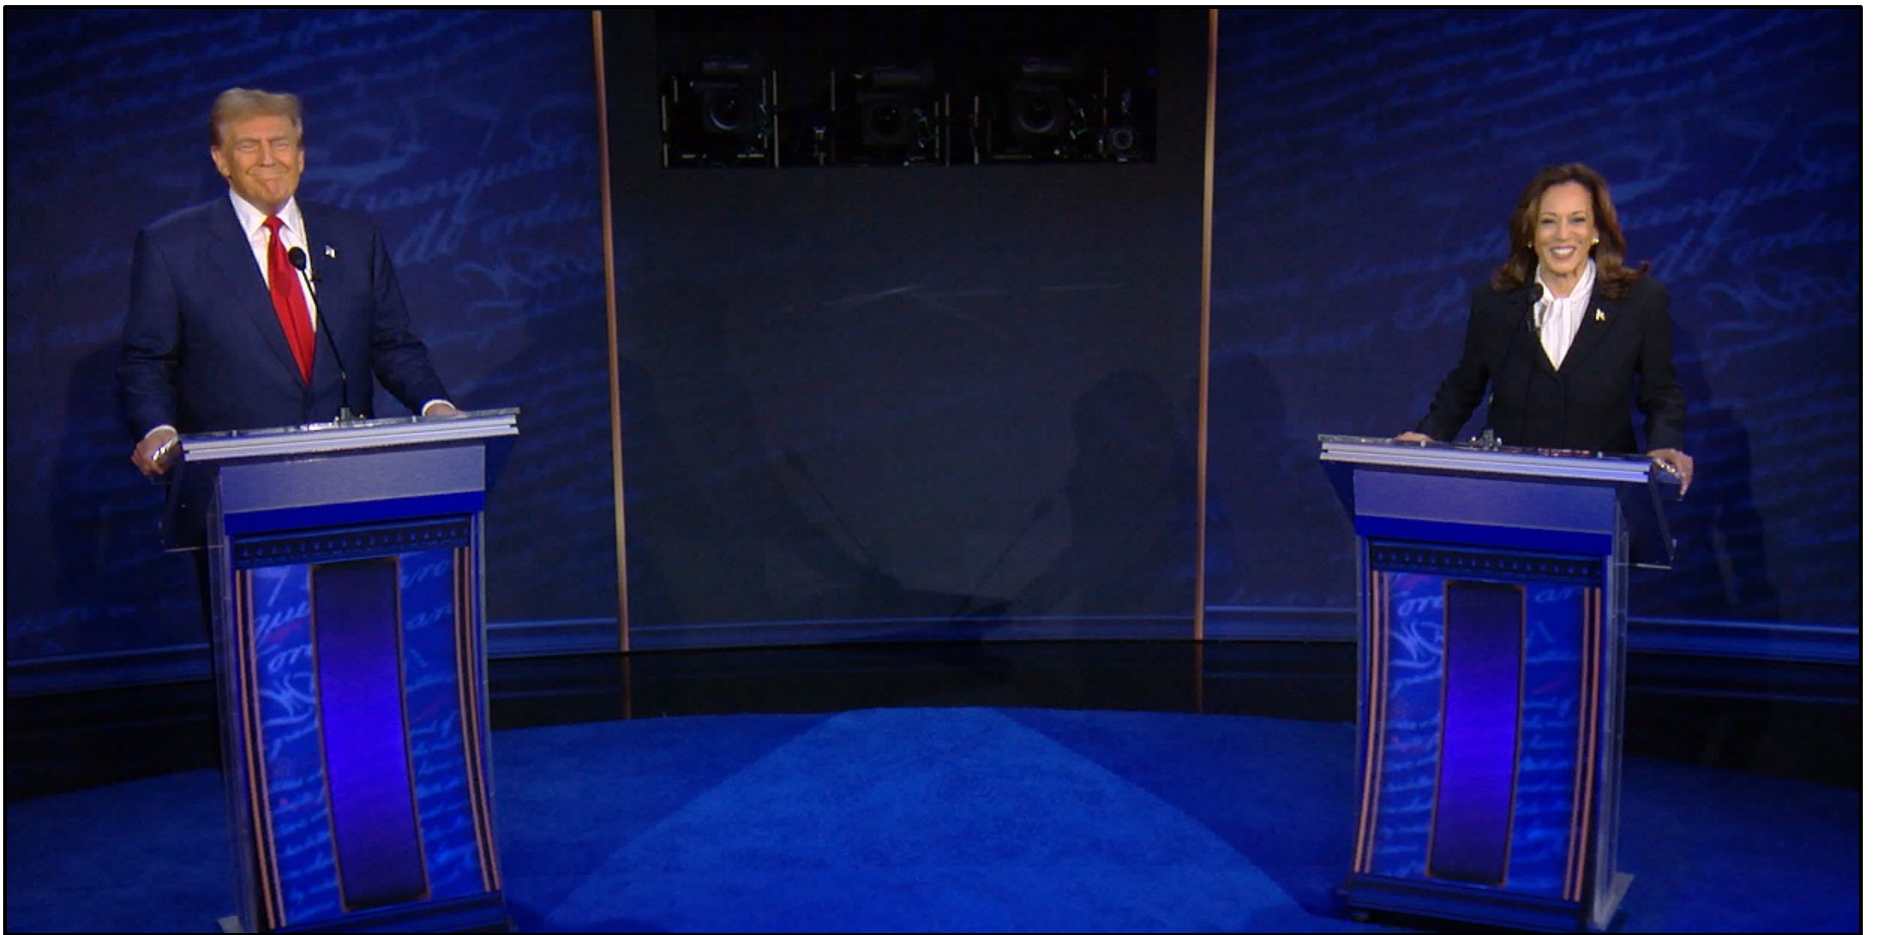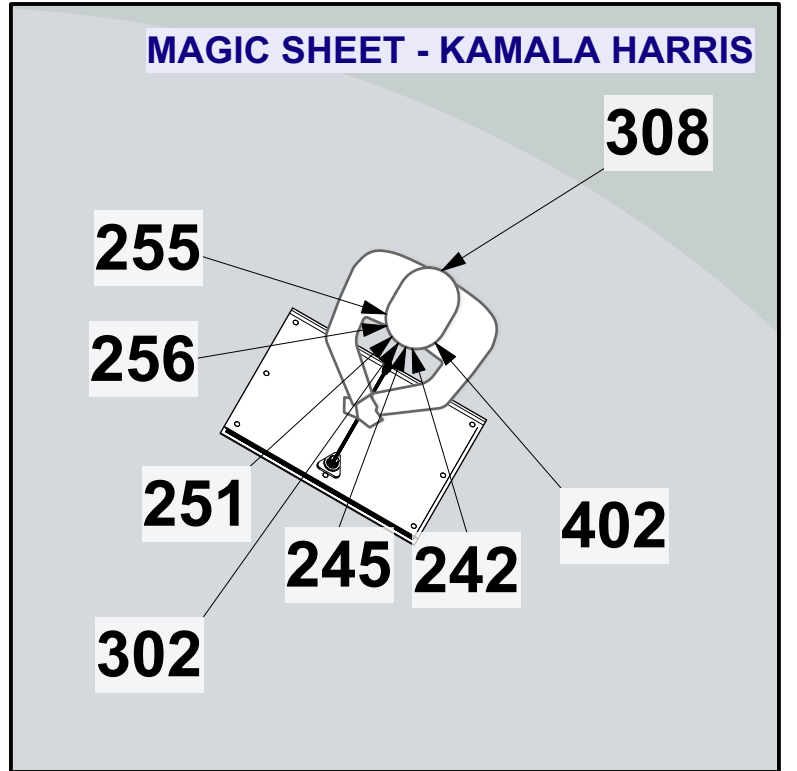

LDG The Lighting Design Group

49 West 27th Street, Suite 920
New York, NY 10001
Tel: (212) 885-4940
www.ldg.com

NEWS
**YOUR VOICE
YOUR VOTE**
2024

NATIONAL CONSTITUTION CENTER
VISIT • LEARN • DEBATE

abc
NEWS

REVISIONS

#	BY	DATE	DESCRIPTION
1	STK	08/16/2024	2020 LX ADAPTATION
2	STK	08/21/2024	NEW GROUND PLAN
3	STK	08/22/2024	UPDATED SCENIC
4	KNOTH	08/25/2024	REDLINES/UPDATES
5	STK	09/14/2024	ARCHIVAL

DRAWING TITLE
**DEBATE - CANDIDATE
MAGIC SHEET**

PRODUCER: ABC NEWS
DESIGNER: DENNIS SIZE

SCALE: 1/2" = 1'-0"
GAFFER: JON GOSS
FILE NAME: 20240905-ABCN2408-PL0 T-V5.vwx




PROJECT ID: ABCN2408
DRAWN BY: STK
FACILITY: 525 ARCH ST, INDEPENDENCE MALL, PHILADELPHIA, PA 19106-1595

PLATE

M2

/03

THIS DRAWING AND THE IDEAS, ARRANGEMENT, DESIGNS AND PLANS INDICATED HEREON OR REPRESENTED HERE ARE OWNED BY AND REMAIN THE EXCLUSIVE PROPERTY OF THE LIGHTING DESIGN GROUP (LDG). THEY HAVE BEEN CREATED AND DEVELOPED FOR USE ON AND IN CONNECTION WITH THIS SPECIFIED PROJECT ONLY AND MAY NOT BE USED FOR ANY OTHER PROJECT WITHOUT THE EXPRESS WRITTEN PERMISSION OF LDG. WRITTEN DIMENSIONS ON DRAWINGS SHALL HAVE AUTHORITY OVER SCALED DIMENSIONS. CONTRACTORS AND MANUFACTURERS SHALL VERIFY AND BE RESPONSIBLE FOR ALL DIMENSIONS AND JOBSITE CONDITIONS. ANY VARIATIONS OR DISCREPANCIES IN THE DRAWINGS SHALL BE REPORTED TO LDG PRIOR TO BEGINNING WORK. THESE DRAWINGS REPRESENT VISUAL CONCEPTS ONLY. RESPONSIBILITY FOR STRUCTURAL, RIGGING AND RELATED ENGINEERING IS BY OTHERS. ALL MEANS, METHODS AND MATERIALS TO MEET OR EXCEED APPLICABLE CODES AND INDUSTRY STANDARDS.

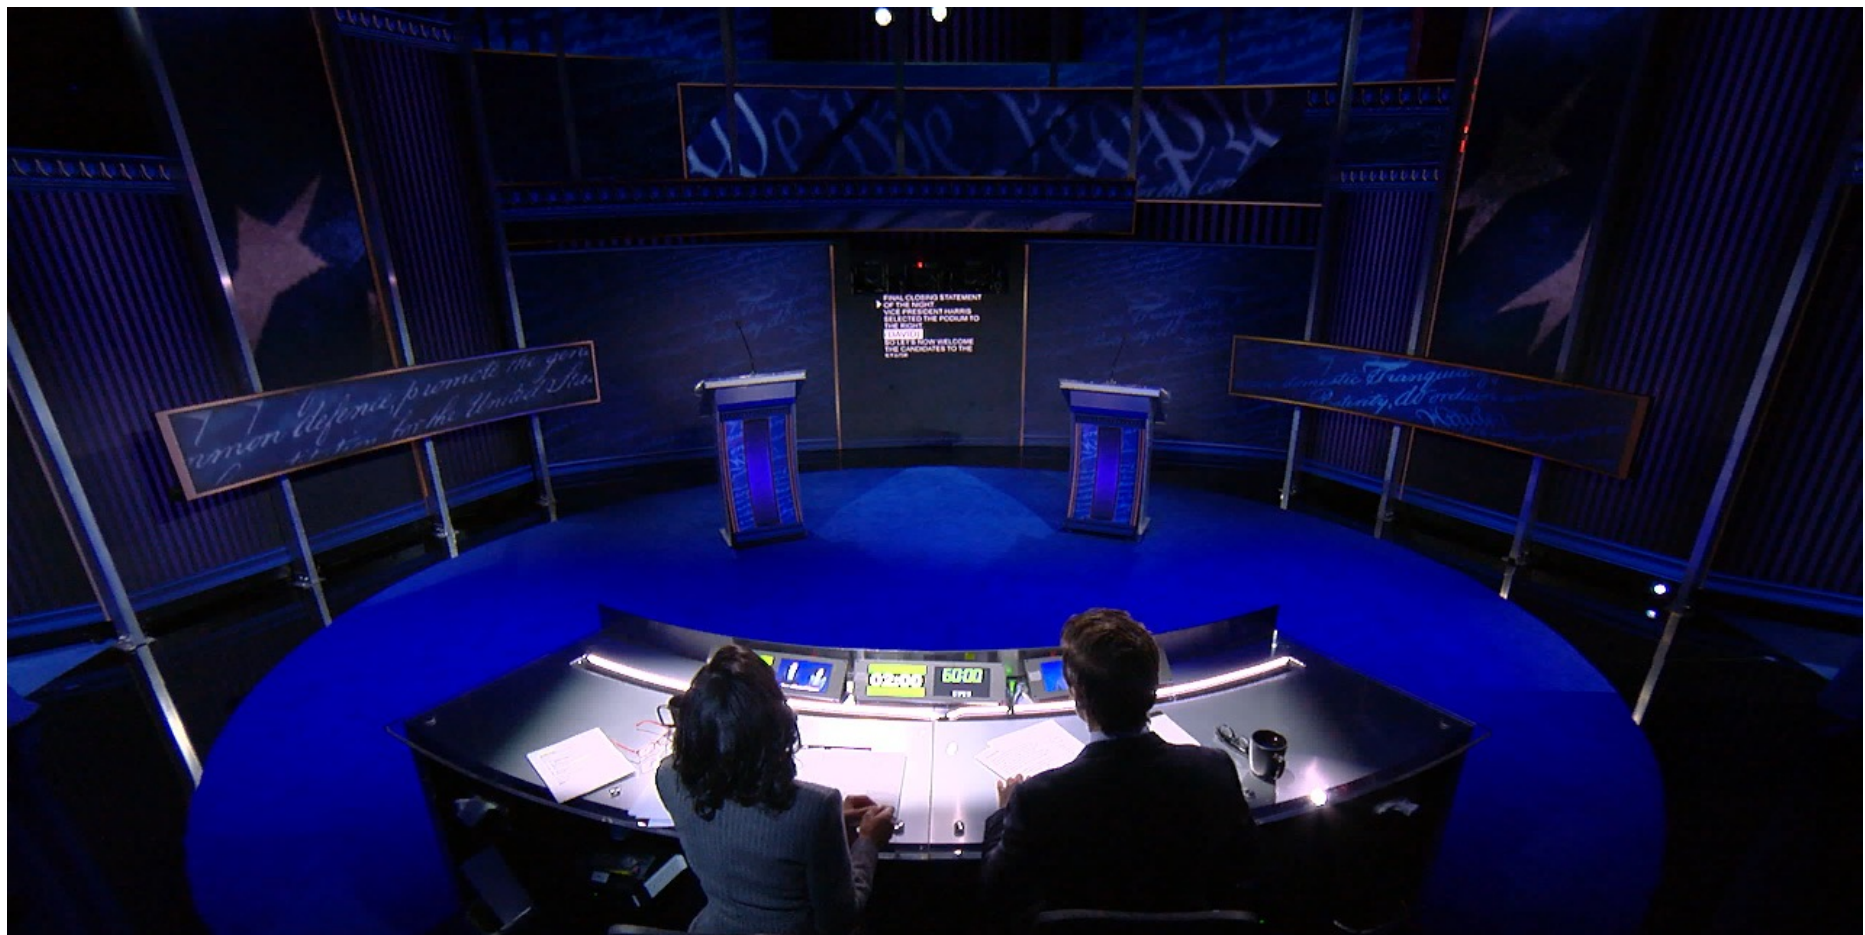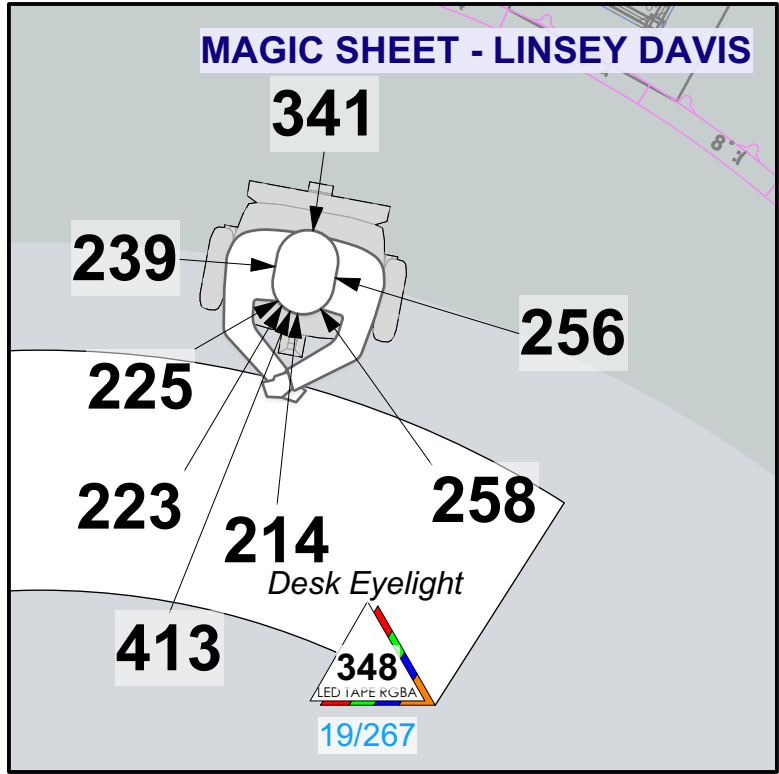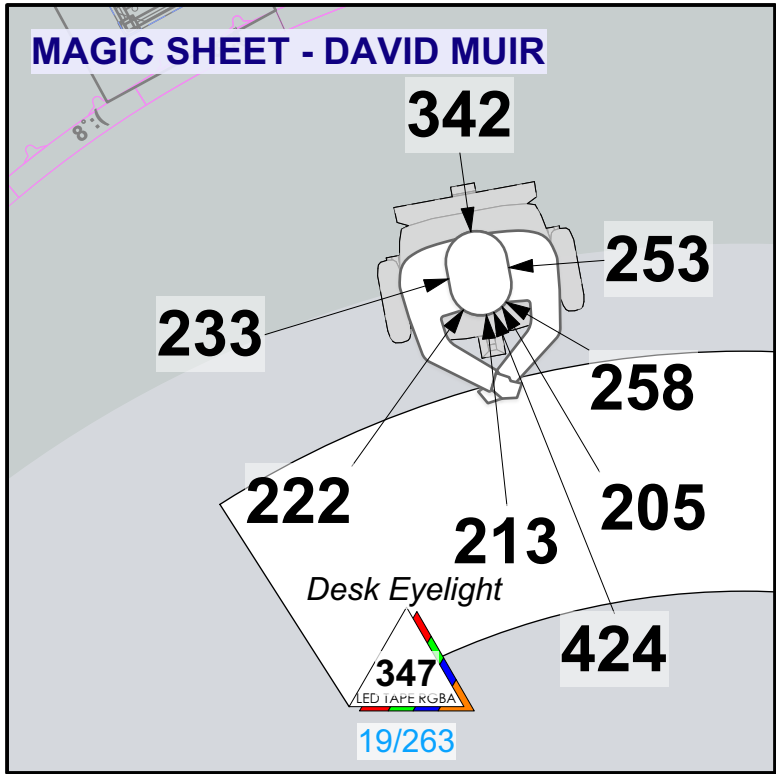

LDG The Lighting Design Group

49 West 27th Street, Suite 920
New York, NY 10001
Tel: (212) 885-4940
www.ldg.com

THIS DRAWING AND THE IDEAS, ARRANGEMENT, DESIGNS AND PLANS INDICATED HEREON OR REPRESENTED HERE ARE OWNED BY AND REMAIN THE EXCLUSIVE PROPERTY OF THE LIGHTING DESIGN GROUP (LDG). THEY HAVE BEEN CREATED AND DEVELOPED FOR USE ON AND IN CONNECTION WITH THIS SPECIFIED PROJECT ONLY AND MAY NOT BE USED FOR ANY OTHER PROJECT WITHOUT THE EXPRESS WRITTEN PERMISSION OF LDG. WRITTEN DIMENSIONS ON DRAWINGS SHALL HAVE AUTHORITY OVER SCALED DIMENSIONS. CONTRACTORS AND MANUFACTURERS SHALL VERIFY AND BE RESPONSIBLE FOR ALL DIMENSIONS AND JOBSITE CONDITIONS. ANY VARIATIONS OR DISCREPANCIES IN THE DRAWINGS SHALL BE REPORTED TO LDG PRIOR TO BEGINNING WORK. THESE DRAWINGS REPRESENT VISUAL CONCEPTS ONLY. RESPONSIBILITY FOR STRUCTURAL, RIGGING AND RELATED ENGINEERING IS BY OTHERS. ALL MEANS, METHODS AND MATERIALS TO MEET OR EXCEED APPLICABLE CODES AND INDUSTRY STANDARDS.

NEWS YOUR VOICE YOUR VOTE 2024

NATIONAL CONSTITUTION CENTER

VISIT • LEARN • DEBATE

abc NEWS

REVISIONS			
#	BY	DATE	DESCRIPTION
1	STK	08/16/2024	2020 LX ADAPTATION
2	STK	08/21/2024	NEW GROUND PLAN
3	STK	08/22/2024	UPDATED SCENIC
4	KNOTH	08/25/2024	REDLINES/UPDATES
5	STK	09/14/2024	ARCHIVAL

DRAWING TITLE DEBATE - MODERATOR MAGIC SHEET		
PRODUCER ABC NEWS		DESIGNER DENNIS SIZE
SCALE 1/2" = 1'-0"	GAFFER JON GOSS	FILE NAME 20240905-ABCN2408-PL0 T-V5.vwx
PROJECT ID ABCN2408	DRAWN BY STK	FACILITY 525 ARCH ST, INDEPENDENCE MALL, PHILADELPHIA, PA 19106-1595

PLATE

M3

/03