



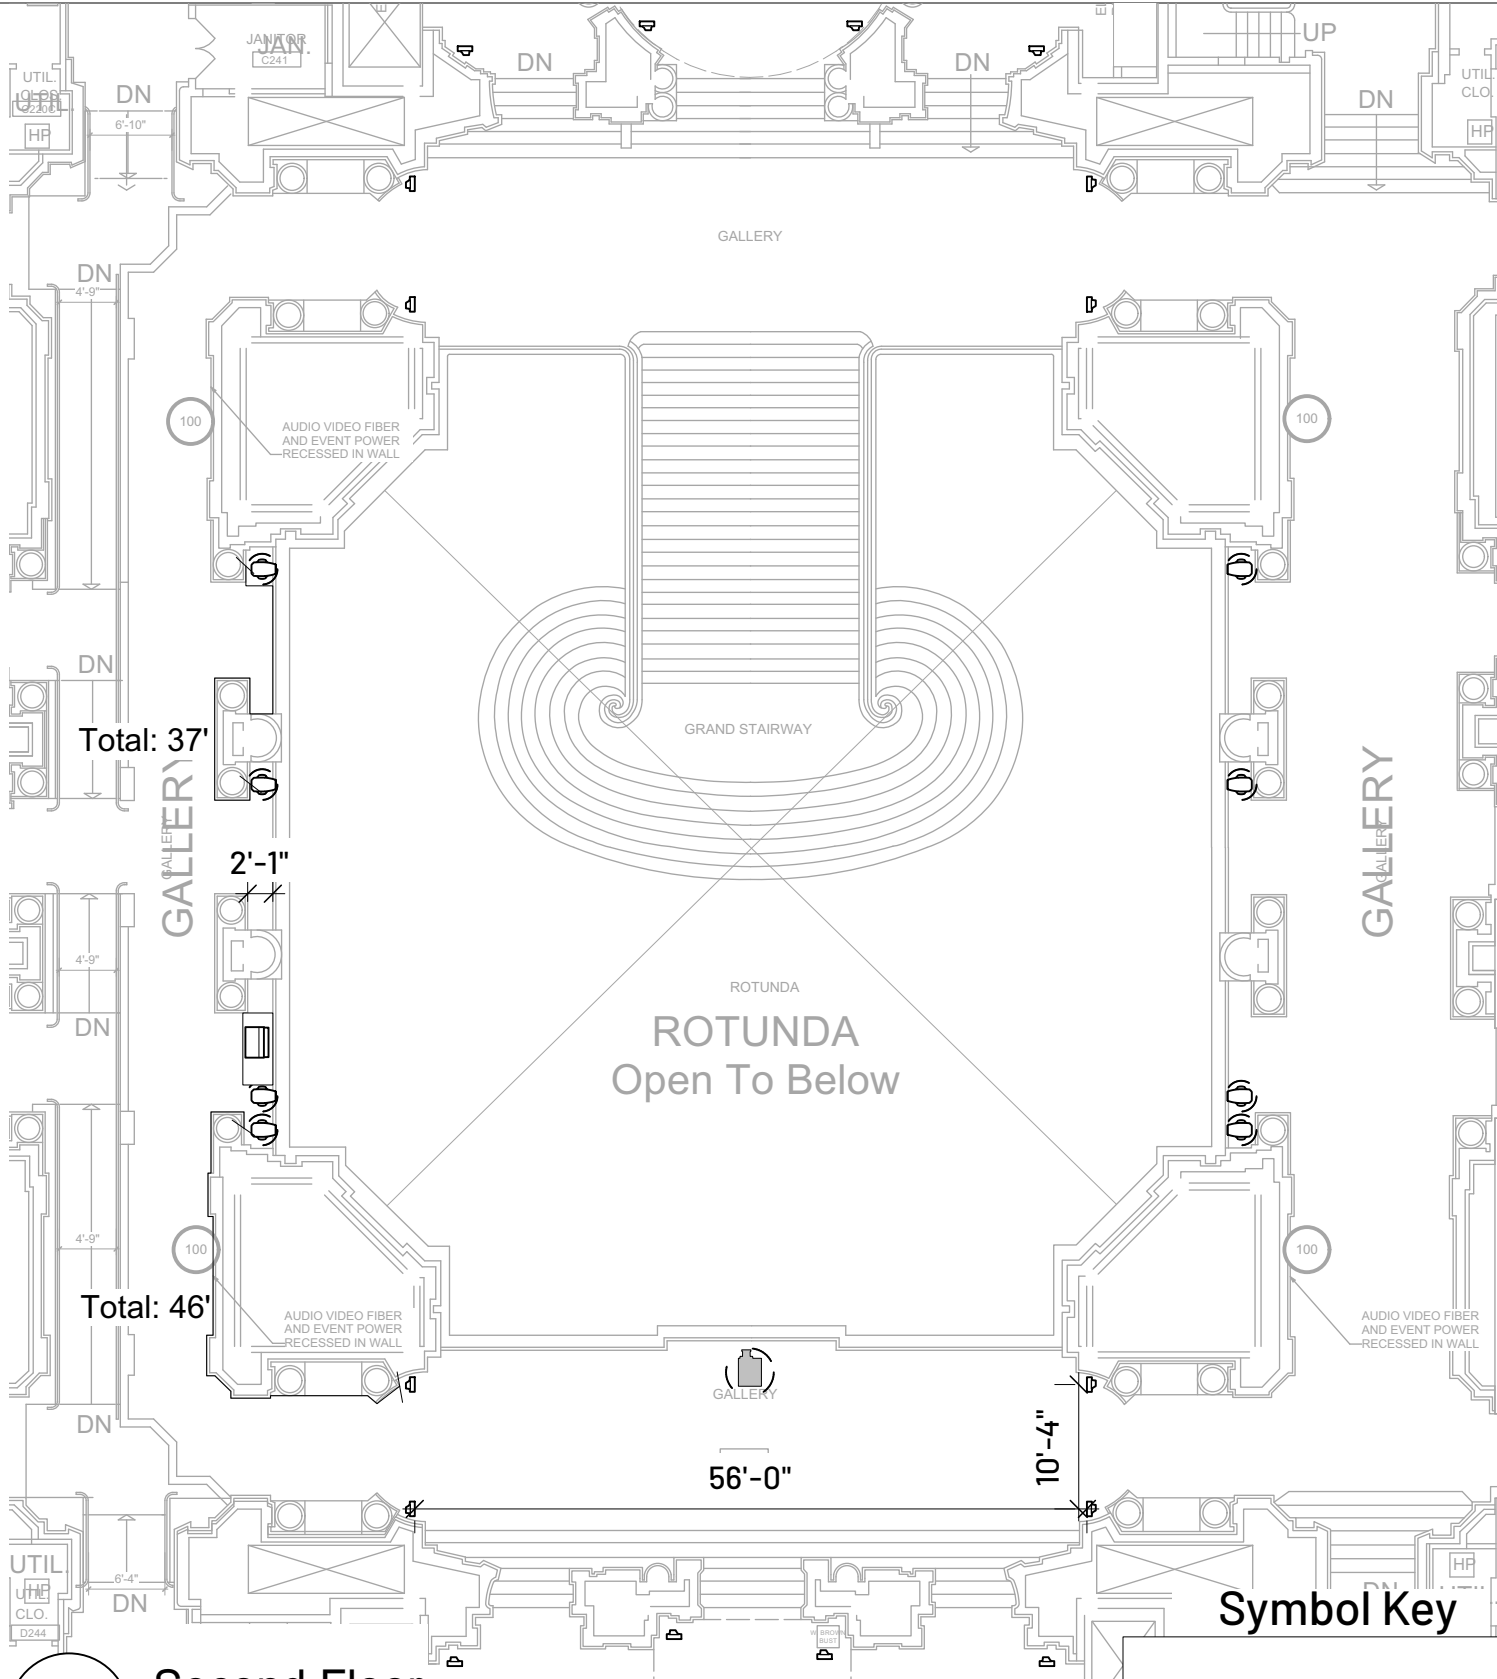

Symbol Key

-  Ayrton Huracan Profile S
-  Chauvet COLORado Solo Batten 4 No Filter
-  Digital Projection Highlite Laser II

1 Second Floor
Scale: 1/16" = 1'-0"

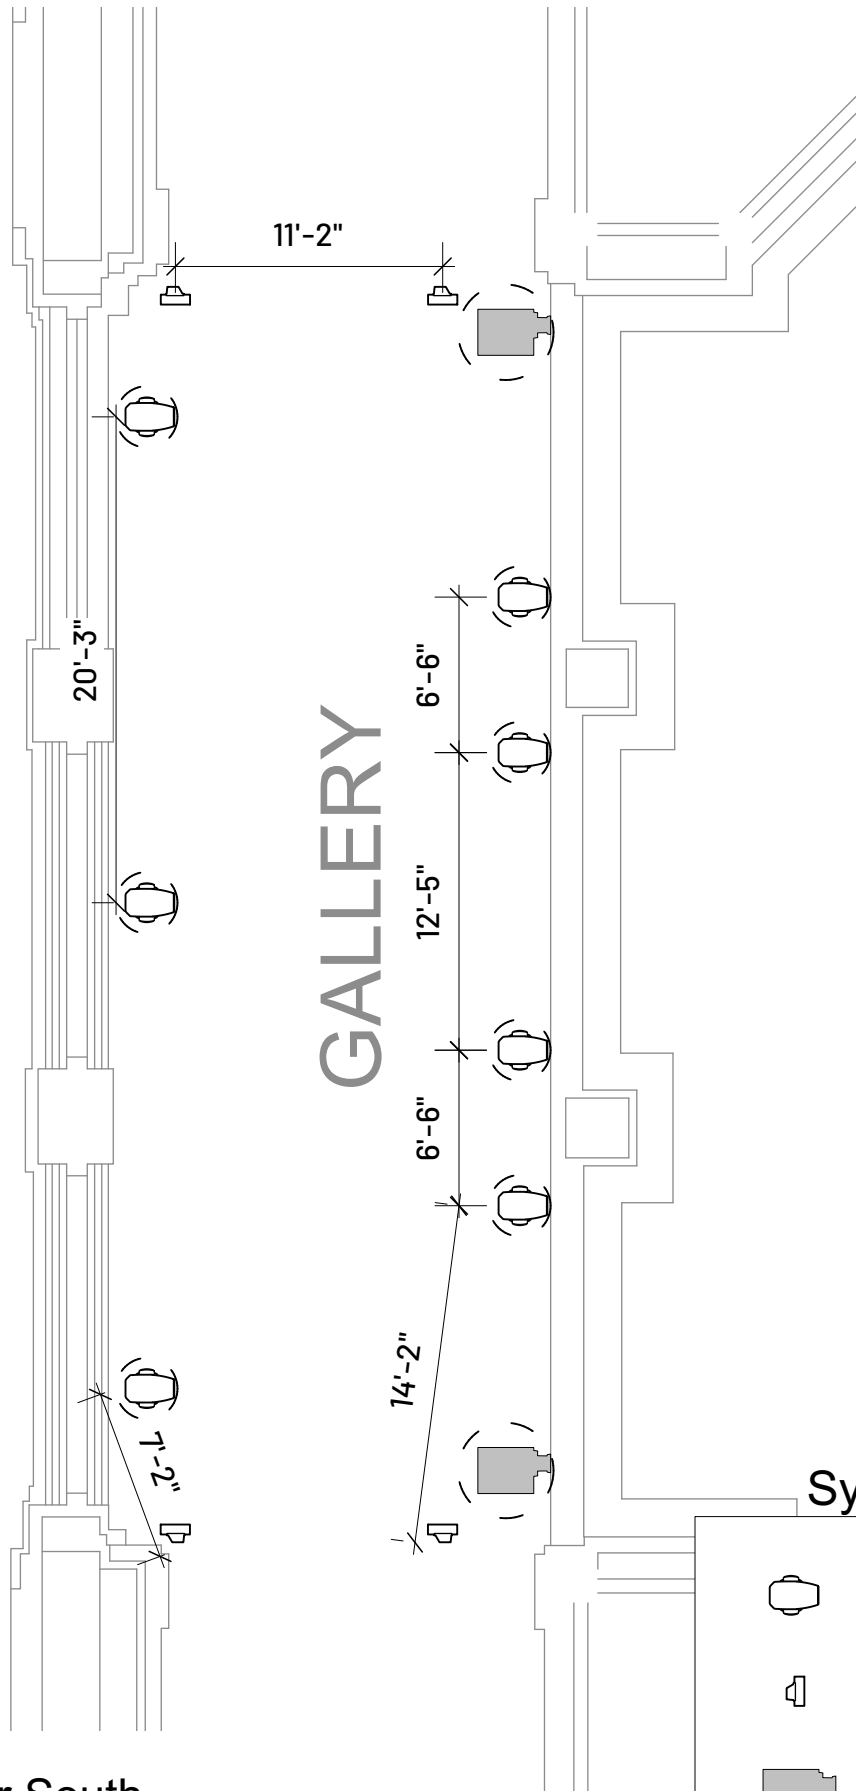

Symbol Key



Ayrton Huracan
Profile S



Chauvet
COLORado Solo
Batten 4 No Filter



Digital Projection
Highlite Laser II

1

Fourth Floor South

Scale: 1/8" = 1'-0"

LIGHTSWITCH®

4000 Bridgeway
Suite 315
Sausalito, CA 94965

Tel. 415-332-7284
Fax. 415-332-7285

THE PEOPLE'S PALACE

DRAWING:

Fourth Floor Lighting Layout - South

DRAWN BY:

SN

CLIENT:

REV #

A

DATE

9/1/2022

ISSUE NOTES

XXXXXXXX

SCALE:


1/16" = 1'-0"

DATE:

2024.05.02

SHEET #:

LS-02

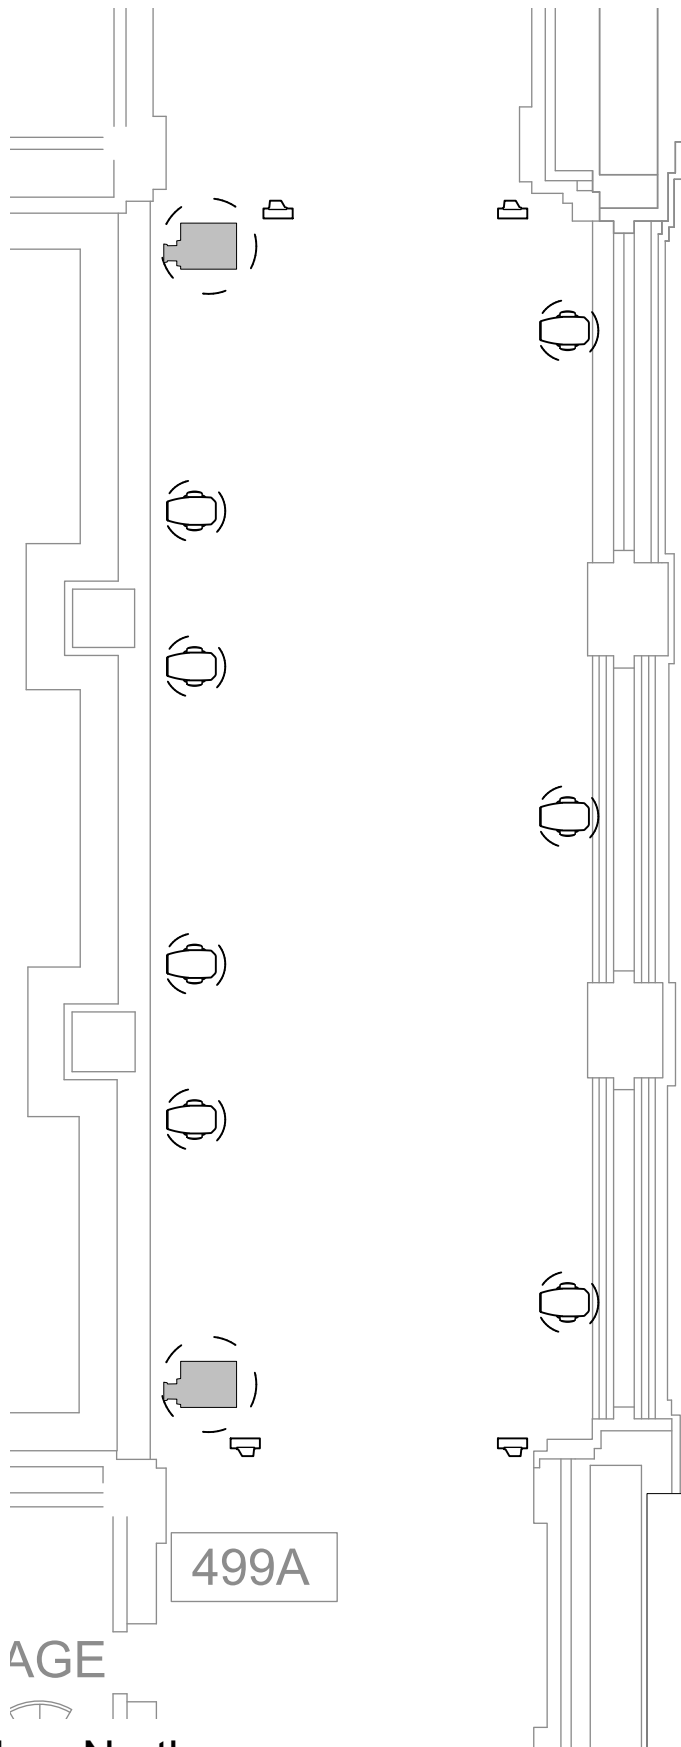

Symbol Key



Ayrton Huracan
Profile S



Chauvet
COLORado Solo
Batten 4 No Filter



Digital Projection
Highlite Laser II

1

Fourth Floor North

Scale: 1/8" = 1'-0"

LIGHTSWITCH®

4000 Bridgeway
Suite 315
Sausalito, CA 94965

Tel. 415-332-7284
Fax. 415-332-7285

THE PEOPLE'S PALACE

DRAWING:

Fourth Floor Lighting Layout - South

DRAWN BY:

SN

CLIENT:

REV #

A

DATE

9/1/2022

ISSUE NOTES

XXXXXXXXX

SCALE:


1/16" = 1'-0"

DATE:

2024.05.02

SHEET #:

LS-03

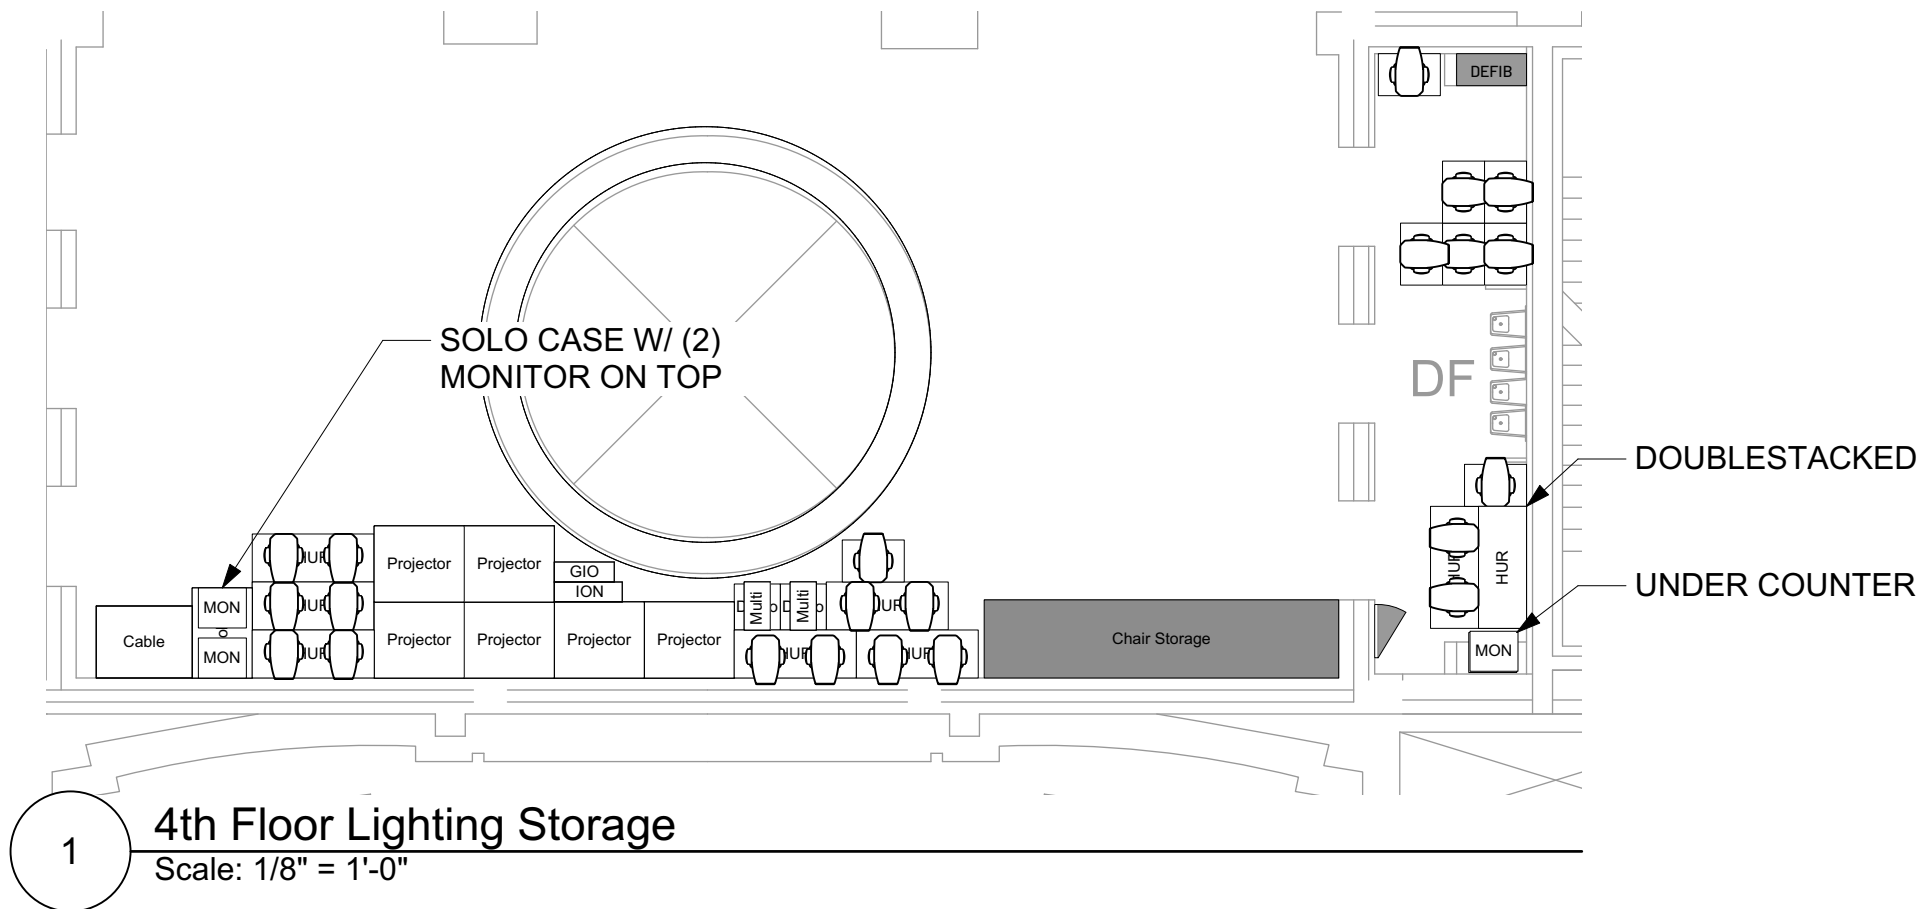

LIGHTSWITCH®

4000 Bridgeway, STE 315
Sausalito, CA 94965

Tel. 415-332-7284
Fax. 415-332-7285

THE PEOPLE'S PALACE

DRAWING:

LIGHTING STORAGE

DRAWN BY:

SN

CLIENT:

REV #

A

DATE

XX/XX/XXXX

ISSUE NOTES

XXXXXXXXXXXX

SCALE:

1/8" = 1'-0"

DATE:

2024.05.02

SHEET #:

LS-04