


- SPOT COLOR:**
1. L206
 2. L279
 3. L209
 4. R132
 5. L223
 6. L279

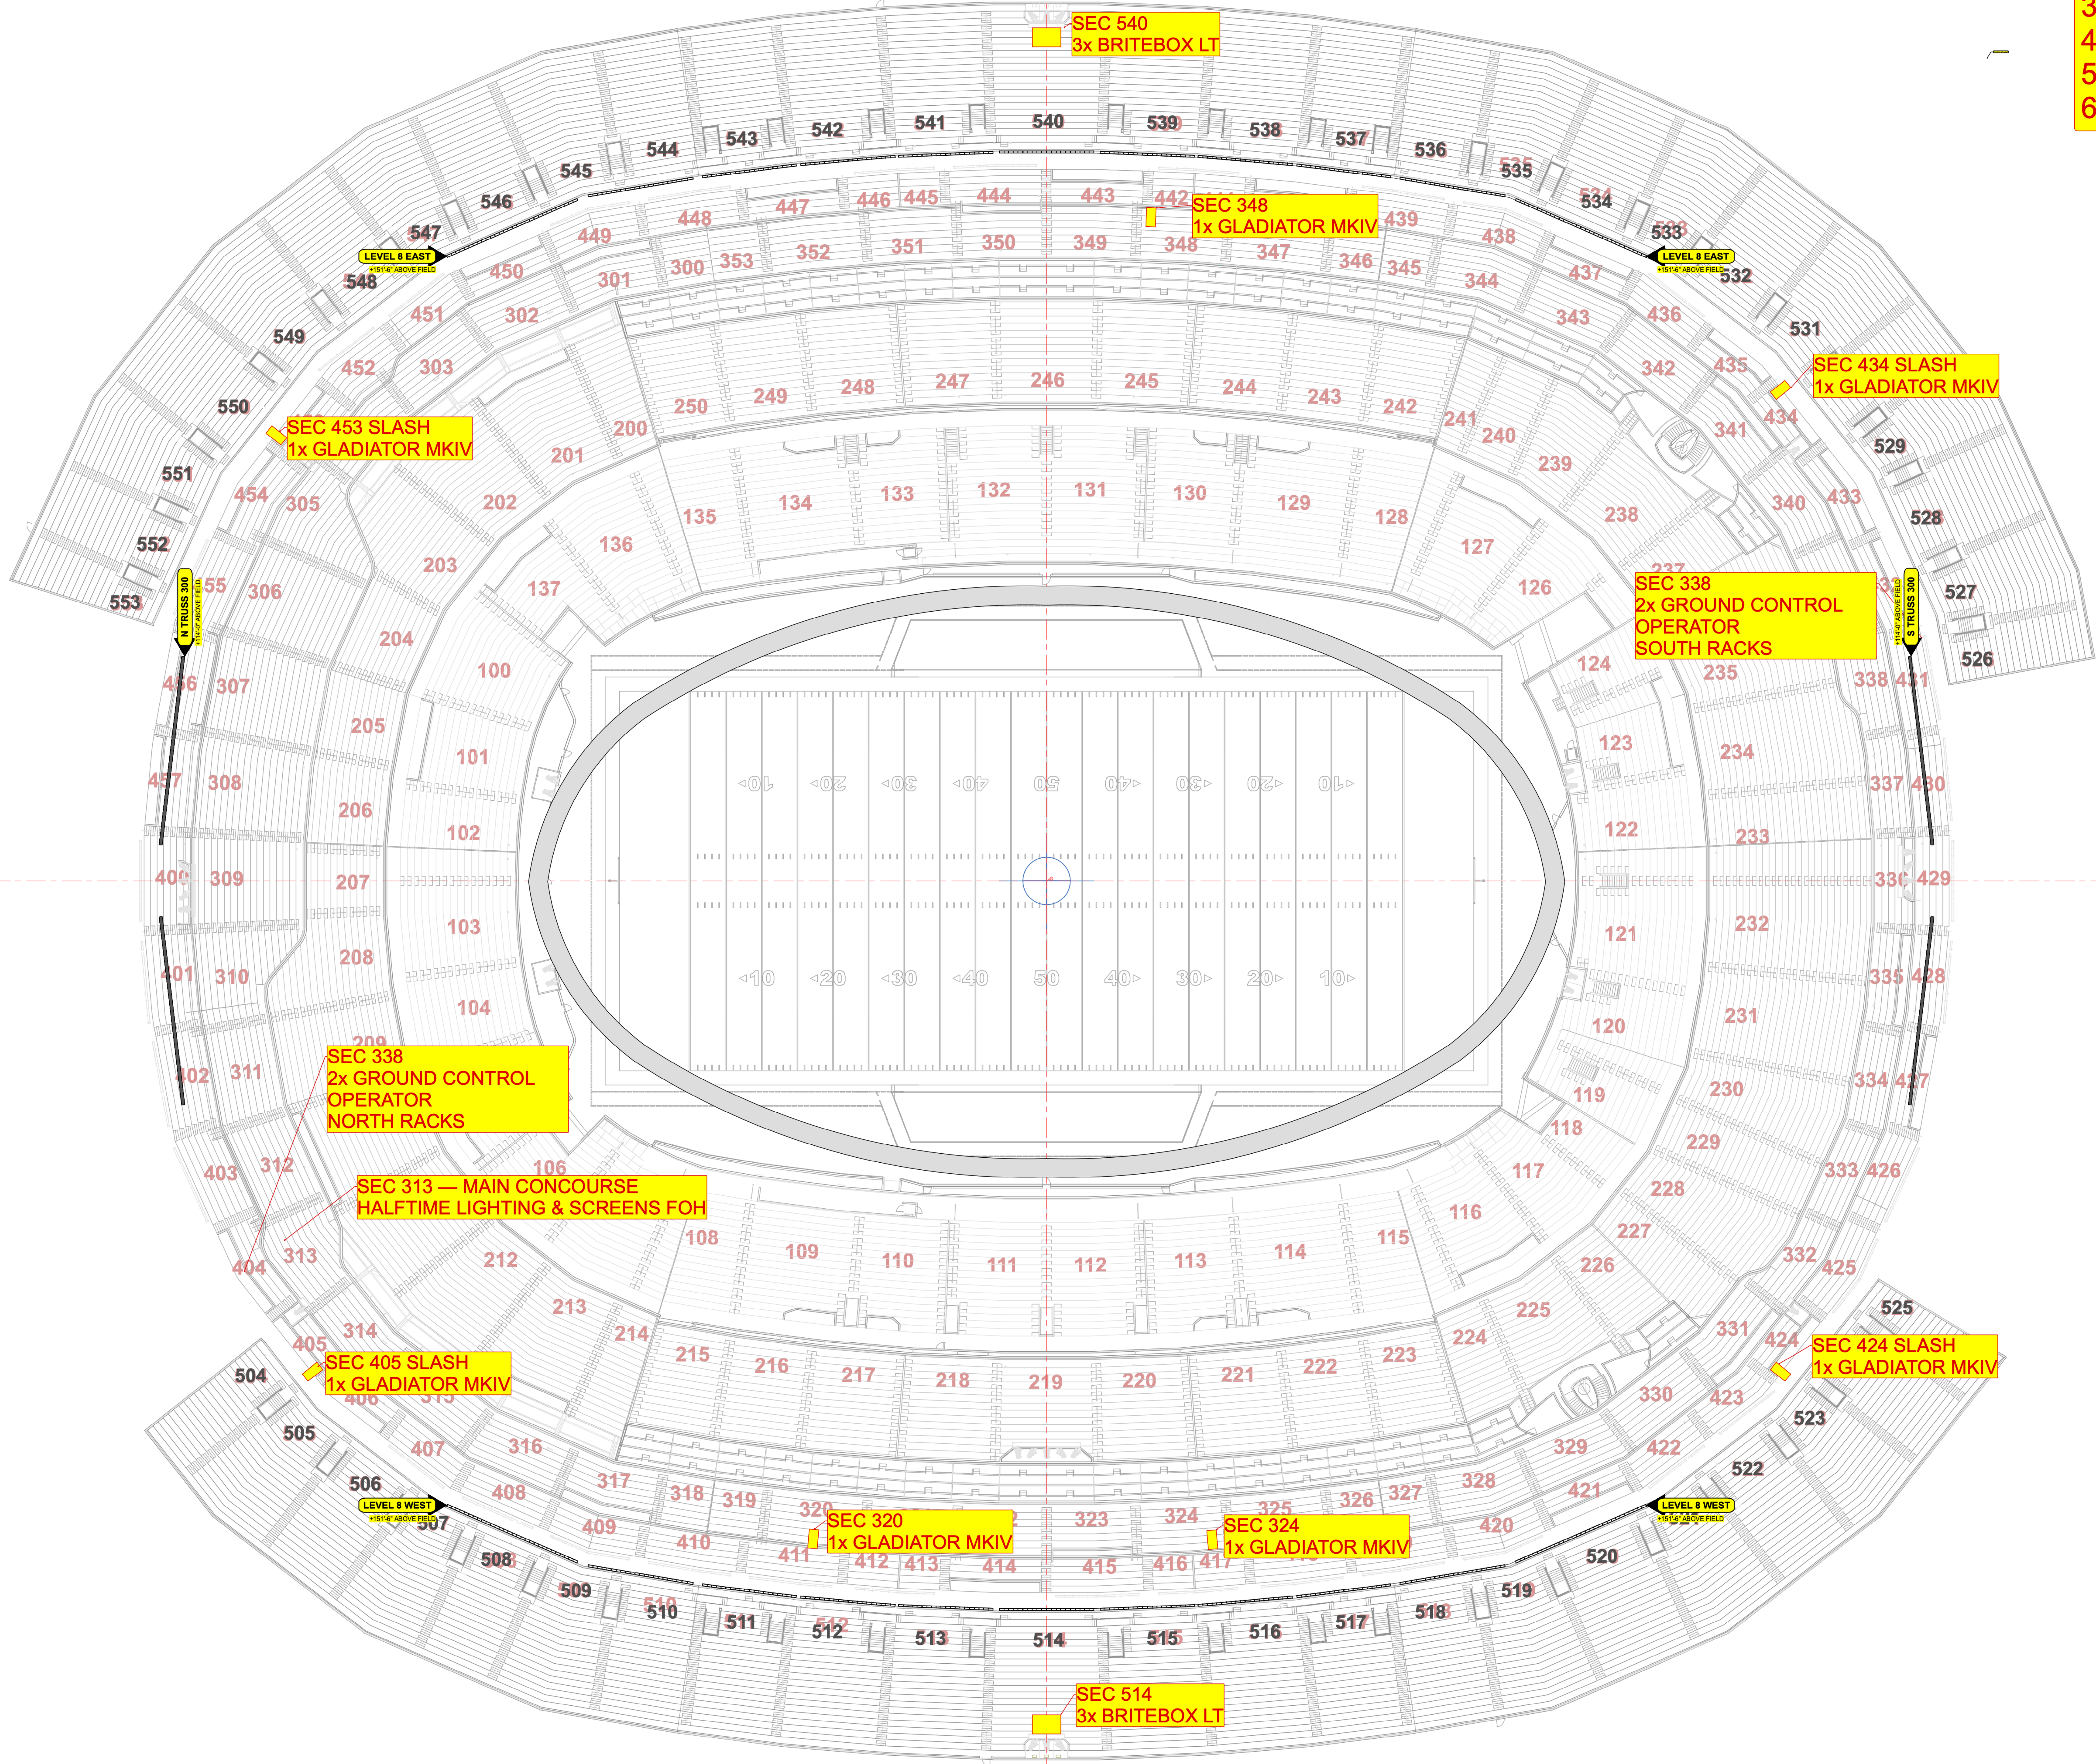

ENTERTAINMENT DESIGN GROUP
Please recycle this paper.

This document and its contents are the property of Entertainment Design Group, Inc. and are to be used only for the project and site specified herein. No part of this document may be reproduced, stored in a retrieval system, or transmitted, in any form or by any means, electronic, mechanical, photocopying, recording, or by any information storage and retrieval system, without the prior written permission of Entertainment Design Group, Inc. The design of this document and the information contained herein are the property of Entertainment Design Group, Inc. and are to be used only for the project and site specified herein. The design of this document and the information contained herein are the property of Entertainment Design Group, Inc. and are to be used only for the project and site specified herein.

INSTRUMENT KEY

- PRG GC Longthrow @ 1.0w
- Elation Proteus Excibur @ 950 w
- Elation Proteus Macro @ 1.4w
- Philips Vari-Lite VL2000 Profile @ 820w
- Robe Robin 1200 LED Wash @ 680w
- TMB Solaris Flare @ 1.0w
- Proton 3000 @ 900w

VENUE
SOFI STADIUM
LOS ANGELES, CA

SHOW
SUPER BOWL LVII
SUPERBOWL LVII HALFTIME SHOW

LOAD-IN	SHOWDAY	SHOW #
01/26/21	02/13/21	#202

DESIGNER	GURDON
LEAD L.D.	GREEN FORSTER
GAFFER	SISUL / UCHTA
PROD. 1	ERIC MARCWINSKI
PROD. 2	MARK HUMPHREY
LEAD TECH	ROBB MINNOTTE

VERSION	STATUS
01. PRELIMINARY	
02. SURVEY UPDATE 1/20/21	
03. NY UPDATE 01/02/21	
04. FOH UPDATE 01/02/21	
05. OH CHANNELS 01/22/21	
06. AS GART UPDATE 01/22/21	
07. AS BUILT	

PRINT ARCH E SHEET

DRAWN BY	SCALE
BEG	1:300

CONTENTS

- LX-01: SITE PLAN
- LX-02: INFRASTRUCTURE
- LX-03: FIELD LAYOUT
- LX-04: N & S TRUSS
- LX-05: LEVEL 8 RAILS

SHEET #
LX-02

PUBLISH DATE
AS BUILT 02/12/2022

INFRASTRUCTURE