
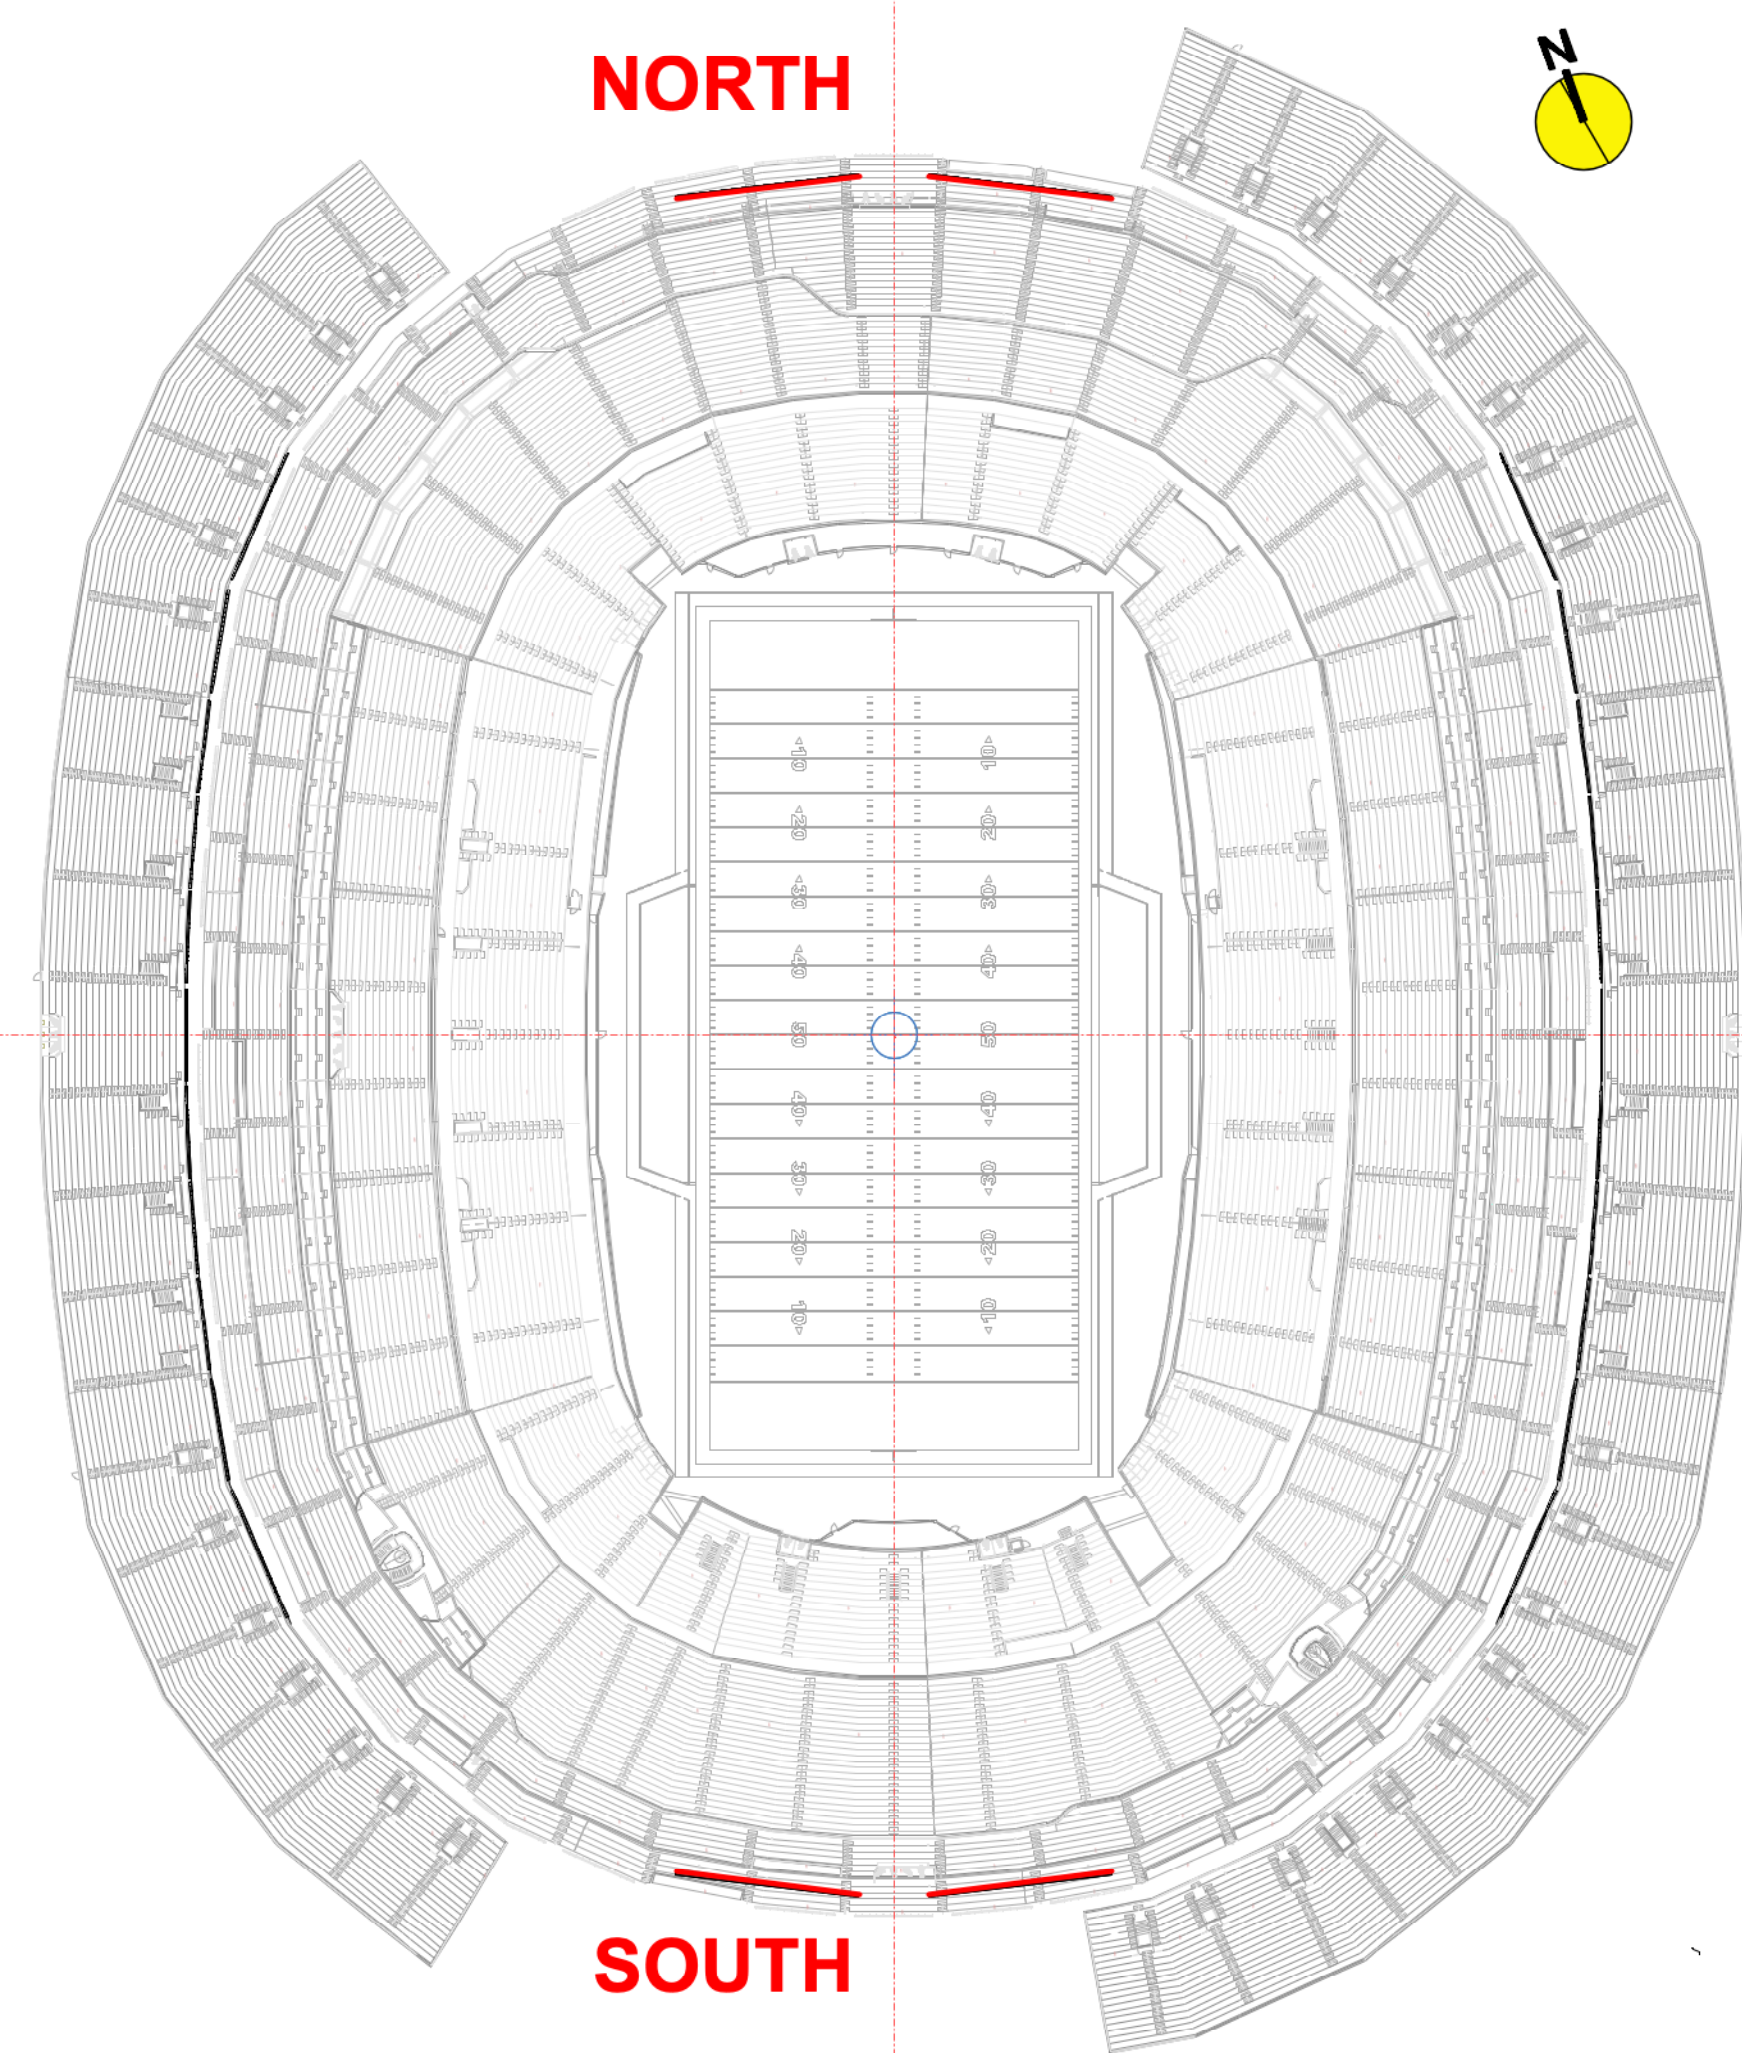
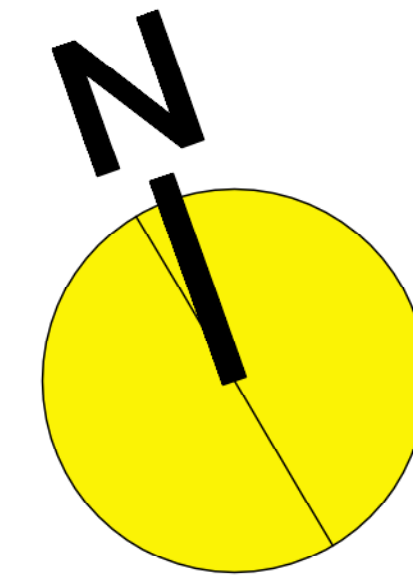


WEST

A

# NORTH 300 LEVEL TRUSS PLAN

Scale: 1/4" = 1'-0"

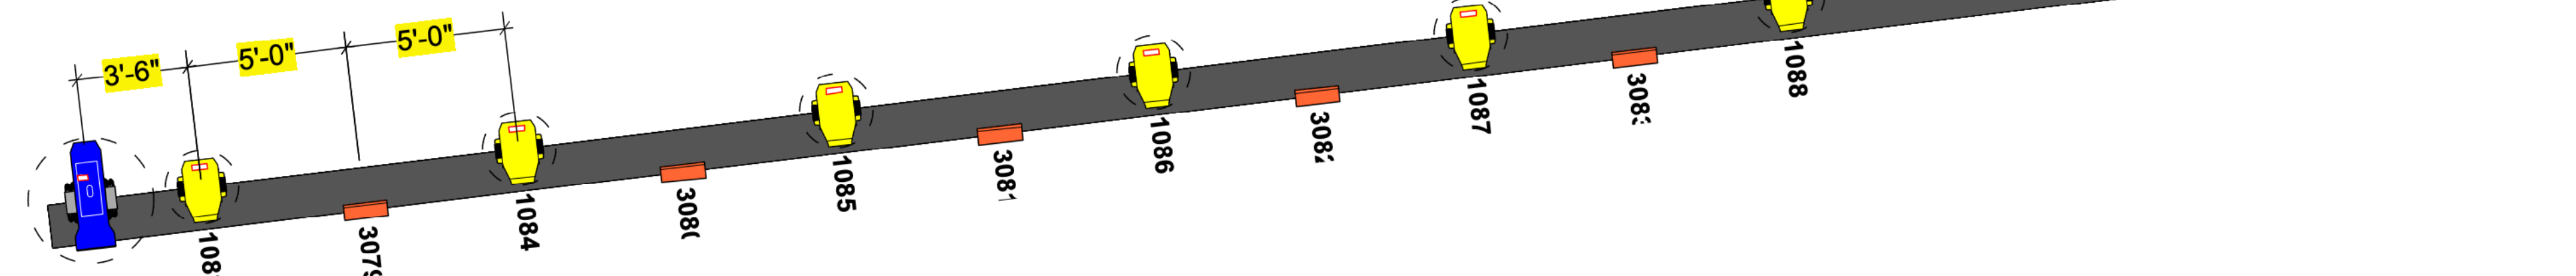


EAST

B

# SOUTH 300 LEVEL TRUSS PLAN

Scale: 1/4" = 1'-0"

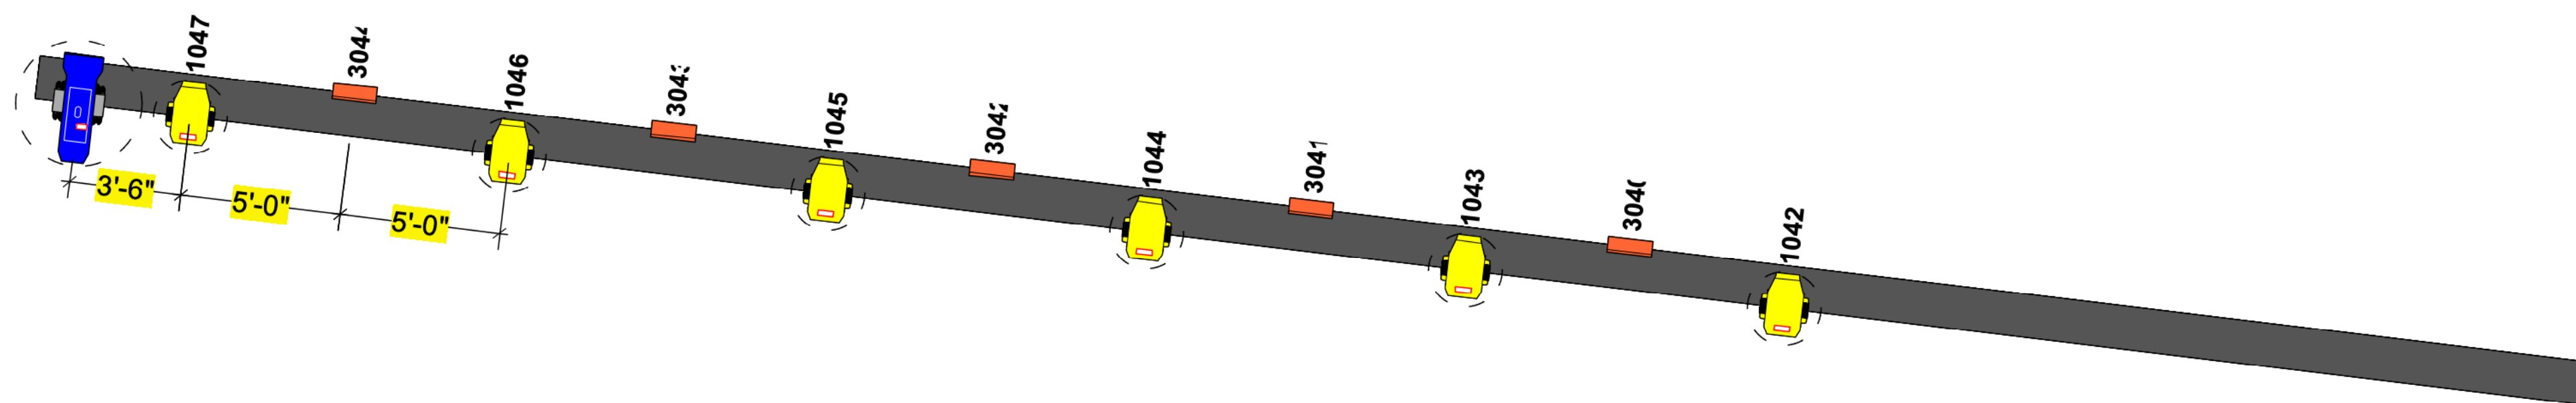

EAST

WEST

ENTERTAINMENT DESIGN GROUP

Please recycle this paper.

This document and its contents are the property of Entertainment Design Group. It is to be used for the project and only for the project. It is not to be reproduced, stored in a retrieval system, or transmitted in any form or by any means, electronic, mechanical, photocopying, recording, or by any information storage and retrieval system, without the prior written permission of Entertainment Design Group. The design of this document and its contents is the property of Entertainment Design Group. The design of this document and its contents is the property of Entertainment Design Group. The design of this document and its contents is the property of Entertainment Design Group.

INSTRUMENT KEY

PRG GC Longthrow @ 1.5kw

Elation Proteus Escalibur @ 950 w

Elation Proteus Mascurus @ 1.4kw

Philips Vari-Lite VL2600 Profile @ 820w

Robe Robin 1200 LED Wash @ 680w

TM8 Solaris Flare @ 1kw

Proton 3000 @ 900w

VENUE

SOFI STADIUM

LOS ANGELES, CA

SHOW

SUPER BOWL LVII

SUPERBOWL LVII HALFTIME SHOW

LOAD-IN

SHOWDAY

SHOW #

01/26/21

02/13/21

#2202

DESIGNER

LEAD L.D.

GAFFER

PROD. 1

PROD. 2

LEAD TECH

GURDON

GREEN / FORSTER

SISUL / UCHTA

ERIC MARCHWINSKI

MARK HUMPHREY

ROBB MINNOTTE

VERSION

01. PRELIMINARY

02. SURVEY UPDATE 01/2021

03. NY UPDATE 01/2022

04. FOM UPDATE 01/2022

05. CH CHANNELS 01/2022

06. AS GART UPDATE 01/2022

07. AS BUILT

PRINT ARCH E SHEET

DRAWN BY

SCALE

BEG

AS NOTED

CONTENTS

LX-01: SITE PLAN

LX-02: INFRASTRUCTURE

LX-03: FIELD LAYOUT

LX-04: N / S TRUSS

LX-05: LEVEL 8 RAILS

SHEET #

LX-04

PUBLISH DATE

AS BUILT 02/12/2022

N / S TRUSS