




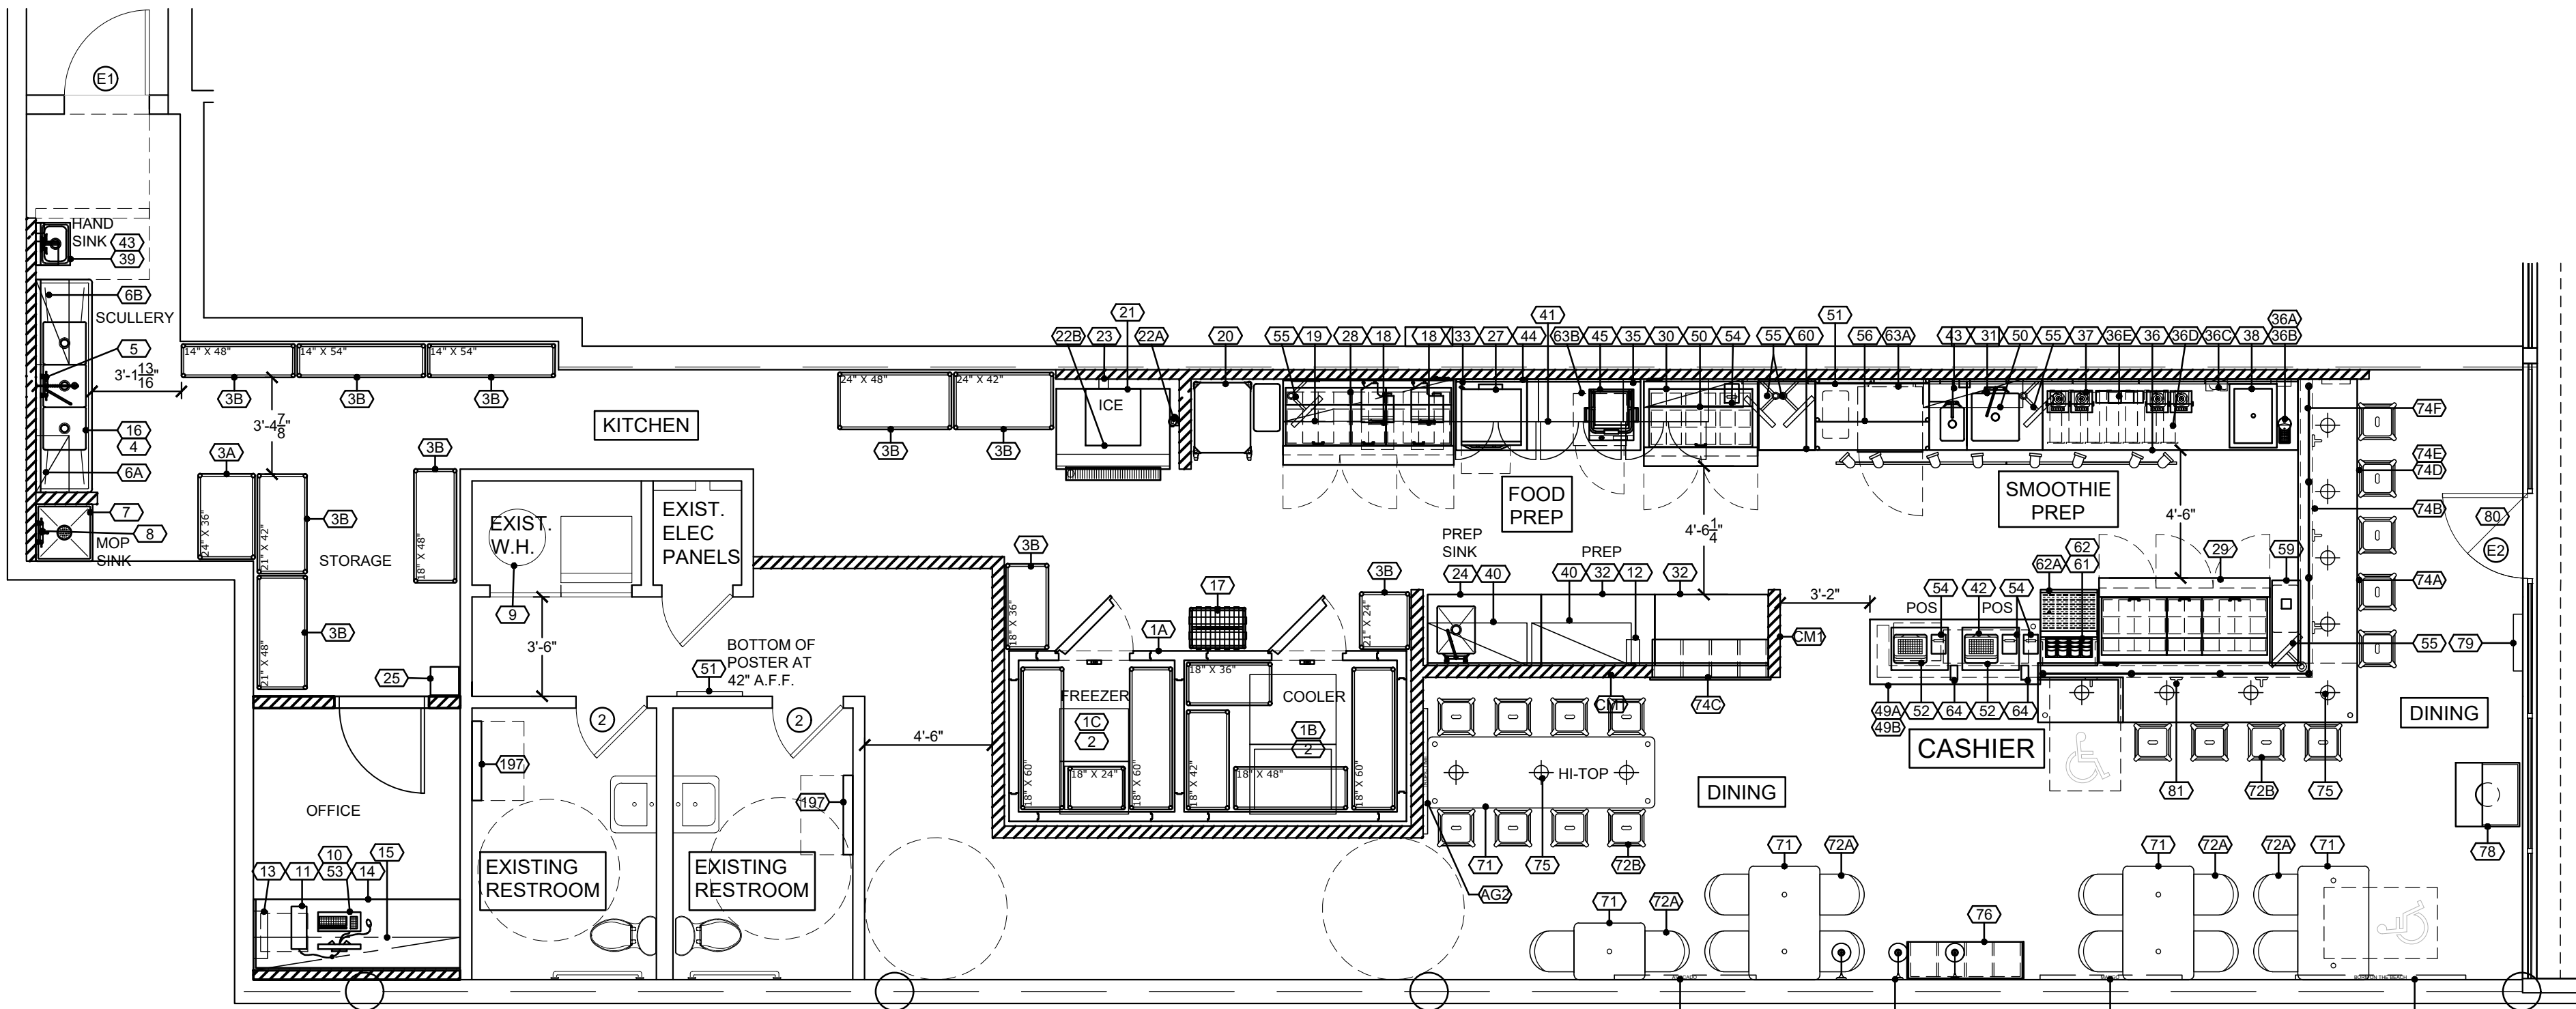


1 EQUIPMENT PLAN
SCALE: NTS

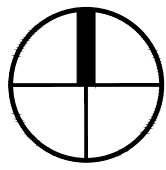


DESIGNER NOTE:
UPDATE ARTWORK
QUANTITY AND TYPE AS
REQUIRED PER SITE
SPECIFIC CONDITIONS.

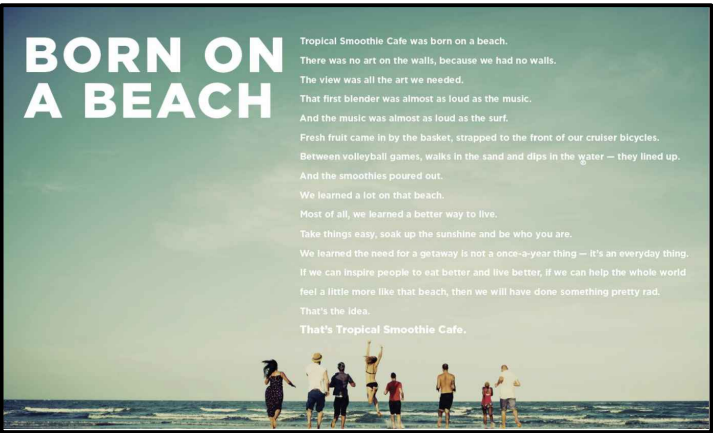


2 ARTWORK (AG-1)
SCALE: NTS

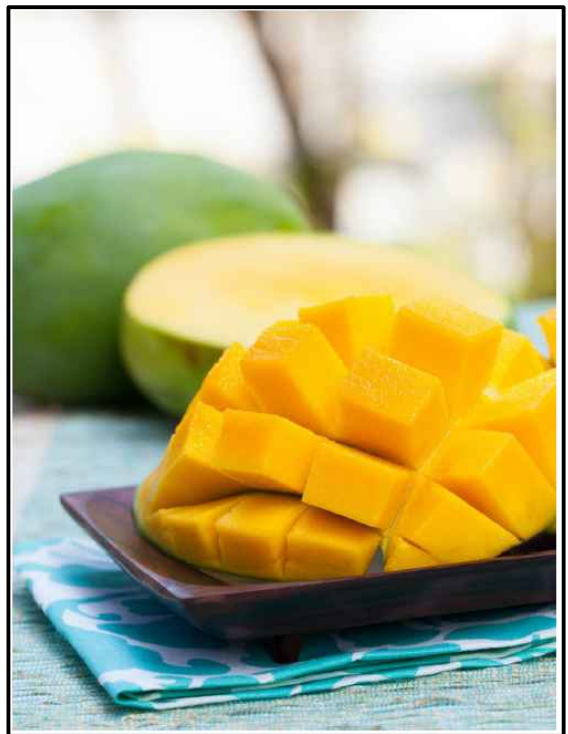


4 ARTWORK (AG-3)
SCALE: NTS

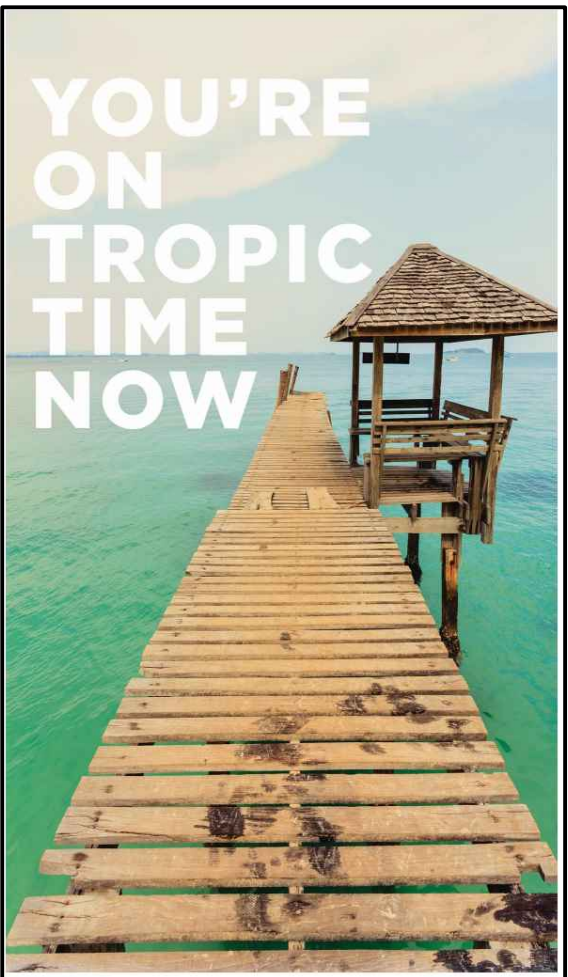

3 ARTWORK (AG-2)
SCALE: NTS

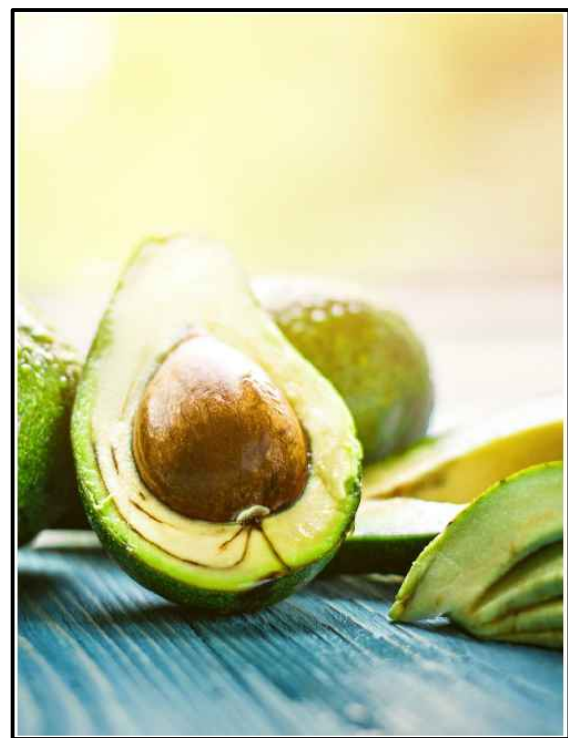


5 ARTWORK (AG-4)
SCALE: NTS

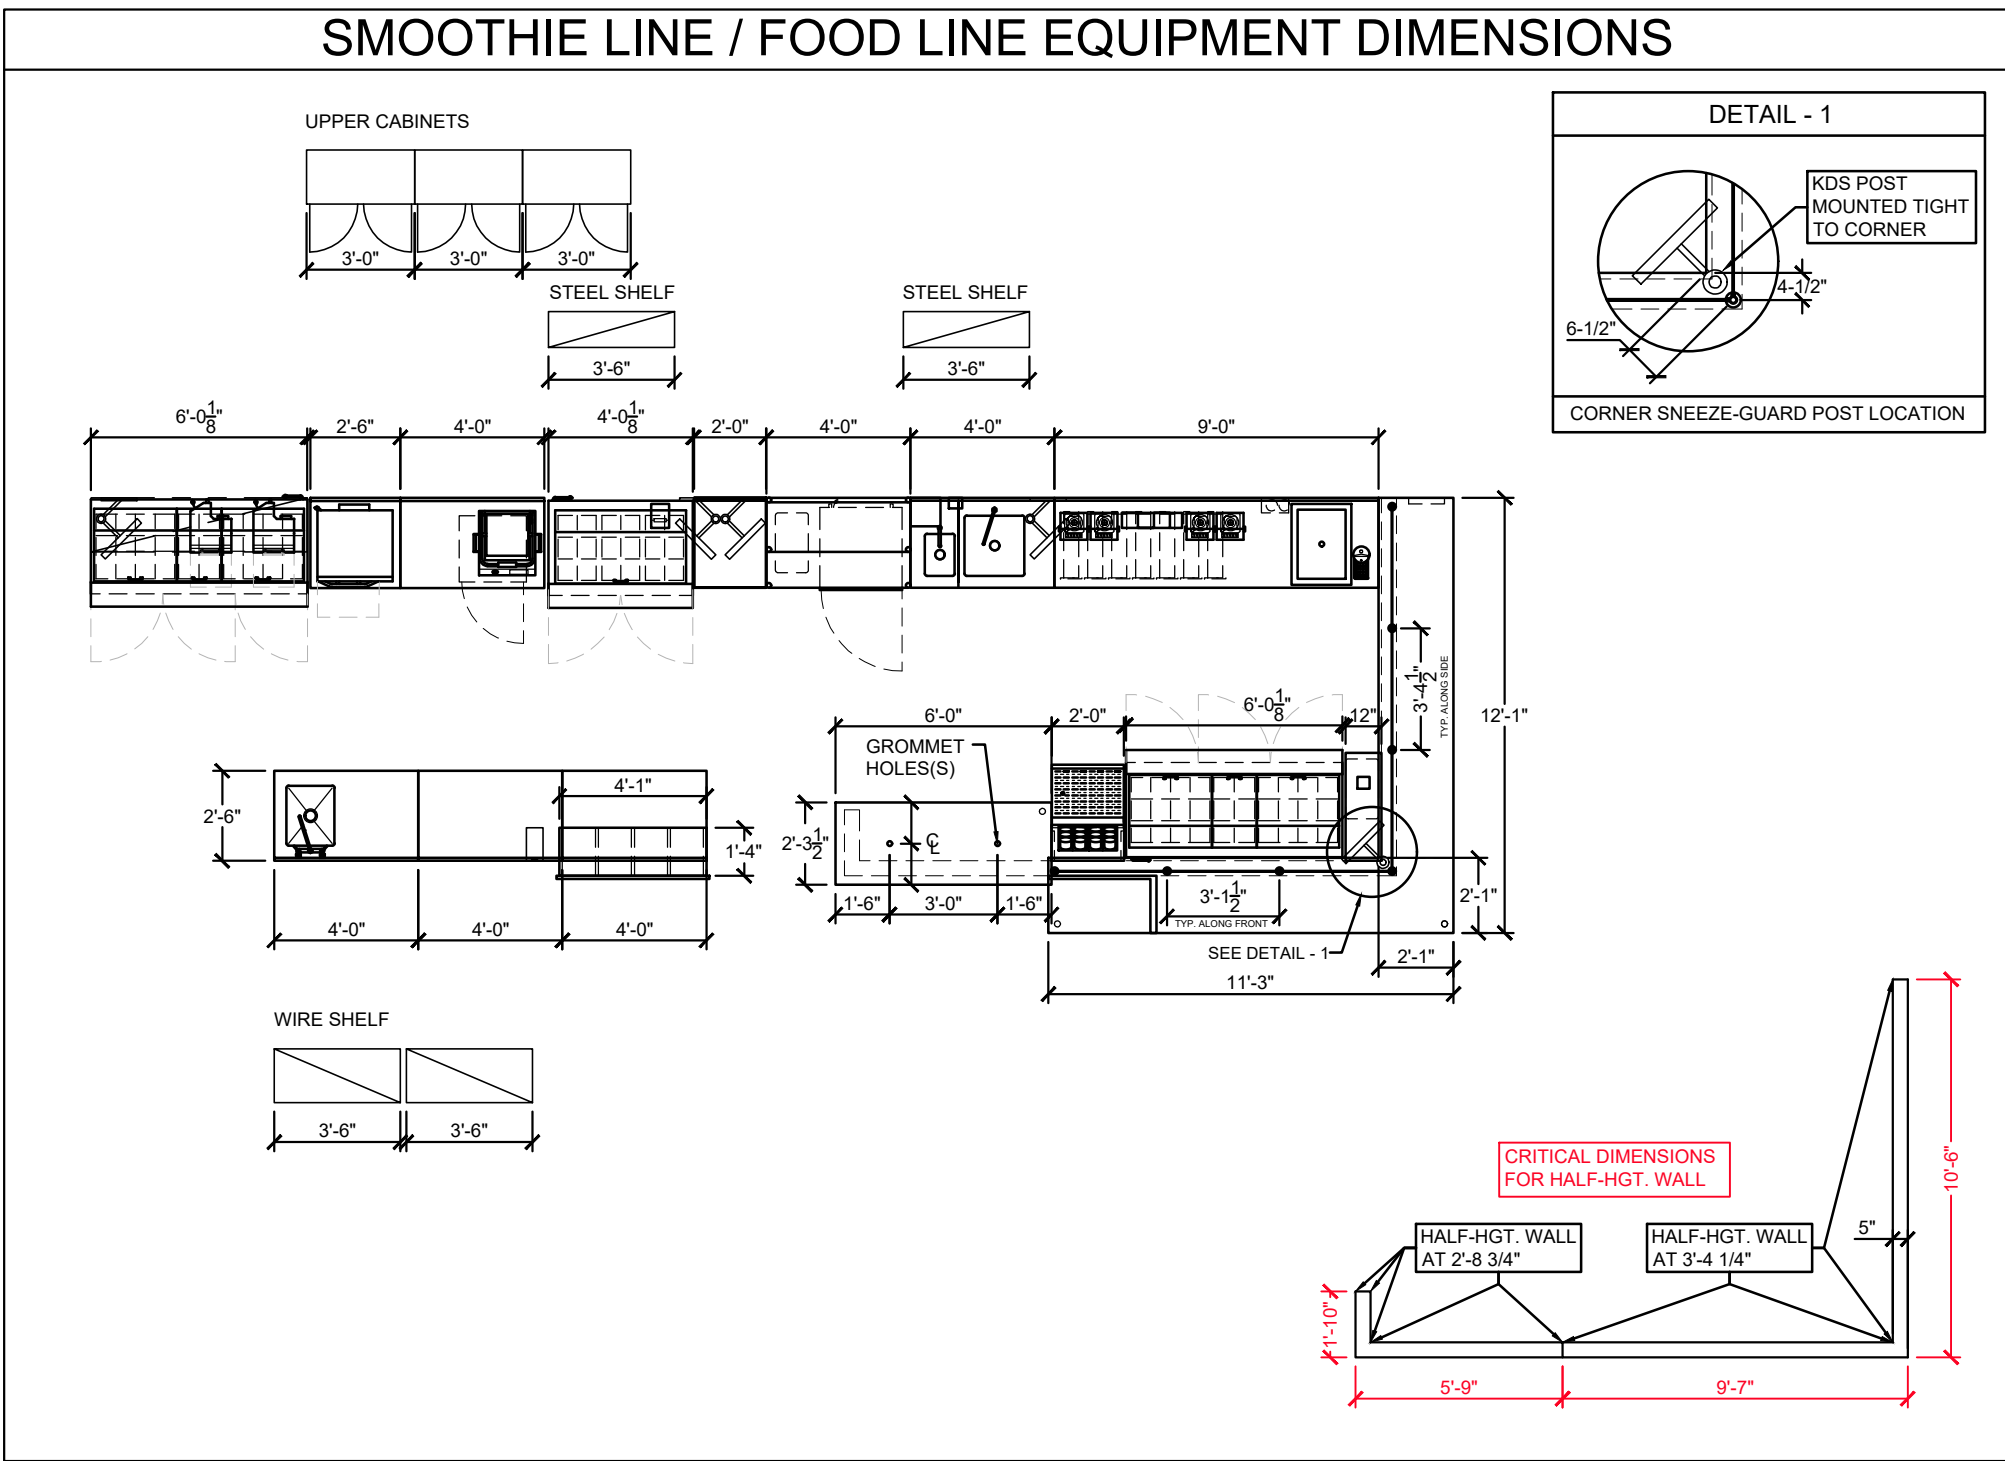

ARTWORK SCHEDULE					
NO.	QTY.	DESCRIPTION	PROVIDER	VENDOR	INSTALL
AG-1	1	BORN ON THE BEACH	F	UMI	GC
AG-2	1	YOU'RE ON TROPIC TIME	F	UMI	GC
AG-3	1	MANGO PHOTO	F	UMI	GC
AG-4	1	AVOCADO PHOTO	F	UMI	GC

WALK-IN DIMENSIONS

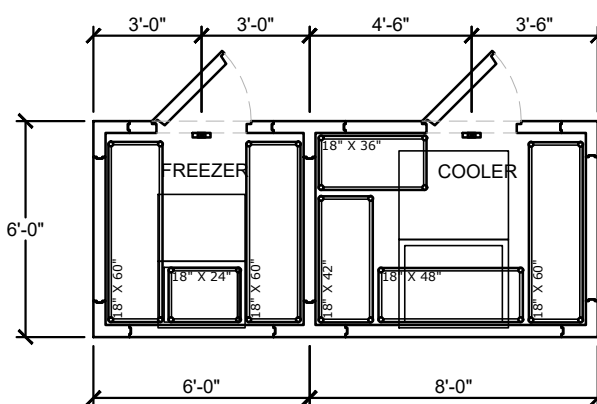

EQUIPMENT VENDOR TO REVIEW DIMENSIONS AND ENSURE SIZES
CONFORM TO STANDARD FABRICATOR MEASUREMENTS AND NOT
SUBJECT TO ORDERING DELAYS. PLEASE CONTACT TSC IF MODIFICATION
ARE REQUIRED TO MAKE WALK-INS CONFIRM TO STANDARD SIZES.

ABBREVIATION KEY

ABBR.	ABBREVIATION DESCRIPTION
F	FRANCHISEE
EV	EQUIPMENT VENDOR
GC	GENERAL CONTRACTOR
EC	ELECTRICAL CONTRACTOR
PC	PLUMBING CONTRACTOR
CC	CONTRACTOR'S CHOICE
OC	OWNER'S CHOICE
LJ	LOCAL JURISDICTION
SC	SIGN COMPANY
VLL	VERIFY WITH LANDLORD
V	VENDOR
PB	PAR BRINK
UMI	ULTERIOR MOTIVES INTERNATIONAL
HL	HERMITAGE LIGHTING
MMM	MUZAK (MOOD MEDIA)
KC	KAY CHEMICALS (ECO-LAB)
UC	UTILITY COMPANY
SFS	SEE FINISH SCHEDULE
SPS	SEE PLUMBING SCHEDULE
INSTALL	EQUIPMENT INSTALLER
FIN. CON.	FINAL CONNECTIONS
DT	DRIVE-THRU
DBL	DOUBLE SHELVES
CM-1	CORRUGATED METAL (SEE FINISHES PAGE)

EQUIPMENT SCHEDULE

NO.	QTY.	EQUIPMENT DESCRIPTION	PROVIDER	VENDOR	INSTALL	FIN. CON.
BACK OF HOUSE EQUIPMENT						
1A	1	WALK-IN COOLER / FREEZER COMBO UNIT	F	EV	GC	EC
1B	1	COOLER REFRIGERATION, SELF-CONTAINED	F	EV	GC	EC
1C	1	FREEZER REFRIGERATION, SELF-CONTAINED	F	EV	GC	EC
2	7	WALK-IN COOLER / FREEZER SHELVING	F	EV	GC	-
3A	1	75" TALL DRY STORAGE SHELVING (EPOXY COATED)	F	EV	EV	-
3B	10	75" TALL DRY STORAGE SHELVING (ZINC COATED)	F	EV	EV	-
4	1	THREE COMPARTMENT SINK	F	EV	EV	PC
5	1	PRE-RINSE FAUCET	F	EV	EV	PC
6A	1	WALL SHELF, WIRE (EPOXY COATED), 14" X 24"	F	EV	EV	-
6B	1	WALL SHELF, WIRE (EPOXY COATED), 14" X 36"	F	EV	EV	-
7	1	MOP SINK	GC	SPS	GC	PC
8	1	SERVICE FAUCET	GC	SPS	GC	PC
9	1	WATER HEATER - EXISTING	EXISTING	SPS	GC	EC/PC
10	LOT	SURVEILLANCE SYSTEM	F	VLL	V	V
11	1	SAFE	F	EV	EV	-
12	1	PRINTER WITH SHELF	F	JOLT	GC	V
13	1	POS PATCH PANEL	F	PB	PB	PB
14	1	MANAGER'S DESK	F	GC	GC	-
15	1	WALL SHELVES (EPOXY COATED)	F	GC	GC	-
16	LOT	WAREWASHING & SANITIZING PRODUCTS	F	KC	KC	-
17	1	18" X 24" DUNNAGE RACK	F	EV	EV	-
18	2	ON QUE	F	EV	EV	-
19	1	18" X 72", ON QUE SHELF	F	EV	EV	-
20	1	MOBILE HALF-HGT STORAGE UNIT WITH WORK TOP	F	EV	EV	-
21	1	ICE MAKER W / BIN	F	EV	EV	EC/PC
22A	1	WATER FILTER, 3-STAGE	F	EV	EV	PC
22B	1	ICE MACHINE TREATMENT SYSTEM	F	EV	EV	PC
23	1	CHANNEL DRAIN, 5" (3'-4" LONG)	GC	SPS	PC	PC
24	1	PREP SINK, 30" X 48"	F	EV	EV	PC
25	1	LOCKER SET	F	EV	EV	-
26	-	SPARE NUMBER	-	-	-	-
SMOOTHIE LINE / FOOD LINE EQUIPMENT						
27	2	MICROWAVE CONVECTION OVEN	F	EV	EV	-
28	1	REFRIGERATED PREP TABLE, 30 PAN	F	EV	EV	-
29	1	REFRIGERATED PREP TABLE, 30 PAN	F	EV	EV	-
30	1	REFRIGERATED PREP TABLE, 18 PAN	F	EV	EV	-
31	1	WORK TABLE W/HAND SINK & DUMP SINK, 30" X 48"	F	EV	EV	PC
32	2	WORK TABLE, 30" X 48"	F	EV	EV	-
33	1	EQUIPMENT STAND, 30" X 30" (26" HGT.)	F	EV	EV	-
35	1	WORK TABLE, 30" X 48"	F	EV	EV	-
36	1	BLENDER TABLE, 30" X 108"	F	EV	EV	PC
36A	1	WATER SPIGOT	F	EV	EV	PC
36B	1	WATER CONTAINER, DROP-IN	F	EV	EV	-
36C	1	WATER FILTER, 2-STAGE	F	EV	EV	PC
36D	4	CUP DISPENSER	F	EV	EV	-
36E	1	LID DISPENSER	F	EV	EV	-
37	4	BLENDER, BAR TYPE	F	EV	EV	-
38	1	ICE BIN, DROP-IN	F	EV	EV	PC
39	1	HAND SINK, HANDS-FREE	F	EV	EV	PC
40	2	WALL SHELF, WIRE (ZINC COATED), 18" X 42"	F	EV	EV	-
41	3	WALL CABINET, 36"	F	EV	EV	-
42	1	MOBILE STORAGE UNIT, 14" X 36"	F	EV	EV	-
43	2	SOAP / PAPER TOWEL DISPENSERS	F	C	C	-
44	1	S/S L-SHAPED WALL PANEL	F	EV	EV	-
45	1	PANINI PRESS	F	EV	EV	-
CASHIER AREA EQUIPMENT						
49A	1	CASHIER COUNTER TOP & SUPPORT LEG	F	EV	EV	-
49B	1	CASHIER COUNTER SUPPORT WALL	F	GC	GC	EC
50	2	WALL SHELF, S/S, 12" X 42"	F	EV	EV	-
51	1	MENU BOARD SYSTEM, WALL MOUNT, 9 PANELS	F	EV	EV	-
52	2	POS TERMINAL	F	PB	PB	PB
53	1	POS SYSTEM - BACK OF HOUSE	F	PB	PB	PB
54	4	POS PRINTER	F	PB	PB	PB
55	5	KDS MONITOR	F	M	PB	PB
56	1	EXPO TABLE	F	EV	EV	-
57	-	SPARE NUMBER	-	-	-	-
58	-	SPARE NUMBER	-	-	-	-
59	1	WALL MTD. WORK TOP, 36" X 12"	F	EV	EV	-
60	1	WORK TABLE, 30" X 24"	F	EV	EV	-
61	2	SUPPLEMENT HOLDER	F	EV	EV	-
62	1	DRAIN BOARD	F	EV	EV	PC
62A	1	CUSTOM SHELF	F	EV	EV	-
63A	1	REFRIGERATOR, UNDERCOUNTER	EV	EV	EV	-
63B	1	FREEZER, UNDERCOUNTER	EV	EV	EV	-
64	2	EMV CARD READER	F	PB	PB	PB
DINING EQUIPMENT						
71	5	TABLE TOP & BASE	F	EV	EV	-
72A	14	DINING CHAIR	F	EV	EV	-
72B	17	DINING STOOL	F	EV	EV	-
73	-	SPARE NUMBER	-	-	-	-
74A	1	SIT-DOWN COUNTER TOP & SUPPORT LEGS	F	EV	EV	-
74B	1	SIT-DOWN COUNTER SUPPORT WALL	F	GC	GC	-
74C	1	MILLWORK 3RD PARTY PICK-UP CABINET	F	EV	EV	-
74D	1	MILLWORK SOFFIT	F	EV	EV	EC
74E	1	THREADED MOUNTING RODS FOR SOFFIT	GC	GC	GC	-
74F	1	SNEEZEGUARD	F	EV	EV	-
75	11	PENDANT LIGHT	F	HL	GC	EC
76	1	MILLWORK ON-LINE ORDER PICK-UP CABINET	F	EV	EV	-
77	-	SPARE NUMBER	F	EV	EV	EC
78	1	TRASH CAN ENCLOSURE WITH TRAY SHELF	F	EV	EV	-
79	1	TROPICAL SMOOTHIE NEON SIGN	F	EV	EV	-
80	1	EXTERIOR SIGNAGE	F	SC	SC	EC
81	6	APPAREL HOOK	F	GC	GC	-
100	-	SPARE NUMBER	F	SC	GC	EC
197	2	BABY CHANGING STATION	F	EV	EV	-
198	3	WALL SCONCE LIGHTING	F	HL	GC	EC

tropical CAFE
SMOOTHIE
eat better. feel better.

STORE ADDRESS

ADDRESS

STORE NUMBER

####

REVISION

△		

DATE MM/DD/YY

PROJECT XXXXXX

THESE DRAWINGS ARE NOT
FOR CONSTRUCTION OR
PERMIT

They are for illustrative purposes only. The client and/or contractor assumes all responsibility to ensure the accuracy, compliance with applicable statute(s), regulation(s) common building practices and local codes. All dimensions and specifications should be verified by client and/or contractor before actual construction begins. Tropical Smoothie Cafe or subsidiaries (to include Baxter Design, INC.) assume no liability for changes and/or revisions made to plans by client and/or contractors. These plans are the property of Tropical Smoothie Cafe. They may not be reproduced without written permission.

FOR INTERNAL USE ONLY
PROTOTYPE REVISION NUMBER

SHEET NAME
EQUIPMENT PLAN
AND SCHEDULE

SHEET NUMBER

A140

ALL RIGHTS RESERVED. ALL IDEAS, DESIGNS, PLANS AND SPECIFICATIONS ARE THE PROPERTY OF FLOW DESIGN INC. RIGHTS OF USE ARE CONDITIONAL AND ARE LIMITED TO A ONE-TIME USE TO CONSTRUCT A SINGLE PROJECT ON THE SITE SO INDICATED. USE OF THE WORK AND ANY DERIVATIVE WORK COVERED UNDER THIS COPYRIGHT FOR OTHER PROJECTS IS PROHIBITED. THE USE OR REPRODUCTION OF THESE PLANS FOR ANY OTHER CONSTRUCTION OR PERMIT APPLICATION IS STRICTLY PROHIBITED WITHOUT PRIOR WRITTEN PERMISSION OF FLOW DESIGN INC. AND THE ARCHITECT WHOSE SIGNATURE AND SEAL MAY BE AFFIXED TO THESE DRAWINGS. MADE BY HUMANS.

14 Mc GRATH HWY,
SOMERVILLE, MA 02143
TEL: 617-785-6577

ARCHITECT:



50 GROVE ST. SUITE 226
SALEM, MA 01970
TEL: 978.498.4370

tropical
SMOOTHIE
CAFE®

[illegible]

DRAWN BY:

SCALE:

DRAWING NO.:

DRAWING NO.:
A-300

