


Linden (interior)

Main Floor Plan
1552 Square Feet
scale: 1/8" = 1'-0"




ELECTRICAL LEGEND				NOTES:		MECHANICAL LEGEND	
RECESSED INTERIOR DOWNLIGHT	VAPOUR PROOF SURFACE MOUNTED CEILING INCANDESCENT FIXTURE	UNDERCOUNTER FLOURESCENT	DOOR ACTIVATED LIGHT	BOX FOR FUTURE VEHICLE CHARGING	1. ALL EXTERIOR RECEPTACLES TO BE WATERPROOF, GFI-	HOSE BIB (FROST PROOF)	
RECESSED INTERIOR DOWNLIGHT -VAPOUR PROOF	RECESSED JUNCTION BOX	EXTERIOR FLOOD LIGHT U/S/OF ROOF OVERHANG	110V DUPLEX OUTLET	SMOKE/CARBON MONOXIDE DETECTOR	2. ALL KITCHEN RECEPTACLES TO BE GFI AND MOUNTED 45" ABOVE THE FINISHED FLOOR WHERE ADJACENT TO CABINETS. REFER TO KITCHEN LAYOUTS FROM KITCHEN MANUFACTURER FOR LOCATIONS AS WELL AS FOR APPLIANCE LOCATIONS.	ENERGY RECOVERY VENTILATOR	
RECESSED EXTERIOR DOWNLIGHT	EXTERIOR WALL MOUNTED INCANDESCENT FIXTURE	OVERHEAD GARAGE DOOR OPERATOR c/w LIGHT SWITCH	220V APPLIANCE	EXHAUST FAN	3. ALL BEDROOM OUTLETS TO BE 'I' PROTECTED.	THERMOSTAT	
SURFACE MOUNTED CEILING INCANDESCENT FIXTURE	INTERIOR WALL MOUNTED INCANDESCENT FIXTURE	SWITCH-FIREPLACE	EXTERIOR WATER PROOF/GFI OUTLET	CHIME	4. ALL SHOWER FIXTURES TO BE VAPOUR/WATER PROOF.	FIREPLACE THERMOSTAT	
RECESSED JUNCTION BOX	INTERIOR WALL MOUNTED INCANDESCENT FIXTURE 2 LIGHTS	3 WAY SWITCH	BATHROOM GROUND FAULT OUTLET	RECESSED CEILING SPEAKER	5. ALL BATHROOM & LAUNDRY ROOM OUTLETS TO BE GFI AND MOUNTED ABOVE COUNTER HEIGHT WHERE APPLICABLE. REFER TO MILLWORK DRAWINGS.		
INCANDESCENT FIXTURE, WITH PULL CHAIN	INTERIOR WALL MOUNTED INCANDESCENT FIXTURE 3 LIGHTS	DIMMER SWITCH	COUNTER HEIGHT GROUND FAULT OUTLET	CENTRAL VACUUM OUTLET	6. ELECTRICAL CONTRACTOR TO COORDINATE THERMOSTAT, CHIME AND SWITCH LOCATIONS WITH SITE SUPERINTENDENT.	EXHAUST FAN	
TRACK LIGHT	OPTIONAL RECESSED DOWNLIGHTS WITH DIMMER SWITCH		FLOOR OUTLET		7. 200 AMP PANEL WITH CONDUIT TO SQUARE 4 11/16" BOX IN GARAGE FOR FUTURE ELECTRIC VEHICLE CHARGING.		

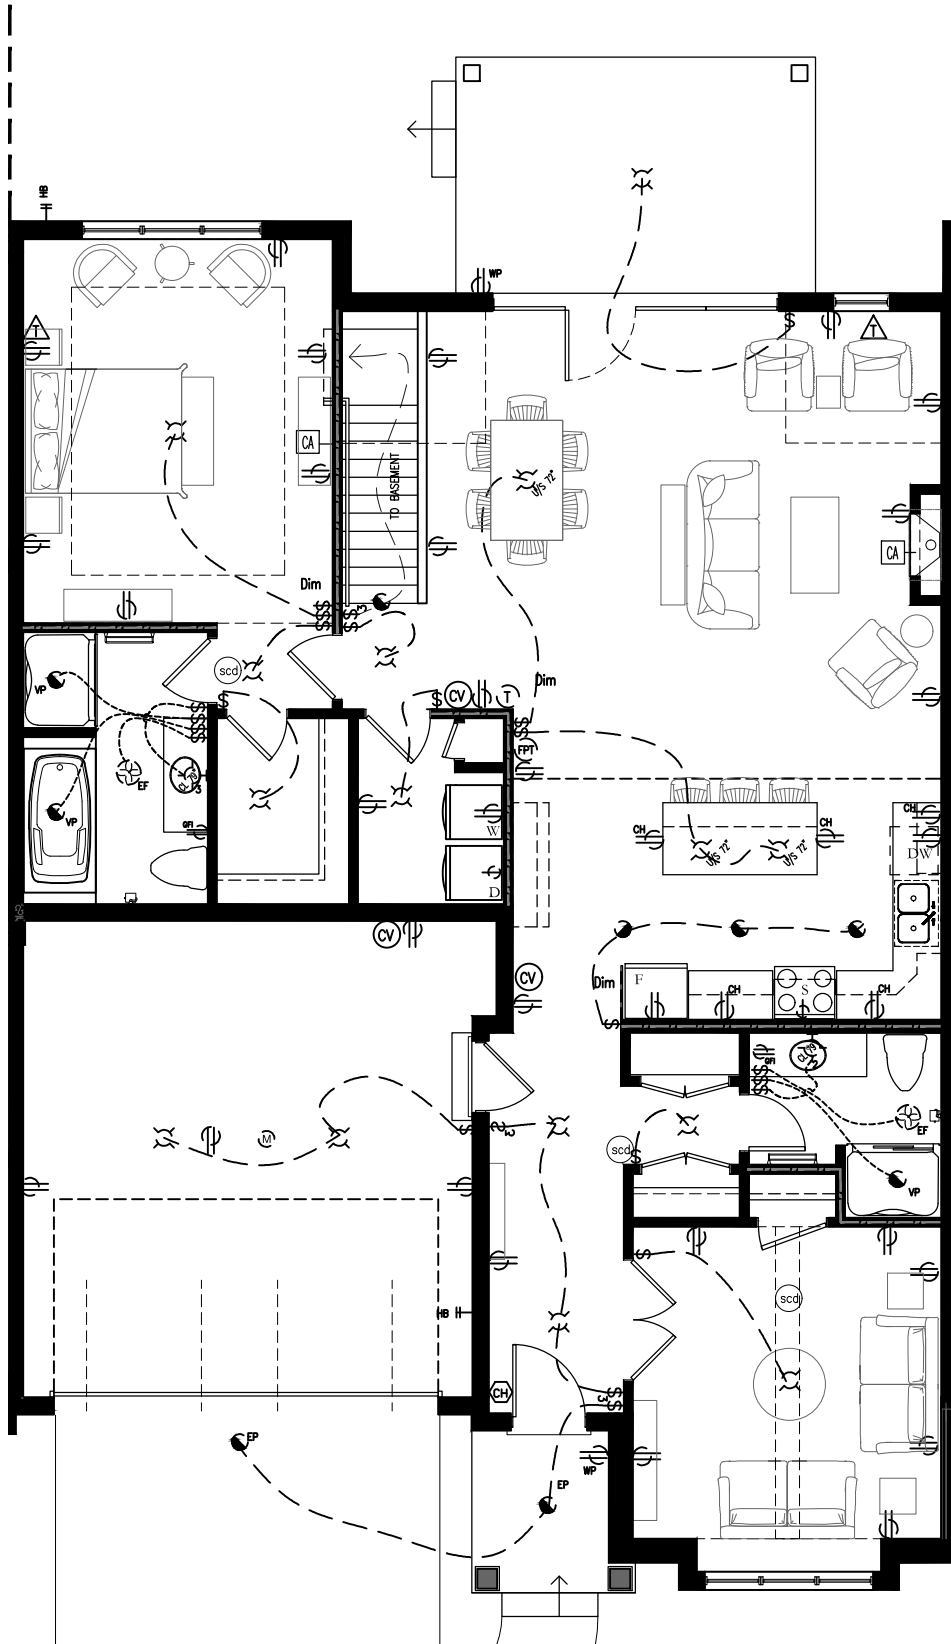

Linden (interior)
 Main Floor Plan
 Electrical Layout
 scale: 1/8" = 1'-0"



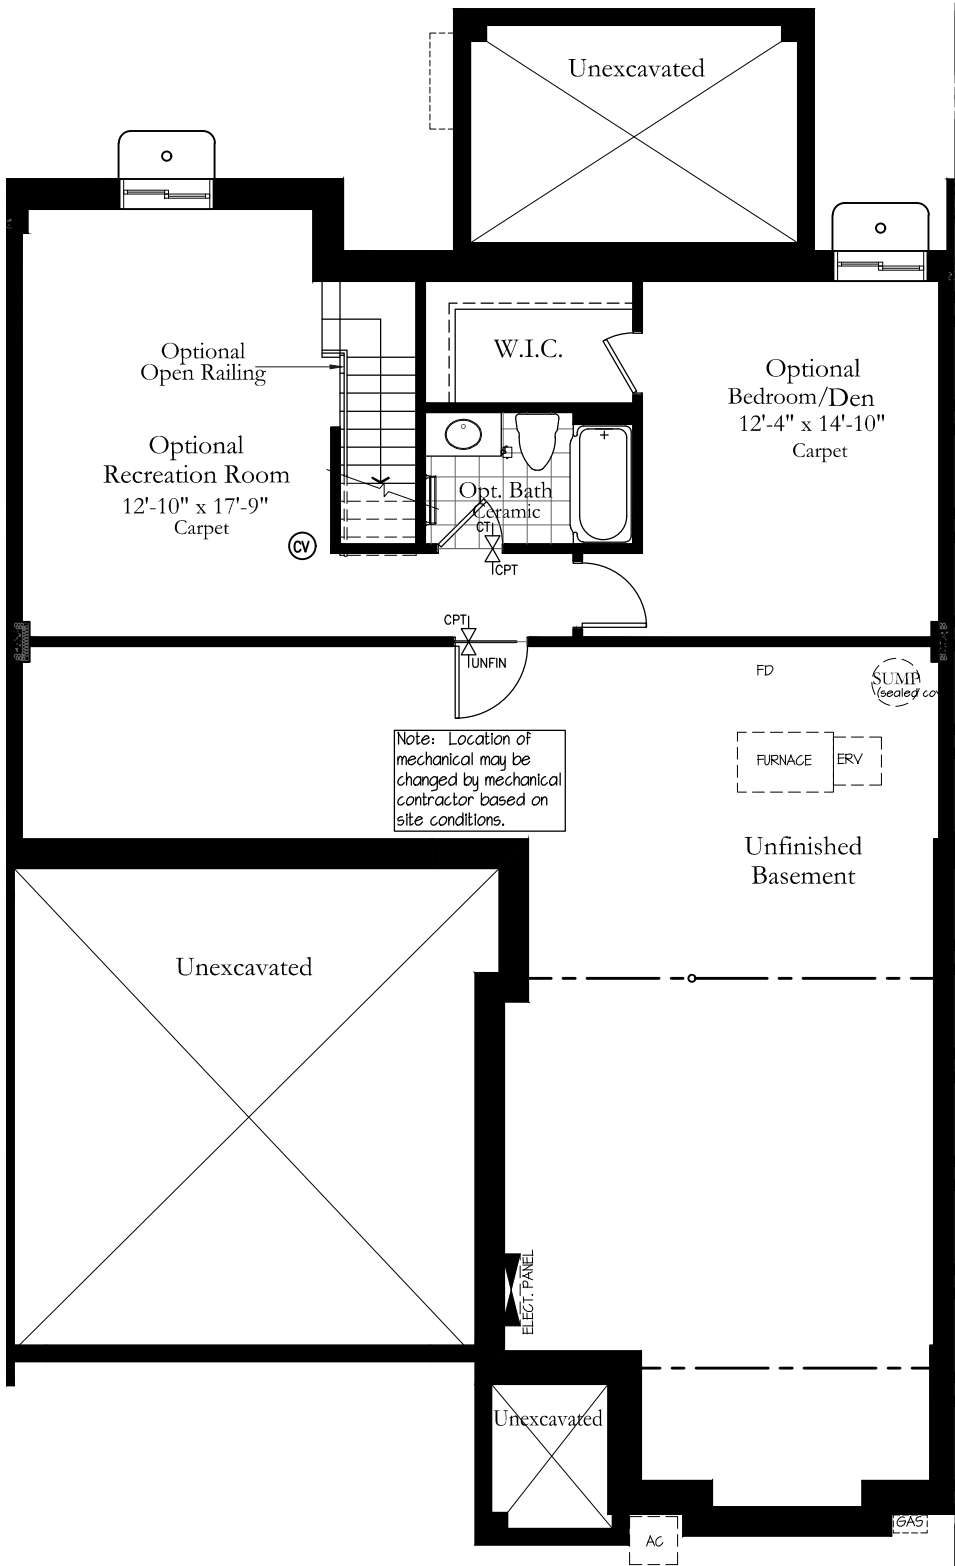


Note: Location of mechanical may be changed by mechanical contractor based on site conditions.

Linden (interior)
 Basement Floor Plan
 640 Square Feet Upgrade
 scale: 1/8"=1'-0"



ELECTRICAL LEGEND				NOTES:		MECHANICAL LEGEND	
RECESSED INTERIOR DOWNLIGHT	VAPOUR PROOF SURFACE MOUNTED CEILING INCANDESCENT FIXTURE	UNDERCOUNTER FLOURESCENT	DOOR ACTIVATED LIGHT	BOX FOR FUTURE VEHICLE CHARGING	1. ALL EXTERIOR RECEPTACLES TO BE WATERPROOF, GFI-	HOSE BIB (FROST PROOF)	
RECESSED INTERIOR DOWNLIGHT -VAPOUR PROOF	RECESSED JUNCTION BOX	EXTERIOR FLOOD LIGHT U/S/OF ROOF OVERHANG W/MOTION SENSOR	110V DUPLEX OUTLET	SMOKE/CARBON MONOXIDE DETECTOR	2. ALL KITCHEN RECEPTACLES TO BE GFI AND MOUNTED 45" ABOVE THE FINISHED FLOOR WHERE ADJACENT TO CABINETS. REFER TO KITCHEN LAYOUTS FROM KITCHEN MANUFACTURER FOR LOCATIONS AS WELL AS FOR APPLIANCE LOCATIONS.	ENERGY RECOVERY VENTILATOR	
RECESSED EXTERIOR DOWNLIGHT	EXTERIOR WALL MOUNTED INCANDESCENT FIXTURE	OVERHEAD GARAGE DOOR OPERATOR c/w LIGHT SWITCH	220V APPLIANCE	EXHAUST FAN	3. ALL BEDROOM OUTLETS TO BE 'I' PROTECTED.	THERMOSTAT	
SURFACE MOUNTED CEILING INCANDESCENT FIXTURE	INTERIOR WALL MOUNTED INCANDESCENT FIXTURE	SWITCH-FIREPLACE	EXTERIOR WATER PROOF/GFI OUTLET	CHIME	4. ALL SHOWER FIXTURES TO BE VAPOUR/WATER PROOF. ELECTRICAL CONTRACTOR TO COORDINATE THERMOSTAT, CHIME AND SWITCH LOCATIONS WITH SITE SUPERINTENDENT.	FIREPLACE THERMOSTAT	
RECESSED JUNCTION BOX	INTERIOR WALL MOUNTED INCANDESCENT FIXTURE 2 LIGHTS	3 WAY SWITCH	BATHROOM GROUND FAULT OUTLET	RECESSED CEILING SPEAKER	5. ALL BATHROOM & LAUNDRY ROOM OUTLETS TO BE GFI AND MOUNTED ABOVE COUNTER HEIGHT WHERE APPLICABLE. REFER TO MILLWORK DRAWINGS.	EXHAUST FAN	
INCANDESCENT FIXTURE, WITH PULL CHAIN	INTERIOR WALL MOUNTED INCANDESCENT FIXTURE 3 LIGHTS	DIMMER SWITCH	COUNTER HEIGHT GROUND FAULT OUTLET	CENTRAL VACUUM OUTLET	6. 200 AMP PANEL WITH CONDUIT TO SQUARE 4 11/16" BOX IN GARAGE FOR FUTURE ELECTRIC VEHICLE CHARGING.		
TRACK LIGHT	OPTIONAL RECESSED DOWNLIGHTS with DIMMER SWITCH		FLOOR OUTLET				

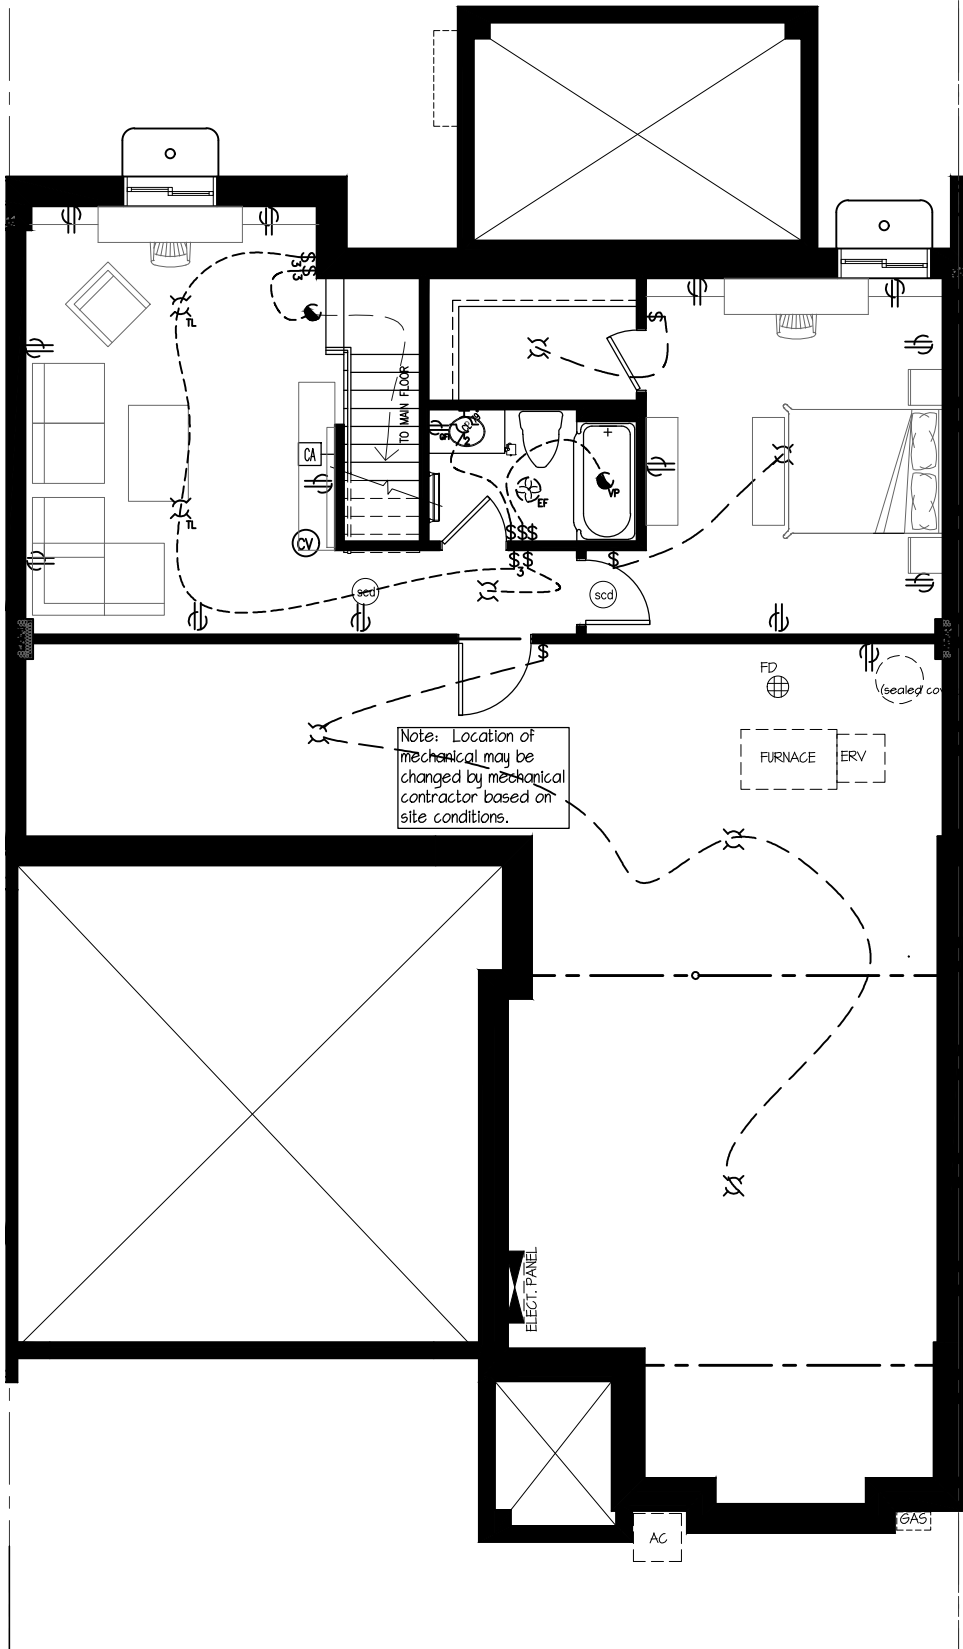

Linden (interior)
 Basement Floor Plan
 Electrical Layout
 scale: 1/8" = 1'-0"





Linden (interior)
 Front Elevation
 scale: 1/8" = 1'-0"





Linden (interior)
 Rear Elevation
 scale: 1/8"=1'-0"

