




REAR ELEVATION

SCALE 1/4" = 1'-0"




FRONT ELEVATION

SCALE 1/4" = 1'-0"

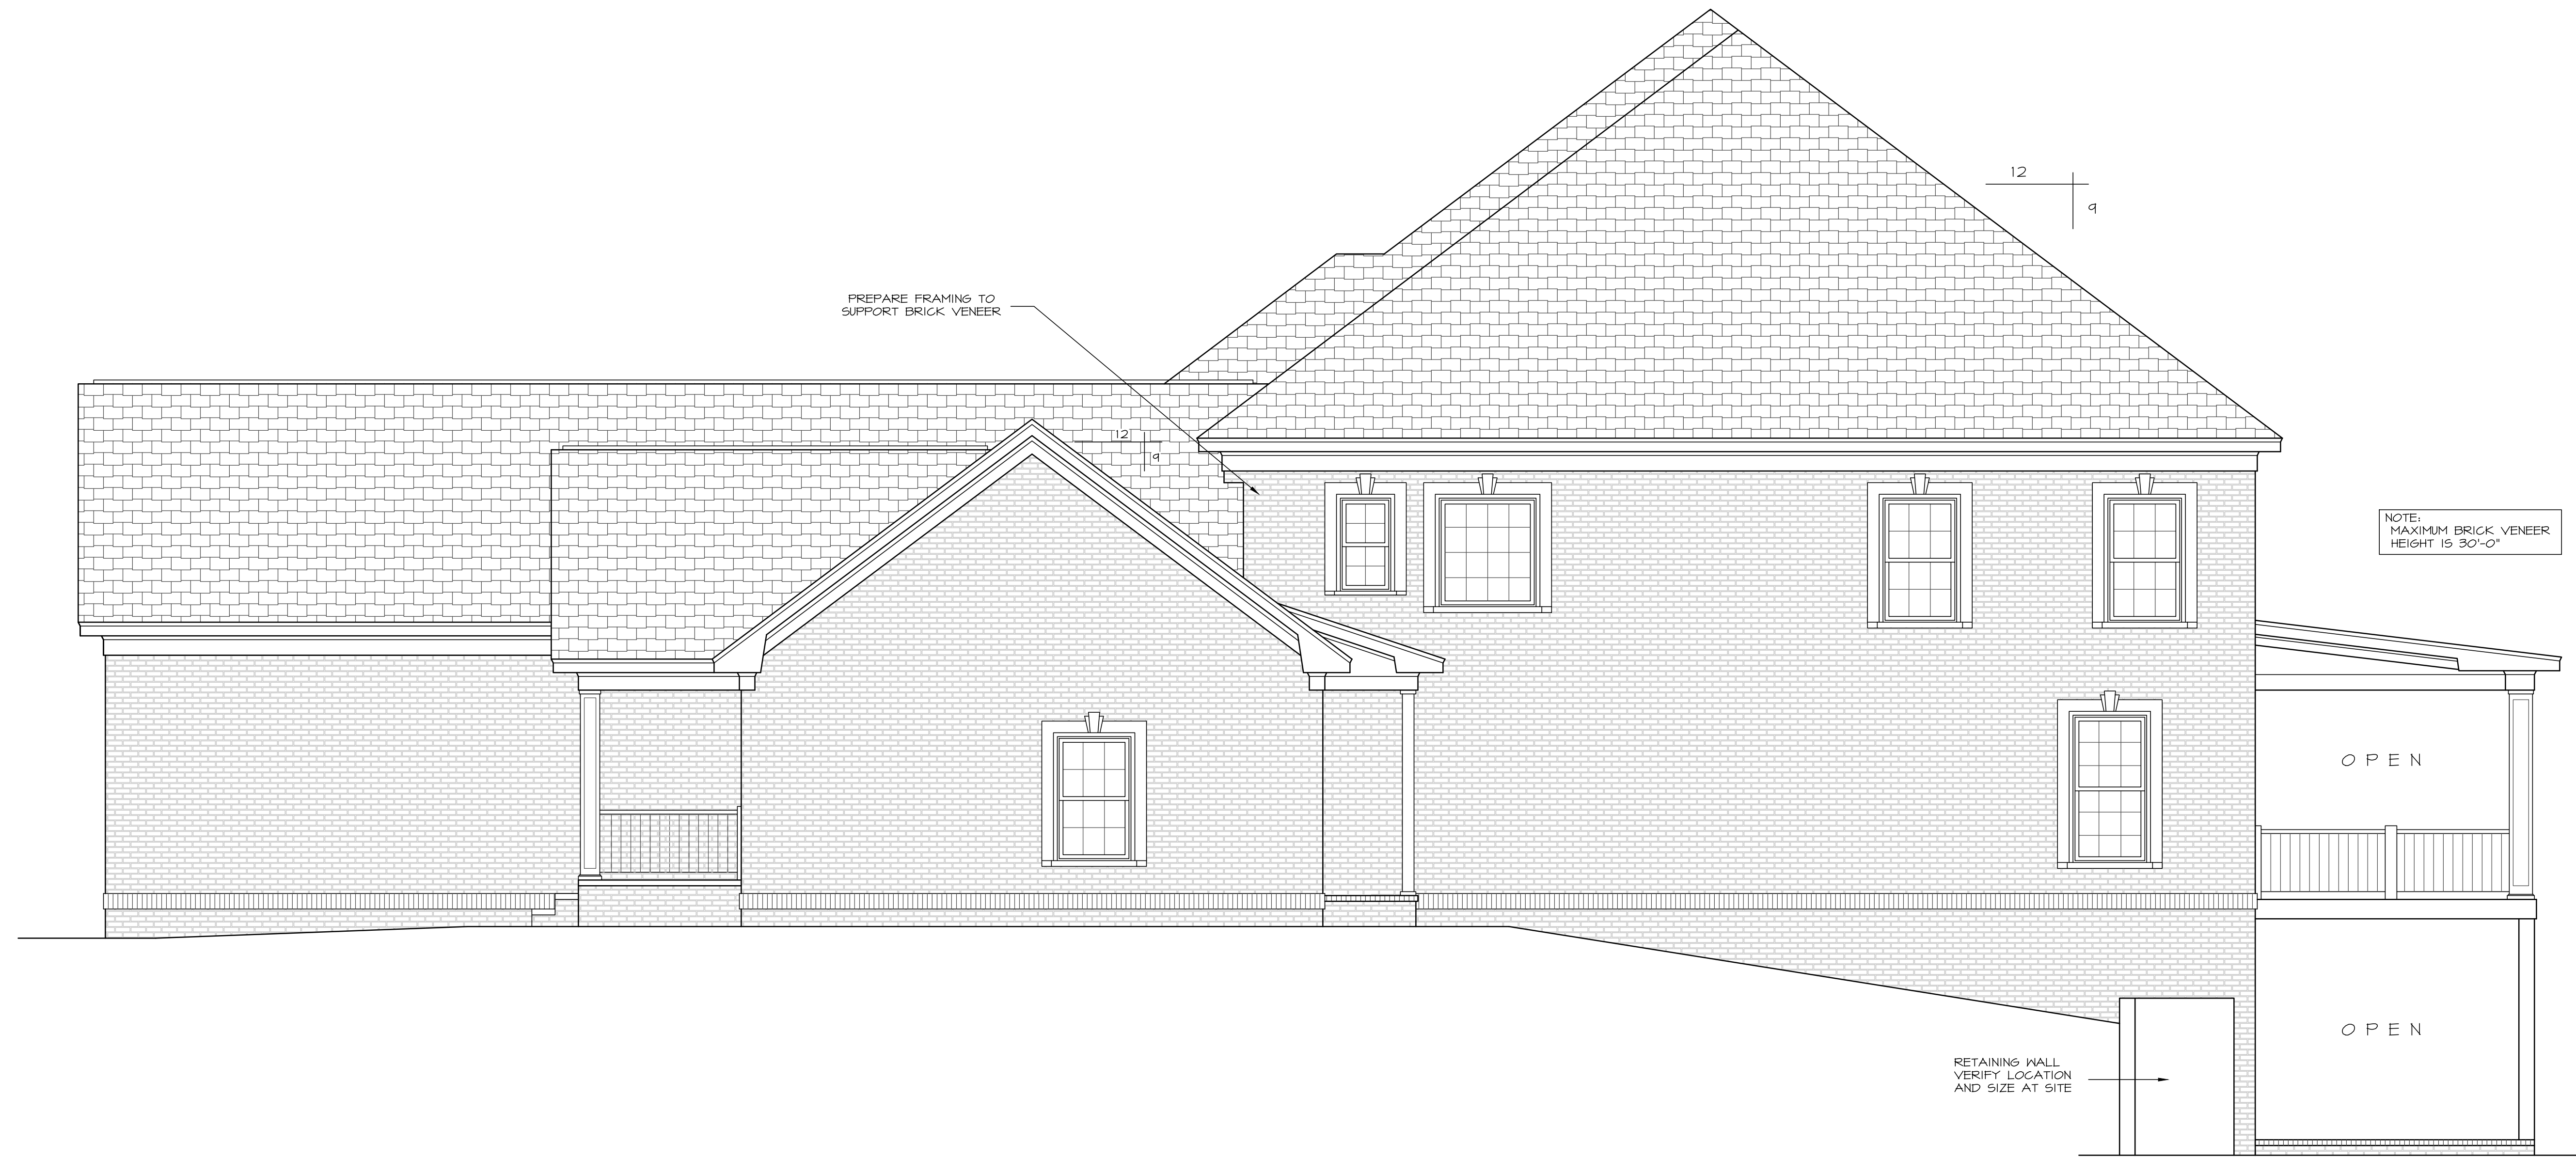


RIGHT ELEVATION

SCALE 1/4" = 1'-0"

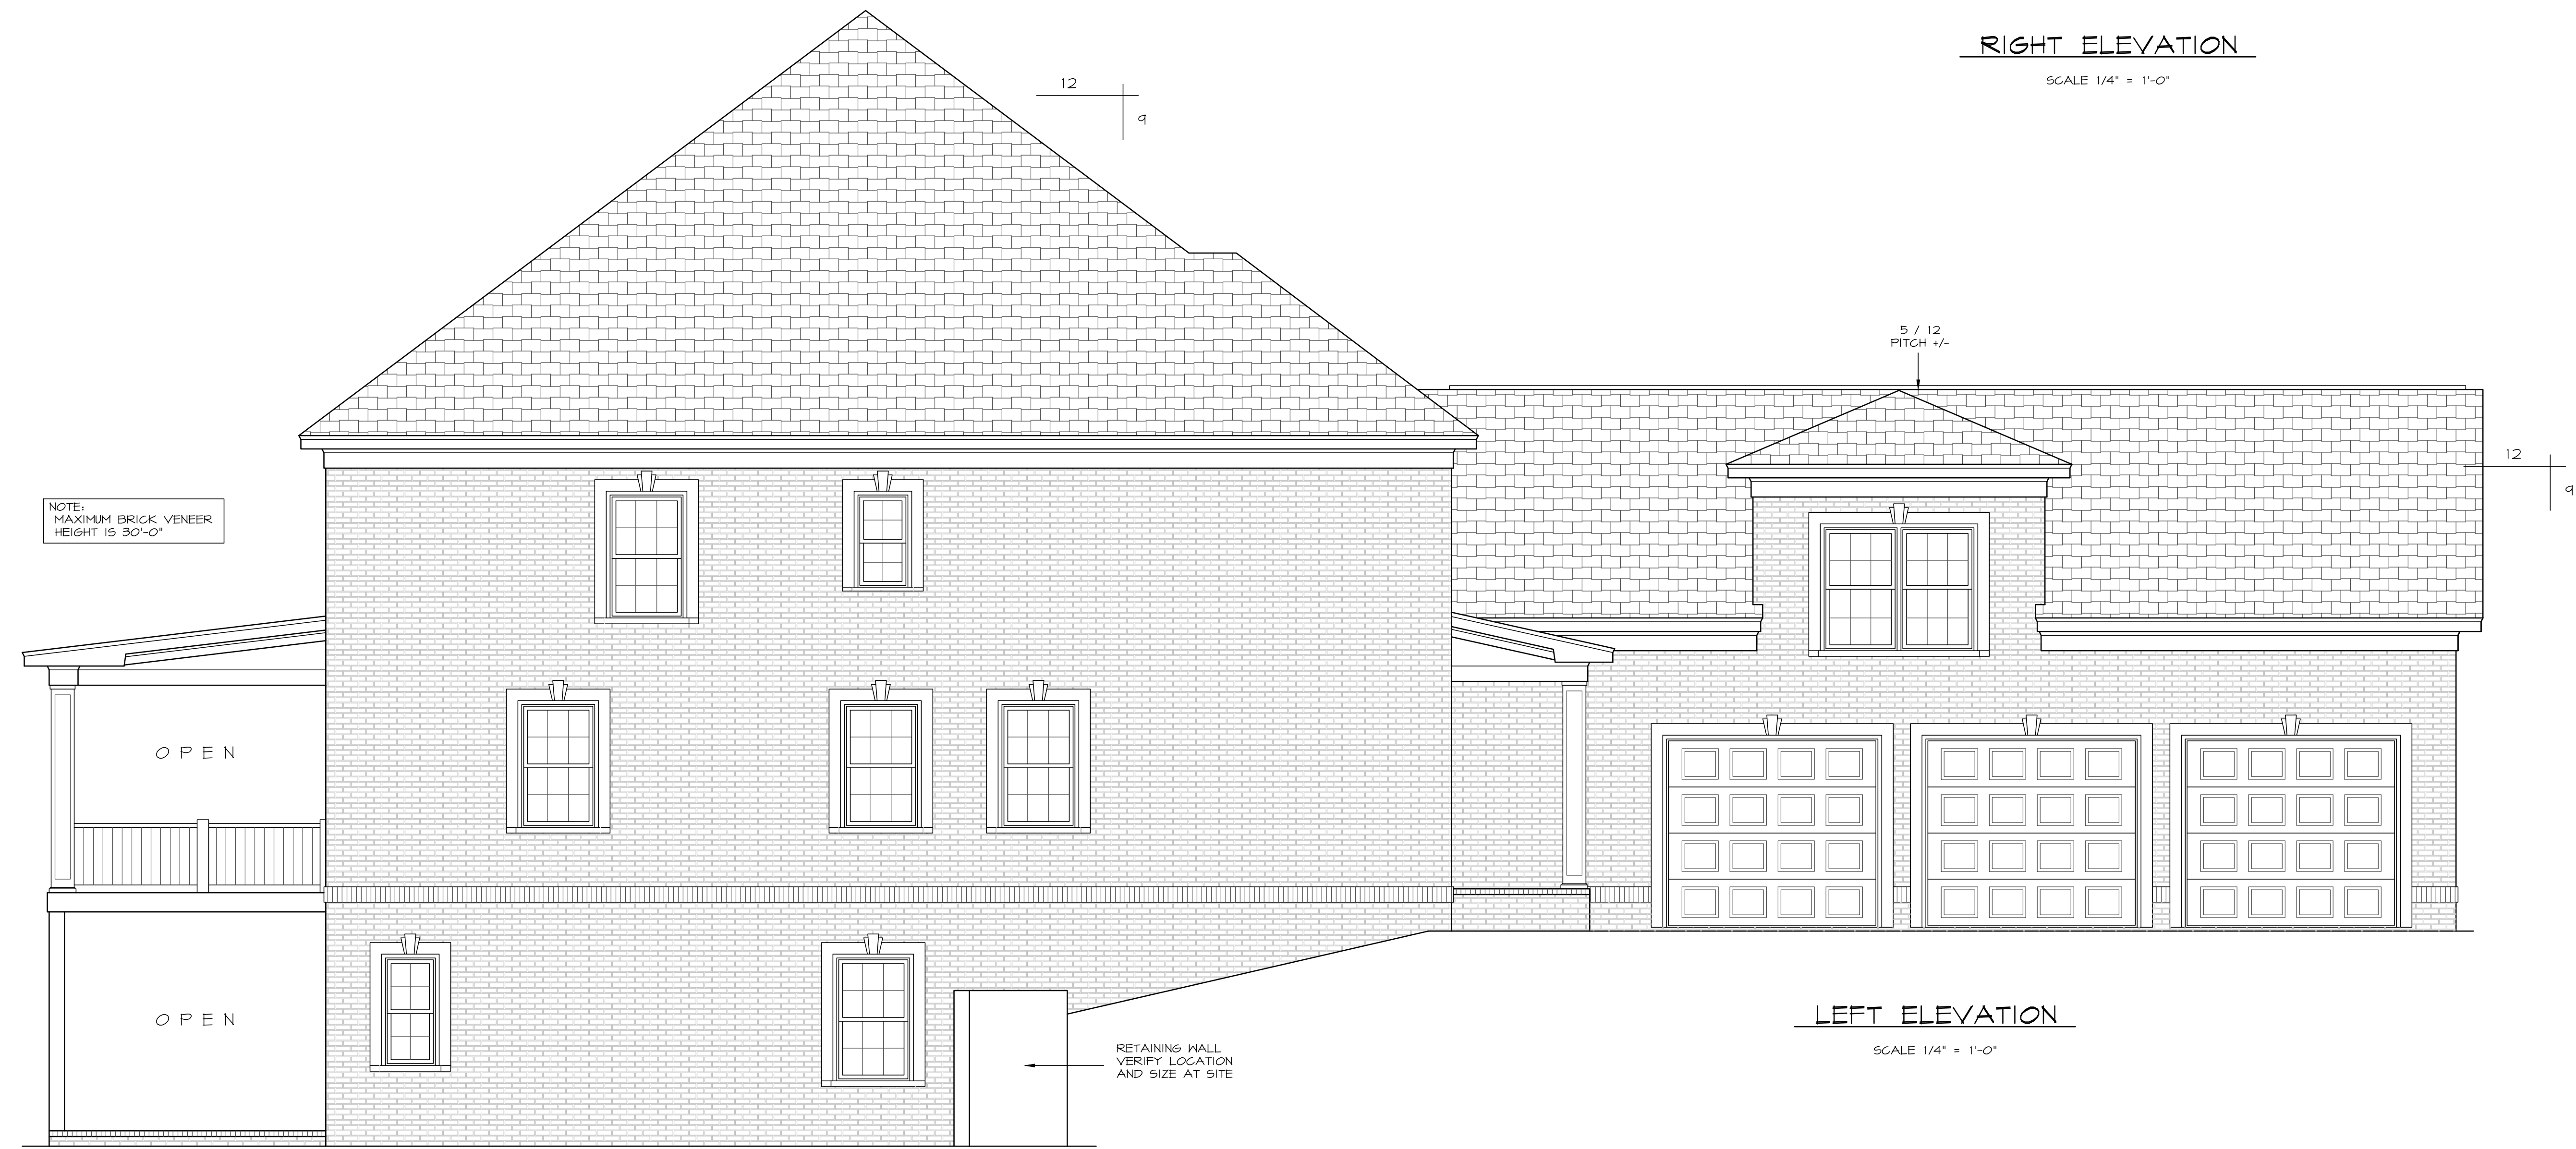

LEFT ELEVATION

SCALE 1/4" = 1'-0"

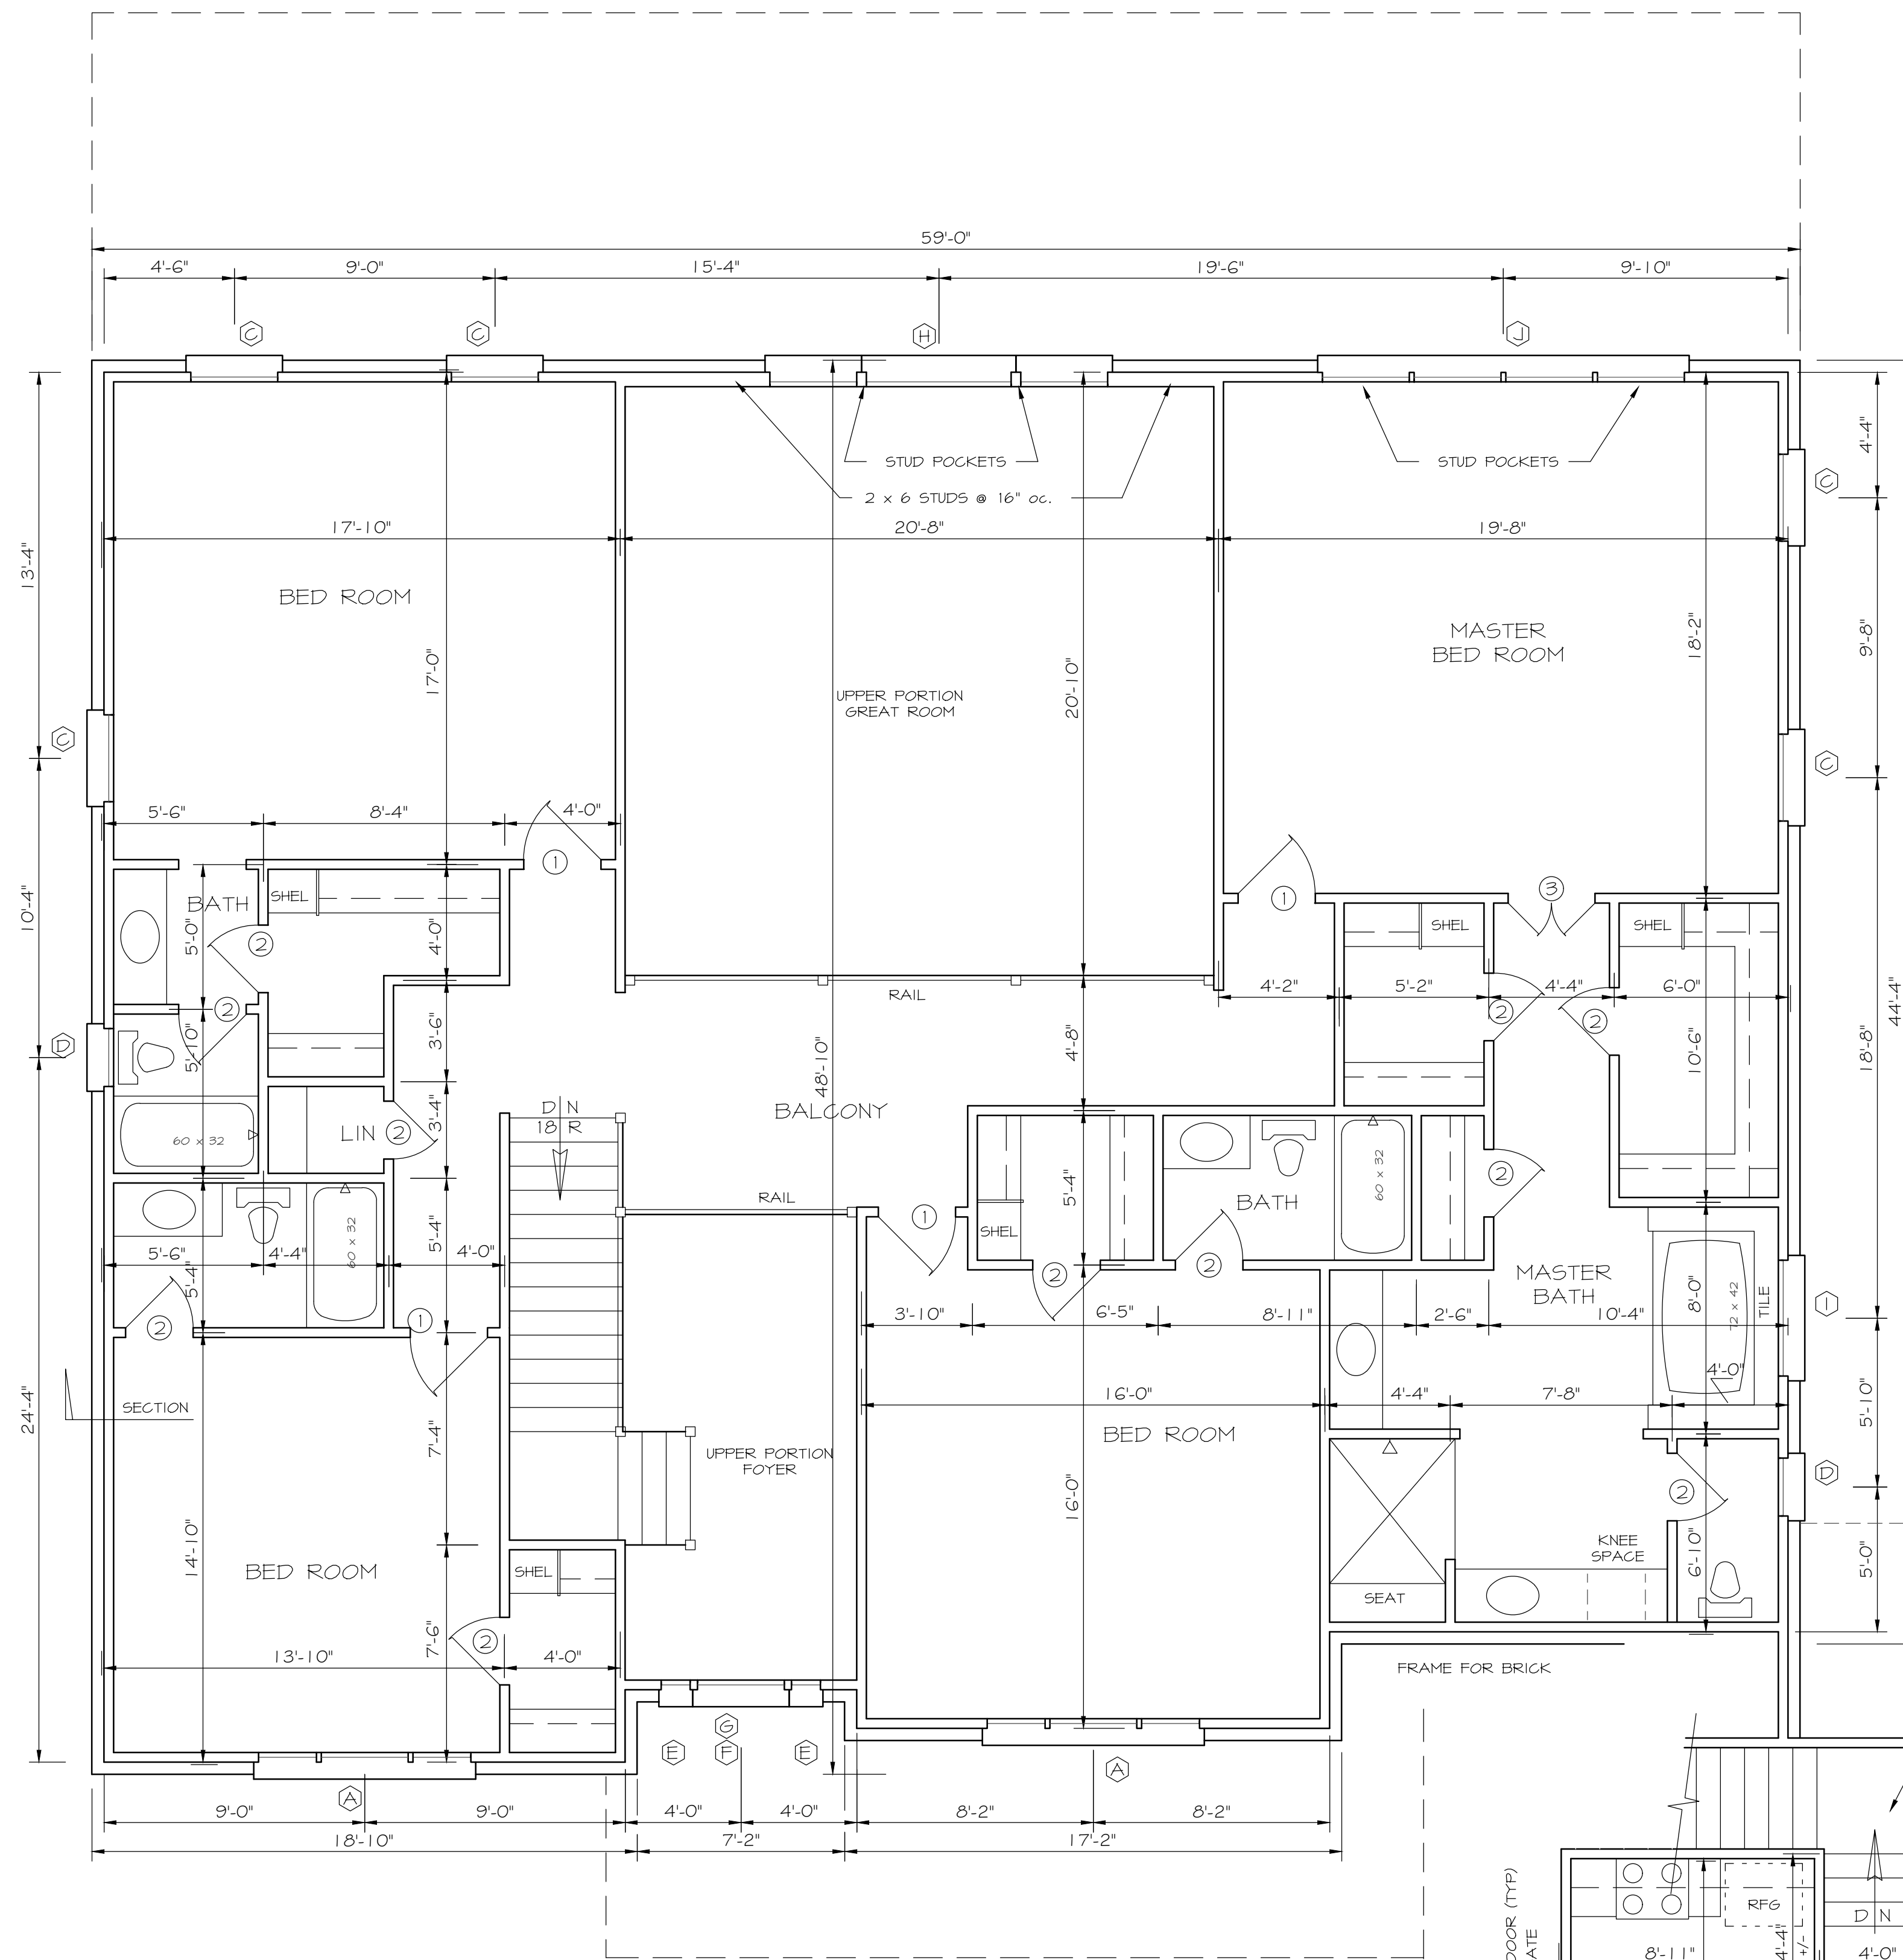

2166 SF HEATED
413 SF UPPER GREAT ROOM
154 SF UPPER FOYER
664 SF OVER GARAGE


SECOND FLOOR PLAN


SCALE 1/4" = 1'-0"

SECOND FLOOR DOOR SCHEDULE			
1	2'-8" x 6'-8"	INTERIOR	AS SPEC
2	2'-4" x 6'-8"	"	"
3	2'-1'-6" x 6'-8"	"	"
4	2'-0" x 6'-8"	"	"

SECOND FLOOR WINDOW SCHEDULE			
A	2'-0"3'-0"12'-0" x 5'-2"	DBL HUNG	4/4 - 6/6 LT
B	3'-3'-0" x 5'-2"	"	6/6 LT
C	3'-0" x 5'-2"	"	6/6 LT
D	2'-0" x 3'-10"	"	4/4 LT
E	1'-0" x 4'-6"	FIXED SASH	
F	3'-0" x 4'-6"	"	
G	3'-0" x 1'-6"	1/2 ROUND SASH	
H	3'-0"5'-0"3'-0" x 6'-2"	FIXED SASHES	
I	4'-0" x 4'-6"	FIXED SASH	
J	4'-3'-0" x 5'-2"	DBL HUNG	6/6 LT
VERIFY EGRESS SIZES W/ INDIVIDUAL MANUFACTURERS			

VERIFY NUMBER OF STEPS AT SITE
FLOOR LEVEL IN ROOM IS DROPPED
APPROX 1'-6" BELOW MAIN FLOOR

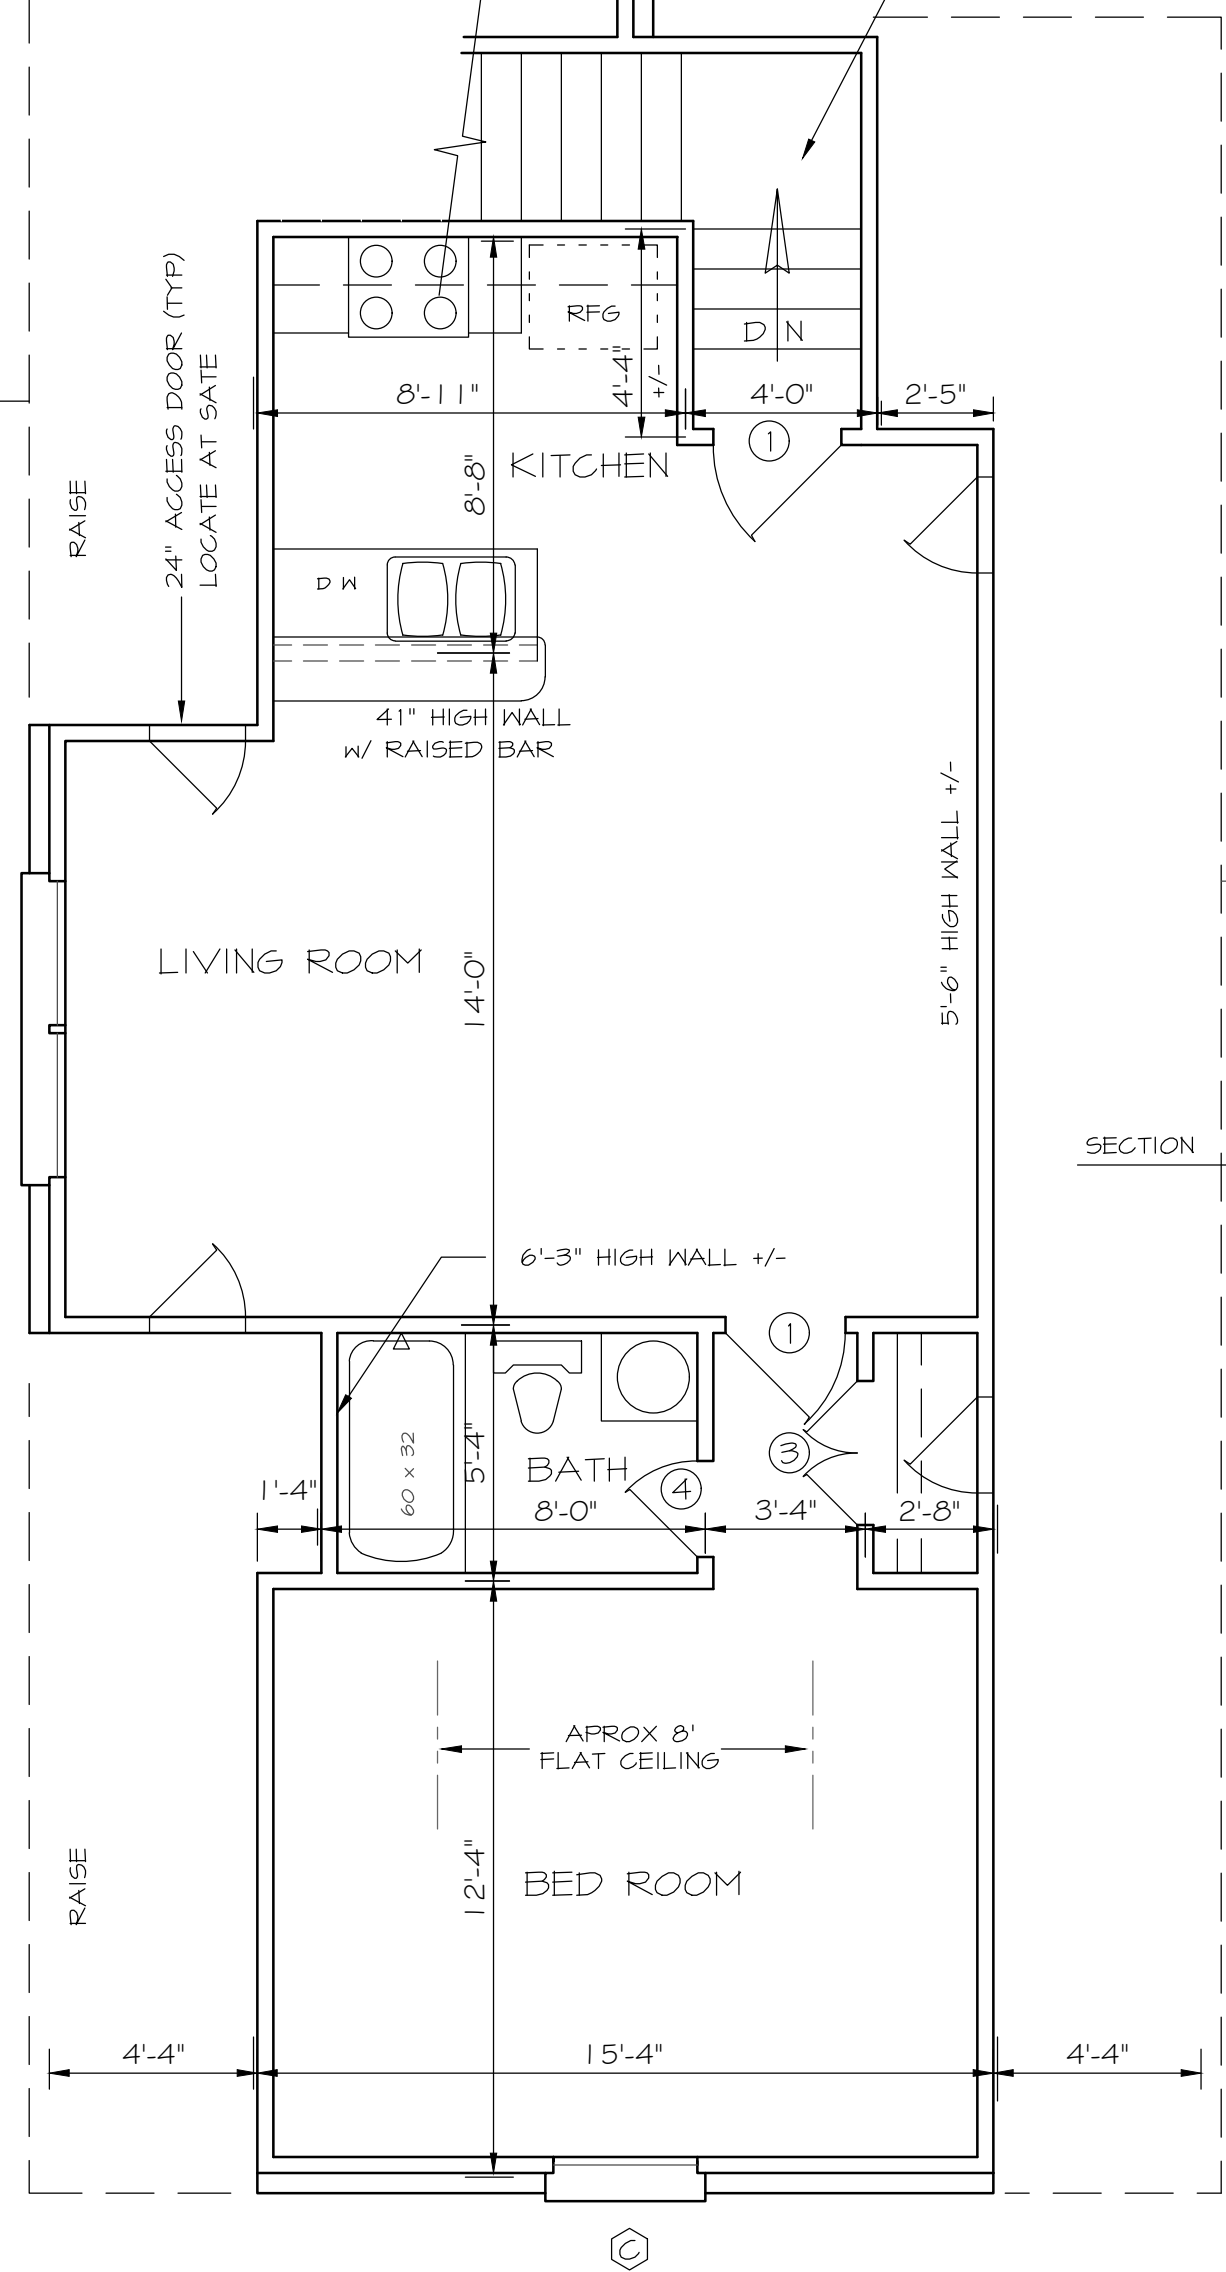

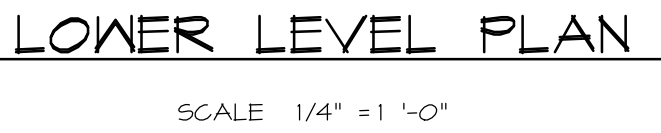


ABBREVIATIONS & SYMBOLS	
	CABLE TV OUTLET
	PHONE OUTLET
	SMOKE DETECTOR
	CASED OPENING
	HOSE BIBB
	TV CABLE OUTLET
	GAS CONNECTION
	EXHAUST FAN & LIGHT
	EXHAUST FAN
	LIGHT
	RECESSED LIGHT
	UNDER CABINET LIGHT
	PENDANT LIGHT
	WALL MOUNTED LIGHT
	CEILING FAN & LIGHT
	110 VOLT OUTLET
	WATERPROOF OUTLET
	GROUND FAULT OUTLET
	220 VOLT OUTLET
	GARAGE DOOR OPENER OUTLET




FIRST FLOOR ELECTRICAL PLAN


ABBREVIATIONS & SYMBOLS	
	CABLE TV, OUTLET
	PHONE OUTLET
	SMOKE DETECTOR
	CASED OPENING
	HOSE BIBB
	TV CABLE OUTLET
	GAS CONNECTION
	EXHAUST FAN & LIGHT
	EXHAUST FAN
	LIGHT
	RECESSED LIGHT
	UNDER CABINET LIGHT
	PENDANT LIGHT
	WALL MOUNTED LIGHT
	CEILING FAN & LIGHT
	110 VOLT OUTLET
	WATERPROOF OUTLET
	GROUND FAULT OUTLET
	220 VOLT OUTLET
	GARAGE DOOR OPENER OUTLET

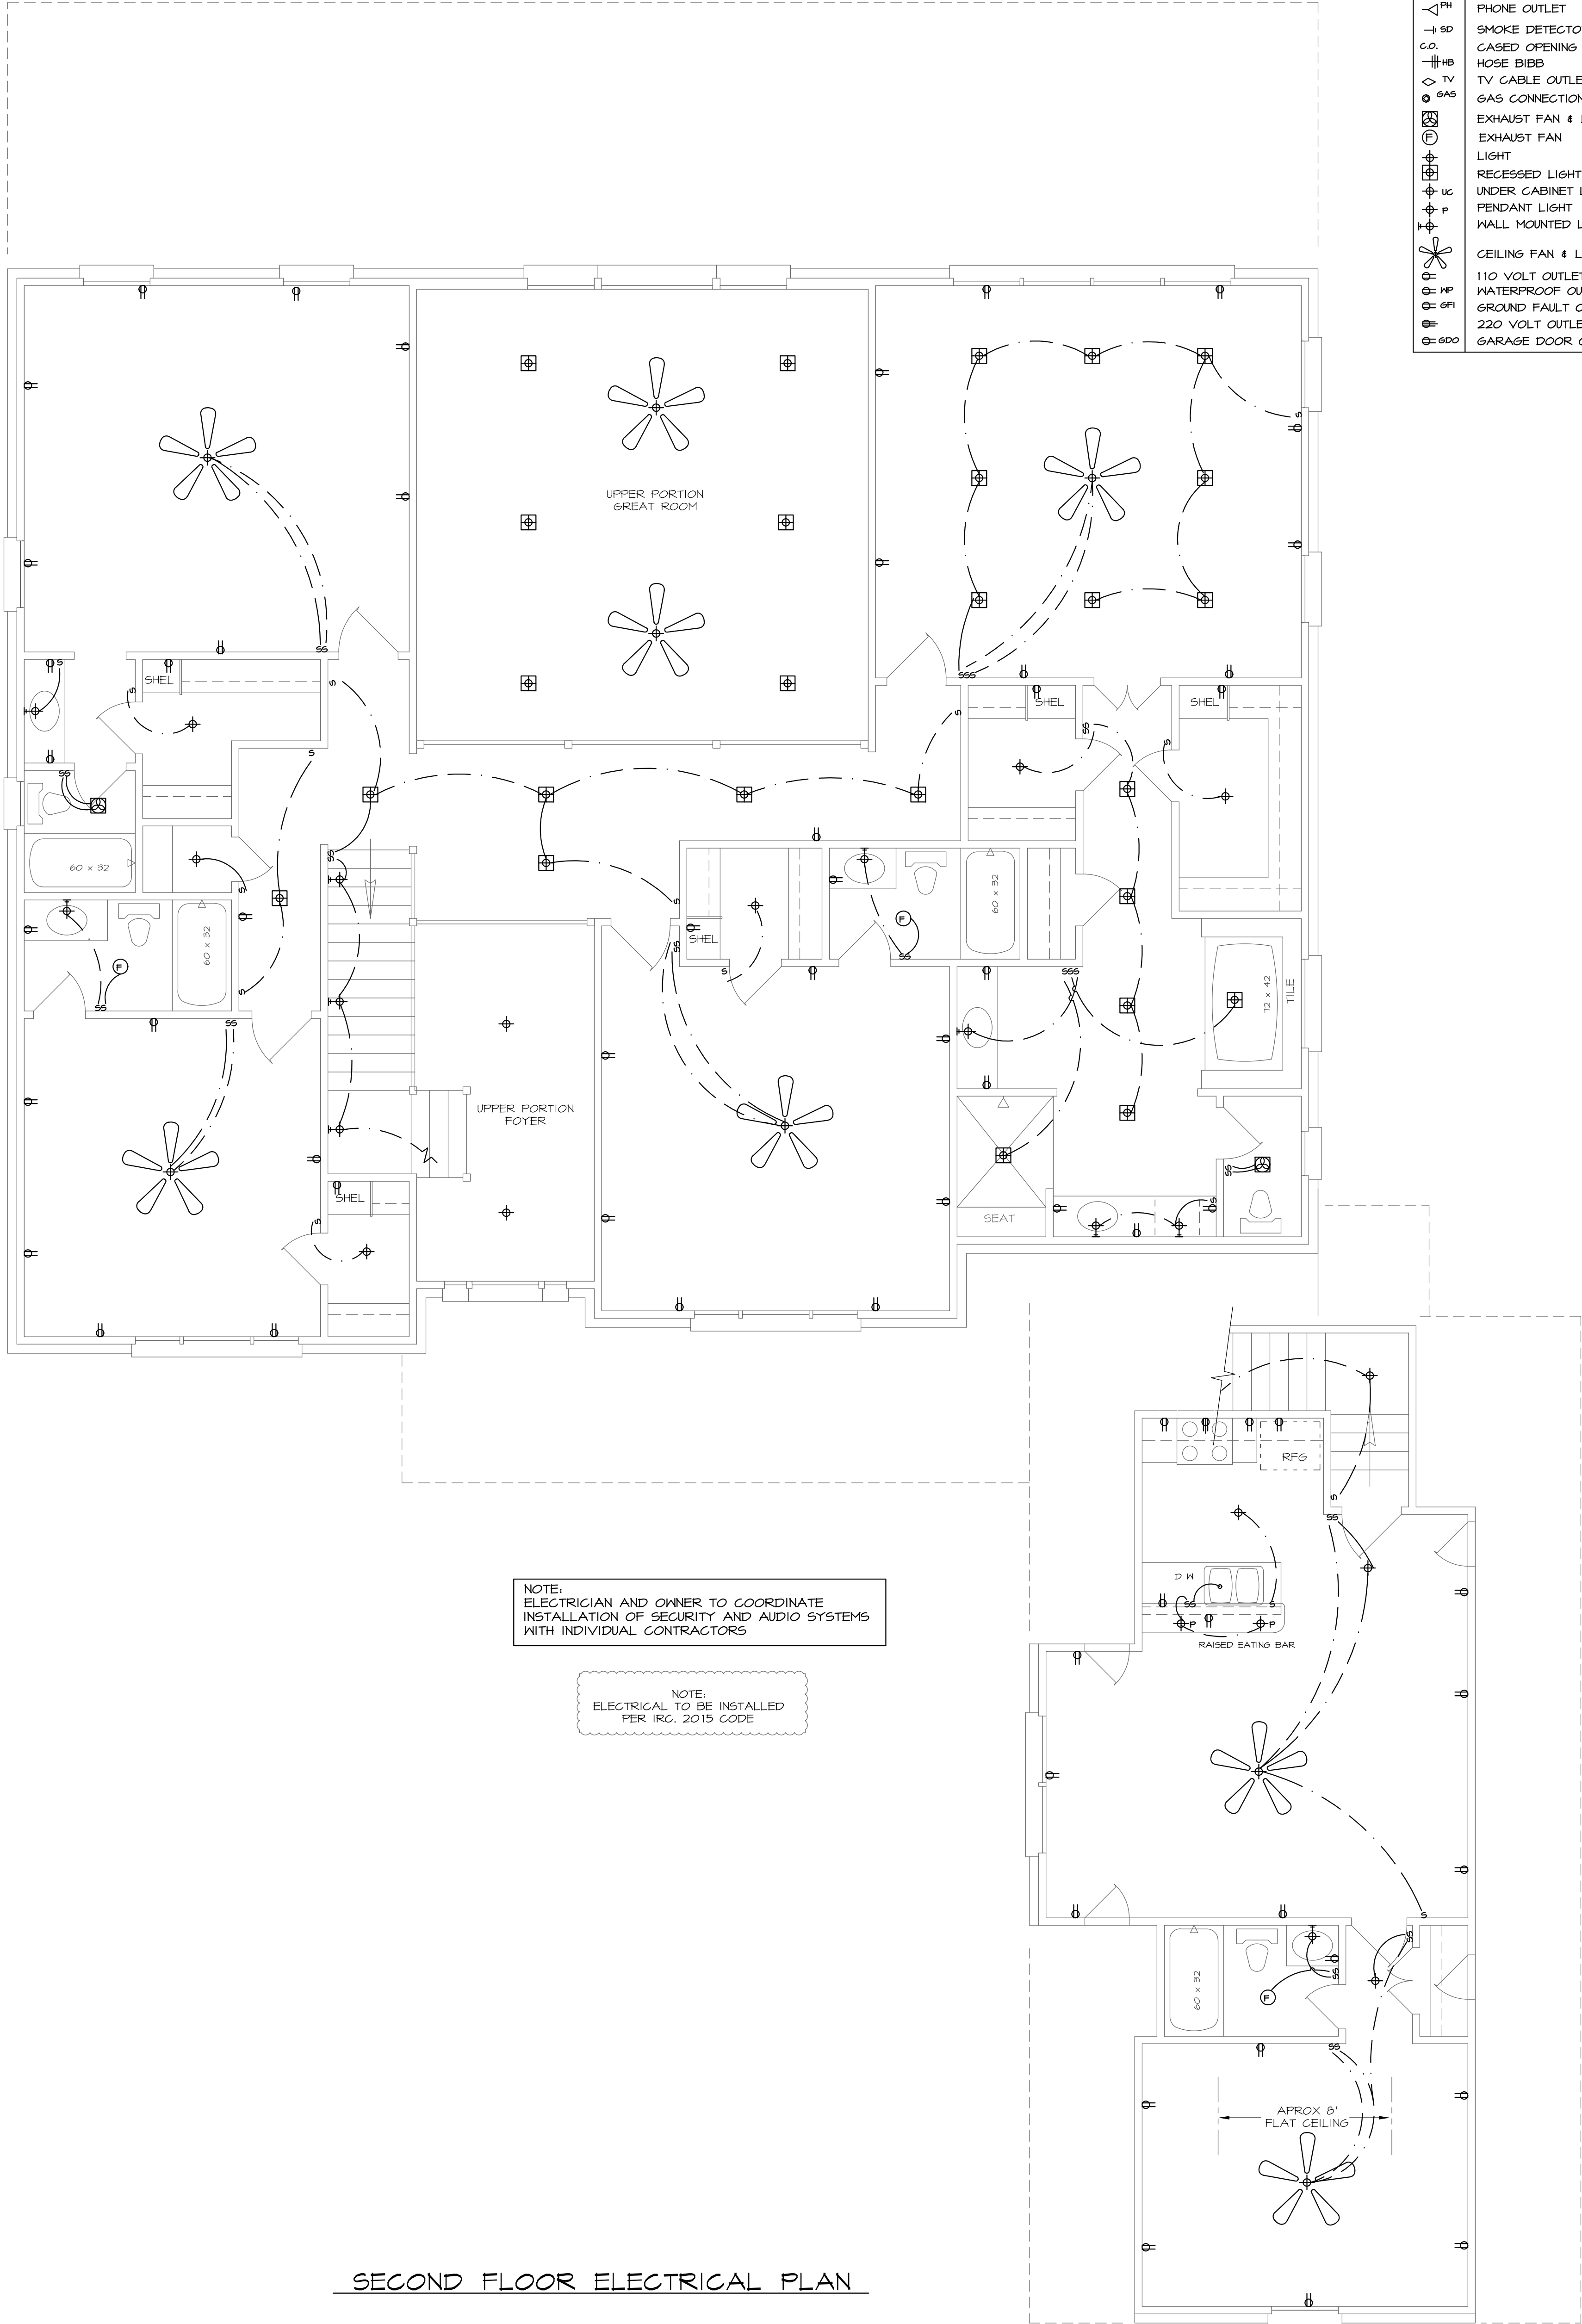

SECOND FLOOR ELECTRICAL PLAN

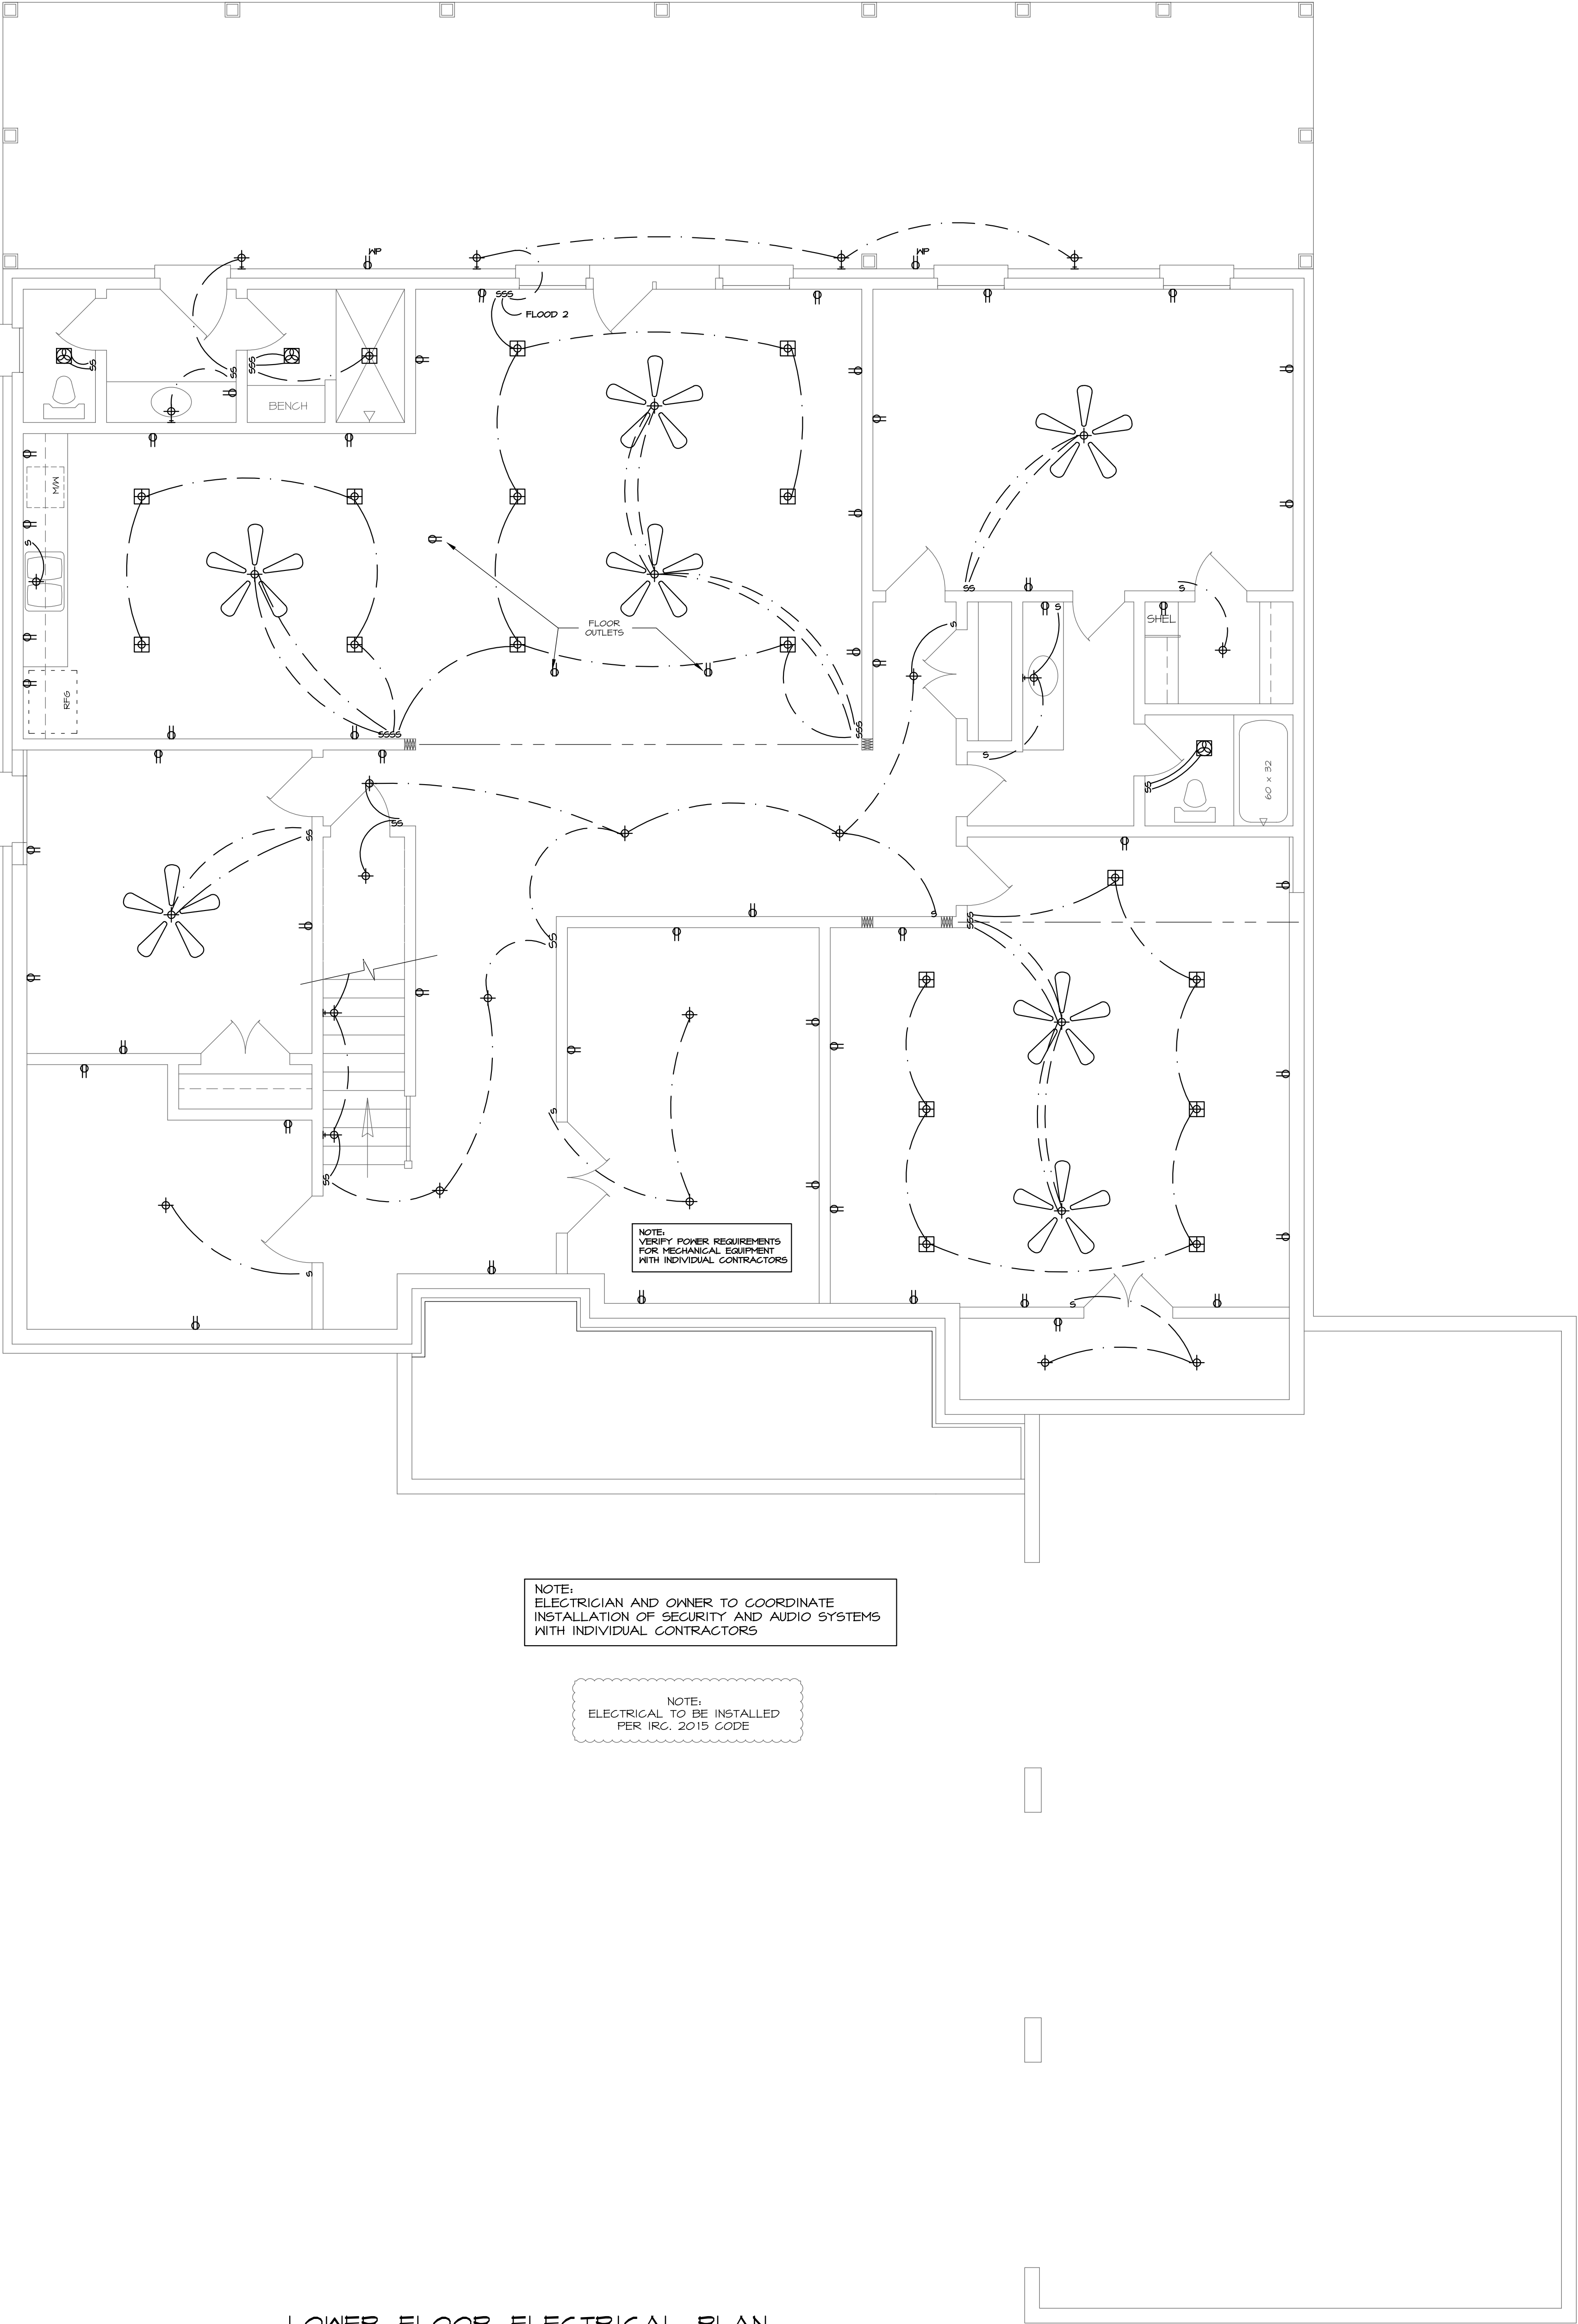


LOWER FLOOR ELECTRICAL PLAN

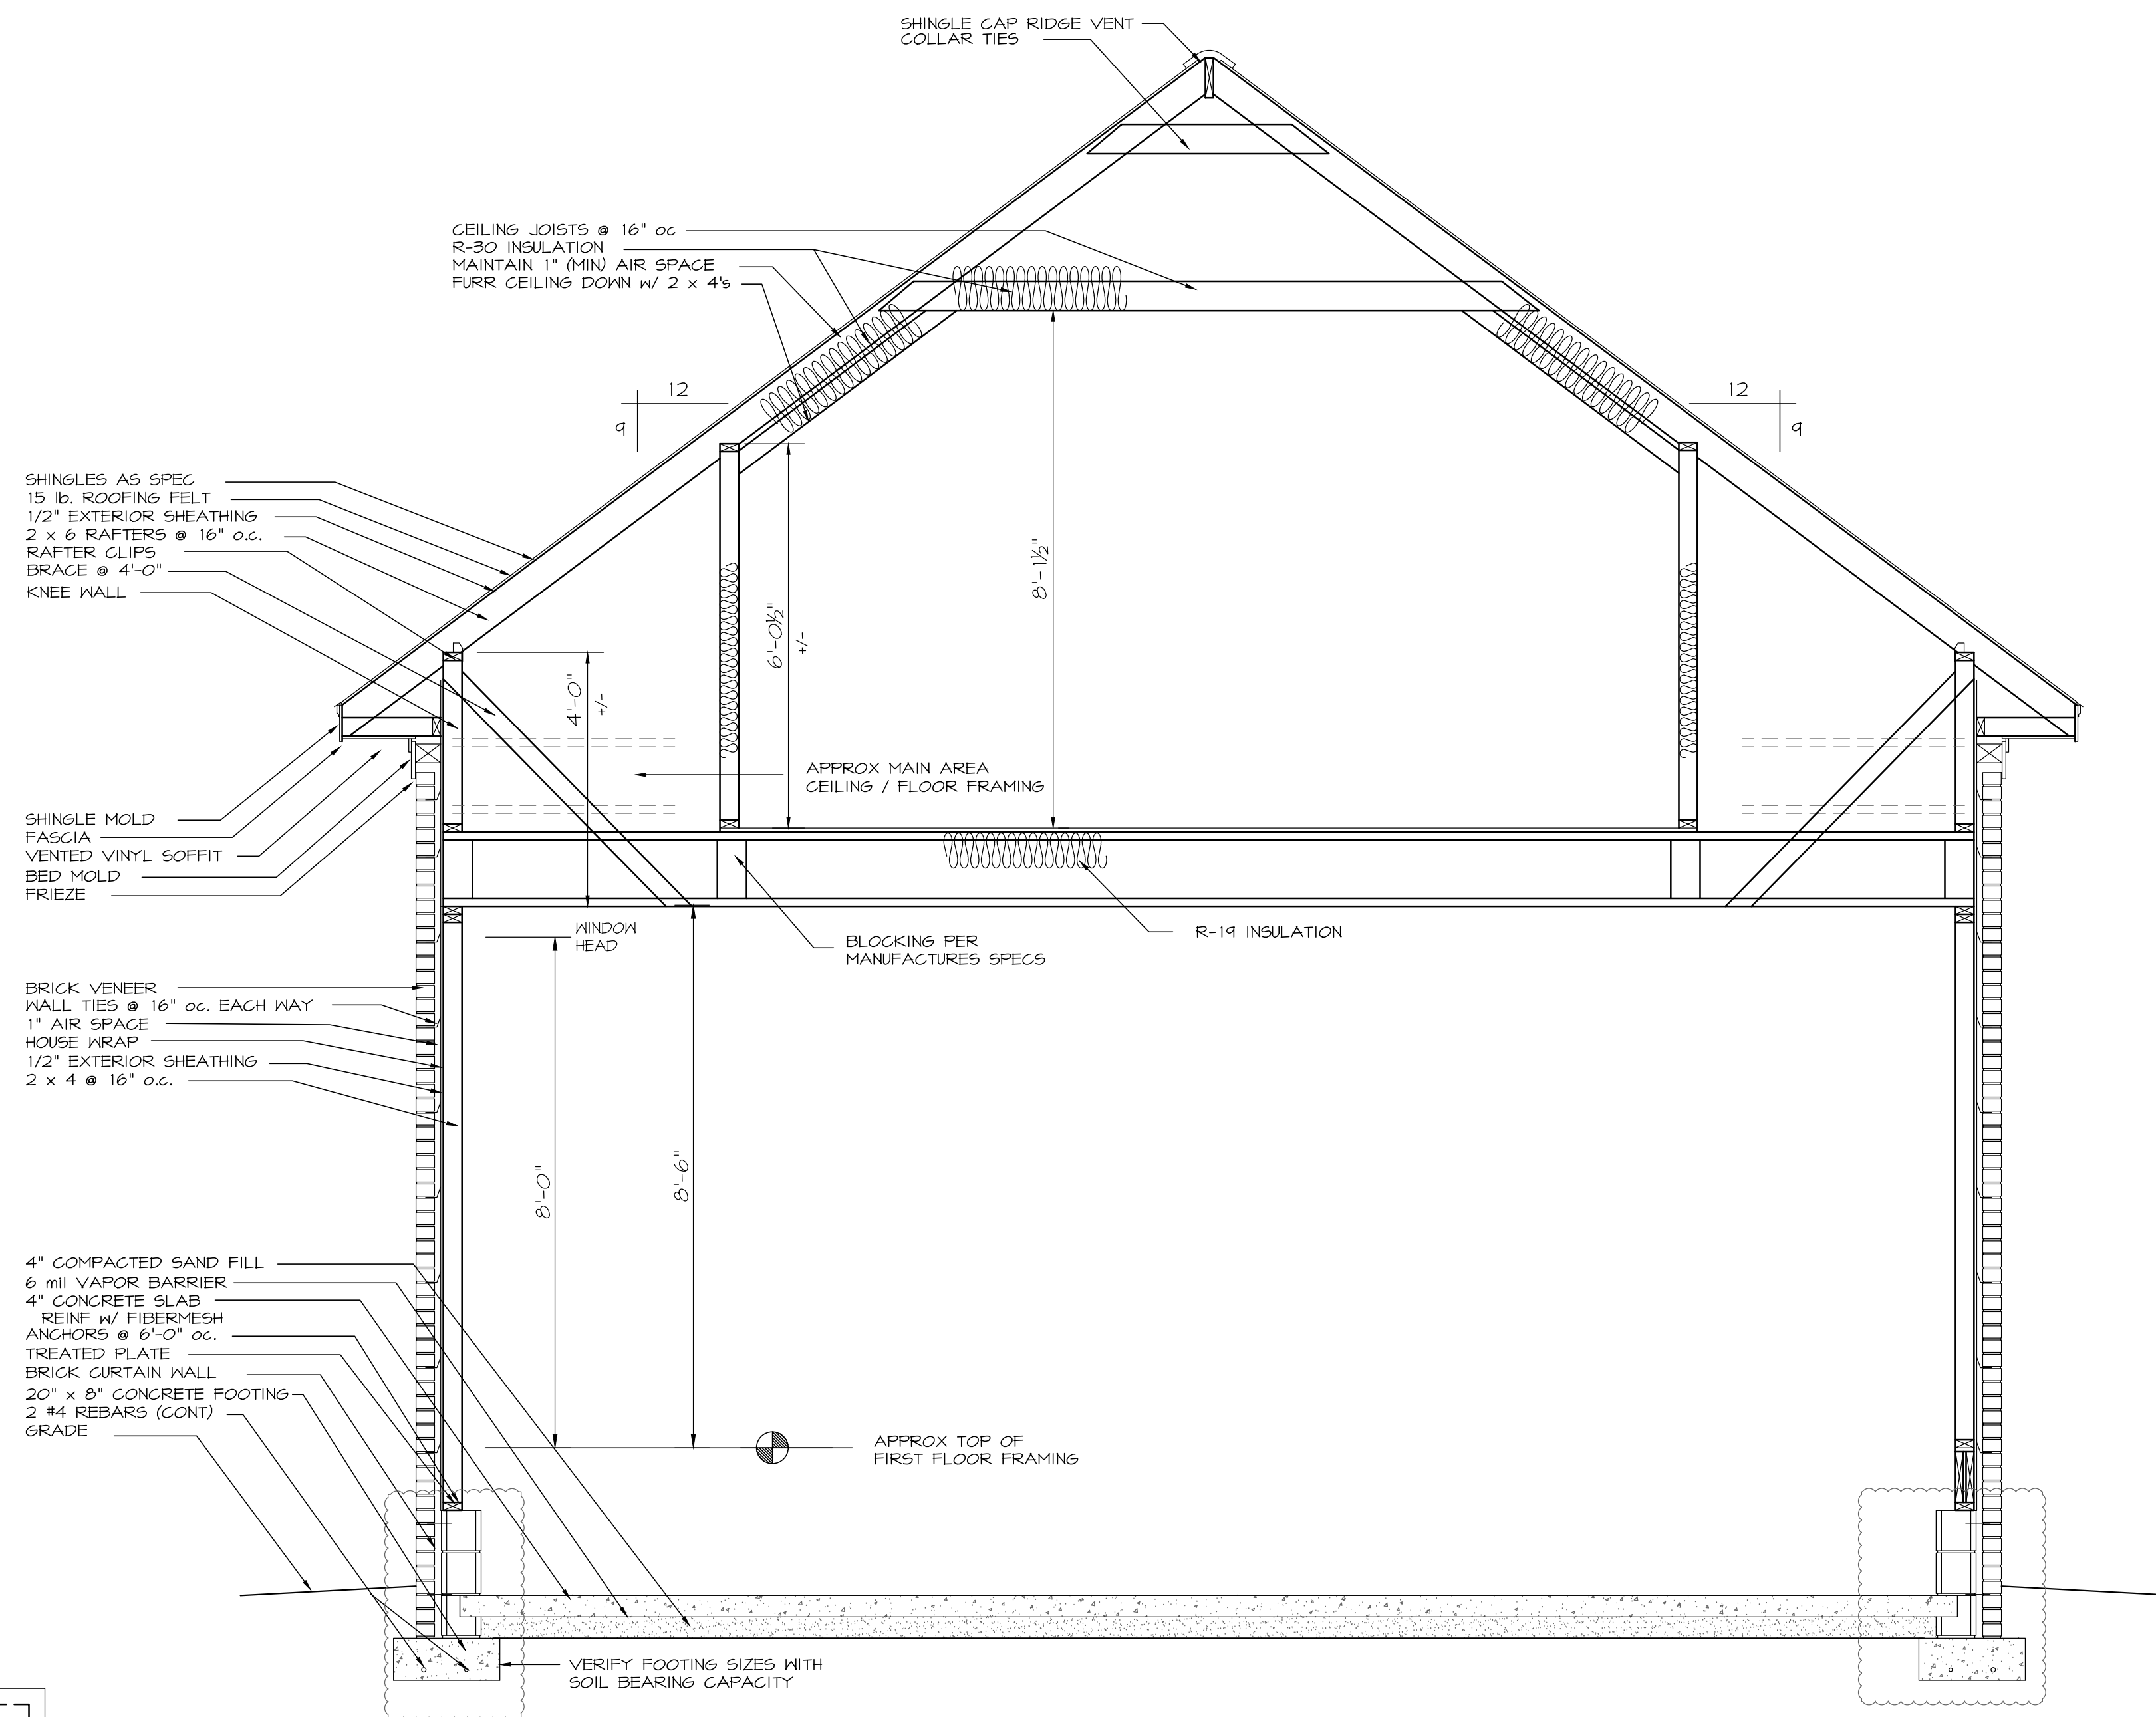


GARAGE SECTION

SCALE 1/2" = 1'-0"

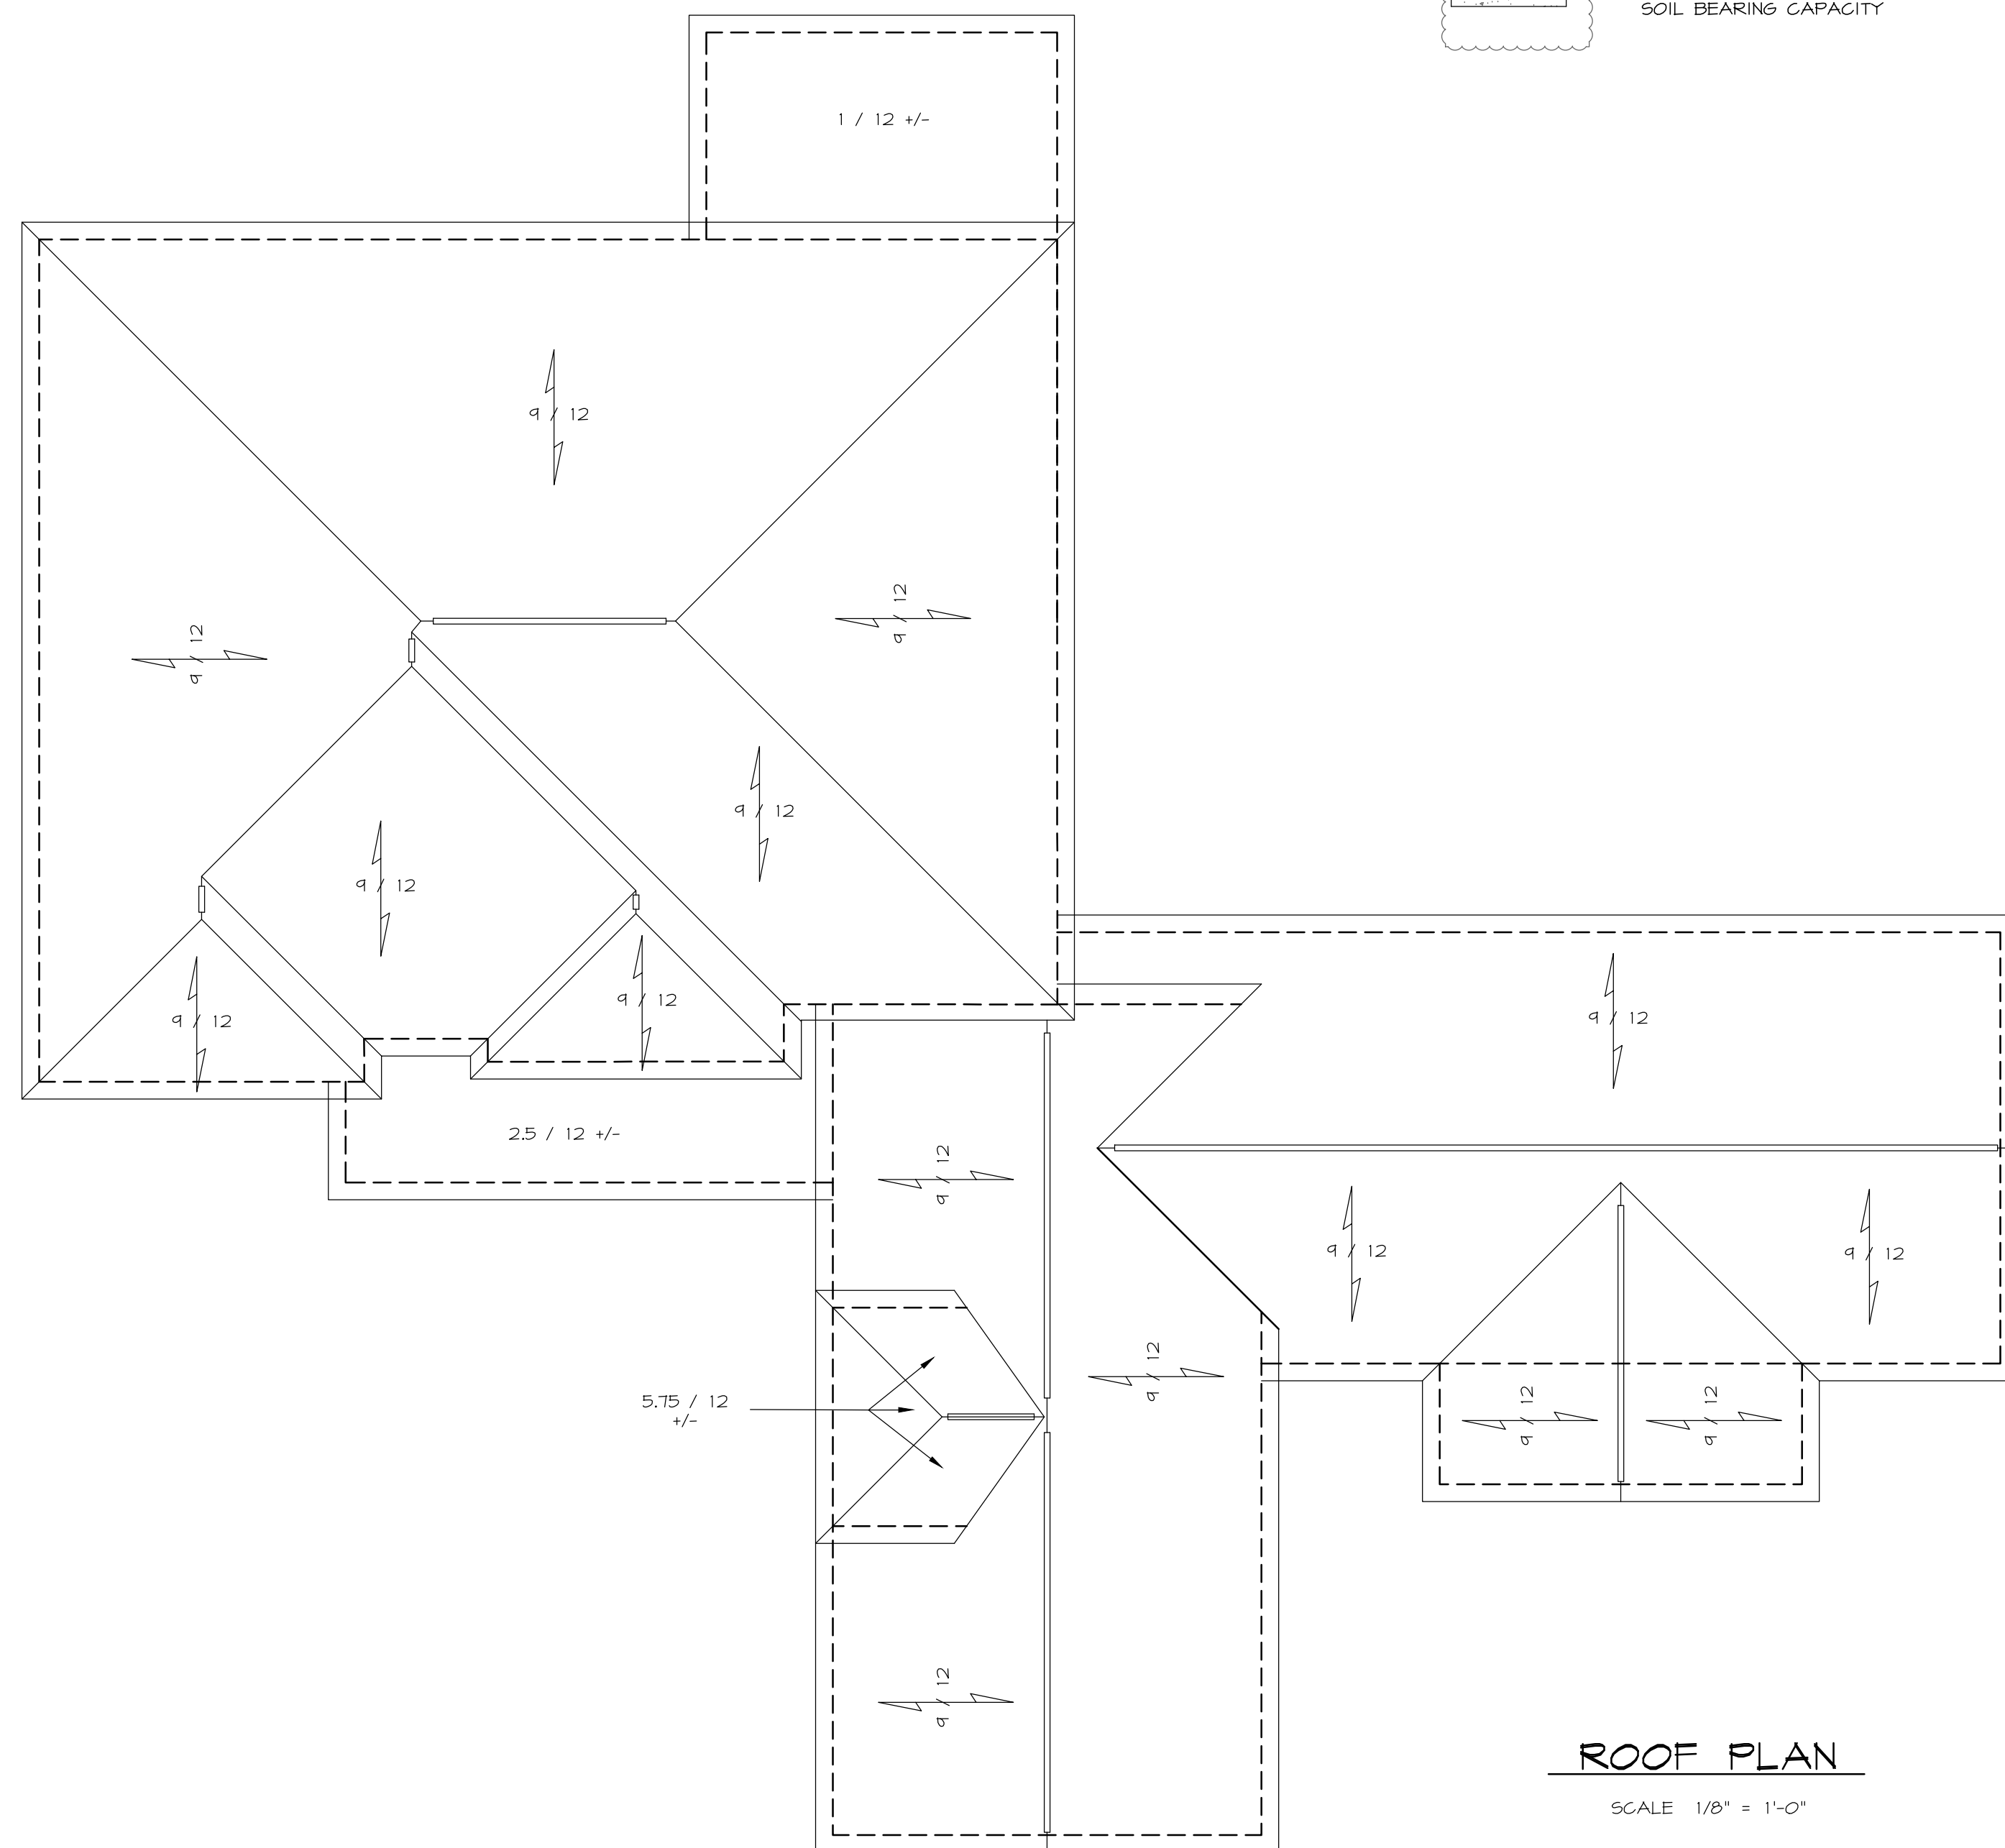


ROOF PLAN

SCALE 1/8" = 1'-0"

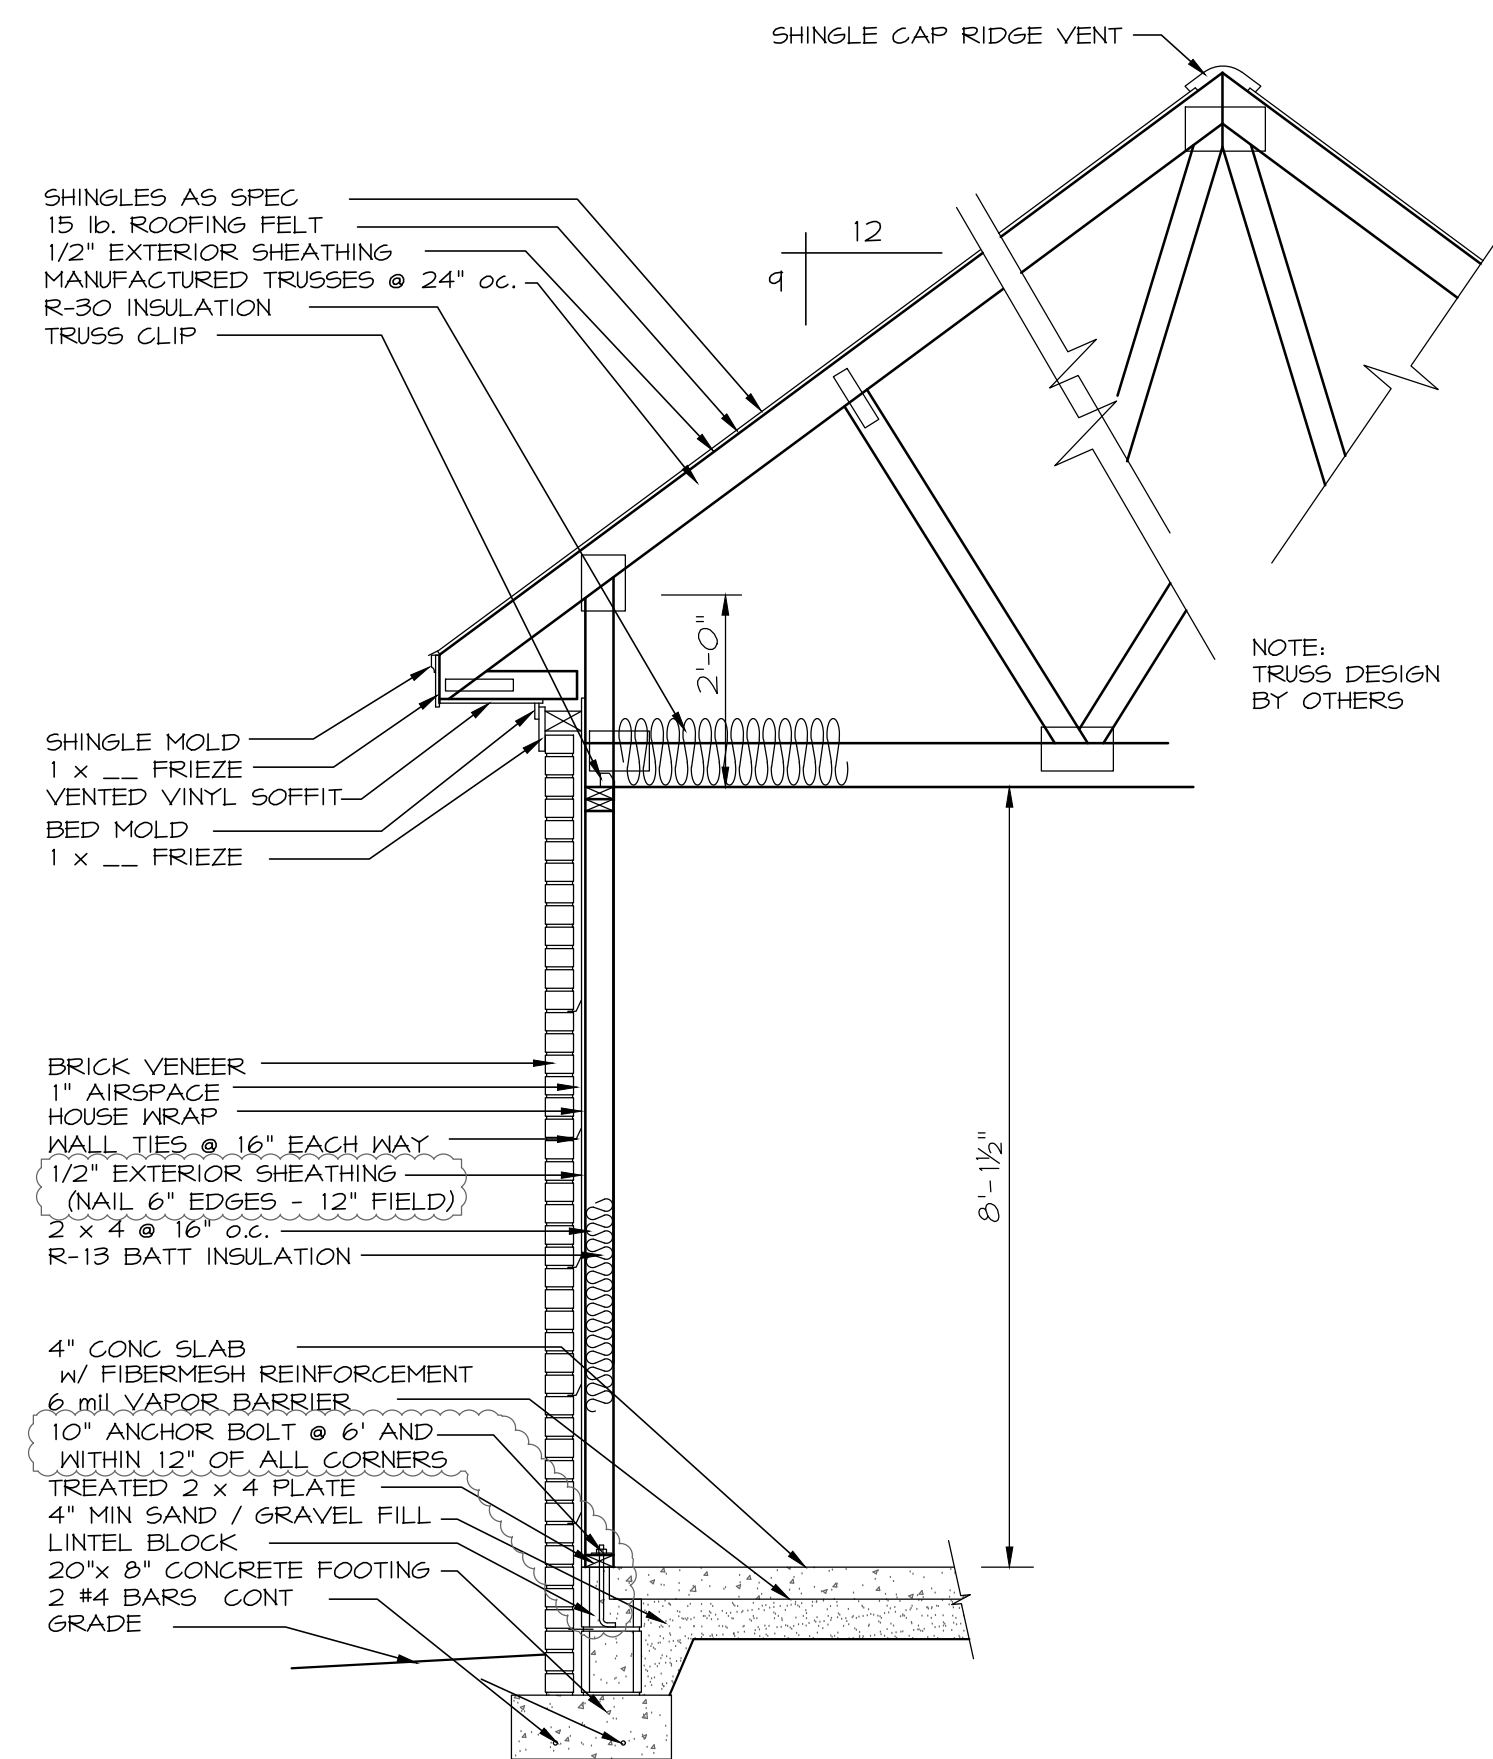

APARTMENT WALL SECTION

SCALE 1/2" = 1'-0"

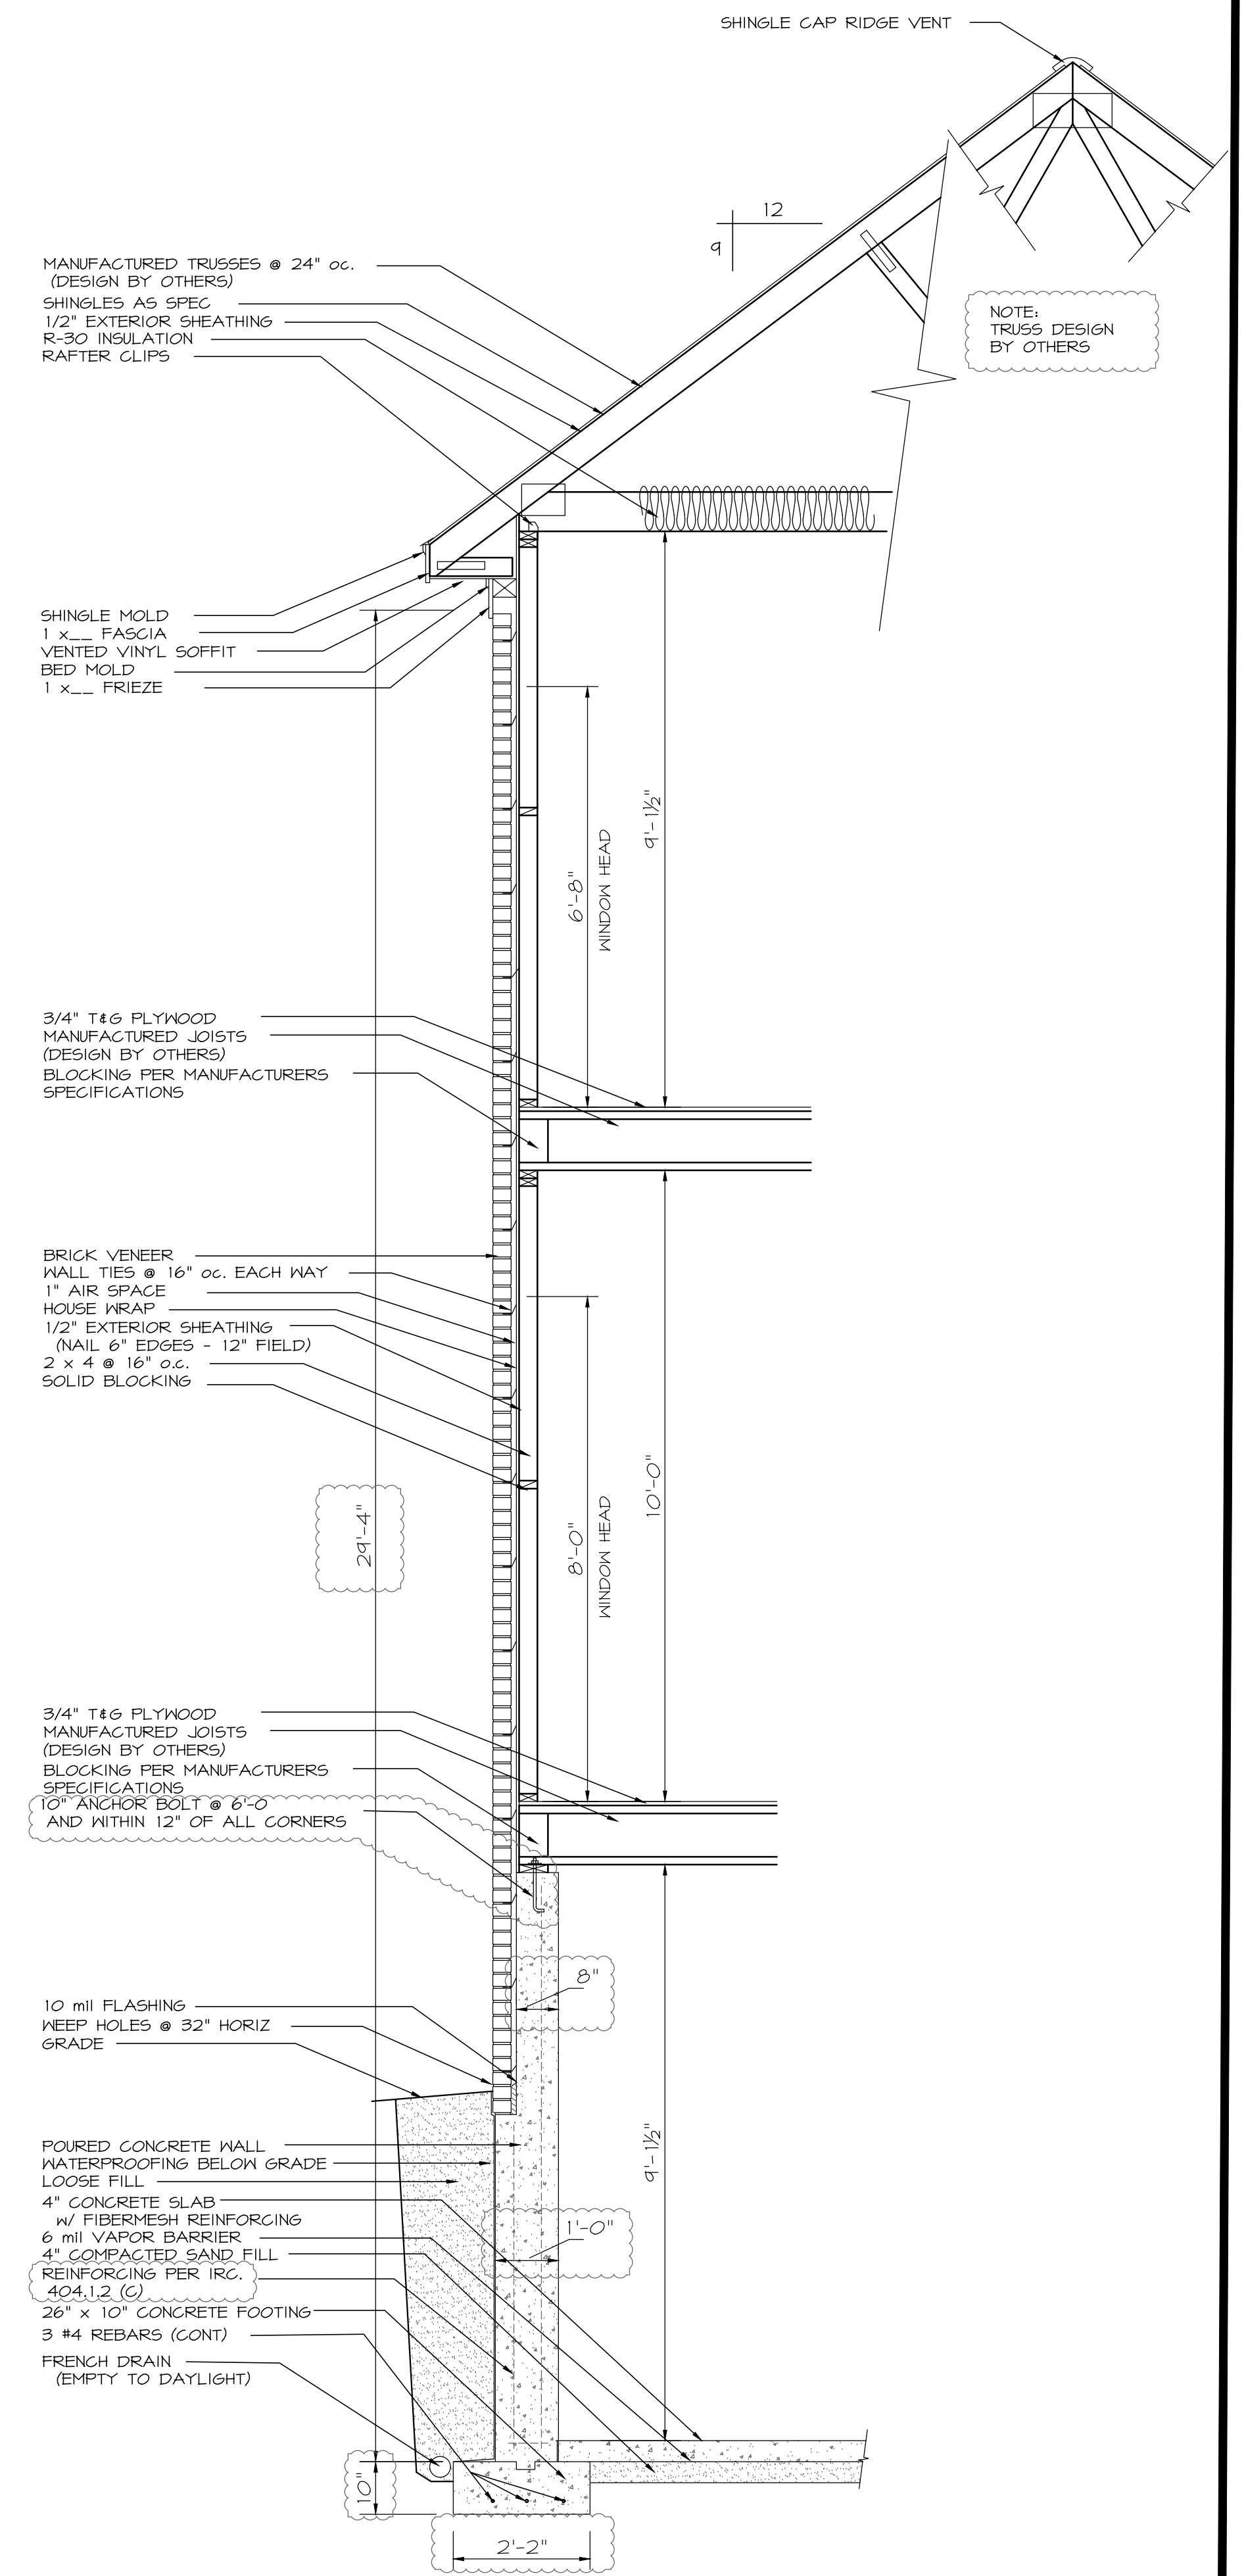

TYPICAL WALL SECTION

SCALE 1/2" = 1'-0"

PLAN NO. 8258

REV DECEMBER 2011

NOVEMBER 2014 BY DAVID PEEK

